

10601 W. 10th Street
Greeley, CO 80634
Phone: 970-350-2161

Region 4 Right of Way

PTS

Sheet Revisions

Date	Description	Initials
8/31/17	rev 2.02, 5.01-5.03, 7.03, 8.01	acr
10/31/17	rev 2.02, 2.07, 2.09, 5.01-5.03, 7.03, 7.11-7.13, 8.01, 8.02	acr
11/16/17	rev 2.02, 2.08, 5.01-5.03, 7.02, 7.03, 7.12, 8.01, 8.02	acr
03/23/18	rev 2.03, 2.04, 5.01-5.03, 7.04, 8.01	jam
05/10/18	rev 2.06, 5.01, 7.10, 8.02	jam

Sheet Revisions

Date	Description	Initials
07/10/18	rev 2.06, 2.08, 5.01-5.03, 7.10, 7.12, 7.13, 8.02, add 7.15	jam

Sheet Revisions

Date	Description	Initials

JACOBS707 17th Street, Suite 2400
Denver, Colorado 80202
Phone: 303-820-8240
Fax: 303-820-5298

Right of Way Plans

Title Sheet

Project Number:	AQC M570-048
Project Location:	US 34 BUSINESS & 10TH STREET
Project Code:	20389
Last Mod. Date:	07-10-18
Subset:	1.01 of 1.01
Sheet No.:	1.01

DEPARTMENT OF TRANSPORTATION

STATE OF COLORADO

RIGHT OF WAY PLANS OF PROPOSED
FEDERAL AID PROJECT NO. AQC M570-048
US 34 BUSINESS & 10TH STREET
WELD COUNTY

R.O.W. Length of Project = 1.02 Miles

Const. Length of Project = 1.02 Miles

SHEET NO.

1.01
2.01-2.09
3.01-3.03
4.01-4.03
5.01-5.03
NA
7.01-7.14, 7.15
8.01-8.02

INDEX OF SHEETS

(1) Title Sheet
(9) Tabulation of Properties
(3) Project Control Diagram
(3) Land Survey Control Diagram
(3) Monumentation Sheets
(NA) Tabulation of Road Approach Sheets
(15) Plan Sheets
(2) Ownership Map
(36) Total Sheets

Scales of Original 11"x17" Drawings

Plan Sheets 1"=30'

Ownership Map 1"=200'

Basis of Bearings: Bearings used in the calculations of coordinates are based on a grid bearing of N74°01'49"E from CM-MP 101 to CM-MP 105. Both monuments are CDOT TYPE 5 set in concrete. The survey data was obtained from a Global Positioning System (GPS) survey base on the Colorado High Accuracy Reference Network (CHARN).

1. This Right-of-Way Plan is not a boundary survey of the adjoining property and is prepared for the Colorado Department of Transportation purposes only.

2. For title information, The Colorado Department of Transportation relied on Title Commitments prepared by Fidelity National Title Co.

3. This plan set is subject to change and may not be the most current set. It is the user's responsibility to verify with CDOT that this set is the most current. The information contained on the attached drawing is not valid unless this copy bears an original signature of the Professional Land Surveyor hereon named.

NOTICE: According to Colorado law you must commence any legal action based upon any defect in this survey within three years after you first discover such defect. In no event may any action based upon any defect in this survey be commenced more than ten years from the date of the certification shown hereon.

COLORADO DEPARTMENT OF TRANSPORTATION
FEDERAL-AID HIGHWAY PROJECT




ROW PLANS AUTHORIZED:

CDOT ROW PROGRAM MANAGER8/21/18
DATE

SURVEYOR STATEMENT (ROW PLAN)

I, Maria M. McOmber, a professional land surveyor licensed in the State of Colorado, do hereby state to the Colorado Department of Transportation that based upon my knowledge, information and belief, research, calculations and evaluation of the survey evidence were performed and this Right-of-Way Plan was prepared under my responsible charge in accordance with applicable standards of practice defined by Colorado Department of Transportation publications. This statement is not a guaranty or warranty, either expressed or implied.

PLS No. 24961

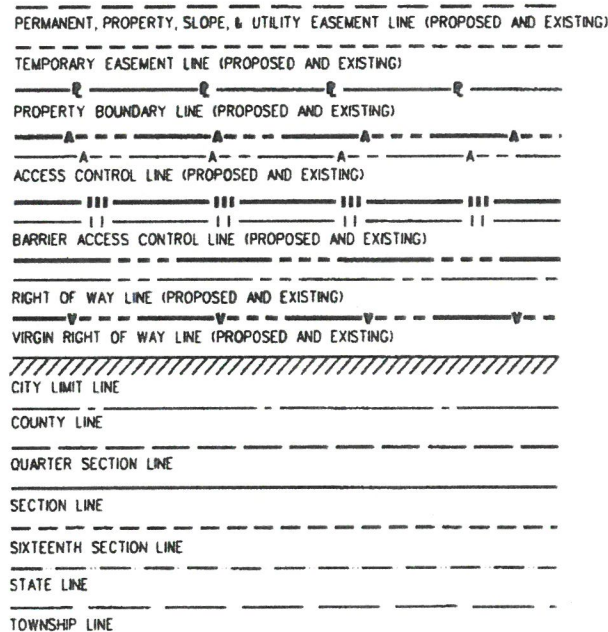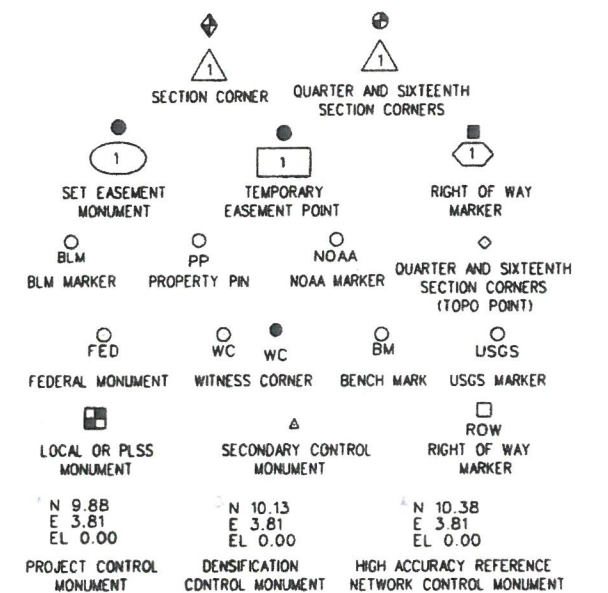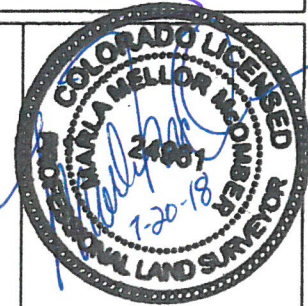

SURVEY/ROW


 
TOP OF CUT

TOE OF FILL


TERRAIN

Note: For a complete listing of symbology used within this set of plans, please refer to the M-100-1 Standard Symbols of the Colorado Department of Transportation M&S Standards Publication. Existing topo features are shown as screened weight (gray scale). Proposed or new features are shown as full weight without screening, except as noted with the word (proposed).

PROJECT LOCATION MAP

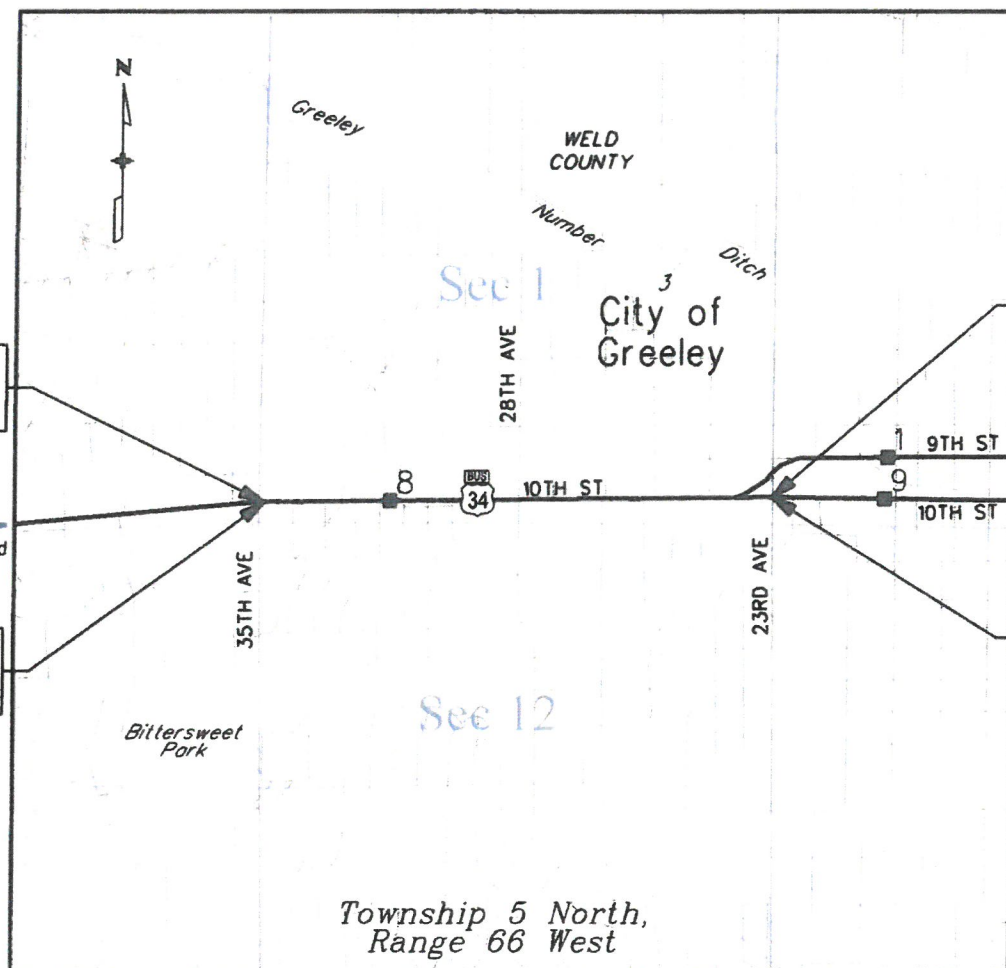End ROW Project
Station: 64+50.00
M.P.: 8.76End Const Project
Station: 64+50.00
M.P.: 8.76Township 5 North,
Range 66 West

 PROJECT LOCATION MAP



CDOT

CO

10601 W. 10th Street

Greeley, CO 80634

Phone: 970-350-2161

Region 4 Right of Way

PTS

Sheet Revisions

Date	Description	Initials
mm/dd/yy	XXXXXXXX	XXX

Sheet Revisions

Date	Description	Initials

Sheet Revisions

Date	Description	Initials

JACOBS™

707 17th Street, Suite 2400

Denver, Colorado 80202

Phone: 303-820-5240

Fax: 303-820-5298

Right of Way Plans

Tabulation of Properties

Project Number: AQC M570-048

Project Location: US 34 BUSINESS & 10TH STREET

Project Code: 20389

Last Mod. Date: 03-07-2017

Subset: 2.01 of 2.09

Sheet No.: 2.01

R.O.W. TABULATION OF PROPERTIES IN WELD COUNTY U.S. NO. 34 BUS

Book and Page No. And/Or Reception No.

Title Commitment No.

Remarks

Parcel No.	Ownership Name and Mailing Address	Site Address	Location	Area In Square Feet (Acres)							
				Area Of Parcel	Existing ROW	Net Area	Remainder Left	Remainder Right			
			Township 5 North, Range 66 West								
RW-1	Solo Sailor, LLC, a South Dakota Limited Liability company	1000 35TH AVE GREELEY, CO	Part of LOTS 1 & 2, BLOCK 1 HUNTER HEIGHTS	591 (0.014)		591 (0.014)		16,239 (0.373)		F0533611 Am-2	new owner
	3685 Sturgis Road	PN-095912209017									
	Rapid City, SD 57702										
TE-1	same as above	same as above	same as above	1,078 (0.025)		1,078 (0.025)					for construction of roadway facilities
RW-2	West Greeley Associates, LLC	3485 W 10TH ST	A part of the SW 1/4, Sec.1	5,966 (0.137)		5,966 (0.137)	148,646 (3.412)			F0532018 Am-2	
	2850 MCCLELLAND DR STE 1600	GREELEY, CO									
	FORT COLLINS, CO 80525-2580	PN-095901318024									
TE-2	same as above	same as above	same as above	9,252 (0.212)		9,252 (0.212)					for construction of roadway facilities
RW-3	1001 34TH AVE LLC	1001 34TH AVE	LOT 1, BLOCK 1	2,591 (0.059)		2,591 (0.059)		9,109 (0.209)		F0533585 Am-2	
	17595 N AVELINO DR	GREELEY, CO	MARCH ADD TO HUNTER HEIGHTS								
	MARICOPA, AZ 85138-4980	PN-095912209015									
TE-3	same as above	same as above	same as above	925 (0.021)		925 (0.021)					for construction of roadway facilities
RW-4	MICHAEL CRUZ	1000 34TH AVE	LOT 1, BLOCK 2	2,493 (0.057)		2,493 (0.057)		9,207 (0.211)		F0533581 Am-2	
	1000 34TH AVE	GREELEY, CO	MARCH ADD TO HUNTER HEIGHTS								
	GREELEY, CO 80634-5329	PN-095912208001									
TE-4A	same as above	same as above	same as above	436 (0.010)		436 (0.010)					for construction of roadway facilities
TE-4B	same as above	same as above	same as above	202 (0.005)		202 (0.005)					for construction of roadway facilities
RW-5	DWIGHT O. MASON and	1001 33RD AVE AB	LOT 19, BLOCK 2	2,105 (0.048)		2,105 (0.048)		8,695 (0.200)		F0533584 Am-2	
	DOROTHY M. MASON	GREELEY, CO	1ST ADD to HUNTER HEIGHTS								
	3318 W 4TH ST RD	PN-095912208014									
	GREELEY, CO 80634-5519										
TE-5	same as above	same as above	same as above	678 (0.016)		678 (0.016)					for construction of roadway facilities

11/16/2017 2:43:16 PM K:\WVXY\6401-Greeley_10thStreet\20389\ROW_Survey\Drawings\20389\ROW_TabProp201.dgn

Rodden\AC

11/16/2017 RoddenAC 2:43:16 PM K:\WVXY\6401-Greeley_10thStreet\20389\ROW_Survey\Drawings\20389ROW_TabProp201.dgn

CDOT

CO

10601 W. 10th Street
Greeley, CO 80634
Phone: 970-350-2161

Region 4 Right of Way

PTS

Sheet Revisions

Date	Description	Initials
8/31/17	rev RW-10 del TE-10	acr
10/31/17	rev RW-9 TE-9	acr
11/16/17	del RW-8 RW-10rev	acr

Sheet Revisions

Date	Description	Initials

Sheet Revisions

Date	Description	Initials

JACOBS™

707 17th Street, Suite 2400
Denver, Colorado 80202
Phone: 303-820-5240
Fax: 303-820-5298

Right of Way Plans

Tabulation of Properties

Project Number: AQC M570-048

Project Location: US 34 BUSINESS & 10TH STREET

Project Code: 20389

Last Mod. Date: 11-16-2017

Subset: 2.02 of 2.09

Sheet No.: 2.02

R.O.W. TABULATION OF PROPERTIES IN WELD COUNTY U.S. NO. 34 BUS

Parcel No.

Ownership Name and Mailing Address

Site Address

Location

Area In Square Feet (Acres)

Area Of Parcel

Existing ROW

Net Area

Remainder Left

Remainder Right

Book and Page No. And/Or Reception No.

Title Commitment No.

Remarks

Township 5 North, Range 66 West

</

11/16/2017 2:39:04 PM k:\WVXY6401-Greeley_10thStreet\20389 ROW_Survey\Drawings\20389ROW_TabProp202.dgn



PTS

[illegible]

Right of Way Plans			
Tabulation of Properties			
Project Number: AQC M570-048			
Project Location: US 34 BUSINESS & 10TH STREET			
Project Code:	Lost Mod. Date	Subset	Sheet No.
20389	03-23-18	2 of 2 of 209	2 of 3

Remarks

Colorado Department of Transportation 10601 W. 10th Street Greeley, CO 80634 Phone: 970-350-2161 Region 4 Right of Way PTS		Sheet Revisions			Sheet Revisions			Sheet Revisions			JACOBS™ 707 17th Street, Suite 2400 Denver, Colorado 80202 Phone: 303-820-5240 Fax: 303-820-5298		Right of Way Plans									
		DateDescriptionInitials			DateDescriptionInitials			DateDescriptionInitials					Tabulation of Properties									
		03/23/18name change RW-16,TE-16jam											Project Number: AQC M570-048									
													Project Location: US 34 BUSINESS & 10TH STREET									
												Project Code: 20389		Last Mod. Date: 03-23-18		Subset: 2.04 of 2.09		Sheet No.: 2.04				
R.O.W. TABULATION OF PROPERTIES IN WELD COUNTY U.S. NO. 34 BUS																	Book and Page No. And/Or Reception No.		Title Commitment No.		Remarks	
Parcel No.	Ownership Name and Mailing Address		Site Address		Location		Area In Square Feet (Acres)															
							Area Of Parcel	Existing ROW	Net Area	Remainder Left	Remainder Right											
			Township 5 North, Range 66 West																			
RW-16	Fair Plaza Associates Limited	3025 W 10TH ST	Part of LOT 1		1,060		1,060	33,427									07151B2017					
	Partnership	GREELEY, CO	MOUNTAIN VIEW ACRES		(0.024)		(0.024)	(0.767)														
	7107 PROSPECT PL NE	PN-095901321007																				
	ALBUQUERQUE, NM 87110-4313																					
TE-16	same as above	same as above	same as above		507		507											for construction of roadway facilities				
					(0.012)		(0.012)															
RW-17	TOMAR, LLC	3018 W 10TH ST	LOTS 1, 2 & 3, BLOCK 7		778		778		17,296								F0533569 Am-2					
	225 DUNDEE AVE UNIT 9	GREELEY, CO	2ND ADD TO WILSHIRE		(0.018)		(0.018)		(0.397)													
	GREELEY, CO 80634-8802	PN-095912205014																				
TE-17	same as above	same as above	same as above		1,935		1,935											for construction of roadway facilities				
					(0.044)		(0.044)															
RW-18	GLORIA J. STONE and	3017 W 10TH ST	LOT 1		1,603		1,603	23,397									F0534558 Am-2					
	DUANE E. TORGERSON	GREELEY, CO	1ST ADD to MOUNTAIN VIEW ACRES		(0.037)		(0.037)	(0.537)														
	1051 W BUSINESS HIGHWAY 83,	PN-095901322015																				
	LOT 743 DONNA, TX 78537-7072																					
TE-18A	same as above	same as above	same as above		121		121											for construction of roadway facilities				
					(0.003)		(0.003)															
TE-18B	same as above	same as above	same as above		1,170		1,170											for construction of roadway facilities				
					(0.027)		(0.027)															
RW-19	Adonai Properties, LLC	3011 W 10TH ST	LOT 2		1,740		1,740	23,099									F0534559 Am-2					
	3011 W 10TH ST STE 107	GREELEY, CO	1ST ADD to MOUNTAIN VIEW ACRES		(0.040)		(0.040)	(0.530)														
	GREELEY, CO 80634-5300	PN-095901322016																				
TE-19	same as above	same as above	same as above		863		863											for construction of roadway facilities				
					(0.020)		(0.020)															

3/26/2018 10:05:38 AM K:\WVXY6401-Creeley_10thStreet\20389 ROW_Survey Drawings\20389ROW_TabPrp204.dgn

3/26/2018 10:05:38 AM K:\W\X\Y6401-Greeley_10thStreet\20389\ROW_Survey\Drawings\20389ROW_TabProp204.dgn MalekUA

[illegible]

Colorado Department of Transportation CDOT CO 10601 W. 10th Street Greeley, CO 80634 Phone: 970-350-2161 Region 4 Right of Way PTS		Sheet Revisions			Sheet Revisions			Sheet Revisions			JACOBS™ 707 17th Street, Suite 2400 Denver, Colorado 80202 Phone: 303-820-5240 Fax: 303-820-5298	Right of Way Plans					
		Tabulation of Properties			Project Number: AQC M570-048												
					Project Location: US 34 BUSINESS & 10TH STREET												
												Project Code:	Last Mod. Date	Subset	Sheet No.		
												20389	07-10-18	2.06 of 2.09	2.06		
R.O.W. TABULATION OF PROPERTIES IN WELD COUNTY U.S. NO. 34 BUS																	
Parcel No.	Ownership Name and Mailing Address	Site Address	Location	Area In Square Feet (Acres)					Book and Page No. And/Or Reception No.	Title Commitment No.	Remarks						
				Area Of Parcel	Existing ROW	Net Area	Remainder Left	Remainder Right									
			Township 5 North, Range 66 West														
RW-25rev	Aziz Zandi &	2525 W 10TH ST	LOTS 10 & 11, BLOCK 3	789		789	20,087			F0532156 Am-2							
	Hamideh Abdolmohammadzadeh	GREELEY, CO	1ST ADD TO HOUSTON HEIGHTS	(0.018)		(0.018)	(0.461)										
	1421 42ND AVE	PN-095901423003															
	GREELEY, CO 80634-2435																
TE-25rev	same as above	same as above	same as above	825		825					for construction of roadway facilities						
				(0.019)		(0.019)											
RW-26	Follow Thru Land &	2502 10TH ST	Part of LOT 1, BLOCK 4	1,653		1,653		10,377		F0534576 Am-2							
	Development, LLC	GREELEY, CO	1ST ADD TO WESTVIEW	(0.038)		(0.038)	(0.238)										
	PO BOX 17728	PN-095912103036															
	DENVER, CO 80217-0728																
TE-26rev	same as above	same as above	same as above	667		667					for construction of roadway facilities						
				(0.015)		(0.015)											
RW-27	FIRST CLASS SUITES, L.L.C.	2501 W 10TH ST	LOT 12, BLOCK 3	1,343		1,343	35,807			F0532158 Am-2							
	2501 W 10TH ST	GREELEY, CO	1ST ADD TO HOUSTON HEIGHTS	(0.031)		(0.031)	(0.822)										
	GREELEY, CO 80634-5250	PN-095901423017															
TE-27	same as above	same as above	same as above	4,409		4,409					for construction of roadway facilities						
				(0.101)		(0.101)											
RW-28	Westview Center, LLC	2412 10TH ST	TRACT A	7,018		7,018		91,143		F0532274 Am-2							
	2450 BROADWAY ST	GREELEY, CO	1ST ADD TO WESTVIEW	(0.161)		(0.161)	(2.092)										
	BOULDER, CO 80304-4109	PN-095912101048															
TE-28	same as above	same as above	same as above	3,594		3,594					for construction of roadway facilities						
				(0.083)		(0.083)											
RW-29	RHC MP, LLC	2439 W 10TH ST	LOT 10, BLOCK 2	794		794	20,802			F0532159 Am-2							
	200 2ND AVE STE 402	GREELEY, CO	1ST ADD TO HOUSTON HEIGHTS	(0.018)		(0.018)	(0.478)										
	SAINT PETERSBURG, FL 33701-4313	PN-095901424002															
TE-29	same as above	same as above	same as above	1,445		1,445					for construction of roadway facilities						
				(0.033)		(0.033)											

7/12/2018 8:28:07 AM k:\WVXY6401-Greeley_10thStreet\20389 ROW_Survey Drawings\20389ROW_ToeProp206.dgn Malek JA

CDOT

CO

10601 W. 10th Street
Greeley, CO 80634
Phone: 970-350-2161

Region 4 Right of Way

PTS

Date

Description

Initials

10/31/17

rev RW-32 TE-32 RW-34 TE-34

acr

Date

Description

Initials

Date

Description

Initials

Date

Description

Initials

Date

Description

Initials

Date

Description

Initials

Date

Description

Initials

Date

Description

Initials

JACOBS™

707 17th Street, Suite 2400
Denver, Colorado 80202
Phone: 303-820-5240
Fax: 303-820-5298

Project Number: AQC M570-048

Project Location: US 34 BUSINESS & 10TH STREET

Project Code: 20389

Last Mod. Date: 10-31-2017

Subset: 2.07 of 2.09

Sheet No.: 2.07

R.O.W. TABULATION OF PROPERTIES IN WELD COUNTY U.S. NO. 34 BUS

Area In Square Feet (Acres)

Area Of Parcel

Existing ROW

Net Area

Remainder Left

Remainder Right

Book and Page No. And/Or Reception No.

Title Commitment No.


Remarks

</

11/16/2017 2:51:52 PM K:\WVXY16401-Greeley_10thStreet\20389\ROW_Survey Drawings\20389ROW_TabProp207.dgn




PTS

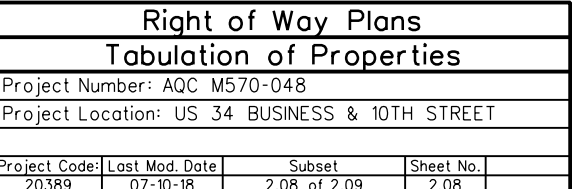[illegible]

Commitment No.



PTS

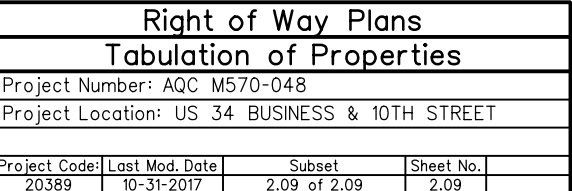[illegible]

Remarks


Sheet Revisions			Sheet Revisions			Sheet Revisions		
Date	Description	Initials	Date	Description	Initials	Date	Description	Initials
mm/dd/yy	XXXXXXXX	XXX						

Project Control Diagram			
Title Sheet			
Project Number: AQC M570-048			
Project Location: US 34 BUSINESS & 10TH STREET			
Project Code: 20389	Last Mod. Date: 03-07-2017	Subset: 3.01 of 3.03	Sheet No.: 3.01


DEPARTMENT OF TRANSPORTATION
STATE OF COLORADO

PROJECT CONTROL DIAGRAM
US Highway 34 MP 7.74 to 8.76
Section 1, Township 5 North,
Section 12, Township 5 North,
Range 66 West of the 6th Principal Meridian
County of Weld

SHEET NO.	INDEX OF SHEETS
3.01	(1) Title Sheet
3.02	(1) Coordinate Tables
3.03	(1) Plan Sheet
	(3) Total Sheets

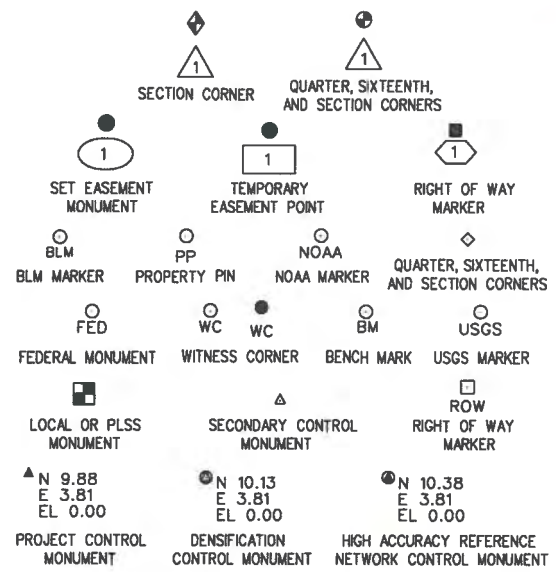

Note: For a complete listing of symbolology used within this set of plans, please refer to the M-100-1 Standard Symbols of the Colorado Department of Transportation M&S Standards Publication. Existing features are shown as screened weight (gray scale). Proposed or new features are shown as full weight without screening.

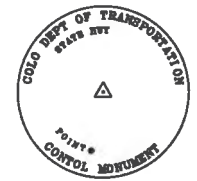


Typical Control Monument Cap
Not to Scale


CM-MP - Control Point Monuments set by CDOT. They are CDOT Type 5 monuments, a 3 1/4" dia. aluminum control monument cap (as shown) on an aluminum stem.

General Notes:

1. This Project Control Diagram is not a boundary survey of the adjoining property and is prepared for the Colorado Department of Transportation purposes only.
2. This plan set is subject to change and may not be the most current set. It is the user's responsibility to verify with CDOT that this set is the most current. The information contained on the attached drawing is not valid unless this copy bears an original signature of the Professional Land Surveyor hereon named.
3. Refer to the M-629-1 Survey Monuments of the Standard Plans found in The Colorado Department of Transportation, M & S Standards for typical survey monument descriptions.

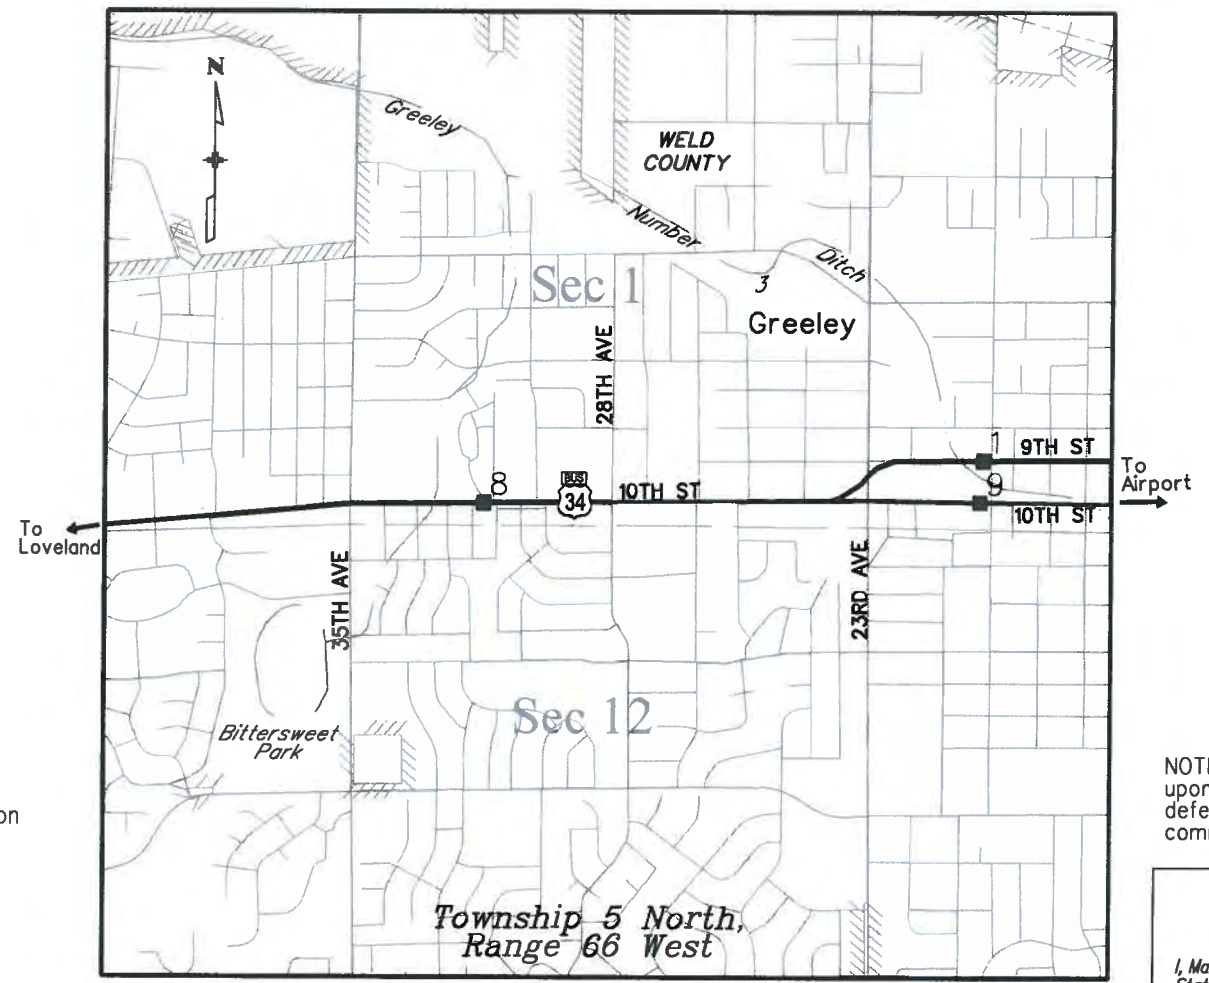

PROJECT LOCATION MAP

 

Basis of Bearings: Bearings used in the calculations of coordinates are based on a grid bearing of N74°01'49"E from CM-MP 101 to CM-MP 105. Both monuments are CDOT TYPE 5 set in concrete. The survey data was obtained from a Global Positioning System (GPS) survey base on the Colorado High Accuracy Reference Network (CHARN).

Basis of Elevations: Project elevations are based on NGS Control Point "RULLI 1995", PID: AB2125, a standard horizontal control disk set on top of a concrete monument, with a NAVD 88 elevation of 4791 feet. Orthometric height was established using GPS observations and a high-resolution geoid model.

COORDINATE DATUM: Project coordinates are modified Colorado State Plane North Zone NAD '83/(11) coordinates. The combined elevation/scale factor used to modify the coordinates from state plane to project coordinates is 1.00026470. The resulting project coordinates were not truncated. The CHARN is based on the NAD '83/(11) datum.
Project Coordinates - Northing US Survey Feet = (State Plane Coordinate Northing * 1.00026470) * (3937/1200).
Project Coordinates - Easting US Survey Feet = (State Plane Coordinate Easting * 1.00026470) * (3937/1200).

NOTICE: According to Colorado law you must commence any legal action based upon any defect in this survey within three years after you first discover such defect. In no event may any action based upon any defect in this survey be commenced more than ten years from the date of the certification shown hereon.

SURVEYOR STATEMENT (PROJECT CONTROL DIAGRAM)

I, Marla M. McOmber, a professional land surveyor licensed in the State of Colorado, do hereby state to the Colorado Department of Transportation this Project Control Diagram was prepared and the field survey it represents was performed under my responsible charge and, based upon my knowledge, information and belief is in accordance with applicable standards of practice defined by Colorado Department of Transportation publications. This statement is not a guaranty or warranty, either expressed or implied.

PLS No. 24961



10601 W. 10th Street
Greeley, CO 80634
Phone: 970-350-2161

Region 4 Right of Way

PTS

Sheet Revisions


Date	Description	Initials
mm/dd/yy	XXXXXXXX	XXX

Sheet Revisions

Date	Description	Initials

Sheet Revisions

Date	Description	Initials

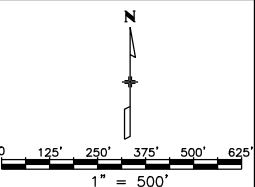

Project Control Diagram


Plan Sheet

Project Number: AQC M570-048
Project Location: US 34 BUSINESS & 10TH STREET

Project Code:	Last Mod. Date	Subset	Sheet No.
20389	03-07-2017	3.03 of 3.03	3.03

T.5N., R.66W., 6th P.M.

T.5N., R.65W., 6th P.M.

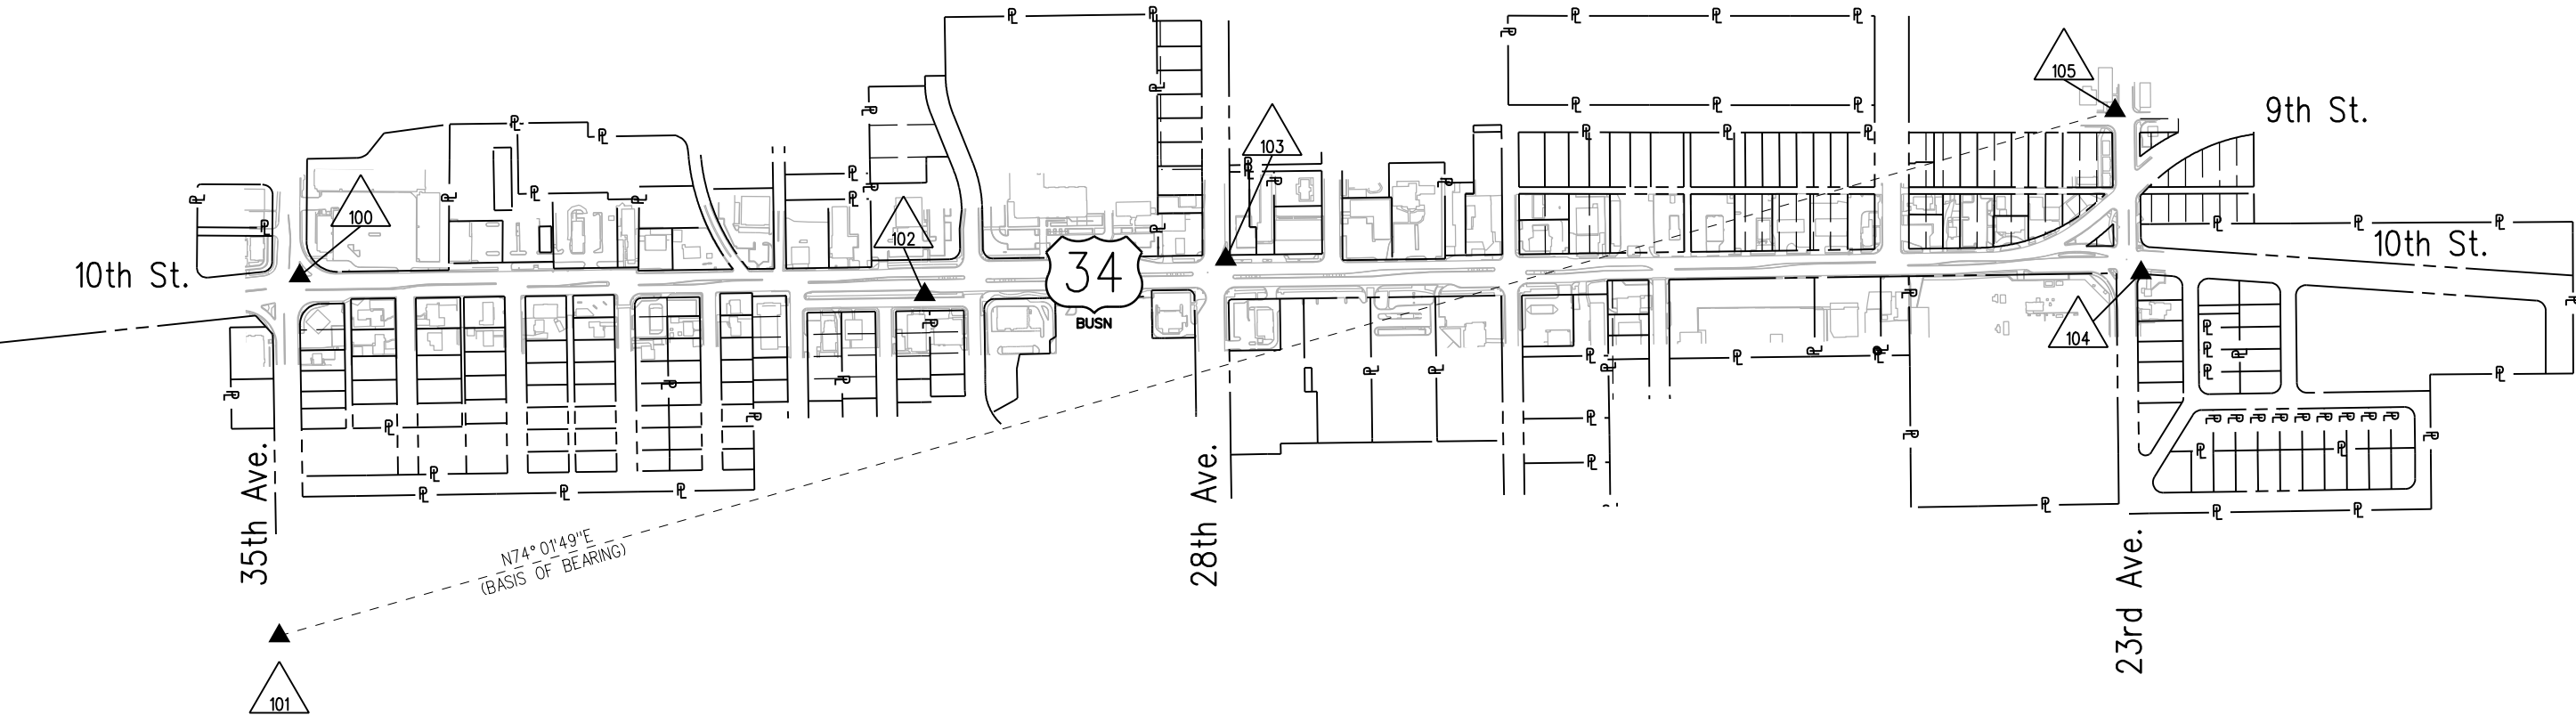



10601 W. 10th Street
Greeley, CO 80634
Phone: 970-350-2161

Region 4 Right of Way

PTS

Sheet Revisions

Date	Description	Initials
mm/dd/yy	XXXXXXXX	XXX

Sheet Revisions

Date	Description	Initials

Sheet Revisions

Date	Description	Initials

Land Survey Control Diagram

Title Sheet

Project Number: AQC M570-048
Project Location: US 34 BUSINESS & 10TH STREET


Project Code:	Last Mod. Date:	Subset:	Sheet No.:
20389	03-07-2017	4.01 of 4.03	4.01

DEPARTMENT OF TRANSPORTATION STATE OF COLORADO

LAND SURVEY CONTROL DIAGRAM

US Highway 34 MP 7.74 to 8.76
Section 1, Township 5 South,
Section 12, Township 5 South,
Range 66 West of the 6th Principal Meridian
County of Weld


SHEET NO.	INDEX OF SHEETS
4.01	(1) Title Sheet
4.02	(1) Monument Coordinate Tables
4.03	(1) Plan Sheet
	(3) Total Sheets

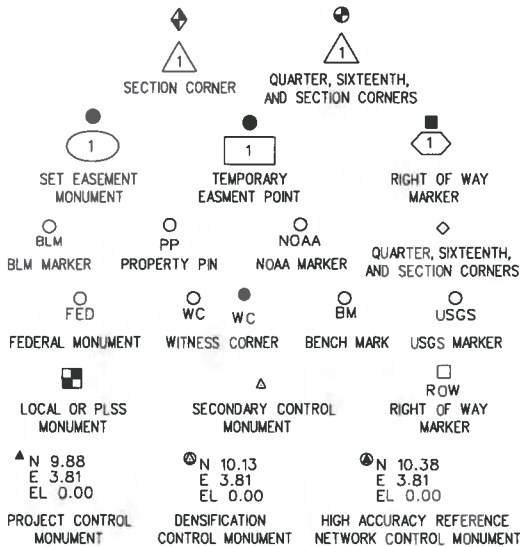

Note: For a complete listing of symbology used within this set of plans, please refer to the M-100-1 Standard Symbols of the Colorado Department of Transportation M&S Standards Publication. Existing features are shown as screened weight (gray scale). Proposed or new features are shown as full weight without screening.

General Notes:

1. This Land Survey Control Diagram is not a boundary survey of the adjoining property and is prepared for the Colorado Department of Transportation purposes only. No determination has been made to determine if the found monuments as shown are in their proper position or if they are at the corners they are intended to monument.
2. Title policy, title commitment, and title research are not part of this survey, therefore easements, rights, and restrictions of record were not researched and are not shown on this diagram. The verification of the physical evidence with relation to easements, rights of ways, property boundaries, and restrictions, as described in the instruments of record, were not included in this controlsurvey.
3. This plan set is subject to change and may not be the most current set. It is the user's responsibility to verify with CDOT that this set is the most current. The information contained on the attached drawing is not valid unless this copy bears an original signature of the Professional Land Surveyor hereon named.
4. Refer to the M-629-1 Survey Monuments of the Standard Plans found in The Colorado Department of Transportation, M & S Standards for typical survey monument descriptions.

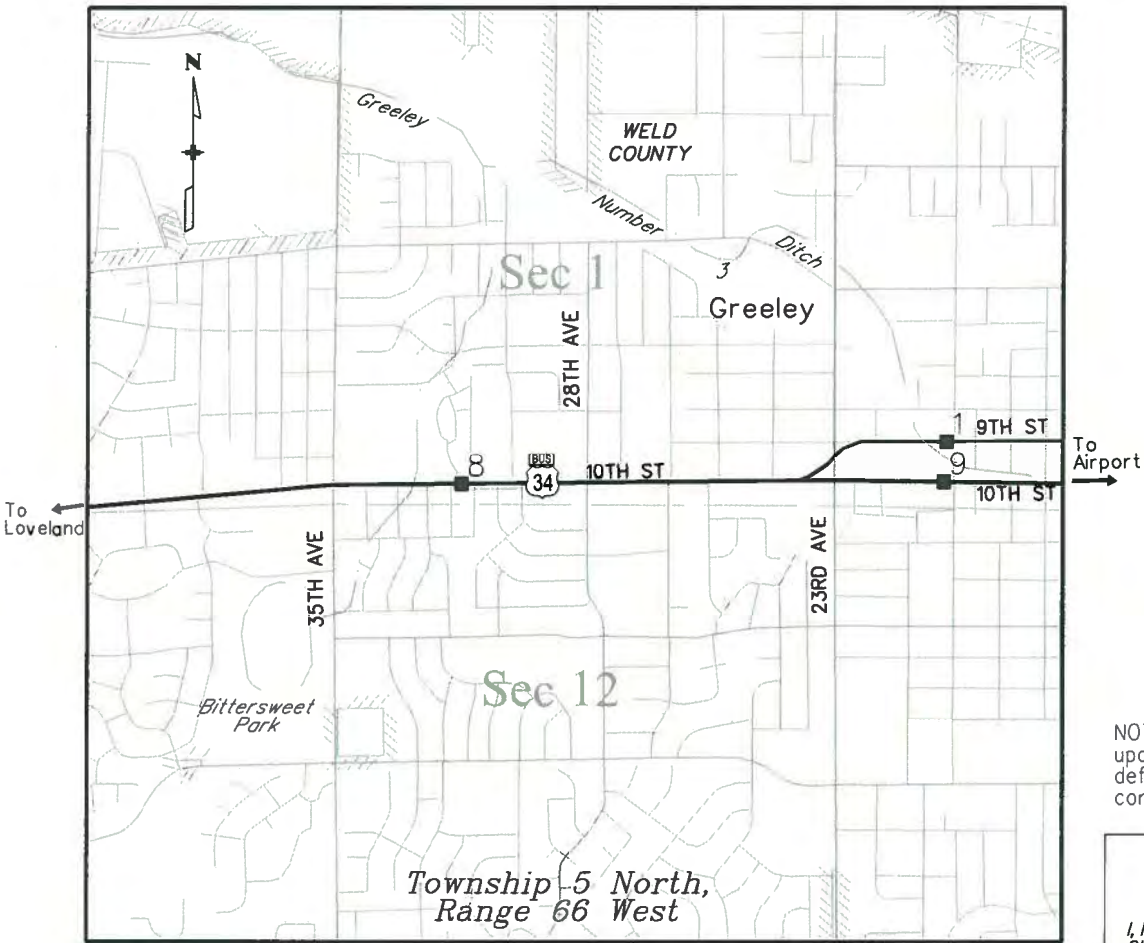

PROJECT LOCATION MAP

0' 1000' 2000' 4000'
Lineal Units = U.S. Survey Feet
Scale : 1"=2000'

Basis of Bearings: Bearings used in the calculations of coordinates are based on a grid bearing of N74°01'49"E from CM-MP 101 to CM-MP 105. Both monuments are CDOT TYPE 5 set in concrete. The survey data was obtained from a Global Positioning System (GPS) survey base on the Colorado High Accuracy Reference Network (CHARN).

Basis of Elevations: Project elevations are based on NGS ControlPoint "RULLI 1995", PID: AB2125, a standard horizontal control disk set on top of a concrete monument, with a NAVD 88 elevation of 4791 feet. Orthometric height was established using GPS observations and a high-resolution geoid model.

COORDINATE DATUM: Project coordinates are modified Colorado State Plane North Zone NAD '83(11) coordinates. The combined elevation/scale factor used to modify the coordinates from state plane to project coordinates is 1.00026470. The resulting project coordinates were not truncated. The CHARN is based on the NAD '83(11) datum.

Project Coordinates - Northing US Survey Feet =
(State Plane Coordinate Northing * 1.00026470) * (3937/1200).
Project Coordinates - Easting US Survey Feet =
(State Plane Coordinate Easting * 1.00026470) * (3937/1200).

NOTICE: According to Colorado law you must commence any legal action based upon any defect in this survey within three years after you first discover such defect. In no event may any action based upon any defect in this survey be commenced more than ten years from the date of the certification shown hereon.

SURVEYOR STATEMENT (LAND SURVEY CONTROL DIAGRAM)

I, Marla M. McOmber, a professional land surveyor licensed in the State of Colorado, do hereby state to the Colorado Department of Transportation this Land Survey Control Diagram was prepared and the field survey it represents was performed under my responsible charge and, based upon my knowledge, information and belief is in accordance with applicable standards of practice defined by Colorado Department of Transportation publications. This statement is not a guaranty or warranty, either expressed or implied.

PLS No. 24961





10601 W. 10th Street
Greeley, CO 80634
Phone: 970-350-2161

Region 4 Right of Way

PTS

Sheet Revisions

Date	Description	Initials
mm/dd/yy	XXXXXXXX	XXX

Sheet Revisions

Date	Description	Initials

Sheet Revisions

Date	Description	Initials

JACOBS™

707 17th Street, Suite 2400
Denver, Colorado 80202
Phone: 303-820-5240
Fax: 303-820-5298

Land Survey Control Diagram

Monument Coordinate Tables

Project Number: AQC M570-048

Project Location: US 34 BUSINESS & 10TH STREET

Project Code:	Last Mod. Date	Subset	Sheet No.
20389	03-07-2017	4.02 of 4.03	4.02



FOUND ALIQUOT MONUMENT COORDINATE TABLE

Point No.	Northing(ft)	Easting(ft)	Description
1001	1400850.19	3216465.19	(C1/4 SEC. 1) 2.25" ALUM CAP IN RANGE BOX - ILLEGIBLE
1002	1400889.29	3219130.31	(E1/4 SEC. 1) 3.25" ALUM CAP - JONES 1997 LS22098
1003	1395269.60	3219188.09	(E1/4 SEC. 12) 3.25" ALUM CAP - MERRICK & CO 2015 PLS 33200
1004	1400811.09	3213801.06	(W1/4 SEC. 1) 3.25" ALUM CAP IN RANGE BOX - JONES 2005 LS22098
1005	1398217.17	3216471.31	(S1/4 SEC. 1) 3.25" ALUM CAP IN RANGE BOX - JONES 1998 LS22098
1006	1398255.33	3219159.38	(SE SEC. 1) 3.25" ALUM CAP IN RANGE BOX - JONES 1997 LS22098

○
PP

FOUND BOUNDARY MONUMENT COORDINATE TABLE

Point No.	Northing(ft)	Easting(ft)	Description
1101	1398446.21	3218771.66	#3 REBAR
1102	1398625.99	3218971.17	#8 REBAR
1103	1398434.21	3216864.56	ORANGE PLASTIC CAP #4 REBAR - ILLEGIBLE
1104	1398222.59	3214805.13	#4 REBAR
1105	1398228.89	3214557.03	#4 REBAR
1106	1398228.88	3214557.17	YELLOW PLASTIC CAP #4 REBAR - ILLEGIBLE
1107	1398224.20	3214250.27	2" ALUM CAP - ILLEGIBLE
1108	1398448.87	3214553.85	#4 REBAR IN ASPHALT
4000	1398550.12	3213835.79	1.5" ALUM CAP FLUSH - M+M LS14647
4001	1398226.40	3214396.42	1" DISK IN ASPHALT- LS 22098
4002	1398228.79	3215237.57	YELLOW PLASTIC CAP - ILLEGIBLE
4003	1398227.16	3215126.33	1" DISK IN CONCRETE - 33202
4004	1398156.74	3215043.10	1" DISK IN ASPHALT- ILLEGIBLE
4005	1398158.08	3215133.56	1" DISK IN ASPHALT- LS 35619
4006	1398148.31	3215136.96	#4 REBAR IN ASPHALT
4007	1398126.87	3213944.37	2.5" PIPE FLUSH
4008	1397990.00	3213816.22	#4 REBAR AT BACK OF WALK
4010	1398053.50	3214154.12	2" PIPE IN WALK FLUSH
4011	1398023.98	3216308.83	#4 REBAR
4012	1397978.70	3216027.71	PK-NAIL STEM IN ASPHALT
4013	1397965.32	3217823.83	BLUE PLASTIC CAP IN ASPHALT - ILLEGIBLE
4014	1398046.54	3217823.79	YELLOW PLASTIC CAP - KSI LS
4015	1398046.34	3217822.76	#4 REBAR IN ASPHALT
4016	1398196.33	3217820.96	PK-NAIL STEM IN CONCRETE
4017	1398202.30	3218245.72	1.25" DISK AND NAIL - KSI LS 22098
4018	1398205.22	3218439.22	#4 REBAR IN ASPHALT FLUSH
4019	1398205.17	3218522.62	2" ANGLE IRON IN 6" CONCRETE BASE FLUSH
4020	1398214.92	3219128.73	1" BRASS CAP FLUSH - 1"WC EAST 33200
4021	1397540.73	3219135.65	1" BRASS PLUG - LS 33200
4022	1398136.94	3219322.09	#4 REBAR
4023	1398445.35	3219098.45	2" ALUM CAP - ILLEGIBLE
4024	1398297.77	3218821.84	1.5" PIPE
4025	1398288.52	3218671.94	#4 REBAR
4026	1398285.63	3218622.29	#4 REBAR
4027	1398284.09	3218422.06	YELLOW PLASTIC CAP - NORTHERN PLS 14823
4028	1398282.80	3218343.15	YELLOW PLASTIC CAP - NORTHERN PLS 14823
4029	1398280.88	3218233.10	YELLOW PLASTIC CAP - ILLEGIBLE
4030	1398279.16	3218123.12	CUT "+" IN CONCRETE
4031	1398276.27	3217865.19	#4 REBAR PLASTIC CAP - ILLEGIBLE
4032	1398272.58	3217646.80	#4 REBAR
4033	1398168.79	3217498.63	CUT "x" IN CONCRETE PAN
4034	1398065.33	3213815.18	YELLOW PLASTIC CAP IN CONCRETE - CO LS 18458
4035	1398125.91	3213874.82	#4 REBAR
4036	1398309.94	3213834.31	1.5" ALUM CAP - M+M LS14647
4037	1398211.72	3213724.63	CUT "x" TOP OF CURB
4038	1398119.09	3213740.76	CUT "x" TOP OF CURB
10012	1398392.22	3216454.99	#4 REBAR

Colorado Department of Transportation



10601 W. 10th Street
Greeley, CO 80634
Phone: 970-350-2161

Region 4 Right of Way

PTS

Sheet Revisions

Date	Description	Initials
mm/dd/yy	XXXXXXXX	XXX


Sheet Revisions

Date	Description	Initials

Sheet Revisions

Date	Description	Initials

 N



Land Survey Control Diagram

Plan Sheet


Project Number: AQC M570-048

Project Location: US 34 BUSINESS & 10TH STREET

Project Code:	Last Mod. Date	Subset	Sheet No.
20389	03-07-2017	4.03 of 4.03	4.03

T.5N., R.66W., 6th P.M.

T.5N., R.65W., 6th P.M.

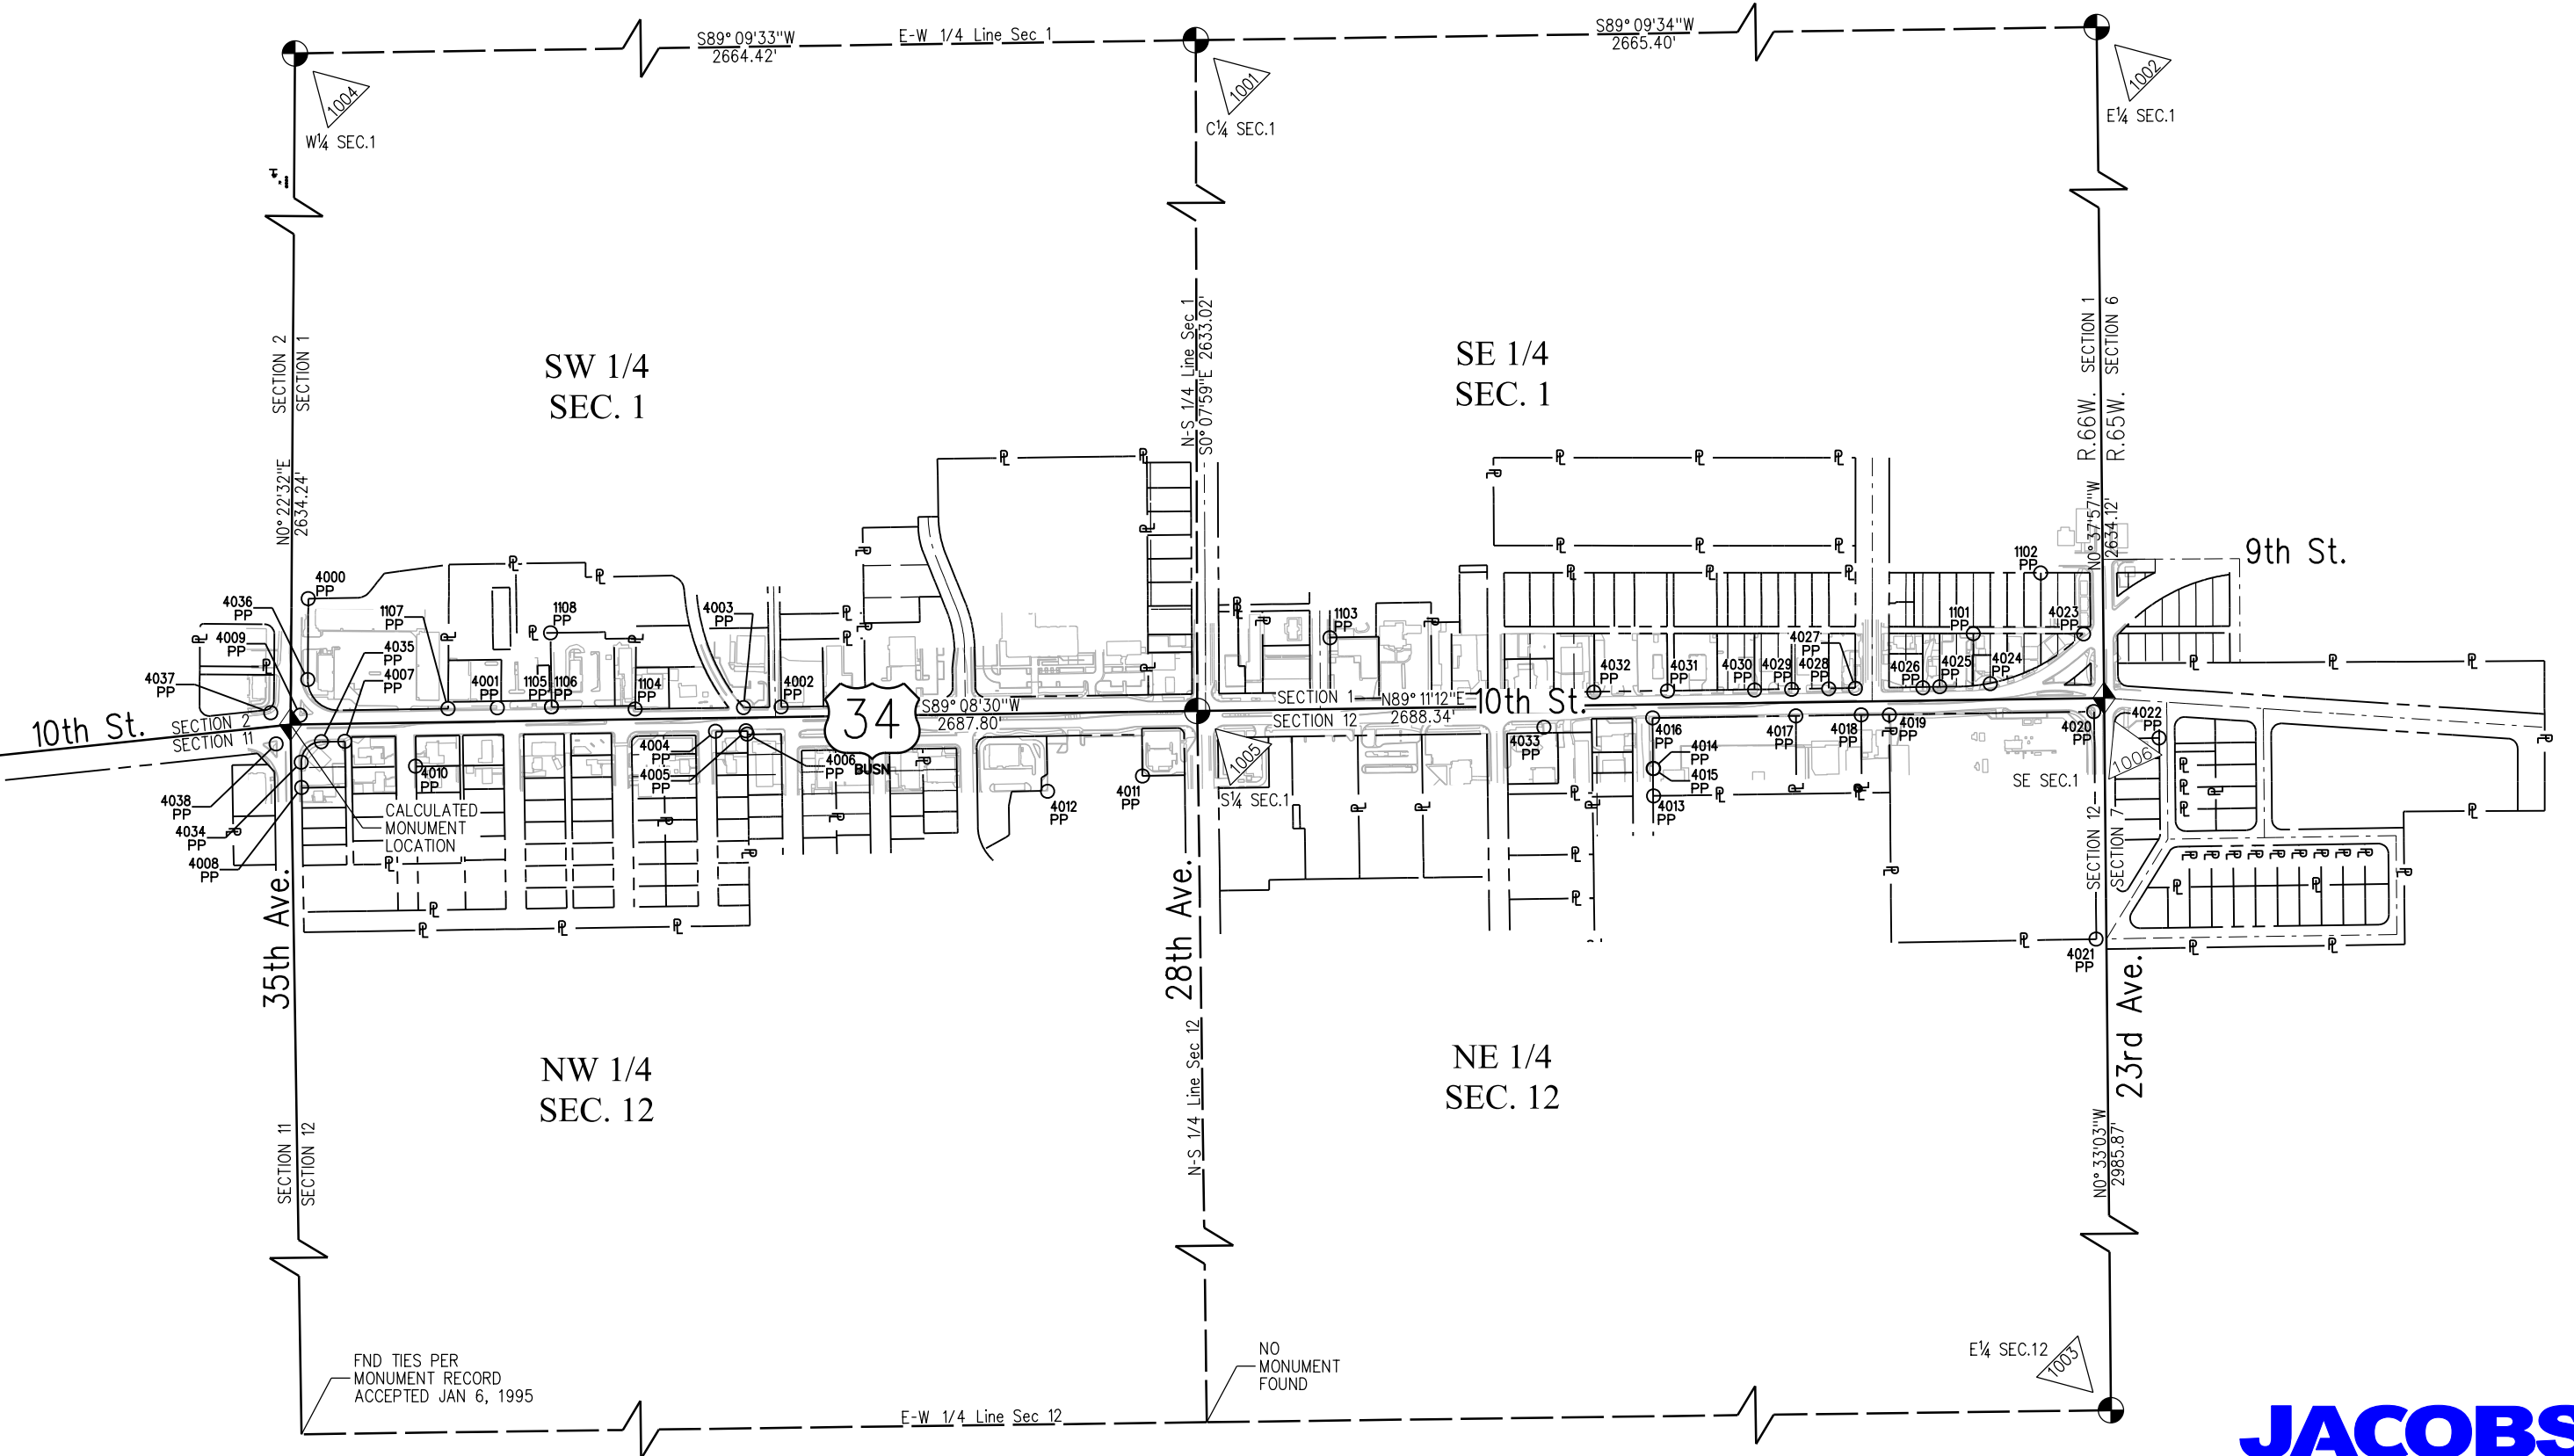

JACOBS

7/12/2018 Malek JA 8:30:14 AM K:\WVXY6401-Greeley_10thStreet_20389\ROW_Survey Drawings\20389ROW_Mon501.dgn



Colorado Department of Transportation

10601 W. 10th Street
Greeley, CO 80634
Phone: 970-350-2161

Region 4 Right of Way

PTS

Sheet Revisions		
Date	Description	Initials
8/31/17	rev 257,260 del 261-264	acr
10/31/17	rev 261-264, 373, 376	acr
11/16/17	del 244, 246, 257, 260, 380-384	
	rev 357, 358, 379	acr
03/23/18	del 282, rev 292	jam
05/10/18	rev 340,341	jam
07/10/18	rev 357,379,382-385	jam

Sheet Revisions		
Date	Description	Initials

Sheet Revisions		
Date	Description	Initials



707 17th Street, Suite 2400
Denver, Colorado 80202
Phone: 303-820-5240
Fax: 303-820-5298

Right of Way Plans Monumentation Sheet			
Project Number: AQC M570-048			
Project Location: US 34 BUSINESS & 10TH STREET			
Project Code: 20389	Last Mod. Date: 07-10-18	Subset: 5.01 of 5.03	Sheet No.: 5.01

TABULATION OF R.O.W. MONUMENTS TO BE SET					
Point No.	Northing(ft)	Easting(ft)	Description	Station	Offset
201	1398120.443	3213944.680	RW-1	12+10.05	57.78
202	1398121.166	3213941.702	RW-1	12+07.09	57.01
203	1398121.077	3213933.782	RW-1	11+99.16	56.99
204	1398115.517	3213928.346	RW-1	11+93.65	62.47
205	1398115.206	3213907.594	RW-1	11+72.89	62.48
206	1398120.439	3213902.241	RW-1	11+67.62	57.17
207	1398119.658	3213850.154	RW-1	11+15.52	57.20
211	1398237.413	3214250.782	RW-2	15+17.81	-54.77
215	1398269.473	3213843.828	RW-2	11+11.36	-92.69
217	1398229.765	3213909.017	RW-2	11+75.97	-52.04
218	1398230.624	3213966.351	RW-2	12+33.31	-52.08
219	1398242.416	3213983.975	RW-2	12+51.10	-63.61
220	1398243.886	3214082.098	RW-2	13+49.23	-63.67
221	1398235.113	3214097.294	RW-2	13+64.30	-54.68
222	1398122.113	3213964.657	RW-3	12+30.05	56.40
225	1398051.569	3214095.751	RW-3	13+60.12	128.82
226	1398051.504	3214091.387	RW-3	13+55.75	128.82
227	1398123.995	3214090.278	RW-3	13+55.69	56.32
228	1398125.907	3214284.636	RW-4	15+50.05	57.21
229	1398123.990	3214156.643	RW-4	14+22.04	57.29
230	1398079.644	3214157.321	RW-4	14+22.08	101.64
231	1398079.614	3214155.329	RW-4	14+20.09	101.64
234	1398127.557	3214294.612	RW-5	15+60.05	55.71
237	1398103.357	3214414.996	RW-5	16+80.07	81.64
238	1398103.294	3214410.741	RW-5	16+75.82	81.64
239	1398110.610	3214403.425	RW-5	16+68.61	74.22
240	1398124.132	3214403.219	RW-5	16+68.60	60.69
241	1398131.812	3214378.350	RW-5	16+43.84	52.66
242	1398130.670	3214302.158	RW-5	15+67.64	52.70
243	1398127.637	3214299.952	RW-5	15+65.39	55.70
244	deleted				
245	1398241.993	3213875.500	RW-2	11+42.63	-64.75
246	deleted				
252	1398242.006	3214557.375	RW-9rev, TE-9rev	18+24.43	-54.95
253	1398244.582	3214729.319	RW-9rev, TE-9rev	19+96.40	-55.05
254	1398234.674	3214802.321	RW-11	20+69.25	-44.09
257	deleted				

TABULATION OF R.O.W. MONUMENTS TO BE SET					
Point No.	Northing(ft)	Easting(ft)	Description	Station	Offset
260	deleted				
261	1398242.197	3214570.134	RW-9rev, TE-9rev	18+37.19	-54.96
262	1398239.660	3214567.672	RW-9rev, TE-9rev	18+34.70	-52.45
263	1398239.610	3214564.357	RW-9rev, TE-9rev	18+31.38	-52.45
264	1398242.072	3214561.820	RW-9rev, TE-9rev	18+28.88	-54.95
265	1398141.998	3214811.020	RW-12A, TE-12	20+76.61	48.70
266	1398137.332	3214811.087	RW-12A	20+76.61	53.37
267	1398133.433	3214798.096	RW-12A	20+63.57	57.08
269	1398132.300	3214984.620	RW-12B	22+50.06	60.90
270	1398135.776	3214979.583	RW-12B	22+45.07	57.35
271	1398144.818	3214979.465	RW-12B	22+45.08	48.31
279	1398238.733	3215073.239	RW-14	23+40.20	-44.25
282	deleted				
283	1398139.961	3215055.797	RW-15rev TE-15rev	23+21.33	54.26
284	1398134.662	3215044.591	RW-15rev TE-15rev	23+10.05	59.40
287	1398241.179	3215203.094	RW-16	24+70.07	-44.83
290	1398239.881	3215116.458	RW-16	23+83.43	-44.77
295	1398119.156	3215238.533	RW-17	25+03.75	77.69
296	1398119.049	3215231.033	RW-17	24+96.25	77.69
299	1398142.581	3215230.697	RW-17	24+96.25	54.16
303	1398241.203	3215238.097	RW-18	25+05.07	-44.35
304	1398242.673	3215336.243	RW-18	26+03.23	-44.40
305	1398244.173	3215336.221	RW-18	26+03.23	-45.90
306	1398246.437	3215487.297	RW-19	27+54.32	-45.99
308	1398160.001	3216426.823	RW-20	36+92.51	53.96
309	1398158.207	3216307.078	RW-20	35+72.75	54.03
316	1398274.038	3216865.667	RW-21	41+32.95	-53.74
317	1398268.097	3216882.204	RW-21	41+49.40	-47.57
318	1398261.285	3216882.245	RW-21	41+49.34	-40.75
319	1398262.461	3216965.137	RW-21	42+32.24	-40.74
320	1398263.708	3216966.574	RW-21	42+33.70	-41.96
321	1398264.032	3216989.395	RW-21	42+56.52	-41.96
322	1398262.827	3216990.907	RW-21	42+58.01	-40.73
323	1398266.097	3217165.699	RW-22	44+32.83	-41.48
325	1398267.033	3217165.693	TE-22B	44+32.84	-42.42
326	1398269.079	3217309.802	RW-23	45+76.97	-42.39
327	1398276.078	3217309.703	RW-23	45+76.97	-49.39

TABULATION OF R.O.W. MONUMENTS TO BE SET					
Point No.	Northing(ft)	Easting(ft)	Description	Station	Offset
328	1398276.377	3217330.755	RW-23	45+98.02	-49.39
329	1398291.645	3217330.663	RW-23	45+98.15	-64.65
330	1398291.657	3217332.663	RW-23	46+00.15	-64.64
335	1398277.617	3217382.749	RW-24	46+50.03	-49.88
336	1398277.855	3217399.545	RW-24	46+66.83	-49.87
337	1398275.884	3217400.926	RW-24	46+68.18	-47.88
338	1398276.865	3217469.998	RW-24	47+37.26	-47.87
339	1398279.390	3217472.432	RW-24	47+39.73	-50.36
340	1398280.516	3217551.795	RW-25rev TE-25rev	48+19.10	-50.34
341	1398278.760	3217554.894	RW-25rev TE-25rev	48+22.17	-48.54
344	1398283.164	3217865.107	RW-27	51+32.42	-48.48
346	1398180.765	3217640.513	RW-26 TE-25rev	49+06.37	50.67
349	1398172.611	3217761.155	RW-26	50+26.88	60.57
350	1398177.021	3217749.916	RW-26	50+15.71	55.99
351	1398182.317	3217749.841	RW-26	50+15.71	50.70
353	1398179.929	3217828.148	RW-28	50+93.97	54.21
354	1398177.041	3217821.105	RW-28	50+86.89	57.00
358	1398187.106	3218439.485	RW-33 TE-33 RW-35rev TE-35rev	57+05.35	55.84
359	1398187.088	3218438.191	RW-33	57+04.06	55.84
360	1398188.566	3218436.660	RW-33	57+02.55	54.34
364	1398283.447	3217885.106	RW-29	51+52.42	-48.48
365	1398285.386	3218021.665	RW-30	52+88.99	-48.45
366	1398283.619	3218031.085	RW-30	52+98.38	-46.55
367	1398284.617	3218101.359	RW-30	53+68.66	-46.53
368	1398286.969	3218112.022	RW-30	53+79.36	-48.73
373	1398289.985	3218324.511	RW-32rev, TE-32rev	55+91.87	-48.69
376	1398286.309	3218333.298	RW-32rev, TE-32rev	56+00.60	-44.88
377	1398287.065	3218386.548	RW-34rev, TE-34rev	56+53.86	-44.87
378	1398284.404	3218389.317	RW-34rev, TE-34rev	56+56.59	-42.17
379	1398190.789	3218560.701	RW-36Arev TE36rev	58+26.61	53.90
380	deleted				
381	deleted				
382	1398187.263	3218451.409	RW-35rev TE-35rev	57+17.28	55.85
383	1398189.331	3218454.036	RW-35rev TE-35rev	57+19.93	53.82
384	1398190.267	3218522.495	RW-35rev TE-35rev RW-36Arev TE-36rev	57+88.40	53.87
386	1398214.907	3219129.767	RW-36Arev	63+95.96	37.98
387	1398110.036	3219130.776	RW-36Arev	63+95.46	142.85

QUANTITY OF MONUMENTS TO BE SET

CAP TYPE	MONUMENT TYPE									
	1	1A	2	2A	3	3A	4	5	5(S)	6
REFERENCE										
ROW	121									
CONTROL										
ALIQUOT CORNER										
PERMANENT EASEMENT										
PROJECT POINTS										
WITNESS POST (REQUIRED)										

General Notes:

1. All centerline and offset stationing may not represent the centerline as constructed in the field.

2. Refer to the M-629-1 Survey Monuments of the Standard Plans found in The Colorado Department of Transportation, M & S Standards for survey monument descriptions.

3. This plan set is subject to change and may not be the most current set. It is the user's responsibility to verify with CDOT that this set is the most current. The information contained on the attached drawing is not valid unless this copy bears an original signature of the Professional Land Surveyor hereon named.

COORDINATE DATUM: Project coordinates are modified Colorado State Plane North Zone NAD '83/(11) coordinates. The combined elevation/scale factor used to modify the coordinates from state plane to project coordinates is 1.00026470. The resulting project coordinates were not truncated. The CHARN is based on the NAD '83(11) datum.

Project Coordinates - Northing US Survey Feet =
(State Plane Coordinate Northing * 1.00026470) * (3937/1200).

Project Coordinates - Easting US Survey Feet =
(State Plane Coordinate Easting * 1.00026470) * (3937/1200).

NOTICE: According to Colorado law you must commence any legal action based upon any defect in this survey within three years after you first discover such defect. In no event may any action based upon any defect in this survey be commenced more than ten years from the date of the certification shown hereon.

SURVEYOR STATEMENT (R.O.W. MONUMENTS)

I, Marla M. McOmber, a professional land surveyor licensed in the State of Colorado, do hereby state to the Colorado Department of Transportation that based upon my knowledge, information and belief, adequate research, calculations and evaluation of survey evidence were performed and the Right-of-Way monuments depicted on this Right-of-Way Plan were set under my responsible charge in accordance with applicable standards of practice defined by Colorado Department of Transportation publications. This statement is not a guaranty or warranty, either expressed or implied.

PLS No. 24961

Colorado Department of Transportation



10601 W. 10th Street
Greeley, CO 80634
Phone: 970-350-2161

Region 4 Right of Way

PTS

Sheet Revisions

Date	Description	Initials
8/31/17	del 2035-2037, 2052, 2053	acr
10/31/17	rev 374, 403, 404	acr
11/16/17	del 247, 248, 258, 259 rev 385	acr
03/23/18	rev 286, 292	jam
07/10/18	rev 386-394, 357, 385, 2035-2037, del 395, 416, 2140-2144	jam

Sheet Revisions

Date	Description	Initials

Sheet Revisions

Date	Description	Initials



707 17th Street, Suite 2400
Denver, Colorado 80202
Phone: 303-820-5240
Fax: 303-820-5298

Right of Way Plans

Monumentation Sheet

Project Number: AQC M570-048			
Project Location: US 34 BUSINESS & 10TH STREET			
Project Code: 20389	Last Mod. Date: 07-10-18	Subset: 5.02 of 5.03	Sheet No.: 5.02

■
xxx

TABULATION OF R.O.W. MONUMENTS TO BE SET					
Point No.	Northing(ft)	Easting(ft)	Description	Station	Offset
388	1398119.408	3219110.115	RW-36Arev	63+74.94	133.18
389	1398128.811	3219110.063	RW-36Arev	63+75.02	123.78
390	1398198.209	3219037.943	RW-36Arev	63+03.91	53.35
391	1398196.851	3218826.001	RW-36Arev	60+91.97	51.66
392	1398205.120	3218820.524	RW-36Arev	60+86.61	43.31
393	1398197.777	3218693.709	RW-36Arev	59+59.70	48.83
394	1398193.719	3218561.327	RW-36Arev	58+27.28	50.98
395	deleted				
399	1398289.607	3218521.994	RW-37	57+89.33	-45.46
402	1398292.021	3218685.344	RW-39rev, TE-39rev	59+52.69	-45.53
403	1398292.618	3218714.514	RW-39rev, TE-39rev	59+81.87	-45.70
404	1398289.021	3218714.565	RW-39rev, TE-39rev	59+81.87	-42.11
407	1398353.389	3218972.019	RW-41	62+40.22	-102.76
408	1398367.315	3218992.337	RW-41	62+60.74	-116.39
410	1398405.334	3219042.033	RW-41	63+10.98	-153.69
411	1398439.214	3219081.834	RW-41	63+51.26	-187.00
412	1398446.427	3219094.757	RW-41	63+64.29	-194.02
415	1398265.063	3217092.879	RW-22	43+60.01	-41.50
416	deleted				

○
xxxx

TABULATION OF R.O.W. POINTS FOR INFORMATION					
Point No.	Northing(ft)	Easting(ft)	Description	Station	Offset
293	1398147.192	3215137.921	RW-17-EX-ROW	24+03.55	48.21
294	1398148.693	3215238.110	RW-17	25+03.75	48.16
300	1398244.575	3215363.061	RW-18, RW-19	26+30.07	-45.92
301	1398230.577	3215363.271	RW-18, RW-19	26+30.08	-31.92
302	1398228.704	3215238.285	RW-18	25+05.08	-31.85
307	1398232.438	3215487.516	RW-19	27+54.34	-31.99
310	1398164.707	3216306.999	RW-20	35+72.76	47.53
311	1398166.279	3216411.971	RW-20	36+77.75	47.47
313	1398263.256	3217010.480	RW-21, RW-22	42+77.59	-40.88
314	1398254.831	3217010.531	RW-21, RW-22	42+77.52	-32.45
315	1398252.777	3216865.796	RW-21	41+32.77	-32.48
324	1398257.035	3217165.754	RW-22	44+32.76	-32.42
331	1398269.406	3217332.798	RW-23	45+99.96	-42.39
332	1398280.185	3217528.444	RW-24 RW-25rev	47+95.75	-50.35
333	1398272.185	3217528.484	RW-24-EX-ROW-RW-25rev	47+95.67	-42.35
334	1398270.117	3217382.794	RW-24	46+49.96	-42.38
342	1398280.088	3217648.446	RW-25rev TE-25rev RW-27	49+15.73	-48.52
343	1398273.888	3217648.477	RW-25rev-EX-ROW-RW-27	49+15.67	-42.32
345	1398276.963	3217865.143	RW-27	51+32.36	-42.28
347	1398193.764	3217640.346	RW-26	49+06.39	37.67
348	1398195.477	3217761.010	RW-26	50+27.07	37.70
352	1398185.857	3218245.780	RW-28, RW-33	55+11.65	54.30
355	1398196.329	3217820.982	RW-28	50+87.05	37.71
356	1398202.357	3218245.676	RW-28, RW-33	55+11.78	37.80
357	1398205.107	3218439.371	RW-33 RW-35rev	57+05.50	37.84
361	1398285.264	3218013.098	RW-29, RW-30	52+80.42	-48.45
362	1398279.064	3218013.134	RW-29, RW-30	52+80.37	-42.25
363	1398277.247	3217885.142	RW-29	51+52.36	-42.28
369	1398287.124	3218122.993	RW-30, RW-31	53+90.33	-48.73
370	1398280.624	3218122.990	RW-30, RW-31	53+90.24	-42.23
371	1398288.686	3218232.993	RW-31, TE-31, RW-32rev, TE-32rev	55+00.34	-48.70
372	1398282.185	3218232.991	RW-31, RW-32rev	55+00.25	-42.20
374	1398286.447	3218342.992	RW-32rev, TE-32rev, RW-34rev, TE-34rev	56+10.30	-44.88
375	1398283.746	3218342.992	RW-32rev, RW-34rev	56+10.26	-42.18
385	1398206.284	3218522.341	RW-35rev RW-36Arev	57+88.47	37.85
396	1398291.084	3218621.995	RW-37, RW-38	58+89.34	-45.50
397	1398287.707	3218621.994	RW-37, RW-38	58+89.29	-42.12
398	1398286.287	3218521.993	RW-37	57+89.28	-42.15
400	1398291.823	3218671.996	RW-38, TE-38, RW-39rev, TE-39rev	59+39.35	-45.52
401	1398288.417	3218671.994	RW-38, RW-39rev	59+39.29	-42.11
405	1398289.195	3218726.806	RW-39rev	59+94.11	-42.10
413	1398446.426	3219096.268	RW-41	63+65.80	-194.00
414	1398436.987	3219086.751	RW-41	63+56.15	-184.70

●
xx

TABULATION OF TEMPORARY EASEMENT POINTS TO BE STAKED					
Point No.	Northing(ft)	Easting(ft)	Description	Station	Offset
2001	1398098.359	3213945.018	TE-1	12+10.07	79.87
2002	1398098.234	3213936.631	TE-1	12+01.68	79.87
2003	1398114.433	3213856.907	TE-1	11+22.20	62.53
2004	1398119.755	3213856.569	TE-1	11+21.94	57.20
2005	1398267.277	3214008.943	TE-2	12+76.42	-88.11
2006	1398268.812	3213898.970	TE-2	11+66.48	-91.23
2007	1398235.035	3213898.750	TE-2	11+65.78	-57.46
2008	1398235.983	3213962.042	TE-2	12+29.08	-57.50
2009	1398266.577	3213962.238	TE-2	12+29.71	-88.09
2010	1398280.669	3214008.750	TE-2	12+76.42	-101.51
2011	1398282.100	3214108.138	TE-2	13+75.82	-101.51
2012	1398116.631	3214090.391	TE-3	13+55.69	63.69
2013	1398114.749	3213964.769	TE-3	12+30.06	63.76
2014	1398118.848	3214284.744	TE-4A	15+50.06	64.27
2015	1398117.923	3214223.041	TE-4A	14+88.35	64.31
2016	1398124.983	3214222.933	TE-4A	14+88.34	57.25
2017	1398124.418	3214185.263	TE-4B	14+50.67	57.27
2018	1398117.359	3214185.371	TE-4B	14+50.67	64.33
2019	1398116.930	3214156.750	TE-4B	14+22.05	64.35
2020	1398129.665	3214350.379	TE-5	16+15.84	54.40
2021	1398119.833	3214350.537	TE-5	16+15.86	64.23
2022	1398118.997	3214294.743	TE-5	15+60.06	64.27
2023	1398246.262	3214407.848	TE-6, TE-7	16+74.98	-61.36
2024	1398105.425	3213912.304	TE-1	11+77.46	72.33
2025	1398247.910	3214250.849	TE-6	15+18.02	-65.27
2026	1398264.075	3214407.959	TE-6, TE-7	16+75.35	-79.17
2027	1398246.849	3214447.030	TE-7	17+14.17	-61.38
2028	1398249.378	3214348.814	TE-6	16+16.00	-65.32
2029	1398257.539	3214348.696	TE-6	16+16.00	-73.48
2030	1398257.977	3214379.138	TE-6	16+46.45	-73.48
2031	1398272.469	3214378.930	TE-6	16+46.45	-87.98
2032	1398272.527	3214398.424	TE-6	16+65.94	-87.76
2033	1398250.857	3214422.870	TE-7	16+90.07	-65.74
2034	1398251.204	3214446.967	TE-7	17+14.17	-65.74
2035	1398166.193	3217685.812	TE-26rev	49+51.45	65.90
2036	1398166.100	3217679.660	TE-26rev	49+45.30	65.90
2037	1398171.928	3217673.785	TE-26rev	49+39.51	59.99
2038	1398139.687	3214903.982	TE-12	21+69.53	52.35
2039	1398128.968	3214904.142	TE-12	21+69.54	63.07
2040	1398247.612	3214557.291	TE-9rev	18+24.43	-60.56
2041	1398248.765	3214634.192	TE-9rev	19+01.34	-60.60
2042	1398267.666	3214633.920	TE-9rev	19+01.34	-79.50
2043	1398268.573	3214696.855	TE-9rev	19+64.28	-79.50
2044	1398250.517	3214697.115	TE-9rev	19+64.28	-61.45
2045	1398251.227	3214744.489	TE-9rev	20+11.66	-61.48
2046	1398250.256	3214744.497	TE-11	20+11.66	-60.50
2047	1398248.514	3214757.328	TE-11	20+24.46	-58.58
2048	1398254.694	3214757.197	TE-11	20+24.42	-64.76
2049	1398255.042	3214772.297	TE-11	20+39.52	-64.89
2050	1398246.456	3214772.495	TE-11	20+39.60	-56.30
2051	1398241.941	3214805.765	TE-11	20+72.80	-51.31
2052	deleted				
2053	deleted				

○
xxxx

TABULATION OF R.O.W. POINTS FOR INFORMATION					
Point No.	Northing(ft)	Easting(ft)	Description	Station	Offset
209	1398125.265	3213874.594	RW-1	11+40.04	51.95
210	1398126.313	3213944.590	RW-1	12+10.05	51.91
212	1398223.910	3214250.695	RW-2	15+17.53	-41.27
213	1398219.045	3213926.014	RW-2	11+92.81	-41.08
223	1398139.611	3213964.389	RW-3	12+30.03	38.90
224	1398141.559	3214094.374	RW-3	13+60.03	38.82
232	1398142.458	3214154.368	RW-4	14+20.03	38.79
233	1398144.405	3214284.353	RW-4	15+50.03	38.71
235	1398144.555	3214294.352	RW-5	15+60.03	38.71
236	1398146.352	3214414.338	RW-5	16+80.03	38.64
247	deleted				
248	deleted				
249	1398242.513	3214744.564	RW-9rev, TE-9rev, RW-11, TE-11	20+11.61	-52.76
250	1398231.310	3214744.661	RW-9rev, RW-11	20+11.55	-41.56
251	1398228.507	3214557.578	RW-9rev	18+24.44	-41.45
255	1398234.725	3214805.682	RW-11, RW-13	20+72.61	-44.09
256	1398232.224	3214805.654	RW-11	20+72.55	-41.59

Colorado Department of Transportation



10601 W. 10th Street
Greeley, CO 80634
Phone: 970-350-2161

Region 4 Right of Way

PTS

Sheet Revisions

Date	Description	Initials
8/31/17	del 2054, 2055	acr
11/16/17	del 2136, 2138	acr
03/23/18	del 2060	jam
07/10/18	rev 2112-2116, 2119, 2135-2136, 2138-2146	jam

Sheet Revisions

Date	Description	Initials

Sheet Revisions

Date	Description	Initials

JACOBS™
707 17th Street, Suite 2400
Denver, Colorado 80202
Phone: 303-820-5240
Fax: 303-820-5298

Right of Way Plans

Monumentation Sheet

Project Number: AQC M570-048			
Project Location: US 34 BUSINESS & 10TH STREET			
Project Code: 20389	Last Mod. Date: 07-10-18	Subset: 5.03 of 5.03	Sheet No.: 5.03

TABULATION OF TEMPORARY EASEMENT POINTS TO BE STAKED

Point No.	Northing(ft)	Easting(ft)	Description	Station	Offset
2054	deleted				
2055	deleted				
2056	1398245.473	3214805.805	TE-13	20+72.89	-54.84
2057	1398246.968	3214905.574	TE-13	21+72.67	-54.90
2058	1398249.196	3214905.540	TE-14	21+72.67	-57.13
2059	1398237.692	3215003.709	TE-14	22+70.66	-44.21
2060	deleted				
2061	1398133.989	3215124.464	TE-15rev	23+89.91	61.22
2062	1398125.798	3215111.818	TE-15rev	23+77.15	69.23
2063	1398125.673	3215103.443	TE-15rev	23+68.77	69.23
2064	1398136.783	3215103.197	TE-15rev	23+68.68	58.12
2065	1398136.157	3215074.920	TE-15rev	23+40.40	58.34
2066	1398134.364	3215074.959	TE-15rev	23+40.41	60.13
2067	1398134.315	3215072.745	TE-15rev	23+38.20	60.15
2068	1398126.115	3215044.722	TE-15rev	23+10.06	67.95
2069	1398240.015	3215125.394	TE-16	23+92.36	-44.78
2070	1398253.052	3215125.198	TE-16	23+92.36	-57.82
2071	1398135.582	3215230.797	TE-17	24+96.25	61.16
2072	1398134.192	3215138.042	TE-15rev TE-17	24+03.49	61.21
2073	1398242.209	3215305.223	TE-18B	25+72.21	-44.38
2074	1398259.098	3215305.000	TE-18B	25+72.23	-61.28
2075	1398259.964	3215362.830	TE-19	26+30.06	-61.31
2076	1398265.069	3215237.740	TE-18A	25+05.06	-68.21
2077	1398265.142	3215242.807	TE-18A	25+10.13	-68.21
2078	1398241.279	3215243.164	TE-18A	25+10.14	-44.35
2079	1398251.261	3215375.424	TE-19	26+42.53	-52.43
2080	1398252.936	3215487.195	TE-19	27+54.32	-52.49
2081	1398264.511	3216882.225	TE-21	41+49.37	-43.98
2082	1398265.540	3216954.725	TE-21	42+21.87	-43.97
2083	1398276.759	3216966.053	TE-21	42+33.36	-55.02
2084	1398277.123	3216991.311	TE-21	42+58.62	-55.02
2085	1398274.394	3216994.421	TE-21	42+61.69	-52.25
2086	1398274.601	3217010.412	TE-21, TE-22A	42+77.69	-52.22
2087	1398279.359	3217188.567	TE-22B	44+55.89	-54.42
2088	1398275.035	3217165.645	TE-22A	44+32.91	-50.42
2089	1398267.884	3217225.627	TE-22B, TE-23	44+92.78	-42.41
2090	1398279.034	3217165.620	TE-22B	44+32.94	-54.42
2091	1398282.392	3217225.539	TE-22B, TE-23	44+92.90	-56.92
2092	1398282.374	3217248.438	TE-23	45+15.80	-56.57
2093	1398268.212	3217248.745	TE-23	45+15.90	-42.40
2094	1398280.403	3217402.907	TE-24	46+70.22	-52.37
2095	1398281.268	3217463.825	TE-24	47+31.15	-52.36
2096	1398286.338	3217468.712	TE-24	47+36.11	-57.36
2097	1398287.185	3217528.410	TE-24	47+95.81	-57.35
2098	1398288.412	3217528.404	TE-25	47+95.82	-58.57
2099	1398288.704	3217549.003	TE-25	48+16.42	-58.57
2100	1398284.775	3217554.022	TE-25	48+21.39	-54.57
2101	1398286.115	3217648.417	TE-25	49+15.79	-54.55
2102	1398291.283	3217648.392	TE-27	49+15.84	-59.72
2103	1398291.710	3217678.441	TE-27	49+45.89	-59.71
2104	1398334.704	3217678.010	TE-27	49+46.08	-102.71
2105	1398335.032	3217700.785	TE-27	49+68.86	-102.71
2106	1398292.036	3217701.409	TE-27	49+68.86	-59.71
2107	1398292.453	3217730.781	TE-27	49+98.24	-59.70

TABULATION OF TEMPORARY EASEMENT POINTS TO BE STAKED

Point No.	Northing(ft)	Easting(ft)	Description	Station	Offset
2108	1398325.541	3217730.305	TE-27	49+98.24	-92.79
2109	1398325.976	3217760.534	TE-27	50+28.47	-92.79
2110	1398292.882	3217761.011	TE-27	50+28.47	-59.70
2111	1398294.356	3217864.896	TE-27	51+32.37	-59.67
2112	1398181.750	3217709.841	TE-26rev	49+75.71	50.69
2113	1398178.750	3217709.884	TE-26rev	49+75.71	53.69
2114	1398178.472	3217690.329	TE-26rev	49+56.15	53.68
2115	1398168.892	3217649.236	TE-26rev	49+14.92	62.67
2116	1398160.196	3217640.778	TE-26rev	49+06.34	71.25
2117	1398176.832	3218245.837	TE-28, TE-33	55+11.58	63.32
2118	1398172.771	3217836.641	TE-28	51+02.36	61.49
2119	1398175.821	3218439.557	TE-33, TE-35rev	57+05.26	67.12
2120	1398312.328	3218857.927	TE-40	61+25.55	-63.35
2121	1398127.449	3214846.401	TE-12	21+11.78	63.76
2122	1398290.991	3217885.062	TE-29	51+52.48	-56.02
2123	1398291.332	3217908.747	TE-29	51+76.17	-56.02
2124	1398295.303	3217908.690	TE-29	51+76.17	-59.99
2125	1398295.564	3218013.038	TE-30	52+80.51	-58.75
2126	1398295.754	3218026.391	TE-30	52+93.86	-58.75
2127	1398297.596	3218026.348	TE-30	52+93.85	-60.59
2128	1398295.125	3218122.996	TE-30	53+90.45	-56.73
2129	1398296.687	3218232.996	TE-31, TE-32rev	55+00.46	-56.70
2130	1398298.105	3218332.913	TE-32rev	56+00.39	-56.68
2131	1398293.887	3218342.995	TE-32rev, TE-34rev	56+10.41	-52.32
2132	1398291.389	3218348.967	TE-34rev	56+16.34	-49.74
2133	1398299.367	3218380.960	TE-34rev	56+48.45	-57.25
2134	1398291.404	3218389.249	TE-34rev	56+63.70	-42.17
2135	1398182.133	3218522.573	TE-35rev TE-36rev	57+88.36	62.01
2136	1398180.870	3218461.300	TE-35rev	57+27.07	62.39
2137	1398138.821	3214846.230	TE-12	21+11.77	52.38
2138	1398175.752	3218452.778	TE-35rev	57+18.48	67.38
2139	1398291.869	3218421.995	TE-34rev	56+89.37	-49.17
2145	1398182.435	3218558.918	TE-36rev	58+24.70	62.23
2146	1398182.207	3218526.190	TE-36rev	57+91.98	61.98
2147	1398296.288	3218521.996	TE-37	57+89.43	-52.15
2148	1398297.708	3218621.998	TE-37, TE-38	58+89.44	-52.12
2149	1398298.418	3218671.998	TE-38	59+39.44	-52.11
2150	1398300.582	3218671.999	TE-39rev	59+39.47	-54.28
2151	1398301.754	3218748.396	TE-39rev	60+15.88	-54.35
2152	1398297.967	3218768.998	TE-39rev, TE-40	60+36.43	-50.27
2153	1398291.543	3218768.995	TE-39rev, TE-40	60+36.33	-43.84
2154	1398318.848	3218872.006	TE-40, TE-41A	61+39.72	-69.66
2155	1398311.770	3218872.003	TE-40, TE-41A	61+39.62	-62.59
2156	1398303.266	3218825.258	TE-40	60+92.76	-54.76
2157	1398338.648	3218923.368	TE-41A	61+91.37	-88.72
2158	1398355.319	3218950.092	TE-41A	62+18.33	-105.01
2159	1398367.419	3218972.024	TE-41A, TE-41B	62+40.43	-116.79
2160	1398389.673	3219003.826	TE-41B	62+72.55	-138.58
2161	1398380.542	3219010.870	TE-41B	62+79.46	-129.35
2162	1398409.223	3219046.602	TE-41C	63+15.60	-157.52
2163	1398418.264	3219039.628	TE-41C	63+08.76	-166.66
2164	1398446.435	3219072.176	TE-41C	63+41.71	-194.35
2165	1398467.027	3219117.041	TE-42	63+86.87	-214.30
2166	1398626.419	3219115.281	TE-42	63+87.40	-373.70

TABULATION OF TEMPORARY EASEMENT POINTS TO BE STAKED

Point No.	Northing(ft)	Easting(ft)	Description	Station	Offset
2167	1398626.418	3219117.281	TE-42	63+89.40	-373.67
2168	1398468.989	3219119.019	TE-42	63+88.87	-216.23
2169	1398138.295	3214811.073	TE-12	20+76.61	52.40
2170	1398142.346	3214814.443	TE-12	20+80.04	48.40
2171	1398140.818	3214979.517	TE-12	22+45.08	52.31
2172	1398243.909	3214250.820	TE-6	15+17.94	-61.27
2173	1398245.617	3214250.834	TE-2	15+17.98	-62.97
2174	1398130.198	3214383.577	TE-5	16+49.04	54.35
2175	1398274.990	3217040.491	TE-22A	43+07.77	-52.18
2176	1398287.864	3217040.202	TE-22A	43+07.66	-65.06
2177	1398288.069	3217059.624	TE-22A	43+27.09	-64.98
2178	1398273.651	3217068.183	TE-22A	43+35.44	-50.44
2179	1398274.050	3217096.291	TE-22A	43+63.55	-50.44
2180	1398301.047	3217095.903	TE-22A	43+63.55	-77.44
2181	1398301.674	3217139.403	TE-22A	44+07.05	-77.44
2182	1398274.849	3217152.557	TE-22A	44+19.82	-50.42
2183	1398246.382	3214866.454	TE-13	21+33.54	-54.87
2184	1398250.685	3214866.392	TE-13	21+33.54	-59.18
2185	1398251.185	3214901.120	TE-13	21+68.28	-59.18
2186	1398246.902	3214901.182	TE-13	21+68.28	-54.89
2187	1398249.705	3214939.528	TE-14	22+06.66	-57.15
2188	1398251.251	3214939.540	TE-14	22+06.69	-58.69
2189	1398251.994	3214987.691	TE-14	22+54.85	-58.74
2190	1398135.456	3215222.399	TE-17	24+87.86	61.16
2191	1398116.272	3215222.676	TE-17	24+87.86	80.35
2192	1398115.518	3215155.123	TE-17	24+20.30	80.13
2193	1398134.448	3215155.085	TE-17	24+20.53	61.20
2194	1398259.784	3215350.791	TE-18B	26+18.02	-61.30



10601 W. 10th Street
Greeley, CO 80634
Phone: 970-350-2161

Sheet Revisions

Date	Description	Initials
mm/dd/yy	XXXXXXXX	XXX

Sheet Revisions

Date	Description	Initials

Sheet Revisions

Date	Description	Initials




Right of Way Plans

Plan Sheet

Project Number: AQC M570-048
Project Location: US 34 BUSINESS & 10TH STREET

Project Code:	Last Mod. Date	Subset	Sheet No.
20389	03-07-2017	7.01 of 7.14	7.01

T.5N., R.66W., 6th P.M.

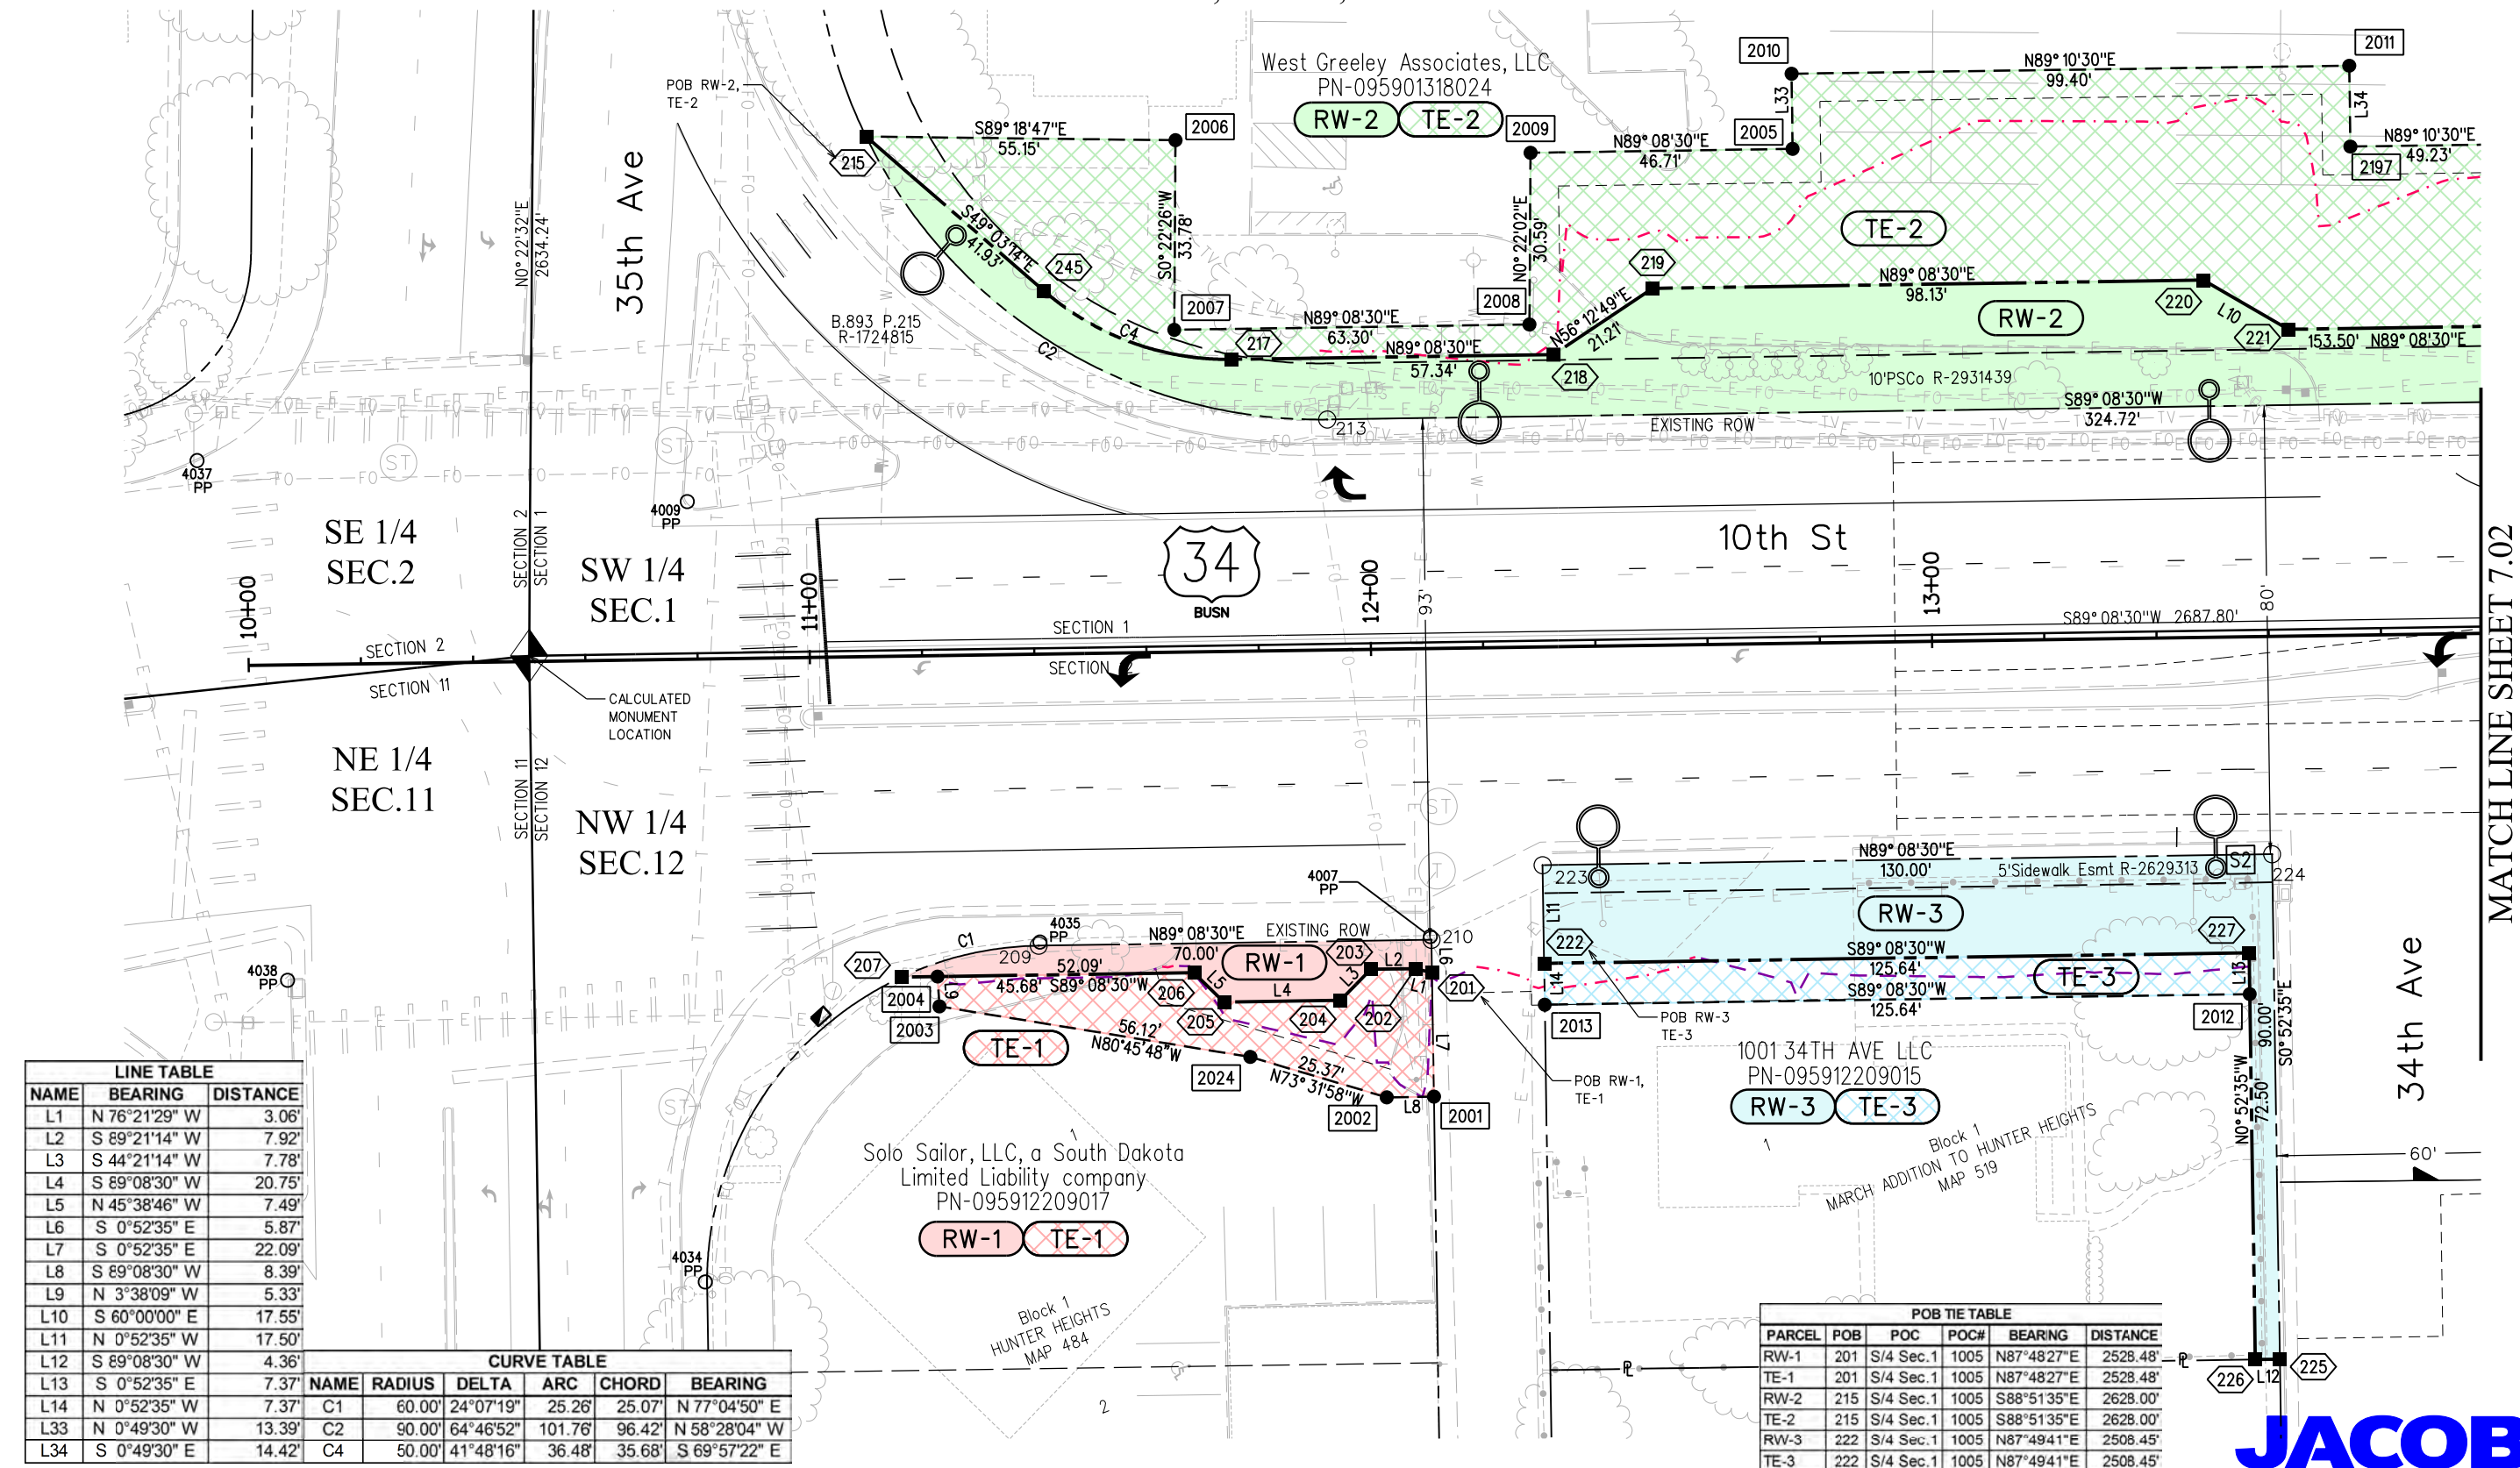



10601 W. 10th Street
Greeley, CO 80634
Phone: 970-350-2161

Region 4 Right of Way

PTS

Sheet Revisions

Date	Description	Initials
8/31/17	rev RW-10 del TE-10	acr
10/31/17	rev RW-9 TE-9	acr
11/16/17	del RW-8 RW-10rev	acr

Sheet Revisions

Date	Description	Initials

Sheet Revisions

Date	Description	Initials

Right of Way Plans

Plan Sheet

Project Number: AQC M570-048
Project Location: US 34 BUSINESS & 10TH STREET

Project Code:	Last Mod. Date	Subset	Sheet No.
20389	11-16-2017	7.03 of 7.14	7.03

NAME	RADIUS	DELTA	ARC	CHORD	BEARING
C5	20.00'	45°36'36"	15.92'	15.50'	N 56°27'57" E
C6	20.00'	9°52'15"	3.45'	3.44'	N 84°12'23" E

SW 1/4
SEC.1

Tommy Loufas and Dina Loufas, Trustees of
the Loufas Living Trust dated March 13, 1994
PN-095901318038

T.5N., R.66W., 6th P.M.

PARCEL	POB	POC	POC#	BEARING	DISTANCE
RW-8	deleted				
RW-9rev	249	S/4 Sec.1	1005	S89°09'33"E	1726.93'
TE-9rev	249	S/4 Sec.1	1005	S89°09'33"E	1726.93'
RW-10rev	deleted				
TE-10	deleted				
RW-11	249	S/4 Sec.1	1005	S89°09'33"E	1726.93'
TE-11	249	S/4 Sec.1	1005	S89°09'33"E	1726.93'
RW-12A	265	S/4 Sec.1	1005	N87°24'27"E	1661.99'
TE-12	265	S/4 Sec.1	1005	N87°24'27"E	1661.99'
RW-13	276	S/4 Sec.1	1005	S89°18'10"E	1565.69'
TE-13	276	S/4 Sec.1	1005	S89°18'10"E	1565.69'
RW-14	276	S/4 Sec.1	1005	S89°18'10"E	1565.69'
TE-14	276	S/4 Sec.1	1005	S89°18'10"E	1565.69'

NAME	BEARING	DISTANCE	NAME	BEARING	DISTANCE
L38	deleted		L49	N 0°49'30" W	18.90'
L39	S 0°51'30" E	10.72'	L50	S 0°49'30" E	18.06'
L40	N 0°51'30" W	11.37'	L51	S 0°29'40" E	8.71'
L41	N 0°49'30" W	4.30'	L52	N 89°08'30" E	3.36'
L42	S 0°49'30" E	4.28'	L53	S 0°39'06" W	2.50'
L43	N 89°08'30" E	4.39'	L54	N 0°29'40" W	7.74'
L44	N 0°26'51" E	1.55'	L55	S 82°16'16" E	12.95'
L45	S 0°29'40" E	11.20'	L56	N 1°13'13" W	6.18'
L46	N 0°51'36" W	13.50'	L57	N 88°40'49" E	15.10'
L47	S 82°16'16" E	15.39'	L58	S 1°19'11" E	8.59'
L48	N 0°51'36" W	5.61'	L59	S 0°39'06" W	7.22'

Nateron, LLC
PN-095901318030

RW-14 TE-14

TE-14

RW-14

TE-14

RW-14

TE-14

NAME	BEARING	DISTANCE	NAME	BEARING	DISTANCE
L60	N 44°08'30" E	3.54'	L69	deleted	
L61	N 89°08'30" E	3.32'	L70	S 0°49'30" E	4.67'
L62	S 45°51'30" E	3.54'	L71	S 73°17'36" W	13.56'
L63	N 89°08'30" E	4.45'	L72	N 0°49'30" W	3.70'
L64	deleted		L78	S 0°51'30" E	12.50'
L65	deleted		L79	N 0°39'06" E	12.50'
L66	deleted		L80	N 0°39'06" E	10.75'
L67	deleted		L81	S 0°51'30" E	10.75'
L68	deleted		L82	N 0°51'30" W	12.97'

JACOBS



10601 W. 10th Street
Greeley, CO 80634
Phone: 970-350-2161

Region 4 Right of Way

PTS

Sheet Revisions

Date	Description	Initials
03/23/18	rev RW-15, TE-15, name change RW-16, TE-16	jam


Sheet Revisions

Date	Description	Initials

Sheet Revisions

Date	Description	Initials

 N



Right of Way Plans

Plan Sheet


Project Number: AQC M570-048
Project Location: US 34 BUSINESS & 10TH STREET

Project Code	Last Mod. Date	Subset	Sheet No.
20389	03-23-18	7.04 of 7.14	7.04

LINE TABLE			LINE TABLE			LINE TABLE			CURVE TABLE					
NAME	BEARING	DISTANCE	NAME	BEARING	DISTANCE	NAME	BEARING	DISTANCE	NAME	RADIUS	DELTA	ARC	CHORD	BEARING
L73	S 0°44'49" E	4.00'	L91	S 1°16'09" E	1.79'	L105	N 0°51'30" W	12.50'	C7	635.00'	1°23'52"	15.49'	15.49'	S 37°03'53" E
L74	N 55°23'26" W	6.12'	L92	S 88°43'51" W	2.21'	L106	N 0°51'30" W	1.50'	C9	600.00'	1°35'12"	16.61'	16.61'	N 39°22'22" W
L75	N 0°44'49" W	9.04'	L93	S 73°41'23" W	29.20'	L107	N 0°51'30" W	23.87'						
L76	N 89°08'30" E	4.96'	L94	N 0°52'35" W	8.55'	L108	N 89°10'30" E	5.07'						
L77	S 0°52'35" E	12.59'	L95	S 0°51'30" E	13.00'	L109	S 0°51'19" E	23.87'						
L83	S 64°41'36" W	12.40'	L96	N 0°51'30" W	13.04'	L110	N 0°45'24" W	16.89'						
L84	S 0°19'46" E	16.00'	L97	N 0°19'46" W	6.00'	L111	S 0°51'30" E	15.39'						
L85	S 0°42'37" E	7.00'	L98	S 89°10'47" W	7.50'	L112	S 55°21'08" E	15.31'						
L86	S 89°08'30" W	13.58'	L101	N 0°49'13" W	23.53'	L116	S 89°08'30" W	8.40'						
L87	S 57°04'15" W	15.07'	L102	S 0°49'13" E	7.00'	L117	S 89°08'30" W	17.04'						
L88	S 89°08'30" W	8.38'	L103	N 0°42'37" W	7.00'	L118	S 89°08'30" W	5.07'						
L89	N 1°16'09" W	11.11'	L104	S 0°51'30" E	14.00'	L119	N 89°26'51" E	11.94'						
L90	S 88°43'51" W	28.28'												

T.5N., R.66W., 6th P.M.

PARCEL	POB	POC	POC#	BEARING	DISTANCE
RW-12B	269	S/4 Sec.1	1005	N86°43'57"E	1489.11'
RW-15rev	292	S/4 Sec.1	1005	N86°44'18"E	1335.51'
TE-15rev	292	S/4 Sec.1	1005	N86°44'18"E	1335.51'
RW-16	287	S/4 Sec.1	1005	S88°54'56"E	1268.44'
TE-16	287	S/4 Sec.1	1005	S88°54'56"E	1268.44'
RW-17	292	S/4 Sec.1	1005	N86°44'18"E	1335.51'
TE-17	292	S/4 Sec.1	1005	N86°44'18"E	1335.51'
TE-18A	303	S/4 Sec.1	1005	S88°53'01"E	1233.44'
RW-18	300	S/4 Sec.1	1005	S88°35'01"E	1108.58'
TE-18B	300	S/4 Sec.1	1005	S88°35'01"E	1108.58'
RW-19	300	S/4 Sec.1	1005	S88°35'01"E	1108.58'
TE-19	300	S/4 Sec.1	1005	S88°35'01"E	1108.58'

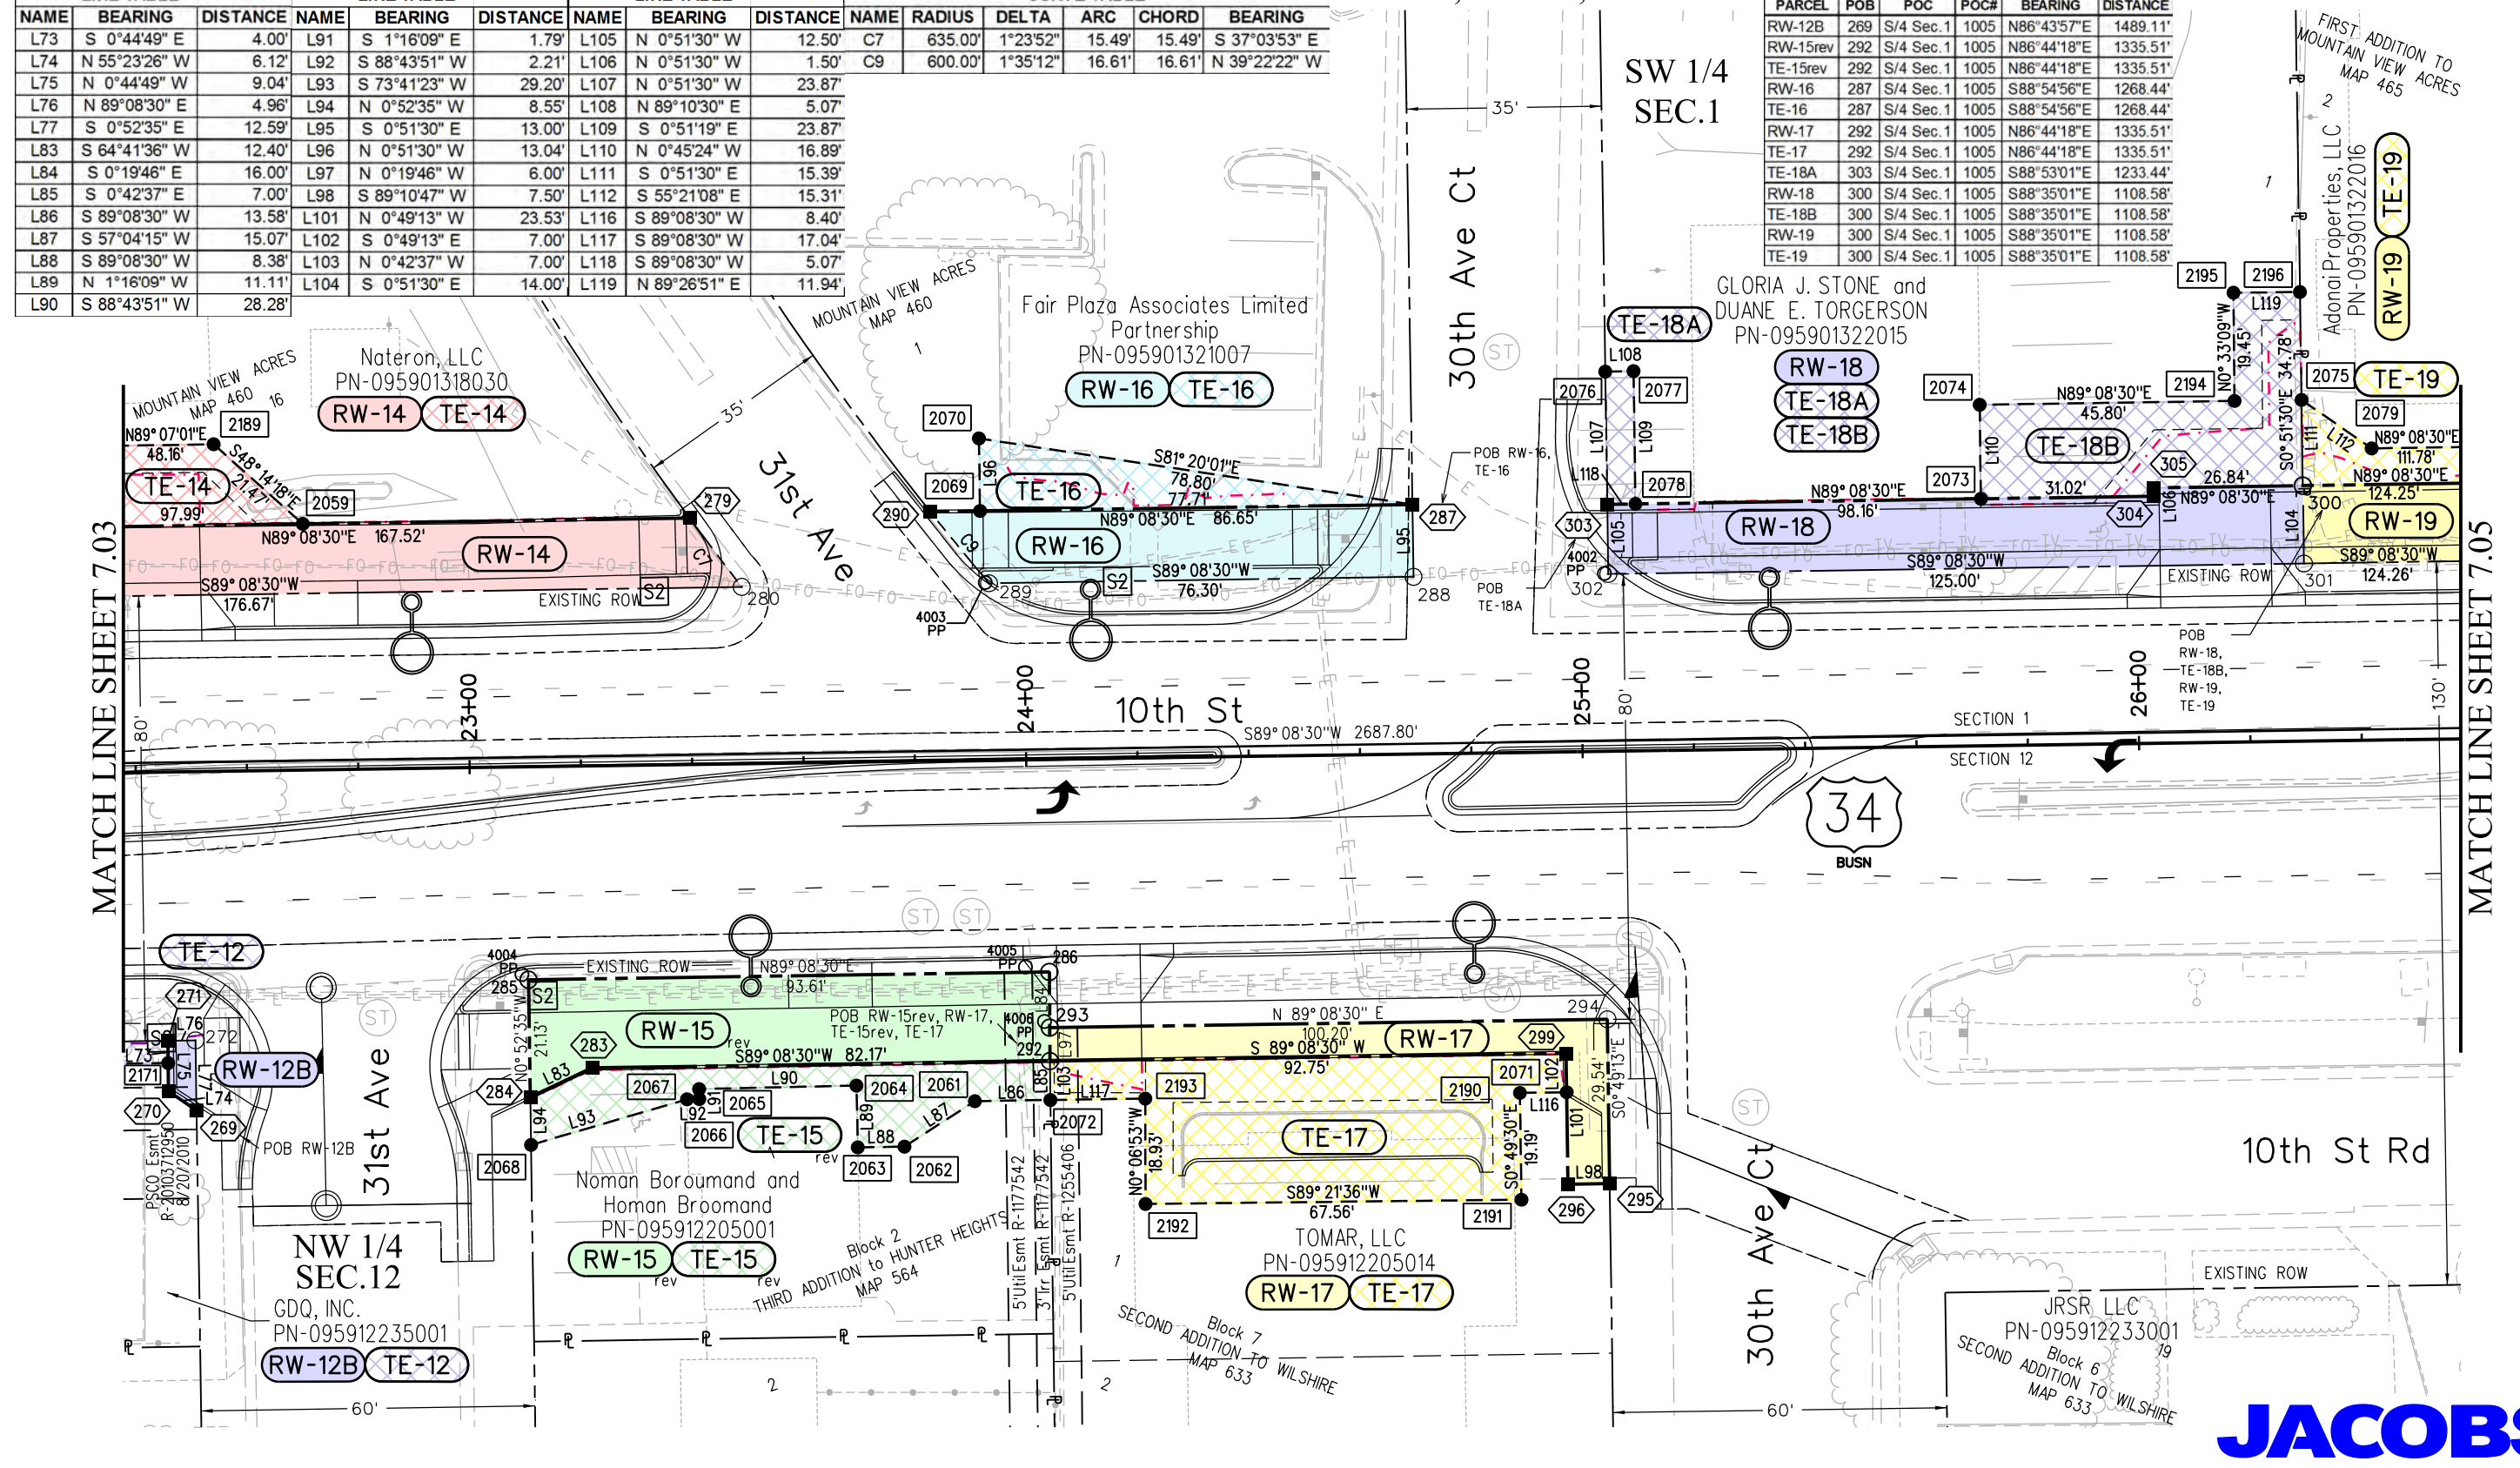

JACOBS



10601 W. 10th Street
Greeley, CO 80634
Phone: 970-350-2161

Sheet Revisions


Date	Description	Initials
mm/dd/yy	XXXXXXXX	XXX

Sheet Revisions

Date	Description	Initials

Sheet Revisions

Date	Description	Initials

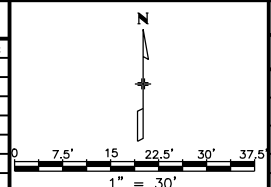

Right of Way Plans

Plan Sheet

Project Number: AQC M570-048
Project Location: US 34 BUSINESS & 10TH STREET

Project Code:	Last Mod. Date	Subset	Sheet No.
20389	03-07-2017	7.05 of 7.14	7.05

LINE TABLE		
NAME	BEARING	DISTANCE
L113	S 0°53'50" E	14.00'
L114	S 0°53'50" E	6.50'

SW 1/4
SEC.1

T.5N., R.66W., 6th P.M.

B.1229 P.466
R-19481035284 6/23/1948
THE FRANKLIN PIPE LINE COMPANY
(blanket agreement)

Adonai Properties, LLC
PN-095901322016

RW-19 TE-19

FIRST ADDITION TO
MOUNTAIN VIEW ACRES
MAP 465

MILLENNIUM LLC
PN-095901331001

Block 1
GREELEY POLICE HEADQUARTERS
SUBDIVISION SECOND FILING
MAP 18469


10'Util.Esmt R-20073525150

EXISTING ROW

30th Ave

MATCH LINE SHEET 7.04

MATCH LINE SHEET 7.06

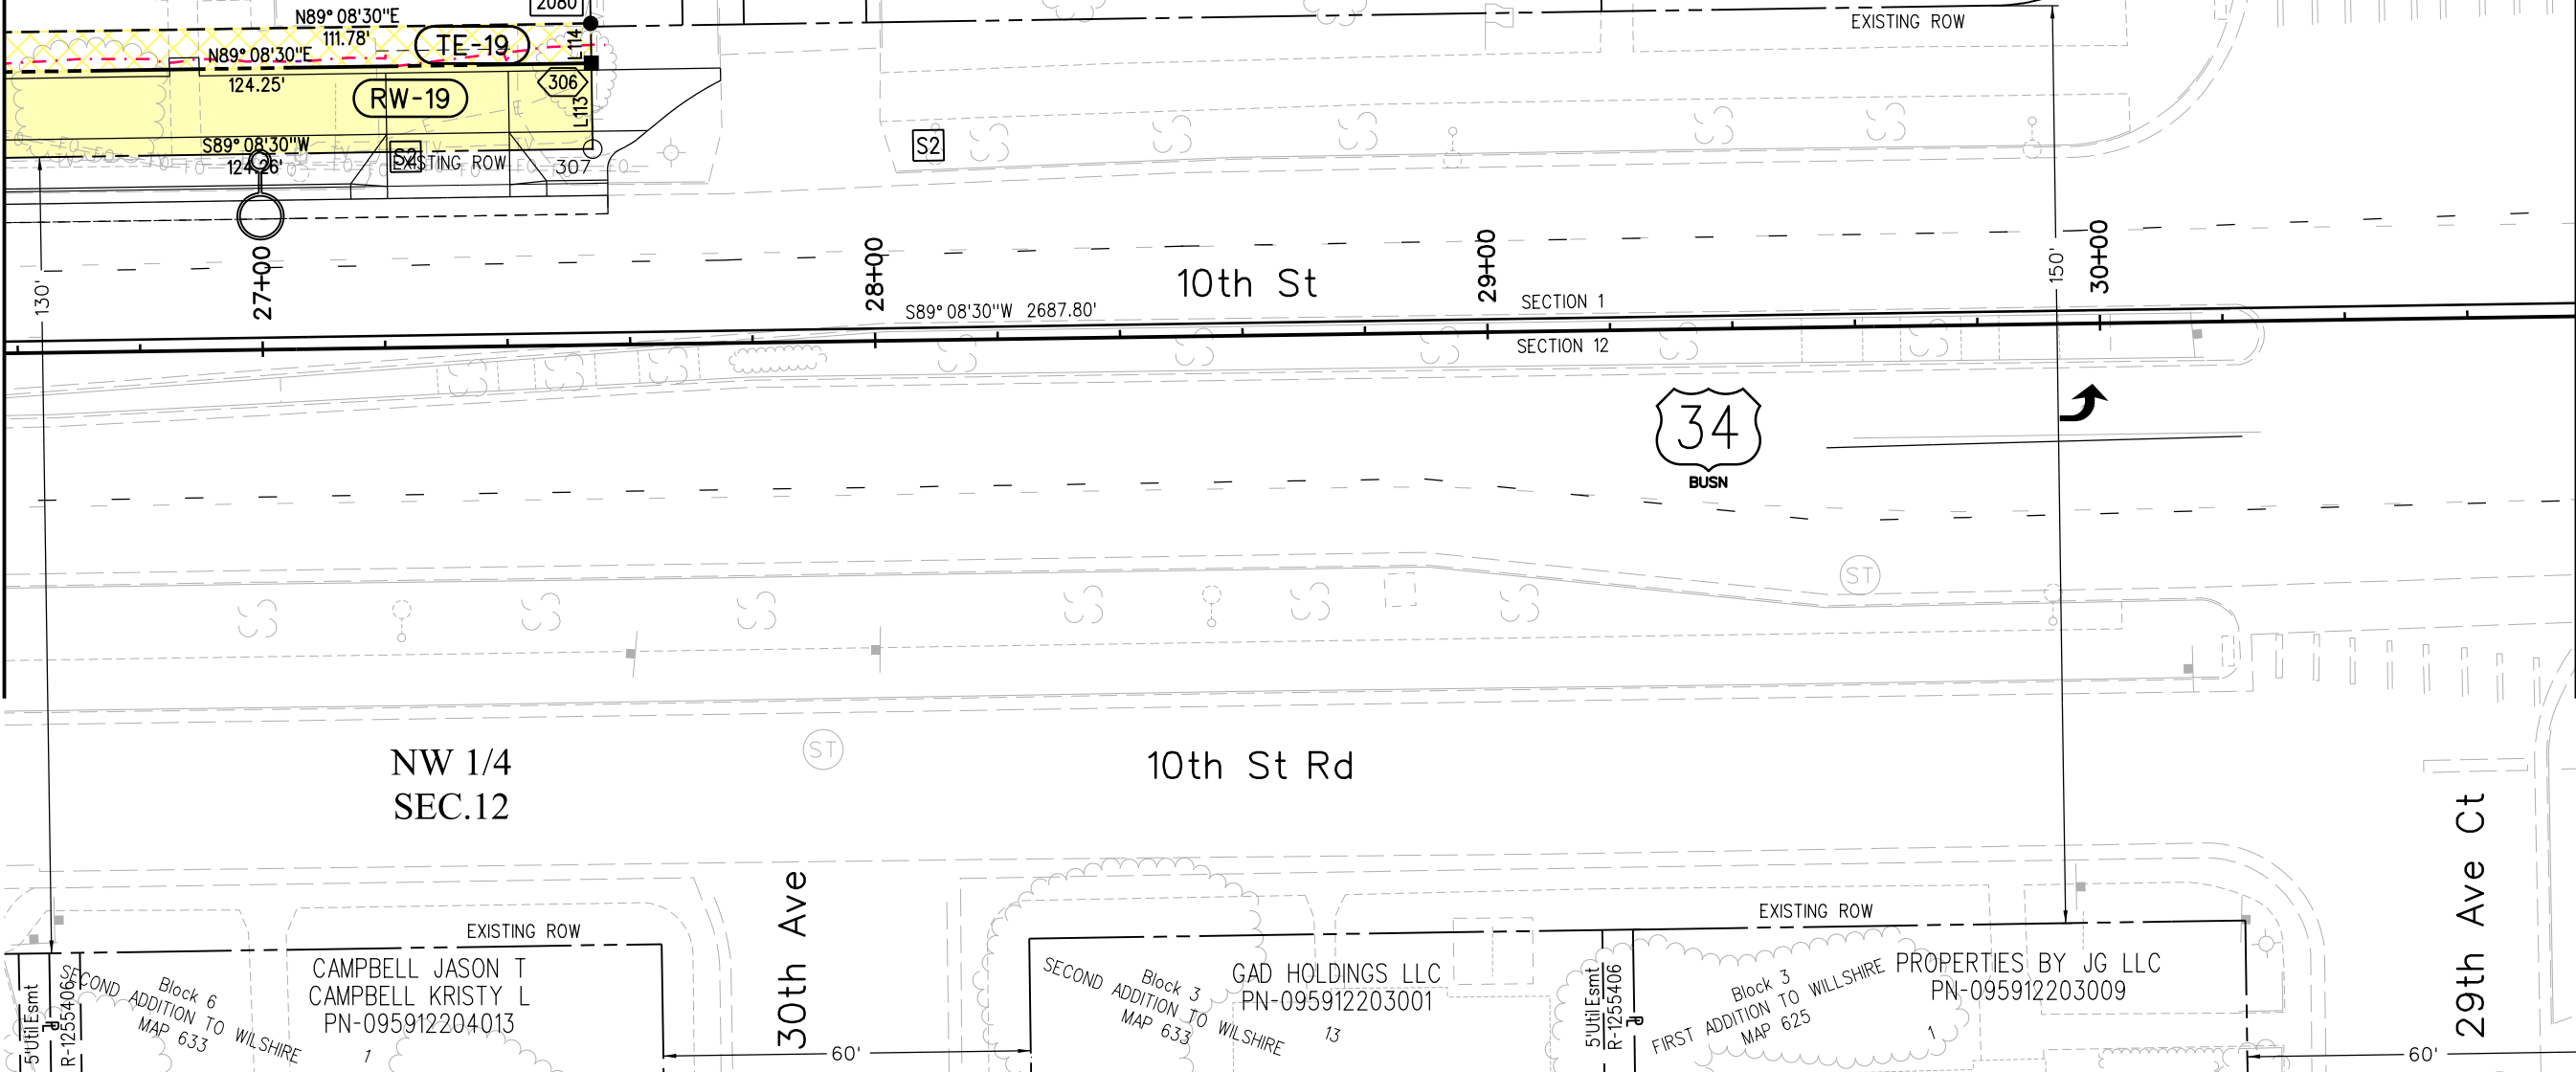

NW 1/4
SEC.12

10th St Rd

30th Ave

29th Ave Ct

CAMPBELL JASON T
CAMPBELL KRISTY L
PN-095912204013

GAD HOLDINGS LLC
PN-095912203001

PROPERTIES BY JG LLC
PN-095912203009

Block 6
SECOND ADDITION TO WILSHIRE
MAP 633

Block 3
SECOND ADDITION TO WILSHIRE
MAP 633

Block 3
FIRST ADDITION TO WILSHIRE
MAP 625



10601 W. 10th Street
Greeley, CO 80634
Phone: 970-350-2161

Region 4 Right of Way

PTS

Sheet Revisions

Date	Description	Initials
mm/dd/yy	XXXXXXXX	XXX


Sheet Revisions

Date	Description	Initials

Sheet Revisions

Date	Description	Initials

 N



Right of Way Plans

Plan Sheet

Project Number: AQC M570-048
Project Location: US 34 BUSINESS & 10TH STREET

Project Code:	Last Mod. Date	Subset	Sheet No.
20389	03-07-2017	7.06 of 7.14	7.06

T.5N., R.66W., 6th P.M.

SW 1/4
SEC.1

Block 1
HEADQUARTERS SUBDIVISION
MAP 18455
1
GREELEY POLICE

CITY OF GREELEY
PN-095901329001

20'Water Esmt
R-20073523577-M18455
12/14/2007

Util,Drainage & Access Esmt
R-20073523577-M18455 12/14/2007

10'Util,Drainage & Access Esmt
R-20073523577-M18455 12/14/2007

EXISTING ROW



10th St

SECTION 1 S89°08'30"W 2687.80'

SECTION 12

EXISTING ROW

WILSHIRE ROAD ROW
VACATED BY
WILSHIRE COMMERCIAL
SUBDIVISION REPLAT
R-4118276

NW 1/4
SEC.12

WACHS CAPITAL LIMITED
PARTNERSHIP
PN-095912234002
1
WILSHIRE COMMERCIAL
SUBDIVISION REPLAT
R-4117276
2

WILSHIRE ROAD ROW
VACATED BY
WILSHIRE COMMERCIAL
SUBDIVISION REPLAT
R-4118276

BGN VENTURES LTD
PN-095912234001

WILSHIRE COMMERCIAL
SUBDIVISION REPLAT
R-4118276
1

JACOBS™



10601 W. 10th Street
Greeley, CO 80634
Phone: 970-350-2161

Region 4 Right of Way

PTS

Sheet Revisions

Date	Description	Initials
mm/dd/yy	XXXXXXXX	XXX


Sheet Revisions

Date	Description	Initials

Sheet Revisions

Date	Description	Initials

 N



Right of Way Plans

Plan Sheet

Project Number: AQC M570-048
Project Location: US 34 BUSINESS & 10TH STREET

Project Code:	Last Mod. Date	Subset	Sheet No.
20389	03-07-2017	7.08 of 7.14	7.08

T.5N., R.66W., 6th P.M.

LINE TABLE			POB TIE TABLE						
NAME	BEARING	DISTANCE	PARCEL	POB	POC	POC#	BEARING	DISTANCE	
L1	S 0°20'48" E	8.43'	RW-21	313	S/4 Sec.1	1005	S85°06'54"W	541.14'	
L2	S 0°20'48" E	6.81'	TE-21	313	S/4 Sec.1	1005	S85°06'54"W	541.14'	
L3	N 49°03'17" E	1.90'	RW-22	313	S/4 Sec.1	1005	S85°06'54"W	541.14'	
L4	N 89°11'12" E	22.82'	TE-22A	313	S/4 Sec.1	1005	S85°06'54"W	541.14'	
L5	S 51°26'47" E	1.93'							
L6	N 0°20'48" W	3.23'							
L7	N 45°16'39" E	15.94'							
L8	S 48°43'38" E	4.14'							
L9	N 89°15'29" E	15.99'							
L10	S 0°20'48" E	11.34'							
L11	N 88°44'38" E	19.58'							
L121	N 1°17'02" W	12.88'							
L122	N 89°23'47" E	19.42'							
L123	S 30°41'48" E	16.77'							

SE 1/4
SEC.1

YURK NORMAN W
PN-095901400002

EXISTING ROW

27th Ave



SECTION 1
SECTION 12

N89°11'12"E 2688.34'

10th St

POB RW-21, TE-21,
RW-22, TE-22A

TE-22A

THE COOKERY
INTERNATIONAL INC.
PN-095901415005

RW-22 TE-22A

TE-22A

2176

2177

2175

2178

2179

2180

2401

<



10601 W. 10th Street
Greeley, CO 80634
Phone: 970-350-2161

Region 4 Right of Way

PTS

Sheet Revisions

Date	Description	Initials
mm/dd/yy	XXXXXXXX	XXX


Sheet Revisions

Date	Description	Initials

Sheet Revisions

Date	Description	Initials

 N



Right of Way Plans

Plan Sheet


Project Number: AQC M570-048
Project Location: US 34 BUSINESS & 10TH STREET

Project Code	Last Mod. Date	Subset	Sheet No.
20389	03-07-2017	7.09 of 7.14	7.09

T.5N., R.66W., 6th P.M.

SE 1/4
SEC.1

PARCEL	POB	POC	POC#	BEARING	DISTANCE
TE-22B	2089	S/4 Sec.1	1005	S86°09'14"W	756.02'
RW-23	326	S/4 Sec.1	1005	S86°27'28"W	840.10'
TE-23	2089	S/4 Sec.1	1005	S86°09'14"W	756.02'

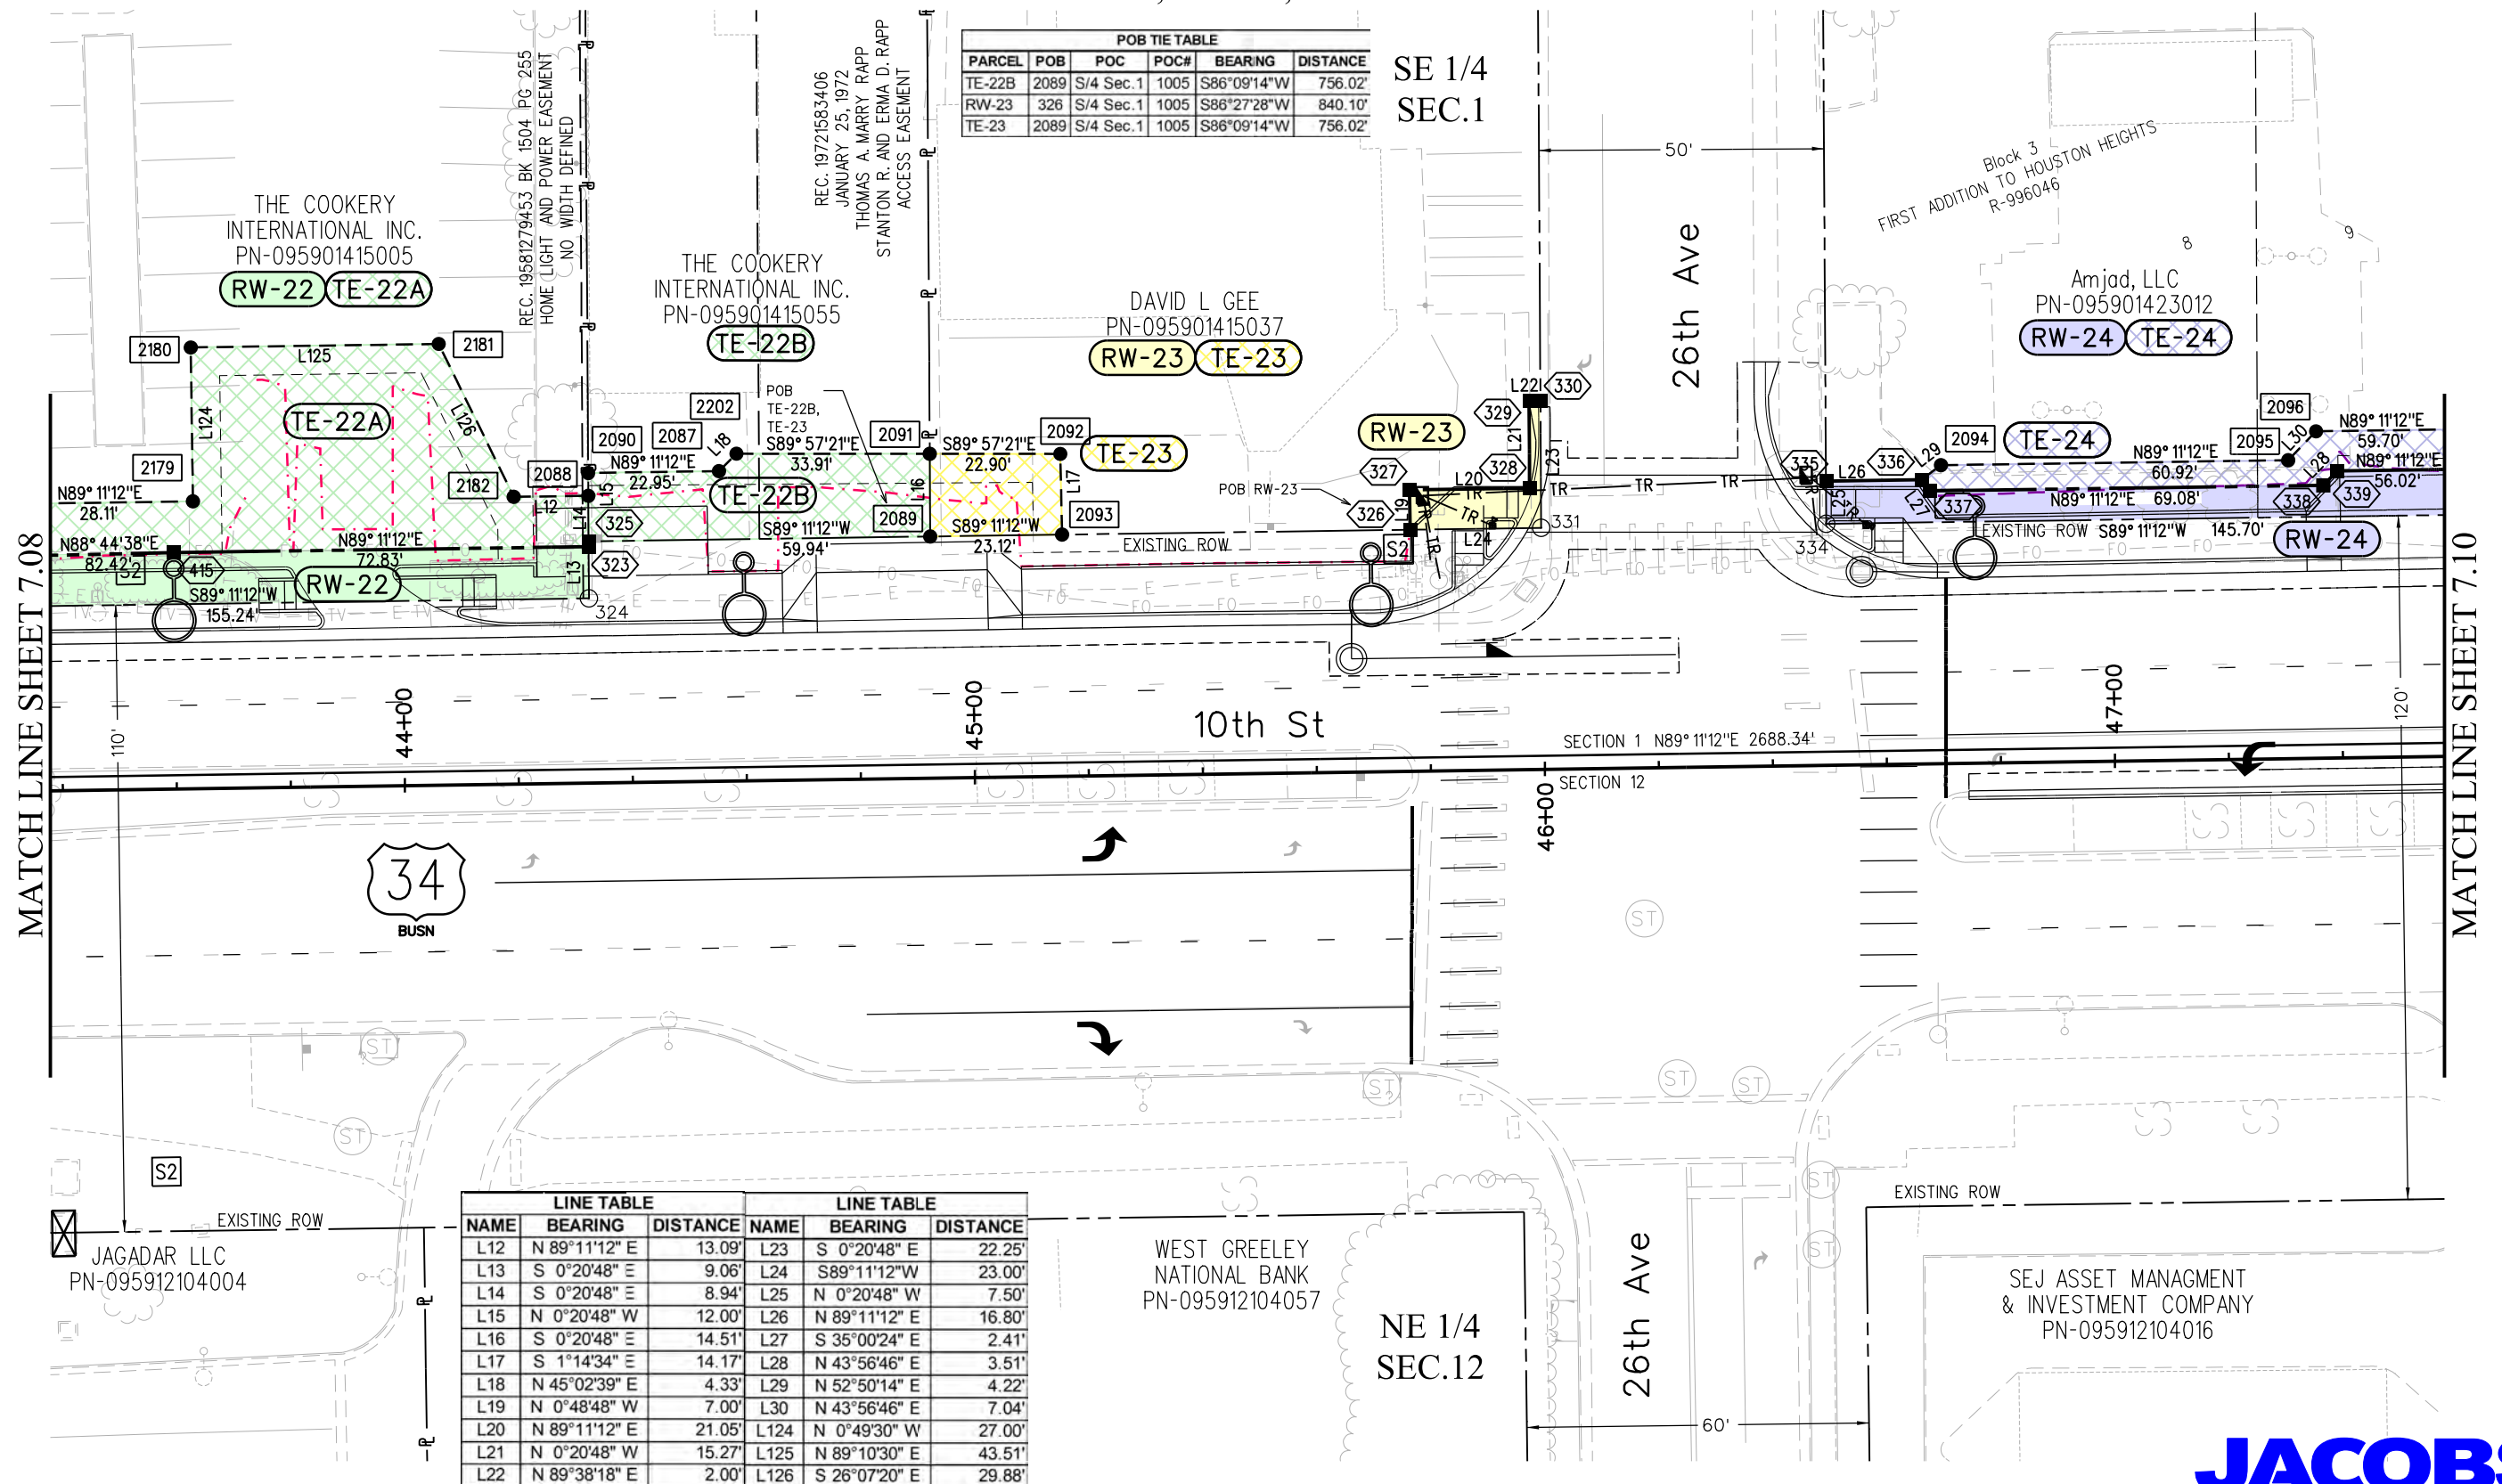

LINE TABLE			LINE TABLE		
NAME	BEARING	DISTANCE	NAME	BEARING	DISTANCE
L12	N 89°11'12" E	13.09'	L23	S 0°20'48" E	22.25'
L13	S 0°20'48" E	9.06'	L24	S89°11'12"W	23.00'
L14	S 0°20'48" E	8.94'	L25	N 0°20'48" W	7.50'
L15	N 0°20'48" W	12.00'	L26	N 89°11'12" E	16.80'
L16	S 0°20'48" E	14.51'	L27	S 35°00'24" E	2.41'
L17	S 1°14'34" E	14.17'	L28	N 43°56'46" E	3.51'
L18	N 45°02'39" E	4.33'	L29	N 52°50'14" E	4.22'
L19	N 0°48'48" W	7.00'	L30	N 43°56'46" E	7.04'
L20	N 89°11'12" E	21.05'	L124	N 0°49'30" W	27.00'
L21	N 0°20'48" W	15.27'	L125	N 89°10'30" E	43.51'
L22	N 89°38'18" E	2.00'	L126	S 26°07'20" E	29.88'

JACOBS



10601 W. 10th Street
Greeley, CO 80634
Phone: 970-350-2161

Region 4 Right of Way

PTS

Sheet Revisions


Date	Description	Initials
05/10/18	rev RW-25, TE-25	jam
07/10/18	rev TE-26	jam

Sheet Revisions

Date	Description	Initials

Sheet Revisions

Date	Description	Initials

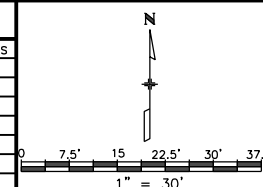

Right of Way Plans

Plan Sheet

Project Number: AQC M570-048
Project Location: US 34 BUSINESS & 10TH STREET


Project Code:	Last Mod. Date	Subset	Sheet No.
20389	07-10-18	7.10 of 7.14	7.10

T.5N., R.66W., 6th P.M.


LINE TABLE			LINE TABLE		
NAME	BEARING	DISTANCE	NAME	BEARING	DISTANCE
L31	S 0°16'48" E	8.00'	L45	N 0°44'13" W	20.57'
L32	S 0°16'48" E	7.00'	L46	S 0°19'54" E	6.20'
L33	N 89°11'12" E	23.35'	L47	N 0°16'48" W	11.20'
L34	S 60°27'38" E	3.56'	L48	S 1°04'48" E	11.19'
L35	S 0°16'48" E	6.20'	L49	S 67°42'23" W	7.61'
L36	N 0°16'48" W	8.23'	L50	N 0°21'48" W	10.13'
L37	N 89°11'12" E	20.60'	L51	N 0°19'54" W	6.20'
L38	S 51°56'47" E	6.37'	L52	N 44°11'12" E	4.07'
L39	S 0°16'48" E	6.03'	L89	N 89°11'12" E	15.97'
L40	N 0°44'13" W	13.00'	L90	S 45°48'48" E	4.07'
L41	N 68°34'34" W	12.07'	L127	S 89°11'12" W	19.56'
L42	N 0°48'48" W	5.30'	L128	S 69°14'42" W	16.55'
L43	S 0°48'48" E	3.00'	L129	N 0°19'54" W	7.54'
L44	S 20°11'51" W	13.08'	L130	N 0°49'30" W	3.97'

POB TIE TABLE					
PARCEL	POB	POC	POC#	BEARING	DISTANCE
RW-24	332	S/4 Sec.1	1005	S86°35'20"W	1059.02'
TE-24	332	S/4 Sec.1	1005	S86°35'20"W	1059.02'
RW-25rev	332	S/4 Sec.1	1005	S86°35'20"W	1059.02'
TE-25rev	332	S/4 Sec.1	1005	S86°35'20"W	1059.02'
RW-26	346	S/4 Sec.1	1005	N88°12'59"W	1169.78'
TE-26rev	346	S/4 Sec.1	1005	N88°12'59"W	1169.78'
RW-27	344	S/4 Sec.1	1005	S87°17'22"W	1395.36'
TE-27	344	S/4 Sec.1	1005	S87°17'22"W	1395.36'


LINE TABLE		
NAME	BEARING	DISTANCE
L145	S89°07'59"W	6.15'
L146	N45°13'32"W	8.28'
L147	S44°12'19"W	12.13'

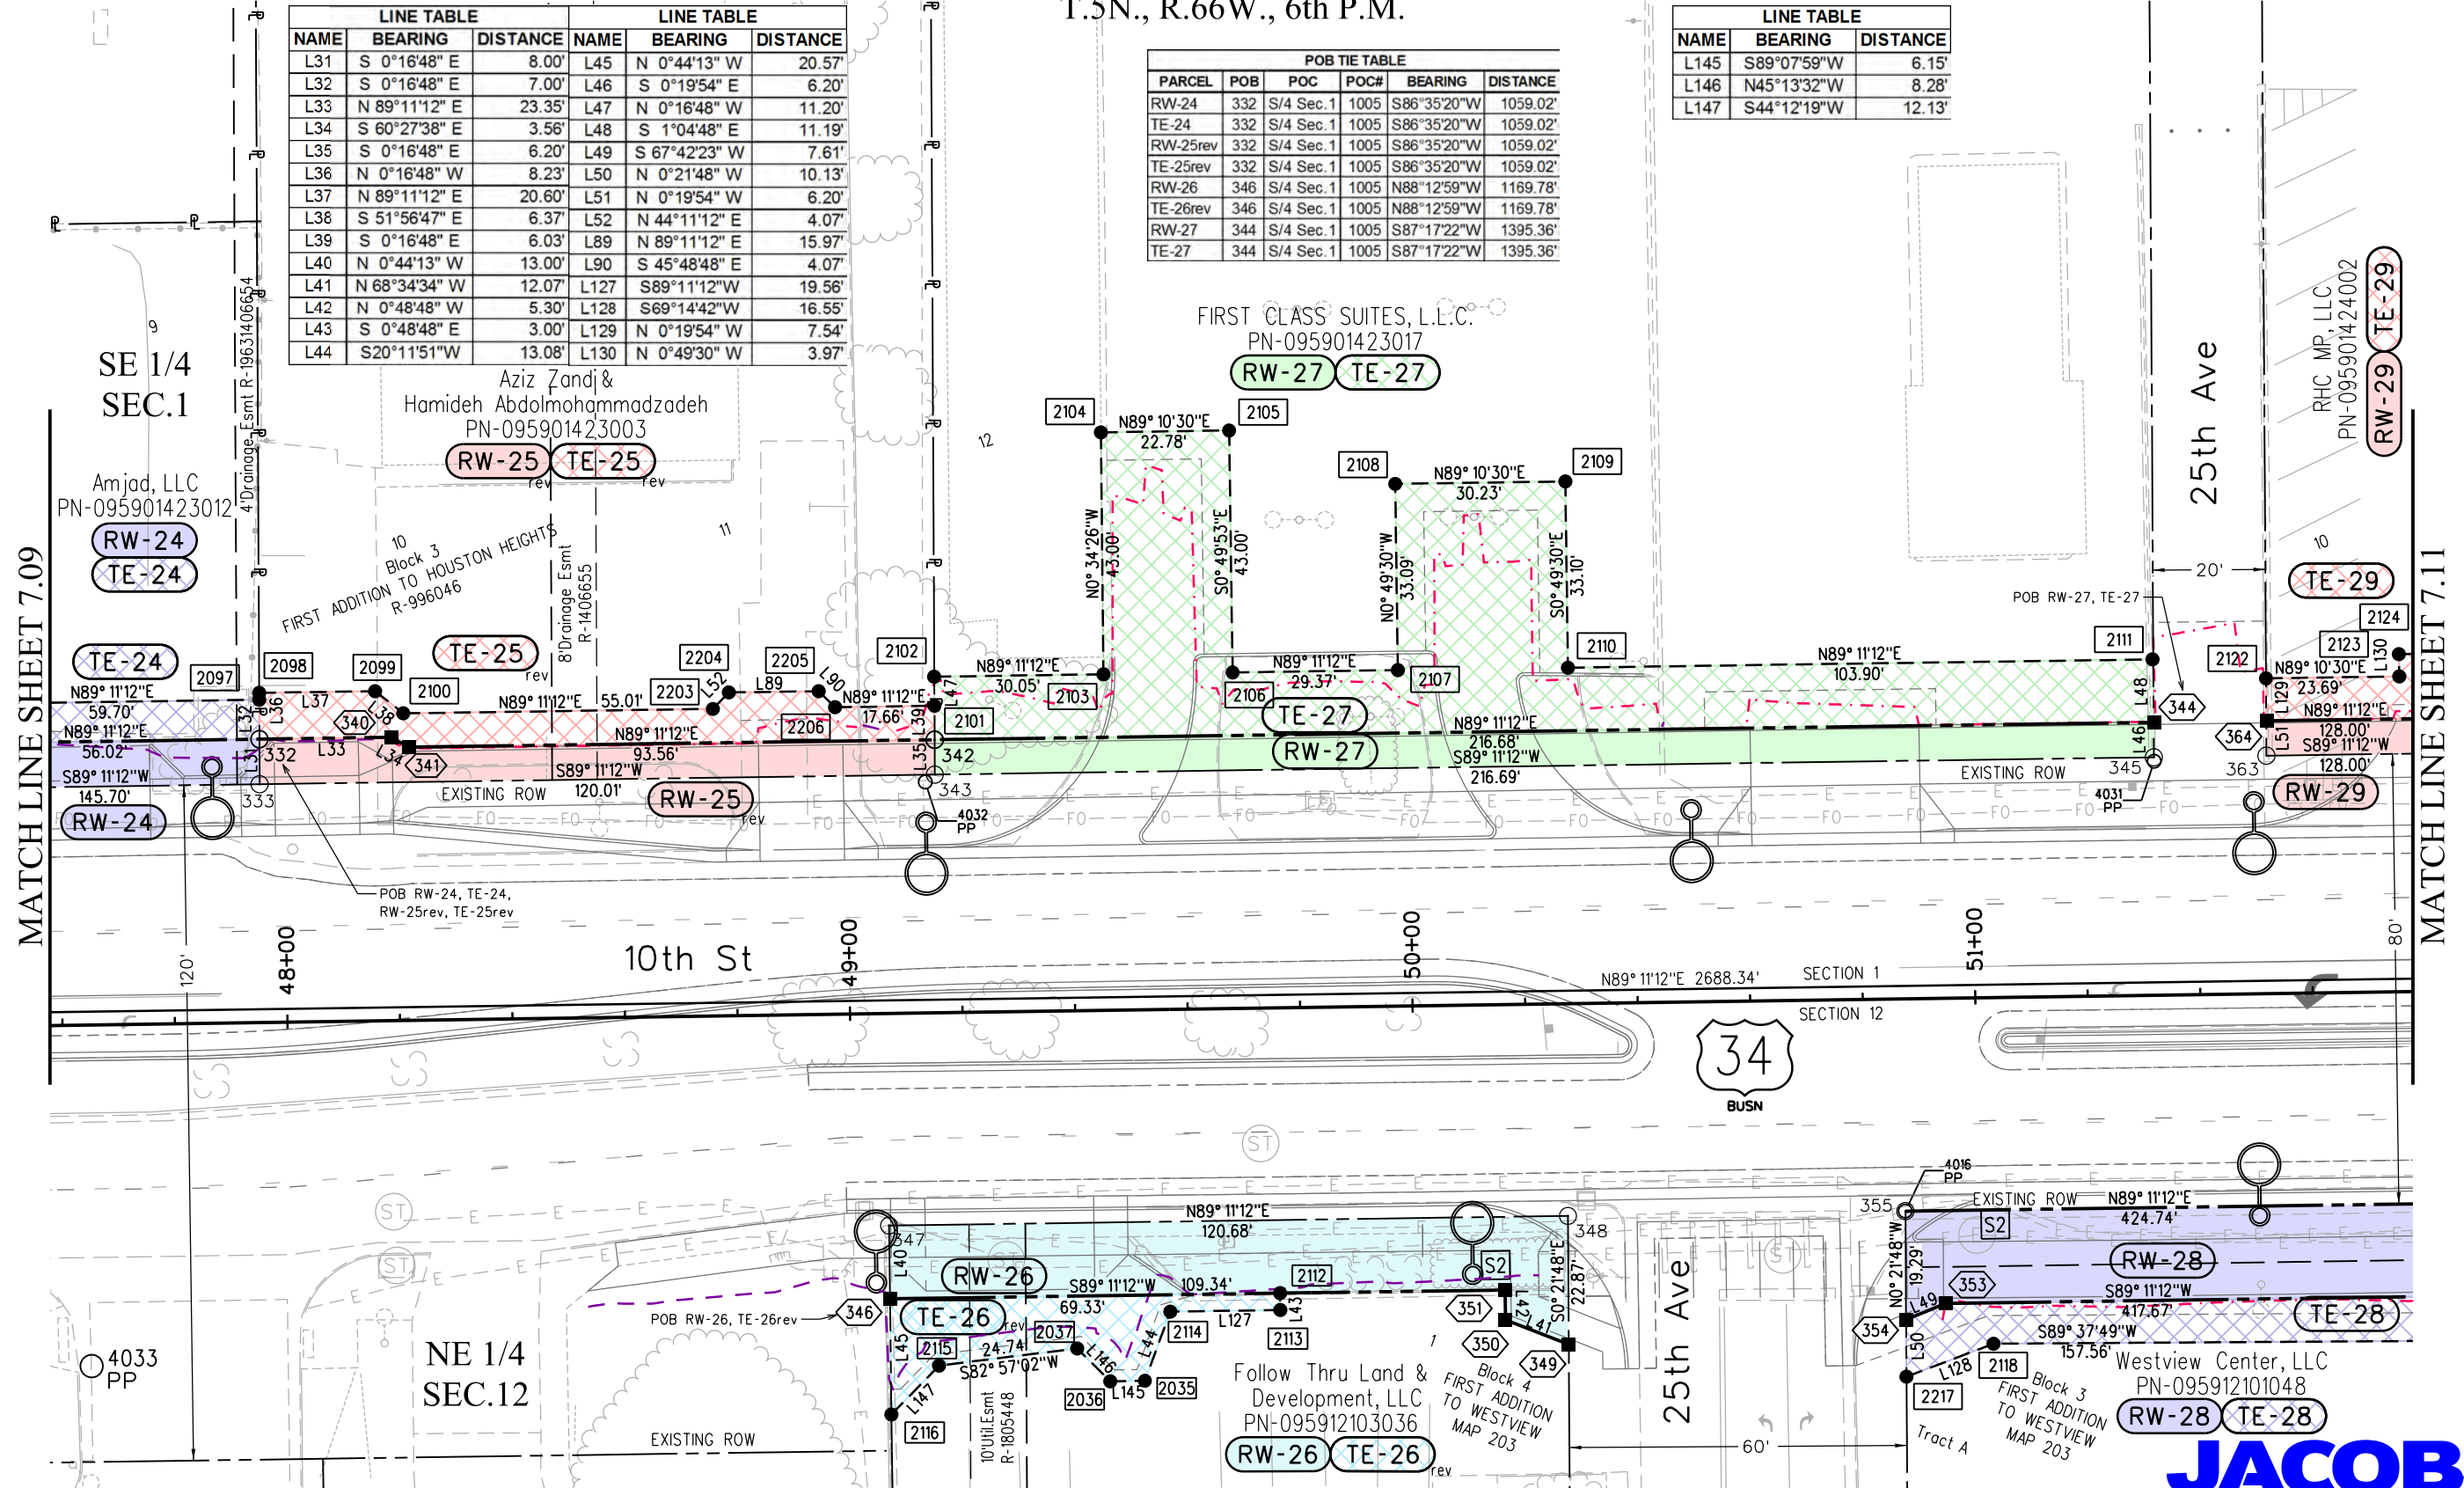

Project Code:	Last Mod. Date	Subset	Sheet No.
20389	10-31-2017	7 11 of 7 14	7 11

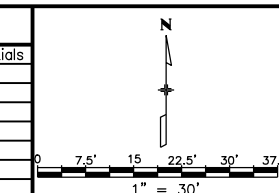

MATCH LINE SHEET 7.12

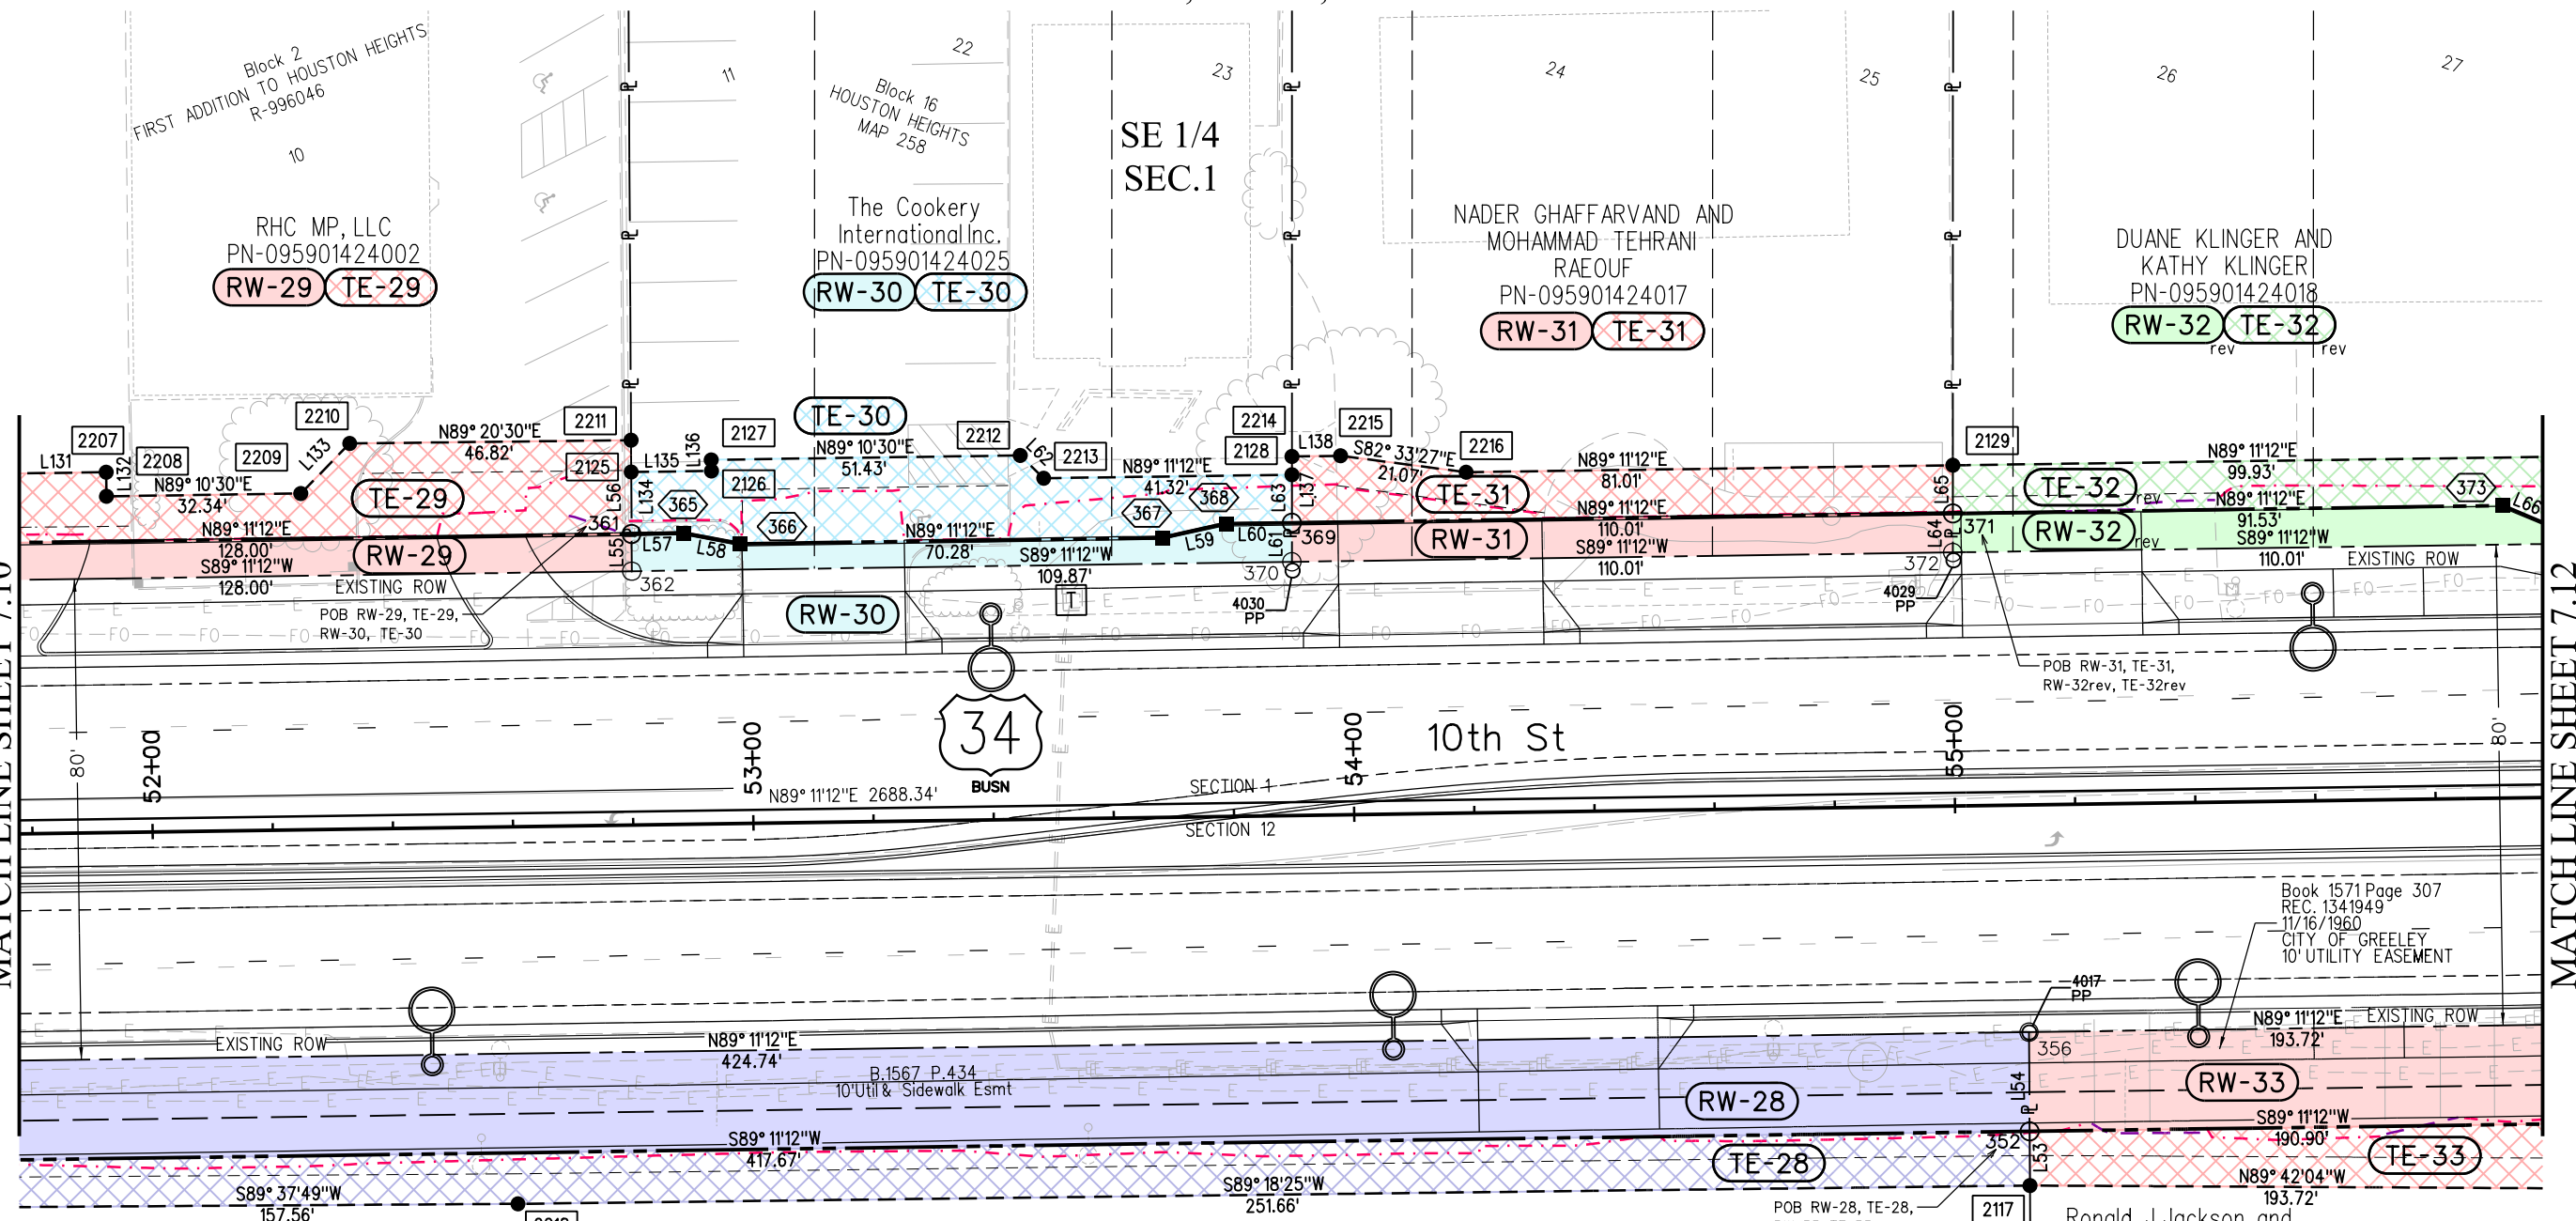

Block 3
FIRST ADDITION TO WESTVIEW
MAP 203

POB TIE TABLE						LINE TABLE			LINE TABLE		
PARCEL	POB	POC	POC#	BEARING	DISTANCE	NAME	BEARING	DISTANCE	NAME	BEARING	DISTANCE
RW-28	352	S/4 Sec. 1	1005	N88°59'20"W	1774.75'	L53	S 0°21'48" E	9.03'	L64	S 0°01'17" W	6.50'
TE-28	352	S/4 Sec. 1	1005	N88°59'20"W	1774.75'	L54	S 0°21'48" E	16.50'	L65	S 0°01'17" W	8.00'
RW-29	361	S/4 Sec. 1	1005	S87°28'17"W	1543.30'	L55	S 0°19'54" E	6.20'	L66	S 67°18'01" E	9.52'
TE-29	361	S/4 Sec. 1	1005	S87°28'17"W	1543.30'	L56	S 0°19'54" E	15.59'	L131	N89°10'30"E	16.97'
RW-30	361	S/4 Sec. 1	1005	S87°28'17"W	1543.30'	L57	N 89°11'12" E	8.57'	L132	S 0°49'30" E	4.02'
TE-30	361	S/4 Sec. 1	1005	S87°28'17"W	1543.30'	L58	S 79°22'46" E	9.58'	L133	N 44°20'30" E	11.64'
RW-31	371	S/4 Sec. 1	1005	S87°40'32"W	1763.14'	L59	N 77°33'45" E	10.92'	L134	N 0°19'54" W	10.30'
TE-31	371	S/4 Sec. 1	1005	S87°40'32"W	1763.14'	L60	N 89°11'12" E	10.97'	L135	N 89°11'12" E	13.35'
RW-32rev	371	S/4 Sec. 1	1005	S87°40'32"W	1763.14'	L61	S 0°01'17" W	6.50'	L136	N 1°19'25" W	1.84'
TE-32rev	371	S/4 Sec. 1	1005	S87°40'32"W	1763.14'	L62	S 45°49'30" E	5.45'	L137	N 0°01'17" E	11.03'
RW-33	352	S/4 Sec. 1	1005	N88°59'20"W	1774.75'	L63	S 0°01'17" W	8.00'	L138	N 89°11'12" E	8.11'
TE-33	352	S/4 Sec. 1	1005	N88°59'20"W	1774.75'						

RW-28 TE-28

RW-33

TE-33

JACOBS™



10601 W. 10th Street
Greeley, CO 80634
Phone: 970-350-2161

Region 4 Right of Way

PTS

Sheet Revisions


Date	Description	Initials
10/31/17	rev RW-32 TE-32 RW-34 TE-34	acr
11/16/17	del RW-35 TE-35	acr
07/10/18	rev RW-35 RW-36A TE-35 TE-36	jam

Sheet Revisions

Date	Description	Initials

Sheet Revisions

Date	Description	Initials

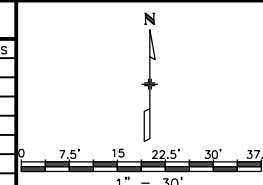

Right of Way Plans

Plan Sheet


Project Number: AQC M570-048
Project Location: US 34 BUSINESS & 10TH STREET

Project Code: 20389 Last Mod. Date: 07-10-18 Subset: 7.12 of 7.14 Sheet No.: 7.12

T.5N., R.66W., 6th P.M.

PARCEL	POB	POC	POC#	BEARING	DISTANCE
RW-34rev	374	S/4 Sec.1	1005	S87°52'49"W	1872.97'
TE-34rev	374	S/4 Sec.1	1005	S87°52'49"W	1872.97'
RW-35rev	384	S/4 Sec.1	1005	N89°14'54"W	2051.37'
TE-35rev	384	S/4 Sec.1	1005	N89°14'54"W	2051.37'
RW-36Arev	384	S/4 Sec.1	1005	N89°14'54"W	2051.37'
TE-36rev	384	S/4 Sec.1	1005	N89°14'54"W	2051.37'
RW-37	396	S/4 Sec.1	1005	S88°01'54"W	2151.96'
TE-37	396	S/4 Sec.1	1005	S88°01'54"W	2151.96'
RW-38	396	S/4 Sec.1	1005	S88°01'54"W	2151.96'
TE-38	396	S/4 Sec.1	1005	S88°01'54"W	2151.96'
RW-39rev	400	S/4 Sec.1	1005	S88°03'26"W	2201.96'
TE-39rev	400	S/4 Sec.1	1005	S88°03'26"W	2201.96'

Gene E. Koonce
PN-095901425006

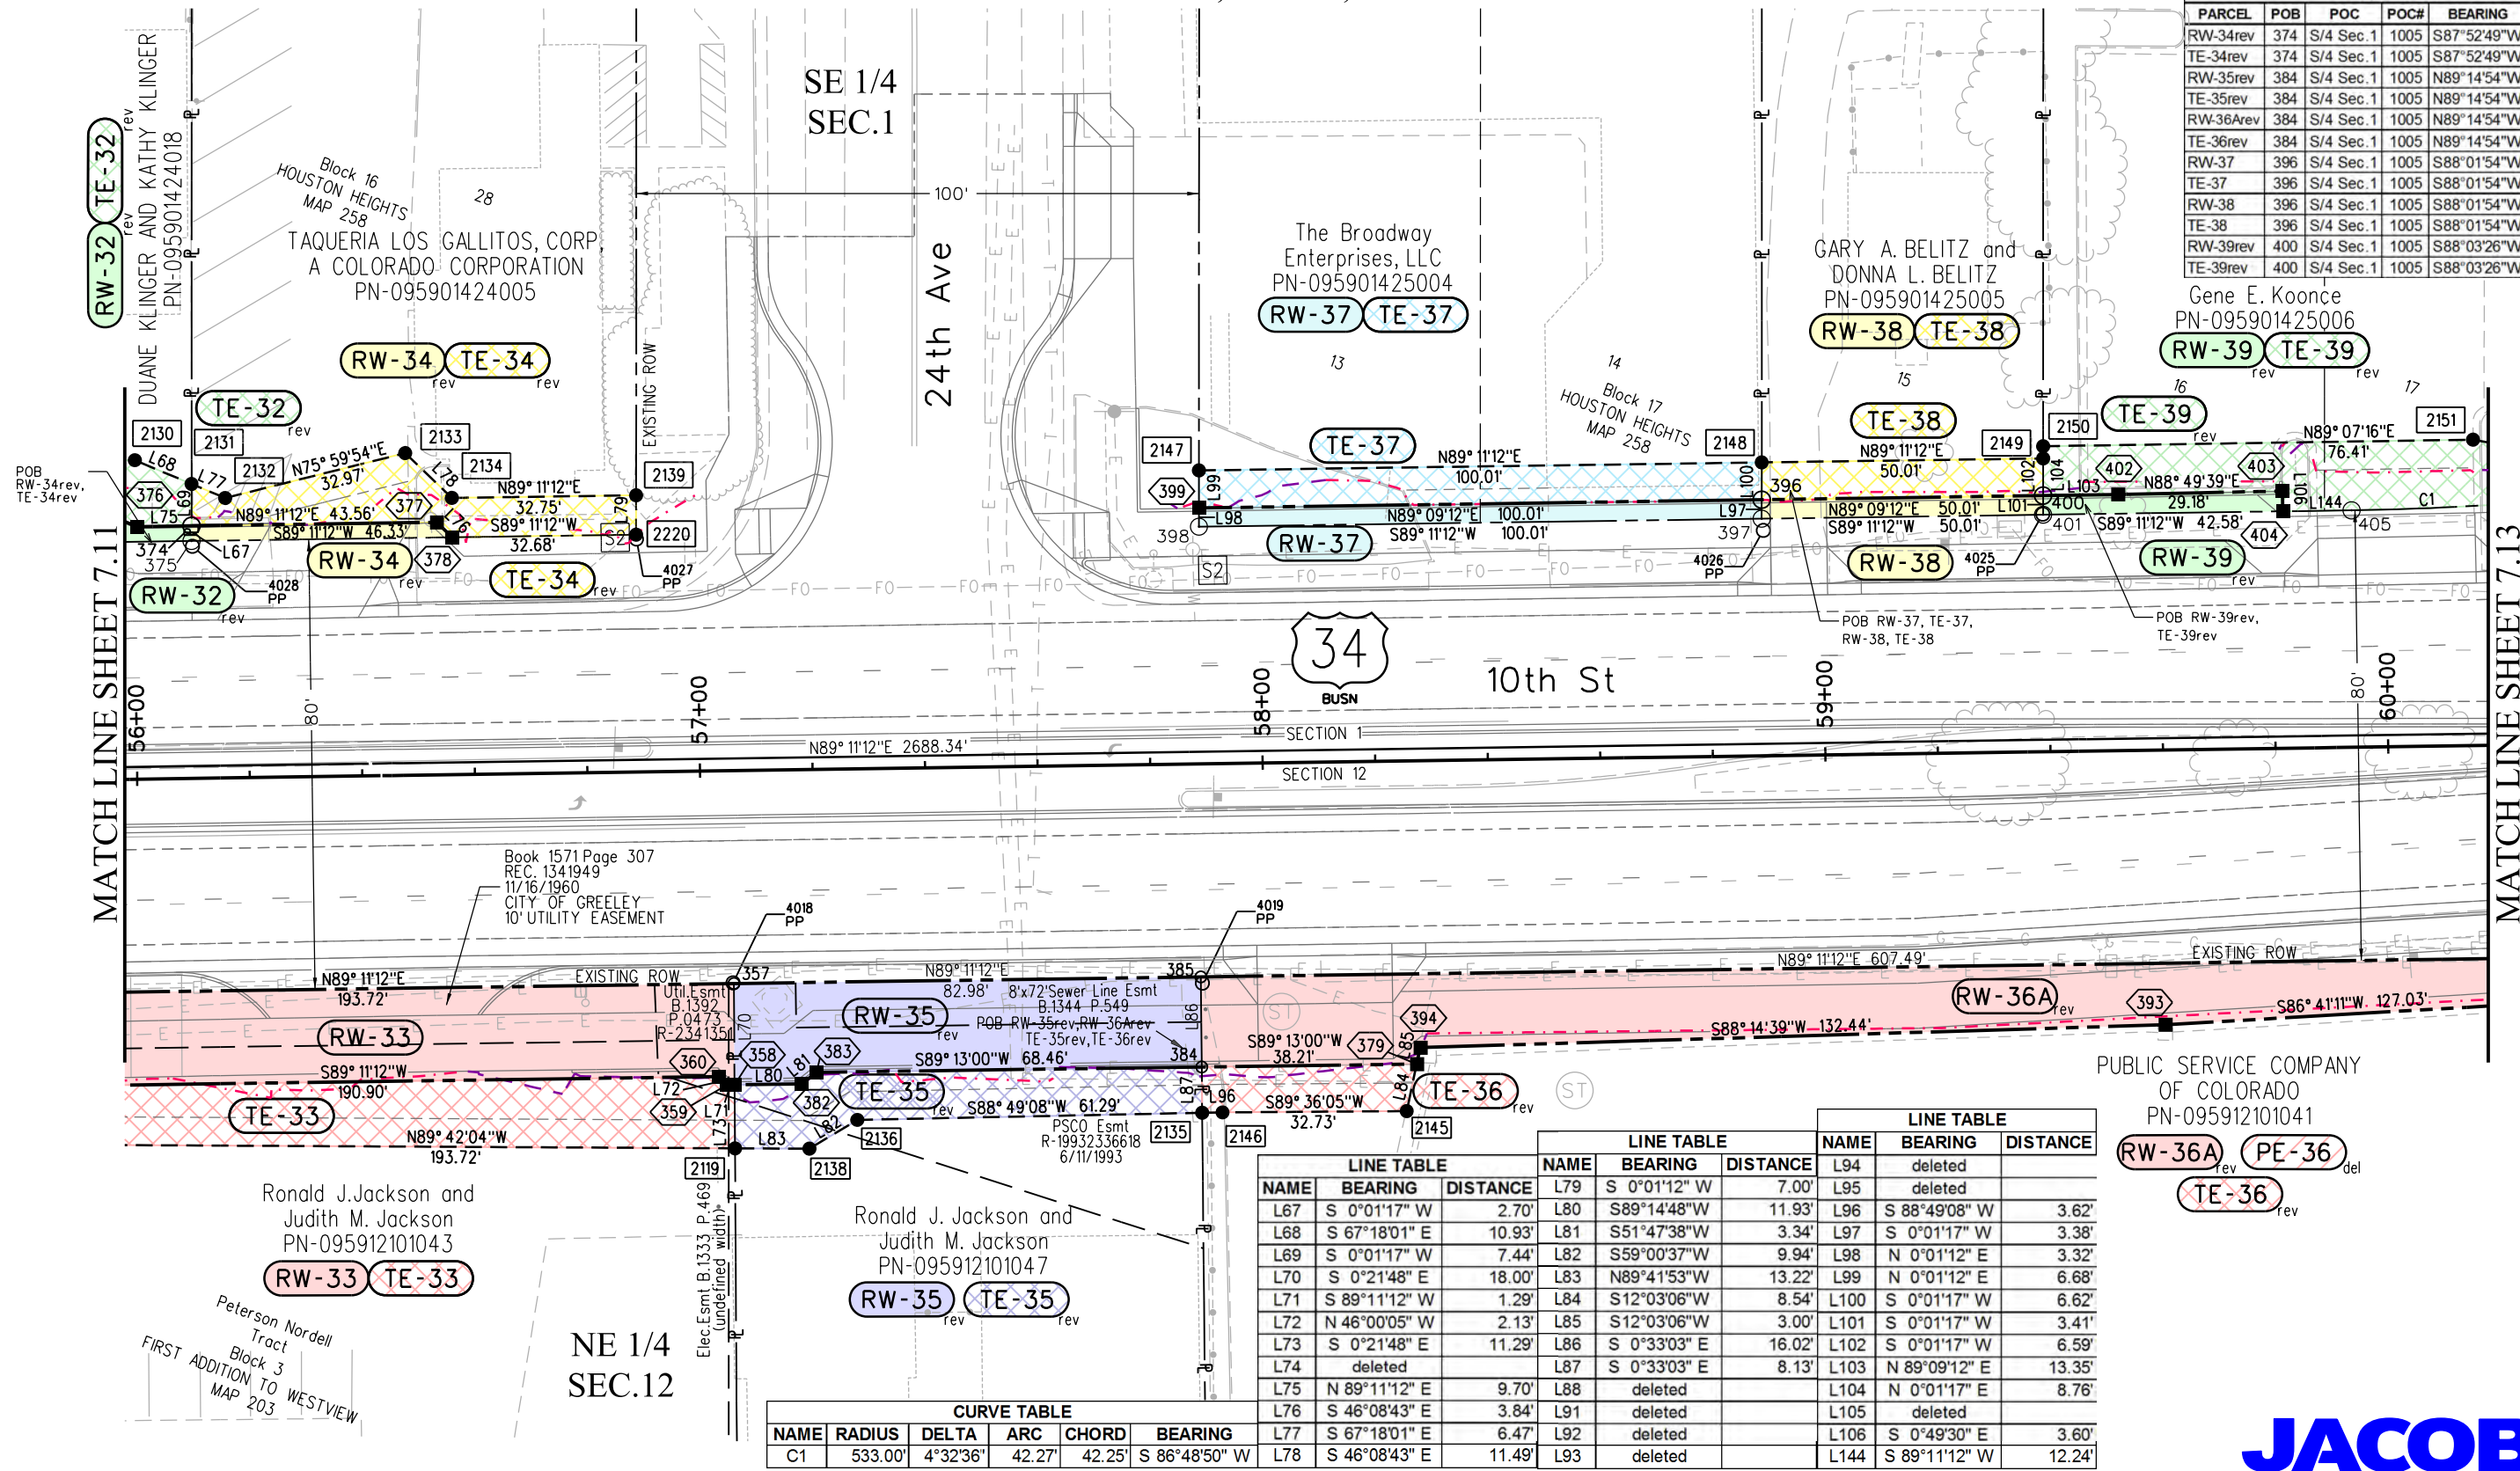

PUBLIC SERVICE COMPANY
OF COLORADO
PN-095912101041

~~RW-36A~~ ~~TE-36~~
~~PE-36~~

LINE TABLE			LINE TABLE			LINE TABLE		
NAME	BEARING	DISTANCE	NAME	BEARING	DISTANCE	NAME	BEARING	DISTANCE
L67	S 0°01'17" W	2.70'	L79	S 0°01'12" W	7.00'	L94	deleted	
L68	S 67°18'01" E	10.93'	L80	S89°14'48"W	11.93'	L96	S 88°49'08" W	3.62'
L69	S 0°01'17" W	7.44'	L81	S51°47'38"W	3.34'	L97	S 0°01'17" W	3.38'
L70	S 0°21'48" E	18.00'	L82	S59°00'37"W	9.94'	L98	N 0°01'12" E	3.32'
L71	S 89°11'12" W	1.29'	L83	N89°41'53"W	13.22'	L99	N 0°01'12" E	6.68'
L72	N 46°00'05" W	2.13'	L84	S12°03'06"W	8.54'	L100	S 0°01'17" W	6.62'
L73	S 0°21'48" E	11.29'	L85	S12°03'06"W	3.00'	L101	S 0°01'17" W	3.41'
L74	deleted		L86	S 0°33'03" E	16.02'	L102	S 0°01'17" W	6.59'
L75	N 89°11'12" E	9.70'	L87	S 0°33'03" E	8.13'	L103	N 89°09'12" E	13.35'
L76	S 46°08'43" E	3.84'	L88	deleted		L104	N 0°01'17" E	8.76'
L77	S 67°18'01" E	6.47'	L89	deleted		L105	deleted	
L78	S 46°08'43" E	11.49'	L90	deleted		L106	S 0°49'30" E	3.60'
			L91	deleted		L107	deleted	
			L92	deleted		L108	deleted	
			L93	deleted		L109	deleted	
						L110	deleted	
						L111	deleted	
						L112	deleted	
						L113	deleted	
						L114	deleted	
						L115	deleted	
						L116	deleted	
						L117	deleted	
						L118	deleted	
						L119	deleted	
						L120	deleted	

CURVE TABLE					
NAME	RADIUS	DELTA	ARC	CHORD	BEARING
C1	533.00'	4°32'36"	42.27'	42.25'	S 86°48'50" W



Colorado Department of Transportation



10601 W. 10th Street
Greeley, CO 80634
Phone: 970-350-2161

Region 4 Right of Way

PTS

Sheet Revisions

Date	Description	Initials
10/31/17	rev RW-39 TE-39	acr
07/10/18	rev RW-36A del RW-36B, PE-36 add sheet 7.15	jam

Sheet Revisions

Date	Description	Initials

Sheet Revisions

Date	Description	Initials



1" = 30'

Right of Way Plans

Plan Sheet


Project Number: AQC M570-048
Project Location: US 34 BUSINESS & 10TH STREET

Project Code	Last Mod. Date	Subset	Sheet No.
20389	07-10-18	7.13 of 7.14	7.13

T.5N., R.66W., 6th P.M.

MATCH LINE SHEET 7.14

T.5N.,
R.65W.,
6th P.M.

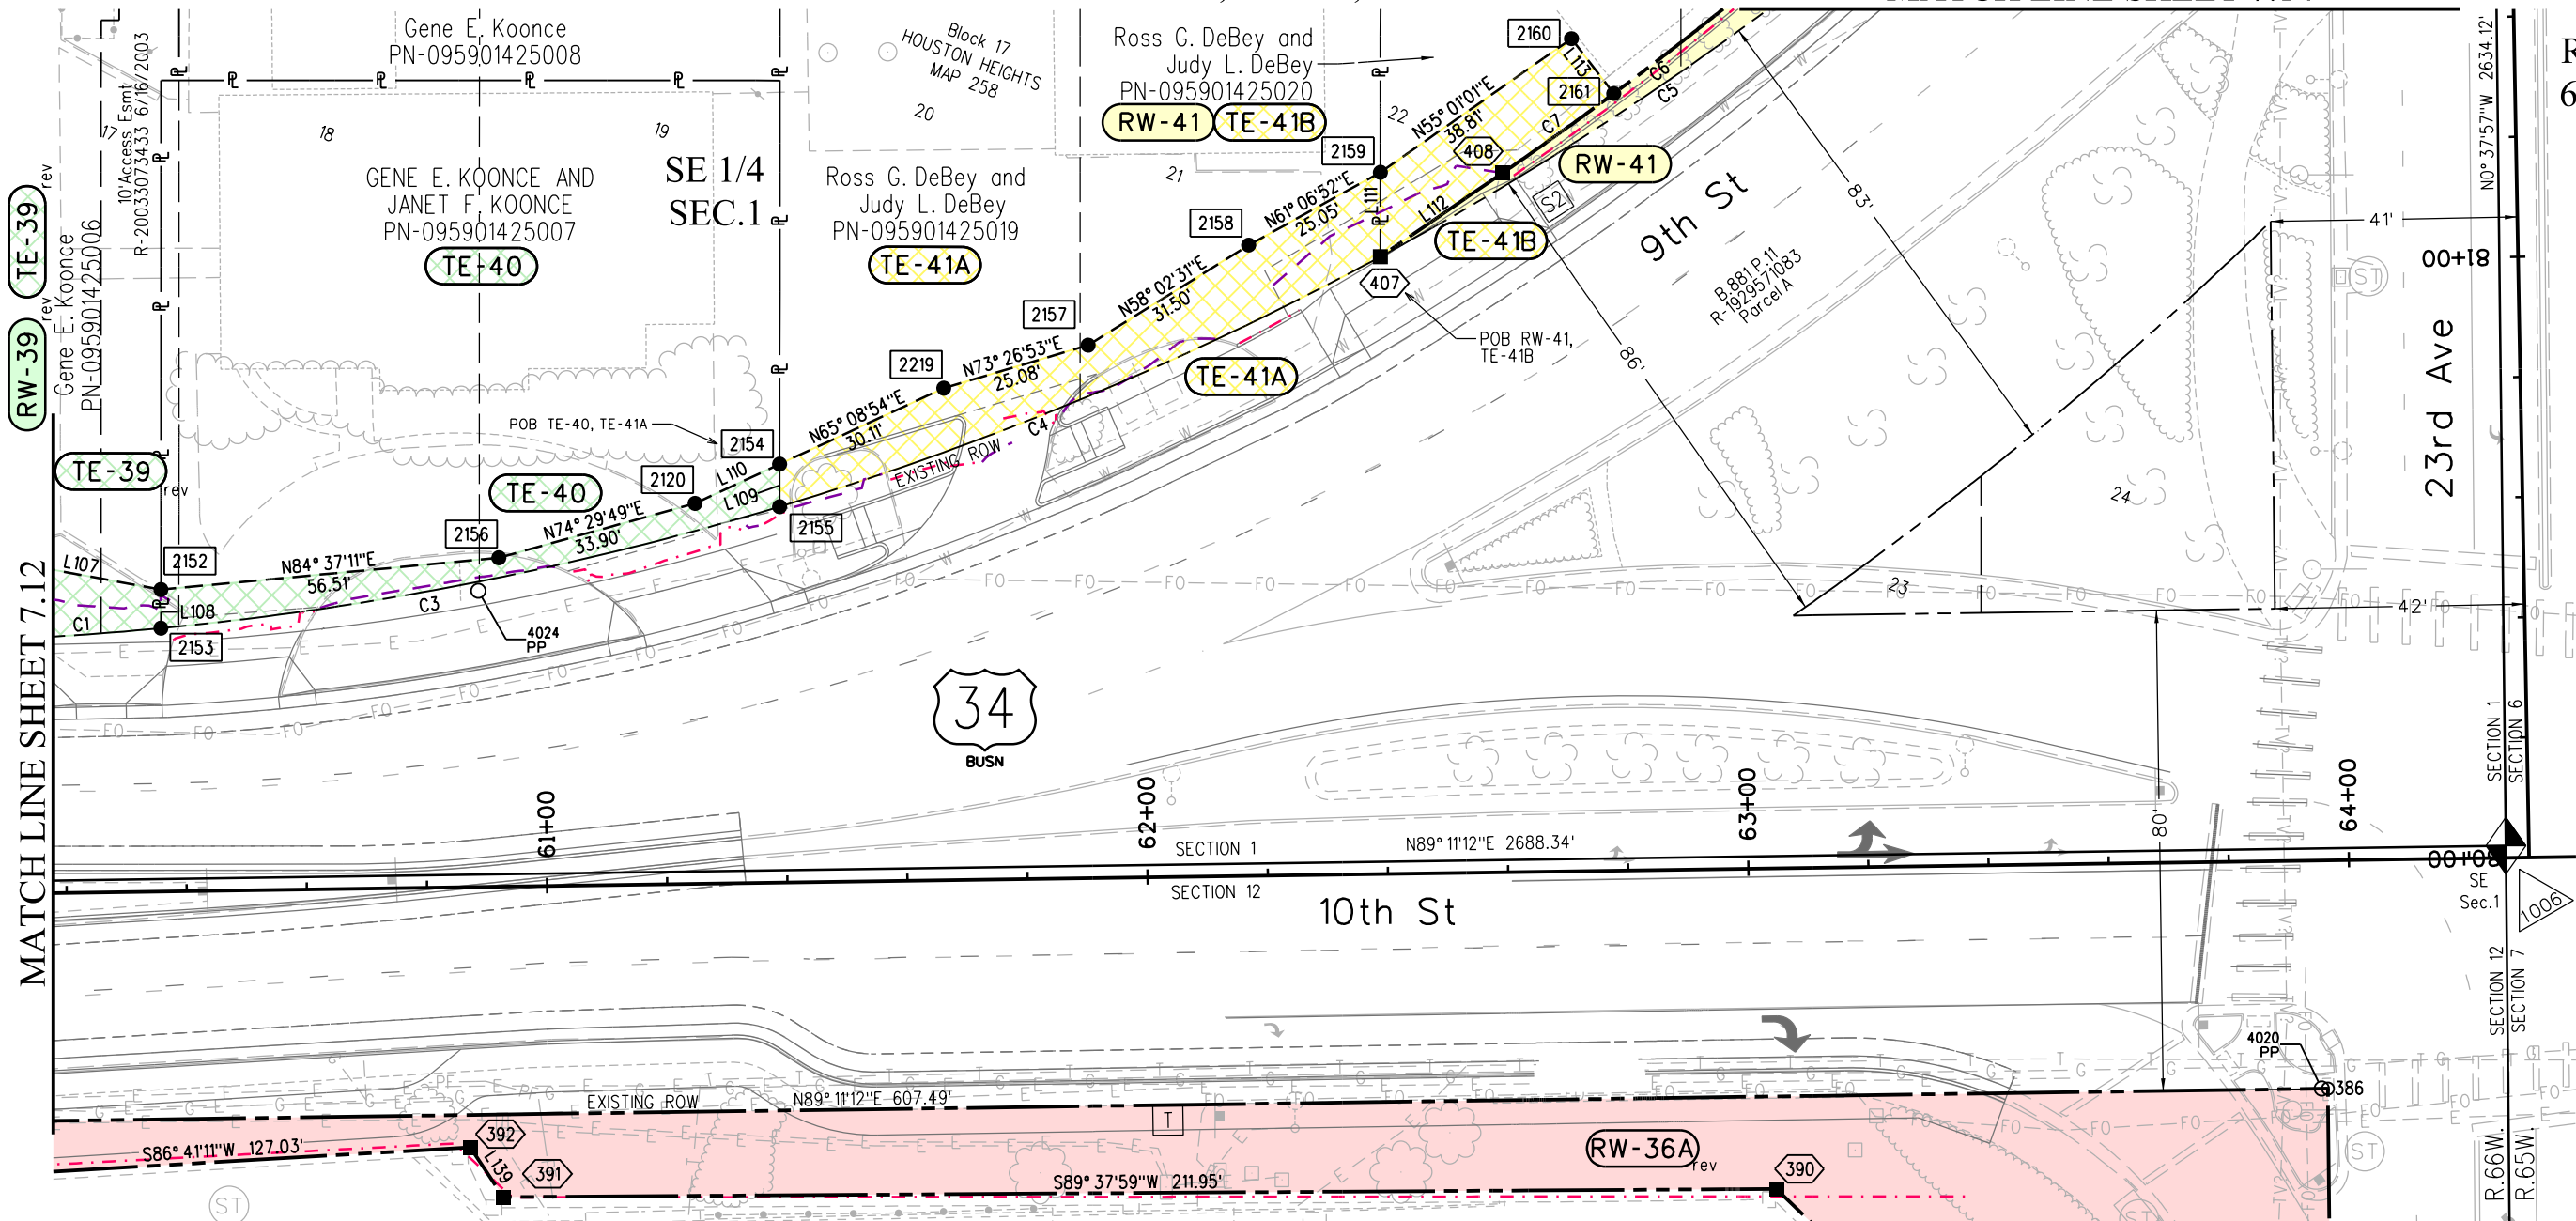

NAME	BEARING	DISTANCE
L107	S 79°35'04" E	20.95'
L108	S 0°01'17" W	6.42'
L109	S 0°01'17" W	7.08'
L110	N 65°08'54" E	15.52'
L111	S 0°01'17" W	14.03'
L112	N 55°34'20" E	24.63'
L113	S 37°38'53" E	11.53'
L139	N33°31'20"W	9.92'
L140	N 57°22'14" W	9.68'
L141	deleted	
L142	deleted	
L143	deleted	

NAME	RADIUS	DELTA	ARC	CHORD	BEARING
C1	533.00'	4°32'36"	42.27'	42.25'	S 86°48'50" W
C2	deleted				
C3	533.00'	11°18'10"	105.15'	104.97'	S 78°53'26" W
C4	533.00'	11°39'55"	108.52'	108.33'	S 67°24'24" W
C5	533.00'	15°18'20"	142.38'	141.96'	S 53°55'17" W
C6	600.00'	5°58'40"	62.60'	62.57'	N 52°35'00" E
C7	600.00'	2°10'28"	22.77'	22.77'	S 54°29'06" W

PARCEL	POB	POC	POC#	BEARING	DISTANCE
RW-36B		deleted			
PE-36		deleted			
TE-40	2154	S/4 Sec.1	1005	S87°34'29"W	2402.85'
RW-41	407	S/4 Sec.1	1005	S86°52'56"W	2504.42'
TE-41A	2154	S/4 Sec.1	1005	S87°34'29"W	2402.85'
TE-41B	407	S/4 Sec.1	1005	S86°52'56"W	2504.42'

PUBLIC SERVICE COMPANY OF COLORADO
PN-095912101041

RW-36A RW-36B PE-36

NE 1/4
SEC.12

JACOBS

MATCH LINE SHEET 7.15



10601 W. 10th Street
Greeley, CO 80634
Phone: 970-350-2161

Sheet Revisions


Date	Description	Initials
mm/dd/yy	XXXXXXXX	XXX

Sheet Revisions

Date	Description	Initials

Sheet Revisions

Date	Description	Initials

 

Right of Way Plans

Plan Sheet

Project Number: AQC M570-048
Project Location: US 34 BUSINESS & 10TH STREET


Project Code:	Last Mod. Date	Subset	Sheet No.
20389	03-07-2017	7.14 of 7.14	7.14

T.5N., R.66W., 6th P.M.

LINE TABLE		
NAME	BEARING	DISTANCE
L114	N 60°50'00" E	14.80'
L115	S 89°58'43" E	1.51'
L116	S 45°14'17" W	13.40'
L117	N 37°38'53" W	11.42'
L118	S 89°58'43" E	22.58'
L119	S 89°58'43" E	2.00'
L120	S 45°14'17" W	2.79'

CURVE TABLE					
NAME	RADIUS	DELTA	ARC	CHORD	BEARING
C5	533.00'	15°18'20"	142.38'	141.96'	S 53°55'17" W
C6	600.00'	5°58'40"	62.60'	62.57'	N 52°35'00" E

POB TIE TABLE					
PARCEL	POB	POC	POC#	BEARING	DISTANCE
TE-41C	412	S/4 Sec.1	1005	S85°00'21"W	2633.45'
TE-42	2165	S/4 Sec.1	1005	S84°36'19"W	2657.51'

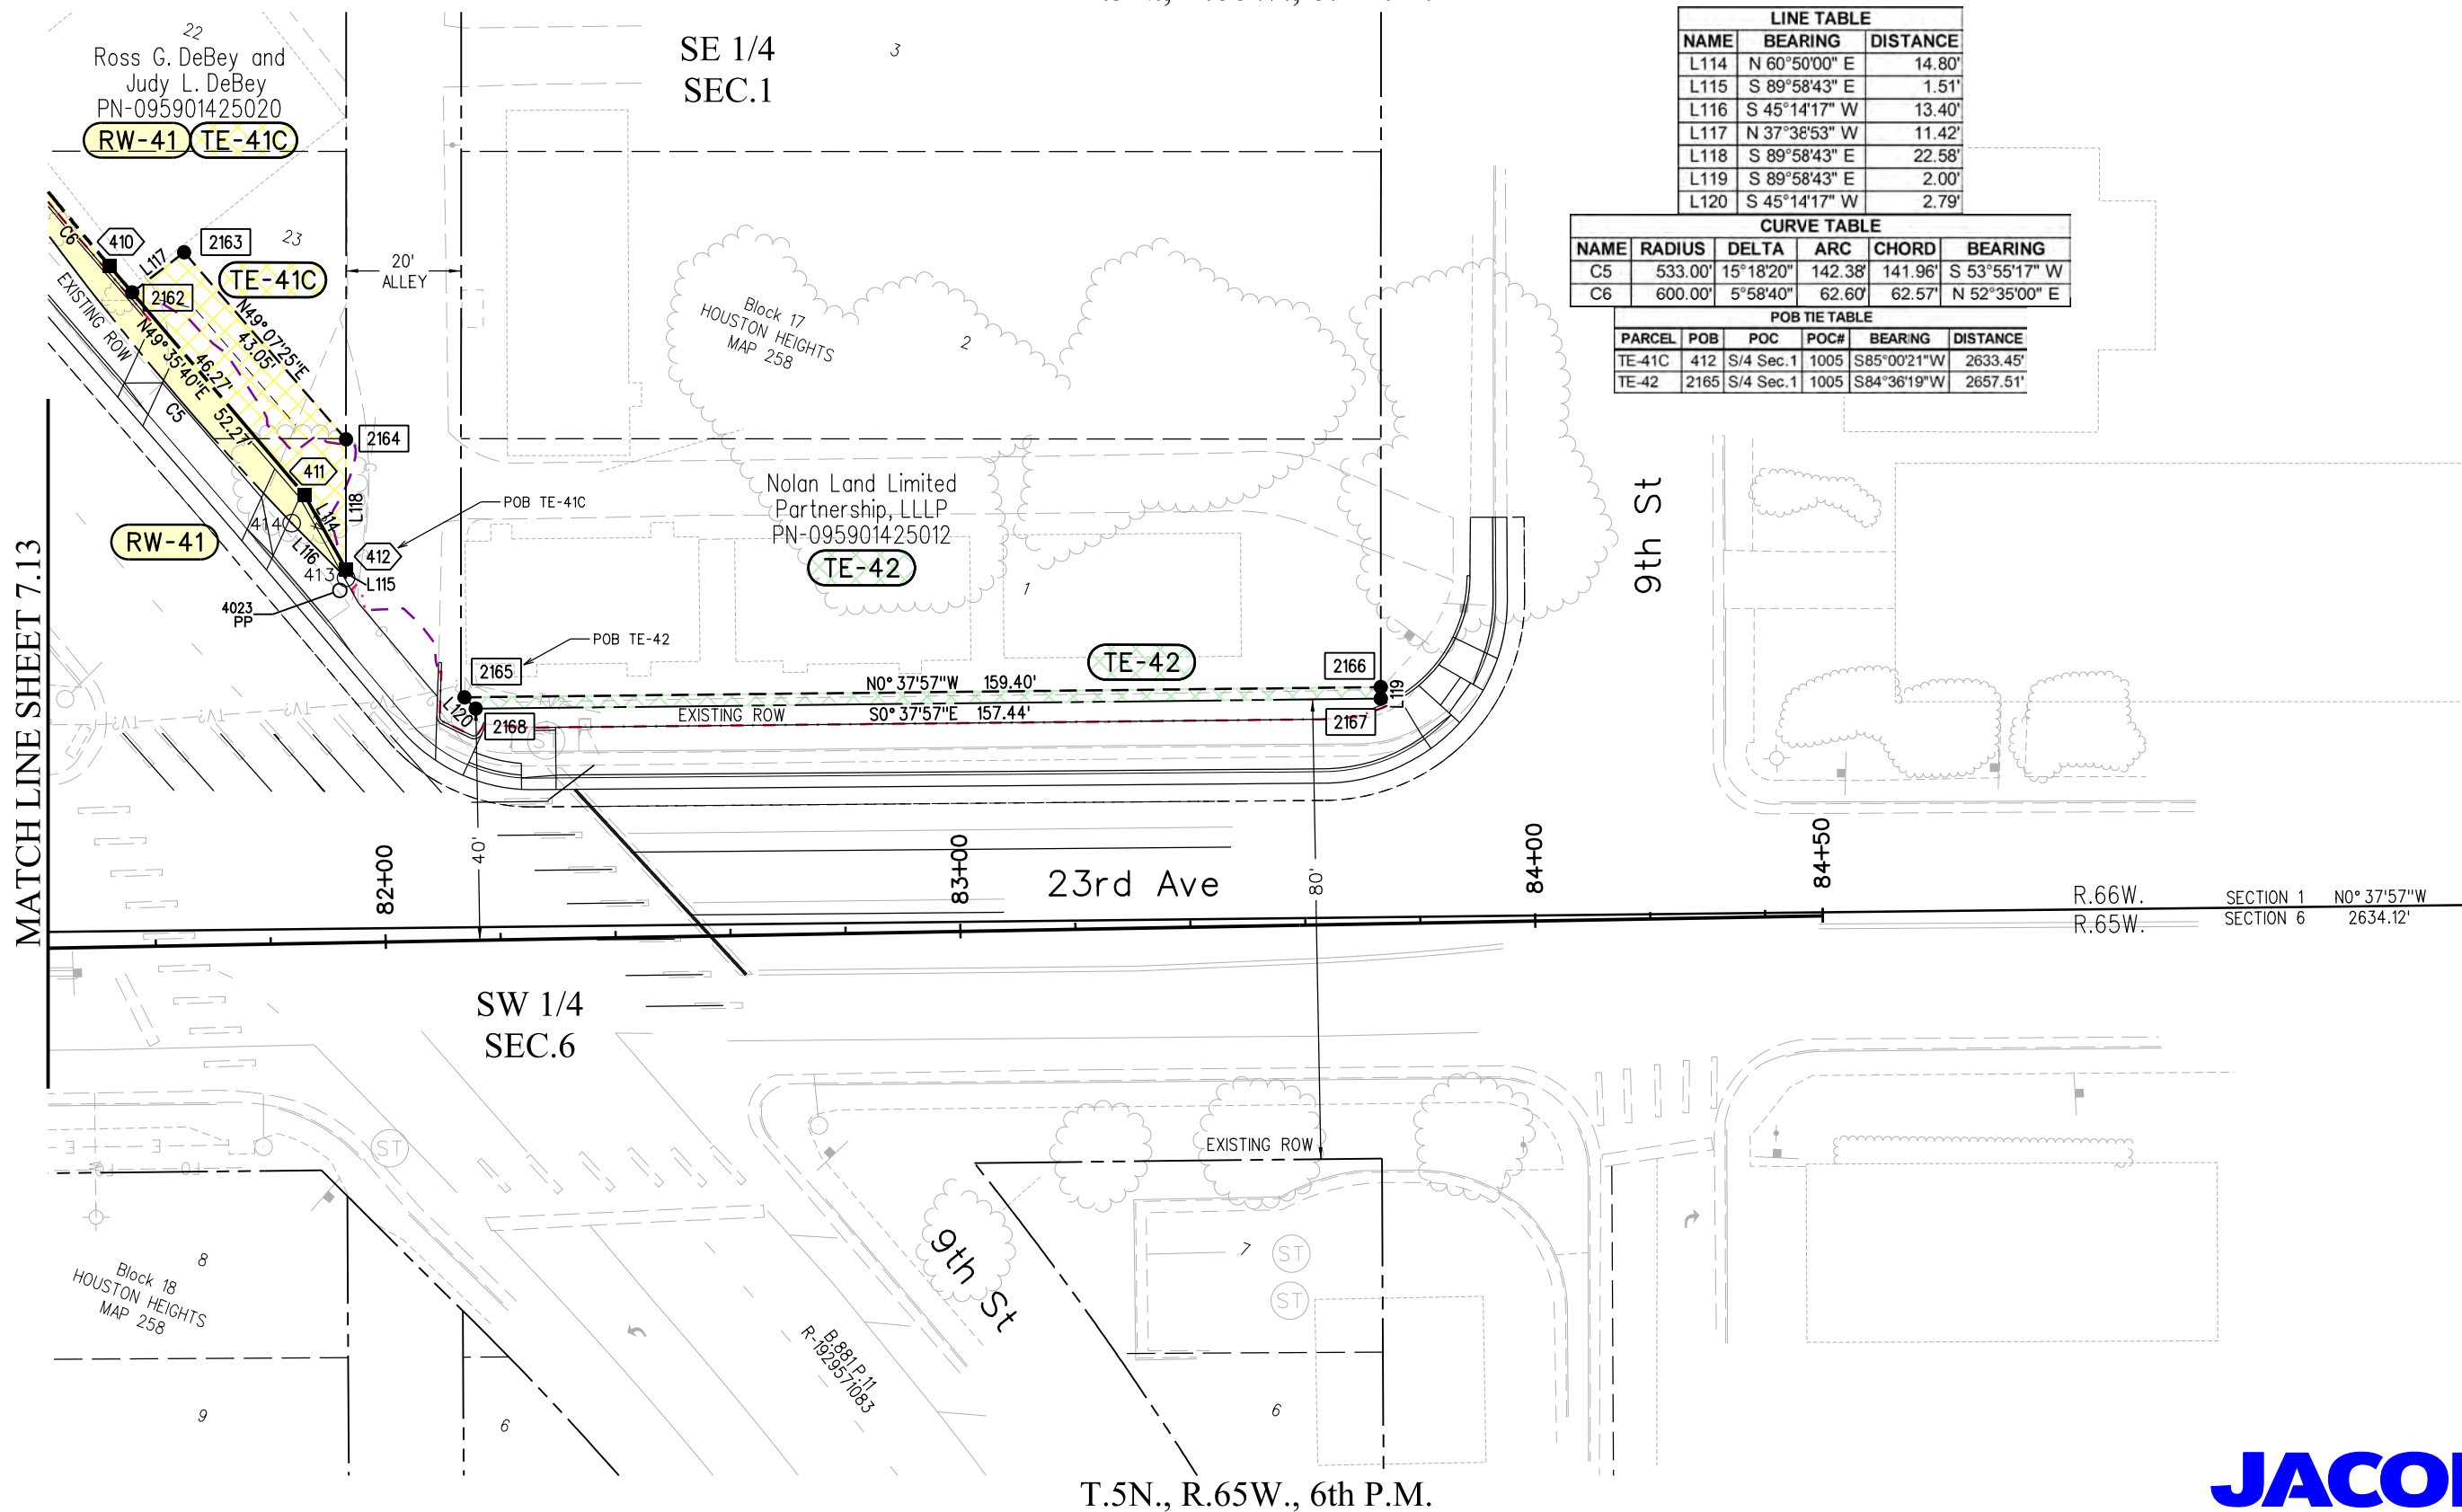

T.5N., R.65W., 6th P.M.



10601 W. 10th Street
Greeley, CO 80634
Phone: 970-350-2161

Region 4 Right of Way

PTS

Sheet Revisions


Date	Description	Initials
07/10/18	add sheet 7.15, rev RW-36A	jgm

Sheet Revisions

Date	Description	Initials

Sheet Revisions

Date	Description	Initials

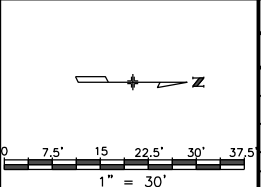

Right of Way Plans

Plan Sheet

Project Number: AQC M570-048
Project Location: US 34 BUSINESS & 10TH STREET

Project Code:	Last Mod. Date	Subset	Sheet No.
20389	07-10-18	7.15 of 7.15	7.15

LINE TABLE		
NAME	BEARING	DISTANCE
L148	N0°19'06"W	9.40'
L149	N46°06'06"W	100.09'

T.5N., R.66W., 6th P.M.

Public Service
Tract
Block 3
FIRST ADDITION TO WESTVIEW
MAP 203

PUBLIC SERVICE COMPANY OF COLORADO
PN-095912101041

RW-36A_{rev}

NE 1/4
SEC.12

MATCH LINE SHEET 7.13

23rd Ave

N0°33'03"W 2985.87'
R.66W. SECTION 12
R.65W. SECTION 7

NW 1/4
SEC.7

T.5N., R.65W., 6th P.M.





10601 W. 10th Street
Greeley, CO 80634
Phone: 970-350-2161

Region 4 Right of Way

PTS

Sheet Revisions


Date	Description	Initials
8/31/17	rev RW-10 del TE-10	acr
10/31/17	rev RW-9 TE-9	acr
11/16/17	del RW-8 RW-10 rev	acr
03/23/18	rev RW-15, TE-15, name change RW-16, TE-16	jam

Sheet Revisions

Date	Description	Initials

Sheet Revisions

Date	Description	Initials

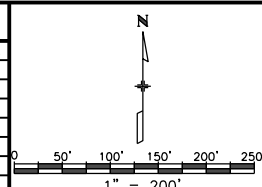

Right of Way Plans


Ownership Sheet

Project Number: AQC M570-048
Project Location: US 34 BUSINESS & 10TH STREET

Project Code:	Last Mod. Date	Subset	Sheet No.
20389	03-23-18	8.01 of 8.02	8.01

T.5N., R.66W., 6th P.M.

SW 1/4
SEC. 1

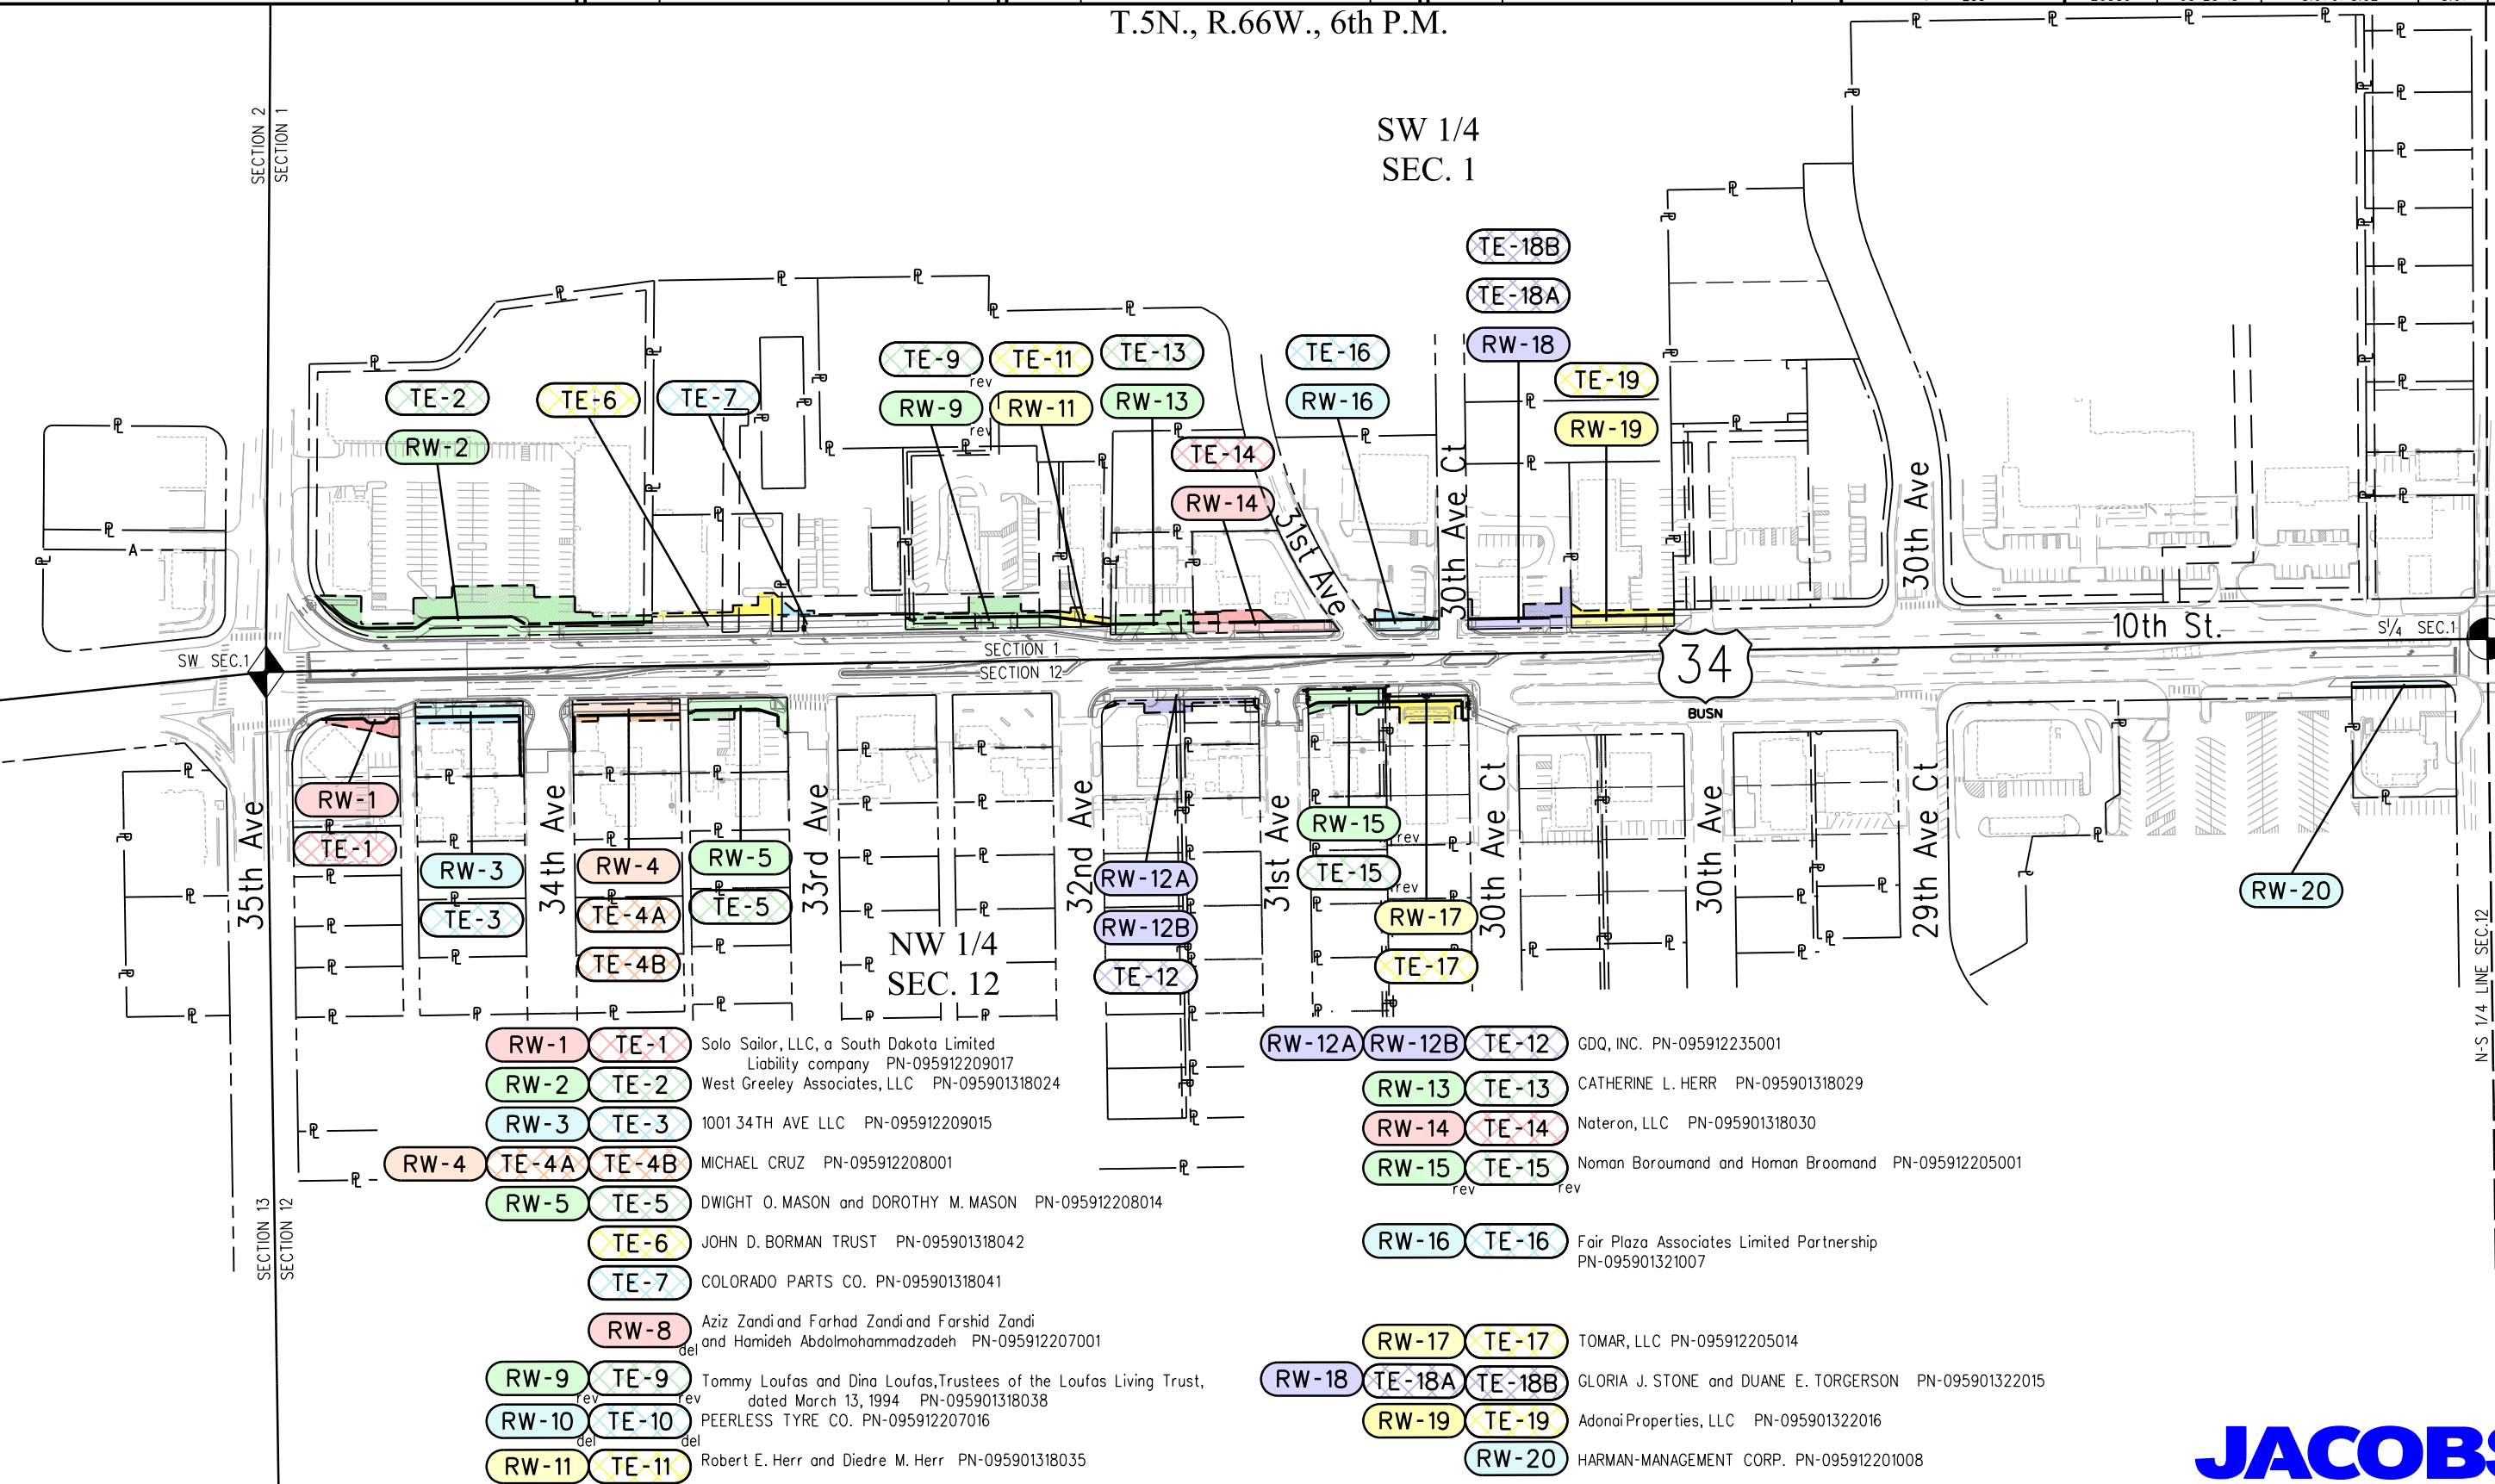

RW-1	TE-1	Solo Sailor, LLC, a South Dakota Limited Liability company PN-095912209017
RW-2	TE-2	West Greeley Associates, LLC PN-095901318024
RW-3	TE-3	1001 34TH AVE LLC PN-095912209015
RW-4	TE-4A	MICHAEL CRUZ PN-095912208001
RW-5	TE-5	DWIGHT O. MASON and DOROTHY M. MASON PN-095912208014
TE-6	TE-6	JOHN D. BORMAN TRUST PN-095901318042
TE-7	TE-7	COLORADO PARTS CO. PN-095901318041
RW-8	TE-8	Aziz Zandi and Farhad Zandi and Farshid Zandi and Hamideh Abdolmohammadzadeh PN-095912207001
RW-9	TE-9	Tommy Loufas and Dina Loufas, Trustees of the Loufas Living Trust, dated March 13, 1994 PN-095901318038
RW-10	TE-10	PEERLESS TYRE CO. PN-095912207016
RW-11	TE-11	Robert E. Herr and Diedre M. Herr PN-095901318035

RW-12A	RW-12B	TE-12	GDQ, INC. PN-095912235001
RW-13	TE-13	TE-13	CATHERINE L. HERR PN-095901318029
RW-14	TE-14	TE-14	Nateron, LLC PN-095901318030
RW-15	TE-15	TE-15	Noman Boroumand and Homan Broomand PN-095912205001
RW-16	TE-16	TE-16	Fair Plaza Associates Limited Partnership PN-095901321007
RW-17	TE-17	TE-17	TOMAR, LLC PN-095912205014
RW-18	TE-18A	TE-18B	GLORIA J. STONE and DUANE E. TORGERSO PN-095901322015
RW-19	TE-19	TE-19	Adonai Properties, LLC PN-095901322016
RW-20	TE-20	TE-20	HARMAN-MANAGEMENT CORP. PN-095912201008

JACOBS



10601 W. 10th Street
Greeley, CO 80634
Phone: 970-350-2161

Sheet Revisions


Date	Description	Initials
10/31/17	rev RW-32 TE-32 RW-34 TE-34	acr
11/16/17	del RW-35 TE-35	acr
05/10/18	rev RW-25, TE-25	jam
07/10/18	rev TE-26, RW-35, TE-35, RW-36A, TE-36	jam
	del RW-36B, PE-36	

Sheet Revisions

Date	Description	Initials

Sheet Revisions

Date	Description	Initials

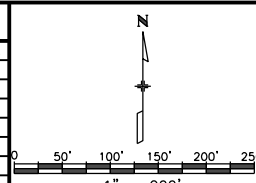

Right of Way Plans

Ownership Sheet

Project Number: AQC M570-048
Project Location: US 34 BUSINESS & 10TH STREET

Project Code	Last Mod. Date	Subset	Sheet No.
20389	07-10-18	8.02 of 8.02	8.02

T.5N., R.66W., 6th P.M.

SE 1/4
SEC. 1

NE 1/4
SEC. 12

