

STATE DEPARTMENT OF HIGHWAYS
DIVISION OF HIGHWAYS—STATE OF COLORADO

ROW, NECESSARY WAS ACQUIRED
UNDER PREVIOUS PROJECTS AND
BY THE DEVELOPER.

FEDERAL ROAD REGION NO.	DIVISION	PROJECT NO.	SHEET NO.
XXX	COLORADO	CC 07-0036-12	1

NO REVISIONS	AS CONSTRUCTED
8-10-84	VOID

DIST. IV	FILE	COPY
DIST. ENGR.		
ASST. ENGR.		
CONSTR.		
PRE-CONST.		
ERA		
UTIL.		
DESIGN		
ROW		
MAT'L'S		
EQ.		
RE-PE'S		
MAINT.		
TRAFFIC		

PLAN AND PROFILE OF PROPOSED

COLORADO PROJECT NO. CC 07-0036-12
STATE HIGHWAY NO. 36


BOULDER COUNTY



SCALES OF ORIGINAL DRAWINGS

ON PLAN, 1 IN. = 50 FT.
ON PROFILE, 1 IN. = 50 FT. HORIZONTAL
1 IN. = 5 FT. VERTICAL

GRADE LINE ON PROFILE IS SHOWN AS GRADE OF FINISHED ROAD

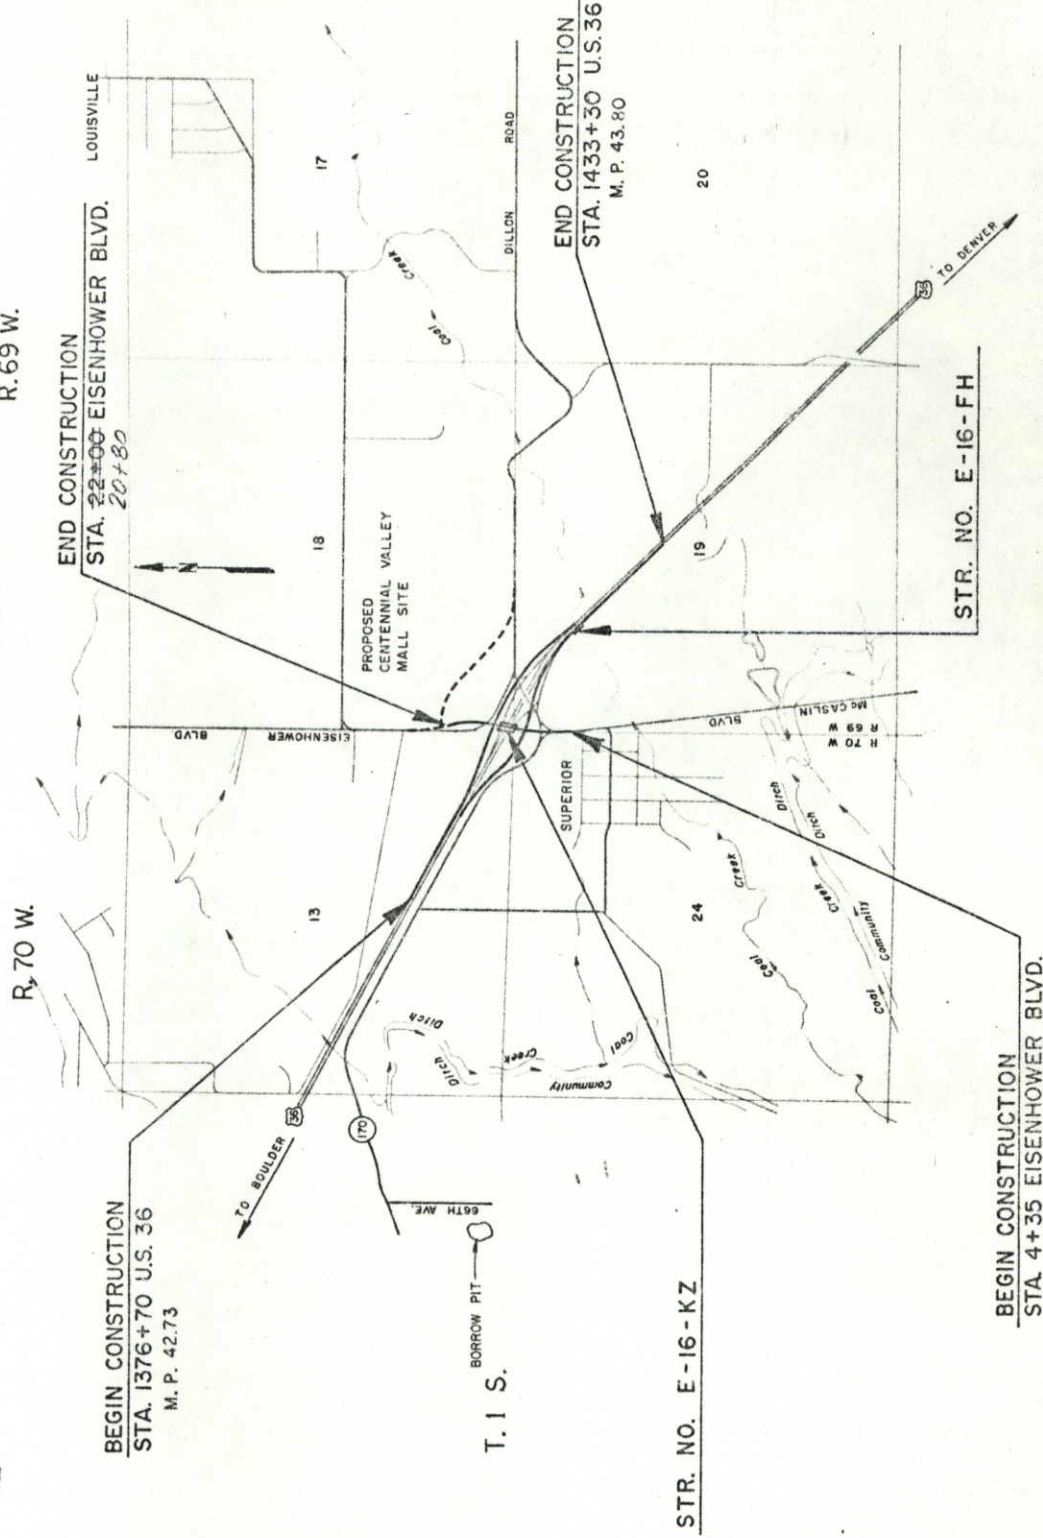

INDEX OF SHEETS

SHEET NO.

DESCRIPTION

- | SHEET NO. | DESCRIPTION |
|-----------|--|
| 1 | TITLE SHEET |
| 2 | STANDARD PLANS LIST |
| 3-4 | TYPICAL SECTIONS |
| 5 | GENERAL NOTES AND TRAFFIC DIAGRAMS |
| 6-12 | SUMMARY OF APPROXIMATE QUANTITIES |
| 13 | TABULATION OF REMOVALS |
| 14 | TABULATION OF FENCING, DELINEATORS AND EARTHWORK |
| 15 | TABULATION OF CURB AND GUTTER, SIDEWALK, CONCRETE CUB RAMP, MEDIAN COVER MATERIAL AND GUARD RAIL |
| 16 | BASE COURSE AND SURFACE COURSE PLAN |
| 17 | TABULATION OF DRAINAGE ITEMS |
| 18 | SPECIAL DETAILS - RIPRAP OUTLET BASINS |
| 19 | SPECIAL DETAILS - TRAFFIC CONTROL DETAILS FOR EISENHOWER BOULEVARD BRIDGE PIER CONSTRUCTION |
| 20 | BORROW PIT SKETCH |
| 21-30 | EISENHOWER BOULEVARD BRIDGE DETAILS |
| 31-45 | COAL CREEK BRIDGE WIDENING DETAILS |
| 46-51 | PLAN SHEETS |
| 52-57 | PROFILE SHEETS |
| 58 | INTERCHANGE GEOMETRICS |
| 59-61 | INTERSECTION DETAILS |
| 62-64 | CONSTRUCTION PHASING PLAN |
| 65-66 | CONTOUR GRADING AND DRAINAGE |
| 67-68 | LANDSCAPING PLAN |
| 69-80 | SIGNING AND PAVEMENT MARKING PLANS |
| 81-82 | TRAFFIC SIGNAL PLANS |
| 83 | LIGHTING PLAN |
| 27A-X | REVISED SIDEWALK SIDEWALK DETAIL |
| 43A-X | REVISED DECK SECTION |
| 58A-X | REVISED EISENHOWER AVENUE DETAILS |
| 59X | REVISED INTERSECTION DETAILS |
| 81X | REVISED TRAFFIC SIGNAL LAYOUT |
| 82X | REVISED TRAFFIC SIGNAL PLAN |
| 83X | REVISED LIGHTING PLAN |

AS CONSTRUCTED PLANS
RETURN TO DIST. 4 DESIGN



AS CONSTRUCTED INFORMATION

CONTRACTOR	VARRA-SIEGIST, LEONARD
PROJECT ENGINEER	DON EVANS
PROJECT STARTED	Jan 4, 1983
PROJECT COMPLETED	Aug 10, 1984
AS CONSTRUCTED PLANS APPROVED	[Signature]
TITLE	8/30/84
DATE	

DIVISION OF HIGHWAYS

APPROVED: [Signature] 11-1-84 DATE

Asst. Chief Engineer



SCALE IN MILES

GENERAL NOTES

ALL WORK SHALL BE DONE ACCORDING TO THE STANDARD SPECIFICATIONS OF THE DIVISION OF HIGHWAYS, STATE OF COLORADO, APPLICABLE TO THE PROJECT.
EXPANSION JOINT MATERIAL SHALL MEET ASHTO SPECIFICATION M-213.
ALL STRUCTURAL STEEL SHALL BE ASHTO M-103 (ASTM A-36) UNLESS OTHERWISE NOTED.
ALL ASHTO M-103 (ASTM A-36) STEEL NOT OTHERWISE NOTED SHALL BE PAINTED IN ACCORDANCE WITH SECTION 509 OF THE STANDARD SPECIFICATIONS. THE COLOR SHALL BE STANDARD GREEN.
ALL BOLTS SHALL BE 3/4 INCH DIAMETER, HIGH STRENGTH, UNLESS OTHERWISE NOTED.
NO WELDING OF ANY KIND SHALL BE PERMITTED ON THE FLANGES OF STEEL GIRDERS UNLESS SPECIFICALLY CALLED FOR ON THE PLANS.
GRADE 60 REINFORCING STEEL IS REQUIRED FOR #5 BARS AND LARGER. GRADE 40 MAY BE USED FOR #4 BARS.
APPLIED WIND LOADS AND EARTHQUAKE LOADS WERE NOT CONSIDERED IN ANALYZING THE STRUCTURE FOR STABILITY DURING THE CONSTRUCTION STAGES.

E.F. = EACH FACE
F.F. = FAR FACE
N.F. = NEAR FACE

STATIONS, ELEVATIONS, AND DIMENSIONS CONTAINED IN THESE PLANS ARE CALCULATED FROM "AS CONSTRUCTED PLANS" AND RECENT FIELD SURVEY.

THESE STATIONS, ELEVATIONS, AND DIMENSIONS MAY BE ADJUSTED TO MEET THE EXISTING STRUCTURE. THE CONTRACTOR SHALL VERIFY ALL DIMENSIONS IN THE FIELD BEFORE ORDERING OR FABRICATING ANY MATERIAL.

STRUCTURE BACKFILL ON THE FILL SIDE OF ABUTMENTS AND WINGWALLS SHALL BE CLASS 1. STRUCTURE BACKFILL ON THE CHANNEL SIDE OF ABUTMENTS AND WINGWALLS SHALL BE CLASS 2.

STRUCTURE EXCAVATION AND BACKFILL QUANTITIES FOR THE ABUTMENTS AND WINGWALLS ARE COMPUTED TO NEAR LINES 18 INCHES OUTSIDE AND PARALLEL TO THE OUTLINE OF THE FOUNDATION PLAN. STRUCTURE EXCAVATION QUANTITIES FOR RIPRAP ARE LIMITED TO THE VOLUME OF RIPRAP PLACED BELOW THE STREAM BED.

DESIGNED BY	DATE	INITIAL	CHECKED BY	DATE	INITIAL
DESIGNED BY	DATE	INITIAL	CHECKED BY	DATE	INITIAL
DESIGNED BY	DATE	INITIAL	CHECKED BY	DATE	INITIAL
DESIGNED BY	DATE	INITIAL	CHECKED BY	DATE	INITIAL

THE FOLLOWING TABLE GIVES THE MINIMUM LAP SPICE LENGTH FOR REINFORCING BARS:

BAR SIZE NUMBER	4	5	6	7	8	9	10	11
CLASS A CONCRETE	1'-0"	1'-3"	1'-6"	2'-0"	2'-3"	3'-0"	3'-10"	4'-10"
CLASS D CONCRETE	1'-0"	1'-3"	1'-6"	2'-0"	2'-3"	3'-0"	3'-4"	4'-2"
LENGTH	5'-1"	5'-1"	5'-1"	5'-1"	5'-1"	5'-1"	5'-1"	5'-1"

CROSS REFERENCE DRAWING NUMBER

SECTION OR DETAIL IDENTIFICATION

SUMMARY OF QUANTITIES

ITEM	DESCRIPTION	UNIT	Super-Structure	Abut 1	Abut 2	Totals
202*	REMOVAL OF PORTIONS OF PRESENT STRUCTURE	L.S.	1	1	1	1
206	STRUCTURE EXCAVATION	CU. YD.		223	223	446
206	STRUCTURE BACKFILL (CLASS 1)	CU. YD.		148	148	296
206	STRUCTURE BACKFILL (CLASS 2)	CU. YD.		52	52	104
403	HOT BITUMINOUS PAVEMENT (GRADING EX) (HAUL & ASPHALT)	TON	7			7
506	RIPRAP	CU. YD.		38	29	67
506	PLASTIC FILTER CLOTH	SQ. YD.		38	29	67
509	STRUCTURAL STEEL	LB.	18,106			18,106
509	STRUCTURAL STEEL (GALVANIZED)	LB.	3,810			3,810
515	WATERPROOFING MEMBRANE	SQ. YD.	46			46
518	WATERSTOP (6 INCH)	L.F.		21	20	41
518	BRIDGE EXPANSION DEVICE (0-2 INCH)	L.F.		10	10	20
601**	CONCRETE CLASS A (BRIDGE)	CU. YD.		61	60	121
601	CONCRETE CLASS D (BRIDGE) CMC No. 10	CU. YD.	15.52			15.52
602	REINFORCING STEEL	LB.	62,159	15,935	5,415	83,509
602	REINFORCING STEEL (EPOXY COATED)	LB.	4,445	1,595	1,595	7,635
606	GUARD RAIL TYPE 3A	L.F.	67			67
613	1 1/2 INCH ELECTRICAL CONDUIT	L.F.	54	114		168
613	2 INCH ELECTRICAL CONDUIT	L.F.	54	114		168

* INCLUDES REMOVAL OF EXISTING RAIL.

** INCLUDES CONCRETE MID SLAB.

LOADING DATA

LIVE LOAD: ASHTO HS-20-44 AND INTERSTATE ALTERNATE
DEAD LOAD: ASSUMES 50 LBS. PER SQ. FT. FOR BITUMINOUS PAVEMENT

DESIGN DATA

CURRENT ASHTO SPECIFICATIONS:
REINFORCED CONCRETE:
CLASS A CONCRETE: $f_c = 1,200$ psi, $n = 9$
CLASS D CONCRETE: $f_c = 1,600$ psi, $n = 8$
REINFORCING STEEL: #4 BARS AND LARGER: $f_s = 20,000$ psi
#5 BARS AND LARGER: $f_s = 24,000$ psi
EXCEPT FOR TRANSVERSE DECK SLAB BETWEEN GIRDERS, $f_s = 20,000$ psi
STRUCTURAL STEEL: ASHTO M-103 (ASTM A-36) $f_y = 20,000$ psi



Approved

BRIDGE ENGINEER DATE

(11-1-79)

AS CONSTRUCTED
NO REVISIONS
REVISED 8-10-84
VOID

FEDERAL ROAD REGION NO. VIII
DIVISION COLORADO
PROJ. NO. CC 07-0036-12
SHEET NO. 40
TOTAL SHEETS 90

REVISIONS

BRIDGE STANDARD O

INDEX OF DRAWINGS

GENERAL INFORMATION AND SUMMARY OF QUANTITIES
GENERAL LAYOUT
ABUTMENT AND WINGWALL DETAILS
SUPERSTRUCTURE DETAILS
BRIDGE EXPANSION DEVICE (0-2 INCH)
BRIDGE RAIL TYPE 3

B-1
B-2
B-3
B-4
B-5
B-6

BRIDGE DESCRIPTION

1 - SIMPLE SPAN (50'-0") BRIDGE WIDENING
WIDENING FROM 42'-0" TO 49'-3" OUT TO OUT.
CONCRETE SLAB AND ROLLED STEEL GIRDER (NON-COMPOSITE)
OVER COAL CREEK
46'-0" ROADWAY CURB TO CURB. 800' 00" SKEM
1'-3" CURB. TYPE 3 BRIDGE RAIL

DIVISION OF HIGHWAYS

GENERAL INFORMATION
SUMMARY OF QUANTITIES

Station 1419+33.00 TO
Station 1419+87.00

Near SUPERIOR Sec 19 T 1 S R 69 N


Designer D. HELLER

Detailer L. PACHECO

Drawing Number B 1 of 6 Drawings


AS CONSTRUCTED		FEDERAL ROAD REGION NO.		DIVISION	PROJ. NO.	SHEET NO.	TOTAL SHEETS
NO REVISIONS	REVISED <u>12-10-84</u>	VOID	XVIII	COLORADO	CC 07-0036-12	41	90

REVISIONS	

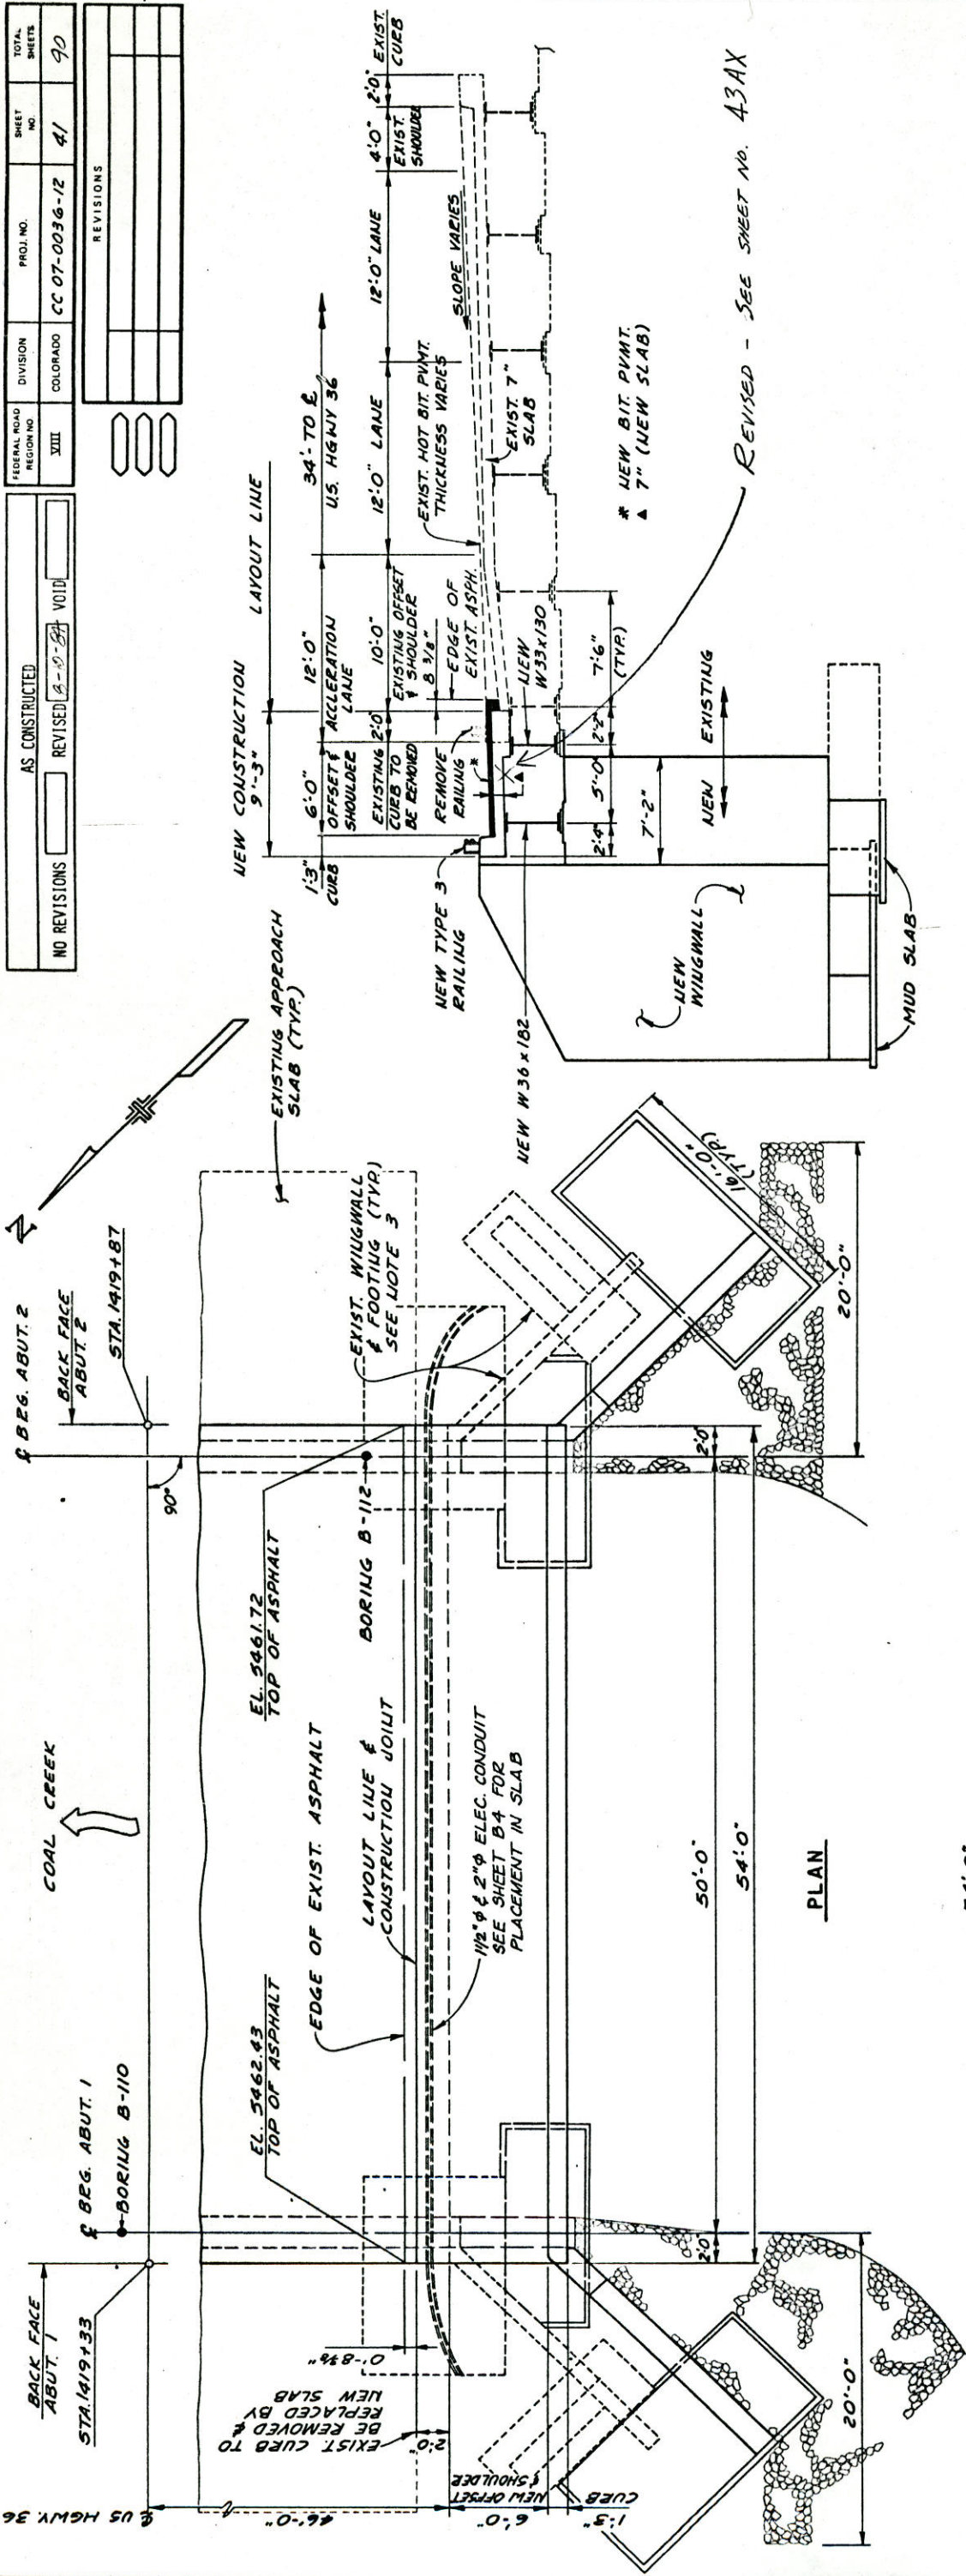

INITIAL	DATE	DESIGNED BY	D.J.H. 6-82	CHECKED BY	
		CHECKED BY			
		QUANTITIES BY	K.L.O. 6-82	CHECKED BY	E.W.K. 6-82
		DETAILED BY	L.J.P. 6-82	CHECKED BY	

TYPICAL SECTION

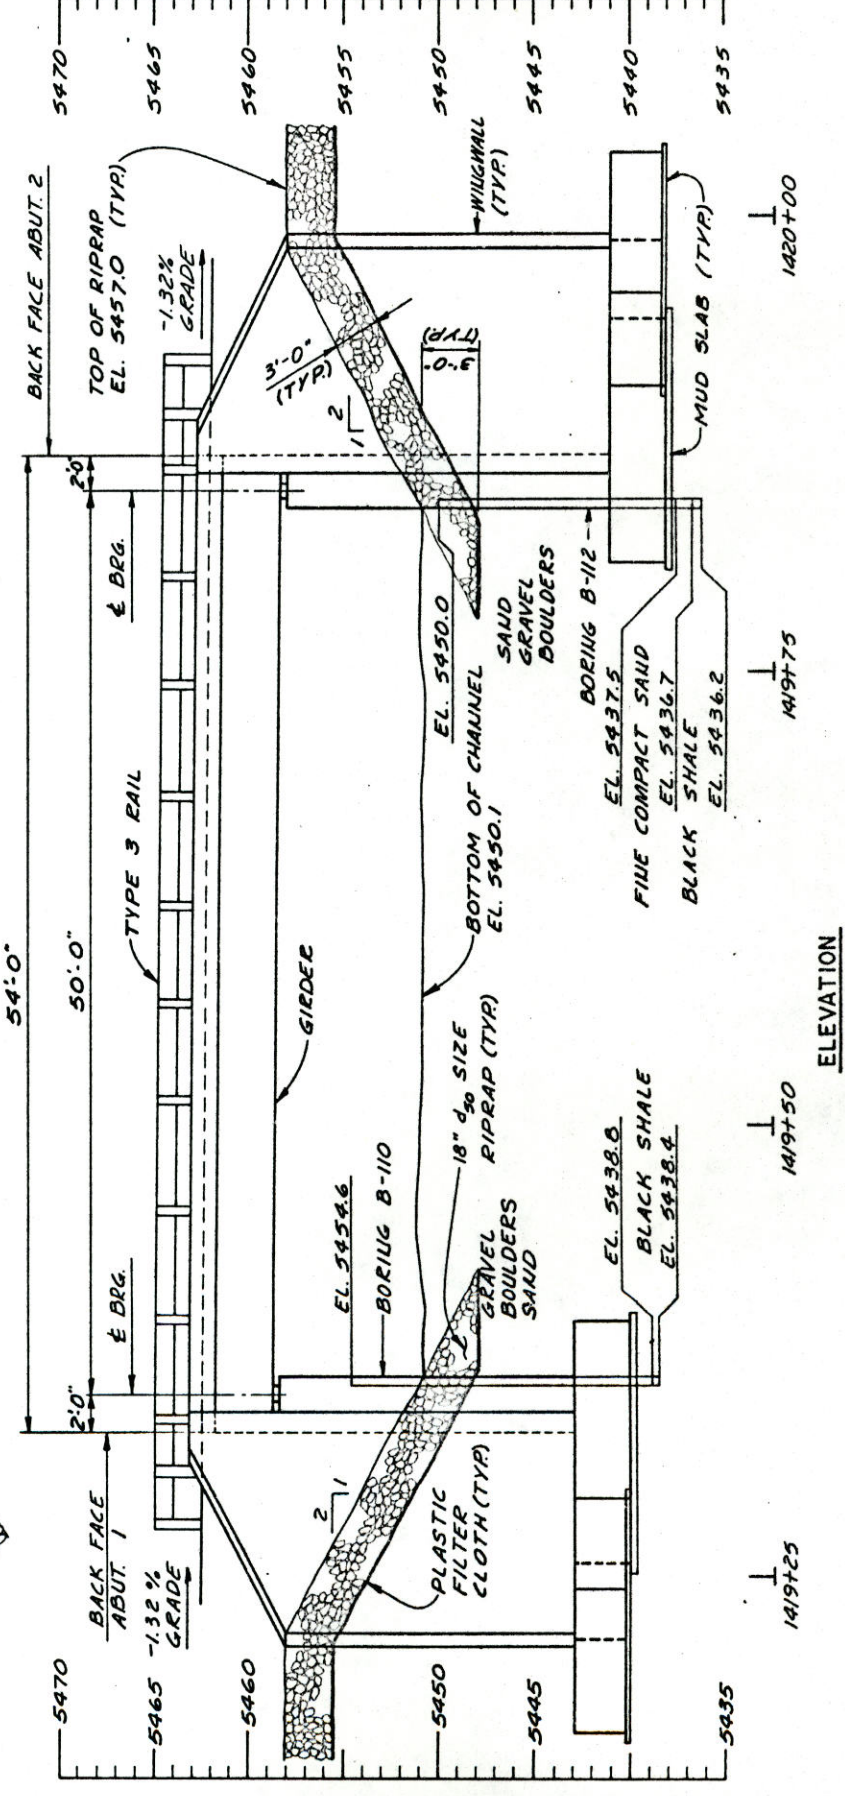

NOTES:

1. LIVE LOAD DESIGN CRITERIA :
HS 20-44 & INTERSTATE ALTERNATE
2 SOIL BORING LOGS TAKEN FROM
"AS CONSTRUCTED PLANS."
- PROJECT NO. T-170 (115)
3. PORTIONS OF EXISTING WINGWALLS
WITHIN 2' OF FINISHED GRADE SHALL BE
REMOVED. REMAINING PORTIONS MAY BE
REMOVED AT CONTRACTOR'S OPTION.
INCLUDE IN BID, PRICE FOR ITEM NO.
202, REMOVAL OF PORTIONS OF
PRESENT STRUCTURE.

CENTENNIAL ENGINEERING, INC. ARVADA, COLORADO

DIVISION OF HIGHWAYS

STATE HIGHWAY 36
OVER COAL CREEK
(SUPERIOR INTERCHANGE)

GENERAL LAYOUT


Designer <i>D. HELLER</i>	Structure	<i>E-16-FH</i>
Detailer <i>G. HIESCH</i>	Numbers	
Drawing Number <i>B 2</i> of <i>6</i> Drawings		

(Preliminary Stage Only)


STATE OF COLORADO
DIVISION OF HIGHWAYS
DESIGN DIVISION
DESIGNER: D. HELLER
CHECKED BY: L. J. P.
DATE: 6-82
DRAWING NUMBER: B-10-84
SHEET NO: 42
TOTAL SHEETS: 90

NO REVISIONS	AS CONSTRUCTED	REVISIONS	VOID
8-10-84			


FEDERAL ROAD DISTRICT NO.	PROJ. NO.	SHEET NO.	TOTAL SHEETS
VIII	CC 07-0036-12	42	90

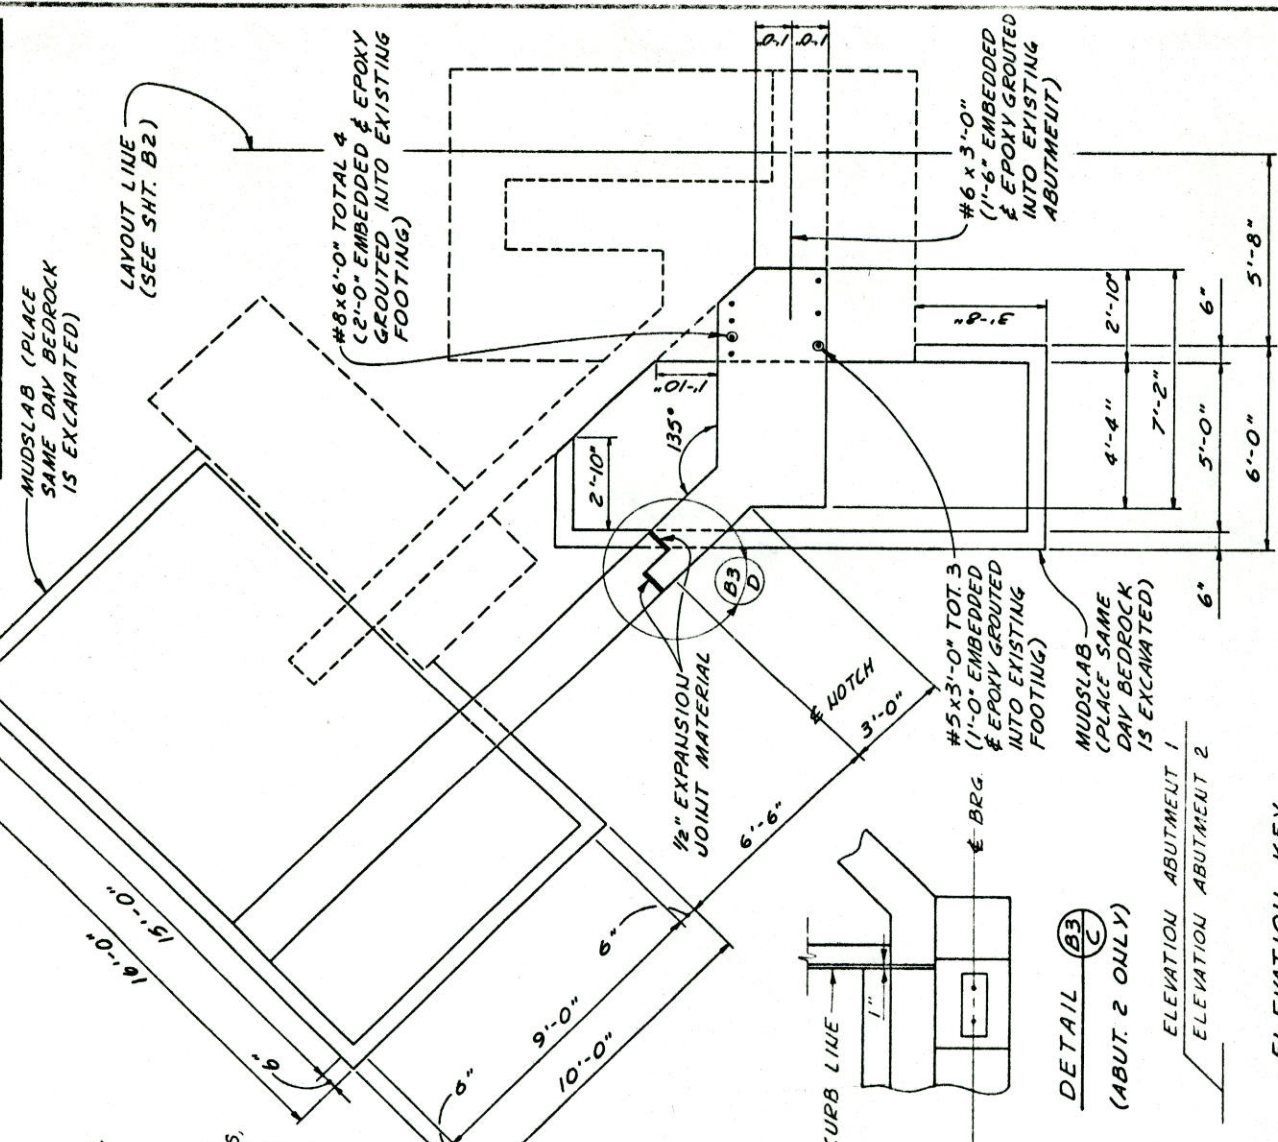

FOOTING PLAN

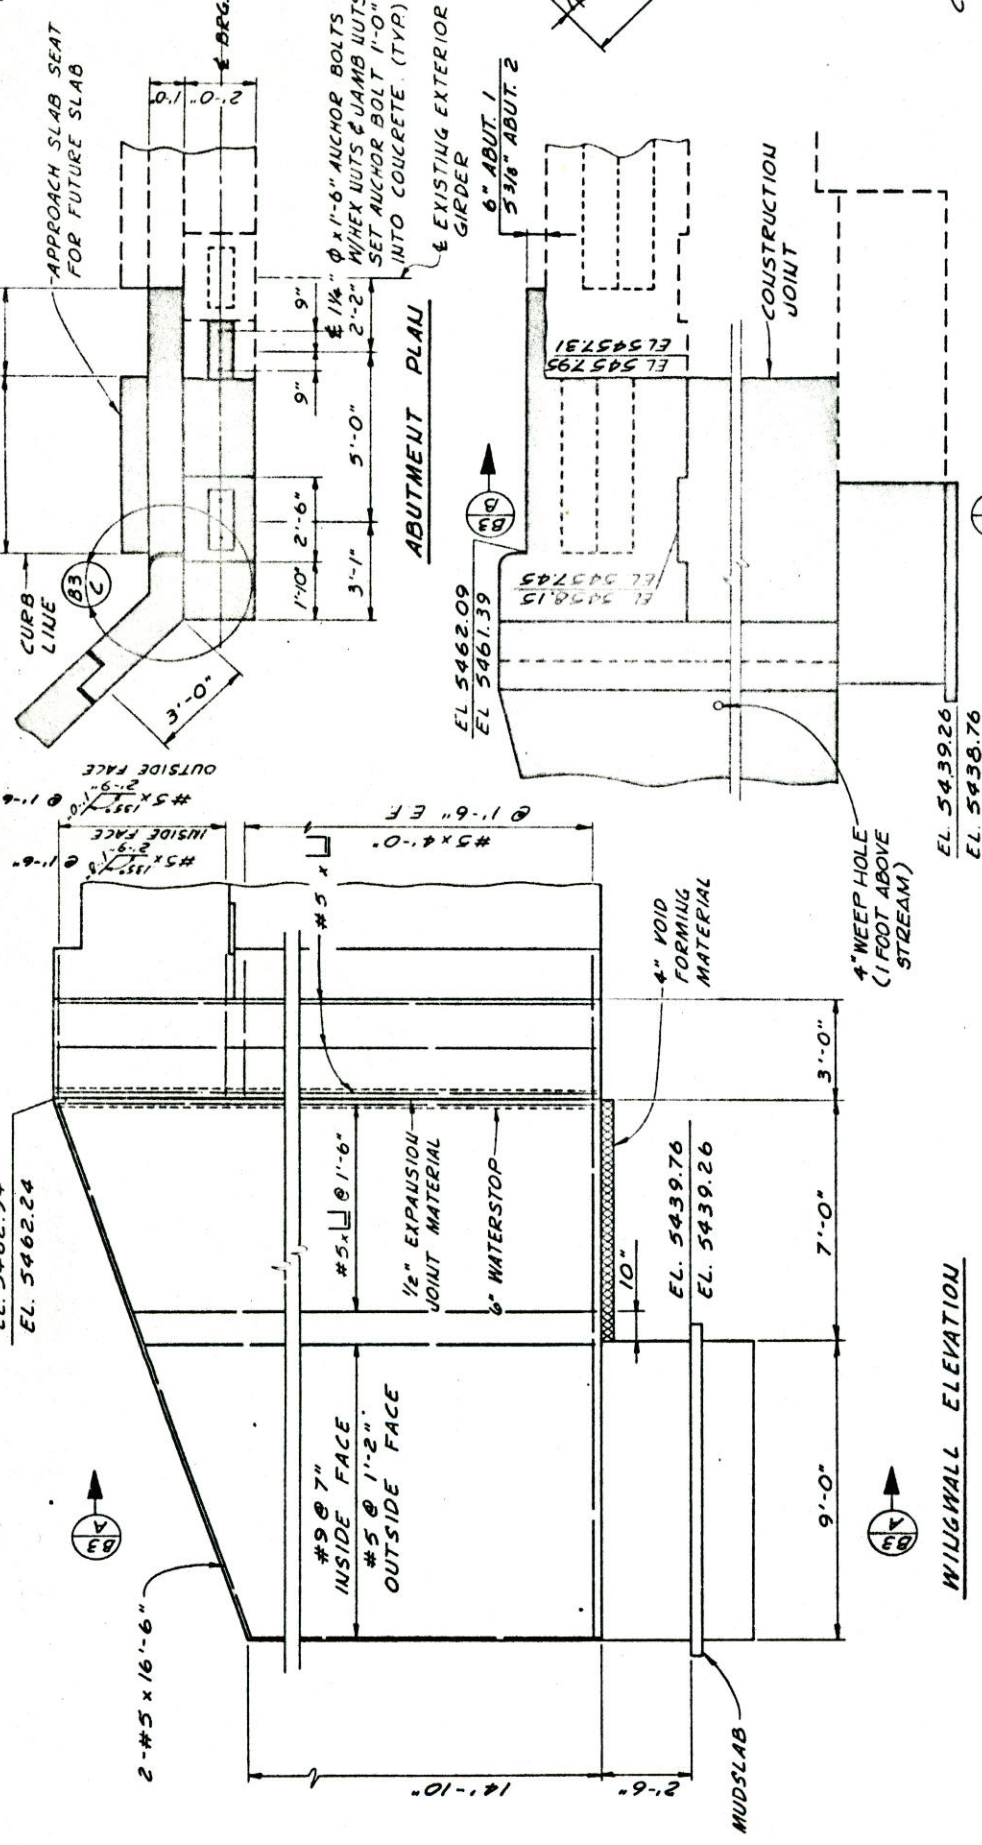


ABUTMENT ELEVATION

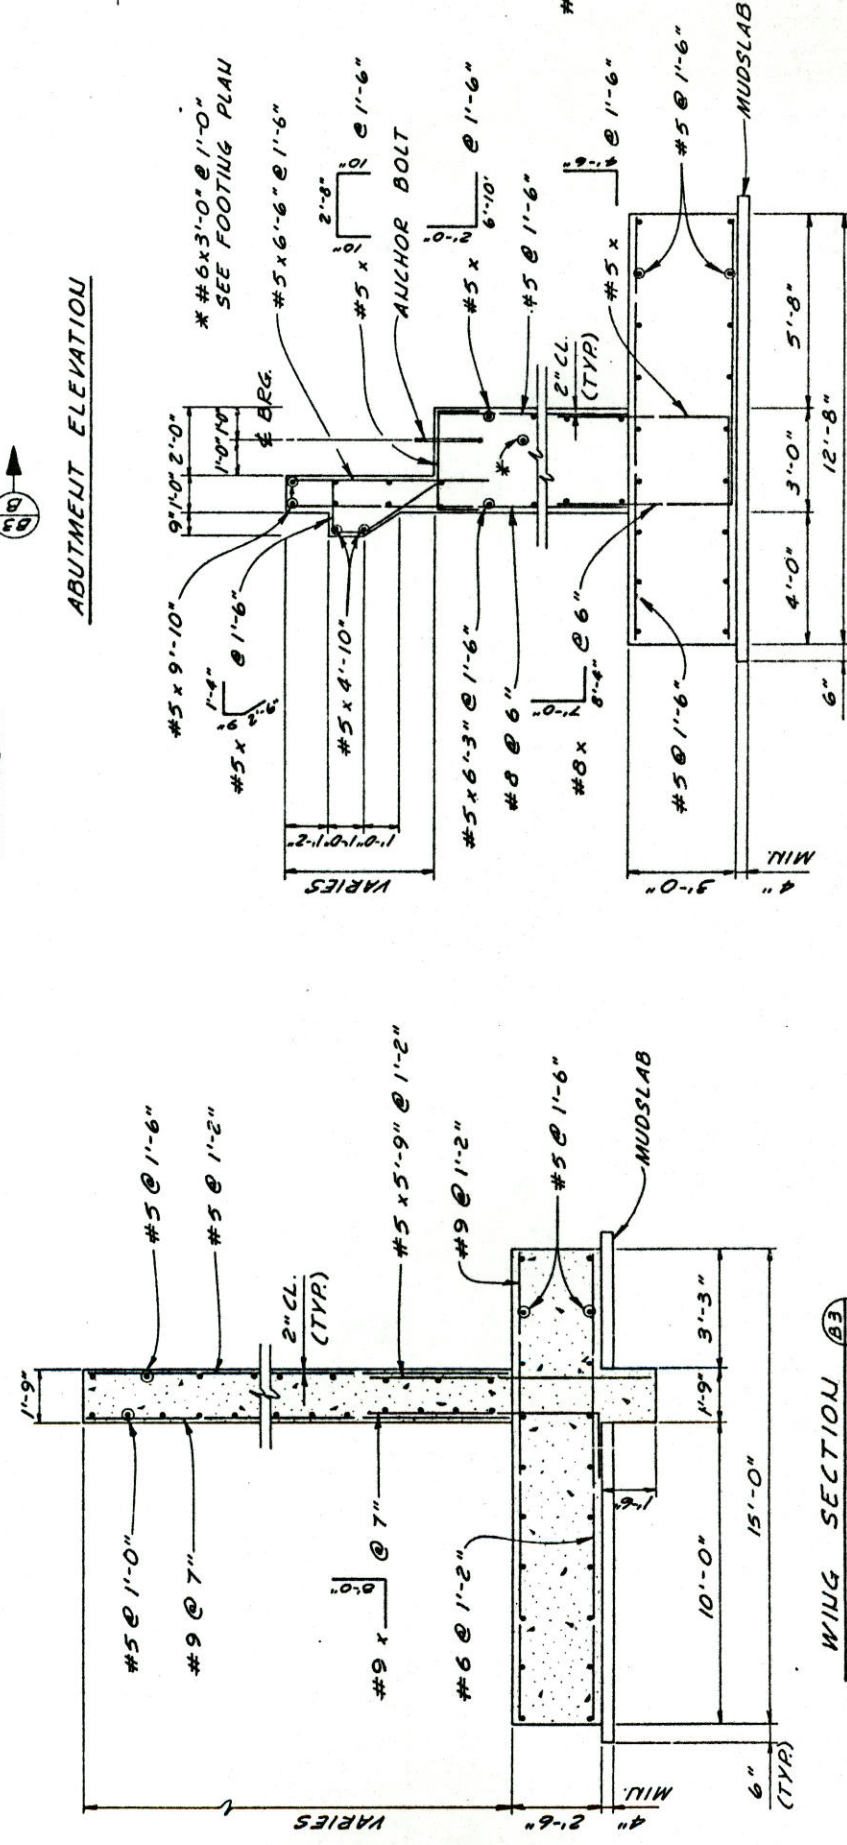


WINGWALL ELEVATION


ELEVATION KEY

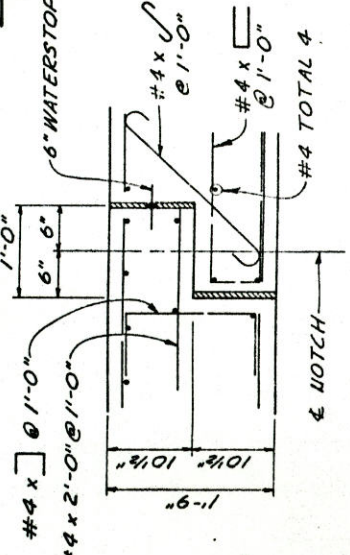

DETAIL B3

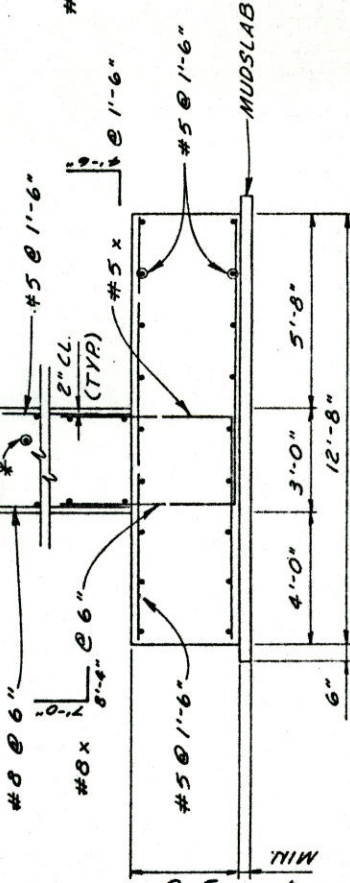

ABUTMENT SECTION B3

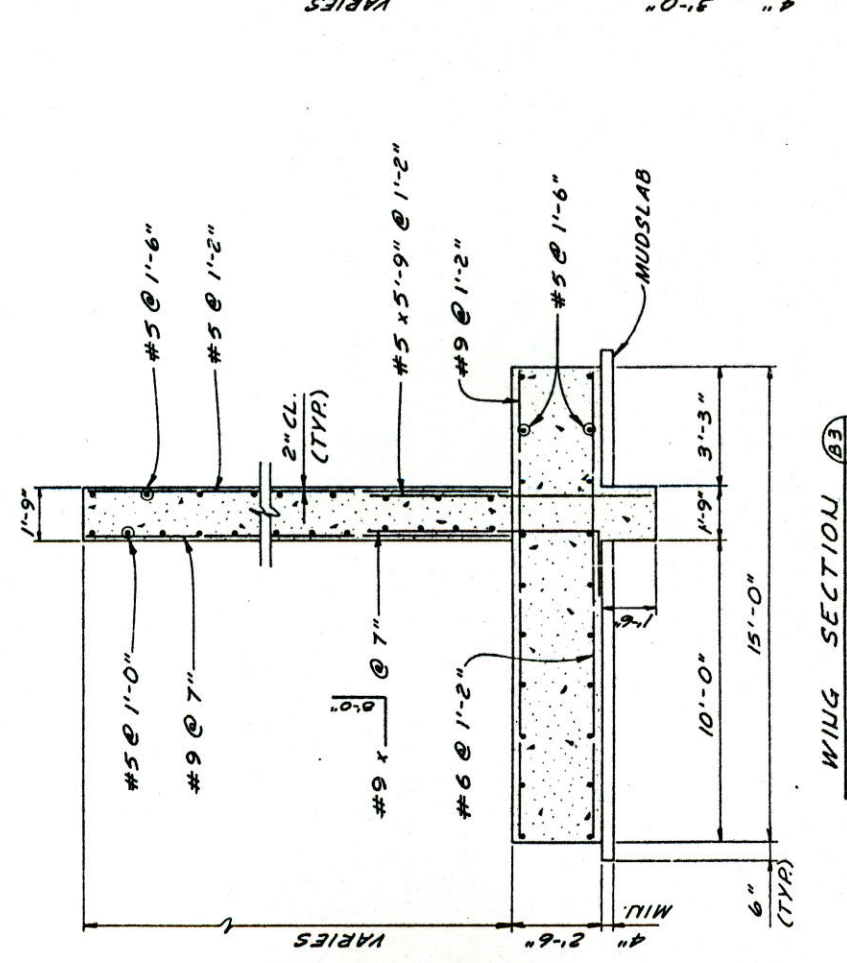

WING SECTION B3

DIVISION OF HIGHWAYS

STATE HIGHWAY 36
OVER COAL CREEK
(SUPERIOR INTERCHANGE)


ABUTMENT & WINGWALL DETAILS

Designer: D. HELLER
Checker: L. J. P.
Drawing Number: B-10-84
SHEET NO: 42
TOTAL SHEETS: 90

FEDERAL POLICE REGION NO.	DIVISION	PROJ. NO.	SHEET NO.	TOTAL SHEETS
VIII	COLORADO	C.C. 57-0036-12	434X	

AS CONSTRUCTED

NO REVISIONS	REVISED	VOID
	8-19-84	

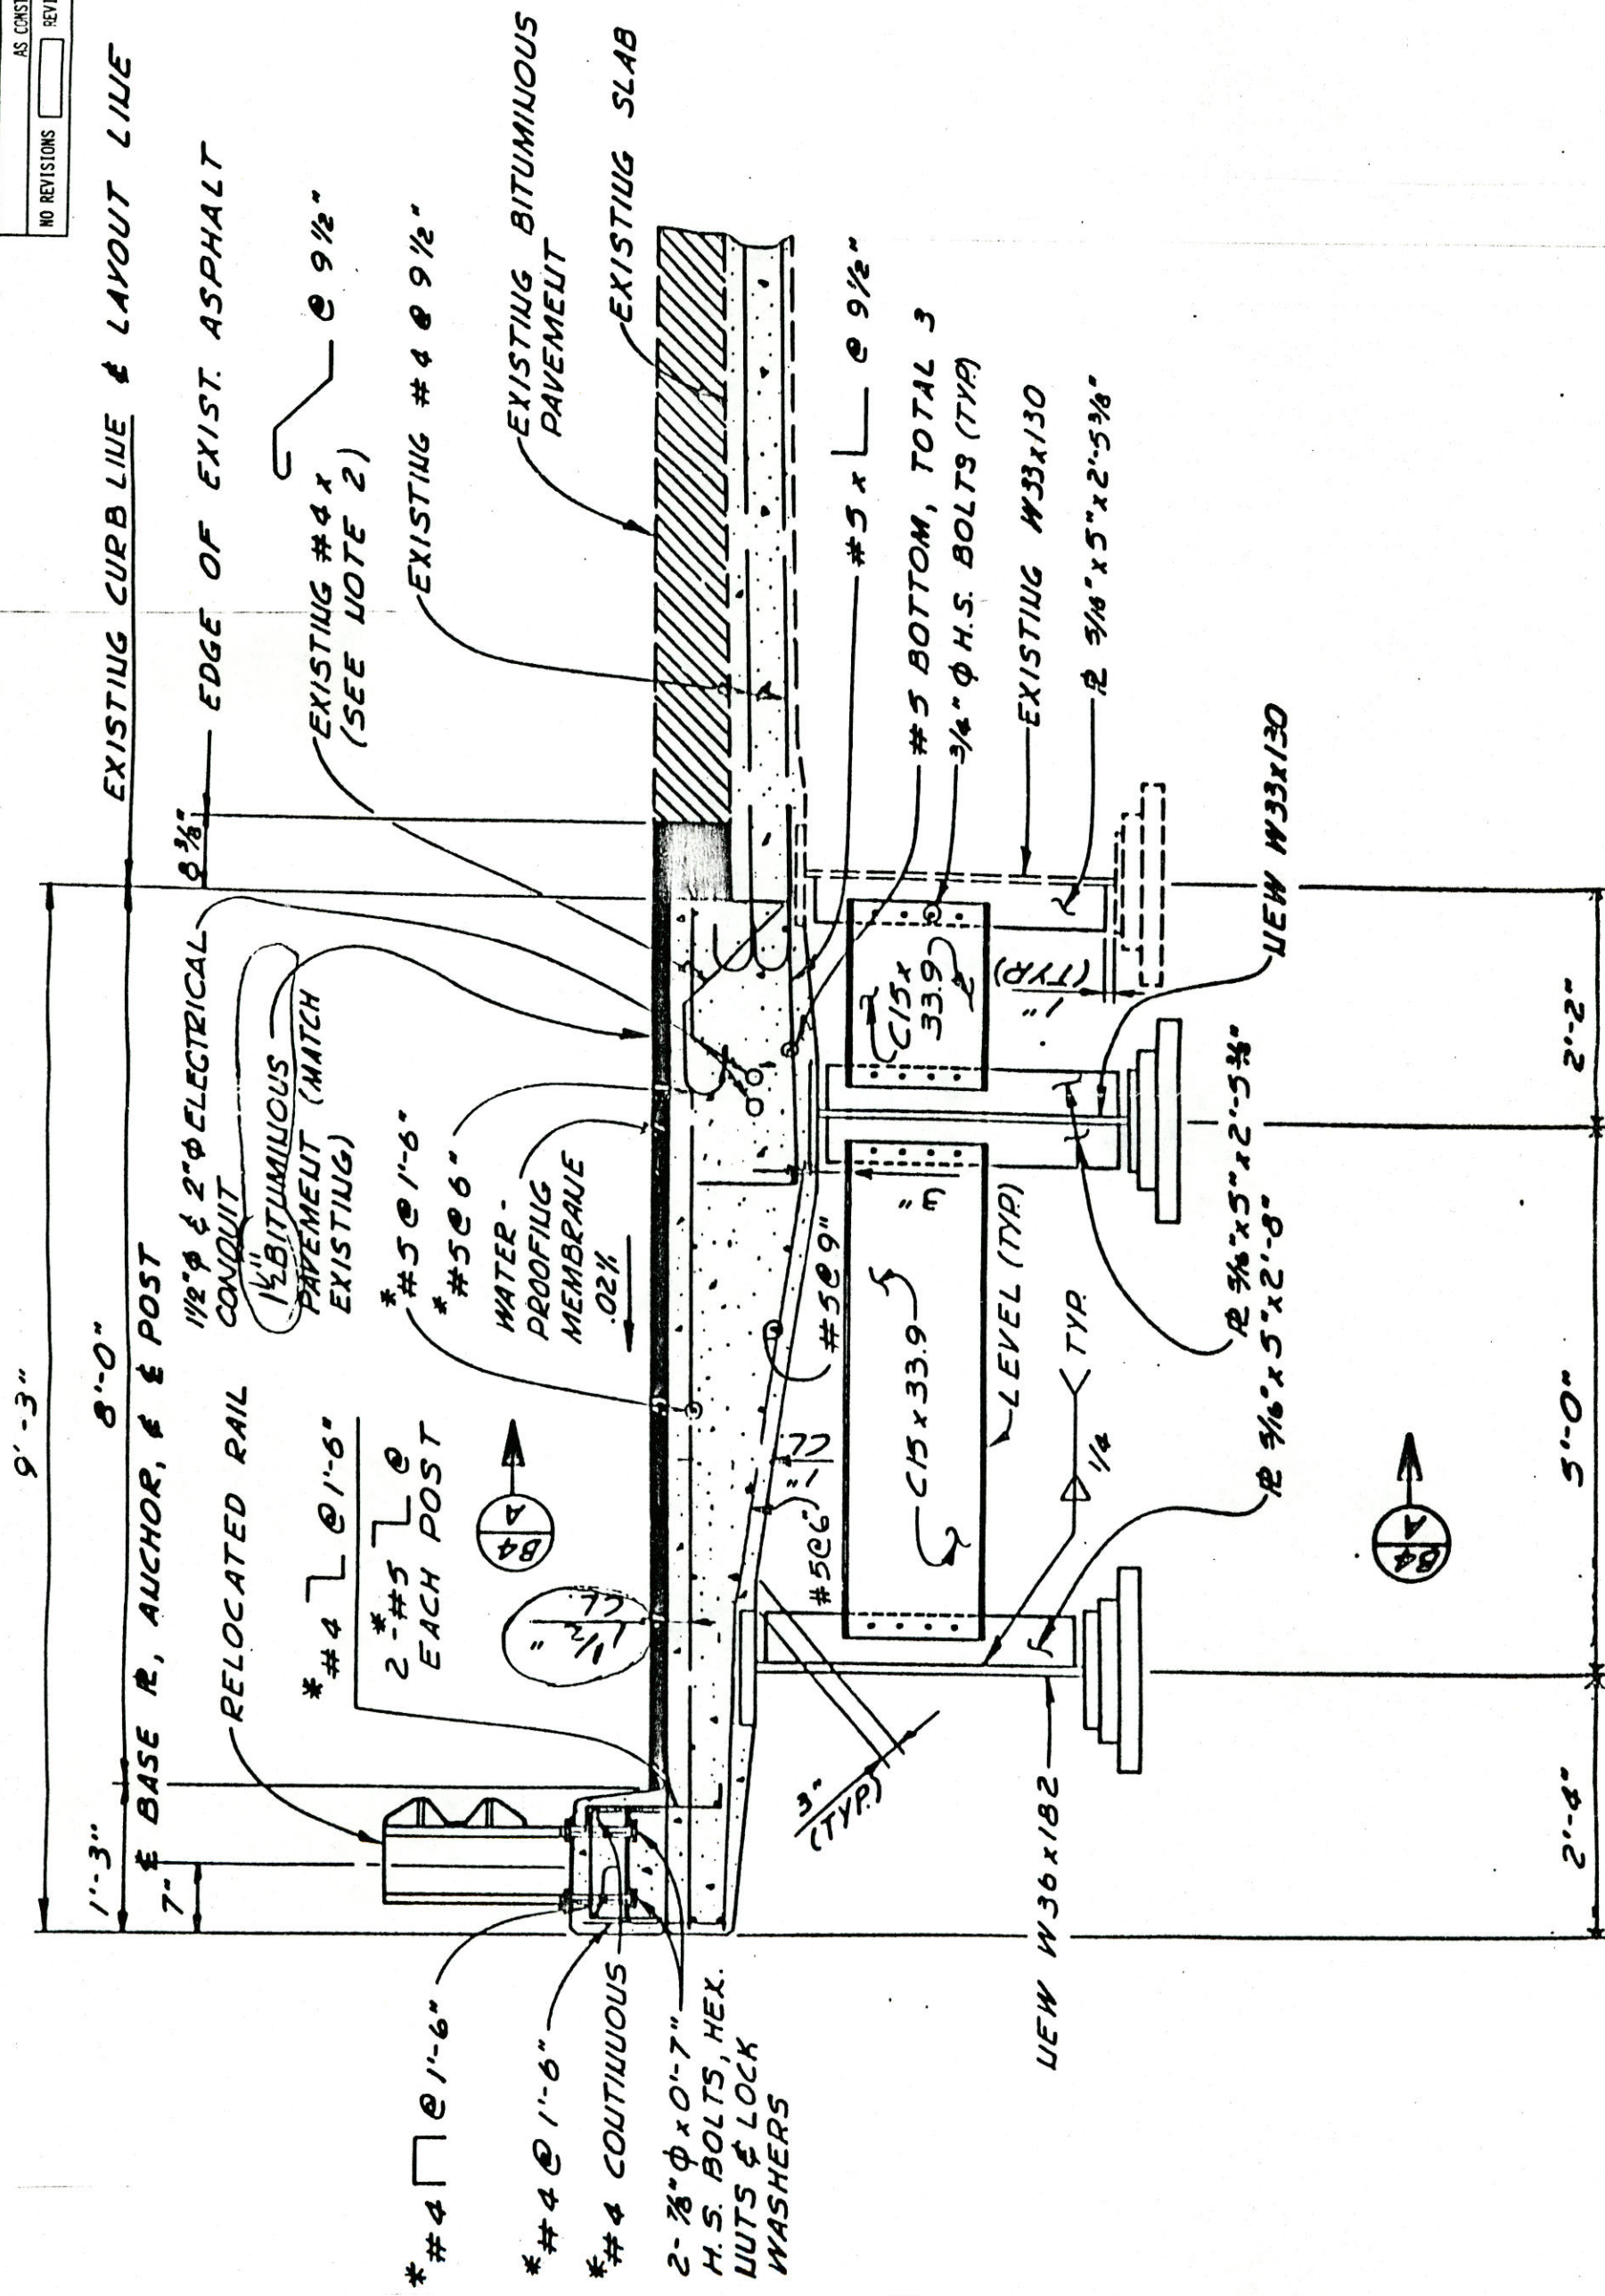

AS CONSTRUCTED	NO REVISIONS	REVISED	8-10-84	VOID
----------------	--------------	---------	---------	------

FEDERAL ROAD DISTRICT NO.	DIVISION	PROJ. NO.	SHEET NO.	TOTAL SHEETS
XIII	COLORADO	CC-07-0036-12	44	90

REVISIONS			

BRIDGE STANDARD 41


NOTES

- THE EXPANSION DEVICE SHALL BE INSTALLED ON GRADE, PARALLEL TO THE SLOPE AND GRADE OF THE DECK.
- AFTER THE CONCRETE HAS ATTAINED INITIAL SET, THE ATTACHMENTS USED TO HOLD THE ANGLE ASSEMBLY IN ITS PROPER POSITION SHALL BE REMOVED.
- DO NOT PAINT STEEL SURFACES.
- THE SHOP DRAWINGS SHALL INDICATE THE "A" DIMENSION AT A RANGE OF TEMPERATURES FROM 30° TO 100° ASSUMING A MID-POINT OPERATING RANGE TEMPERATURE OF 40°.
- ANGLE ASSEMBLIES TO EXTEND GUTTER TO GUTTER ONLY.
- OPENING IN CURB AND SIDEWALK TO BE CONSTRUCTED TO THE EXACT 40TH OF THE DECK OPENING AT THE TIME OF CURB AND SIDEWALK PLACEMENT.
- VENT HOLES SHALL NOT BE USED FOR SUPPORT BOLTS.
- ALL STRUCTURAL STEEL NOT OTHERWISE NOTED SHALL BE AASHTO M-183 (ASTM A-36).
- THE "B" DIMENSION IS DEPENDENT UPON THE PARTICULAR COMPRESSION JOINT SEAL SUPPLIED, AND SHALL BE SHOWN ON THE SHOP DRAWINGS.


* BRAND NAME EVAZOTE

TYP. SECTION THRU EXPANSION JOINT


NOTE: THE "A" DIMENSION FOR THE COMPRESSION JOINT SEAL IS BASED ON A 2 1/2" UNCOMPRESSED SEALER SIZE. THE CONTRACTOR SHALL VERIFY THE EXACT WIDTH OF THE UNCOMPRESSED COMPRESSION JOINT SEALER AT THE JOB SITE AND ADJUST THE "A" DIMENSION ACCORDINGLY.

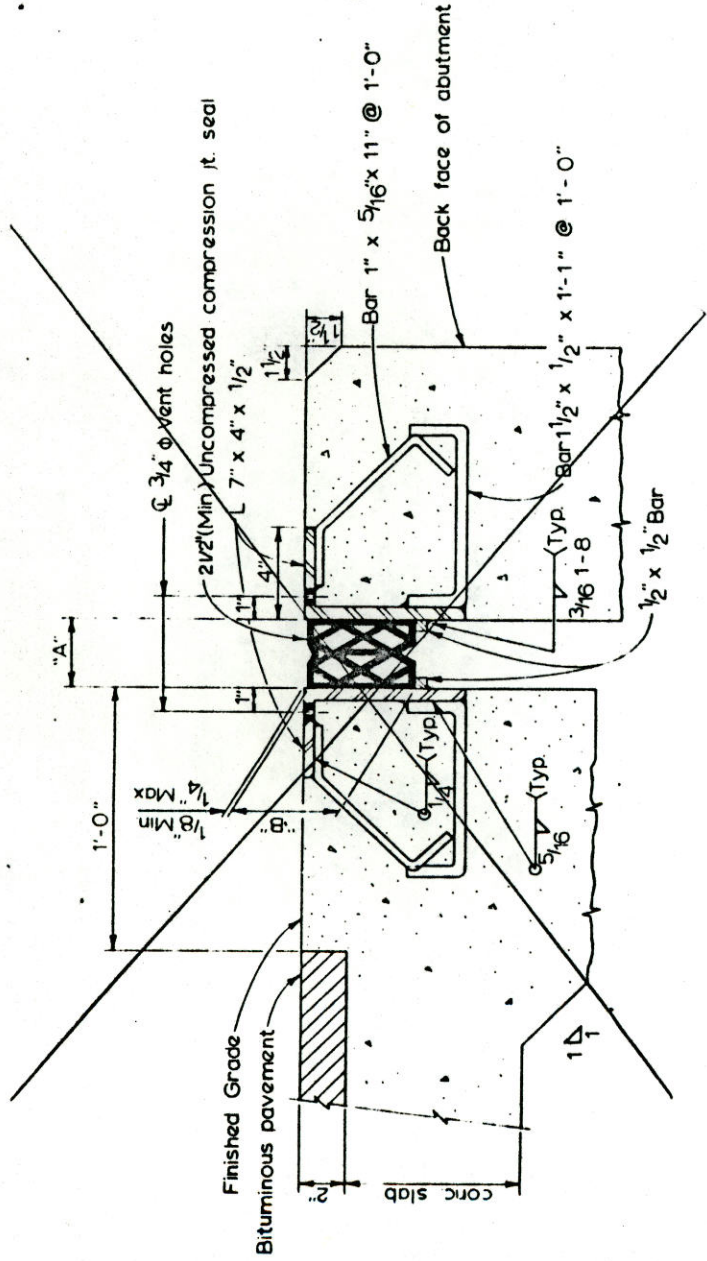

TYP. SECTION THRU EXPANSION JOINT

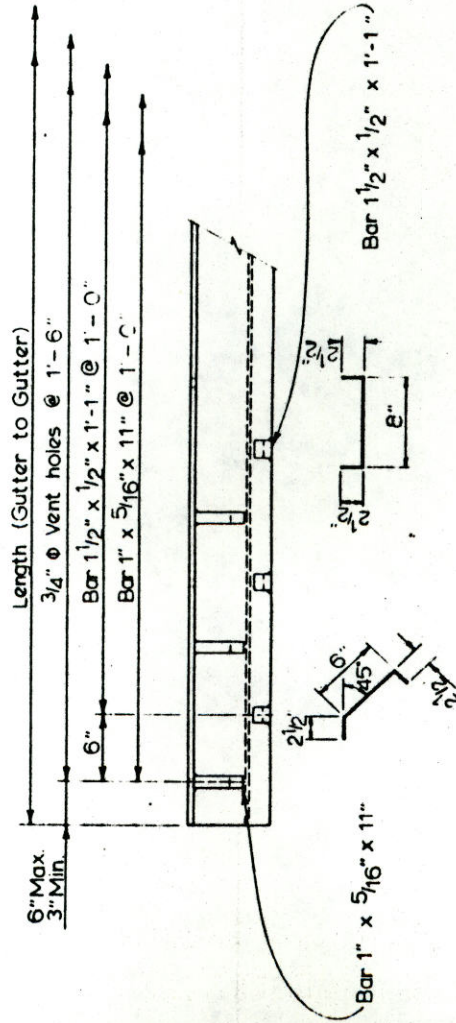

ANGLE (7"x4"x1/2") DETAIL

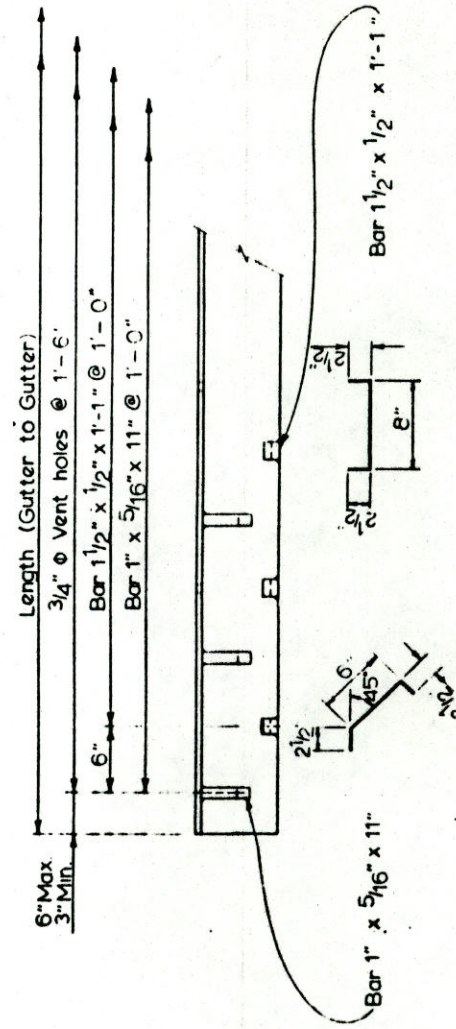

ANGLE (6"x4"x1/2") DETAIL

compression jt. seal		closed-cell, foamed, cross-linked ethylene vinyl acetate/low-density polyethylene copolymer.	
Structure Temperature	Dim. "A"	Structure Temperature	Dim. "A"
30°F	ABUT. 1 1/2"	30°F	ABUT. 1 1/2"
40°F	1 1/2"	40°F	1 1/2"
50°F	1 1/2"	50°F	1 1/2"
60°F	1 1/2"	60°F	1 1/2"
70°F	1 1/2"	70°F	1 1/2"
80°F	1 1/2"	80°F	1 1/2"
90°F	1 1/2"	90°F	1 1/2"
100°F	1 1/2"	100°F	1 1/2"

DIVISION OF HIGHWAYS

BRIDGE EXPANSION DEVICE


(0-2 INCH)

Designer	Structure Numbers	of	Drawings
Detailer S. HILL		6	
Drawing Number B 5			

PLAN	DATE	BY
SHAFTED		
PLOTTED		
ALIGNED & CHECKED		
NOTE BOOK		
NO.		


NO.		
NOTE BOOK		
ALIGNED & CHECKED		
PLOTTED		
SHAFTED		
DATE		
BY		

NO REVISIONS		AS CONSTRUCTED		REVISED		VOID										
5-10-64																
FEDERAL ROAD REGION NO.	DIVISION	PROJ NO.	SHEET NO.	TOTAL SHEETS												
VIII	COLORADO	CC 07-0036-12	49	90												
REVISIONS <table border="1"> <tr><td> </td><td> </td><td> </td></tr> <tr><td> </td><td> </td><td> </td></tr> <tr><td> </td><td> </td><td> </td></tr> </table>																

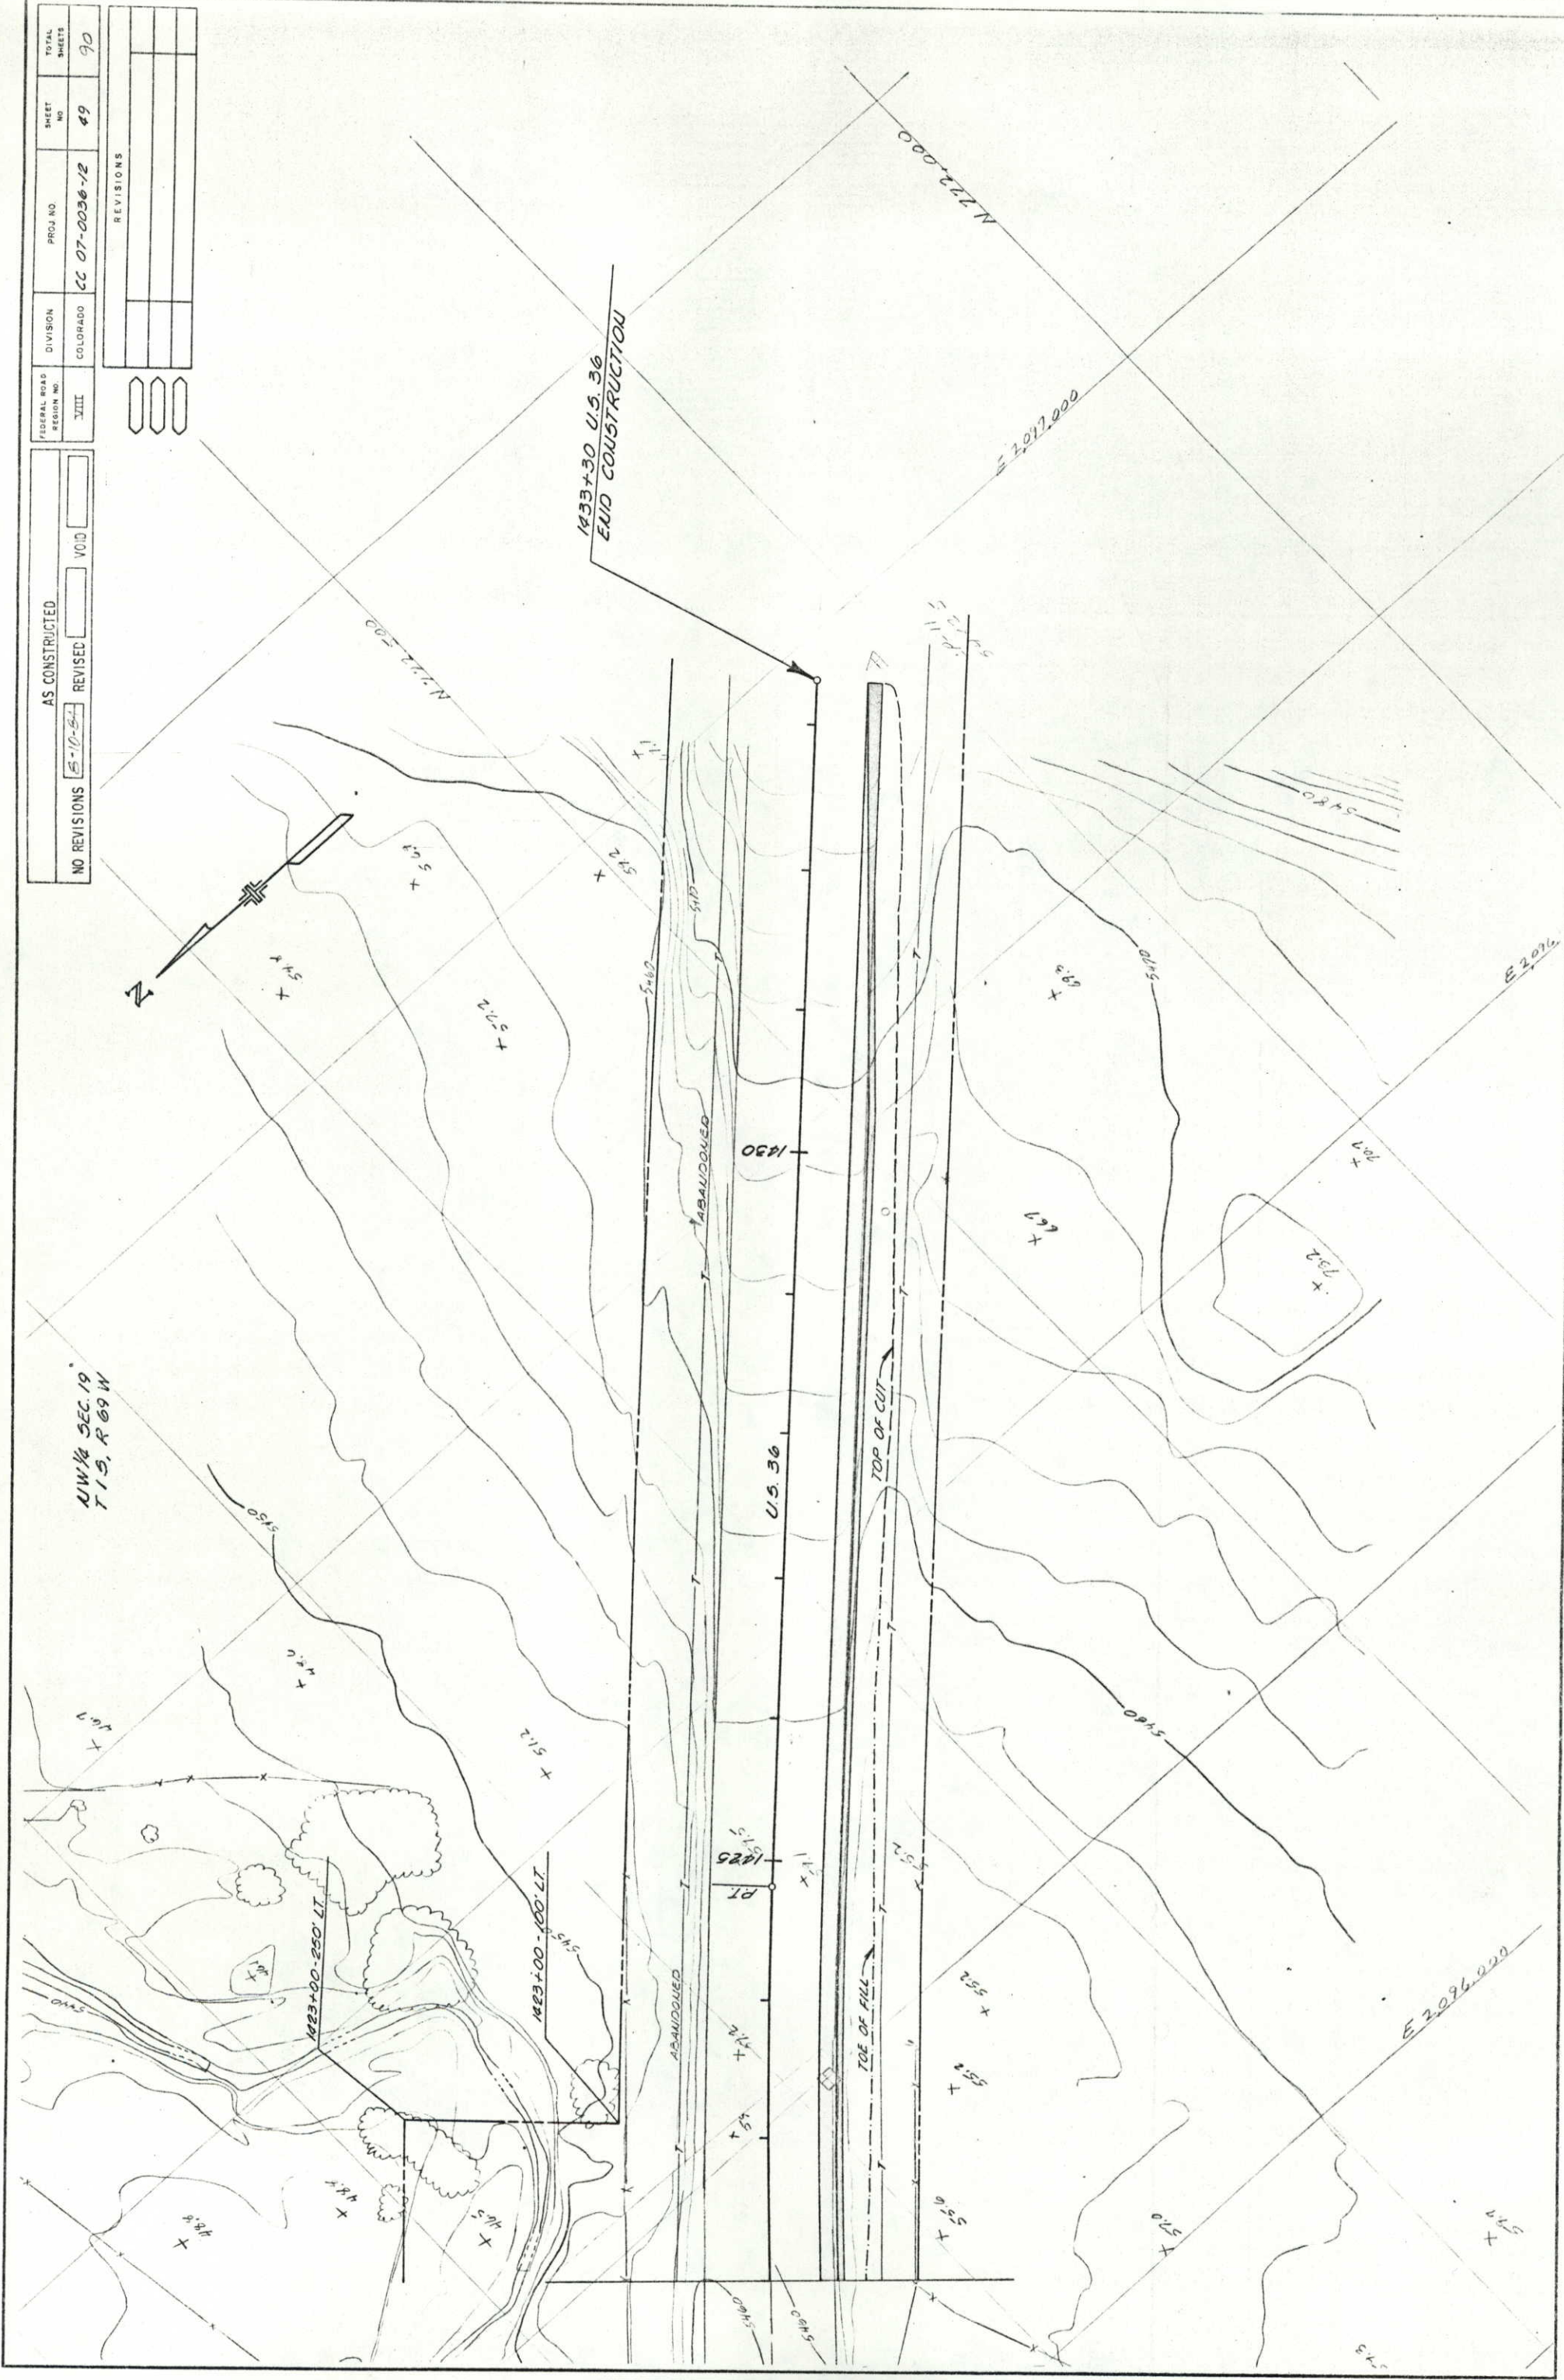

NO REVISIONS		AS CONSTRUCTED		TOTAL SHEETS	
8-10-84		VOID		50	
8-10-84		VOID		90	

REVISIONS	

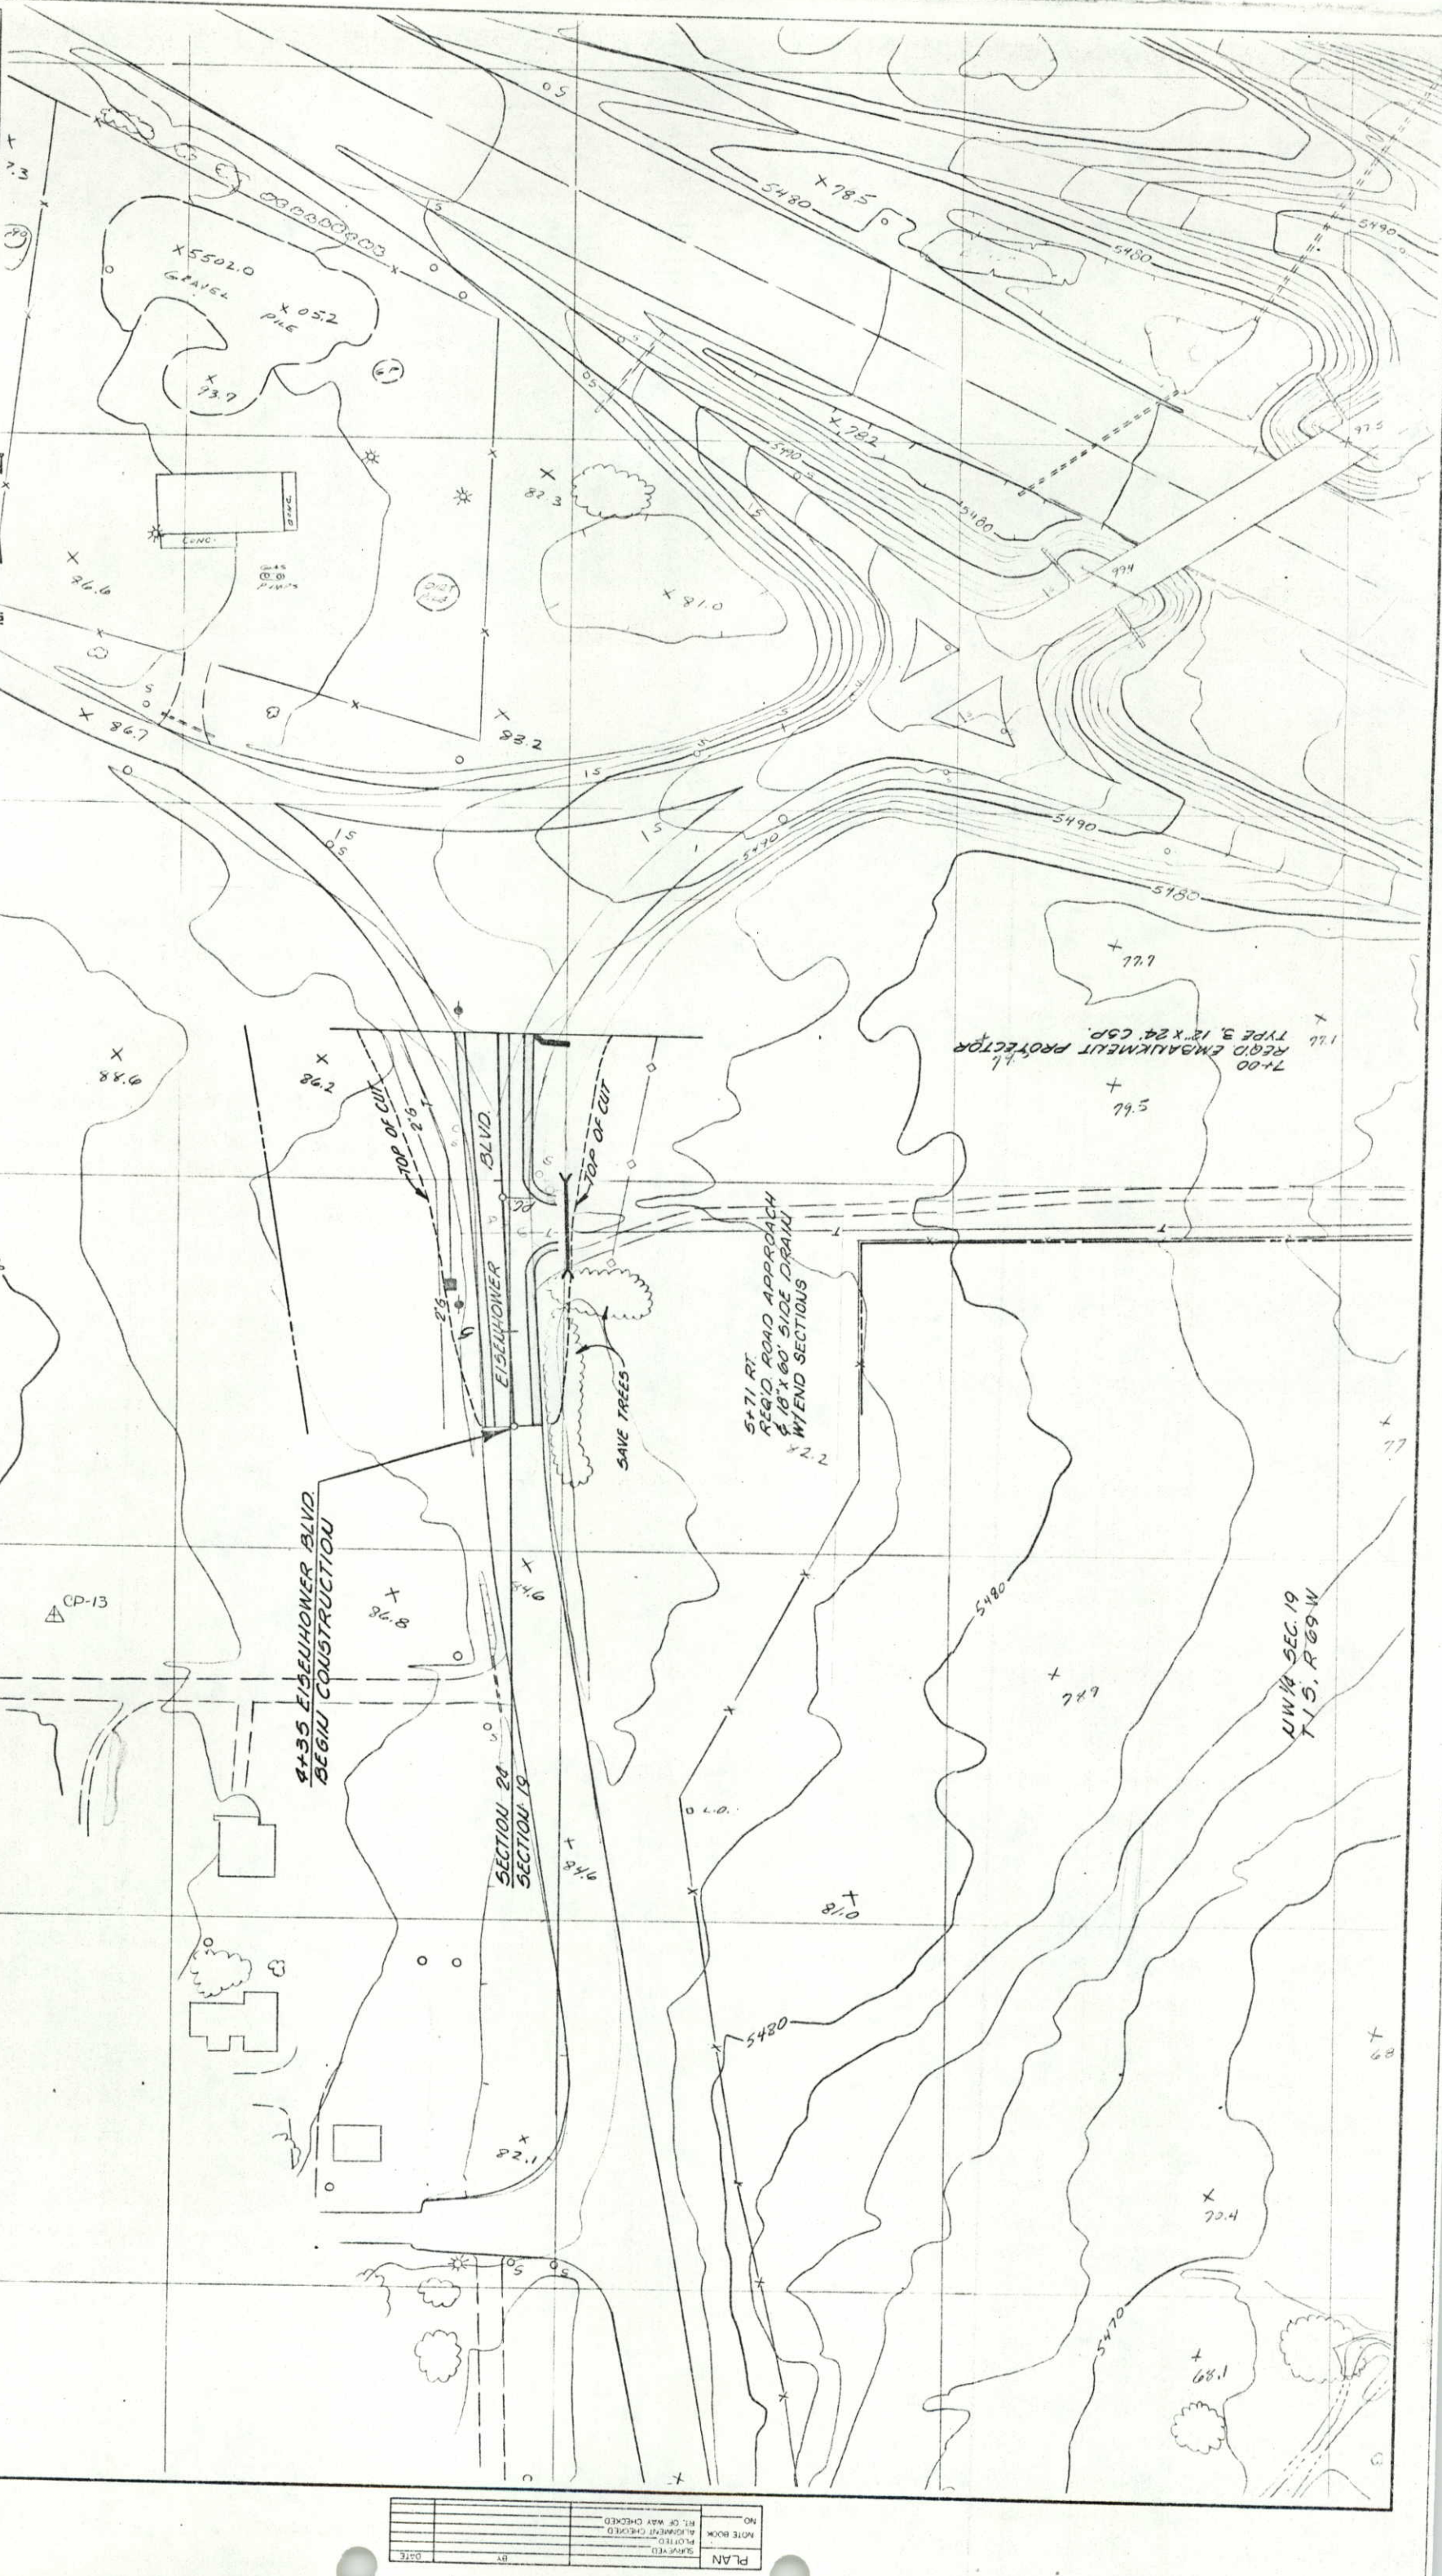


NE 1/4 SEC 28
T 1 S, R 70 W

SW 1/4 SEC 19
T 1 S, R 69 W

PLAN	DATE
BY	
NOTED	
ALIGNED	
CHECKED	
NO.	

REVISIONS

DATUM BEUCHARK:
 SPIKE IN POWER POLE NE CORNER
 OF OLD MAINTENANCE YARD
 EL. 5484.37

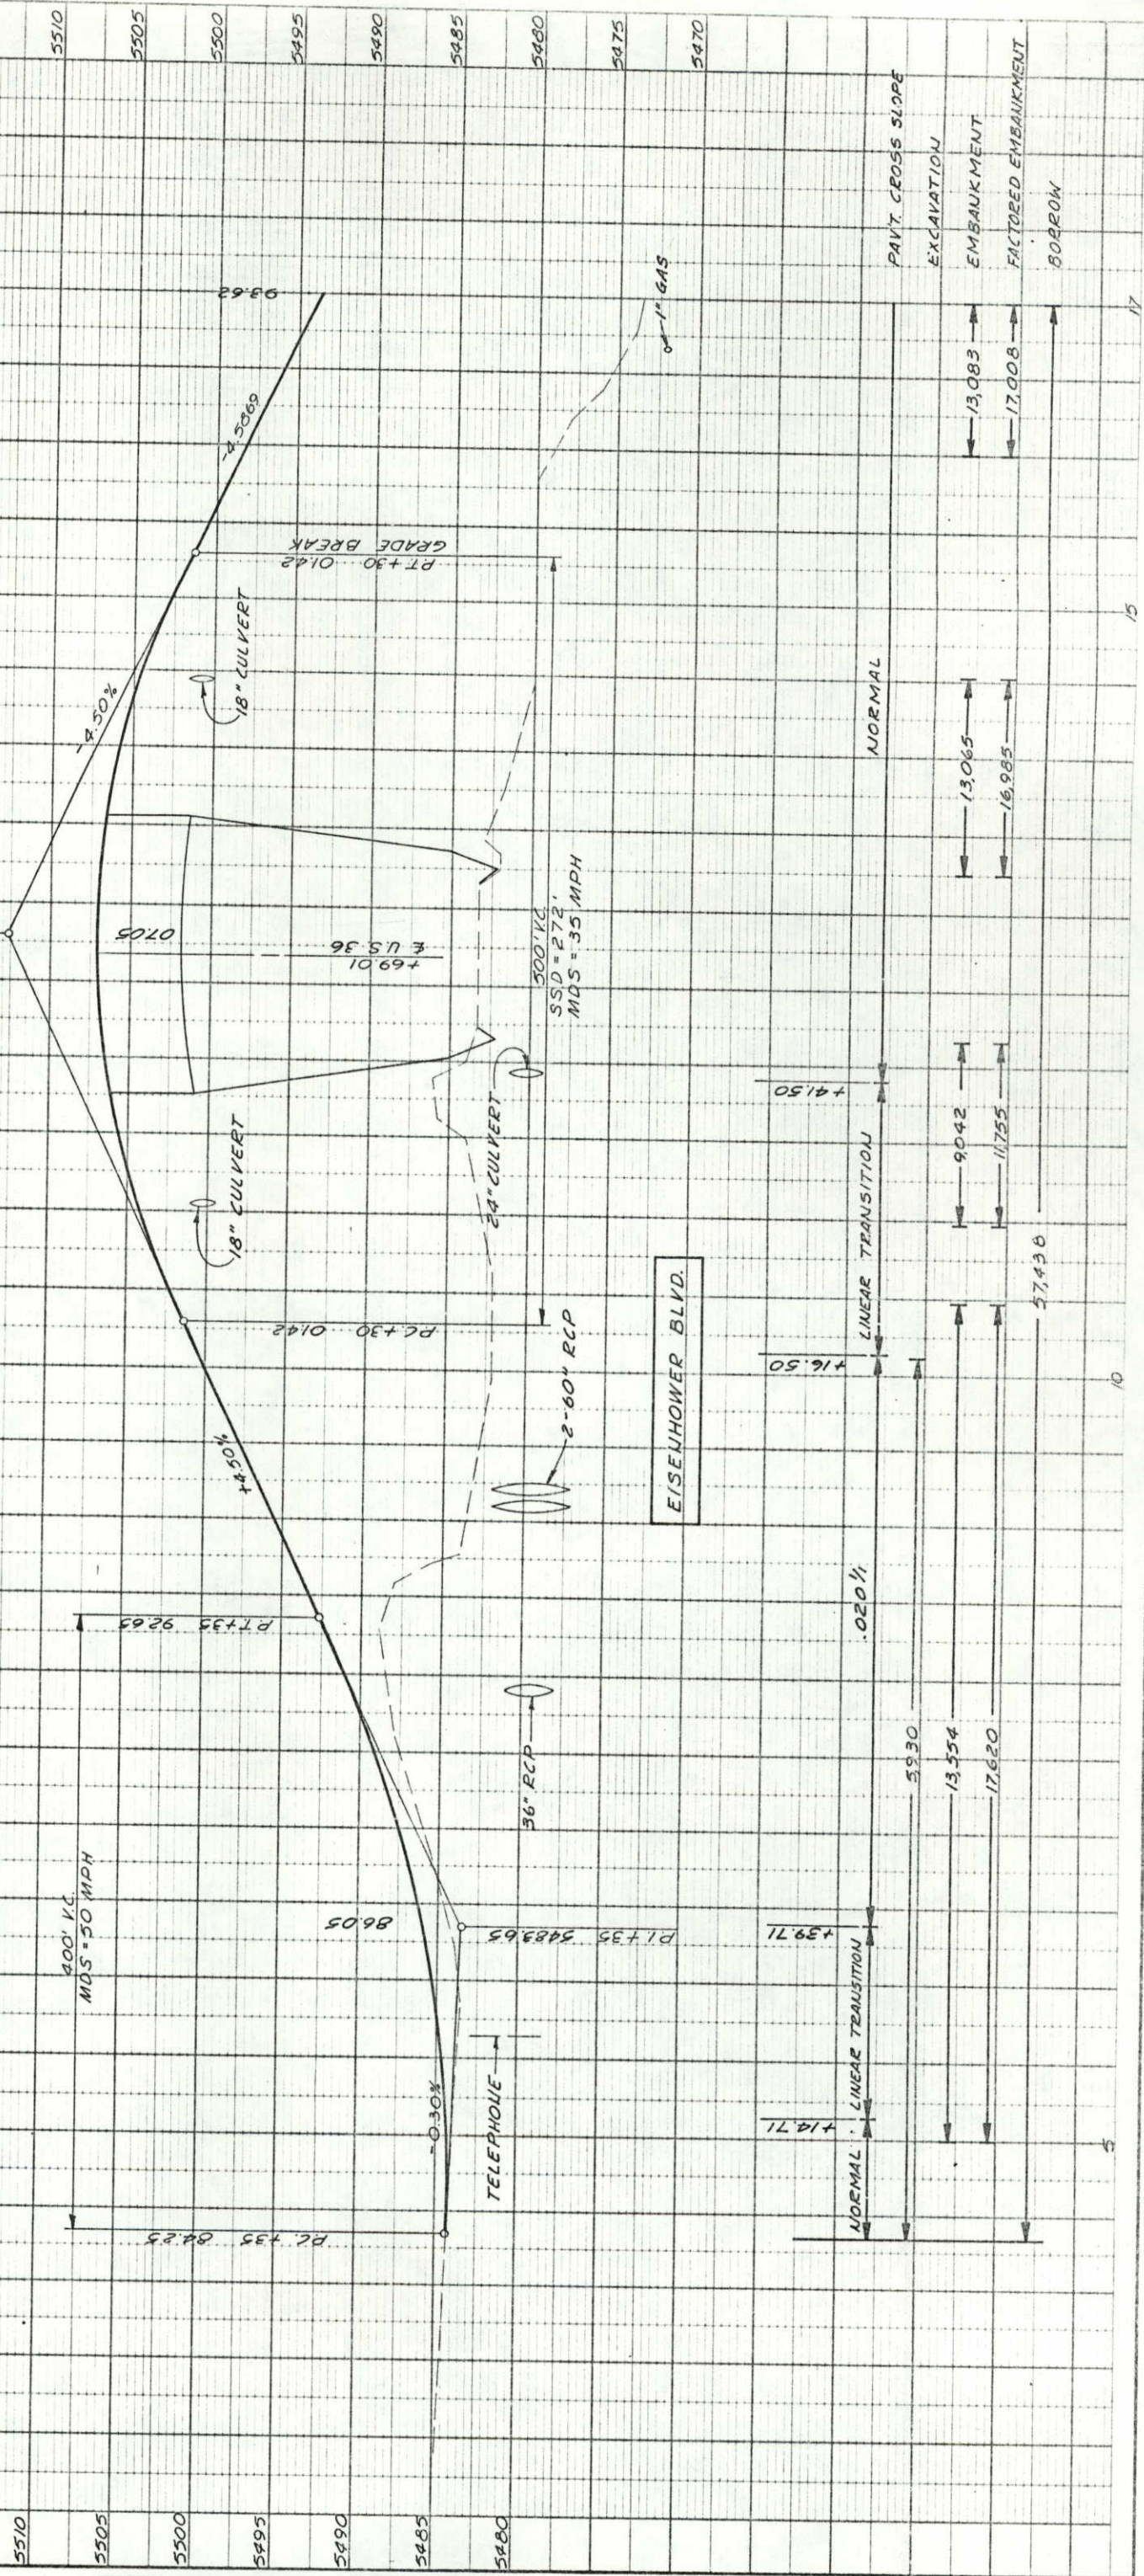

PROFILE

NO.	STRUCTURE	NOTE
1	56" RCP	SEE NOTE
2	2-60" RCP	SEE NOTE
3	18" CULVERT	SEE NOTE
4	24" CULVERT	SEE NOTE
5	18" CULVERT	SEE NOTE
6	400' VC	SEE NOTE
7	50 MPH	SEE NOTE
8	35 MPH	SEE NOTE
9	272' SSD	SEE NOTE
10	0.20% GRADE	SEE NOTE
11	1.71% GRADE	SEE NOTE
12	0.30% GRADE	SEE NOTE
13	4.50% GRADE	SEE NOTE
14	5510' ELEVATION	SEE NOTE
15	5470' ELEVATION	SEE NOTE
16	5480' ELEVATION	SEE NOTE
17	5485' ELEVATION	SEE NOTE
18	5490' ELEVATION	SEE NOTE
19	5495' ELEVATION	SEE NOTE
20	5500' ELEVATION	SEE NOTE
21	5505' ELEVATION	SEE NOTE
22	5510' ELEVATION	SEE NOTE


EISENHOWER BLVD.

LINEAR TRANSITION
 +16.50
 +41.50

LINEAR TRANSITION
 +14.71
 +39.71

5930
 13,554
 17,620
 57,438
 9042
 11,755
 13,065
 16,985
 17,008
 13,083
 17,008
 17,008
 17,008

PAV'T CROSS SLOPE
 EXCAVATION
 EMBANKMENT
 FACTORED EMBANKMENT
 BORROW

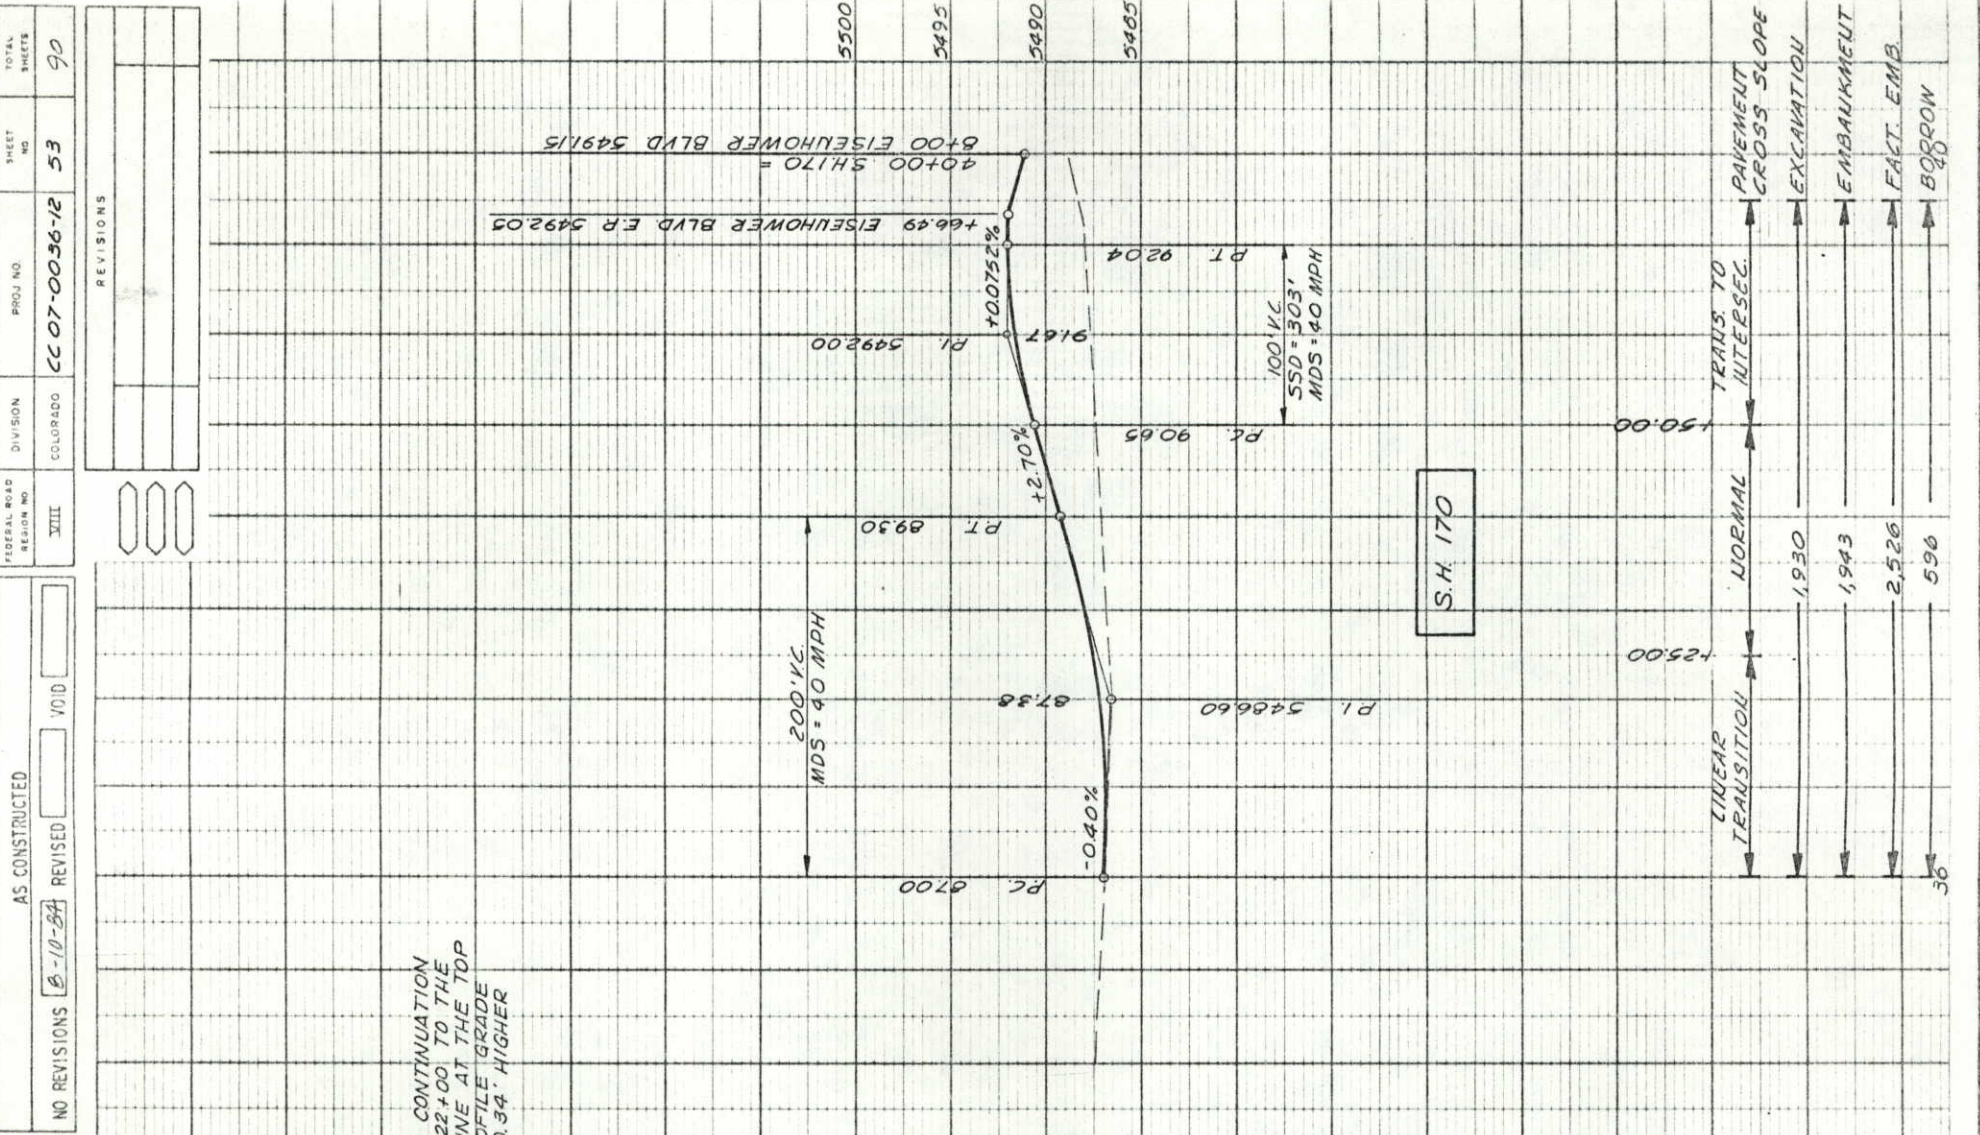[illegible]

PROFILE
 DATE _____
 BY _____
 NOTE BOOK _____
 GRADES CHECKED _____
 PLOTTED _____
 B.M. & ADJUSTED _____
 STRUCK LINE NOT IN CHART

FEDERAL ROAD DISTRICT NO.	III	DIVISION	COLORADO	PROJ. NO.	CC 07-0036-12	SHEET NO.	55	TOTAL SHEETS	90
NO REVISIONS 8-10-64 REVISED VOID									
REVISIONS 									

