

Oversight / NHS


FHWA REGION VIII OVERSIGHT?

☐ NO ☐ YES

NATIONAL HIGHWAY SYSTEM?

☐ NO ☐ YES

CONVENTIONAL SIGNS

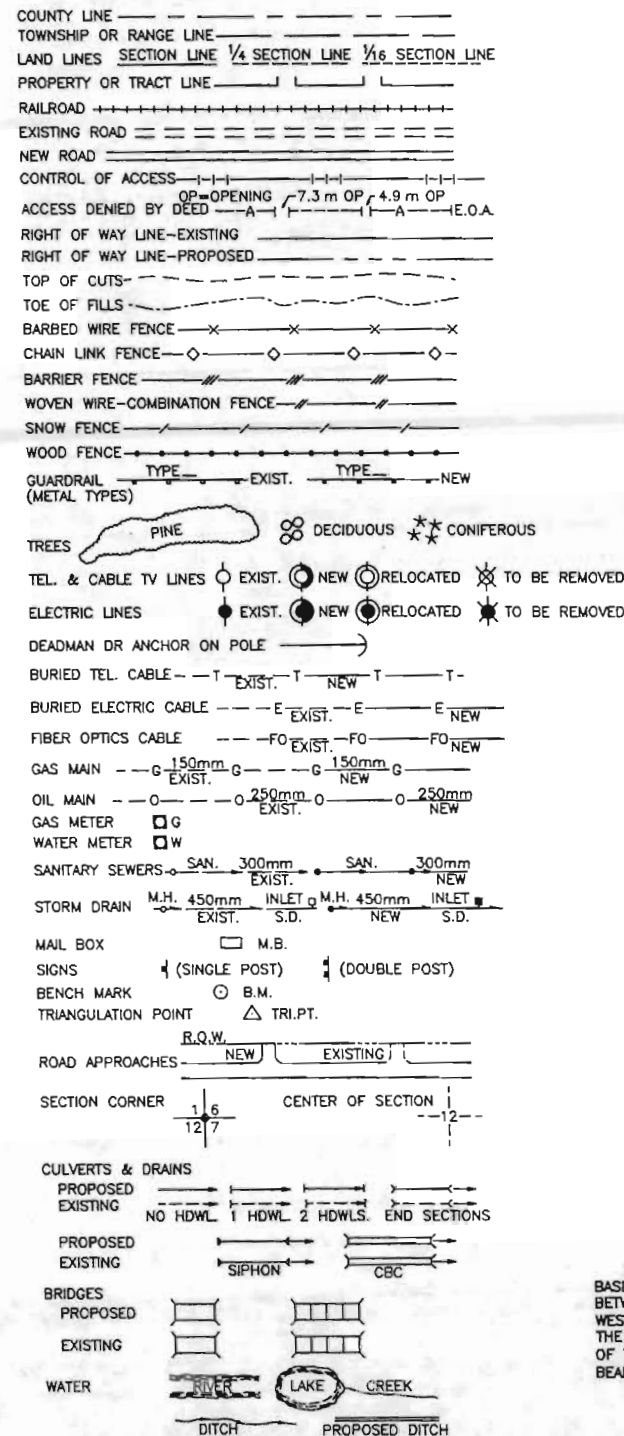

BASIS OF BEARING: THE BEARINGS FOR THIS PROJECT ARE BASED ON A LINE BETWEEN THE SOUTHEAST CORNER OF SECTION 36, TOWNSHIP 12 SOUTH, RANGE 66 WEST OF THE 6th PRINCIPAL MERIDIAN (3 1/4" AL CAP STAMPED "LS 10956") AND THE EAST QUARTER CORNER OF SECTION 36, TOWNSHIP 12 SOUTH, RANGE 66 WEST OF THE 6th PRINCIPAL MERIDIAN (3 1/4" AL CAP STAMPED "LS 10956") WHICH BEARS NORTH 00°35'24" WEST A DISTANCE OF 2,640.56 FEET.


DEPARTMENT OF TRANSPORTATION STATE OF COLORADO

Right of Way Plans of Proposed

PROJECT NO. CR 200-070

POWERS BOULEVARD EXTENSION UNIT I

Woodmen Road to Research Parkway
THE CITY OF COLORADO SPRINGS

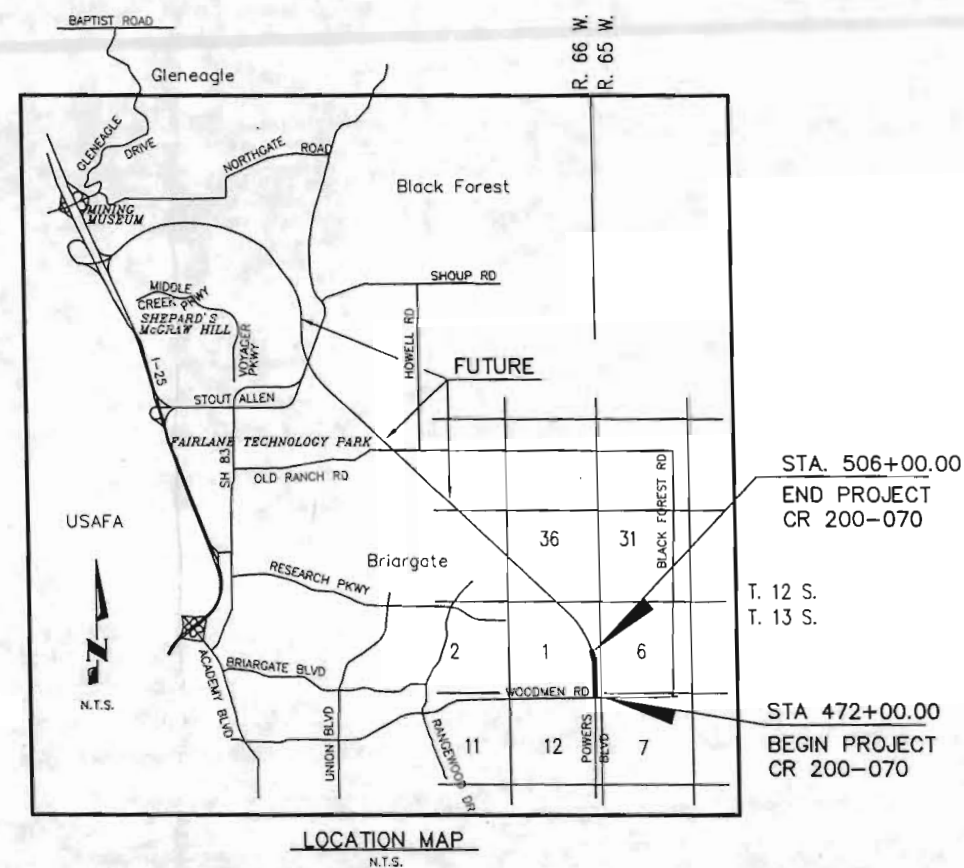

SHEET NO.	INDEX OF SHEETS
1	TITLE SHEET
2-2B	PROPERTY OWNERSHIP TABULATION SHEETS
3-3B	SURVEY CONTROL AND MONUMENTATION SHEETS
4-6	PLAN SHEETS
7	OWNERSHIP MAP

URS GREINER WOODWARD CLYDE SURVEYOR'S CERTIFICATE
Right of Way Plans, and Property Descriptions, were supervised and/or prepared under my direct supervision and review based on surveys, topography and proposed construction prepared by others; Title commitments prepared by Unified Title Co. were relied on for existing deeds, owners and easements shown on these plans.

NAME CARL BODENSTEINER PE/PLS NO. 6965 COLORADO
DATE

URS

9960 Federal Drive Suite 300
Colorado Springs, CO. 80921
(719) 531-0001
Fax (719) 531-0007

Computer File Information

Creation Date: 1/17/99 Initials: DTL
Last Modification Date: 12/13/02 Initials: CST
Full Path: \\S031NTFILE1\6742295\CAD\PLANSHTS
Drawing File Name: TITLE.DWG
Acad Ver. LDD2 Scale: NONE Units: ENGLISH

Sheet Revisions

(R-)	4/19/99	ADDED BASIS-BEAR. & CERT.	CWB
(R-)	8/8/00	REV SHTS 2, 2A, 2B, 3B, 4,	CWB
		5, 6, 7	
(R-)	5/15/02	REVISED SHEETS 6, 7	CWB
(R-)	7/29/02	REVISED SHEETS 6 & 7	CWB
(R-)	12/13/02	REVISED 6A TO 6AX	CWB

Colorado Department of Transportation
905 Erie Avenue
Pueblo, CO 81002
Phone: (719) 546-5454 Fax: (719) 546-5414
Region 2

As Constructed

No Revisions:
Revised:
Void:

GENERAL TITLE SHEET

Designer:
Detailer:
Sheet Subset:
Structure Numbers
Subset Sheets: of

Project No./Code

CR 200-070

12275

Sheet Number

1

R.O.W. TABULATION OF PROPERTIES IN EL PASO, COUNTY

POWERS BOULEVARD

RIGHT OF WAY

PARCEL NO.	OWNER	ADDRESS	LOCATION	AREA IN ACRES					RECEPTION NO.	REMARKS
				AREA OF PARCEL	EXISTING ROW	NET AREA	REMAINDER			
							LEFT	RIGHT		
1 REV	J V LUDWIG & CO. A PARTNERSHIP	3705 MEADOWLAND BLVD	LOT 2 WESTVIEW ESTATES	1.16		1.16		3.07		
		COLORADO SPRINGS,	SEC 6 T13S R65W							
		CO 80918	OF 6TH PM							
1A REV	SAME	SAME	SAME	0.76		0.76		3.07		
SE 1 REV	SAME	SAME	SAME	0.14		0.14				
2 REV	ALBERT C. LUDWIG JR	423 E YAMPA ST	LOT 6 WESTVIEW	3.24		3.24		1.80		
		COLORADO SPRINGS,	ESTATES SEC 6 T13S							
		CO 80903	R65W OF 6TH PM							
3 REV	LP47, LLC	PO BOX 63000	PORTION OF SE 1/4	2.23		2.23	4.61			
		COLORADO SPRINGS,	SEC 1 T13S R66W							
		CO 80962	OF 6TH PM							
3A REV	SAME	SAME	SAME	0.54		0.54				
4 REV	LP47, LLC	PO BOX 63000	PORTION OF SE 1/4	2.44		2.44	8.81			
		COLORADO SPRINGS, CO	SEC 1 T13S R66W 6 PM							
5 REV	BARBARA M. JAGODA	11374 N CLASSICAL DR	LOT 9 WESTVIEW ESTATES	3.60		3.60		1.48		
	C/O LANG PARK ARABIANS	KINGMAN, AZ 86401	SEC 6 T13S R65W 6 PM							
5R REV	SAME	SAME	SAME	1.48		1.48				
6 REV2	LP47, LLC	PO BOX 63000	PORTION OF SW 1/4	8.87		8.87	118.53	1.42		INCLUDES REDUCTION FOR SUMMATION
		COLORADO SPRINGS, CO	SEC 1 T13S R66W 6 PM							OF 6-6B & FUTURE DEDICATED ROW
										(12.76 AC)
6AX	COLORADO DEPARTMENT OF	4201 E. ARKANSAS AVE	SAME	0.12		0.12				TO BE CONVEYED SUBJECT TO
	TRANSPORTATION	DENVER, CO 80222								TRANSPORTATION COMMISSION APPROVAL
										NO REMAINDER

Computer File Information

Creation Date: 11/17/98 Initials: DTL
Last Modification Date: 12/13/02 Initials: CST
Full Path: \\S031NTFILE\6742295\CAD\ROW\PLANSHTS
Drawing File Name: TABS_UNIT.LDWG
Acad Ver: LDD2 Scale: N/A Units: ENGLISH

Sheet Revisions

(R-)	4/19/99	REV 3,4,6, ADDED SE 3, 2R & 5R	CWB
(R-)	5/10/99	ADDED SE 1	CWB
(R-)	5/26/99	REV 1,1A,2,2R,5,5R,SE 1	CWB
(R-)	8/8/00	DEL SE-3, ADDED 3A,	CWB
(R-)	8/8/00	6A, REV. 6	CWB
(R-)	9/7/00	DEL 2R,REV REV 6 REV2	CWB
(R-)	12/13/02	CHANGE 6A TO 6AX	CWB

Colorado Department of Transportation



Region 2

905 Erie Avenue
Pueblo, CO 81002
Phone: (719) 546-5454 Fax: (719) 546-5414

As Constructed

No Revisions:

Revised:

Void:

PROPERTY OWNERSHIP
TABULATION

Designer:	DTL	Structure:	
Detailer:	DTL	Numbers:	
Sheet Subset:	ROW	Subset Sheets:	1 of 2

Project No./Code

CR 200-070

12275

Sheet Number

2

RES JOB# 6742295

R.O.W. TABULATION OF PROPERTIES IN EL PASO, COUNTY

POWERS BOULEVARD

RIGHT OF WAY

PARCEL NO.	OWNER	ADDRESS	LOCATION	AREA IN ACRES					RECEPTION NO.	REMARKS
				AREA OF PARCEL	EXISTING ROW	NET AREA	REMAINDER			
							LEFT	RIGHT		
6B	LP47, LLC	PO BOX 63000	PORTION OF SW 1/4	1.28		1.28				
		COLORADO SPRINGS,	SEC 1 T13S R66W							
		CO 80962	OF 6TH PM							
6C	SAME	SAME	SAME	1.97		1.97		1.42		
7 ^{REV}	THOMAS L. FUQUA	7856 RUSTIC LANE	LOT 12 WESTVIEW	1.35		1.35		2.64		
	AND C. SUSAN FUQUA	COLORADO SPRINGS,	ESTATES SEC 6 T13S							
		CO 80920	R65W OF 6TH PM							
7R ^{REV}	SAME	SAME	SAME	2.64		2.64				
7X	COLO DEPT OF TRANSPORTATION	4201 E ARKANSAS AVE	SAME	1.13		1.13		2.64		TO BE CONVEYED SUBJECT TO
		DENVER, CO 80222								TRANSPORTATION COMMISSION APPROVAL
										NO REMAINDER
8 ^{REV}	ALBERT C. LUDWIG JR	423 E YAMPA ST	PORTION OF W 1/2	1.10		1.10		40.50		
		COLORADO SPRINGS,	SEC 6 T13S R65W							
		CO 80903	OF 6TH PM							
9 ^{REV}	ALBERT C. LUDWIG JR	423 E YAMPA ST	LOT 1 WESTVIEW ESTATES	0.77		0.77		3.46		
		COLORADO SPRINGS,	SEC 6 T13S R65W							
		CO 80903	OF 6TH PM							
9A ^{REV}	SAME	SAME	SAME	0.76		0.76		3.46		
SE 9 ^{REV}	SAME	SAME	SAME	0.24		0.24				
10 ^{REV}	ALBERT C. LUDWIG JR	423 E YAMPA ST	LOT 3 WESTVIEW	4.37		4.37		0.63		
		COLORADO SPRINGS,	ESTATES SEC 6 T13S							
		CO 80903	R65W OF 6TH PM							

Computer File Information

Creation Date: 11/17/98 Initials: DTL
Last Modification Date: 7/29/02 Initials: CST
Full Path: \\S031NTFILE\6742295\CAD\ROW\PLANSHTS
Drawing File Name: TABS_UNIT I.DWG
Acad Ver: LDD2 Scale: N/A Units: ENGLISH

Sheet Revisions

(R-)	3/11/99	ADDED 9A & REV 11	CWB
(R-)	3/31/99	REV 6, 8 & 11	CWB
(R-)	4/19/99	ADDED 7R & 10R	CWB
(R-)	5/10/99	ADDED SE 9	CWB
(R-)	5/26/99	REV 7,7R,8,9,9A,10,10R,SE 9	CWB
(R-)	8/8/00	DEL PE6,PE6A, ADDED 6B,6C	CWB
(R-)	9/7/00	DEL 10R ^{REV}	CWB
(R-)	5/15/02	ADD PARCEL 7X, REV 7 ^{REV}	CWB
(R-)	7/29/02	REV OWNER FOR 7X	CWB

Colorado Department of Transportation



Region 2

905 Erie Avenue
Pueblo, CO 81002
Phone: (719) 546-5454 Fax: (719) 546-5414

As Constructed

No Revisions:

Revised:

Void:

PROPERTY OWNERSHIP
TABULATION

Designer: DTL Structure
Detailer: DTL Numbers
Sheet Subset: ROW Subset Sheets: 2 of 2


Project No./Code

CR 200-070


12275

Sheet Number 2A

JES JOB#: 6742295

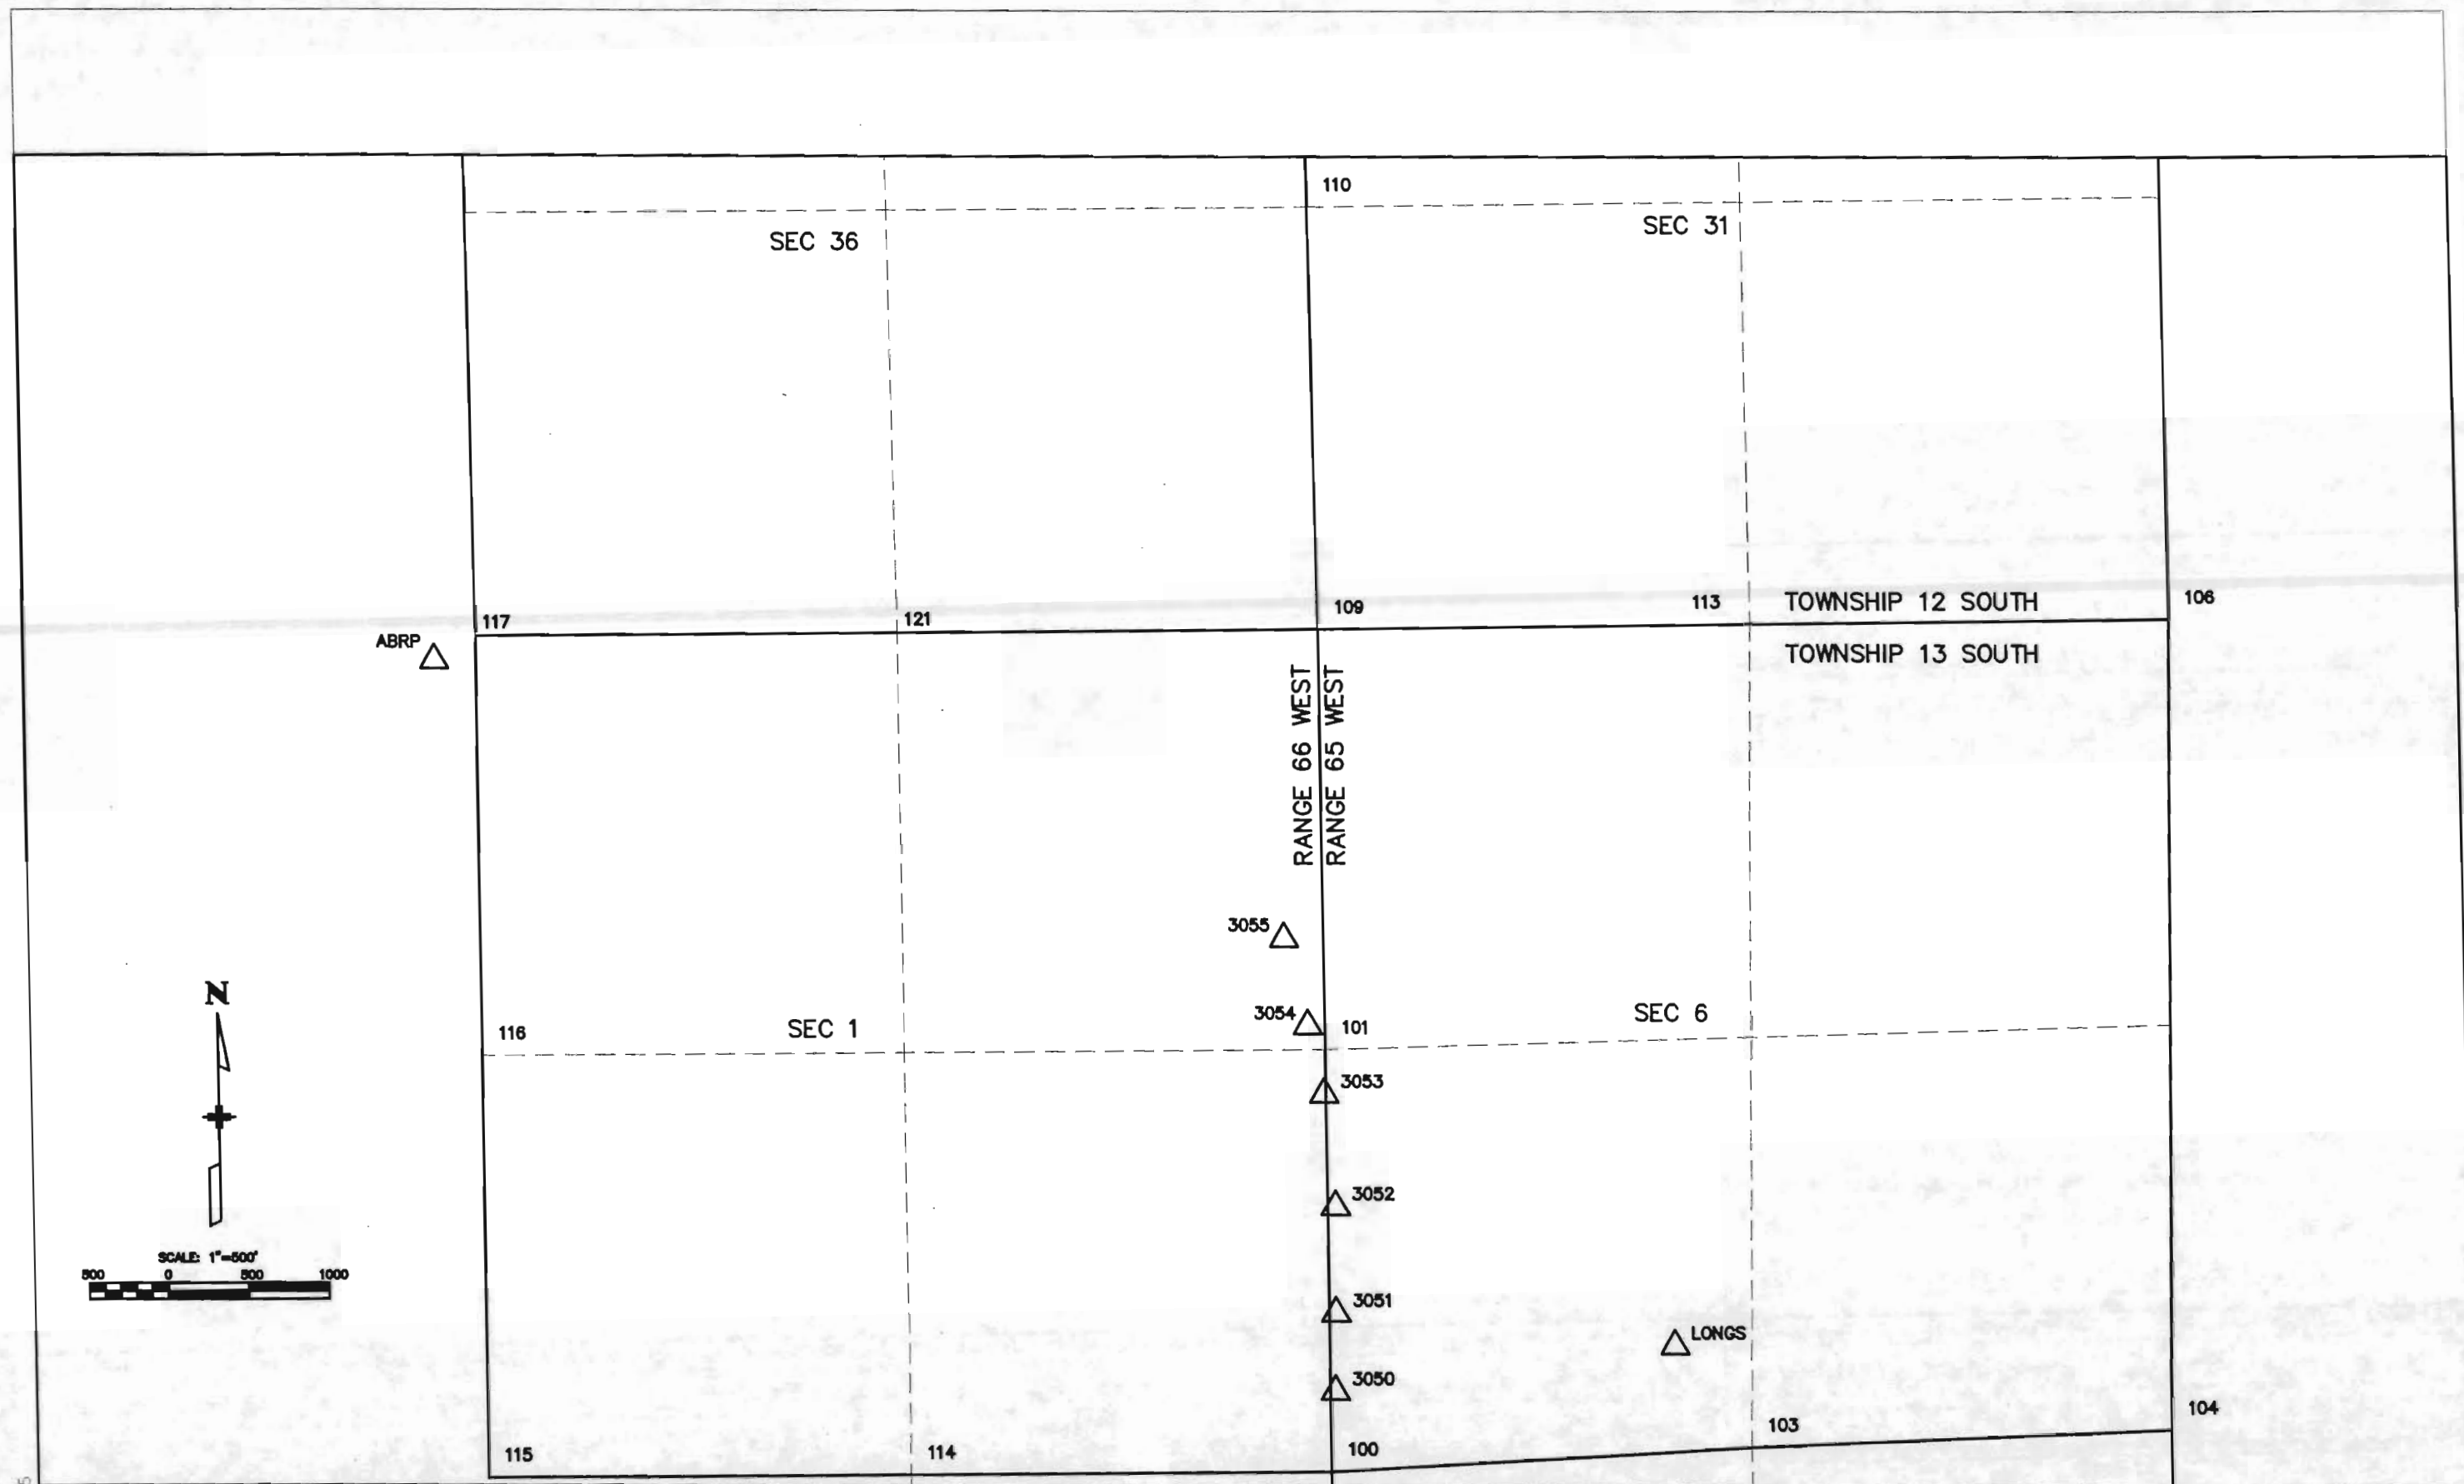

003 JOB# 6742295

 Computer File Information		Sheet Revisions		Colorado Department of Transportation 905 Erie Avenue Pueblo, CO 81002 Phone: (719) 546-5454 Fax: (719) 546-5414 Region 2	As Constructed		SURVEY CONTROL DIAGRAM			Project No./Code	
Creation Date: 11/17/98	Initials: DTL	(R-)	.		.	.	No Revisions:	.		CR 200-070	
Last Modification Date: 4/16/99	Initials: DTL	(R-)	.		.	.	Revised:	.	Designer: DTL	Structure	12275
Full Path: \\URWS167\6742295\CAD\ROW\PLANSHTS		(R-)	.		.	.	Void:	.	Detailer: DTL	Numbers	
Drawing File Name: CONTROL_UNIT I.DWG		(R-)	.		.	.	Sheet Subset: ROW		Subset Sheets: 2 of 3	Sheet Number	
Acad Ver: LDD2	Scale: 1'=1000' Units: ENGLISH	(R-)	.	.	.	3A					

JBS JOB#: 6742295

TABULATION OF ALIQUOT CORNERS TO BE SET

NONE

TABULATION OF ROW MARKERS TO BE SET
TYPE I MONUMENTS

Point	Northing	Easting	Approx. Station/Offset	Comments
400	6427.131	23078.447	491+00 105 LT (POWERS)	
401	6027.479	23041.880	486+93 144 LT (POWERS)	
402	5672.921	22843.806	483+36 336 LT (POWERS)	
403	5453.455	22550.949	481+12 625 LT (POWERS)	
404	5236.934	22385.722	478+92 787 LT (POWERS)	
405	4958.655	22275.867	476+12 892 LT (POWERS)	
406	4705.544	21907.173	113+87 108 LT (WOODMEN)	
407	4700.183	21269.761	107+50 108 LT (WOODMEN)	
408	4649.343	21170.177	106+50 58 LT (WOODMEN)	
409	4772.381	22125.193	116+06 173 LT (WOODMEN)	
410	4812.260	24536.166	140+25 124 LT (WOODMEN)	
411	4887.015	24184.523	136+78 220 LT (WOODMEN)	
412	4881.925	24124.538	136+18 218 LT (WOODMEN)	
413	4834.189	23710.284	132+02 194 LT (WOODMEN)	
414	4887.990	23650.127	131+45 252 LT (WOODMEN)	
415	5025.378	23564.435	477+00 395 RT (POWERS)	
416	6074.996	23596.465	487+50 410 RT (POWERS)	
417	6442.144	23433.125	491+00 250 RT (POWERS)	TO BE REMOVED
418	5927.530	23439.052	486+00 255 RT (POWERS)	
419	6233.074	23587.935	489+00 400 RT (POWERS)	
420	7856.141	23093.483	505+00 165 RT (POWERS)	
421	4843.968	24909.957	144+00 134 LT (WOODMEN)	
422	4797.673	24975.249	144+63 85 LT (WOODMEN)	
424	7955.723	23003.372	506+20 111 RT (POWERS)	
425	7518.345	23230.221	501+50 203 RT (POWERS)	
430	6804.030	23364.896	495+49 209 RT (POWERS)	NEW MARKER 5/15/02
431	6799.432	23285.650	495+45 130 RT (POWERS)	NEW MARKER 5/15/02
432	6436.753	23345.738	499+00 162 RT (POWERS)	NEW MARKER 5/15/02
433	6281.000	23400.335	500+53 213 RT (POWERS)	NEW MARKER 5/15/02
434	6289.464	23546.180	500+47 359 RT (POWERS)	NEW MARKER 5/15/02
463	4817.600	24599.119	140+88 126 LT (WOODMEN)	
464	5248.744	23709.077	132+25 608 LT (WOODMEN)	
465	5168.623	23709.310	132+20 528 LT (WOODMEN)	
466	5272.788	24123.400	136+40 608 LT (WOODMEN)	
467	5192.667	24123.633	136+35 528 LT (WOODMEN)	
468	5276.269	24183.390	137+00 608 LT (WOODMEN)	
469	5196.148	24183.623	136+95 528 LT (WOODMEN)	
470	5300.313	24597.713	141+15 608 LT (WOODMEN)	
471	5220.192	24597.946	141+10 528 LT (WOODMEN)	
472	5304.954	24677.700	141+95 608 LT (WOODMEN)	
473	4824.385	24679.099	141+68 128 LT (WOODMEN)	
475	7699.006	22692.318	504+73 265 RT (POWERS)	
476	7401.570	22776.706	501+47 265 RT (POWERS)	
477	7440.366	22931.931	501+47 105 RT (POWERS)	
478	6299.304	22996.459	489+71 191 RT (POWERS)	TO BE REMOVED
479	6224.616	22989.625	488+93 198 RT (POWERS)	TO BE REMOVED
480	6218.238	23059.334	488+87 129 RT (POWERS)	
481	6292.926	23066.168	489+63 121 RT (POWERS)	

QUANTITY OF MONUMENTS TO BE SET

CAP TYPE	MONUMENT TYPE										
	1	1A	1A	2	2A	3	3A	4	4A	5	6
REFERENCE											
RIGHT OF WAY	47										
CONTROL											
ALIQUOT CORNER							0				
WITNESS POST											
PERM. EASEMENT											

CONTRACTOR'S SURVEYOR'S STATEMENT
Right of Way and Aliquot Corner Monumentation was done under my supervision, checking and in accordance with Colorado Laws and Regulations.

NAME _____ PLS NO _____ COLORADO
DATE _____

ABLE ENGINEERING PROFESSIONALS, INC SURVEYOR'S CERTIFICATE
I, Ronald M. McGill, a Professional Land Surveyor in the State of Colorado, herby state that the Aliquot Monument Evidence ties, Property Corner Monument ties, and ROW monument ties were done under my direction and supervision.

NAME _____ PLS NO 30107 COLORADO
RONALD M. MCGILL
DATE _____

Computer File Information

Creation Date: 11/17/98 Initials: DTL
Last Modification Date: 12/13/02 Initials: CST
Full Path: \\URWS167\6742295\CAD\ROW\PLANSHTS
Drawing File Name: CONTROL_UNIT I.DWG
Acad Ver: LDD2 Scale: N/A Units: ENGLISH

Sheet Revisions

(R-)	3/31/99	REV ROW MARKERS TO BE SET	CWB
(R-)	4/19/99	REMOVED SURV. CERT.	CWB
(R-)	5/26/99	REV MONUMENTS TO BE SET	CWB
(R-)	8/7/00	DEL PERM EASEMENT MON. REV	CWB
(R-)	5/15/02	MONUMENTS TO BE SET	CWB
(R-)	12/13/02	ADD PTS 430-434, DELETE 417 PTS 478,479 TO BE REMOVED	CWB

Colorado Department of Transportation



Region 2

905 Erie Avenue
Pueblo, CO 81002
Phone: (719) 546-5454 Fax: (719) 546-5414

As Constructed

No Revisions:

Revised:

Void:

ROW MONUMENTATION
TABULATION

Designer: DTL Structure
Detailer: DTL Numbers
Sheet Subset: ROW Subset Sheets: 3 of 3


Project No./Code

CR 200-070


12275

Sheet Number

3B

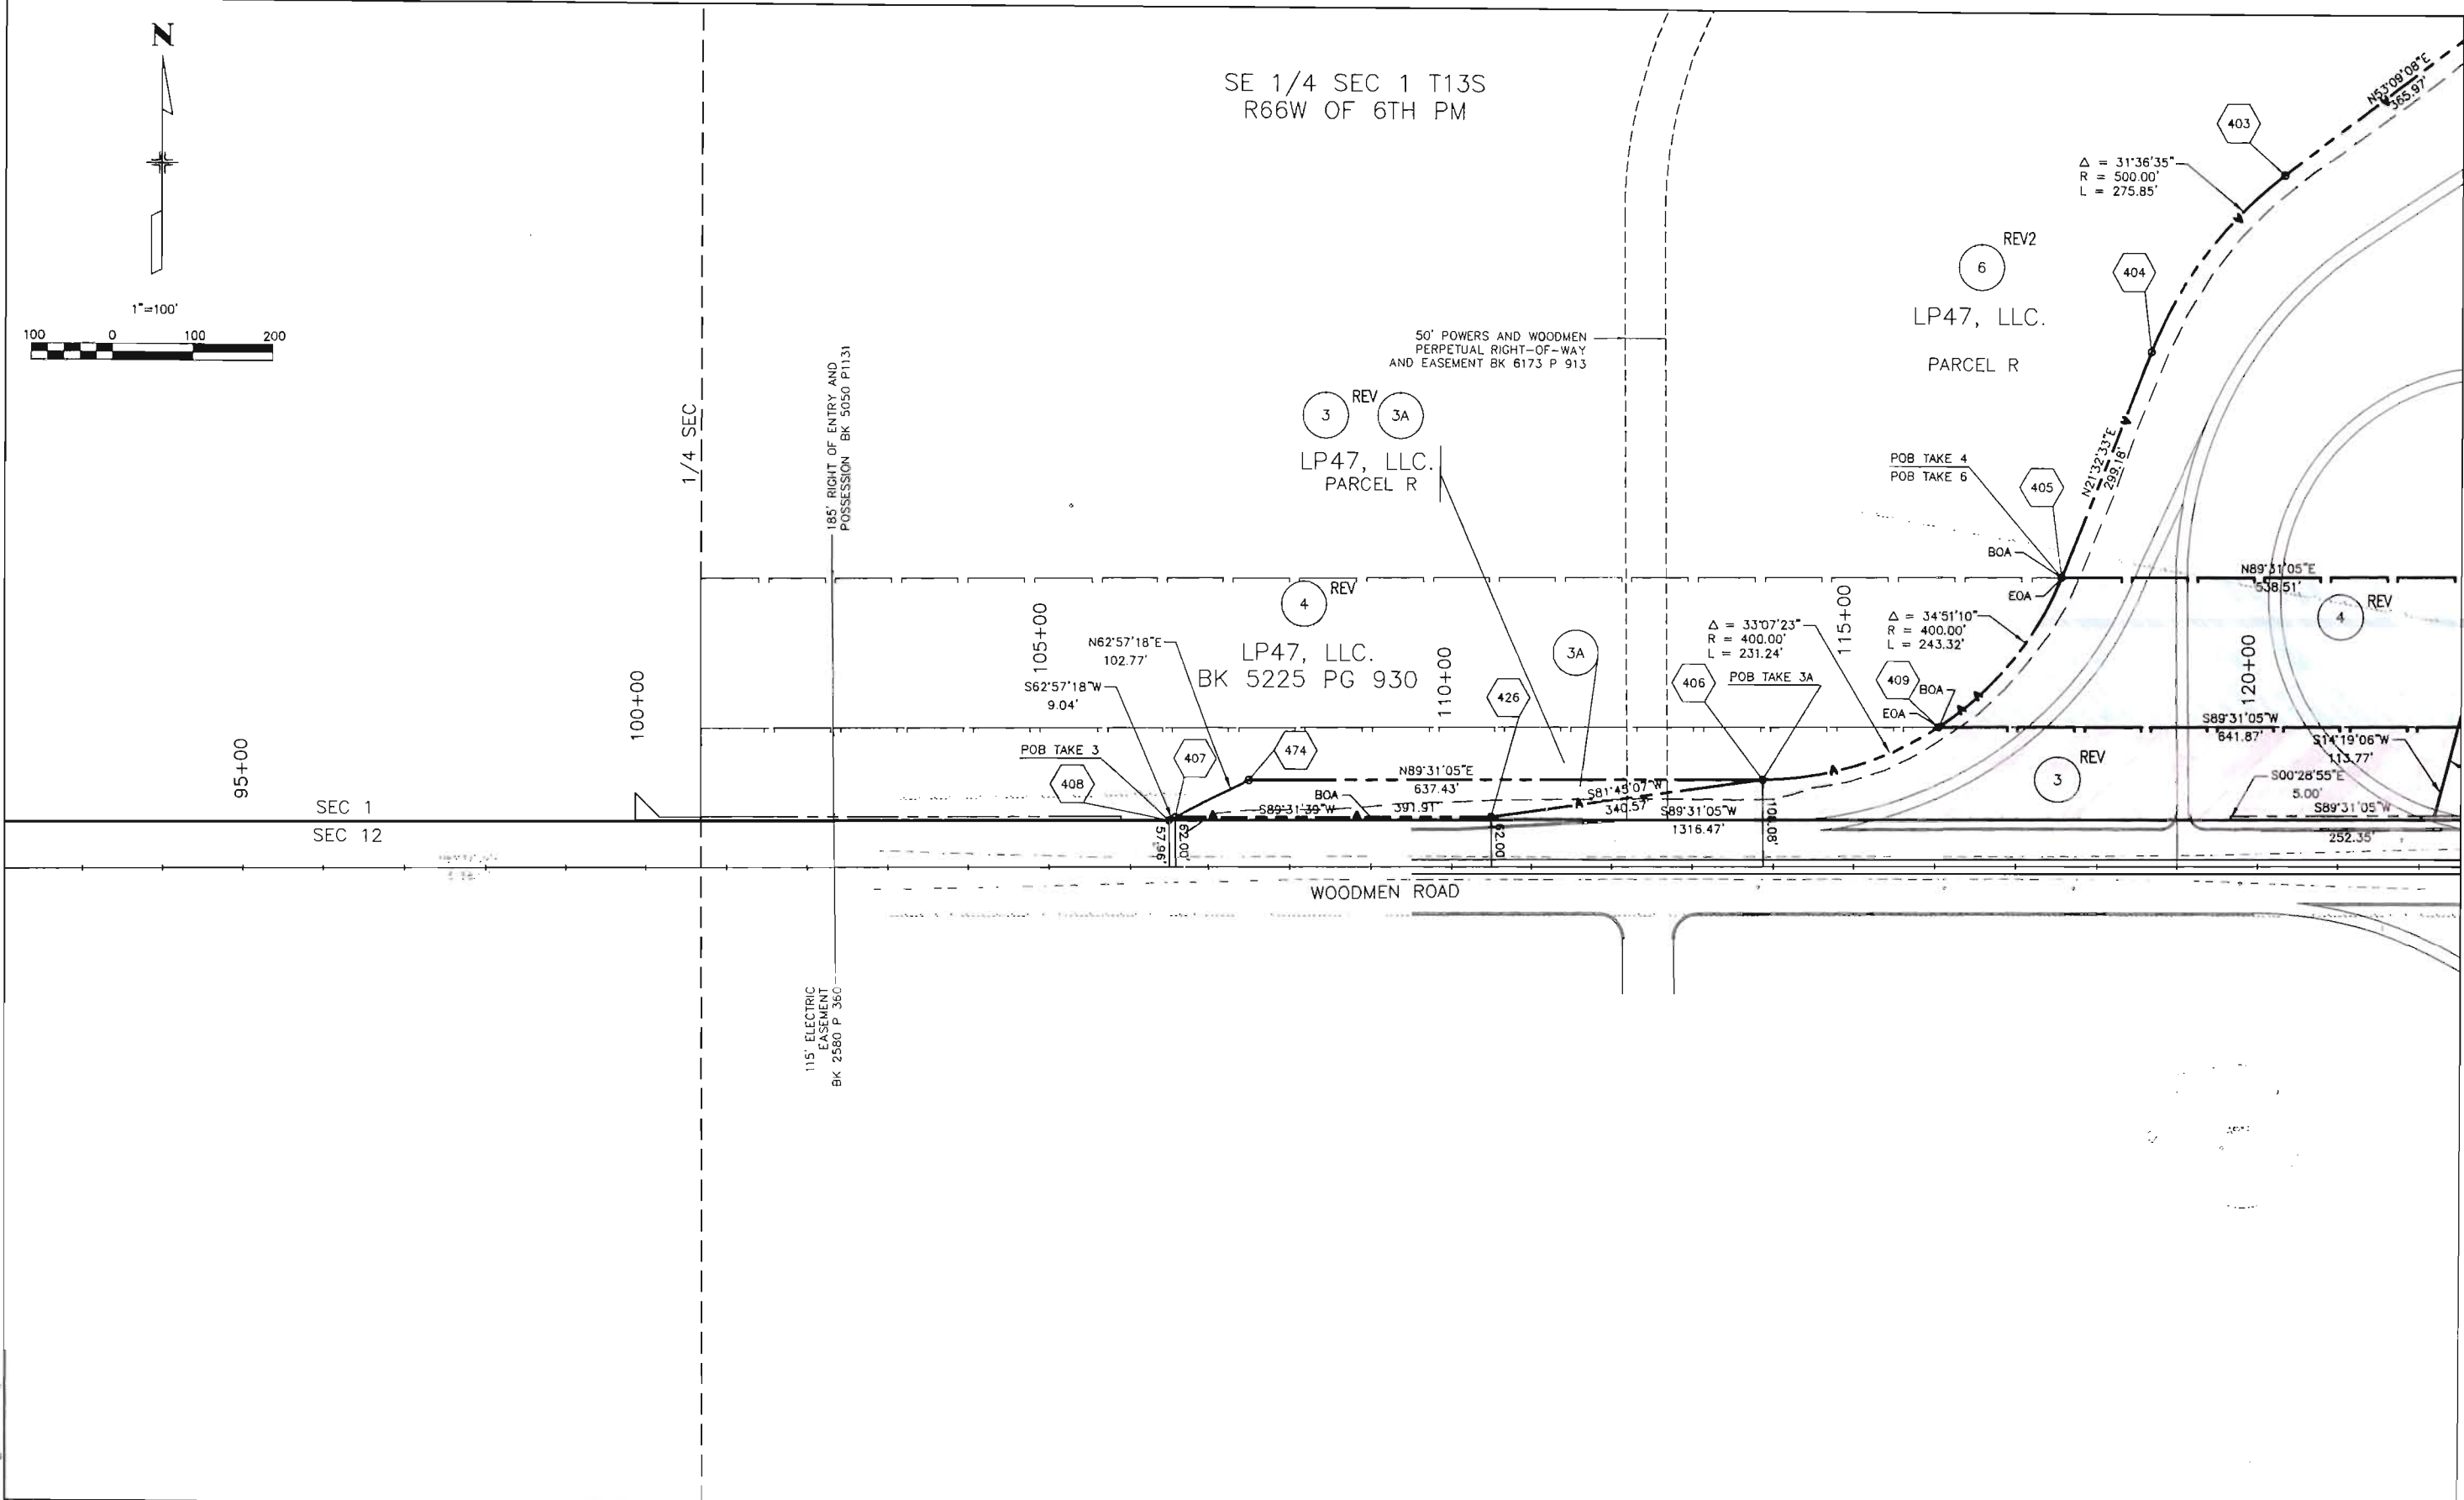

 URS Greiner Woodward Clyde JOB#: 6742295

Computer File Information			Sheet Revisions				Colorado Department of Transportation		As Constructed		RIGHT OF WAY PLAN UNIT I			Project No./Code	
Creation Date: 11/17/98		Initials: DTL	(R-)	4/19/99	REV 3,4,6 ADDED SE 3	CWB	 905 ERIE AVENUE PUEBLO, CO 81002 Phone: (719) 546-5454 Fax: (719) 546-5414 Region 2	No Revisions: .		Designer: DTL Detailer: DTL		Structure		CR 200-070	
Last Modification Date: 12/13/02		Initials: CST	(R-)	7/17/00	REV SE 3 TO TAKE 3A	CWB		Revised: .				Numbers		12275	
Full Path: \\URWS167\6742295\CAD\ROW\PLANSHTS			(R-)	9/7/00	ADD REV2 TO TAKE 6	CWB		Void: .		Sheet Subset: ROW		Subset Sheets: 1 of 3		Sheet Number 4	
Drawing File Name: ROW-PLANS_UNIT I.DWG			(R-)		& DEL REV TAKE 3A										
Acad Ver: LDD2		Scale: 1"=100' Units: ENGLISH	(R-)	12/13/02	CHANGED 6A TO 6AX	CWB									


Colorado Department of Transportation



905 ERIE AVENUE
PUEBLO, CO 81002
Phone: (719) 546-5454 Fax: (719) 546-5414

Region 2

US Grader Woodward Clyde JOB#: 6742295

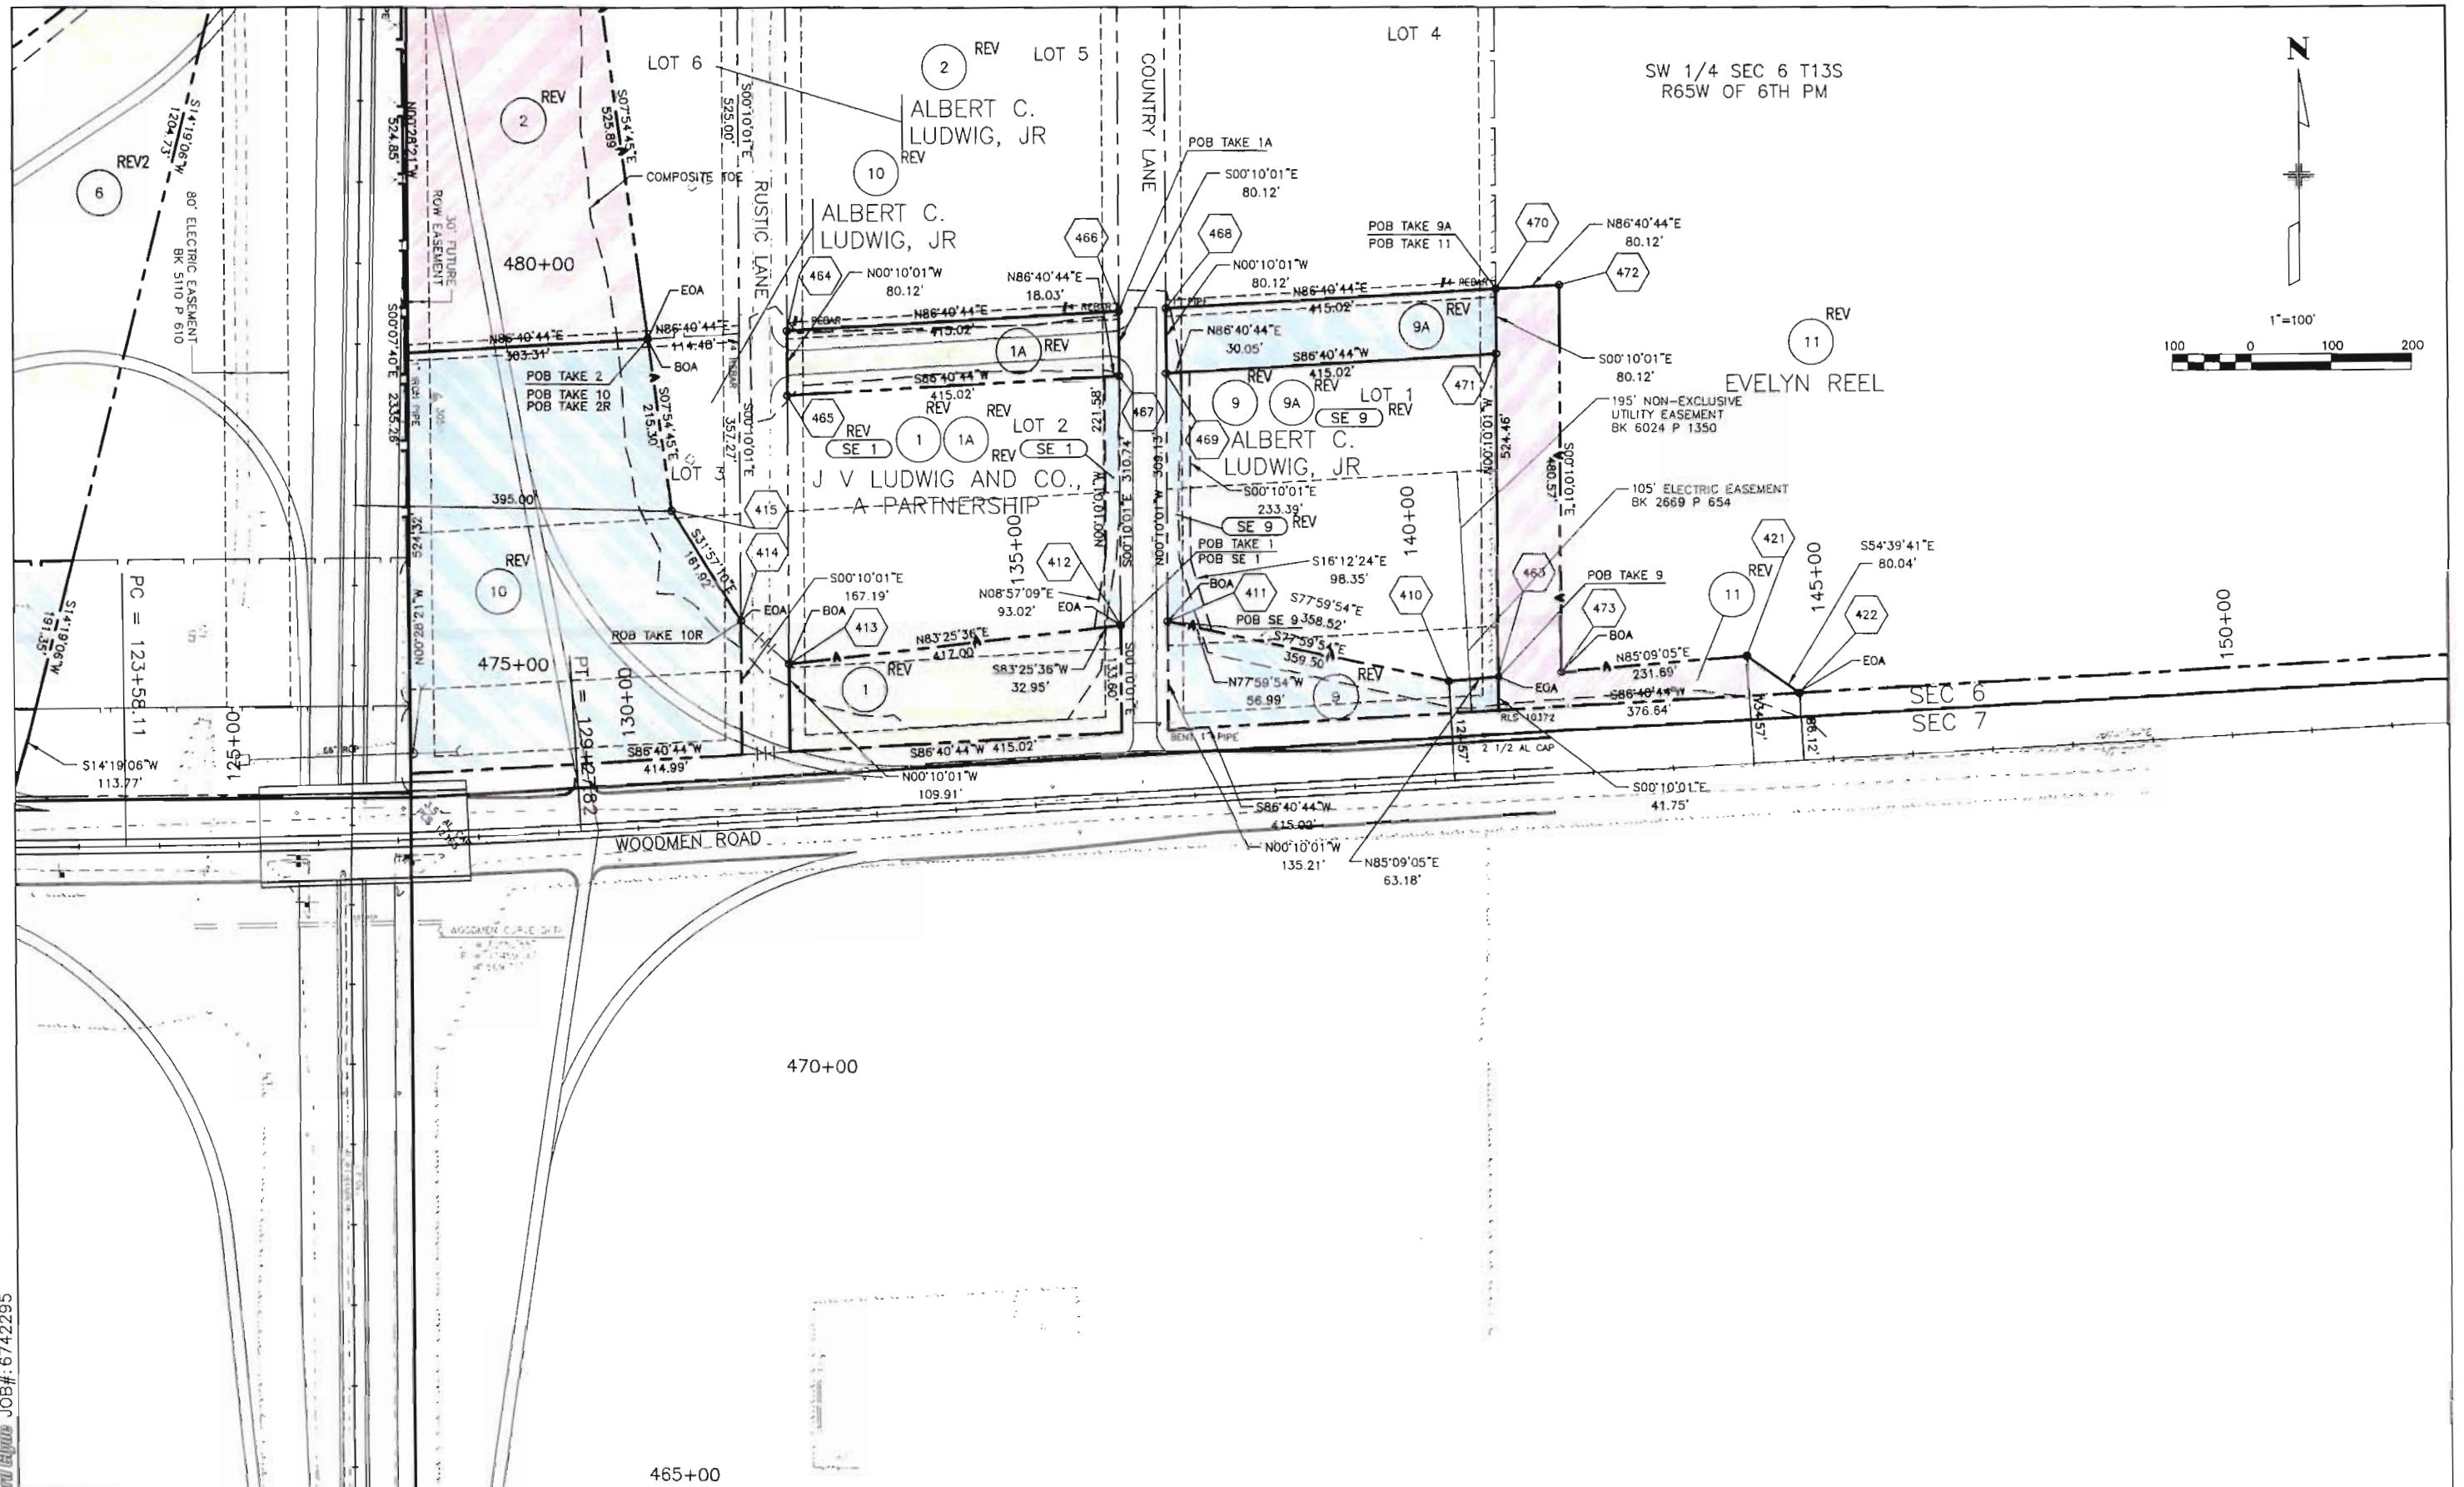

Computer File Information		Sheet Revisions		Colorado Department of Transportation		As Constructed		RIGHT OF WAY PLAN UNIT 1		Project No./Code	
Creation Date: 11/17/98	Initials: DTL	(R-) 3/11/99	ADDED 9A, REV 11 & ADDED FRONTAGE ACCESS CONTROL	CWB	 905 ERIE AVENUE PUEBLO, CO 81002 Phone: (719) 546-5454 Fax: (719) 546-5414 Region 2	No Revisions:		Designer: DTL	Structure:	CR 200-070	
Last Modification Date: 5/15/02	Initials: CST	(R-) 3/31/99	REV EXIST ROW PARCEL 11	CWB		Revised:		Detailer: DTL	Numbers:	12275	
Full Path: \\URWS167\6742295\CAD\ROW\PLANSHTS		(R-) 4/19/99	REV 3, 4, 8 ADDED 2R, 10R	CWB		Void:		Sheet Subset: ROW	Subset Sheets: 2 of 3	Sheet Number 5	
Drawing File Name: ROW-PLANS_UNIT 1.DWG		(R-) 5/10/99	ADDED SE 1 & SE 9	CWB							
Acad Ver: LDD2	Scale: 1"= 100' Units: ENGLISH	(R-) 6/25/99	REV 1, 1A, 2, 2R, 9, 9A, 10, 10R, 11, SE 1, SE 9	CWB							
		(R-) 9/7/00	DELETE 2R & 10R, ADD REV 2 TO TAKE 6	CWB							

0155 Andrew Woodward Civil JOB#: 6742295

