



DEPARTMENT OF TRANSPORTATION - STATE OF COLORADO CONTROL SURVEY DIAGRAM

Project CX 11-0285-28 UNIT 4 & 5
U.S. 285 MP 235.0 to MP 241.29
Sections 4, 5, 7, & 8 of
T. 6 S., R. 70 W.
Sections 11, 12, 14, & 23 of
T. 6 S., R. 71 W.
JEFFERSON COUNTY, COLORADO

CONSTRUCTION SURVEYING AND MONUMENTATION REQUIREMENTS:

- 1). This Control Survey Diagram represents the horizontal and vertical control for the project established by the Division. It is possible that some of the survey control monuments listed have been disturbed or obliterated. It is the Contractor's responsibility to verify the existence and stability of the control monuments before submitting a bid price.
- 2). All Type 1 and Type 2 monuments shall be set flush with the ground. Witness posts shall be installed 1 foot from and facing all Type 1 and Type 2 monuments, or as directed by the Project Engineer.
- 3). Installation of Type 3 and Type 3-A monuments shall be completed in the same day that installation is commenced. Under no circumstances shall holes in the roadway be left open overnight.
- 4). When installing Type 3-A monuments, the aluminum access cover shall be positively secured to the PVC pipe with screws or glue. The access cover shall be caulked with asphalt caulking between the cover and the edges of the roadway surface to provide a positive moisture barrier around the access cover.
- 5). Control survey procedures, statistical analysis, and accuracy obtained for horizontal and vertical control shall be documented in the field book.
- 6). Legible copies of the field books shall be submitted to the Project Engineer for review on a monthly basis.
- 7). It is ultimately the prime Contractor's responsibility to insure that these requirements, as well as any contained in the CDDT specifications, project special provisions, and CDDT Survey Manual are fulfilled under this contract.
- 8). The minimum staking intervals for each item are described on the plans or in the CDDT Survey Manual. If the contractor wishes to reduce the minimum intervals, a Contract Modification Order must be negotiated and the cost of the item reduced accordingly.

BASIS OF BEARINGS: Bearings used in the calculation of coordinates are based on a grid bearing of N 19°03'44" E from US-285 CM-MP 235.4 to US-285 CM-MP 235.6 as obtained from a Global Positioning System (GPS) survey based on the Colorado High Accuracy Reference Network (CHARN).

BASIS OF ELEVATIONS: Project is based on a U.S. Geological Survey (USGS) benchmark G 36 RESET 1965 a 3 inch aluminum cap set in the SW wingwall of a bridge with an NGVD '29 elevation of 7042.12 feet. G 36 RESET 1965 is part of Colorado Line 3 of USGS Quad Denver SW, a third order line leveled in 1923.


NOTE: Refer to NEW-629-1 SURVEY MONUMENTS of the STANDARD PLANS, COLORADO DEPARTMENT OF TRANSPORTATION, M & S STANDARDS MARCH 15, 1996 for survey monument descriptions. Refer to M-100-1 STANDARD SYMBOLS of the STANDARD PLANS, COLORADO DEPARTMENT OF TRANSPORTATION, M & S STANDARDS NOVEMBER 1992 for standard symbol definitions.

NOTE: This control survey is for the use of Colorado Department of Transportation personnel. The survey is not a complete boundary survey and does not subdivide land. Title policy, title commitment, and title research were not part of this control survey, therefore, easements, rights, and restrictions of record are not shown. The verification of the physical evidence with relation to easements, rights of way, property boundaries, and restrictions, as described in the instruments of record, was not included in this control survey.

NOTE: According to Colorado law you must commence any legal action based upon any defect in this survey within three years after you first discover such defect. In no event may any action based upon any defect in this survey be commenced more than ten years from the date of the statement shown.

SURVEYORS STATEMENT: I, Joseph P. Conway, a Professional Land Surveyor in the State of Colorado, hereby state that this Control Survey Diagram was prepared under my supervision this 8th day of January, 1999, from a field survey performed under my supervision from 5/1/96 to 11/11/97, and checking for and on behalf of the Department of Transportation, State of Colorado, and is not a Land Survey Plat or Right-of-Way Survey Plat and to the best of my knowledge and belief this control survey, as shown, meets the minimum horizontal control tolerances of a Type B Survey.

Joseph P. Conway L.S. 25618

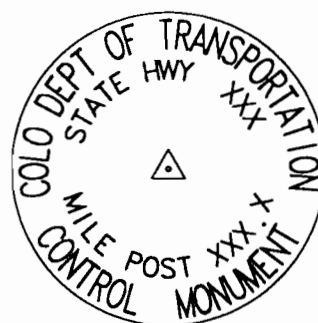

NOT TO SCALE

TYPICAL:
CM-MP - Control Monuments were set by CDDT. They were CDDT type 2 monuments, a 3-1/4" dia. aluminum control monument cap (as shown) on a 3" X 3/4" dia. flinned aluminum security rod on a 3" X 3/4" dia. smooth aluminum rod.

FILING CERTIFICATION: DEPOSITED THIS DAY OF 19 AT M., FOR INFORMATION ONLY IN BOOK OF THE COUNTY LAND SURVEYS/RIGHT OF WAY SURVEYS AT PAGE RECEPTION NUMBER

SIGNED DEPT.

Computer File Information				Sheet Revisions			Colorado Department of Transportation  Region 1 Construction 18500 E Colfax Avenue Aurora, Colorado 80011 Phone: 303-757-9744 FAX: 303-757-9746 Survey Coordinator JPC	As Constructed	SURVEY CONTROL DIAGRAM		Project CX 11-0285-28 UNIT 4 & 5
Creation Date:	10/1/96	Initials:	LCY	1/8/99	Added Correction Diagram to title	D.A.S.		No Revisions:			U.S. 285 - FOXTON ROAD TO MARIPOSA DRIVE
Last Modification Date:	1/8/99	Initials:	DAS	1/8/99	Edited date of surveyor's statement	D.A.S.		Revised:	CORRECTION DIAGRAM		92026
Full Path:	C:\PROJECTS\285PH4\CSDPH4\			1/8/99	Edited basis of bearings from CM-MP 235.7 to CM-MP 235.4	D.A.S.		Void:	Sheet Subset: Survey Subset Sheets: 1/11		Sheet Number
Drawing File Name:	N285CSDC.DWG										
Acad Ver.	R13	Scale:	1"=200'	Units:	FEET	1/8/99	Edited basis of elevations for the project	D.A.S.			

C:\PROJECTS\285PH4\CSDPH4\N285CSDC.DWG 1/8/99 PLOT/EDIT by D.A.S.



DEPARTMENT OF TRANSPORTATION - STATE OF COLORADO CONTROL SURVEY DIAGRAM

Project CX 11-0285-28 UNIT 4 & 5
U.S. 285 MP 235.0 to MP 241.29
Sections 4, 5, 7, & 8 of
T. 6 S., R. 70 W.
Sections 11, 12, 14, & 23 of
T. 6 S., R. 71 W.
JEFFERSON COUNTY, COLORADO

PROJECT COORDINATE SUMMARY TABLE
(ADJUSTED FIELD DATA)

POINT NAME	GEOMETRIC COORDINATES NAD-83(92) (CHARN)		ELEVATION (NGVD '29)	MAPPING ANGLE	SCALE	NAD 83(92) ZONE CENTRAL		DESCRIPTION
	LATITUDE(N)	LONGITUDE(W)				NORTHING (m)	EASTING (m)	
MEYER JCMD	39° 32' 46.07394"	105° 16' 20.04209"		0° 8' 37.13889"	0.999966028	494961.877	933979.126	JCMD Disk in concrete
JWTHOMAS 1995	39° 35' 9.94552"	105° 13' 8.01595"		0° 10' 38.24777"	0.999971686	494911.650	933850.195	JCMD Disk in concrete
US 285 CM-MP 241.29	39° 33' 30.03002"	105° 14' 20.50033"	2317.853	0° 9' 52.53263"	0.999967705	496325.135	936829.401	CDOT Type 2 Control Monument
US 285 CM-MP 241.1	39° 33' 21.81083"	105° 14' 23.27850"	2333.300	0° 9' 50.78047"	0.999967388	496071.469	936763.807	CDOT Type 2 Control Monument
US 285 CM-MP 240.9	39° 33' 11.76918"	105° 14' 28.14156"	2353.125	0° 9' 47.71338"	0.999967003	495761.458	936648.596	CDOT Type 2 Control Monument
US 285 CM-MP 240.8	39° 33' 12.03762"	105° 14' 34.76085"	2362.452	0° 9' 43.53867"	0.999967013	495769.288	936490.547	CDOT Type 2 Control Monument
US 285 CM-MP 240.7	39° 33' 15.811 "	105° 14' 42.612 "	2376.134	0° 9' 38.5872 "	0.999967157	495885.13	936382.79	CDOT Type 2 Control Monument
US 285 CM-MP 240.5	39° 33' 9.74057"	105° 14' 47.95668"	2389.497	0° 9' 35.21620"	0.999966925	495697.564	936175.714	CDOT Type 2 Control Monument
US 285 CM-MP 240.4	39° 33' 4.35547"	105° 14' 53.10797"	2401.347	0° 9' 31.96733"	0.999966720	495531.148	936053.195	CDOT Type 2 Control Monument
US 285 CM-MP 240.2	39° 33' 5.351 "	105° 15' 9.620 "	2423.534	0° 9' 21.5535 "	0.999966758	495560.77	935658.90	CDOT Type 2 Control Monument
US 285 CM-MP 240.0	39° 32' 59.58370"	105° 15' 17.27060"	2434.784	0° 9' 16.72821"	0.999966538	495382.411	935476.729	CDOT Type 2 Control Monument
US 285 CM-MP 239.9	39° 32' 54.27225"	105° 15' 19.68579"	2438.076	0° 9' 15.20498"	0.999966337	495218.454	935419.508	CDOT Type 2 Control Monument
US 285 CM-MP 239.8	39° 32' 50.14865"	105° 15' 27.01968"	2441.730	0° 9' 10.57957"	0.999966181	495090.815	935244.749	CDOT Type 2 Control Monument
US 285 CM-MP 239.6	39° 32' 50.41591"	105° 15' 35.65847"	2441.224	0° 9' 5.13118"	0.999966192	495098.510	935038.472	CDOT Type 2 Control Monument
US 285 CM-MP 239.4	39° 32' 56.86888"	105° 15' 49.03348"	2425.981	0° 8' 56.69570"	0.999966436	495296.678	934718.619	CDOT Type 2 Control Monument
US 285 CM-MP 239.3	39° 32' 56.408 "	105° 15' 54.132 "	2421.677	0° 8' 53.48035"	0.999966418	495282.14	934596.94	CDOT Type 2 Control Monument
US 285 CM-MP 239.1	39° 32' 50.36571"	105° 16' 2.94936"	2416.407	0° 8' 47.91909"	0.999966190	495095.267	934386.892	CDOT Type 2 Control Monument
US 285 CM-MP 238.8	39° 32' 48.33324"	105° 16' 29.64978"	2405.553	0° 8' 31.07942"	0.999966113	495030.981	933749.561	CDOT Type 2 Control Monument
US 285 CM-MP 238.6	39° 32' 44.31032"	105° 16' 45.63363"	2419.093	0° 8' 20.99857"	0.999965962	494905.980	933368.236	CDOT Type 2 Control Monument
US 285 CM-MP 238.3	39° 32' 37.60884"	105° 16' 59.61900"	2430.468	0° 8' 12.17814"	0.999965710	494698.507	933034.813	CDOT Type 2 Control Monument
US 285 CM-MP 238.1	39° 32' 34.85538"	105° 17' 18.04672"	2448.143	0° 8' 0.55597"	0.999965607	494612.554	932595.017	CDOT Type 2 Control Monument
US 285 CM-MP 237.9	39° 32' 34.80889"	105° 17' 30.16084"	2458.875	0° 7' 52.91573"	0.999965606	494610.452	932305.772	CDOT Type 2 Control Monument
US 285 CM-MP 237.6	39° 32' 30.63427"	105° 17' 44.98898"	2462.390	0° 7' 43.56377"	0.999965450	494480.906	931952.010	CDOT Type 2 Control Monument
US 285 CM-MP 237.5	39° 32' 24.254 "	105° 17' 54.017 "	2474.530	0° 7' 33.86985"	0.999965212	494283.68	931736.88	CDOT Type 2 Control Monument
US 285 CM-MP 237.3	39° 32' 21.57977"	105° 18' 0.37408"		0° 7' 33.86055"	0.999965113	494200.854	931585.268	CDOT Type 2 Control Monument
US 285 CM-MP 237.2	39° 32' 16.26764"	105° 18' 4.73152"	2491.650	0° 7' 31.11236"	0.999964917	494036.803	931481.578	CDOT Type 2 Control Monument
US 285 CM-MP 237.1	39° 32' 10.14219"	105° 18' 13.96872"	2503.172	0° 7' 25.28655"	0.999964691	493847.419	931261.413	CDOT Type 2 Control Monument
US 285 CM-MP 237.0	39° 32' 7.62713"	105° 18' 15.16551"		0° 7' 24.53175"	0.999964599	493769.794	931233.002	CDOT Type 2 Control Monument
US 285 CM-MP 236.8	39° 31' 57.07151"	105° 18' 15.45791"		0° 7' 24.34734"	0.999964212	493444.251	931226.720	CDOT Type 2 Control Monument
US 285 CM-MP 236.6	39° 31' 56.16190"	105° 18' 15.65587"	2492.412	0° 7' 24.22249"	0.999964179	493416.190	931222.053	CDOT Type 2 Control Monument
US 285 CM-MP 236.4	39° 31' 50.55460"	105° 18' 21.64097"	2505.979	0° 7' 20.44775"	0.999963975	493242.958	931079.495	CDOT Type 2 Control Monument
US 285 CM-MP 236.2	39° 31' 39.28289"	105° 18' 27.98739"	2510.987	0° 7' 16.44512"	0.999963567	492895.025	930928.670	CDOT Type 2 Control Monument
US 285 CM-MP 236.0	39° 31' 29.30103"	105° 18' 25.56143"	2517.360	0° 7' 17.97515"	0.999963208	492587.315	930987.261	CDOT Type 2 Control Monument
US 285 CM-MP 235.8	39° 31' 19.49286"	105° 18' 22.84101"	2518.945	0° 7' 19.69090"	0.999962858	492284.977	931052.878	CDOT Type 2 Control Monument
US 285 CM-MP 235.6	39° 31' 8.65055"	105° 18' 18.50193"	2529.549	0° 7' 22.42751"	0.999962473	491950.830	931157.231	CDOT Type 2 Control Monument
US 285 CM-MP 235.4	39° 30' 59.79987"	105° 18' 17.93996"	2538.672	0° 7' 22.78193"	0.999962162	491677.912	931171.239	CDOT Type 2 Control Monument
US 285 CM-MP 235.2	39° 30' 45.80626"	105° 18' 24.22643"	2526.425	0° 7' 18.81712"	0.999961672	491246.040	931021.999	CDOT Type 2 Control Monument
US 285 CM-MP 235.0	39° 30' 32.36789"	105° 18' 25.05087"	2527.727	0° 7' 18.29716"	0.999961207	490831.571	931003.186	CDOT Type 2 Control Monument

POINT NAME	PROJECT COORDINATES		ELEV(Ft)	DESCRIPTION
	NORTH (ft)	EAST (ft)		
MEYER JCMD	23868.58	64380.78		JCMD Disk in concrete
JWTHOMAS 1995	38473.96	79383.74		JCMD Disk in concrete
US 285 CM-MP 241.29	28343.25	73735.91	7604.49	CDOT Type 2 Control Monument
US 285 CM-MP 241.1	27510.66	73520.63	7655.17	CDOT Type 2 Control Monument
US 285 CM-MP 240.9	26493.14	73142.50	7720.21	CDOT Type 2 Control Monument
US 285 CM-MP 240.8	26518.83	72623.75	7750.81	CDOT Type 2 Control Monument
US 285 CM-MP 240.7	26899.0	72007.4	7795.70	CDOT Type 2 Control Monument
US 285 CM-MP 240.5	26283.39	71590.41	7839.54	CDOT Type 2 Control Monument
US 285 CM-MP 240.4	25737.18	71188.28	7878.42	CDOT Type 2 Control Monument
US 285 CM-MP 240.2	25834.4	69894.1	7951.21	CDOT Type 2 Control Monument
US 285 CM-MP 240.0	25248.95	69296.20	7988.12	CDOT Type 2 Control Monument
US 285 CM-MP 239.9	24710.81	69108.40	7998.92	CDOT Type 2 Control Monument
US 285 CM-MP 239.8	24291.86	68534.82	8010.91	CDOT Type 2 Control Monument
US 285 CM-MP 239.6	24317.10	67857.77	8009.25	CDOT Type 2 Control Monument
US 285 CM-MP 239.4	24967.51	66807.93	7959.24	CDOT Type 2 Control Monument
US 285 CM-MP 239.3	24918.78	66408.54	7945.12	CDOT Type 2 Control Monument
US 285 CM-MP 239.1	24306.42	65719.15	7927.83	CDOT Type 2 Control Monument
US 285 CM-MP 239.0	23983.20	65206.58	7916.24	CDOT Type 2 Control Monument
US 285 CM-MP 238.8	24095.38	63627.29	7892.22	CDOT Type 2 Control Monument
US 285 CM-MP 238.6	23685.08	62375.71	7936.64	CDOT Type 2 Control Monument
US 285 CM-MP 238.3	23004.09	61281.36	7973.96	CDOT Type 2 Control Monument
US 285 CM-MP 238.1	22721.95	59837.86	8031.95	CDOT Type 2 Control Monument
US 285 CM-MP 237.9	22715.03	58888.50	8067.16	CDOT Type 2 Control Monument
US 285 CM-MP 237.6	22289.81	57727.38	8078.69	CDOT Type 2 Control Monument
US 285 CM-MP 237.5	21642.3	57021.2	8118.52	CDOT Type 2 Control Monument
US 285 CM-MP 237.3	21370.60	56523.67		CDOT Type 2 Control Monument
US 285 CM-MP 237.2	20832.14	56183.35	8174.69	CDOT Type 2 Control Monument
US 285 CM-MP 237.1	20210.53	55460.73	8212.49	CDOT Type 2 Control Monument
US 285 CM-MP 237.0	19955.75	55367.48		CDOT Type 2 Control Monument
US 285 CM-MP 236.8	18887.25	55346.89		CDOT Type 2 Control Monument
US 285 CM-MP 236.6	18795.14	55331.57	8177.19	CDOT Type 2 Control Monument
US 285 CM-MP 236.4	18226.55	54863.67	8221.70	CDOT Type 2 Control Monument
US 285 CM-MP 236.2	17084.55	54368.66	8238.13	CDOT Type 2 Control Monument
US 285 CM-MP 236.0	16074.58	54560.98	8259.04	CDOT Type 2 Control Monument
US 285 CM-MP 235.8	15082.25	54776.37	8264.24	CDOT Type 2 Control Monument
US 285 CM-MP 235.6	13985.52	55118.90	8299.03	CDOT Type 2 Control Monument
US 285 CM-MP 235.4	13089.74	55164.89	8328.96	CDOT Type 2 Control Monument
US 285 CM-MP 235.2	11672.24	54675.08	8288.78	CDOT Type 2 Control Monument
US 285 CM-MP 235.0	10311.86	54613.36	8293.05	CDOT Type 2 Control Monument

FILING CERTIFICATION: DEPOSITED THIS _____ DAY OF _____, 19____, AT _____, FOR INFORMATION ONLY IN BOOK _____ OF THE COUNTY LAND SURVEYS/RIGHT OF WAY SURVEYS AT PAGE _____ RECEPTION NUMBER _____ SIGNED _____ DEPT. _____

Computer File Information			Sheet Revisions			As Constructed	SURVEY CONTROL DIAGRAM	Project CX 11-0285-28 UNIT 4 & 5
Creation Date:	10/1/96	Initials: LCY	1/8/99	Added Correction Diagram to title	D.A.S.			
Last Modification Date:	1/8/99	Initials: DAS	1/8/99	Edited coordinate for Meyer JCMD	D.A.S.	No Revisions:	CORRECTION DIAGRAM	92026
Full Path:	C:\PROJECTS\285PH4\CSDPH4\		1/8/99	Deleted CM-MP 239.2	D.A.S.	Revised:		
Drawing File Name:	N285CSDC.DWG		1/8/99	Edited coordinates for CM-MP 239.3	D.A.S.	Void:	Sheet Subset: Survey	Subset Sheets: 2/11
Acad Ver.	R13	Scale: 1"=200'	Units: FEET					Sheet Number

 
C:\PROJECTS\285PH4\CSDPH4\N285CSDC.DWG 1/8/99 PLOT/EDIT by D.A.S.

Colorado Department of Transportation
Region 1 Construction
18500 E. Colfax Avenue
Aurora, Colorado 80011
Phone: 303-757-9744 FAX: 303-757-9746
Survey Coordinator JPC




DEPARTMENT OF TRANSPORTATION - STATE OF COLORADO CONTROL SURVEY DIAGRAM

Project CX 11-0285-28 UNIT 4 & 5
U.S. 285 MP 235.0 to MP 241.29
Sections 4, 5, 7, & 8 of
T. 6 S., R. 70 W.
Sections 11, 12, 14, & 23 of
T. 6 S., R. 71 W.
JEFFERSON COUNTY, COLORADO



1200
600 2400
ORIGINAL SCALE 1"=1200'

- ◆ FOUND MONUMENT FOR SECTION CORNER
- FOUND MONUMENT FOR QUARTER CORNER
- ⊕ FOUND MONUMENT FOR SIXTEENTH CORNER
- FOUND MONUMENT FOR PROPERTY PIN

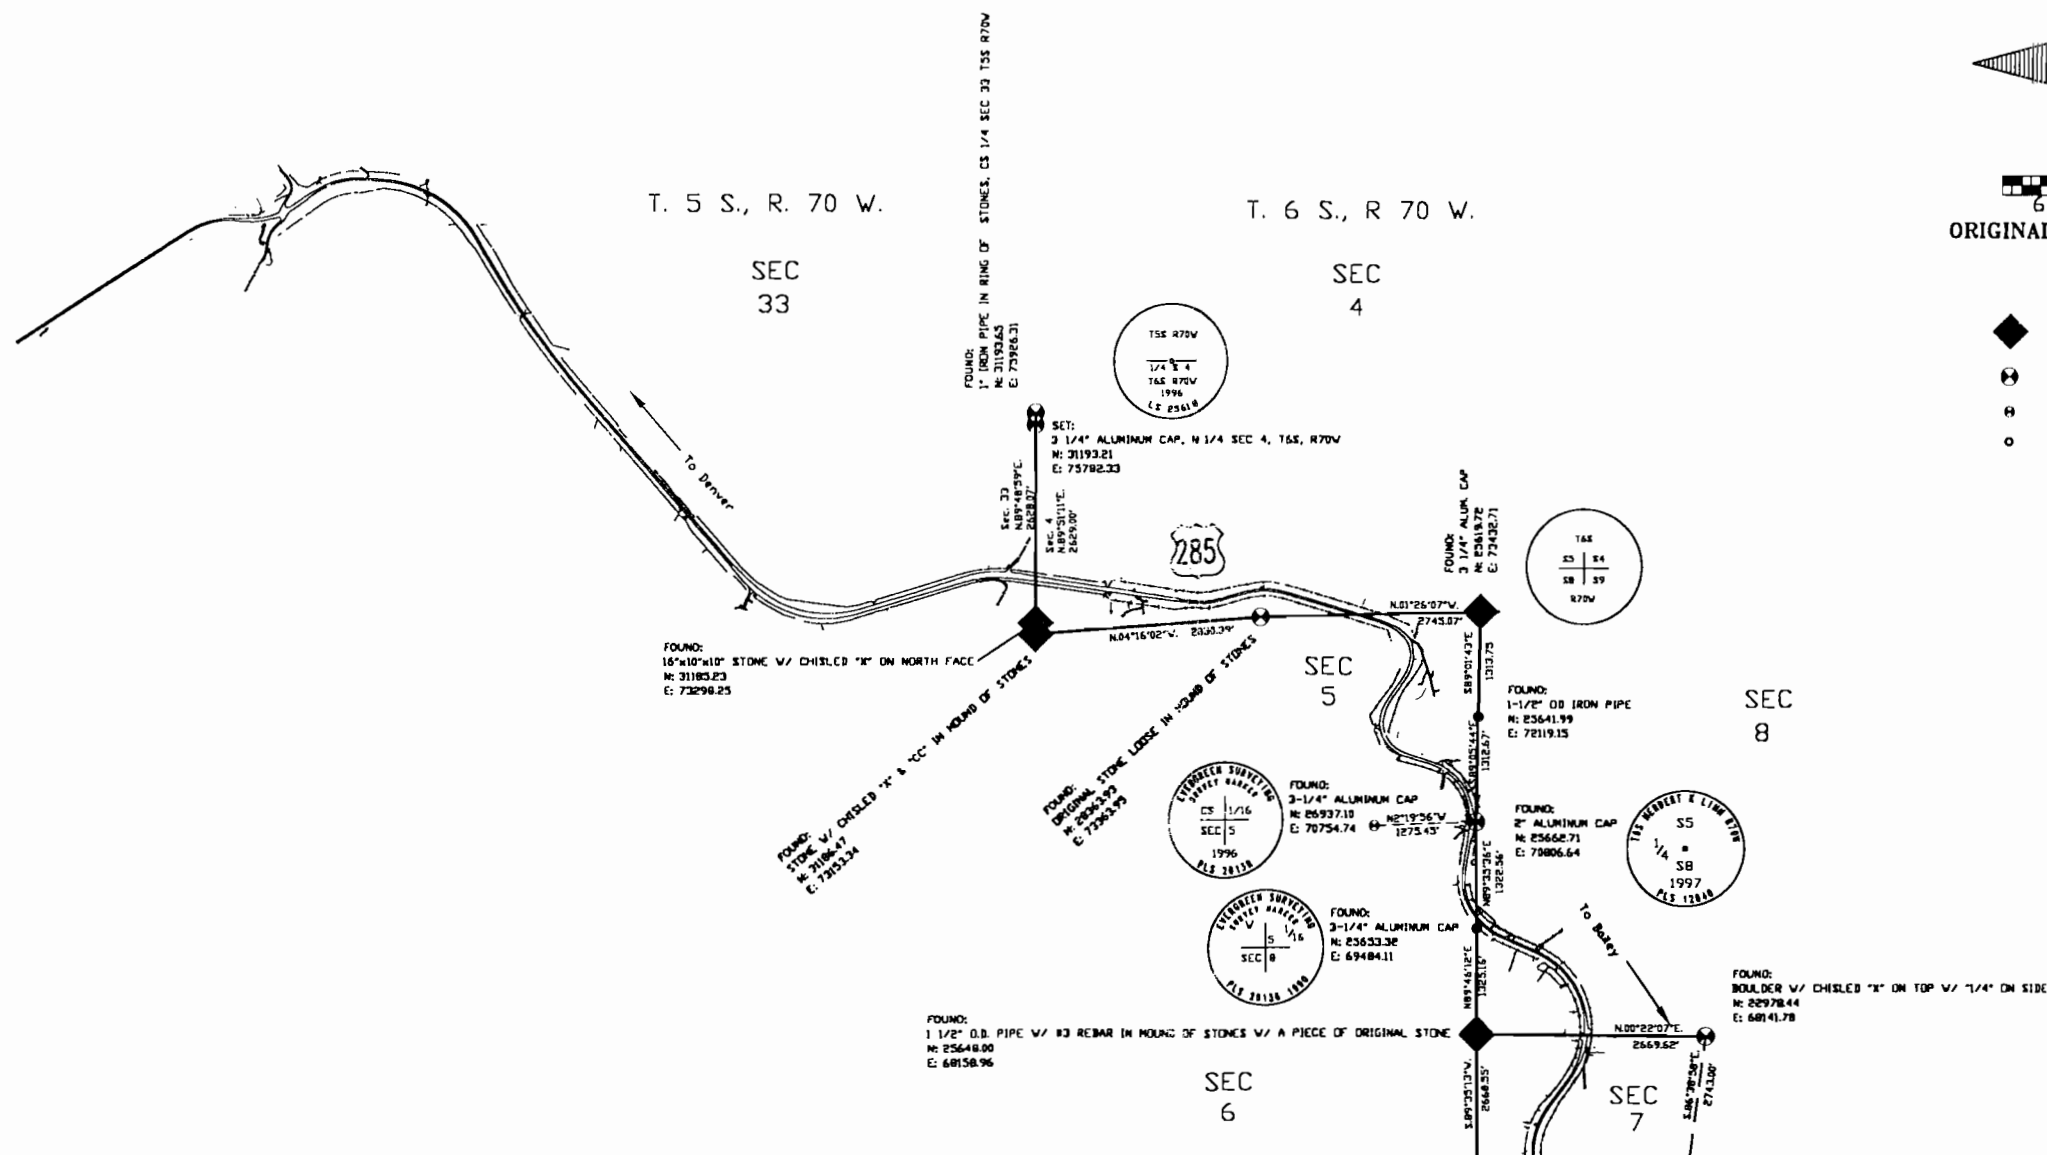

FILING CERTIFICATION:
DEPOSITED THIS ____ DAY OF ____, 19 ____, AT ____, M., FOR INFORMATION
ONLY IN BOOK ____ OF THE COUNTY LAND SURVEYS/RIGHT OF WAY
SURVEYS AT PAGE ____, RECEPTION NUMBER ____

SIGNED _____
DEPT. _____

Computer File Information				Sheet Revisions			Colorado Department of Transportation		As Constructed		SURVEY CONTROL DIAGRAM		Project CX 11-0285-28 UNIT 4 & 5		
Creation Date:		10/1/96		Initials:		LCY		1/8/99		Added Correction Diagram to title		D.A.S.		U.S. 285 - FOXTON ROAD TO MARIPOSA DRIVE	
Last Modification Date:		1/8/99		Initials:		DAS		1/8/99		Edited symbol of S. 1/4 cor. sec. 5		D.A.S.			
Full Path: C:\PROJECTS\285PH4\CSDPH4\				1/8/99		Edited position of E. 1/4 cor. sec. 7		D.A.S.				CORRECTION DIAGRAM		92026	
Drawing File Name: N285CSDC.DWG															
Acad Ver. R13		Scale: 1"=200'		Units: FEET								Sheet Subset: Survey		Subset Sheets: 3/11	
														Sheet Number	

 

C:\PROJECTS\285PH4\CSDPH4\N285CSDC.DWG 1/8/99 PLOT/EDIT by D.A.S.

Colorado Department of Transportation
Region 1 Construction
18500 E Colfax Avenue
Aurora, Colorado 80011
Phone: 303-757-9744 FAX: 303-757-9746
Survey Coordinator JPC



DEPARTMENT OF TRANSPORTATION - STATE OF COLORADO CONTROL SURVEY DIAGRAM

Project CX 11-0285-28 UNIT 4 & 5
U.S. 285 MP 235.0 to MP 241.29
Sections 4, 5, 7, & 8 of
T. 6 S., R. 70 W.
Sections 11, 12, 14, & 23 of
T. 6 S., R. 71 W.
JEFFERSON COUNTY, COLORADO

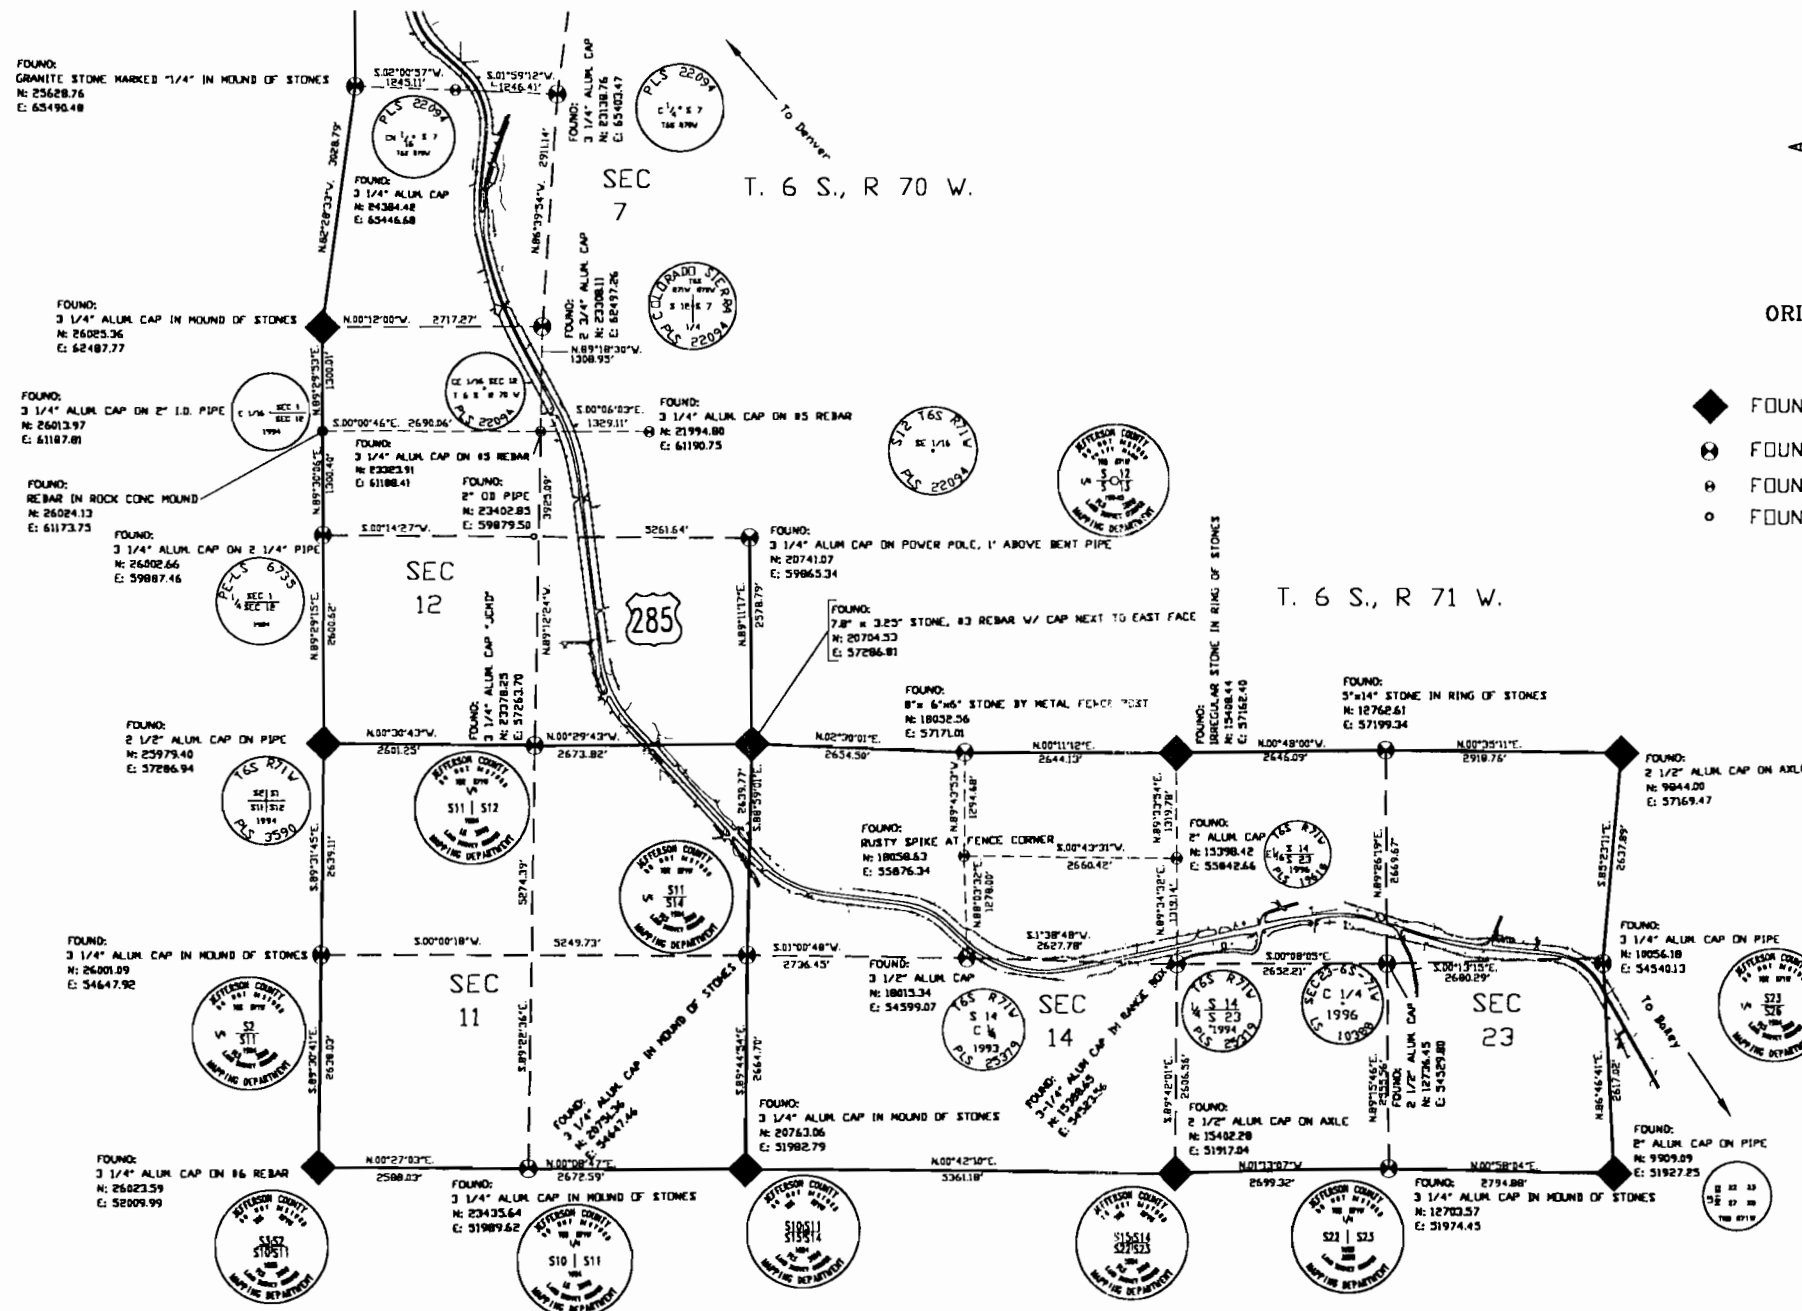

1200
600 2400
ORIGINAL SCALE 1"=1200'

- ◆ FOUND MONUMENT FOR SECTION CORNER
- FOUND MONUMENT FOR QUARTER CORNER
- ⊙ FOUND MONUMENT FOR SIXTEENTH CORNER
- FOUND MONUMENT FOR PROPERTY PIN

FILING CERTIFICATION: DEPOSITED THIS ____ DAY OF _____, 19____, AT _____, M., FOR INFORMATION
ONLY IN BOOK _____ OF THE COUNTY LAND SURVEYS/RIGHT OF WAY
SURVEYS AT PAGE _____, RECEPTION NUMBER _____

SIGNED _____
DEPT.



Computer File Information				Sheet Revisions				Colorado Department of Transportation				As Constructed		SURVEY CONTROL DIAGRAM				Project CX 11-0285-28 UNIT 4 & 5	
Creation Date:		10/1/96		Initials:		LCY		1/8/99		Added Correction Diagram to title		D.A.S.		No Revisions:		U.S. 285 - FOXTON ROAD TO MARIPOSA DRIVE			
Last Modification Date:		1/8/99		Initials:		DAS		1/8/99		Edited monument description CE 1/16 sec. 12		D.A.S.		Revised:		CORRECTION DIAGRAM			
Full Path: C:\PROJECTS\285PH4\CSDPH4\																92026			
Drawing File Name: N285CSDC.DWG																Sheet Subset: Survey		Subset Sheets: 4/11	
Acad Ver.		R13		Scale: 1"=200'		Units:		FEET		Survey Coordinator				JPC		Sheet Number			
C:\PROJECTS\285PH4\CSDPH4\N285CSDC.DWG 1/8/99 PLOT/EDIT by D.A.S.																			

C:\PROJECTS\285PH4\CSDPH4\N285CSDC.DWG 1/8/99 PLOT/EDIT by D.A.S.



DEPARTMENT OF TRANSPORTATION - STATE OF COLORADO CONTROL SURVEY DIAGRAM

Project CX 11-0285-28 UNIT 4 & 5
U.S. 285 MP 235.0 to MP 241.29
Sections 4, 5, 7, & 8 of
T. 6 S., R. 70 W.
Sections 11, 12, 14, & 23 of
T. 6 S., R. 71 W.
JEFFERSON COUNTY, COLORADO

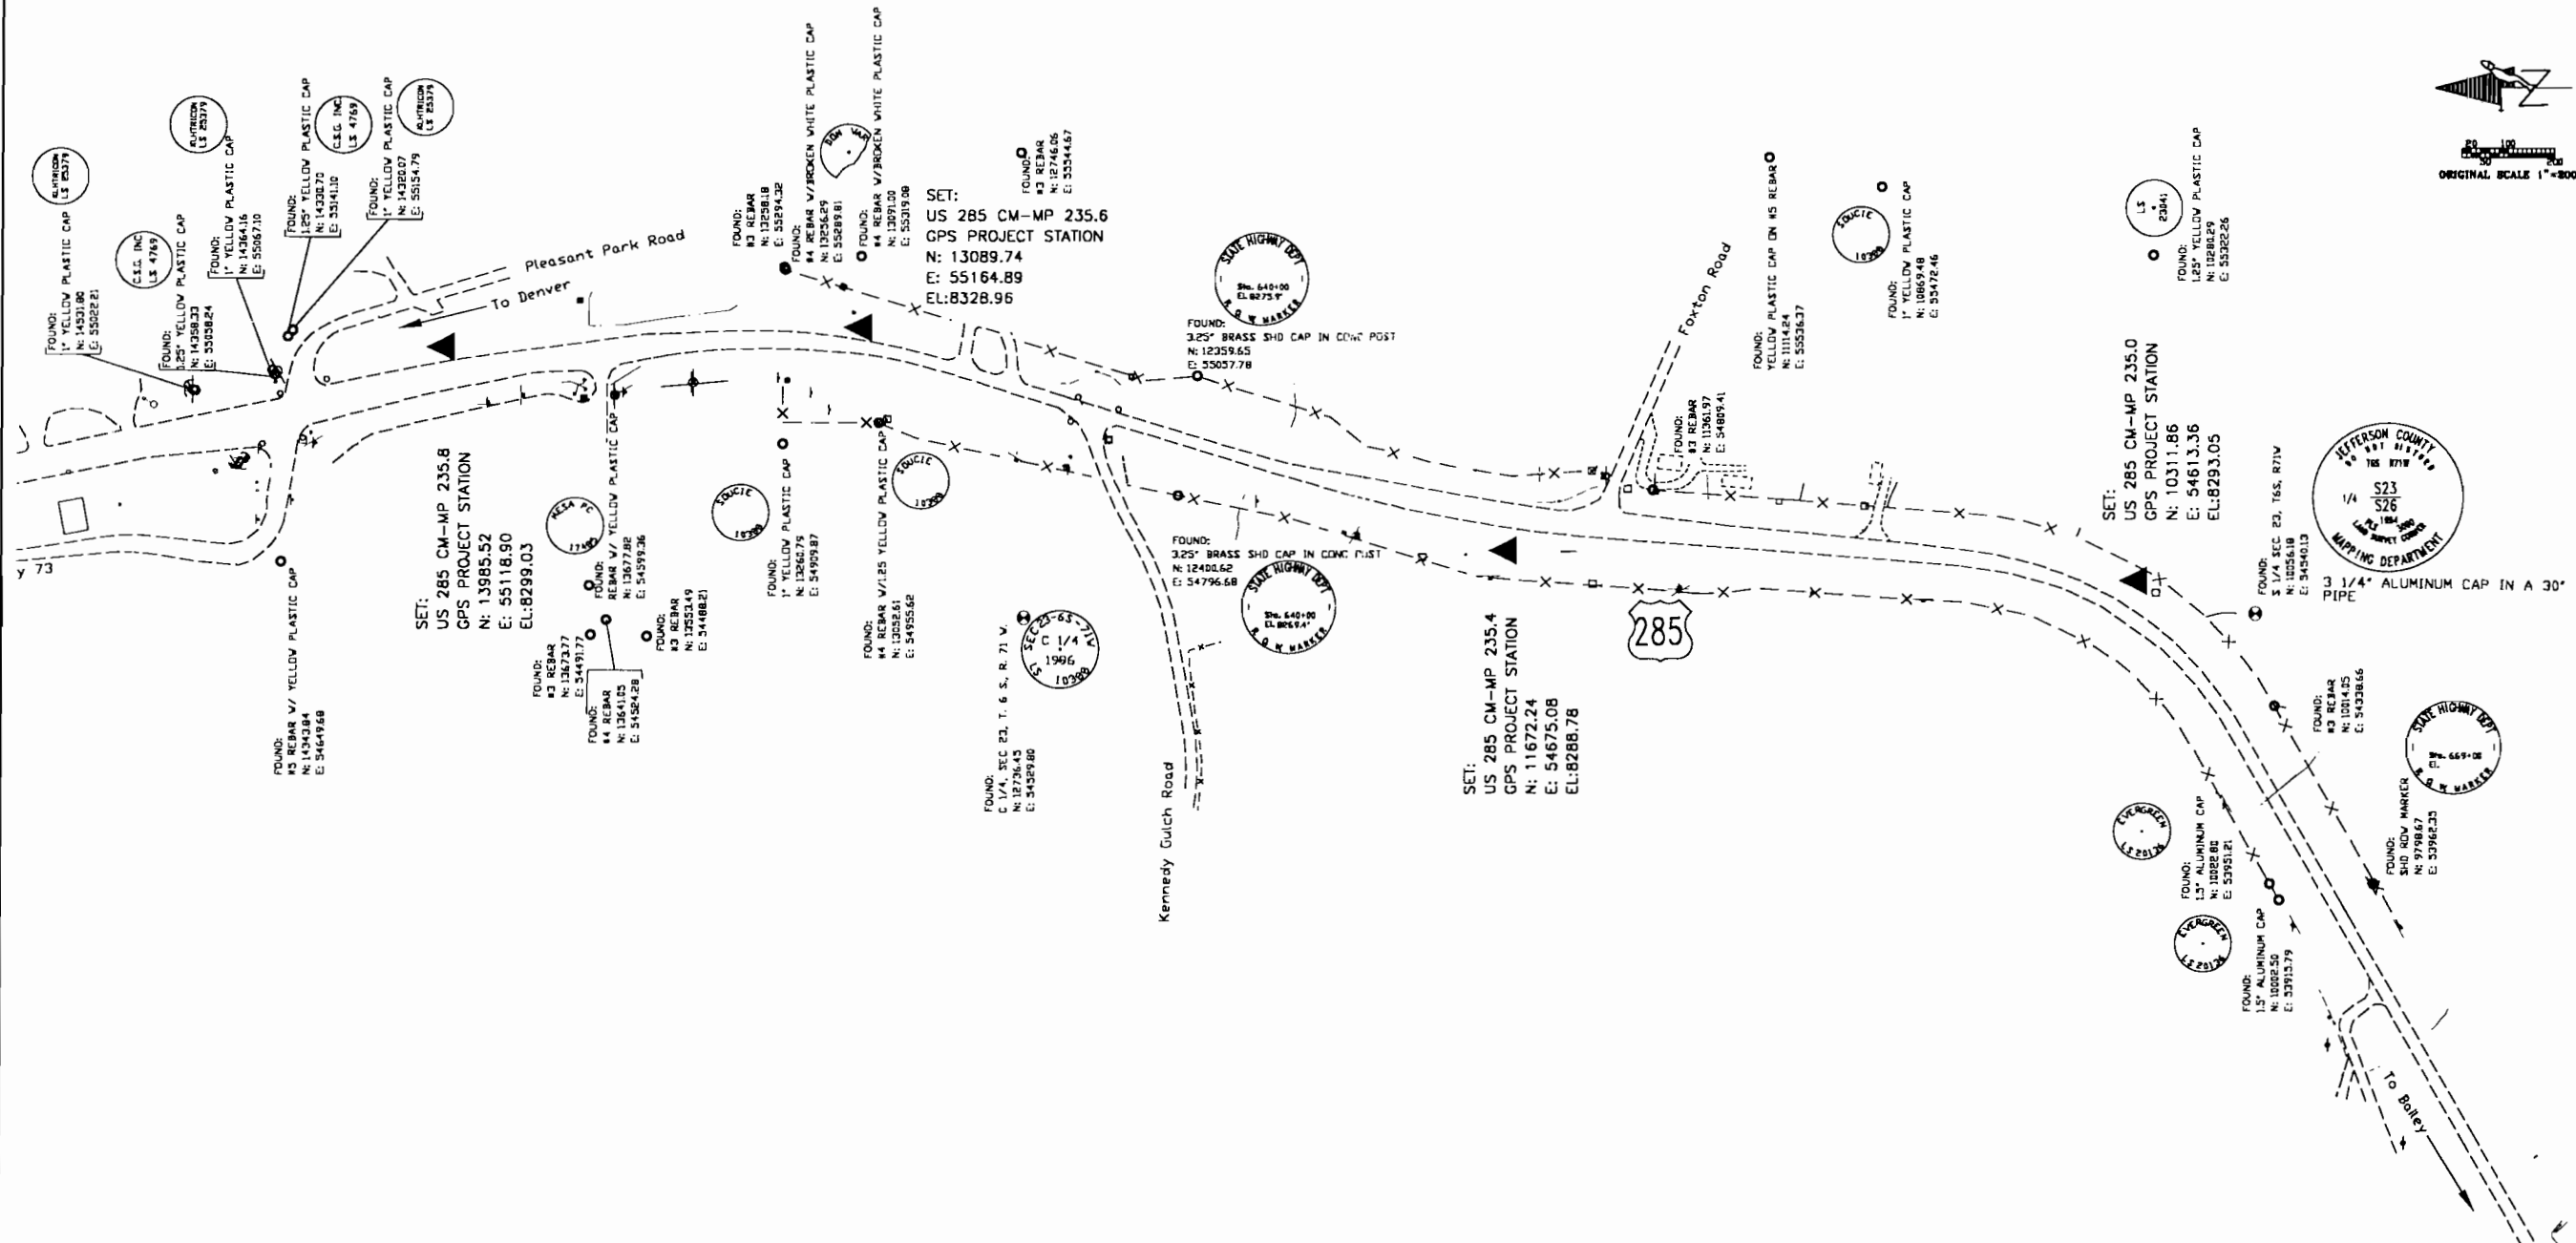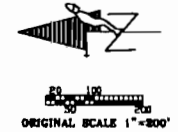

FILING CERTIFICATION:
DEPOSITED THIS _____ DAY OF _____, 19____, AT _____, FOR INFORMATION
ONLY IN BOOK _____ OF THE COUNTY LAND SURVEYS/RIGHT OF WAY
SURVEYS AT PAGE _____, RECEPTION NUMBER _____

SIGNED _____
DEPT. _____

Computer File Information				Sheet Revisions			Colorado Department of Transportation		As Constructed		SURVEY CONTROL DIAGRAM			Project CX 11-0285-28 UNIT 4 & 5	
Creation Date:		10/1/96		Initials:		LCY	1/8/99	Added Correction Diagram to title		D.A.S.				U.S. 285 - FOXTON ROAD TO MARIPOSA DRIVE	
Last Modification Date:		1/8/99		Initials:		DAS								92026	
Full Path:		C:\PROJECTS\285PH4\CSDPH4\													
Drawing File Name:		N285CSDC.DWG													
Acad Ver.		R13		Scale: 1"=200'		Units:	FEET					Sheet Subset: Survey		Subset Sheets: 5/11	
														Sheet Number	



Region 1 Construction
18500 E Colfax Avenue
Aurora, Colorado 80011
Phone: 303-757-9744 FAX: 303-757-9746

Survey Coordinator JPC


C:\PROJECTS\285PH4\CSDPH4\N285CSDC.DWG 1/8/99 PLOT/EDIT by D.A.S.

Colorado Department of Transportation
Region 1 Construction
18500 E Colfax Avenue
Aurora, Colorado 80011
Phone: 303-757-9744 FAX: 303-757-9746
Survey Coordinator JPC



DEPARTMENT OF TRANSPORTATION - STATE OF COLORADO CONTROL SURVEY DIAGRAM

Project CX 11-0285-28 UNIT 4 & 5
U.S. 285 MP 235.0 to MP 241.29
Sections 4, 5, 7, & 8 of
T. 6 S., R. 70 W.
Sections 11, 12, 14, & 23 of
T. 6 S., R. 71 W.
JEFFERSON COUNTY, COLORADO

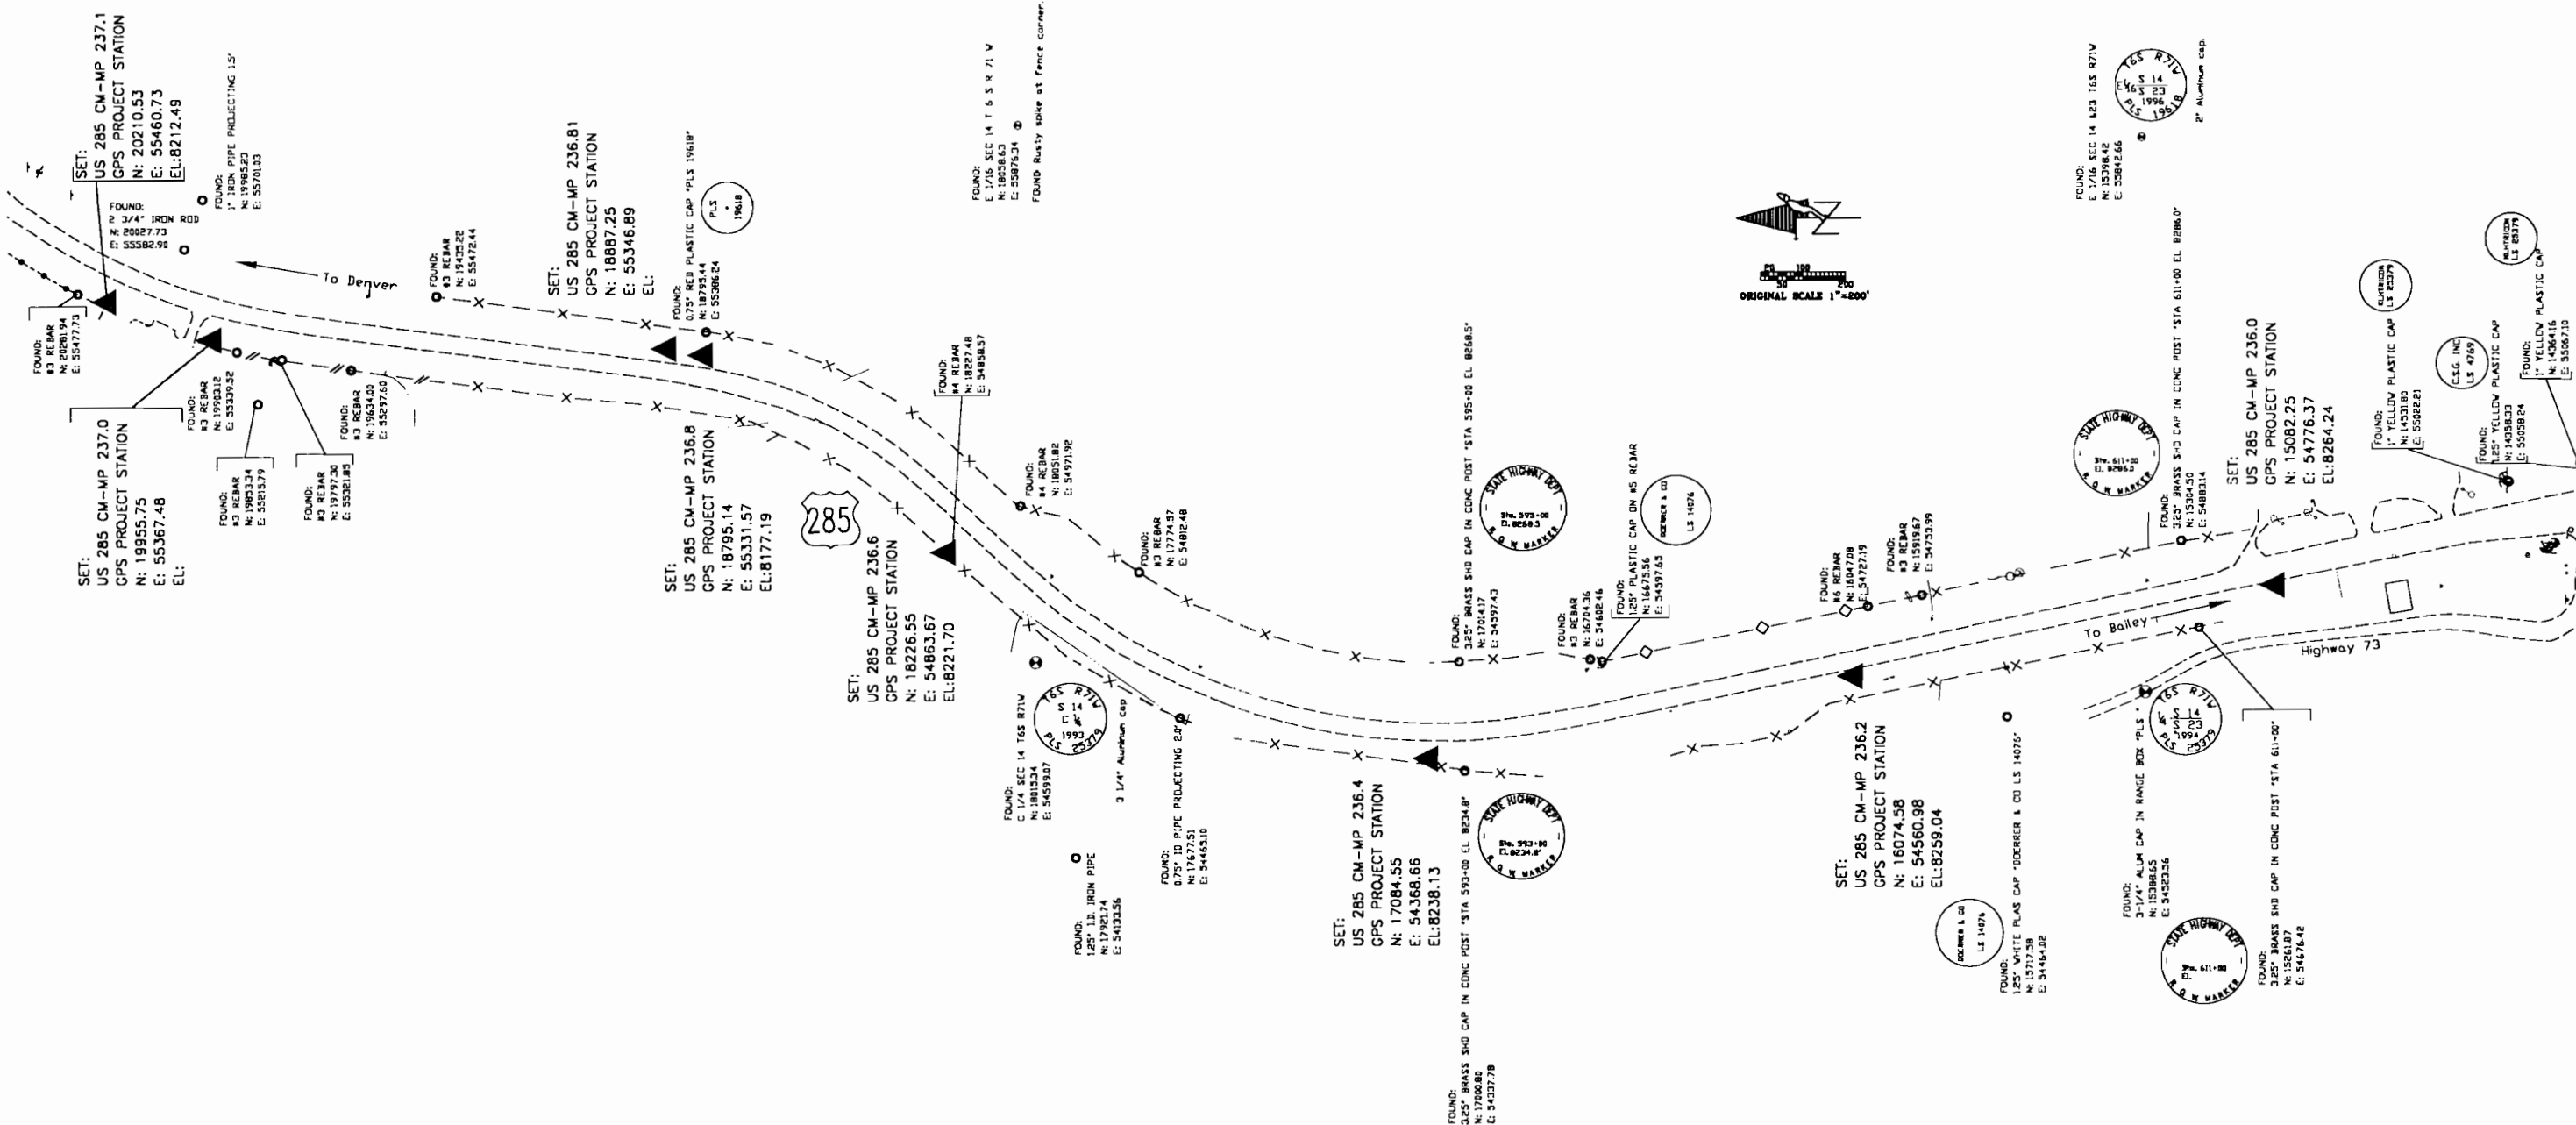

FLING CERTIFICATION: DEPOSITED THIS _____ DAY OF _____, 19____, AT _____ M., FOR INFORMATION ONLY IN BOOK _____ OF THE COUNTY LAND SURVEYS/RIGHT OF WAY SURVEYS AT PAGE _____, RECEPTION NUMBER _____

SIGNED _____
DEPT. _____

Computer File Information			Sheet Revisions			As Constructed			SURVEY CONTROL DIAGRAM		Project CX 11-0285-28 UNIT 4 & 5
Creation Date:	10/1/96	Initials: LCY	1/8/99	Added Correction Diagram to title	D.A.S.	No Revisions:					U.S. 285 - FOXTON ROAD TO MARIPOSA DRIVE
Last Modification Date:	1/8/99	Initials: DAS				Revised:			CORRECTION DIAGRAM		92026
Full Path:	C:\PROJECTS\285PH4\CSDPH4\					Void:			Sheet Subset:	Survey	Subset Sheets: 6/11
Drawing File Name:	N285CSDC.DWG										Sheet Number
Acad Ver.	R13	Scale: 1"=200'	Units:	FEET							


C:\PROJECTS\285PH4\CSDPH4\N285CSDC.DWG 1/8/99 PLOT/EDIT by D.A.S.

Colorado Department of Transportation
Region 1 Construction
18500 E Colfax Avenue
Aurora, Colorado 80011
Phone: 303-757-9744 FAX: 303-757-9746
Survey Coordinator JPC



DEPARTMENT OF TRANSPORTATION - STATE OF COLORADO CONTROL SURVEY DIAGRAM

Project CX 11-0285-28 UNIT 4 & 5
U.S. 285 MP 235.0 to MP 241.29
Sections 4, 5, 7, & 8 of
T. 6 S., R. 70 W.
Sections 11, 12, 14, & 23 of
T. 6 S., R. 71 W.
JEFFERSON COUNTY, COLORADO

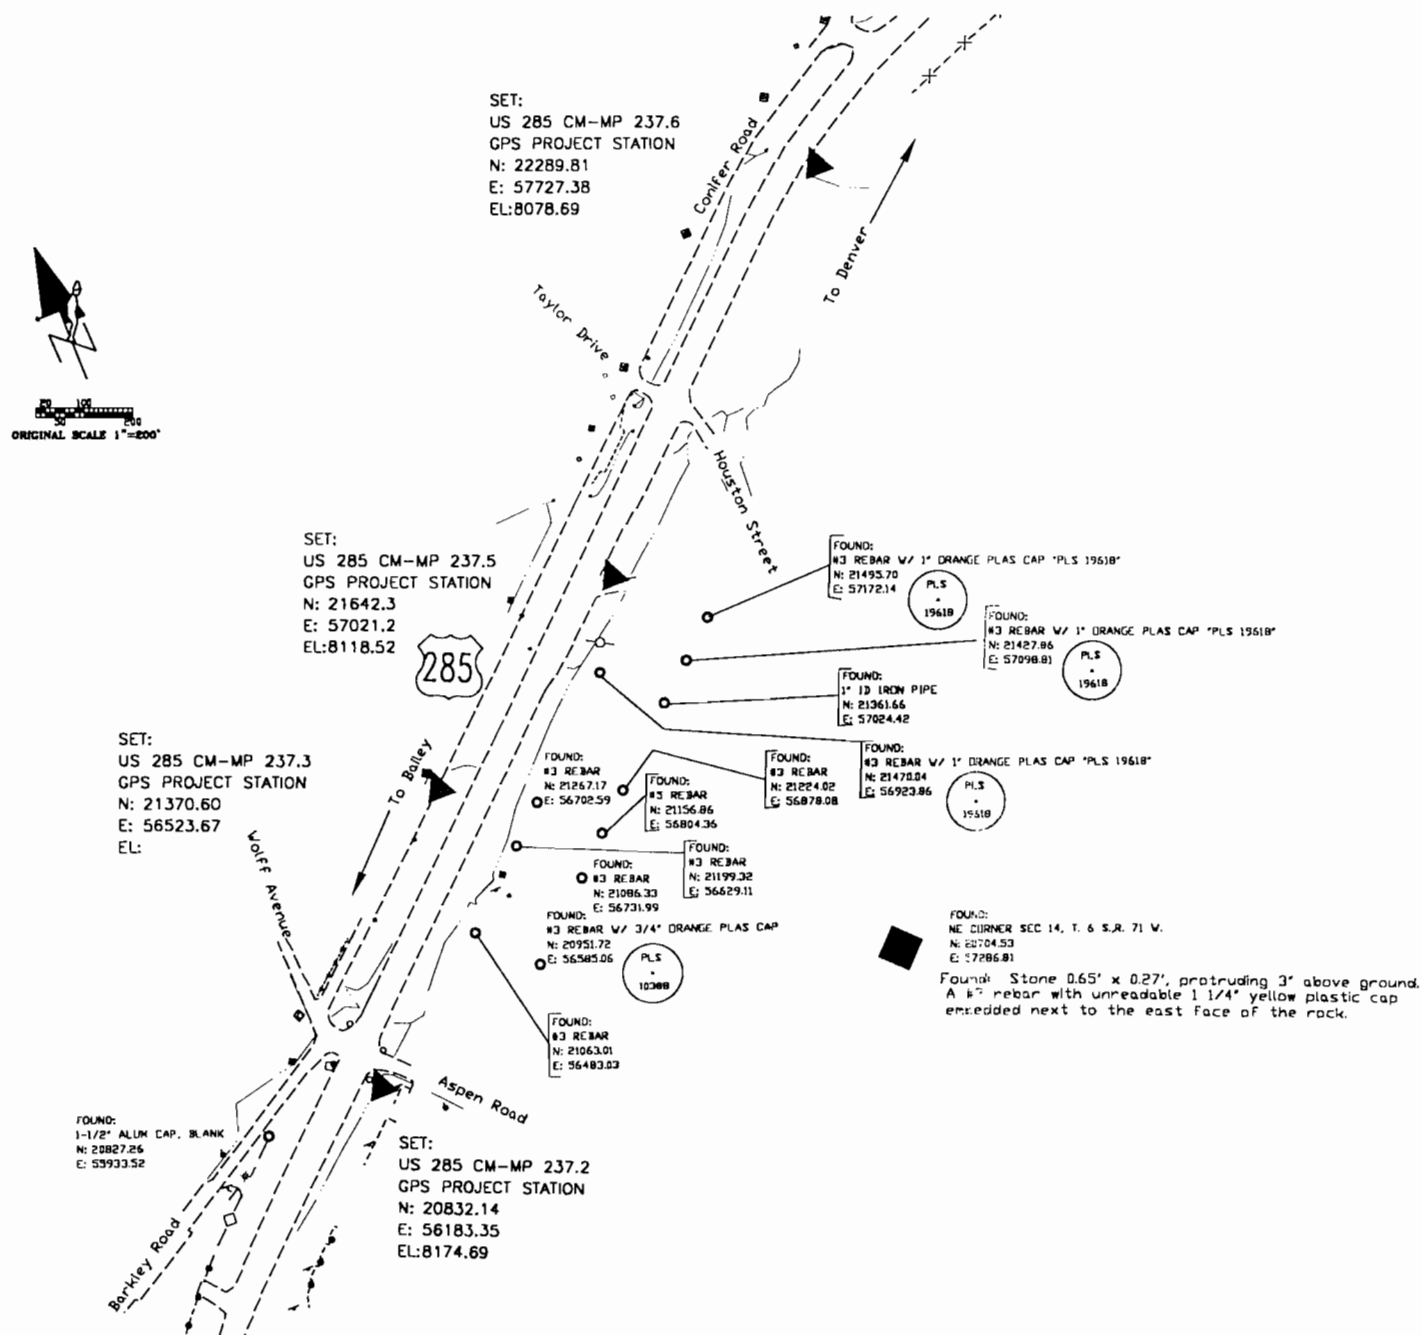

FOUND:
S 1/4 CORNER SEC 12 T6S R71W
N: 20741.07
E: 59865.34



FILED CERTIFICATION: DAY OF 19__ AT __, M., FOR INFORMATION
ONLY IN BOOK OF THE COUNTY LAND SURVEYS/RIGHT OF WAY
SURVEYS AT PAGE RECEPTION NUMBER


SIGNED
DEPT.

Computer File Information			Sheet Revisions			 Colorado Department of Transportation Region 1 Construction 18500 E Colfax Avenue Aurora, Colorado 80011 Phone: 303-757-9744 FAX: 303-757-9746 Survey Coordinator JPC	As Constructed		SURVEY CONTROL DIAGRAM		Project CX 11-0285-28 UNIT 4 & 5	
Creation Date:	10/1/96	Initials: LCY	1/8/99	Added Correction Diagram to title	D.A.S.		No Revisions:				U.S. 285 - FOXTON ROAD TO MARIPOSA DRN	
Last Modification Date:	1/8/99	Initials: DAS					Revised:		92026			
Full Path:	C:\PROJECTS\285PH4\CSDPH4\						Void:		Sheet Subset: Survey Subsel Sheets: 7/11			
Drawing File Name:	N285CSDC.OWG											
Acad Ver.	R13	Scale: 1"=200'	Units: FEET						Sheet Number			




DEPARTMENT OF TRANSPORTATION - STATE OF COLORADO CONTROL SURVEY DIAGRAM

Project CX 11-0285-28 UNIT 4 & 5
U.S. 285 MP 235.0 to MP 241.29
Sections 4, 5, 7, & 8 of
T. 6 S., R. 70 W.
Sections 11, 12, 14, & 23 of
T. 6 S., R. 71 W.
JEFFERSON COUNTY, COLORADO

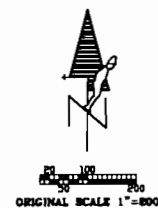

ORIGINAL SCALE 1"=200'

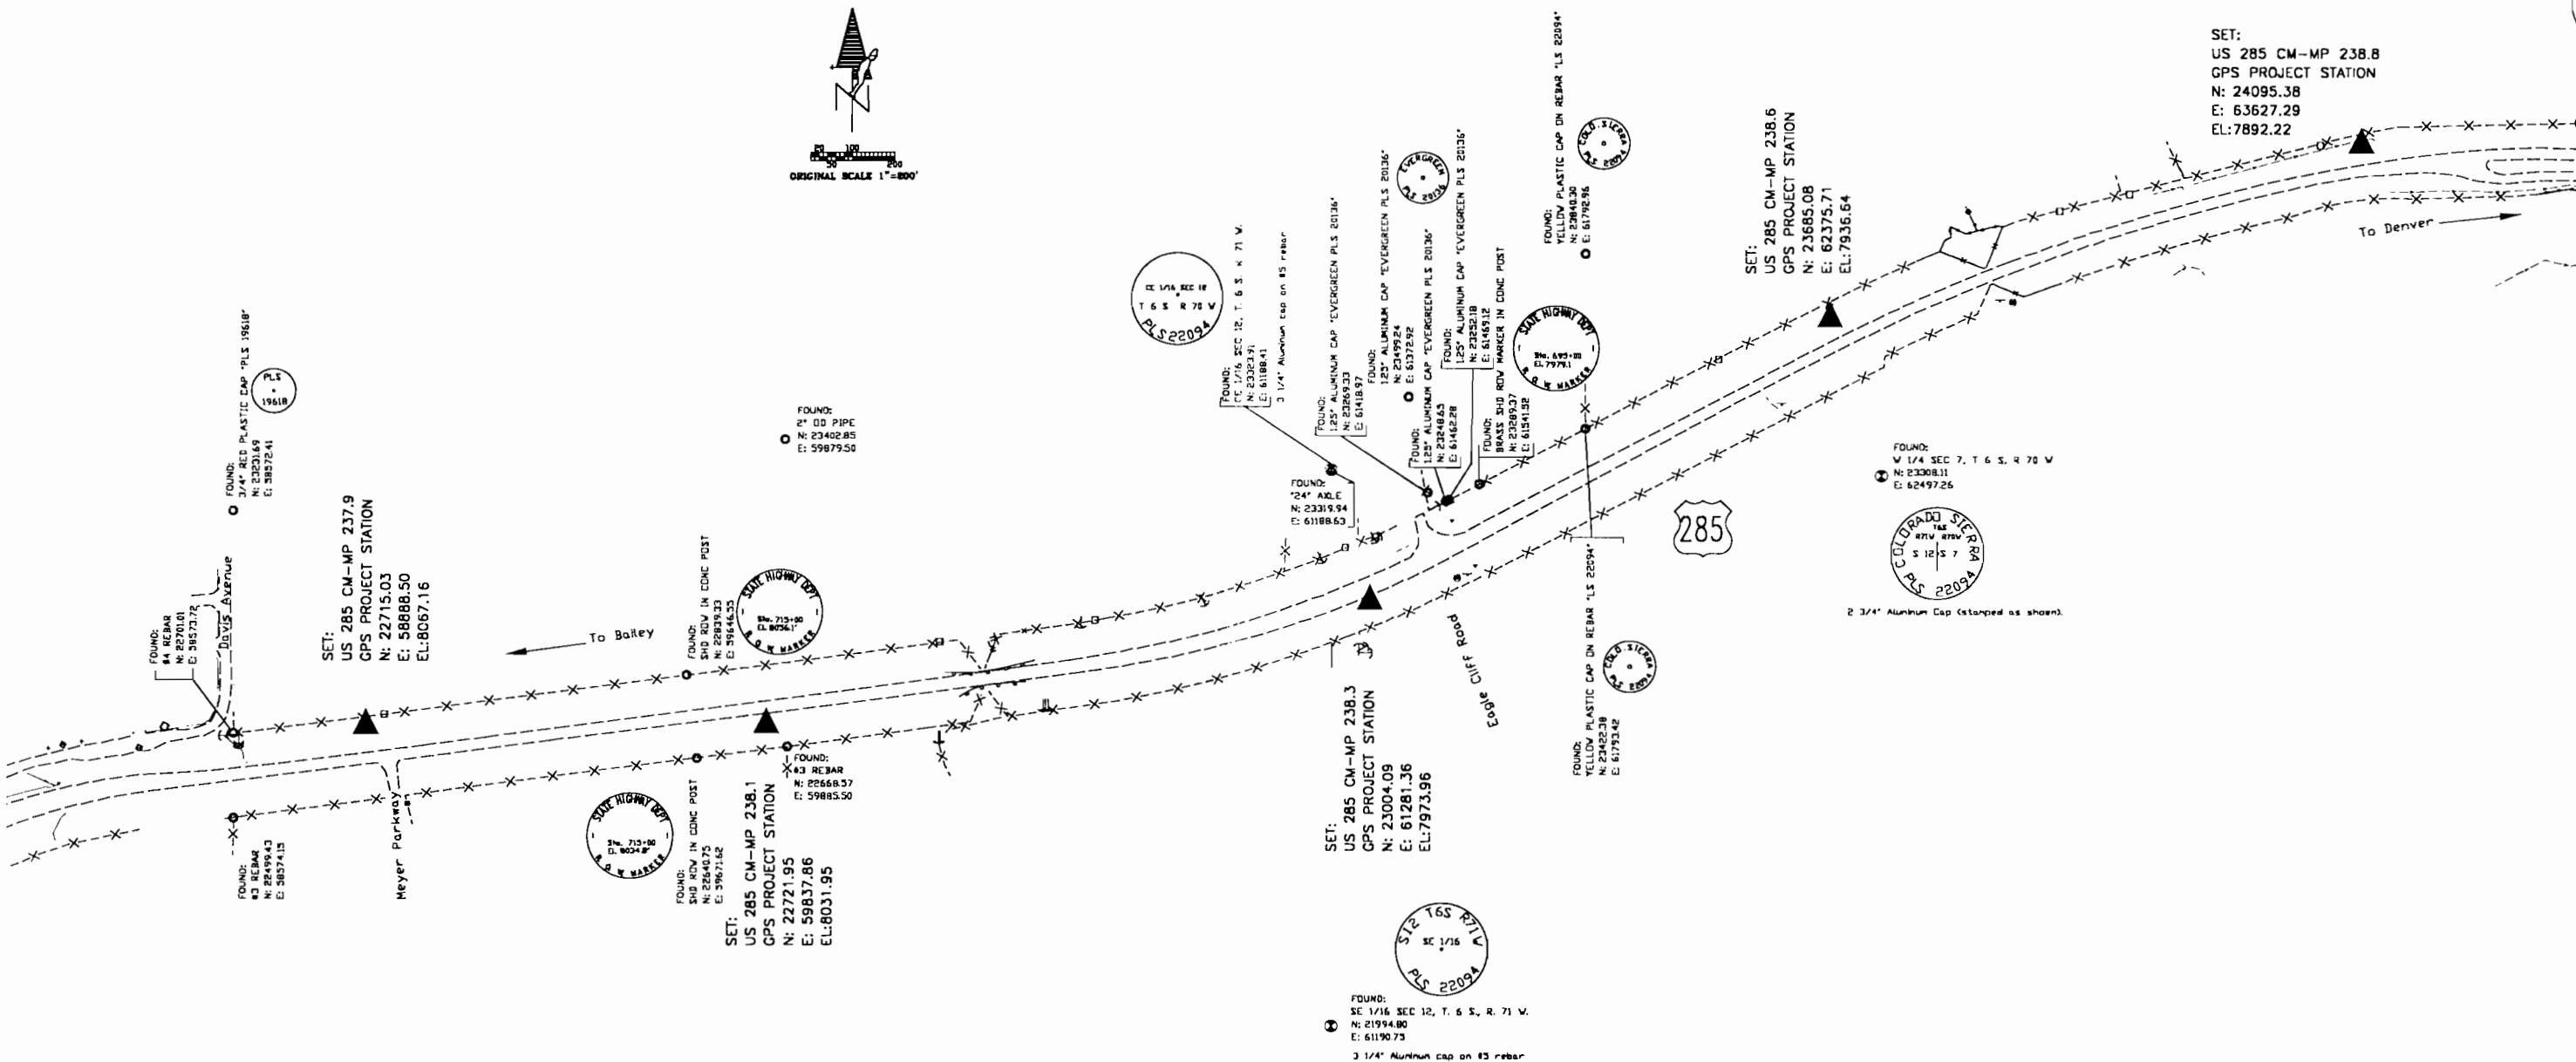

FILING CERTIFICATION:
DEPOSITED THIS ____ DAY OF ____, 19____, AT ____ M., FOR INFORMATION
ONLY IN BOOK ____ OF THE COUNTY LAND SURVEYS/RIGHT OF WAY
SURVEYS AT PAGE ____ RECEPTION NUMBER ____

SIGNED _____
DEPT. _____

Computer File Information			Sheet Revisions			Colorado Department of Transportation  Region 1 Construction 18500 E Colfax Avenue Aurora, Colorado 80011 Phone: 303-757-9744 FAX: 303-757-9746 Survey Coordinator JPC	As Constructed		SURVEY CONTROL DIAGRAM		Project CX 11-0285-28 UNIT 4 & 5	
Creation Date:	10/1/96	Initials: LCY	1/8/99	Added Correction Diagram to title	D.A.S.		No Revisions:		U.S. 285 - FOXTON ROAD TO MARIPOSA DRIVE			
Last Modification Date:	1/8/99	Initials: DAS	1/8/99	Edited monument description CE 1/16 sec. 12	D.A.S.		Revised:		92026			
Full Path:	C:\PROJECTS\285PH4\CSDPH4\						Void:		Sheet Number			
Drawing File Name:	N285CSDC.DWG						Sheet Subset: Survey		Subset Sheets: 8/11			
Acad Ver.	R13	Scale: 1"=200'	Units:	FEET								

C:\PROJECTS\285PH4\CSDPH4\N285CSDC.DWG 1/8/99 PLOT/EDIT by D.A.S.




DEPARTMENT OF TRANSPORTATION - STATE OF COLORADO CONTROL SURVEY DIAGRAM

Project CX 11-0285-28 UNIT 4 & 5
U.S. 285 MP 235.0 to MP 241.29
Sections 4, 5, 7, & 8 of
T. 6 S., R. 70 W.
Sections 11, 12, 14, & 23 of
T. 6 S., R. 71 W.
JEFFERSON COUNTY, COLORADO


FILING CERTIFICATION: DEPOSITED THIS _____ DAY OF _____, 19____, AT _____, FOR INFORMATION
ONLY IN BOOK _____ OF THE COUNTY LAND SURVEYS/RIGHT OF WAY
SURVEYS AT PAGE _____, RECEPTION NUMBER _____

SIGNED _____
DEPT. _____

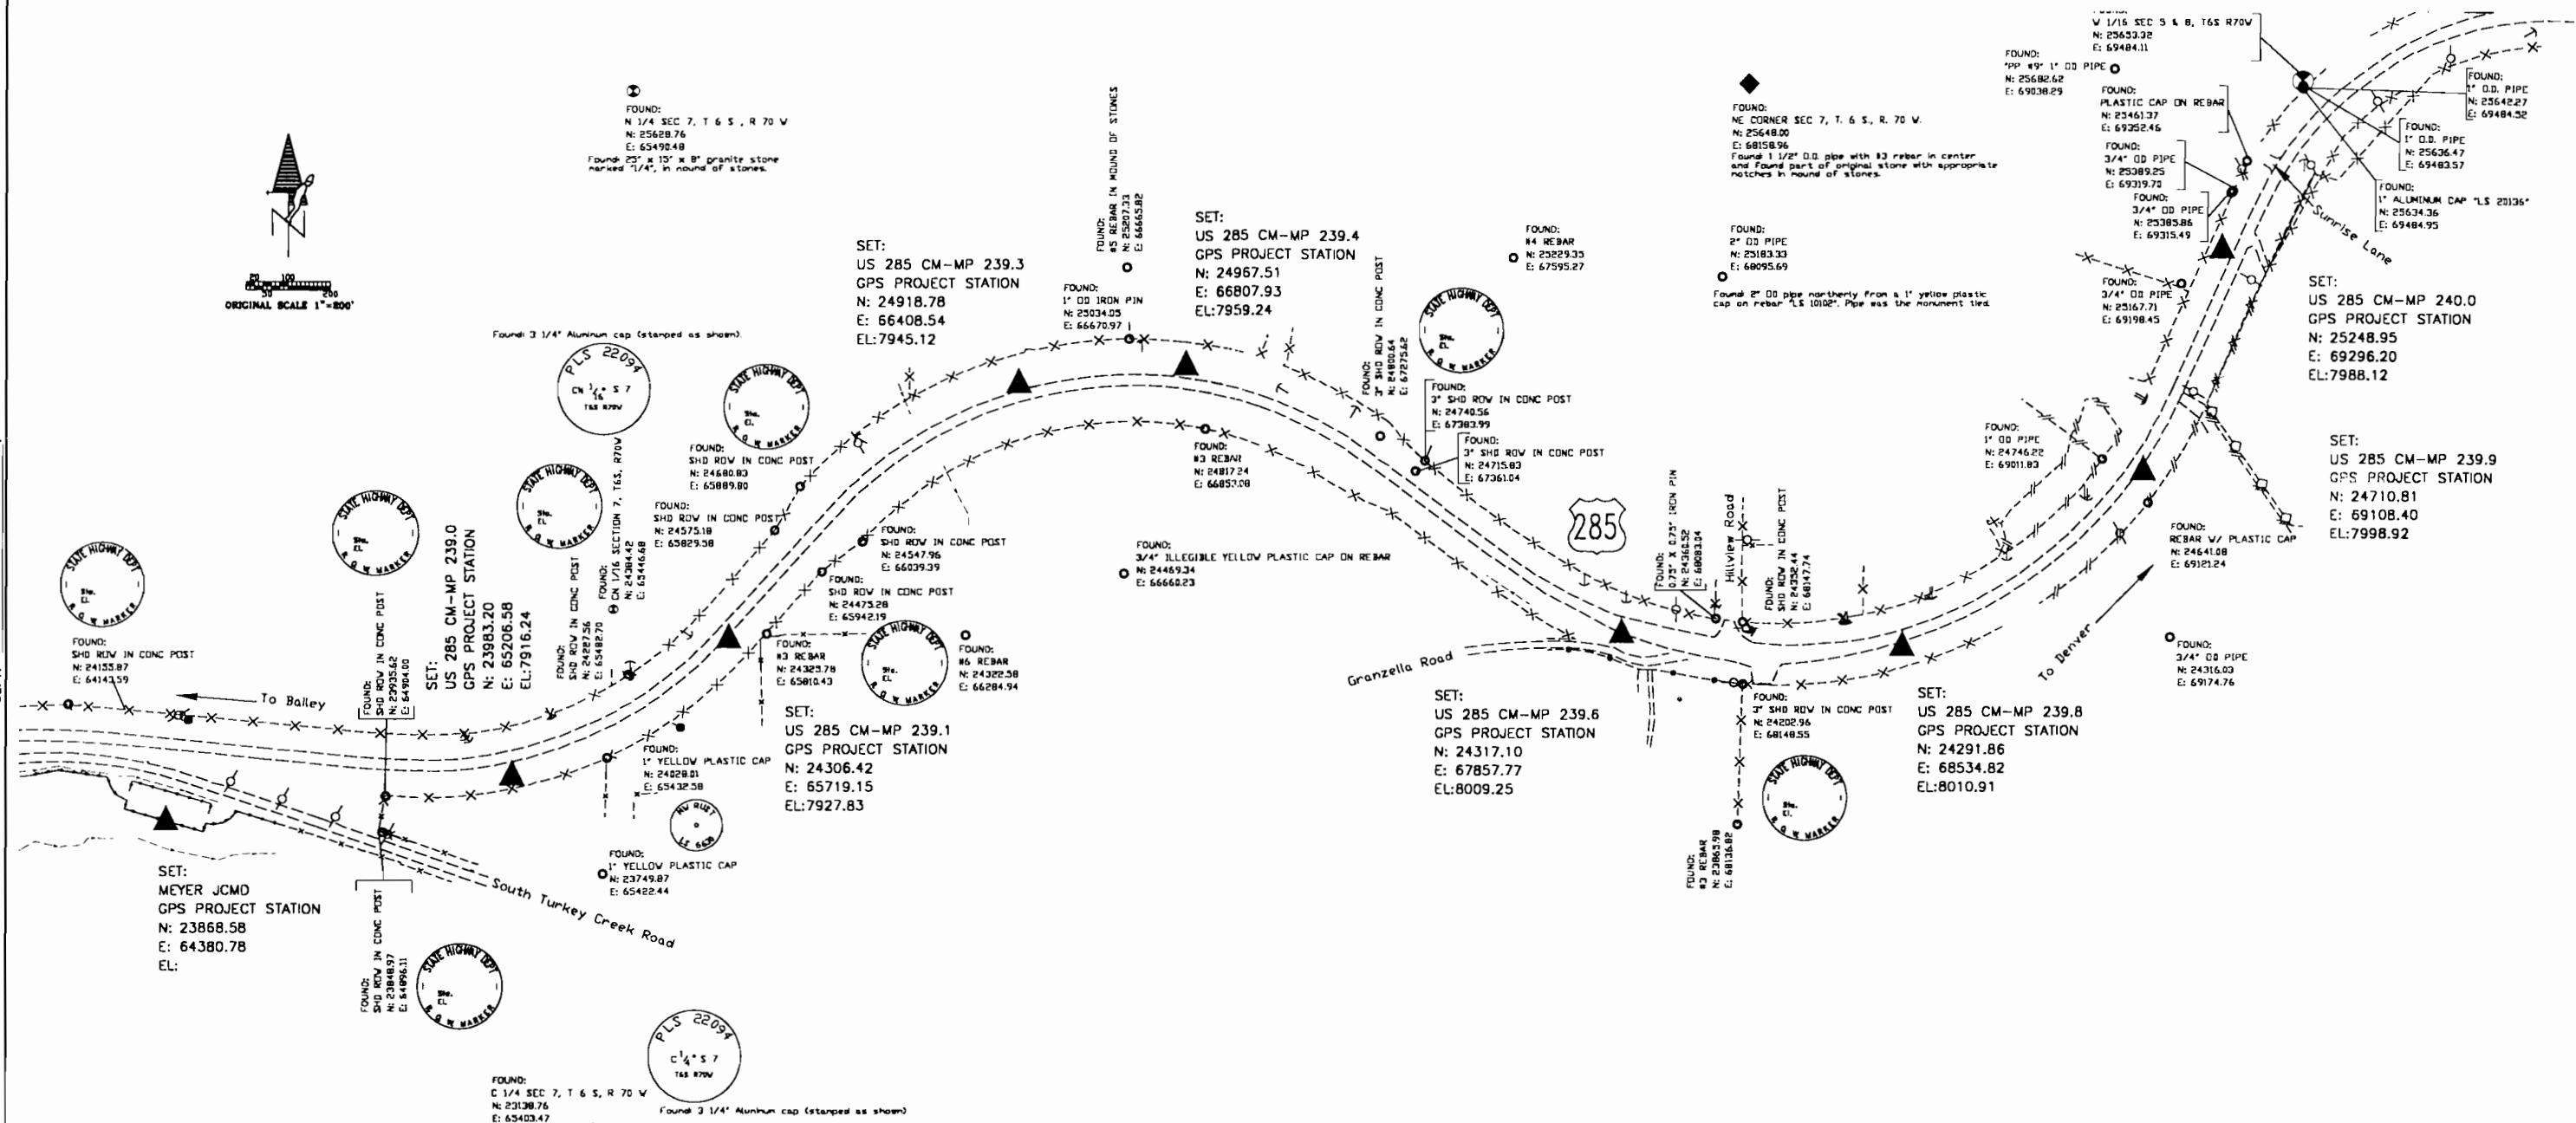

Computer File Information				Sheet Revisions			Colorado Department of Transportation Region 1 Construction 18500 E Colfax Avenue Aurora, Colorado 80011 Phone: 303-757-9744 FAX: 303-757-9746 Survey Coordinator JPC			As Constructed		SURVEY CONTROL DIAGRAM		Project CX 11-0285-28 UNIT 4 & 5	
Creation Date:	10/1/96	Initials:	LCY	1/8/99	Added Correction Diagram to title	D.A.S.				No Revisions:		U.S. 285 - FOXTON ROAD TO MARIPOSA DRN			
Last Modification Date:	1/8/99	Initials:	DAS	1/8/99	Edited coordinates for Meyer JCMD	D.A.S.				Revised:		92026			
Full Path:	C:\PROJECTS\285PH4\CSDPH4\			1/8/99	Revised CM-MP 239.2 to CM-MP 239.3 and edited coordinates	D.A.S.				Void:		Sheet Number			
Drawing File Name:	N285CSDC.DWG											Sheet Subset: Survey Subset Sheets: 9/11			
Acad Ver.	R13	Scale:	1"=200'	Units:	FEET										

C:\PROJECTS\285PH4\CSDPH4\N285CSDC.DWG 1/8/99 PLOT/EDIT by D.A.S.

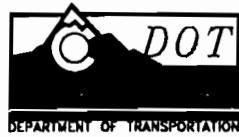


DEPARTMENT OF TRANSPORTATION - STATE OF COLORADO CONTROL SURVEY DIAGRAM

Project CX 11-0285-28 UNIT 4 & 5
U.S. 285 MP 235.0 to MP 241.29
Sections 4, 5, 7, & 8 of
T. 6 S., R. 70 W.
Sections 11, 12, 14, & 23 of
T. 6 S., R. 71 W.
JEFFERSON COUNTY, COLORADO



FILING CERTIFICATION: DAY OF 19__ AT __ M., FOR INFORMATION
DEPOSITED THIS DAY OF 19__ OF THE COUNTY LAND SURVEYS/RIGHT OF WAY
ONLY IN BOOK _____ RECEPTION NUMBER _____
SURVEYS AT PAGE _____

SIGNED _____
DEPT. _____

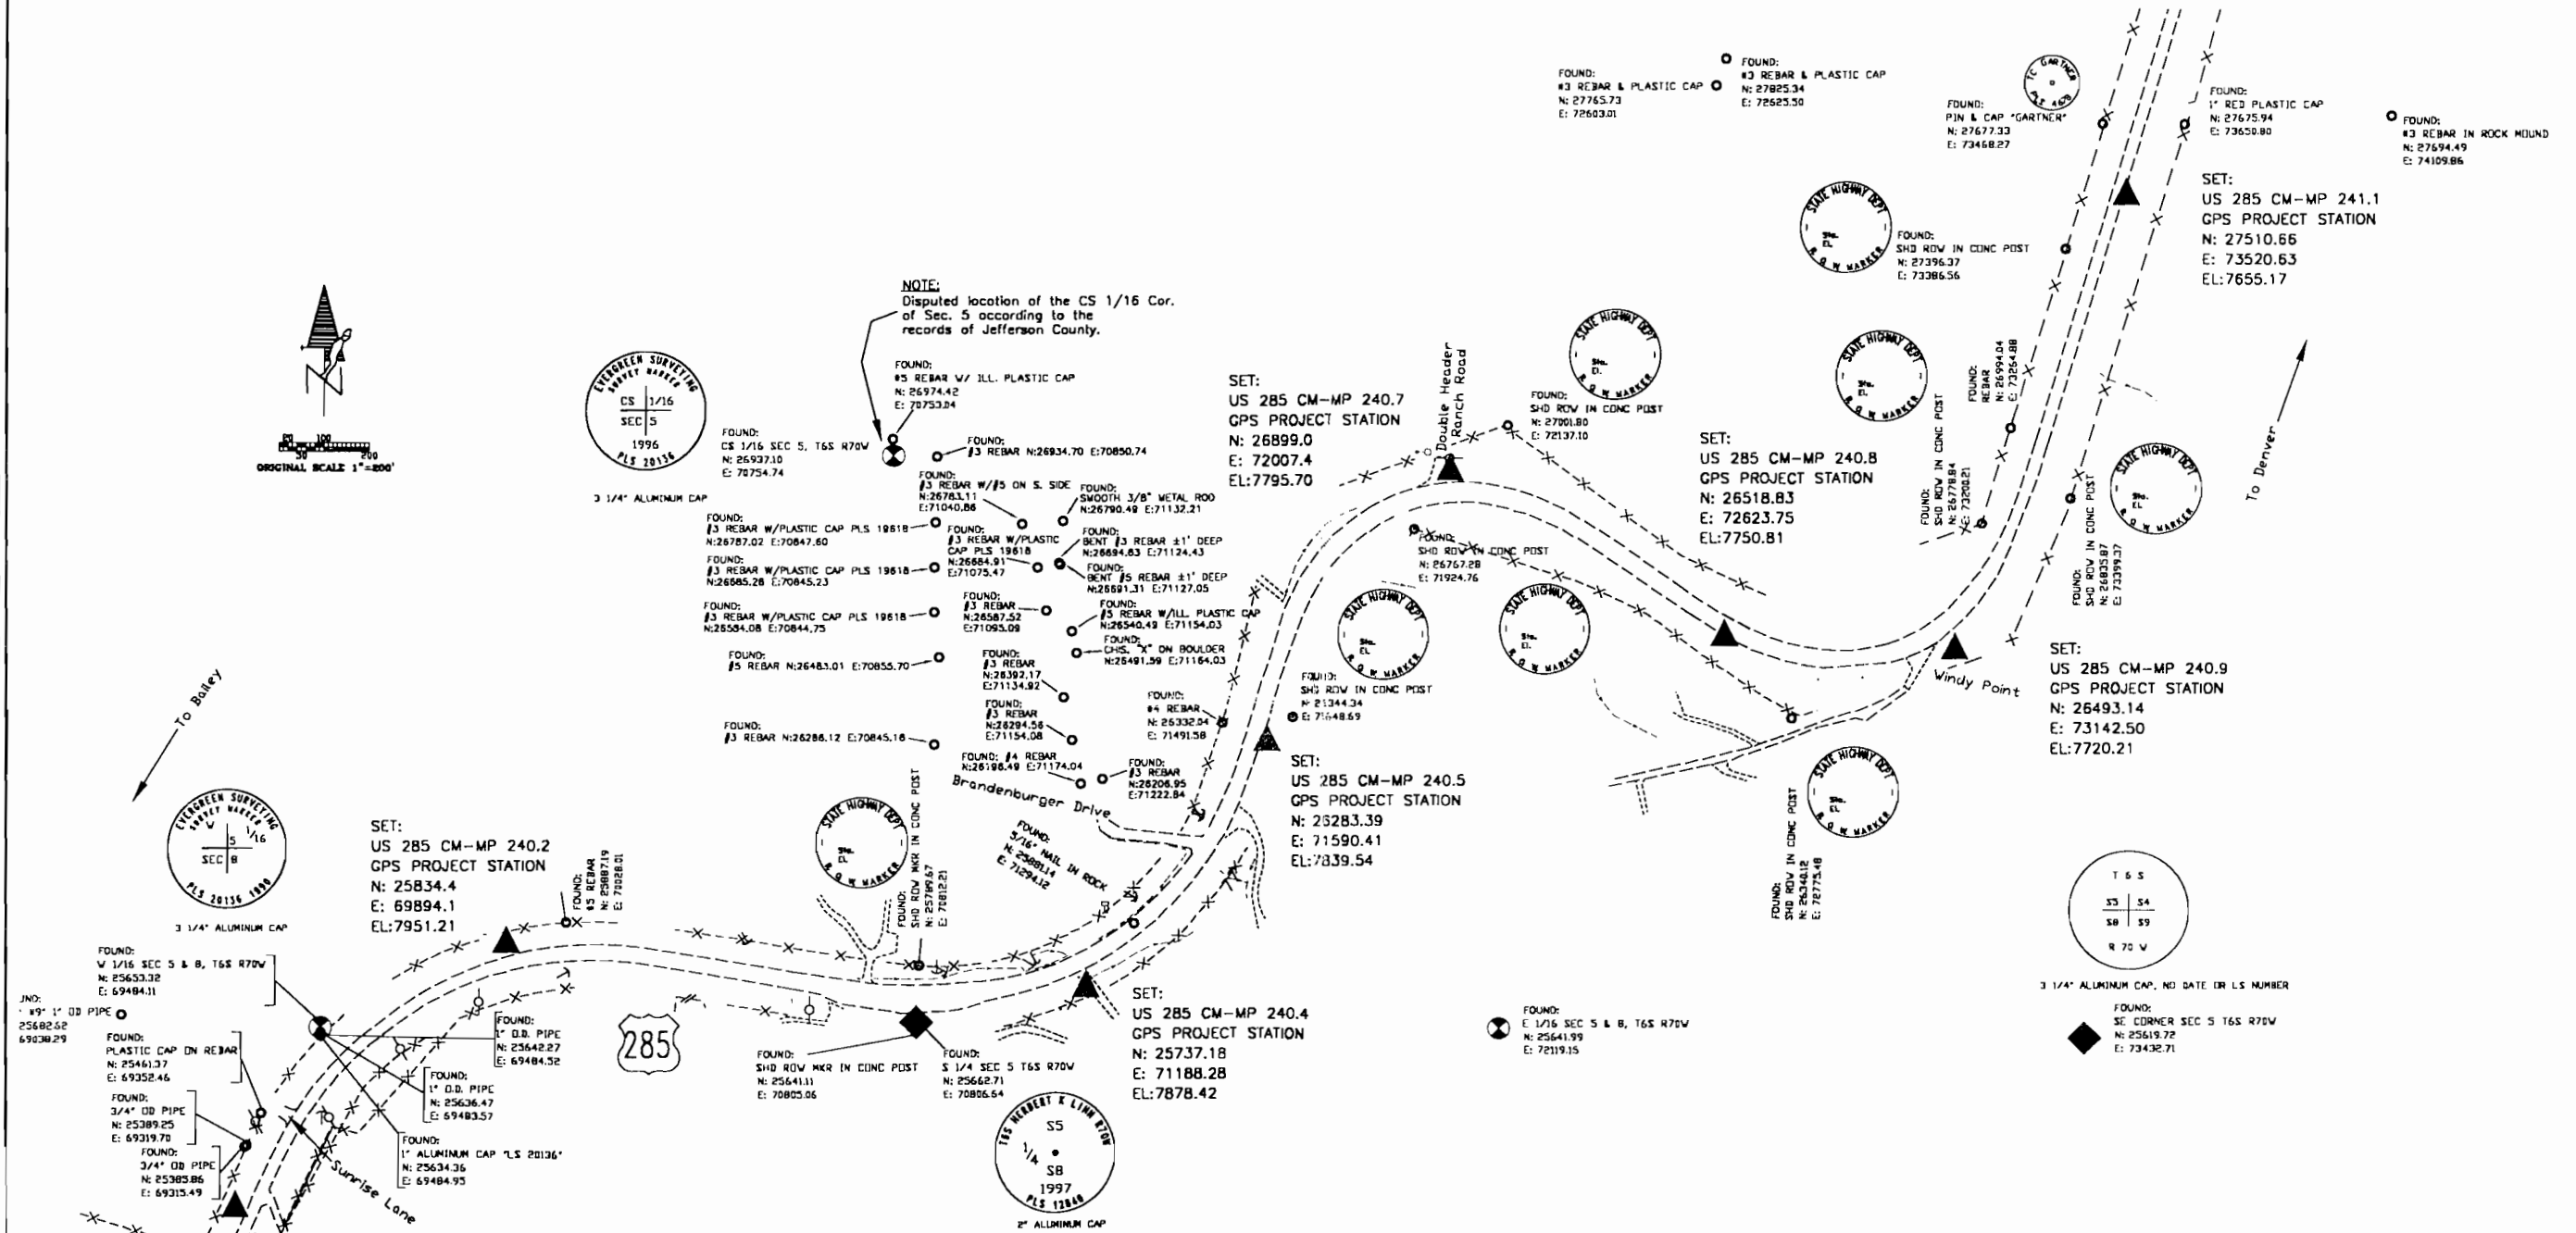

Computer File Information			Sheet Revisions			As Constructed			SURVEY CONTROL DIAGRAM	Project CX 11-0285-28 UNIT 4 & 5
Creation Date:	10/1/96	Initials: LCY	1/8/99	Added Correction Diagram to title	D.A.S.	No Revisions:				
Last Modification Date:	1/8/99	Initials: DAS	1/8/99	Added note and monumentation for CS 1/16 Sec. 5	D.A.S.	Revised:			CORRECTION DIAGRAM	92026
Full Path:	C:\PROJECTS\285PH4\CSDPH4\					Void:				
Drawing File Name:	N285CSDC.DWG								Sheet Subset: Survey Subset Sheets: 10/11	Sheet Number
Acad Ver.:	R13	Scale: 1"=200'	Units: FEET	1/8/99	Added various monuments in the area of Brandenburg Dr. for Crasley's Sub.					

C:\PROJECTS\285PH4\CSDPH4\N285CSDC.DWG 1/8/99 PLOT/EDIT by D.A.S.

Colorado Department of Transportation
Region 1 Construction
18500 E Colfax Avenue
Aurora, Colorado 80011
Phone: 303-757-9744 FAX: 303-757-9746
Survey Coordinator JPC



DEPARTMENT OF TRANSPORTATION - STATE OF COLORADO CONTROL SURVEY DIAGRAM

Project CX 11-0285-28 UNIT 4 & 5
U.S. 285 MP 235.0 to MP 241.29
Sections 4, 5, 7, & 8 of
T. 6 S., R. 70 W.
Sections 11, 12, 14, & 23 of
T. 6 S., R. 71 W.
JEFFERSON COUNTY, COLORADO



285

S. Mariposa Drive
Settlers Drive

FOUND:
STONE W/ CHISELED "X" IN MOUND OF STONES
N: 31185.23
E: 73298.25

FOUND:
STONE W/ CHISELED "CC" IN MOUND OF STONES
N: 31186.47
E: 73153.34

FOUND:
SHD ROW IN CONC POST
N: 29457.08
E: 73436.64

FOUND:
SHD ROW IN CONC POST
N: 29279.04
E: 73482.12

FOUND:
SHD ROW IN CONC POST
N: 28801.22
E: 73513.91

FOUND:
ORIGINAL STONE LOOSE IN MOUND OF STONES
N: 28803.93
E: 73393.95

FOUND:
SHD ROW IN CONC POST
N: 28801.22
E: 73513.91

FOUND:
SHD ROW IN CONC POST
N: 28801.22
E: 73513.91

SET:
US 285 CM-MP 241.29
GPS PROJECT STATION
N: 28343.25
E: 73735.91
EL: 7604.49

SET:
US 285 CM-MP 241.1
GPS PROJECT STATION
N: 27510.66
E: 73520.63
EL: 7655.17

FOUND:
#3 REBAR & PLASTIC CAP
N: 27953.74
E: 72663.01

FOUND:
#3 REBAR & PLASTIC CAP
N: 27953.74
E: 72663.01

FILING CERTIFICATION: DEPOSITED THIS DAY OF 19 AT M., FOR INFORMATION ONLY IN BOOK OF THE COUNTY LAND SURVEYS/RIGHT OF WAY SURVEYS AT PAGE RECEPTION NUMBER SIGNED DEPT.

Computer File Information				Sheet Revisions			Colorado Department of Transportation		As Constructed		SURVEY CONTROL DIAGRAM		Project CX 11-0285-28 UNIT 4 & 5	
Creation Date:	10/1/96	Initials:	LCY	1/8/99	Added Correction Diagram to title		D.A.S.	 Region 1 Construction 18500 E Colfax Avenue Aurora, Colorado 80011 Phone: 303-757-9744 FAX: 303-757-9746 Survey Coordinator JPC	No Revisions:		CORRECTION DIAGRAM		U.S. 285 - FOXTON ROAD TO MARIPOSA DRIVE	
Last Modification Date:	1/8/99	Initials:	DAS				Revised:			92026				
Full Path:	C:\PROJECTS\285PH4\CSDPH4\								Void:		Sheet Subset: Survey Subset Sheets: 11/11		Sheet Number	
Drawing File Name:	N285CSDC.DWG													
Acad Ver.	R13	Scale:	1"=200'	Units:	FEET									
C:\PROJECTS\285PH4\CSDPH4\N285CSDC.DWG 1/8/99 PLOT/EDIT by D.A.S.														

C:\PROJECTS\285PH4\CSDPH4\N285CSDC.DWG 1/8/99 PLOT/EDIT by D.A.S.

Colorado Department of Transportation
Region 1 Construction
18500 E. Colfax Avenue
Aurora, Colorado 80011
Phone: 303-757-9744 FAX: 303-757-9746
Survey Coordinator JPC