

10996

FHWA OVERSIGHT? NO ☐ YES ☐ NOT APPLICABLE ☒

COLORADO DEPARTMENT OF TRANSPORTATION

FED. ROAD REGION	DIVISION	PROJ. NO.	SHEET NO.
VIII	COLO.	C 1601-037	1

FINAL OFFICE REVIEW

DATE: FEBRUARY 25, 1996

SUBJECT TO CHANGE

PLAN AND PROFILE OF PROPOSED COLORADO PROJECT NO. C 1601-037 STATE HIGHWAY NO. 160 & 550 LA PLATA COUNTY CONSTRUCTION SUBACCOUNT NO. 10996

V-File

AS CONSTRUCTED		
NO REVISIONS	REVISED	VOID

REVISIONS		


INDEX OF SHEETS

SHEET NO.	TITLE SHEET
1	STANDARD PLANS LIST
2	SURVEY TABULATION SHEET
3	TYPICAL SECTIONS AND TYPICAL SECTION NOTES
4-8	GENERAL NOTES
9	SUMMARY OF APPROXIMATE QUANTITIES
10,11,12	STRUCTURE QUANTITIES
13-15	SUMMARY OF EARTHWORK QUANTITIES
16	TABULATION OF SURFACING
17	TABULATION OF CURB AND GUTTER, RESET MAILBOX, GUARDRAIL AND LIGHTING
18	TABULATION OF DELINEATORS
19	DETAIL OF THE INTERSECTION OF U.S. 160 AND U.S. 550
20	INLET SPECIAL AND TYPE R DETAILS
21	DETAILS OF CURB TYPE 2, PATTERNED CONCRETE MEDIAN, LEFT TURN LANE MEDIAN, AND SIGN POST SLEEVE
22	DETAIL OF SLOTTED RAIL TERMINAL
23	STORMWATER MANAGEMENT PLAN
24-25	GEOWED SLOPE PROTECTION SYSTEMS
26-28	U.S. 160 PLAN AND PROFILE SHEETS
29-40	U.S. 550 PLAN AND PROFILE SHEETS
41-42	DESIGN AID FOR ROAD APPROACHES
43	ROAD APPROACHES PLAN AND PROFILE SHEETS
44-50	TRAFFIC VOLUME U.S. 160 AND U.S. 550
51	LIGHTING PLAN
52-54	UTILITY PLANS
55-60	PROFILE OF IRRIGATION PIPE - U.S. 160
61	DETAILS OF C.B.C. STA. 206+18.06
62-69	DETAILS OF RETAINING WALLS STA. 215+75 TO 217+55
70-75	TABULATION OF TRAFFIC ENGINEERING QUANTITIES AND SCHEDULE OF CONSTRUCTION TRAFFIC CONTROL DEVICES
76	TRAFFIC CONTROL PLAN
77-82	SIGNING AND STRIPING PLAN
83-86	TABULATION OF SIGNS
87-89	TRAFFIC SIGNAL PLAN JCT. U.S. 160 AND U.S. 550
90	

LENGTH AND DESIGN DATA

STATION		ROADWAY
		LINEAR FEET
STA. 168+00	Begin C 1602-037 5.79 Ft. Offset Left of Sta. 167+86.46 on Project FC 160-2(26) = M.P. 87.572	7,800
STA. 242+00	End C 1602-037 = 1.23 Ft. Offset Right of Sta. 96+69.73 on Project F 022-2(5) = M.P. 88.973	
TOTAL		7,800
SUMMARY		
		LIN. FT. MILES
PROJECT NET AND GROSS LENGTH		7,800 1.477
DESIGN DATA		
MAXIMUM DEGREE OF CURVE 5'00'00"		
MAXIMUM GRADE 4.50%		
MINIMUM S.S.D. HORIZONTAL 490'		
MINIMUM S.S.D. VERTICAL 600'		
MAXIMUM DESIGN SPEED 55 MPH		
1995 TRAFFIC VOLUME		
ADT 18,250		
% TRUCKS 19		
2000 DESIGN TRAFFIC DATA		
ADT 21,900		
DNV 2,767		

SCALES OF ORIGINAL DRAWINGS
ON PLAN 1 IN. = 100 FT.
ON PROFILE 1 IN. = 100 FT. HORIZONTAL
1 IN. = 10 FT. VERTICAL
GRADE LINE ON PROFILE IS SHOWN AS GRADE OF EXISTING ROAD

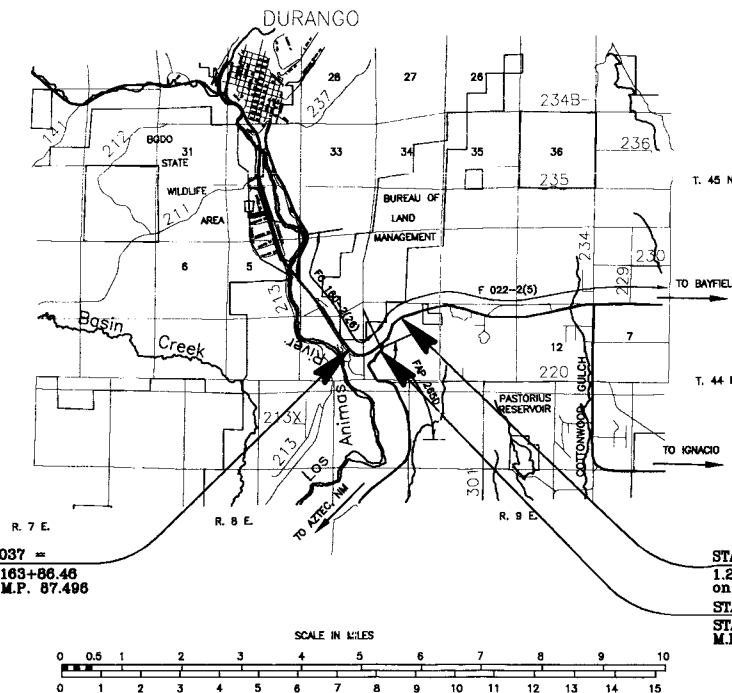

* Clear Zone: (55 MPH) 22'
(40 MPH or less) 14'

STA. 164+00 BEGIN C 1601-037 =
5.79 Ft. Offset Left of STA. 163+86.46
on Project FC 160-2(26) = M.P. 87.496

STA. 242+00 END C 1601-037 =
1.23 Ft. Offset Right of STA. 96+69.73
on Project F 022-2(5) = M.P. 88.973
STA. 65+00 END C 1601-037 =
STA. 65+78.74 on Project FAP 285D =
M.P. 16.466

* Varies (See Roadway Cross Sections)



AS CONSTRUCTED INFORMATION

CONTRACTOR	
ENGINEER	
(Project or Resident)	
PROJECT STARTED	
PROJECT COMPLETED	
AS CONSTRUCTED PLANS	
APPROVED	
TITLE	DATE

B.S./REGION 5

U.S. HIGHWAY 160 PLAN VIEW

AS CONSTRUCTED			FED. ROAD REGION	DIVISION	PROJ. NO.	SHEET NO.
NO REVISIONS	REVISED	VOID	XIII	COL.	C 1601-037	31

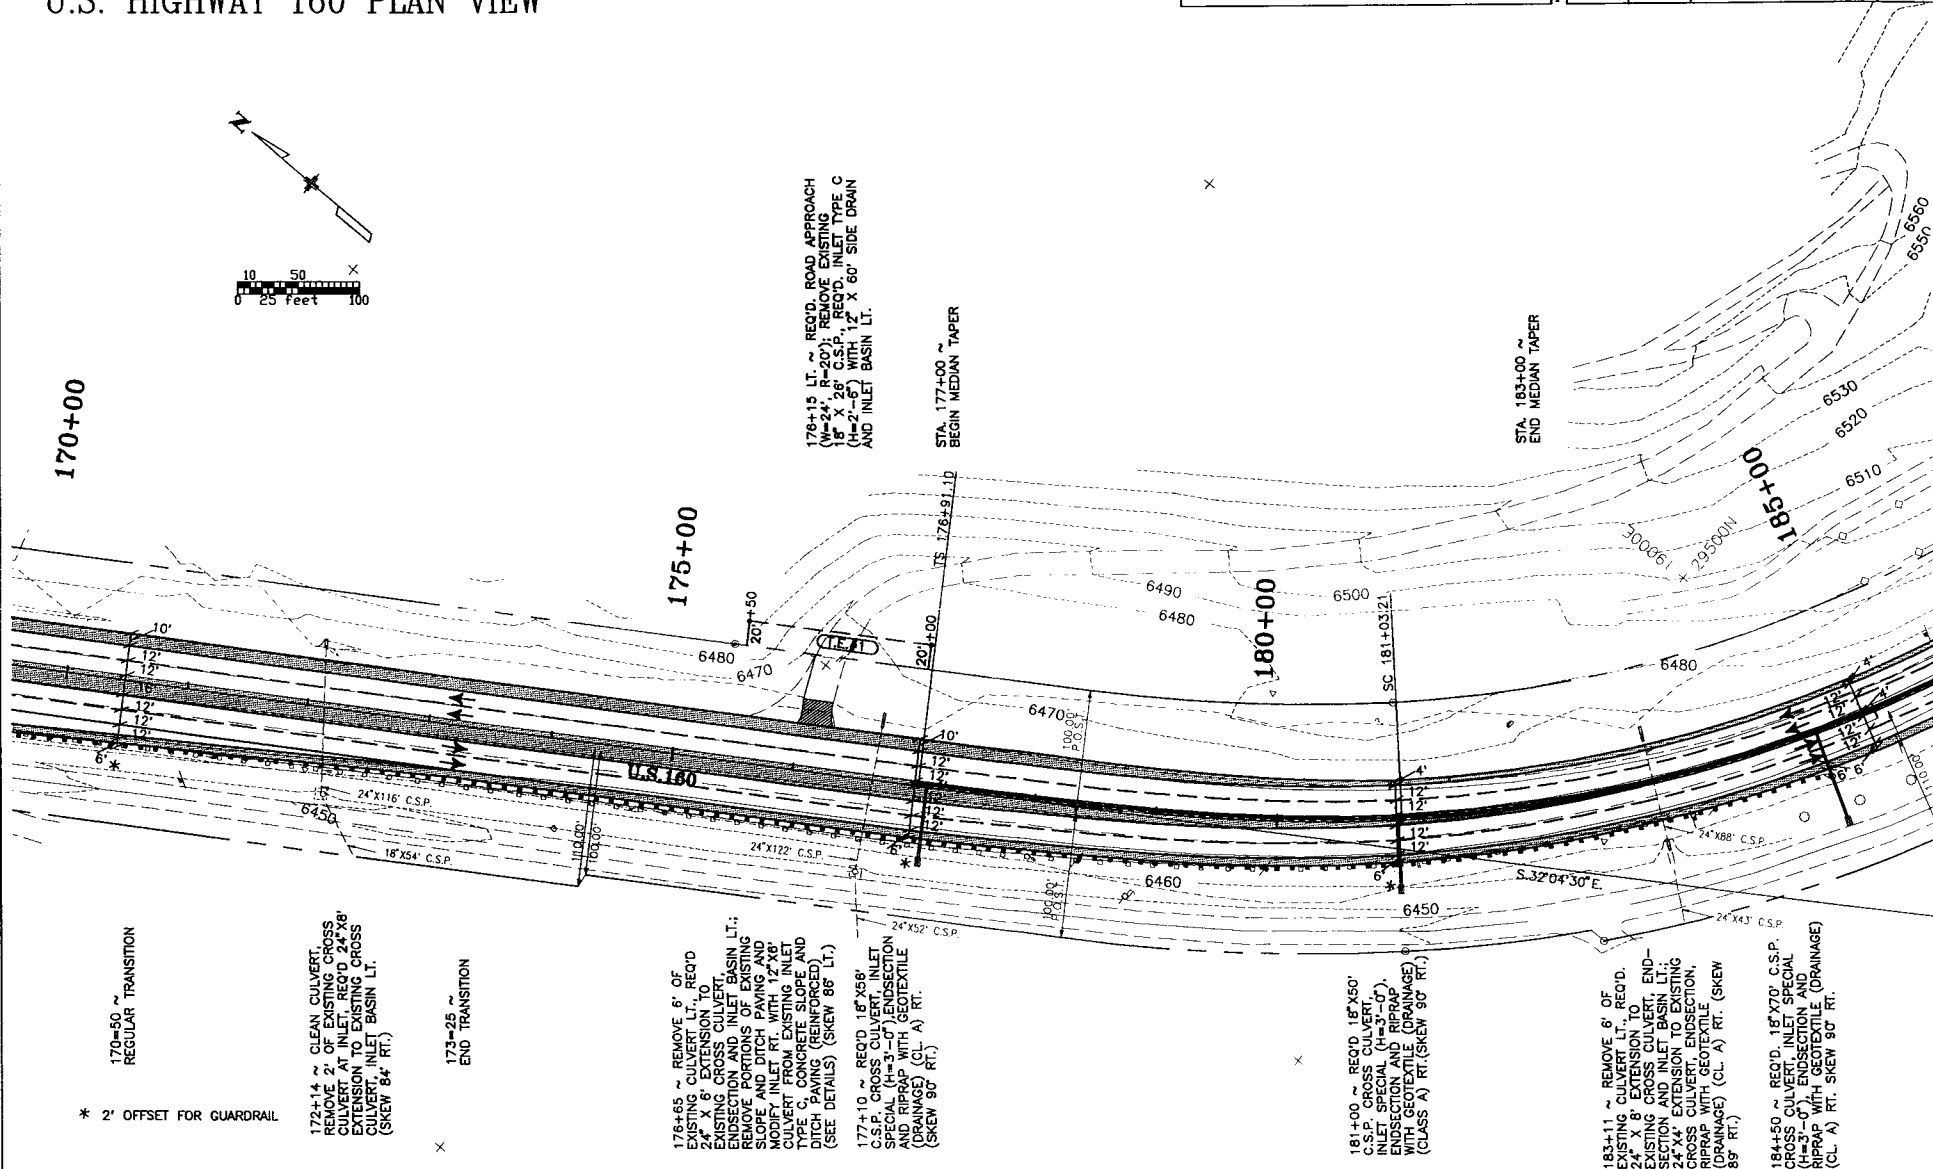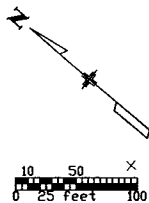

* 2' OFFSET FOR GUARDRAIL

T.E. #1 - B. GARLICK

172+14 ~ CLEAN CULVERT.
REMOVE 2' OF EXISTING CROSS
CULVERT AT INLET. REQ'D 24'X8'
EXTENSION TO EXISTING CROSS
CULVERT. INLET BASIN LT.
(SKEW 84° RT.)

173+25 ~
END TRANSITION

176+65 ~ REMOVE 6' OF
EXISTING CULVERT LT., REQ'D
24'X8' EXTENSION TO
EXISTING CROSS CULVERT.
ENDSECTION AND INLET BASIN LT.:
REMOVE PORTIONS OF EXISTING
SLOPE AND DITCH PAVING AND
MODIFY INLET RT. WITH 12'X8'
CULVERT FROM EXISTING INLET
DITCH. SLOPE REINFORCED AND
DITCH SLOVES REINFORCED
(SEE DETAILS) (SKEW 86° LT.)

177+10 ~ REQ'D 18'X58'
C.S.P. CROSS CULVERT. INLET
SPECIAL (H=3'-0"). ENDSECTION
AND RIPRAP WITH GEOTEXTILE
(DRAINAGE) (CL A) RT.
(SKEW 90° RT.)



181+00 ~ REQ'D 18'X50'
C.S.P. CROSS CULVERT.
INLET SPECIAL (H=3'-0").
ENDSECTION AND RIPRAP WITH
GEOTEXTILE (DRAINAGE) (CL
A) RT. (SKEW 90° RT.)

183+11 ~ REMOVE 6' OF
EXISTING CULVERT LT., REQ'D.
24' X 8' EXTENSION TO
EXISTING CROSS CULVERT. END-
SECTION AND INLET BASIN LT.:
24'X4' EXTENSION TO EXISTING
CROSS CULVERT. ENDSECTION.
RIPRAP WITH GEOTEXTILE
(DRAINAGE) (CL A) RT. (SKEW
89° RT.)

184+50 ~ REQ'D 18'X70' C.S.P.
CROSS CULVERT. INLET SPECIAL
(H=3'-0"). ENDSECTION AND
RIPRAP WITH GEOTEXTILE (DRAINAGE)
(CL A) RT. SKEW 90° RT.

U.S. HIGHWAY 160 PLAN VIEW

AS CONSTRUCTED			FED. ROAD REGION	DIVISION	PROJ. NO.	SHEET NO.
NO REVISIONS	REVISED	VOID	VIII	COLO.	C 1601-037	33

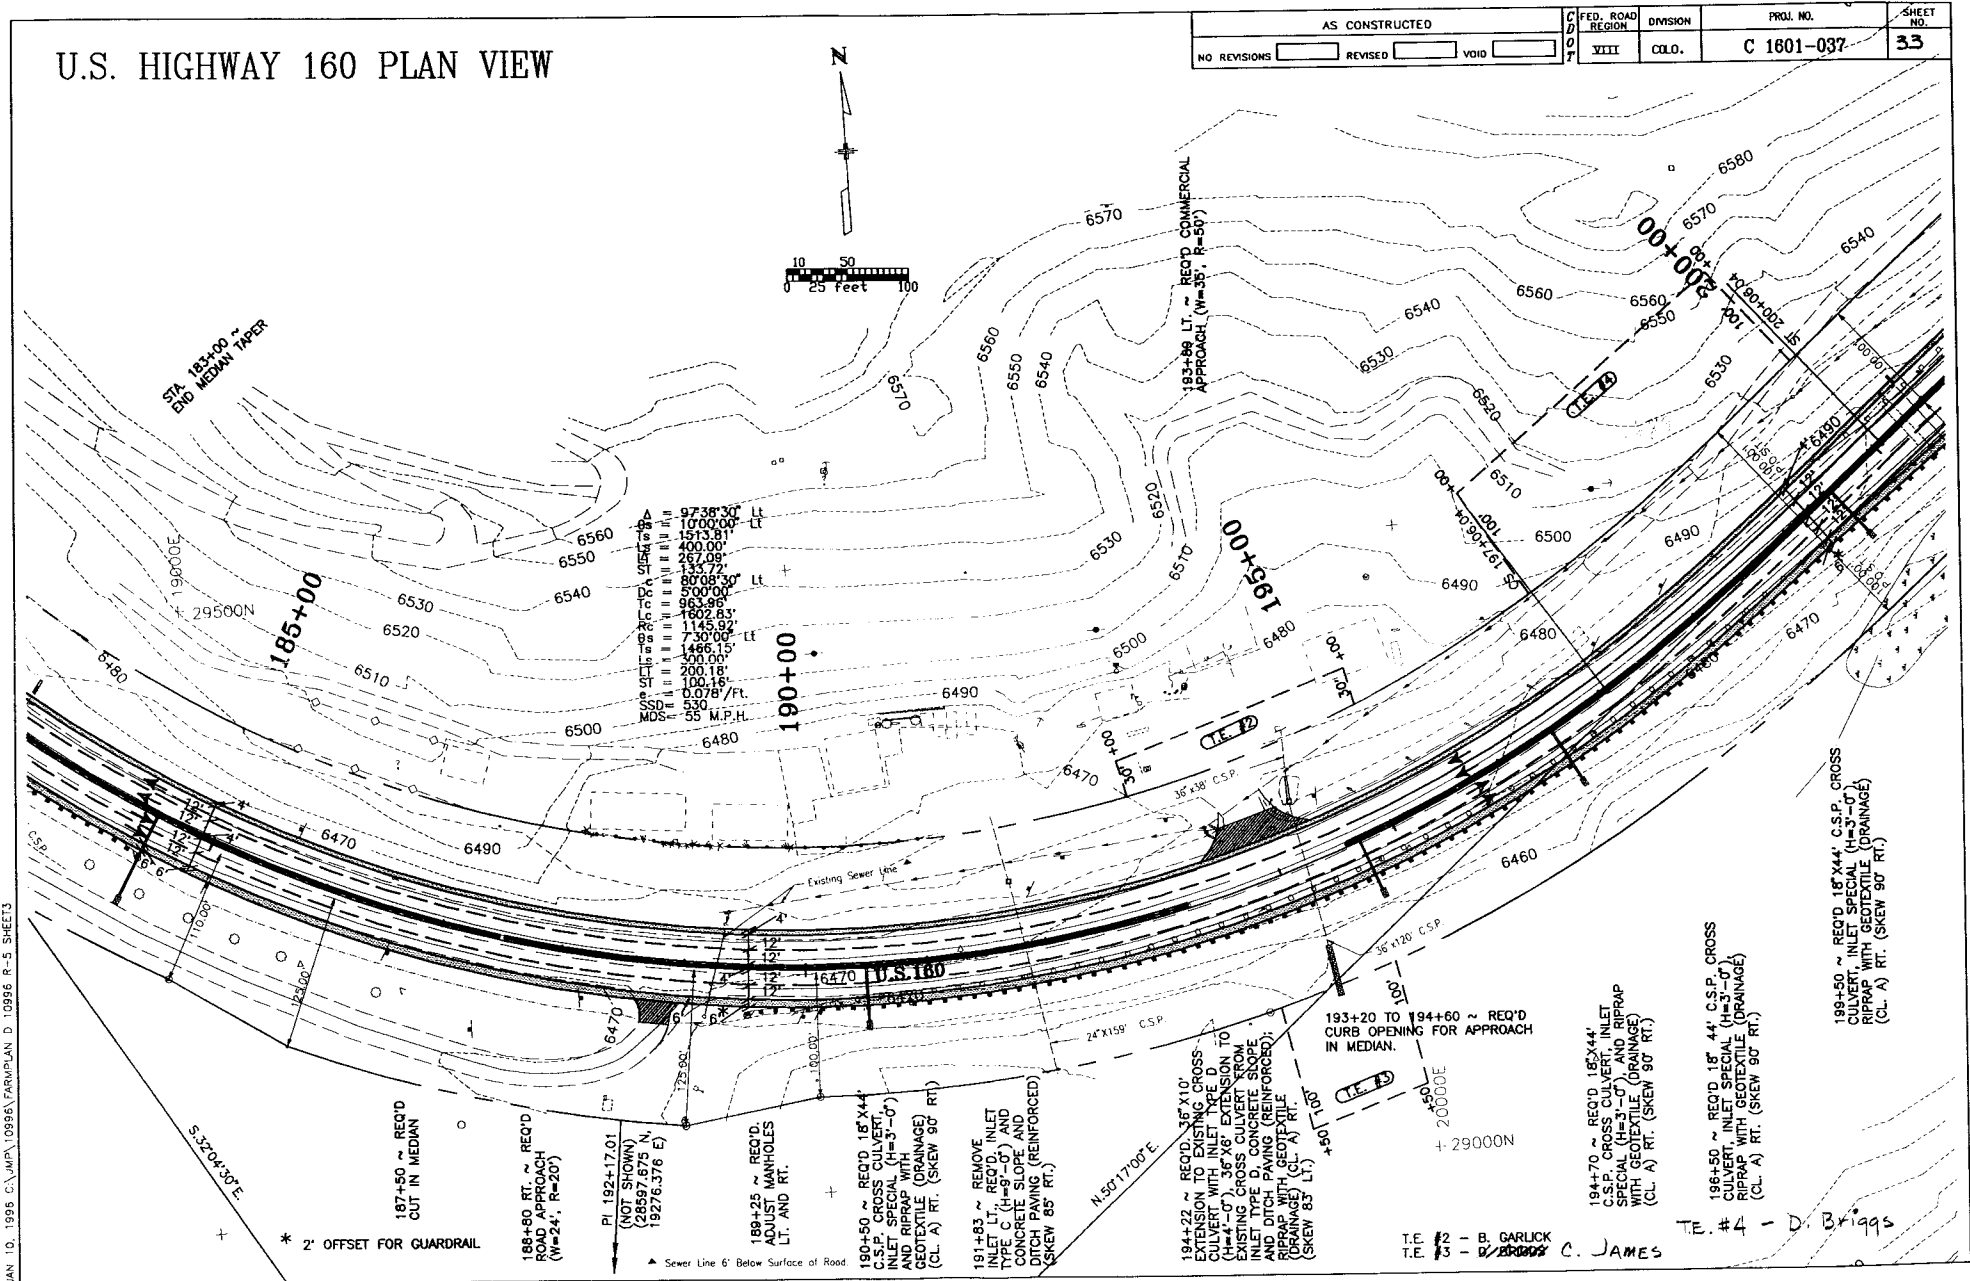
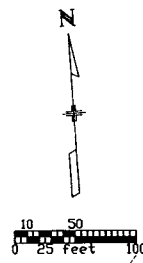


JAN 10, 1995 C:\MP\10996\FARMPAN D 10996 R-5 SHEET3

T.E. #2 - B. GARLICK
T.E. #3 - D. BRIGGS
C. JAMES

T.E. #4 - D. Briggs

U.S. HIGHWAY 160 PLAN VIEW

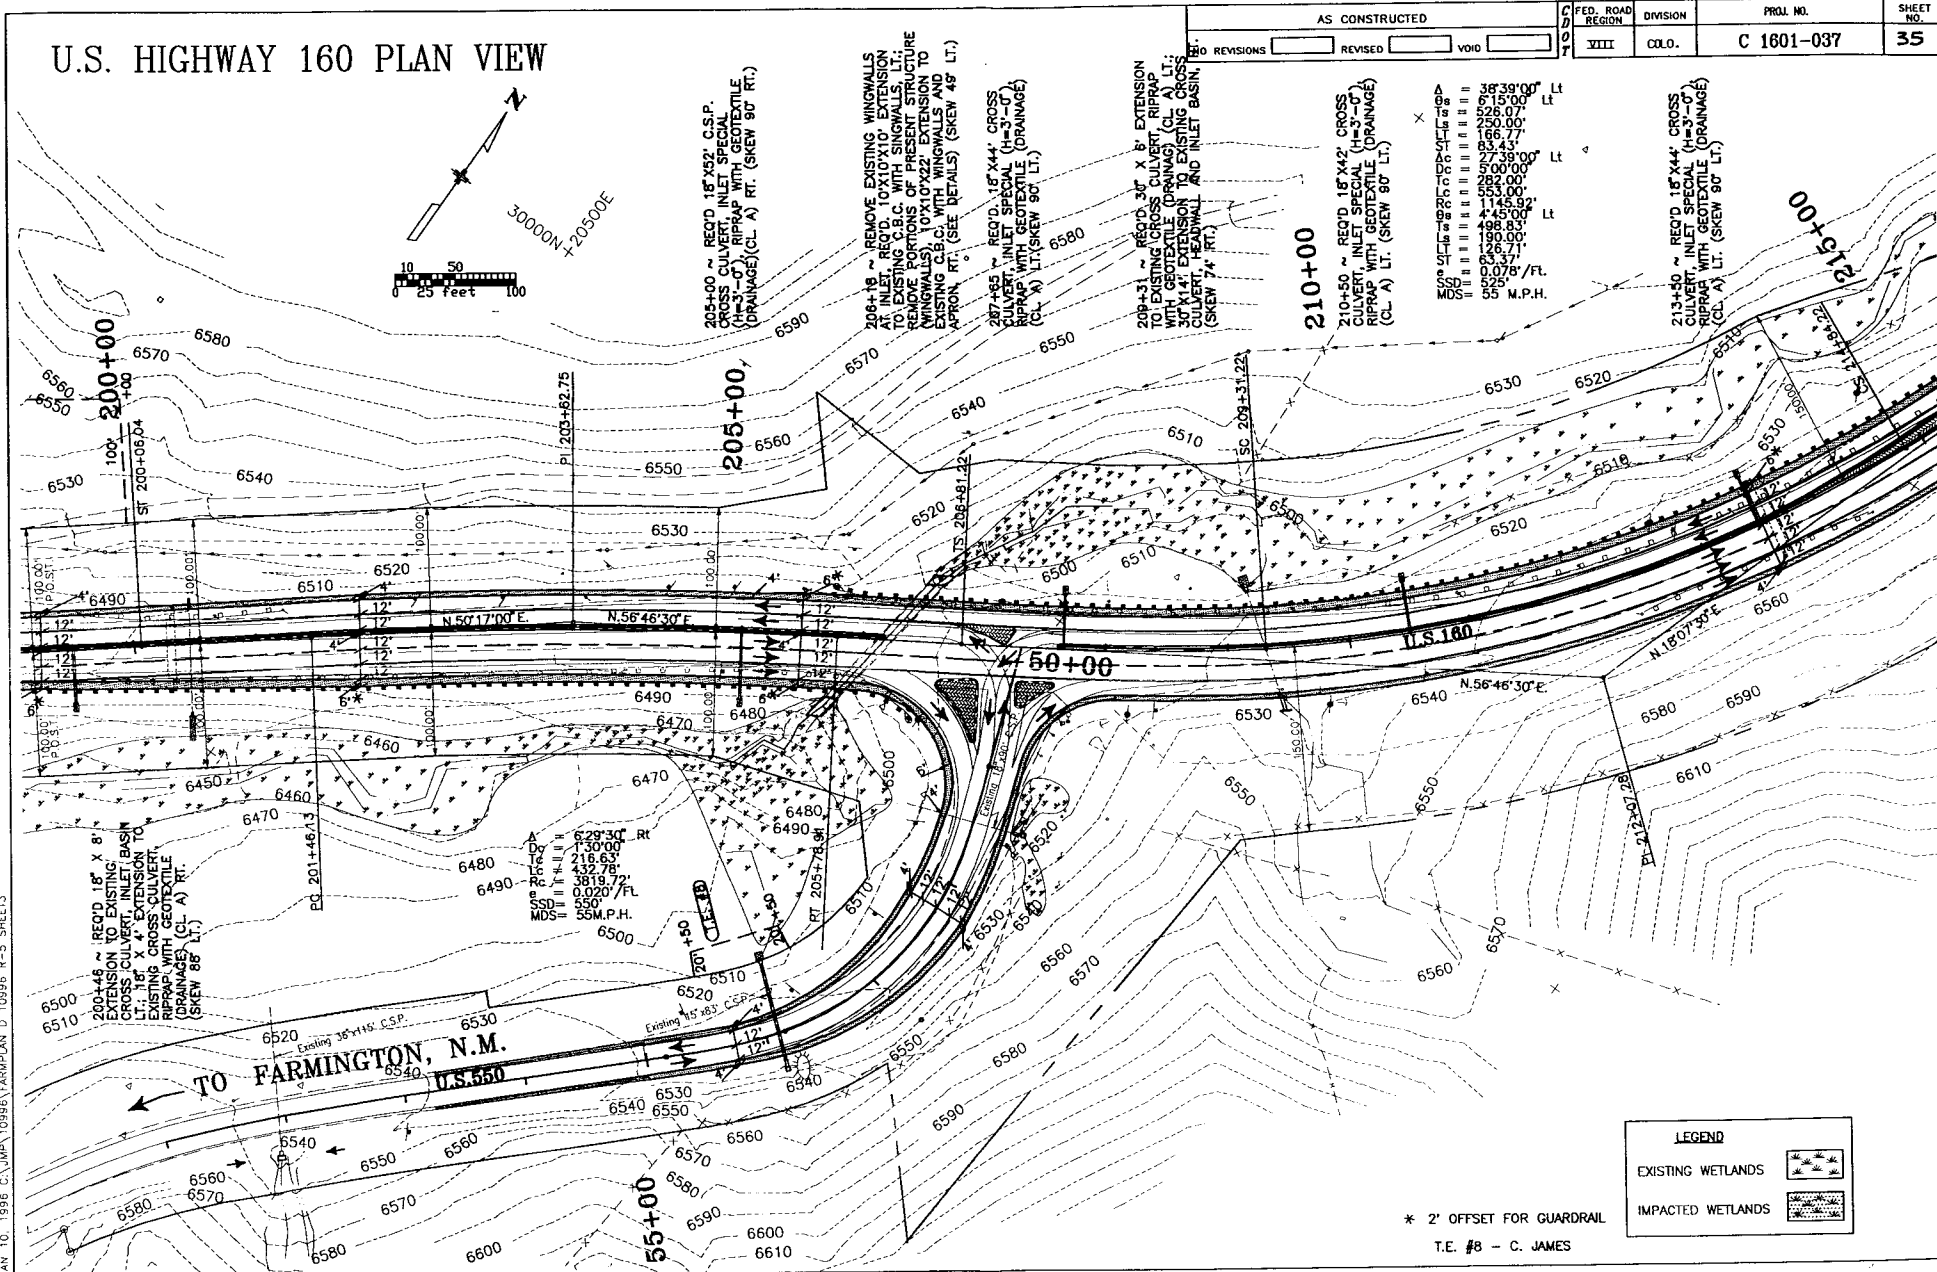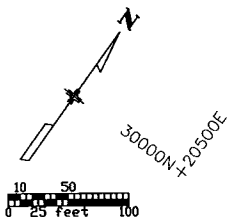

AS CONSTRUCTED		FED. ROAD REGION	DIVISION	PROJ. NO.	SHEET NO.
NO REVISIONS	REVISED	VOID	VIII	C 1601-037	35

200+46 ~ REQ'D 18' X 8' CROSS CULVERT, INLET SPECIAL (H=3'-0") RIPRAP WITH GEOTEXTILE (DRAINAGE) (CL A) RT. (SKEW 86° LT.)	200+46 ~ REQ'D 18' X 8' CROSS CULVERT, INLET SPECIAL (H=3'-0") RIPRAP WITH GEOTEXTILE (DRAINAGE) (CL A) RT. (SKEW 86° LT.)	200+46 ~ REQ'D 18' X 8' CROSS CULVERT, INLET SPECIAL (H=3'-0") RIPRAP WITH GEOTEXTILE (DRAINAGE) (CL A) RT. (SKEW 86° LT.)	200+46 ~ REQ'D 18' X 8' CROSS CULVERT, INLET SPECIAL (H=3'-0") RIPRAP WITH GEOTEXTILE (DRAINAGE) (CL A) RT. (SKEW 86° LT.)	200+46 ~ REQ'D 18' X 8' CROSS CULVERT, INLET SPECIAL (H=3'-0") RIPRAP WITH GEOTEXTILE (DRAINAGE) (CL A) RT. (SKEW 86° LT.)	200+46 ~ REQ'D 18' X 8' CROSS CULVERT, INLET SPECIAL (H=3'-0") RIPRAP WITH GEOTEXTILE (DRAINAGE) (CL A) RT. (SKEW 86° LT.)
200+46 ~ REQ'D 18' X 8' CROSS CULVERT, INLET SPECIAL (H=3'-0") RIPRAP WITH GEOTEXTILE (DRAINAGE) (CL A) RT. (SKEW 86° LT.)	200+46 ~ REQ'D 18' X 8' CROSS CULVERT, INLET SPECIAL (H=3'-0") RIPRAP WITH GEOTEXTILE (DRAINAGE) (CL A) RT. (SKEW 86° LT.)	200+46 ~ REQ'D 18' X 8' CROSS CULVERT, INLET SPECIAL (H=3'-0") RIPRAP WITH GEOTEXTILE (DRAINAGE) (CL A) RT. (SKEW 86° LT.)	200+46 ~ REQ'D 18' X 8' CROSS CULVERT, INLET SPECIAL (H=3'-0") RIPRAP WITH GEOTEXTILE (DRAINAGE) (CL A) RT. (SKEW 86° LT.)	200+46 ~ REQ'D 18' X 8' CROSS CULVERT, INLET SPECIAL (H=3'-0") RIPRAP WITH GEOTEXTILE (DRAINAGE) (CL A) RT. (SKEW 86° LT.)	200+46 ~ REQ'D 18' X 8' CROSS CULVERT, INLET SPECIAL (H=3'-0") RIPRAP WITH GEOTEXTILE (DRAINAGE) (CL A) RT. (SKEW 86° LT.)

LEGEND

EXISTING WETLANDS


IMPACTED WETLANDS

* 2' OFFSET FOR GUARDRAIL
T.E. #B - C. JAMES

U.S. HIGHWAY 160 PLAN VIEW

218+00 TO 217+50
REQUIRED RETAINING WALL
(SEE DETAILS)

216+75 ~ REQ'D
IMPACT ATTENUATOR
(SEE DETAILS)

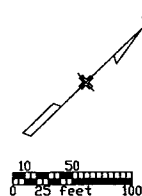


221+78 ~ BEGIN 10' SHOULDER

224+78 ~ END
MEDIAN TAPER

AS CONSTRUCTED		
NO REVISIONS	REVISED	VOID

FED. ROAD REGION	DIVISION	PROJ. NO.	SHEET NO.
VIII	COLD.	C 1601-037	37

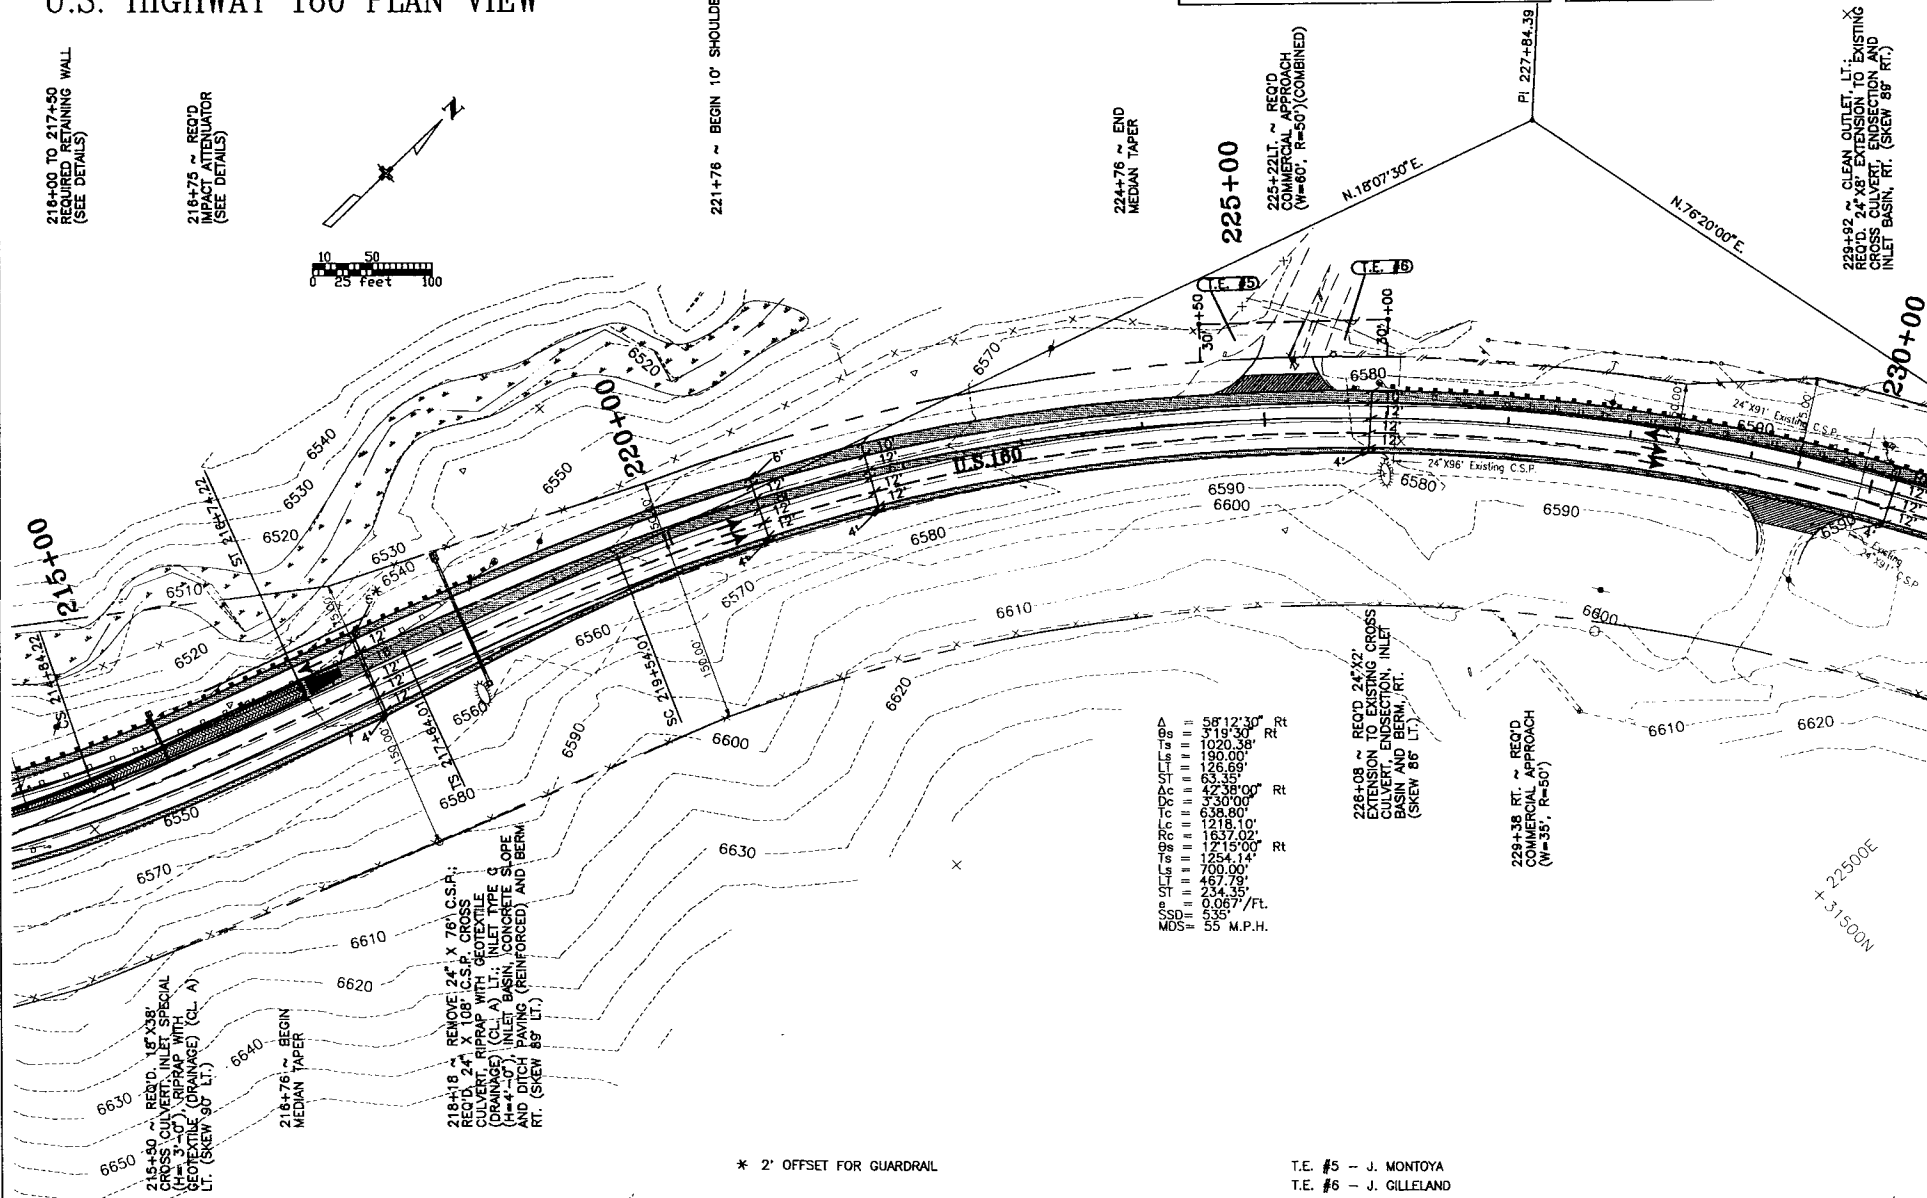

Δ	58.12	30'	Rt
Δ	58.19	30'	Rt
Δ	102.00	30'	Rt
Δ	190.00	30'	Rt
Δ	126.69		
Δ	53.39		
Δ	53.39	00'	Rt
Δ	330.00		
Δ	638.80		
Δ	1218.10'		
Δ	1637.02'		
Δ	1715.00'		
Δ	254.14'		
Δ	700.00'		
Δ	467.79'		
Δ	234.35'		
Δ	0.067	/FT.	
SSD	535'		
MDS	55	M.P.H.	

* 2' OFFSET FOR GUARDRAIL

T.E. #5 - J. MONTOYA
T.E. #6 - J. GILLELAND

 
229+82 ~ CLEAN OUTLET. LT. EXTENSION TO EXISTING CROSS CULVERT. ENDSECTION AND INLET BASIN, RT. (SKEW 88° RT.)

226+08 ~ REQ'D 24'x2' EXTENSION TO EXISTING CROSS CULVERT. ENDSECTION, INLET BASIN AND BERM, RT. (SKEW 86° LT.)

229+38 RT. ~ REQ'D COMMERCIAL APPROACH (W=35', R=50')


22500E
+ 31500W

JAN 10, 1996 C:\JMP\10996\FARMP\PLAN D 10996 R-5 SHEET3

JAN 10, 1996 C:\JMP\10996\FARMP\PLAN D 10996 R-5 SHEET3

JAN 10, 1996 C:\JMP\10996\FARMP\PLAN D 10996 R-5 SHEET3

JAN 10, 1996 C:\JMP\10996\FARMP\PLAN D 10996 R-5 SHEET3

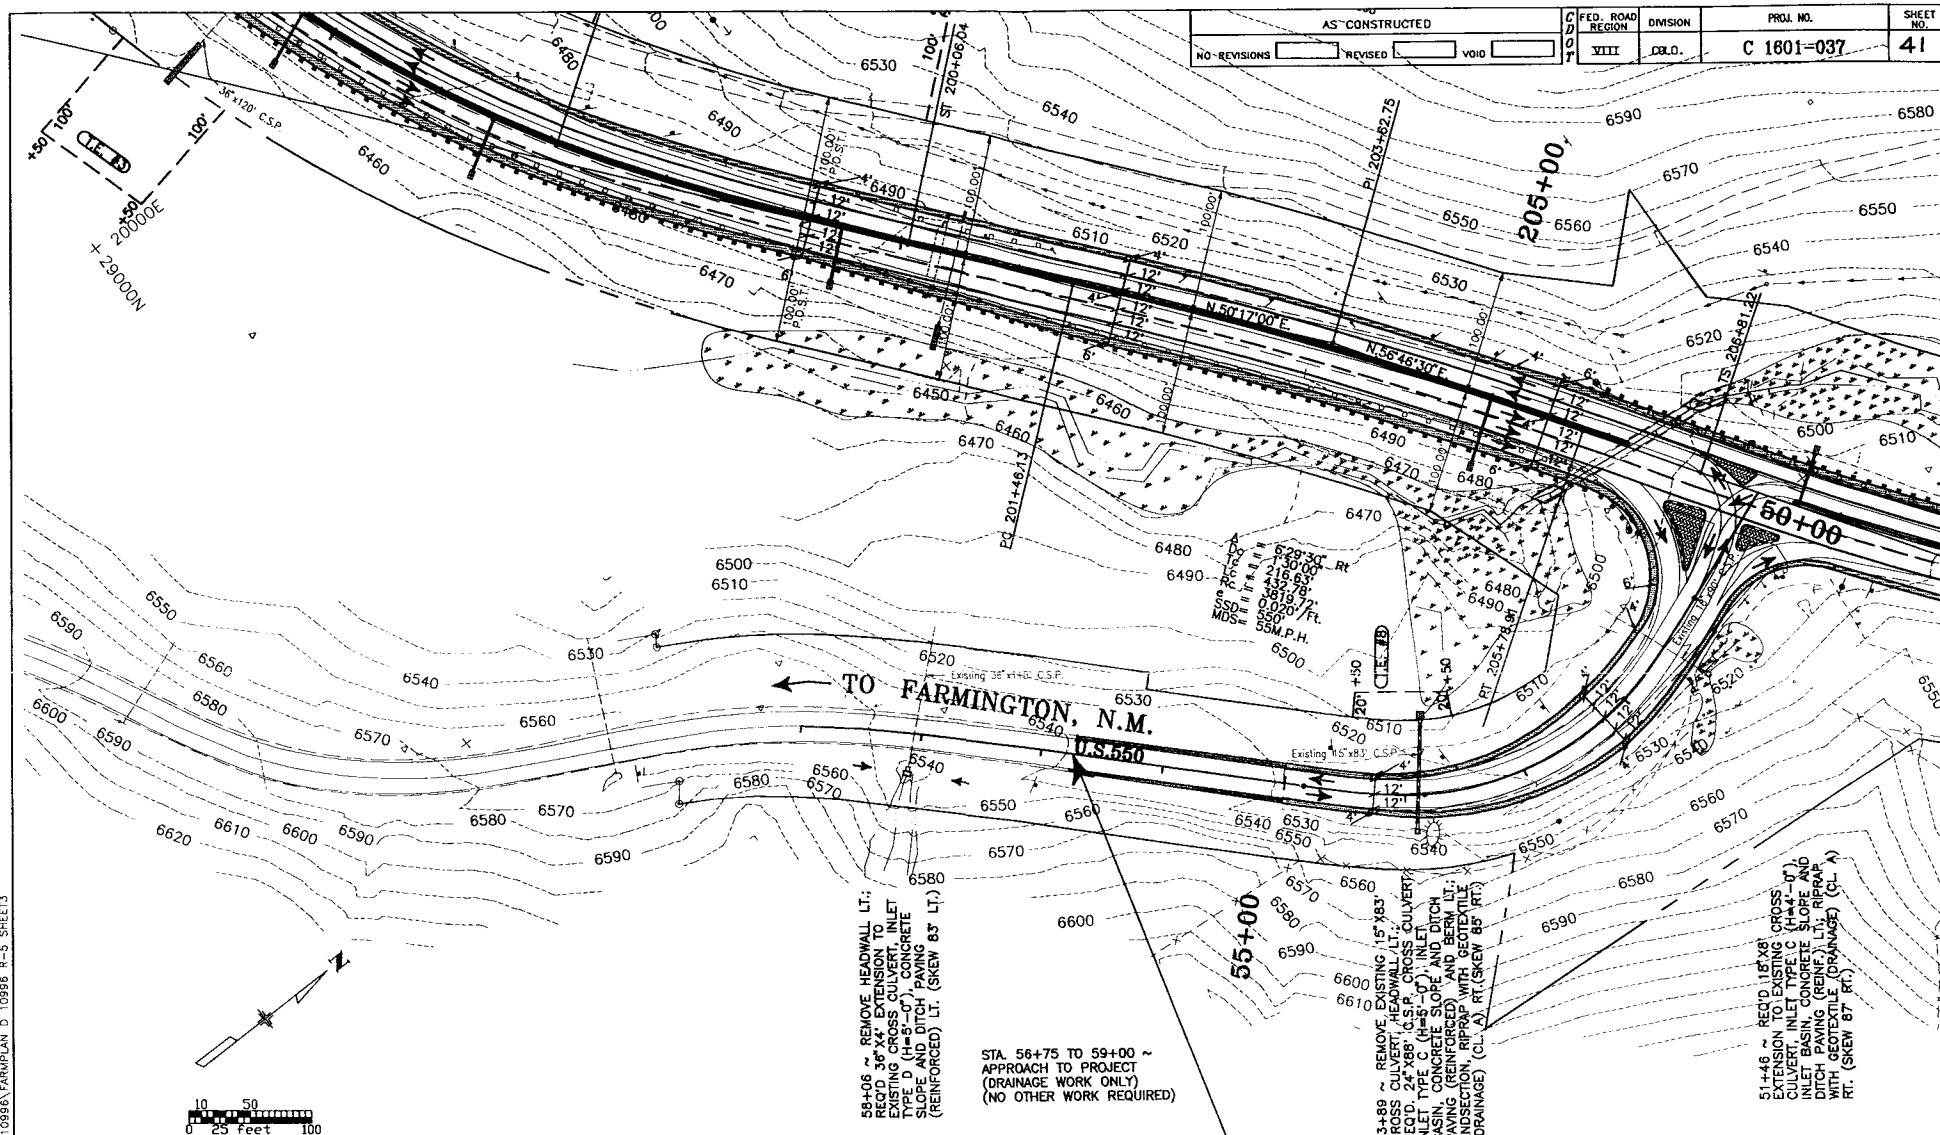

U.S. HIGHWAY 550 PLAN VIEW