

**COLORADO DEPARTMENT OF TRANSPORTATION
DOCUMENT TRANSMITTAL
TO STAFF RIGHT OF WAY**

Project	NH (CX)160-2(50) Unit 2	
Location	Wolf Creek Pass East	
Parcel		
Project code (SA#)	92977	Date 2/24/05

TO: ☒ Administration Unit	FOR: ☒ Filing	FROM: Region	☐ 1 ☐ 4
☐ Property Management Unit	☐ Recording		☐ 2 ☒ 5
☐ Relocation Unit	☐ Processing		☐ 3 ☐ 6
☐ Review Unit	☐ Information		
☐ RW Plans Unit			

RECEIVED

☐ Settlement package including supporting data	MAR 01 2005 Right of Way
☐ Condemnation package including supporting data	
☒ Other individual items described below	

Appraisal by	Date	Appraisal by	Date
Deeds: ☐ Special Warranty ☐ General Warranty ☐ Quit Claim ☐ Access: ☐ Other:			
Easements: ☐ Permanent ☐ Temporary ☐ Right of Entry ☐ Other:(Utility)			
Encumbrances, Release: ☐ Full ☐ Partial ☐ Interest in Real Property			
Estimates by		For	
Fair Market Value Determination ☐ Original ☐ Copy			Dated
Final Offer Letter ☐ Copy		Receipt ☐ Original ☐ Copy	
Invoices by		For	
Lease ☐ Original ☐ Copy			
Legal description ☐ Original ☐ Copy		Access description ☐ Original ☐ Copy	
Memorandum of Ownership ☐ Original ☐ Copy			Dated
Miscellaneous correspondence ☐ Copy			
Relocation forms ☐ Original ☐ Copy		Right of Way Agents closing statement ☐ Original ☐ Copy	
Right of Way cost estimate (Chief Engineer) ☐ Original ☐ Copy		Right of Way property inventory ☐ Original ☐ Copy	
Taxes: ☐ Original request for Tax Pro-Ration		☐ Original certificate of Taxes due	

Miscellaneous

Remarks
For project file

Right of Way Agent	<i>Andrea K. Taylor</i>
--------------------	-------------------------



Region 5
Address: 3803 North Main Avenue, Suite 300
Durango, Colorado 81301
Phone: (970) 385-1400 FAX: (970) 385-1410

Right of Way Plans Unit: Crumbaugh

Sheet Revisions

11/02	Revised Sheet 2, 2A, 2B, 2C, 4, 4A, 7, 26, 34	C-B
01/03	Revised Sheet 2A, 2B, 2C, 26, 27, 28	C-B
01/03	Revised Sheet 14, 15, 17, 26, 27, 28, 29, 31	C-B
04/03	Revised Sheet 2, 2B, 4A, 27	C-B
05/03	Revised Sheet 2, 2B, 4, 4A, 14, 15, 29	C-B
06/03	Revised Sheet 2A, 2B, 27, 45	C-B
02/04	Revised Sheet 2, 4B, 15	C-B
03/04	Revised Sheet 2C, 4A, 29, 30	C-B

Sheet Revisions

mm/yy	XXXXX	XXX

Sheet Revisions

mm/yy	XXXXX	XXX

Right of Way Plans


Title Sheet

Project Number:	NH (CX)160-2(50) UNIT 2			
Project Location:	WOLF CREEK PASS EAST			
Project Location:				
Project Code:	Last Mod. Date	Subset Sheets	Sheet No.	Total No. of Sheets
92977	11-2002	1 of 1	1	49

RELATED PROJECTS

FAP: F022-2(7)	FAP: NH (CX)160-2(50) UNIT 1
FAP: F022-2(4)	FAP: HES 0005(8)
FAP: F022-2(2)	FAP: NH (CX)160-2(49)

CONVENTIONAL SIGNS

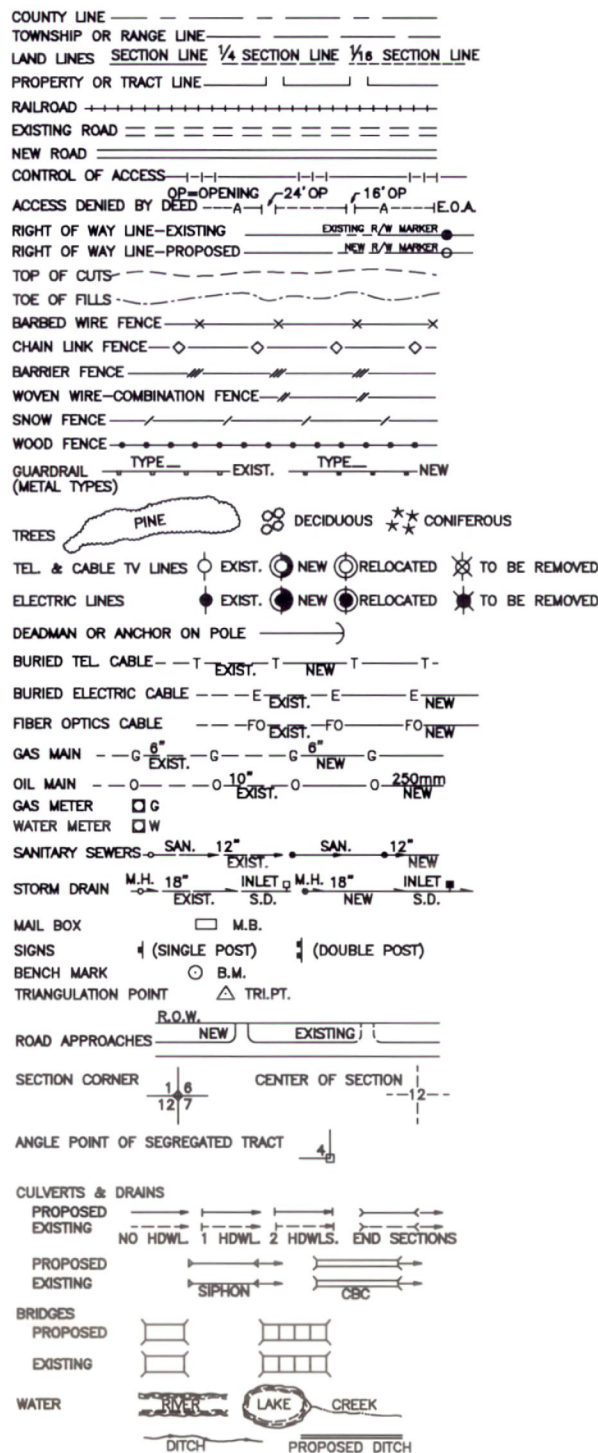

DEPARTMENT OF TRANSPORTATION
STATE OF COLORADO

RIGHT OF WAY PLANS OF PROPOSED


FEDERAL AID PROJECT NO. NH (CX)160-2(50) UNIT 2

U.S. HIGHWAY NO. 160

T. 35 N., R. 2 E. & T. 35 N., R. 3 E. of the N.M.P.M.

MINERAL & RIO GRANDE COUNTY

MP=174.7 / STA. 69+83.52
BEGIN PROJ. NH(CX)160-2(50) UNIT 2
= STA. 69+83.52 ON
PROJ. NH(CX)160-2(50) UNIT 1

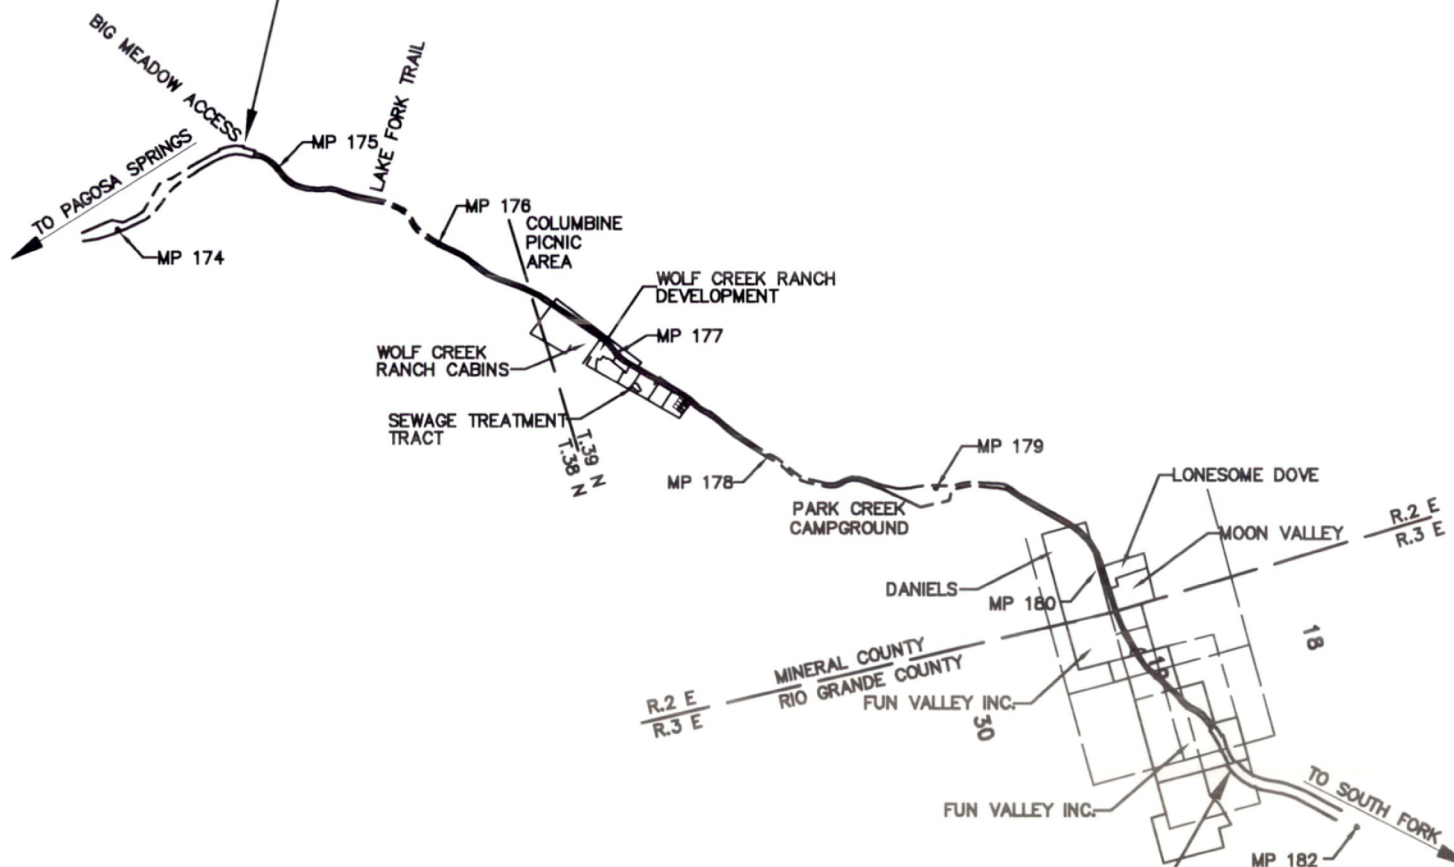


MP=181.2 / STA. 417+00
END PROJ. NH(CX)160-2(50) UNIT 2
= STA. 364+40.57 ON PROJ. NH (CX)160-2(49)

INDEX OF SHEETS

SHEET NO.

TITLE SHEET.....	1
PROPERTY OWNERSHIP TABULATION.....	2-2C
CONTROL AND DIAGRAM SHEET MP 173.8 TO MP 181.2.....	3-3C
CONTROL AND MONUMENTATION SHEET MP 174.69 TO MP 181.25.....	4
ROW INDEX SHEETS.....	5-5A
PLAN SHEETS.....	6-32
UNIT 2 OWNERSHIP MAP.....	33-49

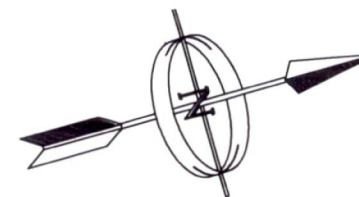

SCALE IN MILES



Basis of bearings: All of the project control is based on a common basis of bearing originating at two FHWA control points near MP 183 and carried by conventional total-station angle & distance traverse. The original bearing is a line between FHWA T-70 (obliterated) and FHWA T-69 (obliterated). Reference bearing: S. 35°54'55" W. Group 3 (MP 174.9 to 176.7): a line between Project Control Point No. 8027 (a CDOT 3.25" al.Cap) and Project Control Point No. 8028 (a CDOT 3.25" al.Cap). Reference bearing N. 34°48'58" E., 334.801 meters.(1098.43')

DEPARTMENT OF TRANSPORTATION
FEDERAL HIGHWAY ADMINISTRATION

AUTHORIZED

DATE

DIVISION ADMINISTRATOR

Carter-Burgess



Region 5
Address: 3803 North Main Avenue, Suite 300
Durango, Colorado 81301
Phone: (970) 385-1400 FAX: (970) 385-1410

Right of Way Plans Unit: Crumbaugh

Sheet Revisions		
11/02	showed net area LT & RT 217B	C-B
01/03	ADDED AC-217	C-B
03/04	Added TE217F	C-B

Sheet Revisions		
mm/yy	XXXXX	XXX

Sheet Revisions		
mm/yy	XXXXX	XXX

Right of Way Plans				
Tabulation of Properties Sheet				
Project Number:		NH (CX)160-2(50) UNIT 2		
Project Location:		WOLF CREEK PASS EAST		
Project Location:				
Project Code:	Last Mod. Date	Subset Sheets	Sheet No.	Total No. of Sheets
92977	---	4 of 4	2C	49

TABULATION OF PROPERTIES IN MINERAL & RIO GRANDE COUNTIES

S.H. NO. 160

PARCEL NO.	OWNER	ADDRESS	LOCATION	AREA IN ACRES					BOOK-PAGE	REMARKS
				AREA OF PARCEL	EXISTING ROW	NET AREA	REMAINDER			
							LEFT	RIGHT		
			T.39 N, R.3 E, N.M.P.M.							
TE-217A	FUN VALLEY INC.	P.O. BOX 208 SOUTH FORK, CO 81154	TRACTS 53, 54, & 55 SEC's 19 & 20	0.010		0.010				Req'd. FOR ROADWAY CONSTRUCTION
PE-217	FUN VALLEY INC.	P.O. BOX 208 SOUTH FORK, CO 81154	TRACTS 53, 54, & 55 SEC's 19 & 20	0.054		0.054				Req'd. FOR CONSTRUCTION AND MAINTENANCE OF DRAINAGE STRUCTURE
217B	FUN VALLEY INC.	P.O. BOX 208 SOUTH FORK, CO 81154	TRACTS 53, 54, & 55 SEC's 19 & 20	17.194	7.690	5.599 Left 3.905 Right	22.998	175.450		
TE-217B	FUN VALLEY INC.	P.O. BOX 208 SOUTH FORK, CO 81154	TRACTS 53, 54, & 55 SEC's 19 & 20	1.993		1.993				Req'd. FOR ROADWAY CONSTRUCTION
TE-217C	FUN VALLEY INC.	P.O. BOX 208 SOUTH FORK, CO 81154	TRACTS 53, 54, & 55 SEC's 19 & 20	0.331		0.331				Req'd. FOR ROADWAY CONSTRUCTION
TE-217D	FUN VALLEY INC.	P.O. BOX 208 SOUTH FORK, CO 81154	TRACTS 53, 54, & 55 SEC's 19 & 20	1.097		1.097				Req'd. FOR ROADWAY CONSTRUCTION
TE-217E	FUN VALLEY INC.	P.O. BOX 208 SOUTH FORK, CO 81154	TRACTS 53, 54, & 55 SEC's 19 & 20	1.422		1.422				Req'd. FOR ROADWAY CONSTRUCTION
TE-217F	FUN VALLEY INC.	P.O. BOX 208 SOUTH FORK, CO 81154	TRACTS 53, 54, & 55 SEC's 19 & 20	0.675		0.675				Req'd. FOR ROADWAY CONSTRUCTION
AC-217	FUN VALLEY INC.	P.O. BOX 208 SOUTH FORK, CO 81154								Req'd. FOR ACCESS PARCEL
			T.39 N, R.2 E, N.M.P.M.							
TE-218	TERRY FULTON AND TANA FULTON, 1/4 INTEREST CHARLES T. JACKSON AND BARBARA K. JACKSON REVOKABLE TRUST, 1/4 INTEREST C.V.Dellinger Jr. and wife Juanice Dellinger, 1/12 INTEREST A.Dwain Farr and wife Nancy Gail Farr, 1/12 INTEREST Thomas E. Wellborn and wife Carolyn Wellborn, 1/12 INTEREST STEVEN S. PATTON & VALERIE L. PATTON, 1/4 INTEREST	P.O.BOX 1135 SOUTH FORK, CO. 81154 P.O.BOX 5164 OVILLA, TX. 75154 1425 MEADOWS LANE MIDLOTHIAN, TX. 76065 4102 GLEN ROSE GARLAND, TX. ROUTE 2 MIDLOTHIAN, TX. 76065 2418 HAWTHORNE DRIVE AMARILLO, TX 79109	COLUMBINE DRIVE (WOLF CREEK RANCH ACCESS EASEMENT)	0.053		0.053				Req'd. FOR ROADWAY AND DRAINAGE CONSTRUCTION
			T.39 N, R.3 E, N.M.P.M.							
219	UNITED STATES FOREST SERVICE		SEC 19			0.050				
TE-219	UNITED STATES FOREST SERVICE		SEC 19			0.197				Req'd. FOR ROADWAY CONSTRUCTION
			T.39 N, R.2 E, N.M.P.M.							
220	UNITED STATES FOREST SERVICE		SECS 24, 25, 26, 34 & 35			0.639				

DEPOSITED THIS _____ DAY OF _____, 19____, AT _____, FOR INFORMATION
ONLY IN BOOK _____ OF THE COUNTY LAND SURVEYS/RIGHT OF WAY
SURVEYS AT PAGE _____ RECEPTION NUMBER _____
SIGNED _____
DEPT. _____



Region 5
Address: 3803 North Main Avenue, Suite 300
Durango, Colorado 81301
Phone: (970) 385-1400 FAX: (970) 385-1410

Right of Way Plans Unit: Crumbaugh

Sheet Revisions		
11/02	Added Points for TE211F	C-B
04/03	Added Points for 213A, Revised TE213	C-B
05/03	Revised Points for 215C 215X	C-B
02/04	Delete Points 1019-1027 for TE-205A, TE205B	C-B
02/04	Added Points 1122-1125 for TE217F	C-B

Sheet Revisions		
mm/yy	XXXXX	XXX

Sheet Revisions		
mm/yy	XXXXX	XXX

Right of Way Plans				
Right of Way Monumentation Sheet				
Project Number:		NH (CX)160-2(50) UNIT 2		
Project Location:		WOLF CREEK PASS EAST		
Project Location:				
Project Code:	Last Mod. Date	Subset Sheets	Sheet No.	Total No. of Sheets
92977	---	2 of 2	4A	49

RIGHT OF WAY MONUMENTATION

M.P. 174.78 TO M.P. 181.2

TABULATION OF PROPOSED R.O.W. MARKERS

NO.	NORTH(FT)	EAST(FT)	STATION	OFFSET	DESC	TYPE
344	343408.037	1645600.906	307+23.15	100.00	Left N-ROW	TYPE 1
490	343343.617	1645790.247	307+23.15	100.00	Right S-ROW	TYPE 1
345	343422.060	1645605.677	307+37.96	100.00	Left N-ROW	TYPE 1
491	343357.640	1645795.018	307+37.96	100.00	Right S-ROW	TYPE 1
346	343655.085	1645692.895	309+77.96	100.00	Left N-ROW	TYPE 1
492	343574.089	1645875.760	309+77.96	100.00	Right S-ROW	TYPE 1
348	344101.916	1646002.372	314+86.98	100.00	Left N-ROW	TYPE 1
493	343959.209	1646142.496	314+86.98	100.00	Right S-ROW	TYPE 1
349	344265.502	1646189.848	317+26.98	100.00	Left N-ROW	TYPE 1
494	344110.904	1646316.731	317+26.98	100.00	Right S-ROW	TYPE 1
350	344332.122	1646271.020	318+31.99	100.00	Left N-ROW	TYPE 1
495	344177.524	1646397.903	318+31.99	100.00	Right S-ROW	TYPE 1
352	344627.152	1646596.564	322+81.31	100.00	Left N-ROW	TYPE 1
496	344485.713	1646737.969	322+81.31	100.00	Right S-ROW	TYPE 1
353	345216.455	1647186.008	331+14.81	100.00	Left N-ROW	TYPE 1
497	345075.016	1647327.413	331+14.81	100.00	Right S-ROW	TYPE 1
354	345372.914	1647348.712	333+34.81	100.00	Left N-ROW	TYPE 1
498	345223.571	1647481.740	333+34.81	100.00	Right S-ROW	TYPE 1
499	345225.320	1647483.707	333+37.59	100.00	Right S-ROW	No Set
500	345238.815	1647483.876	333+47.13	90.00	Right S-ROW	TYPE 1
356	345876.484	1648537.072	345+83.36	100.00	Left N-ROW	TYPE 1
501	345687.004	1648551.108	345+83.36	90.00	Right S-ROW	TYPE 1
357	345884.561	1648762.653	348+03.36	100.00	Left N-ROW	TYPE 1
502	345694.587	1648765.759	348+03.36	90.00	Right S-ROW	TYPE 1
358	345885.263	1648805.540	348+46.25	100.00	Left N-ROW	TYPE 1
359	345883.450	1648805.595	348+46.28	98.19	Left N-ROW	TYPE 1
625	345918.987	1649028.764	350+70.00	130.07	Left N-ROW	TYPE 1
624	345889.243	1649029.250	350+70.00	100.32	Left N-ROW	TYPE 1
1074	345930.657	1649464.068	355+05.44	134.62	Left N-ROW	TYPE 1
503	345707.997	1649585.964	356+23.68	90.00	Right S-ROW	TYPE 1
610	345720.646	1649842.713	358+74.87	90.00	Right S-ROW	TYPE 1
504	345754.659	1650127.636	361+55.27	90.00	Right S-ROW	TYPE 1
505	345764.761	1650127.503	361+56.67	80.00	Right S-ROW	TYPE 1
360	345917.635	1650125.492	361+78.83	71.27	Left N-ROW	TYPE 1
361	345966.911	1650124.844	361+86.36	120.00	Left N-ROW	TYPE 1
363	346029.820	1650426.858	365+04.96	120.00	Left N-ROW	TYPE 1
506	345835.893	1650475.770	365+04.96	80.00	Right S-ROW	TYPE 1
507	345896.293	1650715.244	367+51.93	80.00	Right S-ROW	TYPE 1
508	345873.496	1650724.628	367+55.46	104.40	Right S-ROW	TYPE 1
509	345983.765	1651117.236	371+63.11	93.50	Right S-ROW	TYPE 1
510	345992.667	1651291.617	373+34.37	127.51	Right S-ROW	TYPE 1
511	345974.317	1651318.247	373+55.71	151.82	Right S-ROW	TYPE 1
528	346033.137	1651449.371	374+97.23	126.85	Right S-ROW	TYPE 1
1090	346086.575	1651450.311	375+11.21	75.27	Right S-ROW	TYPE 1
364	346277.386	1651408.406	375+17.25	120.00	Left N-ROW	TYPE 1
366	346325.183	1651577.826	377+00.00	120.00	Left N-ROW	TYPE 1
367	346296.549	1651586.774	377+00.00	90.00	Left N-ROW	TYPE 1
513	346155.817	1651703.937	377+68.19	80.00	Right S-ROW	TYPE 1
368	346520.512	1652124.704	383+00.00	90.00	Left N-ROW	TYPE 1
369	346547.037	1652110.688	383+00.00	120.00	Left N-ROW	TYPE 1
370	346604.539	1652214.709	384+23.39	120.00	Left N-ROW	TYPE 1
514	346431.358	1652314.749	384+23.39	80.00	Right S-ROW	TYPE 1
371	346840.849	1652623.789	388+95.81	120.00	Left N-ROW	TYPE 1
515	346659.007	1652728.829	388+95.81	90.00	Right S-ROW	TYPE 1
372	346892.716	1652713.020	390+00.00	120.00	Left N-ROW	TYPE 1
373	346935.807	1652687.660	390+00.00	170.00	Left N-ROW	TYPE 1
374	346970.846	1652746.287	390+70.81	170.00	Left N-ROW	TYPE 1
516	346740.204	1652886.659	390+70.81	100.00	Right S-ROW	TYPE 1
376	347117.736	1652968.891	393+50.00	170.00	Left N-ROW	TYPE 1
377	347077.037	1652997.935	393+50.00	120.00	Left N-ROW	TYPE 1
518	347033.809	1653336.772	395+93.22	120.00	Right S-ROW	TYPE 1
378	347219.898	1653185.210	395+93.23	120.00	Left N-ROW	TYPE 1
379	347330.709	1653317.081	397+68.23	120.00	Left N-ROW	TYPE 1
519	347144.342	1653476.117	397+68.23	125.00	Right S-ROW	TYPE 1
380	347481.078	1653502.049	399+98.23	120.00	Left N-ROW	TYPE 1
520	347279.982	1653650.577	399+98.23	130.00	Right S-ROW	TYPE 1
521	347329.070	1653730.338	401+00.00	135.00	Right S-ROW	TYPE 1
522	347469.988	1654066.176	405+00.00	155.00	Right S-ROW	TYPE 1
523	347498.431	1654244.760	407+00.00	175.00	Right S-ROW	TYPE 1
524	347799.303	1654247.765	407+60.50	120.00	Left N-ROW	TYPE 1
524	347499.393	1654335.236	408+00.00	190.00	Right S-ROW	TYPE 1
525	347561.514	1654325.945	408+00.00	127.19	Right S-ROW	TYPE 1
383	347808.420	1654306.121	408+15.99	120.00	Left N-ROW	TYPE 1
384	347803.207	1654306.860	408+15.99	114.74	Left N-ROW	TYPE 1

TABULATION OF EXISTING R.O.W. MARKERS

NO.	NORTH(FT)	EAST(FT)	STATION	OFFSET	DESC	TYPE
616	334626.907	1639686.001	196+40.29	86.58	Right EX.ROW-PT	TYPE 1
1028	335431.901	1640526.182	208+00.00	80.16	Right PE208	TYPE 1
617	335914.877	1641030.270	215+01.68	65.11	Right EX.ROW-PC	TYPE 1
623	345900.505	1649464.099	355+04.97	104.47	Left EX.ROW=P/L	TYPE 1
618	346107.909	1651541.626	376+02.94	78.06	Right EX.ROW-PC	TYPE 1

TABULATION OF PERMANENT EASEMENT CORNERS

NO.	NORTH(FT)	EAST(FT)	STATION	OFFSET	DESC	TYPE
1008	333112.952	1637656.623	171+00.99	90.00	Right PE202	TYPE 6
1009	333093.848	1637672.748	171+00.99	115.00	Right PE202	TYPE 6
1010	333125.459	1637710.200	171+50.00	115.00	Right PE202	TYPE 6
1011	333144.563	1637694.075	171+50.00	90.00	Right PE202	TYPE 6
1029	335419.588	1640537.904	208+00.00	97.16	Right PE208	TYPE 6
1030	335488.771	1640610.111	209+00.00	96.85	Right PE208	TYPE 6
1031	335501.083	1640598.389	209+00.00	79.85	Right PE208	TYPE 6
1032	335724.694	1640831.774	212+25.00	76.21	Right PE209	TYPE 6
1033	335714.585	1640841.460	212+25.37	90.21	Right PE209	TYPE 6
1035	335793.384	1640903.467	213+25.00	73.10	Right PE209	TYPE 6
1034	335783.275	1640913.152	213+25.52	87.09	Right PE209	TYPE 6
1091	346060.819	1651449.858	375+04.47	100.13	Right PE217	TYPE 6
1092	346083.146	1651545.419	376+00.00	102.93	Right PE217	TYPE 6
1093	346107.224	1651538.695	376+00.00	77.93	Right PE217	TYPE 6

TABULATION OF TEMPORARY EASEMENT CORNERS

NO.	NORTH(FT)	EAST(FT)	STATION	OFFSET	DESC
1000	325809.229	1630760.699	68+00.00	140.00	Left TE201A
1001	325819.989	1630722.173	68+00.00	180.00	Left TE201A
1003	325903.265	1630748.549	68+75.00	180.00	Left TE201A
1004	325889.884	1630786.244	68+75.00	140.00	Left TE201A
1005	333087.396	1637626.345	170+61.37	90.00	Right TE202A
1006	333085.318	1637628.099	170+61.37	92.72	Right TE202A
1007	333108.902	1637660.042	171+00.99	95.30	Right TE202A
1012	333563.813	1638190.794	178+00.00	90.00	Right TE202B
1013	333578.641	1638309.137	179+00.00	155.00	Right TE202B
1014	333610.891	1638347.346	179+50.00	155.00	Right TE202B
1015	333660.563	1638305.421	179+50.00	90.00	Right TE202B
1016	334397.018	1639344.240	192+47.52	87.58	Right TE203
1017	334384.760	1639398.200	192+88.09	123.78	Right TE203,TE205A
1036	335896.520	1641011.111	214+75.00	66.52	Right TE209
1037	335863.610	1641039.526	214+75.00	110.00	Right TE209
1038	335901.246	1641083.377	215+33.44	110.00	Right TE209,TE218
434	335933.663	1641121.573	215+84.11	110.00	Right TE218
1039	337040.100	1642623.796	234+50.00	100.00	Right TE211A
1040	337016.687	1642642.553	234+50.00	130.00	Right TE211A
1041	337083.460	1642722.980	235+50.00	130.00	Right TE211A
1042	337106.204	1642703.416	235+50.00	100.00	Right TE211A
447	338054.761	1643721.283	249+50.61	100.00	Right TE211B
1043	338103.165	1643871.204	251+00.00	150.00	Right TE211B
1044	338023.021	1644130.450	252+50.00	370.00	Right TE211B
1045	338637.972	1644772.705	259+50.00	480.00	Right TE211B
1046	338942.400	1644788.485	261+75.00	380.00	Right TE211B
460	339098.351	1644568.711	262+50.00	125.00	Right TE211B
1047	340020.441	1644727.627	272+00.00	100.00	Right TE211C
1048	339938.109	1644926.238	272+00.00	315.00	Right TE211C
1049	340317.678	1644945.915	275+85.43	150.00	Right TE211C
1050	340542.698	1645086.419	278+50.71	150.00	Right TE211C
1051	340749.672	1645208.871	280+80.71	150.00	Right TE211C
1052	341013.271	1645322.659	283+44.01	150.00	Right TE211C
1053	341063.765	1645366.894	284+00.00	176.73	Right TE211C
1054	341220.297	1645430.400	285+50.10	200.05	Right TE211C
1055	341380.545	1645455.418	287+00.00	198.29	Right TE211C
1056	341387.496	1645405.898	287+00.00	148.29	Right TE211C
329	341290.251	1645087.407	285+50.10	150.00	Left TE211D
1057	341520.133	1645021.876	287+80.10	250.00	Left TE211D
1058	341751.840	1645057.068	290+00.10	250.00	Left TE211D
334	341942.377	1645206.703	292+00.00	150.00	Left TE211D
1116	345276.103	1647248.037	332+00.00	98.58	Left TE211F
1117	345529.163	1647308.012	334+00.00	245.00	Left TE211F
1118	345653.465	1647489.076	335+94.98	236.01	Left TE211F
1059	345553.600	1647989.489	339+75.00	90.00	Right TE212
1060	345470.040	1648041.448	339+92.79	187.00	Right TE212
1062	345595.524	1648100.953	341+00.00	90.00	Right TE212
1061	345535.347	1648134.580	341+13.64	157.75	Right TE212
1063	345749.586	1647936.992	340+00.00	111.34	Left TE211E
1064	345958.843	1648038.108	341+50.00	275.00	Left TE211E
1065	346083.919	1648365.348	344+50.00	325.00	Left TE211E
1066	346327.791	1648793.238	348+41.19	542.67	Left TE211E
1067	345951.649	1648803.698	348+45.50	166.41	Left TE213
1069	345914.026	1648843.705	348+84.88	128.14	Left TE213
1068	345951.921	1648843.691	348+85.49	166.03	Left TE213
1070	345914.775	1648871.643	349+12.83	128.43	Left TE213
1071	345895.290	1648874.541	349+15.41	108.90	Left TE213
1119	345915.982	1648916.653	349+57.86	128.90	Left TE213
1072	345902.559	1648917.001	349+57.98	115.47	Left TE213

COLORADO DEPARTMENT OF TRANSPORTATION



Region 5
Address: 3803 North Main Avenue, Suite 300
Durango, Colorado 81301
Phone: (970) 385-1400 FAX: (970) 385-1410

Right of Way Plans Unit: Crumbaugh

Sheet Revisions

01/03	Added POB to TE215B, TE215C, TE217B, TE217C	C-B
05/03	Added 215C & 215X	C-B
03/04	Added TE217F	C-B

Sheet Revisions

mm/yy	XXXXX	XXX

Sheet Revisions



mm/yy	XXXXX	XXX

Right of Way Plans

Right of Way Plan Sheet

Project Number:		NH (CX)160-2(50) UNIT 2		
Project Location:		WOLF CREEK PASS EAST		
Project Location:				
Project Code:	Last Mod. Date	Subset Sheets	Sheet No.	Total No. of Sheets
92977	---	24 of 27	29	49

 T.39 N, R.3 E, NMPM

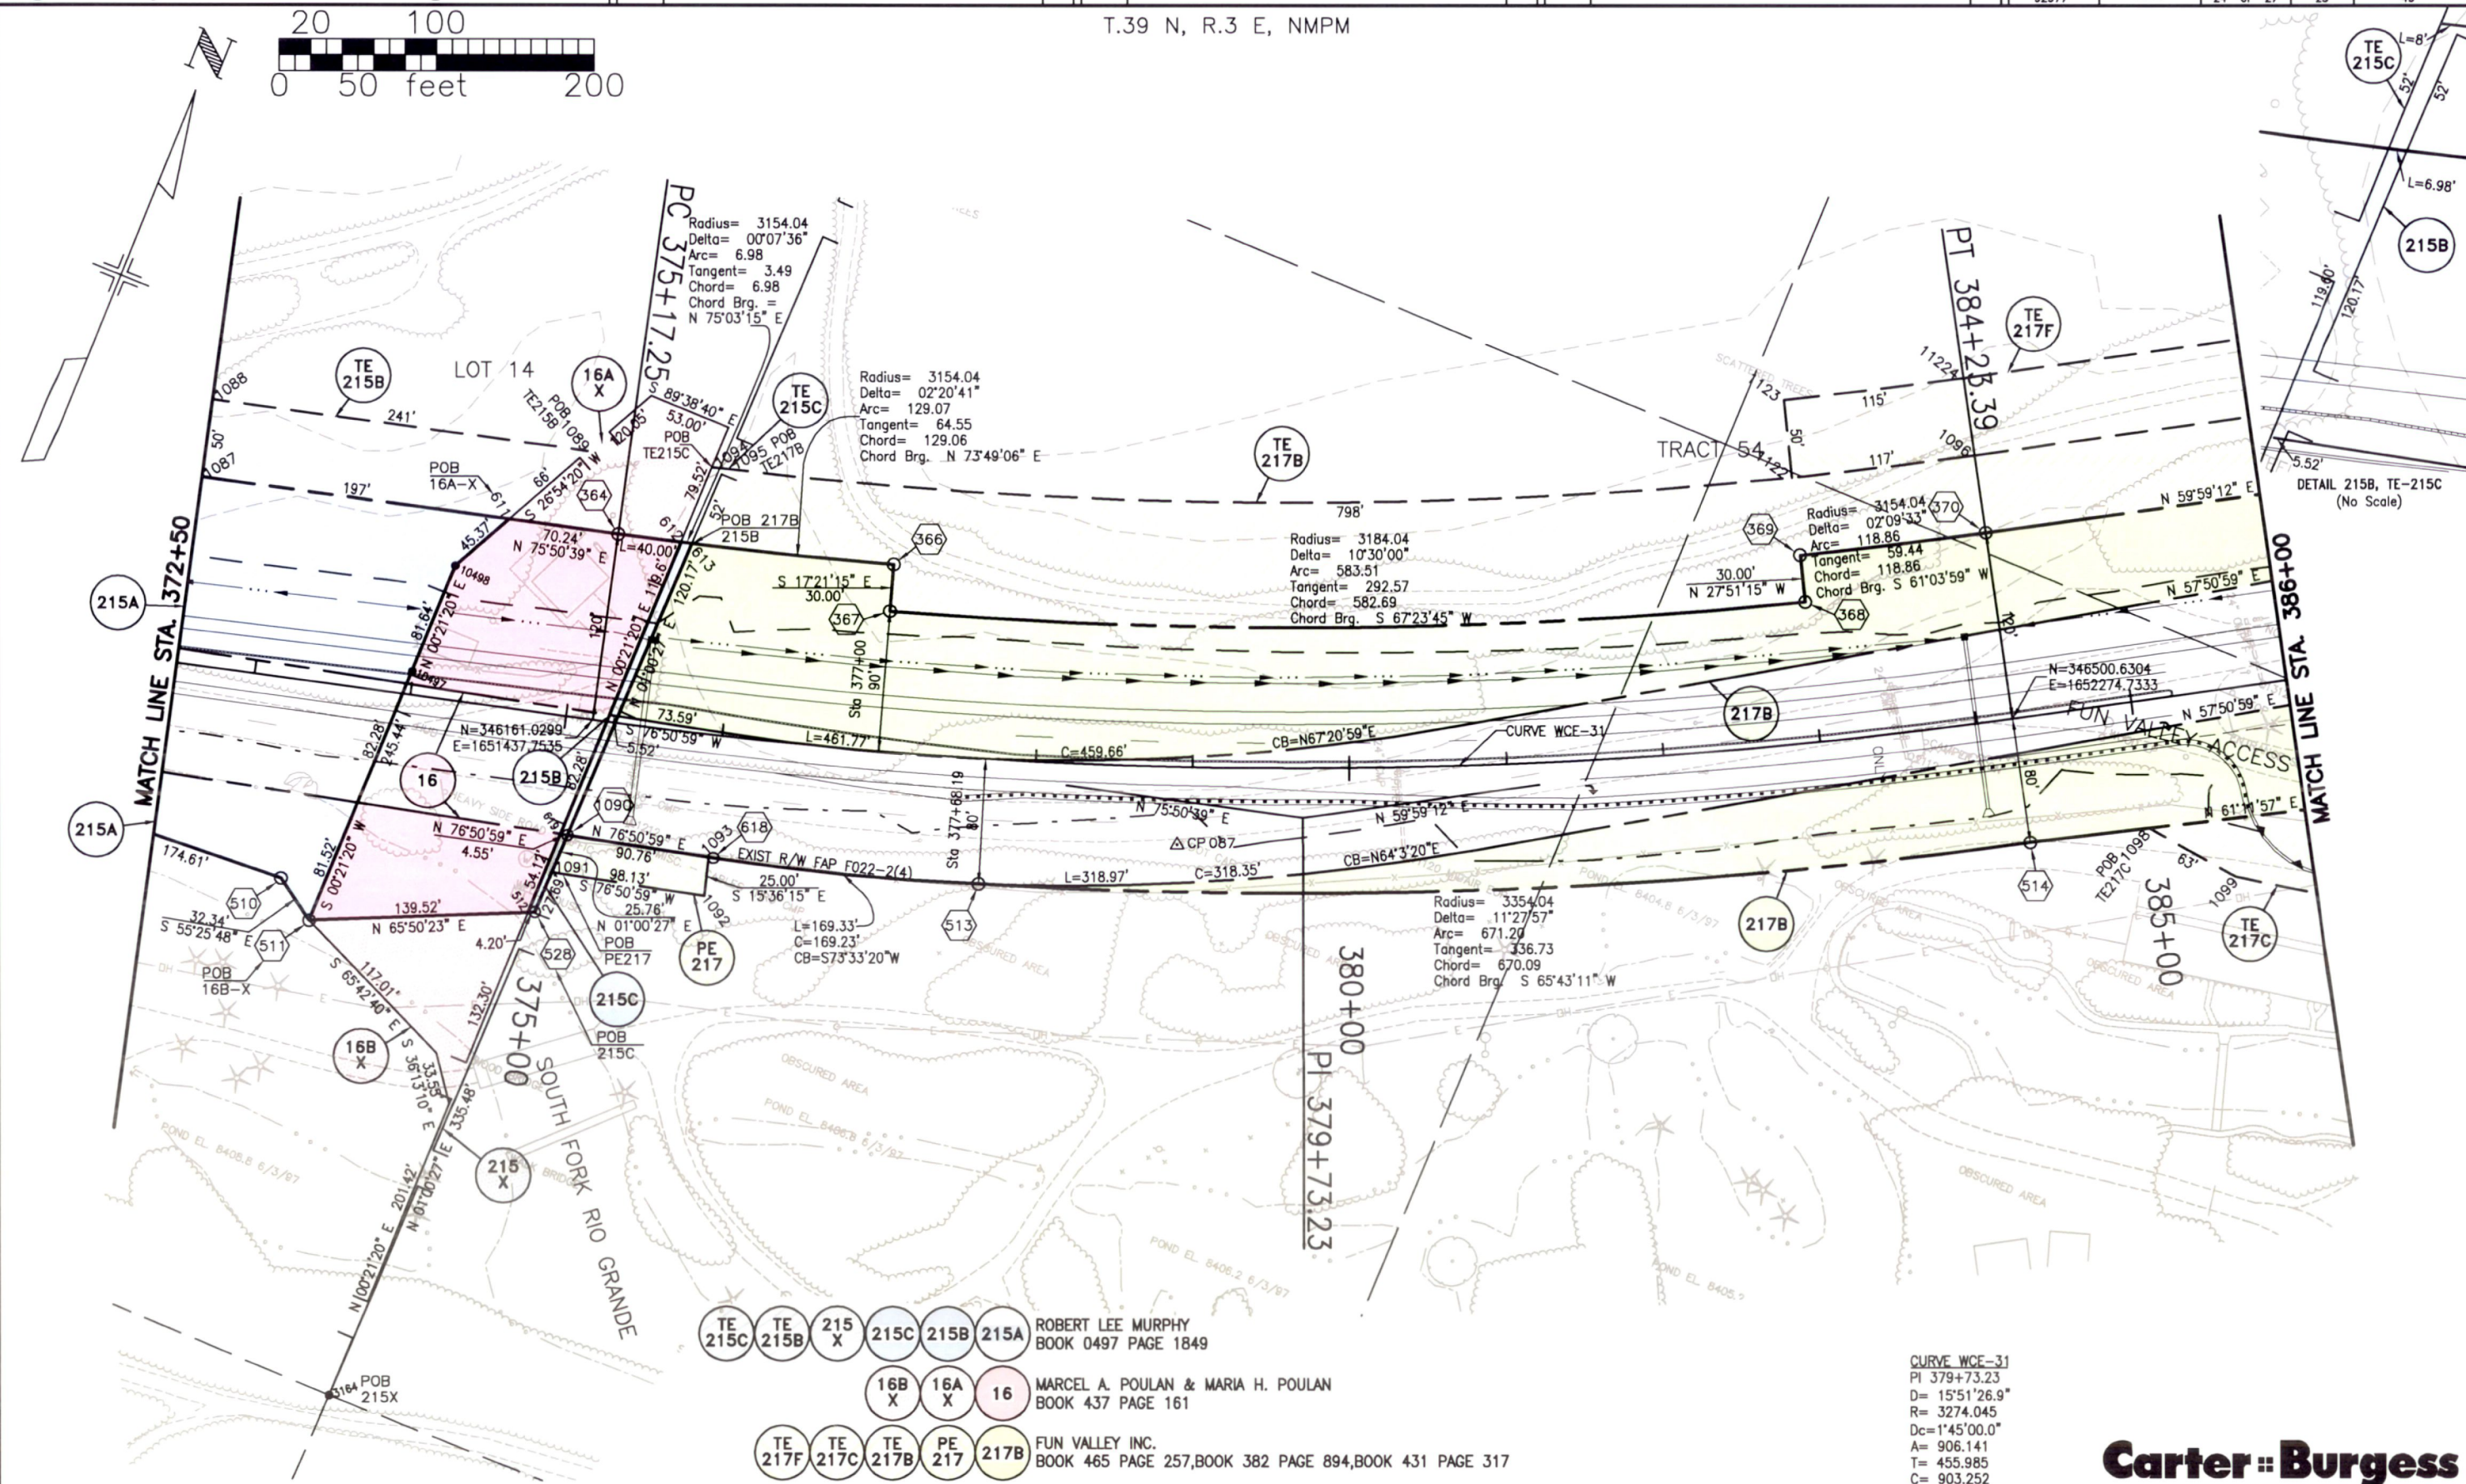

DETAIL 215B, TE-215C
(No Scale)

- TE 215C
- TE 215B
- 215 X
- 215C
- 215B
- 215A
- 16B X
- 16A X
- 16
- TE 217F
- TE 217C
- TE 217B
- PE 217
- 217B

ROBERT LEE MURPHY
BOOK 0497 PAGE 1849

MARCEL A. POULAN & MARIA H. POULAN
BOOK 437 PAGE 161

FUN VALLEY INC.
BOOK 465 PAGE 257, BOOK 382 PAGE 894, BOOK 431 PAGE 317

CURVE WCE-31
PI 379+73.23
D= 15'51'26.9"
R= 3274.045
Dc= 1'45'00.0"
A= 906.141
T= 455.985
C= 903.252

Carter Burgess



Region 5
Address: 3803 North Main Avenue, Suite 300
Durango, Colorado 81301
Phone: (970) 385-1400 FAX: (970) 385-1410

Right of Way Plans Unit: Crumbaugh

Sheet Revisions

mm/yy	Added	mm/yy	mm/yy
03/04	Added TE217F	C-B	

Sheet Revisions

mm/yy	Added	mm/yy	mm/yy
	XXXXX	XXX	

Sheet Revisions



mm/yy	Added	mm/yy	mm/yy
	XXXXX	XXX	

Right of Way Plans

Right of Way Plan Sheet

Project Number:	NH (CX)160-2(50) UNIT 2			
Project Location:	WOLF CREEK PASS EAST			
Project Location:				
Project Code:	Last Mod. Date	Subset Sheets	Sheet No.	Total No. of Sheets
92977	---	25 of 27	30	49

 T.39 N, R.3 E, NMPM

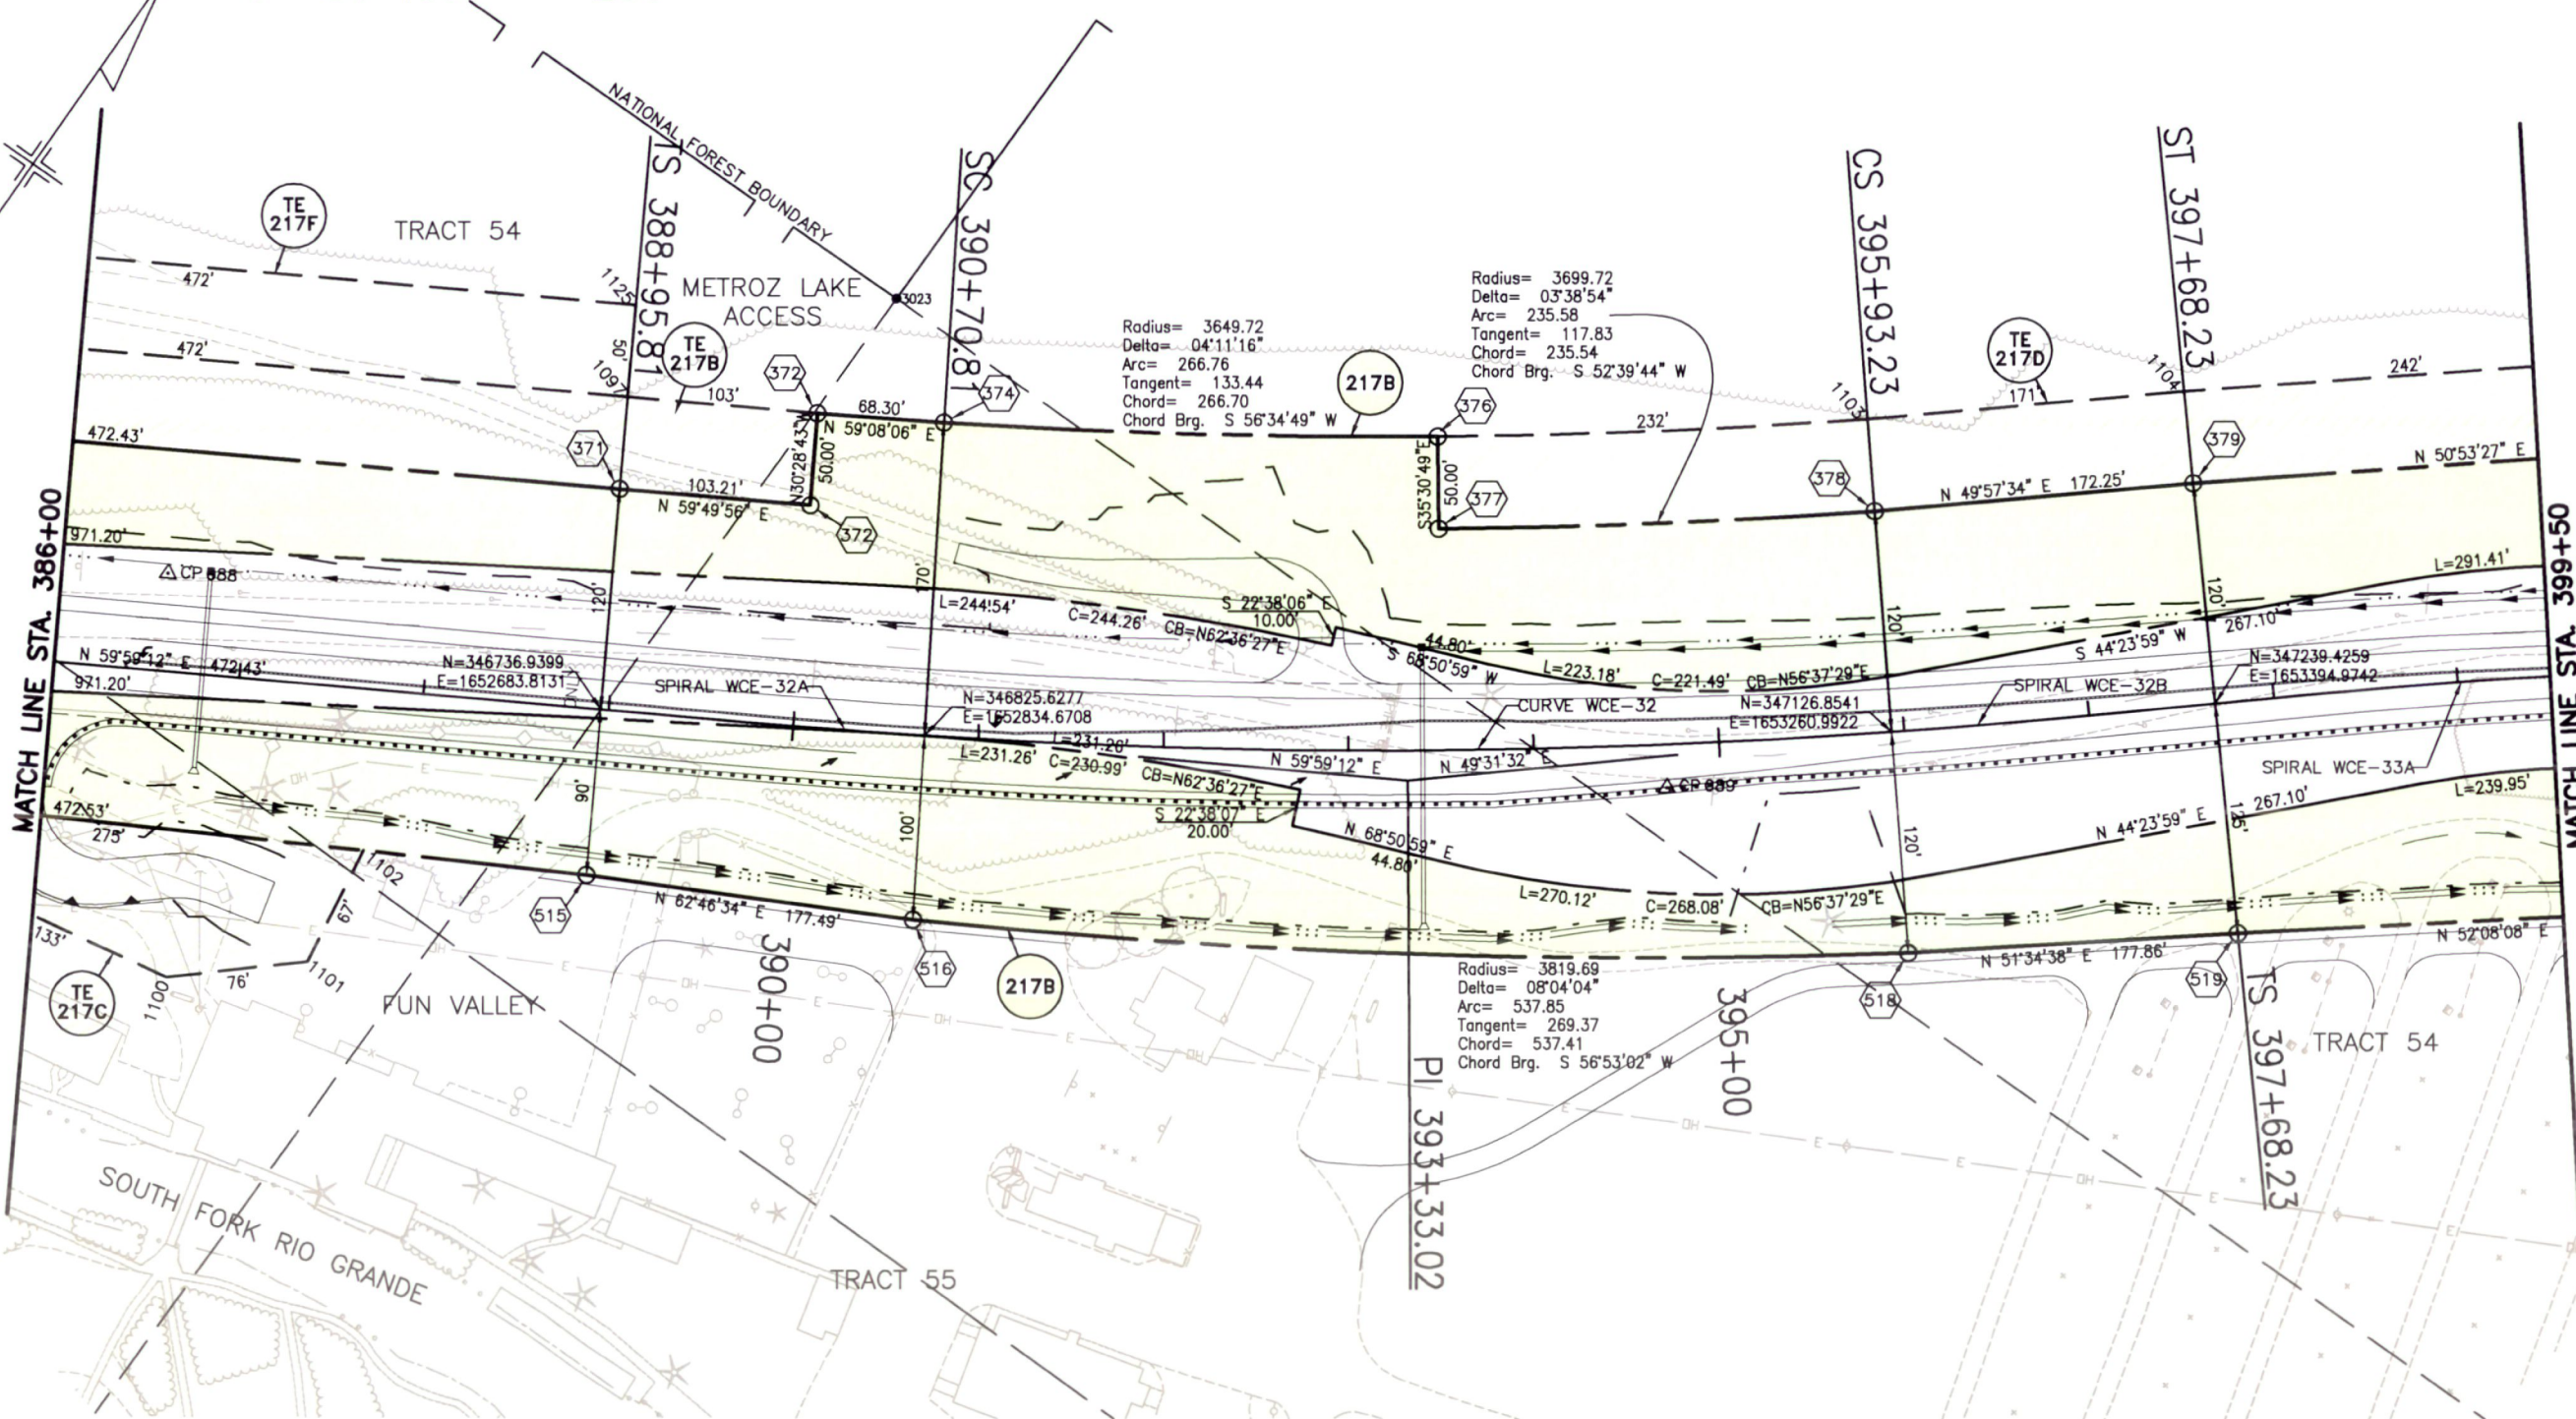

SPIRAL WCE-32A
Ls=175.000
Ang=1°18'45.0"
LT=116.670
ST=58.336

CURVE WCE-32
PI 393+33.02
D= 7°50'10.1"
R= 3819.720
Dc=1°30'00.0"
A= 522.410
C= 522.003

SPIRAL WCE-32B
Ls=175.000
Ang=1°18'45.0"
LT=116.670
ST=58.336

SPIRAL WCE-33A
Ls=230.000
Ang=4°01'30.0"
LT=153.373
ST=76.703

TE 217F TE 217D TE 217C TE 217B 217B

FUN VALLEY INC.
BOOK 465 PAGE 257, BOOK 382 PAGE 894, BOOK 431 PAGE 317

Carter Burgess

COLORADO DEPARTMENT OF TRANSPORTATION



Region 5
Address: 3803 North Main Avenue, Suite 300
Durango, Colorado 81301
Phone: (970) 385-1400 FAX: (970) 385-1410

Right of Way Plans Unit: Crumbaugh

Sheet Revisions

mm/yy	XXXXX	XXX

Sheet Revisions

mm/yy	XXXXX	XXX

Sheet Revisions

mm/yy	XXXXX	XXX

Right of Way Plans

Title Sheet

Project Number:	NH (CX)160-2(50) UNIT 2
Project Location:	WOLF CREEK PASS EAST
Project Code:	92977
Last Mod. Date	--
Subsiet Sheets	1 of 1
Sheet No.	1
Total No. of Sheets	49

RELATED PROJECTS

FAP: F022-2(7)	FAP: NH (CX)160-2(50) UNIT 1
FAP: F022-2(4)	FAP: HES 0005(8)
FAP: F022-2(2)	FAP: NH (CX)160-2(49)


CONVENTIONAL SIGNS

COUNTY LINE	---
TOWNSHIP OR RANGE LINE	---
LAND LINES	SECTION LINE 1/4 SECTION LINE 1/4 SECTION LINE 1/4 SECTION LINE 1/4
PROPERTY OR TRACT LINE	---
RAILROAD	+++++
EXISTING ROAD	==
NEW ROAD	---
CONTROL OF ACCESS	---
ACCESS DENIED BY DEED	OP=OPENING 24' OP 18' OP E.O.A.
RIGHT OF WAY LINE-EXISTING	---
RIGHT OF WAY LINE-PROPOSED	---
TOP OF CUTS	---
TOE OF FILLS	---
BARBED WIRE FENCE	---
CHAIN LINK FENCE	---
BARRIER FENCE	---
WOVEN WIRE-COMBINATION FENCE	---
SNOW FENCE	---
WOOD FENCE	---
GUARDRAIL	TYPE EXIST. TYPE NEW
(METAL TYPES)	---
TREES	PINE DECIDUOUS CONIFEROUS
TEL. & CABLE TV LINES	EXIST. NEW RELOCATED TO BE REMOVED
ELECTRIC LINES	EXIST. NEW RELOCATED TO BE REMOVED
DEADMAN OR ANCHOR ON POLE	---
BURIED TEL. CABLE	EXIST. NEW
BURIED ELECTRIC CABLE	EXIST. NEW
FIBER OPTICS CABLE	FO EXIST. FO NEW
GAS MAIN	G 8" EXIST. G 8" NEW
OIL MAIN	O 10" EXIST. O 250mm NEW
GAS METER	G
WATER METER	W
SANITARY SEWERS	SAN. 12" EXIST. SAN. 12" NEW
STORM DRAIN	M.H. 18" EXIST. M.H. 18" NEW
MAIL BOX	M.B.
SIGNS	(SINGLE POST) (DOUBLE POST)
BENCH MARK	B.M.
TRIANGULATION POINT	TRI.PT.
ROAD APPROACHES	NEW EXISTING
SECTION CORNER	1/12 1/12
CENTER OF SECTION	---
ANGLE POINT OF SEGREGATED TRACT	---
CULVERTS & DRAINS	PROPOSED EXISTING NO HDWL. 1 HDWL. 2 HDWL. END SECTIONS
PROPOSED EXISTING	SIPHON C&C
BRIDGES	PROPOSED EXISTING
WATER	RIVER LAKE CREEK DITCH PROPOSED DITCH


DEPARTMENT OF TRANSPORTATION
STATE OF COLORADO

RIGHT OF WAY PLANS OF PROPOSED
FEDERAL AID PROJECT NO. NH (CX)160-2(50) UNIT 2
U.S. HIGHWAY NO. 160
T. 35 N., R. 2 E. & T. 35 N., R. 3 E. of the N.M.P.M.
MINERAL & RIO GRANDE COUNTY

MP=174.7 / STA. 69+83.52
BEGIN PROJ. NH(CX)160-2(50) UNIT 2
= STA. 69+83.52 ON
PROJ. NH(CX)160-2(50) UNIT 1

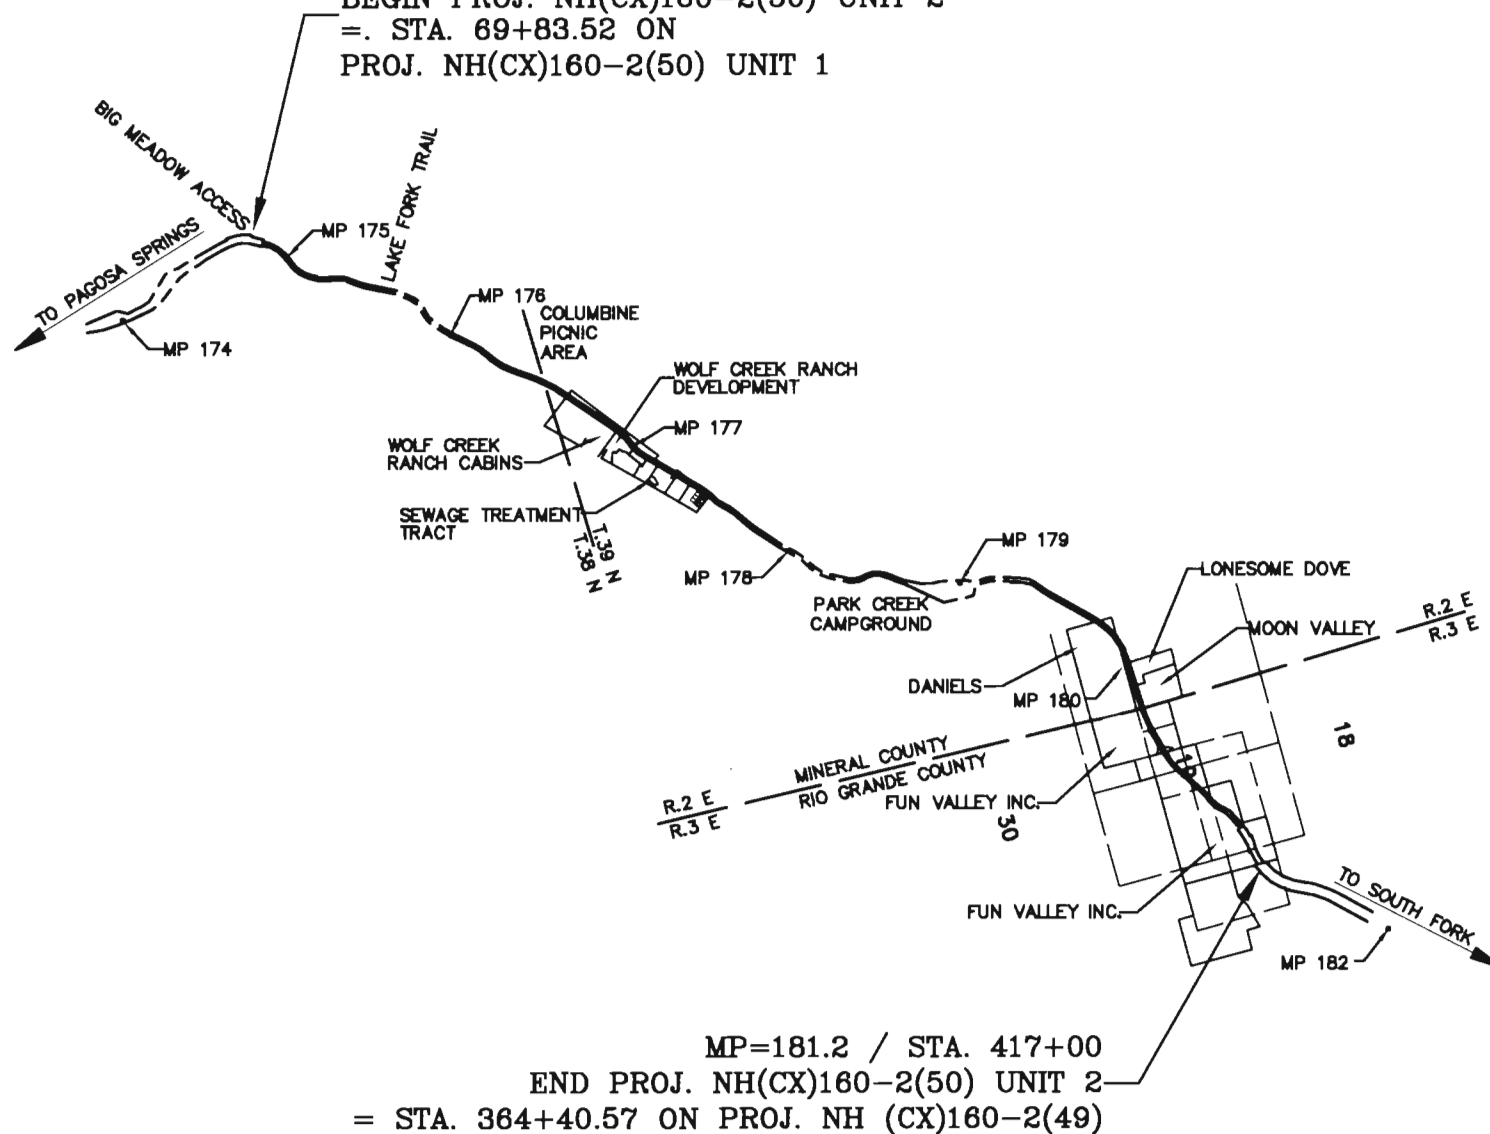

INDEX OF SHEETS	SHEET NO.
TITLE SHEET	1
PROPERTY OWNERSHIP TABULATION	2-2C
CONTROL AND DIAGRAM SHEET MP 173.8 TO MP 181.2	3-3C
CONTROL AND MONUMENTATION SHEET MP 174.69 TO MP 181.25	4
ROW INDEX SHEETS	5-5A
PLAN SHEETS	6-32
UNIT 2 OWNERSHIP MAP	33-49

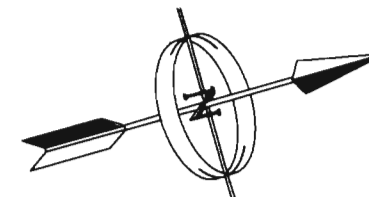

Basis of bearings: All of the project control is based on a common basis of bearing originating at two FHWA control points near MP 183 and carried by conventional total-station angle & distance traverse. The original bearing is a line between FHWA T-70 (obliterated) and FHWA T-69 (obliterated). Reference bearing: S. 35°54'55" W. Group 3 (MP 174.9 to 176.7): a line between Project Control Point No. 8027 (a CDOT 3.25" al.Cap) and Project Control Point No. 8028 (a CDOT 3.25" al.Cap). Reference bearing N. 34°48'58" E., 334.801 meters.(1098.43')

DEPARTMENT OF TRANSPORTATION
FEDERAL HIGHWAY ADMINISTRATION

AUTHORIZED

DATE

DIVISION ADMINISTRATOR

Carter Burgess

COLORADO DEPARTMENT OF TRANSPORTATION



Region 5
Address: 3803 North Main Avenue, Suite 300
Durango, Colorado 81301
Phone: (970) 385-1400 FAX: (970) 385-1410

Right of Way Plans Unit: Crumbaugh

Sheet Revisions

mm/yy	xxxxx	xxx

Sheet Revisions

mm/yy	xxxxx	xxx

Sheet Revisions

mm/yy	xxxxx	xxx

Right of Way Plans

Tabulation of Properties Sheet

Project Number:	NH (CX)160-2(50) UNIT 2			
Project Location:	WOLF CREEK PASS EAST			
Project Location:				
Project Code:	Last Mod. Date	Subset Sheets	Sheet No.	Total No. of Sheets
92977	---	1 of 4	2	49

TABULATION OF PROPERTIES IN MINERAL & RIO GRANDE COUNTIES

S.H. NO. 160

PARCEL NO.	OWNER	ADDRESS	LOCATION	AREA IN ACRES					BOOK-PAGE	REMARKS
				AREA OF PARCEL	EXISTING ROW	NET AREA	REMAINDER			
			LEFT				RIGHT			
			T.38 N, R.2 E, N.M.P.M.							
201	UNITED STATES FOREST SERVICE		SECS 3, 4 & 9			66.489				RIO GRANDE NATIONAL FOREST
TE-201	UNITED STATES FOREST SERVICE		SEC 9			0.079				Req'd. FOR ROADWAY CONSTRUCTION
			T.39 N, R.2 E, N.M.P.M.							
201	UNITED STATES FOREST SERVICE		SECS 34 & 35			5.015				RIO GRANDE NATIONAL FOREST
202	BONNIE RAYLENE KAHLER	2216 SOUTH OAKLAND WAY AURORA, CO 80014	A PART OF THE HOMESTEAD ENTRY SURVEY 273	10.108	3.826	6.282	0.628	33.545		
PE-202	BONNIE RAYLENE KAHLER	2216 SOUTH OAKLAND WAY AURORA, CO 80014	A PART OF THE HOMESTEAD ENTRY SURVEY 273	0.028		0.028				Req'd. FOR CONSTRUCTION AND MAINTENANCE OF DRAINAGE STRUCTURE
TE-202A	BONNIE RAYLENE KAHLER	2216 SOUTH OAKLAND WAY AURORA, CO 80014	A PART OF THE HOMESTEAD ENTRY SURVEY 273	0.004		0.004				Req'd. FOR ROADWAY CONSTRUCTION
TE-202B	BONNIE RAYLENE KAHLER	AURORA, CO 80014 2216 SOUTH OAKLAND WAY	A PART OF THE HOMESTEAD ENTRY SURVEY 273	0.149		0.149				Req'd. FOR ROADWAY CONSTRUCTION
202A-R	BONNIE RAYLENE KAHLER	2216 SOUTH OAKLAND WAY AURORA, CO 80014	A PART OF THE HOMESTEAD ENTRY SURVEY 273	0.555		0.555				
202B-R	BONNIE RAYLENE KAHLER	2216 SOUTH OAKLAND WAY AURORA, CO 80014	A PART OF THE HOMESTEAD ENTRY SURVEY 273	0.073		0.073				To be Acquired in favor of UNITED STATES FOREST SERVICE
203	WOLF CREEK WILDERNESS CABINS, LLC.	P.O. BOX 1144 SOUTH FORK, CO 81154	Tract 1 WOLF CRK RANCHETTES,A PART OF THE HOMESTEAD ENTRY SURVEY 273	0.377		0.377		7.621		
TE-203	WOLF CREEK WILDERNESS CABINS, LLC.	P.O. BOX 1144 SOUTH FORK, CO 81154	Tract 1 WOLF CRK RANCHETTES, A PART OF THE HOMESTEAD ENTRY SURVEY 273	0.013		0.013				Req'd. FOR ROADWAY AND DRAINAGE CONSTRUCTION
204	WOLF CREEK RANCH LLC	P.O. BOX 590 SOUTH FORK, CO 81154	Tract 8 WOLF CREEK RANCHETTES, A PART OF THE HOMESTEAD ENTRY SURVEY 273	4.238		4.238	0.647	3.846		
204-R	WOLF CREEK RANCH LLC	P.O. BOX 590 SOUTH FORK, CO 81154	Tract 8 WOLF CREEK RANCHETTES, A PART OF THE HOMESTEAD ENTRY SURVEY 273	0.647		0.647				To be Acquired in favor of UNITED STATES FOREST SERVICE
TE-205A	JAMES E. BURNS & LINDA N. BURNS	P.O. BOX 242 SOUTH FORK, CO 81154	LOT 13, WOLF CREEK RANCH CABINS RECORDED AT REC.NO. 41740, A PART OF THE HOMESTEAD ENTRY SURVEY 273	0.044		0.044				Req'd. FOR ROADWAY AND DRAINAGE CONSTRUCTION
TE-205B	JAMES E. BURNS & LINDA N. BURNS	P.O. BOX 242 SOUTH FORK, CO 81154	LOT 13, WOLF CREEK RANCH CABINS RECORDED AT REC.NO. 41740, A PART OF THE HOMESTEAD ENTRY SURVEY 273	0.057		0.057				Req'd. FOR ROADWAY AND DRAINAGE CONSTRUCTION
6	Brock E. Schnebel, Trustee of the Brock E. Schnebel 1999 Trust under Agreement dated August 24, 1999 & Kelli R. Schnebel, Trustee of the Kelli R. Schnebel 1999 Trust under Agreement dated August 24, 1999	327 N.W. 18TH OKLAHOMA CITY, OK 73103	Tract 4, WOLF CREEK RANCHETTES, A PART OF THE HOMESTEAD ENTRY SURVEY 273							NO PARCEL

COLORADO DEPARTMENT OF TRANSPORTATION



Region 5
Address: 3803 North Main Avenue, Suite 300
Durango, Colorado 81301
Phone: (970) 385-1400 FAX: (970) 385-1410

Right of Way Plans Unit: Crumbaugh

Sheet Revisions		
mm/yy	xxxxx	xxx

Sheet Revisions		
mm/yy	xxxxx	xxx

Sheet Revisions		
mm/yy	xxxxx	xxx

Right of Way Plans				
Tabulation of Properties Sheet				
Project Number:		NH (CX)160-2(50) UNIT 2		
Project Location:		WOLF CREEK PASS EAST		
Project Code:		Last Mod. Date	Sheet No.	Total No. of Sheets
92977		---	2 of 4	2A 49

TABULATION OF PROPERTIES IN MINERAL & RIO GRANDE COUNTIES S.H. NO. 160

PARCEL NO.	OWNER	ADDRESS	LOCATION	AREA IN ACRES					BOOK-PAGE	REMARKS
				AREA OF PARCEL	EXISTING ROW	NET AREA	REMAINDER			
							LEFT	RIGHT		
			T.39 N, R.2 E, N.M.P.M.							
7	EDWARD J. KOPTA & JULIA L. KOPTA	8236 PASEO VISTA DRIVE LAS VEGAS, NV 89128	Tract 5, WOLF CREEK RANCHETTES, A PART OF THE HOMESTEAD ENTRY SURVEY 273							NO PARCEL
PE-208	ALICE S. LENICH LIVING TRUST, dated 1/10/2001	P.O. BOX 590 SOUTH FORK, CO 81154	Tract 6, WOLF CREEK RANCHETTES, A PART OF THE HOMESTEAD ENTRY SURVEY 273	0.039		0.039				Req'd. FOR CONSTRUCTION AND MAINTENANCE OF DRAINAGE STRUCTURE
PE-209	STEVEN S. PATTON & VALERIE L. PATTON	2418 HAWTHORNE DRIVE AMARILLO, TX 79109	Tract 7, WOLF CREEK RANCHETTES, A PART OF THE HOMESTEAD ENTRY SURVEY 273	0.032		0.032				Req'd. FOR CONSTRUCTION AND MAINTENANCE OF DRAINAGE STRUCTURE
TE-209	STEVEN S. PATTON & VALERIE L. PATTON	2418 HAWTHORNE DRIVE AMARILLO, TX 79109	Tract 7, WOLF CREEK RANCHETTES, A PART OF THE HOMESTEAD ENTRY SURVEY 273	0.061		0.061				Req'd. FOR ROADWAY AND DRAINAGE CONSTRUCTION
A-210	TERRY FULTON & TANA FULTON	P.O. BOX 1135 SOUTH FORK, CO 81154	LOT 1 & NORTH HALF LOT 2, WOLF CREEK RANCH DEVELOPMENT RECORDED AT REC. NO. 30098, A PART OF THE HOMESTEAD ENTRY SURVEY 273	0.138		0.138		0.349		
211A	UNITED STATES FOREST SERVICE		SECS 24, 25, 26, 34 & 35			65.952				RIO GRANDE NATIONAL FOREST
211B	UNITED STATES FOREST SERVICE		SEC 24			1.965				RIO GRANDE NATIONAL FOREST
TE-211A	UNITED STATES FOREST SERVICE		SEC 35			0.071				Req'd. FOR ROADWAY CONSTRUCTION
TE-211B	UNITED STATES FOREST SERVICE		SECS 25, 26, 34 & 35			8.736				Req'd. FOR ROADWAY CONSTRUCTION
TE-211C	UNITED STATES FOREST SERVICE		SECS 24, 25 & 26			2.606				Req'd. FOR ROADWAY CONSTRUCTION
TE-211D	UNITED STATES FOREST SERVICE		SECS 24, 25 & 26			1.015				Req'd. FOR WETLAND CONSTRUCTION
TE-211E	UNITED STATES FOREST SERVICE		SEC 24			5.038				Req'd. FOR WETLAND CONSTRUCTION
212	ROBERT E. CROSS	7309 E. 49th AVENUE E BRADENTON, FL. 34203	NORTH 1/2 OF THE SE 1/4 OF SEC 24, PART OF TRACT 40, T39N, R2E, N.M.P.M.	4.803	1.768	3.035	1.324	70.440		
TE-212	ROBERT E. CROSS	7309 E. 49th AVENUE E BRADENTON, FL. 34203	NORTH 1/2 OF THE SE 1/4 OF SEC 24, PART OF TRACT 40, T39N, R2E, N.M.P.M.	0.223		0.223				Req'd. FOR ROADWAY CONSTRUCTION
212-R	ROBERT E. CROSS	7309 E. 49th AVENUE E BRADENTON, FL. 34203	NORTH 1/2 OF THE SE 1/4 OF SEC 24, PART OF TRACT 40, T39N, R2E, N.M.P.M.	1.324		1.324				

DEPOSITED THIS DAY OF 19 AT M. FOR INFORMATION
ONLY IN BOOK OF THE COUNTY LAND SURVEYS/RIGHT OF WAY
SURVEYS AT PAGE RECEPTION NUMBER
RECORDED
DEPT.

c:\070022\DWGS\WCETAB.DWG, 08/19/2002 12:15:56 PM
datestamp

COLORADO DEPARTMENT OF TRANSPORTATION



Region 5
Address: 3803 North Main Avenue, Suite 300
Durango, Colorado 81301
Phone: (970) 385-1400 FAX: (970) 385-1410

Right of Way Plans Unit: Crumbaugh

Sheet Revisions

mm/yy	xxxxx	xxx

Sheet Revisions

mm/yy	xxxxx	xxx

Sheet Revisions

mm/yy	xxxxx	xxx

Right of Way Plans

Tabulation of Properties Sheet

Project Number:	NH (CX)160-2(50) UNIT 2			
Project Location:	WOLF CREEK PASS EAST			
Project Location:				
Project Code:	Last Mod. Date	Subset Sheets	Sheet No.	Total No. of Sheets
92977	---	3 of 4	2B	49

TABULATION OF PROPERTIES IN MINERAL & RIO GRANDE COUNTIES

S.H. NO. 160

PARCEL NO.	OWNER	ADDRESS	LOCATION	AREA IN ACRES					BOOK-PAGE	REMARKS
				AREA OF PARCEL	EXISTING ROW	NET AREA	REMAINDER			
							LEFT	RIGHT		
			T.39 N, R.2 E, N.M.P.M.							
213	ROBERT M. GOODNIGHT, MARJORIE N. GOODNIGHT & JEANETTE S. DAVIS	P.O. BOX 157 SOUTH FORK, CO 81154	PART OF THE SE 1/4 NE 1/4 SEC 24, PART OF TRACT 40, T39N, R2E, N.M.P.M.	1.210		1.210	12.891			
TE-213	ROBERT M. GOODNIGHT, MARJORIE N. GOODNIGHT & JEANETTE S. DAVIS	P.O. BOX 157 SOUTH FORK, CO 81154	PART OF THE SE 1/4 NE 1/4 SEC 24, PART OF TRACT 40, T39N, R2E, N.M.P.M.	0.470		0.470				Req'd. FOR ROADWAY CONSTRUCTION
214	LARRY EHARDT	BOX 82 SOUTH FORK, CO 81154	PART OF THE SE 1/4 NE 1/4 SEC 24, PART OF TRACT 40, T39N, R2E, N.M.P.M.	1.525		1.525	23.545	0.114		
TE-214	LARRY EHARDT	BOX 82 SOUTH FORK, CO 81154	PART OF THE SE 1/4 NE 1/4 SEC 24, PART OF TRACT 40, T39N, R2E, N.M.P.M.	0.192		0.192				Req'd. FOR ROADWAY CONSTRUCTION
TE-214B	LARRY EHARDT	BOX 82 SOUTH FORK, CO 81154	PART OF THE SE 1/4 NE 1/4 SEC 24, PART OF TRACT 40, T39N, R2E, N.M.P.M.	0.015		0.015				Req'd. FOR ROADWAY CONSTRUCTION
214-R	LARRY EHARDT	BOX 82 SOUTH FORK, CO 81154	PART OF THE SE 1/4 NE 1/4 SEC 24, PART OF TRACT 40, T39N, R2E, N.M.P.M.	0.114		0.114				
			T.39 N, R.3 E, N.M.P.M.							
215A	ROBERT LEE MURPHY	18172 EAST ADRIATIC PLACE AURORA, CO. 80013-4214	LOTS 14 & 15 SEC 19 T39N, R3E, N.M.P.M.	5.477	2.234	3.243	14.822			
TE-215A	ROBERT LEE MURPHY	18172 EAST ADRIATIC PLACE AURORA, CO. 80013-4214	LOTS 14 & 15 SEC 19 T39N, R3E, N.M.P.M.	0.744		0.744				Req'd. FOR ROADWAY CONSTRUCTION
TE-215B	ROBERT LEE MURPHY	18172 EAST ADRIATIC PLACE AURORA, CO. 80013-4214	LOTS 14 & 15 SEC 19 T39N, R3E, N.M.P.M.	0.251		0.251				Req'd. FOR ROADWAY CONSTRUCTION
215B	ROBERT LEE MURPHY	18172 EAST ADRIATIC PLACE AURORA, CO. 80013-4214	LOTS 14 & 15 SEC 19 T39N, R3E, N.M.P.M.	0.017		0.017	14.822	0.020		
TE-215C	ROBERT LEE MURPHY	18172 EAST ADRIATIC PLACE AURORA, CO. 80013-4214	LOTS 14 & 15 SEC 19 T39N, R3E, N.M.P.M.	0.008		0.008				Req'd. FOR ROADWAY CONSTRUCTION
16	MARCEL A. POULAIN & MARIE H. POULAIN	301 BAYLOR BORGER, TX 79007	A PART OF LOT 14 SEC 19, T39N, R3E, N.M.P.M.	1.1	0.2	0.9				
16A-X			A PART OF LOT 14 SEC 19, T39N, R3E, N.M.P.M.	0.163						EXCESS PARCEL TO BE SOLD. NOT TO BE SOLD UNTIL AFTER COMPLETION OF PROJECT NH(CX)160-2(50) UNIT 2
16B-X			A PART OF LOT 14 SEC 19, T39N, R3E, N.M.P.M.	0.171						EXCESS PARCEL TO BE SOLD. NOT TO BE SOLD UNTIL AFTER COMPLETION OF PROJECT NH(CX)160-2(50) UNIT 2
217A	FUN VALLEY INC.	P.O. BOX 208 SOUTH FORK, CO 81154	LOT 15, SEC 19 T39N, R3E, N.M.P.M.	0.509		0.509		175.450		

COLORADO DEPARTMENT OF TRANSPORTATION



Region 5
Address: 3803 North Main Avenue, Suite 300
Durango, Colorado 81301
Phone: (970) 385-1400 FAX: (970) 385-1410

Right of Way Plans Unit: Crumbaugh

Sheet Revisions

mm/yy	xxxxx	xxx

Sheet Revisions

mm/yy	xxxxx	xxx

Sheet Revisions

mm/yy	xxxxx	xxx

Right of Way Plans

Tabulation of Properties Sheet

Project Number:	NH (CX)160-2(50) UNIT 2
Project Location:	WOLF CREEK PASS EAST
Project Code:	92977
Last Mod. Date:	---
Subset Sheets:	4 of 4
Sheet No.:	2C
Total No. of Sheets:	49

TABULATION OF PROPERTIES IN MINERAL & RIO GRANDE COUNTIES

S.H. NO. 160

PARCEL NO.	OWNER	ADDRESS	LOCATION	AREA IN ACRES					BOOK-PAGE	REMARKS
				AREA OF PARCEL	EXISTING ROW	NET AREA	REMAINDER			
							LEFT	RIGHT		
			T.39 N, R.3 E, N.M.P.M.							
TE-217A	FUN VALLEY INC.	P.O. BOX 208 SOUTH FORK, CO 81154	TRACTS 53, 54, & 55 SEC's 19 & 20 T39N, R3E, N.M.P.M.	0.010		0.010				Req'd. FOR ROADWAY CONSTRUCTION
PE-217	FUN VALLEY INC.	P.O. BOX 208 SOUTH FORK, CO 81154	TRACTS 53, 54, & 55 SEC's 19 & 20 T39N, R3E, N.M.P.M.	0.054		0.054				Req'd. FOR CONSTRUCTION AND MAINTENANCE OF DRAINAGE STRUCTURE
217B	FUN VALLEY INC.	P.O. BOX 208 SOUTH FORK, CO 81154	TRACTS 53, 54, & 55 SEC's 19 & 20 T39N, R3E, N.M.P.M.	17.194	7.690	9.504	22.998	175.450		
TE-217B	FUN VALLEY INC.	P.O. BOX 208 SOUTH FORK, CO 81154	TRACTS 53, 54, & 55 SEC's 19 & 20 T39N, R3E, N.M.P.M.	1.993		1.993				Req'd. FOR ROADWAY CONSTRUCTION
TE-217C	FUN VALLEY INC.	P.O. BOX 208 SOUTH FORK, CO 81154	TRACTS 53, 54, & 55 SEC's 19 & 20 T39N, R3E, N.M.P.M.	0.331		0.331				Req'd. FOR ROADWAY CONSTRUCTION
TE-217D	FUN VALLEY INC.	P.O. BOX 208 SOUTH FORK, CO 81154	TRACTS 53, 54, & 55 SEC's 19 & 20 T39N, R3E, N.M.P.M.	1.097		1.097				Req'd. FOR ROADWAY CONSTRUCTION
TE-217E	FUN VALLEY INC.	P.O. BOX 208 SOUTH FORK, CO 81154	TRACTS 53, 54, & 55 SEC's 19 & 20 T39N, R3E, N.M.P.M.	1.422		1.422				Req'd. FOR ROADWAY CONSTRUCTION
			T.39 N, R.2 E, N.M.P.M.							
TE-218	TERRY FULTON AND TANA FULTON, 1/4 INTEREST CHARLES T. JACKSON AND BARBARA K. JACKSON REVOKABLE TRUST, 1/4 INTEREST C.V.Dellinger Jr. and wife Juanice Dellinger, 1/12 INTEREST A.Dwain Farr and wife Nancy Gail Farr, 1/12 INTEREST Thomas E. Wellborn and wife Carolyn Wellborn, 1/12 INTEREST STEVEN S. PATTON & VALERIE L. PATTON, 1/4 INTEREST	P.O.BOX 1135 SOUTH FORK, CO. 81154 P.O.BOX 5164 OVILLA, TX. 75154 1425 MEADOWS LANE MIDLOTHIAN, TX. 76065 4102 GLEN ROSE GARLAND, TX. ROUTE 2 MIDLOTHIAN, TX. 76065 2418 HAWTHORNE DRIVE AMARILLO, TX 79109	COLUMBINE DRIVE (WOLF CREEK RANCH ACCESS EASEMENT)	0.053		0.053				Req'd. FOR ROADWAY AND DRAINAGE CONSTRUCTION
			T.39 N, R.3 E, N.M.P.M.							
219	UNITED STATES FOREST SERVICE		SEC 19			0.050				
TE-219	UNITED STATES FOREST SERVICE		SEC 19			0.197				Req'd. FOR ROADWAY CONSTRUCTION
			T.39 N, R.2 E, N.M.P.M.							
220	UNITED STATES FOREST SERVICE		SECS 24, 25, 26, 34 & 35			0.639				

TOTAL SURVEY CONTROL
U.S. HWY. 160 MP 173.8 to MP 181.2

TABULATION OF PROJECT CONTROL MONUMENTS

RIO GRANDE COUNTY
SECTIONS 17, 19, AND 20, T. 39 N., R. 3 E., N.M.P.M.

MINERAL COUNTY
R. 2 E., N.M.P.M.

SURVEY CONTROL GROUP 1 (ORIG CDOT 1992 -RESET 1998 BY CONSULTANT)

POINT	NORTHING(m)	EASTING(m)	ELEV.(m)	DESCRIPTION
091	105960.970	504382.704	2591.915	83mm CDOT AL. CAP (Type 1)
090	105955.422	504170.383	2580.487	83mm CDOT AL. CAP (Type 1)
089	105775.730	503889.946	2572.003	83mm CDOT AL. CAP (Type 1)
088	105663.283	503667.987	2567.822	83mm CDOT AL. CAP (Type 1)
087	105530.098	503473.322	2567.365	83mm CDOT AL. CAP (Type 1)
086	105442.335	503150.278	2565.844	83mm CDOT AL. CAP (Type 1)
085	105417.069	502899.607	2567.733	83mm CDOT AL. CAP (Type 1)
084	105429.349	502627.839	2569.312	83mm CDOT AL. CAP (Type 1)
083	105252.261	502130.642	2575.068	83mm CDOT AL. CAP (Type 1)
983	105372.047	502305.460	2572.838	83mm CDOT AL. CAP (Type 1)
082	105020.528	501910.838	2578.026	83mm CDOT AL. CAP (Type 1)
081	104890.921	501773.289	2582.920	83mm CDOT AL. CAP (Type 1)

SURVEY CONTROL GROUP 2 (SET IN 1995 BY CDOT FORCES)

POINT	NORTHING(m)	EASTING(m)	ELEV.(m)	DESCRIPTION
755	101563.321	499161.099	2624.376	83mm CDOT AL. CAP (Type 1)
246	101848.469	499482.755	2619.621	83mm CDOT AL. CAP (Type 1)
247	101934.161	499674.701	2615.427	83mm CDOT AL. CAP (Type 1)
248	102223.897	500002.972	2609.629	83mm CDOT AL. CAP (Type 1)
249	102413.050	500203.623	2606.572	83mm CDOT AL. CAP (Type 1)
005	102620.768	500473.248	2603.084	83mm CDOT AL. CAP (Type 1)
771	102867.057	500794.687	2605.099	83mm CDOT AL. CAP (Type 1)
772	103001.921	500909.038	2604.706	83mm CDOT AL. CAP (Type 1)
754	103103.779	501076.438	2601.722	83mm CDOT AL. CAP (Type 1)
753	103220.620	501189.629	2604.806	83mm CDOT AL. CAP (Type 1)
752	103399.502	501265.422	2597.741	83mm CDOT AL. CAP (Type 1)
751	103566.163	501241.437	2596.049	83mm CDOT AL. CAP (Type 1)
750	103650.977	501287.153	2594.382	83mm CDOT AL. CAP (Type 1)
760	103944.663	501471.032	2588.059	83mm CDOT AL. CAP (Type 1)
770	104157.650	501485.251	2586.685	83mm CDOT AL. CAP (Type 1)
780	104283.403	501538.023	2584.113	83mm CDOT AL. CAP (Type 1)
790	104579.644	501589.258	2582.737	83mm CDOT AL. CAP (Type 1)
800	104760.072	501622.704	2601.274	83mm CDOT AL. CAP (Type 1)

SURVEY CONTROL GROUP 3 (SET IN 1997 BY CONSULTANT)

POINT	NORTHING(m)	EASTING(m)	ELEV.(m)	DESCRIPTION
8009	97396.017	497459.573	2794.771	83mm CDOT AL. CAP (Type 1)
8010	97682.824	497419.044	2796.484	83mm CDOT AL. CAP (Type 1)
8011	98038.352	497485.523	2797.455	83mm CDOT AL. CAP (Type 1)
8012	98349.840	497414.686	2771.569	83mm CDOT AL. CAP (Type 1)
8013	98587.576	497210.673	2755.423	83mm CDOT AL. CAP (Type 1)
8014	98833.614	497141.904	2740.209	83mm CDOT AL. CAP (Type 1)
8015	98977.810	497148.595	2731.045	83mm CDOT AL. CAP (Type 1)
8016	99226.341	497075.832	2719.046	83mm CDOT AL. CAP (Type 1)
8017	99507.655	497206.530	2707.463	83mm CDOT AL. CAP (Type 1)
8018	99640.917	497470.306	2701.890	83mm CDOT AL. CAP (Type 1)
8019	99770.876	497578.159	2695.487	83mm CDOT AL. CAP (Type 1)
8020	99951.815	497629.494	2690.955	83mm CDOT AL. CAP (Type 1)
8021	100090.224	497712.769	2686.622	83mm CDOT AL. CAP (Type 1)
8022	100261.391	497794.722	2684.163	83mm CDOT AL. CAP (Type 1)
8023	100509.726	497962.795	2674.301	83mm CDOT AL. CAP (Type 1)
8024	100570.630	498132.132	2671.134	83mm CDOT AL. CAP (Type 1)
8040	100684.734	498301.857	2664.208	83mm CDOT AL. CAP (Type 1)
8025	100837.159	498439.683	2658.443	83mm CDOT AL. CAP (Type 1)
8026	100951.050	498560.490	2657.810	83mm CDOT AL. CAP (Type 1)
8027	101082.621	498726.080	2646.866	83mm CDOT AL. CAP (Type 1)
8028	101357.489	498917.232	2629.794	83mm CDOT AL. CAP (Type 1)

GENERAL NOTES

- NOTE: This Control Survey is not a boundary survey or right-of-way survey and is prepared for the use of the Colorado Department of Transportation and their designated Consultants.
- NOTICE: According to Colorado law you must commence any legal action based upon any defect in this survey within three years after you first discover such defect. In no event may any action based upon any defect in this survey be commenced more than ten years from the date of the certification shown hereon.
- NOTE: No warranty is implied or expressed unless this sheet bears the original signature(s) and seal(s) of all of the Professional Land Surveyor's in responsible charge for their part of the survey work as indicated by the signature blocks.
- NOTE: Field survey was established by conventional total-station angle and distance measurements. Raw data precision is computed to exceed 1:20000 or meet the minimum horizontal control tolerances of a Type B Survey and the vertical control accuracy as listed in the Colorado Department of Transportation Survey Manual Chapter 3 (Rev. 4/29/92).
- NOTE: It is possible that some of the survey control monuments listed are subject to movement, have been disturbed, or have been obliterated. It is the user's responsibility to verify the existence and stability of the control monuments.
- NOTE: All coordinates listed are PROJECT COORDINATES ONLY. Coordinates are determined from traverse calculations and are NOT derived from GPS observations.

BASIS OF BEARINGS

Note: All of the Project Control is based on a common basis of bearing originating at two FHWA control points near MP 183 and carried by conventional total-station angle & distance traverse. The original bearing is a line between FHWA T-70 (obliterated) and FHWA T-69 (obliterated). Reference bearing: S. 35°54'55" W.

GROUP 1 (MP 179.4 to 181.3) : A line between Project Control Point No. 91 (a CDOT 3.25" Al. Cap) and Project Control Point No. 88 (a CDOT 3.25" Al. Cap). Reference bearing: S. 67°23'16" W., 774.233 METERS.

GROUP 2 (MP 176.7 to 179.4) : A line between Project Control Point No. 780 (a CDOT 3.25" Al. Cap) and Project Control Point No. 800 (a CDOT 3.25" Al. Cap). Reference bearing: N. 10°04'25" E., 484.133 METERS.

GROUP 3 (MP 174.9 to 176.7) : A line between Project Control Point No. 8027 (a CDOT 3.25" Al. Cap) and Project Control Point No. 8028 (a CDOT 3.25" Al. Cap). Reference bearing: N. 34°48'58" E., 334.801 METERS.

BASIS OF ELEVATIONS

NOTE: All elevations are based on ties to USC&GS BM U-161 found in the project corridor. The datum used was NGVD 29 elevations in feet as listed on the NGS datum sheets prior to current NAVD 88 datum sheets. The units were converted to metric using the U.S. Survey feet to metric factor.

GROUP 1 (MP 179.4 to 181.3): Based on Group 2 Control Point No. 790 (CDOT Type 1). Reference elevation: 2582.737m. Bench Levels run 1998 by consultant.

GROUP 2 (MP 176.7 to 179.4): Based on a tie to USC&GS BM U-161 (Brass disk in concrete). Reference elevation: 2596.895m (8519.98'). Bench Levels run 1995 by CDOT forces.

GROUP 3 (MP 174.9 to 176.7): Based on Group 2 Control Point No. 755 (CDOT Type 1). Reference elevation: 2624.376m. Bench Levels run 1997 by consultant.

CONSULTANT'S SURVEYOR'S STATEMENT
CONTROL GROUPS 1, 2, 3, and 4 photogrammetric control set under my supervision and checking.
NAME: *[Signature]*
DATE: *4-7-00*

Computer File Information		Sheet Revisions		Colorado Department of Transportation  Region 5	As Constructed	TOTAL SURVEY CONTROL	Project No./Code NH(CX) 160-2(50) Unit: 92977
Creation Date: 12\10\97	Initials: ACW	(R-X) mm/dd/yy XXXXX	XXX		No Revisions: mm/dd/yy		
Last Modification Date: 1\11\00	Initials: ACW	(R-X) mm/dd/yy XXXXX	XXX		Revised: mm/dd/yy		
Full Path: P5-166\C:\PROJECTS\10016\SCD_DWG		(R-X) mm/dd/yy XXXXX	XXX		Void: mm/dd/yy		
Drawing File Name: 92977_3.DWG		(R-X) mm/dd/yy XXXXX					Sheet Subset: T.S.C. Subset Sheets: 1 of 4 Sheet Number 3
Acad Ver. R13C4 Scale: NTS Units: METRIC		(R-X) mm/dd/yy XXXXX					

TOTAL SURVEY CONTROL
U.S. HWY. 160 MP 173.8 to MP 181.2
RIO GRANDE COUNTY
SECTIONS 17, 19, AND 20, T. 39 N., R. 3 E., N.M.P.M.
MINERAL COUNTY
R. 2 E., N.M.P.M.

TABULATION OF COLORADO H.A.R.N. GPS POINTS NEAR THE PROJECT

GEODETIC POSITIONS ARE BASED ON PRELIMINARY DATA OBTAINED FROM CDOT. THIS DATA HAS NOT BEEN APPROVED OR ACCEPTED BY THE NATIONAL GEODETIC SURVEY FOR INCLUSION IN THE COLORADO H.A.R.N. AT THIS TIME (FEB. 4, 1998).

STATION	LATITUDE	LONGITUDE	ELLIPSOID HEIGHT	STATE PLANE COORDINATES:				NAD83(92) CO. SO. ZONE
				NORTH	EAST	MAPPING ANGLE	SCALE FACTOR	
LENICH	37°38'06.17450"	106°40'24.73443"		412925.700	810826.204	-0°43'11.36"	0.99995141	
MCGEE	37°34'35.42497"	106°45'01.25732"		406517.075	803960.263	-0°46'00.97"	0.99995545	
MARTINEZ	37°31'38.67148"	106°46'12.51642"		401092.088	802137.885	-0°46'44.68"	0.99995965	

GENERAL NOTES

- NOTE: This Control Survey is not a boundary survey or right-of-way survey and is prepared for the use of the Colorado Department of Transportation and their designated Consultants.
- NOTE: It is possible that some of the survey control monuments listed are subject to movement, have been disturbed, or have been obliterated. It is the user's responsibility to verify the existence and stability of the control monuments.
- NOTE: All coordinates listed are PROJECT COORDINATES ONLY. Coordinates are determined from traverse calculations and are NOT derived from GPS observations. GPS observations were carried out to establish a relationship between the PROJECT CONTROL and NAD83 Colorado South Zone State Plane Coordinates for the purpose of positioning some aerial panel points. The transformation parameters used for that purpose are:
COMBINED SCALE FACTOR APPLIED TO ALL STATE PLANE COORDS: 1.000453898
REDUCTION APPLIED TO NORTHING AFTER SCALING: 304,943.132
REDUCTION APPLIED TO EASTING AFTER SCALING: 304,881.188
ROTATION: NONE
- NOTE: Aerial Panel Point Coordinates are carried to 3 decimal places for calculation purposes only. Actual field precision is in the order of a CDOT Type B Survey (+/- 8cm).

AERIAL PANEL POINTS (SET IN 1997 BY CONSULTANT)

POINT	NORTHING(m)	EASTING(m)	ELEV.(m)	DESCRIPTION
0010	106629.223	505042.668	2574.968	2" Al. Cap CAJE LS 29431 PP10
0011	106411.503	504816.251	2590.746	2" Al. Cap CAJE LS 29431 PP11
0012	105976.846	505087.023	2557.085	12" Spike
0013	106029.231	504555.509	2593.214	CDOT 3.25" Al. Cap "53"
0014	106058.150	503930.829	2656.561	12" Spike
0015	105740.251	504113.954	2558.555	12" Spike
0016	105576.194	503532.079	2567.147	2" Al. Cap CAJE LS 29431 PP16
0017	105624.548	502870.193	2603.841	PK Nail
0018	105428.845	502956.581	2567.356	2" Al. Cap CAJE LS 29431 PP18
0019	105255.077	503040.994	2575.377	12" Spike
0020	105197.806	501771.036	2662.948	GPS
0021	105022.882	501914.439	2577.879	12" Spike
0022	104873.311	502084.426	2608.733	PK Nail
0023	104255.754	501298.754	2705.669	PK Nail w/ 1.5" brass washer
0024	104108.396	501477.817	2587.302	
0025	104063.132	501783.519	2676.489	PK Nail
0026	103566.163	501241.437	2596.049	
0027	103317.122	501400.302	2592.472	12" Spike
0028	103067.677	501617.916	2606.071	12" Spike
0029	102795.201	500544.442	2673.342	PK Nail w/ 1.5" brass washer
0030	102564.641	500762.942	2657.913	PK Nail w/ 1.5" brass washer
0031	102264.118	499881.166	2678.606	PK Nail w/ 1.5" brass washer
0032	102080.837	500199.199	2642.930	12" Spike
0033	101719.330	499327.968	2621.635	
0034	101391.288	498759.348	2732.612	PK Nail w/ 1.5" brass washer
0035	101075.990	499071.009	2691.111	12" Spike
0036	100394.294	497692.063	2768.648	PK Nail w/ 1.5" brass washer
0037	100056.641	498077.735	2856.086	PK Nail w/ 1.5" brass washer
0038	99599.609	497370.366	2704.379	2" Al. Cap CAJE LS 29431
0039	99382.069	496883.910	2808.716	PK Nail w/ 1.5" brass washer
0040	99188.126	496900.617	2720.424	2" Al. Cap CAJE LS 29431
0041	99146.725	497089.193	2721.857	1.5" Al. Cap CAJE
0042	98395.041	497267.449	2806.138	PK Nail w/ 1.5" brass washer
0043	98466.590	497319.759	2764.628	2" Al. Cap CAJE LS 29431
0044	98525.963	497542.103	2877.472	12" Spike
0045	97618.928	497228.483	2833.733	12" Spike
0046	97722.537	497649.513	2859.878	12" Spike
0047	97510.062	497652.602	2870.084	12" Spike
0100	107587.622	504399.470	2798.815	12" Spike
0101	106191.286	505341.797	2563.693	2" Al. Cap CAJE LS 29431 PP101
0102	105406.763	502342.564	2572.294	2" Al. Cap CAJE LS 29431
0103	103220.620	501189.629	2604.806	CDOT 3.25" Al. Cap "753"
0104	102110.585	501335.054	2635.051	12" Spike
0105	100832.836	498436.181	2658.686	12" Spike
0106	98531.806	496113.449	2751.949	2" Al. Cap CAJE LS 29431
0107	97387.361	497354.918	2804.564	12" Spike

Computer File Information			Sheet Revisions			As Constructed			Project No./Code		
Creation Date:	12\10\97	Initials: ACW	(R-X)	mm/dd/yy	XXXXX	XXX	No Revisions:	mm/dd/yy	TOTAL SURVEY CONTROL		
Last Modification Date:	1\11\00	Initials: ACW	(R-X)	mm/dd/yy	XXXXX	XXX	Revised:	mm/dd/yy			
Full Path:	P5-166\C:\PROJECTS\10016\SCD_DWG		(R-X)	mm/dd/yy	XXXXX	XXX	Void:	mm/dd/yy			
Drawing File Name:	92977_3.DWG		(R-X)	mm/dd/yy	XXXXX	XXX					
Acad Ver. R13C4	Scale: NTS	Units: METRIC	(R-X)	mm/dd/yy	XXXXX	XXX			Sheet Subset:	T.S.C.	Subset Sheets: 2 of 4
										Sheet Number	3A


Colorado Department of Transportation
3803 N. Main Street, Suite 300
Durango, CO 81301
Phone: (970) 385-1400
Fax: (970) 385-1410
Region 5

TOTAL SURVEY CONTROL DIAGRAM

U.S. HWY. 160 MP 173.8 to MP 181.2


RIO GRANDE COUNTY
SECTIONS 17, 19, AND 20, T. 39 N., R. 3 E., N.M.P.M.

MINERAL COUNTY
R. 2 E., N.M.P.M.

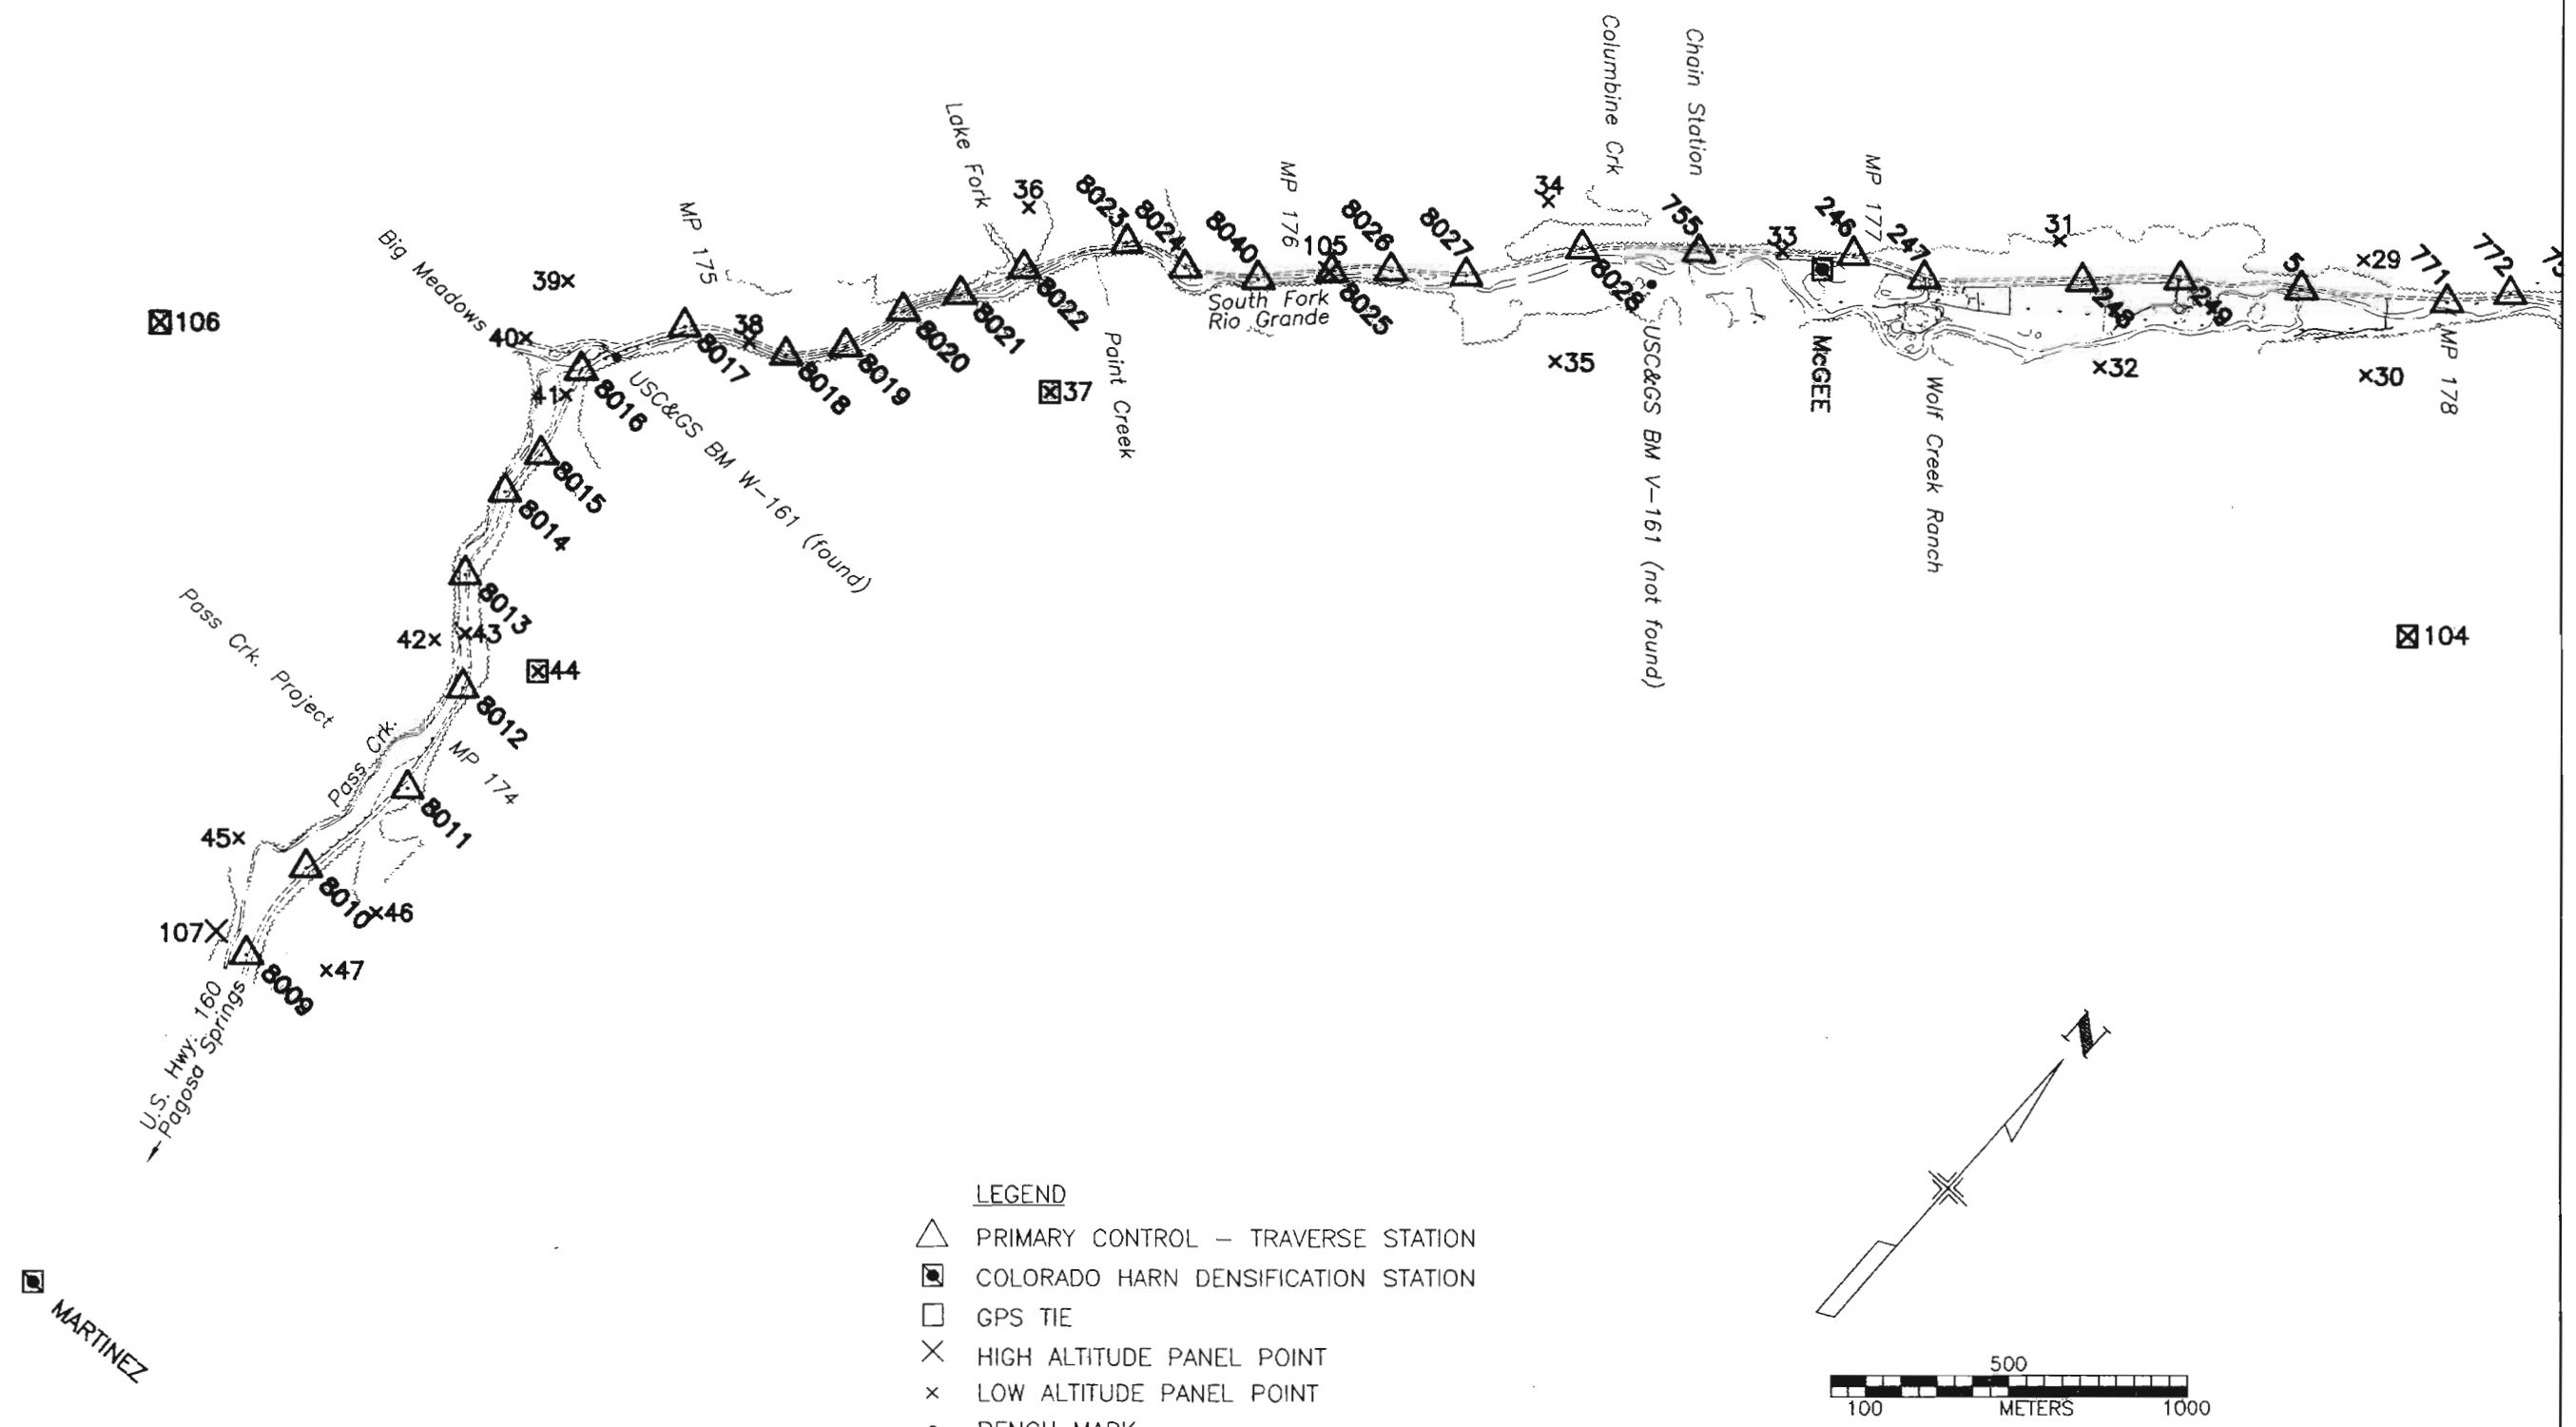

LEGEND

- △ PRIMARY CONTROL – TRAVERSE STATION
- COLORADO HARN DENSIFICATION STATION
- GPS TIE
- × HIGH ALTITUDE PANEL POINT
- × LOW ALTITUDE PANEL POINT
- BENCH MARK

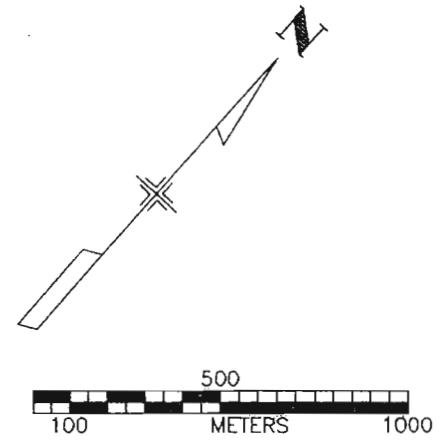

Computer File Information

Creation Date:	12/10/97	Initials:	ACW
Last Modification Date:	1/11/00	Initials:	ACW
Full Path:	P6-155\\C:\PROJECTS\10016\SCD_DWG		
Drawing File Name:	92977_3b.DWG		
Acad Ver.	R13C4	Scale:	1:1000
		Units:	METRIC

Sheet Revisions

Rev	Date	Description	By
(R-X)	mm/dd/yy	XXXXX	XXX
(R-X)	mm/dd/yy	XXXXX	XXX
(R-X)	mm/dd/yy	XXXXX	XXX
(R-X)	mm/dd/yy	XXXXX	XXX
(R-X)	mm/dd/yy	XXXXX	XXX

Colorado Department of Transportation



3803 N. Main Street, Suite 300
Durango, CO 81301
Phone: (970) 385-1400
Fax: (970) 385-1410

Region 5

As Constructed

No Revisions:	mm/dd/yy
Revised:	mm/dd/yy
Void:	mm/dd/yy


TOTAL SURVEY CONTROL DIAGRAM

Sheet Subset:	T.S.C.	Subset Sheets:	3 of 4
---------------	--------	----------------	--------

Project No./Code

NH(CX) 160-2(50) Unit:
92977
Sheet Number 3B

TOTAL SURVEY CONTROL DIAGRAM
 U.S. HWY. 160 MP 173.8 to MP 181.2
 RIO GRANDE COUNTY
 SECTIONS 17, 19, AND 20, T. 39 N., R. 3 E., N.M.P.M.
 MINERAL COUNTY
 R. 2 E., N.M.P.M.

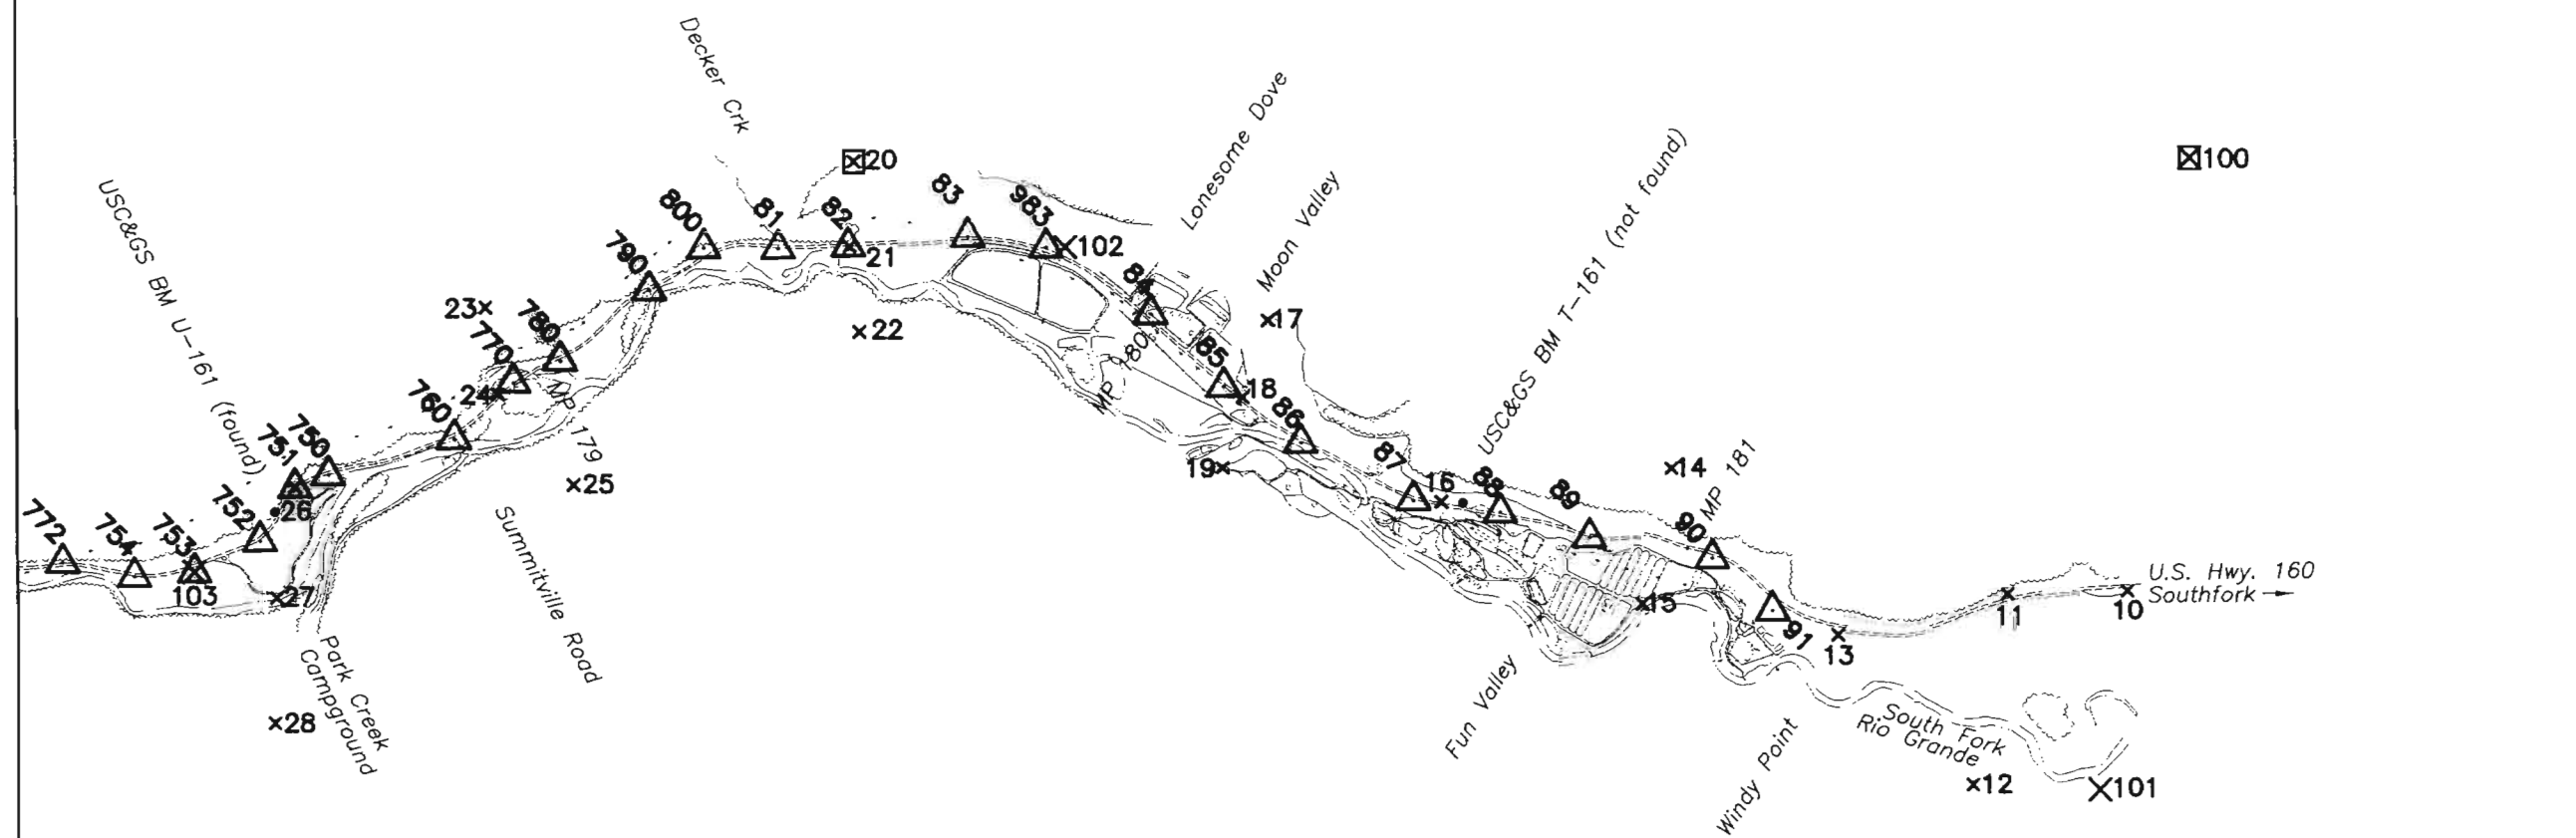

COLORADO DEPARTMENT OF TRANSPORTATION



Region 5
Address: 3803 North Main Avenue, Suite 300
Durango, Colorado 81301
Phone: (970) 385-1400 FAX: (970) 385-1410

Right of Way Plans Unit: Crumbaugh

Sheet Revisions

mm/yy	xxxxx	xxx

Sheet Revisions

mm/yy	xxxxx	xxx

Sheet Revisions

mm/yy	xxxxx	xxx

Right of Way Plans

Land Survey Control Diagram

Project Number:		NH (CX)160-2(50) UNIT 2		
Project Location:		WOLF CREEK PASS EAST		
Project Location:				
Project Code:	Last Mod. Date	Subset Sheets	Sheet No.	Total No. of Sheets
92977	---	1 of 3	30	49

T.39 N, R.2 E, NMPM


T.39 N, R.3 E, NMPM

TABULATION OF FOUND BOUNDARY EVIDENCE

Pt.#	Northing	Easting	Description
3008	347489.081	1654063.109	ROW MON
3011	347626.532	1654561.874	ROW MON
3012	347810.145	1654427.022	ROW MON
3013	347803.207	1654306.860	CDOT 1-1/2"AC
3018	347808.785	1654698.861	ROW MON
3020	347808.176	1654658.944	ROW MON
3059	345836.109	1650046.738	ROW MON
3060	345916.888	1650057.524	ROW MON
3133	343598.667	1645731.171	ROW MON
3134	343957.372	1645913.760	ROW MON
3140	345859.223	1648447.995	ROW MON
3141	345779.553	1648459.074	ROW MON

Pt.#	Northing	Easting	Description
3083	332268.491	1638097.520	STONE - HES273/3
3084	333251.145	1637365.172	STONE - HES273/4
3085	334120.269	1638794.293	LS 5442
3090	334638.905	1639223.091	LS 5442
3093	334482.888	1639289.918	LS 5442
3103	334930.938	1640003.424	LS 5442
3119	335646.113	1640749.798	LS 5442
3120	335627.324	1641542.271	STONE - HES273/2
3121	336102.074	1641182.075	3/4IN STEEL ROD - HES273/1
3125	335986.144	1641269.910	LS 5442
3126	335855.589	1641180.852	LS 5442
3127	335946.303	1641300.267	LS 5442
3129	335626.407	1641292.094	1/2 GROUND ROD
3131	335785.590	1641171.351	1/2 GROUND ROD

Pt.#	Northing	Easting	Description
3000	347661.800	1653906.819	LS 10402
3004	346996.884	1655111.192	GLOMON - TR54/6,TR55/3
3005	348304.494	1655134.663	GLOMON - TR54/1,TR55/2
3009	348320.388	1653921.327	USFSMON
3023	347011.096	1652686.762	USFSMON - TR54/5,TR55/4
3024	346602.429	1651459.383	USFSMON - LOT15
3027	346619.458	1650116.262	GLO BC - W/4 SEC19
3028	347020.534	1650112.805	BLM 2-1/2 IN - TR40/1
3031	345736.628	1648809.678	3-1/4 BLM AC - TR40/3
3037	345756.218	1647490.365	BLM BC 3-1/4 AC - TR40/4
3058	345716.230	1650128.141	E/4 SEC24
3064	344441.198	1650064.329	GLOMON - TR53/3
3068	346136.632	1649233.906	LS 13389
3137	344504.645	1647474.670	BLM - WC TR40/5
3138	347088.626	1648772.079	BLM MON - TR40/2
3164	345697.710	1651443.472	GLO BRASS CAP - TR53/1,TR54/3,LOT 15

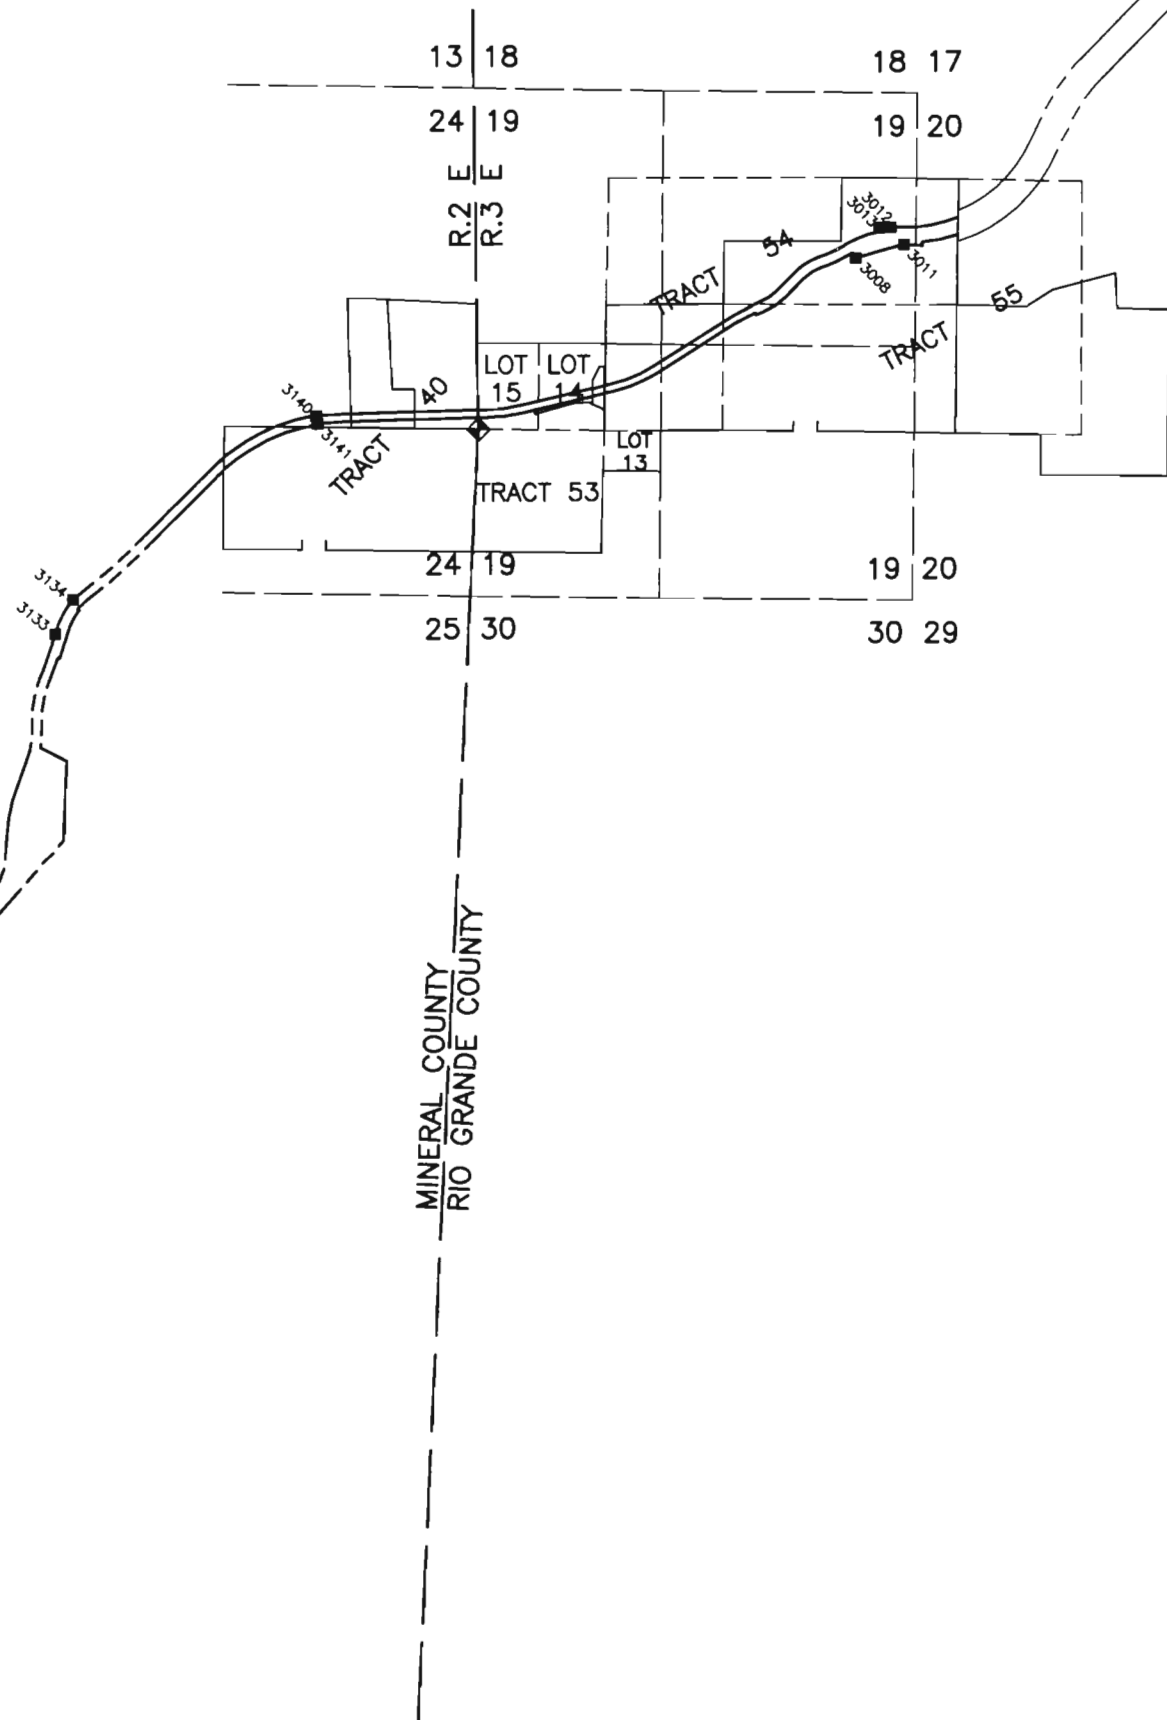

HOMESTEAD ENTRY SURVEY 273

T.39 N
T.38 N

DEPOSITED THIS 18 DAY OF AT 11:50 AM FOR INFORMATION
ONLY IN BOOK OF THE COUNTY LAND SURVEYS/RIGHT OF WAY
SURVEYS AT PAGE RECEPTION NUMBER
SHOWN DEPT.

COLORADO DEPARTMENT OF TRANSPORTATION



Region 5
Address: 3803 North Main Avenue, Suite 300
Durango, Colorado 81301
Phone: (970) 385-1400 FAX: (970) 385-1410

Right of Way Plans Unit: Crumbaugh

Sheet Revisions

mm/yy	xxxxx	xxx

Sheet Revisions

mm/yy	xxxxx	xxx

Sheet Revisions



mm/yy	xxxxx	xxx

Right of Way Plans

Land Survey Control Diagram

Project Number:	NH (CX)160-2(50) UNIT 2
Project Location:	WOLF CREEK PASS EAST
Project Location:	
Project Code:	92977
Last Mod. Date:	---
Subset Sheets:	2 of 3
Sheet No.:	3E
Total No. of Sheets:	49

T.39 N, R.2 E, NMPM

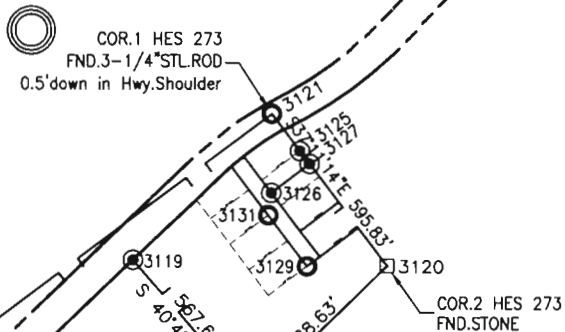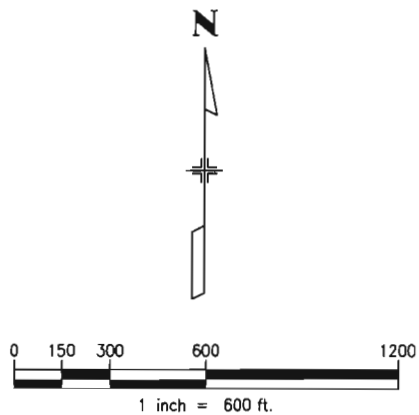

HOMESTEAD ENTRY SURVEY 273
Approved April 30, 1918

COR.4 HES 273
FND.STONE

3084 L

3083

COR.3 HES 273
FND.12"x6"x18"Stone
in a ring of stones



T.39 N
T.38 N

T.38 N, R.2 E, NMPM

DEPOSITED THIS ____ DAY OF ____ AT ____ FOR INFORMATION
ONLY IN BOOK ____ OF THE COUNTY LAND SURVEYS/RIGHT OF WAY
SURVEYS AT PAGE ____ RECEPTION NUMBER ____

DRAWN BY ____
DEPT. ____

COLORADO DEPARTMENT OF TRANSPORTATION



Region 5
Address: 3803 North Main Avenue, Suite 300
Durango, Colorado 81301
Phone: (970) 385-1400 FAX: (970) 385-1410

Right of Way Plans Unit: Crumbaugh

Sheet Revisions

mm/yy	xxxxx	xxx

Sheet Revisions

mm/yy	xxxxx	xxx


Sheet Revisions

mm/yy	xxxxx	xxx

Right of Way Plans

Land Survey Control Diagram

Project Number:	NH (CX)160-2(50) UNIT 2
Project Location:	WOLF CREEK PASS EAST
Project Code:	92977
Last Mod. Date:	---
Subset Sheets:	3 of 3
Sheet No.:	3F
Total No. of Sheets:	49

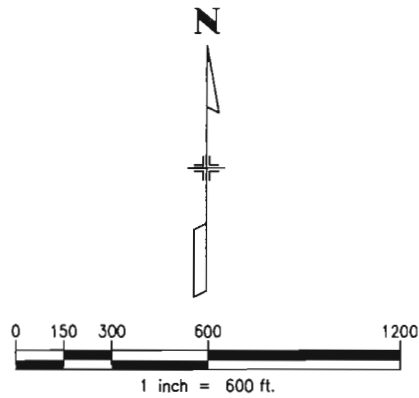

T.39 N, R.2 E, NMPM


13 18

T.39 N, R.3 E, NMPM

18 17

19 20

MINERAL COUNTY
RIO GRANDE COUNTY

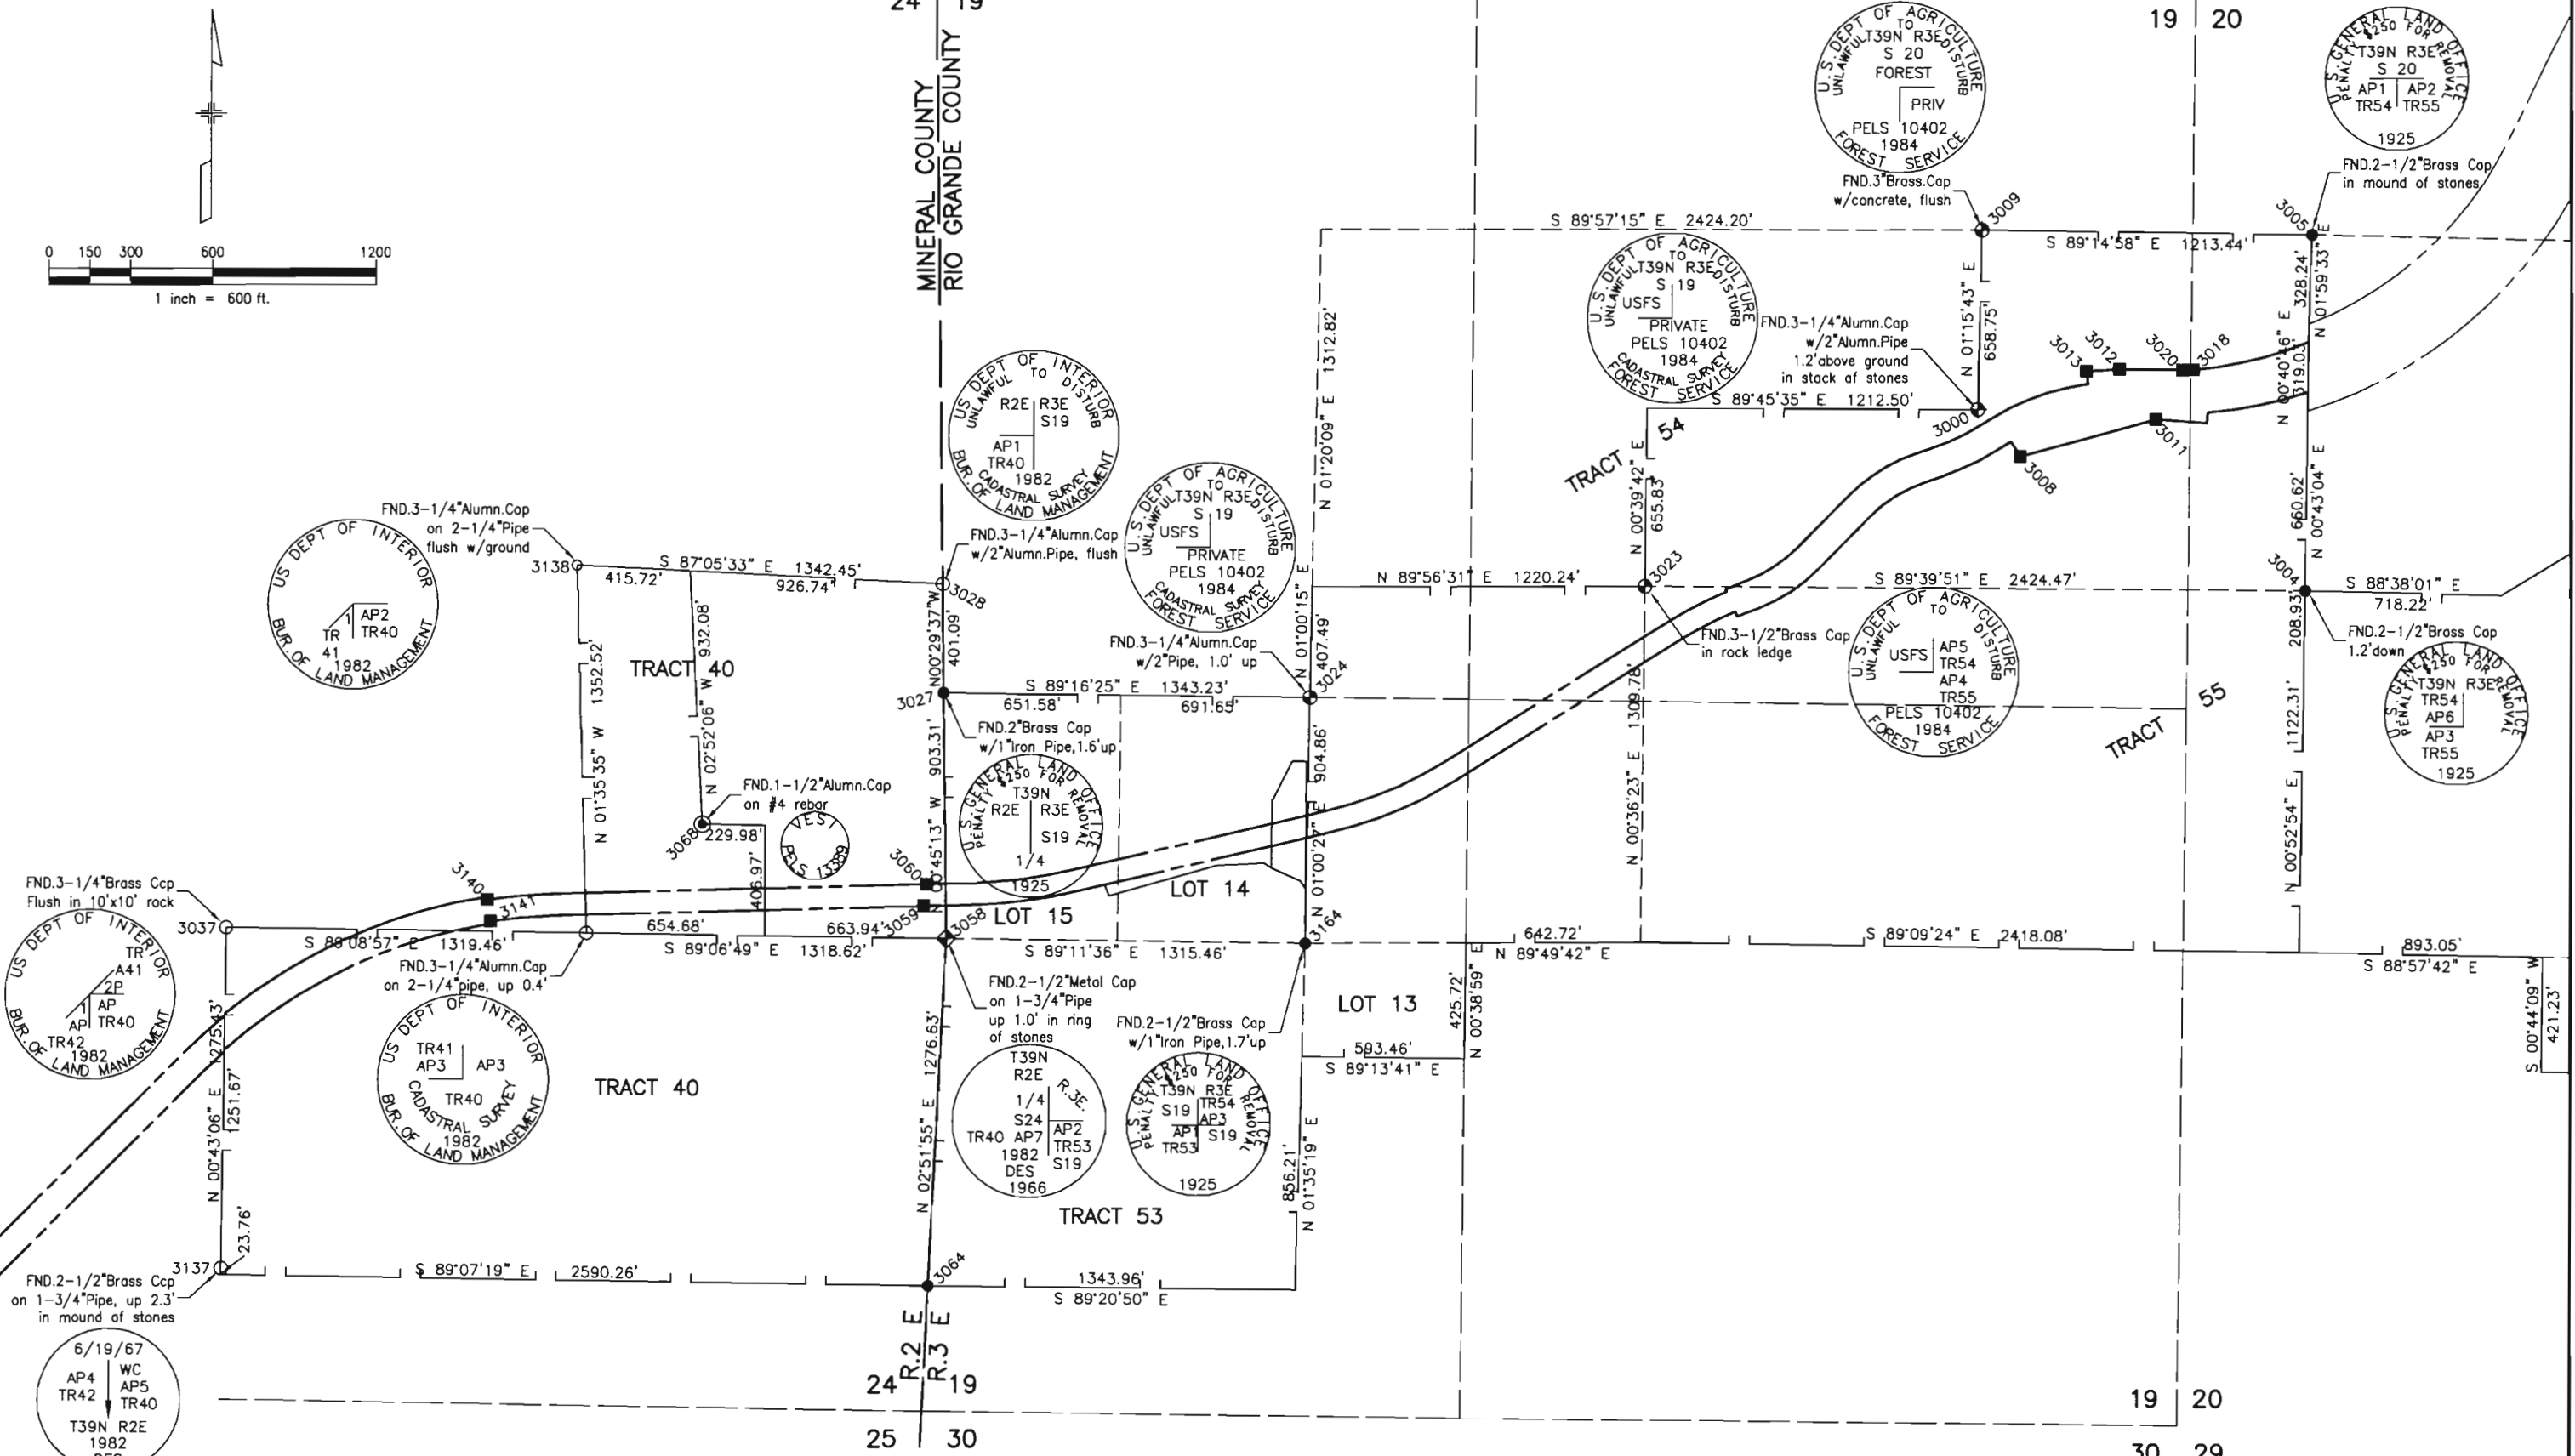

COLORADO DEPARTMENT OF TRANSPORTATION



Region 5
Address: 3803 North Main Avenue, Suite 300
Durango, Colorado 81301
Phone: (970) 385-1400 FAX: (970) 385-1410

Right of Way Plans Unit: Crumbaugh

Sheet Revisions

mm/yy	xxxxx	xxx

Sheet Revisions

mm/yy	xxxxx	xxx

Sheet Revisions

mm/yy	xxxxx	xxx

Right of Way Plans

Right of Way Monumentation Sheet

Project Number:	NH (CX)160-2(50) UNIT 2			
Project Location:	WOLF CREEK PASS EAST			
Project Location:				
Project Code:	Last Mod. Date	Subset Sheets	Sheet No.	Total No. of Sheets
92977	---	1 of 2	4	49

RIGHT OF WAY MONUMENTATION

M.P. 174.78 TO M.P. 181.2

TABULATION OF PROPOSED R.O.W. MARKERS

NO.	NORTH(FT)	EAST(FT)	STATION	OFFSET	DESC	TYPE
251	326003.043	1630832.865	69+83.52	140.00	Left N-ROW	TYPE 1
252	326028.628	1630778.593	69+83.52	200.00	Left N-ROW	TYPE 1
385	325900.705	1631049.952	69+83.52	100.00	Right S-ROW	TYPE 1
253	326247.728	1630900.947	72+13.52	200.00	Left N-ROW	TYPE 1
386	326091.973	1631157.346	72+13.52	100.00	Right S-ROW	TYPE 1
254	326355.442	1630966.380	73+39.55	200.00	Left N-ROW	TYPE 1
387	326199.687	1631222.779	73+39.55	100.00	Right S-ROW	TYPE 1
255	326502.326	1631060.809	74+99.55	200.00	Left N-ROW	TYPE 1
388	326328.211	1631305.112	74+99.55	100.00	Right S-ROW	TYPE 1
257	326921.189	1631562.352	80+57.86	200.00	Left N-ROW	TYPE 1
389	326649.766	1631690.139	80+57.86	100.00	Right S-ROW	TYPE 1
258	326987.928	1631723.713	82+17.86	200.00	Left N-ROW	TYPE 1
390	326707.875	1631831.279	82+17.86	100.00	Right S-ROW	TYPE 1
259	327043.160	1631858.112	83+77.86	200.00	Left N-ROW	TYPE 1
391	326771.737	1631985.899	83+77.86	100.00	Right S-ROW	TYPE 1
261	327618.324	1632339.259	93+25.48	200.00	Left N-ROW	TYPE 1
392	327540.483	1632628.983	93+25.48	100.00	Right S-ROW	TYPE 1
262	327760.365	1632369.884	94+85.48	200.00	Left N-ROW	TYPE 1
393	327703.952	1632664.537	94+85.48	100.00	Right S-ROW	TYPE 1
263	327990.214	1632420.222	97+05.48	200.00	Left N-ROW	TYPE 1
394	327911.362	1632709.674	97+05.48	100.00	Right S-ROW	TYPE 1
265	328325.976	1632553.083	100+22.98	200.00	Left N-ROW	TYPE 1
395	328185.418	1632818.118	100+22.98	100.00	Right S-ROW	TYPE 1
266	328528.035	1632673.650	102+42.98	200.00	Left N-ROW	TYPE 1
396	328340.812	1632969.365	102+42.98	100.00	Right S-ROW	TYPE 1
267	328643.545	1633161.031	106+00.00	150.01	Right S-ROW	TYPE 1
267	328828.230	1632863.709	106+01.72	200.00	Left N-ROW	TYPE 1
268	329253.743	1633122.987	111+00.00	200.00	Left N-ROW	TYPE 1
269	329396.366	1633268.444	112+97.48	150.00	Left N-ROW	TYPE 1
398	329240.263	1633524.631	112+97.48	150.00	Right S-ROW	TYPE 1
270	329533.061	1633357.592	114+47.48	150.00	Left N-ROW	TYPE 1
399	329354.961	1633599.005	114+47.48	150.00	Right S-ROW	TYPE 1
272	329545.753	1633367.112	114+60.96	150.00	Left N-ROW	TYPE 1
400	329363.841	1633605.665	114+60.96	150.00	Right S-ROW	TYPE 1
273	329669.599	1633473.390	116+10.96	150.00	Left N-ROW	TYPE 1
401	329467.346	1633694.961	116+10.96	150.00	Right S-ROW	TYPE 1
274	329810.787	1633602.268	118+02.13	150.00	Left N-ROW	TYPE 1
402	329608.534	1633823.839	118+02.13	150.00	Right S-ROW	TYPE 1
275	329911.396	1633701.460	119+27.13	150.00	Left N-ROW	TYPE 1
403	329686.225	1633899.697	119+27.13	150.00	Right S-ROW	TYPE 1
277	330020.974	1633867.263	120+85.14	150.00	Left N-ROW	TYPE 1
405	329774.010	1634058.051	121+74.30	150.00	Right S-ROW	TYPE 1
406	329797.181	1634164.134	122+99.30	150.00	Right S-ROW	TYPE 1
407	329801.161	1634185.835	123+21.37	150.00	Right S-ROW	TYPE 1
408	329829.974	1634320.422	124+46.37	150.00	Right S-ROW	TYPE 1
410	329959.336	1634596.477	127+01.07	150.00	Right S-ROW	TYPE 1
411	330044.325	1634704.740	128+26.07	150.00	Right S-ROW	TYPE 1
412	330069.340	1634734.741	128+65.13	150.00	Right S-ROW	TYPE 1
278	330399.791	1634659.317	130+25.13	150.00	Left N-ROW	TYPE 1
413	330177.625	1634860.916	130+25.13	150.00	Right S-ROW	TYPE 1
280	330478.916	1634741.044	131+48.60	150.00	Left N-ROW	TYPE 1
414	330270.237	1634956.574	131+48.60	150.00	Right S-ROW	TYPE 1
281	330592.315	1634844.804	133+08.60	150.00	Left N-ROW	TYPE 1
415	330392.844	1635068.883	133+08.60	150.00	Right S-ROW	TYPE 1
282	330928.657	1635144.210	137+58.90	150.00	Left N-ROW	TYPE 1
416	330729.186	1635368.289	137+58.90	150.00	Right S-ROW	TYPE 1
283	331058.306	1635262.573	139+28.90	150.00	Left N-ROW	TYPE 1
417	330850.663	1635479.101	139+28.90	150.00	Right S-ROW	TYPE 1
285	331340.367	1635585.151	143+31.60	150.00	Left N-ROW	TYPE 1
418	331098.071	1635762.048	143+31.60	150.00	Right S-ROW	TYPE 1
286	331440.374	1635729.434	145+01.60	150.00	Left N-ROW	TYPE 1
419	331191.685	1635897.224	145+01.60	150.00	Right S-ROW	TYPE 1
287	331545.060	1635879.709	146+91.60	150.00	Left N-ROW	TYPE 1
420	331304.277	1636058.660	146+91.60	150.00	Right S-ROW	TYPE 1
289	331903.225	1636247.401	152+46.36	150.00	Left N-ROW	TYPE 1
421	331718.015	1636483.404	152+46.36	150.00	Right S-ROW	TYPE 1
290	332079.744	1636315.294	154+36.36	200.00	Left N-ROW	TYPE 1
422	331876.441	1636600.194	154+36.36	150.00	Right S-ROW	TYPE 1
291	332422.857	1636560.138	158+57.88	200.00	Left N-ROW	TYPE 1
423	332219.554	1636845.038	158+57.88	150.00	Right S-ROW	TYPE 1
292	332559.794	1636722.639	160+57.88	150.00	Left N-ROW	TYPE 1
424	332376.082	1636959.809	160+57.88	150.00	Right S-ROW	TYPE 1

TABULATION OF PROPOSED R.O.W. MARKERS

NO.	NORTH(FT)	EAST(FT)	STATION	OFFSET	DESC	TYPE
294	332899.270	1637035.601	164+94.45	150.00	Left N-ROW	TYPE 1
425	332677.789	1637237.952	164+94.45	150.00	Right S-ROW	TYPE 1
295	333034.137	1637191.151	166+94.45	150.00	Left N-ROW	TYPE 1
426	332804.882	1637384.651	166+94.45	150.00	Right S-ROW	TYPE 1
427	332967.345	1637577.134	169+46.33	150.00	Right S-ROW	TYPE 1
428	333015.547	1637541.220	169+49.98	90.00	Right S-ROW	TYPE 1
296	334092.976	1638445.643	183+36.06	150.00	Left N-ROW	TYPE 1
429	333909.572	1638600.443	183+36.06	90.00	Right S-ROW	TYPE 1
526	334003.593	1638669.160	184+50.00	62.00	Right S-ROW	TYPE 1
297	334210.606	1638588.046	185+16.06	150.00	Left N-ROW	TYPE 1
430	334059.781	1638791.376	185+84.10	93.68	Right S-ROW	TYPE 1
299	334484.352	1638998.996	189+85.80	150.00	Left N-ROW	TYPE 1
431	334299.306	1639140.029	190+20.43	80.01	Right S-ROW	TYPE 1
300	334570.437	1639162.412	191+65.80	150.00	Left N-ROW	TYPE 1
432	334411.164	1639373.804	192+79.46	88.96	Right S-ROW	TYPE 1
301	334679.718	1639361.787	194+05.80	150.00	Left N-ROW	TYPE 1
303	334768.005	1639486.101	195+76.21	150.00	Left N-ROW	TYPE 1
304	334920.248	1639654.965	198+16.21	150.00	Left N-ROW	TYPE 1
305	335734.963	1640510.709	209+97.76	150.00	Left N-ROW	TYPE 1
434	335933.663	1641121.573	215+84.11	110.00	Right S-ROW	TYPE 1
433	335970.293	1641093.783	215+86.52	64.08	Right S-ROW	TYPE 1
435	336070.112	1641285.754	218+00.00	109.30	Right S-ROW	TYPE 1
436	336077.351	1641279.909	218+00.00	100.00	Right S-ROW	TYPE 1
307	336770.677	1641796.873	226+26.13	150.00	Left N-ROW	TYPE 1
437	336563.648	1641937.011	226+26.13	100.00	Right S-ROW	TYPE 1
308	336926.529	1642027.116	229+04.16	150.00	Left N-ROW	TYPE 1
438	336719.500	1642167.254	229+04.16	100.00	Right S-ROW	TYPE 1
309	337105.722	1642291.840	232+19.67	150.00	Left N-ROW	TYPE 1
439	336898.693	1642431.978	232+19.67	100.00	Right S-ROW	TYPE 1
311	337439.256	1642694.700	237+72.44	150.00	Left N-ROW	TYPE 1
440	337262.941	1642871.937	237+72.44	100.00	Right S-ROW	TYPE 1
441	337654.681	1643261.637	243+25.00	100.00	Right S-ROW	TYPE 1
442	337647.628	1643268.727	243+25.00	110.00	Right S-ROW	TYPE 1
312	337856.975	1643110.244	243+61.64	150.00	Left N-ROW	TYPE 1
443	337718.158	1643339.005	244+25.00	110.00	Right S-ROW	TYPE 1
444	337724.719	1643332.462	244+25.00	100.73	Right S-ROW	TYPE 1
313	338000.990	1643257.365	245+61.64	150.00	Left N-ROW	TYPE 1
445	337817.853	1643427.544	245+61.64	100.00	Right S-ROW	TYPE 1
315	338131.635	1643408.859	247+50.61	150.00	Left N-ROW	TYPE 1
446	337936.386	1643564.992	247+50.61	100.00	Right S-ROW	TYPE 1
316	338255.990	1643572.936	249+50.61	150.00	Left N-ROW	TYPE 1
447	338054.761	1643721.283	249+50.61	100.00	Right S-ROW	TYPE 1
317	338345.513	1643694.372	251+01.47	150.00	Left N-ROW	TYPE 1
448	338176.481	1643818.983	251+01.47	60.00	Right S-ROW	TYPE 1
318	338485.538	1643874.507	253+41.47	150.00	Left N-ROW	TYPE 1
449	338326.804	1644011.997	253+41.47	60.00	Right S-ROW	TYPE 1
450	338349.903	1644038.081	253+75.00	60.00	Right S-ROW	TYPE 1
451	338275.770	1644105.195	253+75.00	160.00	Right S-ROW	TYPE 1
452	338332.861	1644165.228	254+50.00	160.00	Right S-ROW	TYPE 1
453	338403.612	1644094.557	254+50.00	60.00	Right S-ROW	TYPE 1
454	338499.074	1644182.613	255+75.00	60.00	Right S-ROW	TYPE 1
455	338421.388	1644274.072	255+75.00	180.00	Right S-ROW	TYPE 1
456	338508.890	1644343.599	256+75.00	180.00	Right S-ROW	TYPE 1
457	338580.428	1644247.254	256+75.00	60.00	Right S-ROW	TYPE 1
458	338918.565	1644439.059	260+50.00	60.00	Right S-ROW	TYPE 1
459	338943.948	1644519.004	261+00.00	125.00	Right S-ROW	TYPE 1
460	339098.351	1644568.711	262+50.00	125.00	Right S-ROW	TYPE 1
461	339104.837	1644544.567	262+50.00	100.00	Right S-ROW	TYPE 1
320	339276.916	1644327.379	263+71.95	150.00	Left N-ROW	TYPE 1
462	339231.532	1644573.225	263+71.95	100.00	Right S-ROW	TYPE 1
321	339503.163	1644356.845	266+11.95	150.00	Left N-ROW	TYPE 1
463	339477.208	1644605.494	266+11.95	100.00	Right S-ROW	TYPE 1
464	339539.234	1644613.418	266+75.00	101.33	Right S-ROW	TYPE 1
465	339535.562	1644646.885	266+75.00	135.00	Right S-ROW	TYPE 1
466	339607.354	1644655.397	267+50.00	135.00	Right S-ROW	TYPE 1
467	339611.611	1644622.663	267+50.00	101.99	Right S-ROW	TYPE 1
322	339741.681	1644387.528	268+41.95	150.00	Left N-ROW	TYPE 1
468	339698.337	1644633.742	268+41.95	100.00	Right S-ROW	TYPE 1
324	340269.596	1644568.995	273+55.43	150.00	Left N-ROW	TYPE 1
469	340152.398	1644789.822	273+55.43	100.00	Right S-ROW	TYPE 1
325	340476.569	1644691.448	275+85.43	150.00	Left N-ROW	TYPE 1
470	340344.160	1644903.504	275+85.43	100.00	Right S-ROW	TYPE 1

COLORADO DEPARTMENT OF TRANSPORTATION



Region 5
Address: 3803 North Main Avenue, Suite 300
Durango, Colorado 81301
Phone: (970) 385-1400 FAX: (970) 385-1410

Right of Way Plans Unit: Crumbaugh

Sheet Revisions

mm/yy	xxxxx	xxx

Sheet Revisions

mm/yy	xxxxx	xxx

Sheet Revisions

mm/yy	xxxxx	xxx

Right of Way Plans

Right of Way Monumentation Sheet

Project Number:		NH (CX)160-2(50) UNIT 2		
Project Location:		WOLF CREEK PASS EAST		
Project Location:				
Project Code:	Last Mod. Date	Subset Sheets	Sheet No.	Total No. of Sheets
92977	---	2 of 2	4A	49

RIGHT OF WAY MONUMENTATION

M.P. 174.78 TO M.P. 181.2

TABULATION OF PROPOSED R.O.W. MARKERS

NO.	NORTH(FT)	EAST(FT)	STATION	OFFSET	DESC	TYPE
344	343408.037	1645600.906	307+23.15	100.00	Left N-ROW	TYPE 1
490	343343.617	1645790.247	307+23.15	100.00	Right S-ROW	TYPE 1
345	343422.060	1645605.677	307+37.96	100.00	Left N-ROW	TYPE 1
491	343357.640	1645795.018	307+37.96	100.00	Right S-ROW	TYPE 1
346	343655.085	1645692.895	309+77.96	100.00	Left N-ROW	TYPE 1
492	343574.089	1645875.760	309+77.96	100.00	Right S-ROW	TYPE 1
348	344101.916	1646002.372	314+86.98	100.00	Left N-ROW	TYPE 1
493	343959.209	1646142.496	314+86.98	100.00	Right S-ROW	TYPE 1
349	344265.502	1646189.848	317+26.98	100.00	Left N-ROW	TYPE 1
494	344110.904	1646316.731	317+26.98	100.00	Right S-ROW	TYPE 1
350	344332.122	1646271.020	318+31.99	100.00	Left N-ROW	TYPE 1
495	344177.524	1646397.903	318+31.99	100.00	Right S-ROW	TYPE 1
352	344627.152	1646596.564	322+81.31	100.00	Left N-ROW	TYPE 1
496	344485.713	1646737.969	322+81.31	100.00	Right S-ROW	TYPE 1
353	345216.455	1647186.008	331+14.81	100.00	Left N-ROW	TYPE 1
497	345075.016	1647327.413	331+14.81	100.00	Right S-ROW	TYPE 1
354	345372.914	1647348.712	333+34.81	100.00	Left N-ROW	TYPE 1
498	345223.571	1647481.740	333+34.81	100.00	Right S-ROW	TYPE 1
499	345225.320	1647483.707	333+37.59	100.00	Right S-ROW No Set	
500	345238.815	1647483.876	333+47.13	90.00	Right S-ROW	TYPE 1
356	345876.484	1648537.072	345+83.36	100.00	Left N-ROW	TYPE 1
501	345687.004	1648551.108	345+83.36	90.00	Right S-ROW	TYPE 1
357	345884.561	1648762.653	348+03.36	100.00	Left N-ROW	TYPE 1
502	345694.587	1648765.759	348+03.36	90.00	Right S-ROW	TYPE 1
358	345885.263	1648805.540	348+46.25	100.00	Left N-ROW	TYPE 1
359	345883.450	1648805.595	348+46.28	98.19	Left N-ROW	TYPE 1
503	345707.997	1649585.964	356+23.68	90.00	Right S-ROW	TYPE 1
504	345754.659	1650127.636	361+55.27	90.00	Right S-ROW	TYPE 1
505	345764.761	1650127.503	361+56.67	80.00	Right S-ROW	TYPE 1
360	345917.635	1650125.492	361+78.83	71.27	Left N-ROW	TYPE 1
361	345966.911	1650124.844	361+86.36	120.00	Left N-ROW	TYPE 1
363	346029.820	1650426.858	365+04.96	120.00	Left N-ROW	TYPE 1
506	345835.893	1650475.770	365+04.96	80.00	Right S-ROW	TYPE 1
507	345896.293	1650715.244	367+51.93	80.00	Right S-ROW	TYPE 1
508	345873.496	1650724.628	367+55.46	104.40	Right S-ROW	TYPE 1
509	345983.765	1651117.236	371+63.11	93.50	Right S-ROW	TYPE 1
510	345992.667	1651291.617	373+34.37	127.51	Right S-ROW	TYPE 1
511	345974.317	1651318.247	373+55.71	151.82	Right S-ROW	TYPE 1
512	346031.420	1651445.543	374+93.10	127.58	Right S-ROW	TYPE 1
364	346277.386	1651408.406	375+17.25	120.00	Left N-ROW	TYPE 1
366	346325.183	1651577.826	377+00.00	120.00	Left N-ROW	TYPE 1
367	346296.549	1651586.774	377+00.00	90.00	Left N-ROW	TYPE 1
513	346155.817	1651703.937	377+68.19	80.00	Right S-ROW	TYPE 1
368	346520.512	1652124.704	383+00.00	90.00	Left N-ROW	TYPE 1
369	346547.037	1652110.688	383+00.00	120.00	Left N-ROW	TYPE 1
370	346604.539	1652214.709	384+23.39	120.00	Left N-ROW	TYPE 1
514	346431.358	1652314.749	384+23.39	80.00	Right S-ROW	TYPE 1
371	346840.849	1652623.789	388+95.81	120.00	Left N-ROW	TYPE 1
515	346659.007	1652728.829	388+95.81	90.00	Right S-ROW	TYPE 1
372	346892.716	1652713.020	390+00.00	120.00	Left N-ROW	TYPE 1
373	346935.807	1652687.660	390+00.00	170.00	Left N-ROW	TYPE 1
374	346970.846	1652746.287	390+70.81	170.00	Left N-ROW	TYPE 1
516	346740.204	1652886.659	390+70.81	100.00	Right S-ROW	TYPE 1
376	347117.736	1652968.891	393+50.00	170.00	Left N-ROW	TYPE 1
377	347077.037	1652997.935	393+50.00	120.00	Left N-ROW	TYPE 1
518	347033.809	1653336.772	395+93.22	120.00	Right S-ROW	TYPE 1
378	347219.898	1653185.210	395+93.23	120.00	Left N-ROW	TYPE 1
379	347330.709	1653317.081	397+68.23	120.00	Left N-ROW	TYPE 1
519	347144.342	1653476.117	397+68.23	125.00	Right S-ROW	TYPE 1
380	347481.078	1653502.049	399+98.23	120.00	Left N-ROW	TYPE 1
520	347279.982	1653650.577	399+98.23	130.00	Right S-ROW	TYPE 1
521	347329.070	1653730.338	401+00.00	135.00	Right S-ROW	TYPE 1
522	347469.988	1654066.176	405+00.00	155.00	Right S-ROW	TYPE 1
523	347498.431	1654244.760	407+00.00	175.00	Right S-ROW	TYPE 1
382	347799.303	1654247.765	407+60.50	120.00	Left N-ROW	TYPE 1
524	347499.393	1654335.236	408+00.00	190.00	Right S-ROW	TYPE 1
525	347561.514	1654325.945	408+00.00	127.19	Right S-ROW	TYPE 1
383	347808.420	1654306.121	408+15.99	120.00	Left N-ROW	TYPE 1
384	347803.207	1654306.860	408+15.99	114.74	Left N-ROW	TYPE 1

TABULATION OF EXISTING R.O.W. MARKERS

NO.	NORTH(FT)	EAST(FT)	STATION	OFFSET	DESC	TYPE
616	334626.907	1639686.001	196+40.29	86.58	Right EX.ROW-PT	TYPE 1
1028	335431.901	1640526.182	208+00.00	80.16	Right PE208	TYPE 1
617	335914.877	1641030.270	215+01.68	65.11	Right EX.ROW-PC	TYPE 1
619	346085.539	1651445.879	375+06.66	75.19	Right EX.ROW-PI	TYPE 1
618	346107.909	1651541.626	376+02.94	78.06	Right EX.ROW-PC	TYPE 1

TABULATION OF PERMANENT EASEMENT CORNERS

NO.	NORTH(FT)	EAST(FT)	STATION	OFFSET	DESC	TYPE
1008	333112.952	1637656.623	171+00.99	90.00	Right PE202	TYPE 6
1009	333093.848	1637672.748	171+00.99	115.00	Right PE202	TYPE 6
1010	333125.459	1637710.200	171+50.00	115.00	Right PE202	TYPE 6
1011	333144.563	1637694.075	171+50.00	90.00	Right PE202	TYPE 6
1029	335419.588	1640537.904	208+00.00	97.16	Right PE208	TYPE 6
1030	335488.771	1640610.111	209+00.00	96.85	Right PE208	TYPE 6
1031	335501.083	1640598.389	209+00.00	79.85	Right PE208	TYPE 6
1032	335724.694	1640831.774	212+25.00	76.21	Right PE209	TYPE 6
1033	335714.585	1640841.460	212+25.37	90.21	Right PE209	TYPE 6
1035	335793.384	1640903.467	213+25.00	73.10	Right PE209	TYPE 6
1034	335783.275	1640913.152	213+25.52	87.09	Right PE209	TYPE 6
1091	346060.819	1651449.858	375+04.47	100.13	Right PE217	TYPE 6
1090	346086.575	1651450.311	375+11.21	75.27	Right PE217	TYPE 6
1092	346083.146	1651545.419	376+00.00	102.93	Right PE217	TYPE 6
1093	346107.224	1651538.695	376+00.00	77.93	Right PE217	TYPE 6

TABULATION OF TEMPORARY EASEMENT CORNERS

NO.	NORTH(FT)	EAST(FT)	STATION	OFFSET	DESC
1000	325809.229	1630760.699	68+00.00	140.00	Left TE201A
1001	325819.989	1630722.173	68+00.00	180.00	Left TE201A
1003	325903.265	1630748.549	68+75.00	180.00	Left TE201A
1004	325889.884	1630786.244	68+75.00	140.00	Left TE201A
1005	333087.396	1637626.345	170+61.37	90.00	Right TE202A
1006	333085.318	1637628.099	170+61.37	92.72	Right TE202A
1007	333108.902	1637660.042	171+00.99	95.30	Right TE202A
1012	333563.813	1638190.794	178+00.00	90.00	Right TE202B
1013	333578.641	1638309.137	179+00.00	155.00	Right TE202B
1014	333610.891	1638347.346	179+50.00	155.00	Right TE202B
1015	333660.563	1638305.421	179+50.00	90.00	Right TE202B
1016	334397.018	1639344.240	192+47.52	87.58	Right TE203
1017	334384.760	1639398.200	192+88.09	123.78	Right TE203,TE205A
1018	334383.728	1639402.746	192+91.44	126.85	Right TE205A
1019	334413.770	1639414.280	193+14.91	106.06	Right TE205A
1020	334464.853	1639488.605	194+00.00	99.43	Right TE205A
1021	334471.392	1639484.560	194+00.00	91.75	Right TE205A
1022	334547.149	1639593.772	195+25.00	90.57	Right TE205B
1023	334529.149	1639607.210	195+25.00	113.03	Right TE205B
1024	334586.372	1639676.300	196+08.35	111.10	Right TE205B
1025	334595.539	1639668.708	196+08.42	99.19	Right TE205B
1026	334625.472	1639700.745	196+50.00	97.37	Right TE205B
1027	334633.923	1639693.324	196+50.00	86.12	Right TE205B
1036	335896.520	1641011.111	214+75.00	66.52	Right TE209
1037	335863.610	1641039.526	214+75.00	110.00	Right TE209
1038	335901.246	1641083.377	215+33.44	110.00	Right TE209,TE218
434	335933.663	1641121.573	215+84.11	110.00	Right TE218
1039	337040.100	1642623.796	234+50.00	100.00	Right TE211A
1040	337016.687	1642642.553	234+50.00	130.00	Right TE211A
1041	337083.460	1642722.980	235+50.00	130.00	Right TE211A
1042	337106.204	1642703.416	235+50.00	100.00	Right TE211A
447	338054.761	1643721.283	249+50.61	100.00	Right TE211B
1043	338103.165	1643871.204	251+00.00	150.00	Right TE211B
1044	338023.021	1644130.450	252+50.00	370.00	Right TE211B
1045	338637.972	1644772.705	259+50.00	480.00	Right TE211B
1046	338942.400	1644788.485	261+75.00	380.00	Right TE211B
460	339098.351	1644568.711	262+50.00	125.00	Right TE211B
1047	340020.441	1644727.627	272+00.00	100.00	Right TE211C
1048	339938.109	1644926.238	272+00.00	315.00	Right TE211C
1049	340317.678	1644945.915	275+85.43	150.00	Right TE211C
1050	340542.698	1645086.419	278+50.71	150.00	Right TE211C
1051	340749.672	1645208.871	280+80.71	150.00	Right TE211C
1052	341013.3271	1645322.659	283+44.01	150.00	Right TE211C
1053	341063.765	1645366.894	284+00.00	176.73	Right TE211C
1054	341220.297	1645430.400	285+50.10	200.05	Right TE211C
1055	341380.545	1645455.418	287+00.00	198.29	Right TE211C
1056	341387.496	1645405.898	287+00.00	148.29	Right TE211C
329	341290.251	1645087.407	285+50.10	150.00	Left TE211D
1057	341520.133	1645021.876	287+80.10	250.00	Left TE211D
1058	341751.840	1645057.068	290+00.10	250.00	Left TE211D
334	341942.377	1645206.703	292+00.00	150.00	Left TE211D
1059	345553.600	1647989.489	339+75.00	90.00	Right TE212
1060	345470.340	1648041.448	339+92.79	187.00	Right TE212
1062	345595.524	1648100.953	341+00.00	90.00	Right TE212
1061	345535.347	1648134.580	341+13.64	157.75	Right TE212
1063	345749.586	1647936.992	340+00.00	111.34	Left TE211E
1064	345958.843	1648038.108	341+50.00	275.00	Left TE211E
1065	346083.919	1648365.348	344+50.00	325.00	Left TE211E
1066	346327.791	1648793.238	348+41.19	542.67	Left TE211E
1067	345951.649	1648803.698	348+45.50	166.41	Left TE213
1069	345914.026	1648843.705	348+84.88	128.14	Left TE213
1068	345951.921	1648843.691	348+85.49	166.03	Left TE213
1070	345914.775	1648871.643	349+12.83	128.43	Left TE213
1071	345895.290	1648874.541	349+15.41	108.90	Left TE213
1073	345915.938	1648915.011	349+56.21	128.88	Left TE213
1072	345902.559	1648917.001	349+57.98	115.47	Left TE213
1074	345930.657	1649464.068	355+05.44	134.62	Left TE213
1075	346026.027	1649463.969	355+06.90	229.98	Left TE214
1076	346028.165	1649512.070	355+05.23	231.33	Left TE214
1077	346001.429	1649513.400	355+55.92	204.58	Left TE214
1079	345902.344	1649535.112	355+76.01	105.15	Left TE214
1078	346003.105	1649535.008	355+77.55	205.90	Left TE214

COLORADO DEPARTMENT OF TRANSPORTATION



Region 5
Address: 3803 North Main Avenue, Suite 300
Durango, Colorado 81301
Phone: (970) 385-1400 FAX: (970) 385-1410

Right of Way Plans Unit: Crumbaugh

Sheet Revisions

mm/yy	xxxxx	xxx

Sheet Revisions

mm/yy	xxxxx	xxx


Sheet Revisions

mm/yy	xxxxx	xxx

Right of Way Plans

Right of Way Plan Sheet Index

Project Number:	NH (CX)160-2(50) UNIT 2			
Project Location:	WOLF CREEK PASS EAST			
Project Location:				
Project Code:	Last Mod. Date	Subset Sheets	Sheet No.	Total No. of Sheets
9297	---	1 of 2	5	49

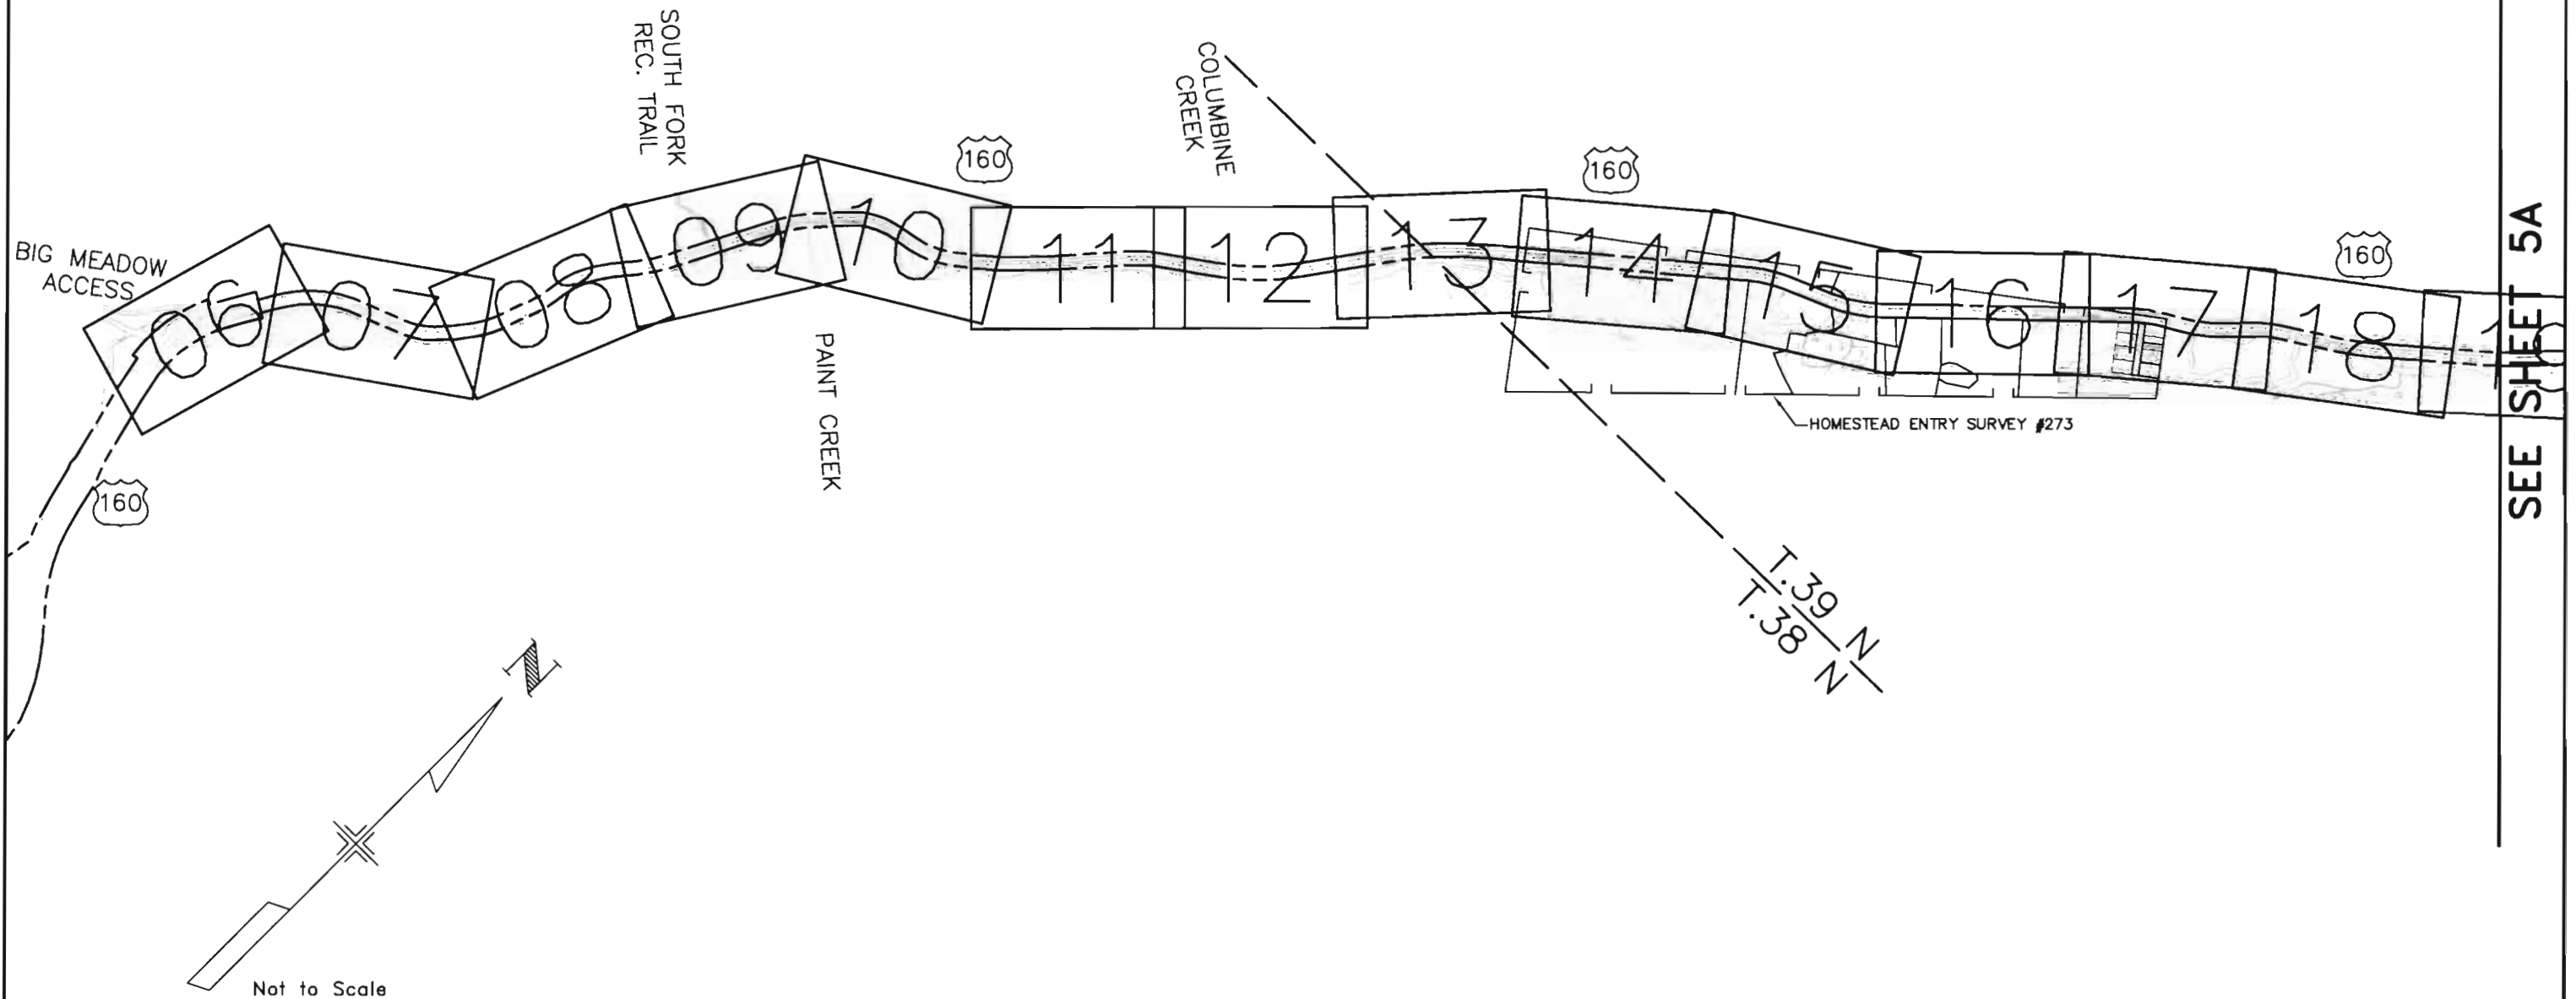

COLORADO DEPARTMENT OF TRANSPORTATION



Region 5
Address: 3803 North Main Avenue, Suite 300
Durango, Colorado 81301
Phone: (970) 385-1400 FAX: (970) 385-1410

Right of Way Plans Unit: Crumbaugh

Sheet Revisions

mm/yy	XXXXX	XXX

Sheet Revisions

mm/yy	XXXXX	XXX


Sheet Revisions

mm/yy	XXXXX	XXX

Right of Way Plans

Right of Way Plan Sheet Index

Project Number:	NH (CX)160-2(50) UNIT 2			
Project Location:	WOLF CREEK PASS EAST			
Project Code:	Last Mod. Date	Subset Sheets	Sheet No.	Total No. of Sheets
9297	---	2 of 2	5A	49

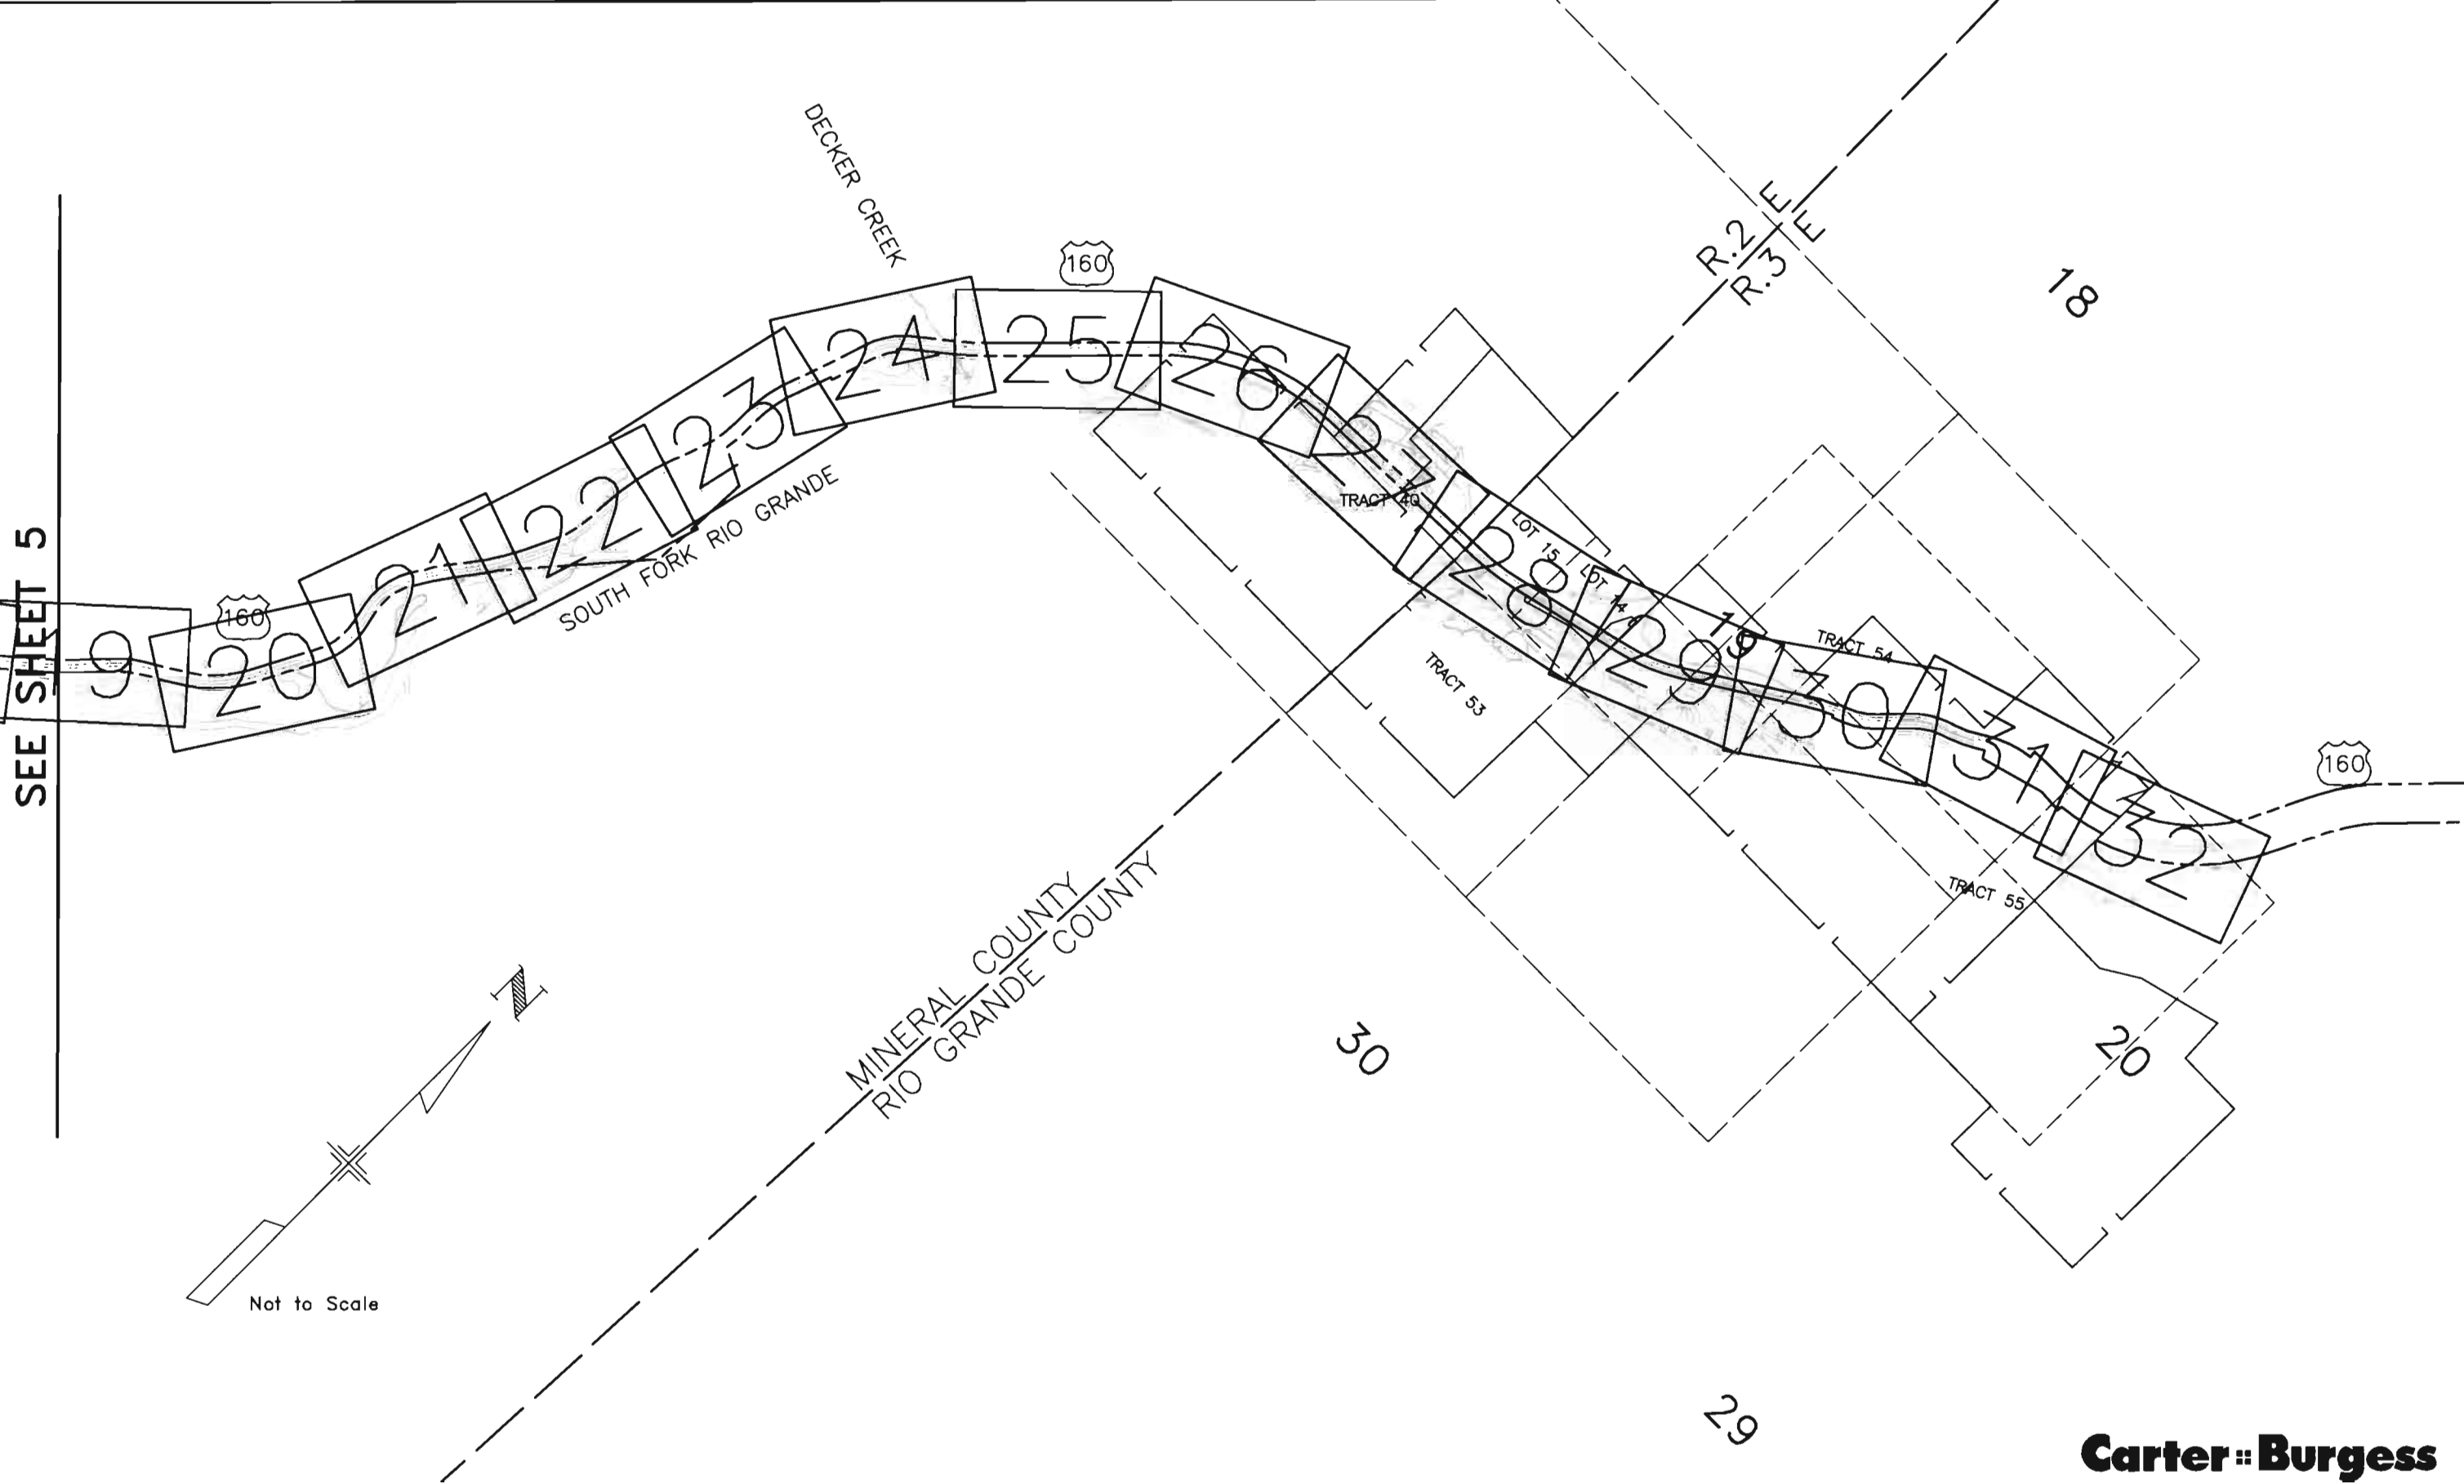

DEPOSITED THIS ____ DAY OF ____ 18__ AT ____ AL., FOR INFORMATION
ONLY IN BOOK ____ OF THE COUNTY LAND SURVEYS/RIGHT OF WAY
SURVEYS AT PAGE ____ RECEPTION NUMBER ____

SIGNED _____
DOT.

COLORADO DEPARTMENT OF TRANSPORTATION



Region 5
Address: 3803 North Main Avenue, Suite 300
Durango, Colorado 81301
Phone: (970) 385-1400 FAX: (970) 385-1410

Right of Way Plans Unit: Crumbaugh



Sheet Revisions		
mm/yy	xxxxx	xxx

Sheet Revisions		
mm/yy	xxxxx	xxx

Sheet Revisions		
mm/yy	xxxxx	xxx

Right of Way Plans				
Right of Way Plan Sheet				
Project Number:	NH (CX)160-2(50) UNIT 2			
Project Location:	WOLF CREEK PASS EAST			
Project Location:				
Project Code:	Last Mod. Date	Sheet No.	Total No. of Sheets	
92977	---	1 of 27	6 49	

T.38 N, R.2 E, NMPM

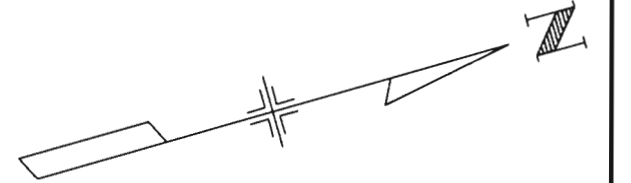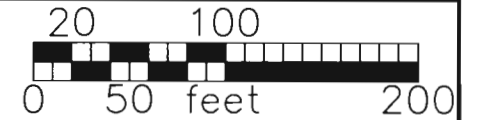

STA. 69+83.52 / M.P. 174.7
BEGIN ROW PROJECT
NH(CX)160-2(50) UNIT 2
= STA. 69+83.52 ON
NH(CX)160-2(50) UNIT 1

BIG MEADOW ACCESS

PASS CREEK

SOUTH FORK

RIO GRANDE

EXIST R/W FAP NH(CX)160-2(50) UNIT 1

SPIRAL WCE-5A

N=325333.5751
E=1630864.9047

65+00

SC 63+57.92

CURVE WCE-5

N=325943.3459
E=1630959.4994

CS 69+83.52

SPIRAL WCE-5B

N=326143.8912
E=1631071.8798

SOUTH FORK RIO GRANDE

ST 72+13.52

TS 73+39.55

SPIRAL WCE-6A

N=326386.2493
E=1631223.6778

CURVE WCE-6

SC 74+99.55

MATCH LINE STA. 75+50

Radius= 1291.3486
Delta= 29°18'41"
Arc= 660.6265
Tangent= 337.7109
Chord= 653.4461
Chord Brg. N 50°07'59" E

Radius= 991.3486
Delta= 29°18'41"
Arc= 507.1529
Tangent= 259.2555
Chord= 501.6406
Chord Brg. N 50°07'59" E

SPIRAL WCE-5A	CURVE WCE-5	SPIRAL WCE-5B	SPIRAL WCE-6A	CURVE WCE-6
Ls=230.000	PI 66+94.86	Ls=230.000	Ls=160.000	PI 77+92.58
Ang=6°02'15.0"	D= 32°50'37.3"	Ang=6°02'15.0"	Ang=4°12'00.0"	D= 29°18'40.7"
LT=153.423	R= 1091.349	LT=153.423	R= 1091.349	R= 1091.349
ST=76.748	Dc=515'00.0"	ST=76.748	ST=53.361	Dc=515'00.0"
	A= 625.595			A= 558.311
	C= 617.064			C= 552.242

DEPOSITED THIS 19th DAY OF 19__ AT 11:00 A.M. FOR INFORMATION
ONLY IN BOOK OF THE COUNTY LAND SURVEYS/RIGHT OF WAY
SURVEYS AT PAGE 1 RECEPTION NUMBER

0/0022\DWGS\ROW\PLAN\WC\01RIP.DWG, 08/12/2002 10:50:31 AM
testump

COLORADO DEPARTMENT OF TRANSPORTATION



Region 5
Address: 3803 North Main Avenue, Suite 300
Durango, Colorado 81301
Phone: (970) 385-1400 FAX: (970) 385-1410

Right of Way Plans Unit: Crumbaugh

Sheet Revisions

mm/yy	xxxxx	xxx

Sheet Revisions

mm/yy	xxxxx	xxx

Sheet Revisions

mm/yy	xxxxx	xxx


Right of Way Plans

Right of Way Plan Sheet

Project Number:		NH (CX)160-2(50) UNIT 2		
Project Location:		WOLF CREEK PASS EAST		
Project Location:				
Project Code:	Last Mod. Date	Subset Sheets	Sheet No.	Total No. of Sheets
92977	---	2 of 27	7	49

T.38 N, R.2 E, NMPM

Carter-Burgess

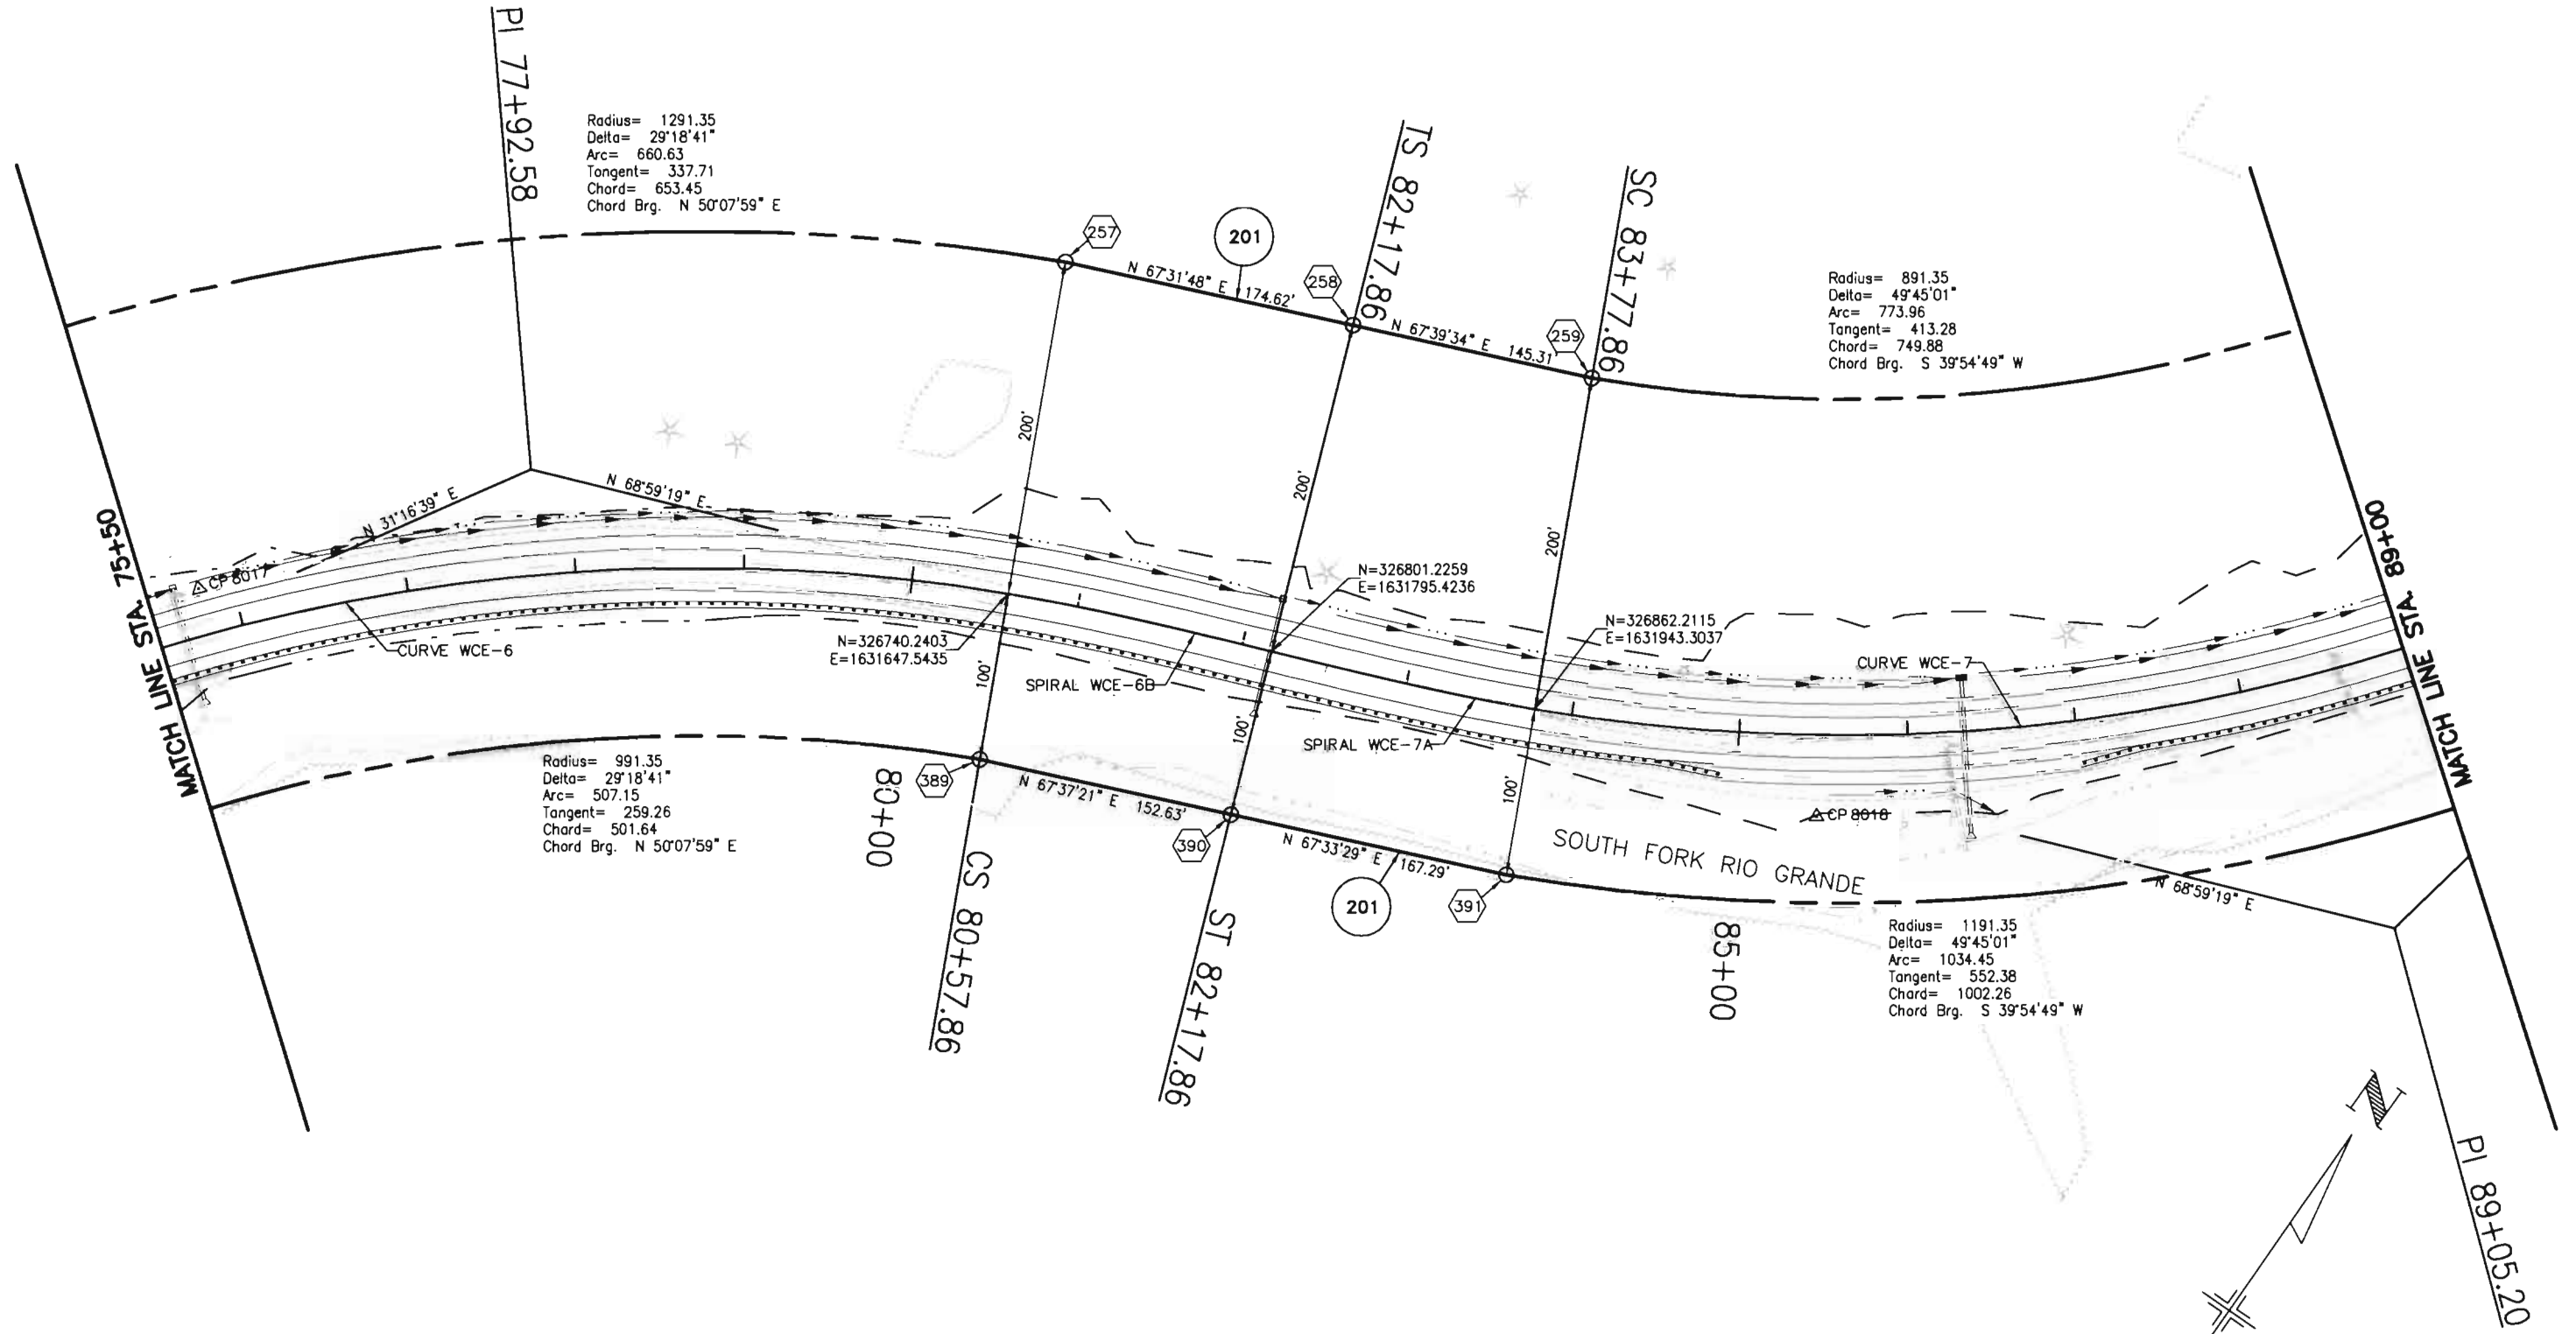


Radius= 1291.35
Delta= 29°18'41"
Arc= 660.63
Tangent= 337.71
Chord= 653.45
Chord Brg. N 50°07'59" E

Radius= 891.35
Delta= 49°45'01"
Arc= 773.96
Tangent= 413.28
Chord= 749.88
Chord Brg. S 39°54'49" W

Radius= 991.35
Delta= 29°18'41"
Arc= 507.15
Tangent= 259.26
Chord= 501.64
Chord Brg. N 50°07'59" E

Radius= 1191.35
Delta= 49°45'01"
Arc= 1034.45
Tangent= 552.38
Chord= 1002.26
Chord Brg. S 39°54'49" W

CURVE WCE-6 PI 77+92.58 D= 29°18'40.7" R= 1091.349 Dc= 5°15'00.0" A= 558.311 C= 552.242	SPIRAL WCE-6B Ls=160.000 Ang= 4°12'00.0" LT=106.697 ST=53.361	SPIRAL WCE-7A Ls=160.000 Ang= 4°12'00.0" LT=106.697 ST=53.361	CURVE WCE-7 PI 89+05.20 D= 49°45'00.5" R= 1091.349 Dc= 5°15'00.0" A= 947.622 C= 918.132
---	---	---	---

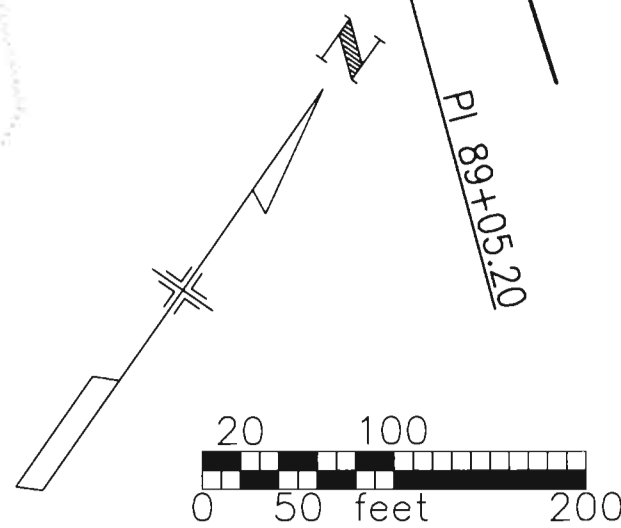

COLORADO DEPARTMENT OF TRANSPORTATION



Region 5
Address: 3803 North Main Avenue, Suite 300
Durango, Colorado 81301
Phone: (970) 385-1400 FAX: (970) 385-1410

Right of Way Plans Unit: Crumbaugh

Sheet Revisions

mm/yy	xxxxx	xxx

Sheet Revisions

mm/yy	xxxxx	xxx

Sheet Revisions

mm/yy	xxxxx	xxx


Right of Way Plans

Right of Way Plan Sheet

Project Number:	NH (CX)160-2(50) UNIT 2
Project Location:	WOLF CREEK PASS EAST
Project Location:	
Project Code:	92977
Last Mod. Date:	---
Subset Sheets:	3 of 27
Sheet No.:	8
Total No. of Sheets:	49

T.38 N, R.2 E, NMPM

Carter-Burgess

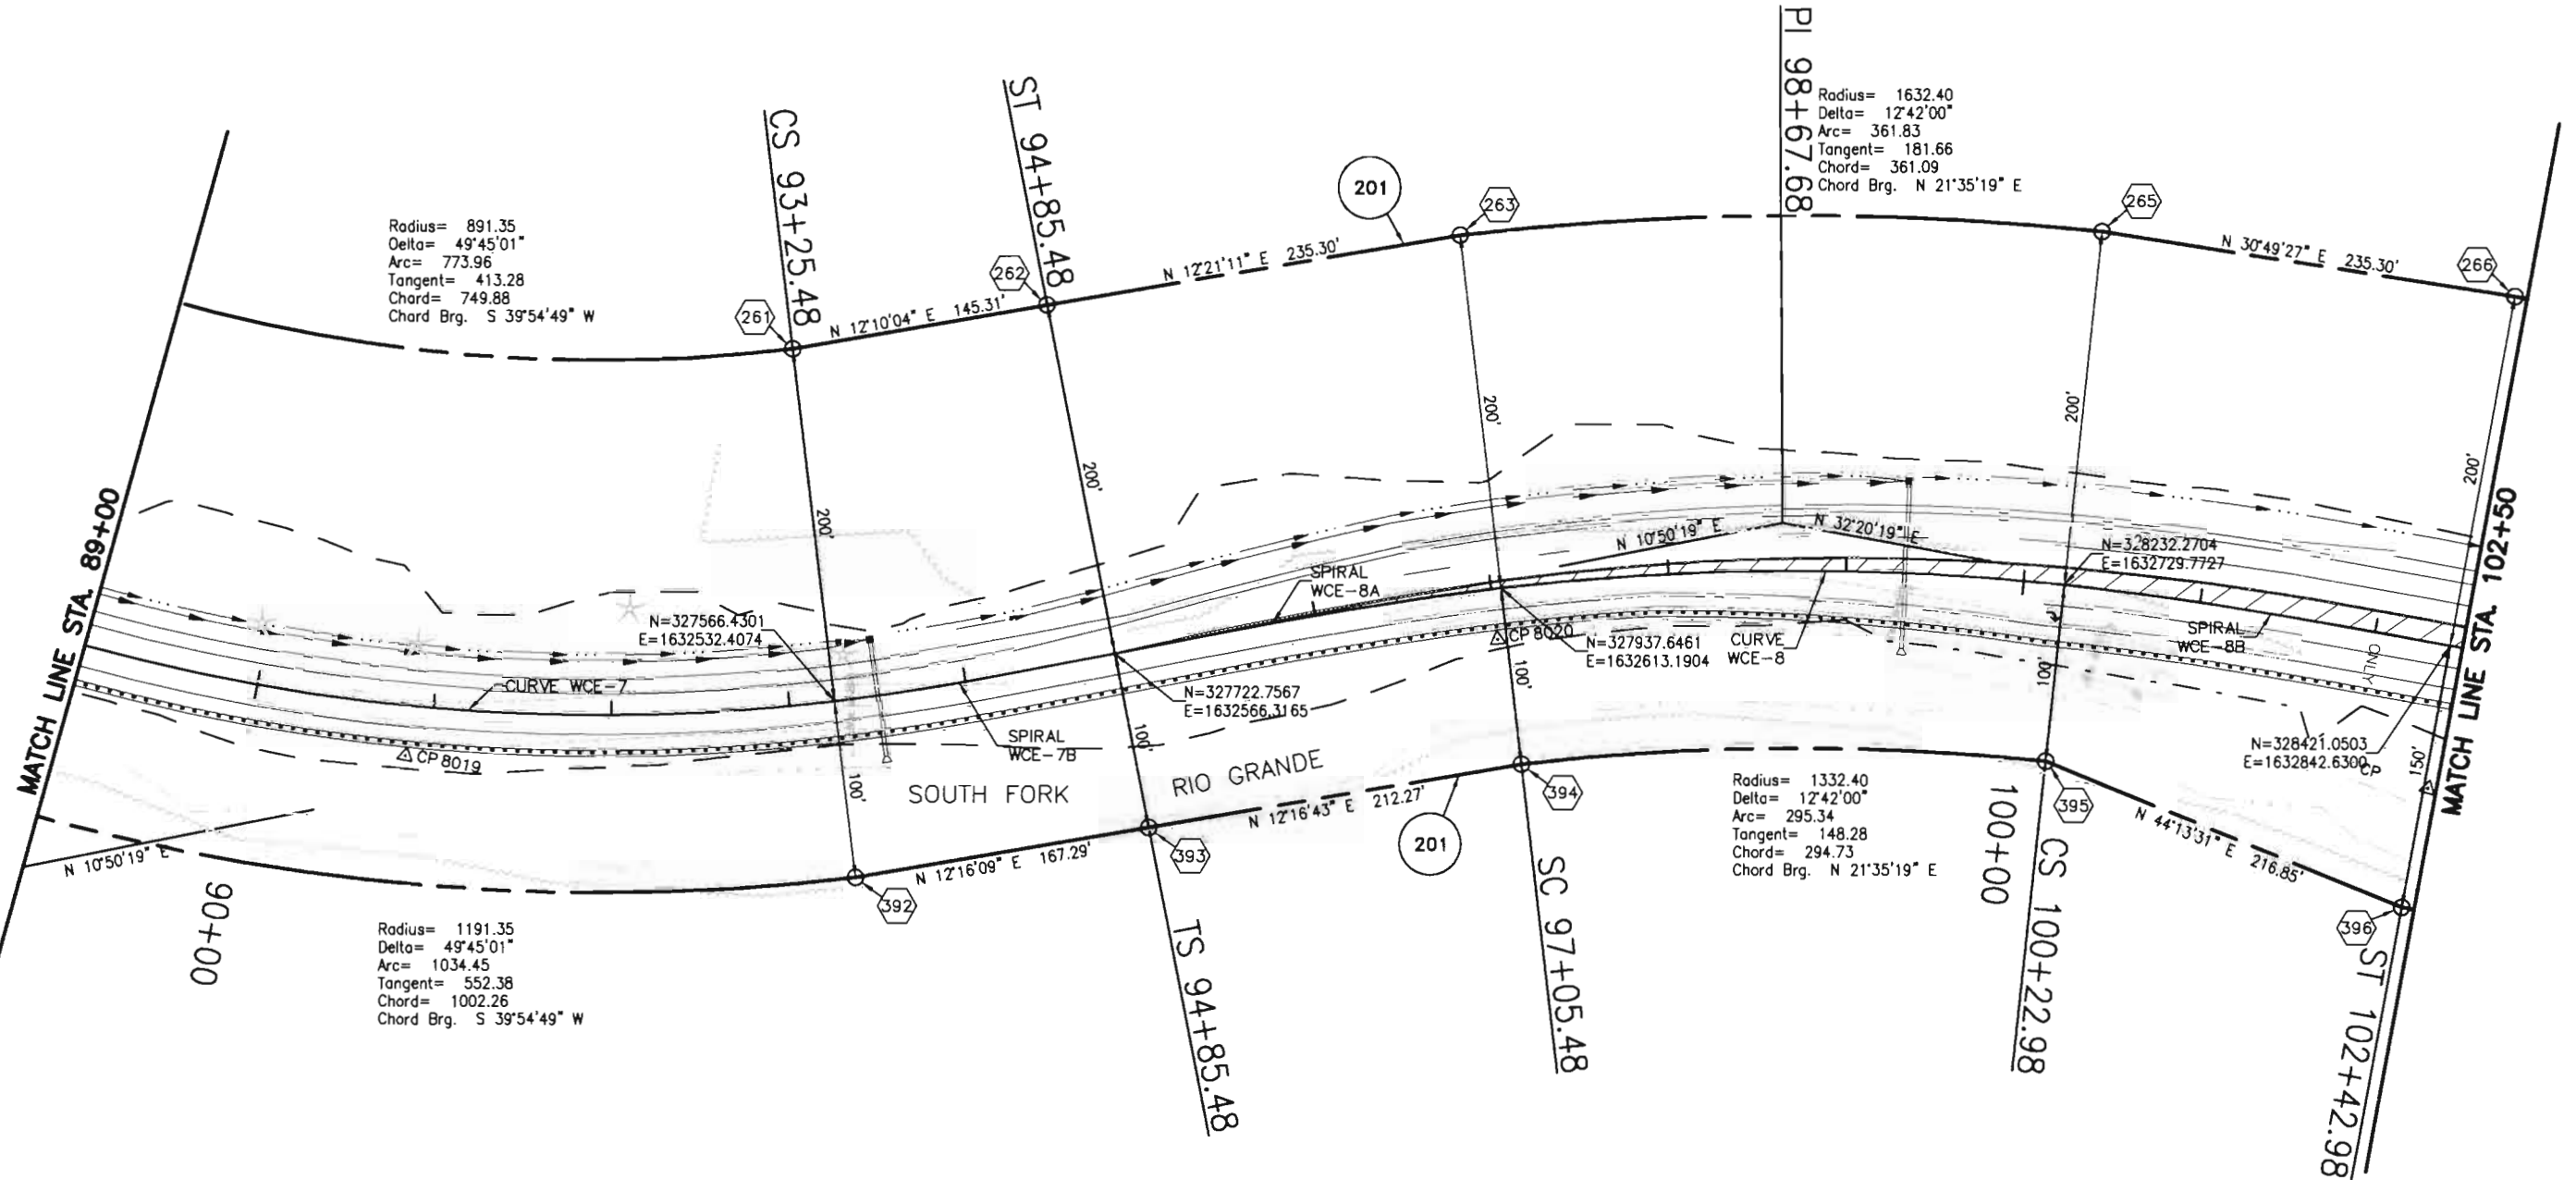


Radius= 891.35
Delta= 49°45'01"
Arc= 773.96
Tangent= 413.28
Chord= 749.88
Chord Brg. S 39°54'49" W

Radius= 1632.40
Delta= 12°42'00"
Arc= 361.83
Tangent= 181.66
Chord= 361.09
Chord Brg. N 21°35'19" E

Radius= 1191.35
Delta= 49°45'01"
Arc= 1034.45
Tangent= 552.38
Chord= 1002.26
Chord Brg. S 39°54'49" W

Radius= 1332.40
Delta= 12°42'00"
Arc= 295.34
Tangent= 148.28
Chord= 294.73
Chord Brg. N 21°35'19" E

CURVE WCE-7 PI 89+05.20 D= 49°45'00.5" R= 1091.349 Dc= 5715'00.0" A= 947.622 C= 918.132	SPIRAL WCE-7B Ls=160.000 Ang=4°12'00.0" LT=106.697 ST=53.361	SPIRAL WCE-8A Ls=220.000 Ang=4°24'00.0" LT=146.712 ST=73.375	CURVE WCE-8 PI 98+67.68 D= 12°42'00.1" R= 1432.395 Dc= 4700'00.0" A= 317.501 C= 316.852	SPIRAL WCE-8B Ls=220.000 Ang=4°24'00.0" LT=146.712 ST=73.375
--	---	---	--	---

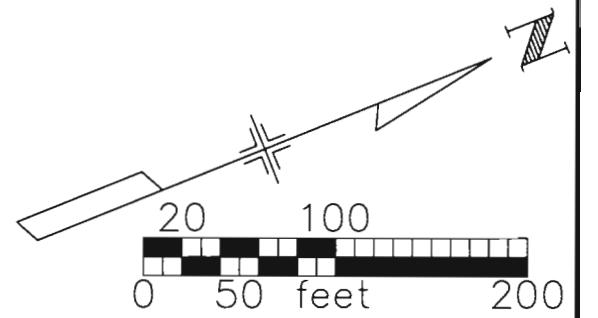

COLORADO DEPARTMENT OF TRANSPORTATION



Region 5
Address: 3803 North Main Avenue, Suite 300
Durango, Colorado 81301
Phone: (970) 385-1400 FAX: (970) 385-1410

Right of Way Plans Unit: Crumbaugh

Sheet Revisions

mm/yy	xxxxx	xxx

Sheet Revisions

mm/yy	xxxxx	xxx

Sheet Revisions

mm/yy	xxxxx	xxx

Right of Way Plans


Right of Way Plan Sheet

Project Number:	NH (CX)160-2(50) UNIT 2
Project Location:	WOLF CREEK PASS EAST
Project Code:	92977
Last Mod. Date	---
Subst Sheets	4 of 27
Sheet No.	9
Total No. of Sheets	49

T.38 N, R.2 E, NMPM

Carter-Burgess

Radius= 998.84
Delta= 00°54'36"
Arc= 15.87
Tangent= 7.93
Chord= 15.87
Chord Brg. N 36°52'22" E

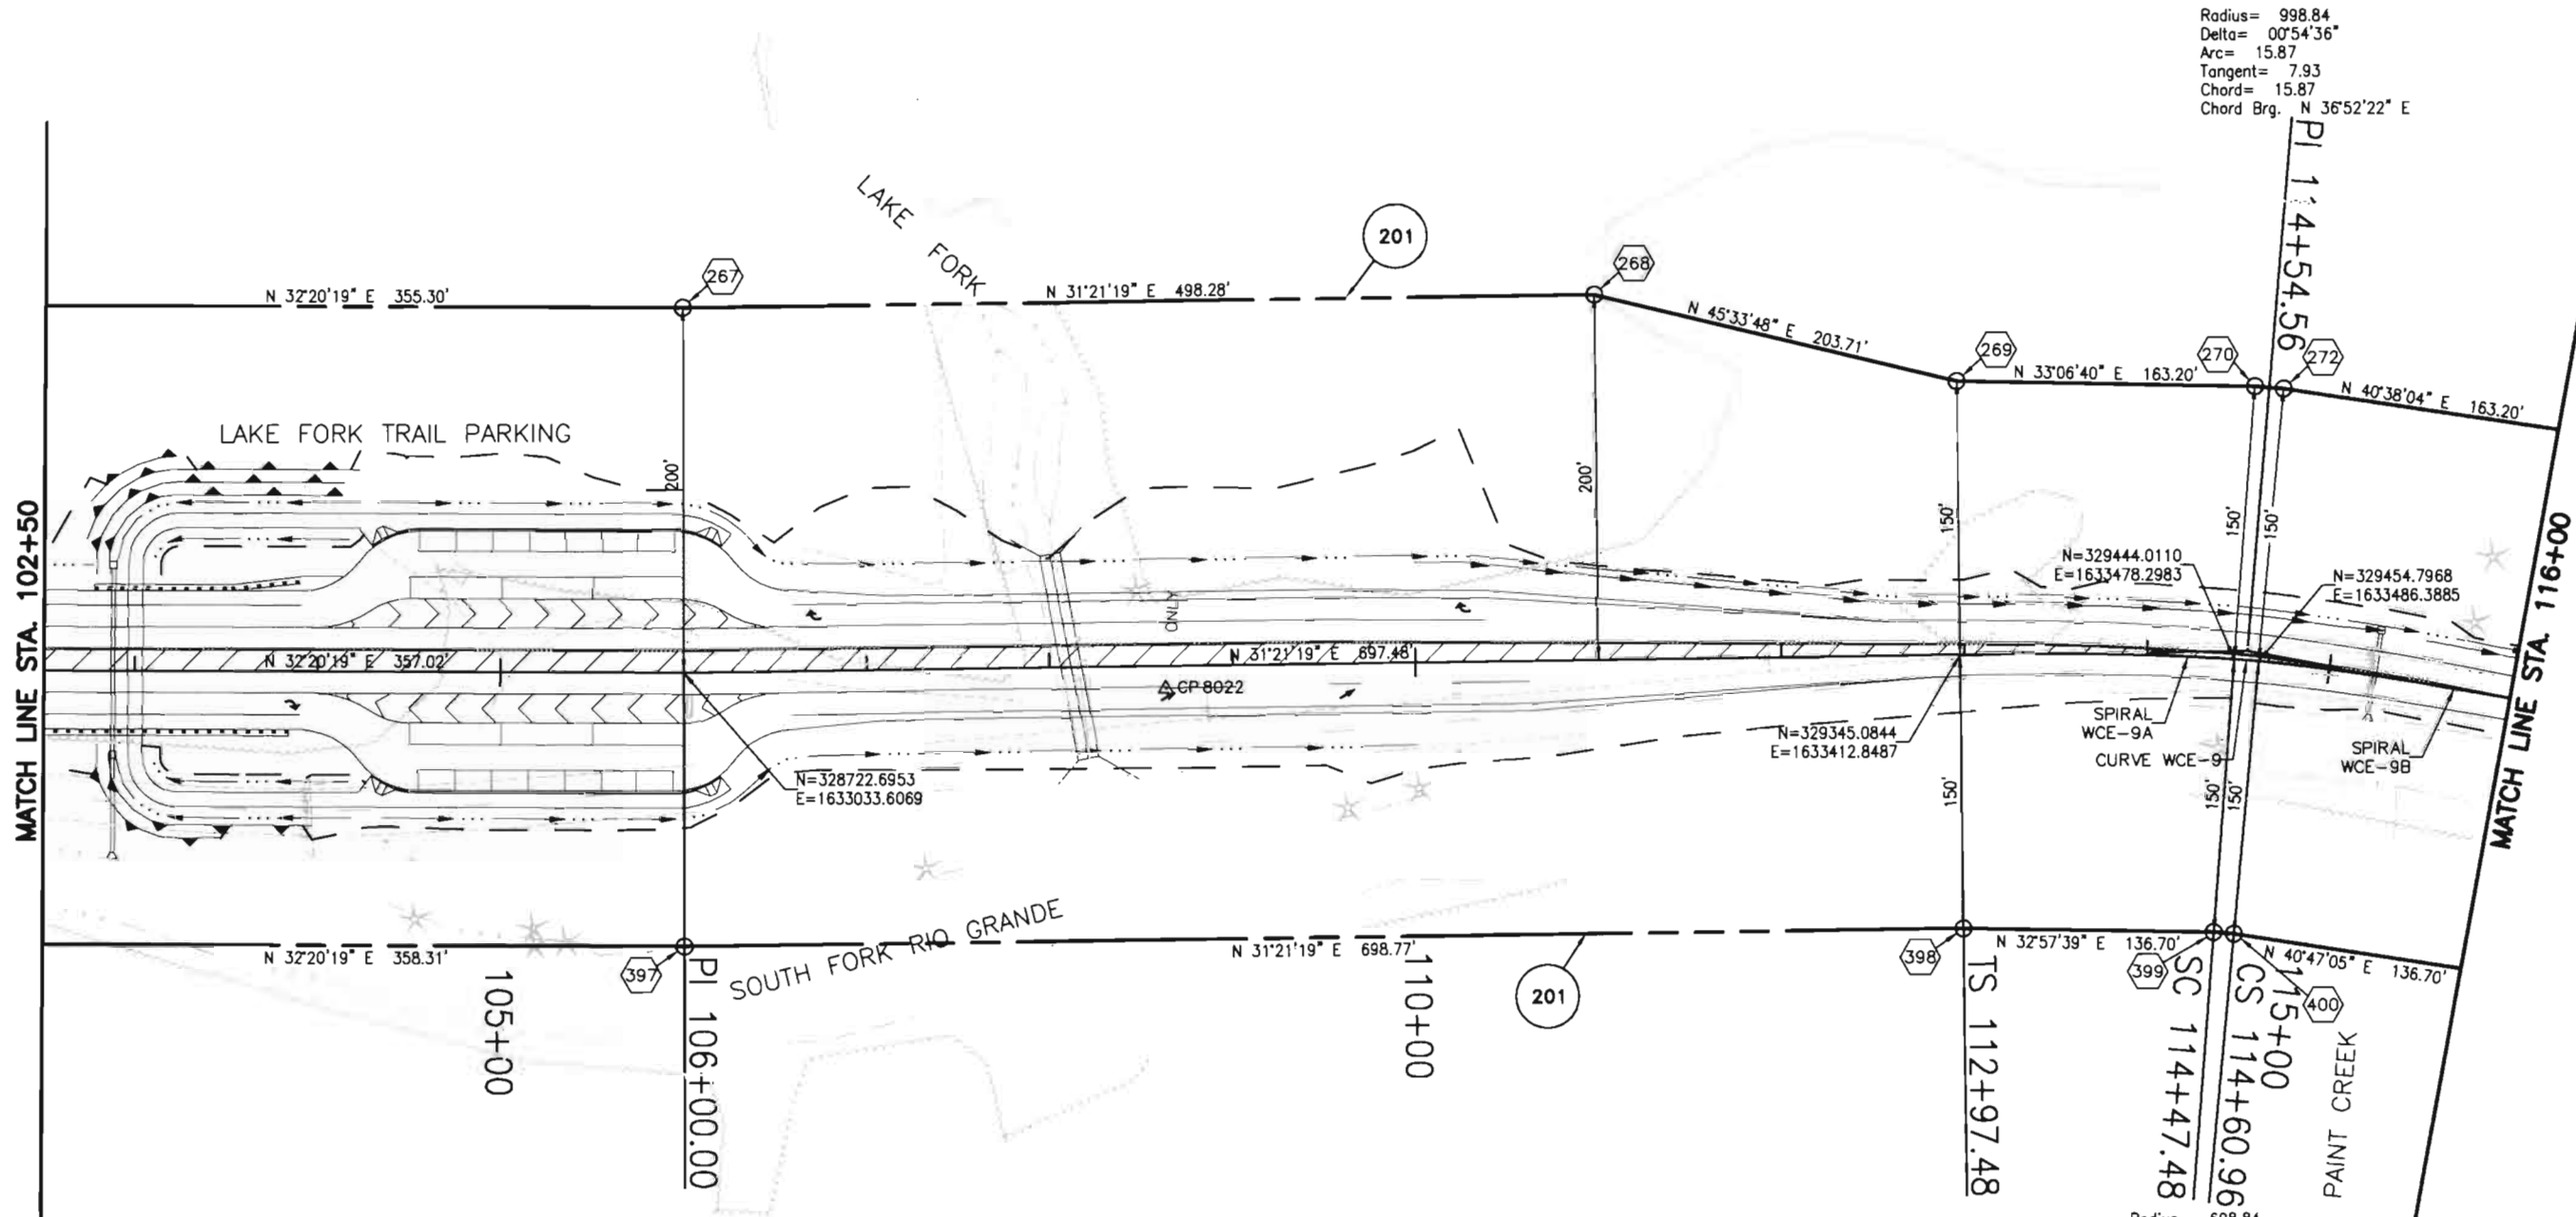


Radius= 698.84
Delta= 00°54'36"
Arc= 11.10
Tangent= 5.55
Chord= 11.10
Chord Brg. N 36°52'22" E

SPIRAL WCE-9A
Ls=150.000
Ang=5°03'45.0"
LT=100.041
ST=50.037

CURVE WCE-9
PI 114+85.91
D= 0°54'35.9"
R= 848.827
Dc=6°45'00.0"
A= 13.481
C= 13.481

SPIRAL WCE-9B
Ls=150.000
Ang=5°03'45.0"
LT=100.041
ST=50.037

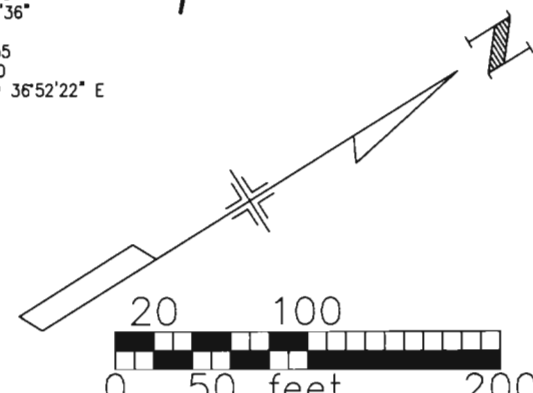

COLORADO DEPARTMENT OF TRANSPORTATION



Region 5
Address: 3803 North Main Avenue, Suite 300
Durango, Colorado 81301
Phone: (970) 385-1400 FAX: (970) 385-1410

Right of Way Plans Unit: Crumbaugh

Sheet Revisions

mm/yy	xxxx	xxx

Sheet Revisions

mm/yy	xxxx	xxx

Sheet Revisions

mm/yy	xxxx	xxx


Right of Way Plans

Right of Way Plan Sheet

Project Number:	NH (CX)160-2(50) UNIT 2
Project Location:	WOLF CREEK PASS EAST
Project Code:	92977
Last Mod. Date	---
Subset Sheets	5 of 27
Sheet No.	10
Total No. of Sheets	49

T.38 N, R.2 E, NMPM

Carter-Burgess

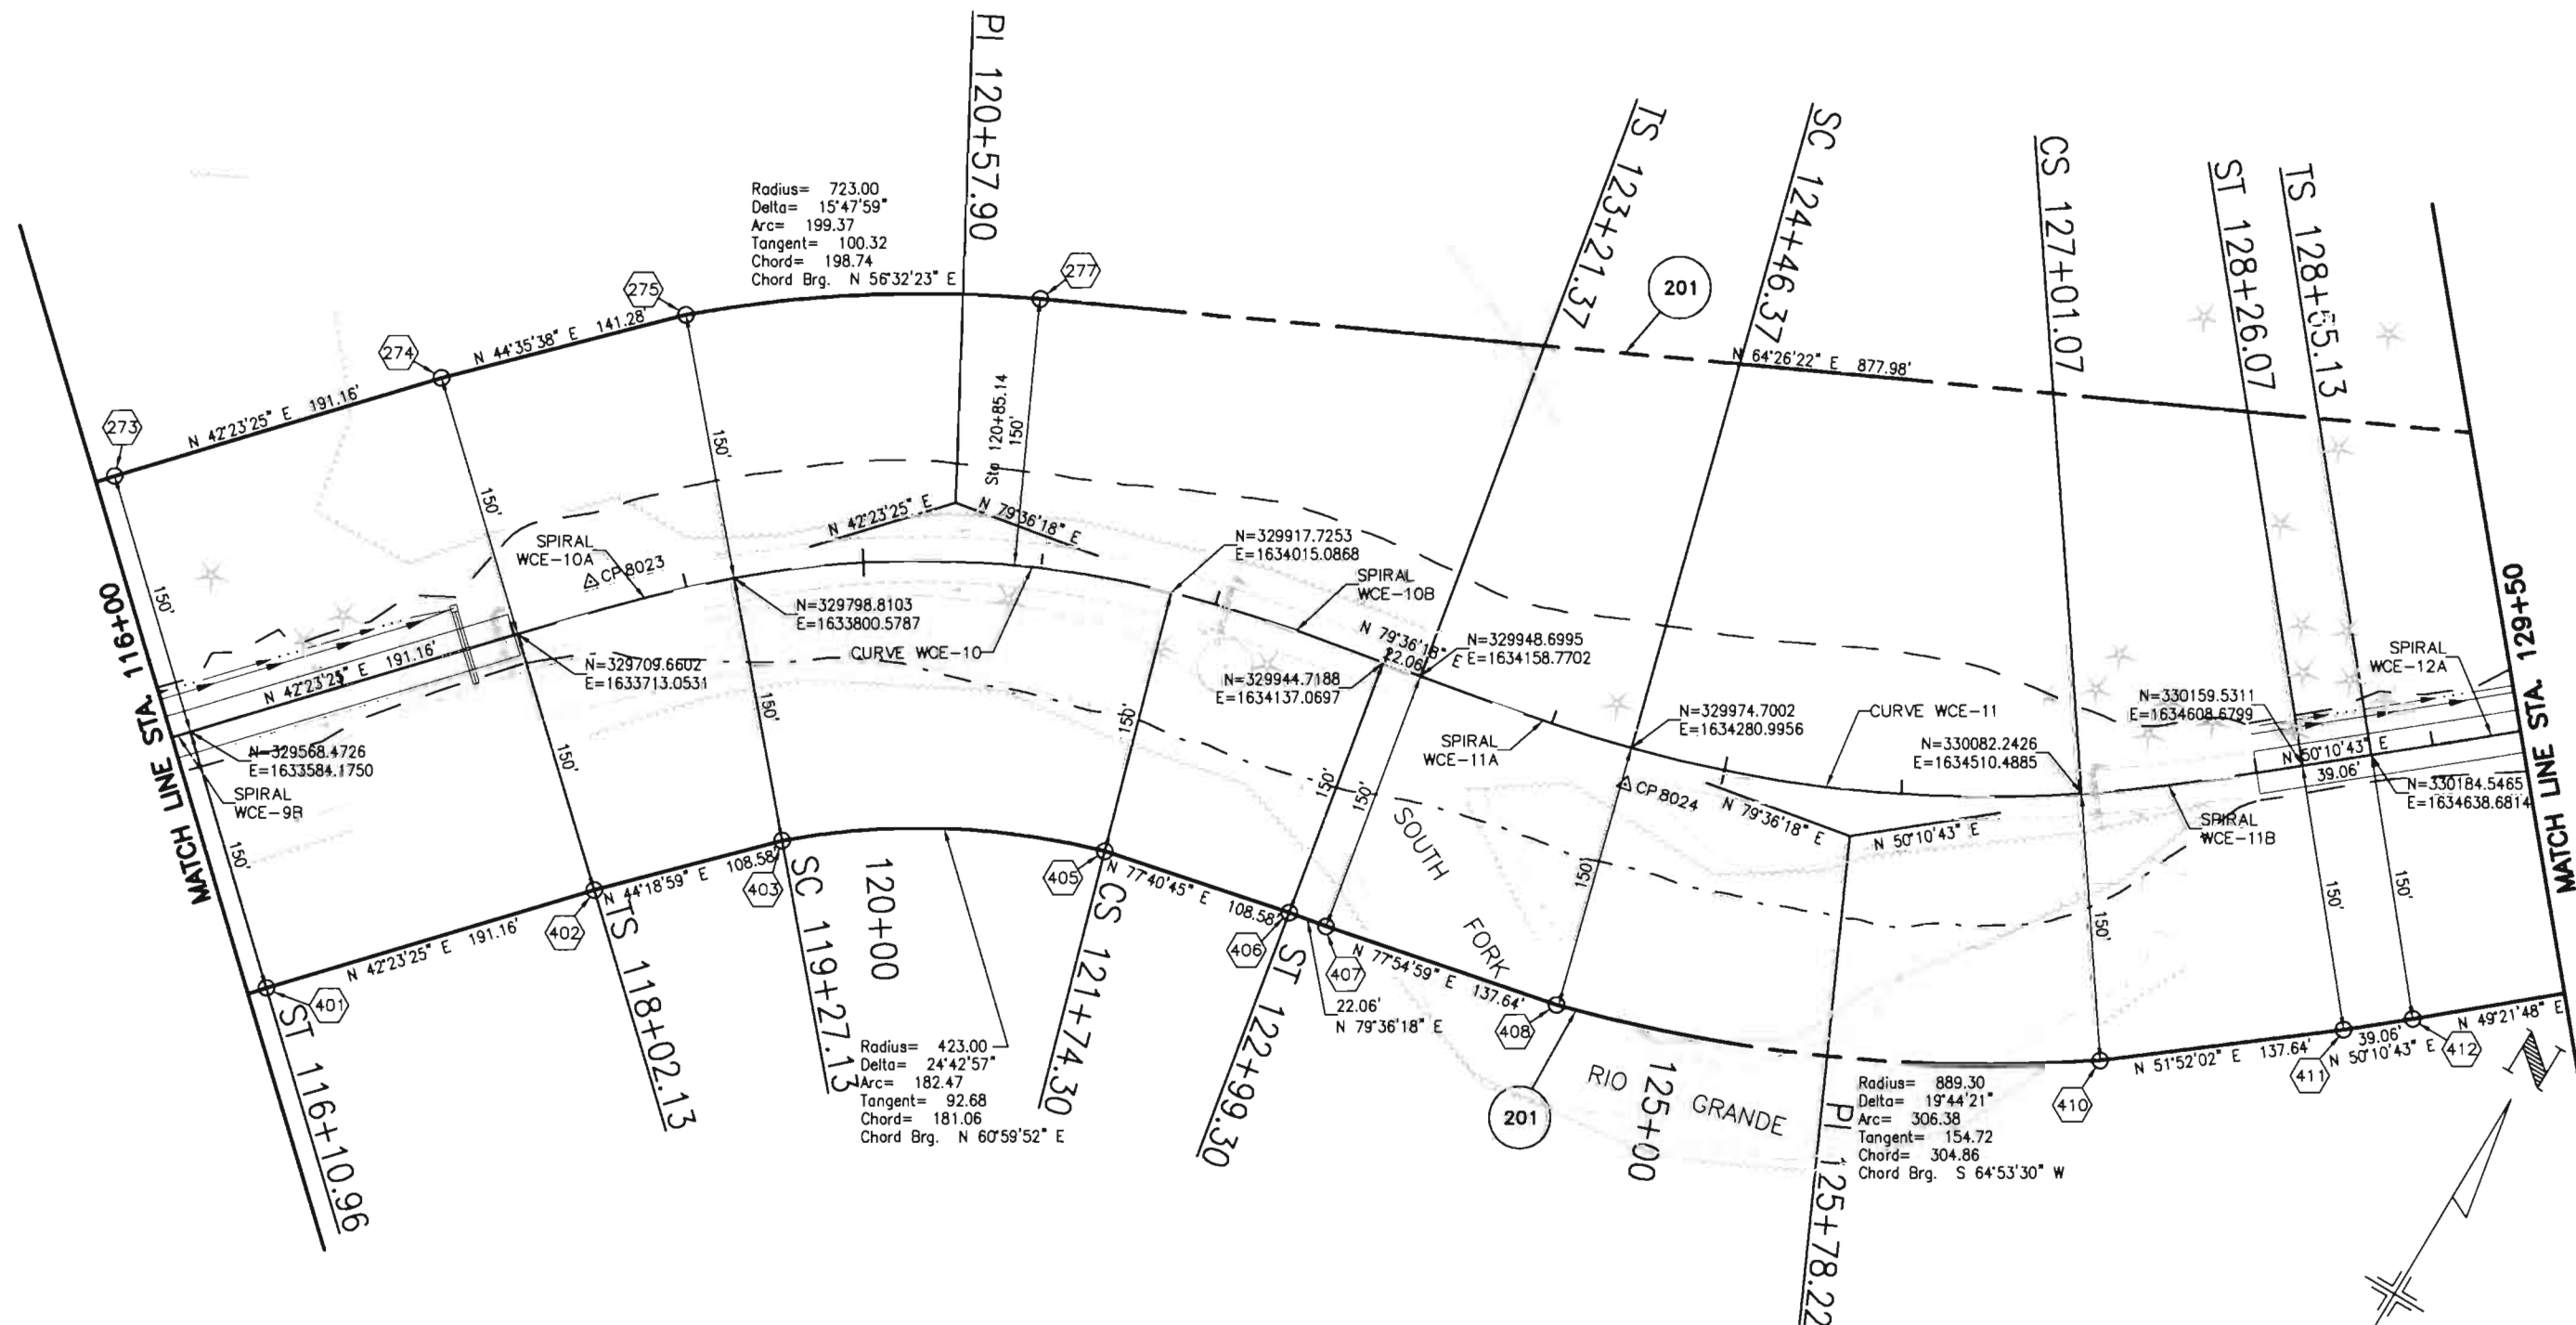

SPIRAL WCE-9B
Ls=150.000
Ang=5°03'45.0"
LT=100.041
ST=50.037

SPIRAL WCE-10A
Ls=125.00
Ang=6°14'58"
LT=83.39
ST=41.71

CURVE WCE-10
PI 120+57.90
D= 24°42'57"
R= 573.00
Dc=9°59'57"
A= 247.18
C= 245.26

 
SPIRAL WCE-10B
Ls=125.00
Ang=6°14'58"
LT=83.39
ST=41.71

SPIRAL WCE-11A
Ls=125.00
Ang=4°50'38"
LT=83.36
ST=41.70

CURVE WCE-11
PI 125+78.22
D= 19°44'21"
R= 739.30
Dc=7°45'00"
A= 254.70
C= 253.44

SPIRAL WCE-11B
Ls=125.00
Ang=4°50'38"
LT=83.36
ST=41.70

SPIRAL WCE-12A
Ls=160.00
Ang=2°23'59"
LT=106.68
ST=53.34



COLORADO DEPARTMENT OF TRANSPORTATION



Region 5
Address: 3803 North Main Avenue, Suite 300
Durango, Colorado 81301
Phone: (970) 385-1400 FAX: (970) 385-1410

Right of Way Plans Unit: Crumbaugh

Sheet Revisions

mm/yy	xxxxx	xxx

Sheet Revisions

mm/yy	xxxxx	xxx

Sheet Revisions

mm/yy	xxxxx	xxx


Right of Way Plans

Right of Way Plan Sheet

Project Number:	NH (CX)160-2(50) UNIT 2
Project Location:	WOLF CREEK PASS EAST
Project Location:	
Project Code:	92977
Last Mod. Date:	---
Subset Sheets:	6 of 27
Sheet No.:	11
Total No. of Sheets:	49

T.38 N, R.2 E, NMPM

Carter-Burgess

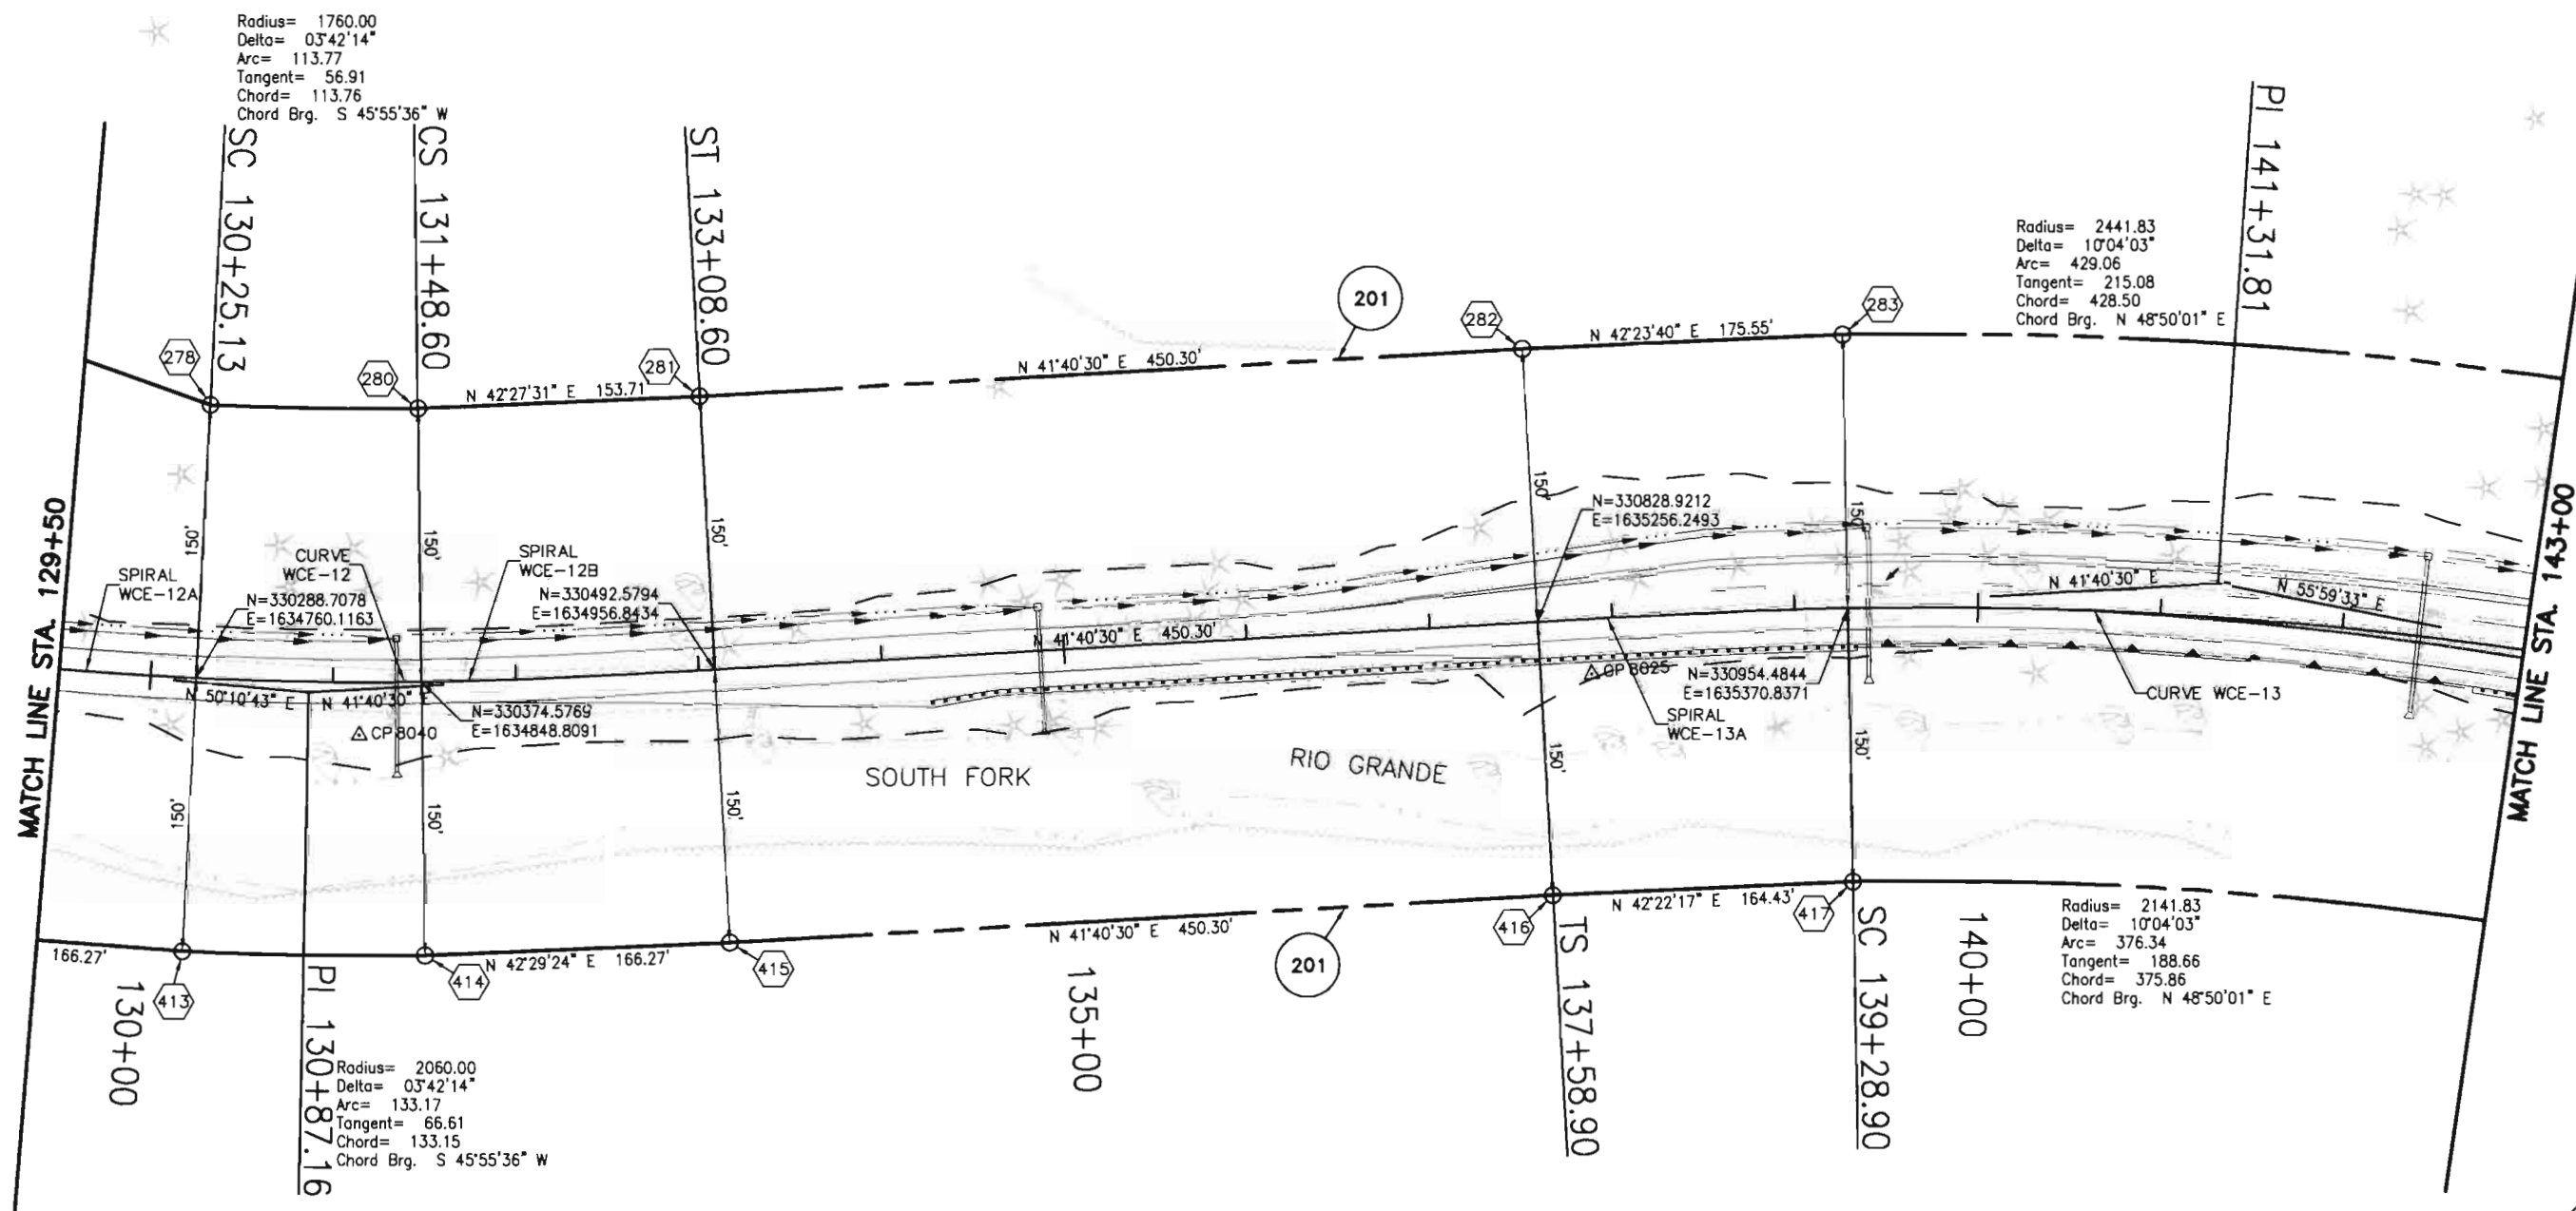


SPIRAL WCE-12A
Ls=160.00
Ang=2°23'59"
LT=106.68
ST=53.34

CURVE WCE-12
PI=130+87.16
D= 3°42'14"
R= 1910.00
Dc=2°59'59"
A= 123.47
C= 123.45

SPIRAL WCE-12B
Ls=160.00
Ang=2°23'59"
LT=106.68
ST=53.34

SPIRAL WCE-13A
Ls=170.00
Ang=2°07'30"
LT=113.34
ST=56.67

CURVE WCE-13
PI=141+31.81
D= 10°04'03"
R= 2291.83
Dc=2°30'00"
A= 402.70
C= 402.18

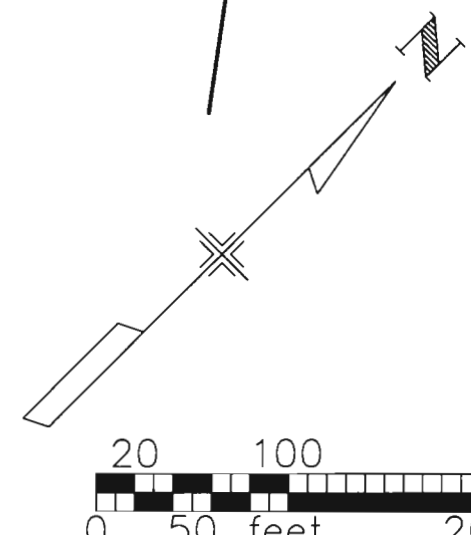

COLORADO DEPARTMENT OF TRANSPORTATION



Region 5
Address: 3803 North Main Avenue, Suite 300
Durango, Colorado 81301
Phone: (970) 385-1400 FAX: (970) 385-1410

Right of Way Plans Unit: Crumbaugh

Sheet Revisions

mm/yy	XXXXX	XXX

Sheet Revisions

mm/yy	XXXXX	XXX

Sheet Revisions

mm/yy	XXXXX	XXX


Right of Way Plans

Right of Way Plan Sheet

Project Number:	NH (CX)160-2(50) UNIT 2			
Project Location:	WOLF CREEK PASS EAST			
Project Location:				
Project Code:	Last Mod. Date	Subset Sheets	Sheet No.	Total No. of Sheets
92977	---	7 of 27	12	49

T.38 N, R.2 E, NMPM

Carter-Burgess

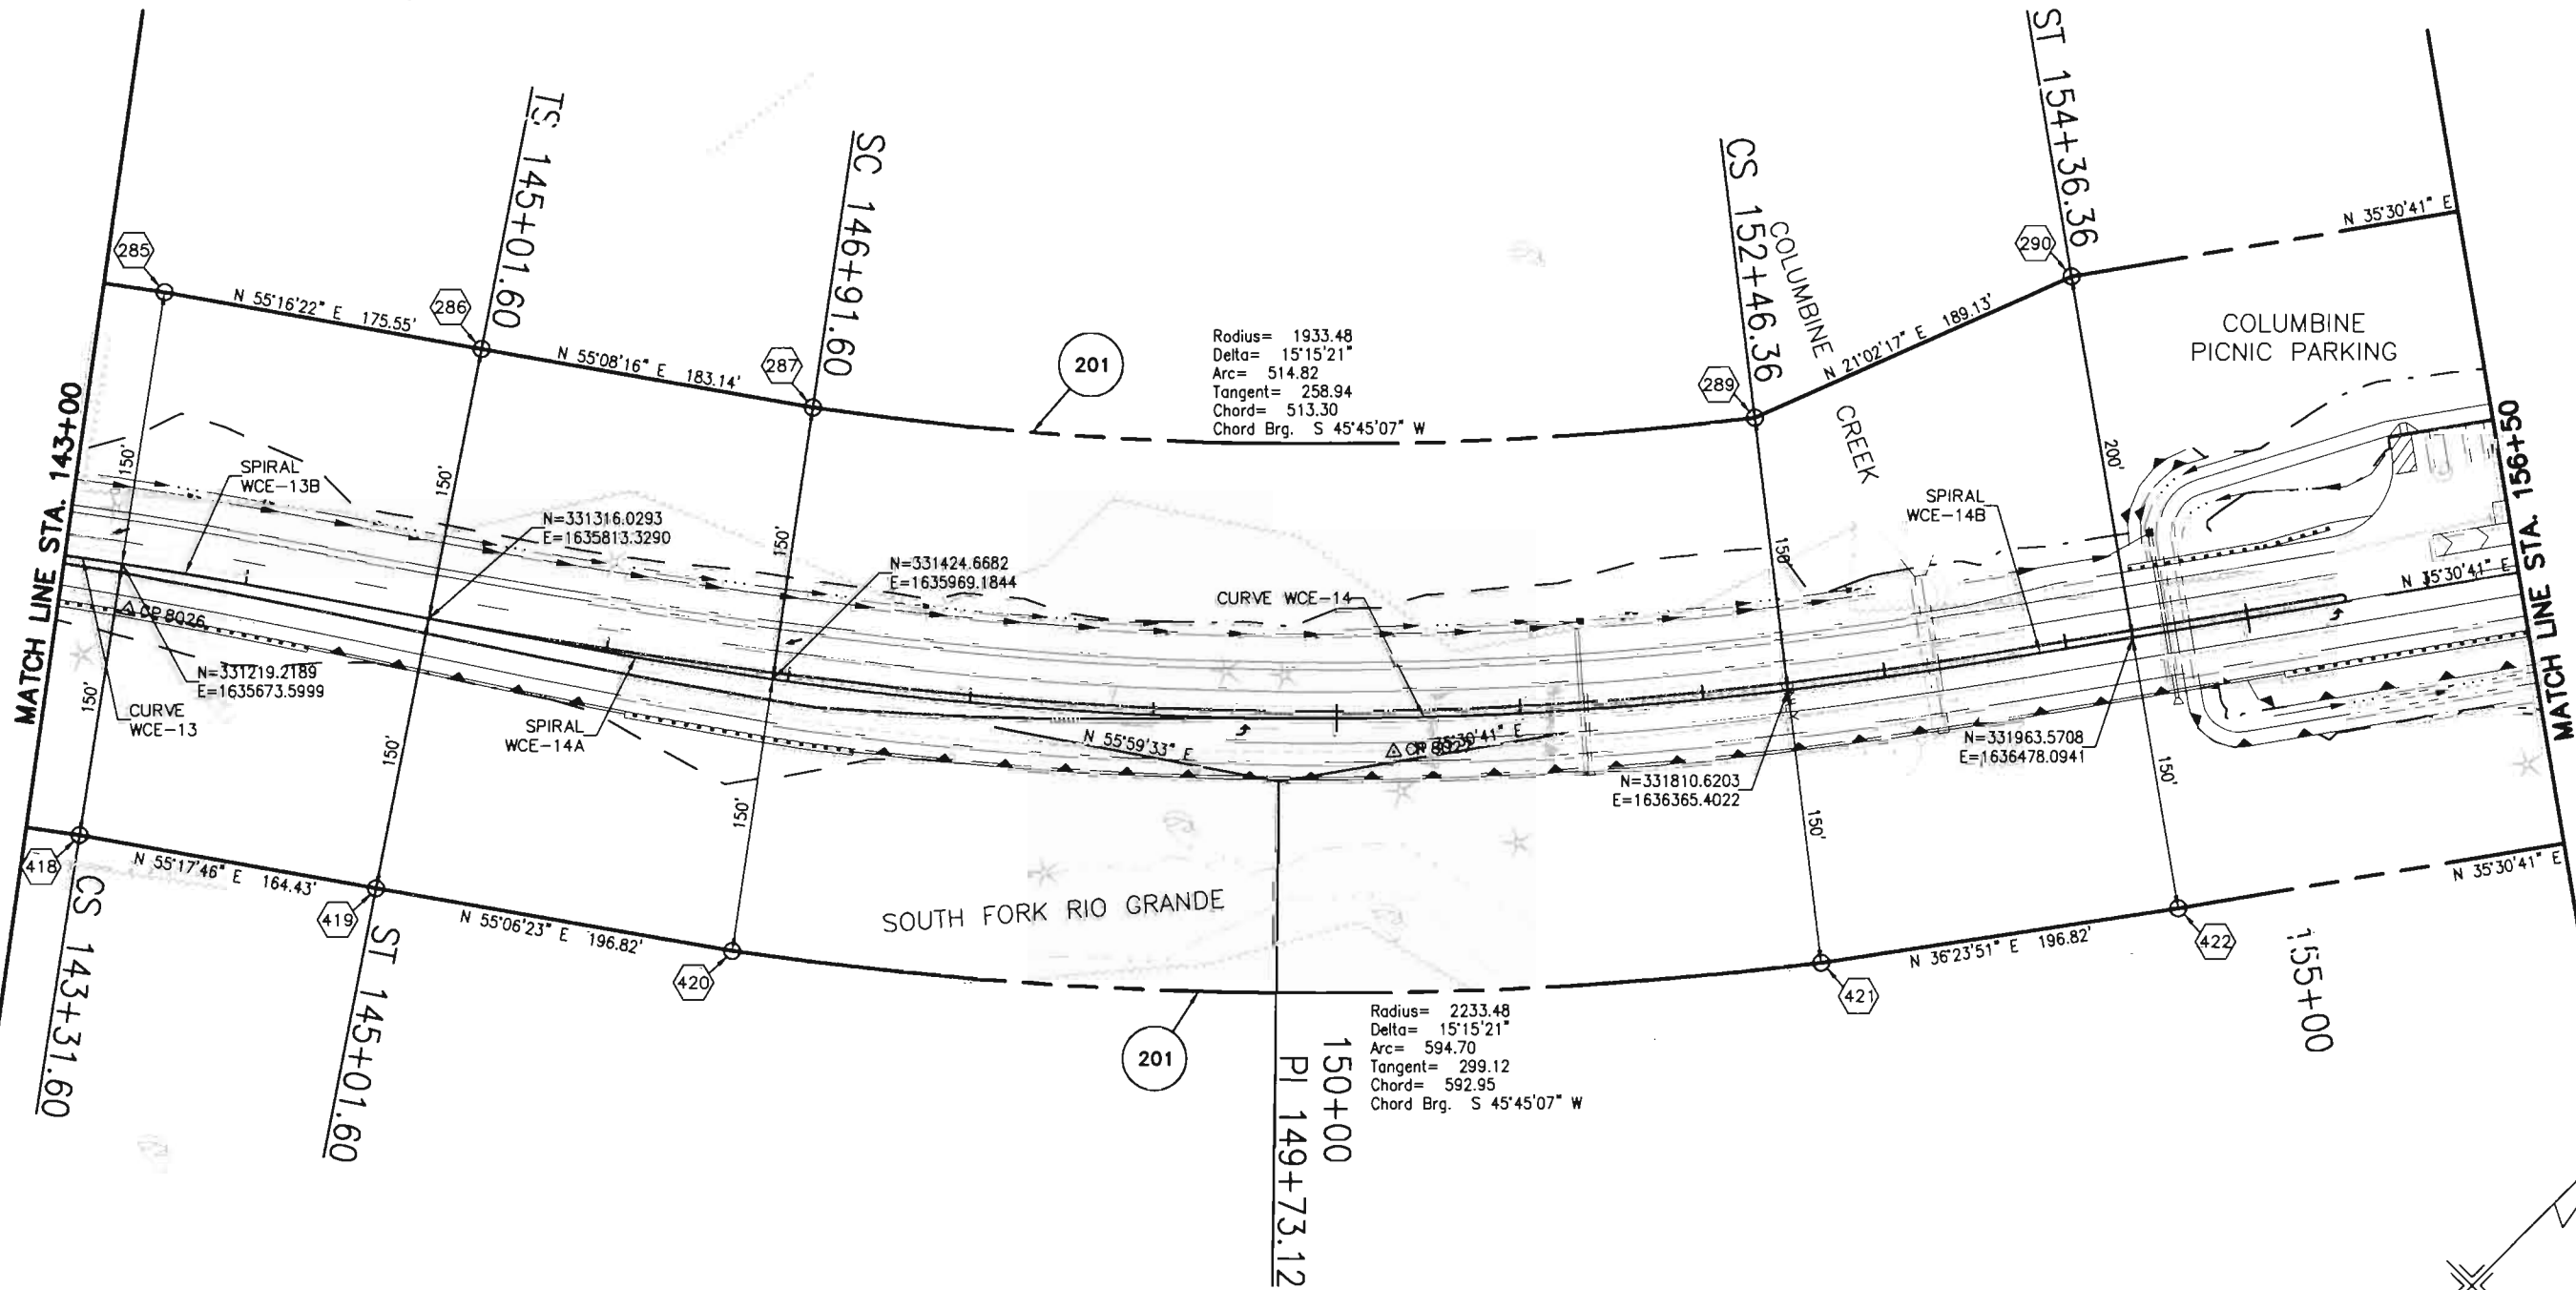


CURVE WCE-13
PI=141+31.81
D= 10°04'03"
R= 2291.83
Dc=2°30'00"
A= 402.70
C= 402.18

SPIRAL WCE-13B
Ls=170.00
Ang=2°07'30"
LT=113.34
ST=56.67

SPIRAL WCE-14A
Ls=190.00
Ang=2°36'45"
LT=126.68
ST=63.35

CURVE WCE-14
PI=149+73.12
D= 15°15'21"
R= 2083.48
Dc=2°45'00"
A= 554.76
C= 553.13

SPIRAL WCE-14B
Ls=190.00
Ang=2°36'45"
LT=126.68
ST=63.35

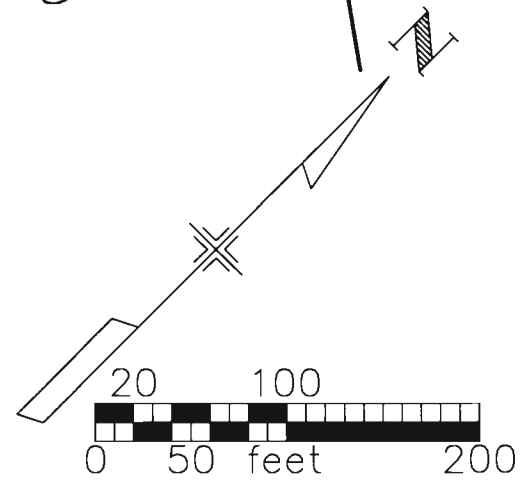



Region 5
Address: 3803 North Main Avenue, Suite 300
Durango, Colorado 81301
Phone: (970) 385-1400 FAX: (970) 385-1410

Right of Way Plans Unit: Crumbaugh

[illegible][illegible][illegible]

Right of Way Plans


Right of Way Plan Sheet

Project Number:		NH (CX)160-2(50) UNIT 2		
Project Location:		WOLF CREEK PASS EAST		
Project Location:				
Project Code:	Last Mod. Date	Subset Sheets	Sheet No.	Total No. of Sheets
92977	---	8 of 27	13	49

T.39 N, R.2 E, NMPM

T.38 N, R.2 E, NMPM

Carter :: Burgess

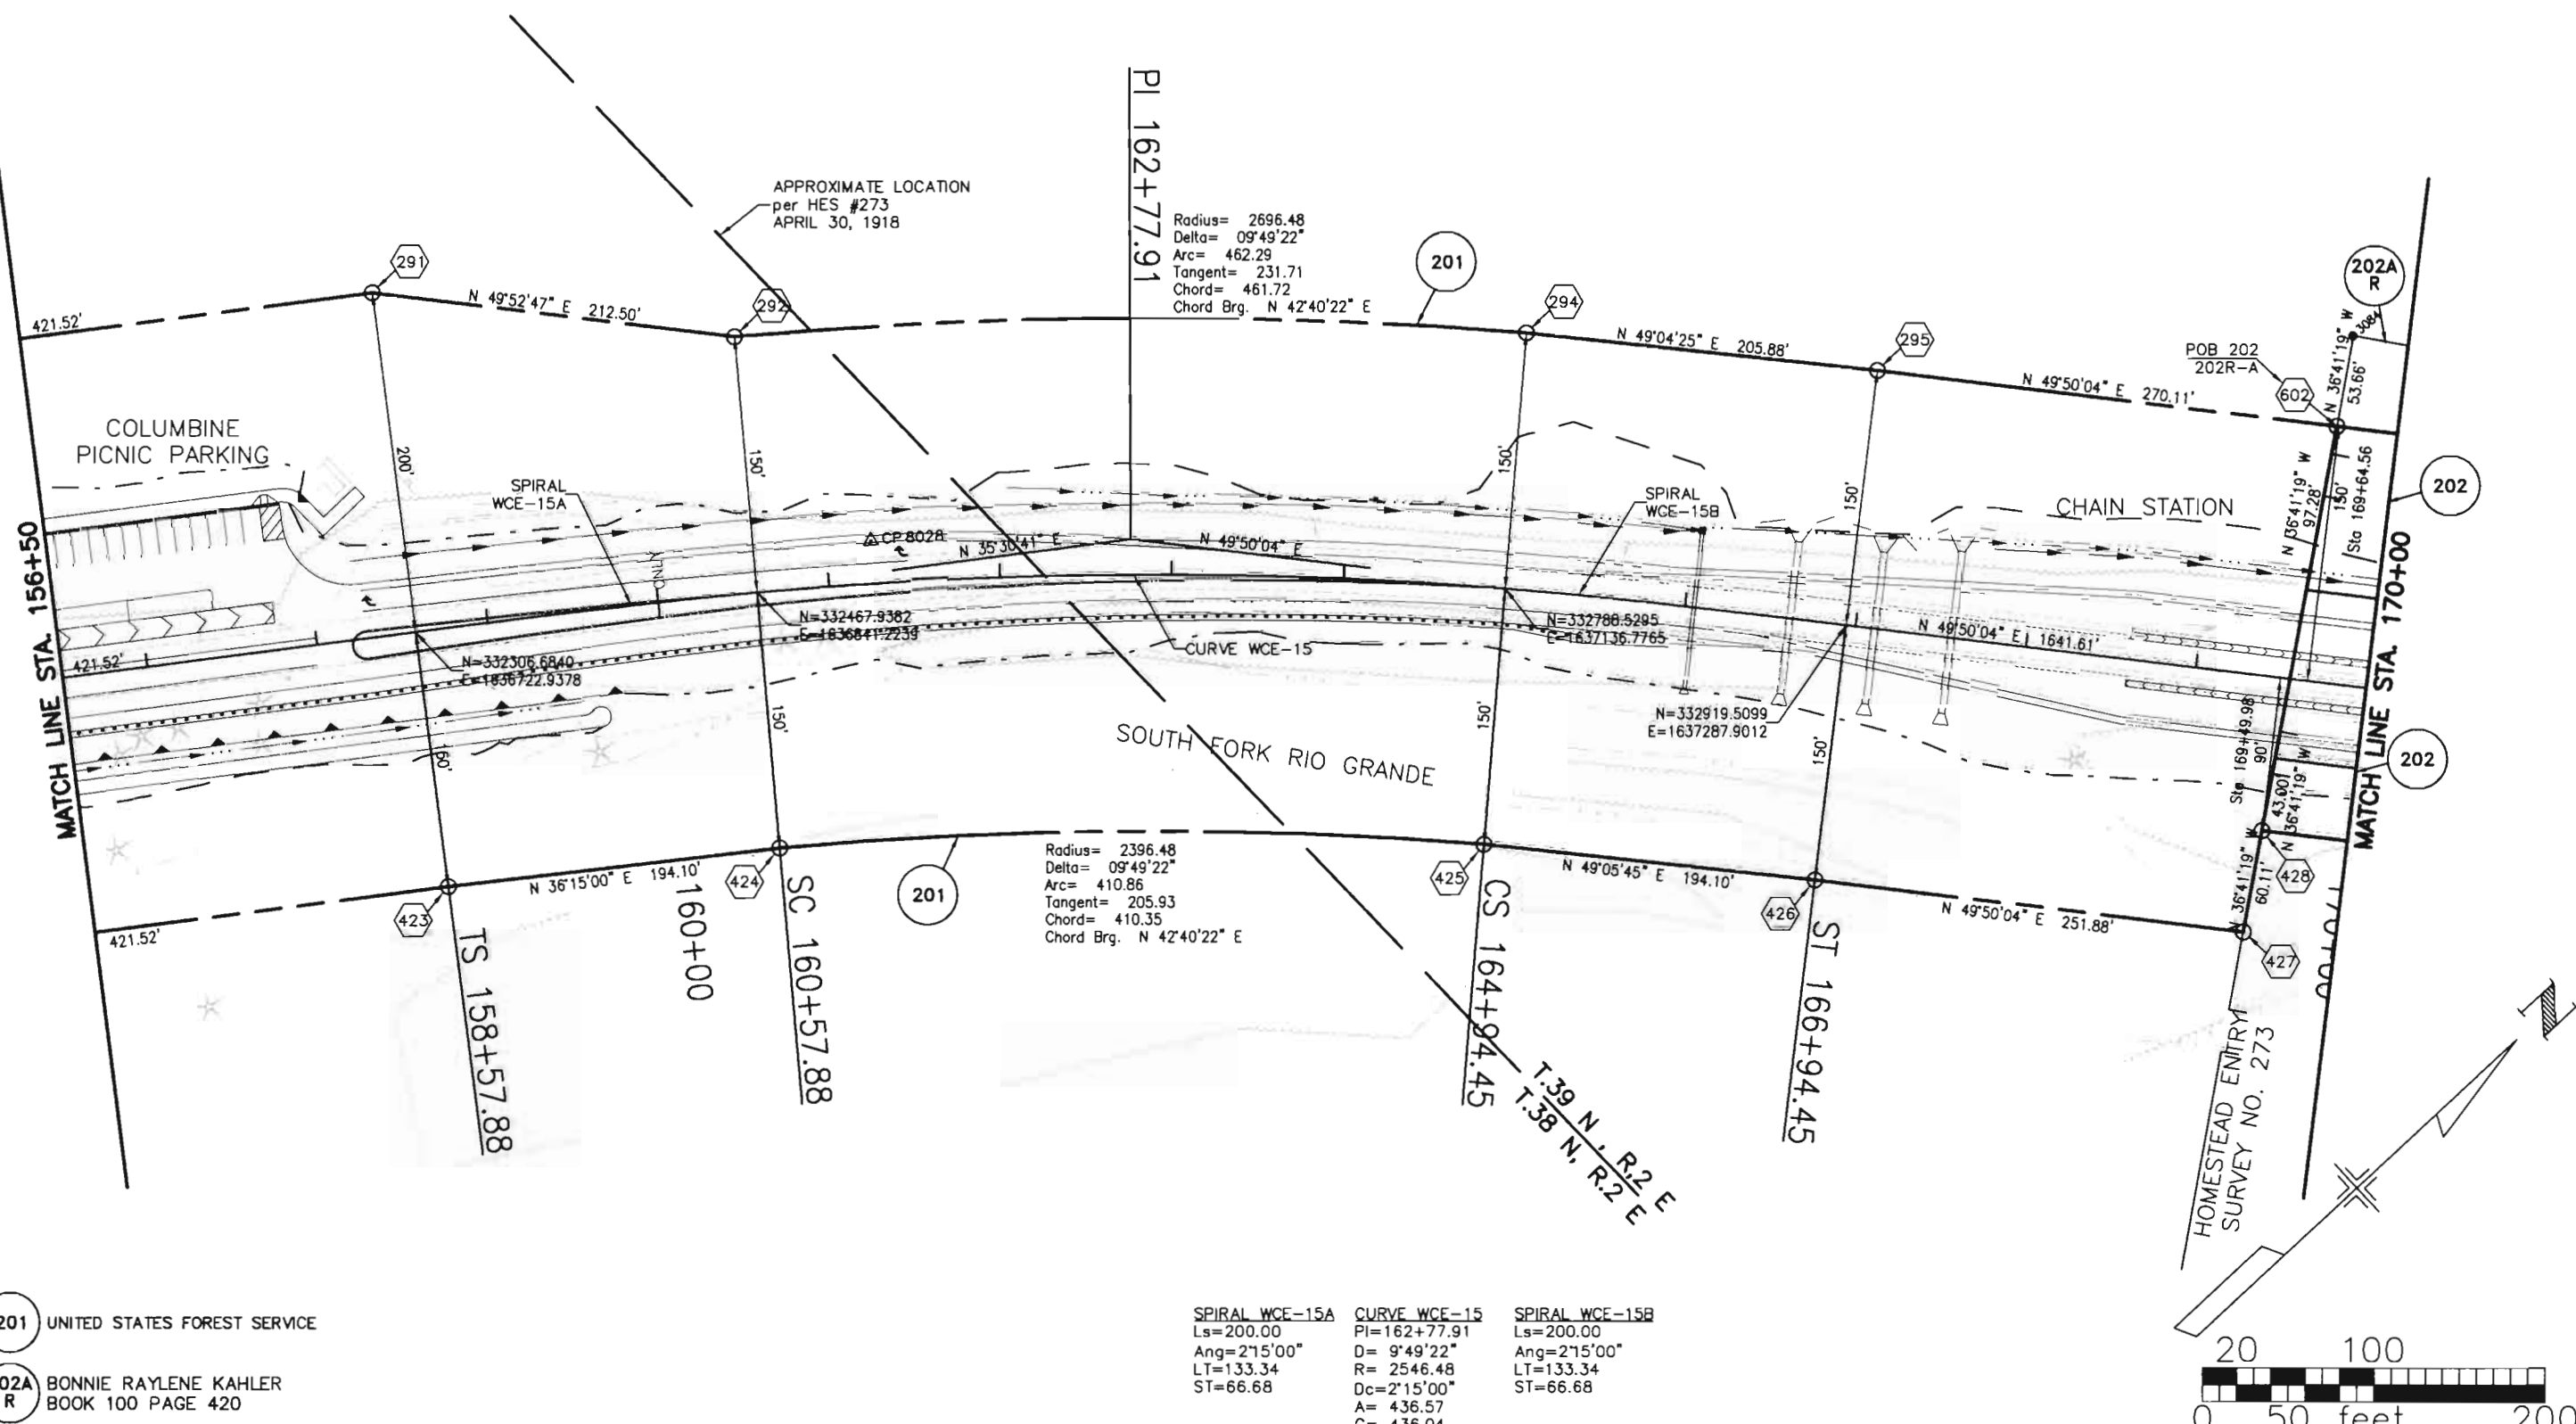

DEPOSITED THIS ____ DAY OF _____, 19____, AT _____, _____, FOR INFORMATION
ONLY IN BOOK _____ OF THE COUNTY LAND SURVEYS/RIGHT OF WAY
SURVEYS AT PAGE _____, RECEPTION NUMBER _____.

\\0/0022\DWGS\RCWPLAN\WCE08HG.DWG, 08/12/2002 10:34:02 AM

COLORADO DEPARTMENT OF TRANSPORTATION



Region 5
Address: 3803 North Main Avenue, Suite 300
Durango, Colorado 81301
Phone: (970) 385-1400 FAX: (970) 385-1410

Right of Way Plans Unit: Crumbaugh

Sheet Revisions

mm/yy	xxxxx	xxx

Sheet Revisions

mm/yy	xxxxx	xxx

Sheet Revisions

mm/yy	xxxxx	xxx


Right of Way Plans

Right of Way Plan Sheet

Project Number:		NH (CX)160-2(50) UNIT 2		
Project Location:		WOLF CREEK PASS EAST		
Project Location:				
Project Code:	Last Mod. Date	Subset Sheets	Sheet No.	Total No. of Sheets
92977	---	9 of 27	14	49

T.39 N, R.3 E, NMPM

Carter-Burgess

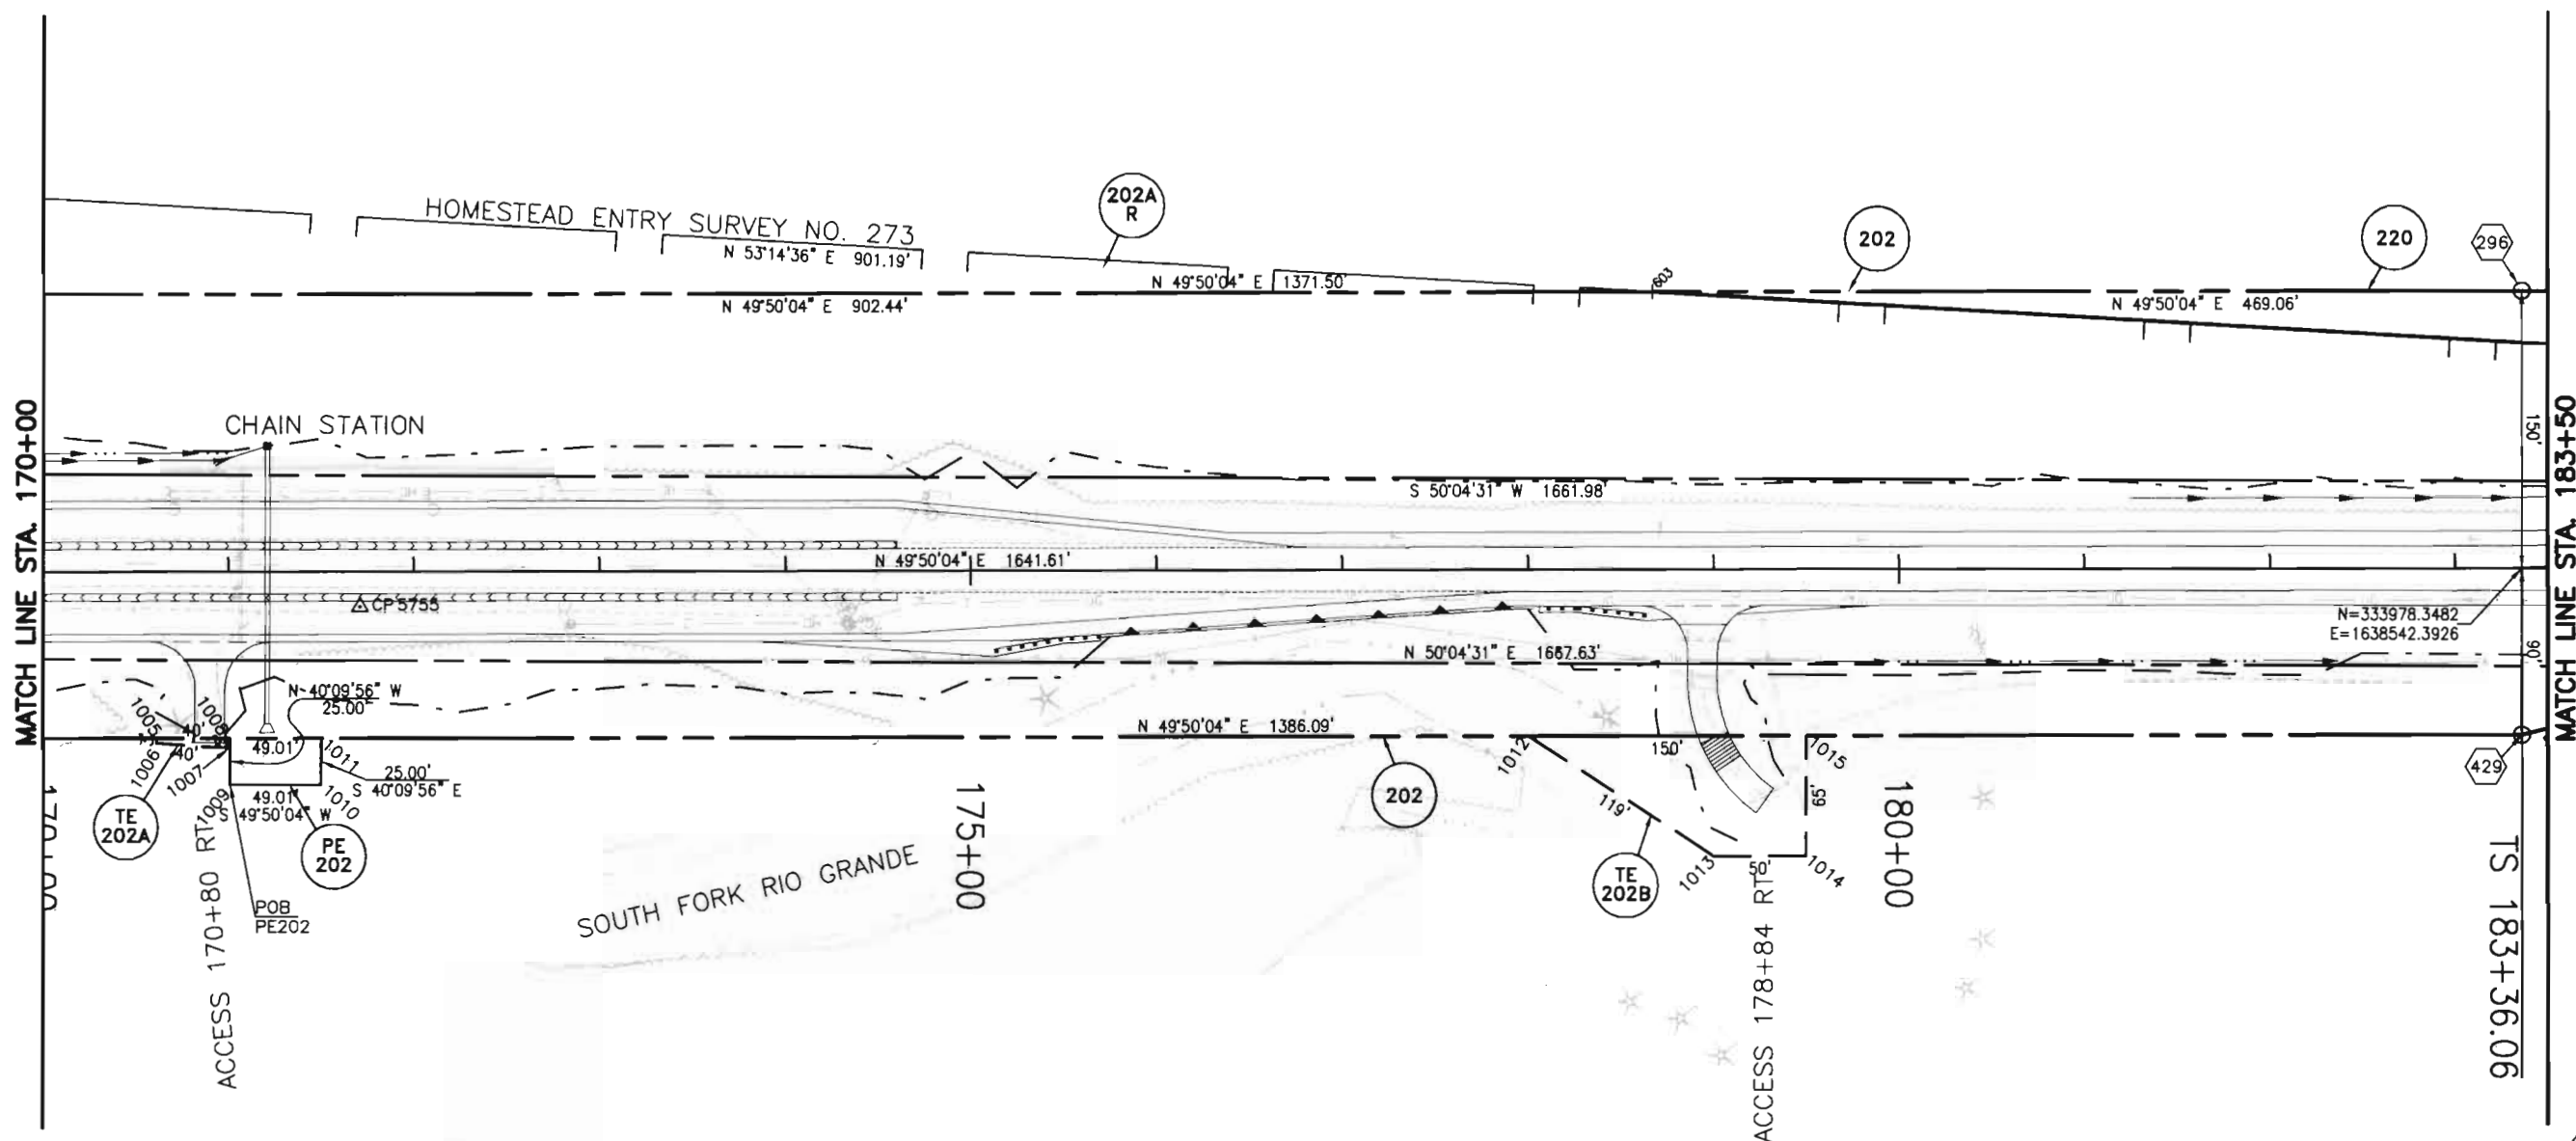

220 UNITED STATES FOREST SERVICE

TE 202B TE 202A PE 202 202A R 202 BONNIE RAYLENE KAHLER
BOOK 100 PAGE 420



DEPOSITED THIS DAY OF 19 AT FOR INFORMATION
ONLY IN BOOK OF THE COUNTY LAND SURVEYS/RIGHT OF WAY
SURVEYS AT PAGE RECEPTION NUMBER

0/0022\DWGS\RCWPLAN\WCE09RP.DWG, 08/12/2002 10:31:49 AM

dstamp

COLORADO DEPARTMENT OF TRANSPORTATION



Region 5
Address: 3803 North Main Avenue, Suite 300
Durango, Colorado 81301
Phone: (970) 385-1400 FAX: (970) 385-1410

Right of Way Plans Unit: Crumbaugh

Sheet Revisions		
mm/yy	xxxx	xxx



Sheet Revisions		
mm/yy	xxxx	xxx

Sheet Revisions		
mm/yy	xxxx	xxx

Right of Way Plans				
Right of Way Plan Sheet				
Project Number:	NH (CX)160-2(50) UJIT 2			
Project Location:	WOLF CREEK PASS EAST			
Project Location:				
Project Code:	Last Mod. Date	Subset Sheets	Sheet No.	Total No. of Sheets
92977	---	10 of 27	15	49

T.39 N, R.2 E, NMPPM

Carter-Burgess

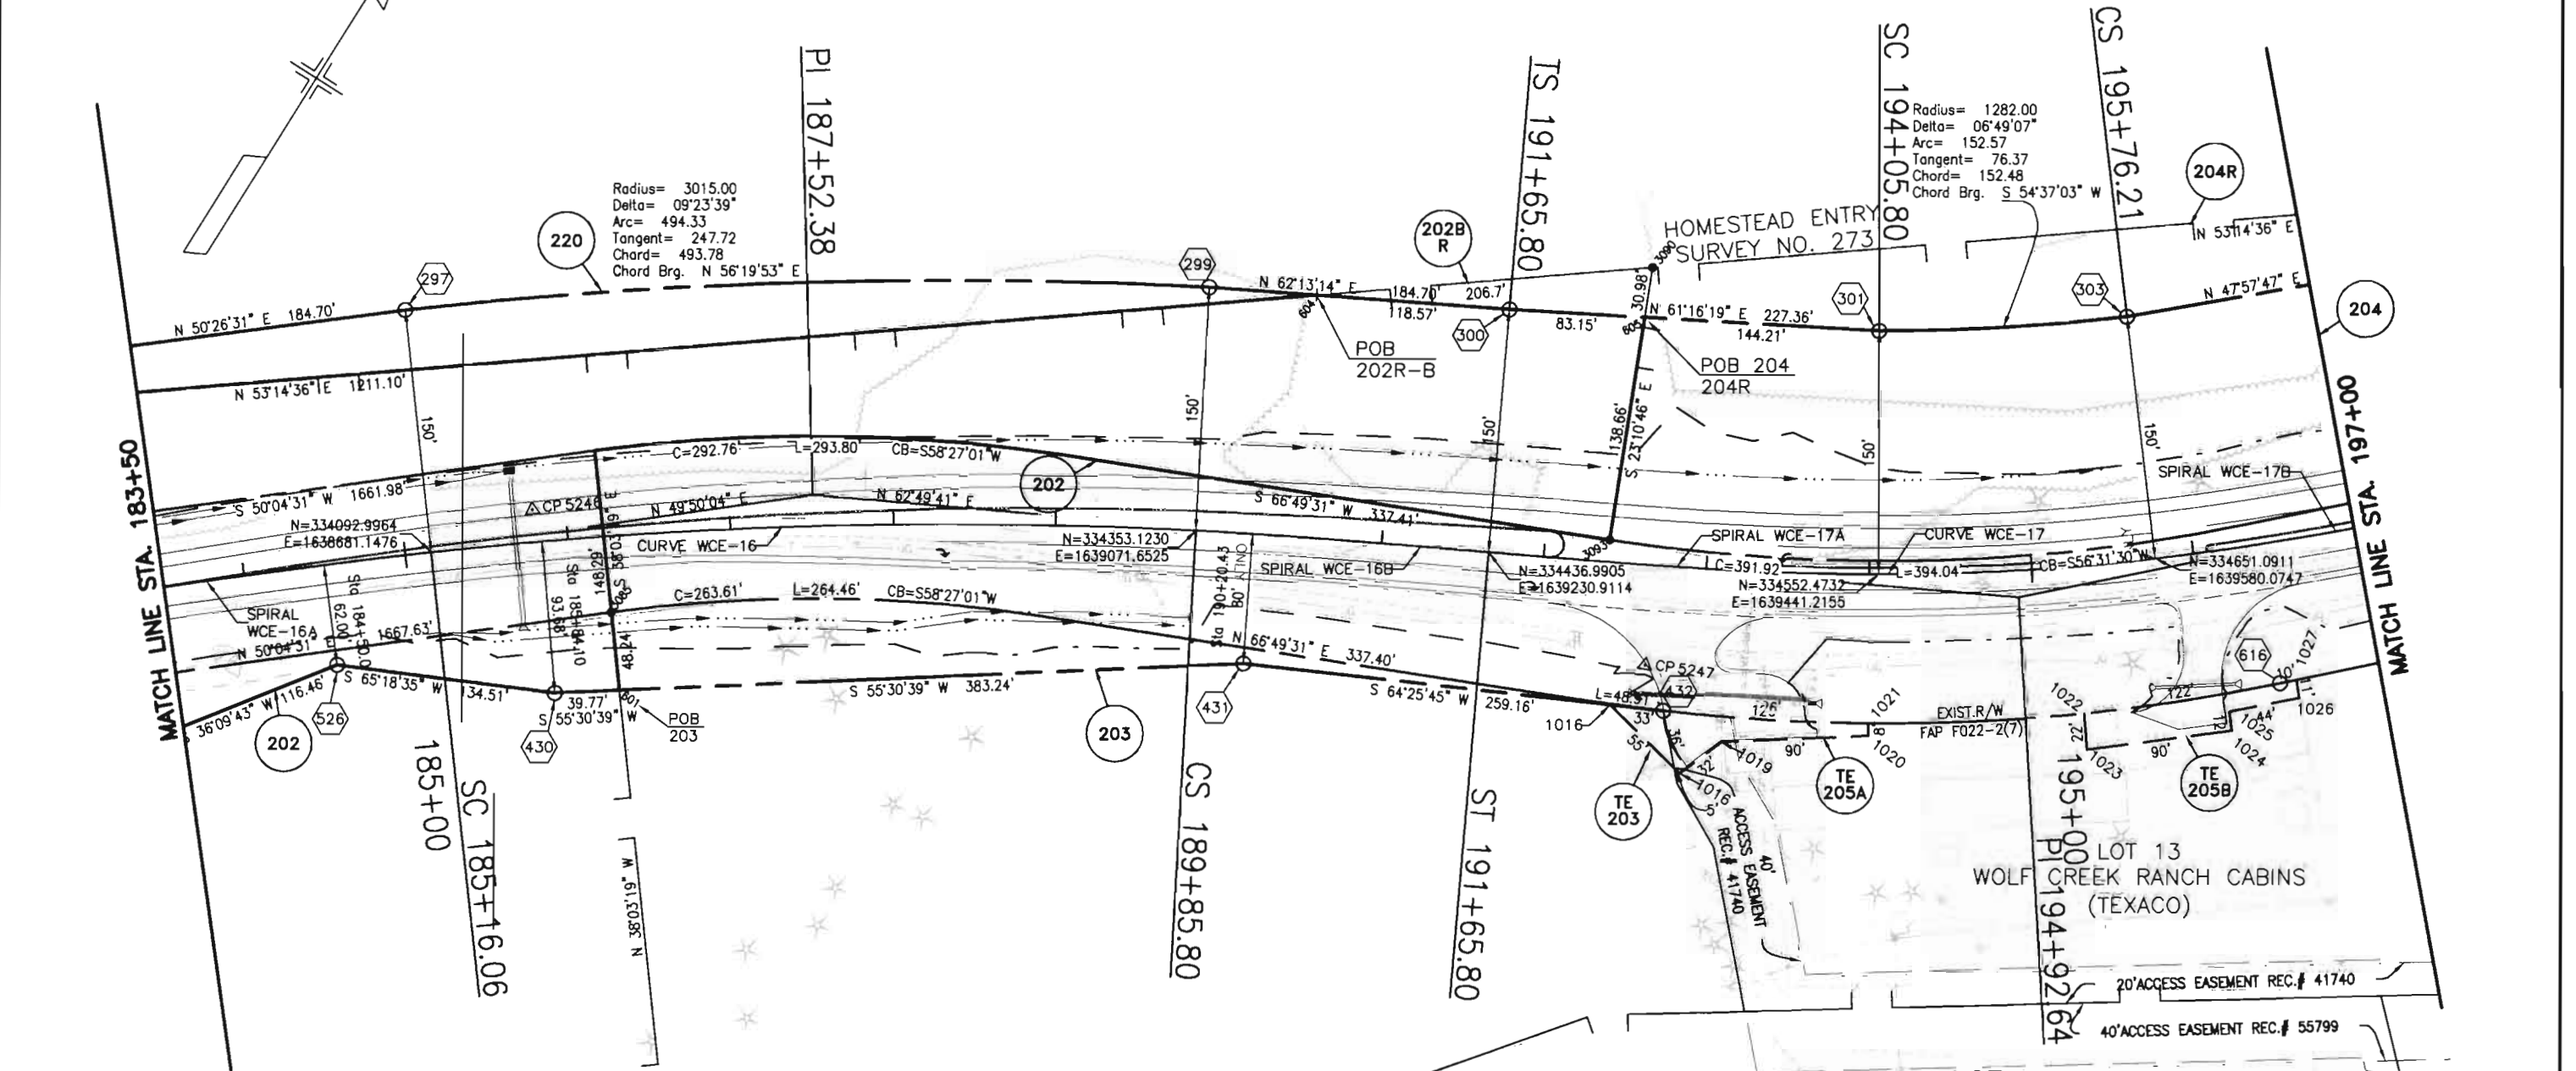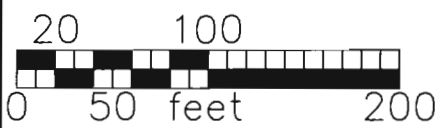

202B R **202** BONNIE RAYLENE KAHLER
BOOK 100 PAGE 420

TE 203 **203** WOLF CREEK WILDERNESS CABINS, LLC.
BOOK 103 PAGE 524

204R **204** WOLF CREEK RANCH, LLC.
BOOK 113-K PAGE 86

TE 205A **TE 205B** JAMES E. BURNS & LINDA N. BURNS
BOOK 113-L PAGE 309

220 UNITED STATES FOREST SERVICE

SPIRAL WCE-16A
Ls=180.00
Ang=1'48'00"
LT=120.01
ST=60.01

CURVE WCE-16
PI 187+52.38
D= 9'23'39"
R= 2865.00
Dc=1'59'59"
A= 469.74
C= 469.21

SPIRAL WCE-16B
Ls=180.00
Ang=1'48'00"
LT=120.01
ST=60.01

SPIRAL WCE-17A
Ls=240.00
Ang=4'48'05"
LT=160.06
ST=80.05

CURVE WCE-17
PI 194+92.64
D= 6'49'07"
R= 1432.00
Dc=4'00'04"
A= 170.42
C= 170.32

SPIRAL WCE-17B
Ls=240.00
Ang=4'48'05"
LT=160.06
ST=80.05

COLORADO DEPARTMENT OF TRANSPORTATION



Region 5
Address: 3803 North Main Avenue, Suite 300
Durango, Colorado 81301
Phone: (970) 385-1400 FAX: (970) 385-1410

Right of Way Plans Unit: Crumbaugh

Sheet Revisions

mm/yy	xxxxx	xxx

Sheet Revisions

mm/yy	xxxxx	xxx

Sheet Revisions

mm/yy	xxxxx	xxx


Right of Way Plans

Right of Way Plan Sheet

Project Number:	NH (CX)160-2(50) UNIT 2
Project Location:	WOLF CREEK PASS EAST
Project Code:	92977
Last Mod. Date:	---
Subset Sheets:	11 of 27
Sheet No.:	16
Total No. of Sheets:	49

T.39 N, R.2 E, NMPM


Carter-Burgess

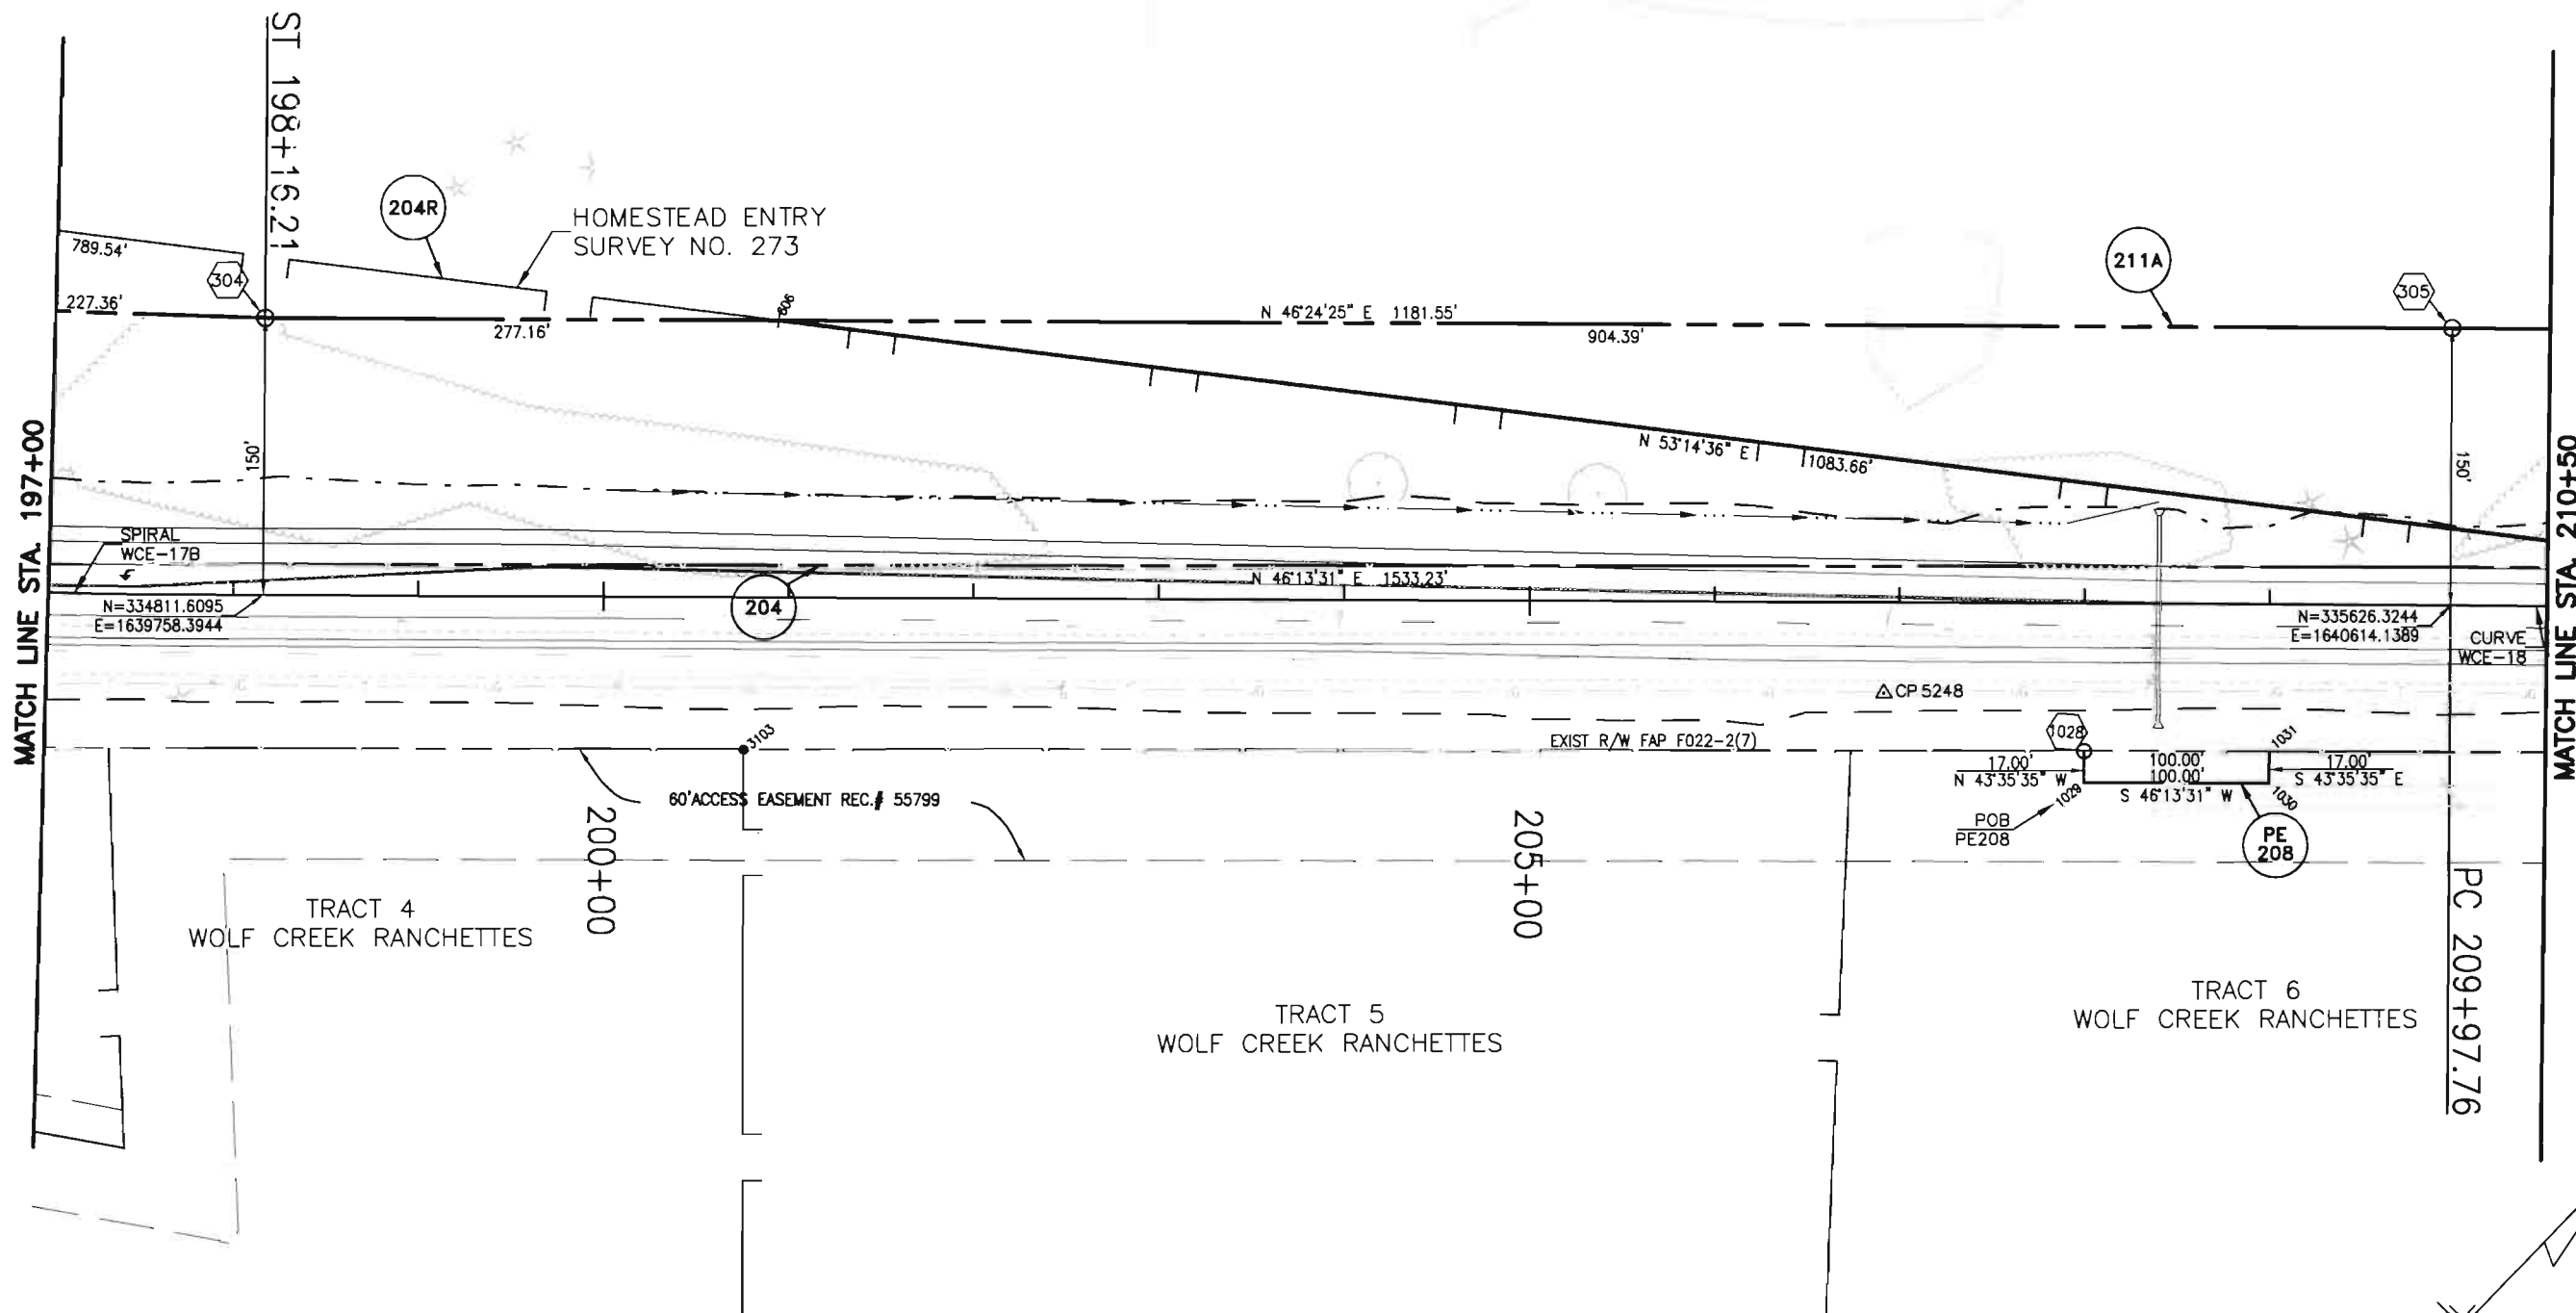

- 204R WOLF CREEK RANCH, LLC.
BOOK 113-K PAGE 86
- 204 ALICE S. LENICH LIVING TRUST
BOOK 113-L PAGE 333
- PE 208
- 211A UNITED STATES FOREST SERVICE

SPIRAL WCE-17B
Ls=240.00
Ang=4°48'05"
LT=160.06
ST=80.05

CURVE WCE-18
Pi=218+13.82
D= 9°29'56"
R= 9822.13
Dc=0°35'00"
A= 1628.36
T= 816.05
C= 1626.50

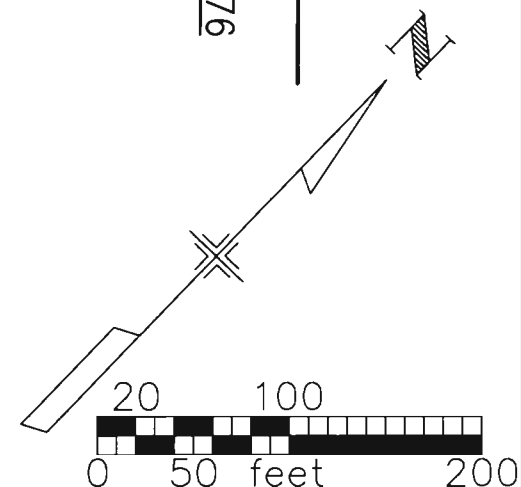

COLORADO DEPARTMENT OF TRANSPORTATION



Region 5
Address: 3803 North Main Avenue, Suite 300
Durango, Colorado 81301
Phone: (970) 385-1400 FAX: (970) 385-1410

Right of Way Plans Unit: Crumbaugh

Sheet Revisions

mm/yy	xxxxx	xxx

Sheet Revisions

mm/yy	xxxxx	xxx

Sheet Revisions

mm/yy	xxxxx	xxx


Right of Way Plans

Right of Way Plan Sheet

Project Number:	NH (CX)160-2(50) UNIT 2
Project Location:	WOLF CREEK PASS EAST
Project Code:	92977
Last Mod. Date:	---
Subset Sheets:	12 of 27
Sheet No.:	17
Total No. of Sheets:	49

T.39 N, R.2 E, NMPM

Carter-Burgess

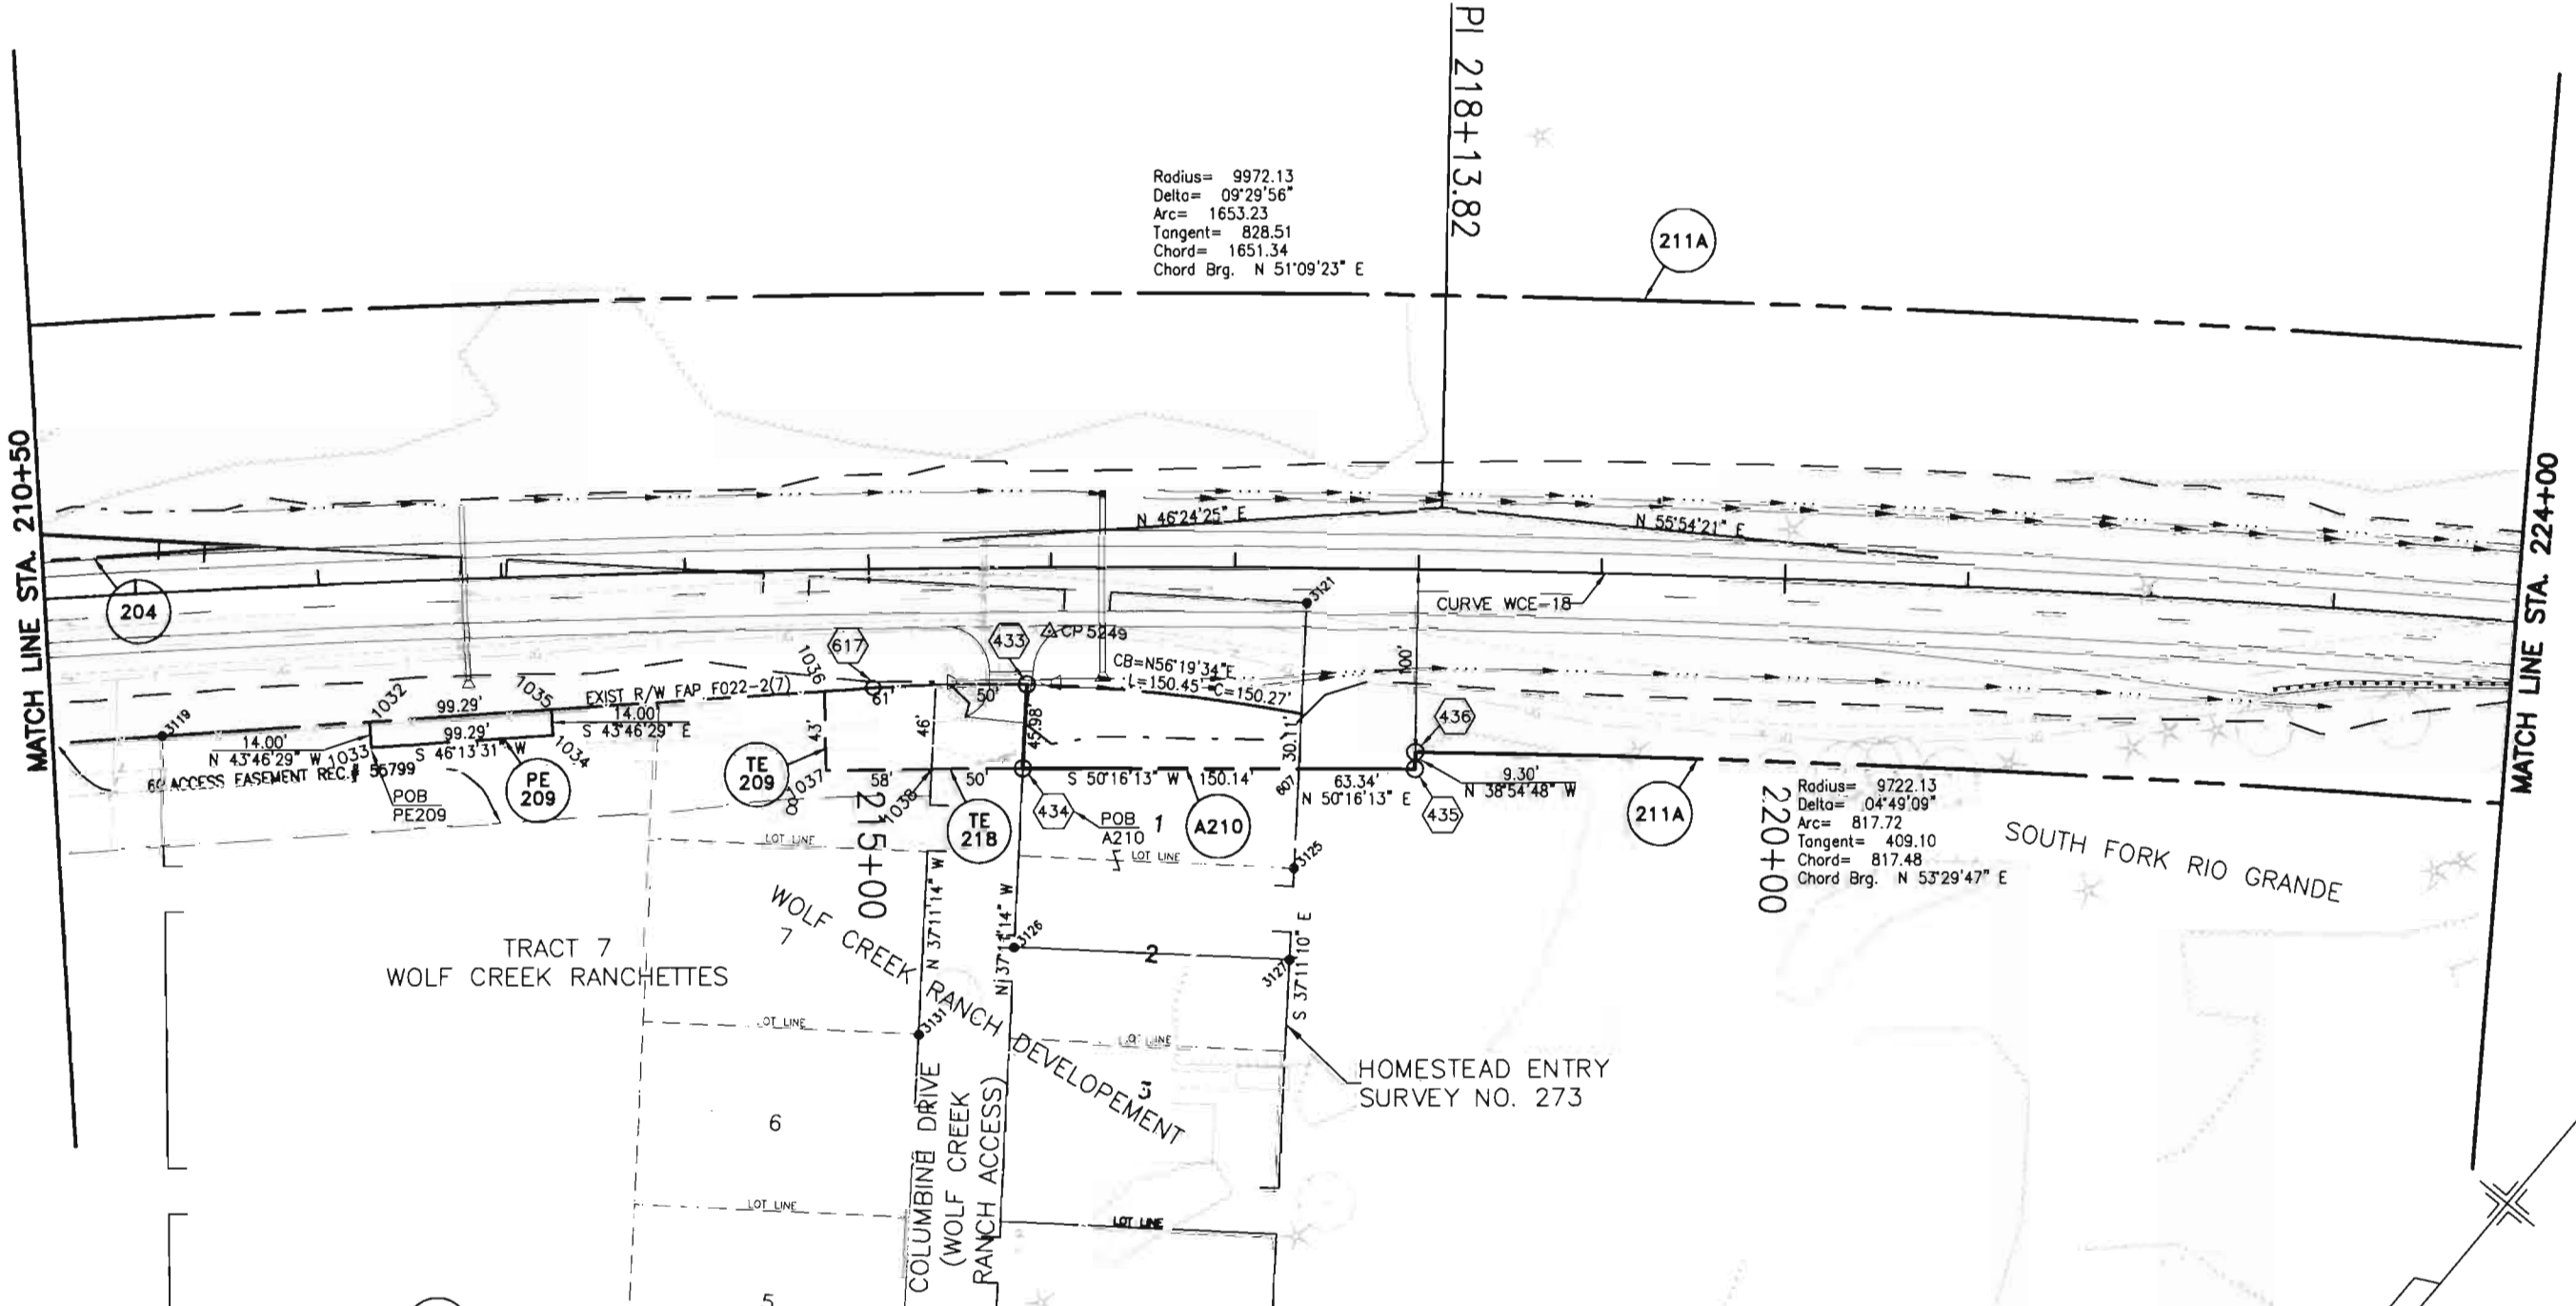

Radius= 9972.13
Delta= 09°29'56"
Arc= 1653.23
Tangent= 828.51
Chord= 1651.34
Chord Brg. N 51°09'23" E

Radius= 9722.13
Delta= 04°49'09"
Arc= 817.72
Tangent= 409.10
Chord= 817.48
Chord Brg. N 53°29'47" E

CURVE WCE-18

PI=218+13.82

D= 9°29'56"

 
R= 9822.13

Dc=0°35'00"

A= 1628.36

T= 816.05

C= 1626.50



204 WOLF CREEK RANCH, LLC.
BOOK 113-K PAGE 86

211A UNITED STATES FOREST SERVICE

TE 209 STEVE S. PATTON & VALERIE L. PATTON
BOOK 113-L PAGE 337

TE 218 COLUMBINE DRIVE
(WOLF CREEK RANCH ACCESS)

A210 TERRY FULTON & TANA FULTON
BOOK 102 PAGE 435

DEPOSITED THIS DAY OF AT FOR INFORMATION
ONLY IN BOOK OF THE COUNTY LAND SURVEYS/RIGHT OF WAY
SURVEYS AT PAGE RESECTION NUMBER

0/0022\DWGS\ROWPLAN\WCE12RP.DWG, 08/12/2002 10:24:54 AM

COLORADO DEPARTMENT OF TRANSPORTATION



Region 5
Address: 3803 North Main Avenue, Suite 300
Durango, Colorado 81301
Phone: (970) 385-1400 FAX: (970) 385-1410

Right of Way Plans Unit: Crumbaugh

Sheet Revisions

mm/yy	xxxxx	xxx

Sheet Revisions

mm/yy	xxxxx	xxx

Sheet Revisions



mm/yy	xxxxx	xxx

Right of Way Plans

Right of Way Plan Sheet

Project Number:	NH (CX)160-2(50) UNIT 2
Project Location:	WOLF CREEK PASS EAST
Project Code:	92977
Last Mod. Date:	---
Subset Sheets:	13 of 27
Sheet No.:	18
Total No. of Sheets:	49

 T.39 N, R.2 E, NMMP

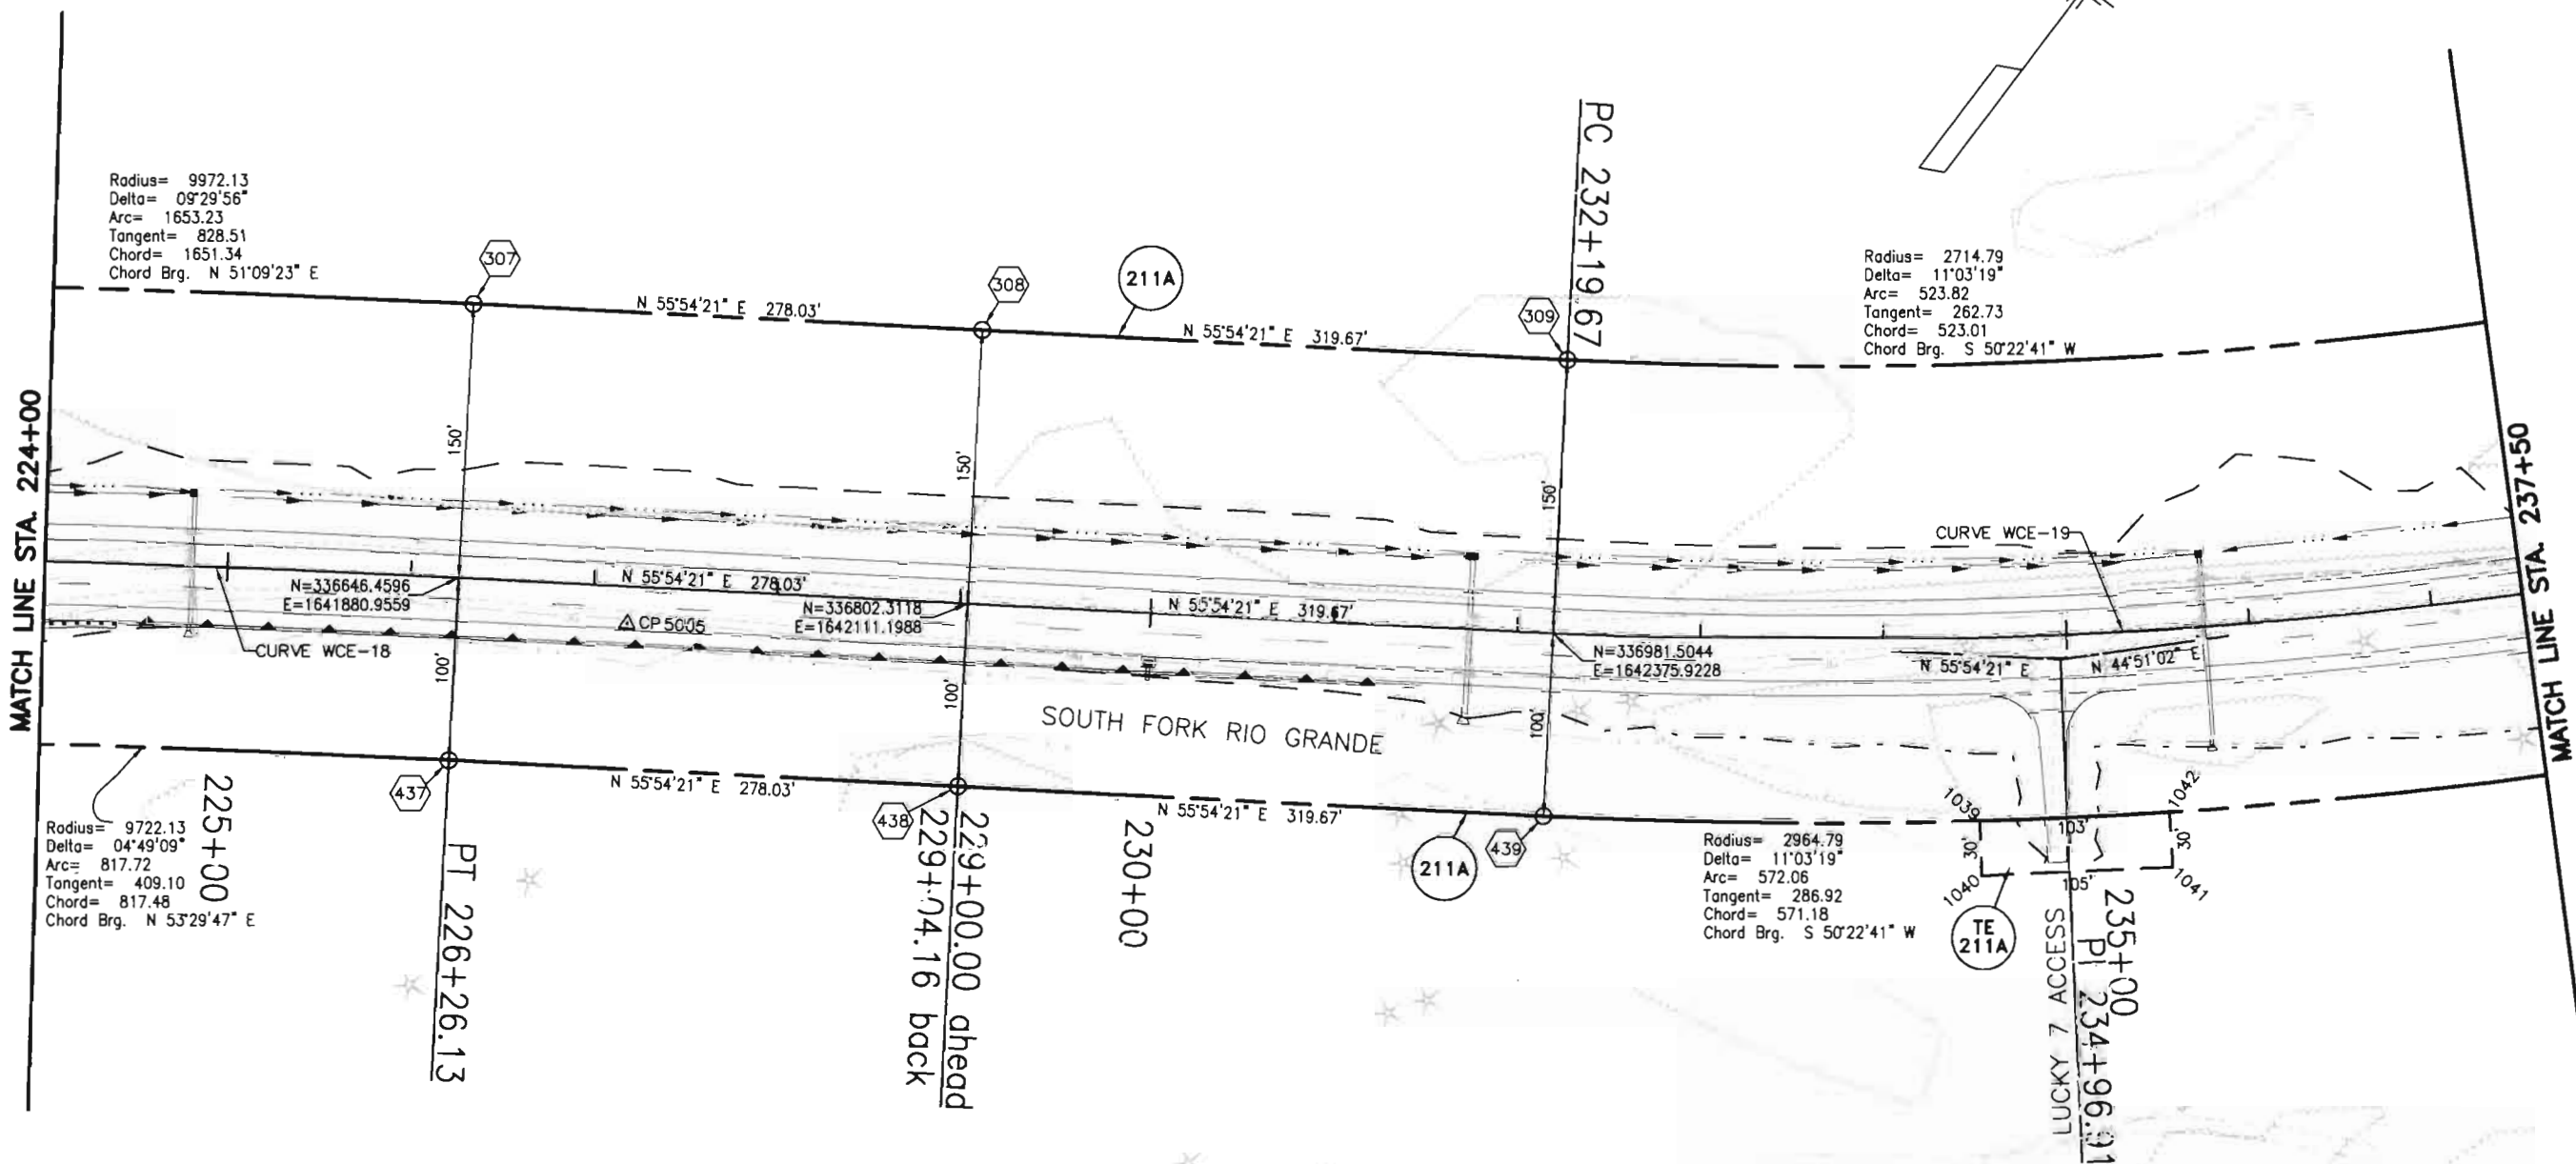

CURVE WCE-18	CURVE WCE-19
PI=218+13.82	PI 234+96.91
D= 9'29'56"	D= 11'03'19.2"
R= 9822.13	R= 2864.790
Dc=0'35'00"	Dc=2'00'00.0"
A= 1628.36	A= 552.767
T= 816.05	T= 277.244
C= 1626.50	C= 551.910

COLORADO DEPARTMENT OF TRANSPORTATION



Region 5
Address: 3803 North Main Avenue, Suite 300
Durango, Colorado 81301
Phone: (970) 385-1400 FAX: (970) 385-1410

Right of Way Plans Unit: Crumbaugh


Sheet Revisions		
mm/yy	XXXXX	XXX

Sheet Revisions		
mm/yy	XXXXX	XXX


Sheet Revisions		
mm/yy	XXXXX	XXX

Right of Way Plans				
Right of Way Plan Sheet				
Project Number:		NH (CX)160-2(50) UNIT 2		
Project Location:		WOLF CREEK PASS EAST		
Project Code:		92977		
Last Mod. Date	Subst Sheets	Sheet No.	Total No. of Sheets	
---	14 of 27	19	49	

 T.39 N, R.2 E, NMPM



Radius= 2696.48
Delta= 04°15'06"
Arc= 200.09
Tangent= 100.09
Chord= 200.05
Chord Brg. N 49°13'35" E

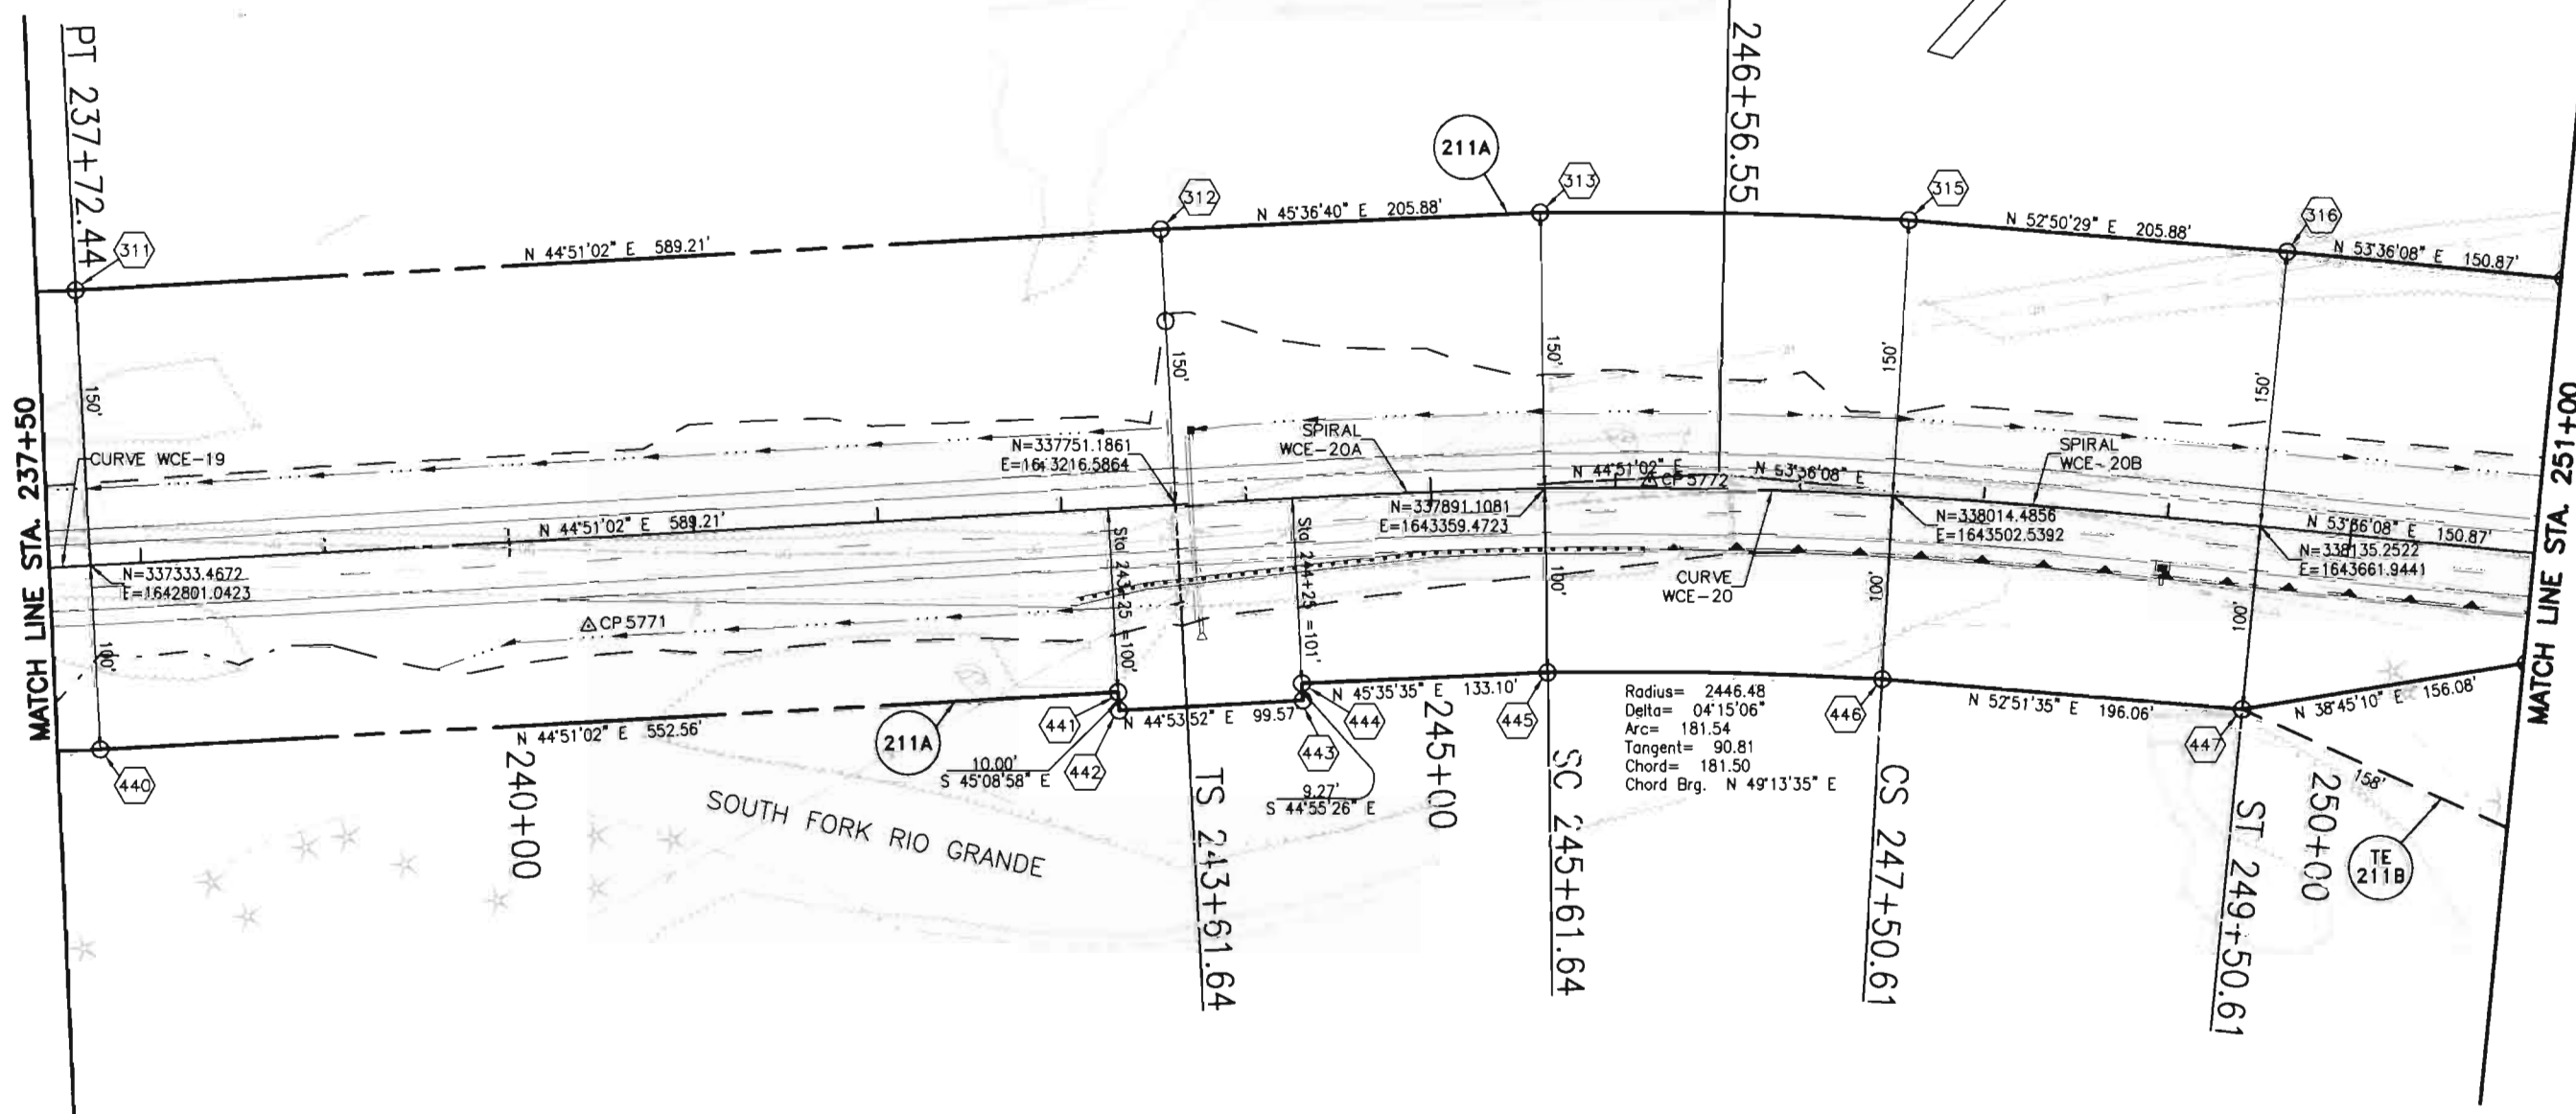

CURVE WCE-19

PI 234+96.91
D= 11°03'19.2"
R= 2864.790
Dc= 2°00'00.0"
A= 552.767
T= 277.244
C= 551.910

SPIRAL WCE-20A

Ls=200.000
Ang=2°15'00.0"
LT=133.344
ST=66.676

CURVE WCE-20

PI 246+56.55
D= 4°15'05.9"
R= 2546.479
Dc= 2°15'00.0"
A= 188.962
C= 188.918

SPIRAL WCE-20B

Ls=200.000
Ang=2°15'00.0"
LT=133.344
ST=66.676

COLORADO DEPARTMENT OF TRANSPORTATION



Region 5
Address: 3803 North Main Avenue, Suite 300
Durango, Colorado 81301
Phone: (970) 385-1400 FAX: (970) 385-1410

Right of Way Plans Unit: Crumbaugh

Sheet Revisions

mm/yy	xxxxx	xxx

Sheet Revisions

mm/yy	xxxxx	xxx

Sheet Revisions

mm/yy	xxxxx	xxx

Right of Way Plans

Right of Way Plan Sheet

Project Number:	NH (CX)160-2(50) UNIT 2
Project Location:	WOLF CREEK PASS EAST
Project Code:	92977
Last Mod. Date	---
Subst. Sheets	15 of 27
Sheet No.	20
Total No. of Sheets	49

T.39 N, R.2 E, NMPM

Carter-Burgess

TE 211B 211A UNITED STATES FOREST SERVICE

Radius= 1377.89
Delta= 38°38'34"
Arc= 929.31
Tangent= 483.11
Chord= 911.80
Chord Brg. S 29°46'50" W

N=339249.6859
E=1644474.8865

Radius= 1627.89
Delta= 04°34'23"
Arc= 129.93
Tangent= 65.00
Chord= 129.90
Chord Brg. S 12°44'45" W

Radius= 1652.89
Delta= 05°37'30"
Arc= 162.27
Tangent= 81.20
Chord= 162.21
Chord Brg. S 17°50'42" W

Radius= 1587.89
Delta= 14°03'45"
Arc= 389.73
Tangent= 195.85
Chord= 388.75
Chord Brg. S 29°33'49" W

 
Radius= 1587.89
Delta= 04°41'15"
Arc= 129.91
Tangent= 64.99
Chord= 129.87
Chord Brg. S 42°41'19" W

Radius= 1587.89
Delta= 01°15'26"
Arc= 34.84
Tangent= 17.42
Chord= 34.84
Chord Brg. S 48°28'25" W

SPIRAL WCE-21A
Ls=240.000
Ang=4°30'00.0"
LT=160.052
ST=80.047

CURVE WCE-21
PI 258+96.70
D= 38°38'34.3"
R= 1527.887
Dc=3°45'00.0"
A= 1030.477
C= 1011.057

SPIRAL WCE-21B
Ls=240.000
Ang=4°30'00.0"
LT=160.052
ST=80.047



DEPOSITED THIS DAY OF 12 AT AL FOR INFORMATION
ONLY IN BOOK OF THE COUNTY LAND SURVEYS/RIGHT OF WAY
SURVEYS AT PAGE RECEPTION NUMBER

0/0022\DWGS\ROWPLAN\WCE15RP.DWG, 08/12/2002 10:19:48 AM

COLORADO DEPARTMENT OF TRANSPORTATION



Region 5
Address: 3803 North Main Avenue, Suite 300
Durango, Colorado 81301
Phone: (970) 385-1400 FAX: (970) 385-1410

Right of Way Plans Unit: Crumbaugh

Sheet Revisions

mm/yy	XXXXX	XXX

Sheet Revisions

mm/yy	XXXXX	XXX

Sheet Revisions




mm/yy	XXXXX	XXX

Right of Way Plans

Right of Way Plan Sheet

Project Number:		NH (CX)160-2(50) UNIT 2		
Project Location:		WOLF CREEK PASS EAST		
Project Location:				
Project Code:	Last Mod. Date	Subset Sheets	Sheet No.	Total No. of Sheets
92977	---	16 of 27	21	49

 T.39 N, R.2 E, NMPM

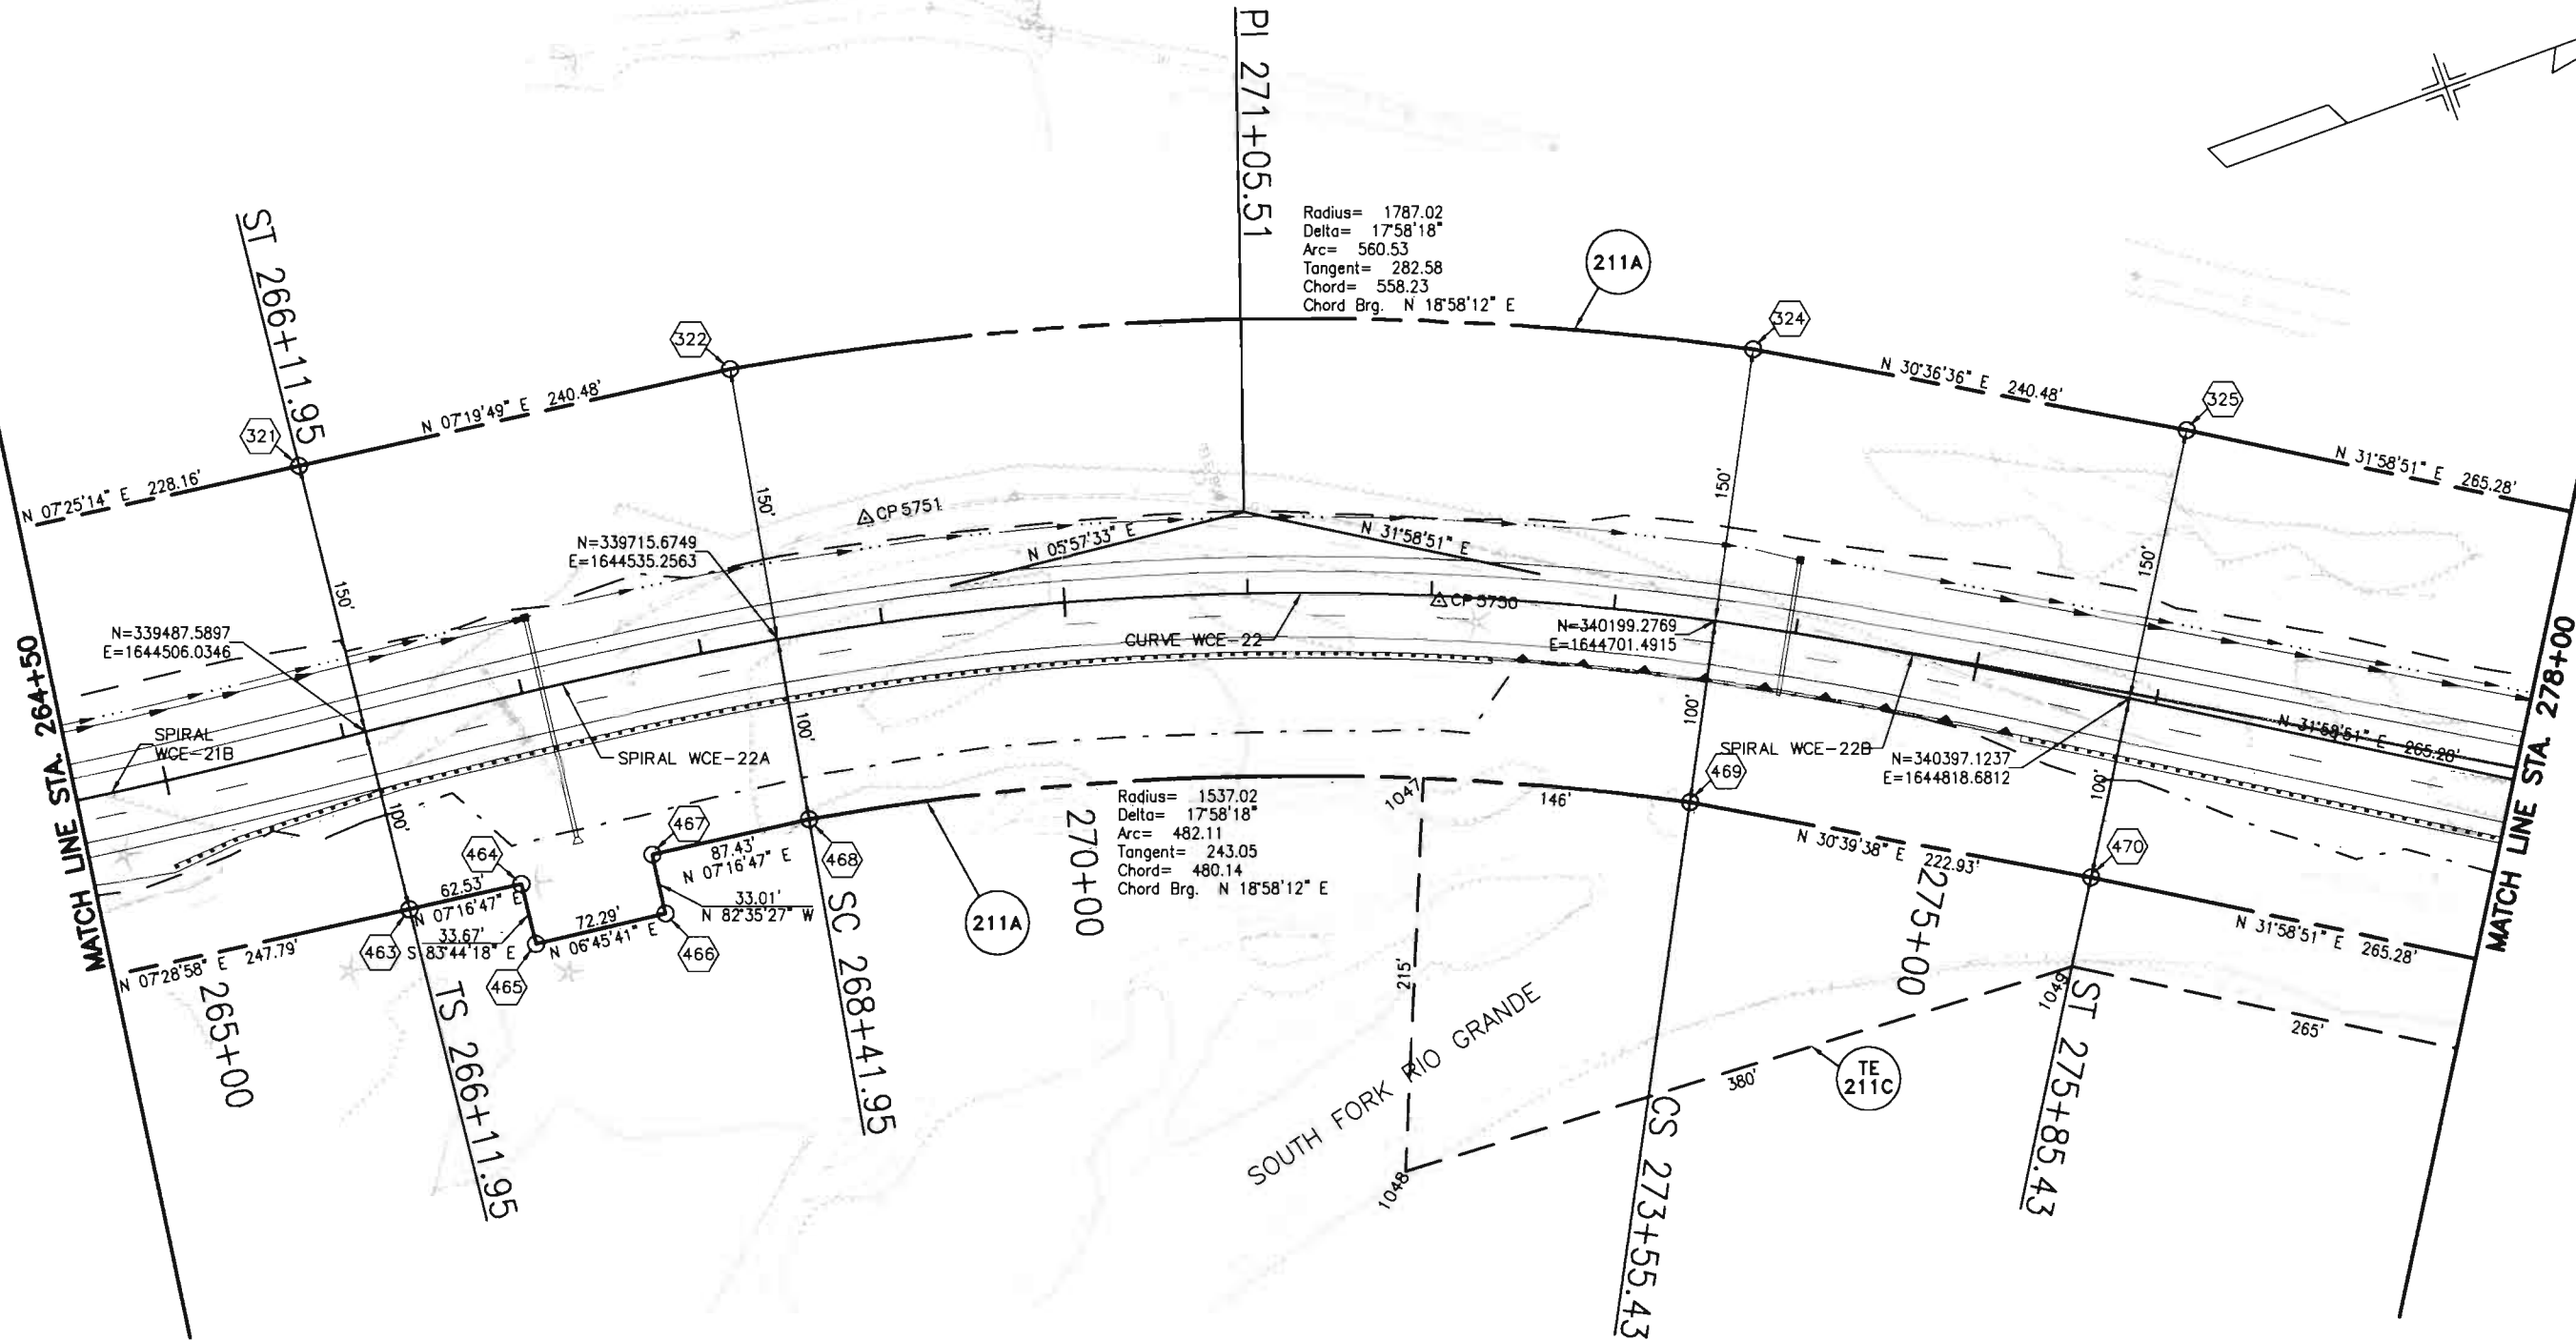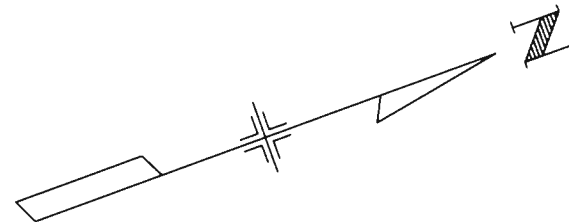

SPIRAL WCE-21B
Ls=240.000
Ang=4°30'00.0"
LT=160.052
ST=80.047

SPIRAL WCE-22A
Ls=240.000
Ang=4°30'00.0"
LT=160.052
ST=80.047

CURVE WCE-22
PI 258+96.70
D= 38°38'34.3"
R= 1527.887
Dc=3°45'00.0"
A= 1030.477
C= 1011.057

SPIRAL WCE-22B
Ls=240.000
Ang=4°30'00.0"
LT=160.052
ST=80.047

COLORADO DEPARTMENT OF TRANSPORTATION



Region 5
Address: 3803 North Main Avenue, Suite 300
Durango, Colorado 81301
Phone: (970) 385-1400 FAX: (970) 385-1410

Right of Way Plans Unit: Crumbaugh

Sheet Revisions

mm/yy	XXXXX	XXX

Sheet Revisions

mm/yy	XXXXX	XXX

Sheet Revisions

mm/yy	XXXXX	XXX



Right of Way Plans

Right of Way Plan Sheet

Project Number:		NH (CX)160-2(50) UNIT 2		
Project Location:		WOLF CREEK PASS EAST		
Project Location:				
Project Code:	Last Mod. Date	Subset Sheets	Sheet No.	Total No. of Sheets
92977	---	17 of 27	22	49

T.39 N, R.2 E, NMPM

Carter-Burgess

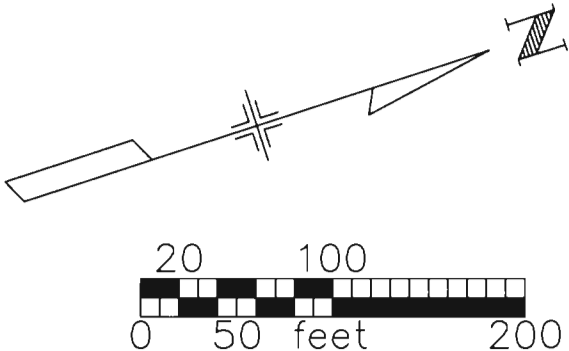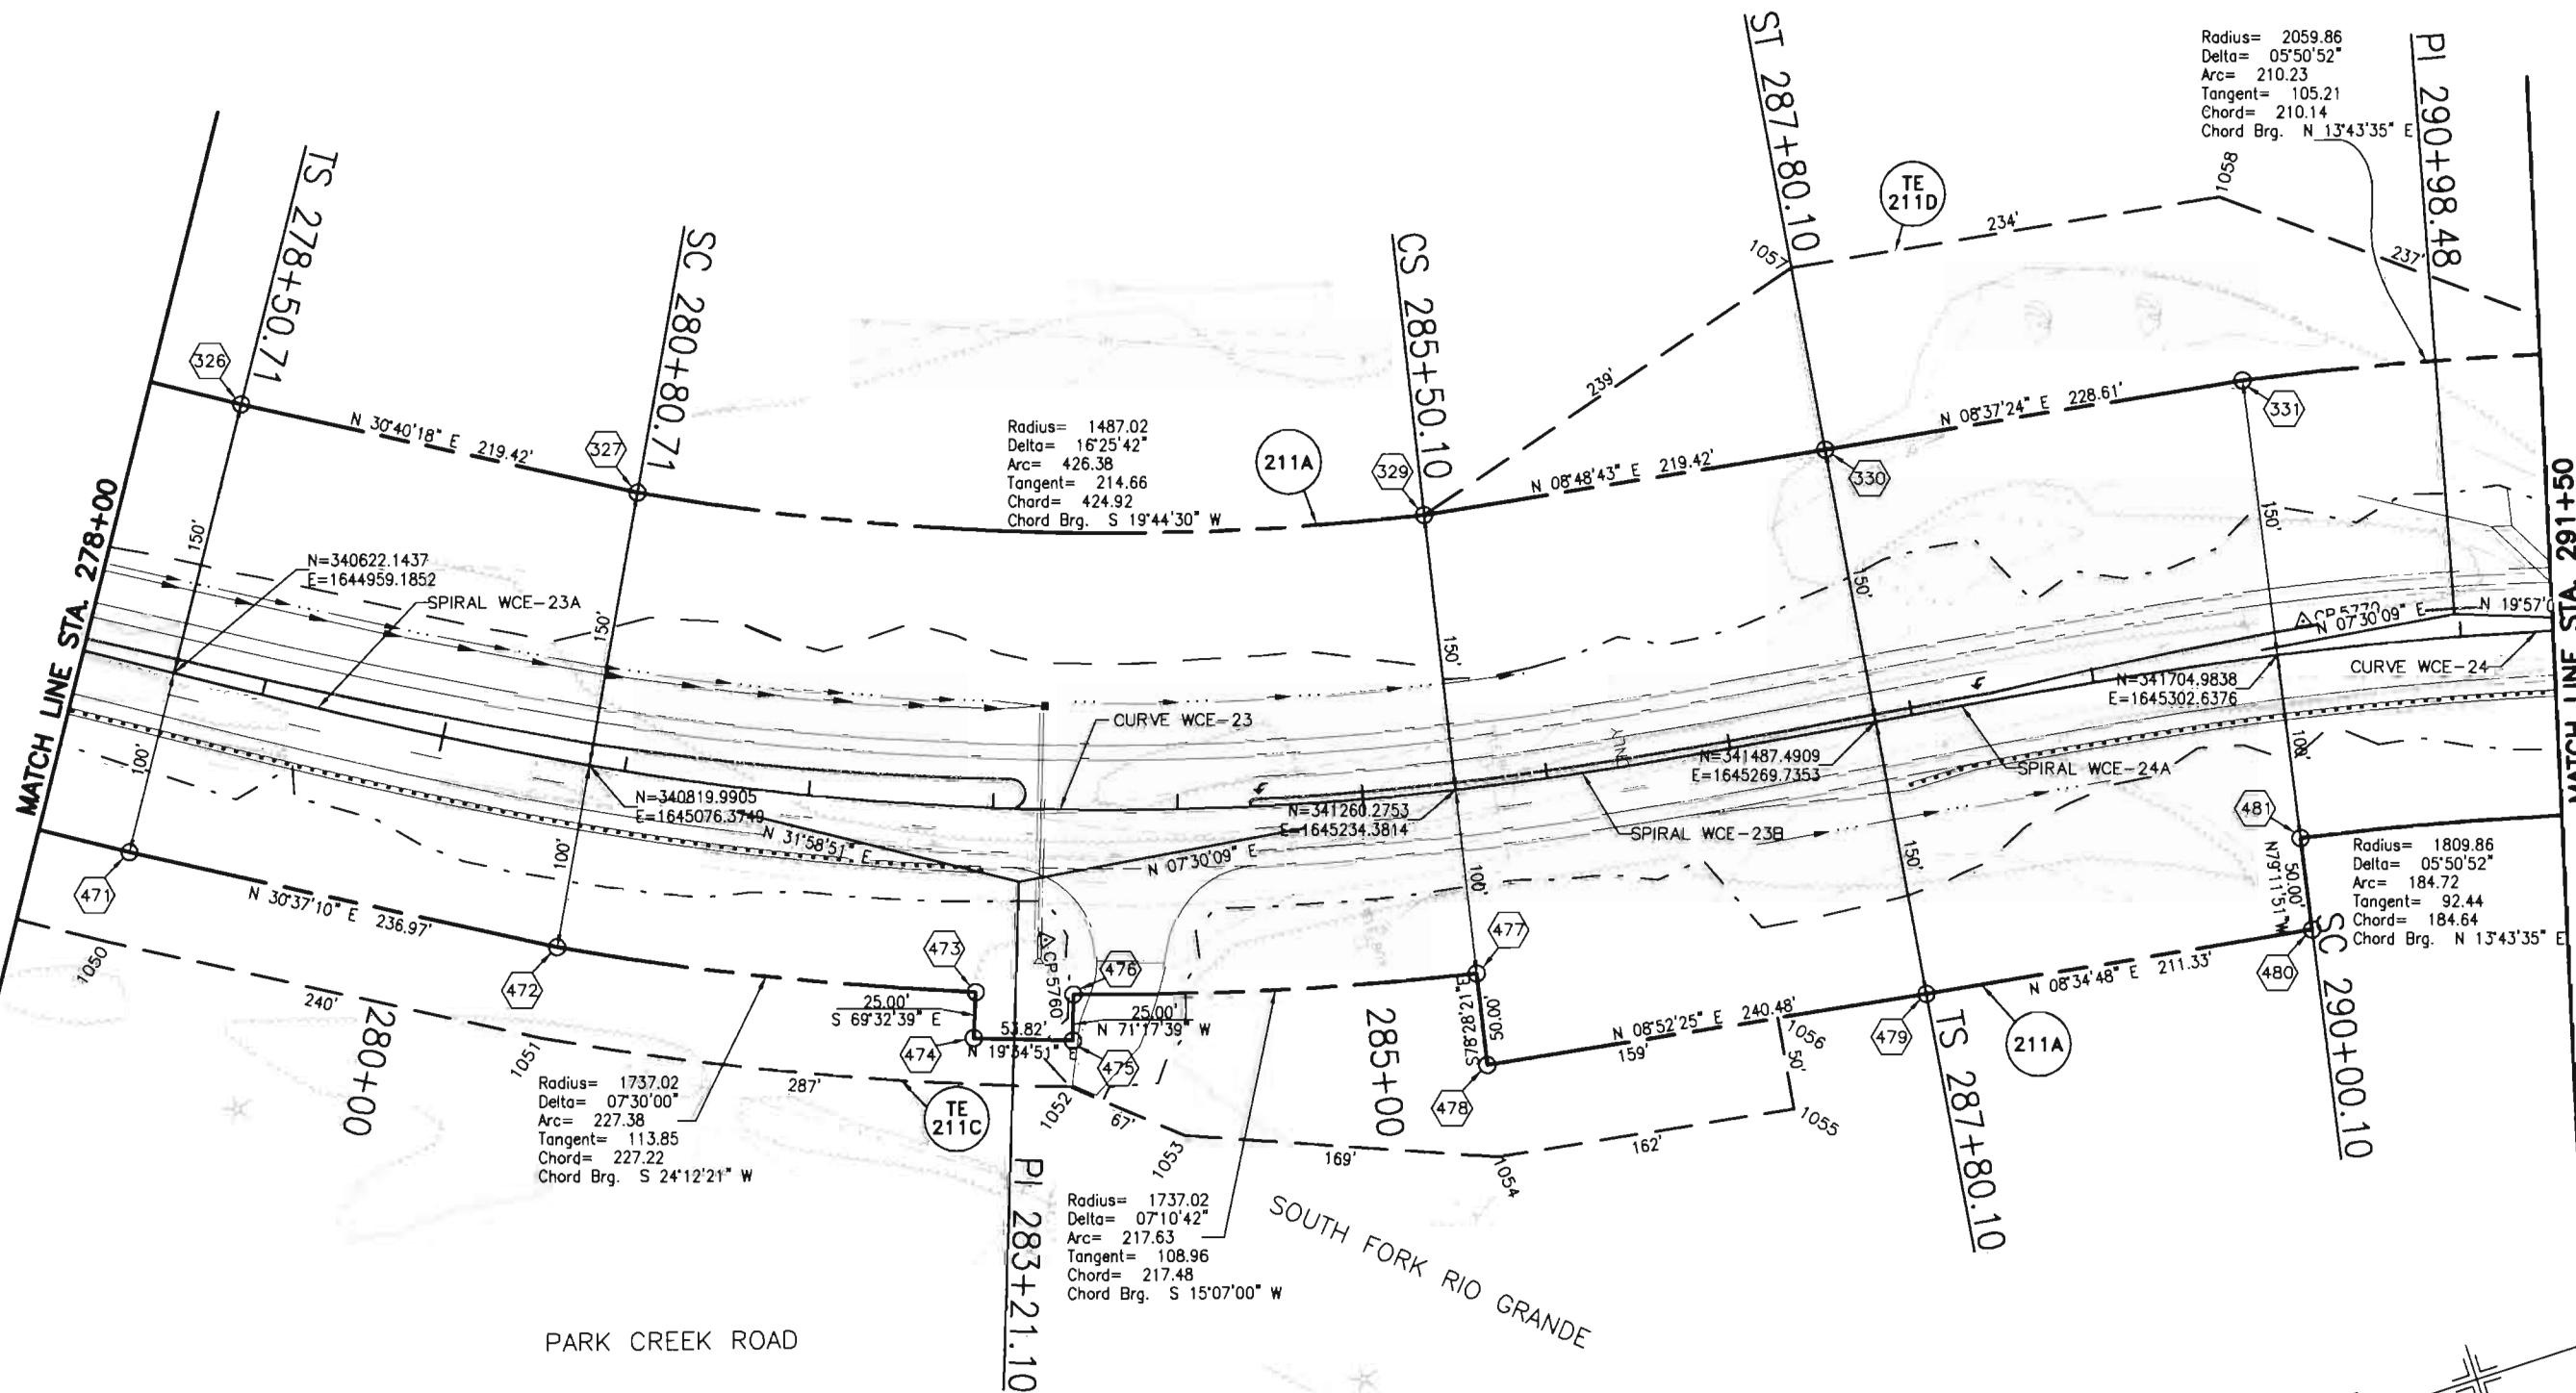

COLORADO DEPARTMENT OF TRANSPORTATION



Region 5
Address: 3803 North Main Avenue, Suite 300
Durango, Colorado 81301
Phone: (970) 385-1400 FAX: (970) 385-1410

Right of Way Plans Unit: Crumbaugh

Sheet Revisions

mm/yy	xxxx	xxx

Sheet Revisions

mm/yy	xxxx	xxx

Sheet Revisions

mm/yy	xxxx	xxx


Right of Way Plans

Right of Way Plan Sheet

Project Number:	NH (CX)160-2(50) UNIT 2
Project Location:	WOLF CREEK PASS EAST
Project Code:	92877
Last Mod. Date	---
Subset Sheets	18 of 27
Sheet No.	23
Total No. of Sheets	49

T.39 N, R.2 E, NMPM

Carter-Burgess

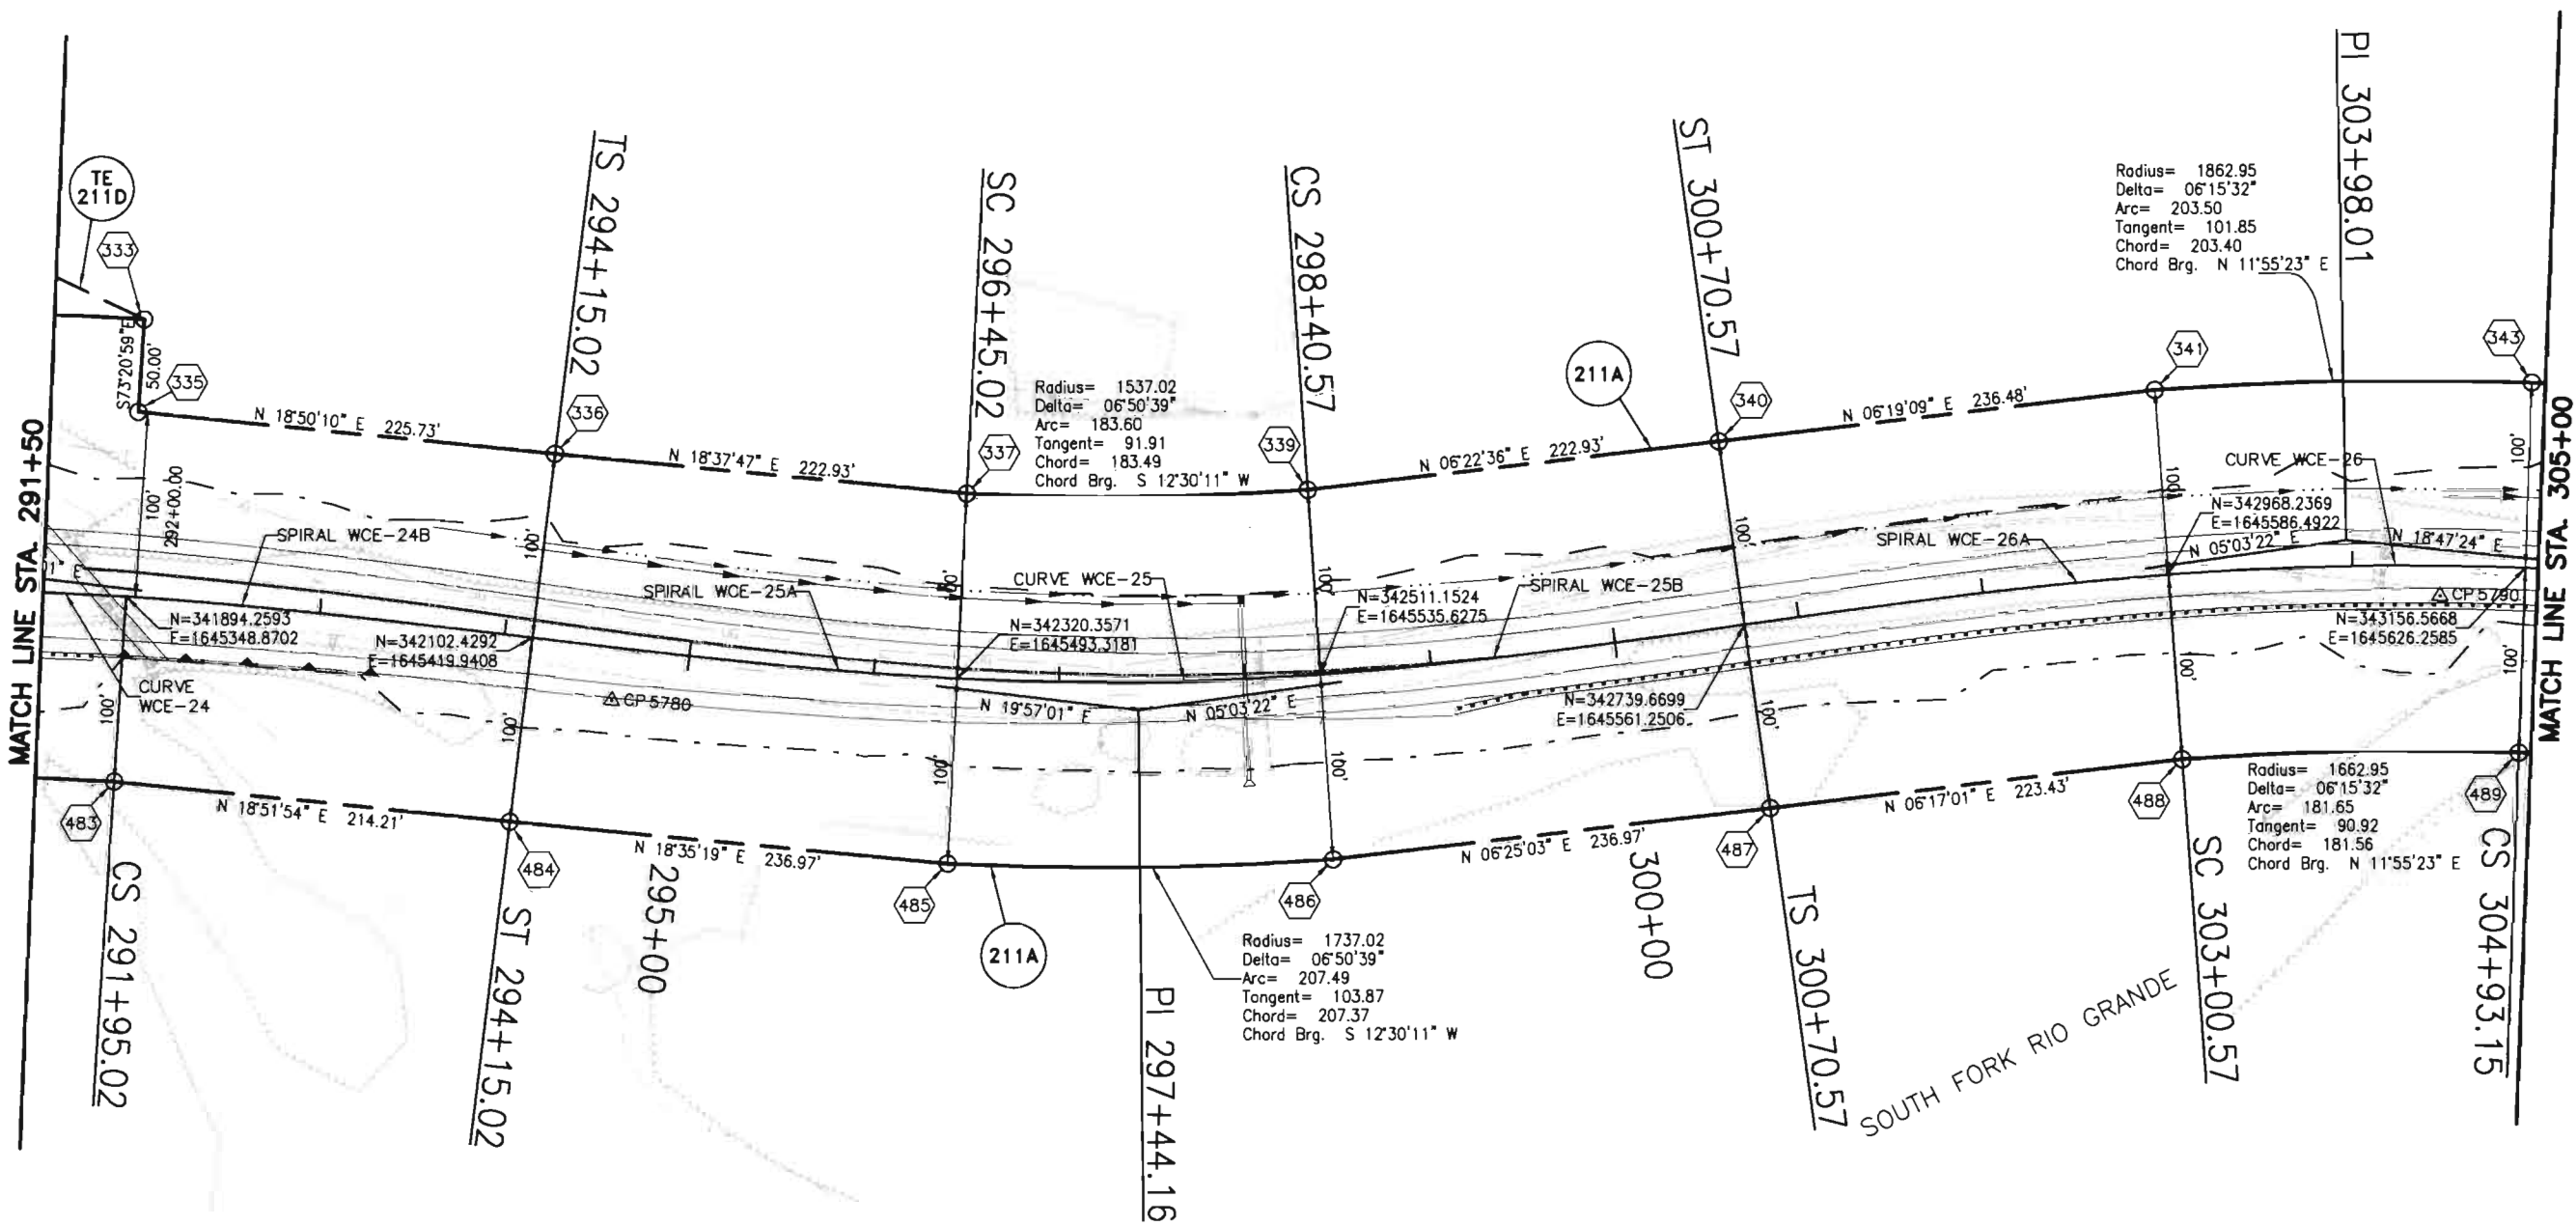

CURVE WCE-24
PI 290+98.48
D= 5'50'51.8"
R= 1909.860
Dc=3'00'00.0"
A= 194.925
C= 194.840

SPIRAL WCE-24B
Ls=220.000
Ang=3'18'00.0"
LT=146.692
ST=73.357


SPIRAL WCE-25A
Ls=230.000
Ang=4'01'30.0"
LT=153.373
ST=76.703

CURVE WCE-25
PI 297+44.16
D= 6'50'38.8"
R= 1637.023
Dc=3'30'00.0"
A= 195.546
C= 195.430

SPIRAL WCE-25B
Ls=230.000
Ang=4'01'30.0"
LT=153.373
ST=76.703

SPIRAL WCE-26A
Ls=230.000
Ang=3'44'15.0"
LT=153.368
ST=76.698

CURVE WCE-26
PI 303+98.01
D= 6'15'31.6"
R= 1762.948
Dc=3'15'00.0"
A= 192.578
C= 192.483

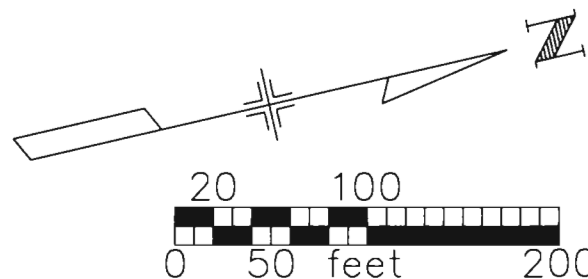

COLORADO DEPARTMENT OF TRANSPORTATION



Region 5
Address: 3803 North Main Avenue, Suite 300
Durango, Colorado 81301
Phone: (970) 385-1400 FAX: (970) 385-1410

Right of Way Plans Unit: Crumbaugh

Sheet Revisions

mm/yy	xxxxx	xxx

Sheet Revisions

mm/yy	xxxxx	xxx

Sheet Revisions

mm/yy	xxxxx	xxx


Right of Way Plans

Right of Way Plan Sheet

Project Number:	NH (CX)160-2(50) UNIT 2
Project Location:	WOLF CREEK PASS EAST
Project Code:	92977
Last Mod. Date:	---
Subset Sheets:	19 of 27
Sheet No.:	24
Total No. of Sheets:	49

T.39 N, R.2 E, NMPM

Carter Burgess

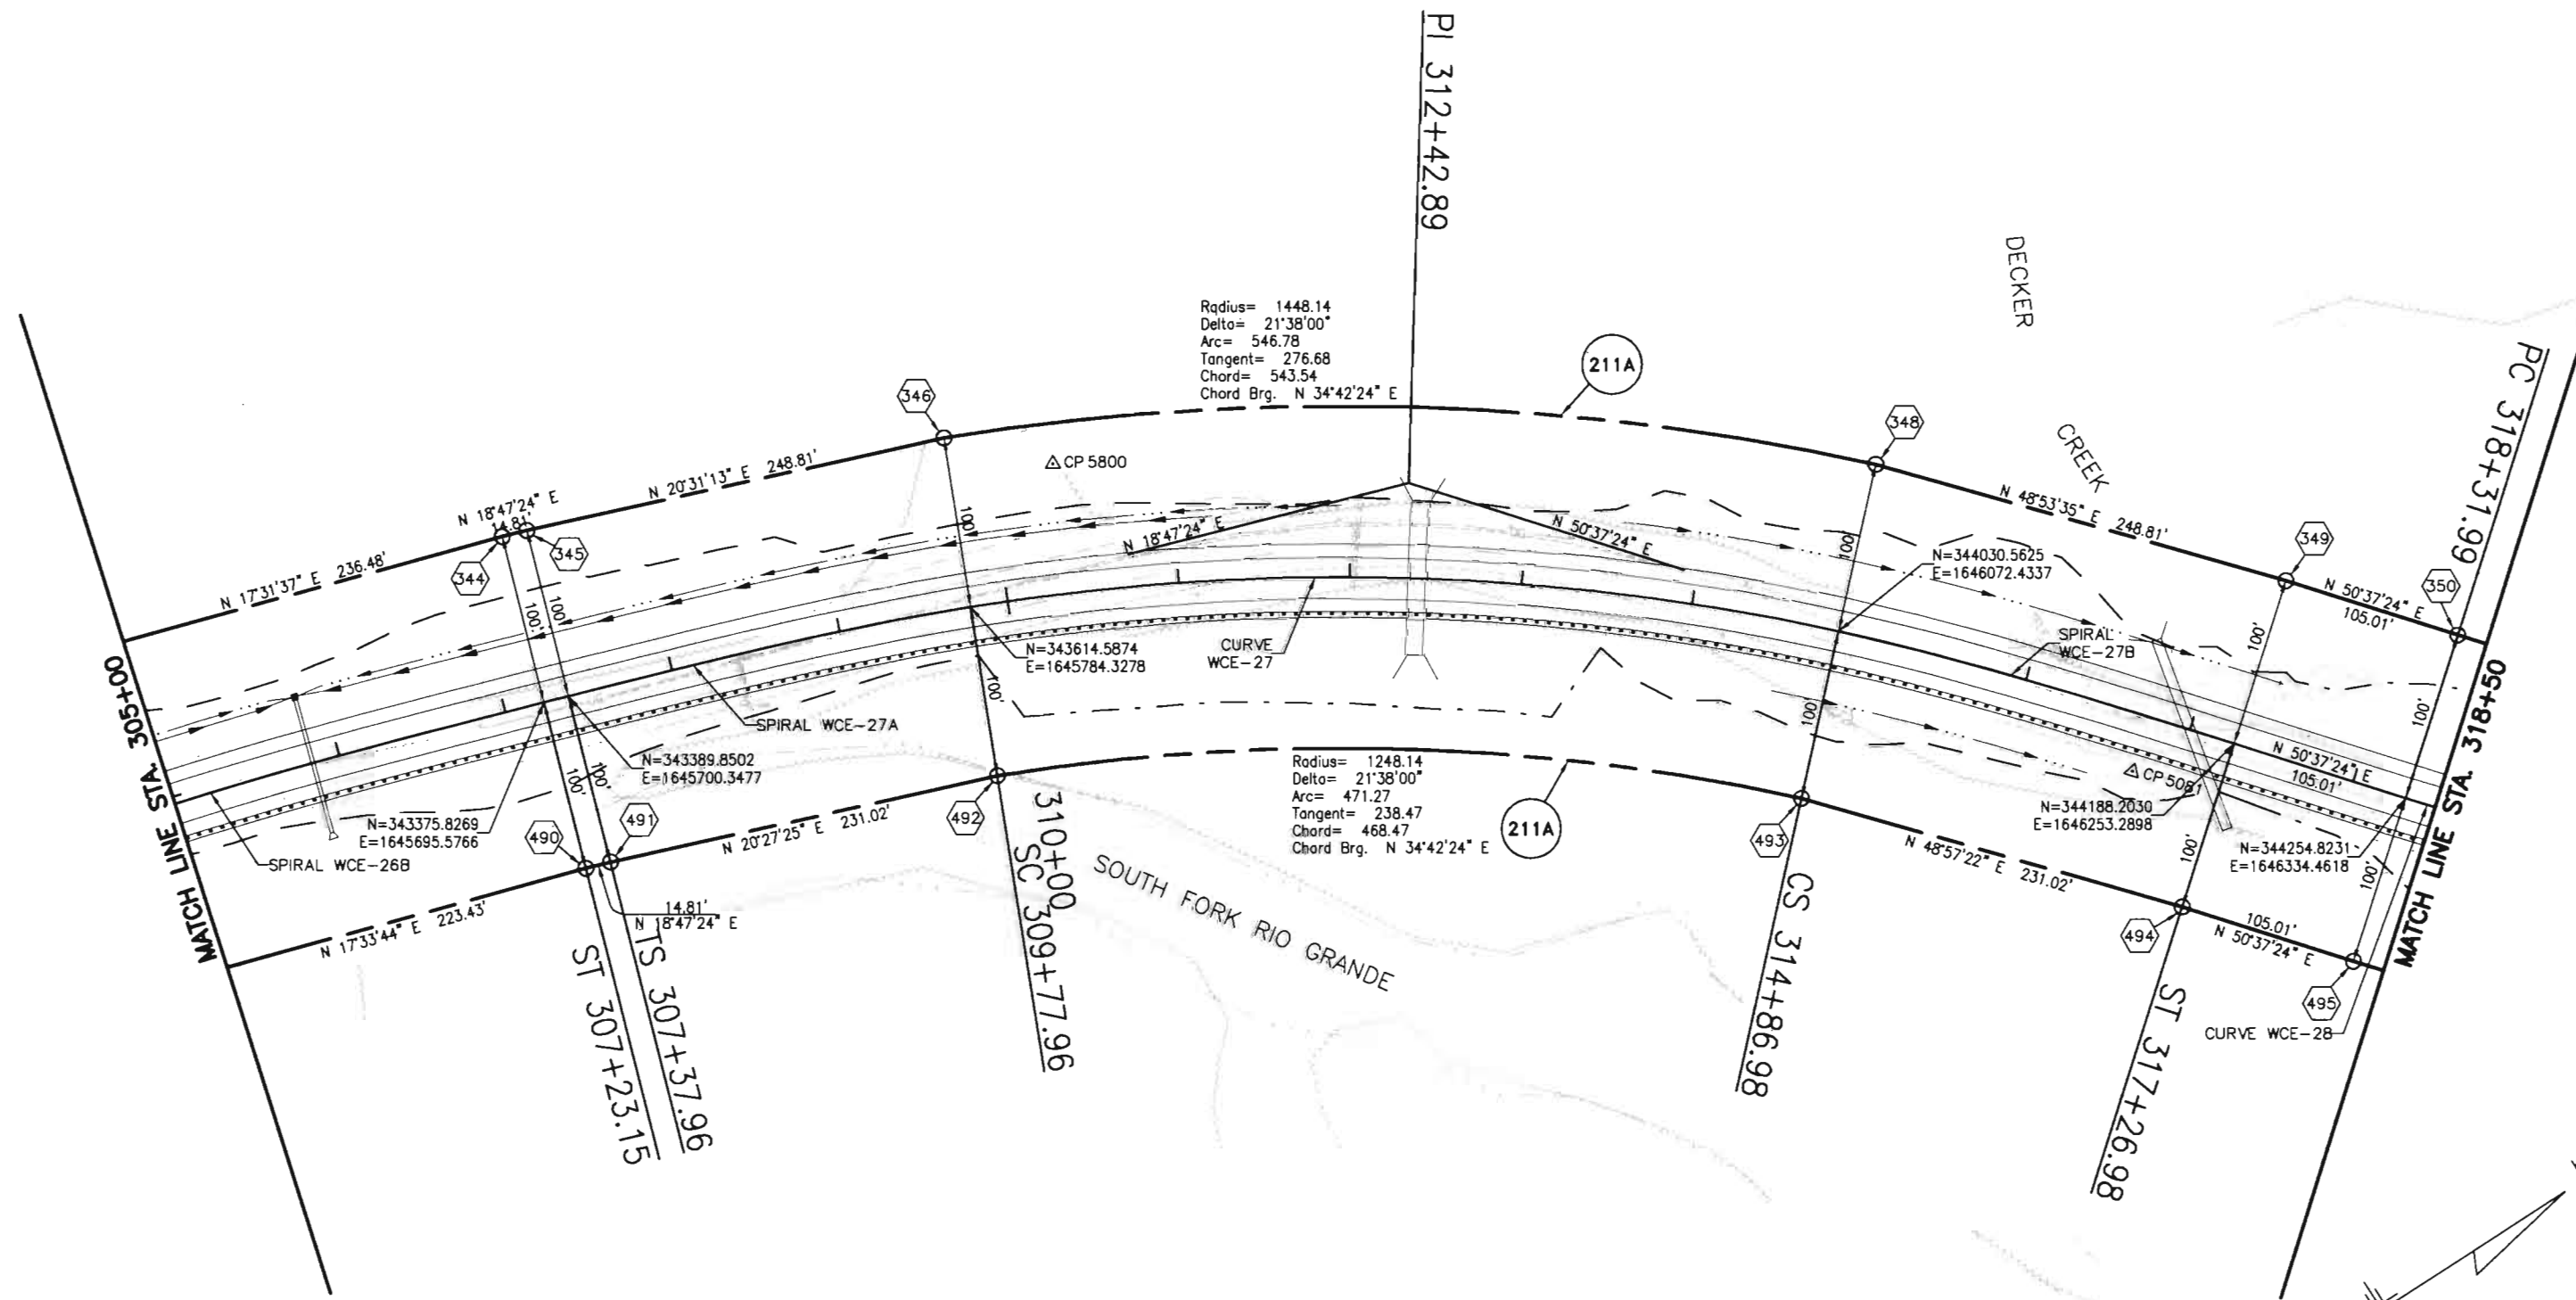

Radius= 1448.14
Delta= 21°38'00"
Arc= 546.78
Tangent= 276.68
Chord= 543.54
Chord Brg. N 34°42'24" E

Radius= 1248.14
Delta= 21°38'00"
Arc= 471.27
Tangent= 238.47
Chord= 468.47
Chord Brg. N 34°42'24" E

SPIRAL WCE-26B
Ls=230.000
Ang=3°44'15.0"
LT=153.368
ST=76.698

SPIRAL WCE-27A
Ls=240.000
Ang=5°06'00.0"
LT=160.066
ST=80.060

CURVE WCE-27
PI 312+42.88
D= 21°38'00.4"
R= 1348.136
Dc=4°15'00.0"
A= 509.023
C= 506.004

SPIRAL WCE-27B
Ls=240.000
Ang=5°06'00.0"
LT=160.066
ST=80.060

CURVE WCE-28
PI 320+56.83
D= 5°36'59.4"
R= 4583.664
Dc=1°15'00.0"
A= 449.320
T= 224.840
C= 449.140

211A UNITED STATES FOREST SERVICE

DEPOSITED THIS DAY OF AT FOR INFORMATION
ONLY IN BOOK OF THE COUNTY LAND SURVEYS/RIGHT OF WAY
SURVEYS AT PAGE RECEPTION NUMBER

0/0022\DWGS\ROW\PLAN\WCE\SRP.DWG. 08/12/2002 10:11:54 AM

DEPT.

COLORADO DEPARTMENT OF TRANSPORTATION



Region 5
Address: 3803 North Main Avenue, Suite 300
Durango, Colorado 81301
Phone: (970) 385-1400 FAX: (970) 385-1410

Right of Way Plans Unit: Crumbaugh

Sheet Revisions

mm/yy	XXXXX	XXX

Sheet Revisions

mm/yy	XXXXX	XXX

Sheet Revisions

mm/yy	XXXXX	XXX


Right of Way Plans

Right of Way Plan Sheet

Project Number:	NH (CX)160-2(50) UNIT 2
Project Location:	WOLF CREEK PASS EAST
Project Code:	92977
Last Mod. Date:	---
Subset Sheets:	20 of 27
Sheet No.:	25
Total No. of Sheets:	49

T.39 N, R.2 E, NMPM

Carter-Burgess

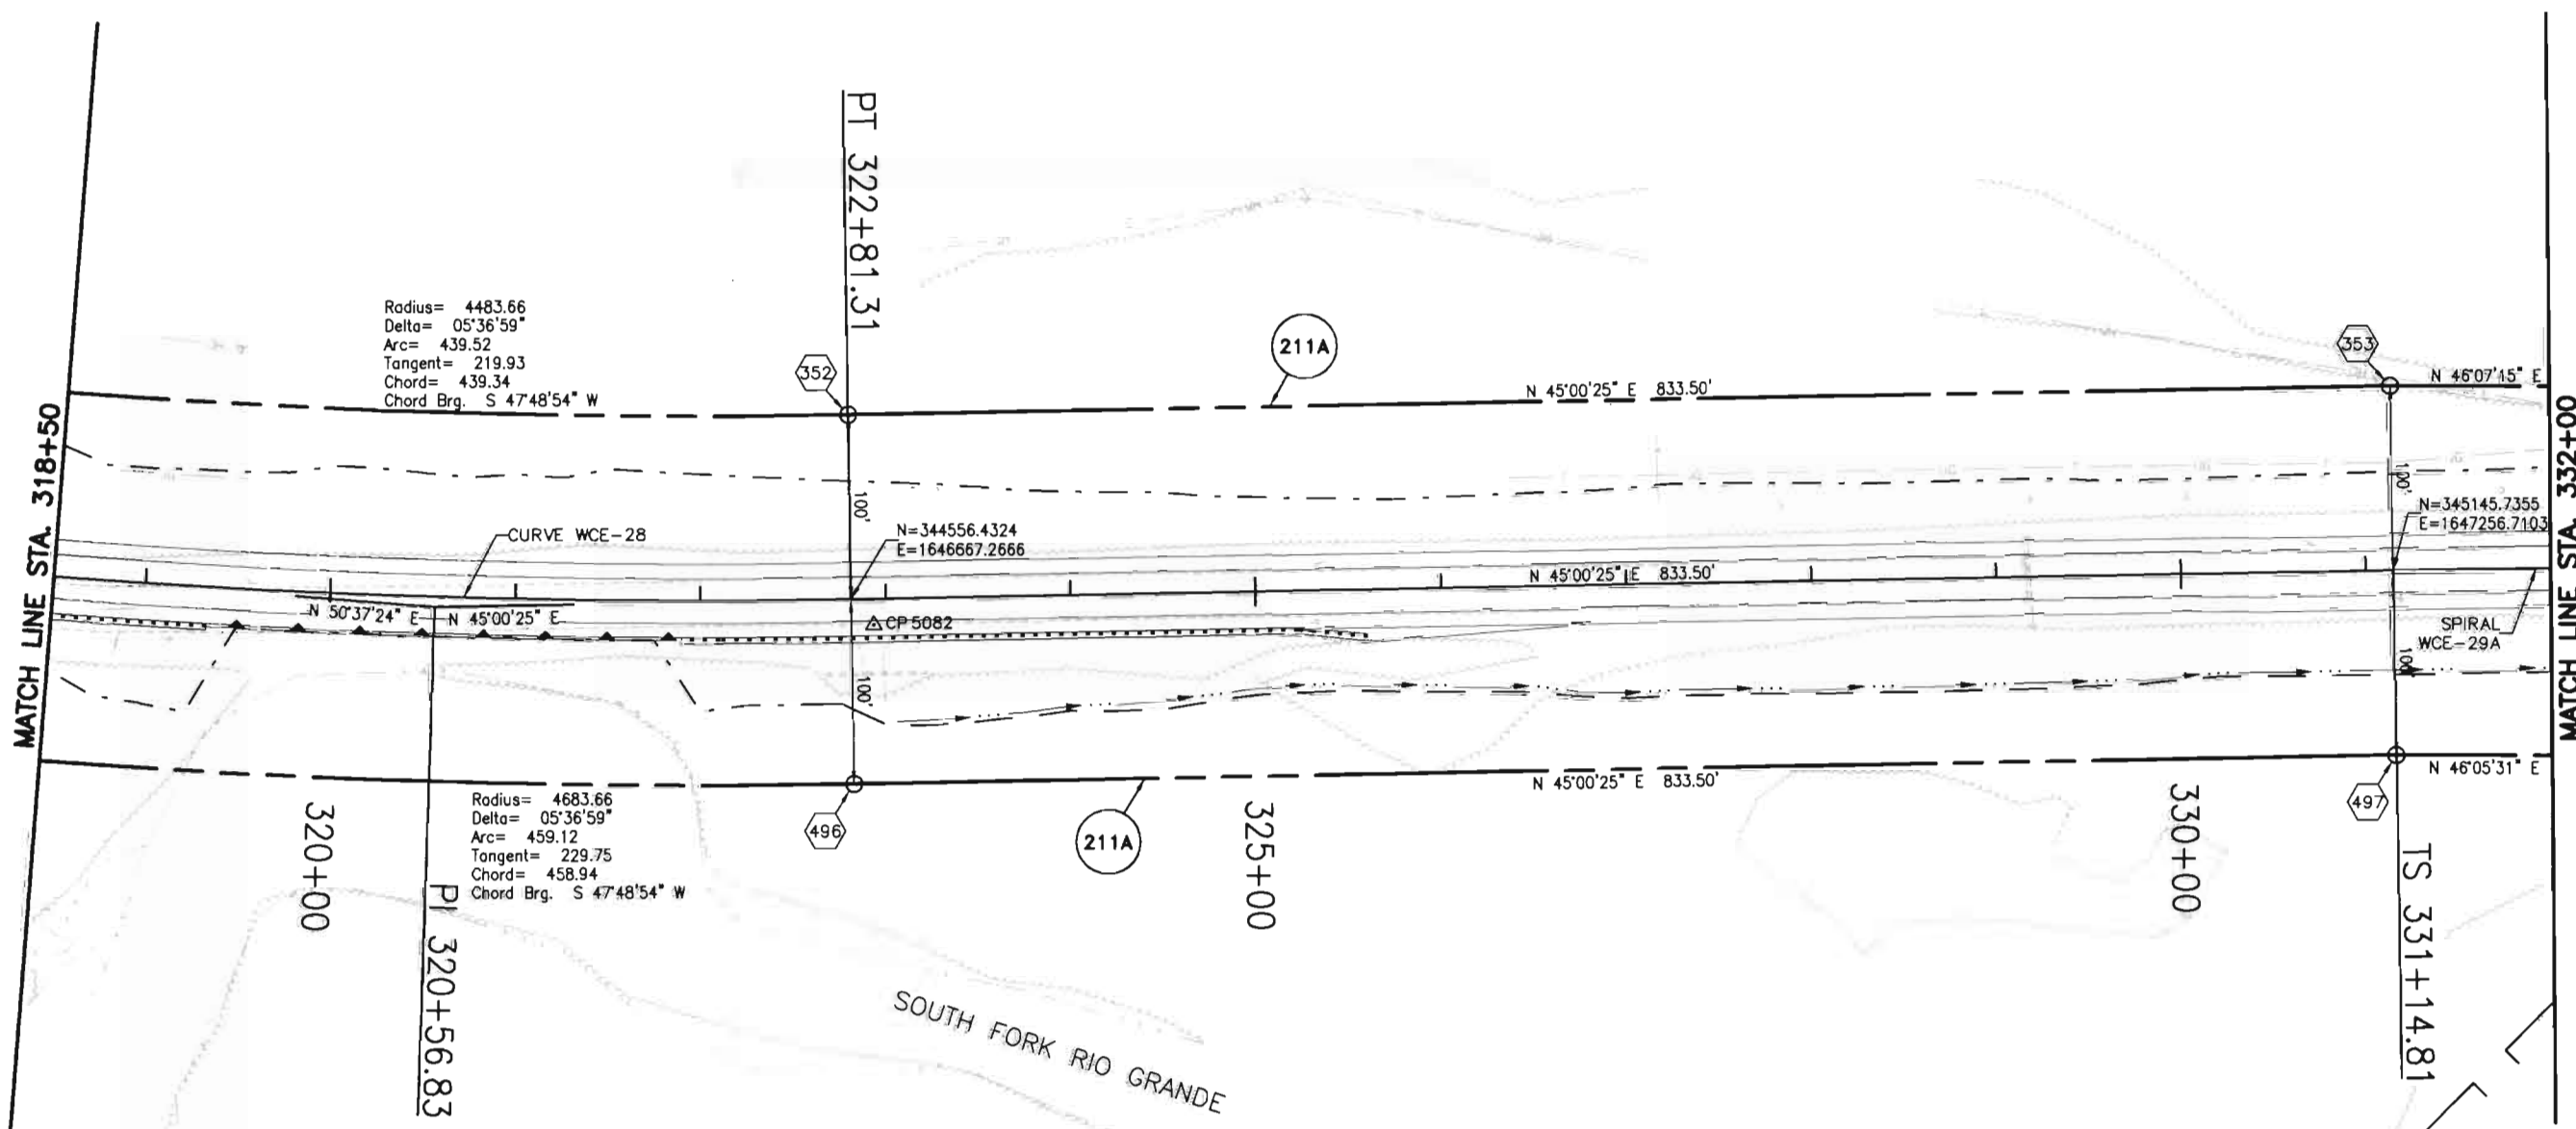

Radius= 4483.66
Delta= 05°36'59"
Arc= 439.52
Tangent= 219.93
Chord= 439.34
Chord Brg. S 47°48'54" W

Radius= 4683.66
Delta= 05°36'59"
Arc= 459.12
Tangent= 229.75
Chord= 458.94
Chord Brg. S 47°48'54" W

CURVE WCE-28
PI 320+56.83
D= 5°36'59.4"
R= 4583.664
Dc=175°00.0"
A= 449.320
T= 224.840
C= 449.140

SPIRAL WCE-29A
Ls=220.000
Ang=3°18'00.0"
LT=146.692
ST=73.357



COLORADO DEPARTMENT OF TRANSPORTATION



Region 5
Address: 3803 North Main Avenue, Suite 300
Durango, Colorado 81301
Phone: (970) 385-1400 FAX: (970) 385-1410

Right of Way Plans Unit: Crumbaugh

Sheet Revisions		
mm/yy	xxxxx	xxx


Sheet Revisions		
mm/yy	xxxxx	xxx

Sheet Revisions		
mm/yy	xxxxx	xxx

Right of Way Plans				
Right of Way Plan Sheet				
Project Number:		NH (CX)160-2(50) UNIT 2		
Project Location:		WOLF CREEK PASS EAST		
Project Location:				
Project Code:	Last Mod. Date	Subset Sheets	Sheet No.	Total No. of Sheets
92977	---	21 of 27	26	49

T.39 N, R.2 E, NMPM

Carter-Burgess

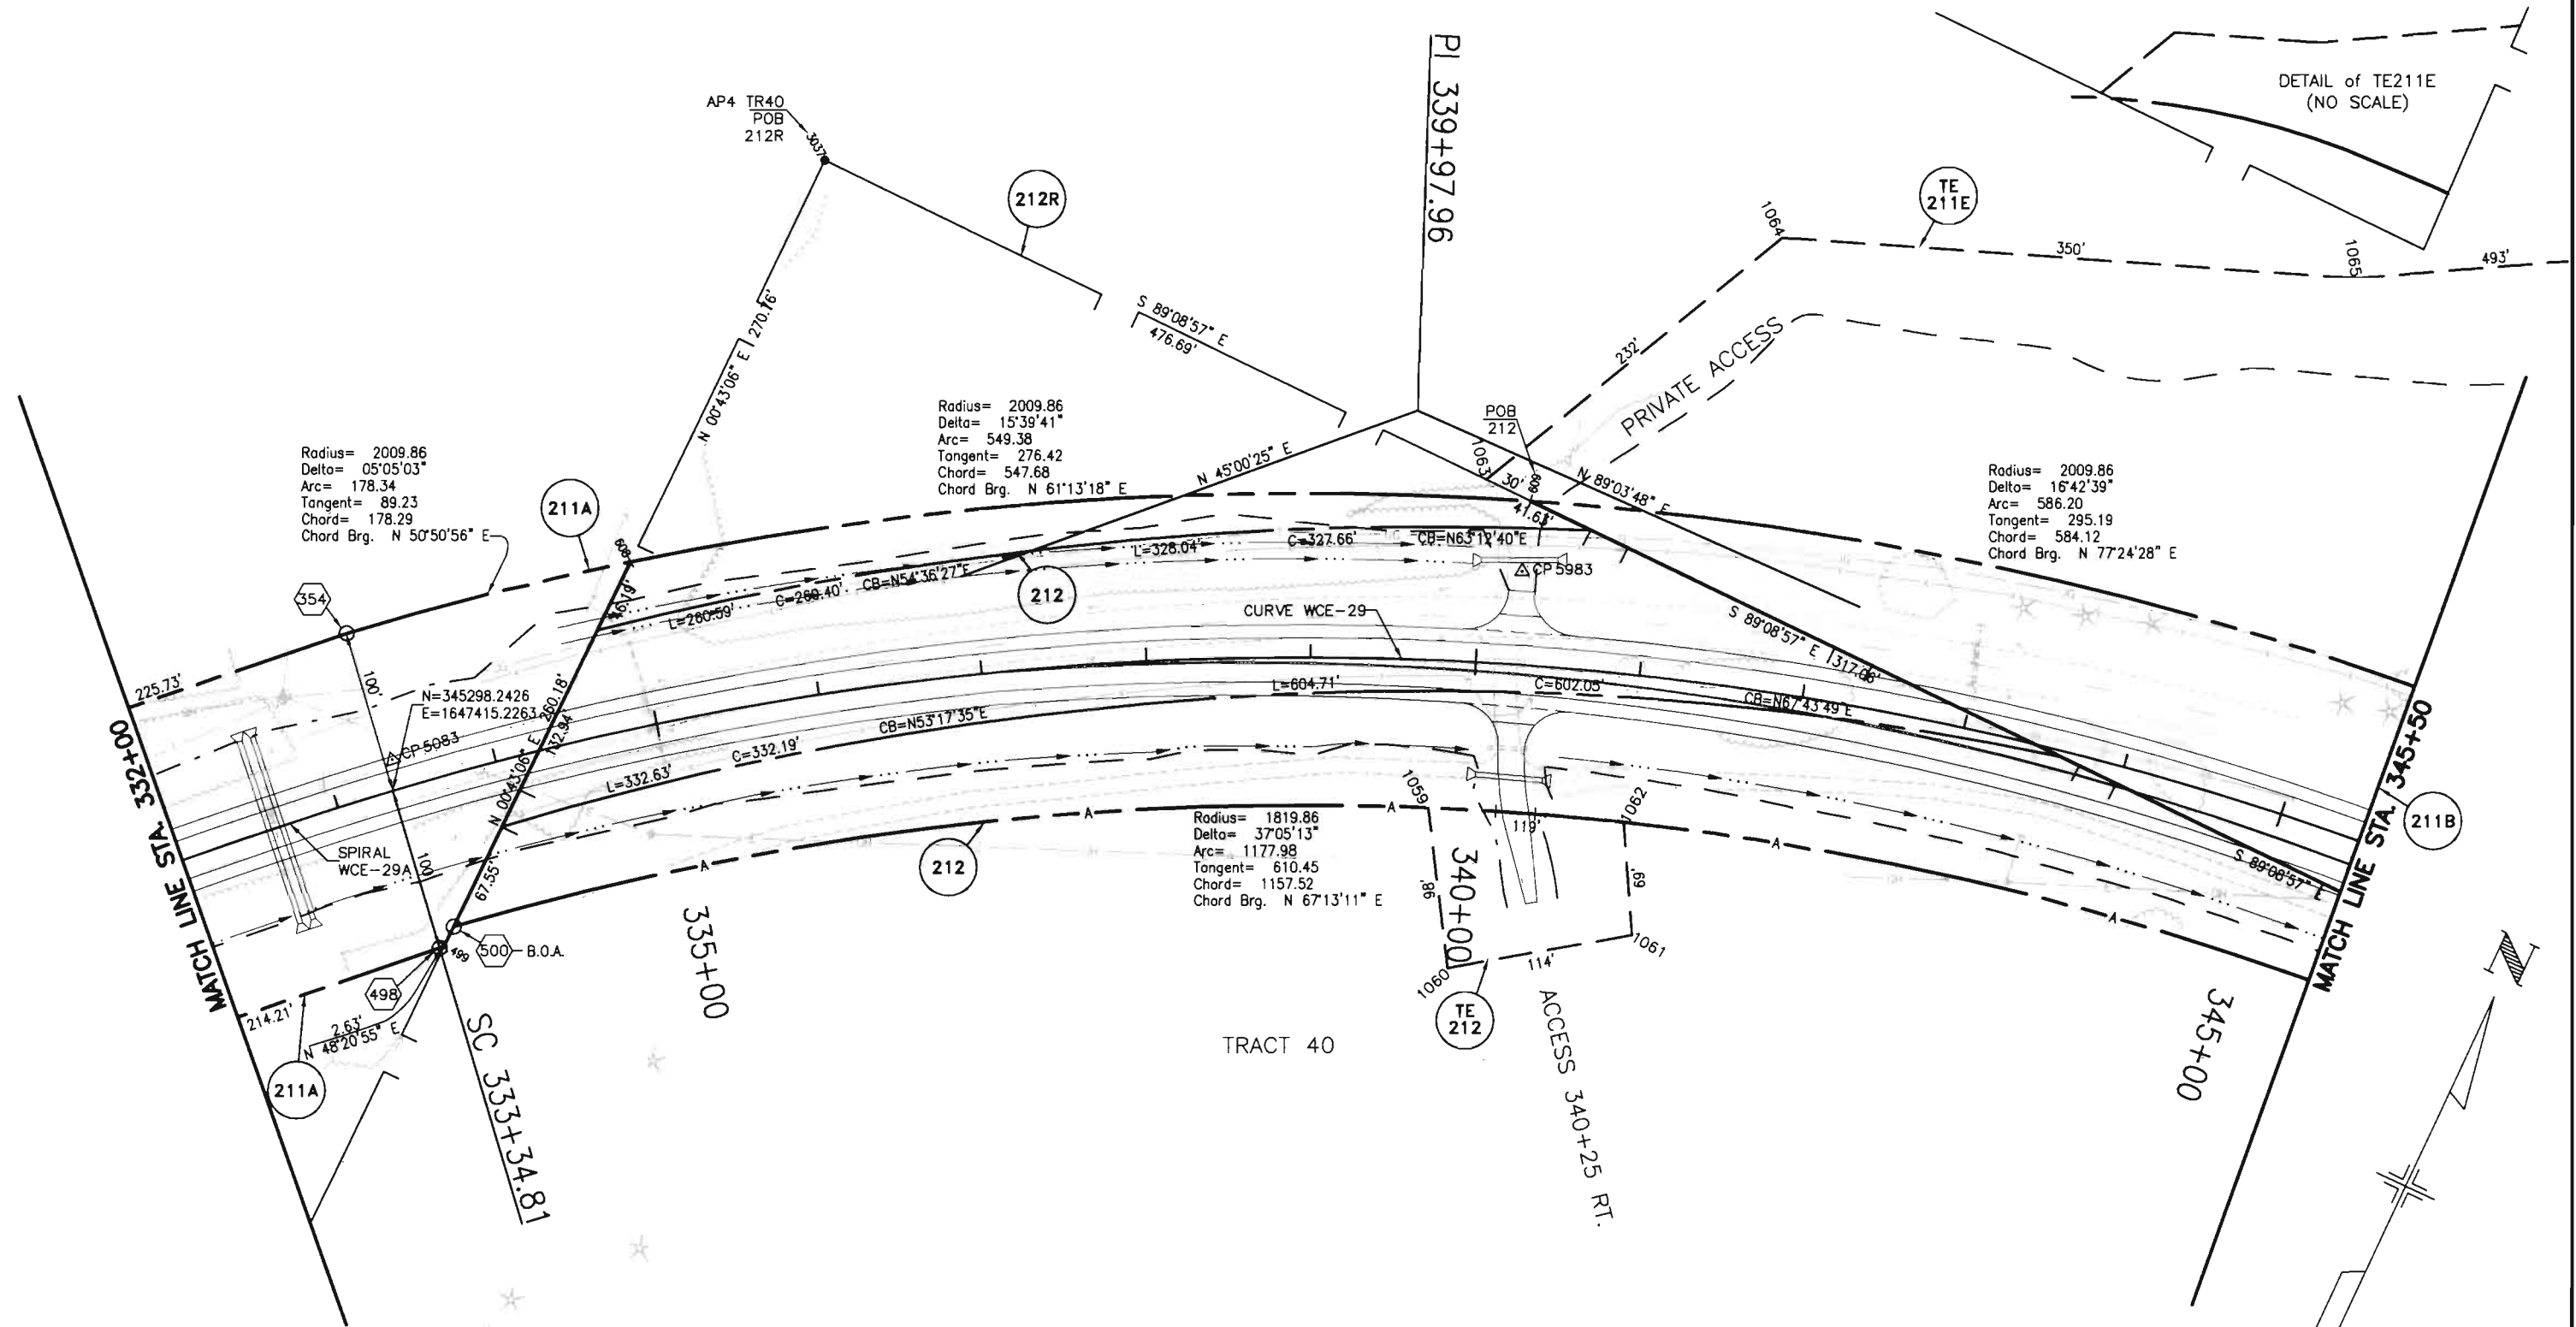

DETAIL of TE211E
(NO SCALE)

Radius= 2009.86
Delta= 05°05'03"
Arc= 178.34
Tangent= 89.23
Chord= 178.29
Chord Brg. N 50°50'56" E

 
Radius= 2009.86
Delta= 15°39'41"
Arc= 549.38
Tangent= 276.42
Chord= 547.68
Chord Brg. N 61°13'18" E

Radius= 2009.86
Delta= 16°42'39"
Arc= 586.20
Tangent= 295.19
Chord= 584.12
Chord Brg. N 77°24'28" E

Radius= 1819.86
Delta= 37°05'13"
Arc= 1177.98
Tangent= 610.45
Chord= 1157.52
Chord Brg. N 67°13'11" E

TE 211E 211B 211A UNITED STATES FOREST SERVICE
212R TE 212 212 ROBERT E. CROSS
BOOK 104 PAGE 74

SPIRAL WCE-29A
Ls=220.000
Ang=3°18'00.0"
LT=146.692
ST=73.357
CURVE WCE-29
PI 339+97.95
D= 37°27'23.4"
R= 1909.859
Dc=3°00'00.0"
A= 1248.550
C= 1226.435



REPORTED THIS DAY OF AT AL, FOR INFORMATION
ONLY IN BOOK OF THE COUNTY LAND SURVEYS/RIGHT OF WAY
SURVEYS AT PAGE RECEPTION NUMBER

0/0022\DWGS\ROW\PLAN\WCE21RP.DWG, 08/19/2002 08:03:21 AM

COLORADO DEPARTMENT OF TRANSPORTATION



Region 5
Address: 3803 North Main Avenue, Suite 300
Durango, Colorado 81301
Phone: (970) 385-1400 FAX: (970) 385-1410

Right of Way Plans Unit: Crumbaugh

Sheet Revisions

mm/yy	xxxxx	xxx

Sheet Revisions

mm/yy	xxxxx	xxx

Sheet Revisions

mm/yy	xxxxx	xxx


Right of Way Plans

Right of Way Plan Sheet


Project Number:	NH (CX)160-2(50) UNIT 2			
Project Location:	WOLF CREEK PASS EAST			
Project Location:				
Project Code:	Last Mod. Date	Subsect Sheets	Sheet No.	Total No. of Sheets
92977	---	22 of 27	27	49

T.39 N, R.2 E, NMPM

Carter-Burgess

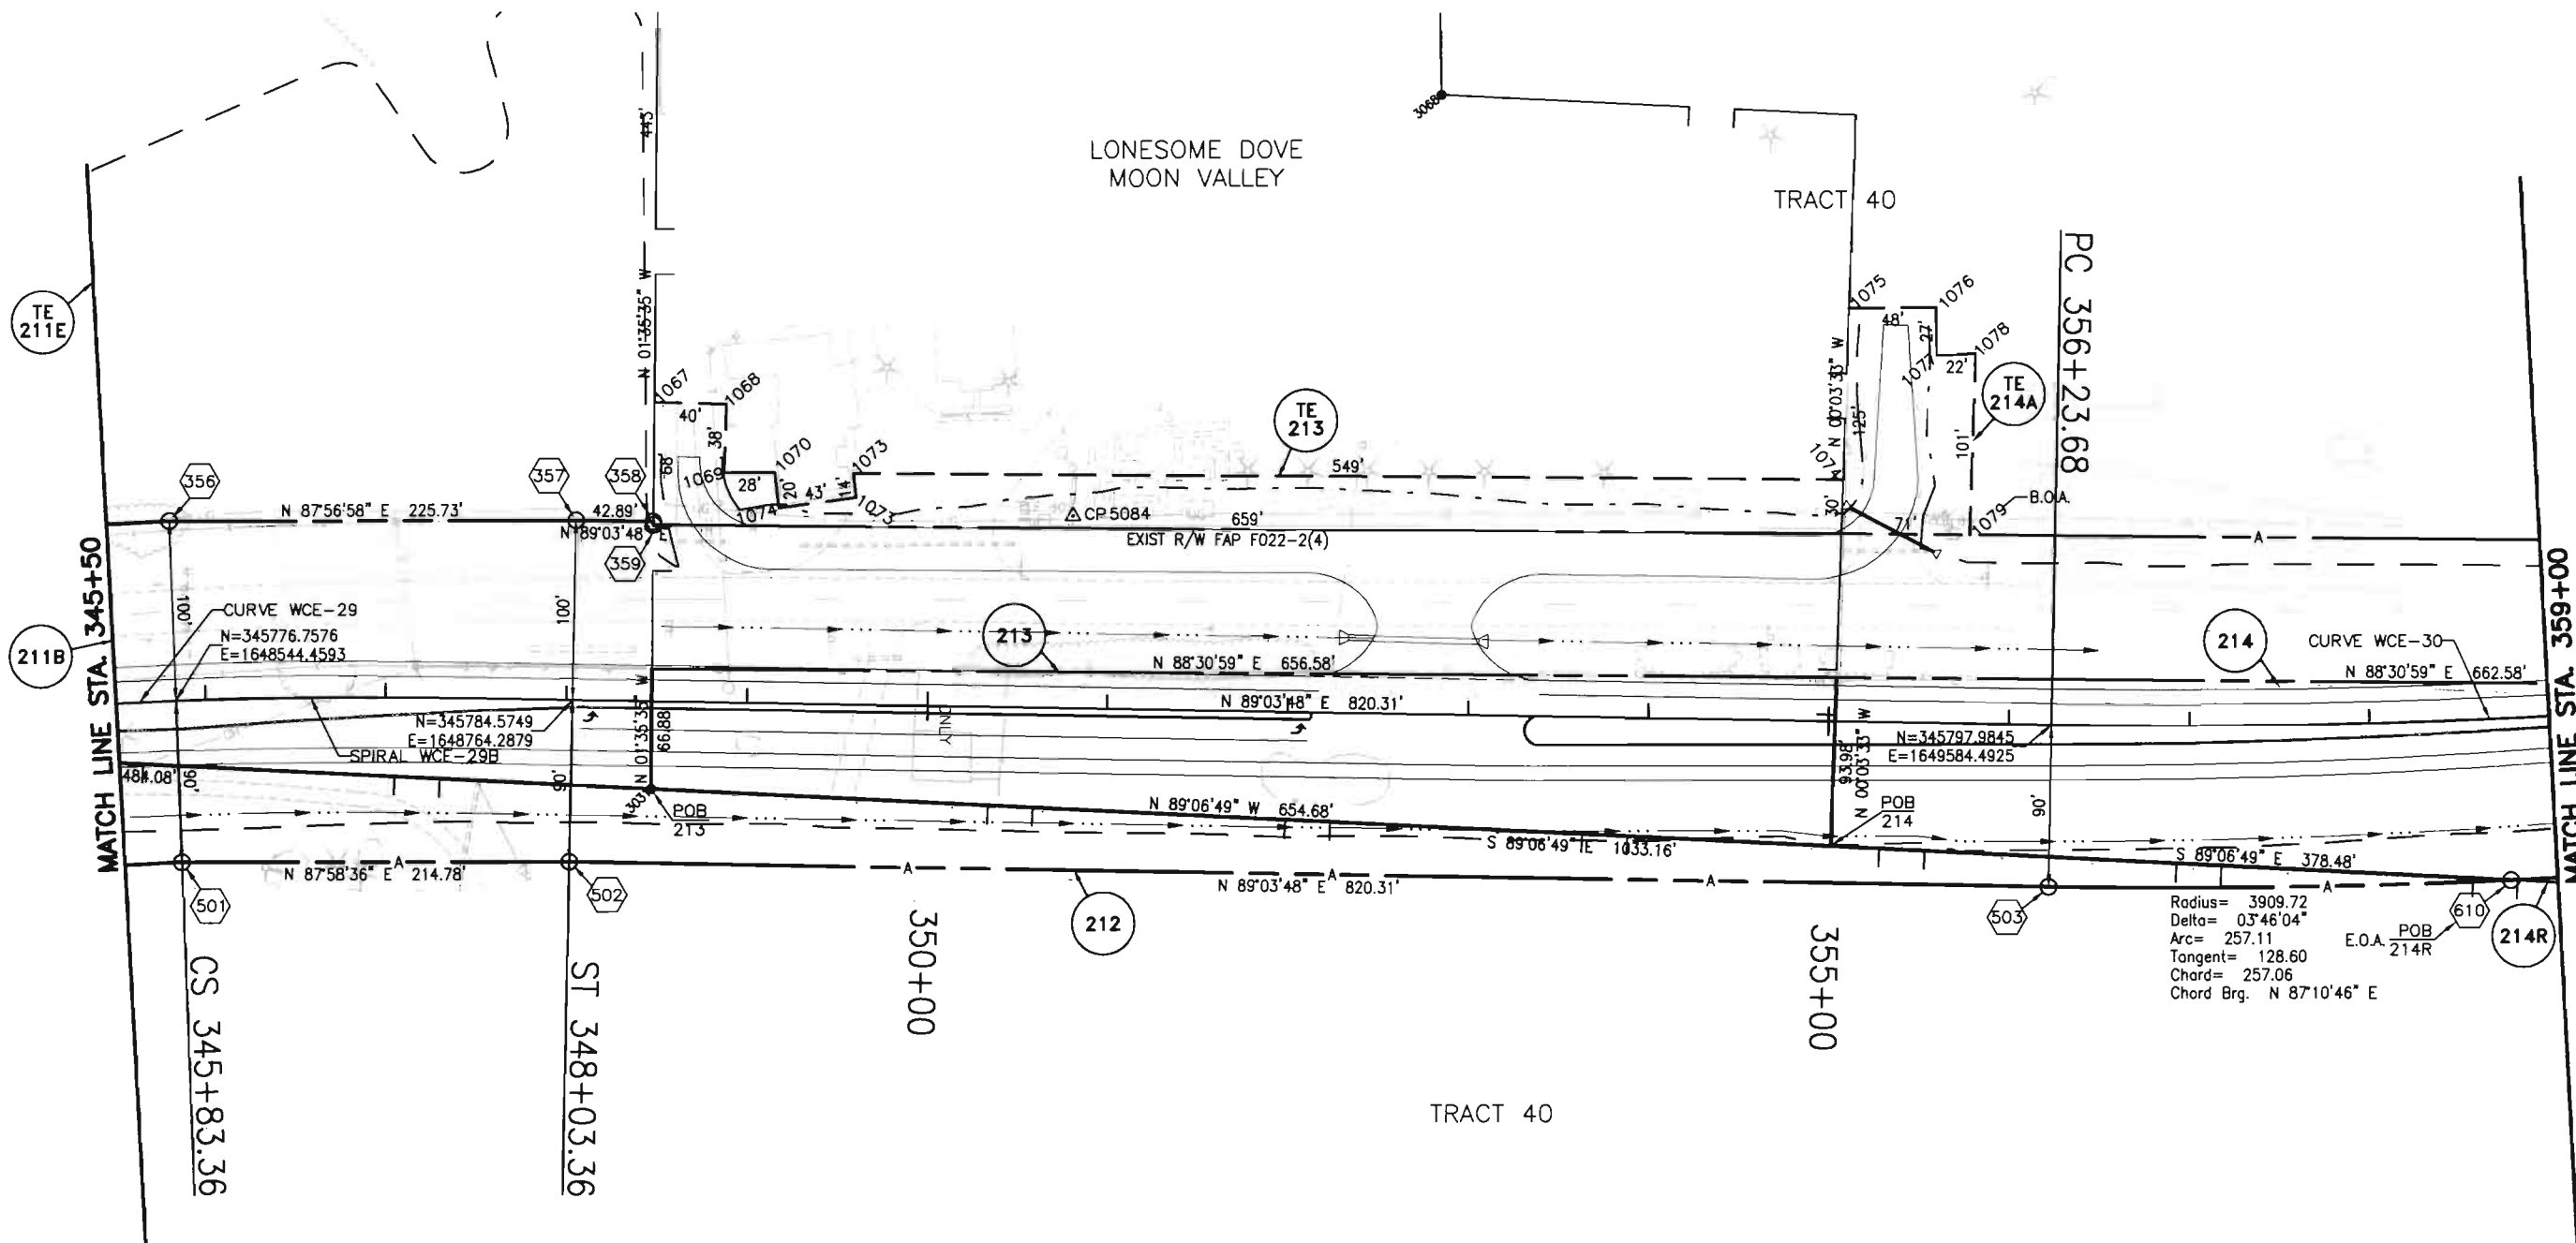

 Radius= 3909.72
Delta= 03°46'04"
Arc= 257.11
Tangent= 128.60
Chord= 257.06
Chord Brg. N 87°10'46" E



- TE 211E 211B UNITED STATES FOREST SERVICE
- 212 ROBERT E. CROSS
BOOK 104 PAGE 74
- TE 213 213 ROBERT M. GOODNIGHT, MARJORIE N. GOODNIGHT, & JEANETTE S. DAVIS
BOOK 113-J PAGE 1
- TE 214A 214R 214 LARRY EHARDT
BOOK 111-L PAGE 74

CURVE WCE-29
PI 339+97.95
D= 37°27'23.4"
R= 1909.859
Dc= 3°00'00.0"
A= 1248.550
C= 1226.435

SPIRAL WCE-29B
Ls=220.000
Ang=3°18'00.0"
LT=146.692
ST=73.357

CURVE WCE-30
PI 360+66.28
D= 13°13'09.2"
R= 3819.719
Dc= 1°30'00.0"
A= 881.282
T= 442.606
C= 879.329

COLORADO DEPARTMENT OF TRANSPORTATION



Region 5
Address: 3803 North Main Avenue, Suite 300
Durango, Colorado 81301
Phone: (970) 385-1400 FAX: (970) 385-1410

Right of Way Plans Unit: Crumbaugh

Sheet Revisions

mm/yy	XXXXX	XXX

Sheet Revisions

mm/yy	XXXXX	XXX

Sheet Revisions

mm/yy	XXXXX	XXX

Right of Way Plans


Right of Way Plan Sheet

Project Number:	NH (CX)160-2(50) UNIT 2
Project Location:	WOLF CREEK PASS EAST
Project Code:	92977
Last Mod. Date:	---
Subset Sheets:	23 of 27
Sheet No.:	28
Total No. of Sheets:	49

T.39 N, R.2 E, NMPM



T.39 N, R.3 E, NMPM

Carter-Burgess

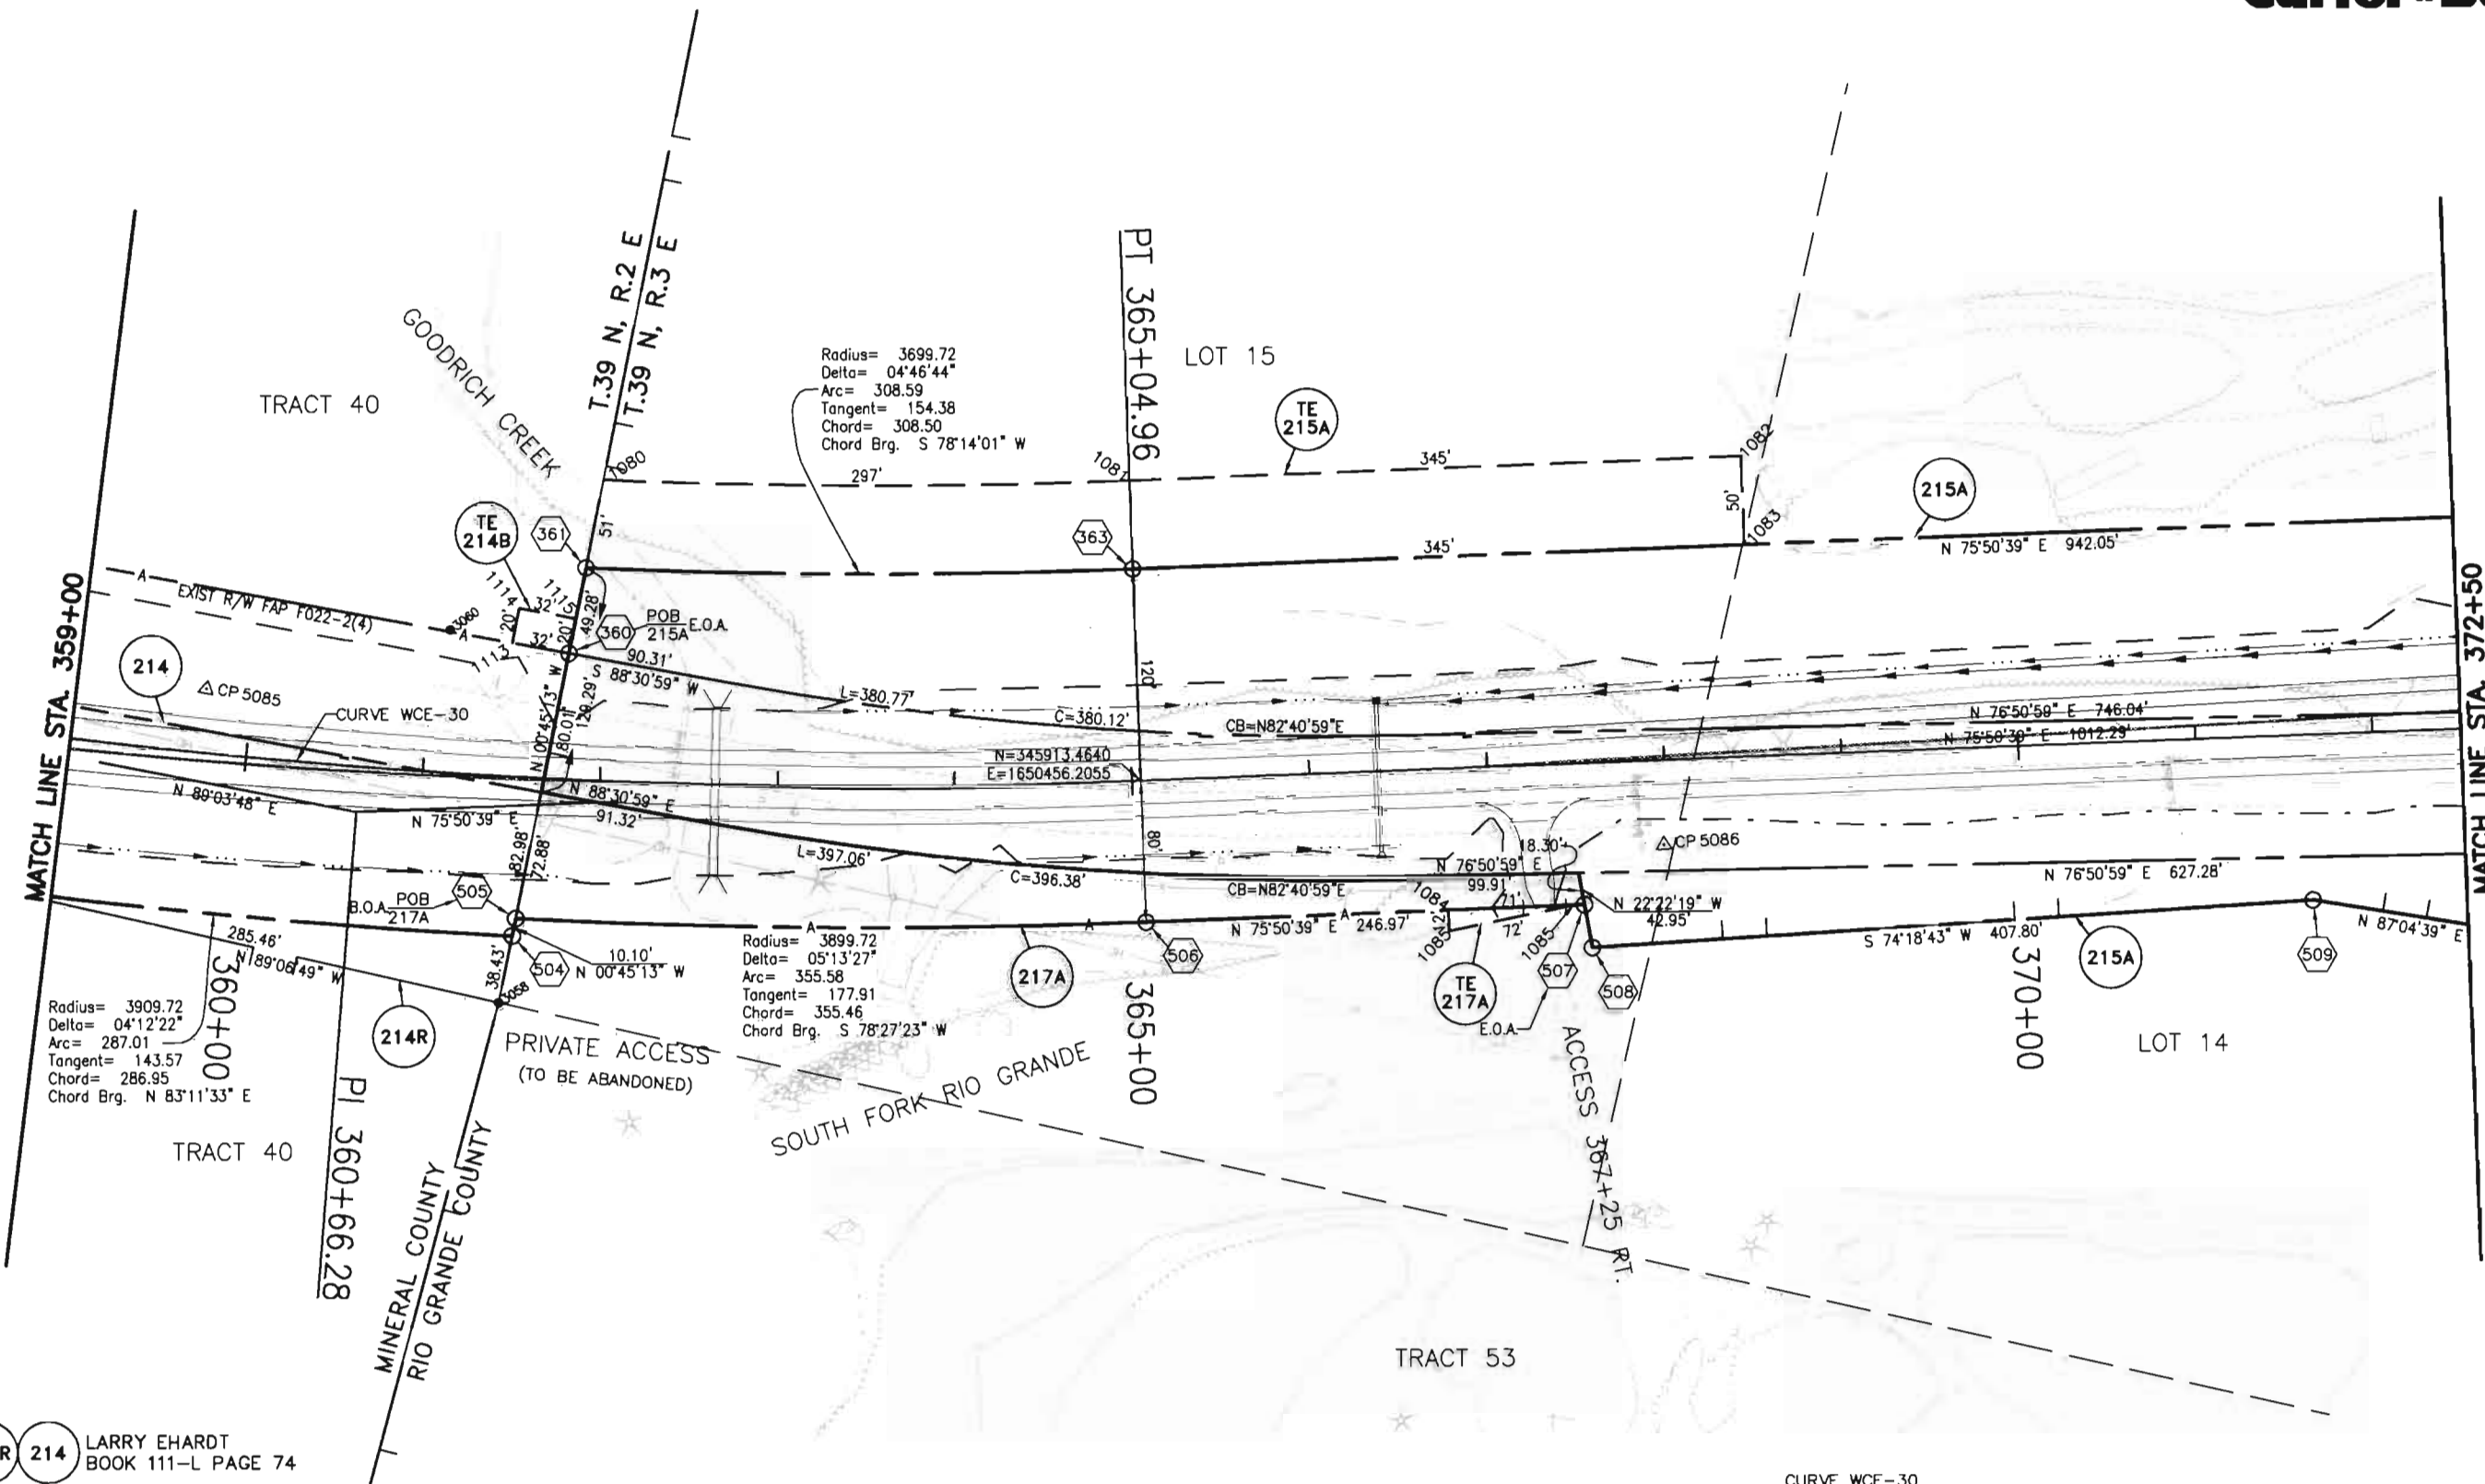

- TE 214B 214R 214 LARRY EHARDT
BOOK 111-L PAGE 74
- TE 215A 215A ROBERT LEE MURPHY
BOOK 0497 PAGE 1849
- TE 217A 217A FUN VALLEY INC.
BOOK 465 PAGE 257,BOOK 382 PAGE 894,BOOK 431 PAGE 317

 CURVE WCE-30
PI 360+66.28
D= 13'13'09.2"
R= 3819.719
Dc=1'30'00.0"
A= 881.282
T= 442.606
C= 879.329

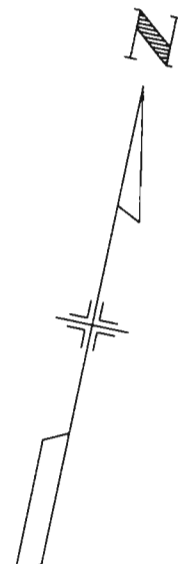

COLORADO DEPARTMENT OF TRANSPORTATION



Region 5
Address: 3803 North Main Avenue, Suite 300
Durango, Colorado 81301
Phone: (970) 385-1400 FAX: (970) 385-1410

Right of Way Plans Unit: Crumbaugh

Sheet Revisions

mm/yy	XXXXX	XXX

Sheet Revisions

mm/yy	XXXXX	XXX

Sheet Revisions



mm/yy	XXXXX	XXX

Right of Way Plans

Right of Way Plan Sheet

Project Number:		NH (CX)160-2(50) UNIT 2		
Project Location:		WOLF CREEK PASS EAST		
Project Location:				
Project Code:	Last Mod. Date	Subset Sheets	Sheet No.	Total No. of Sheets
92977	---	24 of 27	29	49

 T.39 N, R.3 E, NMPM

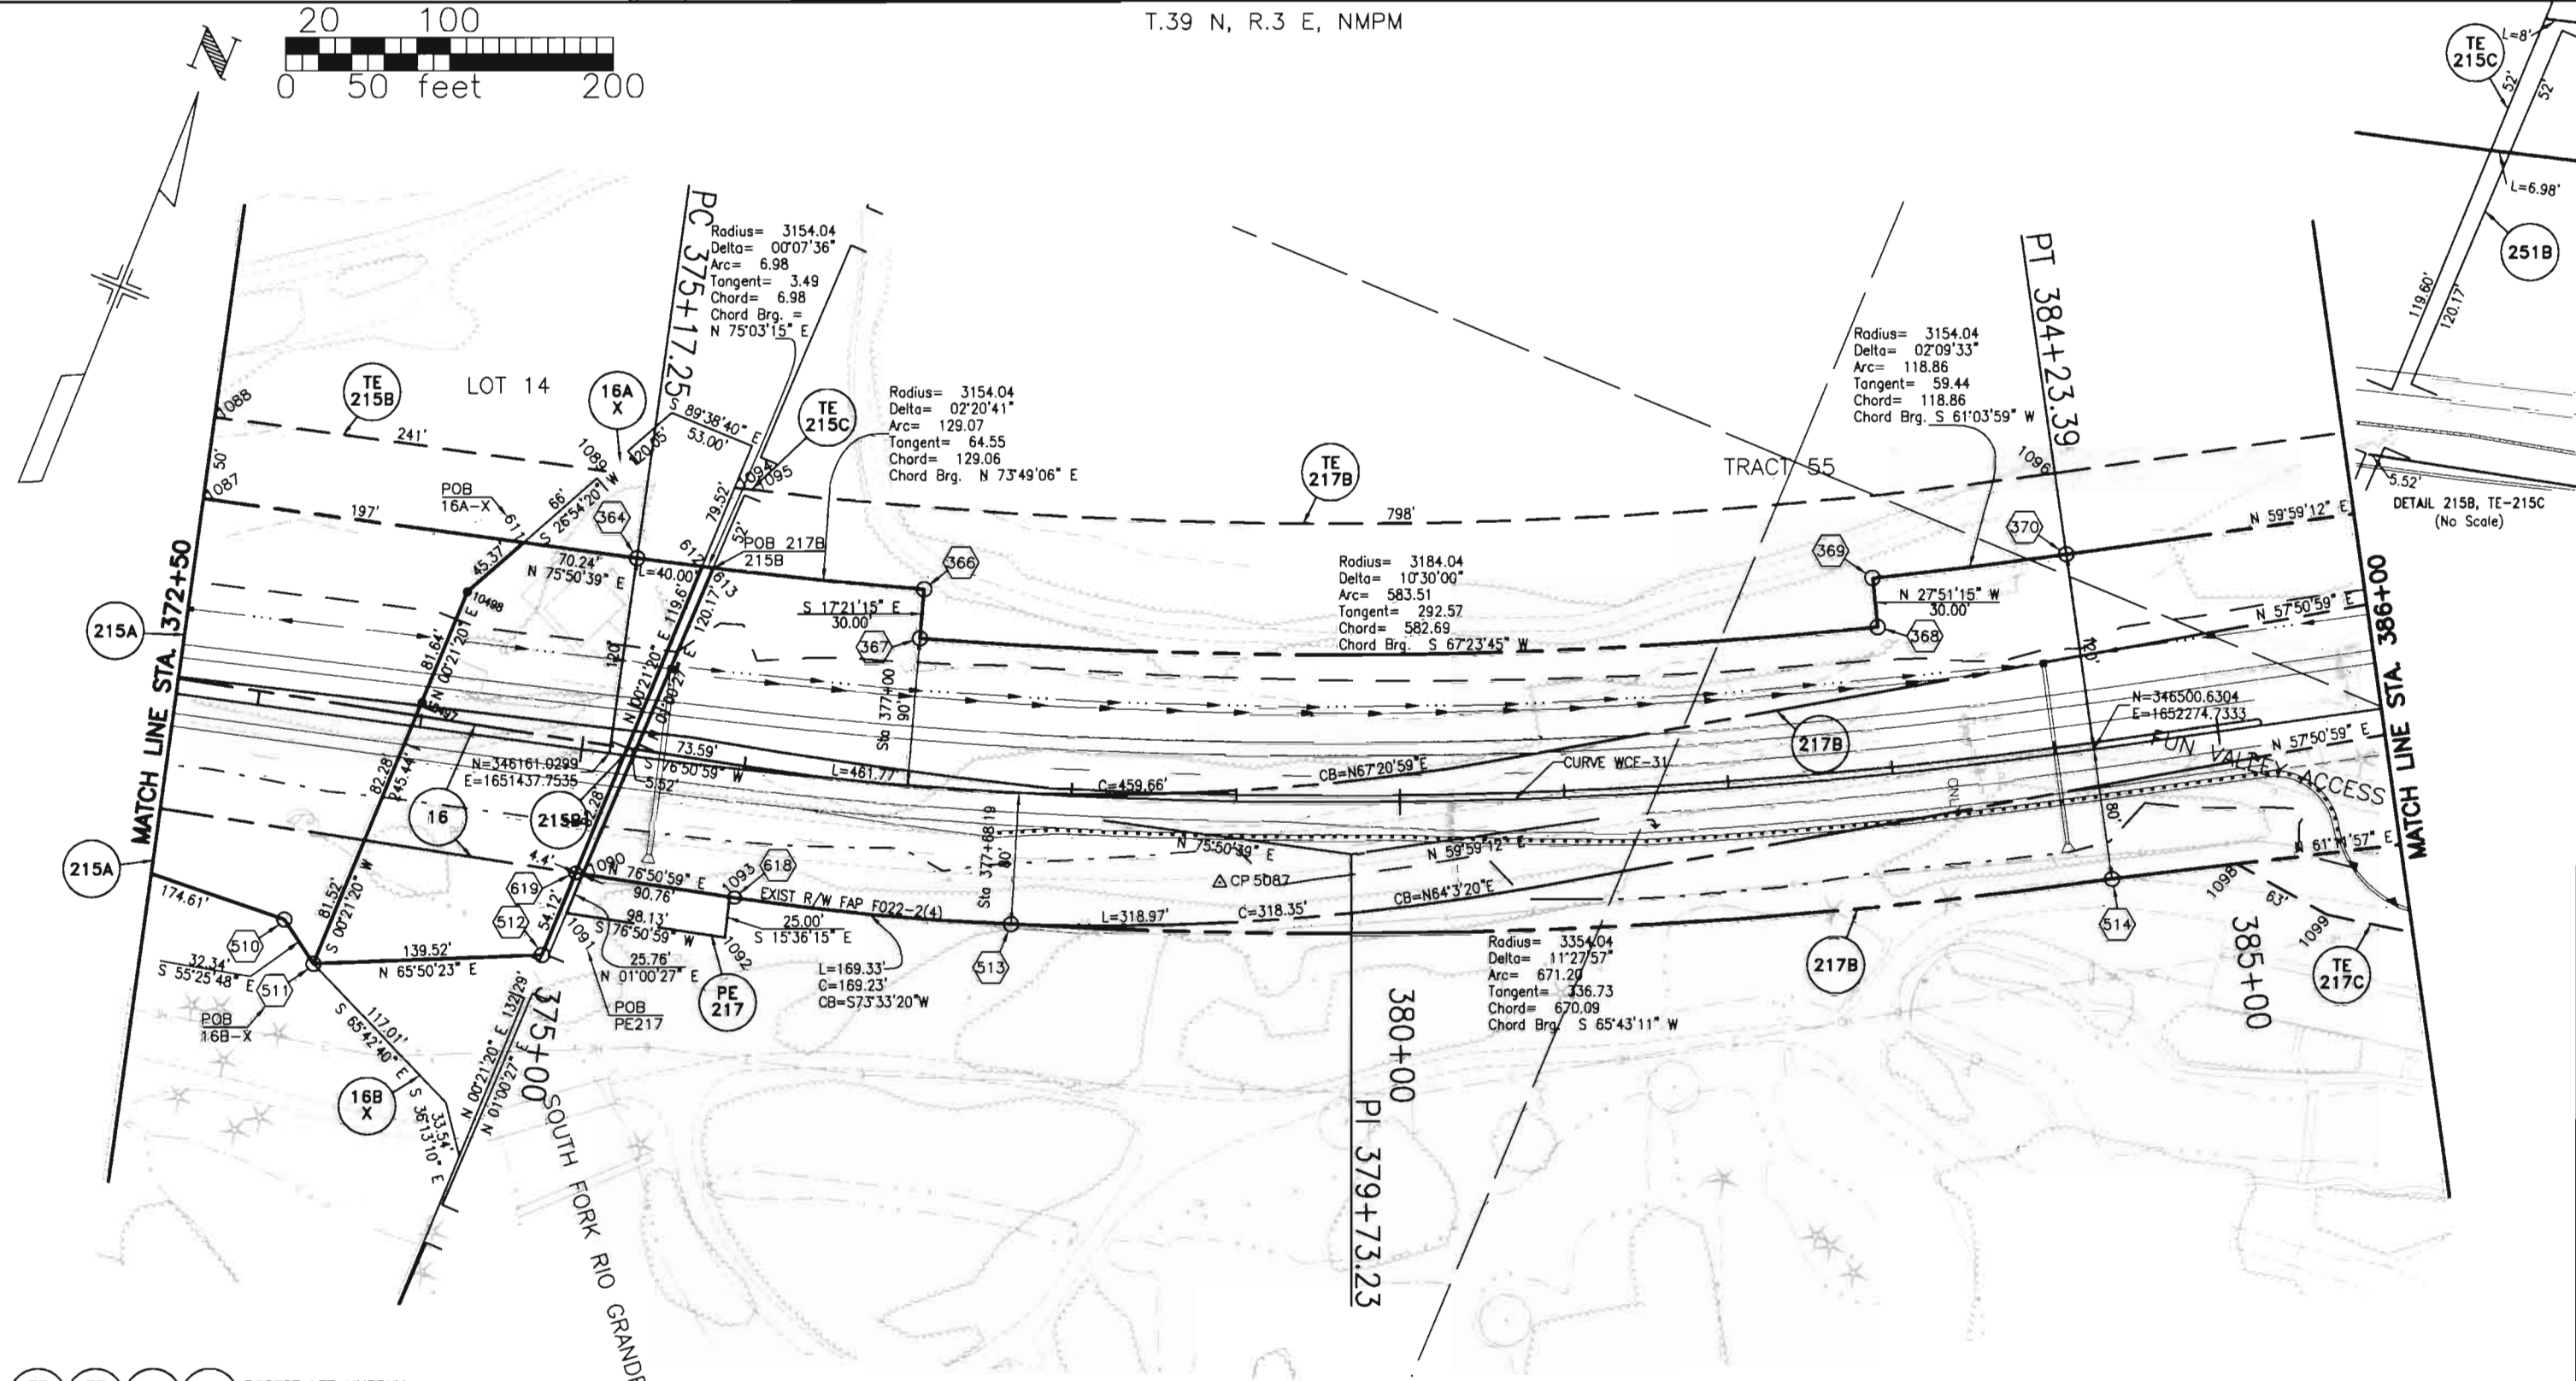

- TE 215C

TE 215B

215B

215A
- 16B X

16A X

16
- TE 217C

TE 217B

PE 217

217B
- ROBERT LEE MURPHY
BOOK 0497 PAGE 1849
- MARCEL A. POULAN & MARIA H. POULAN
BOOK 437 PAGE 161
- FUN VALLEY INC.
BOOK 465 PAGE 257, BOOK 382 PAGE 894, BOOK 431 PAGE 317

CURVE WCE=31
PI 379+73.23
D= 15°51'26.9"
R= 3274.045
Dc=1°45'00.0"
A= 906.141
T= 455.985
C= 903.252

Carter Burgess

COLORADO DEPARTMENT OF TRANSPORTATION



Region 5
Address: 3803 North Main Avenue, Suite 300
Durango, Colorado 81301
Phone: (970) 385-1400 FAX: (970) 385-1410

Right of Way Plans Unit: Crumbaugh

Sheet Revisions

mm/yy	XXXXX	XXX

Sheet Revisions

mm/yy	XXXXX	XXX

Sheet Revisions



mm/yy	XXXXX	XXX

Right of Way Plans

Right of Way Plan Sheet

Project Number:		NH (CX)160-2(50) UNIT 2		
Project Location:		WOLF CREEK PASS EAST		
Project Location:				
Project Code:	Last Mod. Date	Subset Sheets	Sheet No.	Total No. of Sheets
92977	---	25 of 27	30	49

 T.39 N, R.3 E, NMPM

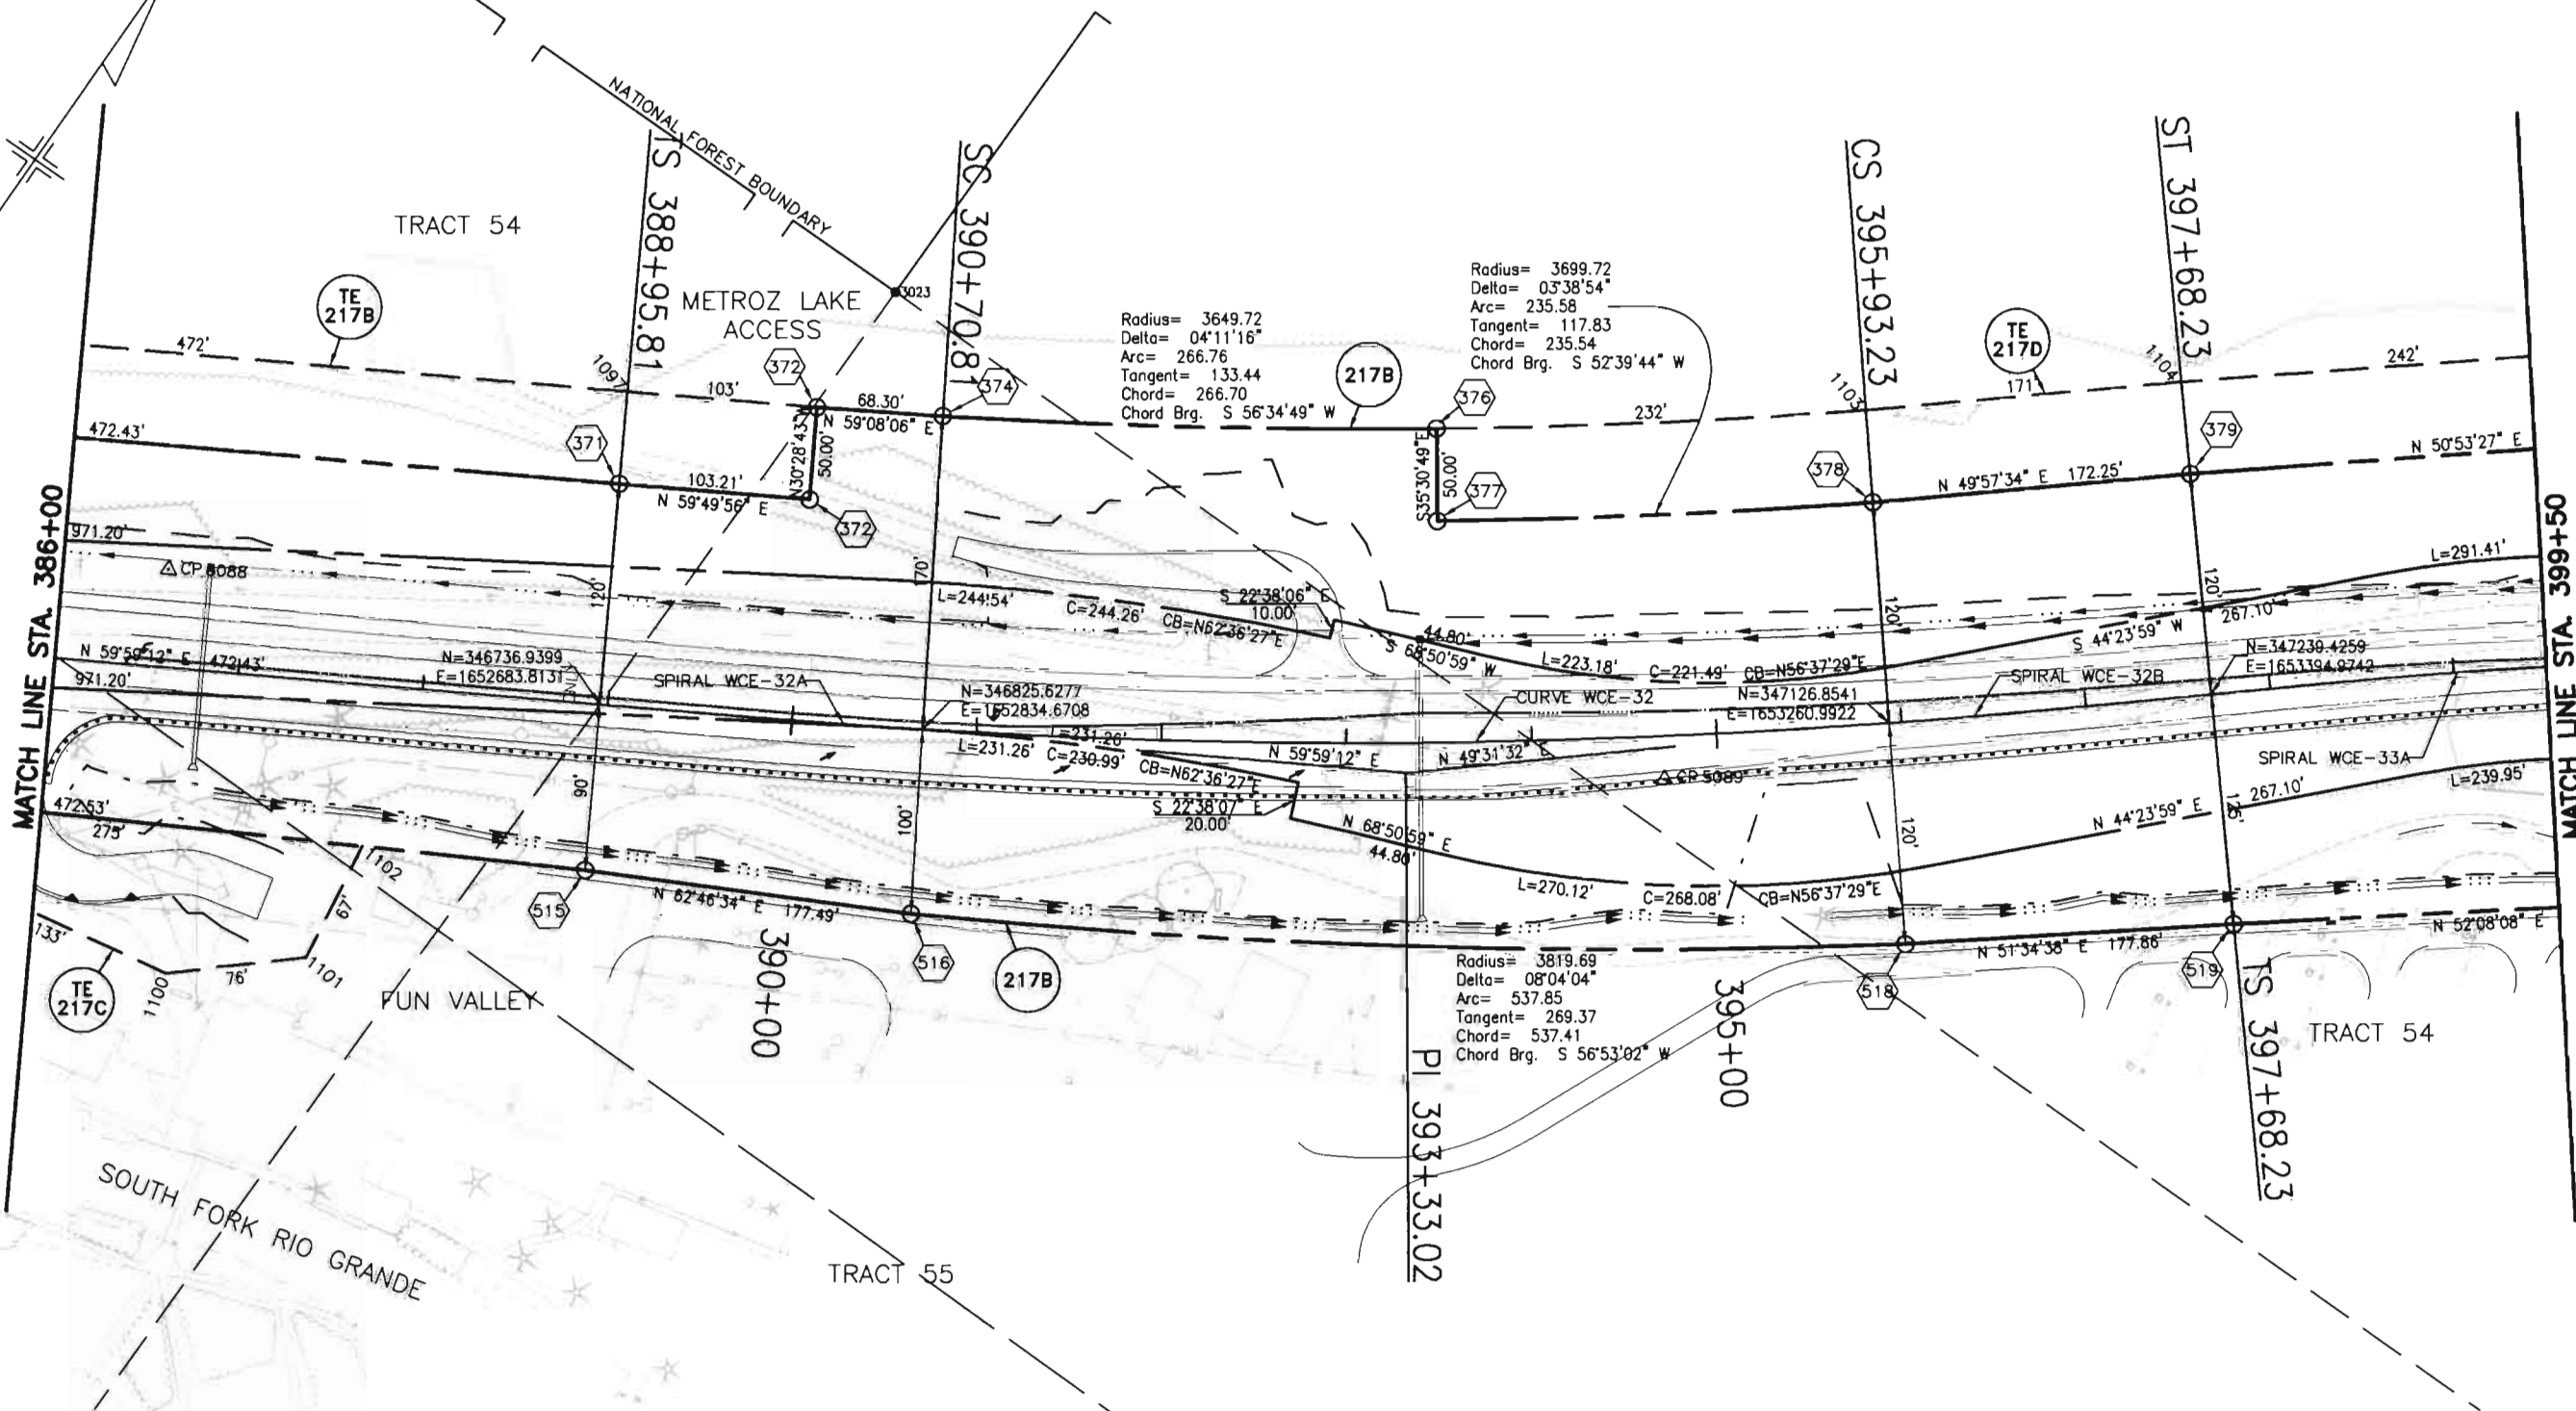

SPIRAL WCE-32A
Ls=175.000
Ang=1°18'45.0"
LT=116.670
ST=58.336

CURVE WCE-32
PI 393+33.02
D= 7°50'10.1"
R= 3819.720
Dc=1°30'00.0"
A= 522.410
C= 522.003

SPIRAL WCE-32B
Ls=175.000
Ang=1°18'45.0"
LT=116.670
ST=58.336

SPIRAL WCE-33A
Ls=230.000
Ang=4°01'30.0"
LT=153.373
ST=76.703

TE 217D
TE 217C
TE 217B
217B

FUN VALLEY INC.
BOOK 465 PAGE 257, BOOK 382 PAGE 894, BOOK 431 PAGE 317

Carter Burgess

DEPOSITED THIS DAY OF 11 AT J.L. FOR INFORMATION
ONLY IN BOOK OF THE COUNTY LAND SURVEYS/RIGHT OF WAY
SURVEYS AT PAGE RECEPTION NUMBER

0/0/0022\DWGS\ROW\PLAN\WCE25RP.DWG, 08/12/2002 10:52:39 AM

DEPT.

testamp

COLORADO DEPARTMENT OF TRANSPORTATION



Region 5
Address: 3803 North Main Avenue, Suite 300
Durango, Colorado 81301
Phone: (970) 385-1400 FAX: (970) 385-1410

Right of Way Plans Unit: Crumbaugh

Sheet Revisions

mm/yy	XXXXX	XXX

Sheet Revisions

mm/yy	XXXXX	XXX

Sheet Revisions

mm/yy	XXXXX	XXX


Right of Way Plans

Right of Way Plan Sheet

Project Number:	NH (CX)160-2(50) UNIT 2
Project Location:	WOLF CREEKPASS EAST
Project Code:	92977
Last Mod. Date	---
Subset Sheets	26 of 27
Sheet No.	31
Total No. of Sheets	49

Carter-Burgess

T.39 N, R.3 E, NMPM

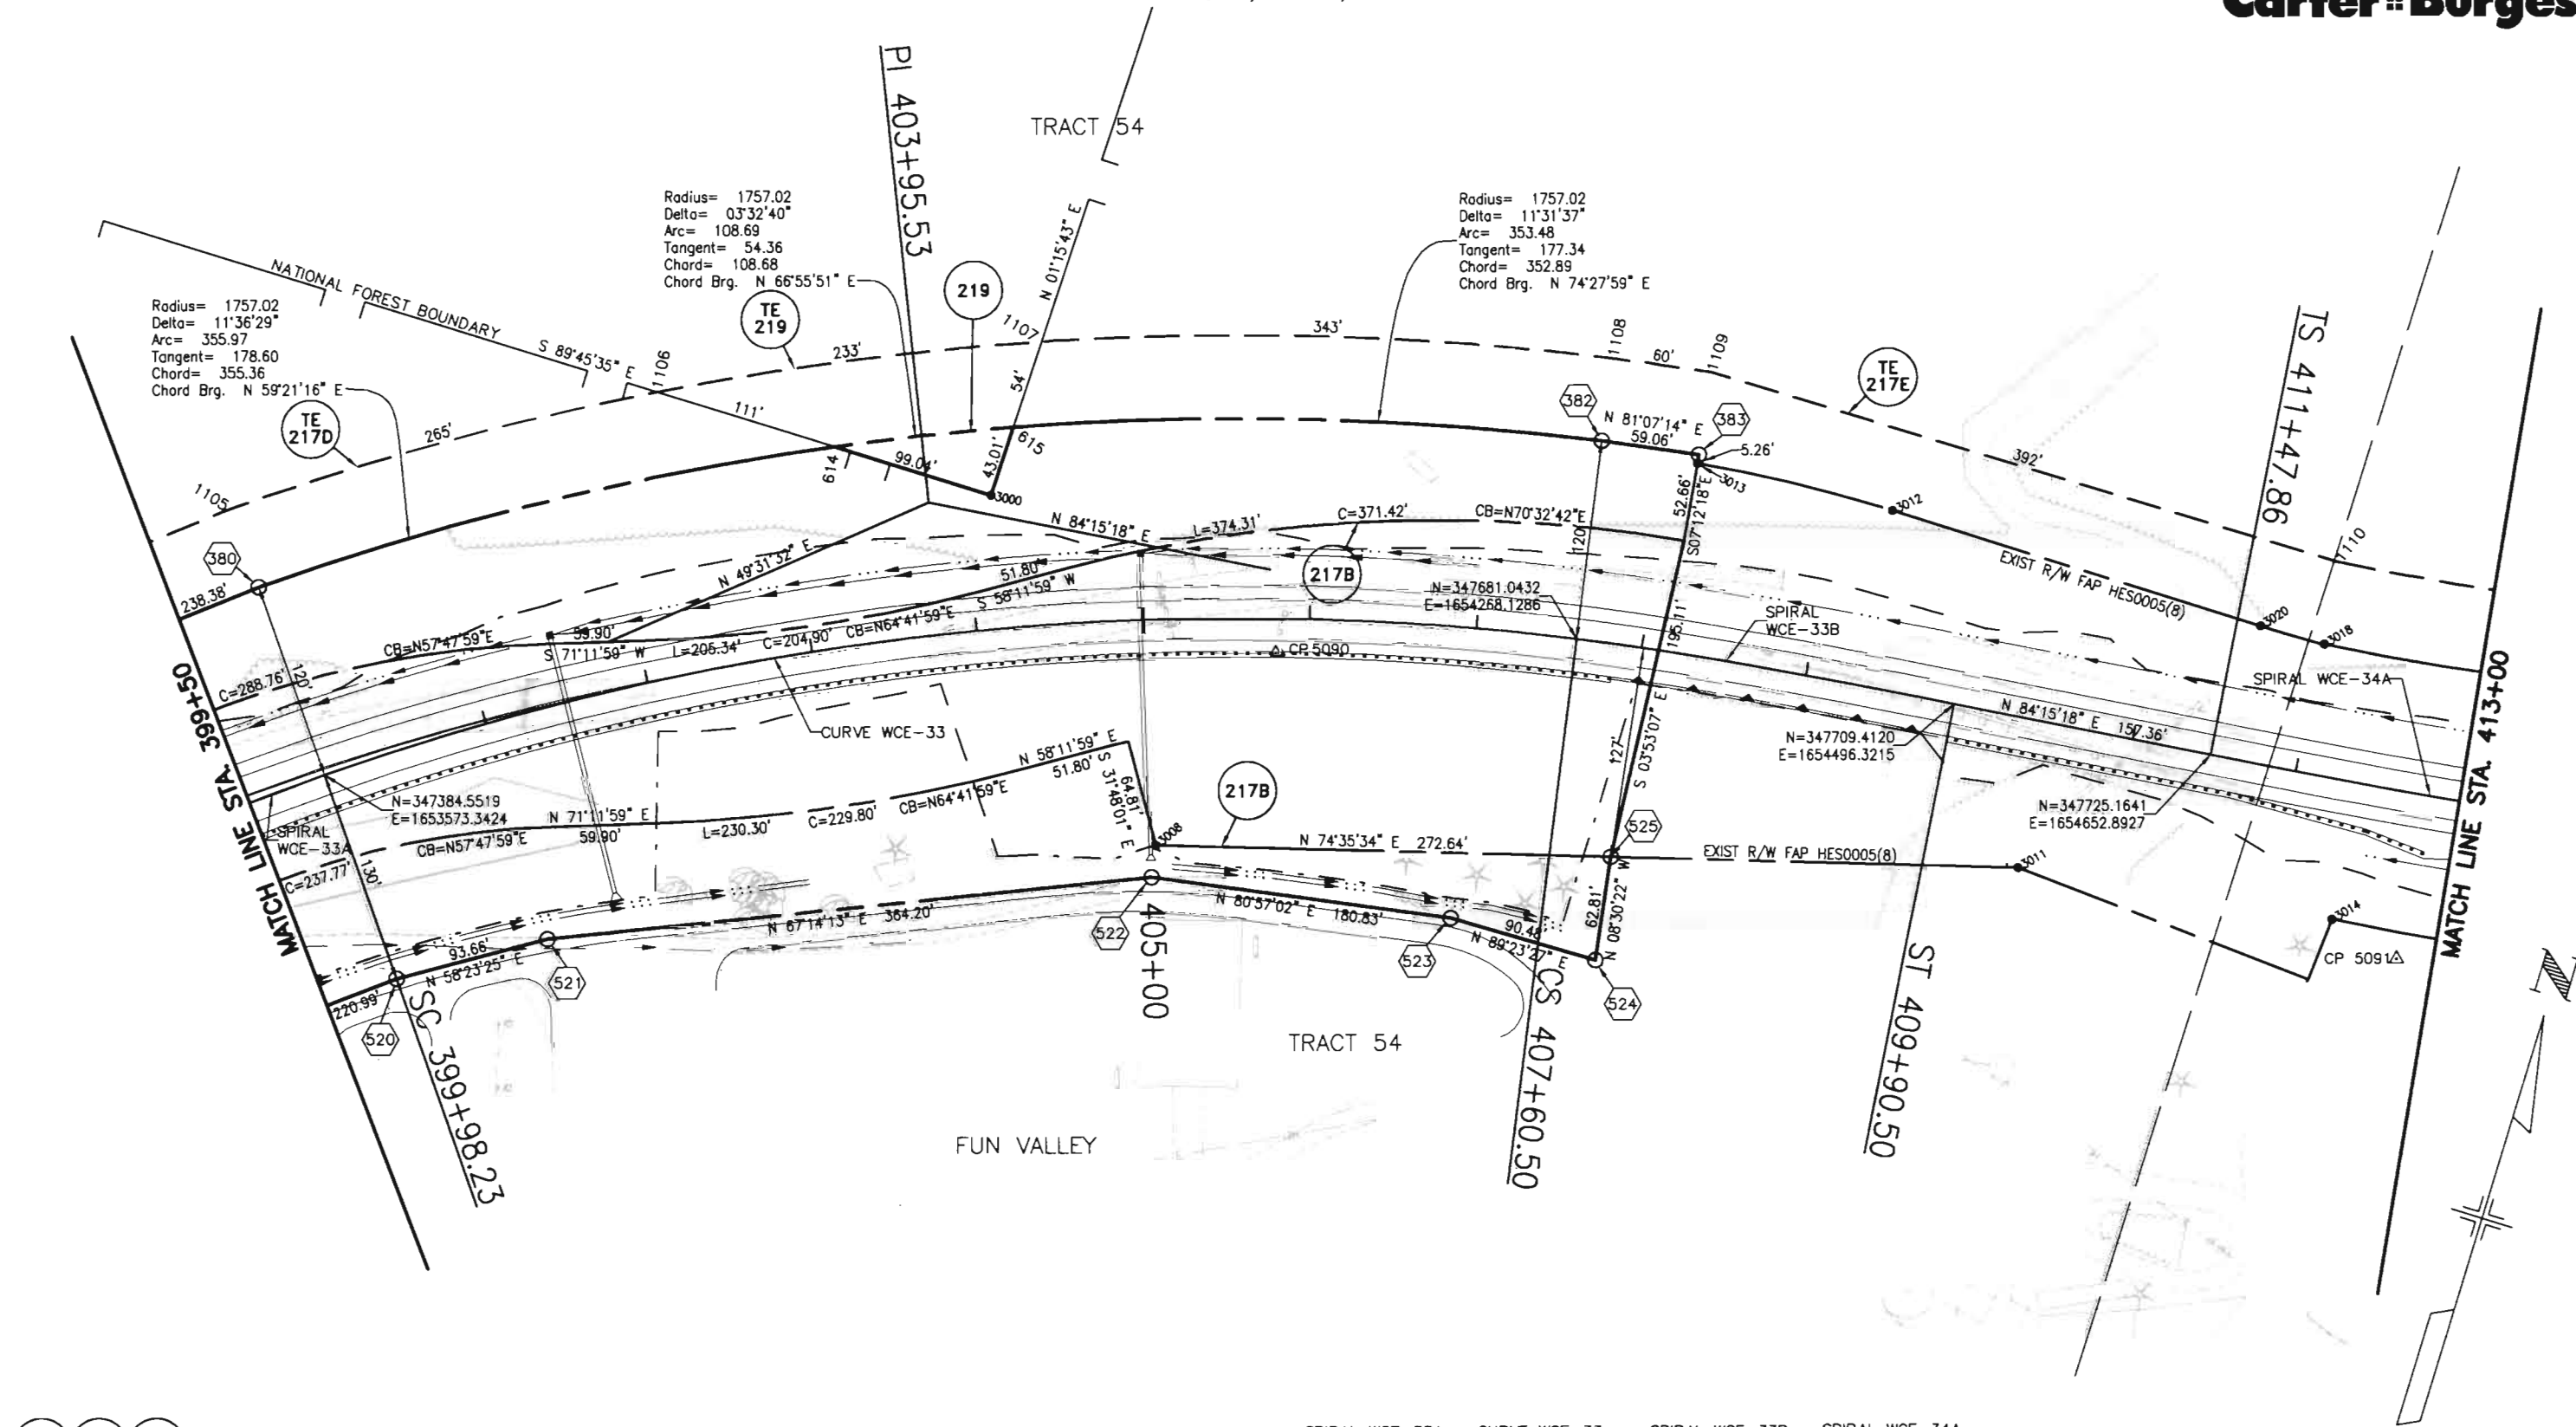


TE 217E TE 217D 217B FUN VALLEY INC.
BOOK 465 PAGE 257, BOOK 382 PAGE 894, BOOK 431 PAGE 317
TE 219 219 UNITED STATES FOREST SERVICE

SPIRAL WCE-33A
Ls=230.000
Ang=4°01'30.0"
LT=153.373
ST=76.703

CURVE WCE-33
PI 403+95.53
D= 26°40'46.2"
R= 1637.023
Dc=3°30'00.0"
A= 762.272
C= 755.404

SPIRAL WCE-33B
Ls=230.000
Ang=4°01'30.0"
LT=153.373
ST=76.703

 SPIRAL WCE-34A
Ls=240.000
Ang=4°30'00.0"
LT=160.052
ST=80.047



DEPOSITED THIS DAY OF 19 AT A.M. FOR INFORMATION
ONLY IN BOOK OF THE COUNTY LAND SURVEYS/RIGHT OF WAY
SURVEYS AT PAGE RECEPTION NUMBER

0/0022\DWGS\ROWPLAN\WCE26RF.DWG, 08/12/2002 10:54:11 AM

COLORADO DEPARTMENT OF TRANSPORTATION



Region 5
Address: 3803 North Main Avenue, Suite 300
Durango, Colorado 81301
Phone: (970) 385-1400 FAX: (970) 385-1410

Right of Way Plans Unit: Crumbaugh

Sheet Revisions

mm/yy	xxxxx	xxx

Sheet Revisions

mm/yy	xxxxx	xxx

Sheet Revisions

mm/yy	xxxxx	xxx

Right of Way Plans

Right of Way PlanSheet

Project Number:		NH (CX)160-2(50) UNIT 2		
Project Location:		WOLF CREEK PASS EAST		
Project Location:				
Project Code:	Last Mod. Date	Subset Sheets	Sheet No.	Total No. of Sheets
92977	---	27 of 27	32	49

T.39 N, R.3 E, NMPM

Carter-Burgess


REPORTED THIS DAY OF 12 AT 11:00 AM, FOR INFORMATION
ONLY IN BOOK OF THE COUNTY LAND SURVEYS/RIGHT OF WAY
SURVEYS AT PAGE REGISTRATION NUMBER

07/0022\DWG5\ROWPLAN\WCE2\RP.DWG, 08/12/2002 10:55:57 AM

cdstamp



FUN VALLEY INC.
BOOK 465 PAGE 257,BOOK 382 PAGE 894,BOOK 431 PAGE 317

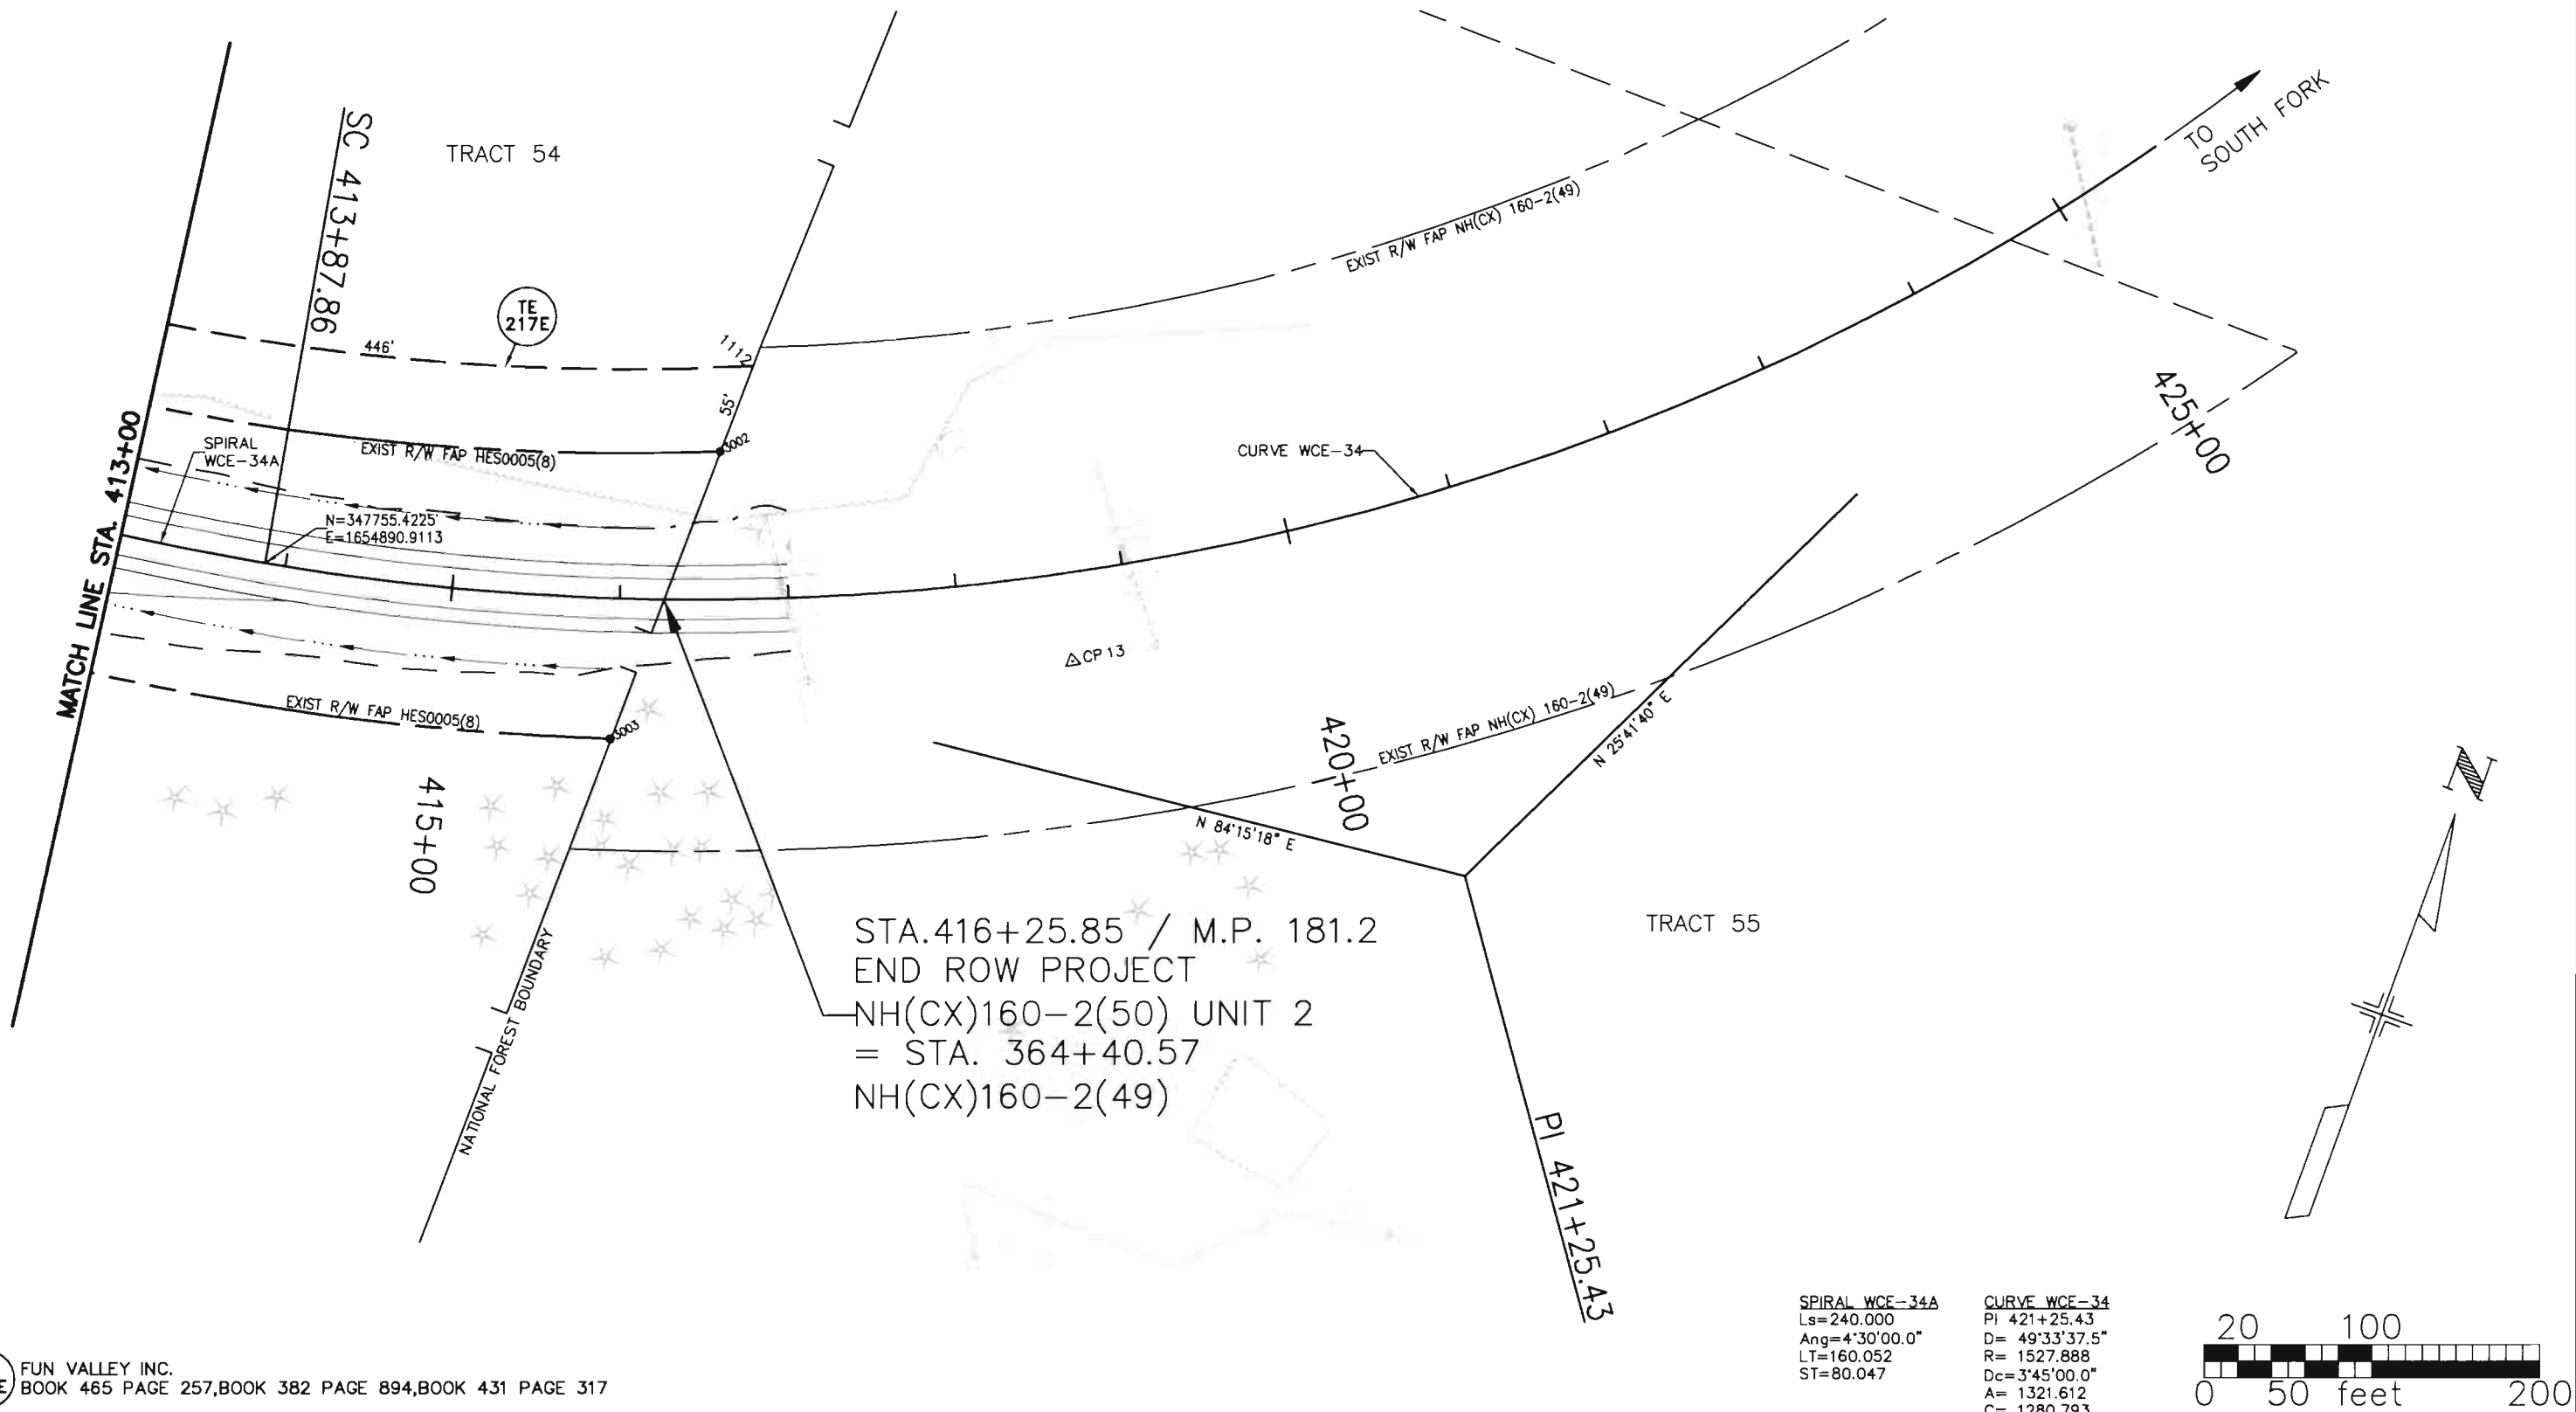

COLORADO DEPARTMENT OF TRANSPORTATION



Region 5
Address: 3803 North Main Avenue, Suite 300
Durango, Colorado 81301
Phone: (970) 385-1400 FAX: (970) 385-1410

Right of Way Plans Unit: Crumbaugh

Sheet Revisions

mm/yy	xxxxx	xxx

Sheet Revisions

mm/yy	xxxxx	xxx

Sheet Revisions

mm/yy	xxxxx	xxx

Right of Way Plans



Ownership Map Cover and Index Sheet

Project Number:		NH (CX)160-2(50) UNIT 2		
Project Location:		WOLF CREEK PASS EAST		
Project Location:				
Project Code:	Last Mod. Date	Subset Sheets	Sheet No.	Total No. of Sheets
92977	---	1 of 18	33	49

CONVENTIONAL SIGNS

COUNTY LINE
TOWNSHIP OR RANGE LINE
LAND LINES SECTION LINE 1/4 SECTION LINE 1/16 SECTION LINE
PROPERTY OR TRACT LINE
RAILROAD
EXISTING ROAD
NEW ROAD
CONTROL OF ACCESS
ACCESS DENIED BY DEED
RIGHT OF WAY LINE-EXISTING
RIGHT OF WAY LINE-PROPOSED

- FOUND USFS MONUMENT
- FOUND STONE
- FOUND PIN & CAP
- FOUND IRON PIPE
- FOUND ALIQUOT CORNER
- FOUND BLM MONUMENT
- FOUND GLO MONUMENT

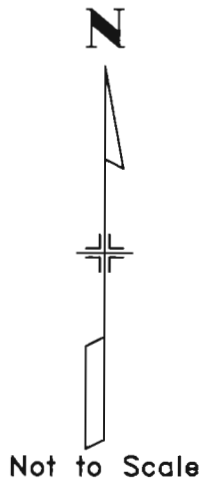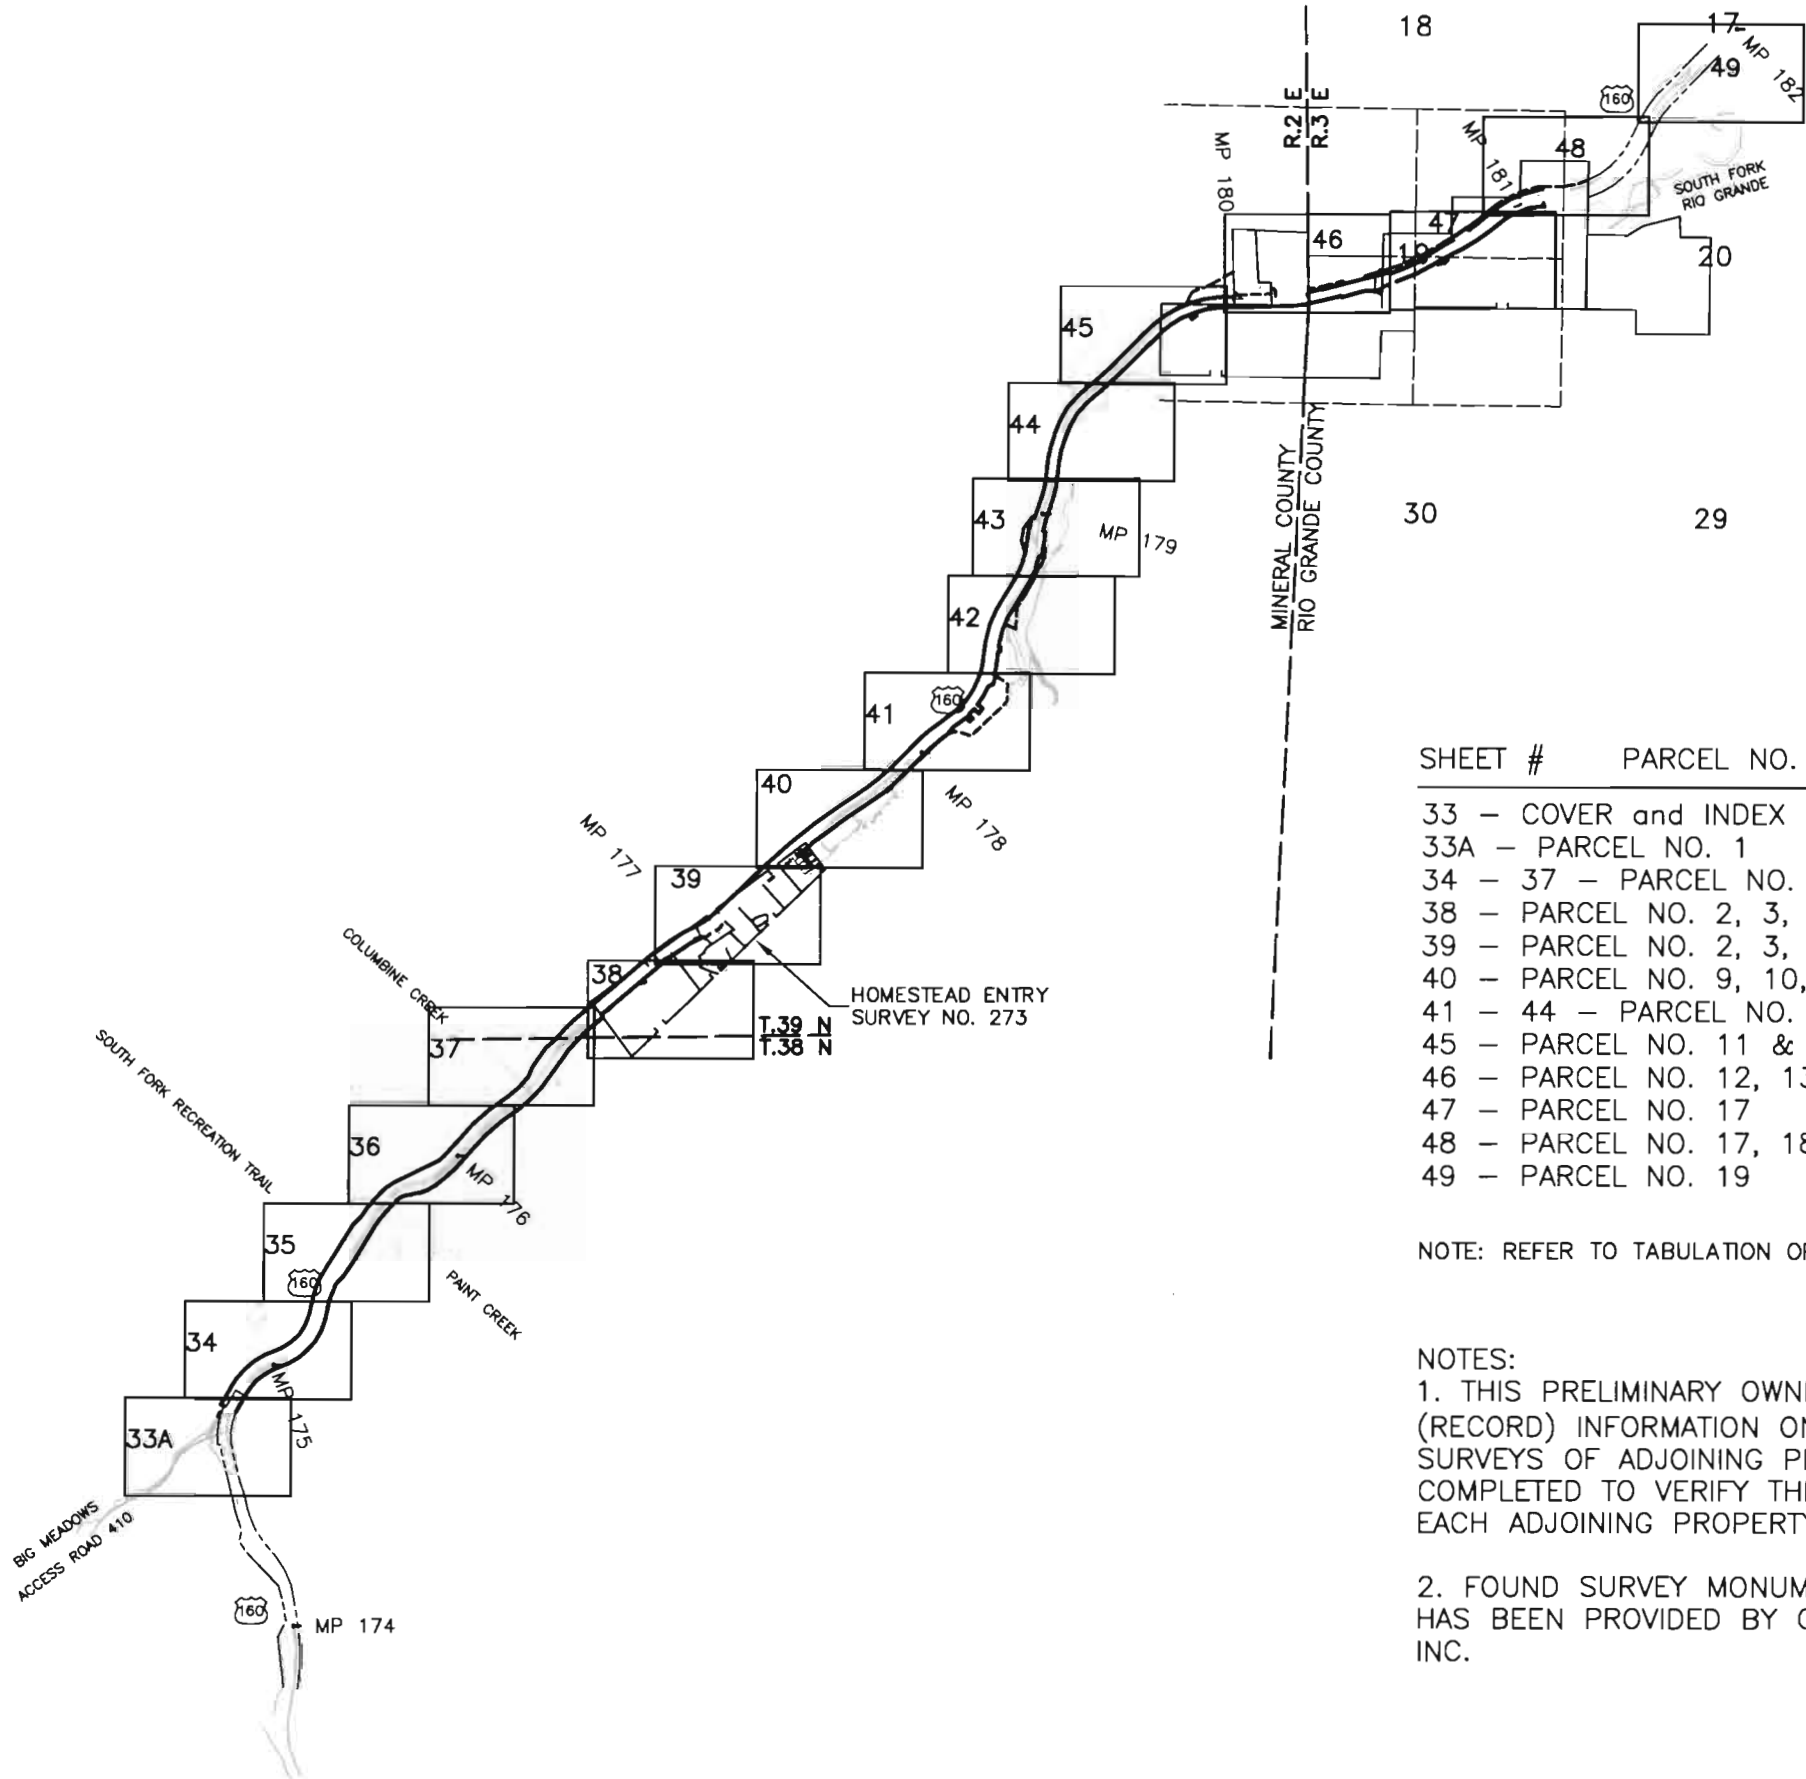

SHEET #	PARCEL NO.
33	COVER and INDEX
33A	PARCEL NO. 1
34	37 - PARCEL NO. 1
38	PARCEL NO. 2, 3, & 4
39	PARCEL NO. 2, 3, 4, 5, 6, 7, 8, & 9
40	PARCEL NO. 9, 10, & 11
41	44 - PARCEL NO. 11
45	PARCEL NO. 11 & 12
46	PARCEL NO. 12, 13, 14, 15, 16, & 17
47	PARCEL NO. 17
48	PARCEL NO. 17, 18, & 19
49	PARCEL NO. 19

NOTE: REFER TO TABULATION OF PROPERTIES FOR NAMES AND ADDRESSES

NOTES:
1. THIS PRELIMINARY OWNERSHIP MAP IS BASED ON TITLE (RECORD) INFORMATION ONLY. INDIVIDUAL BOUNDARY SURVEYS OF ADJOINING PROPERTIES HAVE NOT BEEN COMPLETED TO VERIFY THE GRAPHIC REPRESENTATION OF EACH ADJOINING PROPERTY SHOWN HEREON.

2. FOUND SURVEY MONUMENT INFORMATION SHOWN HEREON HAS BEEN PROVIDED BY GOFF ENGINEERING & SURVEYING, INC.



COLORADO DEPARTMENT OF TRANSPORTATION

Region 5
Address: 3803 North Main Avenue, Suite 300
Ourango, Colorado 81301
Phone: (970) 385-1400 FAX: (970) 385-1410

Right of Way Plans Unit: Crumbaugh


Sheet Revisions		
mm/yy	XXXXX	XXX

Sheet Revisions		
mm/yy	XXXXX	XXX

Sheet Revisions		
mm/yy	XXXXX	XXX

Right of Way Plans				
Ownership Map				
Project Number:		NH (CX)160-2(50) UNIT 2		
Project Location:		WOLF CREEK PASS EAST		
Project Location:				
Project Code:	Last Mod. Date	Subset Sheets	Sheet No.	Total No. of Sheets
92977	---	2 of 18	33A	49

T.38 N, R.2 E, NMPM

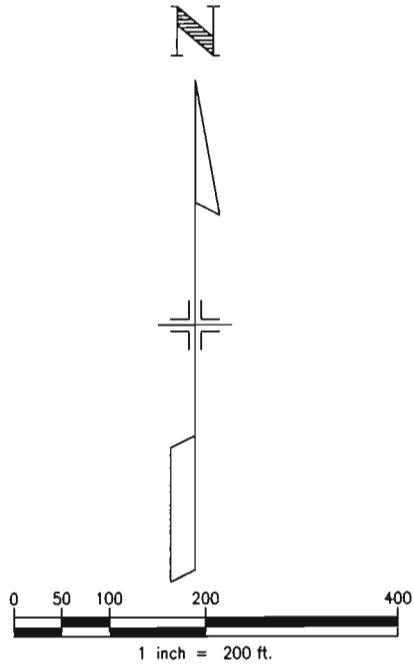

(201)
USFS

BIG MEADOWS ACCESS ROAD 410

SOUTH FORK RIO GRANDE

PASS CREEK

(201)
USFS

EXISTING R/W FAP NH(CX)160-2(50) UNIT 1

(201)
USFS

240'

200'

DEPOSITED THIS ____ DAY OF ____ 18__ AT ____ A.M. FOR INFORMATION
ONLY IN BOOK ____ OF THE COUNTY LAND SURVEYS/RIGHT OF WAY
SURVEYS AT PAGE ____ RECEPTION NUMBER ____

0/00022\DWG\OWNERMAP\OWNR02.DWG, 08/12/2002 11:52:40 AM
testamp

COLORADO DEPARTMENT OF TRANSPORTATION



Region 5
Address: 3803 North Main Avenue, Suite 300
Durango, Colorado 81301
Phone: (970) 385-1400 FAX: (970) 385-1410

Right of Way Plans Unit: Crumbaugh


Sheet Revisions		
mm/yy	xxxxx	xxx

Sheet Revisions		
mm/yy	xxxxx	xxx

Sheet Revisions		
mm/yy	xxxxx	xxx

Right of Way Plans				
Ownership Map				
Project Number:		NH (CX)160-2(50) UNIT 2		
Project Location:		WOLF CREEK PASS EAST		
Project Location:				
Project Code:	Last Mod. Date	Subset Sheets	Sheet No.	Total No. of Sheets
92977	---	3 of 18	34	49

T.38 N, R.2 E, NMPM

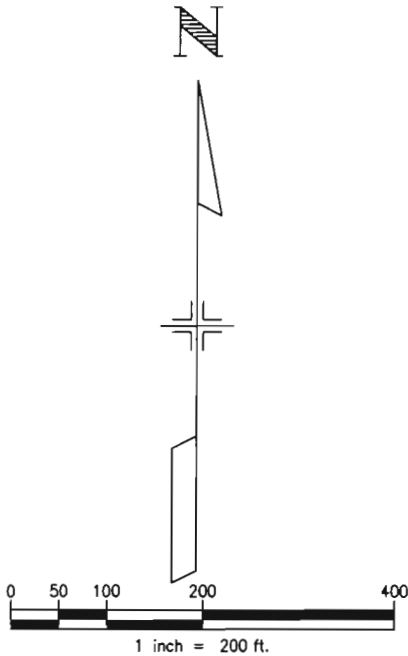

(201)
USFS

MP 175

(201)
USFS

SOUTH

FORK

RIQ

GRANDE

300'

DEPOSITED THIS DAY OF 19 AT FOR INFORMATION
ONLY IN BOOK OF THE COUNTY LAND SURVEYS/RIGHT OF WAY
SURVEYS AT PAGE RECEPTION NUMBER

SIGNED DEPT.

\\0/0022\DWG\OWNER\MAP\OWNING\DWG, 08/12/2002 11:53:05 AM

stestomp

COLORADO DEPARTMENT OF TRANSPORTATION



Region 5
Address: 3803 North Main Avenue, Suite 300
Durango, Colorado 81301
Phone: (970) 385-1400 FAX: (970) 385-1410

Right of Way Plans Unit: Crumbaugh

Sheet Revisions

mm/yy	xxxxx	xxx

Sheet Revisions

mm/yy	xxxxx	xxx

Sheet Revisions

mm/yy	xxxxx	xxx

Right of Way Plans

Ownership Map

Project Number:		NH (CX)160-2(50) UNIT 2		
Project Location:		WOLF CREEK PASS EAST		
Project Location:				
Project Code:	Last Mod. Date	Subset Sheets	Sheet No.	Total No. of Sheets
92977	---	4 of 18	35	49

T.38 N, R.2 E, NMPM

SOUTH FORK
RECREATIONAL TRAIL

(201)
USFS

 
PAINT CREEK

350'
GRANDE
RIO
FORK

(201)
USFS

300'

N



DEPOSITED THIS ____ DAY OF ____ 19__ AT ____ M., FOR INFORMATION
ONLY IN BOOK ____ OF THE COUNTY LAND SURVEYS/RIGHT OF WAY
SURVEYS AT PAGE ____ RECEPTION NUMBER ____

RECEIVED
DEPT.

\\0/0022\DWGS\OWNERMAP\OWNR04.DWG, 08/12/2002 11:53:32 AM
teststamp

COLORADO DEPARTMENT OF TRANSPORTATION



Region 5
Address: 3803 North Main Avenue, Suite 300
Durango, Colorado 81301
Phone: (970) 385-1400 FAX: (970) 385-1410

Right of Way Plans Unit: Crumbaugh

Sheet Revisions

mm/yy	XXXXX	XXX

Sheet Revisions

mm/yy	XXXXX	XXX

Sheet Revisions

mm/yy	XXXXX	XXX

Right of Way Plans

Ownership Map

Project Number:

NH (CX)160-2(50) UNIT 2

Project Location:



WOLF CREEK PASS EAST

Project Location:

Project Code:	Last Mod. Date	Subset Sheets	Sheet No.	Total No. of Sheets
92977	---	5 of 18	36	49

T.38 N, R.2 E, NMPM

 N

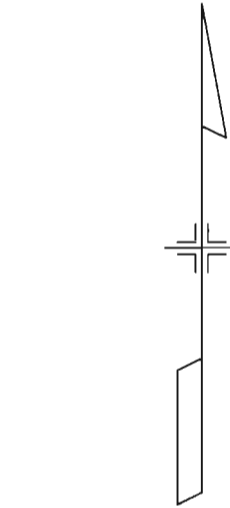

(201)
USFS

MP 176

GRANDE

RIO

FORK

SOUTH

(201)
USFS

300'

COLORADO DEPARTMENT OF TRANSPORTATION



Region 5
Address: 3803 North Main Avenue, Suite 300
Durango, Colorado 81301
Phone: (970) 385-1400 FAX: (970) 385-1410

Right of Way Plans Unit: Crumbaugh

Sheet Revisions

mm/yy	xxxxx	xxx

Sheet Revisions

mm/yy	xxxxx	xxx

Sheet Revisions


mm/yy	xxxxx	xxx

Right of Way Plans

Ownership Map

Project Number:		NH (CX)160-2(50) UNIT 2			
Project Location:		WOLF CREEK PASS EAST			
Project Location:					
Project Code:	Last Mod. Date	Subset Sheets	Sheet No.	Total No. of Sheets	
92977	---	6 of 18	37	49	

 T.39 N, R.2 E, NMPM



(201)
USFS

COLUMBINE CREEK

T.39 N
T.38 N

350'

300'

SOUTH FORK RIO GRANDE

(201)
USFS

300'

T.38 N, R.2 E, NMPM

Carter-Burgess

COLORADO DEPARTMENT OF TRANSPORTATION



Region 5
Address: 3803 North Main Avenue, Suite 300
Durango, Colorado 81301
Phone: (970) 385-1400 FAX: (970) 385-1410

Right of Way Plans Unit: Crumbaugh

Sheet Revisions

mm/yy	XXXXX	XXX

Sheet Revisions

mm/yy	XXXXX	XXX

Sheet Revisions


mm/yy	XXXXX	XXX

Right of Way Plans

Ownership Map

Project Number:	NH (CX)160-2(50) UNIT 2
Project Location:	WOLF CREEK PASS EAST
Project Code:	92977
Last Mod. Date:	---
Subset Sheets:	7 of 18
Sheet No.:	38
Total No. of Sheets:	49

T.39 N, R.2 E, NMPM

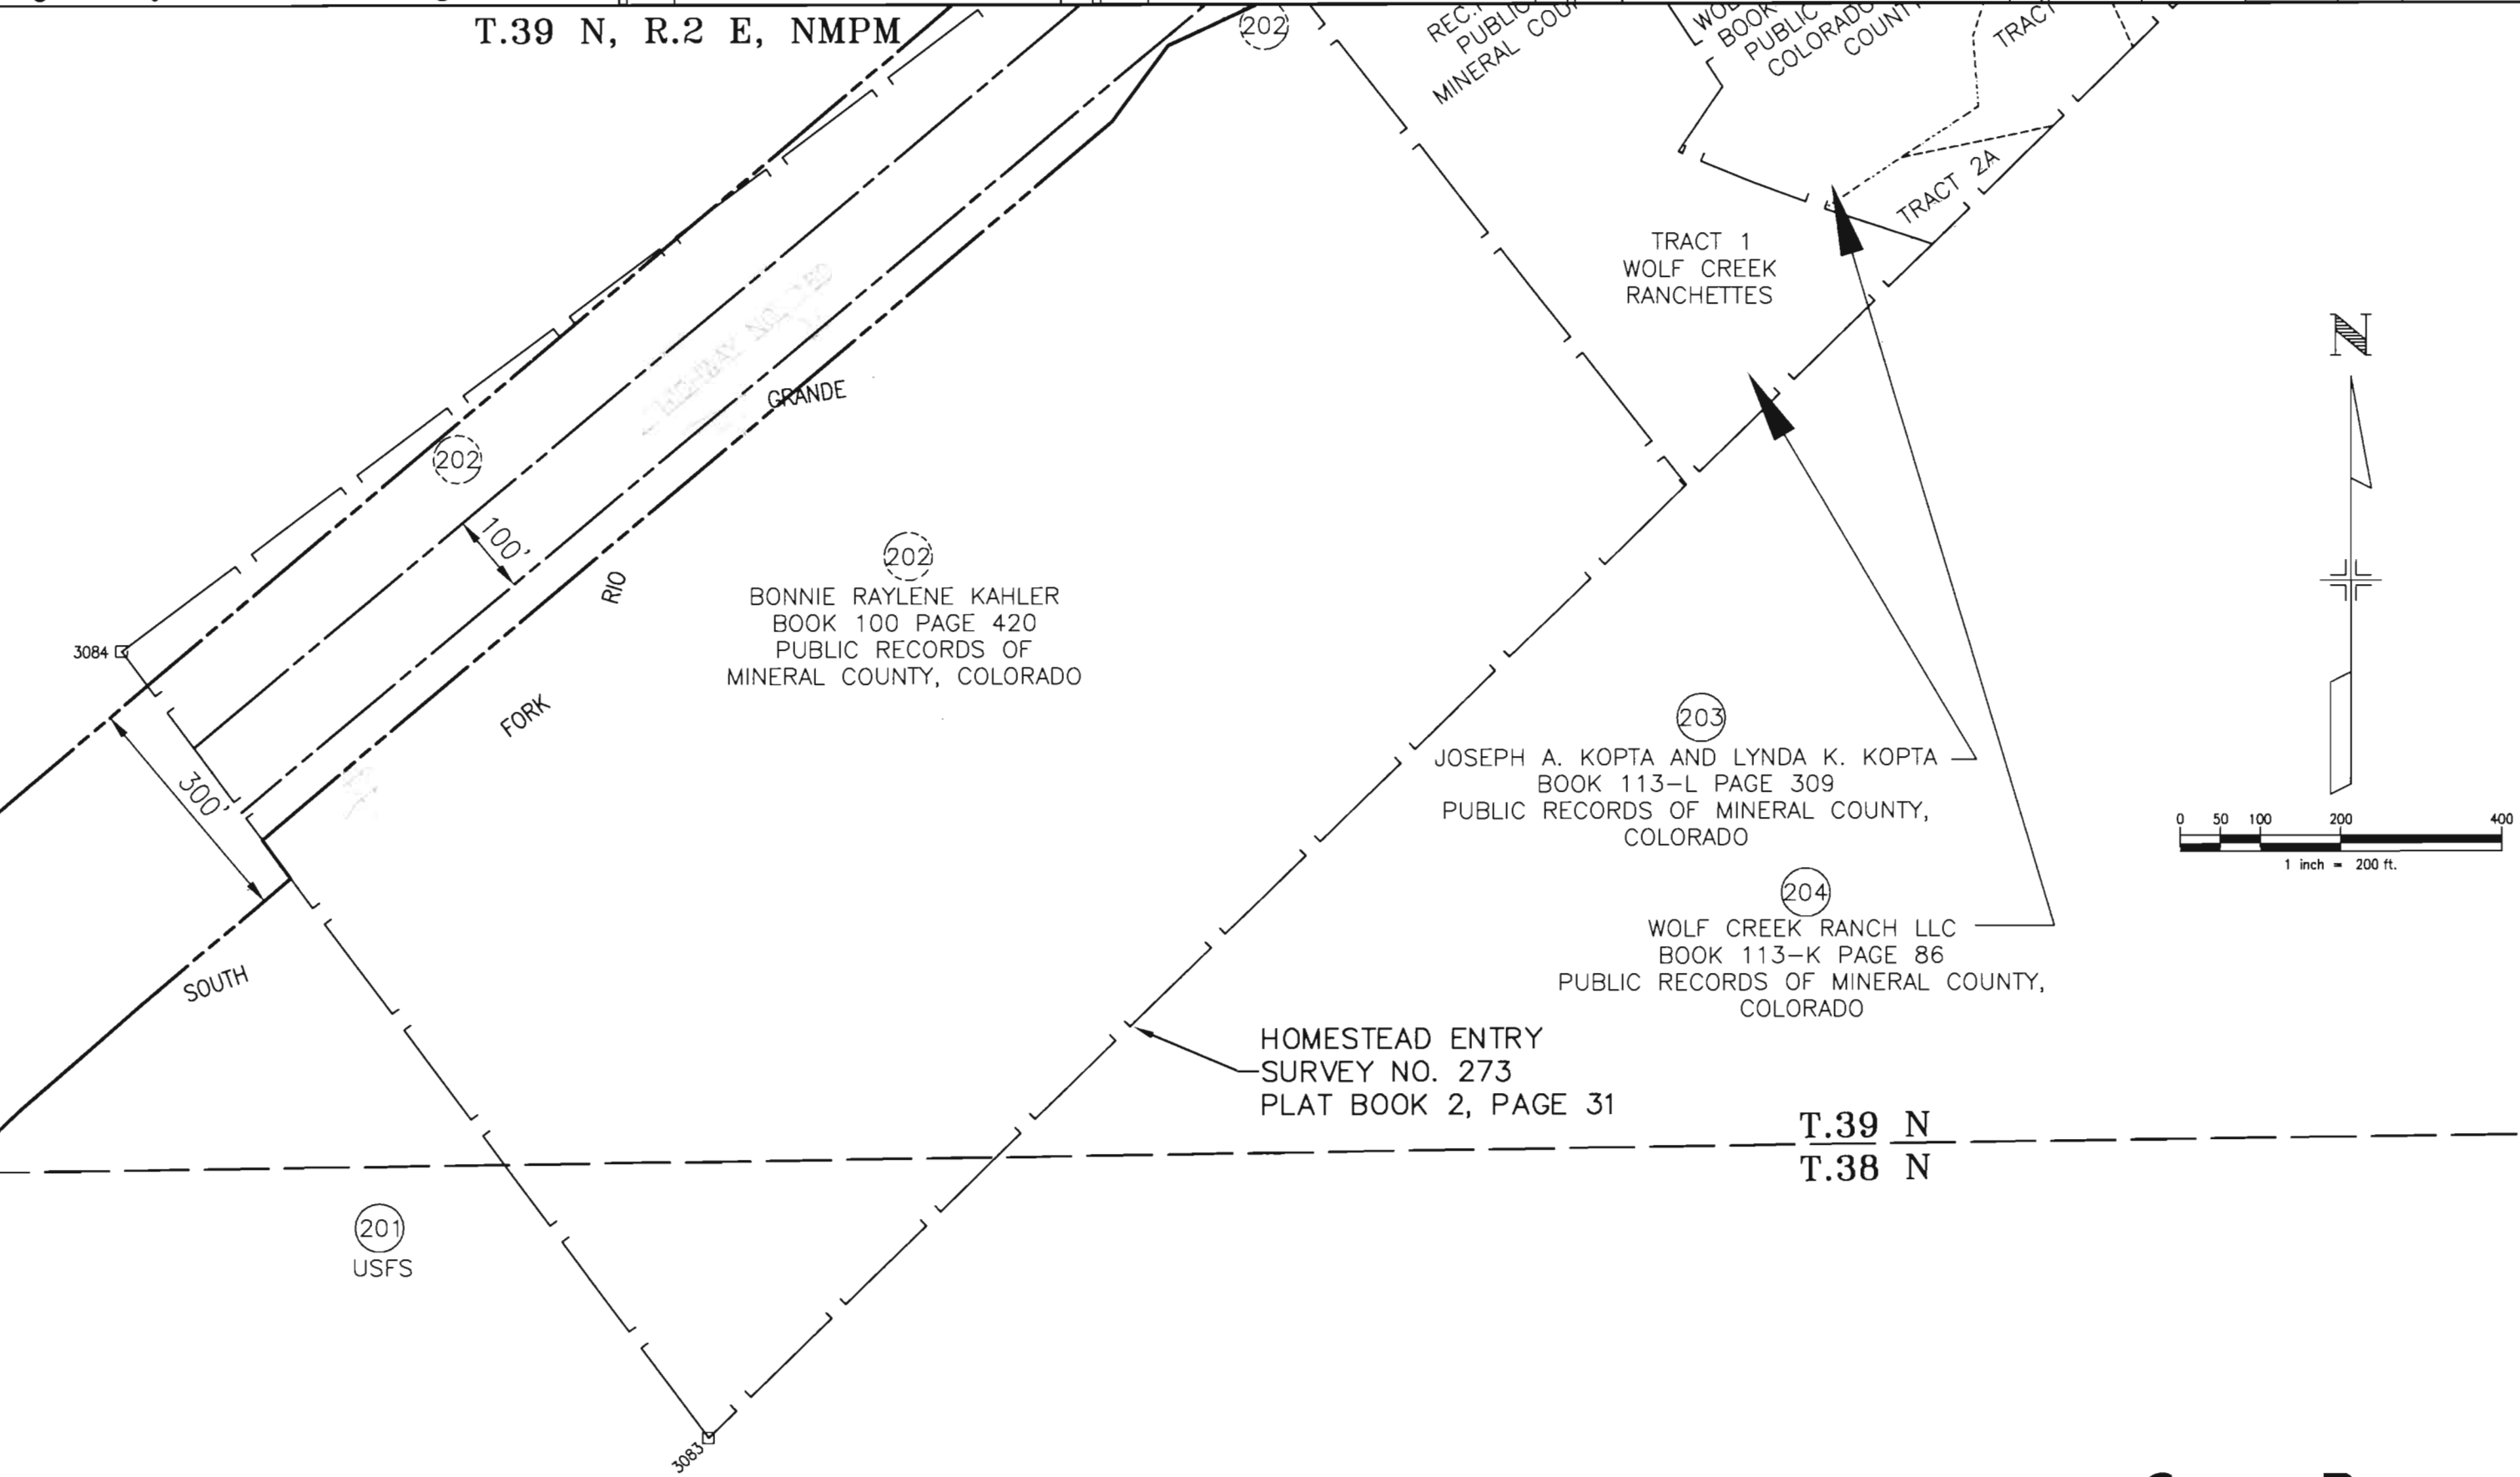

T.38 N, R.2 E, NMPM

Carter Burgess

DEPOSITED THIS 18 DAY OF 18 AT 11:54:43 AM
ONLY IN BOOK OF THE COUNTY LAND SURVEYS/RIGHT OF WAY
SURVEYS AT PAGE RECEPTION NUMBER

\\070022\DWGS\OWNERS\OWNR\DWG. 08/12/2002 11:54:43 AM

testamp

COLORADO DEPARTMENT OF TRANSPORTATION



Region 5
Address: 3803 North Main Avenue, Suite 300
Durango, Colorado 81301
Phone: (970) 385-1400 FAX: (970) 385-1410

Right of Way Plans Unit: Crumbaugh

Sheet Revisions

mm/yy	xxxxx	xxx

Sheet Revisions

mm/yy	xxxxx	xxx

Sheet Revisions

mm/yy	xxxxx	xxx


Right of Way Plans

Ownership Map

Project Number:	NH (CX)160-2(50) UNIT 2
Project Location:	WOLF CREEK PASS EAST
Project Location:	
Project Code:	92977
Last Mod. Date	---
Subset Sheets	8 of 18
Sheet No.	39
Total No. of Sheets	49

T.39 N, R.2 E, NMPM

 N



40' ACCESS
EASEMENT
REC. NO. 55799

20' ACCESS
EASEMENT
REC. NO. 41740

40' ACCESS
EASEMENT
REC. NO. 41740

(220)
USFS

WOLFCREEK WILDERNESS
CABINS, LLC
REC. NO. 59605 9/19/01
PUBLIC RECORDS OF
MINERAL COUNTY, COLORADO

WOLF CREEK RANCH LLC
BOOK 113-K PAGE 86
PUBLIC RECORDS OF
COLORADO MINERAL
COUNTY

60' ACCESS
EASEMENT
REC. NO. 55799

60' ACCESS
EASEMENT
REC. NO. 55799

TRACT 4
WOLF CREEK
RANCHETTES

(207)
EDWARD J. KOPTA
JULIA L. KOPTA
BOOK 113-L PAGE 329
PUBLIC RECORDS OF
MINERAL COUNTY,
COLORADO

TRACT 6
WOLF CREEK RANCHETTES

(208)
ALICE S. LENICH LIVING
TRUST
BOOK 113-L PAGE 333
PUBLIC RECORDS OF
MINERAL COUNTY, COLORADO

(209)
STEVEN S. PATTON
VALERIE L. PATTON
BOOK 113-L PAGE 337
PUBLIC RECORDS OF
MINERAL COUNTY,
COLORADO

HOMESTEAD ENTRY
SURVEY NO. 273

(206)
Brock E. Schnebel, Trustee of the Brock E. Schnebel
1999 Trust under Agreement dated August 24, 1999
& Kelli R. Schnebel, Trustee of the Kelli R. Schnebel
1999 Trust under Agreement dated August 24, 1999,
BOOK xxxx PAGE xxxx
PUBLIC RECORDS OF MINERAL COUNTY, COLORADO

20' ACCESS
EASEMENT
REC. NO. 55799

(205)
JAMES E. BURNS & LINDA N. BURNS
BOOK 112-K PAGE 331
PUBLIC RECORDS OF MINERAL COUNTY,
COLORADO

TRACT 3
TRACT 2B

TRACT 3

TRACT 2B

2A

Carter Burgess

COLORADO DEPARTMENT OF TRANSPORTATION



Region 5
Address: 3803 North Main Avenue, Suite 300
Durango, Colorado 81301
Phone: (970) 385-1400 FAX: (970) 385-1410

Right of Way Plans Unit: Crumbaugh

Sheet Revisions

mm/yy	xxxxx	xxx

Sheet Revisions

mm/yy	xxxxx	xxx

Sheet Revisions


mm/yy	xxxxx	xxx

Right of Way Plans

Ownership Map

Project Number:		NH (CX)160-2(50) UNIT 2		
Project Location:		WOLF CREEK PASS EAST		
Project Location:				
Project Code:	Last Mod. Date	Subset Sheets	Sheet No.	Total No. of Sheets
92977	10-12-00	9 of 18	40	49

 T.39 N, R.2 E, NMPM



(211)
USFS

250'

RIO
GRANDE
FORK

(211)
USFS

(210)

TERRY FULTON
TANA FULTON
BOOK 102 PAGE 435
PUBLIC RECORDS OF
MINERAL COUNTY,
COLORADO

60' ACCESS
EASEMENT
REC. NO. 55799

TRACT 7
WOLF CREEK RANCHETTES

WOLF CREEK RANCH
DEVELOPMENT

SOUTH

HOMESTEAD ENTRY
SURVEY NO. 273

3119

(209)

STEVEN S. PATTON
VALERIE PATTON

3120

Carter Burgess

DEPOSITED THIS 18th DAY OF 2002 AT 11:55:39 AM
ONLY IN BOOK OF THE COUNTY LAND SURVEYS/RIGHT OF WAY
SURVEYS AT PAGE RECEPTION NUMBER

SIGNED

DEPT.

K:\070022\DWGS\OWNRMAP\OWNR09.DWG, 08/12/2002 11:55:39 AM

datestamp

COLORADO DEPARTMENT OF TRANSPORTATION



Region 5
Address: 3803 North Main Avenue, Suite 300
Durango, Colorado 81301
Phone: (970) 385-1400 FAX: (970) 385-1410

Right of Way Plans Unit: Crumbaugh

Sheet Revisions

mm/yy	xxxxx	xxx

Sheet Revisions

mm/yy	xxxxx	xxx

Sheet Revisions

mm/yy	xxxxx	xxx



Right of Way Plans

Ownership Map

Project Number:	NH (CX)160-2(50) UNIT 2			
Project Location:	WOLF CREEK PASS EAST			
Project Location:				
Project Code:	Last Mod. Date	Subset Sheets	Sheet No.	Total No. of Sheets
92977	---	10 of 18	41	49

T.39 N, R.2 E, NMPM

  N



(211)
USFS

(211)
USFS

250'
SOUTH

FORK

RIO

GRANDE

MP 178

Carter Burgess

DEPOSITED THIS ____ DAY OF ____ 19__ AT ____ M., FOR INFORMATION
ONLY IN BOOK ____ OF THE COUNTY LAND SURVEYS/RIGHT OF WAY
SURVEYS AT PAGE ____, RECEPTION NUMBER ____

DRAWN BY ____
DEPT. ____

K:\070029\DWGS\OWNERSHIP\OWNR10.DWG, 08/12/2002 11:55:58 AM

dotstamp

COLORADO DEPARTMENT OF TRANSPORTATION



Region 5
Address: 3803 North Main Avenue, Suite 300
Durango, Colorado 81301
Phone: (970) 385-1400 FAX: (970) 385-1410

Right of Way Plans Unit: Crumbaugh

Sheet Revisions

mm/yy	xxxxx	xxx

Sheet Revisions

mm/yy	xxxxx	xxx

Sheet Revisions

mm/yy	xxxxx	xxx

Right of Way Plans

Ownership Map

Project Number:	NH (CX)160-2(50) UNIT 2			
Project Location:	WOLF CREEK PASS EAST			
Project Location:				
Project Code:	Last Mod. Date	Subset Sheets	Sheet No.	Total No. of Sheets
92977	---	11 of 18	42	49

T.39 N, R.2 E, NMPM



0 50 100 200 400
1 inch = 200 ft.

(211)
USFS

250'

PARK CREEK
CAMPGROUND

RIO

FORK

SOUTH

(211)
USFS

COLORADO DEPARTMENT OF TRANSPORTATION



Region 5
Address: 3803 North Main Avenue, Suite 300
Durango, Colorado 81301
Phone: (970) 385-1400 FAX: (970) 385-1410

Right of Way Plans Unit: Crumbaugh

Sheet Revisions

mm/yy	xxxxx	xxx

Sheet Revisions

mm/yy	xxxxx	xxx

Sheet Revisions

mm/yy	xxxxx	xxx


Right of Way Plans

Ownership Map

Project Number:	NH (CX)160-2(50) UN			
Project Location:	WOLF CREEK PASS EAST			
Project Location:				
Project Code:	Last Mod. Date	Subsct Sheets	Sheet No.	Total No. of Sheets
92977	---	12 of 18	43	49

T.39 N, R.2 E, NMPM

 N



(211)
USFS

MP 179

250'

200'

U.S. HIGHWAY 160

SOUTH FORK RIO GRANDE

(211)
USFS

COLORADO DEPARTMENT OF TRANSPORTATION



Region 5
Address: 3803 North Main Avenue, Suite 300
Durango, Colorado 81301
Phone: (970) 385-1400 FAX: (970) 385-1410

Right of Way Plans Unit: Crumbaugh

Sheet Revisions

mm/yy	xxxxx	xxx

Sheet Revisions

mm/yy	xxxxx	xxx

Sheet Revisions

mm/yy	xxxxx	xxx

Right of Way Plans

Ownership Map

Project Number:	NH (CX)160-2(50) UNIT 2			
Project Location:	WOLF CREEK PASS EAST			
Project Location:				
Project Code:	Last Mod. Date	Subset Sheets	Sheet No.	Total No. of Sheets
92977	---	13 of 18	44	49

T.39 N, R.2 E, NMPM

DECKER

CREEK

 
SOUTH FORK RIO GRANDE

(211)
USFS

(211)
USFS

200'

N



DEPOSITED THIS ____ DAY OF ____ AT ____ M., FOR INFORMATION
ONLY IN BOOK ____ OF THE COUNTY LAND SURVEYS/RIGHT OF WAY
SURVEYS AT PAGE ____ RECEPTION NUMBER ____

SIGNED _____
DOT.

K:\0\0002\DWGS\OWNER\MAIN\OWNR13.DWG, 08/12/2002 11:51:20 AM

datestamp

COLORADO DEPARTMENT OF TRANSPORTATION



Region 5
Address: 3803 North Main Avenue, Suite 300
Durango, Colorado 81301
Phone: (970) 385-1400 FAX: (970) 385-1410

Right of Way Plans Unit: Crumbaugh

Sheet Revisions

mm/yy	xxxxx	xxx

Sheet Revisions

mm/yy	xxxxx	xxx

Sheet Revisions

mm/yy	xxxxx	xxx

Right of Way Plans

Ownership Map

Project Number:	NH (CX)160-2(50) UNIT 2			
Project Location:	WOLF CREEK PASS EAST			
Project Location:				
Project Code:	Last Mod. Date	Subset Sheets	Sheet No.	Total No. of Sheets
92977	---	14 of 18	45	49

 
T.39 N, R.2 E, NMPM

DEPOSITED THIS ____ DAY OF ____ 19__ AT ____ A.M. FOR INFORMATION
ONLY IN BOOK ____ OF THE COUNTY LAND SURVEYS/RIGHT OF WAY
SURVEYS AT PAGE ____ RECEPTION NUMBER ____

SIGNED
DOT.

K:\0\0022\DWGS\OWNERMAP\OWNR14.DWG, 08/19/2002 08:39:01 AM

dotstamp



(211)
USFS

(212)

(212)
ROBERT E. CROSS
BOOK 104 PAGE 74
PUBLIC RECORDS OF
MINERAL COUNTY, COLORADO

TRACT 40

(211)
USFS

SOUTH FORK

RIO GRANDE

30370

31370

Carter-Burgess

COLORADO DEPARTMENT OF TRANSPORTATION



Region 5
Address: 3803 North Main Avenue, Suite 300
Durango, Colorado 81301
Phone: (970) 385-1400 FAX: (970) 385-1410

Right of Way Plans Unit: Crumbaugh

Sheet Revisions

mm/yy	xxxxx	xxx

Sheet Revisions

mm/yy	xxxxx	xxx

Sheet Revisions

mm/yy	xxxxx	xxx

Right of Way Plans


Ownership Map

Project Number:	NH (CX)160-2(50) UNIT 2				
Project Location:	WOLF CREEK PASS EAST				
Project Location:					
Project Code:	Last Mod. Date	Subset Sheets	Sheet No.	Total No. of Sheets	
92977	---	15 of 18	46	49	


T.39 N, R.2 E, NMPM

T.39 N, R.3 E, NMPM

 MINERAL COUNTY
RIO GRANDE COUNTY



SECTION 19

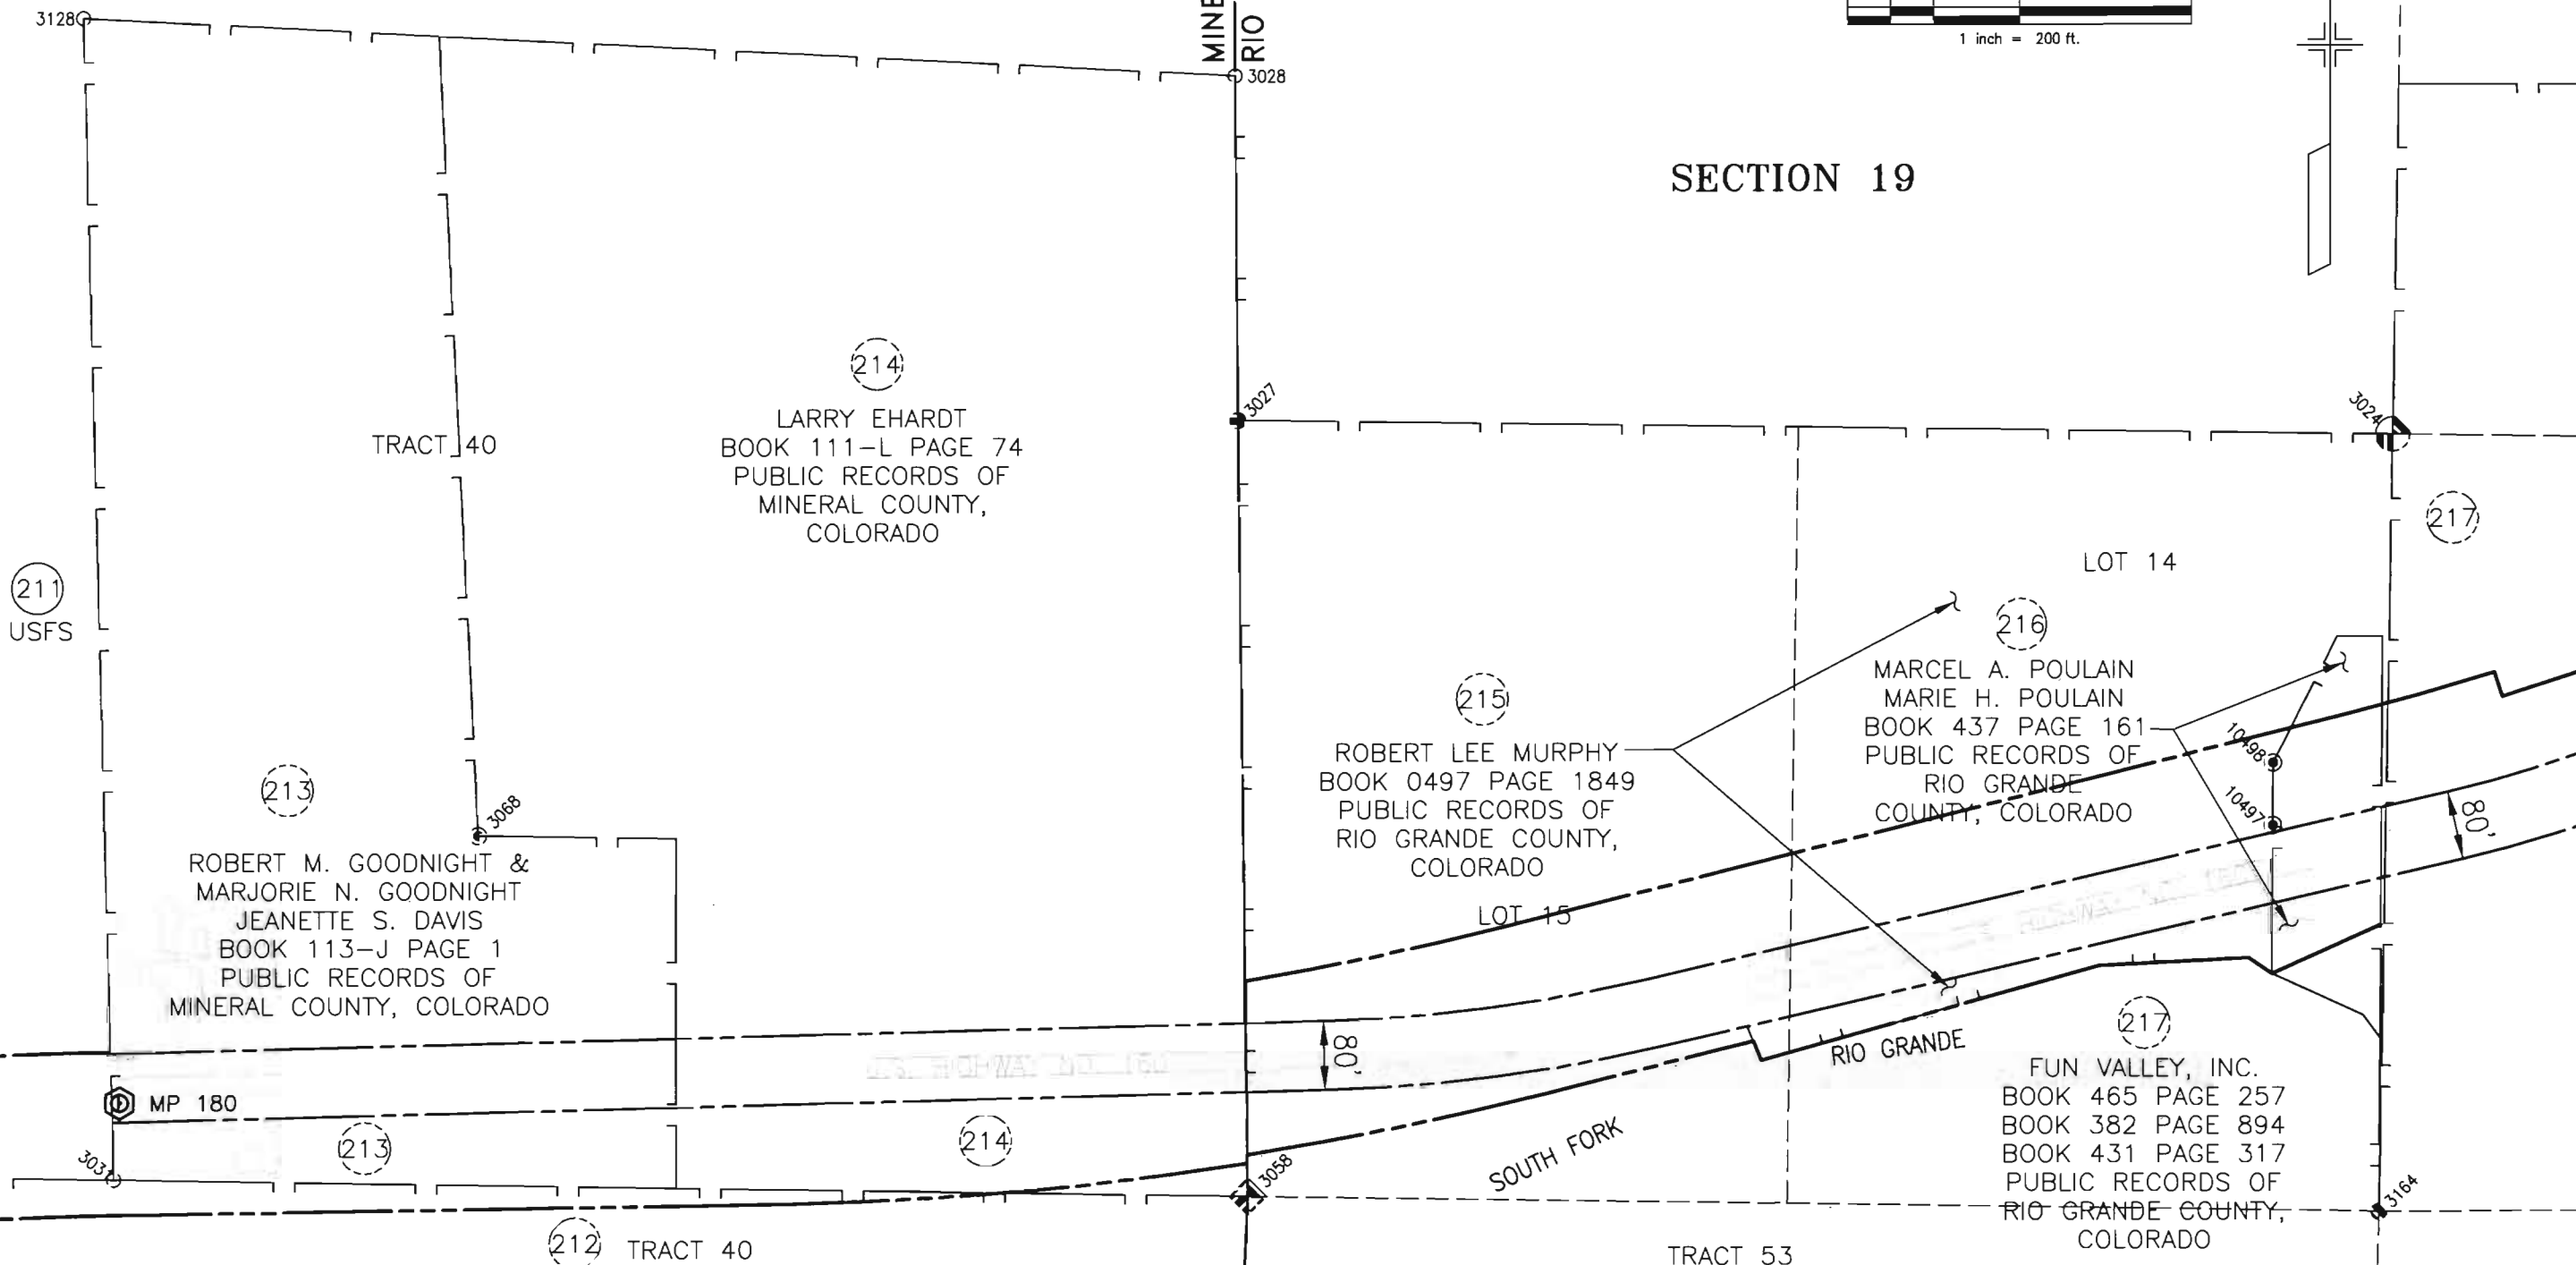

Carter Burgess

COLORADO DEPARTMENT OF TRANSPORTATION



Region 5
Address: 3803 North Main Avenue, Suite 300
Durango, Colorado 81301
Phone: (970) 385-1400 FAX: (970) 385-1410

Right of Way Plans Unit: Crumbaugh

Sheet Revisions

mm/yy	xxxxx	xxx

Sheet Revisions

mm/yy	xxxxx	xxx

Sheet Revisions


mm/yy	xxxxx	xxx

Right of Way Plans

Ownership Map

Project Number:	NH (CX)160-2(50) UNIT 2			
Project Location:	WOLF CREEK PASS EAST			
Project Location:				
Project Code:	Last Mod. Date	Subset Sheets	Sheet No.	Total No. of Sheets
92977	---	16 of 18	47	49

 T.39 N, R.3 E, NMPM



(217)

(217)

(217)

FUN VALLEY, INC.
BOOK 465 PAGE 257
BOOK 382 PAGE 894
BOOK 431 PAGE 317
PUBLIC RECORDS OF
RIO GRANDE COUNTY,
COLORADO

SOUTH FORK RIO GRANDE

TRACT 55

EXISTING ROW

110'

80'

8'

COLORADO DEPARTMENT OF TRANSPORTATION



Region 5
Address: 3803 North Main Avenue, Suite 300
Durango, Colorado 81301
Phone: (970) 385-1400 FAX: (970) 385-1410

Right of Way Plans Unit: Crumbaugh

Sheet Revisions

mm/yy	xxxxx	xxx

Sheet Revisions

mm/yy	xxxxx	xxx

Sheet Revisions

mm/yy	xxxxx	xxx


Right of Way Plans

Ownership Map

Project Number:		NH (CX)160-2(50) UNIT 2		
Project Location:		WOLF CREEK PASS EAST		
Project Location:				
Project Code:	Last Mod. Date	Subset Sheets	Sheet No.	Total No. of Sheets
92977	---	17 of 18	48	49

T.39 N, R.3 E, NMPM 19 20

 N



(219)
USFS

TRACT 54

(217)
FUN VALLEY, INC.
BOOK 465 PAGE 257
BOOK 382 PAGE 894
BOOK 431 PAGE 317
PUBLIC RECORDS OF
RIO GRANDE COUNTY,
COLORADO

3000

MP 181

110'

161'

(217)

3005

3002

3003

(219)
USFS

TRACT 55

(219)
USFS

SOUTH FORK

RIO GRANDE

300'

EXISTING ROW L&AP NH(CX)160-2(49)

Carter Burgess

COLORADO DEPARTMENT OF TRANSPORTATION



Region 5
Address: 3803 North Main Avenue, Suite 300
Durango, Colorado 81301
Phone: (970) 385-1400 FAX: (970) 385-1410

Right of Way Plans Unit: Crumbaugh

Sheet Revisions

mm/yy	xxxxx	xxx

Sheet Revisions

mm/yy	xxxxx	xxx

Sheet Revisions

mm/yy	xxxxx	xxx

Right of Way Plans

Ownership Map

Project Number:		NH (CX)160-2(50) UNIT 2		
Project Location:		WOLF CREEK PASS EAST		
Project Location:				
Project Code:	Last Mod. Date	Subset Sheets	Sheet No.	Total No. of Sheets
92977	---	18 of 18	49	49

T.39 N, R.3 E, NMPM

MP 182


(219)
USFS

NW/4 SEC.20

(219)
USFS

300'

EXISTING ROW
FAP NH(CX)160-2(49)

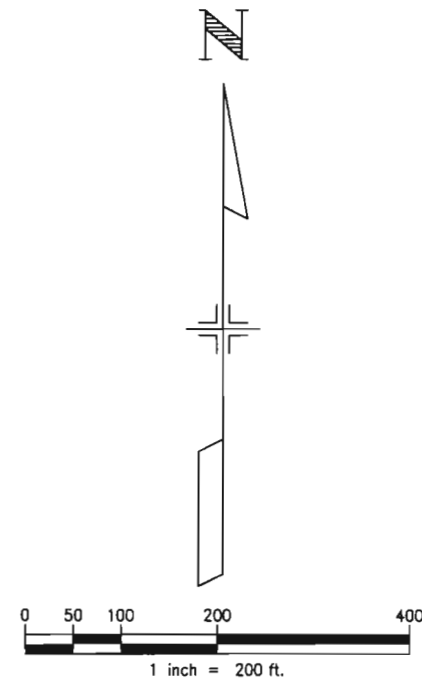

Carter::Burgess

REPORTED THIS DAY OF 18, AT M, FOR INFORMATION
ONLY IN BOOK OF THE COUNTY LAND SURVEYS/RIGHT OF WAY
SURVEYS AT PAGE, RECEPTION NUMBER

SIGNED DEPT.

K:\O\0022\DWGS\OWNER\AP\OWNR18.DWG, 08/12/2002 11:59:50 AM

datestamp