

Colorado Department of Transportation



222 South 6th Street
Room 317
Grand Junction, CO 81501
Phone: 970-683-6236
FAX: 970-683-6227

Region 3

JMK



6501 E. Bellevue Ave. Suite 300
Englewood CO 80111
Tel: (720) 259-9323
SURVEY/MAPPING UTILITY/SUE REAL ESTATE

Sheet Revisions


Date	Description	Initials

Sheet Revisions

Date	Description	Initials

Sheet Revisions

Date	Description	Initials

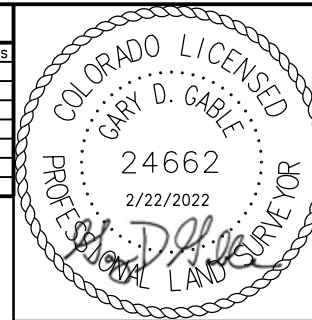

Right of Way Plans

Title Sheet

Project Number: NHPP-0502-090

Project Location: US Highway 50 Passing Lanes

MP 134.6 to 136.0

Project Code:	Last Mod. Date	Subset	Sheet No.
23557	02-11-2022	1.01 to 1.01	1.01

SURVEYOR STATEMENT (ROW PLAN)

I, Gary D. Gable, a professional land surveyor licensed in the State of Colorado, do hereby state to the Colorado Department of Transportation that based upon my knowledge, information and belief, the research, calculations and evaluation of the survey evidence were performed and this Right-of-Way Plan was prepared under my responsible charge in accordance with applicable standards of practice defined by Colorado Department of Transportation publications. This statement is not a guaranty or warranty, either expressed or implied.

DEPARTMENT OF TRANSPORTATION

STATE OF COLORADO

RIGHT OF WAY PLANS OF PROPOSED


STATE PROJECT NO. NHPP 0502-090

US HIGHWAY NO. 50

GUNNISON COUNTY

R.D.W. Length of Project = 0.7 Miles

Const. Length of Project = 1.3 Miles

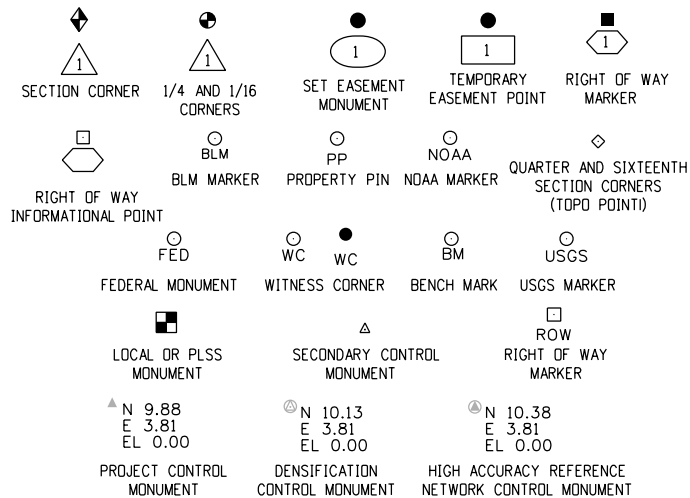

PERMANENT, PROPERTY, SLOPE, & UTILITY EASEMENT LINE (PROPOSED AND EXISTING)

TEMPORARY EASEMENT LINE (PROPOSED AND EXISTING)

PROPERTY BOUNDARY LINE (PROPOSED AND EXISTING)

ACCESS CONTROL LINE (PROPOSED AND EXISTING)

BARRIER ACCESS CONTROL LINE (PROPOSED AND EXISTING)

RIGHT OF WAY LINE (PROPOSED AND EXISTING)

VIRGIN RIGHT OF WAY LINE (PROPOSED AND EXISTING)

CITY LIMIT LINE

COUNTY LINE

QUARTER SECTION LINE

SECTION LINE

SIXTEENTH SECTION LINE

STATE LINE


TOWNSHIP LINE

SURVEY/ROW




TERRAIN

Note: For a complete listing of symbology used within this set of plans, please refer to the M-100-1 Standard Symbols of the Colorado Department of Transportation M&S Standards Publication. Existing topo features are shown as screened weight (gray scale). Proposed or new features are shown as full weight without screening, except as noted with the word (proposed).

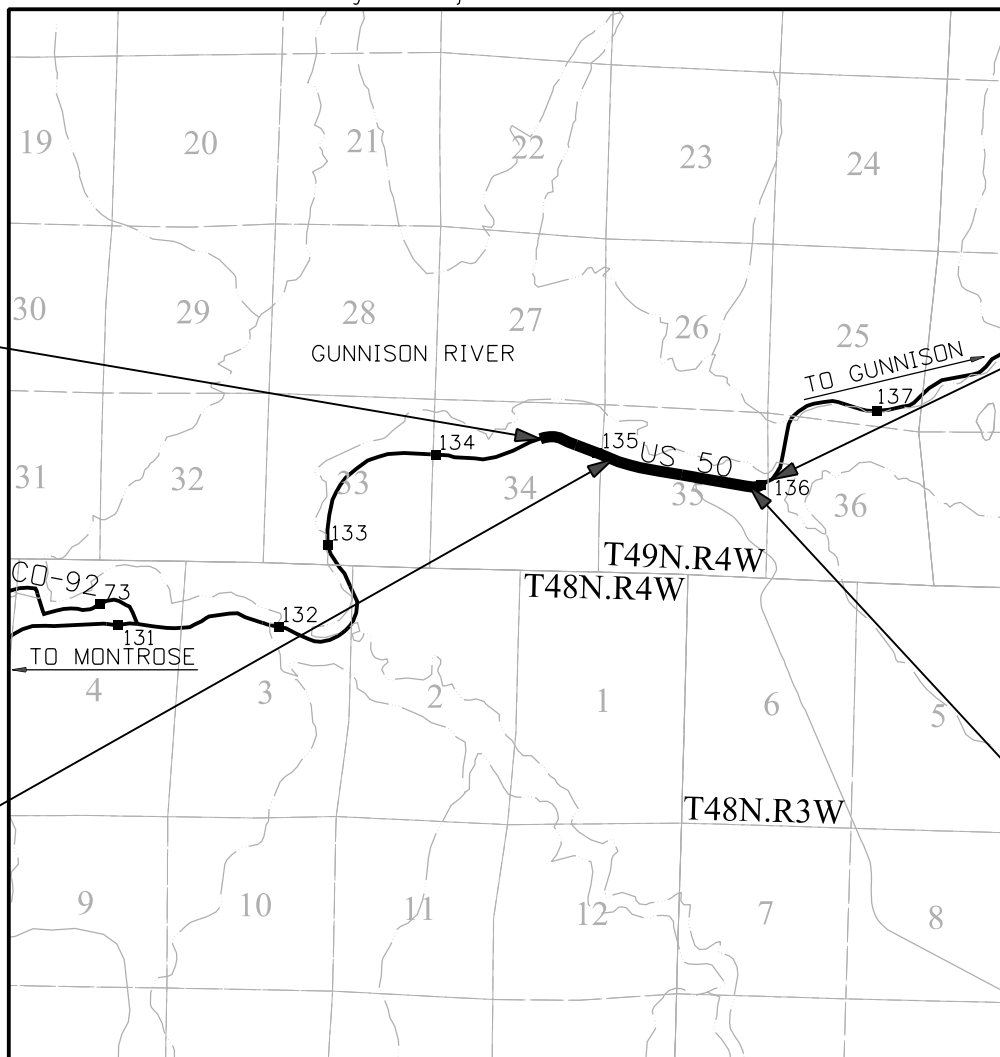

PROJECT LOCATION MAP

 

Basis of Bearings: Bearings used in the calculations of coordinates are based on a grid bearing of S78°06'46"E from Point 1347, CM-MP 134.7 to Point 1360, CM-MP 136.0. Both monuments are CDOT Type II, marked appropriately for their milepost location and control position. The survey data was obtained from a Global Positioning System (GPS) survey base on the Colorado High Accuracy Reference Network (CHARN).

1. This Right-of-Way Plan is not a boundary survey of the adjoining property and is prepared for the Colorado Department of Transportation purposes for this project only.

2. For title information, The Colorado Department of Transportation relied on Title Commitments prepared by First National Title Insurance Company.

3. This plan set is subject to change and may not be the most current set. It is the user's responsibility to verify with CDOT that this set is the most current. The information contained on the attached drawing is not valid unless this copy bears an original signature of the Professional Land Surveyor hereon named.

NOTICE: According to Colorado law you must commence any legal action based upon any defect in this survey within three years after you first discover such defect. In no event may any action based upon any defect in this survey be commenced more than ten years from the date of the certification shown hereon.

COLORADO DEPARTMENT OF TRANSPORTATION
STATE HIGHWAY PROJECT

ROW PLANS AUTHORIZED:

Stephen Harelson
Stephen Harelson (Mar 14, 2022 12:24 MDT)

CDOT CHIEF ENGINEER

03/14/22

DATE


SHEET NO. INDEX OF SHEETS

1.01	(1) Title Sheet
2.01	(1) Tabulation of Properties
3.01-3.04	(4) Project Control/Land Survey Control Diagram
5.01	(1) Monumentation Sheet
7.01-7.05	(5) Plan Sheets
8.01-8.01	(1) Ownership Map
(13)	Total Sheets

Scales of Original 11"x17" Drawings


Plan Sheets 1"=100'

Ownership Map 1"=500'

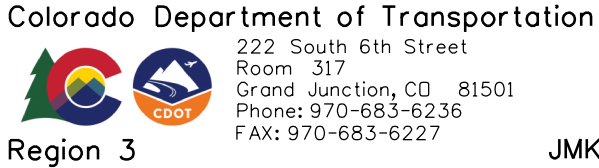

222 South 6th Street
Room 317
Grand Junction, CO 81501
Phone: 970-683-6236
FAX: 970-683-6227

JMK

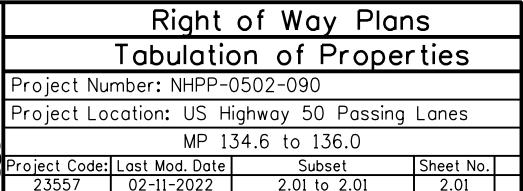[illegible][illegible]

2/22/2022 3:22:27 PM P:_P20 Projects\P200172 - MEC-COOT US 50 Passing Lane\RDW_Survey\Drawings\201-23557RDW_TobProp01.dgn

Colorado Department of Transportation



222 South 6th Street
Room 317
Grand Junction, CO 81501
Phone: 970-683-6236
FAX: 970-683-6227

Region 3

JMK



6501 E. Bellevue Ave. Suite 300
Englewood CO 80111
Tel: (720) 259-9323
SURVEY/MAPPING UTILITY/SUE REAL ESTATE

Sheet Revisions


Date	Description	Initials

Sheet Revisions

Date	Description	Initials

Sheet Revisions

Date	Description	Initials

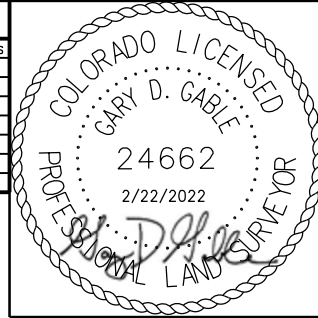

Project/Land Survey ControlDiagram

Title Sheet

Project Number: NHPP-0502-090

Project Location: US Highway 50 Passing Lanes

MP 134.6 to 136.0

Project Code:	Last Mod. Date	Subset	Sheet No.
23557	02-11-2022	3.01 to 3.04	3.01


SURVEYOR STATEMENT (ROW PLAN)
I, Gary D Gable, a professional land surveyor licensed in the State of Colorado, do hereby state to the Colorado Department of Transportation that based upon my knowledge, information and belief, the research, calculations and evaluation of the survey evidence were performed and this Right-of-Way Plan was prepared under my responsible charge in accordance with applicable standards of practice defined by Colorado Department of Transportation publications.
This statement is not a guaranty or warranty, either expressed or implied.

DEPARTMENT OF TRANSPORTATION
STATE OF COLORADO


PROJECT CONTROL/LAND SURVEY CONTROL DIAGRAM

US Highway 50 MP 134.6 to 136.0
Sections 34 & 35

Townships 49 North, Range 4 West
of the New Mexico Principal Meridian
County of Gunnison

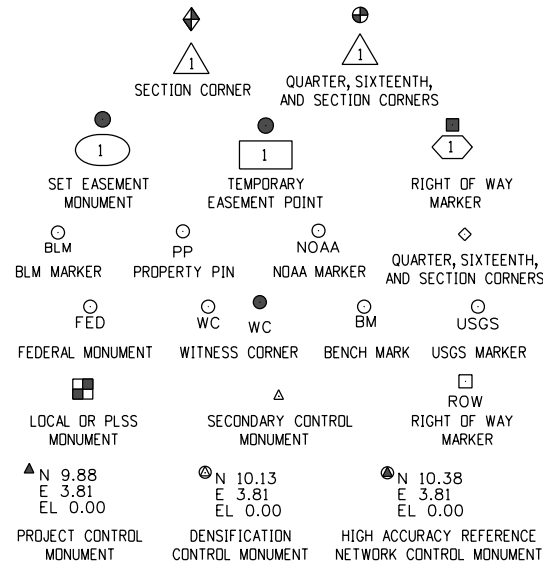

Note: For a complete listing of symbololgy used within this set of plans, please refer to the M-100-1 Standard Symbols of the Colorado Department of Transportation M&S Standards Publication. Existing features are shown as screened weight (gray scale). Proposed or new features are shown as full weight without screening.

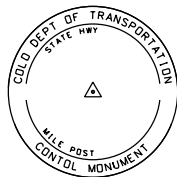


Typical Control Monument Cap
Not to Scale


▲ CM-MP - ControlPoint Monuments set by CDDT. They are CDDT Type 2 monuments, a 3 1/4" dia. aluminum control monument cap (as shown) on a 3' x 3/4" dia. aluminum security rod on a 3' x 3/4" dia. smooth aluminum rod.

General Notes:

1. This Project Control/ Land Survey ControlDiagram is not a boundary survey of the adjoining property and is prepared for the Colorado Department of Transportation purposes only.
2. This plan set is subject to change and may not be the most current set. It is the user's responsibility to verify with CDDT that this set is the most current. The information contained on the attached drawing is not valid unless this copy bears an original signature of the Professional Land Surveyor hereon named.
3. Refer to the M-629-1 Survey Monuments of the Standard Plans found in The Colorado Department of Transportation, M & S Standards for typical survey monument descriptions.

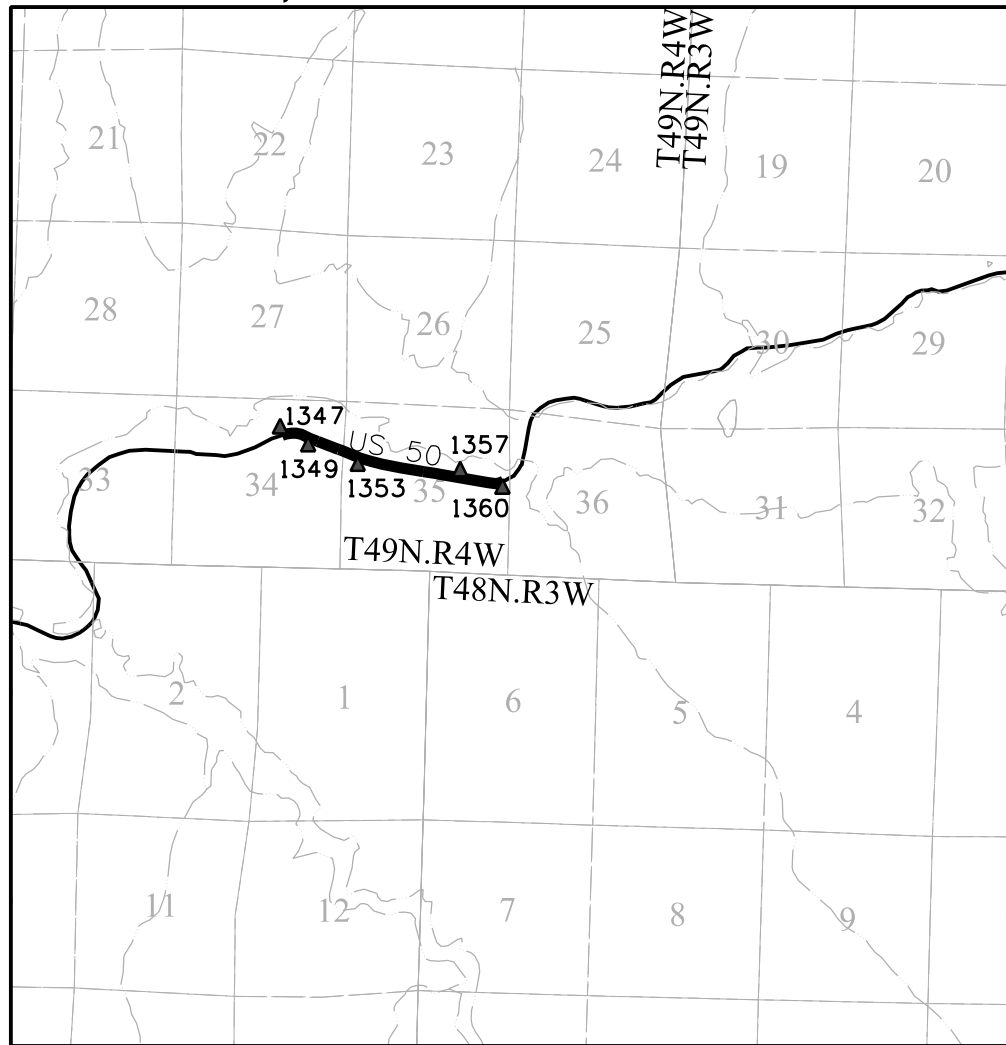

PROJECT LOCATION MAP

 

Basis of Bearings: Bearings used in the calculations of coordinates are based on a grid bearing of S78°06'46"E from Point 1347, CM-MP 134.7 to Point 1360, CM-MP 136.0. Both monuments are CDDT Type II, marked appropriately for their milepost location and control position. The survey data was obtained from a Global Positioning System (GPS) survey base on the Colorado High Accuracy Reference Network (CHARN).

Basis of Elevations: Project elevations are based on Bench Mark R424 2020, PID: JL0507, a standard NGS bench mark stainless steel rod without sleeve in well, with a NAVD 88 elevation of 7,607.04ft. R424 is a First order Class II benchmark.

COORDINATE DATUM: Project coordinates are modified Colorado State Plane 0502 Zone NAD '83/(2011) coordinates. The combined elevation/scale factor used to modify the coordinates from state plane to project coordinates is of 1.000365063 The resulting project coordinates are truncated by 304,800.610 m in the Northing and 609,601.219 m in the Easting after converting from state plane coordinates to project coordinates. The CHARN is based on the NAD '83(2011) datum.

Project Coordinates Northing US Survey Feet = (State Plane Coordinate Northing * 1.000365063 - 304,800.610) * (3937/1200).
Project Coordinates Easting US Survey Feet = (State Plane Coordinate Easting * 1.000365063 - 609,601.219) * (3937/1200).

SHEET NO. INDEX OF SHEETS

3.01-3.01	(1) Title Sheet
3.02-3.02	(1) Coordinate Tables
3.03-3.04	(2) Plan Sheet
	(4) Total Sheets

Colorado Department of Transportation



222 South 6th Street
Room 317
Grand Junction, CO 81501
Phone: 970-683-6236
FAX: 970-683-6227

Region 3

JMK



6501 E. Bellevue Ave. Suite 300
Englewood CO 80111
Tel: (720) 259-9323
SURVEY/MAPPING UTILITY/SUE REAL ESTATE

Sheet Revisions


Date	Description	Initials

Sheet Revisions

Date	Description	Initials

Sheet Revisions

Date	Description	Initials

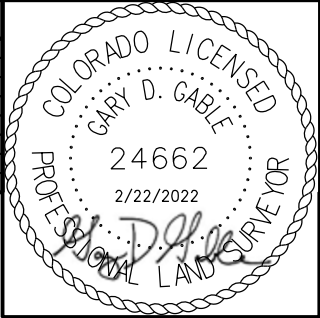

Project/Land Survey Control Diagram

Coordinate Tables

Project Number: NHPP-0502-090			
Project Location: US Highway 50 Passing Lanes			
MP 134.6 to 136.0			
Project Code:	Last Mod. Date	Subset	Sheet No.
23557	02-11-2022	3.01 to 3.04	3.02

CHARN GEODETIC COORDINATE SUMMARY TABLE

Point No.	Geodetic Coordinates NAD-83(2011) (CHARN)		Elip Height (NAVD88)(m)	Ortho Height (m)	Mapping Angle	Grid Scale Factor	NAD 83(2011) Zone 0502		Description
	Latitude(N)	Longitude(W)					SP Northing(m)	SP Easting(m)	
MC05	38°44'22.38412"	108°04'22.68418"	1505.900	1522.820	-1°37'21.9"	0.9997194837	408564.70	690739.88	NGS PID: DH6918 - NGS STATION "MESA CNTY 05"
MC10	38°27'20.13742"	107°52'42.39343"	1809.455	1825.861	-1°30'00.2"	0.9997150721	376593.97	706820.32	NGS PID: DL3585 - NGS STATION "MONTROSE CORS"
R301	38°39'23.73971"	107°35'27.36714"	2025.011	2040.471	-1°19'07.4"	0.9996481890	398282.88	732421.64	NGS PID: DL3478 - NGS STATION "CRAWFORD CORS"
35 RHM RESET	38°26'21.12145"	107°22'47.04432"	2481.146	2495.894	-1°11'07.9"	0.9996129847	373754.53	750301.00	USGS 3 1/2" BRASS CAP "35RHM 1955"
N424	38°28'37.05657"	107°13'41.67939"	2287.959	2302.505	-1°05'23.9"	0.9996359467	377682.67	763604.17	NGS 3 1/2" BRASS VERT CTL MARK "N424 1984"
S424	38°27'35.60928"	107°18'12.64398"	2299.479	2314.107	-1°08'14.8"	0.9996373996	375916.00	756999.91	NGS 3 1/2" BRASS VERT CTL MARK "S424 1984"
R424	38°28'05.85500"	107°16'53.96578"	2304.034	2318.630	-1°07'25.2"	0.9996350702	376810.80	758925.36	NGS STAINLESS STEEL ROD IN BOX "R 424 1984"

GEODETIC COORDINATE TABLE

Point No.	Geodetic Coordinates NAD-83(2011) (CHARN)		Elip Height (NAVD88)(m)	Ortho Height (m)	Mapping Angle	Grid Scale Factor	NAD 83(2011) Zone 0502		Description
	Latitude(N)	Longitude(W)					SP Northing(m)	SP Easting(m)	
1347	38°28'05.20405"	107°16'53.56554"	2304.227	2318.823	-1°07'25.0"	0.9996350745	376790.54	758934.66	FOUND CDOT TYPE II MONUMENT "CM-MP 134.7"
1349	38°28'05.54892"	107°16'44.36840"	2303.373	2317.966	-1°07'19.2"	0.9996351902	376796.80	759157.79	FOUND CDOT TYPE II MONUMENT "CM-MP 134.9"
1353	38°27'57.70664"	107°16'16.33823"	2300.842	2315.430	-1°07'01.5"	0.9996360037	376541.76	759832.45	FOUND CDOT TYPE II MONUMENT "CM-MP 135.3"
1357	38°27'54.36746"	107°15'49.19880"	2303.357	2317.939	-1°06'44.4"	0.9996357874	376426.02	760488.25	FOUND CDOT TYPE II MONUMENT "CM-MP 135.7"
1360	38°27'51.63635"	107°15'22.85607"	2290.134	2304.711	-1°06'27.8"	0.9996380063	376329.45	761125.13	FOUND CDOT TYPE II MONUMENT "CM-MP 136.0"

PROJECT COORDINATE TABLE

Point No.	Project Coordinates		Elev(ft) (NAVD88)	Description
	Northing(ft)	Easting(ft)		
1347	236638.25	490847.13	7607.67	FOUND CDOT TYPE II MONUMENT "CM-MP 134.7"
1349	236658.80	491579.42	7604.86	FOUND CDOT TYPE II MONUMENT "CM-MP 134.9"
1353	235821.74	493793.68	7596.54	FOUND CDOT TYPE II MONUMENT "CM-MP 135.3"
1357	235441.87	495946.06	7604.77	FOUND CDOT TYPE II MONUMENT "CM-MP 135.7"
1360	235124.93	498036.31	7561.37	FOUND CDOT TYPE II MONUMENT "CM-MP 136.0"

FOUND BOUNDARY MONUMENT COORDINATE TABLE

Point No.	Northing(ft)	Easting(ft)	Description
SA2793	235570.67	494289.07	2 1/2" AC POWERS ELEVATION CO INC LS# 30113
SA2797	235319.20	495694.94	3 1/4" AC INTERIOR U.S DEPARTMENT A 133 1984
SA2806	236497.97	491790.55	1 1/2" AC DEL-MONT 24299
SA2812	236283.33	492352.59	1 1/2" AC DEL-MONT 24299

FOUND R.O.W. MONUMENT COORDINATE TABLE

Point No.	Northing(ft)	Easting(ft)	Description
4663	236672.71	492051.80	3 1/4" BC COLO. DEPT. OF HIGHWAYS STA. EL. R.O.W. MARKER
4667	236590.23	490559.08	3 1/4" BC COLO. DEPT. OF HIGHWAYS STA. EL. R.O.W. MARKER
SA2775	234904.60	498319.79	3 1/4" BC STATE HIGHWAY DEPT ST. EL. R.O.W. MARKER
SA2777	235255.21	497792.85	3 1/4" BC STATE HIGHWAY DEPT ST. EL. R.O.W. MARKER
SA2780	235423.03	496640.34	3 1/4" BC STATE HIGHWAY DEPT ST. EL. R.O.W. MARKER
SA2782	235478.65	496446.90	3 1/4" BC STATE HIGHWAY DEPT ST. EL. R.O.W. MARKER
SA2784	235485.20	496245.32	3 1/4" BC STATE HIGHWAY DEPT ST. EL. R.O.W. MARKER
SA2786	235706.99	494846.71	3 1/4" BC STATE HIGHWAY DEPT ST. EL. R.O.W. MARKER
SA2788	236035.07	493651.96	3 1/4" BC STATE HIGHWAY DEPT ST. EL. R.O.W. MARKER
SA2795	235459.98	494807.43	3 1/4" BC STATE HIGHWAY DEPT ST. EL. R.O.W. MARKER
SA2801	236369.79	490675.88	3 1/4" BC STATE HIGHWAY DEPT ST. EL. R.O.W. MARKER
SA2810	236439.90	491958.93	3 1/4" BC STATE HIGHWAY DEPT ST. EL. R.O.W. MARKER

FOUND ALIQUOT MONUMENT COORDINATE TABLE

Point No.	Northing(ft)	Easting(ft)	Description
SA1007	234940.60	493070.87	3 1/4" AC T48N 1/4 34 35 R4W 1990 LS10738 *
SA1021	235043.94	487833.92	3 1/2" AC T49N R4W 1/4 33 34 1989 BLM CADASTRAL
SA1023	234766.16	498342.32	3 1/2" AC T49N 1/4 35 36 R4W LS 24299 1991
SA2808	236293.11	491787.00	2" AC NE 1/16 34 DEL-MONT LS 24299

* Survey Monument Cap is mismarked as T48N in the field. Actual Township is 49 North.

COORDINATE DATUM: Project coordinates are modified Colorado State Plane Central Zone NAD '83/(2011) coordinates. The combined elevation/scale factor used to modify the coordinates from state plane to project coordinates is 1.000365063. The resulting project coordinates are truncated by 304,800.610 meters in the Northing and 609,601.219 meters in the Easting after converting from state plane coordinates to project coordinates. The CHARN is based on the NAD '83(2011) datum.
Project Coordinates Northing US Survey Feet = (State Plane Coordinate Northing * 1.000365063 - 304,800.610) * (3937/1200).
Project Coordinates Easting US Survey Feet = (State Plane Coordinate Easting * 1000365063 - 609,601.219) * (3937/1200).

Colorado Department of Transportation



222 South 6th Street
Room 317
Grand Junction, CO 81501
Phone: 970-683-6236
FAX: 970-683-6227

Region 3

JMK



6501 E. Belview Ave. Suite 300
Englewood CO 80111
Tel: (720) 259-9323
SURVEY/MAPPING UTILITY/SUE REAL ESTATE

Sheet Revisions


Date	Description	Initials

Sheet Revisions

Date	Description	Initials

Sheet Revisions

Date	Description	Initials

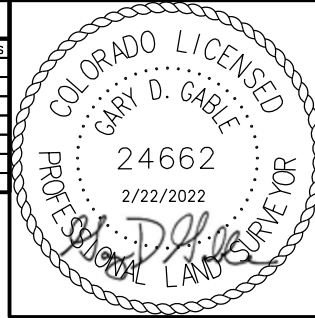

Project/Land Survey Control Diagram

Plan Sheet


Project Number: NHPP-0502-090

Project Location: US Highway 50 Passing Lanes

MP 134.6 to 136.0

Project Code:	Last Mod. Date	Subset	Sheet No.
23557	02-11-2022	3.01 to 3.04	3.03

T49N R4W N.M. P.M.

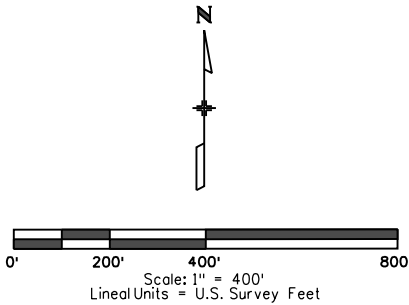

NE 1/4 SEC. 34

NW 1/4 SEC. 35

NW 1/4 SEC. 34

US-50 MP 134.6
NHPP-0502-090
STA. 105+00.00

US 50
(250' PUBLIC ROW)

PI = 115+60.68
 Δ = 50° 12' 06" RT
Tc = 816.02'
Dc = 04° 21' 26"
Lc = 1,152.19'
Rc = 1,315.00'

PI = 145+95.62
 Δ = 12° 47' 37" LT
Tc = 632.87'
Dc = 01° 00' 54"
Lc = 1,260.48'
Rc = 5,645.00'

APPROX. WEST LINE NW 1/4 SEC. 34

APPROX. WEST LINE NW 1/4 SEC. 35

SA1021

APPROX. SOUTH LINE OF NORTH 1/2 SEC. 34

SA1007

APPROX. SOUTH LINE
NW 1/4 SEC. 35

SW1/4 SEC. 34

SE1/4 SEC. 34

SW1/4 SEC. 35

Colorado Department of Transportation

222 South 6th Street
Room 317
Grand Junction, CO 81501
Phone: 970-683-6236
FAX: 970-683-6227

Region 3

JMK



6501 E. Bellevue Ave. Suite 300
Englewood CO 80111
Tel: (720) 259-9323
SURVEY/MAPPING UTILITY/SUE REAL ESTATE

Sheet Revisions


Date	Description	Initials

Sheet Revisions

Date	Description	Initials

Sheet Revisions

Date	Description	Initials

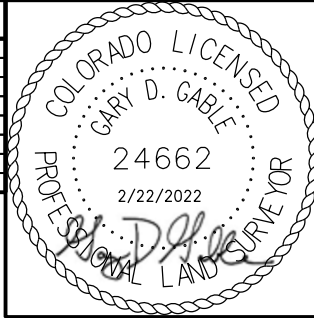


Project/Land Survey Control Diagram

Plan Sheet

Project Number: NHPP-0502-090			
Project Location: US Highway 50 Passing Lanes			
MP 134.6 to 136.0			
Project Code: 23557	Last Mod. Date: 02-11-2022	Subset: 3.01 to 3.04	Sheet No.: 3.04

T49N R4W N.M. P.M.

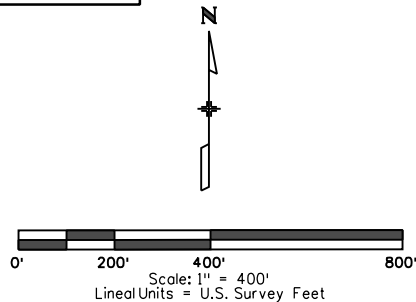

NE1/4 SEC. 35

NW1/4 SEC. 36

PI = 145+95.62
Δ = 12° 47' 37" LT
Tc = 632.87'
Dc = 01° 00' 54"
Lc = 1,260.48'
Rc = 5,645.00'

US0-50 MP 136.0
NHPP-0502-090
STA. 184+67.77

PI = 186+76.00
Δ = 64° 39' 16" LT
Tc = 620.18'
Dc = 05° 50' 47"
Lc = 1,105.87'
Rc = 980.00'

NW1/4 SEC. 35

US 50

(250' PUBLIC ROW)

APPROX. SOUTH LINE OF NORTH 1/2 SEC. 35

APPROX. SOUTH LINE OF NW1/4 SEC. 36

SW1/4 SEC. 35

SE1/4 SEC. 35

SW1/4 SEC. 36

2/22/2022 cprbble 3:22:41 PM P:_P20 Projects\200172 - MEC-CDOT US 50 Passing Lane\RDW_Survey\Drawings\304-23557SURV_PCD-Plan_04.dgn

[illegible]

Colorado Department of Transportation

222 South 6th Street
Room 317
Grand Junction, CO 81501
Phone: 970-683-6236
FAX: 970-683-6227

Region 3

JMK



6501 E. Belview Ave, Suite 300
Englewood CO 80111
Tel: (720) 259-9323
SURVEY/MAPPING UTILITY/SUE REAL ESTATE

Sheet Revisions


Date	Description	Initials

Sheet Revisions

Date	Description	Initials

Sheet Revisions

Date	Description	Initials

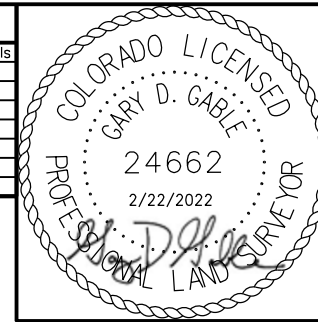

Right of Way Plans

Plan Sheet



Project Number: NHPP-0502-090

Project Location: US Highway 50 Passing Lanes

MP 134.6 to 136.0

Project Code:	Last Mod. Date	Subset	Sheet No.
23557	02-11-2022	7.01 to 7.05	7.01

NE 1/4 SEC. 34,
T49N, R4W,
N.M. P.M.

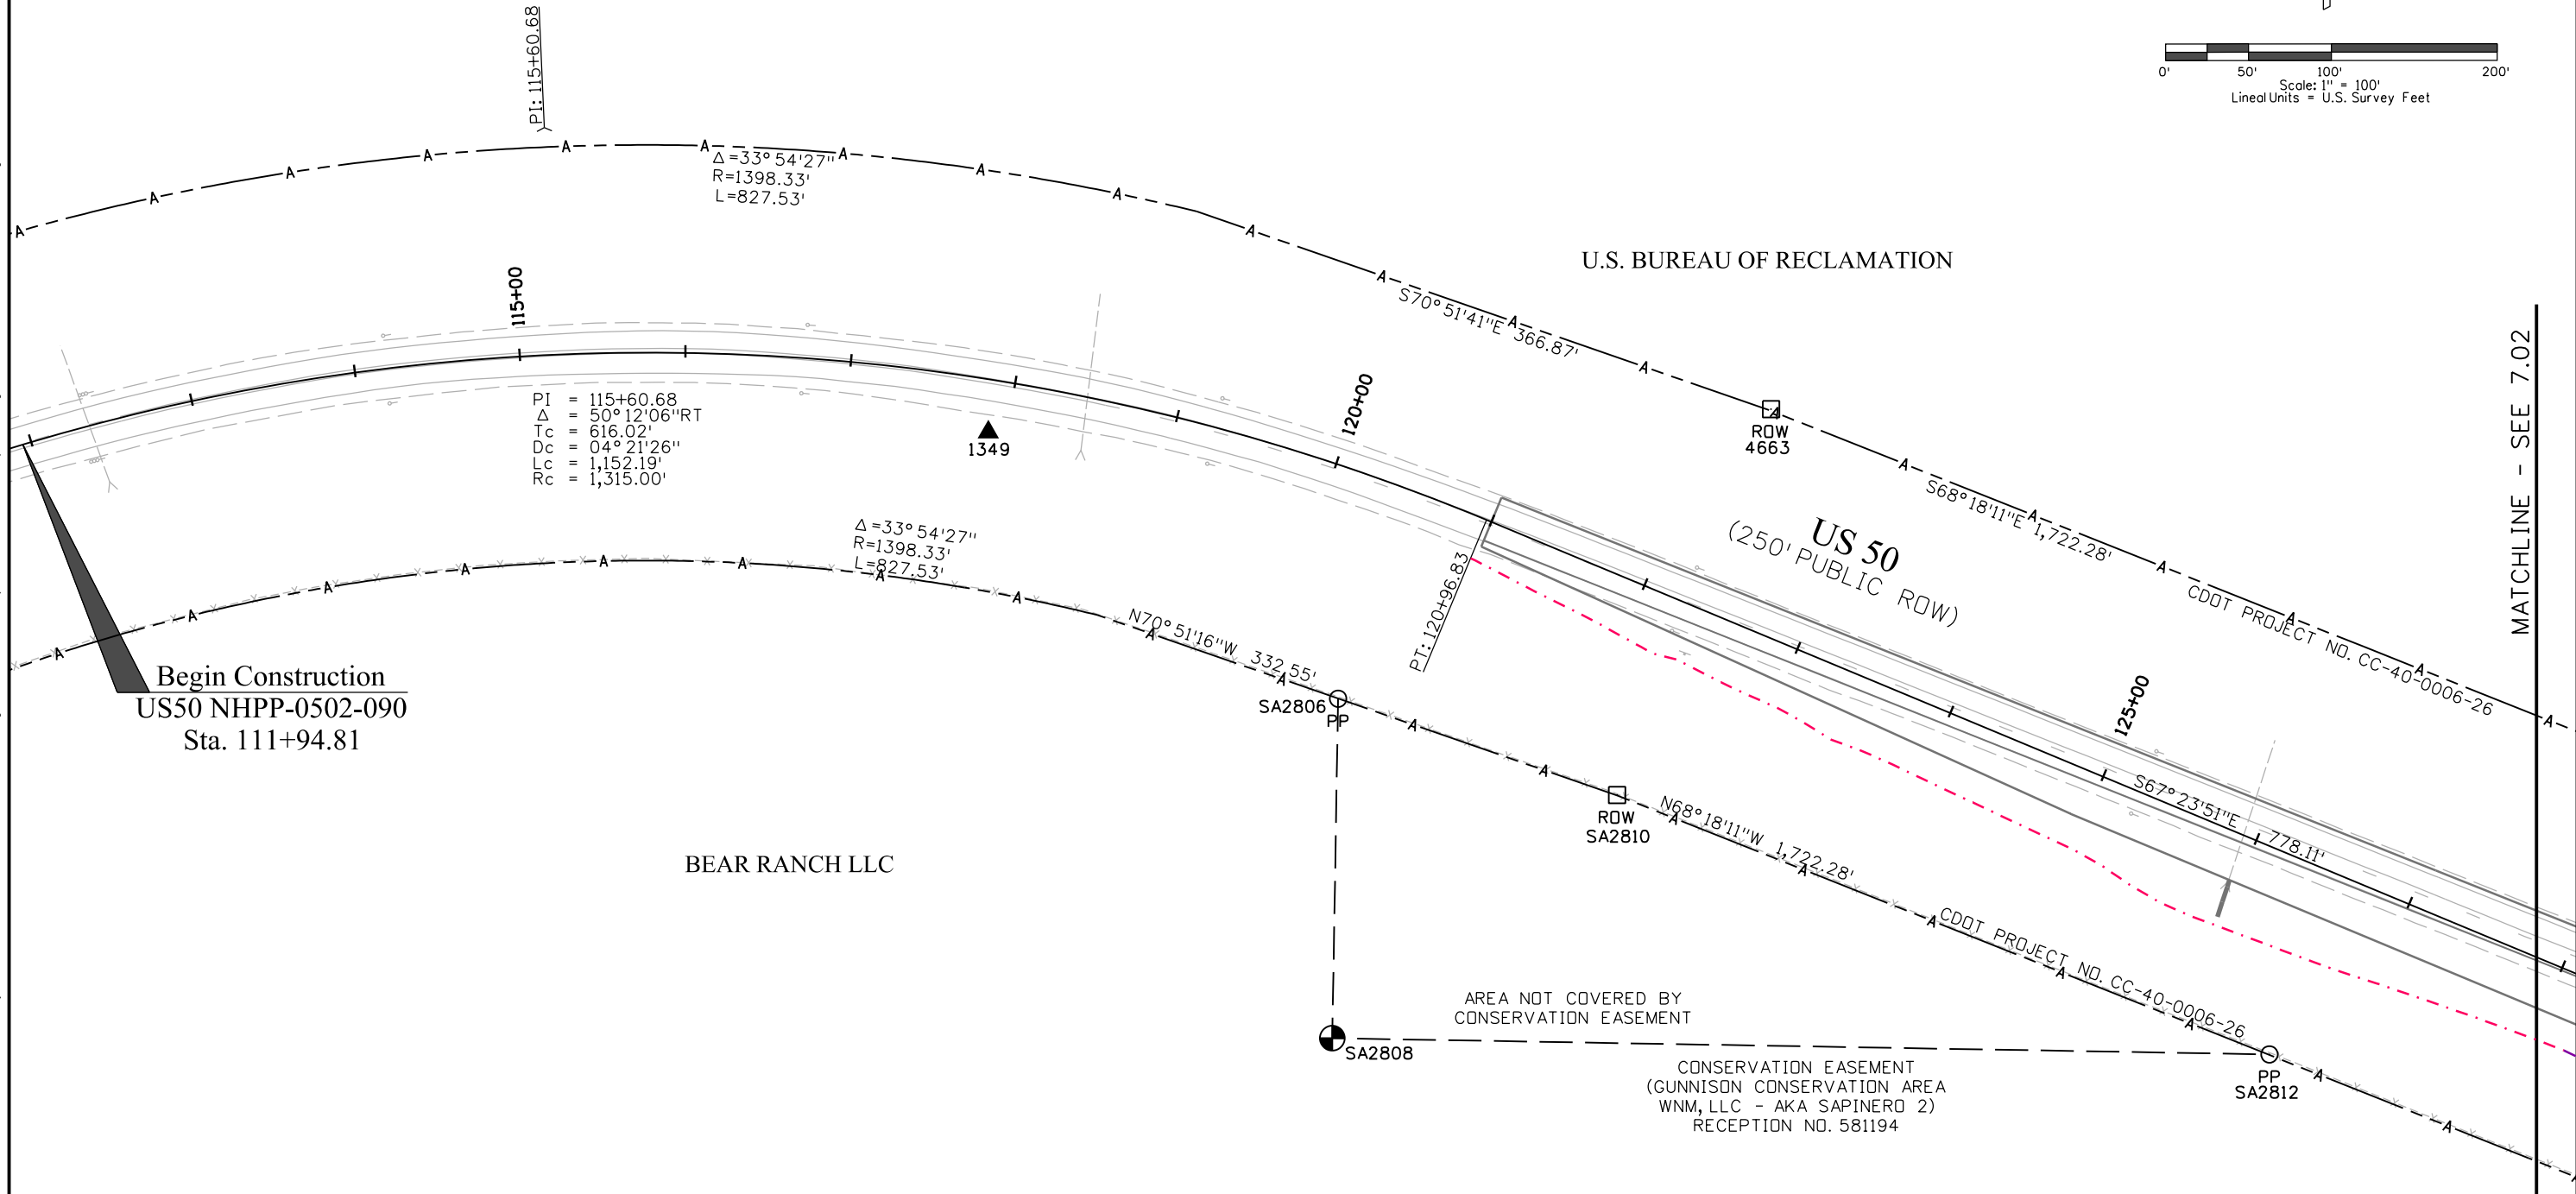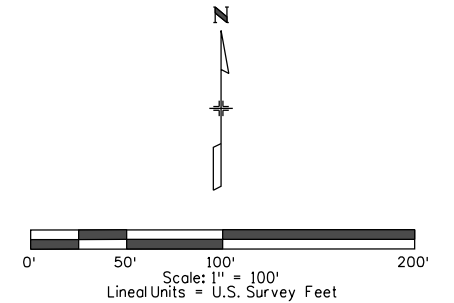

2/22/2022 3:22:45 PM P:_P20 Projects\VP200172 - MEC-CDOT US 50 Passing Lane\RDW_Survey\Drawings\701-23557\RDW_Plan_01.dgn

Colorado Department of Transportation



222 South 6th Street
Room 317
Grand Junction, CO 81501
Phone: 970-683-6236
FAX: 970-683-6227

Region 3

JMK



6501 E. Bellevue Ave. Suite 300
Englewood CO 80111
Tel: (720) 259-9323
SURVEY/MAPPING UTILITY/SUE REAL ESTATE

Sheet Revisions


Date	Description	Initials

Sheet Revisions

Date	Description	Initials

Sheet Revisions


Date	Description	Initials

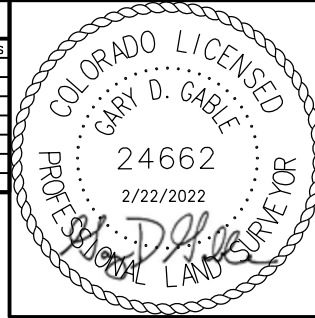

Right of Way Plans

Plan Sheet

Project Number: NHPP-0502-090			
Project Location: US Highway 50 Passing Lanes			
MP 134.6 to 136.0			
Project Code:	Last Mod. Date:	Subset:	Sheet No.:
23557	02-11-2022	7.01 to 7.05	7.02

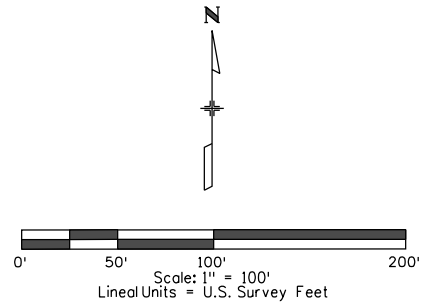

NE 1/4 SEC. 34,
T49N, R4W,
N.M. P.M.

NW 1/4 SEC. 35,
T49N, R4W,
N.M. P.M.

APPROX. WEST LINE NW 1/4 SEC. 35

U.S. BUREAU OF RECLAMATION

US 50
(250' PUBLIC ROW)

ROW
SA2788

PI = 145+95.62
Δ = 12° 47' 37" LT
Tc = 632.87'
Dc = 01° 00' 54"
Lc = 1,260.48'
Rc = 5,645.00'

Δ = 12° 41' 24"
R = 5855.00'
L = 1,296.78'

CONSERVATION EASEMENT
(GUNNISON CONSERVATION AREA
WNM, LLC - AKA SAPINERO 2)
RECEPTION NO. 581194

BEAR RANCH, LLC, A COLORADO
LIMITED LIABILITY COMPANY
REC. NO. 586442

CONSERVATION EASEMENT
(GUNNISON CONSERVATION AREA
WNM, LLC - AKA SAPINERO 2)
RECEPTION NO. 581194

TE-1 8,198 +/- SQ.FT.
(0.188 +/- AC.)

P.O.B. OF TE-1
TO E 1/4 CDR., SEC. 34
S13° 47' 08" E 1,205.59'

N64° 08' 44" W 248.79'

N68° 18' 11" W 1,722.28'
S68° 18' 11" E 644.58'
N68° 21' 03" W 269.42'

N76° 17' 06" W 128.27'

PC: 139+62.75

Begin R-O-W
US50 NHPP-0502-090
Sta. 131+19.23

MATCHLINE - SEE 7.01

MATCHLINE - SEE 7.03

2/22/2022 cprbble 3:22:46 PM P:_P20 Projects\IP200172 - MEC-CDOT US 50 Passing Lane\RDW_Survey\Drawings\702-23557\RDW_SURV_Plan_02.dgn

Colorado Department of Transportation



222 South 6th Street
Room 317
Grand Junction, CO 81501
Phone: 970-683-6236
FAX: 970-683-6227

Region 3

JMK



6501 E. Bellevue Ave. Suite 300
Englewood CO 80111
Tel: (720) 259-9323
SURVEY/MAPPING UTILITY/SUE REAL ESTATE

Sheet Revisions


Date	Description	Initials

Sheet Revisions

Date	Description	Initials

Sheet Revisions

Date	Description	Initials


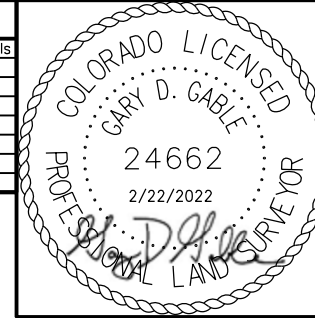


Right of Way Plans

Plan Sheet

Project Number: NHPP-0502-090			
Project Location: US Highway 50 Passing Lanes			
MP 134.6 to 136.0			
Project Code: 23557	Last Mod. Date: 02-11-2022	Subset: 7.01 to 7.05	Sheet No.: 7.03

NW 1/4 SEC. 35,
T49N, R4W,
N.M. P.M.

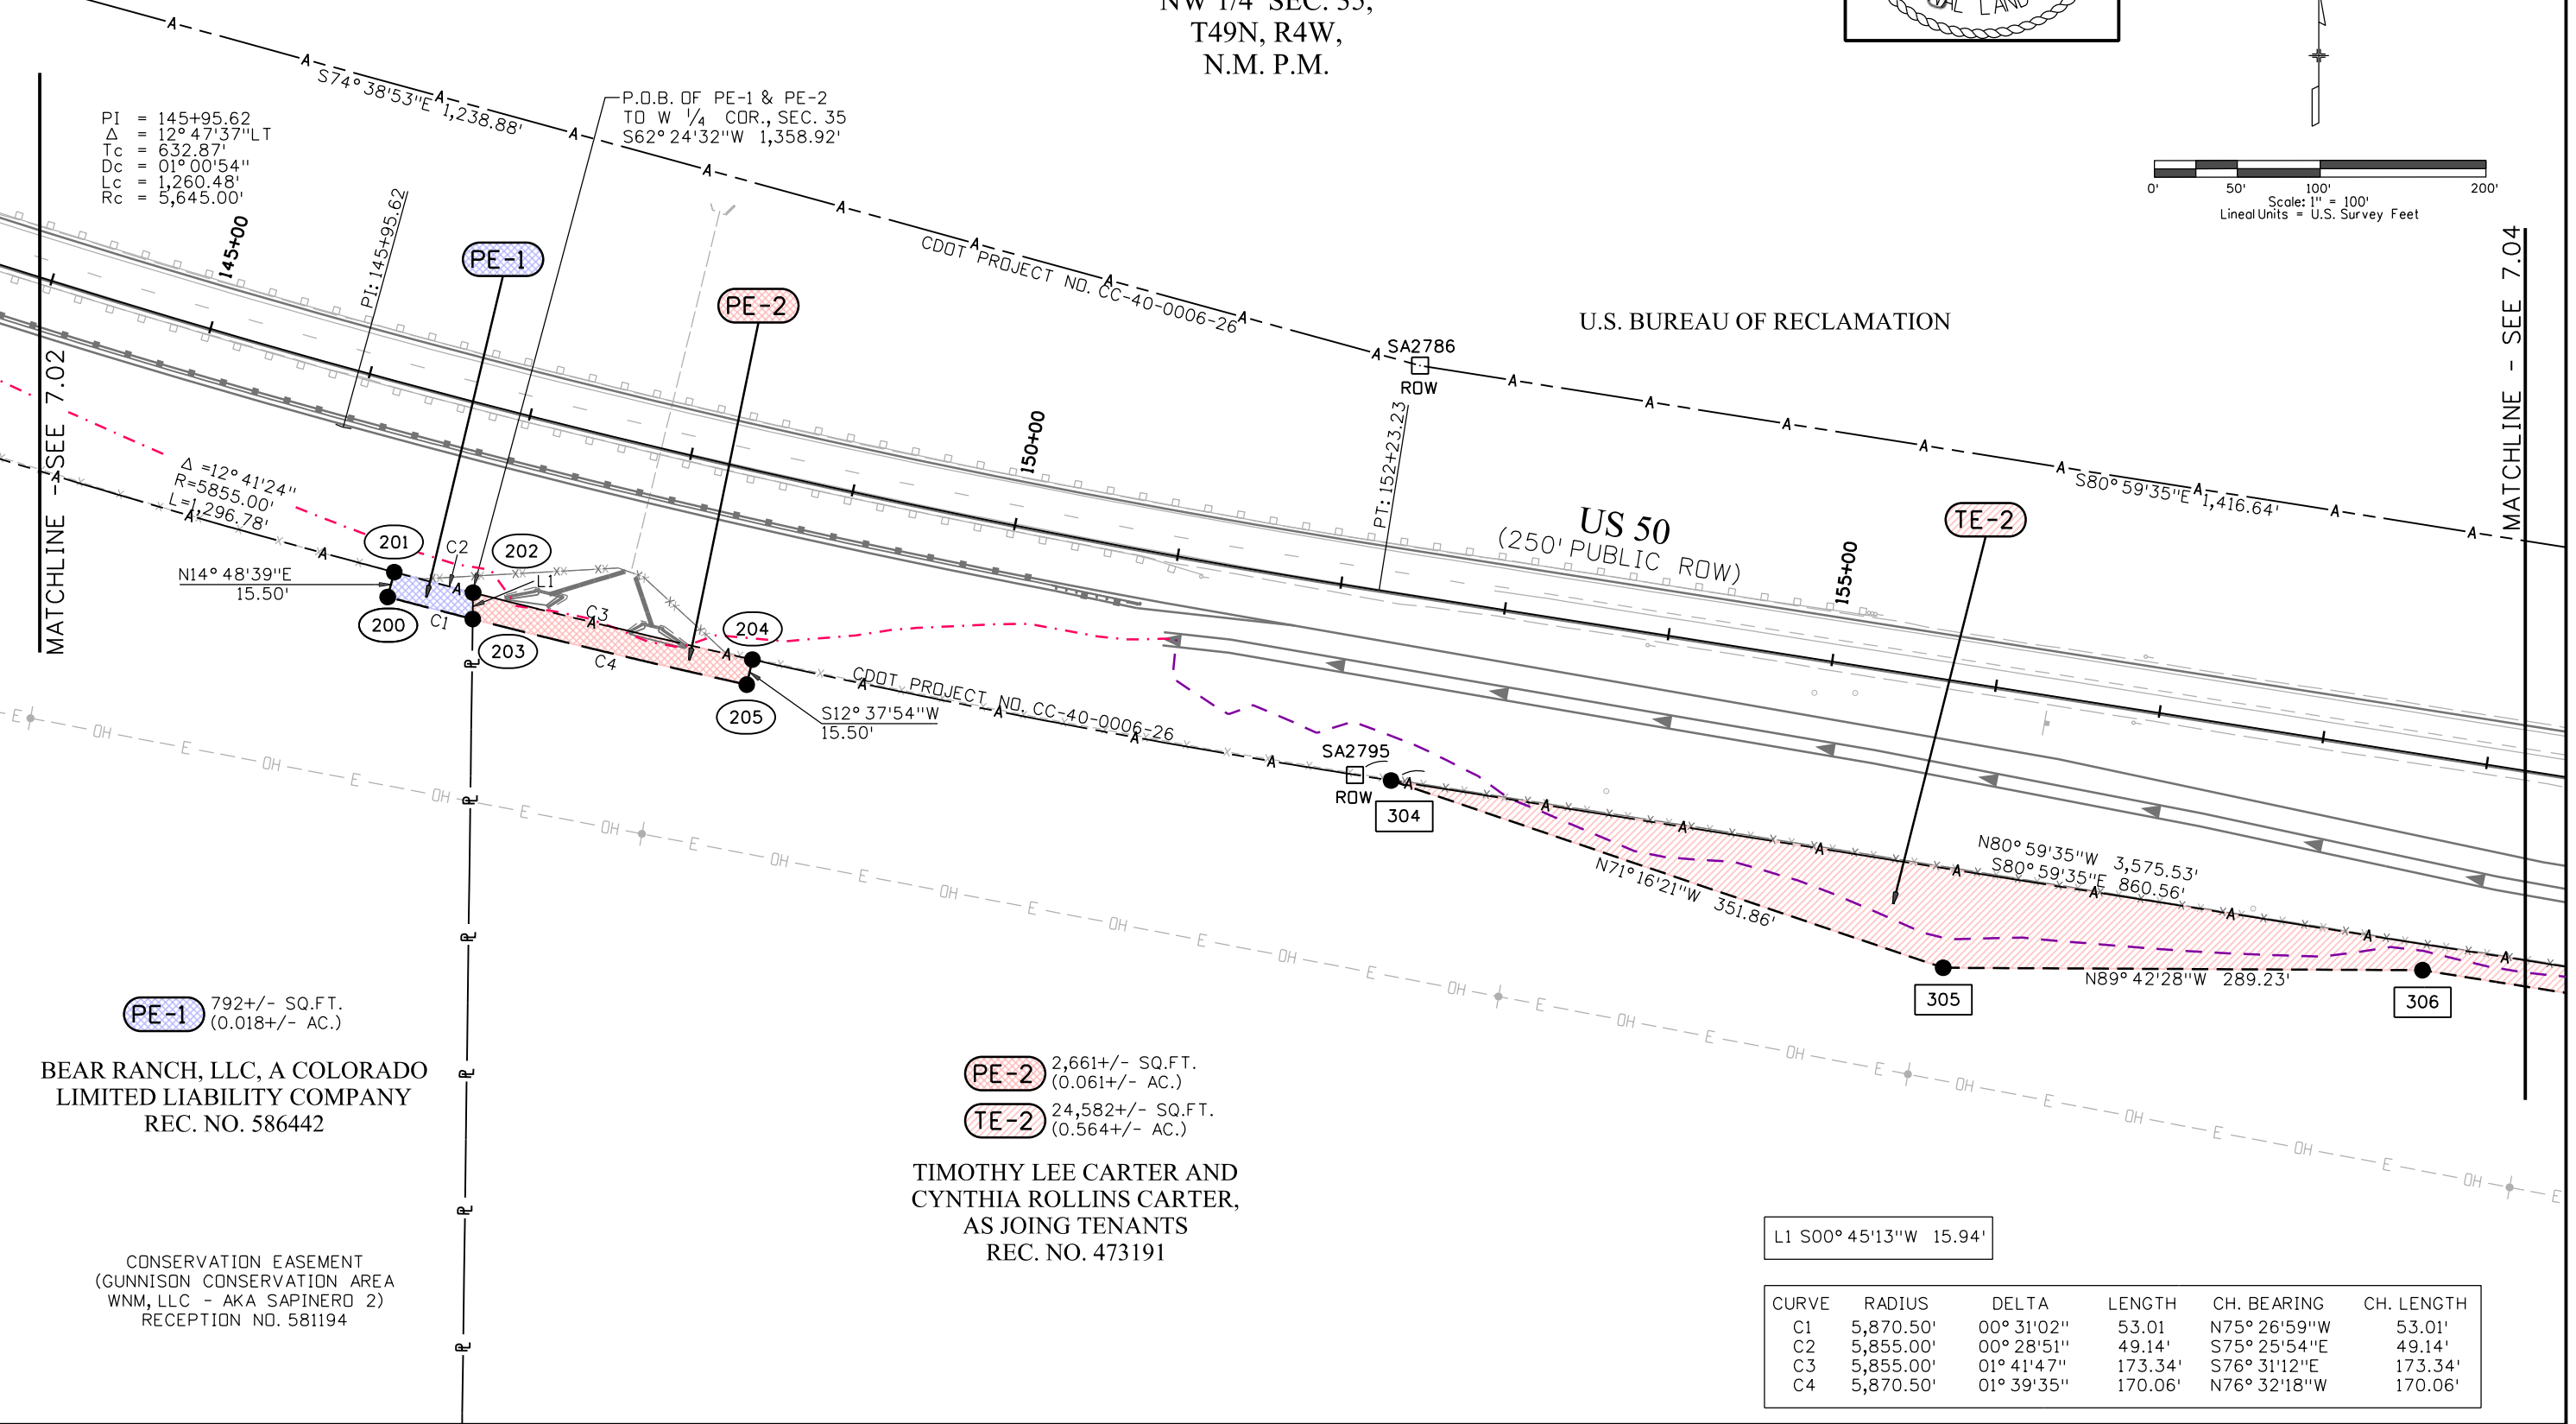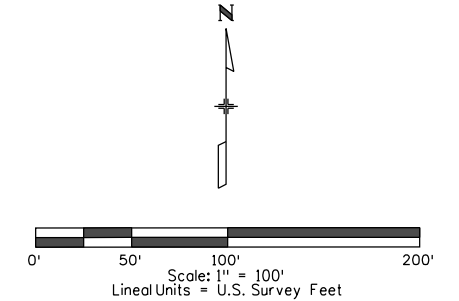

L1 S00° 45'13"W 15.94'

CURVE	RADIUS	DELTA	LENGTH	CH. BEARING	CH. LENGTH
C1	5,870.50'	00° 31'02"	53.01	N75° 26'59"W	53.01'
C2	5,855.00'	00° 28'51"	49.14'	S75° 25'54"E	49.14'
C3	5,855.00'	01° 41'47"	173.34'	S76° 31'12"E	173.34'
C4	5,870.50'	01° 39'35"	170.06'	N76° 32'18"W	170.06'

2/22/2022 cprbbie 3:22:46 PM P:_P20 Projects\23557 ROW Survey\Drawings\703-23557 SURV ROW_Plan_03.dgn

Colorado Department of Transportation



222 South 6th Street
Room 317
Grand Junction, CO 81501
Phone: 970-683-6236
FAX: 970-683-6227

Region 3

JMK



6501 E. Belview Ave. Suite 300
Englewood CO 80111
Tel: (720) 259-9323
SURVEY/MAPPING UTILITY/SUE REAL ESTATE

Sheet Revisions


Date	Description	Initials

Sheet Revisions

Date	Description	Initials

Sheet Revisions

Date	Description	Initials

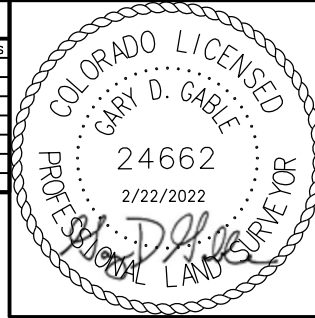


Right of Way Plans


Plan Sheet

Project Number: NHPP-0502-090			
Project Location: US Highway 50 Passing Lanes			
MP 134.6 to 136.0			
Project Code: 23557	Last Mod. Date: 02-11-2022	Subset: 7.01 to 7.05	Sheet No.: 7.04

NE 1/4 SEC. 35,
T49N, R4W,
N.M. P.M.

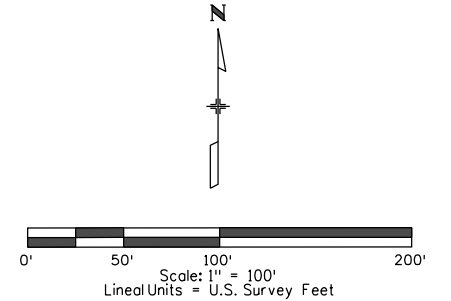

2/22/2022 cprbble 3:22:47 PM P:_P20 Projects\VP200172 - MEC-CDOT US 50 Passing Lane ROW Survey\Drawings\704-23557\SURV_ROW_Plan_04.dgn

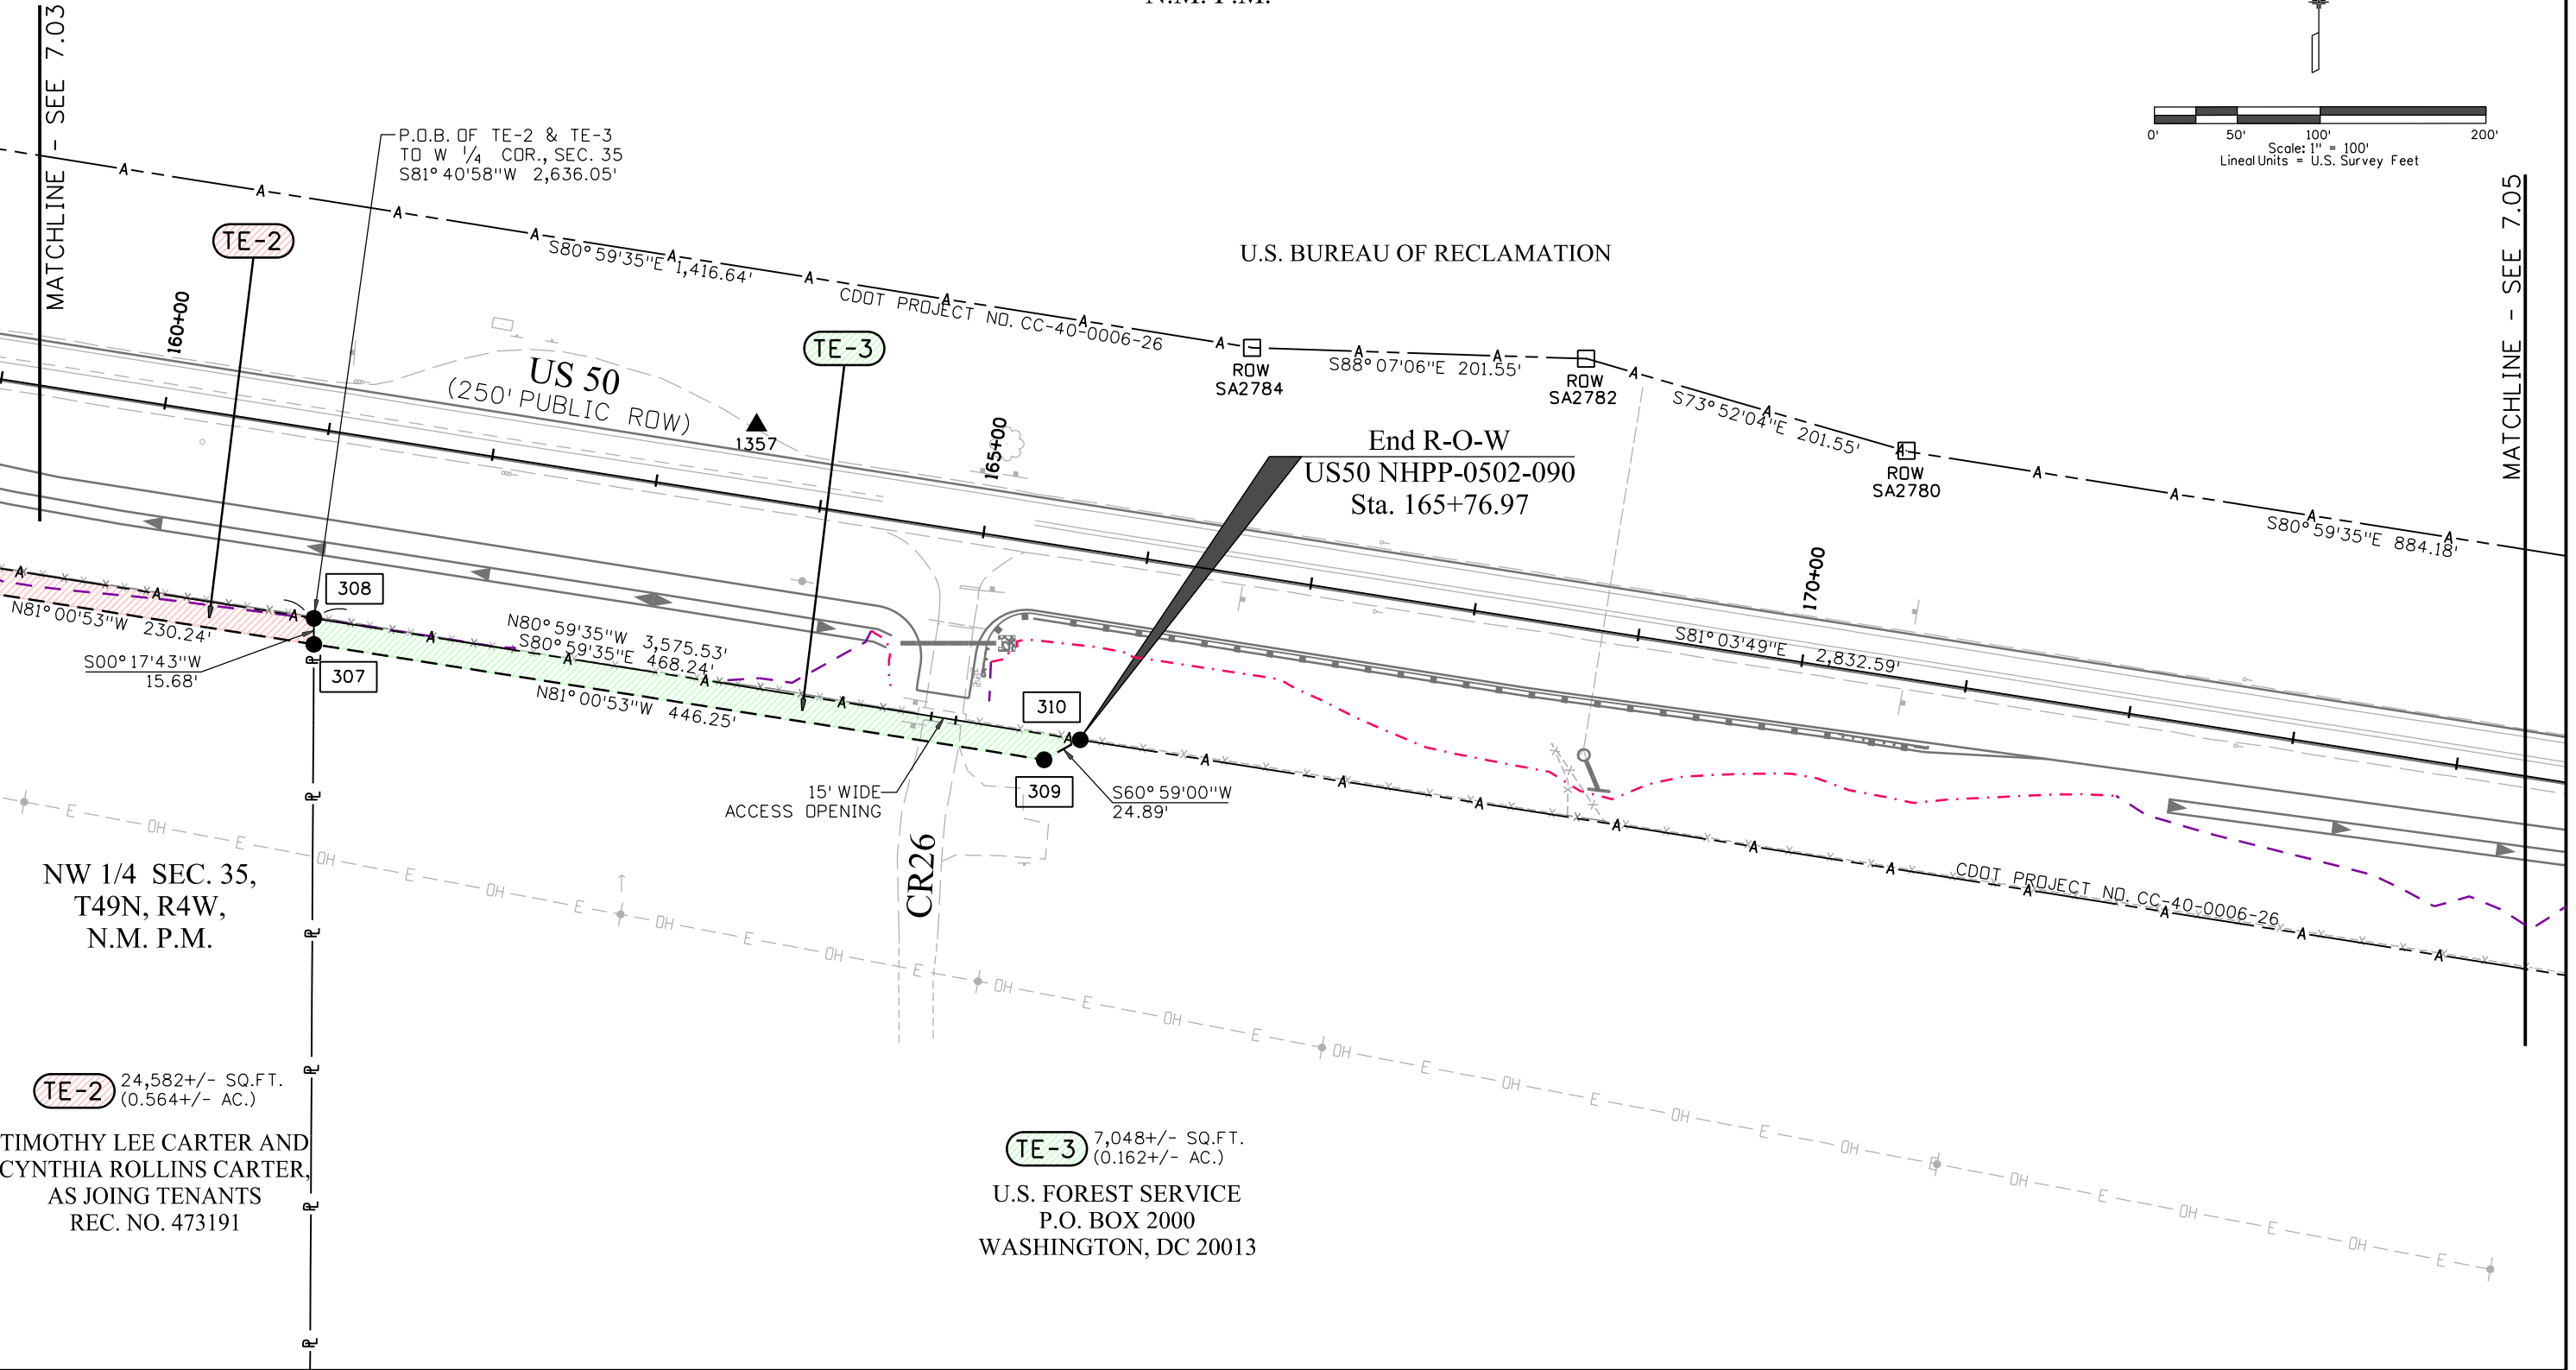

NW 1/4 SEC. 35,
T49N, R4W,
N.M. P.M.

TIMOTHY LEE CARTER AND
CYNTHIA ROLLINS CARTER,
AS JOING TENANTS
REC. NO. 473191

U.S. FOREST SERVICE
P.O. BOX 2000
WASHINGTON, DC 20013

Colorado Department of Transportation

222 South 6th Street
Room 317
Grand Junction, CO 81501
Phone: 970-683-6236
FAX: 970-683-6227

Region 3

JMK



6501 E. Belview Ave. Suite 300
Englewood CO 80111
Tel: (720) 259-9323
SURVEY/MAPPING UTILITY/SUE REAL ESTATE

Sheet Revisions


Date	Description	Initials

Sheet Revisions

Date	Description	Initials

Sheet Revisions

Date	Description	Initials

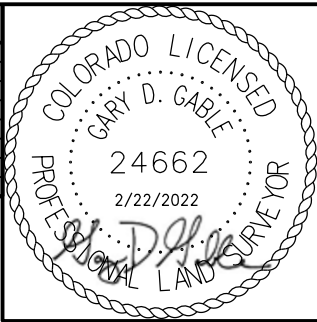


Right of Way Plans

Plan Sheet

Project Number: NHPP-0502-090			
Project Location: US Highway 50 Passing Lanes			
MP 134.6 to 136.0			
Project Code: 23557	Last Mod. Date: 02-11-2022	Subset: 7.01 to 7.05	Sheet No.: 7.05

NE 1/4 SEC. 35,
T49N, R4W,
N.M. P.M.

MATCHLINE - SEE 7.04

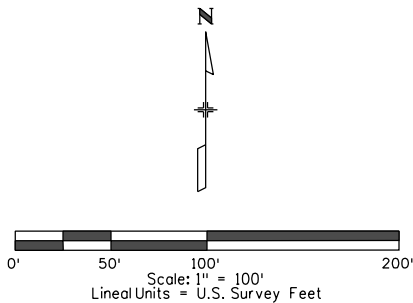

U.S. BUREAU OF RECLAMATION

End Constructioin
US50 NHPP-0502-090
Sta. 188+00.00

PI = 186+76.00
Δ = 64°39'16"LT
Tc = 620.18'
Dc = 05°50'47"
Lc = 1,105.87'
Rc = 980.00'

US 50
(250' PUBLIC ROW)

ROW
SA2777


PC: 180+55.82

1360


U.S. FOREST SERVICE

EAST LINE NE 1/4 SEC. 35

SA2775
ROW

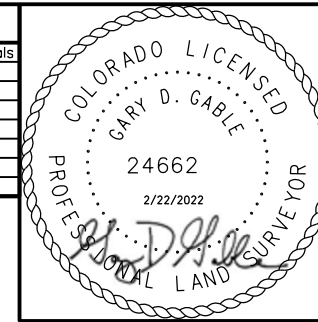[illegible]

Right of Way Plans			
Ownership Map			
Project Number: NHPP-0502-090			
Project Location: US Highway 50 Passing Lanes			
MP 134.6 to 136.0			
Project Code:	Last Mod. Date	Subest	Sheet No.
23552	03-11-2022	8.01 to 8.01	8.01

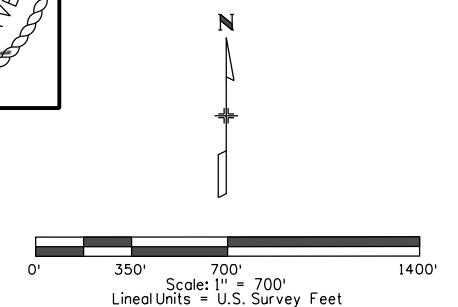

NW 1/4 SEC. 35,
T49N, R4W,
N.M. P.M.

PE-1 TE-1

BEAR RANCH, LLC, A COLORADO
LIMITED LIABILITY COMPANY
1601 FORUM PLACE, SUITE 307
WEST PALM BEACH, FL 33401

PE-2 TE-2

TIMOTHY LEE CARTER AND
CYNTHIA ROLLINS CARTER,
AS JOINT TENANTS
605 NORTH TAYLOR STREET
GUNNISON, CO 81230

TE-3
U.S. FOREST SERVICE
P.O. BOX 2000
WASHINGTON, DC 20013

NE 1/4 SEC. 35,
T49N, R4W,
N.M. P.M.

