

COLORADO DEPARTMENT OF TRANSPORTATION



Region 1
18500 E. Colfax Avenue
Aurora, CO 80011
Phone: (303) 757-9117 FAX: (303) 757-9746

Right-of-Way and Survey Unit: Kevin A. Williams

Sheet Revisions

Date	Description	Initials
3/7/05	Revised sheets 2, 2A, 4, 4A, 4C, 13, 14, 15, 16, 19 & 20	BDL
4/25/05	Revised sheets 2A, 4, 14 & 19	BDL
5/02/05	Revised sheets 13, 14 & 19	BDL
5/11/05	Revised sheet 14	BDL
2/02/07	Revised sheet's 2A, 2B, 13, 14, 19, & 20	HLS

Sheet Revisions

Date	Description	Initials

Prepared By:

URS

URS Corporation
8181 East Tufts Ave. Denver, CO 80237
Phone: (303)694-2770 Fax: (303) 694-3946

Computer File
Information


CREATION DATE: 11/18/2004 INITIALS: BDL
LAST MOD. DATE: 2/02/2007 INITIALS: HLS
DRAWING NAME & FULL PATH: SEE LEFT
SIDE OF SHEET
SCALE: As Shown UNITS: English

Right of Way Plans

TITLE SHEET

Project Number: NH 0852-086 Phase IV (ROW) / NH 0852-097 (Const.) (P.C. 15139)
Project Location: SH 85, Meadows to C470
Project Location: Louviers South to Sedalia / M.P. 194.0 to M.P. 190.6
Project Code: 13429
Subset Sheets: 1 of 1
Sheet No.: 1
Total No. of Sheets: 43

CONVENTIONAL SIGNS

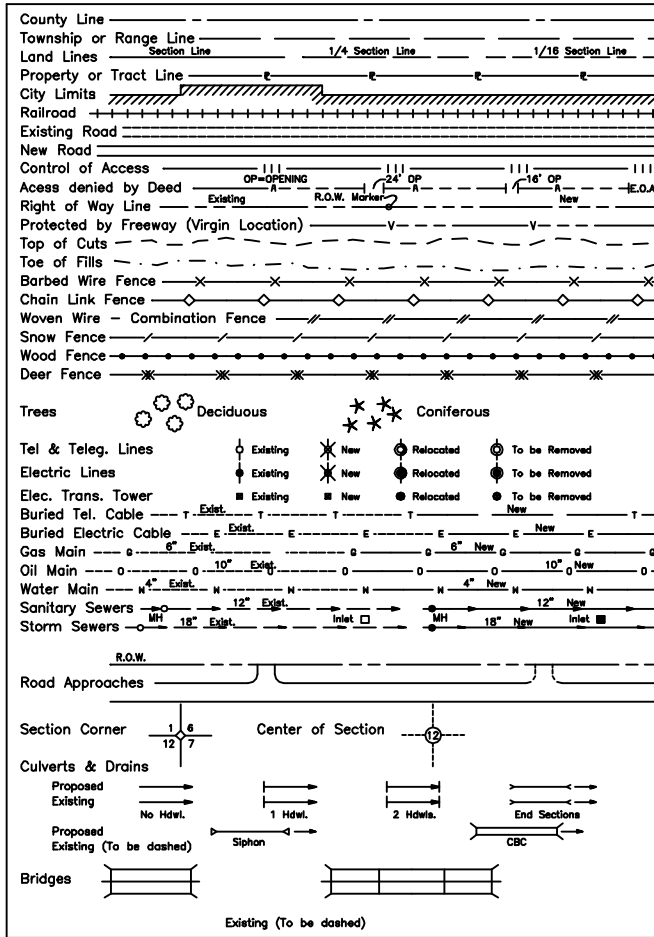

Survey Control Diagram
prepared by Mountain
Surveying & Mapping, Inc.
Sheets 3-3N

Rec.# _____
Douglas County Clerk and
Recorder

All Measurements Are In English Units
Unless Otherwise Noted

BASIS OF BEARINGS

BASIS OF BEARINGS: Bearings used in the calculations of coordinates are based on a grid bearing of N30°49'24"W from SH-85 CM-MP 196.80 and SH-85 CM-MP 197.00. Both monuments are CDOT Type II, marked appropriately for their milepost location and control position. The survey data was obtained from a Global Positioning System (GPS) survey based on the Colorado High Accuracy Reference Network (CHARN).

SH-85 CM-MP 196.80 N30°49'24"W SH-85 CM-MP 197.00

Date: February, 2005
Region 1
Project Code: 13429

DEPARTMENT OF TRANSPORTATION
STATE OF COLORADO


RIGHT OF WAY PLAN OF PROPOSED
FEDERAL AID PROJECT NO. NH 0852-086 Phase IV
STATE HIGHWAY NO. US 85
DOUGLAS COUNTY
RIGHT OF WAY

INDEX OF SHEETS

Subsets	Sheet Nos.
Title Sheet	1 (1)
Tabulation of Properties	2 - 2C (4)
Survey Control Diagram	3 - 3N (15)
Monumentation Sheets	4 - 4F (7)
Plan Sheets	5 - 16 (12)
Ownership Sheets	17 - 20 (4)
Total Number of Sheets	(43)

SCALES OF ORIGINAL 11x17 DRAWINGS

PLAN SHEETS 1"=100'
OWNERSHIP MAP 1"=400'
R.O.W. LENGTH OF PROJECT = 1.3 Miles
Const. LENGTH OF PROJECT = 1.3 Miles

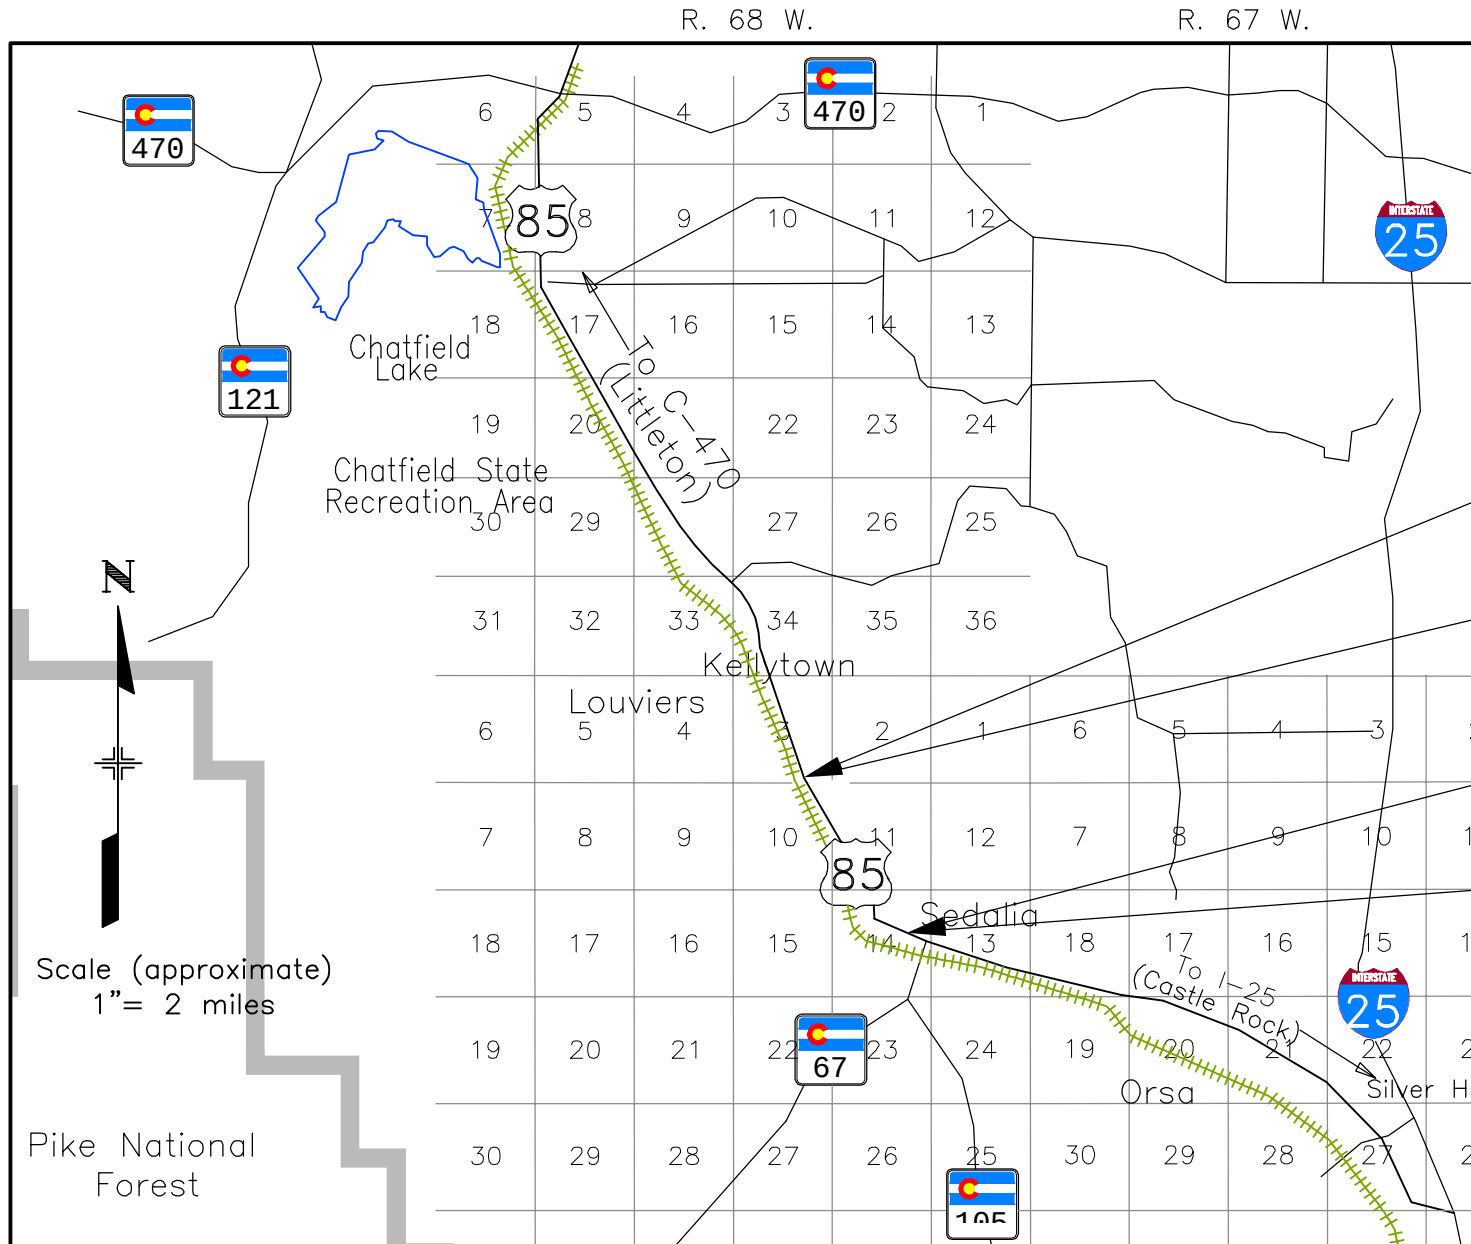

Beginning of Right of Way
Project NH 0852-086 Phase IV
Station: 454+86.02
M.P.: 192.1

Beginning of Construction
Project NH 0852-097
Project Code: 15139
M.P.: 192.1

End of Construction Project
NH 0852-097
Project Code: 15139
M.P.: 190.8

End of Right of Way Project
NH 0852-086 Phase IV
Station: 518+81.72
M.P.: 190.8

DEPARTMENT OF TRANSPORTATION
FEDERAL HIGHWAY ADMINISTRATION

AUTHORIZED: _____ DATE _____

DIVISION ADMINISTRATOR

COLORADO DEPARTMENT OF TRANSPORTATION  Region 1 18500 E. Colfax Avenue Aurora, CO 80011 Phone: (303) 757-9117 FAX: (303) 757-9746 Right-of-Way and Survey Unit: Kevin A. Williams	Sheet Revisions		Sheet Revisions		Prepared By: URS URS Corporation 8181 East Tufts Ave. Denver, CO 80237 Phone: (303)694-2770 Fax: (303) 694-3946	Computer File Information CREATION DATE: 12/1/2005 INITIALS: TWS LAST MOD. DATE: 3/2/2005 INITIALS: TWS DRAWING NAME & FULL PATH: SEE LEFT SIDE OF SHEET SCALE: As Shown UNITS: English	Right of Way Plans TABULATION OF PROPERTIES						
	Date	Description	Initials	Date			Description	Initials	Project Number: NH 0852-086 Phase IV (ROW) / NH 0852-097 (Const.) (P.C. 15139)				
	02/24/05	Revised Parcels 158 & 161	TWS						Project Location: SH 85, Meadows to C470				
									Project Location: Louviers South to Sedalia / M.P. 194.0 to M.P. 190.6				
									Project Code: Subset Sheets Sheet No. Total No. of Sheets				
							13429		1 of 4	2	43		

R.O.W. TABULATION OF PROPERTIES IN DOUGLAS COUNTY

S.H. NO. 85

PARCEL NO.	OWNER	ADDRESS	LOCATION	AREA IN SQUARE FEET (sf) / ACRES (ac)					BOOK-PAGE	REMARKS
				AREA OF PARCEL	EXISTING ROW	NET AREA	REMAINDER			
							LEFT	RIGHT		
			T. 7 S., R. 68 W., 6th P.M.							
157	William D. Henry & Diane D. Henry	P.O. Box 365	Tract in SW 1/4 Sec. 11	162,328 sf		162,328 sf	718,181 sf			
	Commitment # 02378A2004	6490 W. Hwy. 85		3.73 ac		3.73 ac	16.49 ac			
	Site Address	Sedalia, CO. 80135								
		303-688-2332								
TE-157	(Same as above)	(Same as above)	(Same as above)	5,400 sf		5,400 sf	718,181 sf			Temporary Easement Acquired for Driveway
				0.12 ac		0.12 ac	16.49 ac			access reconstruction
AC-157	(Same as above)	(Same as above)	(Same as above)							
158 REV	Clayton S. Thomas	6222 N. U.S. Hwy 85	(Same as above)	53,122 sf		53,122 sf	822,887 sf			
	Commitment # 02377A2004	Sedalia, CO 80135		1.22 ac		1.22 ac	18.89 ac			
	Site Address	303-688-3821								
TE-158	(Same as above)	(Same as above)	(Same as above)	21,587 sf		21,587 sf	822,887 sf			Temporary Easement Acquired for Driveway
				0.50 ac		0.50 ac	18.89 ac			access reconstruction
AC-158	(Same as above)	(Same as above)	(Same as above)							
161 REV	Steven Blohm & Florence Blohm	6200 N. Hwy 85	Tract in the NW 1/4 Sec. 14	33,670 sf		33,670 sf	379,947 sf			
	Commitment # 02362A2004	Sedalia, CO. 80135		0.77 ac		0.77 ac	8.72 ac			
	Site Address	303-660-6245								
TE-161	(Same as above)	(Same as above)	(Same as above)	22,164 sf		22,164 sf	379,947 sf			Temporary Easement Acquired for Driveway
				0.51 ac		0.51 ac	8.72 ac			access reconstruction
AC-161	(Same as above)	(Same as above)	(Same as above)							

FILING CERTIFICATION: _____, 19____, AT _____M., FOR INFORMATION
DEPOSITED THIS _____ DAY OF _____ OF THE COUNTY LAND SURVEYS/RIGHT OF WAY
ONLY IN BOOK _____, RECEPTION NUMBER _____
SIGNED _____
DEPT. _____

I:\PROJECTS\2227041_SUBS_Sof_Titan\Sedalia_North\6.07_Right_Lof_Way\Plans\TabSheet.dwg 3/4/2005 11:30:58 AM MST

FILING CERTIFICATION:
DEPOSITED THIS _____ DAY OF _____, 19____, AT _____M., FOR INFORMATION
ONLY IN BOOK _____ OF THE COUNTY LAND SURVEYS/RIGHT OF WAY
SURVEYS AT PAGE _____, RECEPTION NUMBER _____
SIGNED _____
DEPT. _____

COLORADO DEPARTMENT OF TRANSPORTATION			Sheet Revisions <table><tr><th>Date</th><th>Description</th><th>Initials</th></tr><tr><td>3/2/05</td><td>Revised TE-163, TE-164 & AC-164</td><td>BOL</td></tr><tr><td>4/25/05</td><td>Deleted PE-165</td><td>BOL</td></tr><tr><td>02/02/07</td><td>Name change on TE-162, TE-163 REV, and TE-165.</td><td>HLS</td></tr><tr><td> </td><td> </td><td> </td></tr><tr><td> </td><td> </td><td> </td></tr><tr><td> </td><td> </td><td> </td></tr><tr><td> </td><td> </td><td> </td></tr></table>			Date	Description	Initials	3/2/05	Revised TE-163, TE-164 & AC-164	BOL	4/25/05	Deleted PE-165	BOL	02/02/07	Name change on TE-162, TE-163 REV, and TE-165.	HLS													Sheet Revisions <table><tr><th>Date</th><th>Description</th><th>Initials</th></tr><tr><td> </td><td> </td><td> </td></tr><tr><td> </td><td> </td><td> </td></tr><tr><td> </td><td> </td><td> </td></tr><tr><td> </td><td> </td><td> </td></tr><tr><td> </td><td> </td><td> </td></tr><tr><td> </td><td> </td><td> </td></tr><tr><td> </td><td> </td><td> </td></tr></table>			Date	Description	Initials																						Prepared By: URS URS Corporation 8181 East Tufts Ave. Denver, CO 80237 Phone: (303)694-2770 Fax: (303) 694-3946		Computer File Information CREATION DATE: 12/1/2005 INITIALS: TWS LAST MOD. DATE: 02/02/07 INITIALS: LS DRAWING NAME & FULL PATH: SEE LEFT SIDE OF SHEET SCALE: As Shown UNITS: English		Right of Way Plans TABULATION OF PROPERTIES Project Number: NH 0852-086 Phase IV (ROW) / NH 0852-097 (Const.) (P.C. 15139) Project Location: SH 85, Meadows to C470 Project Location: Louviers South to Sedalia / M.P. 194.0 to M.P. 190.6 Project Code: Subset Sheets Sheet No. Total No. of Sheets 13429 2 of 4 2A 43			
Date	Description	Initials																																																														
3/2/05	Revised TE-163, TE-164 & AC-164	BOL																																																														
4/25/05	Deleted PE-165	BOL																																																														
02/02/07	Name change on TE-162, TE-163 REV, and TE-165.	HLS																																																														
Date	Description	Initials																																																														
R.O.W. TABULATION OF PROPERTIES IN DOUGLAS COUNTY S.H. NO. 85																																																																
PARCEL NO.	OWNER	ADDRESS	LOCATION	AREA IN SQUARE FEET (sf) / ACRES (ac)					BOOK-PAGE	REMARKS																																																						
				AREA OF PARCEL	EXISTING ROW	NET AREA	REMAINDER LEFT RIGHT																																																									
			T. 7 S., R. 68 W., 6th P.M.																																																													
162	Charles W. Smith & M. Eleanore Smith	P.O. Box 105	Tract in NW 1/4 of Sec.14	32,032 sf		32,032 sf	194,493 sf																																																									
	Commitment # 02361A2004	6142 N. Hwy 85		0.74 ac		0.74 ac	4.46 ac																																																									
	Not Site Address	Sedalia, CO 80135																																																														
		303-688-4233																																																														
TE-162	Sedalia Land Company, a Colorado	5970 N. Hwy 85	(Same as above)	367 sf		367 sf	194,493 sf			Temporary Easement Acquired for Driveway																																																						
	Corporation	Sedalia, CO 80135		0.01 ac		0.01 ac	4.46 ac			access reconstruction. TE-162 to be																																																						
										acquired from the new owner of the 162																																																						
AC-162	(Same as above)	(Same as above)	(Same as above)							ownership.																																																						
163	Edward J. Flynn & Elsie M. Flynn	6090 N. U.S. Hwy 85	(Same as above)	12,573 sf		12,573 sf	281,291 sf																																																									
	Commitment # 02360A2004	Sedalia, CO. 80135		0.29 ac		0.29 ac	6.46 ac																																																									
	Site Address	303-688-3566																																																														
TE-163 REV	Sedalia Land Company, a Colorado	5970 N. Hwy 85	(Same as above)	3,374 sf		3,374 sf	281,291 sf			Temporary Easement Acquired for Driveway																																																						
	Corporation	Sedalia, CO 80135		0.08 ac		0.08 ac	6.46 ac			access reconstruction. TE-163 Rev to be																																																						
AC-163	(Same as above)	(Same as above)	(Same as above)							acquired from the new owner of the 163																																																						
										ownership.																																																						
164	Woodson Adair & Wilmina Adair	6046 N. Hwy 85	(Same as above)	65,028 sf		65,028 sf	154,202 sf																																																									
	Commitment # 02359A2004	Sedalia, CO. 80135		1.49 ac		1.49 ac	3.54 ac																																																									
		303-688-4555																																																														
TE-164 REV	(Same as above)	(Same as above)	(Same as above)	16,491 sf		16,491 sf	154,202 sf			Temporary Easement Acquired for Driveway																																																						
				0.38 ac		0.38 ac	3.54 ac			access reconstruction																																																						
AC-164 REV	(Same as above)	(Same as above)	(Same as above)																																																													
PE-165	Deleted																																																															
TE-165	Mary Kathryn Griffin	5557 N. Hwy 85 PO Box	(Same as above)	2,004		2,004 sf		155,991 sf		Temporary Easement Acquired for Driveway																																																						
	Commitment # 02363A2004	284 Sedalia CO. 80135		0.05 ac		0.05		3.58 ac		access reconstruction																																																						

FILING CERTIFICATION: _____, 19____, AT _____M., FOR INFORMATION
 DEPOSITED THIS _____ DAY OF _____ OF THE COUNTY LAND SURVEYS/RIGHT OF WAY
 ONLY IN BOOK _____, RECEPTION NUMBER _____
 SIGNED _____
 DEPT. _____

COLORADO DEPARTMENT OF TRANSPORTATION  Region 1 18500 E. Colfax Avenue Aurora, CO 80011 Phone: (303) 757-9117 FAX: (303) 757-9746 Right-of-Way and Survey Unit: Kevin A. Williams			Sheet Revisions <table> <tr> <th>Date</th> <th>Description</th> <th>Initials</th> </tr> <tr> <td>02/02/07</td> <td>Name change on AC-165, and TE-165A</td> <td>HLS</td> </tr> <tr><td> </td><td> </td><td> </td></tr> <tr><td> </td><td> </td><td> </td></tr> <tr><td> </td><td> </td><td> </td></tr> <tr><td> </td><td> </td><td> </td></tr> <tr><td> </td><td> </td><td> </td></tr> <tr><td> </td><td> </td><td> </td></tr> </table>			Date	Description	Initials	02/02/07	Name change on AC-165, and TE-165A	HLS																			Sheet Revisions <table> <tr> <th>Date</th> <th>Description</th> <th>Initials</th> </tr> <tr><td> </td><td> </td><td> </td></tr> <tr><td> </td><td> </td><td> </td></tr> <tr><td> </td><td> </td><td> </td></tr> <tr><td> </td><td> </td><td> </td></tr> <tr><td> </td><td> </td><td> </td></tr> <tr><td> </td><td> </td><td> </td></tr> <tr><td> </td><td> </td><td> </td></tr> </table>			Date	Description	Initials																						Prepared By:  URS Corporation 8181 East Tufts Ave. Denver, CO 80237 Phone: (303)694-2770 Fax: (303) 694-3946		Computer File Information CREATION DATE: 12/1/2005 INITIALS: TWS LAST MOD. DATE: 2/12/2007 INITIALS: SKV DRAWING NAME & FULL PATH: SEE LEFT SIDE OF SHEET SCALE: As Shown UNITS: English		Right of Way Plans TABULATION OF PROPERTIES Project Number: NH 0852-086 Phase IV (ROW) / NH 0852-097 (Const.) (P.C. 15139) Project Location: SH 85, Meadows to C470 Project Location: Louviers South to Sedalia / M.P. 194.0 to M.P. 190.6 <table> <tr> <td>Project Code:</td> <td>Subset Sheets</td> <td>Sheet No.</td> <td>Total No. of Sheets</td> </tr> <tr> <td>13429</td> <td>3 of 4</td> <td>28</td> <td>43</td> </tr> </table>				Project Code:	Subset Sheets	Sheet No.	Total No. of Sheets	13429	3 of 4	28	43
Date	Description	Initials																																																																						
02/02/07	Name change on AC-165, and TE-165A	HLS																																																																						
Date	Description	Initials																																																																						
Project Code:	Subset Sheets	Sheet No.	Total No. of Sheets																																																																					
13429	3 of 4	28	43																																																																					
R.O.W. TABULATION OF PROPERTIES IN DOUGLAS COUNTY S.H. NO. 85																																																																								
PARCEL NO.	OWNER	ADDRESS	LOCATION	AREA IN SQUARE FEET (sf) / ACRES (ac)					BOOK-PAGE	REMARKS																																																														
				AREA OF PARCEL	EXISTING ROW	NET AREA	REMAINDER																																																																	
							LEFT	RIGHT																																																																
			T. 7 S., R. 68 W., 6th P.M.																																																																					
TE-165A	Mary Kathryn Griffin	5557 N. Hwy 85 PO Box	Tract in NW 1/4 of Sec.14	360 sf		360 sf		155,991 sf		Temporary Easement Acquired for Driveway																																																														
	Commitment # 02363A2004	284 Sedalia CO. 80135		0.01 ac		0.01		3.58 ac		access reconstruction																																																														
AC-165	(Same as above)	(Same as above)	(Same as above)																																																																					
166	Sedalia Land Company	3773 Cherry Creek Drive	Tract in SE 1/4 of Sec.14	6,040 sf		6,040 sf		339,060 sf																																																																
	Commitment # 02357A2004	North Suite 801		0.14 ac		0.14 ac		7.78 ac																																																																
	Not site address	Denver, CO. 80209																																																																						
PE-166	(Same as above)	(Same as above)	Tract in NW 1/4 of Sec.14	600 sf		600 sf		339,060 sf		Permanent Easement Acquired for the																																																														
				0.01 ac		0.01 ac		7.78 ac		construction and maintenance of drainage																																																														
										facilities																																																														
TE-166	(Same as above)	(Same as above)	Tract in SW 1/4 of Sec.14	39,339 sf		39,339 sf		339,060 sf		Temporary Easement Acquired for Driveway																																																														
				0.90 ac		0.90 ac		7.78 ac		access reconstruction																																																														
AC-166	(Same as above)	(Same as above)	Tract in W 1/2 of Sec.14																																																																					
TE-167	John Delva & Marguerite Delva	6240 Meadowbrook Lane	Tract in NW 1/4 of Sec. 14	971 sf		971 sf	1,615,413 sf			Temporary Easement Acquired for Driveway																																																														
	Commitment # 02358A2004	Sedalia, CO. 80135		0.02 ac		0.02 ac	37.08 ac			access reconstruction																																																														
	Not site address	303-688-6342																																																																						
AC-167	(Same as above)	(Same as above)	Tract in North 1/2 & SE																																																																					
			1/4 of Sec. 14																																																																					
AC-167A	(Same as above)	(Same as above)	Tract in E 1/2 of Sec. 14																																																																					
TE-169	The Intermountain Rural Electric Association	5496 N. U. S. 85	(Same as above)	16,066 sf		16,066 sf	1,524,287 sf			Temporary Easement Acquired for Driveway																																																														
	Commitment # 01040A2003	Sedalia, CO. 80135		0.37 ac		0.37 ac	34.99 ac			access reconstruction																																																														
	Site address	303-688-3100																																																																						
AC-169	(Same as above)	(Same as above)	(Same as above)																																																																					



Region 1
18500 E. Colfax Avenue
Aurora, CO 80011
Phone: (303) 757-9117 FAX: (303) 757-9746

Right-of-Way and Survey Unit: Kevin A. Williams

[illegible][illegible]

Prepared By:



URS Corporation
8181 East Tufts Ave. Denver, CO 80237
Phone: (303)694-2770 Fax: (303) 694-3946

Computer File Information	
CREATION DATE: 12/1/2005	INITIALS: TV
LAST MOD. DATE: 2/1/2005	INITIALS: TV
DRAWING NAME & FULL PATH: SEE LEFT SIDE OF SHEET	
SCALE: As Shown UNITS: English	

Right of Way Plans				
TABULATION OF PROPERTIES				
VS	Project Number: NH 0852-086 Phase IV (ROW) / NH 0852-097 (Const.) (P.C. 15139)			
	Project Location: SH 85, Meadows to C470			
	Project Location: Louviers South to Sedalia / M.P. 194.0 to M.P. 190.6			
	Project Code:	Subset Sheets	Sheet No.	Total No. of Sheets
	13429	4 of 4	2C	43

R.O.W. TABULATION OF PROPERTIES IN DOUGLAS COUNTY

S.H. NO. 85

[illegible]

FILING CERTIFICATION:
DEPOSITED THIS ____ DAY OF _____, 19____, AT ____M., FOR INFORMATION
ONLY IN BOOK _____ OF THE COUNTY LAND SURVEYS/RIGHT OF WAY
SURVEYS AT PAGE _____ RECEPTION NUMBER _____

SIGNED _____
DEPT. _____

3/4/2005 11:30:58 AM MST

COLORADO DEPARTMENT OF TRANSPORTATION



Region 1
18500 East Colfax Avenue
Aurora, Colorado 80011
Phone: (303) 757-9744 FAX: (303) 757-9746

Survey Unit:

Sheet Revisions		
mm/yy	XXXXX	XXX

US HIGHWAY 85 MP 187.00 to MP 200.00
SURVEY CONTROL DIAGRAM

Prepared By:
Mountain Surveying & Mapping, Inc.
8751 E. Hampden Ave. Suite B-1
Denver, CO (303) 306-1858

Survey Control Diagram

Title Sheet

Project Number: IM-0252-317

Project Location: US HIGHWAY 85

Project Location:

Project Code:	Last Mod. Date	Subset Sheets	Sheet No.	Total No. of Sheets
12255	08-24-01	1 of 15	3	3 of 20



Typical Control
Mounment Cap
Not to Scale

BASIS OF BEARINGS: Bearings used in the calculations of coordinates are based on a grid bearing of N 30°49'24" W from SH 85 CM-MP 196.80 and SH 85 CM-MP 197.00 as obtained from a Global Positioning System (GPS) survey based on the Colorado High Accuracy Reference Network (CHARN).

BASIS OF ELEVATIONS: Project is based on NOAA Bench Mark K 23 1929, PID: KK0203 a standard Bench Mark Disk set on top of a concrete monument, with an NAVD 88 elevation of 5984.83. K 23 is a first order benchmark.

COORDINATE DATUM: Coordinates on this project are for the exlusive use of the CDOT for the construction of this project and are considered Project Coordinates only.



CP - Control Point Monuments set by CDOT. They were CDOT type 2 monuments, a 3-1/4" dia. aluminum control monument cap (as shown) on a 3' X 3/4" dia. finned aluminum security rod on a 3' X 3/4" dia. smooth aluminum rod.

NOTE: This control survey is for the use of the Colorado Department of Transportation personnel. The survey is not a complete Boundary Survey. Title Policy, Title Commitment, and Title Research were not part of this control survey, therefore, easements, rights, and restrictions of record are not shown. The verification of the physical evidence with relation to easements, rights of way, property boundaries, and restriction, as described in the instruments of record, were not included in this control survey.

NOTE: According to Colorado law you must commence any legal action based upon any defect in this survey within three years after you first discover such defect. In no event may any action based upon any defect in this survey be commenced more than ten years from the date of the statement shown.

NOTE: No guarantee as to the accuracy of the information contained on the attached drawing is either stated or implied unless this copy bears an original signature of the professional land surveyor hereon named.

SURVEYORS STATEMENT: I, Michael D. Heimbuck, a Professional Land Surveyor in the State of Colorado, hereby state that this Control Survey Diagram was prepared under my direct supervision this _____day of _____, from a field survey performed under my supervision and checking for and on behalf of the Department of Transportation, State of Colorado, and is not a Land Survey Plat or Right-of-Way Survey Plat and to the best of my knowledge and belief this control survey, as shown, meets the minimum horizontal control tolerances of a Type B Survey and this topographic survey, as shown, meets the minimum horizontal control tolerances of a Type D Survey as listed in the Colorado Department of Transportation Survey Manual Chapter Three (Revised 4/29/92).

CONSTRUCTION SURVEYING AND MONUMENTATION REQUIREMENTS:

- 1). This Control Survey Diagram represents the horizontal and vertical control for the project established by the Division. It is possible that some of the survey control monuments listed have been disturbed or obliterated. It is the Contractor's responsibility to verify the existence and stability of the control monuments before submitting a bid price.
- 2). All Type 1 and Type 2 monuments shall be set flush with the ground. Witness posts shall be installed 1 foot from and facing all Type 1 and Type 2 monuments, or as directed by the Project Engineer.
- 3). Installation of Type 3 and Type 3-A monuments shall be completed in the same day that installation is commenced. Under no circumstances shall holes in the roadway be left open overnight.
- 4). When installing Type 3-A monuments, the aluminum access cover shall be positively secured to the PVC pipe with screws or glue. The access cover shall be caulked with asphalt caulking between the cover and the edges of the roadway surface to provide a positive moisture barrier around the access cover.
- 5). Control survey procedures, statistical analysis, and accuracy obtained for horizontal and vertical control shall be documented in the field book.
- 6). Legible copies of the field books shall be submitted to the Project Engineer for review on a monthly basis.
- 7). It is ultimately the prime Contractors responsibility to insure that these requirements, as well as any contained in the CDOT specifications, project special provisions, and CDOT Survey Manual are fulfilled under this contract.
- 8). The minimum staking intervals for each item are described on the plans or in the CDOT Survey Manual. If the contractor wishes to reduce the minimum intervals, a Contract Modification Order must be negotiated and the cost of the item reduced accordingly.

Michael D. Heimbuck, PLS 17488

FILING CERTIFICATION:
DEPOSITED THIS ____ DAY OF _____, 19____, AT _____, M., FOR INFORMATION
ONLY IN BOOK _____ OF THE COUNTY LAND SURVEYS/RIGHT OF WAY
SURVEYS AT PAGE _____, RECEPTION NUMBER _____

SIGNED _____
DEPT. _____

00070scd.dwg 24 AUG 2001 12:40:42.9 PLOT/EDIT by wws

COLORADO DEPARTMENT OF TRANSPORTATION




Region 1
18500 East Colfax Avenue
Aurora, Colorado 80011
Phone: (303) 757-9744 FAX: (303) 757-9746

Survey Unit:


Sheet Revisions		
mm/yy	XXXX	XXX

US HIGHWAY 85 MP 187.00 to MP 200.00
SURVEY CONTROL DIAGRAM

Prepared By:
Mountain Surveying & Mapping, Inc.
8751 E. Hampden Ave. Suite B-1
Denver, CO (303) 306-1858

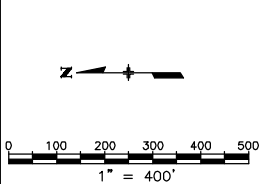

Survey Control Diagram				
Plan Sheet				
Project Number: IM-0252-317				
Project Location: US HIGHWAY 85				
Project Location:				
Project Code:	Last Mod. Date	Subset Sheets	Sheet No.	Total No. of Sheets
12255	08-24-01	4 of 15	3C	3C of 20

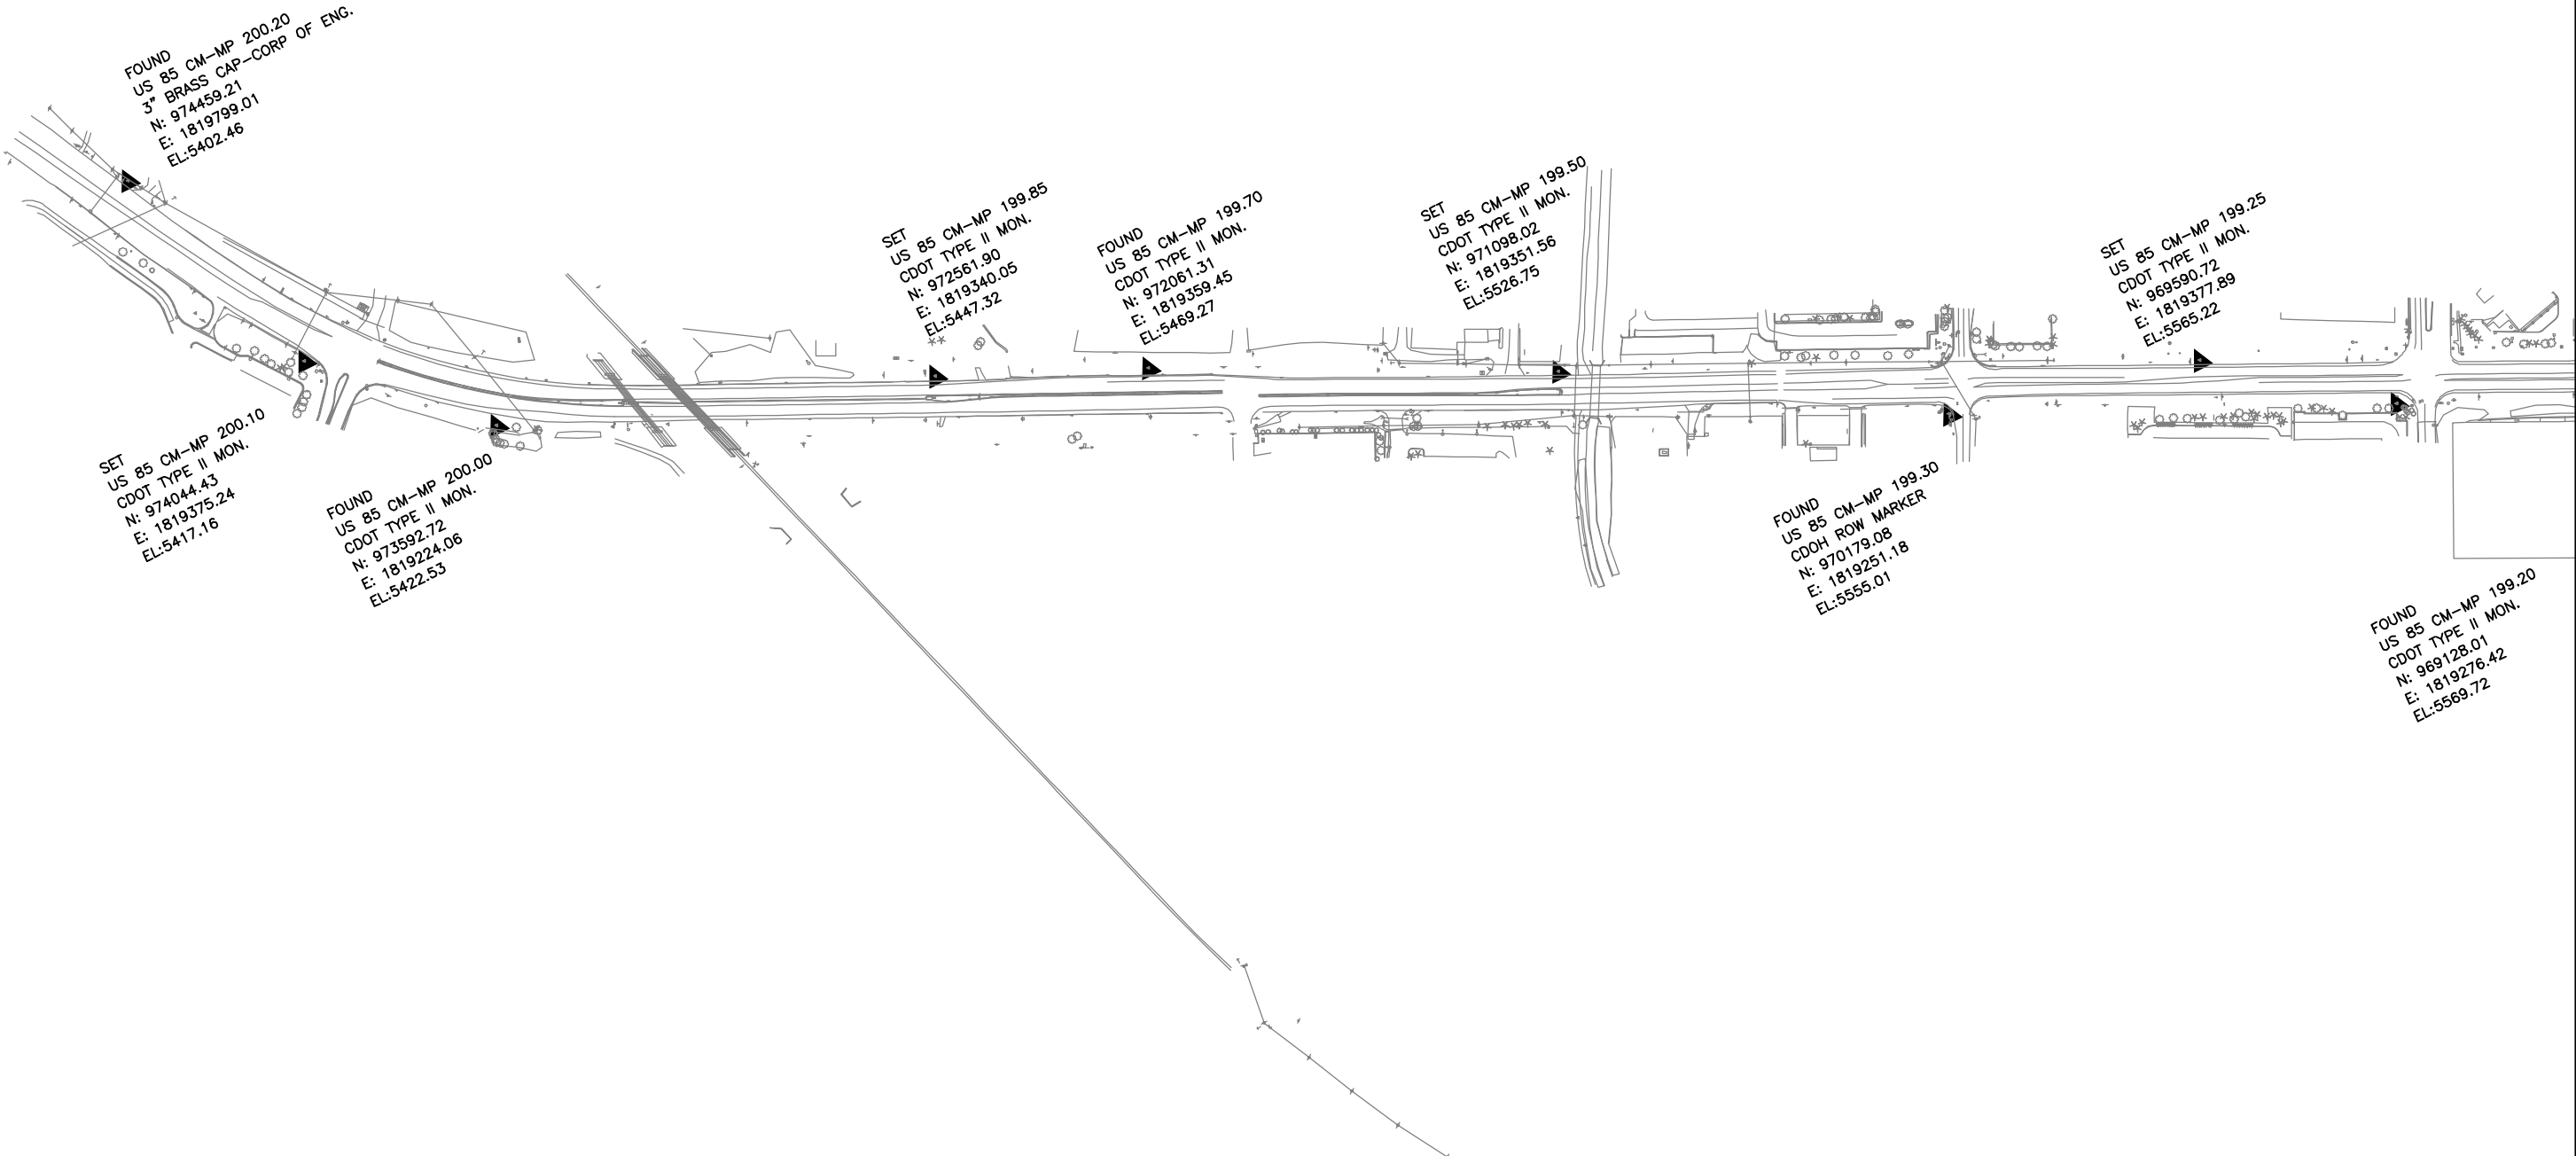




Region 1
18500 East Colfax Avenue
Aurora, Colorado 80011
Phone: (303) 757-9744 FAX: (303) 757-9746

Survey Unit:

Sheet Revisions		
mm/yy	XXXX	XXX

US HIGHWAY 85 MP 187.00 to MP 200.00
SURVEY CONTROL DIAGRAM


Prepared By:
Mountain Surveying & Mapping, Inc.
8751 E. Hampden Ave. Suite B-1
Denver, CO (303) 306-1858

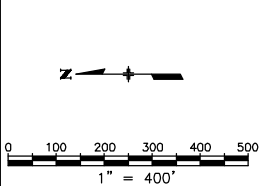

Survey Control Diagram				
Plan Sheet				
Project Number: IM-0252-317				
Project Location: US HIGHWAY 85				
Project Location:				
Project Code:	Last Mod. Date	Subset Sheets	Sheet No.	Total No. of Sheets
12255	08-24-01	5 of 15	3D	3D of 20

DEPOSITED THIS ____ DAY OF _____, 19____, AT _____M., FOR INFORMATION
ONLY IN BOOK _____ OF THE COUNTY LAND SURVEYS/RIGHT OF WAY
SURVEYS AT PAGE _____, RECEPTION NUMBER _____

SIGNED _____
DEPT. _____

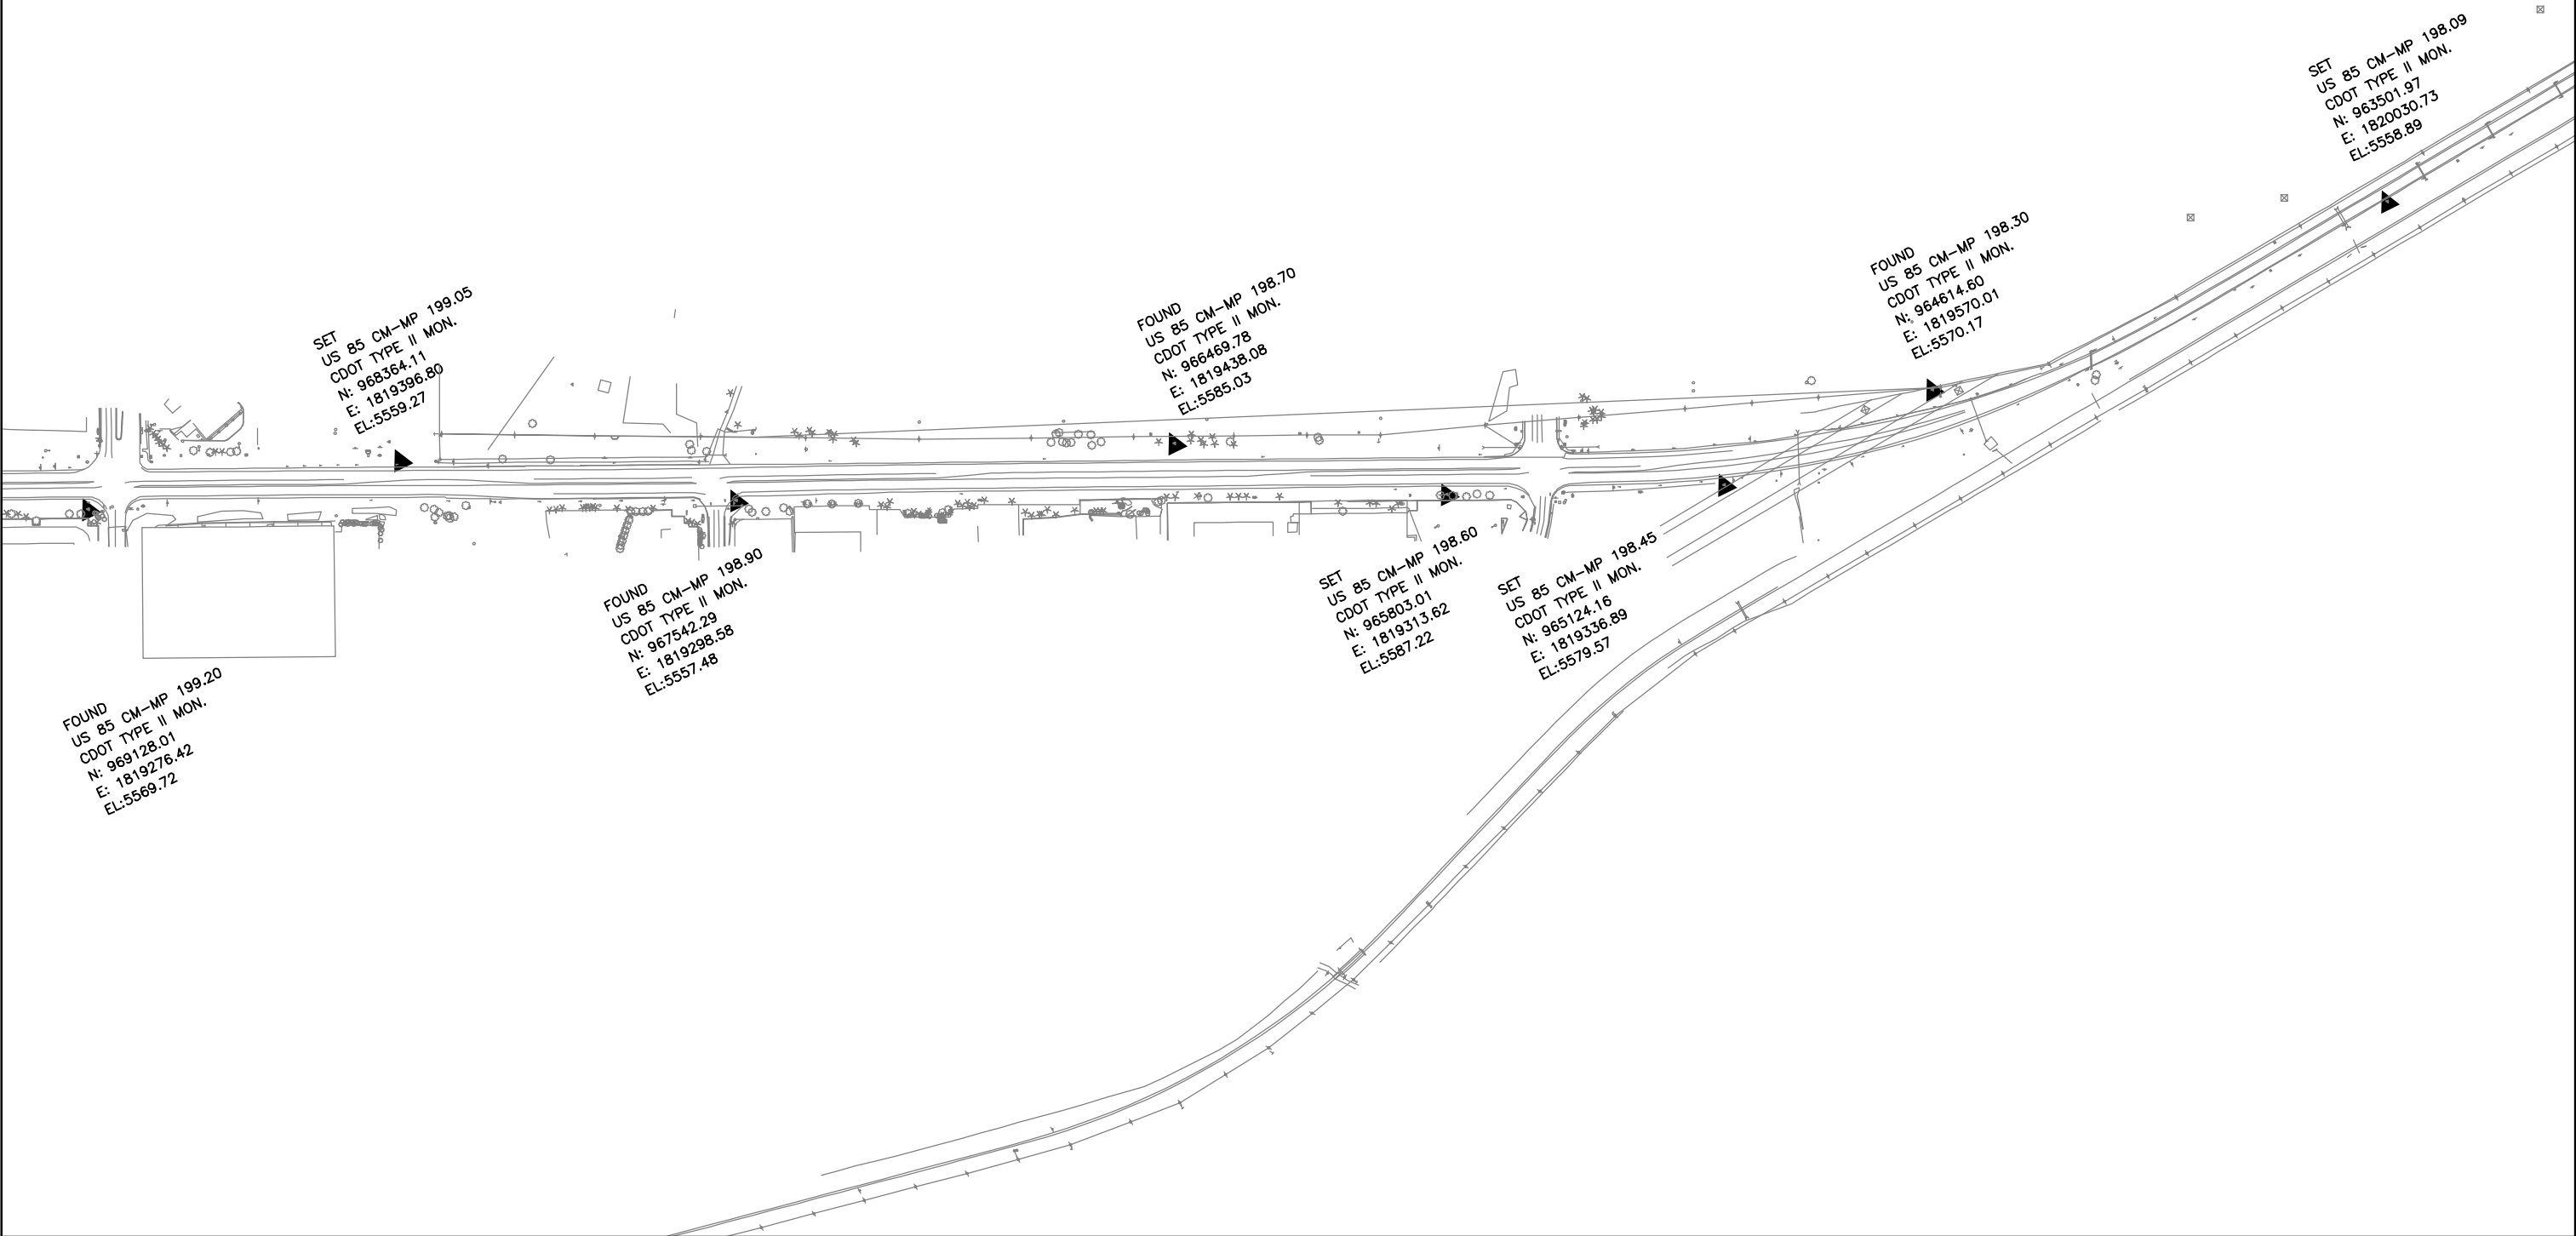

COLORADO DEPARTMENT OF TRANSPORTATION




Region 1
18500 East Colfax Avenue
Aurora, Colorado 80011
Phone: (303) 757-9744 FAX: (303) 757-9746

Survey Unit:

Sheet Revisions		
mm/yy	XXXX	XXX

US HIGHWAY 85 MP 187.00 to MP 200.00
SURVEY CONTROL DIAGRAM


Prepared By:
Mountain Surveying & Mapping, Inc.
8751 E. Hampden Ave. Suite B-1
Denver, CO (303) 306-1858

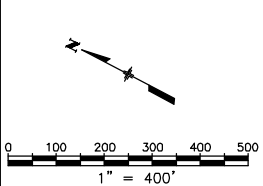

Survey Control Diagram				
Plan Sheet				
Project Number: IM-0252-317				
Project Location: US HIGHWAY 85				
Project Location:				
Project Code:	Last Mod. Date	Subset Sheets	Sheet No.	Total No. of Sheets
12255	08-24-01	6 of 15	3E	3E of 20

DEPOSITED THIS ____ DAY OF ____, 19 ____, AT ____, M., FOR INFORMATION
ONLY IN BOOK ____ OF THE COUNTY LAND SURVEYS/RIGHT OF WAY
SURVEYS AT PAGE ____, RECEPTION NUMBER ____

SIGNED _____
DEPT. _____

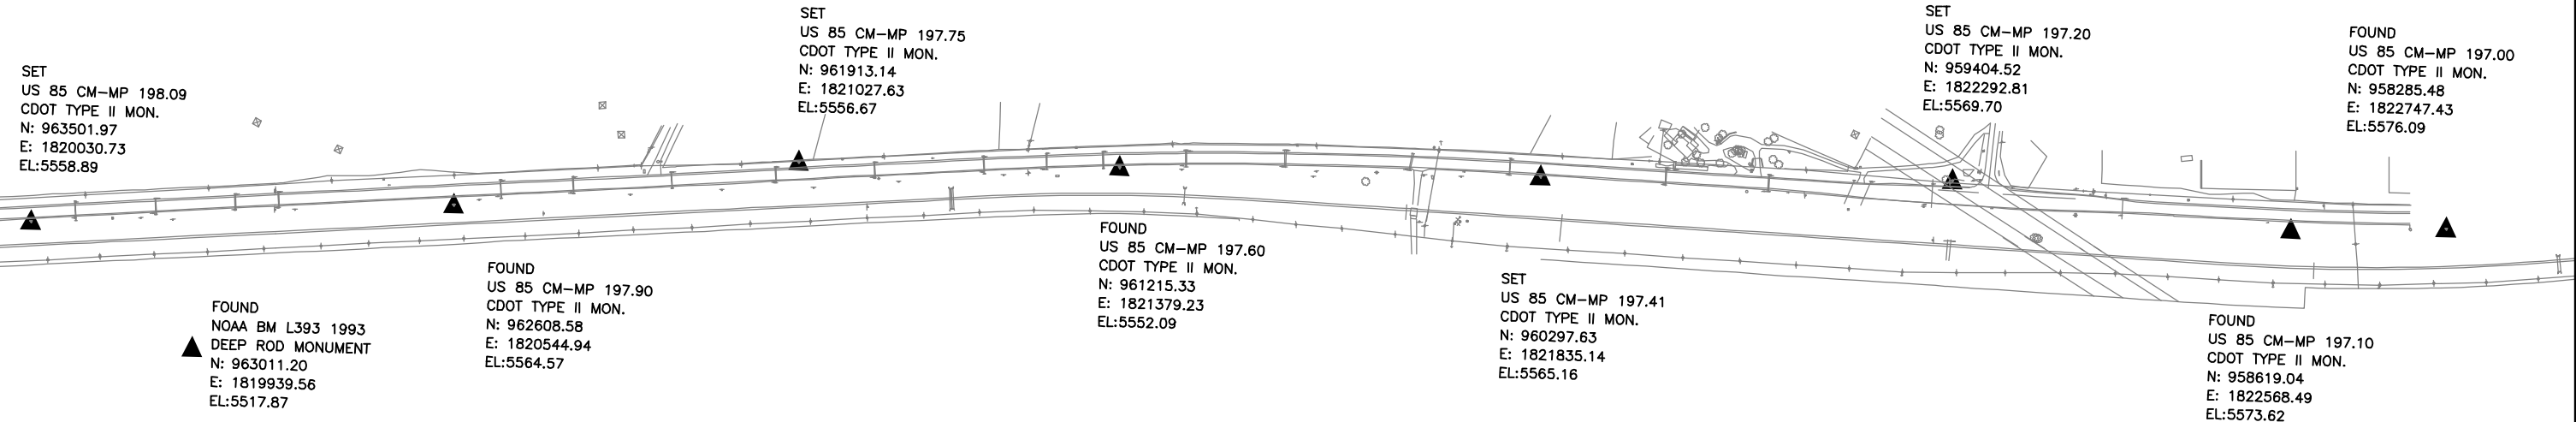

AREA PREVIOUSLY SURVEYED IN PROJECT: STA-0852-082 →




Region 1
18500 East Colfax Avenue
Aurora, Colorado 80011
Phone: (303) 757-9744 FAX: (303) 757-9746

Survey Unit:

Sheet Revisions		
mm/yy	XXXX	XXX

US HIGHWAY 85 MP 187.00 to MP 200.00
SURVEY CONTROL DIAGRAM

Prepared By:
Mountain Surveying & Mapping, Inc.
8751 E. Hampden Ave. Suite B-1
Denver, CO (303) 306-1858

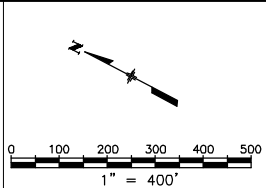


Survey Control Diagram				
Plan Sheet				
Project Number: IM-0252-317				
Project Location: US HIGHWAY 85				
Project Location:				
Project Code:	Last Mod. Date	Subset Sheets	Sheet No.	Total No. of Sheets
12255	08-24-01	7 of 15	3F	3F of 20

DEPOSITED THIS ____ DAY OF _____, 19____, AT _____M., FOR INFORMATION
ONLY IN BOOK _____ OF THE COUNTY LAND SURVEYS/RIGHT OF WAY
SURVEYS AT PAGE _____, RECEPTION NUMBER _____

SIGNED _____
DEPT. _____

00070scd.dwg 24 AUG 2001 12:40:42.9 PLOT/EDIT by wws

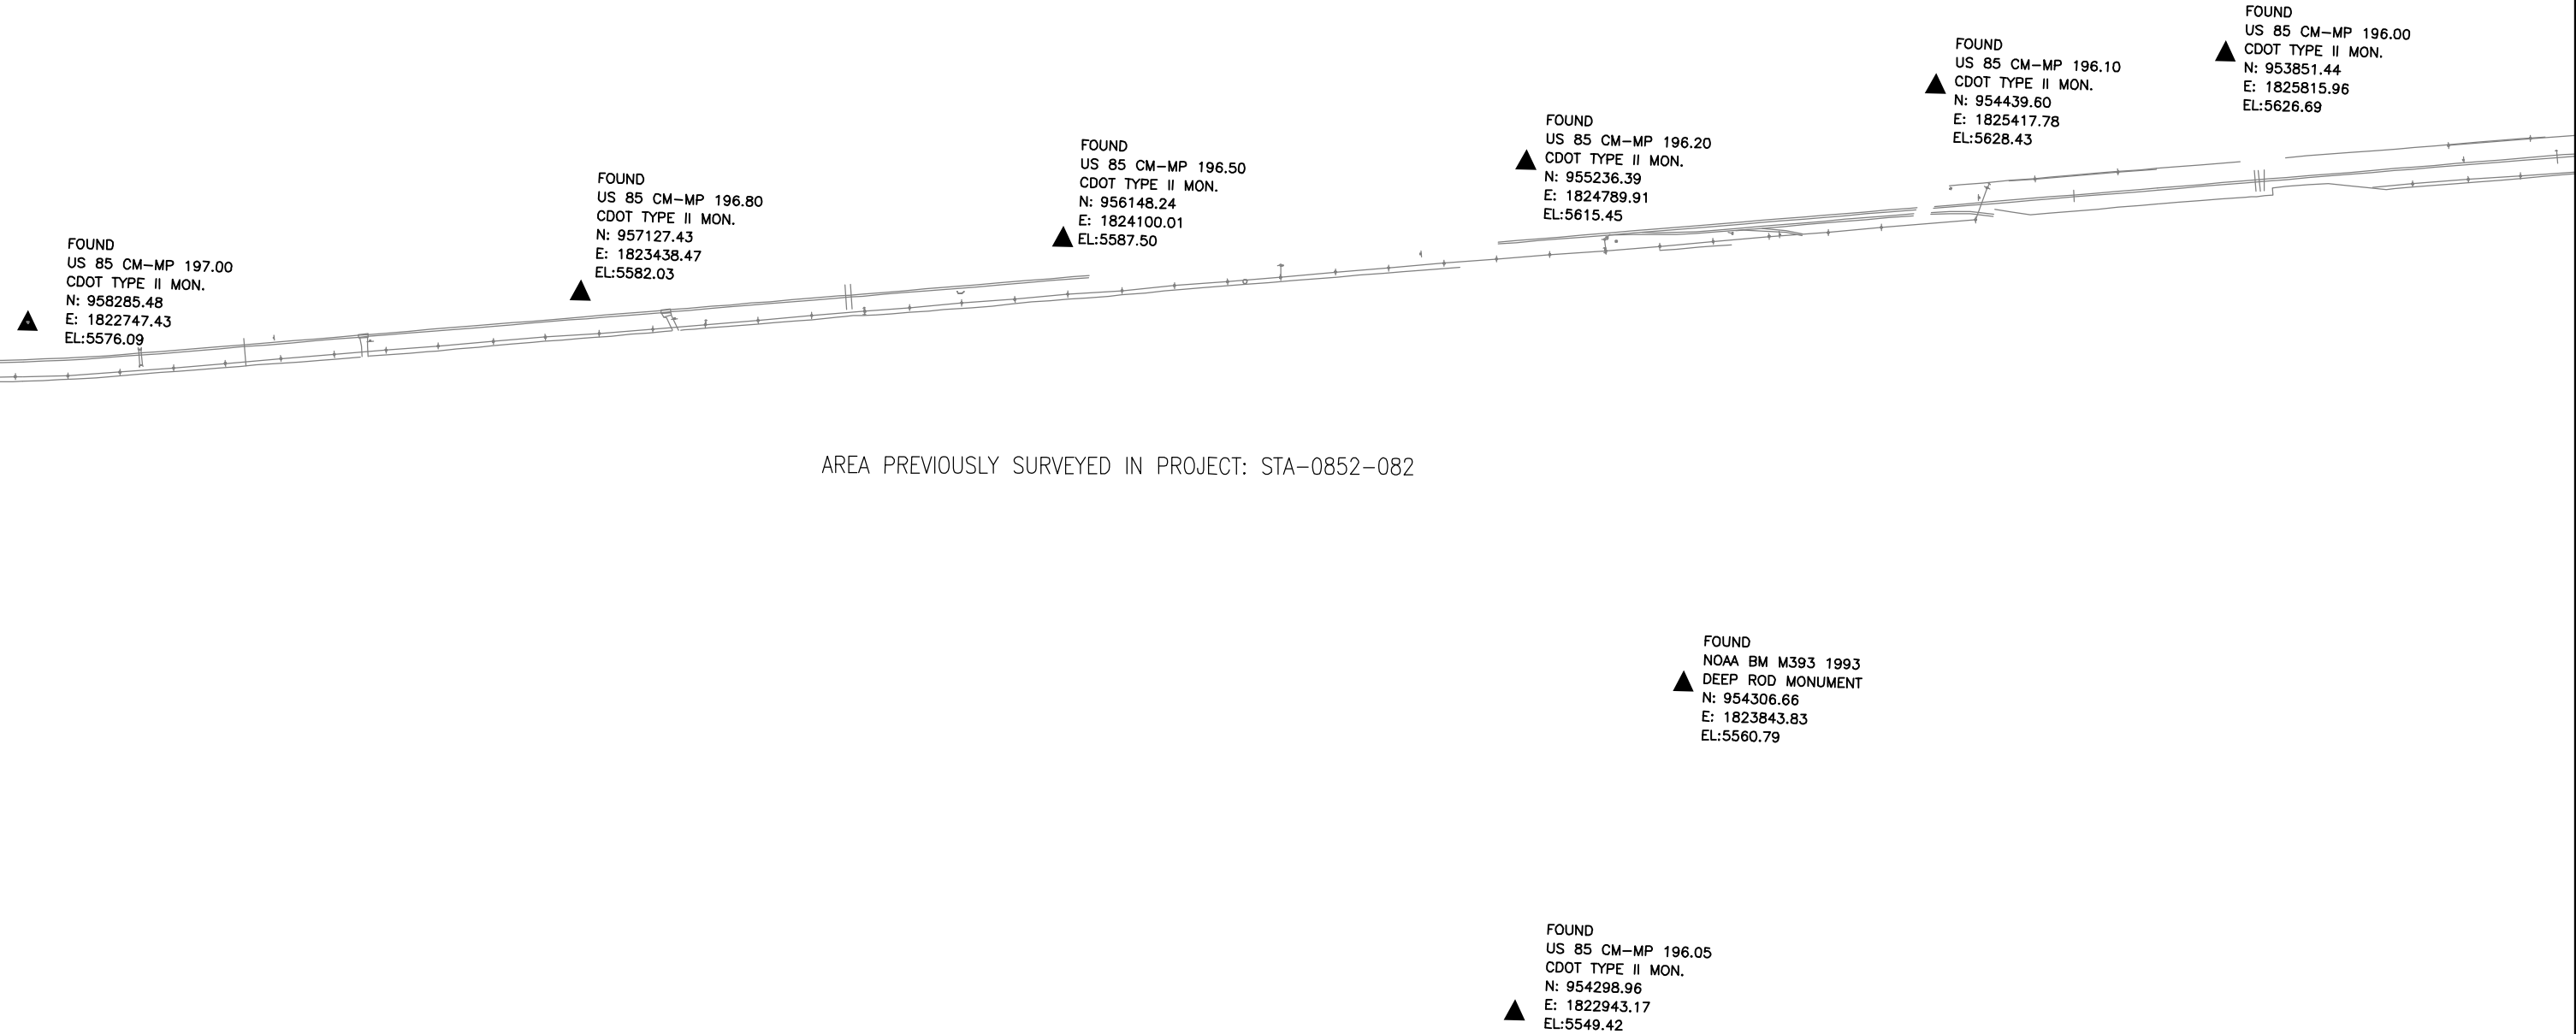




Region 1
18500 East Colfax Avenue
Aurora, Colorado 80011
Phone: (303) 757-9744 FAX: (303) 757-9746

Survey Unit:

Sheet Revisions		
mm/yy	XXXX	XXX

US HIGHWAY 85 MP 187.00 to MP 200.00
SURVEY CONTROL DIAGRAM


Prepared By:
Mountain Surveying & Mapping, Inc.
8751 E. Hampden Ave. Suite B-1
Denver, CO (303) 306-1858

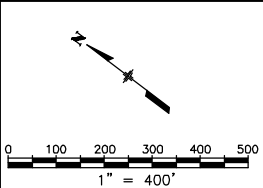

Survey Control Diagram				
Plan Sheet				
Project Number: IM-0252-317				
Project Location: US HIGHWAY 85				
Project Location:				
Project Code:	Last Mod. Date	Subset Sheets	Sheet No.	Total No. of Sheets
12255	08-24-01	8 of 15	3G	3G of 20

DEPOSITED THIS ____ DAY OF _____, 19____, AT _____M., FOR INFORMATION
ONLY IN BOOK _____ OF THE COUNTY LAND SURVEYS/RIGHT OF WAY
SURVEYS AT PAGE _____, RECEPTION NUMBER _____

SIGNED _____
DEPT. _____

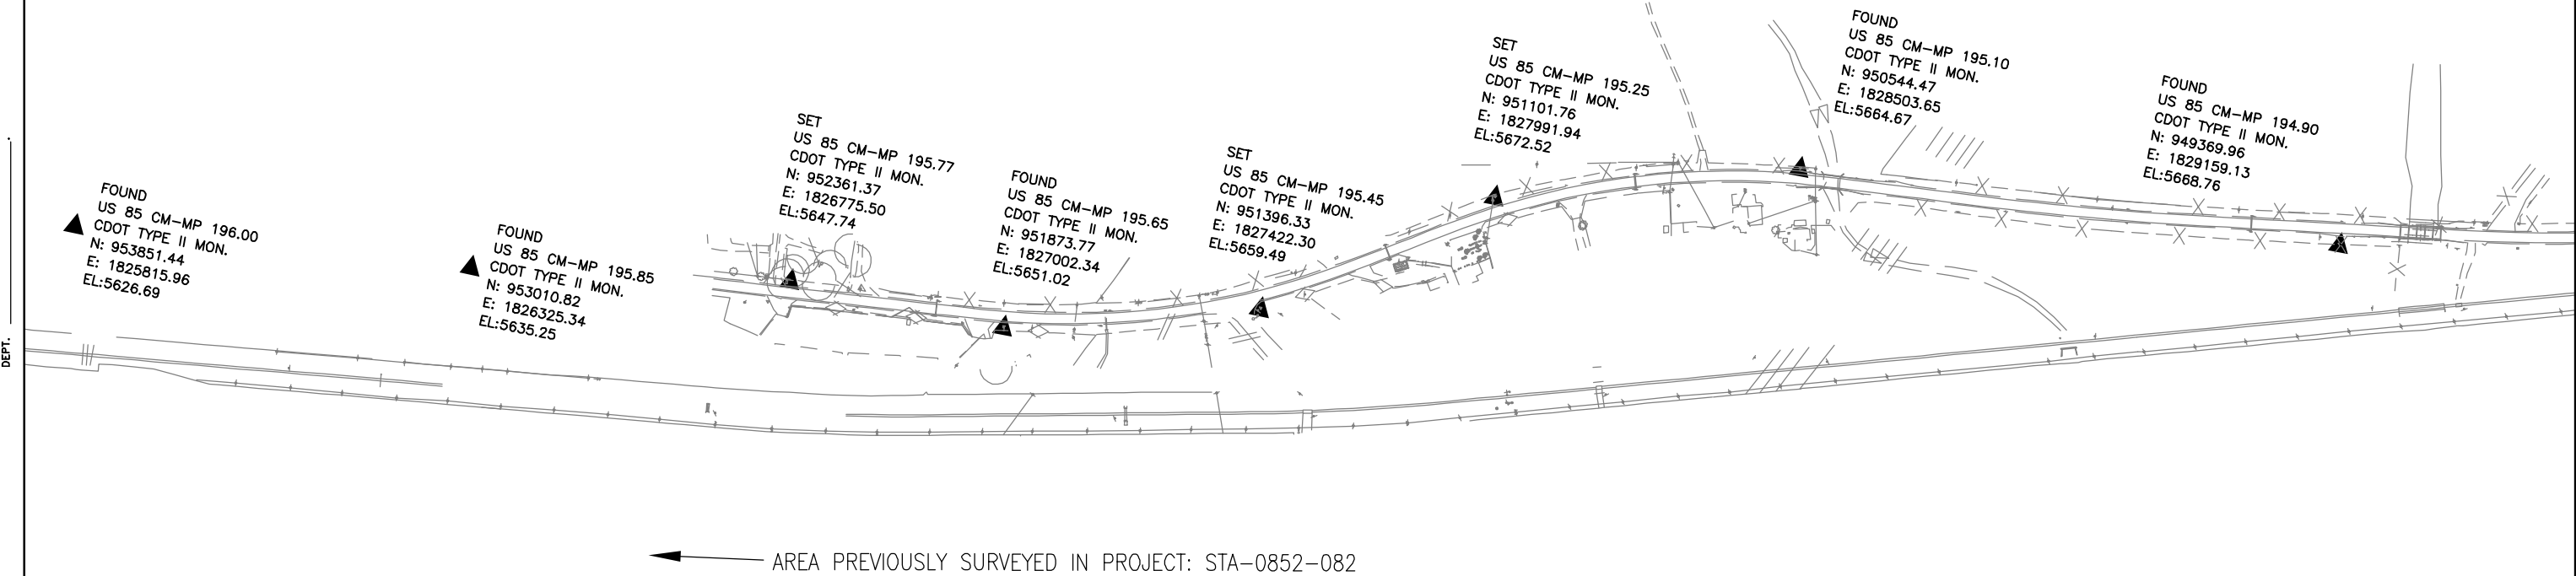




Region 1
18500 East Colfax Avenue
Aurora, Colorado 80011
Phone: (303) 757-9744 FAX: (303) 757-9746

Survey Unit:

Sheet Revisions		
mm/yy	xxxx	xxx

US HIGHWAY 85 MP 187.00 to MP 200.00
SURVEY CONTROL DIAGRAM


Prepared By:
Mountain Surveying & Mapping, Inc.
8751 E. Hampden Ave. Suite B-1
Denver, CO (303) 306-1858

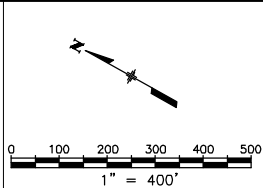

Survey Control Diagram				
Plan Sheet				
Project Number: IM-0252-317				
Project Location: US HIGHWAY 85				
Project Location:				
Project Code:	Last Mod. Date	Subset Sheets	Sheet No.	Total No. of Sheets
12255	08-24-01	9 of 15	3H	3H of 20

DEPOSITED THIS ____ DAY OF ____, 19 ____, AT ____, M., FOR INFORMATION
ONLY IN BOOK ____ OF THE COUNTY LAND SURVEYS/RIGHT OF WAY
SURVEYS AT PAGE ____, RECEPTION NUMBER ____

SIGNED _____
DEPT. _____

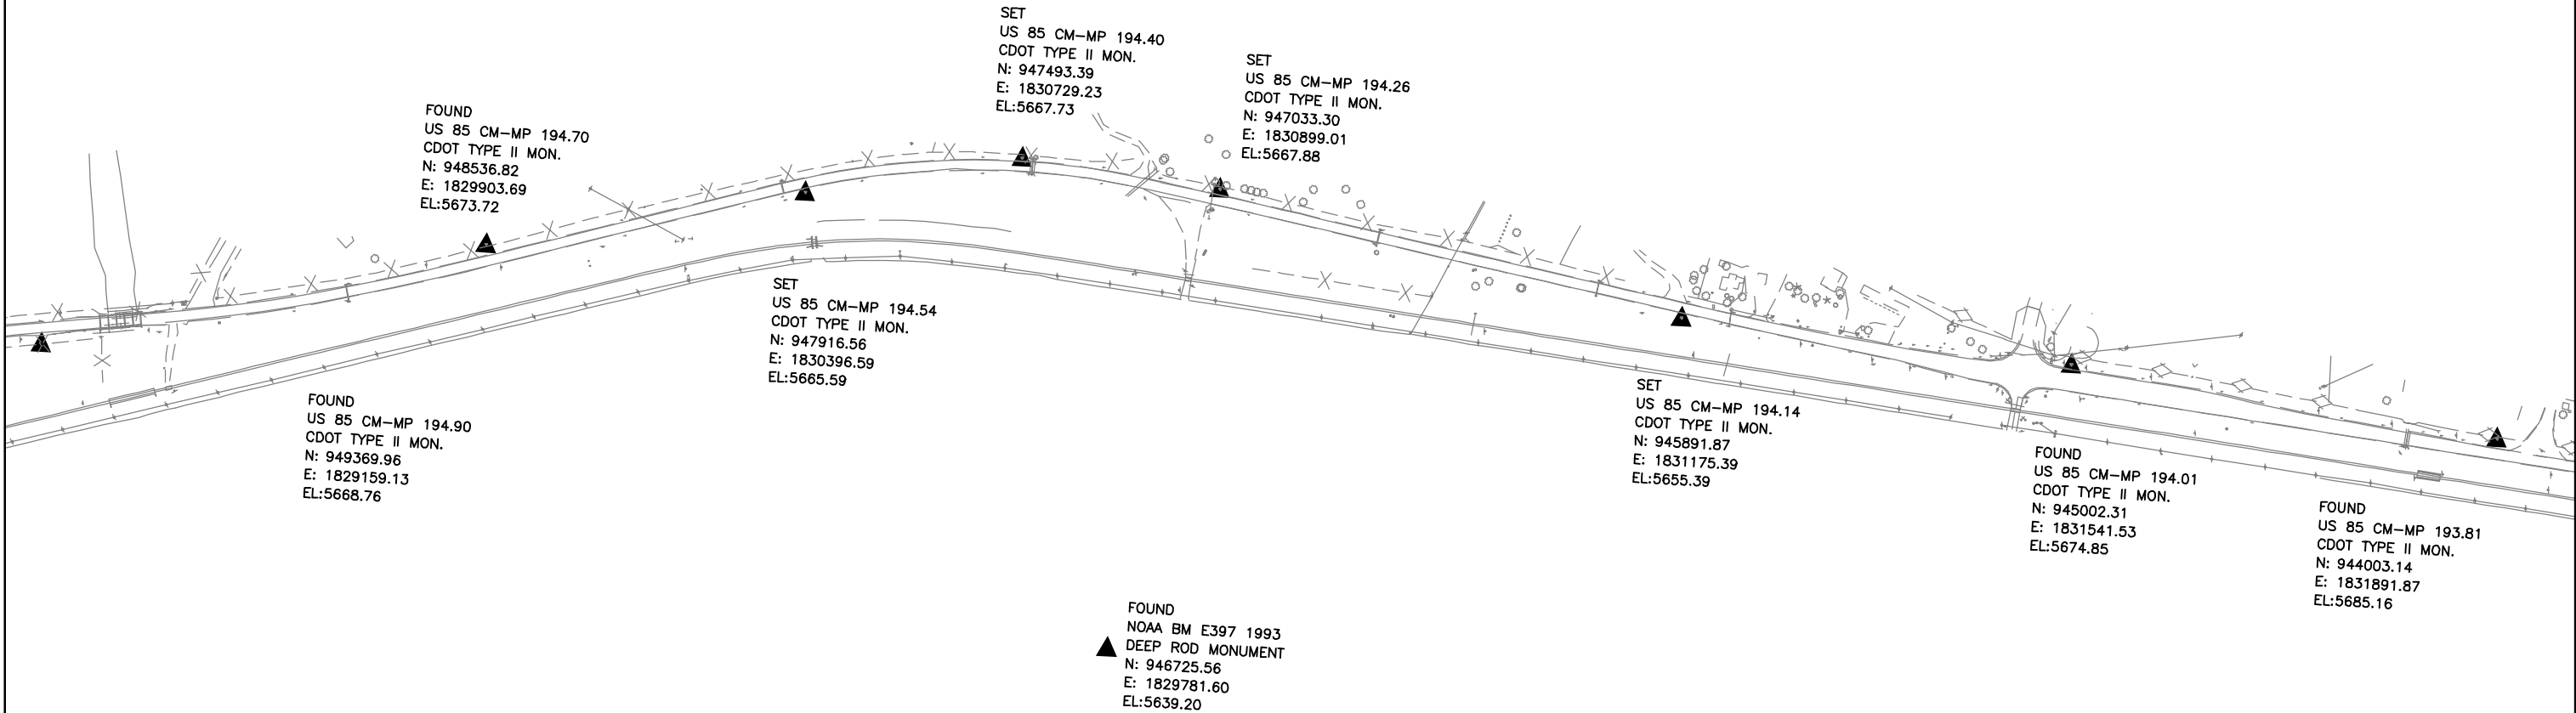




Region 1
18500 East Colfax Avenue
Aurora, Colorado 80011
Phone: (303) 757-9744 FAX: (303) 757-9746

Survey Unit:

Sheet Revisions		
mm/yy	xxxx	xxx

US HIGHWAY 85 MP 187.00 to MP 200.00
SURVEY CONTROL DIAGRAM


Prepared By:
Mountain Surveying & Mapping, Inc.
8751 E. Hampden Ave. Suite B-1
Denver, CO (303) 306-1858

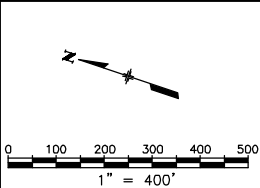

Survey Control Diagram				
Plan Sheet				
Project Number: IM-0252-317				
Project Location: US HIGHWAY 85				
Project Location:				
Project Code:	Last Mod. Date	Subset Sheets	Sheet No.	Total No. of Sheets
12255	08-24-01	10 of 15	31	31 of 20

DEPOSITED THIS ____ DAY OF _____, 19____, AT _____M., FOR INFORMATION
ONLY IN BOOK _____ OF THE COUNTY LAND SURVEYS/RIGHT OF WAY
SURVEYS AT PAGE _____, RECEPTION NUMBER _____

SIGNED _____
DEPT. _____

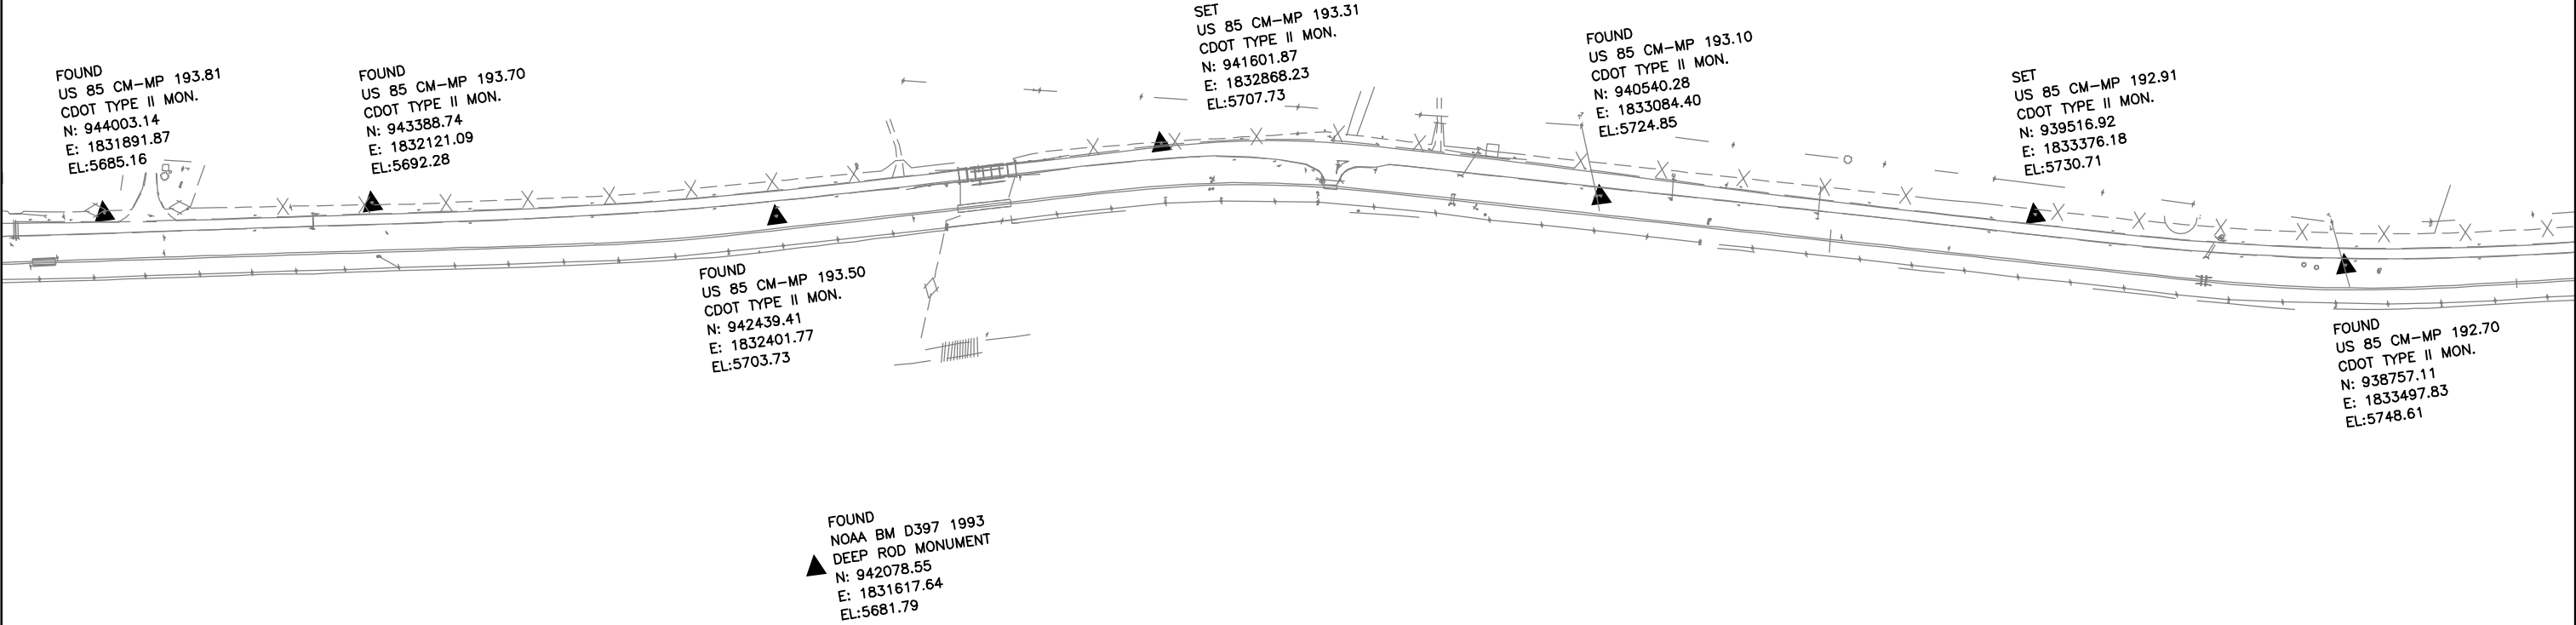

COLORADO DEPARTMENT OF TRANSPORTATION




Region 1
18500 East Colfax Avenue
Aurora, Colorado 80011
Phone: (303) 757-9744 FAX: (303) 757-9746

Survey Unit:

Sheet Revisions		
mm/yy	xxxx	xxx

US HIGHWAY 85 MP 187.00 to MP 200.00
SURVEY CONTROL DIAGRAM


Prepared By:
Mountain Surveying & Mapping, Inc.
8751 E. Hampden Ave. Suite B-1
Denver, CO (303) 306-1858

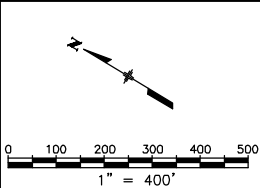

Survey Control Diagram				
Plan Sheet				
Project Number: IM-0252-317				
Project Location: US HIGHWAY 85				
Project Location:				
Project Code:	Last Mod. Date	Subset Sheets	Sheet No.	Total No. of Sheets
12255	08-24-01	11 of 15	3J	3J of 20

DEPOSITED THIS ____ DAY OF ____, 19 ____, AT ____, M., FOR INFORMATION
ONLY IN BOOK ____ OF THE COUNTY LAND SURVEYS/RIGHT OF WAY
SURVEYS AT PAGE ____, RECEPTION NUMBER ____

SIGNED _____
DEPT. _____

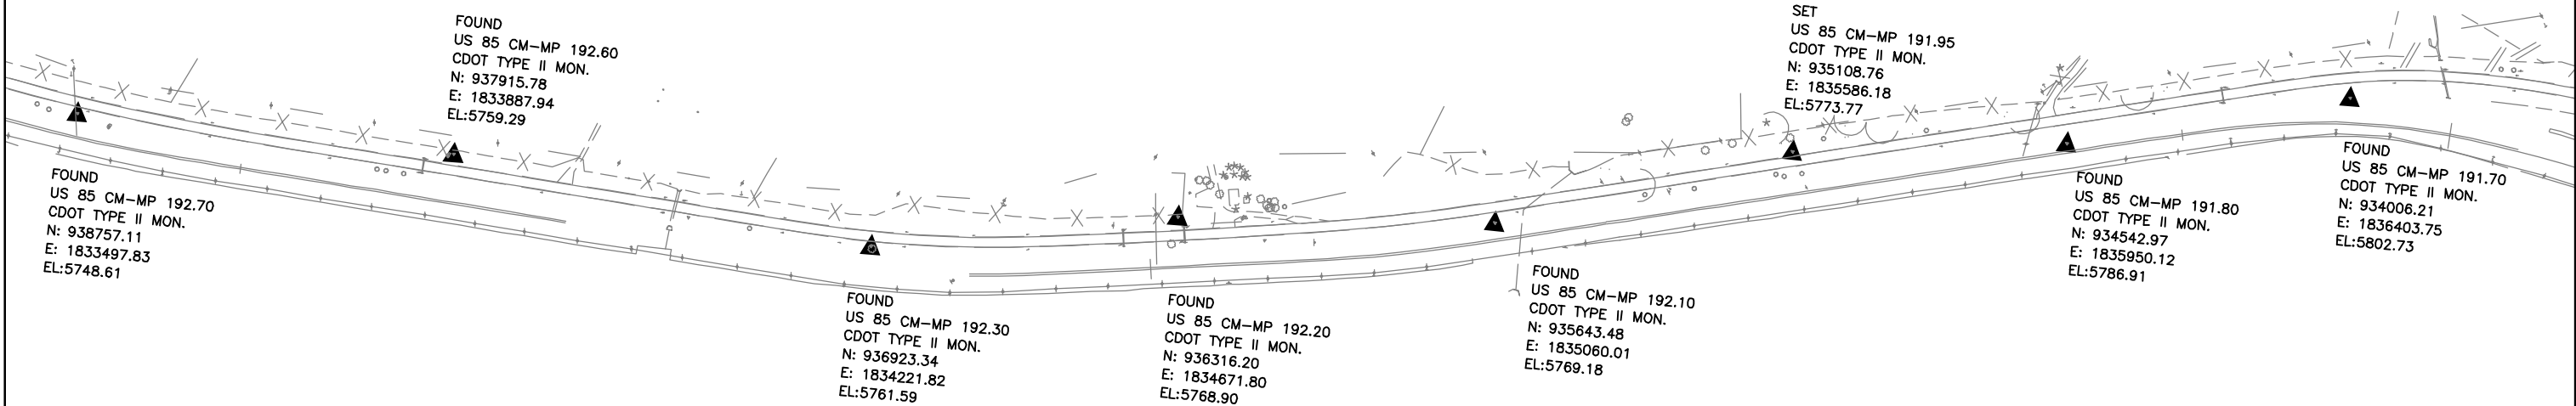

COLORADO DEPARTMENT OF TRANSPORTATION




Region 1
18500 East Colfax Avenue
Aurora, Colorado 80011
Phone: (303) 757-9744 FAX: (303) 757-9746

Survey Unit:

Sheet Revisions		
mm/yy	XXXX	XXX

US HIGHWAY 85 MP 187.00 to MP 200.00
SURVEY CONTROL DIAGRAM


Prepared By:
Mountain Surveying & Mapping, Inc.
8751 E. Hampden Ave. Suite B-1
Denver, CO (303) 306-1858

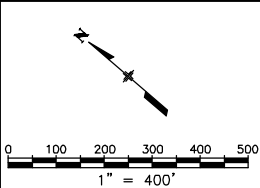

Survey Control Diagram				
Plan Sheet				
Project Number: IM-0252-317				
Project Location: US HIGHWAY 85				
Project Location:				
Project Code:	Last Mod. Date	Subset Sheets	Sheet No.	Total No. of Sheets
12255	08-24-01	12 of 15	3K	3K of 20

DEPOSITED THIS ____ DAY OF ____, 19 ____, AT ____, M., FOR INFORMATION
ONLY IN BOOK ____ OF THE COUNTY LAND SURVEYS/RIGHT OF WAY
SURVEYS AT PAGE ____, RECEPTION NUMBER ____

SIGNED _____
DEPT. _____

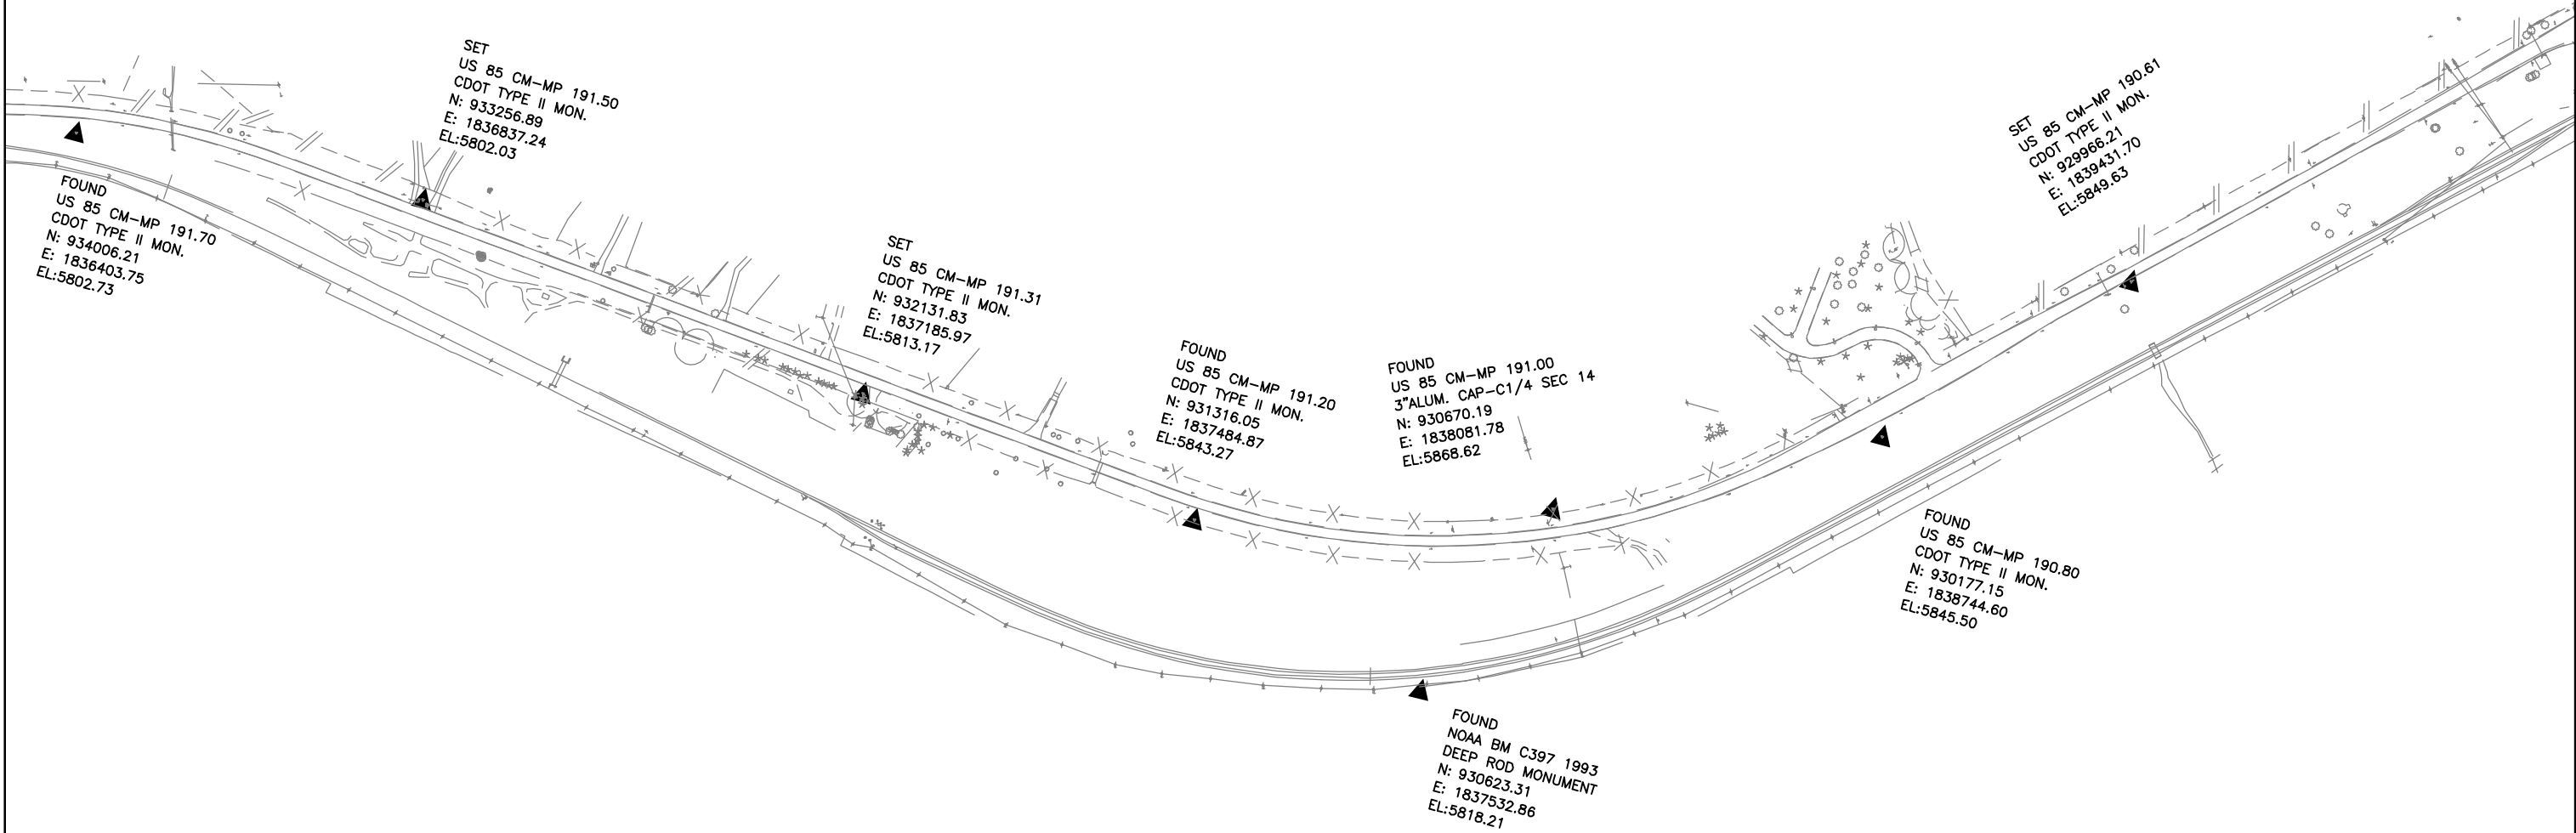

COLORADO DEPARTMENT OF TRANSPORTATION




Region 1
18500 East Colfax Avenue
Aurora, Colorado 80011
Phone: (303) 757-9744 FAX: (303) 757-9746

Survey Unit:

Sheet Revisions		
mm/yy	xxxx	xxx

US HIGHWAY 85 MP 187.00 to MP 200.00
SURVEY CONTROL DIAGRAM


Prepared By:
Mountain Surveying & Mapping, Inc.
8751 E. Hampden Ave. Suite B-1
Denver, CO (303) 306-1858

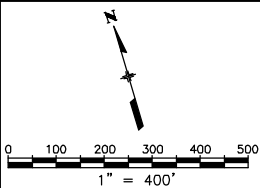

Survey Control Diagram				
Plan Sheet				
Project Number: IM-0252-317				
Project Location: US HIGHWAY 85				
Project Location:				
Project Code:	Last Mod. Date	Subset Sheets	Sheet No.	Total No. of Sheets
12255	08-24-01	13 of 15	3L	3L of 20

DEPOSITED THIS ____ DAY OF ____, 19__, AT ____, M., FOR INFORMATION
ONLY IN BOOK ____ OF THE COUNTY LAND SURVEYS/RIGHT OF WAY
SURVEYS AT PAGE ____, RECEPTION NUMBER ____

SIGNED _____
DEPT. _____

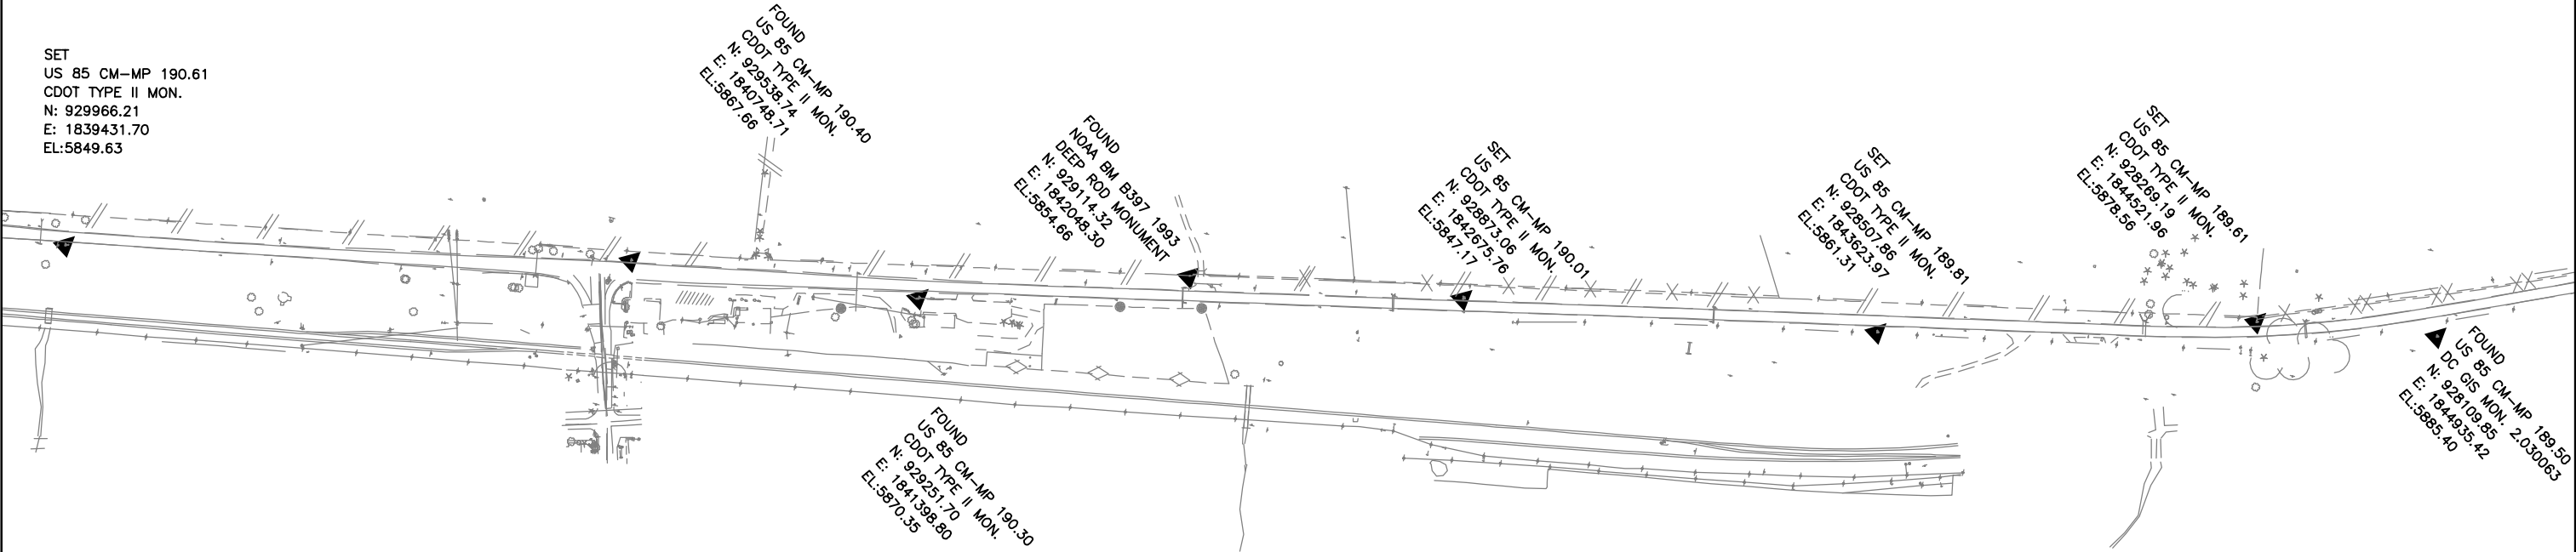

COLORADO DEPARTMENT OF TRANSPORTATION




Region 1
18500 East Colfax Avenue
Aurora, Colorado 80011
Phone: (303) 757-9744 FAX: (303) 757-9746

Survey Unit:

Sheet Revisions		
mm/yy	XXXX	XXX

US HIGHWAY 85 MP 187.00 to MP 200.00
SURVEY CONTROL DIAGRAM


Prepared By:
Mountain Surveying & Mapping, Inc.
8751 E. Hampden Ave. Suite B-1
Denver, CO (303) 306-1858

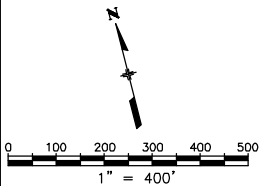

Survey Control Diagram				
Plan Sheet				
Project Number: IM-0252-317				
Project Location: US HIGHWAY 85				
Project Location:				
Project Code:	Last Mod. Date	Subset Sheets	Sheet No.	Total No. of Sheets
12255	08-24-01	14 of 15	3M	3M of 20

DEPOSITED THIS ____ DAY OF ____, 19__, AT ____, M., FOR INFORMATION
ONLY IN BOOK ____ OF THE COUNTY LAND SURVEYS/RIGHT OF WAY
SURVEYS AT PAGE ____, RECEPTION NUMBER ____

SIGNED _____
DEPT. _____

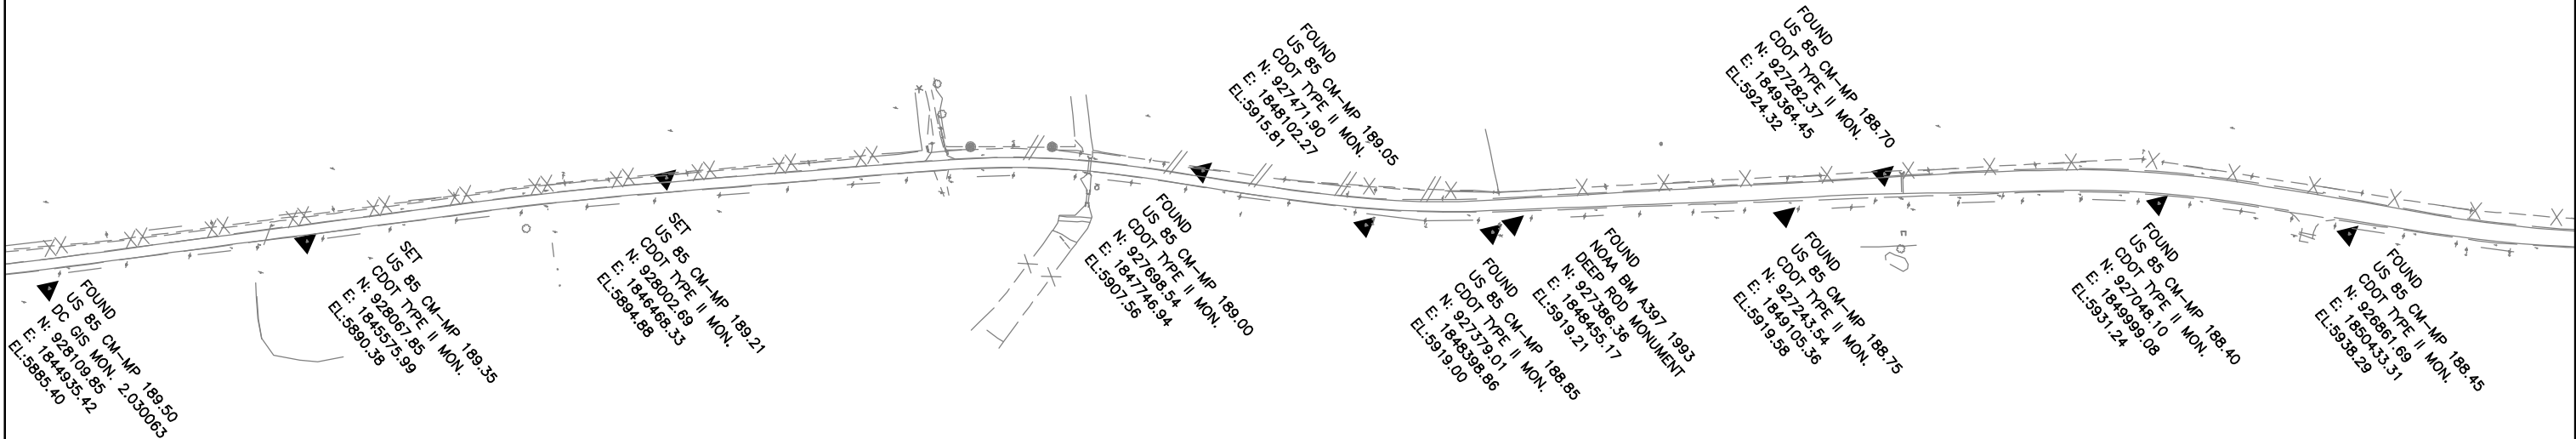

COLORADO DEPARTMENT OF TRANSPORTATION



Region 1
18500 East Colfax Avenue
Aurora, Colorado 80011
Phone: (303) 757-9744 FAX: (303) 757-9746


Survey Unit:

Sheet Revisions

mm/yy	XXXX	XXX

US HIGHWAY 85 MP 187.00 to MP 200.00
SURVEY CONTROL DIAGRAM

Prepared By:
Mountain Surveying & Mapping, Inc.
8751 E. Hampden Ave. Suite B-1
Denver, CO (303) 306-1858

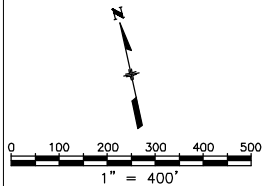

Survey Control Diagram

Plan Sheet

Project Number: IM-0252-317


Project Location: US HIGHWAY 85

Project Location:

Project Code:	Last Mod. Date	Subset Sheets	Sheet No.	Total No. of Sheets
12255	08-24-01	15 of 15	3N	3N of 20

DEPOSITED THIS ____ DAY OF ____, 19__, AT ____, M., FOR INFORMATION
ONLY IN BOOK ____ OF THE COUNTY LAND SURVEYS/RIGHT OF WAY
SURVEYS AT PAGE ____, RECEPTION NUMBER ____

SIGNED _____
DEPT. _____

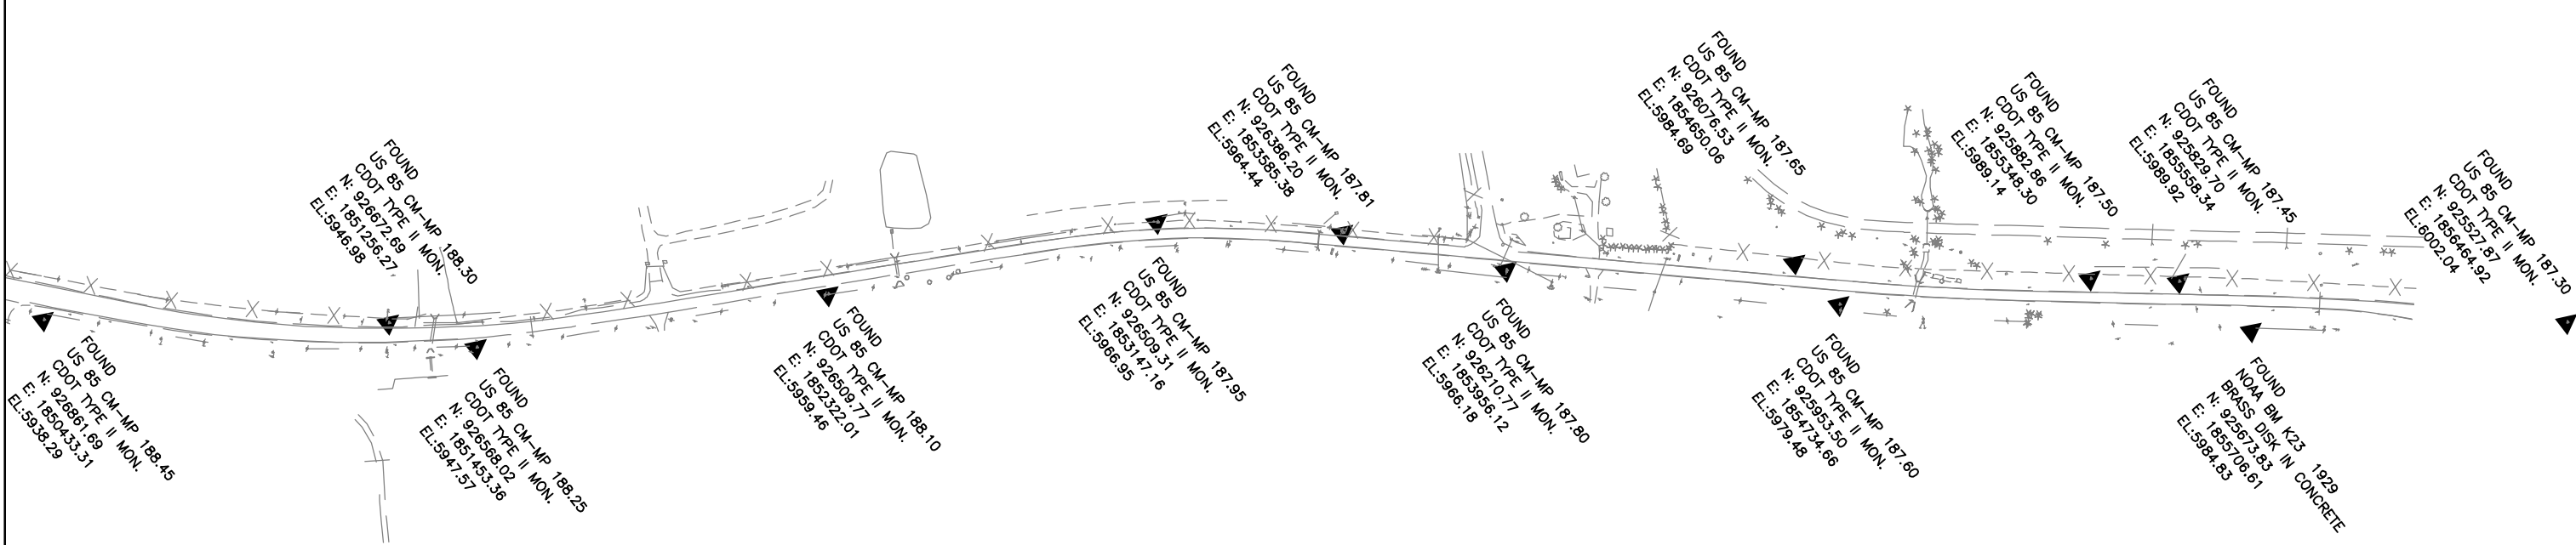

COLORADO DEPARTMENT OF TRANSPORTATION



Region 1
18500 E. Colfax Avenue
Aurora, CO 80011
Phone: (303) 757-9117 FAX: (303) 757-9746

Right-of-Way and Survey Unit: Kevin A. Williams

Sheet Revisions

Date	Description	Initials
3/7/05	Updated Points List	BDL
4/25/05	Updated Points List- Deleted Pnts. 701-704	BDL

Sheet Revisions

Date	Description	Initials

Prepared By:



URS Corporation
8181 East Tufts Ave. Denver, CO 80237
Phone: (303)694-2770 Fax: (303) 694-3946

Computer File
Information

CREATION DATE: 11/18/2004 INITIALS: BDL
LAST MOD. DATE: 4/25/2005 INITIALS: BDL
DRAWING NAME & FULL PATH: SEE LEFT
SIDE OF SHEET
SCALE: As Shown UNITS: English

Right of Way Plans

MONUMENT TABULATION

Project Number:	NH 0852-086 Phase IV (ROW) / NH 0852-097 (Const.) (P.C. 15139)			
Project Location:	SH 85, Meadows to C470			
Project Location:	Louviers South to Sedalia / M.P. 194.0 to M.P. 190.6			
Project Code:	Subst. Sheets	Sheet No.	Total No. of Sheets	
13429			1 of 7	43



Tabulation of Right of Way Markers To Be Set

Point	Northing	Easting	Type
600	935038.92	1835768.85	1
601	934626.75	1836109.55	1
602	934425.37	1836340.88	1
603	933610.61	1836861.18	1
604	933326.48	1836913.97	1
605	933068.12	1837010.51	1
606	932973.11	1837114.18	1
607	932903.92	1836881.72	1
609	932831.63	1837093.54	1
612	932577.75	1837188.40	1
615	932448.67	1837319.54	1
616	932267.11	1837320.49	1
617	932158.90	1837408.96	1
622	930526.70	1838083.60	1
623	931394.58	1837443.51	1
624	930472.61	1838084.27	1
632	931989.09	1837472.41	1
633	931988.04	1837398.38	1
634	931703.96	1837504.28	1
635	931677.10	1837551.64	1
636	931492.65	1837620.40	1
637	931441.39	1837602.20	1
638	930803.84	1838016.99	1
639	930395.30	1838658.57	1
640	930242.95	1839070.48	1
642	934317.47	1836176.11	1
643	935007.12	1835600.39	1
644	933561.60	1836566.60	1
645	933305.85	1836634.11	1
646	933307.14	1836731.38	1
647	934226.78	1836505.04	1
648	931985.57	1837224.14	1
649	931985.56	1837223.24	1
651	935184.75	1835674.27	1
652	935246.27	1835623.41	1
653	935245.14	1835538.32	1
659	930391.80	1838264.58	1

Tabulation of Aliquot Corners

Point	Northing	Easting	Description
100	930706.38	1840714.68	E1/4 S14
102	932026.36	1840702.73	N1/16 S14/S13
103	933346.24	1840690.83	NE S14
104	933324.62	1838048.80	N1/4 S14
105	930670.18	1838081.82	C1/4 S14
106	931997.50	1838065.30	N1/16 C-C S14
107	928043.51	1840755.02	SE S14
108	928016.89	1838114.74	S1/4 S14
110	930638.09	1835439.66	W1/4 S14
111	933289.49	1835401.81	NW S14
112	929374.43	1840734.71	S1/16 S13/S14
131	934609.67	1836709.61	SWC1/16 S11
132	935911.42	1836695.74	W1/16 C-C S11
133	935929.53	1838024.63	C1/4 S11
134	937265.20	1838012.32	N1/16 C-C S11
135	938600.42	1837999.89	N1/4 S11
136	938581.66	1835353.08	NW S11
147	935893.09	1830127.74	W1/4 S10
148	938556.40	1832704.54	N1/4 S10
153	935894.16	1835366.70	E1/4 S10
154	933270.35	1832801.16	S1/4 S10
183	937237.91	1835359.89	SET 3.25IN AC
185	934591.82	1835384.26	SET 3.25IN AC
6019	934627.02	1838036.79	S1/16 C-C S11
187	931959.99	1835420.79	SET 3.25IN AC
188	933307.07	1836725.96	SET 3.25IN AC
189	930654.13	1836760.74	SET 3.25IN AC 30'EAST TO COR
190	935260.54	1836702.68	SET 3.25IN AC
191	935242.99	1835375.48	SET 3.25IN AC
192			
193			

Tabulation of Found Property Pins (By M.S.M., Inc)

Point	Northing	Easting	Description
3068	943801.95	1831965.96	FND by MSM
3069	943786.55	1831965.83	FND by MSM
3070	941877.25	1832753.93	FND by MSM
3071	941176.37	1833030.61	FND by MSM
3072	941230.19	1833023.51	FND by MSM
3073	941091.88	1833052.39	FND by MSM
3074	939160.26	1833468.19	FND by MSM
3075	938565.34	1833642.51	FND by MSM
3078	931986.73	1837329.41	FND by MSM
3079	932474.71	1837147.40	FND by MSM
3080	937423.35	1834098.85	FND by MSM
3082	937469.82	1834076.95	FND by MSM
3085	937517.22	1834058.45	FND by MSM
3086	937553.53	1834257.70	FND by MSM
3087	937456.29	1834284.89	FND by MSM
3088	937556.76	1834288.10	FND by MSM
3111	930334.16	1838636.00	FND by MSM
3112	932949.17	1836970.78	FND by MSM
3113	933645.89	1836721.14	FND by MSM
3114	934462.71	1836158.43	FND by MSM
3115	934618.94	1836029.36	FND by MSM

Tabulation of Found Property Pins (By URS)

Point	Northing	Easting	Description
6017	935260.61	1836703.94	FND NO.4RBR NO CAP
6020	933998.32	1838042.49	FND 1.5IN STEEL PIPE NO CAP
6027	932964.66	1838053.34	FND NO.4RBR NO CAP
6031	932604.42	1838057.73	FND NO.4RBR NO CAP
6032	931992.12	1837689.36	FND NO.5 RBR NO CAP
6048	933979.72	1836718.68	FND NO.4RBR NO CAP
6053	931982.92	1837033.80	FND NO.5 RBR NO CAP

Tabulation of Temporary Easement Points To
Be Staked

Point	Northing	Easting	Type
900	934655.80	1836085.54	TE
901	934655.80	1836152.03	TE
902	934615.67	1836196.63	TE
903	934547.82	1836200.22	TE
904	933504.10	1836880.97	TE
905	933331.57	1837114.90	TE
906	933268.48	1837138.47	TE
907	933134.93	1836985.54	TE
908	933197.43	1836772.28	TE
909	933186.93	1836744.18	TE
910	933249.53	1836720.84	TE
911	933260.03	1836748.94	TE
912	932879.63	1837100.54	TE
913	932860.18	1837107.81	TE
914	932835.63	1837104.23	TE
915	932593.52	1837265.52	TE
916	932541.47	1837266.25	TE
917	932540.90	1837225.84	TE
918	932334.85	1837320.13	TE
919	932392.80	1837425.01	TE
920	932406.18	1837465.64	TE
921	932358.69	1837481.27	TE
922	932114.03	1837176.24	TE
923	932109.83	1837165.00	TE
924	932081.72	1837175.48	TE
925	932085.92	1837186.72	TE
926	930668.21	1837919.61	TE
927	930665.66	1837710.31	TE
929	932345.31	1837440.64	TE
930	930304.21	1838904.93	TE
931	930443.40	1838881.59	TE
932	930338.62	1839013.63	TE
933	930272.97	1838989.33	TE
934	931808.78	1837496.64	TE
935	931793.44	1837512.20	TE
936	931753.56	1837517.80	TE
937	931730.00	1837510.58	TE
938	931762.98	1837498.29	TE
939	930398.01	1838881.83	TE
940	930397.50	1838787.37	TE
941	932284.59	1837388.73	TE
942	932224.36	1837427.79	TE
943	932592.35	1837182.95	TE

GENERAL NOTES

- This Right-of-Way plan is not a complete boundary survey of all the adjoining property owners and is prepared for the Transportation Department purposes ONLY.
- Title Commitments / Policies supplied by H. C. Peck and Associates, Inc. (United General Title Insurance Company (Denver, CO)
- NOTICE: According to Colorado law you must commence any legal action based upon any defect in this survey within three years after you first discover such defect. In no event, may any action based upon any defect in this survey be commenced more than ten years from the date of certification shown hereon.
- All R.O.W. Markers set from survey control points.
- All centerline and offset stationing is theoretical only and may not represent the centerline as constructed in the field.
- All coordinates listed are PROJECT COORDINATES.
- BASIS OF BEARINGS: Bearings used in the calculations of coordinates are based on a grid bearing of N30°49'24"W from SH-85 CM-MP 196.80 and SH-85 CM-MP 197.00. Both monuments are CDOT Type II, marked appropriately for their milepost location and control position. The survey data was obtained from a Global Positioning System (GPS) survey based on the Colorado High Accuracy Reference Network (CHARN) NAD 83(92).

FIELD SURVEYOR'S STATEMENT

ORIGINAL ALIQUOT AND BOUNDARY MARKER
LOCATION AND RIGHT OF WAY MONUMENTATION
WAS DONE UNDER MY SUPERVISION AND
CHECKING.

NAME THOMAS W. STOUTENBURG P.L.S. NO. 22103

DATE _____

OFFICE SURVEYOR'S STATEMENT

R.O.W. PLANS AND LEGAL DESCRIPTIONS WERE
PREPARED UNDER MY SUPERVISION AND
CHECKING.

NAME THOMAS W. STOUTENBURG P.L.S. NO. 22103

DATE _____

FILED CERTIFICATION: _____ DAY OF _____, 19____, AT _____, FOR INFORMATION
ONLY IN BOOK _____ OF THE COUNTY LAND SURVEYS/RIGHT OF WAY
SURVEYS AT PAGE _____, RECEPTION NUMBER _____

SIGNED _____
DEPT. _____

COLORADO DEPARTMENT OF TRANSPORTATION



Region 1
18500 E. Colfax Avenue
Aurora, CO 80011
Phone: (303) 757-9117 FAX: (303) 757-9746

Right-of-Way and Survey Unit: Kevin A. Williams

Sheet Revisions

Date	Description	Initials
3/2/05	Added Pnts. 192&193	BDL
3/2/05	Deleted 101&109 (not needed for boundaries)	BDL

Sheet Revisions

Date	Description	Initials

Prepared By:



URS Corporation
8181 East Tufts Ave. Denver, CO 80237
Phone: (303)694-2770 Fax: (303) 694-3946

Computer File
Information

CREATION DATE: 11/18/2004 INITIALS: BDL
LAST MOD. DATE: 3/2/2005 INITIALS: BDL
DRAWING NAME & FULL PATH: SEE LEFT
SIDE OF SHEET

SCALE: As Shown UNITS: English

Right of Way Plans

 

ALIQUOT SECTION BREAKDOWN

Project Number: NH 0852-086 Phase IV (ROW) / NH 0852-097 (Const.) (P.C. 15139)
Project Location: SH 85, Meadows to C470
Project Location: Louviers South to Sedalia / M.P. 194.0 to M.P. 190.6
Project Code: 13429
Subset Sheets: 2 of 7
Sheet No.: 4A
Total No. of Sheets: 43

FILING CERTIFICATION:
DEPOSITED THIS _____ DAY OF _____, 19____, AT _____, FOR INFORMATION
ONLY IN BOOK _____ OF THE COUNTY LAND SURVEYS/RIGHT OF WAY
SURVEYS AT PAGE _____, RECEPTION NUMBER _____

SIGNED _____
DEPT. _____

I:\PROJECTS\22237041_SH85_Sof_Titan\Sedalia_North\6.07_Right_of_Way\Plans\Section-Contral.dwg 3/4/2005 9:35:04 AM MST

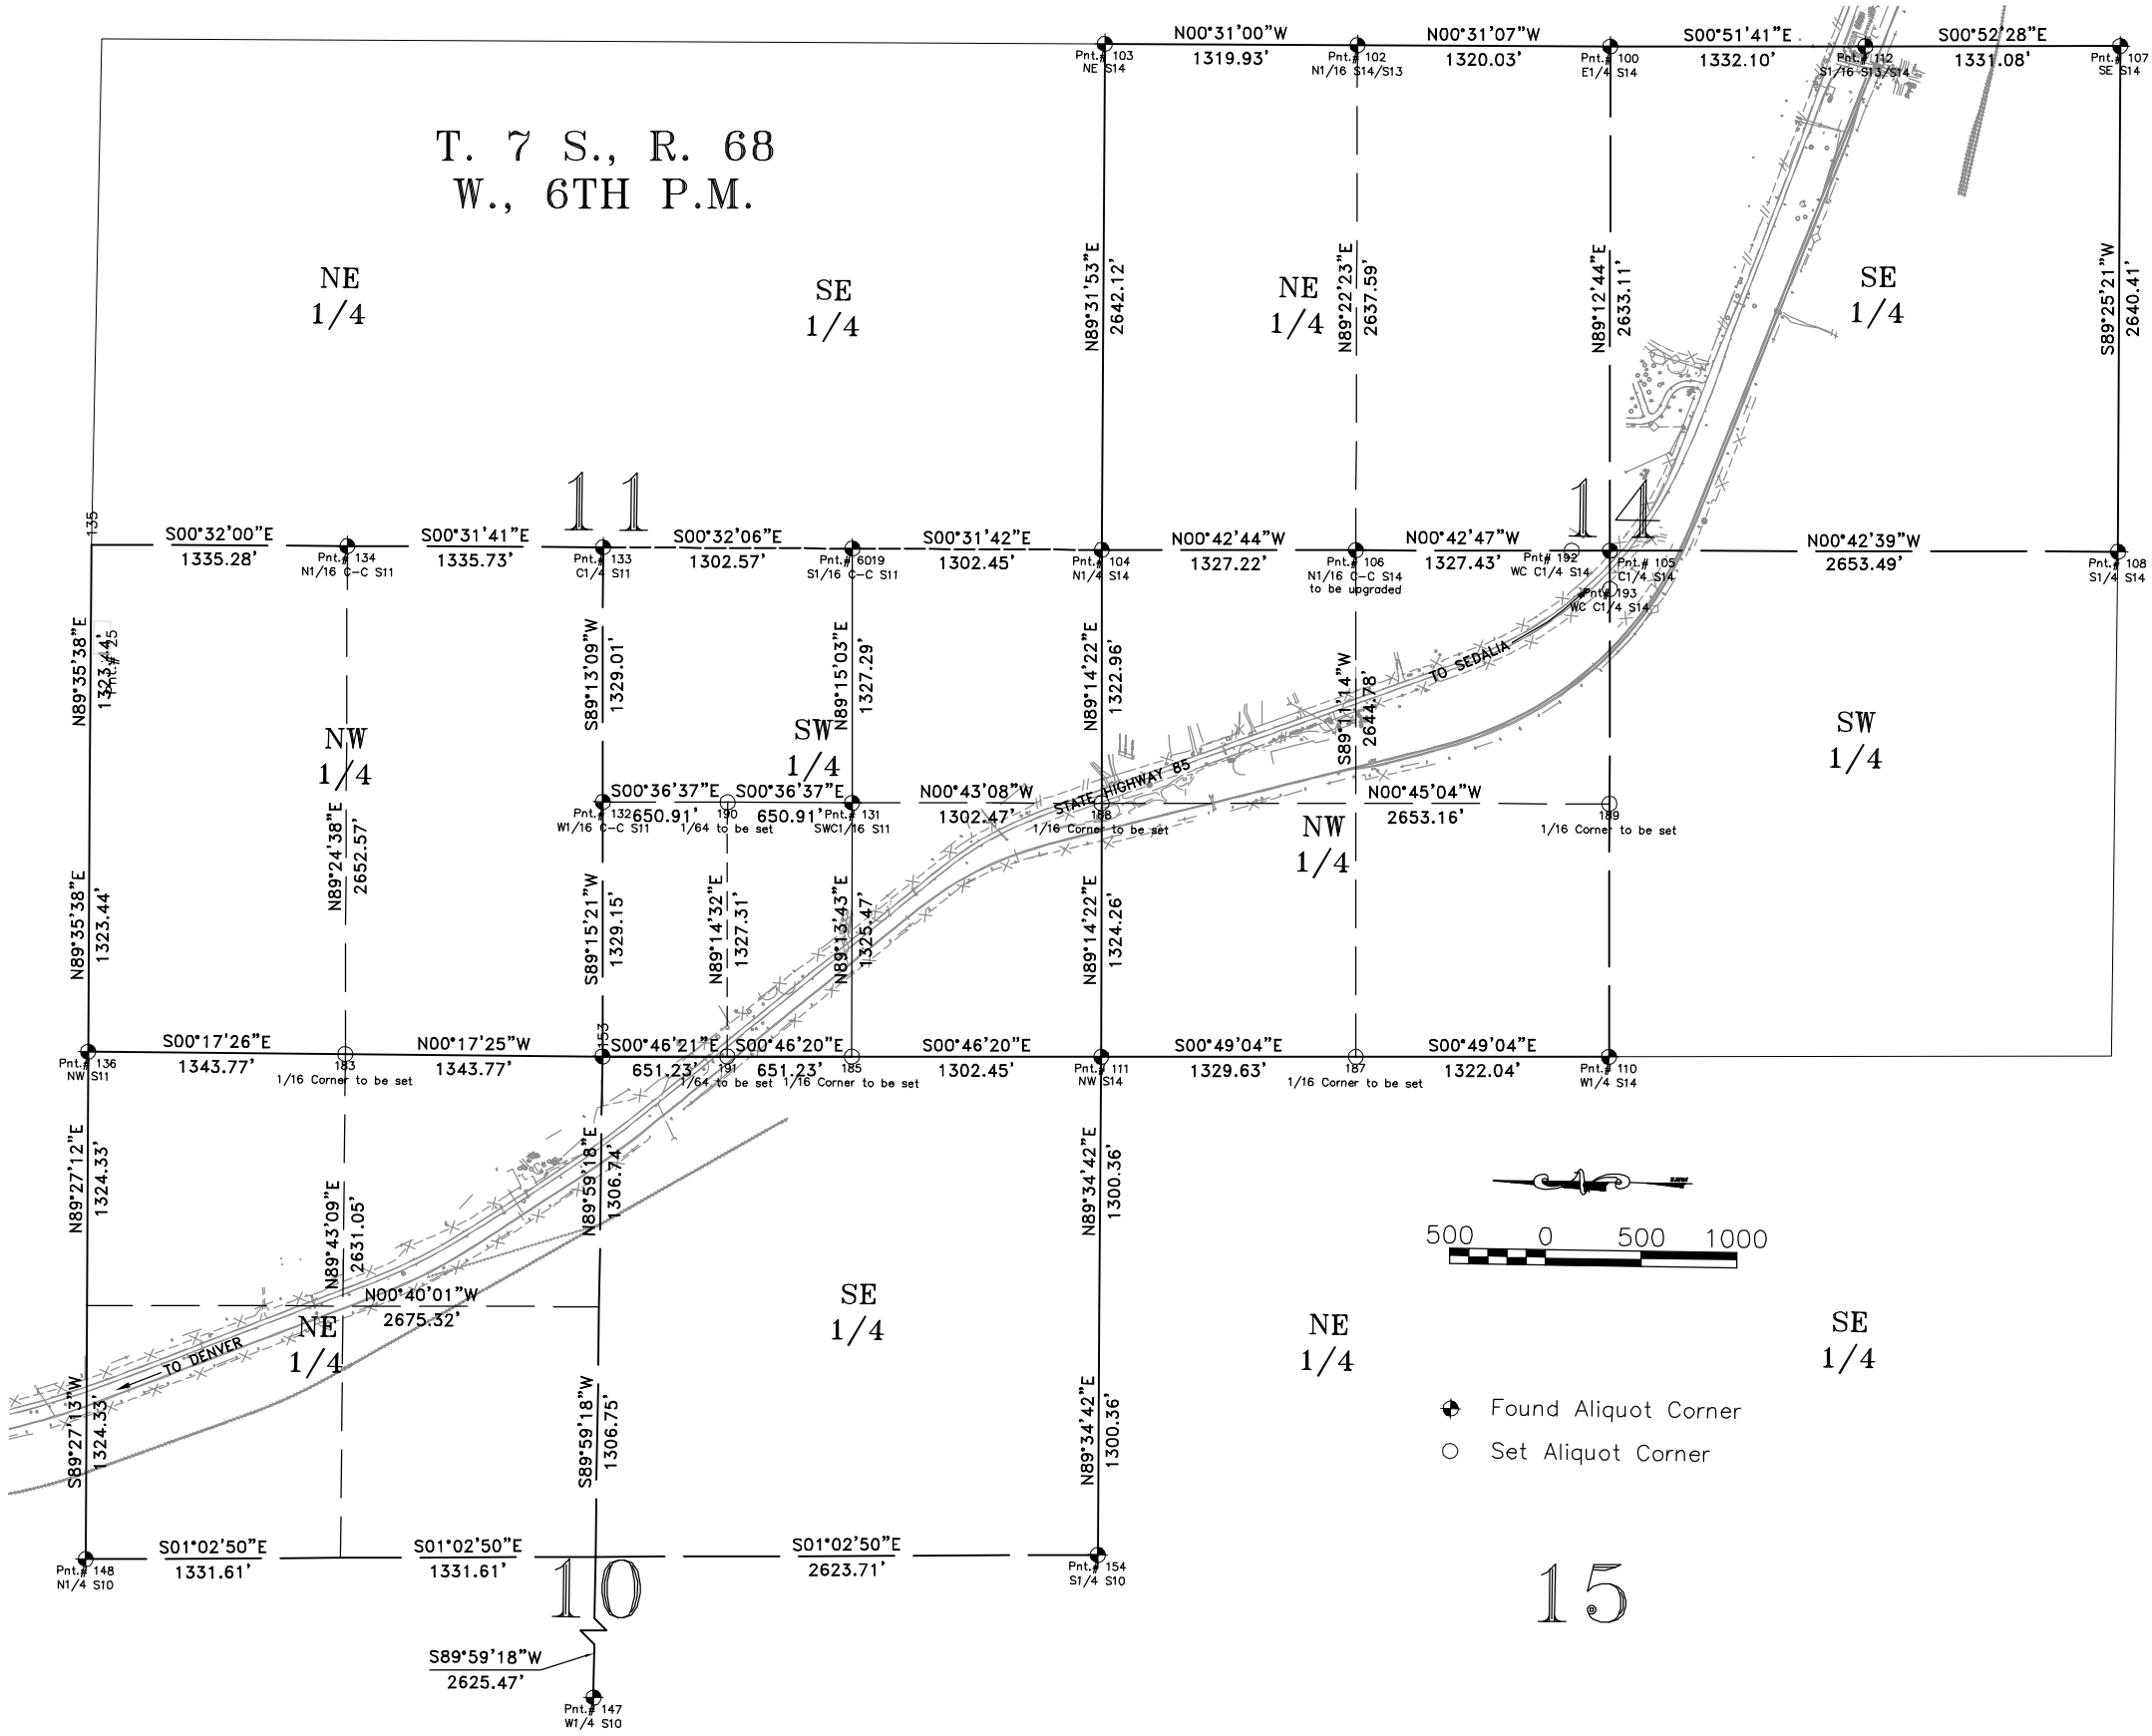

Found Aliquot Corner
Set Aliquot Corner

15

COLORADO DEPARTMENT OF TRANSPORTATION



Region 1
18500 E. Colfax Avenue
Aurora, CO 80011
Phone: (303) 757-9117 FAX: (303) 757-9746

Right-of-Way and Survey Unit: Kevin A. Williams

Sheet Revisions

Date	Description	Initials
xx/xx/xx	x	xxx

Sheet Revisions

Date	Description	Initials

Prepared By:

URS

URS Corporation
8181 East Tufts Ave. Denver, CO 80237
Phone: (303)694-2770 Fax: (303) 694-3946


Computer File
Information

CREATION DATE: 11/18/2004 INITIALS: BDL
LAST MOD. DATE: 2/1/2005 INITIALS: BDL
DRAWING NAME & FULL PATH: SEE LEFT
SIDE OF SHEET
SCALE: As Shown UNITS: English


Right of Way Plans

MONUMENTS SHEET


Project Number: NH 0852-086 Phase IV (ROW) / NH 0852-097 (Const.) (P.C. 15139)				
Project Location: SH 85, Meadows to C470				
Project Location: Louviers South to Sedalia / M.P. 194.0 to M.P. 190.6				
Project Code: 13429		Subset Sheets: 3 of 7	Sheet No.: 4B	Total No. of Sheets: 43

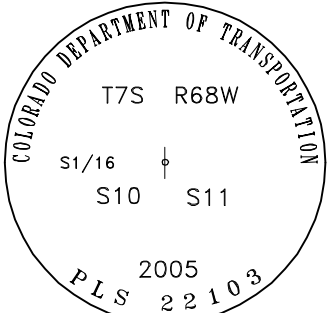


Set 3 1/4" Alum Cap
Pt. No. 185

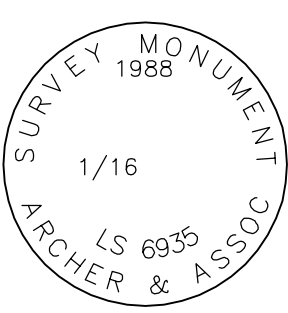


Fnd 2.5" Alum Cap
stamped as shown
Pt. Nos. 131 & 132

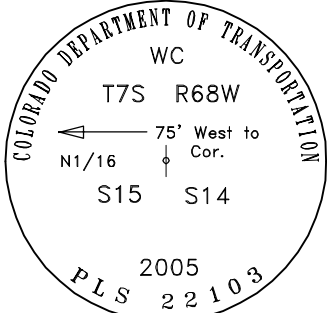


Set 3 1/4" Alum Cap
Pt. No. 187

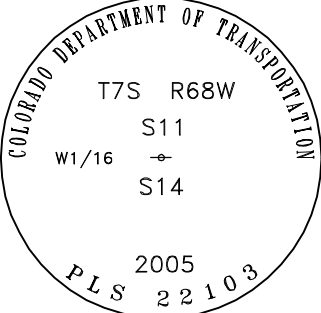


Set 3 1/4" Alum Cap
Pt. No. 188

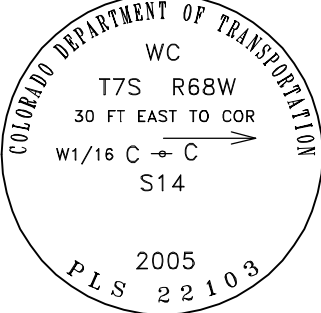


Set 3 1/4" Alum Cap
Pt. No. 189

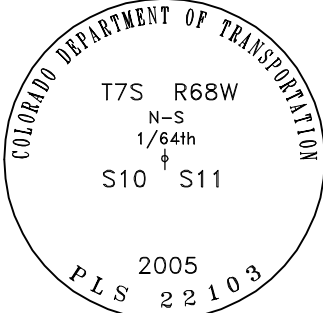


Set 3 1/4" Alum Cap
Pt. No. 191

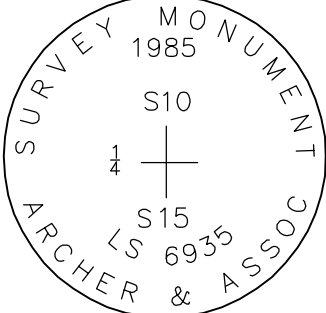

Fnd 3 1/4 " AC stamped as shown
Pt. No. 154

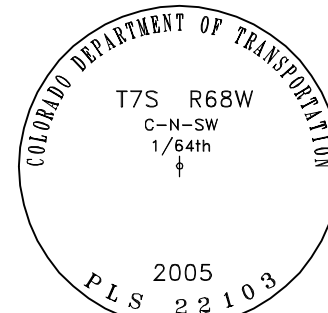


Set 3 1/4" Alum Cap
Pt. No. 190

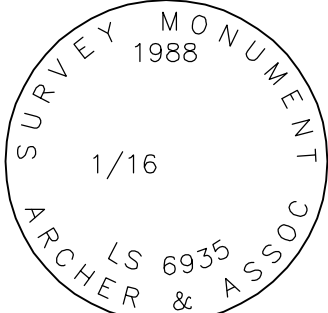


Fnd 2.5" Alum Cap
stamped as shown
Pt. No. 6019




Fnd No. 4 Rebar with
no cap.
Pt. Nos. 6017, 6027,
6031, & 6048

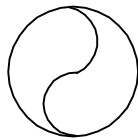


Fnd No. 5 Rebar with
no cap.
Pt. No. 6032

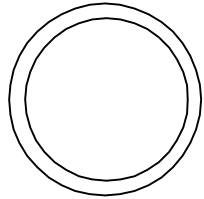


Fnd. 1 1/2 " Pipe
with no cap.
Pt. No. 6020

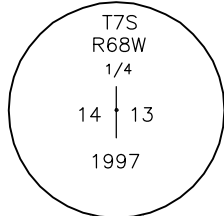


Fnd 2" AC stamped as
shown
PT. No. 100

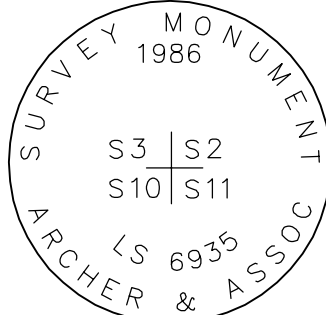


Fnd 3 1/4 " AC stamped as shown
Pt. No. 136

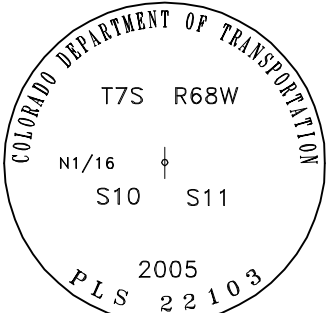


Set 3 1/4" Alum Cap
Pt. No. 183

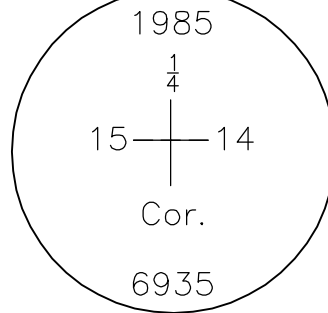


Fnd 3" AC stamped as
shown
Pt. No. 110

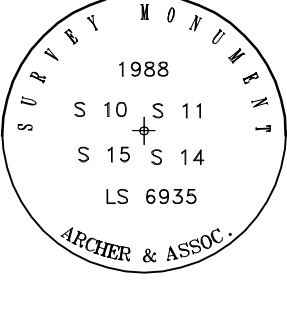


Fnd 2" AC stamped as
shown
Pt. No. 111

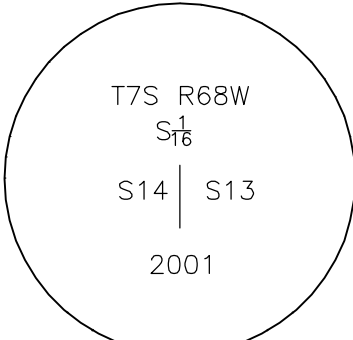


Set 3 1/4" AC stamped
as shown
Pt. No. 112

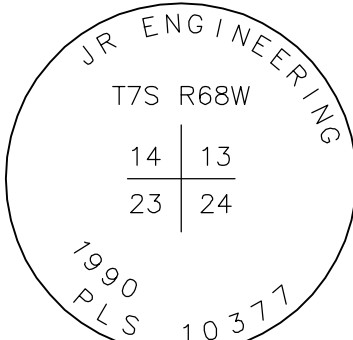


Fnd 3.5" AC stamped
as shown
Pt. No. 107

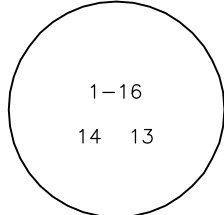


Fnd 2" AC stamped as
shown
Pt. No. 102

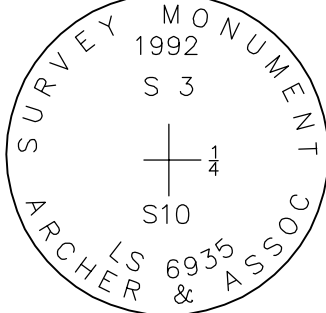


Fnd 2.5" AC stamped
as shown Pt. No. 148

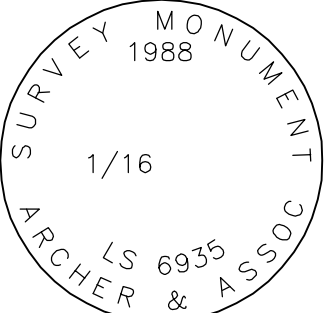


Fnd 21/2" AC stamped
as shown Pt. No. 134

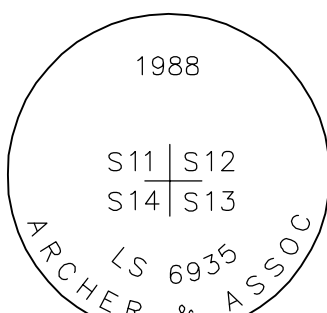


Fnd 3 1/4 " AC stamped as shown
Pt. No. 103

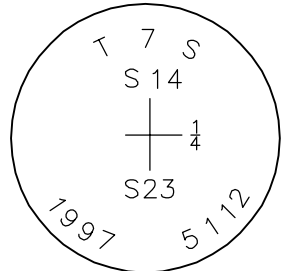


Fnd 2" AC stamped as
shown Pt. No. 108

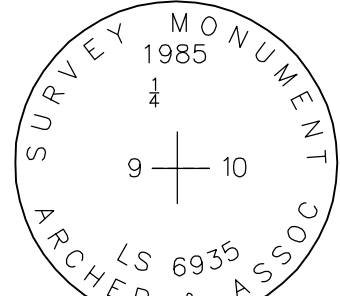


Fnd 31/4" AC stamped
as shown Pt. No. 147

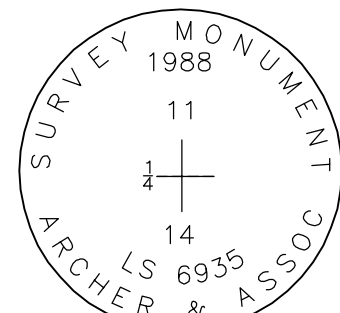

Fnd 21/2" AC stamped as
shown Pt. No. 104

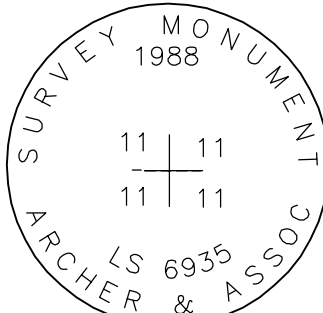

Fnd 3" AC stamped as
shown Pt. No. 133

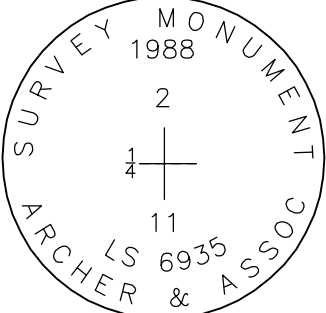

Fnd 21/2" AC stamped
as shown Pt. No. 135

FILED CERTIFICATION: DEPOSITED THIS DAY OF 19 AT M., FOR INFORMATION ONLY IN BOOK OF THE COUNTY LAND SURVEYS/RIGHT OF WAY SURVEYS AT PAGE RECEPTION NUMBER

SIGNED DEPT.

COLORADO DEPARTMENT OF TRANSPORTATION



Region 1
18500 E. Colfax Avenue
Aurora, CO 80011
Phone: (303) 757-9117 FAX: (303) 757-9746

Right-of-Way and Survey Unit: Kevin A. Williams

Sheet Revisions

Date	Description	Initials
3/2/05	Added Pnts. 192&193, deleted Pnts.101&109	BDL

Sheet Revisions

Date	Description	Initials

Prepared By:



URS Corporation
8181 East Tufts Ave. Denver, CO 80237
Phone: (303)694-2770 Fax: (303) 694-3946

Computer File
Information


CREATION DATE: 11/18/2004 INITIALS: BDL
LAST MOD. DATE: 3/2/2005 INITIALS: BDL
DRAWING NAME & FULL PATH: SEE LEFT
SIDE OF SHEET

SCALE: As Shown UNITS: English


Right of Way Plans

MONUMENTS SHEET


Project Number: NH 0852-086 Phase IV (ROW) / NH 0852-097 (Const.) (P.C. 15139)				
Project Location: SH 85, Meadows to C470				
Project Location: Louviers South to Sedalia / M.P. 194.0 to M.P. 190.6				
Project Code:	Subset Sheets	Sheet No.	Total No. of Sheets	
13429	4 of 7	4C	43	

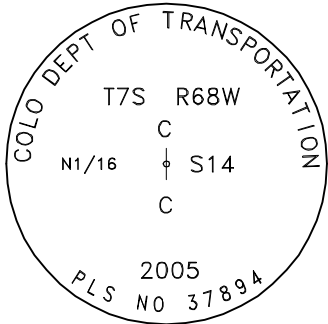

Set 3 1/4" Alum Cap
Pt. No. 106

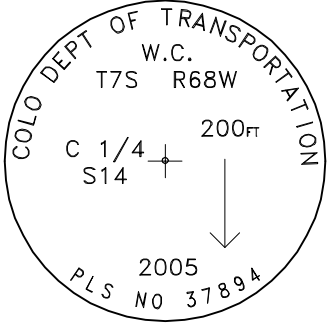

Set 3 1/4" Alum Cap
Pt. No. 192

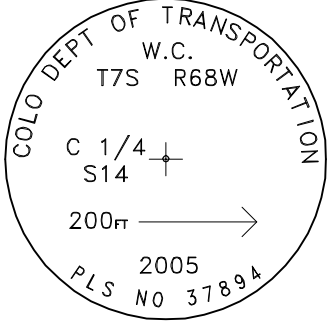

Set 3 1/4" Alum Cap
Pt. No. 193

FILING CERTIFICATION:
DEPOSITED THIS ____ DAY OF _____, 19____, AT _____M., FOR INFORMATION
ONLY IN BOOK ____ OF THE COUNTY LAND SURVEYS/RIGHT OF WAY
SURVEYS AT PAGE _____, RECEPTION NUMBER _____

SIGNED _____
DEPT. _____



Region 1
18500 E. Colfax Avenue
Aurora, CO 80011
Phone: (303) 757-9117 FAX: (303) 757-9746

Right-of-Way and Survey Unit: Kevin A. Williams

Sheet Revisions

Date	Description	Initials

Sheet Revisions

Date	Description	Initials

Prepared By:

URS

URS Corporation
8181 East Tufts Ave. Denver, CO 80237
Phone: (303)694-2770 Fax: (303) 694-3946


Computer File
Information

CREATION DATE: 1/26/2005 INITIALS: BDL
LAST MOD. DATE: 2/1/2005 INITIALS: BDL
DRAWING NAME & FULL PATH: SEE LEFT
SIDE OF SHEET
SCALE: As Shown UNITS: English


Right of Way Plans

MONUMENT TYPICAL 1


Project Number: NH 0852-086 Phase IV (ROW) / NH 0852-097 (Const.) (P.C. 15139)
Project Location: SH 85, Meadows to C470
Project Location: Louviers South to Sedalia / M.P. 194.0 to M.P. 190.6
Project Code: 13429
Subset Sheets 5 of 7
Sheet No. 40
Total No. of Sheets 43

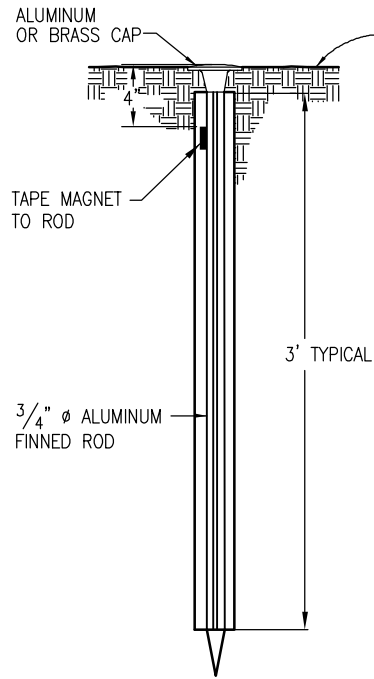


TYPE 1 MONUMENT

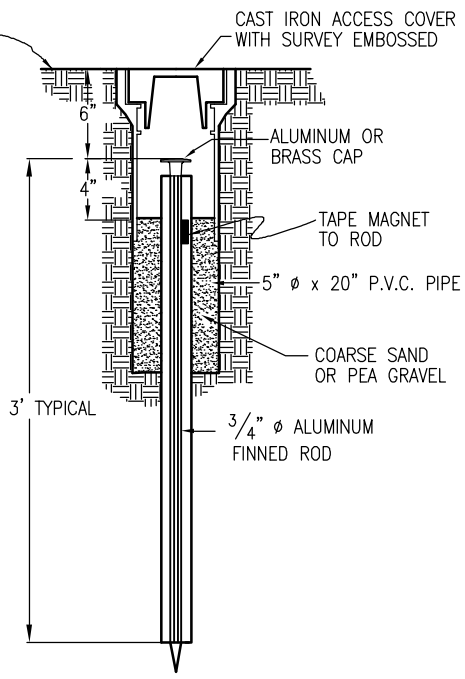


TYPE 1A MONUMENT
INCLUDES MONUMENT BOX

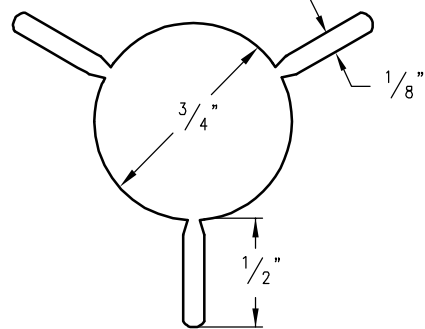


SECTION A-A

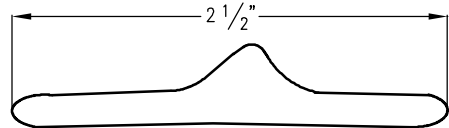


SECTION B-B

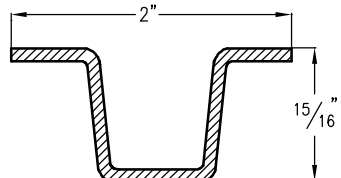


DELINEATOR POST
SECTION C-C

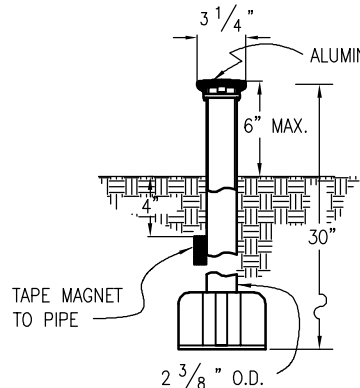


TYPE 3 MONUMENT

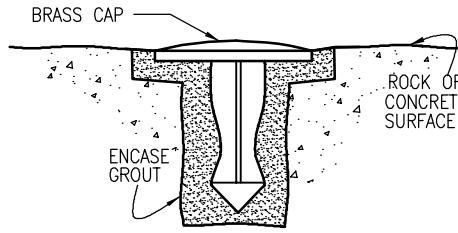


TYPE 5 MONUMENT
ALUMINUM CAP AND TYPE 5(S)
DETAILS SHOWN ON SHEET 2

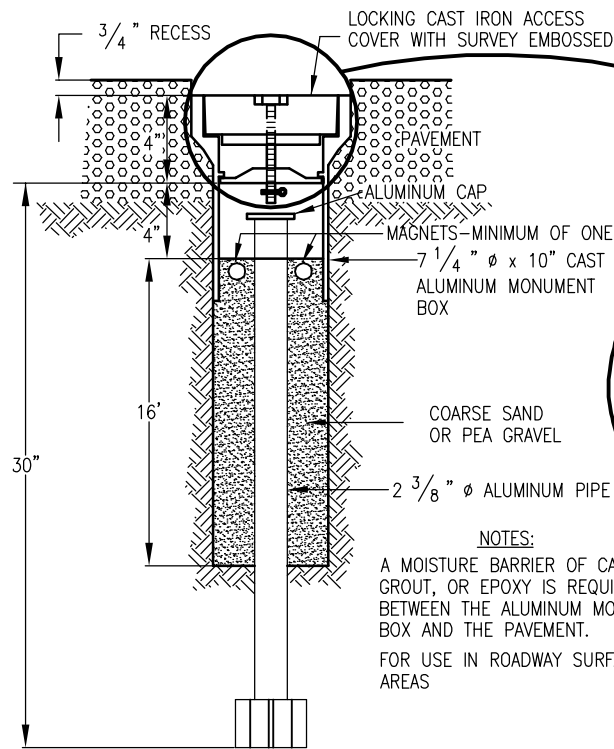


TYPE 3A MONUMENT
ROADWAY INSTALLATION
INCLUDES MONUMENT BOX

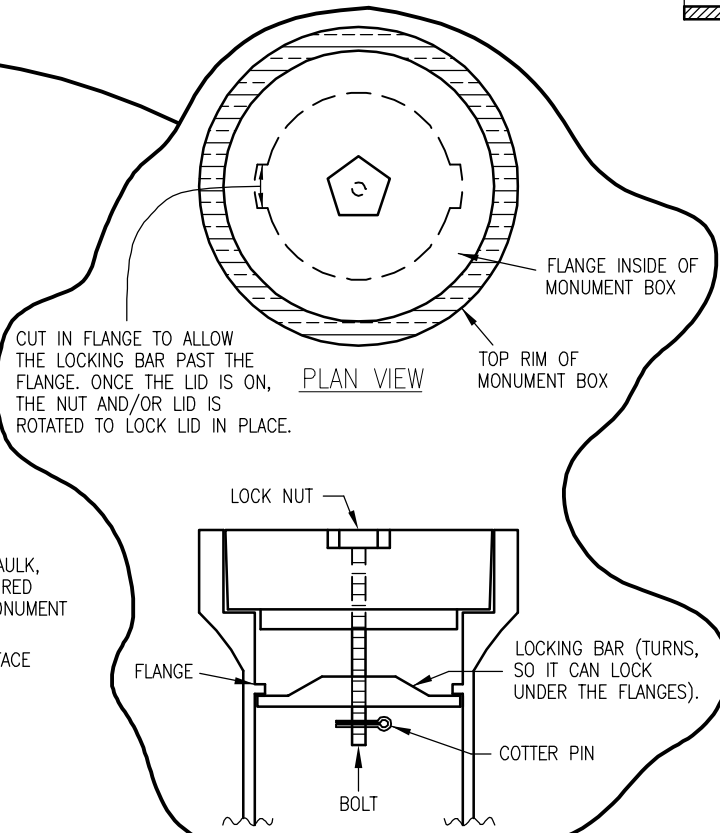


LOCKING CAST IRON ACCESS COVER

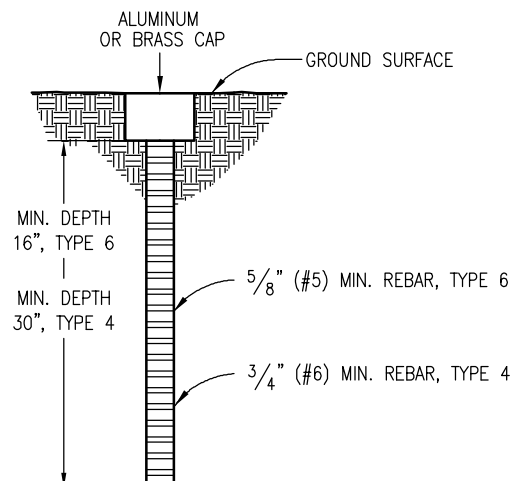

TYPE 4 AND TYPE 6 MONUMENT

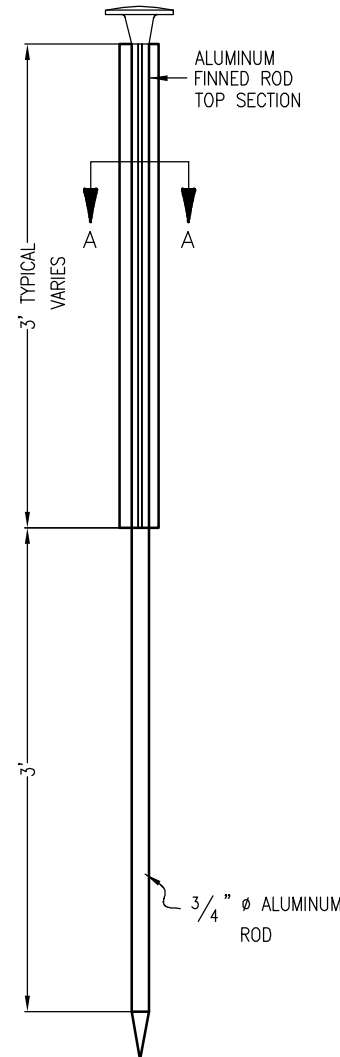

TYPE 2 MONUMENT
TYPE 2A INCLUDES MONUMENT BOX

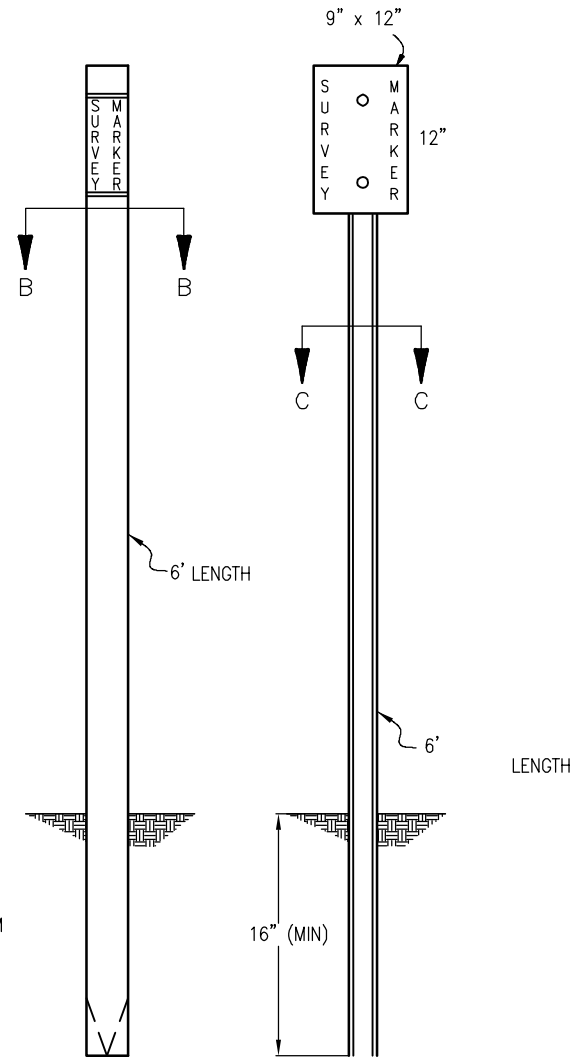

WITNESS POSTS

FILING CERTIFICATION: DEPOSITED THIS _____ DAY OF _____, 19____, AT _____, FOR INFORMATION
ONLY IN BOOK _____ OF THE COUNTY LAND SURVEYS/RIGHT OF WAY
SURVEYS AT PAGE _____, RECEPTION NUMBER _____
SIGNED _____
DEPT. _____

COLORADO DEPARTMENT OF TRANSPORTATION



Region 1
18500 E. Colfax Avenue
Aurora, CO 80011
Phone: (303) 757-9117 FAX: (303) 757-9746

Right-of-Way and Survey Unit: Kevin A. Williams

Sheet Revisions

Date	Description	Initials

Sheet Revisions

Date	Description	Initials

Prepared By:



URS Corporation
8181 East Tufts Ave. Denver, CO 80237
Phone: (303)694-2770 Fax: (303) 694-3946

Computer File
Information

CREATION DATE: 1/26/2005 INITIALS: BDL
LAST MOD. DATE: 2/1/2005 INITIALS: BDL
DRAWING NAME & FULL PATH: SEE LEFT
SIDE OF SHEET

SCALE: As Shown UNITS: English

Right of Way Plans


MONUMENT TYPICAL 2

Project Number: NH 0852-086 Phase IV (ROW) / NH 0852-097 (Const.) (P.C. 15139)


Project Location: SH 85, Meadows to C470

Project Location: Louviers South to Sedalia / M.P. 194.0 to M.P. 190.6


Project Code:	Subset Sheets	Sheet No.	Total No. of Sheets
13429		6 of 7	4E 43

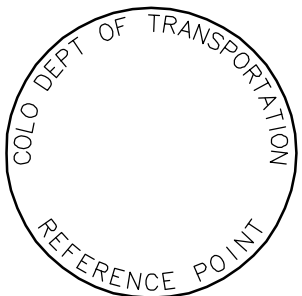


REFERENCE
MONUMENT CAP

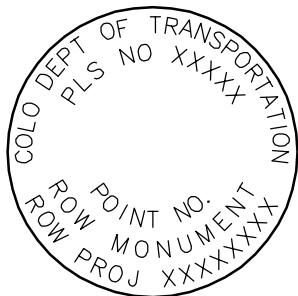

ROW
MONUMENT CAP

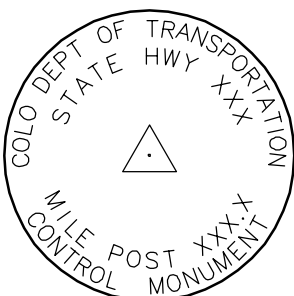

CONTROL
MONUMENT CAP

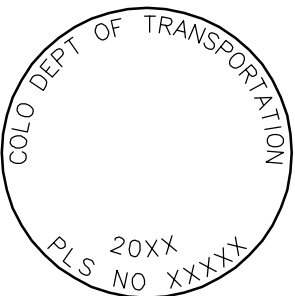


ALIQOT CORNER
MONUMENT CAP




ALUMINUM CAP


NOTE: A BLANK CAP MAY BE SUBSTITUTED IF THE APPROPRIATE CAP SHOWN ABOVE IS NOT AVAILABLE. IF A BLANK CAP IS USED, ALL INFORMATION NORMALLY INCLUDED ON THE APPROPRIATE STANDARD CAP, SHALL BE STAMPED ON THE BLANK CAP ALONG WITH SPECIFIC PROJECT INFORMATION SUCH AS PROJECT NO., DATE, POINT NO., ETC..

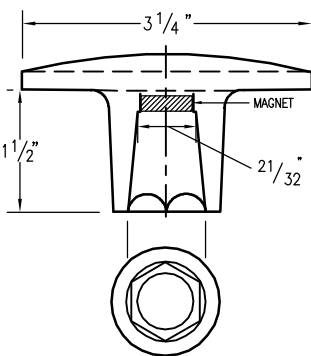


ALUMINUM CAP
USED WITH ALUMINUM ROD

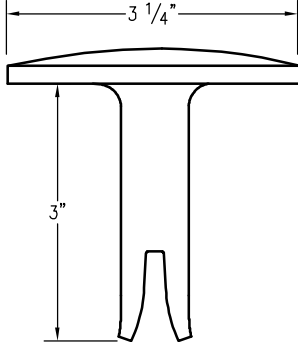



ALUMINUM CAP
TYPE 5
FOR PLACING IN EXISTING
CONCRETE OR ROCK

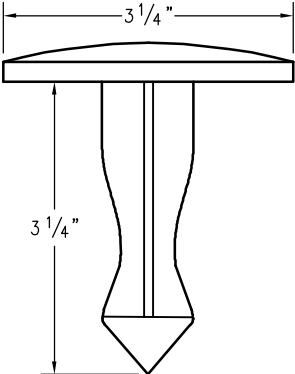

BRASS CAP
TYPE 5
FOR PLACING IN EXISTING
CONCRETE OR ROCK

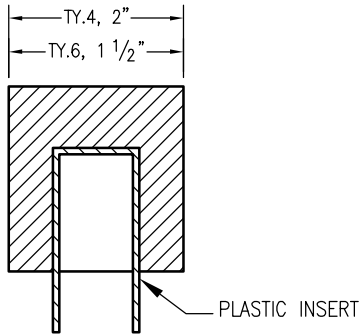

ALUMINUM CAP

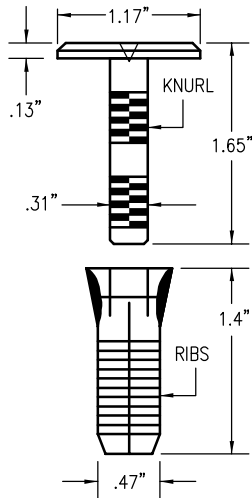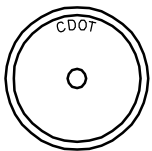

COPPER ALLOY CAP
TYPE 5(S)
FOR PLACING IN EXISTING
SIDEWALK, CURB, OR GUTTER

ALL MONUMENTATION MATERIALS WILL BE FURNISHED BY CDOT

THE MONUMENT TYPE SHALL MEET THE MINIMUM STANDARDS AS DETERMINED BY THE COLORADO STATE BOARD OF REGISTRATION FOR PROFESSIONAL LAND SURVEYORS RULES (STATE BOARD RULES).

THE CDOT SURVEY COORDINATOR SHALL APPROVE ALL EXCEPTIONS FOR STAMPING MONUMENTS DIFFERING FROM THE STANDARDS.

TYPE 1 AND TYPE 1A ALUMINUM FINNED ROD MONUMENTS

THIS MONUMENT SHALL BE USED FOR ROW OR REFERENCE MONUMENTS OR MAY BE USED FOR AN ALIQUOT CORNER MONUMENT. WHEN USED AS AN ALIQUOT CORNER MONUMENT, INSTALLATION AND RECORD FILING REQUIREMENTS SHALL BE AS STATED FOR TYPE 3 AND TYPE 3A MONUMENTS.

MONUMENTS SHALL BE INSTALLED BY ATTACHING THE PROPER SIZE TIP TO ONE END OF A SECTION OF FINNED ROD, AND A 3 INCH LONG X 3/4 INCH DIA. STAINLESS STEEL ADAPTER TO THE OTHER END. THE DRIVER IS THEN PLACED OVER THE STAINLESS STEEL ADAPTER FOR THE HAMMER TO CONTACT. TYPE 1 MONUMENTS SHALL USE A MINIMUM 3 FOOT SECTION OF FINNED ROD.

WHEN SUBSURFACE ROCK OR CONCRETE IS ENCOUNTERED LESS THAN 3 FEET BELOW THE GROUND SURFACE, THE ROD SHALL BE EMBEDDED IN THE ROCK OR IN CONCRETE AT LEAST 6 INCHES WITH A GROUT MATERIAL. THE ROD MAY BE SHORTENED TO ACCOMMODATE THE CONDITIONS.

WHEN UNSTABLE SOIL CONDITIONS ARE ENCOUNTERED, ADDITIONAL SECTIONS OF ROD SHALL BE ADDED TO ACHIEVE STABILITY. HORIZONTAL AND VERTICAL STABILITY ARE REQUIRED.

TYPE 1A MONUMENT INCLUDES MONUMENT BOX. A LOCKING CAST IRON ACCESS COVER SHALL BE REQUIRED WHEN THE MONUMENT IS LOCATED IN THE ROADWAY.

TYPE 2 AND TYPE 2A ALUMINUM FINNED ROD MONUMENTS

THIS MONUMENT SHALL BE USED FOR HORIZONTAL AND VERTICAL CONTROL MONUMENTS. ADDITIONAL FINNED SECTIONS OF ROD ARE INSTALLED TO ACHIEVE REQUIRED HORIZONTAL AND VERTICAL STABILITY WHERE UNSTABLE SOIL CONDITIONS ARE ENCOUNTERED. IN MOST SOIL CONDITIONS THE TYPE 2 MONUMENT IS EMBEDDED 6 FEET INTO THE GROUND.

THE MONUMENT SHALL BE INSTALLED BY FIRST ATTACHING THE PROPER SIZE TIP TO A 3 FOOT LONG X 3/4 INCH DIA. ROD, THEN DRIVING THE ROD AT LEAST 30 INCHES INTO THE GROUND. ADDITIONAL 3 FOOT LONG X 3/4 INCH FINNED ROD SECTIONS ARE ADDED AND DRIVEN FLUSH WITH THE GROUND UNTIL THE MONUMENT IS IN A STABLE POSITION. THE FINNS ARE BENT OVER USING PLIERS TO ACCOMMODATE INSTALLING THE CAP. THE CAP IS FIRMLY SEATED ONTO THE LAST FINNED SECTION OF ROD USING A DEAD BLOW SLEDGE HAMMER.

TYPE 2A MONUMENT INCLUDES MONUMENT BOX. A LOCKING CAST IRON ACCESS COVER SHALL BE REQUIRED WHEN THE MONUMENT IS LOCATED IN THE ROADWAY.

TYPE 3 AND TYPE 3A ALUMINUM PIPE MONUMENTS

THIS MONUMENT SHALL BE USED FOR AN ALIQUOT CORNER MONUMENT. THE INSTALLATION OF THIS MONUMENT AND RECORD FILING SHALL BE DONE IN ACCORDANCE WITH THE STATE BOARD RULES. ALSO REFER TO THE CDOT SURVEY MANUAL AND THE BUREAU OF LAND MANAGEMENT REQUIREMENTS FOR MONUMENT INSTALLATION. THE LAND SURVEYOR'S LICENSE NUMBER AND THE YEAR SHALL BE STAMPED ON THE CAP.

TYPE 3A MONUMENT INCLUDES MONUMENT BOX. A LOCKING CAST IRON ACCESS COVER SHALL BE REQUIRED WHEN THE MONUMENT IS LOCATED IN THE ROADWAY.

TYPE 4 ALUMINUM MONUMENT

THIS MONUMENT MAY BE INSTALLED IN LIEU OF REPLACING THE ENTIRE MONUMENT WHEN REBAR IS IN PLACE AT AN ALIQUOT CORNER LOCATION. REFER TO THE STATE BOARD RULES. A MINIMUM 2 INCH DIA. CAP SHALL BE USED ON 3/4 INCH (#6) REBAR.

TYPE 5 BRASS/ALUMINUM CAP MONUMENT

THIS MONUMENT CAN BE USED IN LIEU OF ALL OTHER CDOT MONUMENTS, WHEN THE POSITION IS LOCATED IN CONCRETE OR STABLE ROCK FORMATION.

TYPE 5(S) COPPER ALLOY CAP MONUMENT – SMALL

THIS MONUMENT MAY BE USED IN LIEU OF A TYPE 5 MONUMENT, WHEN THE POSITION IS LOCATED IN A CONCRETE SIDEWALK, CURB OR GUTTER, OR WHEN SETTING A TYPE 5 WOULD COMPROMISE THE INTEGRITY OF THE RECEIVING STRUCTURE.

STAMPING REQUIREMENTS:

- "RP", WHEN THE APPLICATION IS A REFERENCE POINT.
- "ROW", POINT NUMBER, "LS", AND REGISTRATION NUMBER WHEN THE APPLICATION IS A ROW POINT.
- "CP" AND A UNIQUE IDENTIFIER PROVIDED BY THE REGION SURVEY COORDINATOR, WHEN THE APPLICATION IS A CONTROL POINT.
- "PE", POINT NUMBER, "LS", AND REGISTRATION NUMBER, WHEN THE APPLICATION IS A PERMANENT EASEMENT POINT.
- "PP" AND NUMBER, WHEN THE APPLICATION IS A PROJECT POINT.

TYPE 6 ALUMINUM MONUMENT

THIS MONUMENT SHALL BE USED FOR PERMANENT EASEMENTS, PROJECT BENCH MARKS, PROJECT POINTS, AND REFERENCES. AN ALUMINUM CAP WITH A MINIMUM DIAMETER OF 1 1/2 INCHES, SHALL BE USED ON 5/8 INCH (#5) MINIMUM REBAR.

* WITNESS POSTS

THE WITNESS POST WILL BE SUPPLIED BY CDOT AND INSTALLATION SHALL BE INCLUDED IN THE WORK. IT SHALL BE DRIVEN WITHIN 1 FOOT OF THE MONUMENT WHEN POSSIBLE. A DELINEATOR POST WITH A 9 INCH X 12 INCH METAL SIGN PANEL MAY BE USED IN LIEU OF THE PLASTIC POST. THIS POST SHALL CONFORM TO STANDARD PLAN S-612-1. A REQUIRED WITNESS POST MAY BE OMITTED WITH THE APPROVAL OF THE ENGINEER IF THE WITNESS POST LOCATION IS WITHIN A TRAVELED WAY, DRIVEWAY, OR ACCESS OPENING.

FILING CERTIFICATION: DEPOSITED THIS _____ DAY OF _____, 19____, AT _____, FOR INFORMATION ONLY IN BOOK _____ OF THE COUNTY LAND SURVEYS/RIGHT OF WAY SURVEYS AT PAGE _____, RECEPTION NUMBER _____

SIGNED _____
DEPT. _____

COLORADO DEPARTMENT OF TRANSPORTATION



Region 1
18500 E. Colfax Avenue
Aurora, CO 80011
Phone: (303) 757-9117 FAX: (303) 757-9746

Right-of-Way and Survey Unit: Kevin A. Williams

Sheet Revisions

Date	Description	Initials

Sheet Revisions

Date	Description	Initials

Prepared By:

URS

URS Corporation
8181 East Tufts Ave. Denver, CO 80237
Phone: (303)694-2770 Fax: (303) 694-3946

Computer File
Information

CREATION DATE: 11/18/2004 INITIALS: BDL
LAST MOD. DATE: 2/1/2005 INITIALS: BDL
DRAWING NAME & FULL PATH: SEE LEFT
SIDE OF SHEET

SCALE: As Shown UNITS: English


Right of Way Plans

FOUND MONUMENTS DETAIL


Project Number:	NH 0852-086 Phase IV (ROW) / NH 0852-097 (Const.) (P.C. 15139)			
Project Location:	SH 85, Meadows to C470			
Project Location:	Louviers South to Sedalia / M.P. 194.0 to M.P. 190.6			
Project Code:	13429	Subset Sheets	7 of 7	Sheet No. 4F
				Total No. of Sheets 43

1''=2'

DETAIL A

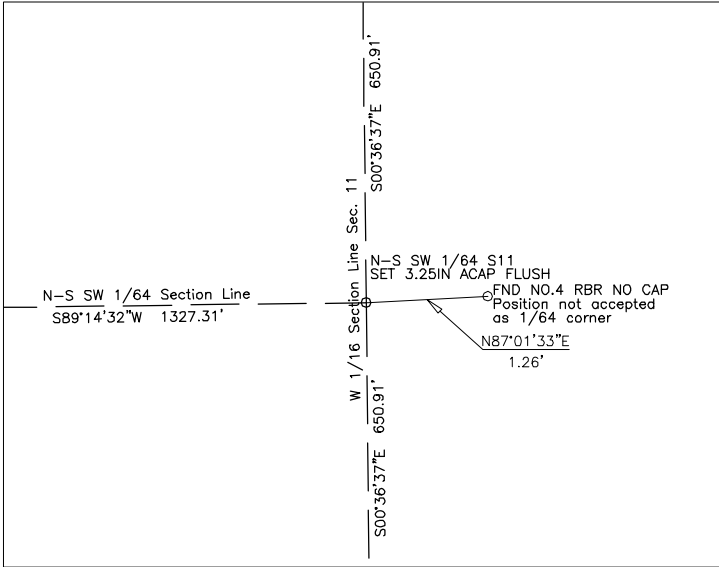

DETAIL B

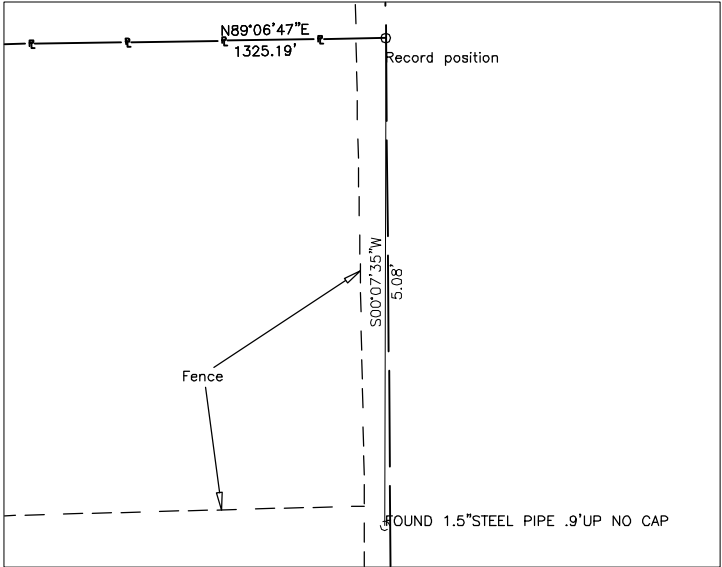

FILING CERTIFICATION:
DEPOSITED THIS ____ DAY OF ____, 19__, AT ____, FOR INFORMATION
ONLY IN BOOK ____ OF THE COUNTY LAND SURVEYS/RIGHT OF WAY
SURVEYS AT PAGE ____, RECEPTION NUMBER ____

SIGNED _____
DEPT. _____

COLORADO DEPARTMENT OF TRANSPORTATION



Region 1
18500 E. Colfax Avenue
Aurora, CO 80011
Phone: (303) 757-9117 FAX: (303) 757-9746

Right-of-Way and Survey Unit: Kevin A. Williams

Sheet Revisions

Date	Description	Initials

Sheet Revisions

Date	Description	Initials

Prepared By:



URS Corporation
8181 East Tufts Ave. Denver, CO 80237
Phone: (303)694-2770 Fax: (303) 694-3946

Computer File
Information

CREATION DATE: 11/18/2004 INITIALS: BDL
LAST MOD. DATE: 2/1/2005 INITIALS: BDL
DRAWING NAME & FULL PATH: SEE LEFT
SIDE OF SHEET
SCALE: As Shown UNITS: English

Right of Way Plans

PLAN SHEET

Project Number: NH 0852-086 Phase IV (ROW) / NH 0852-097 (Const.) (P.C. 15139)
Project Location: SH 85, Meadows to C470
Project Location: Louviers South to Sedalia / M.P. 194.0 to M.P. 190.6
Project Code: 13429
Subset Sheets: 1 of 12
Sheet No.: 5
Total No. of Sheets: 43


KT East LLC
Bk 1950 Pg 1553

Michael E. Smith & Margaret
A. Smith
Bk 1151 Pg 596

FILING CERTIFICATION:
DEPOSITED THIS ____ DAY OF ____, 19__, AT ____, FOR INFORMATION
ONLY IN BOOK ____ OF THE COUNTY LAND SURVEYS/RIGHT OF WAY
SURVEYS AT PAGE ____, RECEPTION NUMBER ____

SIGNED _____
DEPT. _____

I:\PROJECTS\22237041_SH85_Sof_Titon\Sedalia_North\6.0_Design\6.07_Right_of_Way\Plans\ROW_Plan.dwg 3/4/2005 11:21:23 AM MST

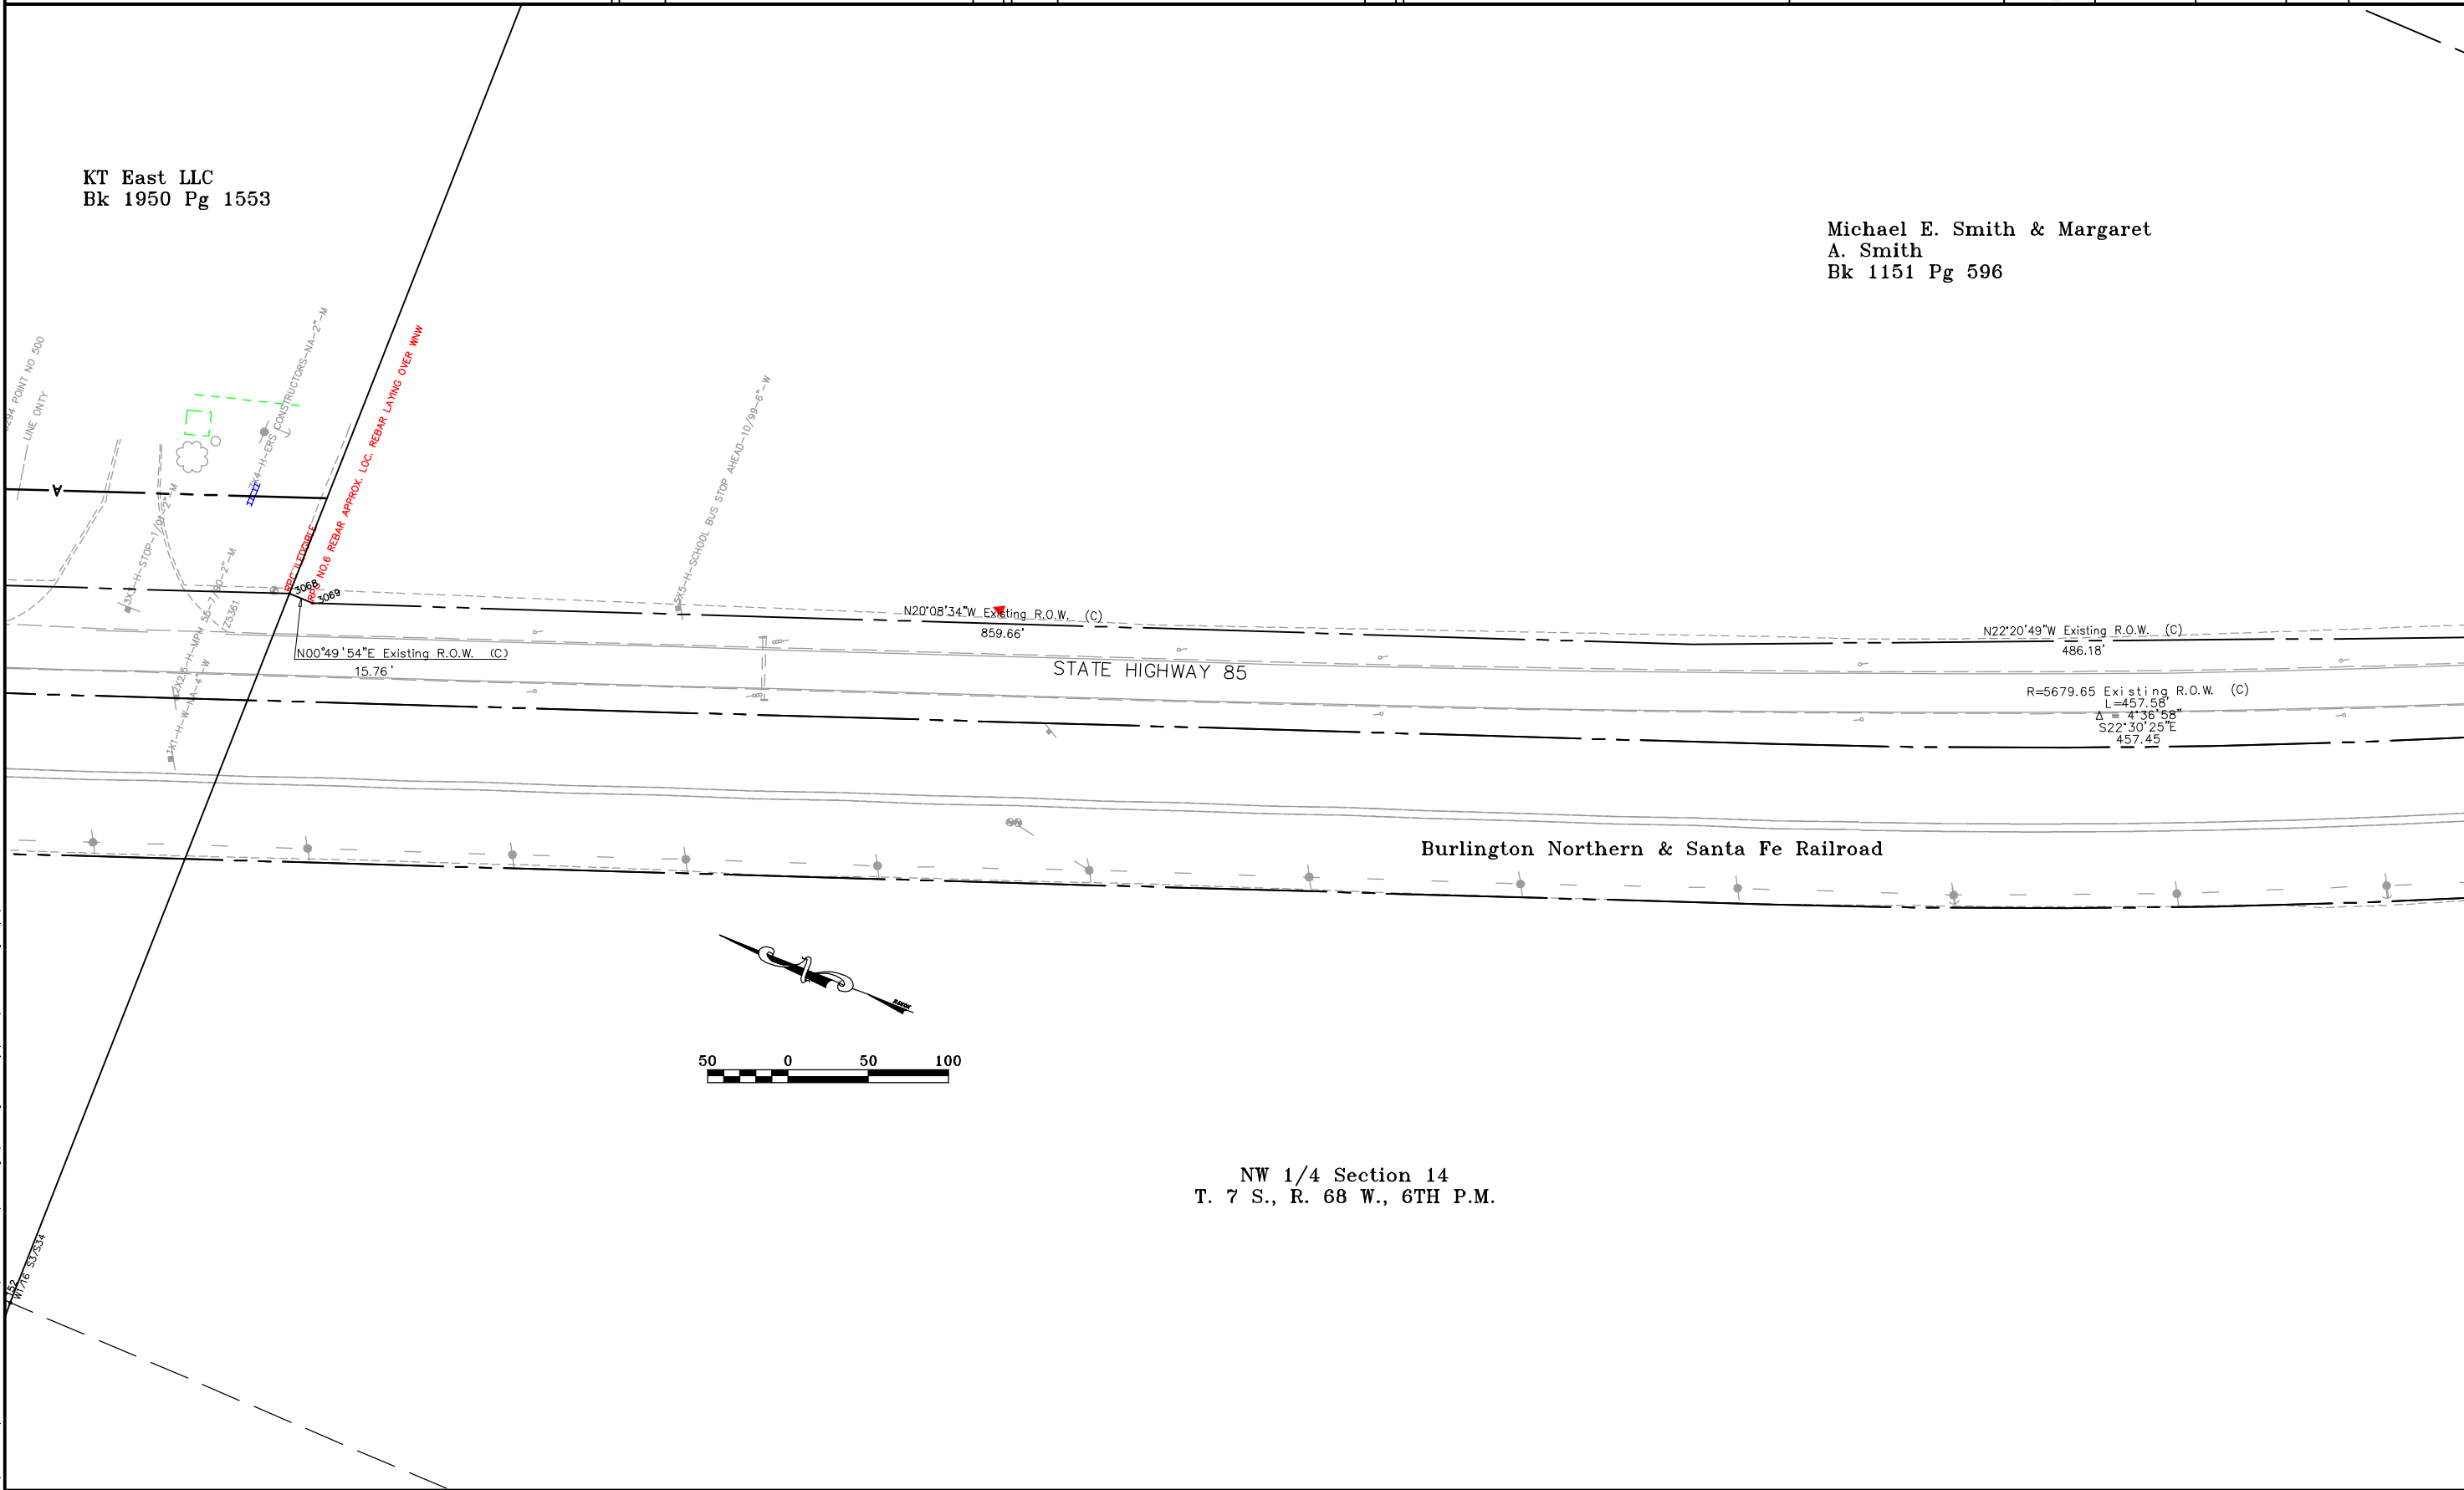

COLORADO DEPARTMENT OF TRANSPORTATION



Region 1
18500 E. Colfax Avenue
Aurora, CO 80011
Phone: (303) 757-9117 FAX: (303) 757-9746

Right-of-Way and Survey Unit: Kevin A. Williams

Sheet Revisions

Date	Description	Initials

Sheet Revisions

Date	Description	Initials

Prepared By:

URS

URS Corporation
8181 East Tufts Ave. Denver, CO 80237
Phone: (303)694-2770 Fax: (303) 694-3946

Computer File
Information

CREATION DATE: 11/18/2004 INITIALS: BDL
LAST MOD. DATE: 2/1/2005 INITIALS: BDL
DRAWING NAME & FULL PATH: SEE LEFT
SIDE OF SHEET
SCALE: As Shown UNITS: English

Right of Way Plans

PLAN SHEET

Project Number: NH 0852-086 Phase IV (ROW) / NH 0852-097 (Const.) (P.C. 15139)
Project Location: SH 85, Meadows to C470
Project Location: Louviers South to Sedalia / M.P. 194.0 to M.P. 190.6
Project Code: 13429
Subset Sheets: 2 of 12
Sheet No.: 6
Total No. of Sheets: 43


Michael E. Smith & Margaret
A. Smith
Bk 1151 Pg 596

FILING CERTIFICATION:
DEPOSITED THIS _____ DAY OF _____, 19____, AT _____, FOR INFORMATION
ONLY IN BOOK _____ OF THE COUNTY LAND SURVEYS/RIGHT OF WAY
SURVEYS AT PAGE _____, RECEPTION NUMBER _____

SIGNED _____
DEPT. _____

I:\PROJECTS\22237041_SH85_Sof_Titan\Sedalia_North\6.07_Right_of_Way\Plans\ROW_Plan.dwg 3/4/2005 11:21:23 AM JST

NW 1/4 Section 14
T. 7 S., R. 68 W., 6TH P.M.

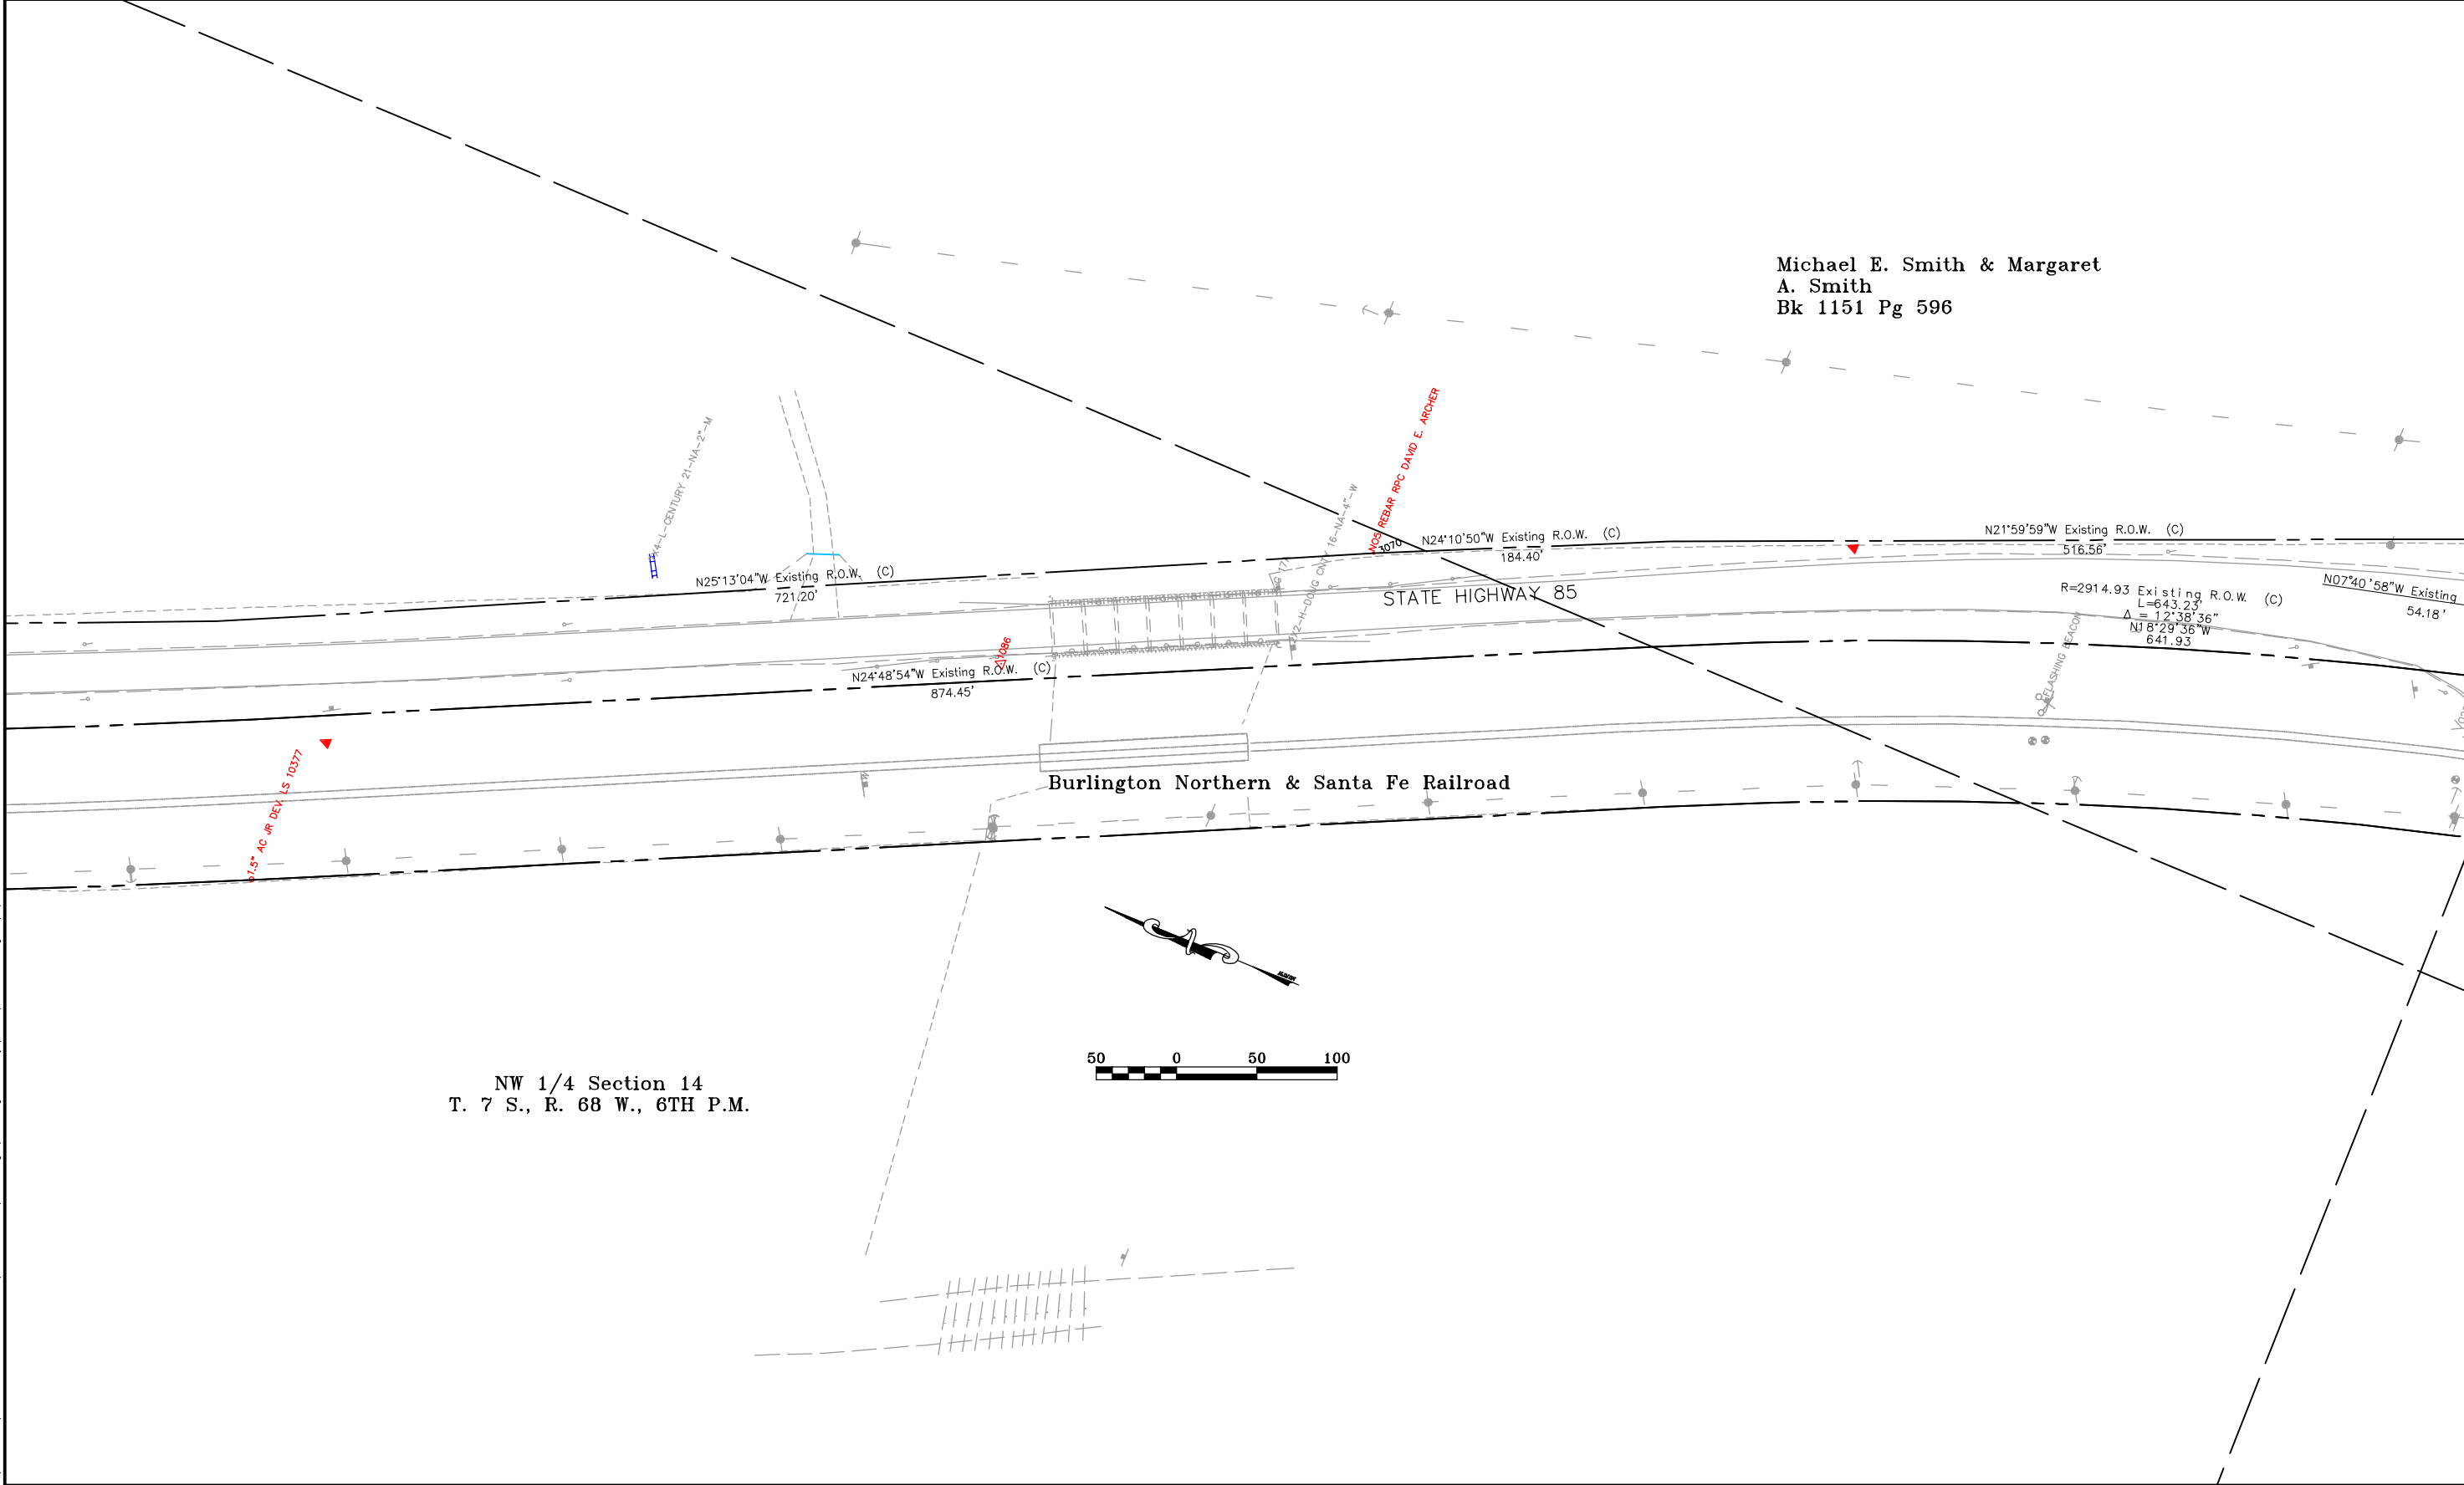

COLORADO DEPARTMENT OF TRANSPORTATION



Region 1
18500 E. Colfax Avenue
Aurora, CO 80011
Phone: (303) 757-9117 FAX: (303) 757-9746

Right-of-Way and Survey Unit: Kevin A. Williams

Sheet Revisions

Date	Description	Initials

Sheet Revisions

Date	Description	Initials

Prepared By:



URS Corporation
8181 East Tufts Ave. Denver, CO 80237
Phone: (303)694-2770 Fax: (303) 694-3946

Computer File
Information

CREATION DATE: 11/18/2004 INITIALS: BDL
LAST MOD. DATE: 2/1/2005 INITIALS: BDL
DRAWING NAME & FULL PATH: SEE LEFT
SIDE OF SHEET
SCALE: As Shown UNITS: English

Right of Way Plans

PLAN SHEET

Project Number: NH 0852-086 Phase IV (ROW) / NH 0852-097 (Const.) (P.C. 15139)

Project Location: SH 85, Meadows to C470


Project Location: Louviers South to Sedalia / M.P. 194.0 to M.P. 190.6

Project Code:	Subset Sheets	Sheet No.	Total No. of Sheets
13429	3 of 12	7	43

FILING CERTIFICATION:
DEPOSITED THIS _____ DAY OF _____, 19____, AT _____, FOR INFORMATION
ONLY IN BOOK _____ OF THE COUNTY LAND SURVEYS/RIGHT OF WAY
SURVEYS AT PAGE _____, RECEPTION NUMBER _____

SIGNED _____
DEPT. _____

I:\PROJECTS\22237041_SH85_Sof_Titan\Sedalia_North\6.0_Design\6.07_Right_of_Way\Plans\ROW_Plan.dwg 3/4/2005 11:21:23 AM MST

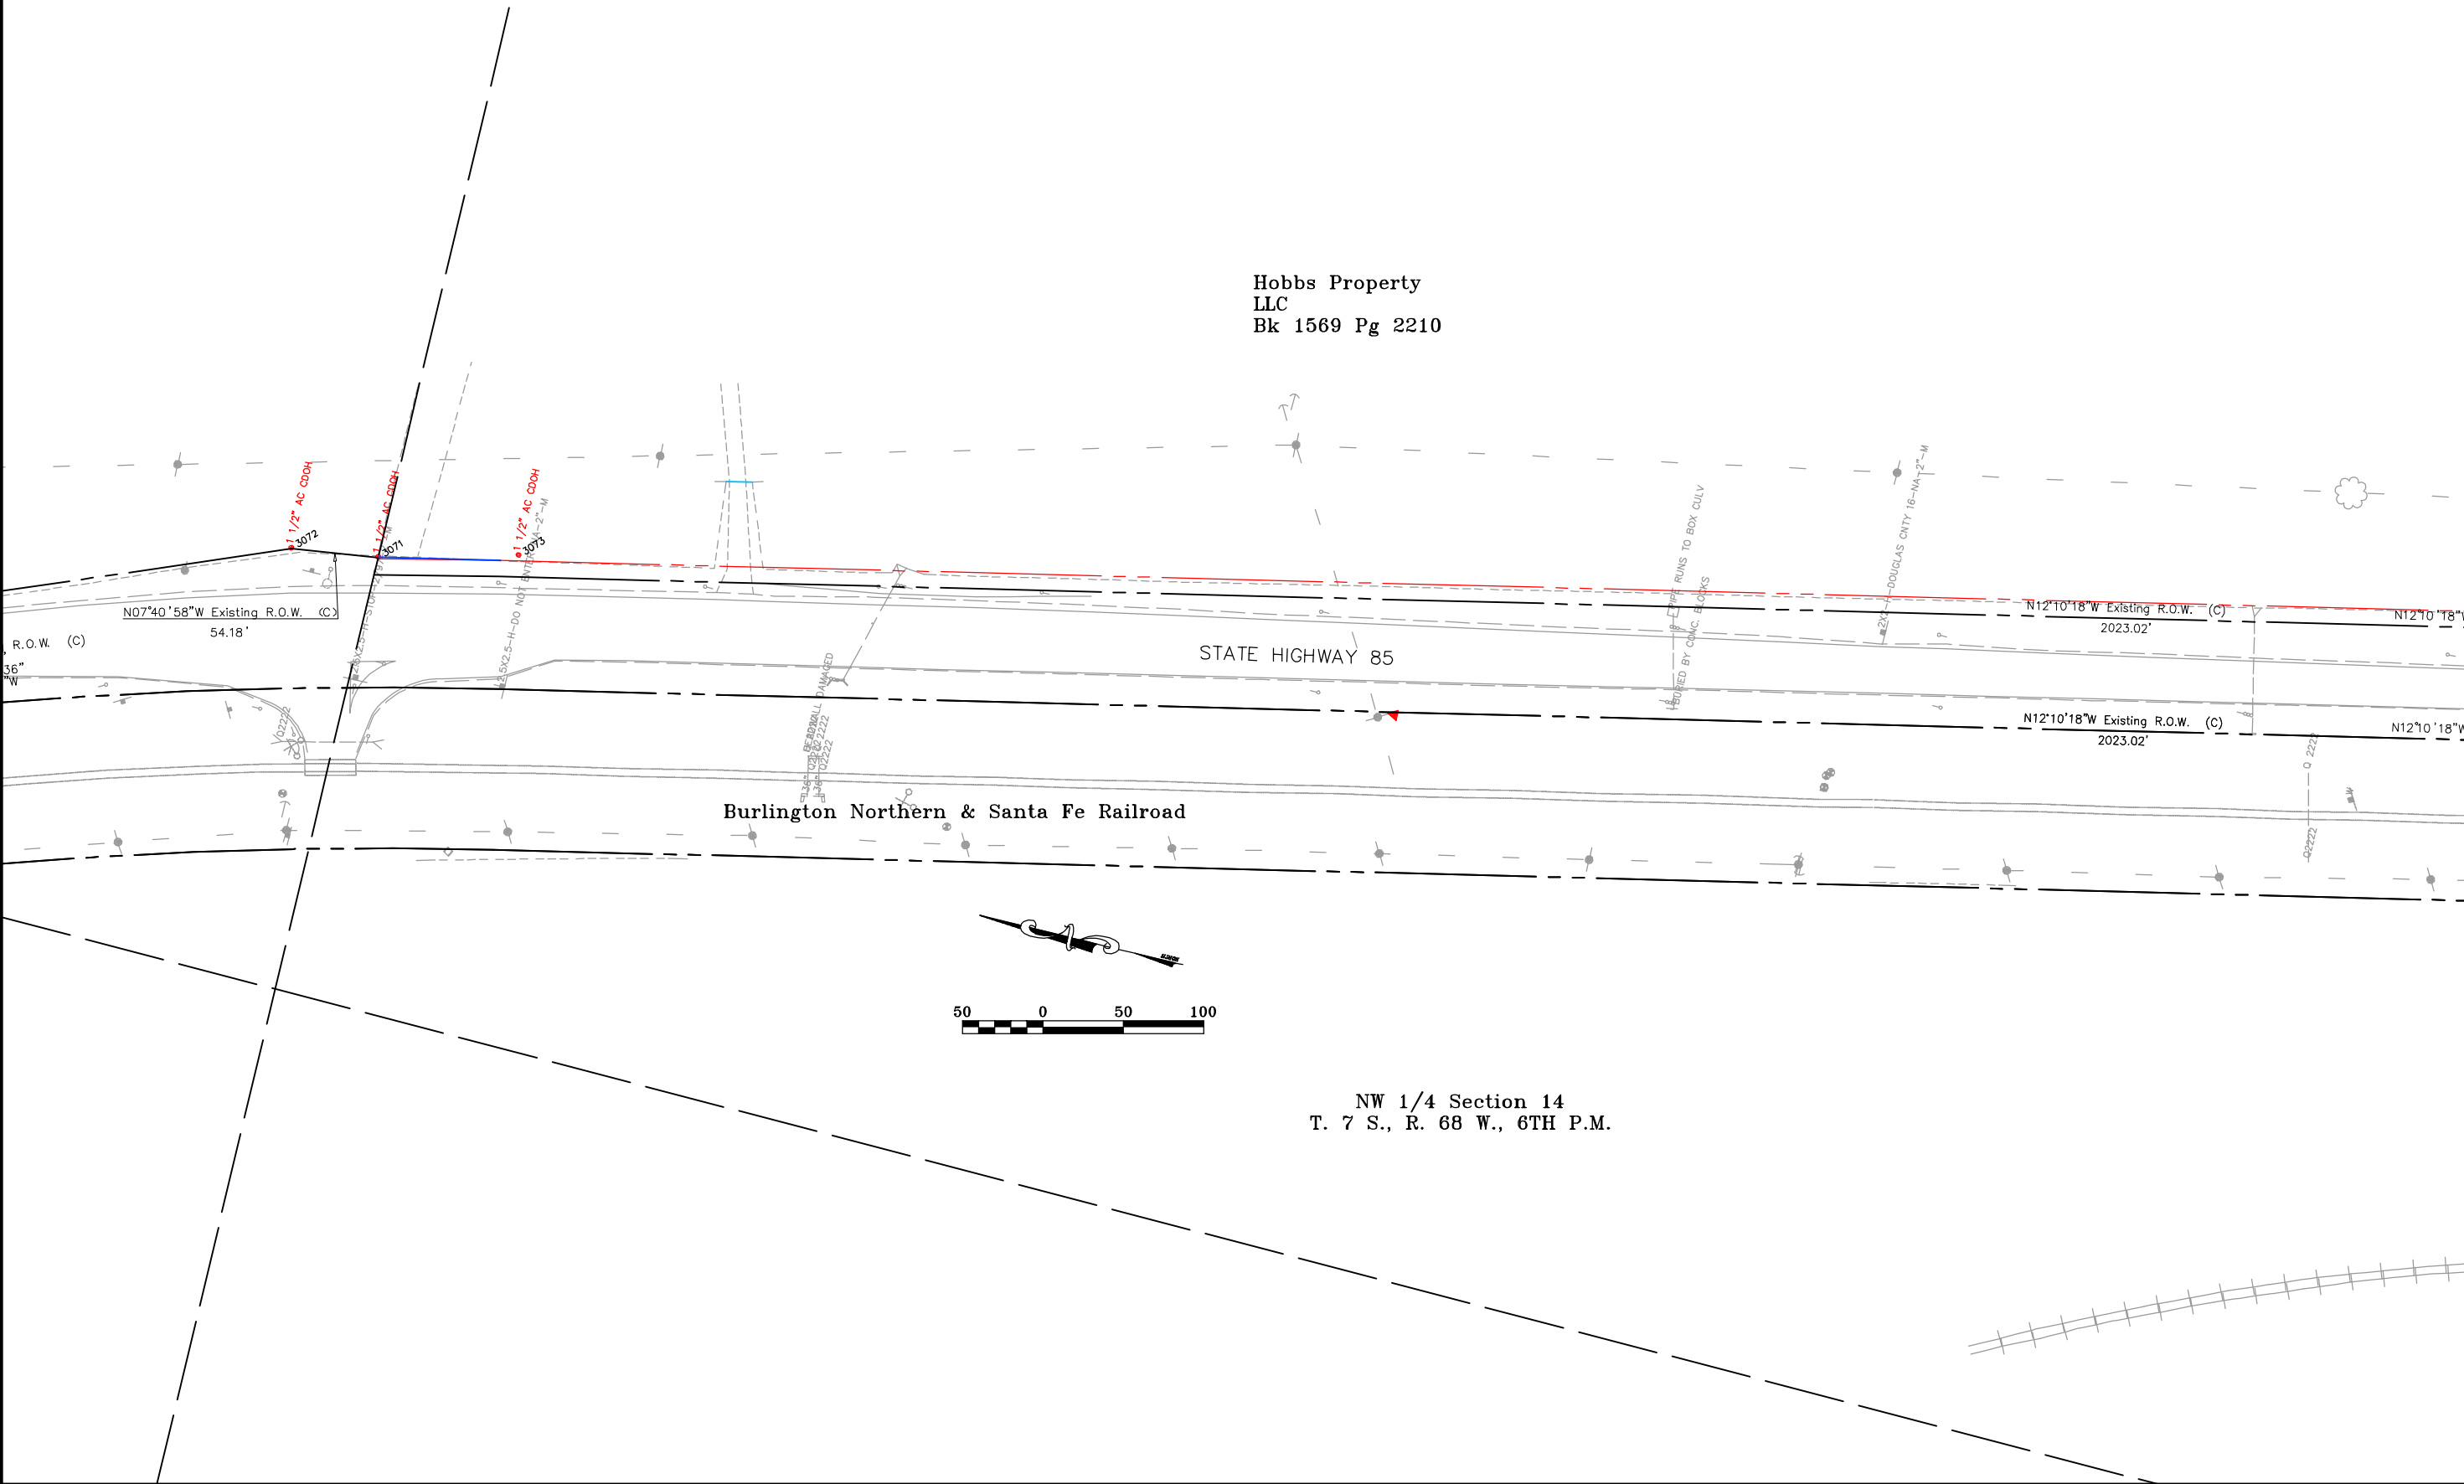

Hobbs Property
LLC
Bk 1569 Pg 2210

STATE HIGHWAY 85

Burlington Northern & Santa Fe Railroad

NW 1/4 Section 14
T. 7 S., R. 68 W., 6TH P.M.

COLORADO DEPARTMENT OF TRANSPORTATION



Region 1
18500 E. Colfax Avenue
Aurora, CO 80011
Phone: (303) 757-9117 FAX: (303) 757-9746

Right-of-Way and Survey Unit: Kevin A. Williams

Sheet Revisions

Date	Description	Initials

Sheet Revisions

Date	Description	Initials

Prepared By:



URS Corporation
8181 East Tufts Ave. Denver, CO 80237
Phone: (303)694-2770 Fax: (303) 694-3946

Computer File
Information

CREATION DATE: 11/18/2004 INITIALS: BDL
LAST MOD. DATE: 2/1/2005 INITIALS: BDL
DRAWING NAME & FULL PATH: SEE LEFT
SIDE OF SHEET
SCALE: As Shown UNITS: English

Right of Way Plans

PLAN SHEET


Project Number: NH 0852-086 Phase IV (ROW) / NH 0852-097 (Const.) (P.C. 15139)
Project Location: SH 85, Meadows to C470
Project Location: Louviers South to Sedalia / M.P. 194.0 to M.P. 190.6
Project Code: 13429
Subset Sheets: 4 of 12
Sheet No.: 8
Total No. of Sheets: 43

Hobbs Property LLC
Bk 1569 Pg 2210

FILING CERTIFICATION:
DEPOSITED THIS ____ DAY OF ____, 19____, AT ____M., FOR INFORMATION
ONLY IN BOOK ____ OF THE COUNTY LAND SURVEYS/RIGHT OF WAY
SURVEYS AT PAGE ____, RECEPTION NUMBER ____

SIGNED _____
DEPT. _____

I:\PROJECTS\22237041_SH85_Sof_Titan\Sedalia_North\6.0_Design\6.07_Right_of_Way\Plans\ROW_Plan.dwg 3/4/2005 11:21:23 AM JST

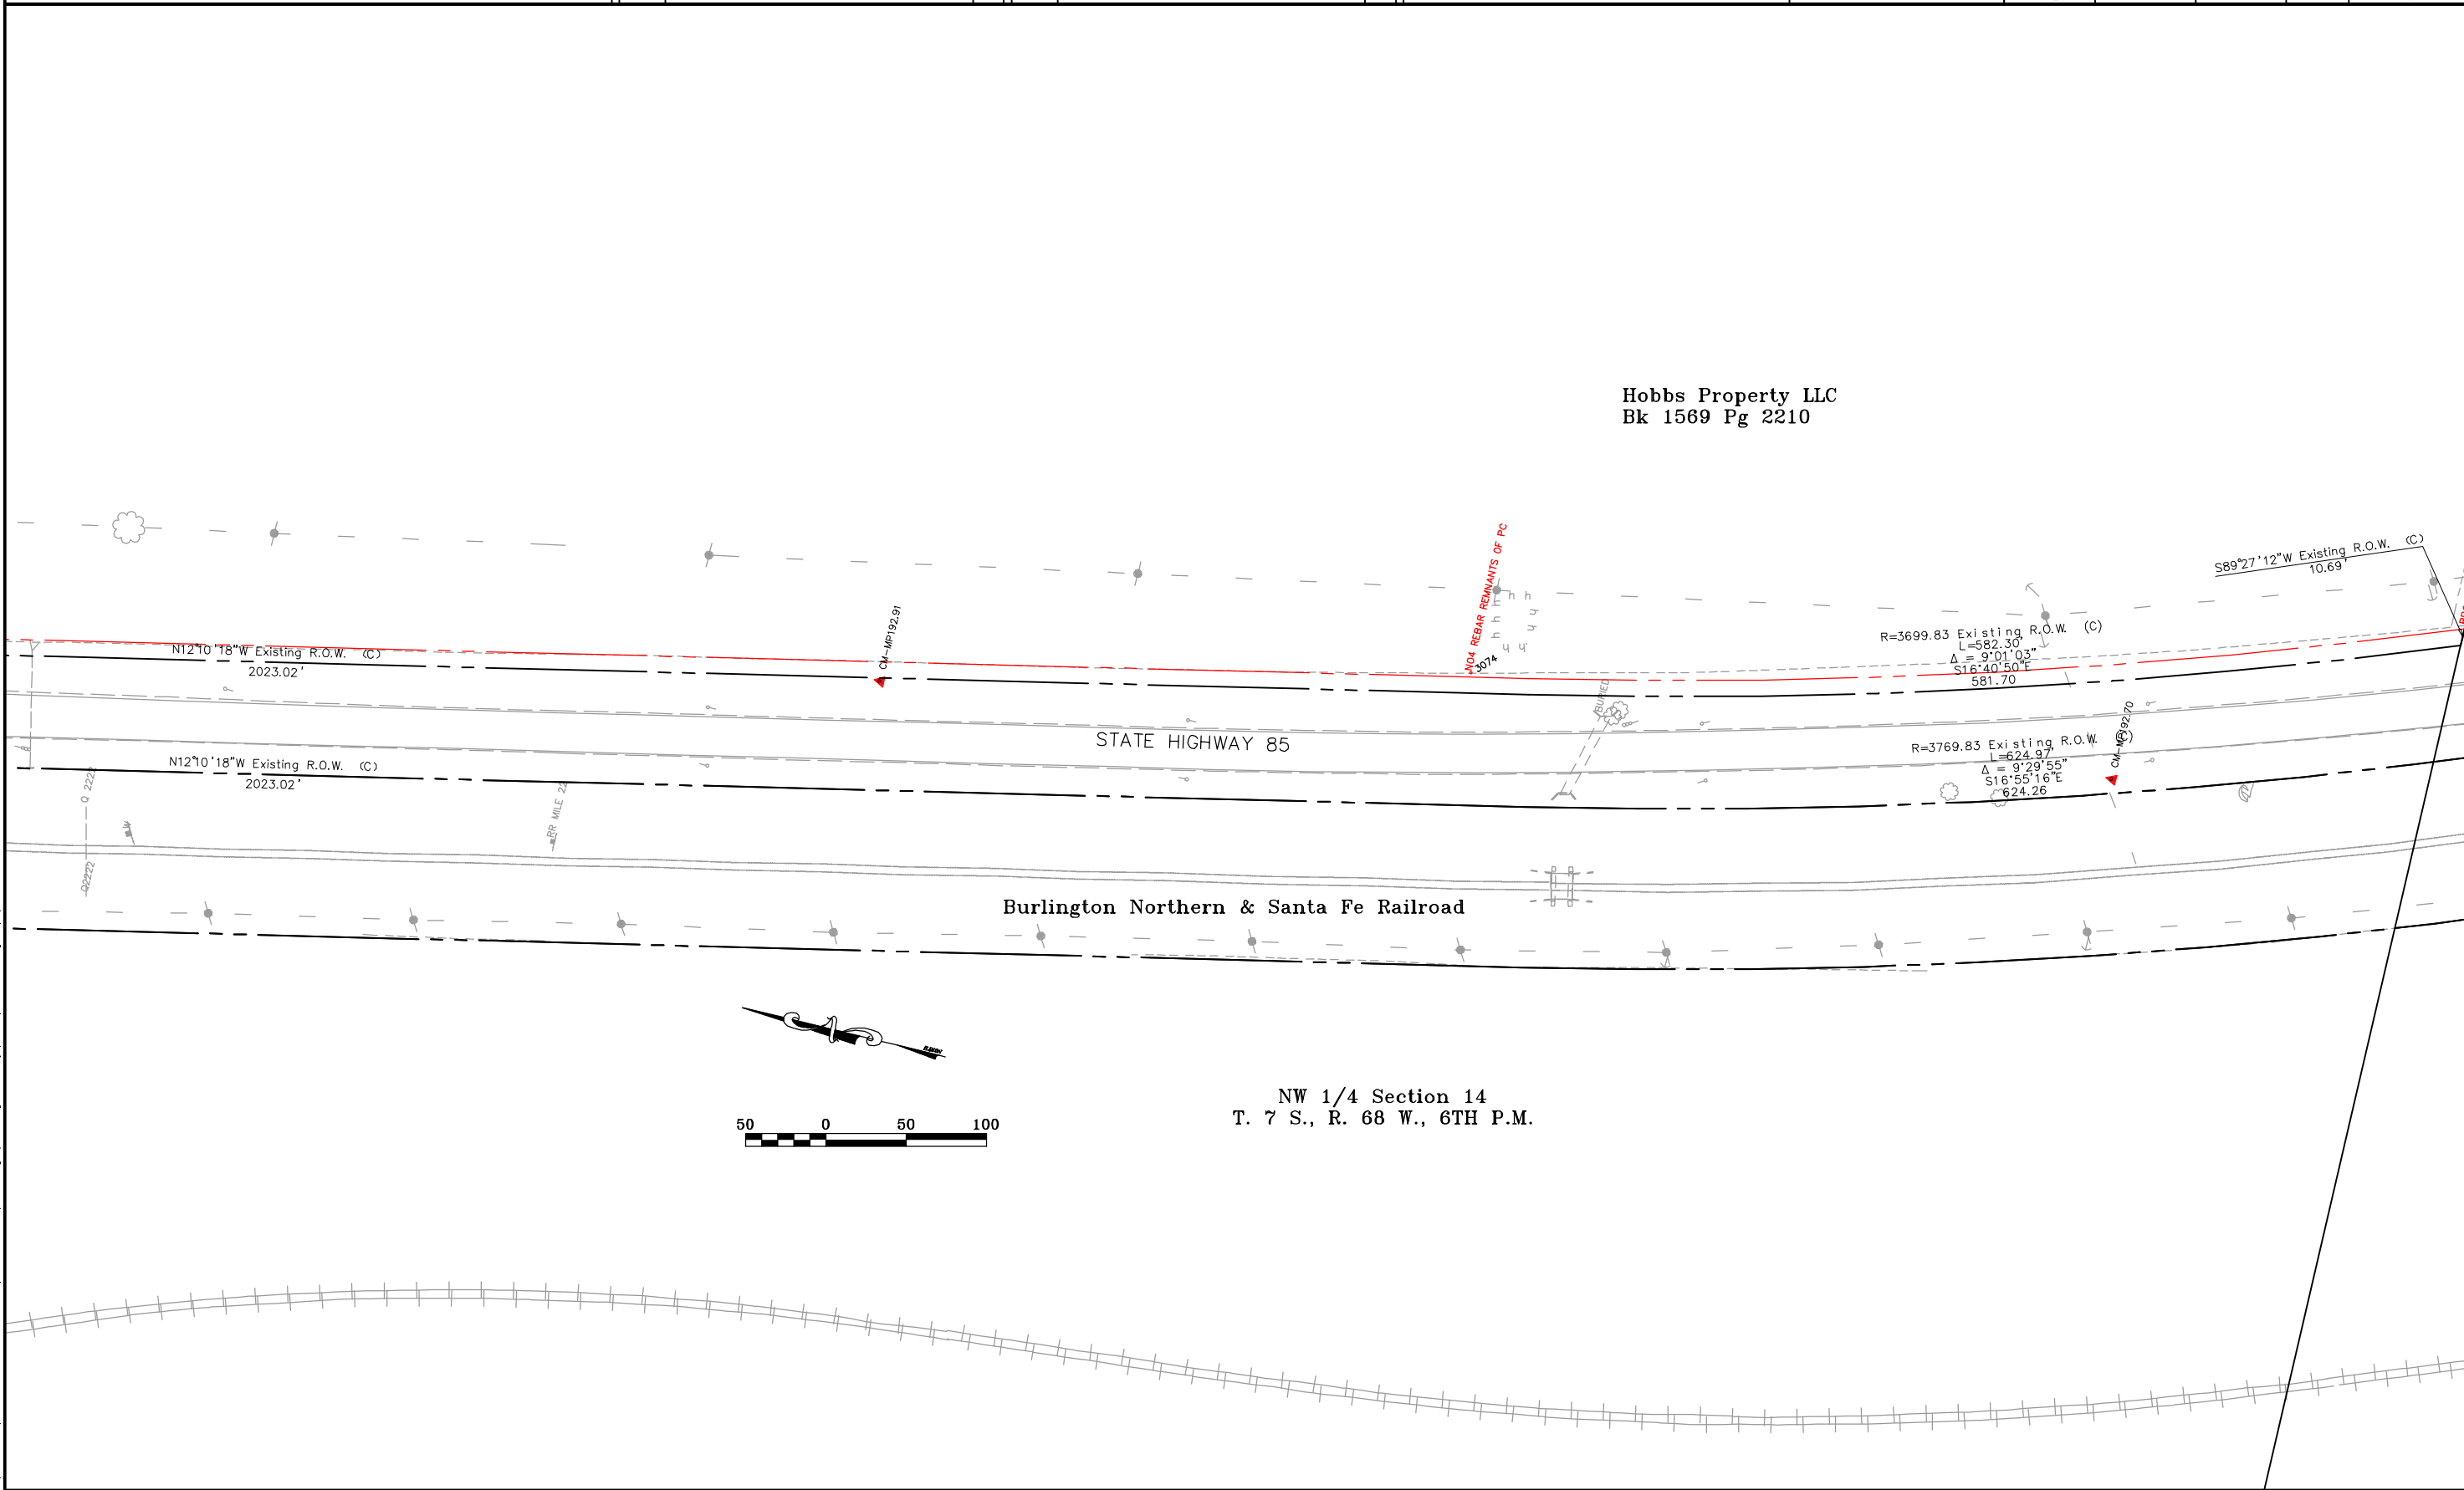

NW 1/4 Section 14
T. 7 S., R. 68 W., 6TH P.M.

COLORADO DEPARTMENT OF TRANSPORTATION



Region 1
18500 E. Colfax Avenue
Aurora, CO 80011
Phone: (303) 757-9117 FAX: (303) 757-9746

Right-of-Way and Survey Unit: Kevin A. Williams

Sheet Revisions

Date	Description	Initials

Sheet Revisions

Date	Description	Initials

Prepared By:



URS Corporation
8181 East Tufts Ave. Denver, CO 80237
Phone: (303)694-2770 Fax: (303) 694-3946

Computer File
Information

CREATION DATE: 11/18/2004 INITIALS: BDL
LAST MOD. DATE: 2/1/2005 INITIALS: BDL
DRAWING NAME & FULL PATH: SEE LEFT
SIDE OF SHEET
SCALE: As Shown UNITS: English

Right of Way Plans


PLAN SHEET

Project Number: NH 0852-086 Phase IV (ROW) / NH 0852-097 (Const.) (P.C. 15139)
Project Location: SH 85, Meadows to C470
Project Location: Louviers South to Sedalia / M.P. 194.0 to M.P. 190.6
Project Code: 13429
Subset Sheets: 5 of 12
Sheet No.: 9
Total No. of Sheets: 43

FILING CERTIFICATION:
DEPOSITED THIS ____ DAY OF ____ 19____, AT ____ M., FOR INFORMATION
ONLY IN BOOK ____ OF THE COUNTY LAND SURVEYS/RIGHT OF WAY
SURVEYS AT PAGE ____ RECEPTION NUMBER ____

SIGNED _____
DEPT. _____

I:\PROJECTS\22237041_SH85_Sof_Titan\Sedalia_North\6.0_Design\6.07_Right_of_Way\Plans\ROW_Plan.dwg 3/4/2005 11:21:23 AM JST

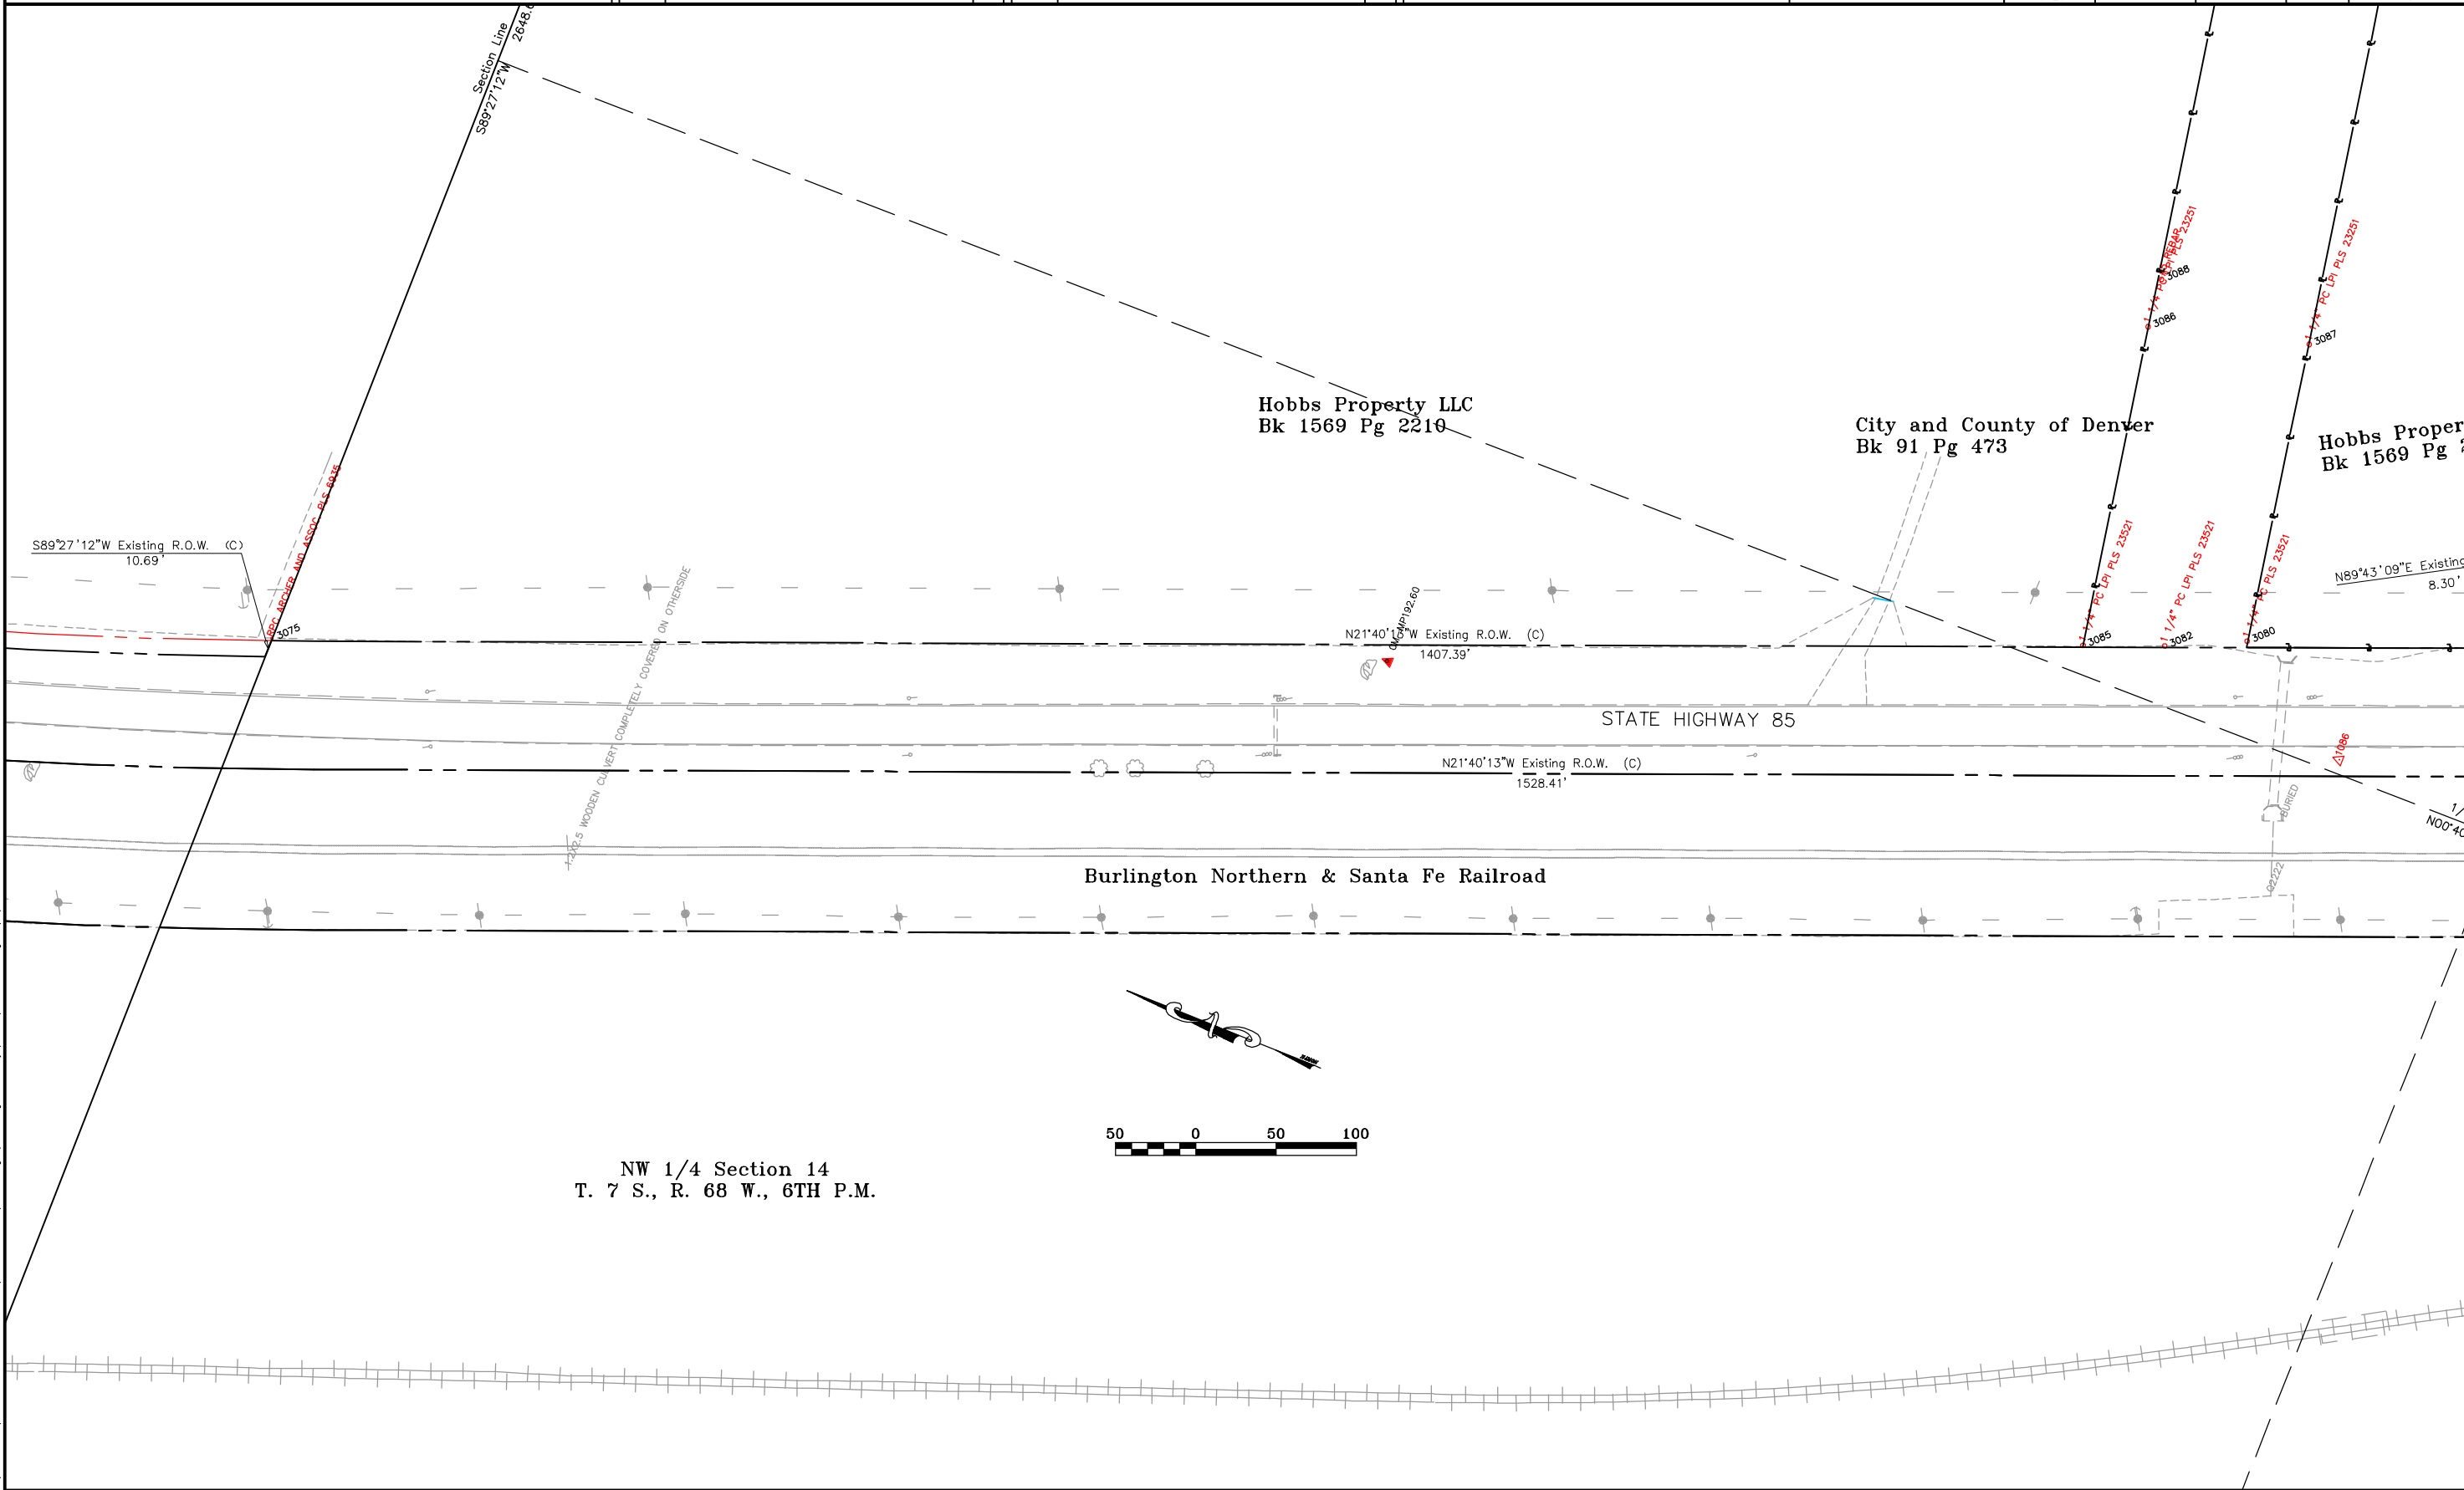

COLORADO DEPARTMENT OF TRANSPORTATION



Region 1
18500 E. Colfax Avenue
Aurora, CO 80011
Phone: (303) 757-9117 FAX: (303) 757-9746

Right-of-Way and Survey Unit: Kevin A. Williams

Sheet Revisions

Date	Description	Initials

Sheet Revisions

Date	Description	Initials

Prepared By:

URS

URS Corporation
8181 East Tufts Ave. Denver, CO 80237
Phone: (303)694-2770 Fax: (303) 694-3946

Computer File
Information

CREATION DATE: 11/18/2004 INITIALS: BDL
LAST MOD. DATE: 2/1/2005 INITIALS: BDL
DRAWING NAME & FULL PATH: SEE LEFT
SIDE OF SHEET
SCALE: As Shown UNITS: English

Right of Way Plans


PLAN SHEET

Project Number: NH 0852-086 Phase IV (ROW) / NH 0852-097 (Const.) (P.C. 15139)
Project Location: SH 85, Meadows to C470
Project Location: Louviers South to Sedalia / M.P. 194.0 to M.P. 190.6
Project Code: 13429
Subset Sheets: 6 of 12
Sheet No.: 10
Total No. of Sheets: 43

FLING CERTIFICATION: DEPOSITED THIS _____ DAY OF _____, 19____, AT _____, FOR INFORMATION
ONLY IN BOOK _____ OF THE COUNTY LAND SURVEYS/RIGHT OF WAY
SURVEYS AT PAGE _____, RECEPTION NUMBER _____

SIGNED _____
DEPT. _____

I:\PROJECTS\22237041_SH85_Sof_Tiron\Sedalia_North\6.07_Design\Right_of_Way\Plans\ROW_Plan.dwg 3/4/2005 11:21:23 AM JST

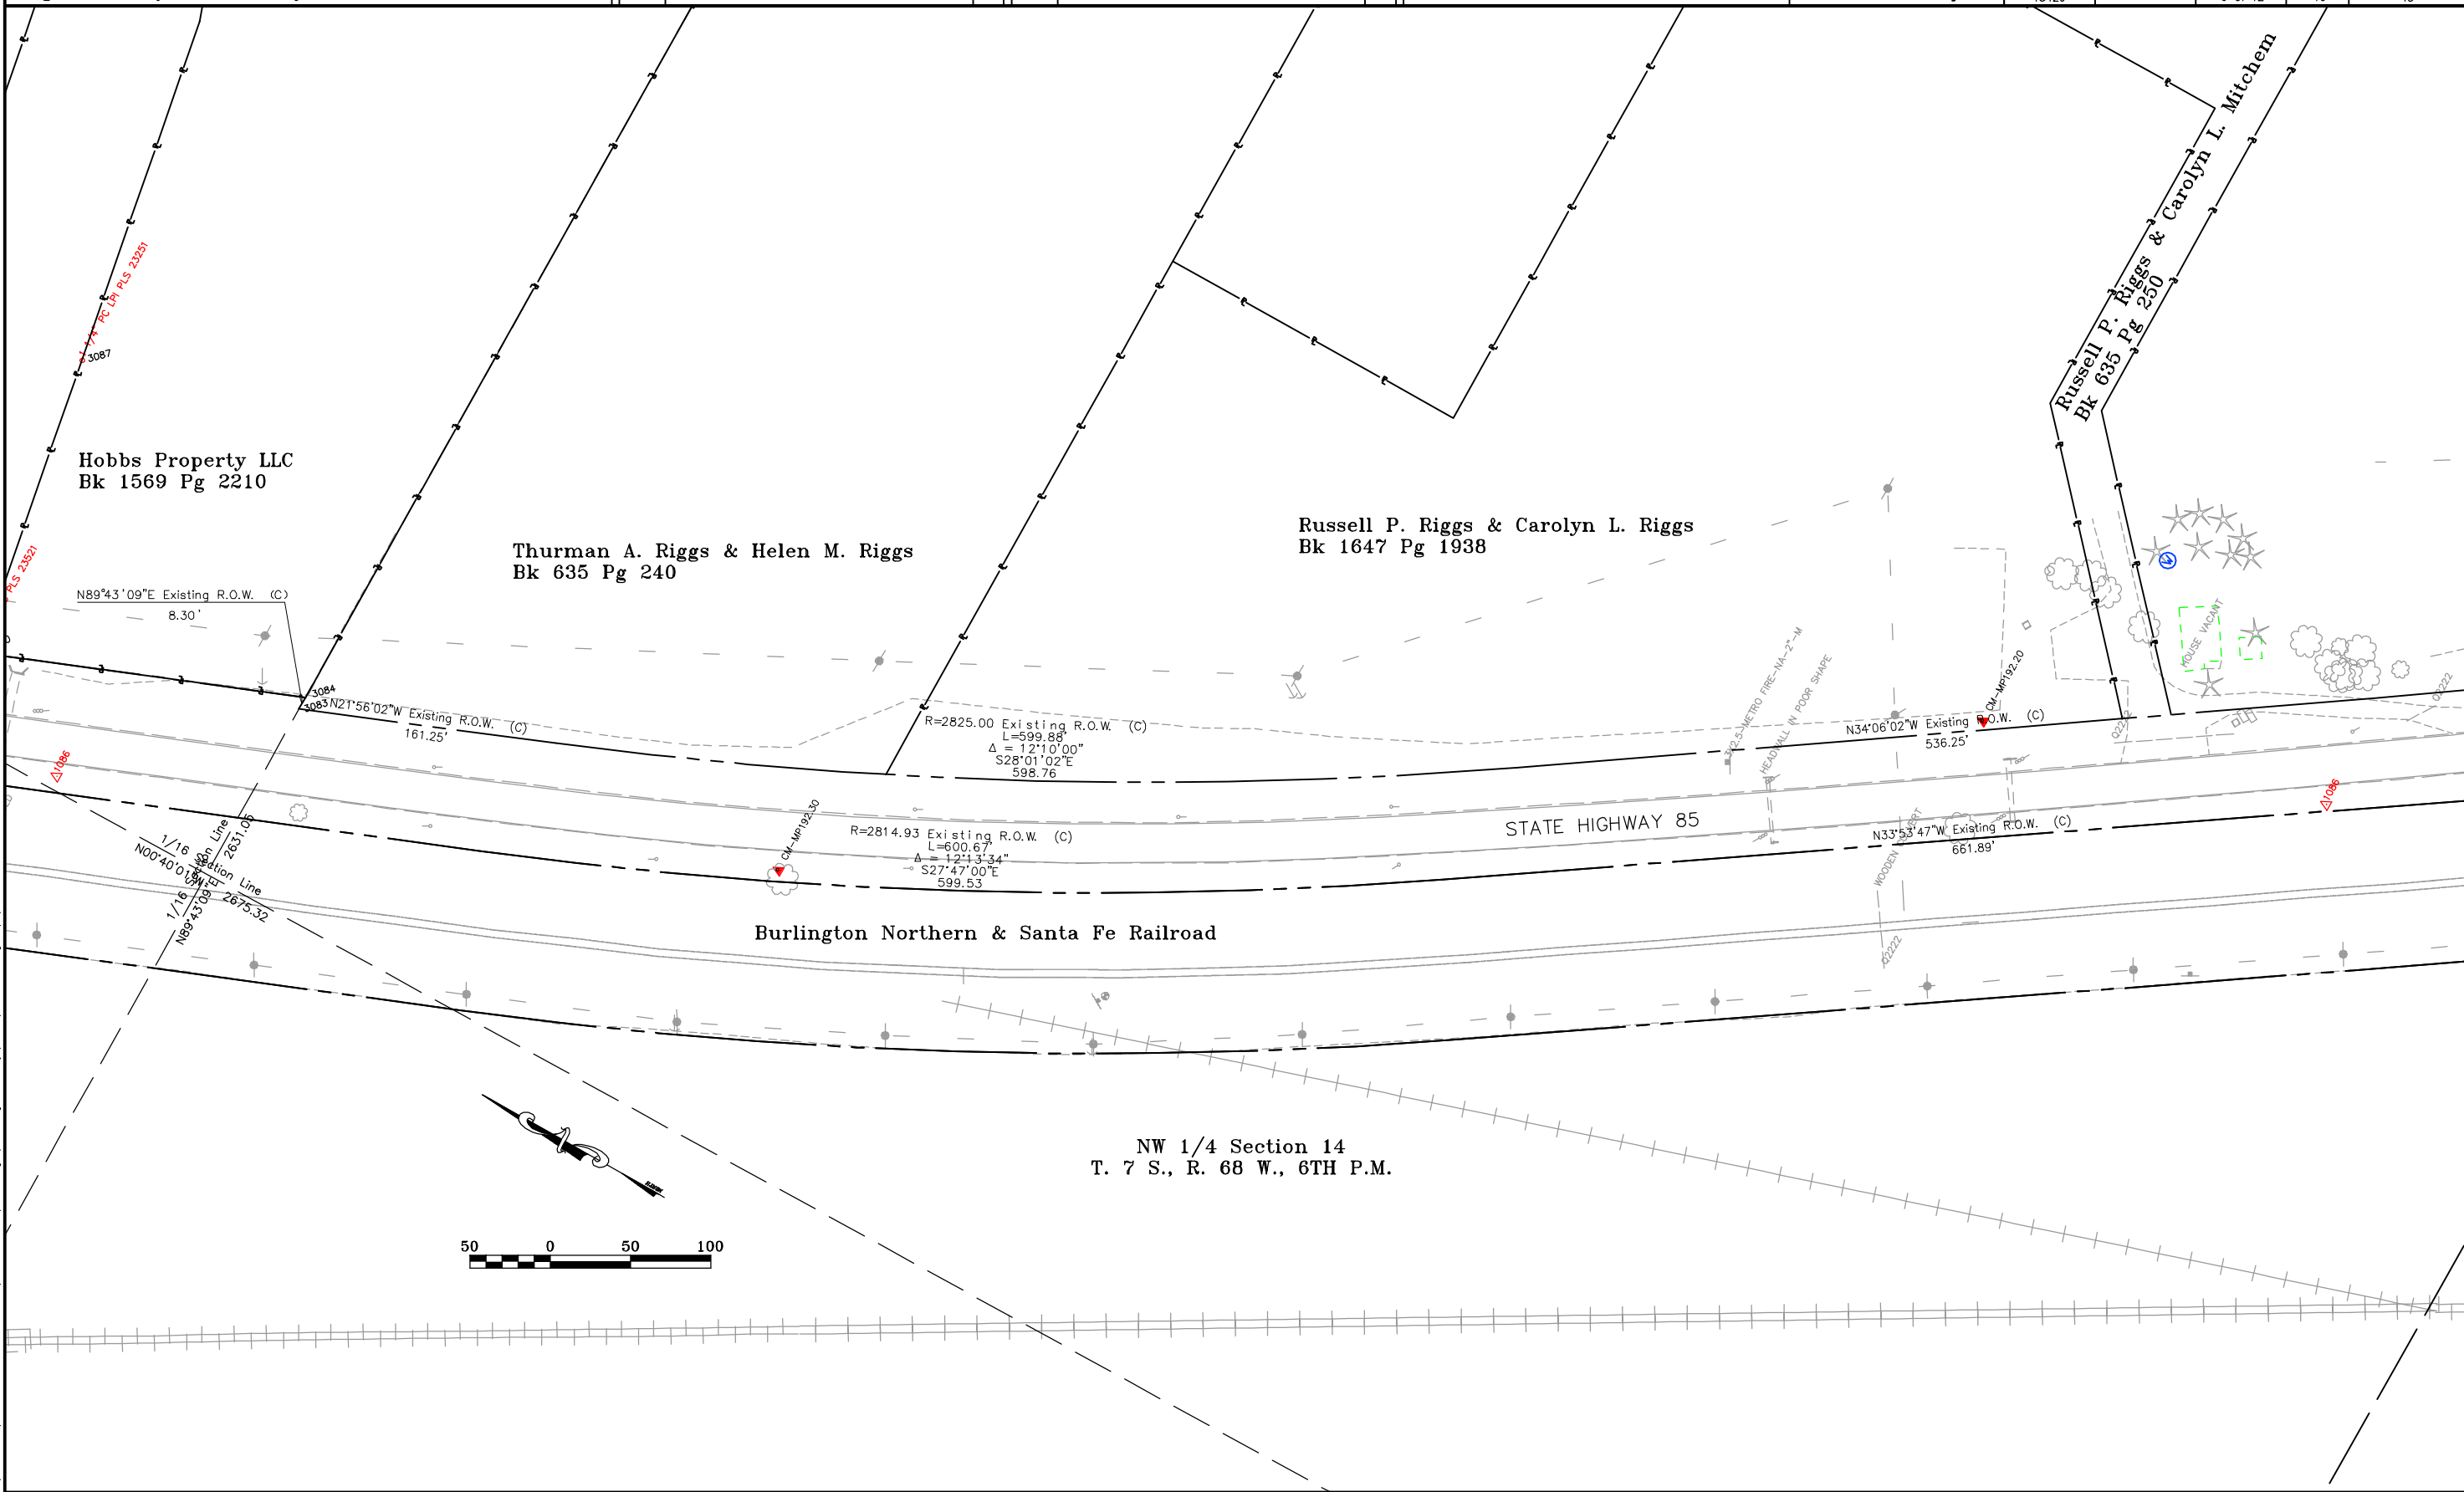

COLORADO DEPARTMENT OF TRANSPORTATION



Region 1
18500 E. Colfax Avenue
Aurora, CO 80011
Phone: (303) 757-9117 FAX: (303) 757-9746

Right-of-Way and Survey Unit: Kevin A. Williams

Sheet Revisions

Date	Description	Initials

Sheet Revisions

Date	Description	Initials

Prepared By:



URS Corporation
8181 East Tufts Ave. Denver, CO 80237
Phone: (303)694-2770 Fax: (303) 694-3946

Computer File
Information

CREATION DATE: 11/18/2004 INITIALS: BDL
LAST MOD. DATE: 2/1/2005 INITIALS: BDL
DRAWING NAME & FULL PATH: SEE LEFT
SIDE OF SHEET
SCALE: As Shown UNITS: English

Right of Way Plans


PLAN SHEET

Project Number: NH 0852-086 Phase IV (ROW) / NH 0852-097 (Const.) (P.C. 15139)
Project Location: SH 85, Meadows to C470
Project Location: Louviers South to Sedalia / M.P. 194.0 to M.P. 190.6
Project Code: 13429
Subset Sheets: 7 of 12
Sheet No.: 11
Total No. of Sheets: 43

FLING CERTIFICATION: DEPOSITED THIS _____ DAY OF _____, 19____, AT _____, FOR INFORMATION
ONLY IN BOOK _____ OF THE COUNTY LAND SURVEYS/RIGHT OF WAY
SURVEYS AT PAGE _____, RECEPTION NUMBER _____

SIGNED _____
DEPT. _____

I:\PROJECTS\22237041_SH85_Sof_Titon\Sedalia_North\6.07_Right_of_Way\Plans\ROW_Plan.dwg 3/4/2005 11:21:23 AM MST

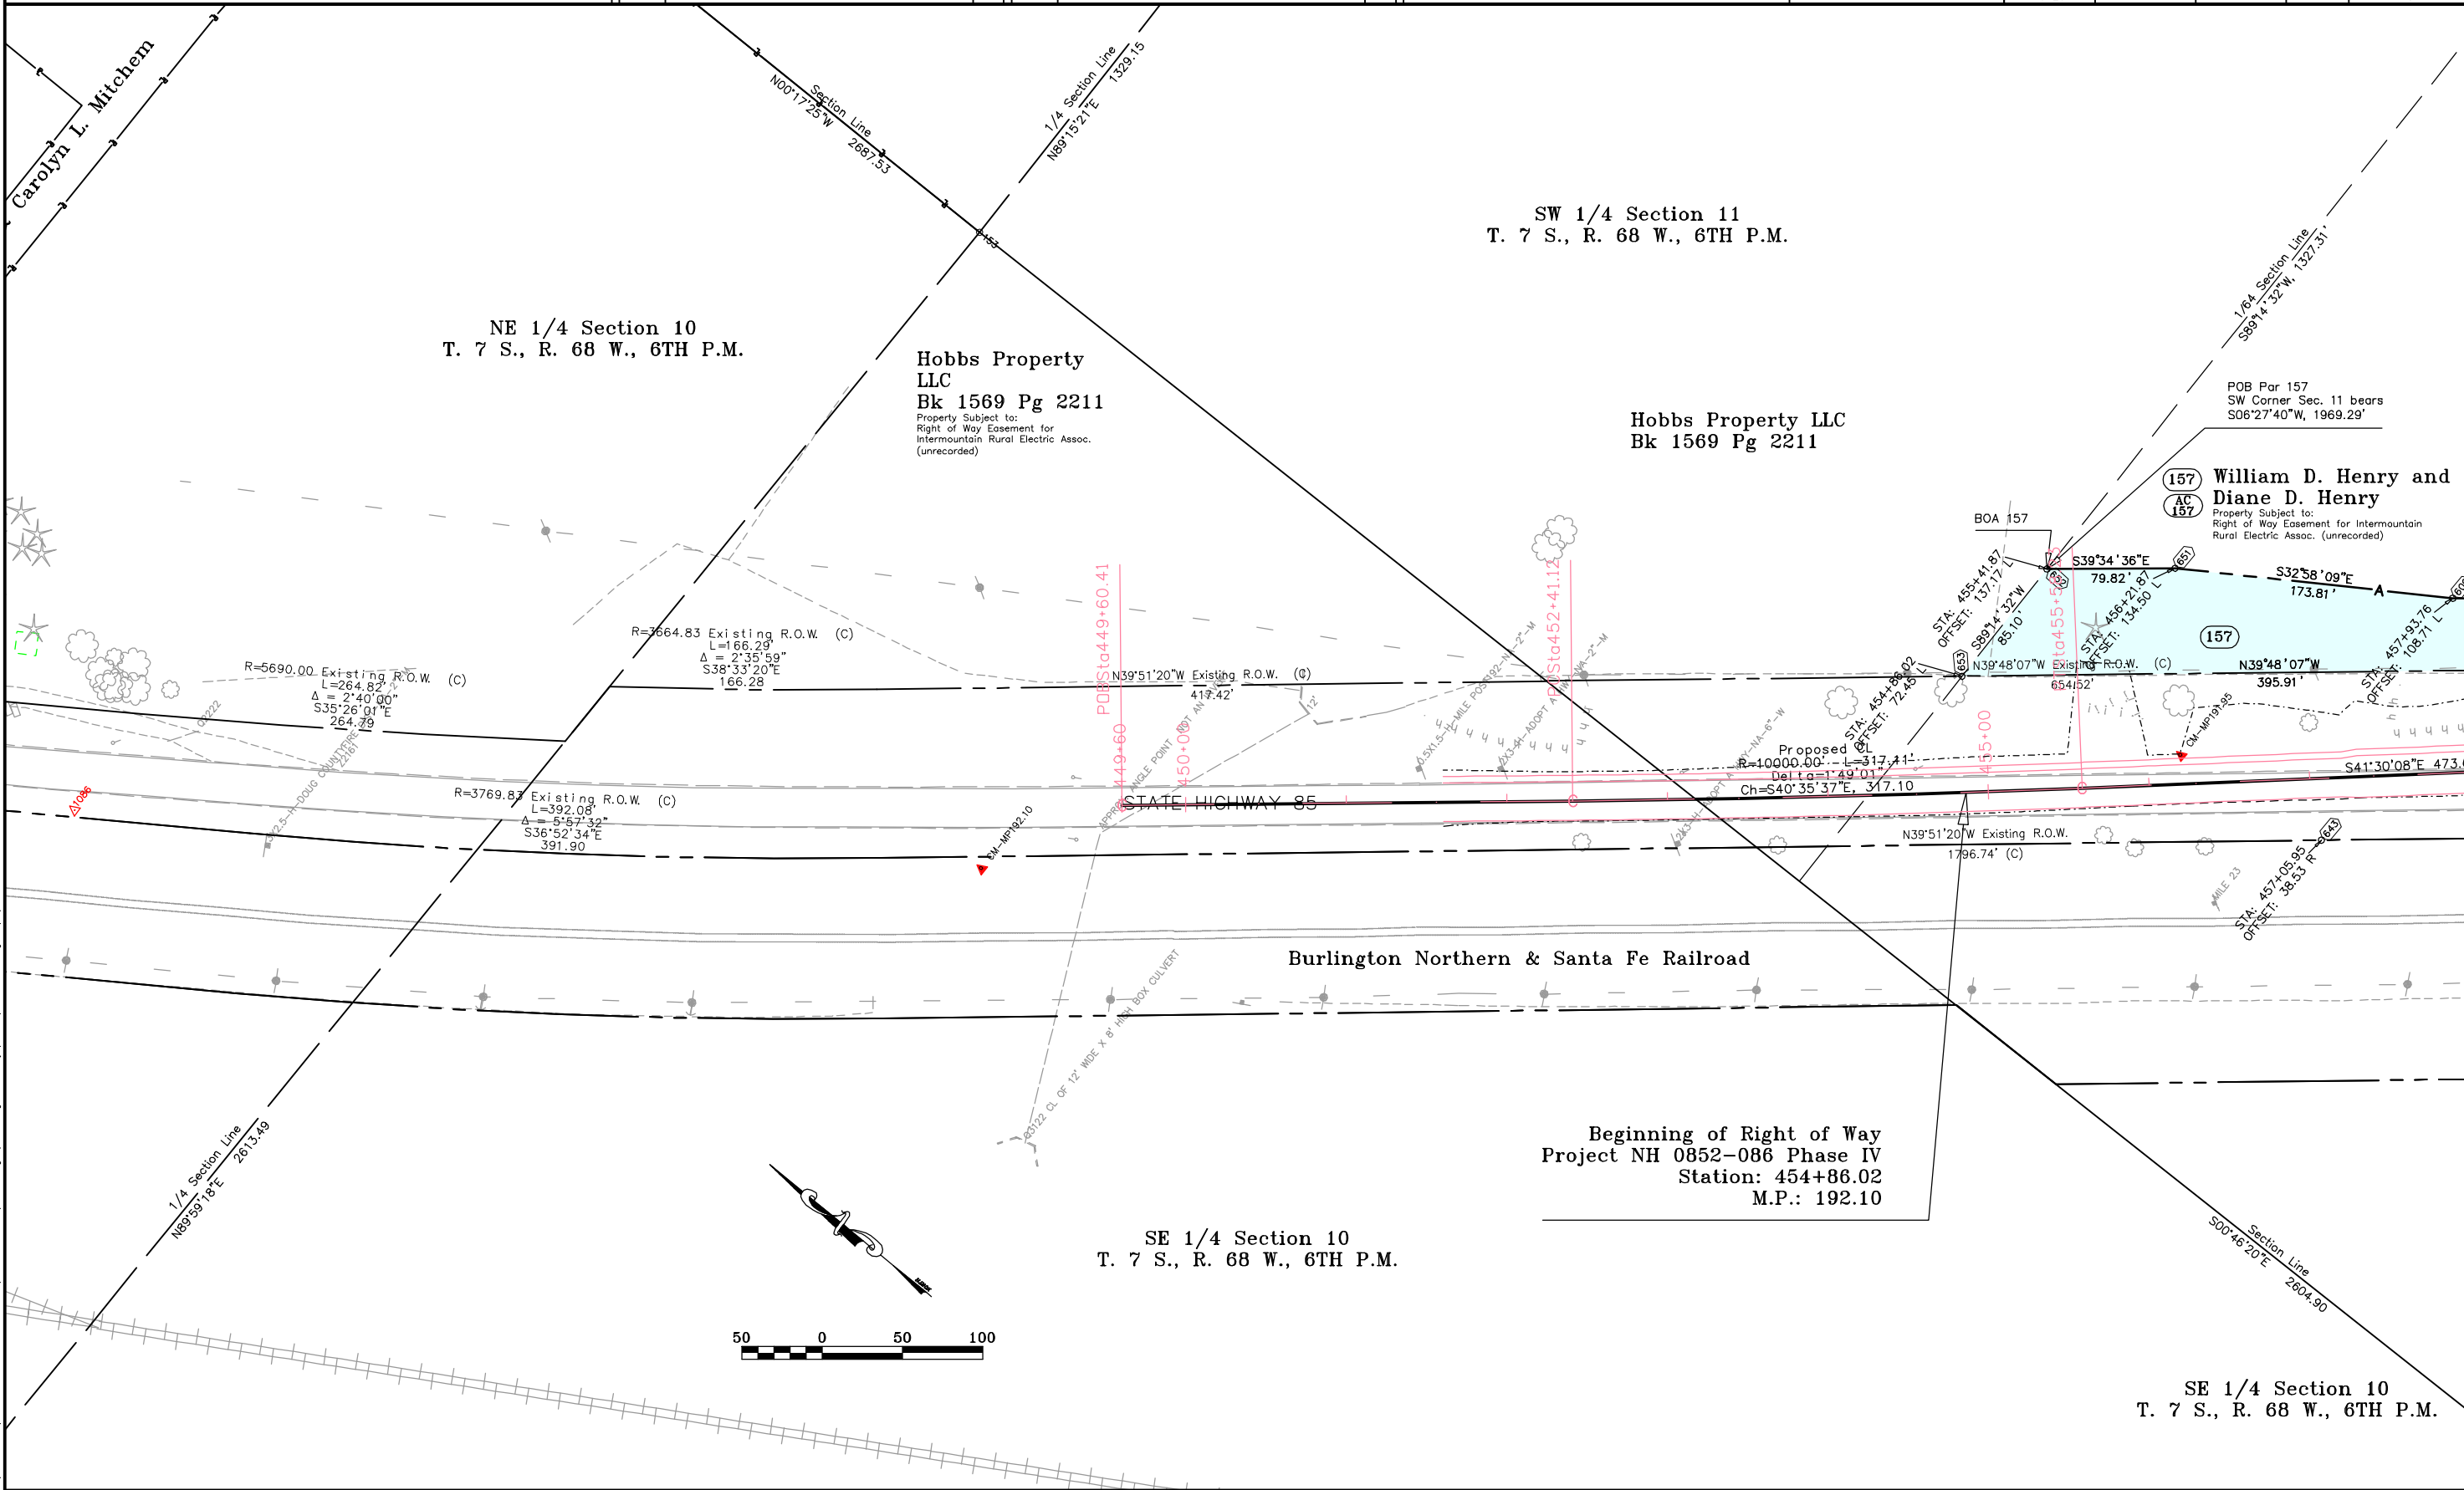

COLORADO DEPARTMENT OF TRANSPORTATION



Region 1
18500 E. Colfax Avenue
Aurora, CO 80011
Phone: (303) 757-9117 FAX: (303) 757-9746

Right-of-Way and Survey Unit: Kevin A. Williams

Sheet Revisions

Date	Description	Initials

Sheet Revisions

Date	Description	Initials

Prepared By:

URS

URS Corporation
8181 East Tufts Ave. Denver, CO 80237
Phone: (303)694-2770 Fax: (303) 694-3946

Computer File
Information

CREATION DATE: 11/18/2004 INITIALS: BDL
LAST MOD. DATE: 2/1/2005 INITIALS: BDL
DRAWING NAME & FULL PATH: SEE LEFT
SIDE OF SHEET
SCALE: As Shown UNITS: English

Right of Way Plans


PLAN SHEET

Project Number: NH 0852-086 Phase IV (ROW) / NH 0852-097 (Const.) (P.C. 15139)
Project Location: SH 85, Meadows to C470
Project Location: Louviers South to Sedalia / M.P. 194.0 to M.P. 190.6
Project Code: 13429
Subset Sheets: 8 of 12
Sheet No.: 12
Total No. of Sheets: 43

FILING CERTIFICATION:
DEPOSITED THIS _____ DAY OF _____, 19____, AT _____, FOR INFORMATION
ONLY IN BOOK _____ OF THE COUNTY LAND SURVEYS/RIGHT OF WAY
SURVEYS AT PAGE _____, RECEPTION NUMBER _____

SIGNED _____
DEPT. _____

I:\PROJECTS\22237041_SH85_Sof_Titan\Sedalia_North (6.07_Design)\Plan\Right_of_Way\Plans\ROW_Plan.dwg 3/4/2005 11:21:23 AM JST

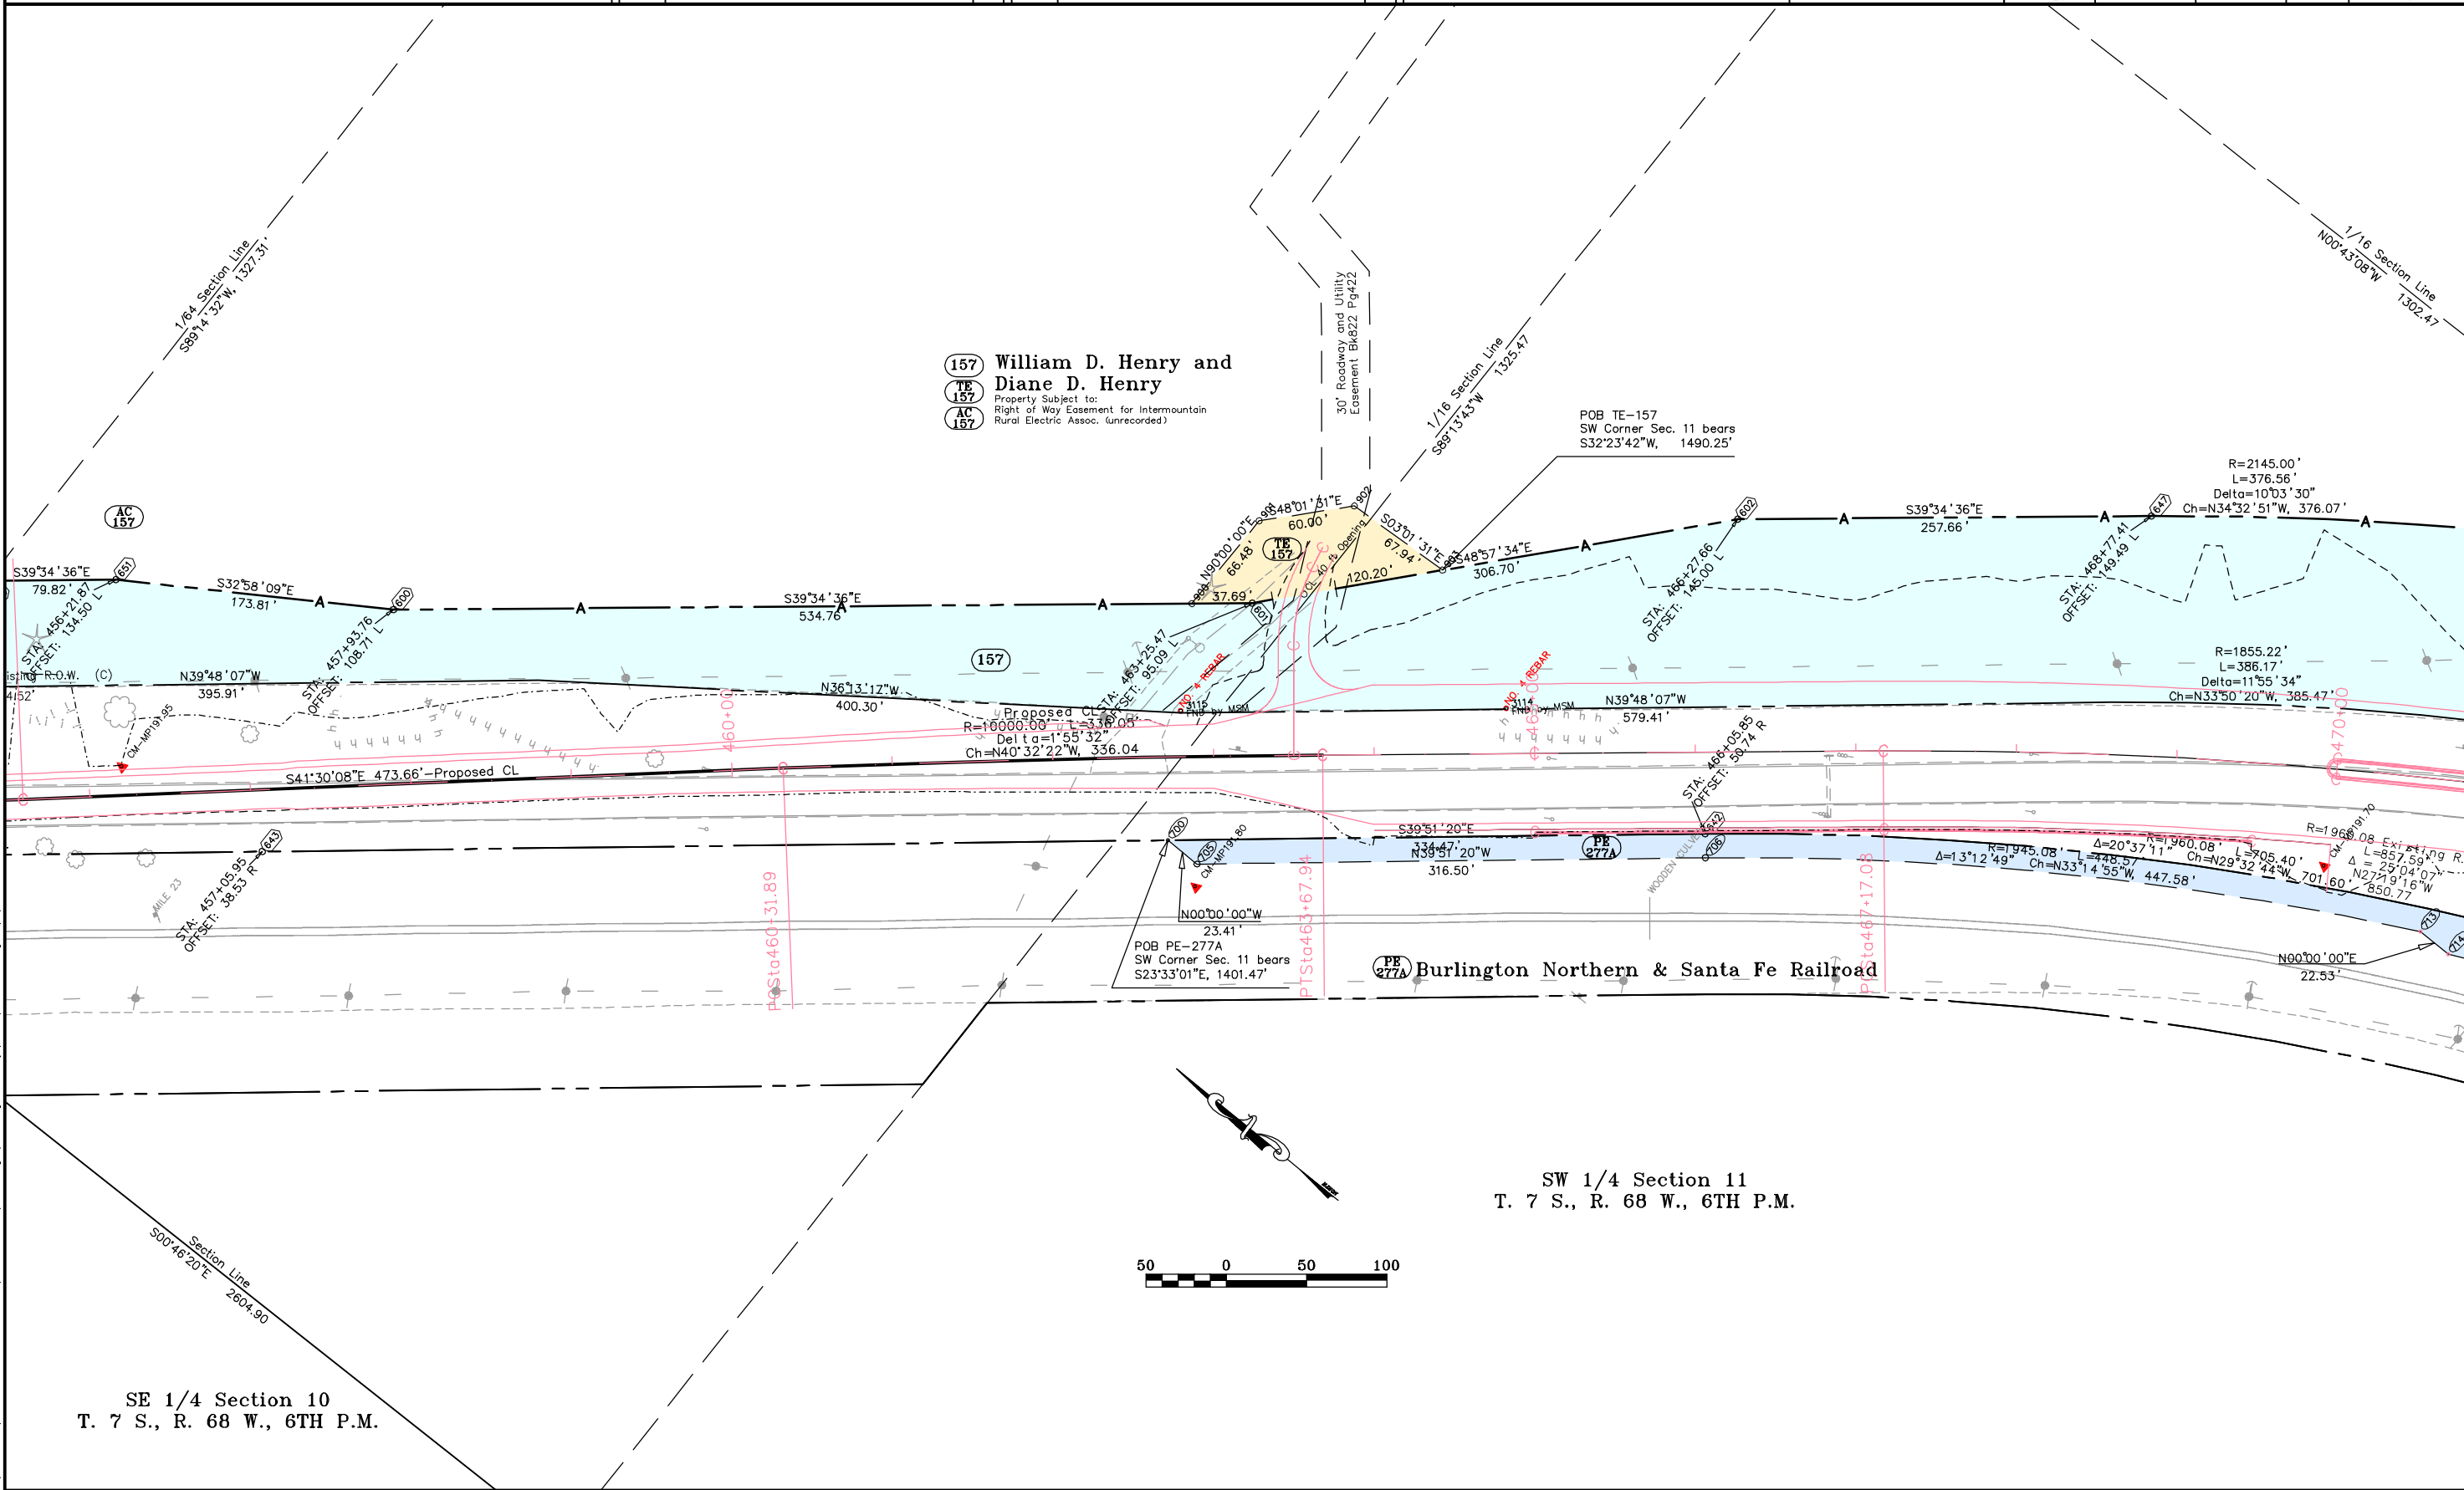

COLORADO DEPARTMENT OF TRANSPORTATION



Region 1
18500 E. Colfax Avenue
Aurora, CO 80011
Phone: (303) 757-9117 FAX: (303) 757-9746

Right-of-Way and Survey Unit: Kevin A. Williams

Sheet Revisions

Date	Description	Initials
3/2/05	Revised Parcels 158 & 161 (Boundary correction)	BDL
5/02/05	Corrected existing easement location- Ownership 162	BDL
02/02/07	Name Change on TE-162, AC-165, and TE-165.	PHK

Sheet Revisions

Date	Description	Initials

Prepared By:

URS

URS Corporation
8181 East Tufts Ave. Denver, CO 80237
Phone: (303)694-2770 Fax: (303) 694-3946

Computer File
Information

CREATION DATE: 11/18/2004 INITIALS: BDL
LAST MOD. DATE: 02/02/2007 INITIALS: PHK
DRAWING NAME & FULL PATH: SEE LEFT
SIDE OF SHEET
SCALE: As Shown UNITS: English

Right of Way Plans

PLAN SHEET

Project Number: NH 0852-086 Phase IV (ROW) / NH 0852-097 (Const.) (P.C. 15139)
Project Location: SH 85, Meadows to C470
Project Location: Louviers South to Sedalia / M.P. 194.0 to M.P. 190.6
Project Code: 13429
Subset Sheets: 9 of 12
Sheet No.: 13
Total No. of Sheets: 43

TE-162 to be acquired from the new owners,
Parcel 162, and AC-162 was acquired from
Charles and Eleanore Smith on 10/21/2005
at Reception No. 2005101767.

162 Charles W. &
AC Eleanore Smith
162 Bk 184 Pg 430

TE Sedalia Land Company,
162 a Colorado Corporation
Reception # 2007007875

161 Richard W. &
TE Florence Blohm
161 Bk 246 Pg 312

AC Mary Kathryn Griffin
165 Reception # 2006011700

158 Clayton S. & June F. Thomas
TE Bk 166 Pg 475
158
AC

157 William D. Henry
AC and Diane D. Henry
157 Property Subject to:
Right of Way Easement for Intermountain
Rural Electric Assoc. (unrecorded)

EOA 157
BOA 158

POB Par 158Rev, Par 161Rev,
TE158 & TE161
SW Corner Sec. 11 bears
S89°14'22"W, 1518.58'

EOA 161
BOA 162

18"x83" Leachfield
Permit # 9603
Possible location from
As-built drawing
Pipes measured in field

STATE HIGHWAY 85

PE Burlington Northern & Santa
277A Fe-Railroad

50 0 50 100

SW 1/4 Section 11
T. 7 S., R. 68 W., 6TH P.M.

NW 1/4 Section 14
T. 7 S., R. 68 W., 6TH P.M.

FLING CERTIFICATION: _____ DAY OF _____, 19____, AT _____, FOR INFORMATION
ONLY IN BOOK _____ OF THE COUNTY LAND SURVEYS/RIGHT OF WAY
SURVEYS AT PAGE _____, RECEPTION NUMBER _____

SIGNED _____
DEPT. _____

I:\PROJECTS\22237041_SH85_Sof_Titan\Sedalia_North\6.07_Design\6.07_Right_of_Way\Plans\ROW_Plan.dwg 3/4/2005 11:21:23 AM JST



Region 1
18500 E. Colfax Avenue
Aurora, CO 80011
Phone: (303) 757-9117 FAX: (303) 757-9746

Right-of-Way and Survey Unit: Kevin A. Williams

Sheet Revisions		
Date	Description	Initials
3/7/06	Revised TE163, TE164 & AC164	BOL
4/25/05	Deleted PE-165	BOL
5/02/05	Corrected existing easement location- Ownership 162	BOL
5/11/05	Added dimension for AC-167- Ownership 167	BOL
02/02/07	Name Change on TE-162, TE-163 Rev, AC-165, and TE-165	HLS

[illegible]

Prepared By	
-------------	--



URS Corporation
8181 East Tufts Ave. Denver, CO 80237
Phone: (303)694-2770 Fax: (303) 694-3946


Computer File Information

CREATION DATE: 11/18/2004	INITIALS: BI
LAST MOD. DATE: 02/02/2007	INITIALS: HI
DRAWING NAME & FULL PATH: SEE LEFT	
SIDE OF SHEET	
SCALE: As Shown	UNITS: English

Right of Way Plans

PLAN SHEET

PROJECT DATA	Project Number: NH 0852-086 Phase IV (ROW) / NH 0852-097 (Const.) (P.C. 15139)			
	Project Location: SH 85, Meadows to C470			
	Project Location: Louviers South to Sedalia / M.P. 194.0 to M.P. 190.6			
	Project Code:	Subset Sheets	Sheet No.	Total No. of Sheets
13429	10 of 12	14	43	

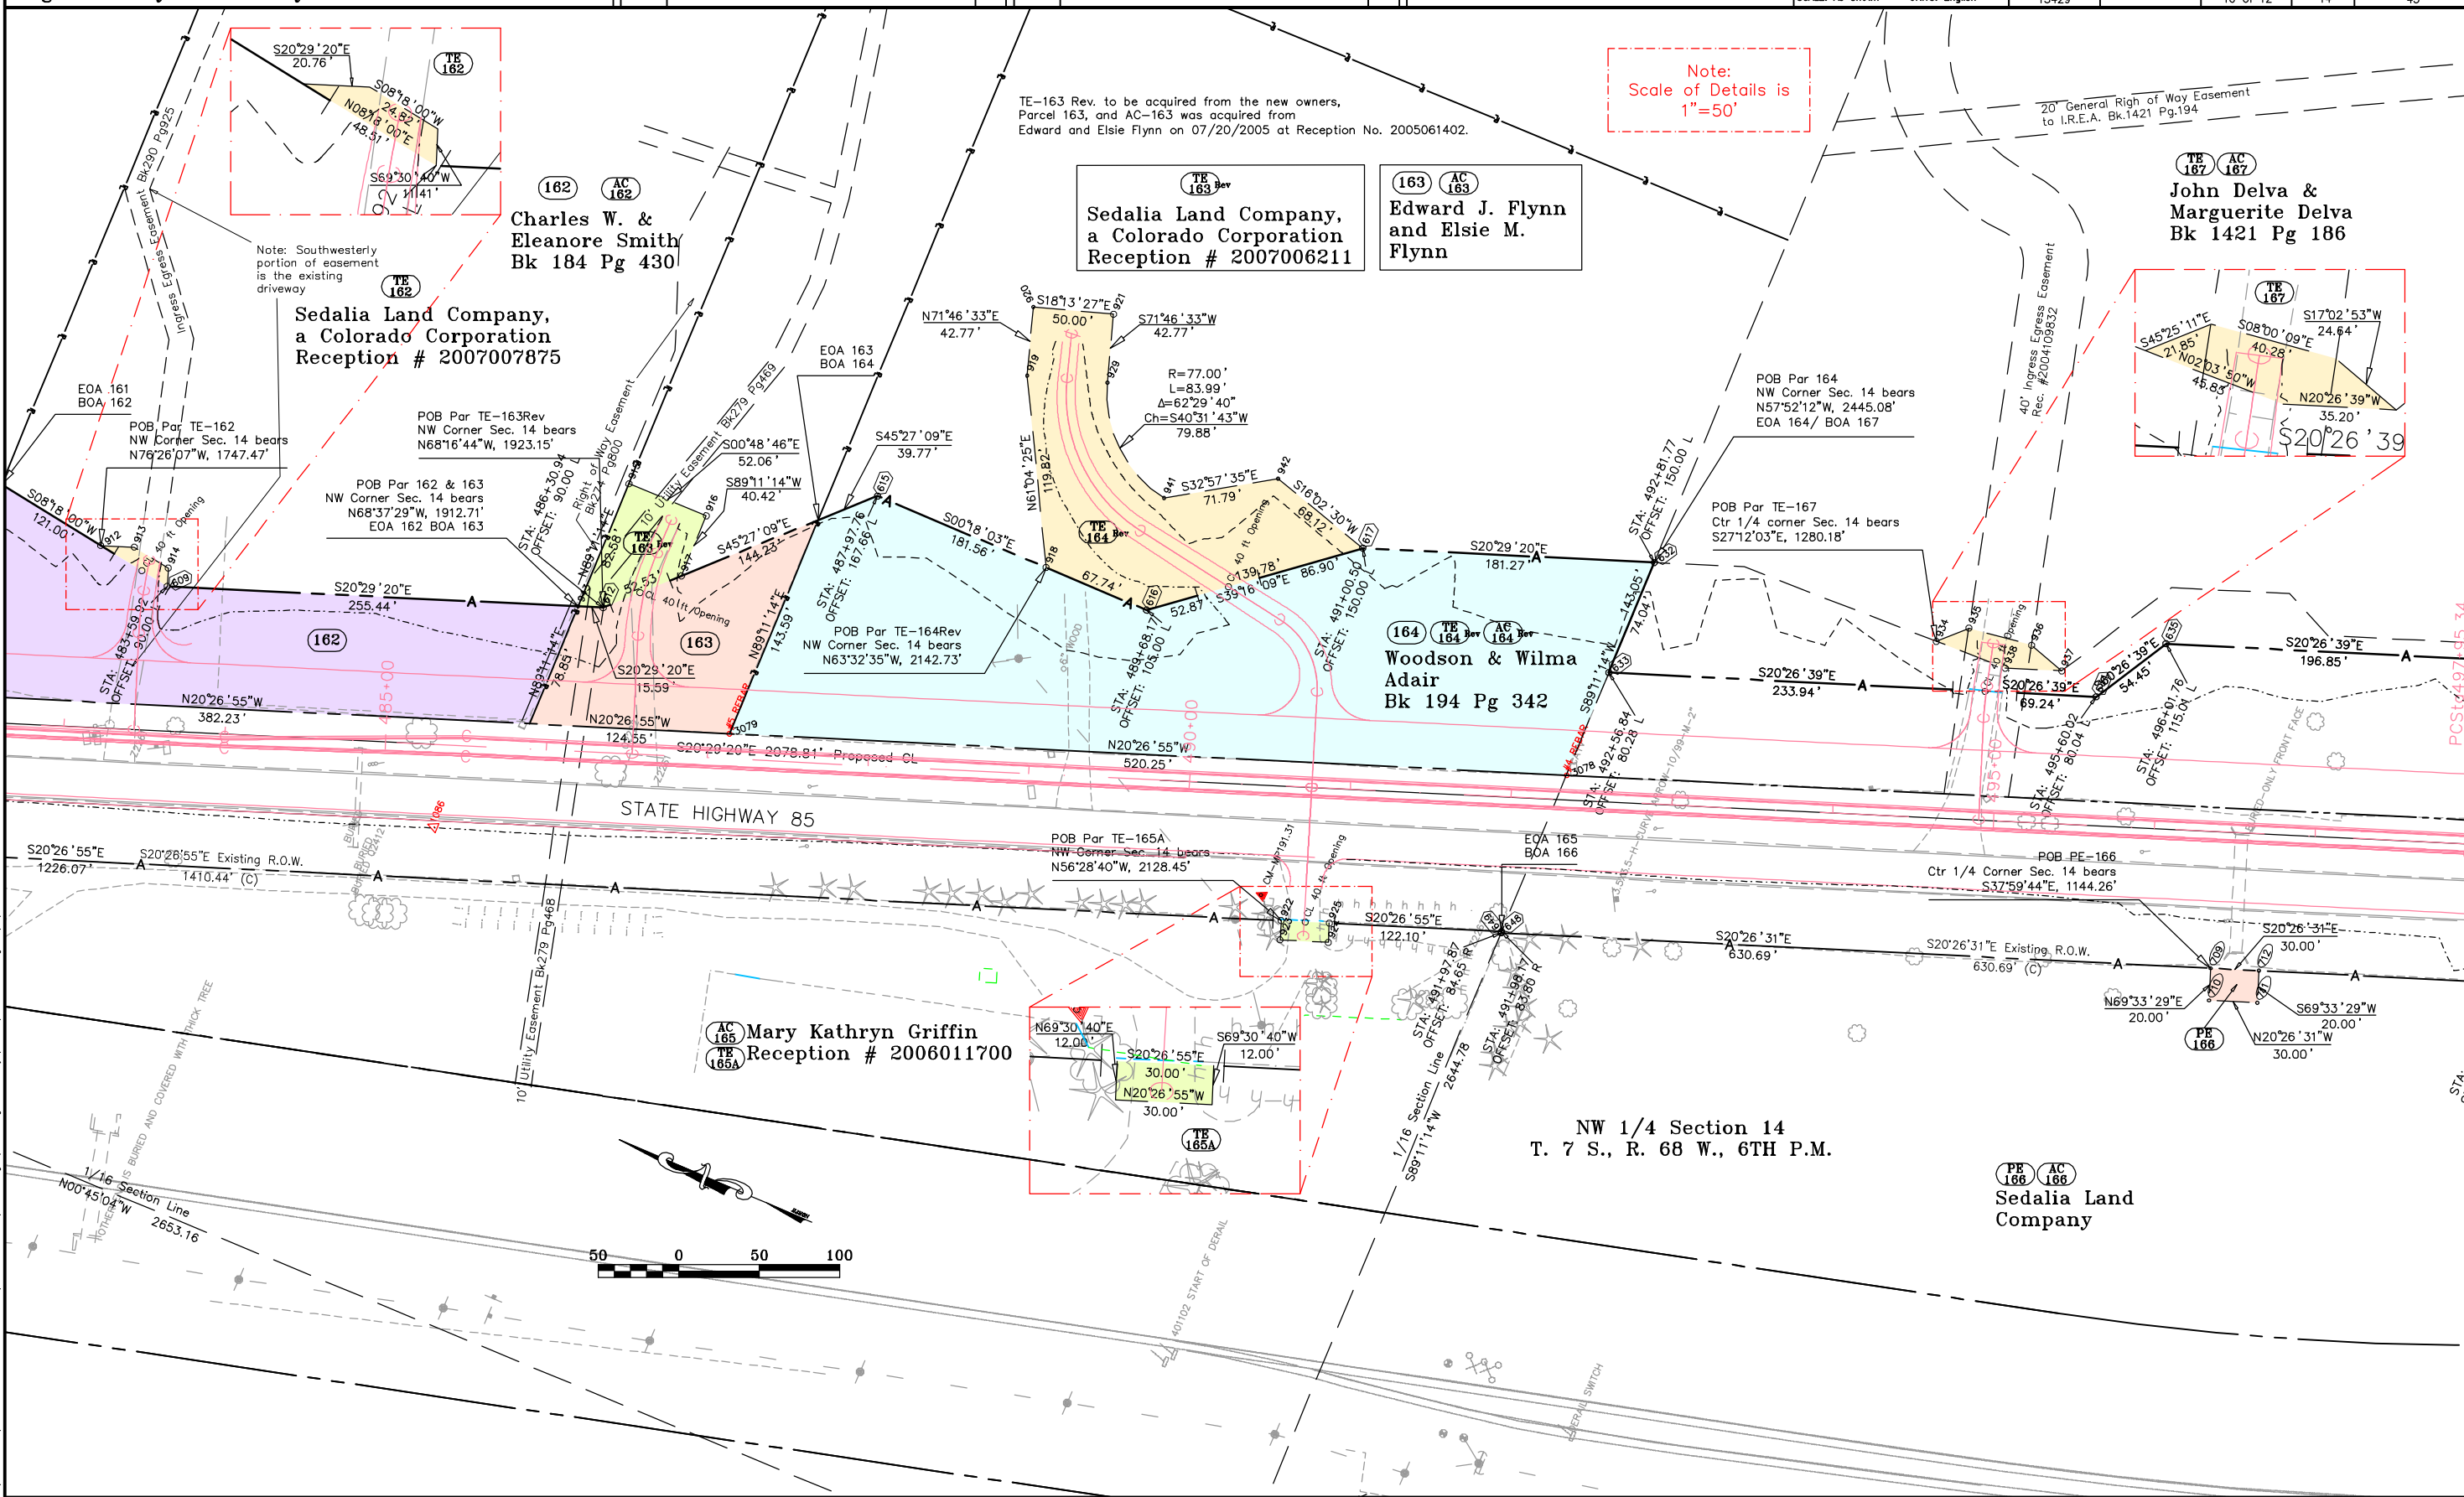

COLORADO DEPARTMENT OF TRANSPORTATION



Region 1
18500 E. Colfax Avenue
Aurora, CO 80011
Phone: (303) 757-9117 FAX: (303) 757-9746

Right-of-Way and Survey Unit: Kevin A. Williams

Sheet Revisions

Date	Description	Initials
3/2/05	Revised AC-167A	BDL

Sheet Revisions

Date	Description	Initials

Prepared By:

URS

URS Corporation
8181 East Tufts Ave. Denver, CO 80237
Phone: (303)694-2770 Fax: (303) 694-3946

Computer File
Information

CREATION DATE: 11/18/2004 INITIALS: BDL
LAST MOD. DATE: 3/2/2005 INITIALS: BDL
DRAWING NAME & FULL PATH: SEE LEFT
SIDE OF SHEET
SCALE: As Shown UNITS: English

Right of Way Plans

PLAN SHEET

Project Number: NH 0852-086 Phase IV (ROW) / NH 0852-097 (Const.) (P.C. 15139)
Project Location: SH 85, Meadows to C470
Project Location: Louviers South to Sedalia / M.P. 194.0 to M.P. 190.6
Project Code: 13429
Subset Sheets: 11 of 12
Sheet No.: 15
Total No. of Sheets: 43

Note: Parcel numbers 1, 1A, SE1 & 3 were derived from a Douglas County land swap. Legal Descriptions for said parcels were written by Mountain Surveying and Mapping, Inc.

AC 167 AC 167A

John Delva & Marguerite Delva
Bk 1421 Pg 186

NE 1/4 Section 14
T. 7 S., R. 68 W., 6TH P.M.

SE 1/4 Section 14
T. 7 S., R. 68 W., 6TH P.M.

NW 1/4 Section 14
T. 7 S., R. 68 W., 6TH P.M.

SW 1/4 Section 14
T. 7 S., R. 68 W., 6TH P.M.

166 PE 166 TE 166 AC 166

Sedalia Land Company

PE 277B

Burlington Northern & Santa
Fe Railroad

FILING CERTIFICATION: DEPOSITED THIS DAY OF 19 AT M., FOR INFORMATION ONLY IN BOOK OF THE COUNTY LAND SURVEYS/RIGHT OF WAY SURVEYS AT PAGE RECEPTION NUMBER

SIGNED DEPT.

I:\PROJECTS\22237041_SH85_Sof_Tiron\Sedalia_North\6.07_Right_of_Way\Plans\ROW_Plan.dwg 3/4/2005 11:21:23 AM MST

COLORADO DEPARTMENT OF TRANSPORTATION



Region 1
18500 E. Colfax Avenue
Aurora, CO 80011
Phone: (303) 757-9117 FAX: (303) 757-9746

Right-of-Way and Survey Unit: Kevin A. Williams

Sheet Revisions

Date	Description	Initials
3/2/05	Revised AC-167A	BDL

Sheet Revisions

Date	Description	Initials

Prepared By:

URS

URS Corporation
8181 East Tufts Ave. Denver, CO 80237
Phone: (303)694-2770 Fax: (303) 694-3946

Computer File
Information

CREATION DATE: 11/18/2004 INITIALS: BDL
LAST MOD. DATE: 3/2/2005 INITIALS: BDL
DRAWING NAME & FULL PATH: SEE LEFT
SIDE OF SHEET
SCALE: As Shown UNITS: English

Right of Way Plans

PLAN SHEET

Project Number: NH 0852-086 Phase IV (ROW) / NH 0852-097 (Const.) (P.C. 15139)
Project Location: SH 85, Meadows to C470
Project Location: Louviers South to Sedalia / M.P. 194.0 to M.P. 190.6
Project Code: 13429
Subset Sheets 12 of 12 Sheet No. 16 Total No. of Sheets 43

Note: Parcel numbers 1, 1B, TE4A & 4 were derived from a Douglas County land swap. Legal Descriptions for said parcels were written by Mountain Surveying and Mapping, Inc.

NE 1/4 Section 14
T. 7 S., R. 68 W., 6TH P.M.

TE 169 Intermountain Rural Electric Association

Cherokee Ranch and Castle Foundation

John Delva & Marguerite Delva
Bk 1421 Pg 186

POB TE-169
C 1/4 Corner Sec. 14 bears
N66°01'46"W, 900.80'

STATE HIGHWAY 85

PE 277B Burlington Northern & Santa Fe Railroad

SE 1/4 Section 14
T. 7 S., R. 68 W., 6TH P.M.

SEE RIGHT OF WAY PROJECT NH 0852-086

End of Right of Way
Project NH 0852-086 Phase IV
Station: 518+81.72
M.P.: 190.80

Sedalia Land Company



FLING CERTIFICATION: DEPOSITED THIS DAY OF 19 AT M., FOR INFORMATION ONLY IN BOOK OF THE COUNTY LAND SURVEYS/RIGHT OF WAY SURVEYS AT PAGE RECEPTION NUMBER

SIGNED DEPT.

I:\PROJECTS\22237041_SH85_Sof_Titan\Sedalia_North\6.07_Right_of_Way\Plans\ROW_Plan.dwg 3/4/2005 11:21:23 AM MST

COLORADO DEPARTMENT OF TRANSPORTATION



Region 1
18500 E. Colfax Avenue
Aurora, CO 80011
Phone: (303) 757-9117 FAX: (303) 757-9746

Right-of-Way and Survey Unit: Kevin A. Williams

Sheet Revisions

Date	Description	Initials
XX/XX/XX	X	XXX

Sheet Revisions

Date	Description	Initials

Prepared By:

URS

URS Corporation
8181 East Tufts Ave. Denver, CO 80237
Phone: (303)694-2770 Fax: (303) 694-3946


Computer File
Information

CREATION DATE: 11/18/2004 INITIALS: BDL
LAST MOD. DATE: 2/1/2005 INITIALS: BDL
DRAWING NAME & FULL PATH: SEE LEFT
SIDE OF SHEET
SCALE: As Shown UNITS: English

Right of Way Plans

OWNERSHIP SHEET

Project Number: NH 0852-086 Phase IV (ROW) / NH 0852-097 (Const.) (P.C. 15139)
Project Location: SH 85, Meadows to C470
Project Location: Louviers South to Sedalia / M.P. 194.0 to M.P. 190.6
Project Code: 13429
Subset Sheets 1 of 4
Sheet No. 17
Total No. of Sheets 43

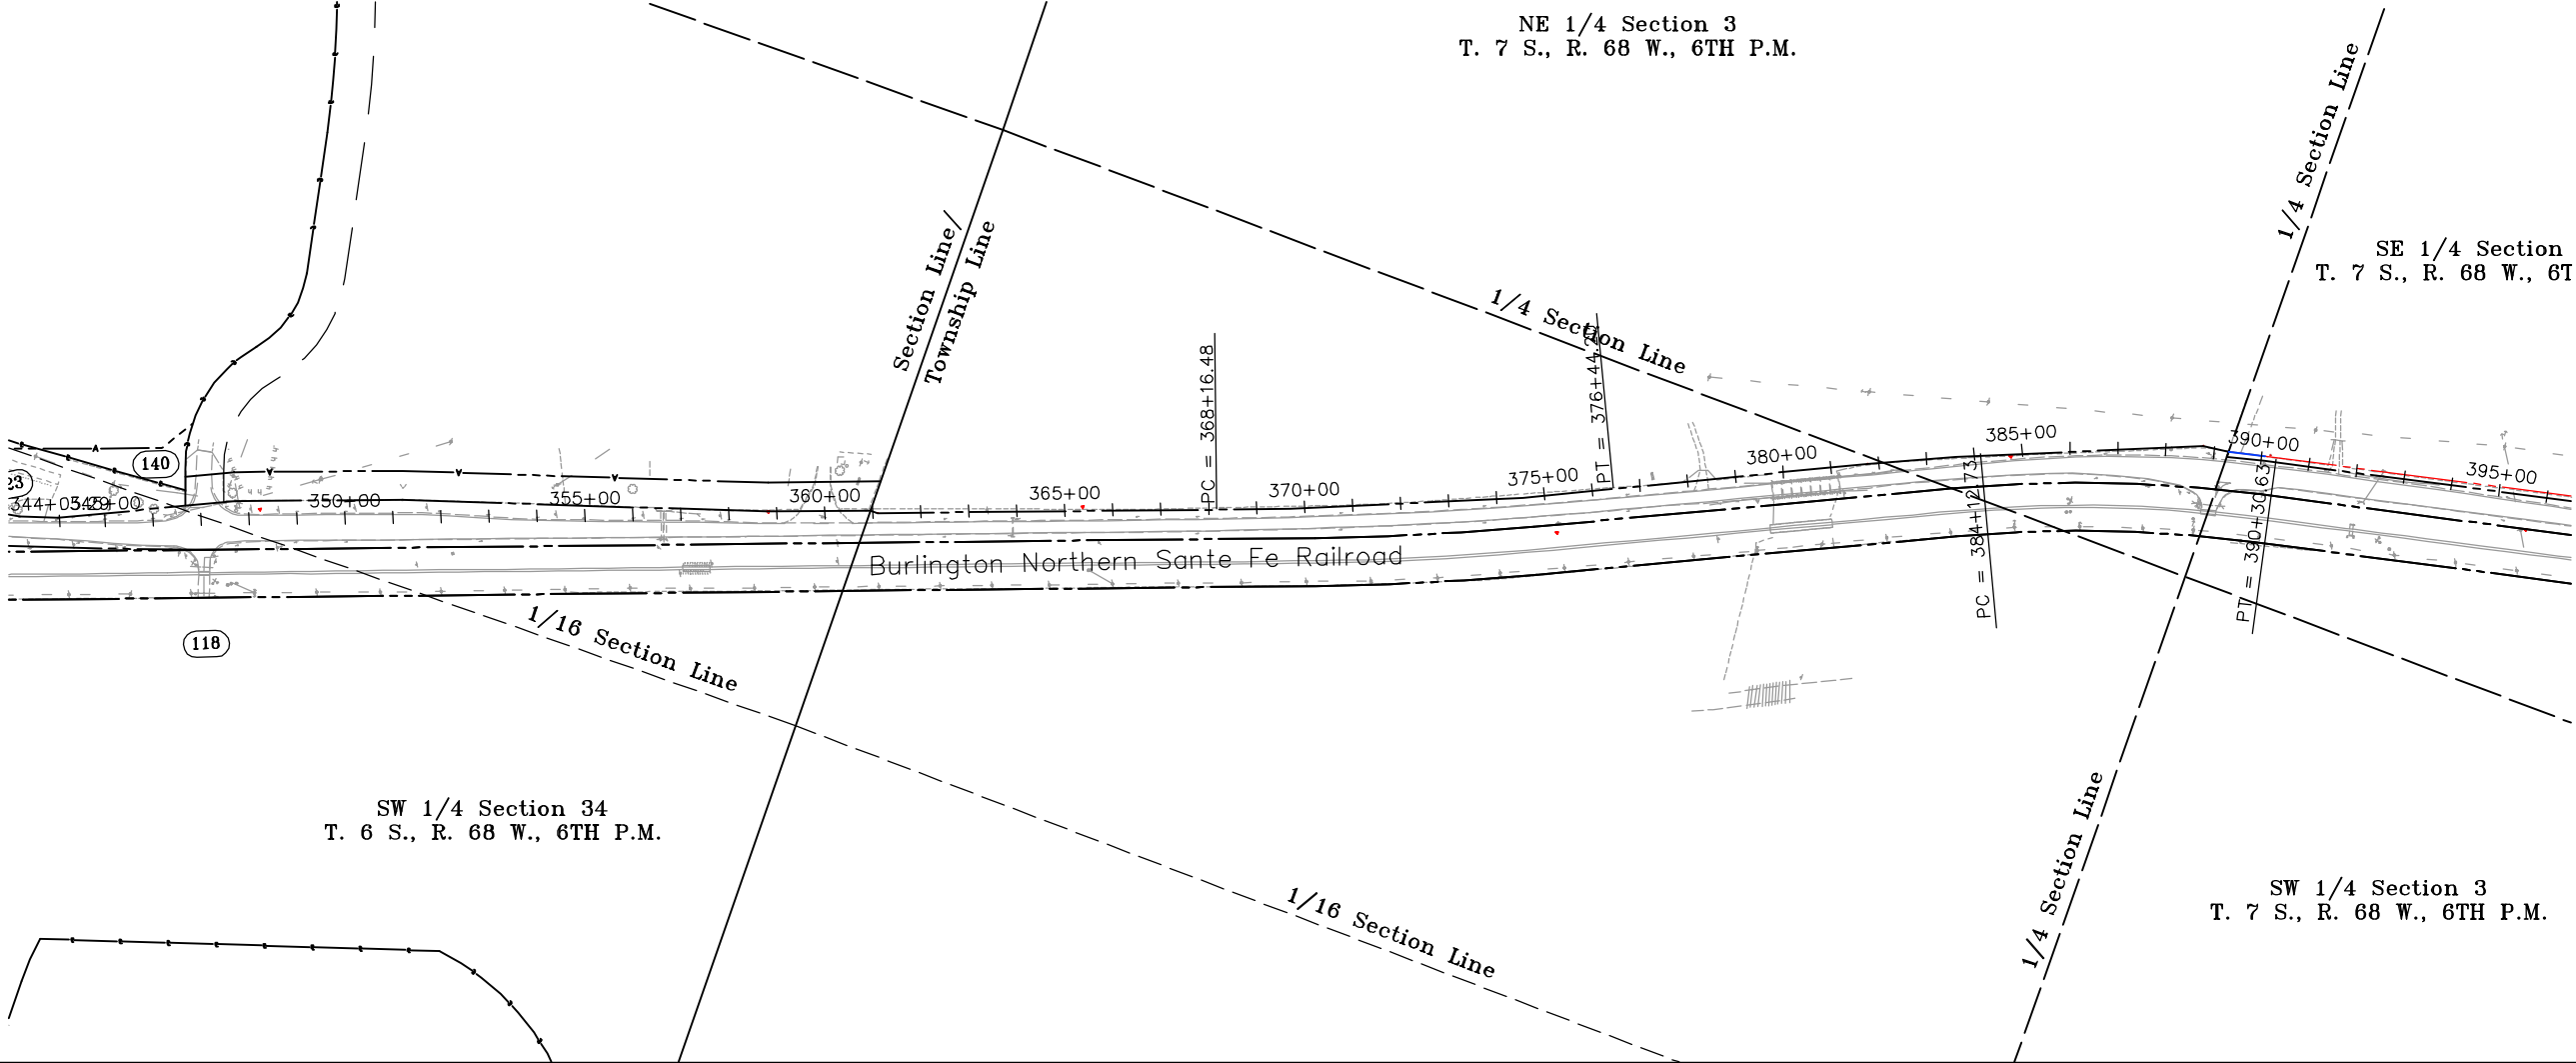

FILING CERTIFICATION:
DEPOSITED THIS ____ DAY OF ____ 19____, AT ____ M., FOR INFORMATION
ONLY IN BOOK ____ OF THE COUNTY LAND SURVEYS/RIGHT OF WAY
SURVEYS AT PAGE ____ RECEPTION NUMBER ____

SIGNED _____
DEPT. _____

COLORADO DEPARTMENT OF TRANSPORTATION



Region 1
18500 E. Colfax Avenue
Aurora, CO 80011
Phone: (303) 757-9117 FAX: (303) 757-9746

Right-of-Way and Survey Unit: Kevin A. Williams

Sheet Revisions

Date	Description	Initials
XX/XX/XX	X	XXX

Sheet Revisions

Date	Description	Initials

Prepared By:



URS Corporation
8181 East Tufts Ave. Denver, CO 80237
Phone: (303)694-2770 Fax: (303) 694-3946


Computer File
Information

CREATION DATE: 11/18/2004 INITIALS: BDL
LAST MOD. DATE: 2/1/2005 INITIALS: BDL
DRAWING NAME & FULL PATH: SEE LEFT
SIDE OF SHEET
SCALE: As Shown UNITS: English

Right of Way Plans

OWNERSHIP SHEET


Project Number: NH 0852-086 Phase IV (ROW) / NH 0852-097 (Const.) (P.C. 15139)
Project Location: SH 85, Meadows to C470
Project Location: Louviers South to Sedalia / M.P. 194.0 to M.P. 190.6
Project Code: 13429
Subset Sheets 2 of 4
Sheet No. 18
Total No. of Sheets 43

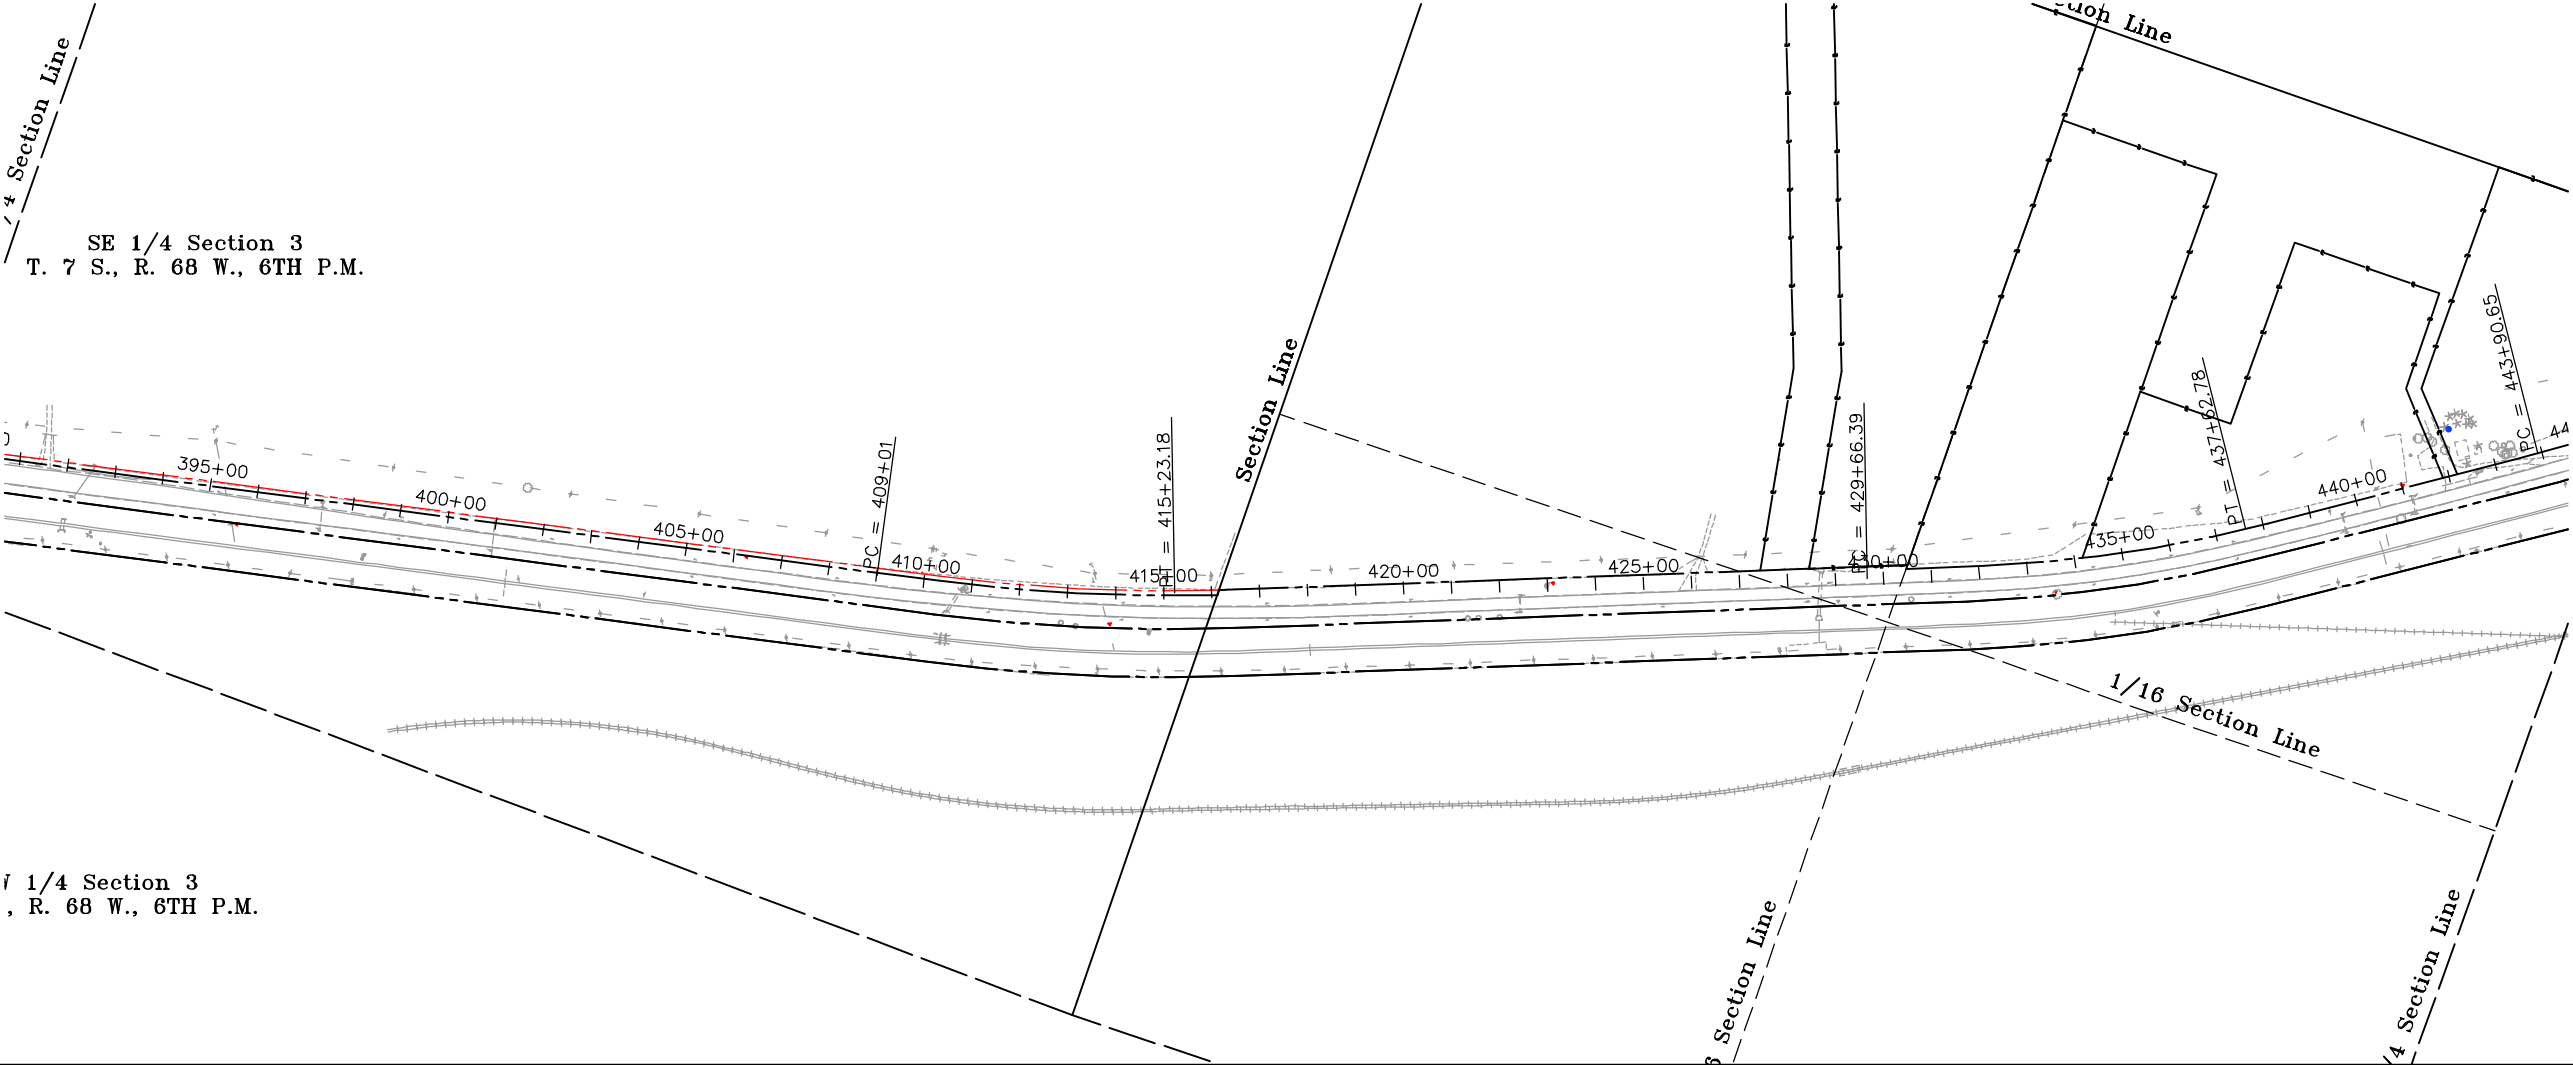

1/4 Section 3
, R. 68 W., 6TH P.M.

FILING CERTIFICATION:
DEPOSITED THIS ____ DAY OF ____, 19____, AT ____ M., FOR INFORMATION
ONLY IN BOOK ____ OF THE COUNTY LAND SURVEYS/RIGHT OF WAY
SURVEYS AT PAGE ____, RECEPTION NUMBER ____

SIGNED _____
DEPT. _____

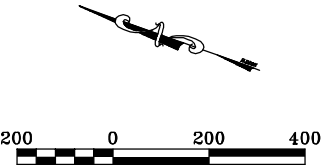

COLORADO DEPARTMENT OF TRANSPORTATION



Region 1
18500 E. Colfax Avenue
Aurora, CO 80011
Phone: (303) 757-9117 FAX: (303) 757-9746

Right-of-Way and Survey Unit: Kevin A. Williams

Sheet Revisions

Date	Description	Initials
3/2/05	Revised Parcels 158 & 161 (boundary correction)	BDL
3/2/05	Revised TE-163, TE-164 & AC-164	BDL
4/25/05	Deleted PE-165	BDL
5/02/05	Corrected existing easement location- Ownership 162	BDL
2/02/07	Name change on TE-162, TE-163 Rev, AC-165, TE-165, and TE-165A	HLS

Sheet Revisions

Date	Description	Initials

Prepared By:

URS

URS Corporation
8181 East Tufts Ave. Denver, CO 80237
Phone: (303)694-2770 Fax: (303) 694-3946


Computer File
Information

CREATION DATE: 11/18/2004 INITIALS: TWS
LAST MOD. DATE: 2/2/2007 INITIALS: HLS
DRAWING NAME & FULL PATH: SEE LEFT
SIDE OF SHEET
SCALE: As Shown UNITS: English

Right of Way Plans

OWNERSHIP SHEET

Project Number: NH 0852-086 Phase IV (ROW) / NH 0852-097 (Const.) (P.C. 15139)
Project Location: SH 85, Meadows to C470
Project Location: Louviers South to Sedalia / M.P. 194.0 to M.P. 190.6
Project Code: 13429
Subset Sheets 3 of 4
Sheet No. 19
Total No. of Sheets 43

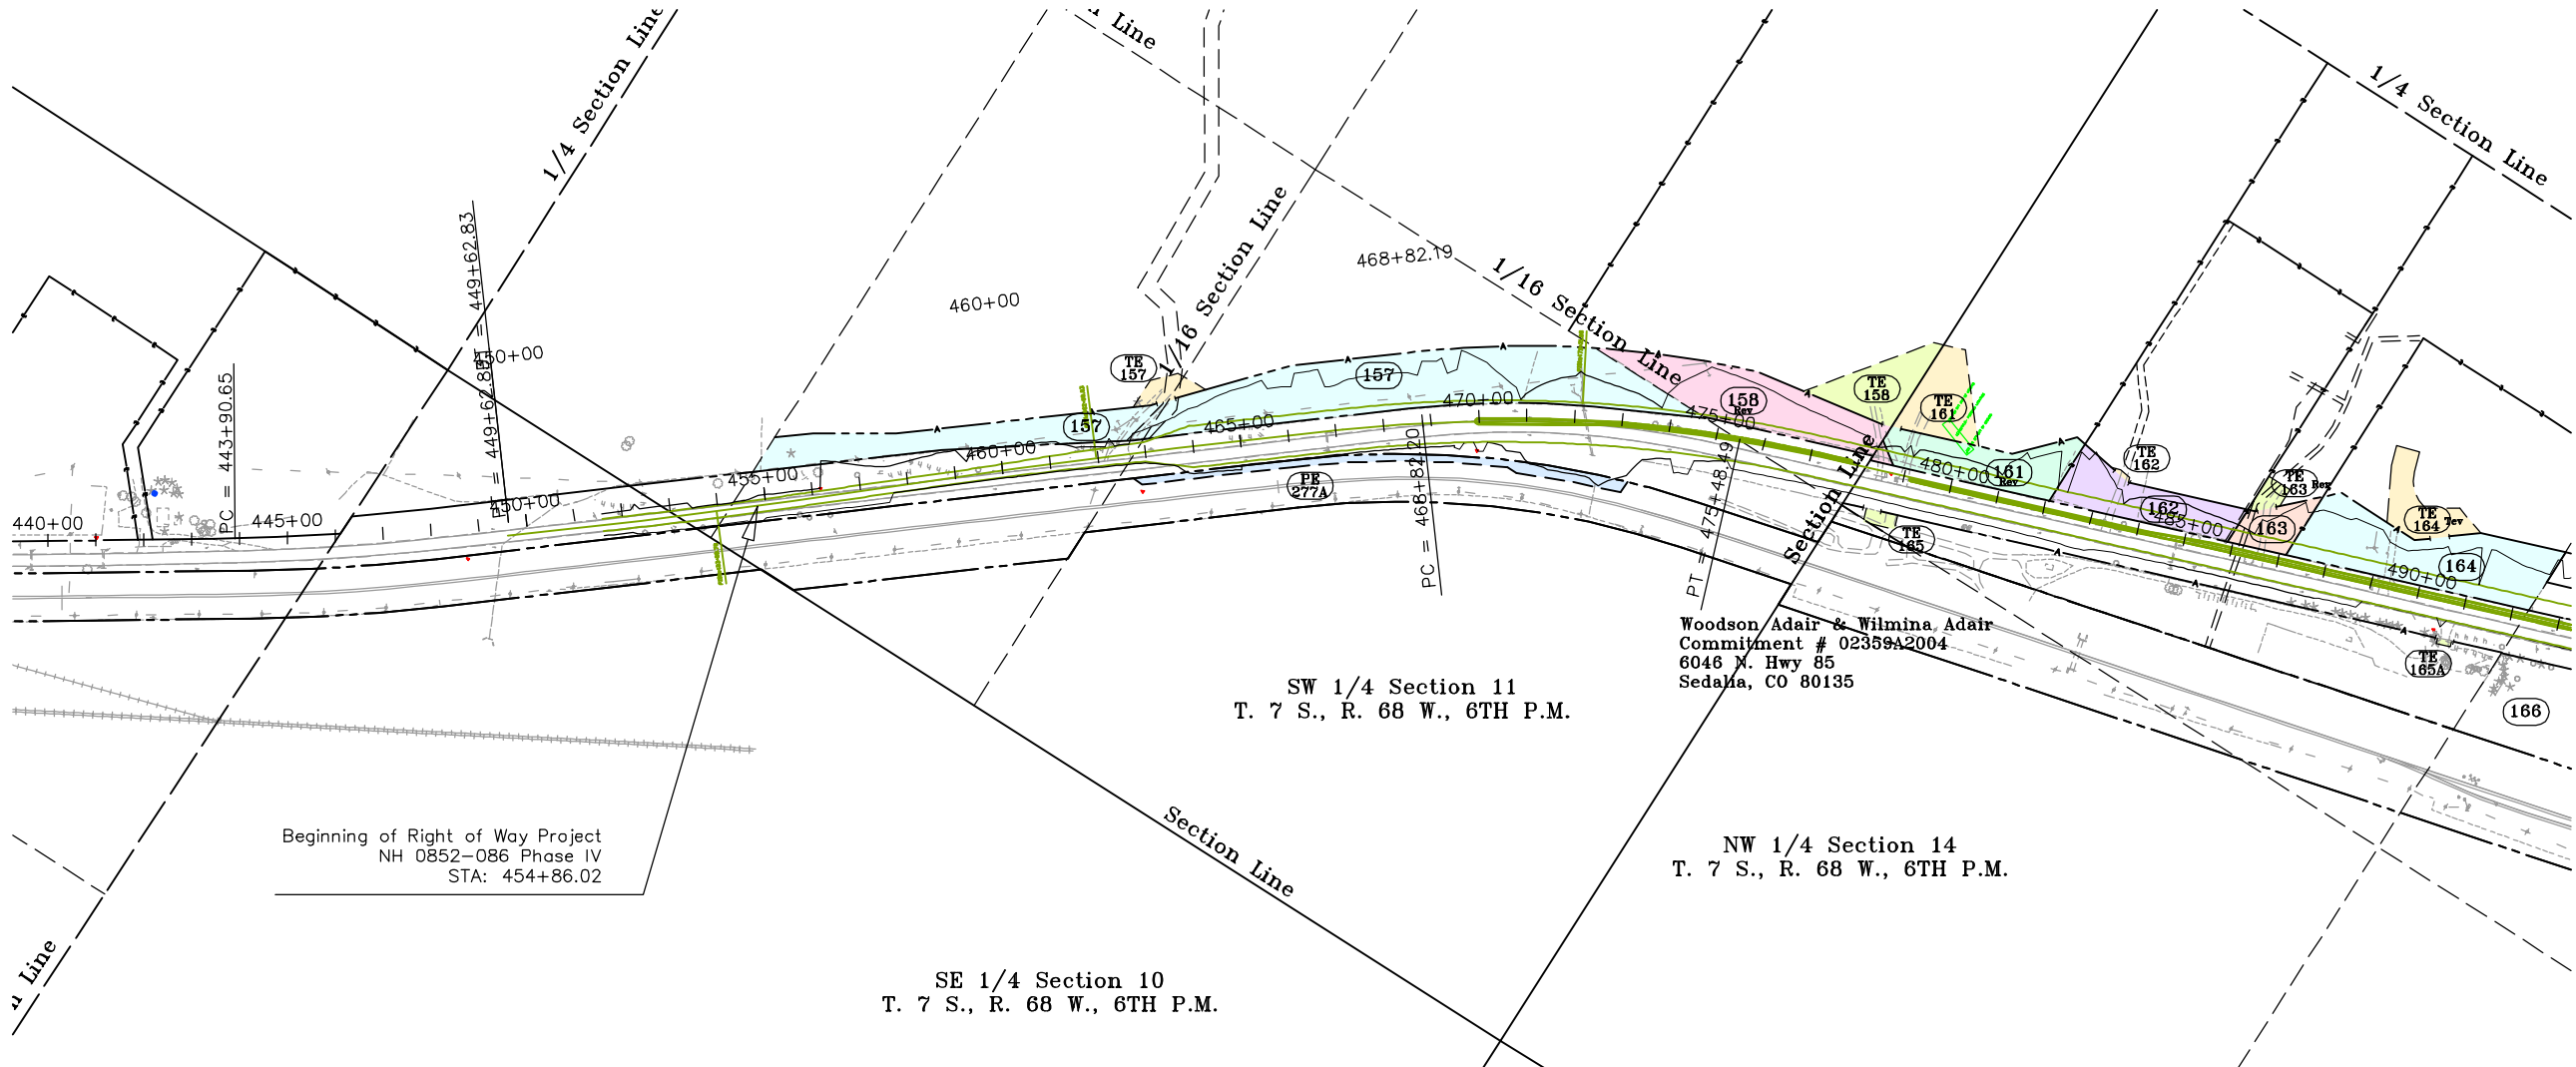

AC 157 157 William D. Henry & Diane D. Henry
Commitment # 02378A2004
P.O. Box 365
6490 W. Hwy 85
Sedalia, CO 80135

AC 158 158 Clayton S. Thomas
Commitment # 02377A2004
6222 N. U.S. Hwy 85
Sedalia, CO 80135

AC 161 161 Steven Blohm & Florence Blohm
Commitment # 02362A2004
6200 N. Hwy 85
Sedalia, CO 80135

AC 162 162 Charles W. Smith & M. Eleanore Smith
Commitment # 02361A2004
P.O. Box 105
6142 N. Hwy 85
Sedalia, CO 80135

TE 162 Sedalia Land Company, a Colorado
Corporation
5970 North Highway 85
Sedalia, CO 80135

AC 163 163 Edward J. Flynn & Elsie M. Flynn
Commitment # 02360A2004
6090 N. U.S. Hwy 85
Sedalia, CO 80135


TE 163 Sedalia Land Company, a Colorado
Corporation
5970 North Highway 85
Sedalia, CO 80135

AC 164 164 Woodson Adair & Wilmina Adair
Commitment # 02359A2004
6046 N. Hwy 85
Sedalia, CO 80135

AC 165 Mary Kathryn Griffin
5557 North Highway 85
P.O. Box 284
Sedalia, CO 80135

AC 166 Sedalia Land Company
Commitment # 02357A2004
3773 Cherry Creek Drive North
Suite 801
Denver, CO 80209

PE 277A Burlington Northern Sante Fe Railroad

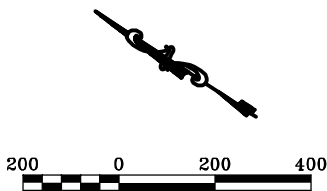

FLING CERTIFICATION: DEPOSITED THIS DAY OF 19 AT M., FOR INFORMATION
ONLY IN BOOK OF THE COUNTY LAND SURVEYS/RIGHT OF WAY
SURVEYS AT PAGE RECEPTION NUMBER

SIGNED DEPT.

10:16:38 AM MST

I:\PROJECTS\22237041_SH85_Sol_Tion\Sedalia_North\6.07_Design\6.07_Right_of_Way\Plans\Ownership.dwg 3/4/2005

COLORADO DEPARTMENT OF TRANSPORTATION



Region 1
18500 E. Colfax Avenue
Aurora, CO 80011
Phone: (303) 757-9117 FAX: (303) 757-9746

Right-of-Way and Survey Unit: Kevin A. Williams

Sheet Revisions

Date	Description	Initials
3/2/05	Revised TE-163, TE-164, AC-164 & AC-167A	BDL
2/2/07	Name change on TE-163 Rev, TE-165A	HLS

Sheet Revisions

Date	Description	Initials

Prepared By:

URS

URS Corporation
8181 East Tufts Ave. Denver, CO 80237
Phone: (303)694-2770 Fax: (303) 694-3946


Computer File
Information

CREATION DATE: 11/18/2004 INITIALS: TWS
LAST MOD. DATE: 2/2/2007 INITIALS: HLS
DRAWING NAME & FULL PATH: SEE LEFT
SIDE OF SHEET
SCALE: As Shown UNITS: English

Right of Way Plans

OWNERSHIP SHEET

Project Number: NH 0852-086 Phase IV (ROW) / NH 0852-097 (Const.) (P.C. 15139)
Project Location: SH 85, Meadows to C470
Project Location: Louviers South to Sedalia / M.P. 194.0 to M.P. 190.6
Project Code: 13429
Subset Sheets 4 of 4
Sheet No. 20
Total No. of Sheets 43

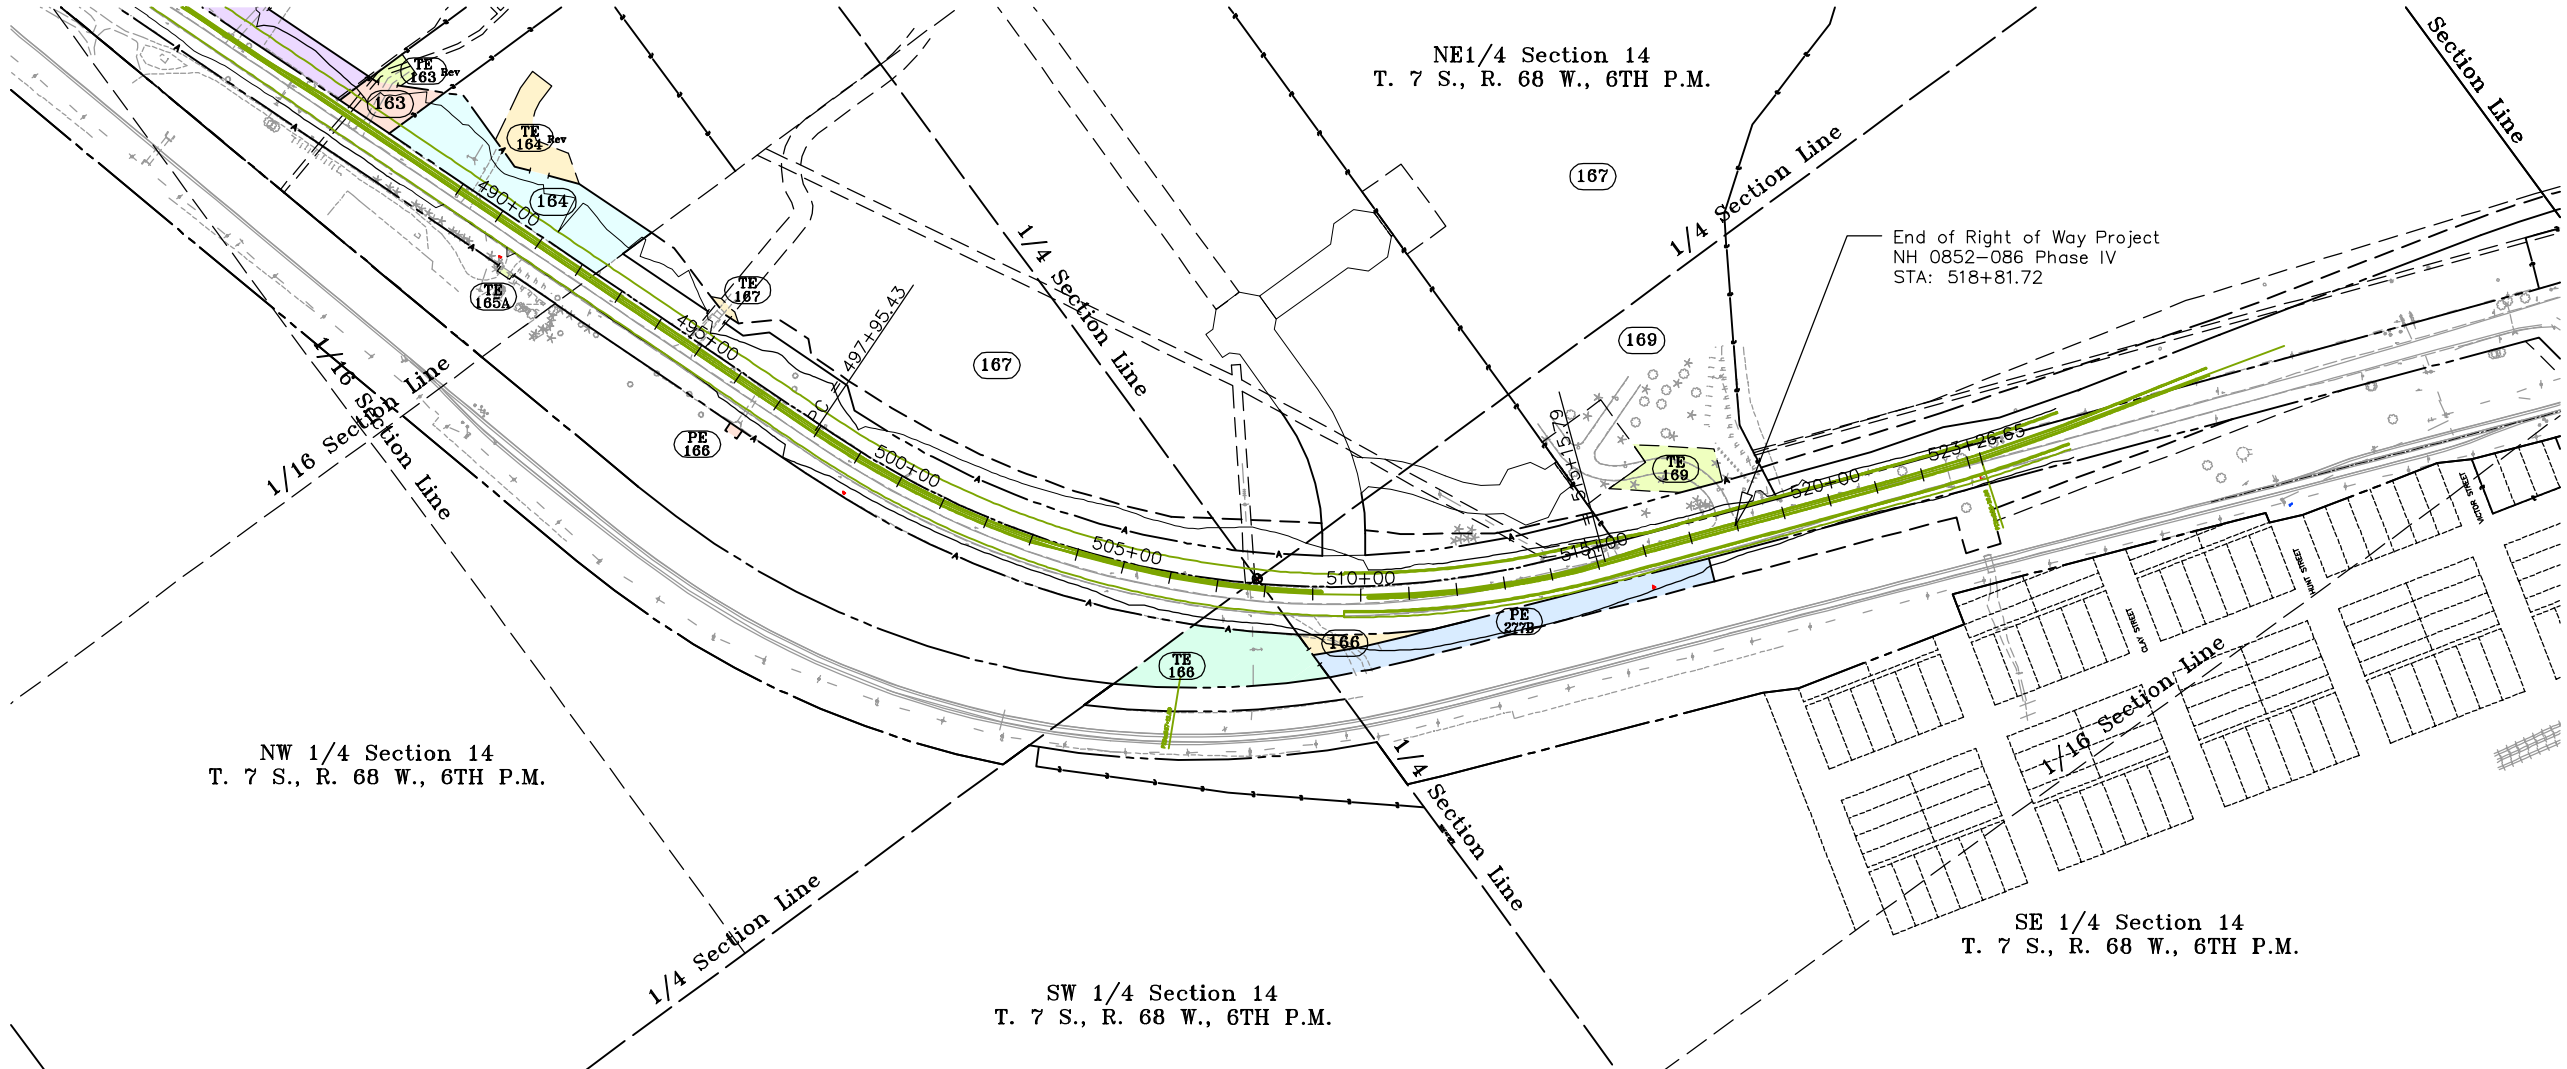

AC 163 163 Edward J. Flynn & Elsie M. Flynn
Commitment # 02360A2004
6090 N. U.S. Hwy 85
Sedalia, CO 80135

AC 167 167 John Delva & Marguerite Delva
Commitment # 02358A2004
6240 Meadowbrook Lane
Sedalia, CO 80135

TE 163 163 Sedalia Land Company, a Colorado
Corporation
5970 North Highway 85
Sedalia, CO 80135


AC 169 169 The Intermountain Rural Electric
Association
Commitment # 01040A2003
5496 N. U.S. 85
Sedalia, CO 80135

AC 164 164 Woodson Adair & Wilmina Adair
Commitment# 20359A2004
6046 N. Hwy 85
Sedalia, CO 80135

PE 277B Burlington Northern Sante Fe Railroad

AC 165 165 Mary Kathryn Griffin
5557 North Highway 85
P.O. Box 284
Sedalia, CO 80135

AC 166 166 Sedalia Land Company
Commitment # 02357A2004
3773 Cherry Creek Drive North
Suite 801
Denver, CO 80209

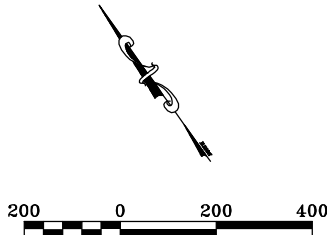

FILING CERTIFICATION:
DEPOSITED THIS _____ DAY OF _____, 19____, AT _____, FOR INFORMATION
ONLY IN BOOK _____ OF THE COUNTY LAND SURVEYS/RIGHT OF WAY
SURVEYS AT PAGE _____, RECEPTION NUMBER _____

SIGNED _____
DEPT. _____