

STATE OF COLORADO

DEPARTMENT OF TRANSPORTATION



DEPOSITED RIGHT OF WAY PLANS MEMO

DATE: May 1, 2012
TO: Central Office Project Development Branch, ROW Services
FROM: Todd Johnston, Survey Coordinator Region 5
SUBJECT: Deposited ROW Plans

RECEIVED
MAY 08 2012
Right of Way

REGION: 5
PROJECT CODE: 13927
PROJECT NUMBER: NH 1602-089
PROJECT LOCATION: US 160 Turkey Springs Road

The Region office has completed and filed the Right of Way Plans for the above captioned project with the County Clerk and Recorder of Archuleta County.

Plat Number S1181A – S1181G.

Date: October 23, 2007.

Section 27, Township 34 North, Range 2 1/2 West and Sections 1, 9, 10, 11, & 12, Township 34 North, Range 3 West of the New Mexico Principal Meridian.

Highway 160, Beginning Mile Post 130.35, Ending Mile Post 134.13.

The total number of sheets deposited 7.

By 
Region ROW Plans Coordinator



Region 5
Address: 3803 North Main Avenue, Suite 300
Durango, CO 81301
Phone: (970) 385-1400 FAX: (970) 385-1410

Right of Way Plans Unit: Willis

Sheet Revisions

Sheet Revisions

Sheet Revisions

Right of Way Plans

Title Sheet

Project Number: NH 1602-089

Project Location: US 160 Turkey Springs Road

Project Location: US 160

Project Code	Last Mod. Date	Subst Sheets	Sheet No.	Total No. of Sheets
13927	XX-XX-XX		1	12

DEPARTMENT OF TRANSPORTATION STATE OF COLORADO

PRELIMINARY RIGHT OF WAY PLANS FOR

FEDERAL AID PROJECT NO. NH 1602-089

BEING A DEPENDENT RESURVEY OF THE ORIGINAL RIGHT OF WAY LINES
ESTABLISHED BY FEDERAL AID PROJECT NO. 243-G

U.S. HIGHWAY NO. 160

in Section 27, T. 34 N., R. 2 1/2 W., and Sections 1, 9,
10, 11, & 12, T. 34 N., R. 3 W., N.M.P.M.

ARCHULETA COUNTY

R.O.W. LENGTH OF PROJECT: 5.770 MILE

END R.O.W. PROJECT NO. NH 1601-089 =
STA 658+83.20 ON FAP 243-G =
M.P. 134.13 ON U.S. 160

CONVENTIONAL SIGNS

COUNTY LINE
TOWNSHIP OR RANGE LINE

LAND LINES SECTION LINE 1/4 SECTION LINE 1/16 SECTION LINE

PROPERTY OR TRACT LINE

RAILROAD

EXISTING ROAD

NEW ROAD

CONTROL OF ACCESS

ACCESS DENIED BY DEED

RIGHT OF WAY LINE-EXISTING

RIGHT OF WAY LINE-PROPOSED

TOP OF CUTS

TOE OF FILLS

BARBED WIRE FENCE

CHAIN LINK FENCE

BARRIER FENCE

WOVEN WIRE-COMBINATION FENCE

SNOW FENCE

WOOD FENCE

GUARDRAIL (METAL TYPES)

TREES

TEL. & CABLE TV LINES

ELECTRIC LINES

DEADMAN OR ANCHOR ON POLE

BURIED TEL. CABLE

BURIED ELECTRIC CABLE

FIBER OPTICS CABLE

GAS MAIN

OIL MAIN

GAS METER

WATER METER

SANITARY SEWERS

STORM DRAIN

MAIL BOX

SIGNS

BENCH MARK

TRIANGULATION POINT

R.O.W.

ROAD APPROACHES

SECTION CORNER

CENTER OF SECTION

ANGLE POINT OF SEGREGATED TRACT

OTHER ALIQUOT CORNER

CULVERTS & DRAINS

PROPOSED

EXISTING

PROPOSED

EXISTING

BRIDGES


PROPOSED

EXISTING

WATER

DITCH

PROPOSED DITCH

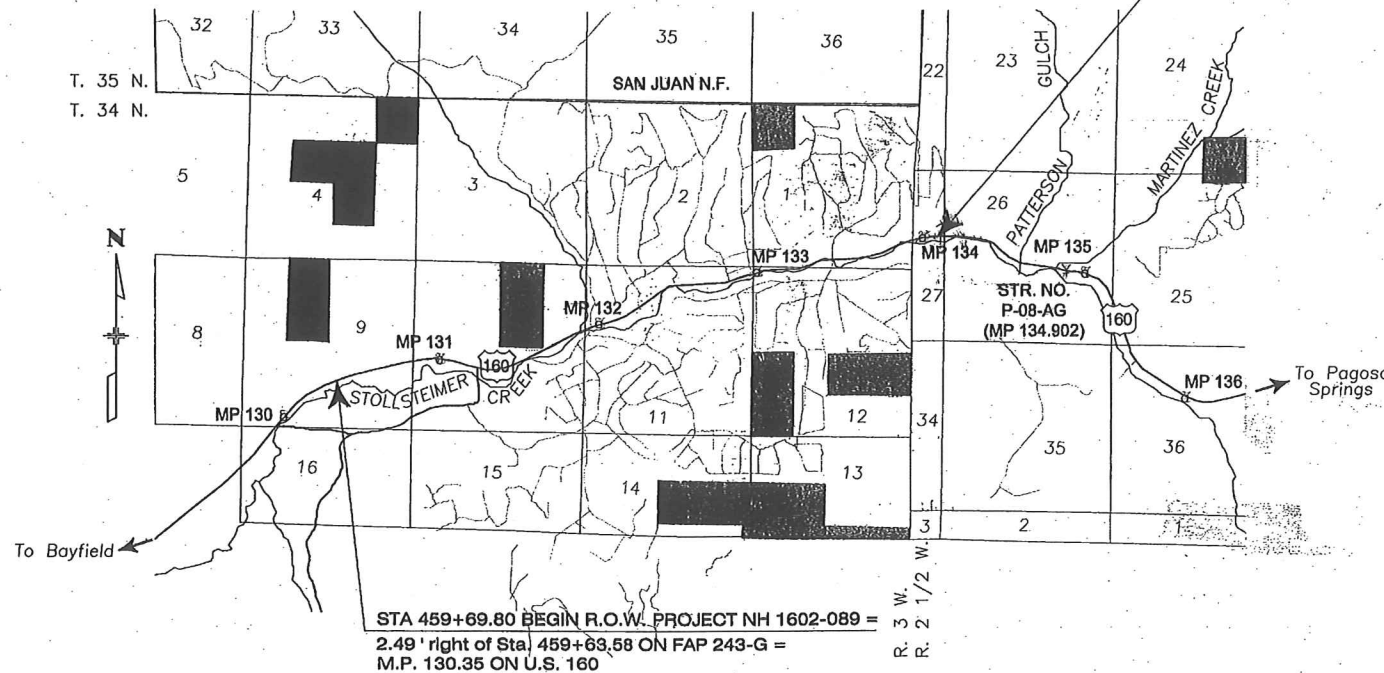

INDEX OF SHEETS

SHEET NO.

TITLE SHEET	1
Property Ownership Tabulation N/A	2 & 2A
Survey Control Diagram	3
Land Survey Control Diagram	3A
Tabulation of Boundary Evidence	3B
Right of Way Monumentation Sheet	4
Right of Way Plan. Sheets	5 - 12
Ownership Map	

SCALE OF ORIGINAL DRAWINGS

PLAN SHEETS: 1 IN. = 200 FT.
TOTAL OWNERSHIP MAP: 1 IN. = 400 FT.
CONTROL DIAGRAM SHEET: 1 IN. = 400 FT.

DEPOSITED COPY:

Final Right of Way plans filed with
ARCHULETA County
Reception Number 51181A-51181G
Book 51181A, Page 1, Date 10/23/07

DEPARTMENT OF TRANSPORTATION
FEDERAL HIGHWAY ADMINISTRATION

AUTHORIZED

DATE

DIVISION ADMINISTRATOR

FILED CERTIFICATION: DEPOSITED THIS DAY OF 19 AT M., FOR INFORMATION
ONLY IN BOOK OF THE COUNTY LAND SURVEYS/RIGHT OF WAY
SURVEYS AT PAGE RECEPTION NUMBER

SIGNED
DEPT.

date stamp

0.5 0 0.5 1 2
SCALE IN MILES

COLORADO DEPARTMENT OF TRANSPORTATION



Region 5
3803 N. Main Ave., Suite 300
Durango, CO 81301
Phone: (970) 385-1400 FAX: (970) 385-1410

Right of Way Plans Unit: Willis

Sheet Revisions

X/XX/02	mm/yy	mm/yy
XXXXXX	XXXX	XXX

Sheet Revisions

X/XX/02	mm/yy	mm/yy
XXXXXX	XXXX	XXX

Sheet Revisions

X/XX/02	mm/yy	mm/yy
XXXXXX	XXXX	XXX

Right of Way Plans

Control Diagram Sheet

Project Number: NH 1602-089

Project Location: US 160 & TURKEY SPRINGS ROAD

Project Location:

Project Code:	Last Mod. Date	Subset Sheets	Sheet No.	Total No. of Sheets
13927	10-06-03	1 of 3	3	12

PROJECT CONTROL DIAGRAM SHEET

NAME	LATITUDE	LONGITUDE	ELLIPS. HT. (meters)	STATE PLANE COORD. (meters)		PROJECT COORDINATES (feet)			MILE POST	DISTANCE FROM CENTERLINE
				NORTHING	EASTING	NORTHING	EASTING	ELEVATION		
CP 100	37° 13' 44.32666" N	107° 12' 21.04555" W	2057.722	368590.711	763026.451	28586.8375	10761.7746	6810.2488	130.65	47.7' Left
CP 101	37° 13' 47.32223" N	107° 12' 07.29899" W	2052.933	368676.863	763366.945	28869.5819	11879.2522	6794.4943	130.87	45.3' Left
CP 102	37° 13' 44.87134" N	107° 11' 47.30133" W	2061.686	368592.351	763858.451	28592.2216	13492.3376	6823.1917	131.13	22.5' Right
CP 103	37° 13' 43.99535" N	107° 11' 36.85311" W	2062.669	368560.677	764115.479	28488.2690	14335.8842	6826.3905	131.30	18.5' Right
CP 104	37° 13' 52.73699" N	107° 11' 13.40697" W	2067.222	368819.665	764698.226	29338.2482	16248.4164	6841.2265	131.70	43.6' Right
CP 105	37° 13' 59.42559" N	107° 10' 54.22628" W	2068.992	369017.305	765174.673	29986.8866	17812.0775	6846.9253	132.01	41.9' Right
CP 106	37° 14' 04.58892" N	107° 10' 41.44041" W	2071.835	369170.788	765492.650	30490.6071	18855.6546	6856.2035	132.25	26.9' Right
CP 107	37° 14' 12.36295" N	107° 10' 25.47953" W	2075.820	369403.352	765890.305	31253.8631	20160.7283	6869.1825	132.55	49.5' Left
CP 108	37° 14' 12.14767" N	107° 10' 12.21974" W	2082.645	369390.866	766216.969	31212.8876	21232.8145	6891.5381	132.75	21.1' Right
CP 109	37° 14' 17.03487" N	107° 09' 54.24752" W	2088.437	369533.599	766662.574	31681.3247	22695.2559	6910.4816	133.02	44.6' Left
CP 110	37° 14' 17.61265" N	107° 09' 39.13781" W	2095.971	369544.778	767035.258	31718.0142	23918.3766	6935.1469	133.28	9.0' Right
CP 111	37° 14' 19.99067" N	107° 09' 27.86388" W	2094.764	369613.141	767314.396	31942.3762	24834.4863	6931.1410	133.46	50.0' Right
CP 112	37° 14' 21.03210" N	107° 09' 14.66492" W	2103.973	369639.475	767640.240	32028.8014	25903.8806	6961.3312	133.67	16.8' Right
CP 113	37° 14' 28.09616" N	107° 08' 52.39840" W	2111.359	369847.514	768192.816	32711.5720	27717.3937	6985.4847	134.06	38.3' Left
CP 114	37° 14' 28.35420" N	107° 08' 35.03870" W	2122.553	369847.931	768620.756	32712.9404	29121.8615	7022.1940	134.30	71.4' Left

BASIS OF BEARING

Bearings are based on the "State Plane" grid bearing from CDOT Control Point 103 to CDOT Control Point 104 being N 66° 02' 18" E.
Both monuments are standard CDOT 3 1/4" aluminum caps on 3/4" aluminum finned rods.

MONUMENTS


Project control monuments are standard CDOT 3 1/4" aluminum caps on 3/4" aluminum finned rods (except CP 111 which is "U 160 MP 133.5", U 160 MP 120.8" and "U 160 MP 133.5" is a standard CDOH Right of Way disk set in a concrete post. "9 CAH 1952 6624" is a standard U.S. Geological Survey bench mark disk set in a concrete post. "W 162" is a standard U.S. Coast and Geodetic Survey bench mark disk set in a concrete post.

VERTICAL CONTROL

Vertical control was established by differential leveling from "W 162", a National Geodetic Survey Second Order, Class 0 benchmark. The published orthometric height of W 162 is 2073.062 m (6801.37 ft).

COORDINATE INFORMATION

Geodetic coordinates (NAD 83 - 1992) were derived from GPS observations tied to First Order CHARN stations "U 160 MP 120.8", "U 160 133.5", and "9 CAH 1952 6624". State Plane Coordinates are Colorado South Zone (NAD 83 - 1992). Project coordinates are modified State Plane Coordinates in U.S. Survey Feet. To convert project coordinates to State Plane Coordinates, convert to meters by multiplying by 0.3048006096, add 360,000 to the northings and 760,000 to the eastings, then multiply by the combined scale factor of 0.9996675602.

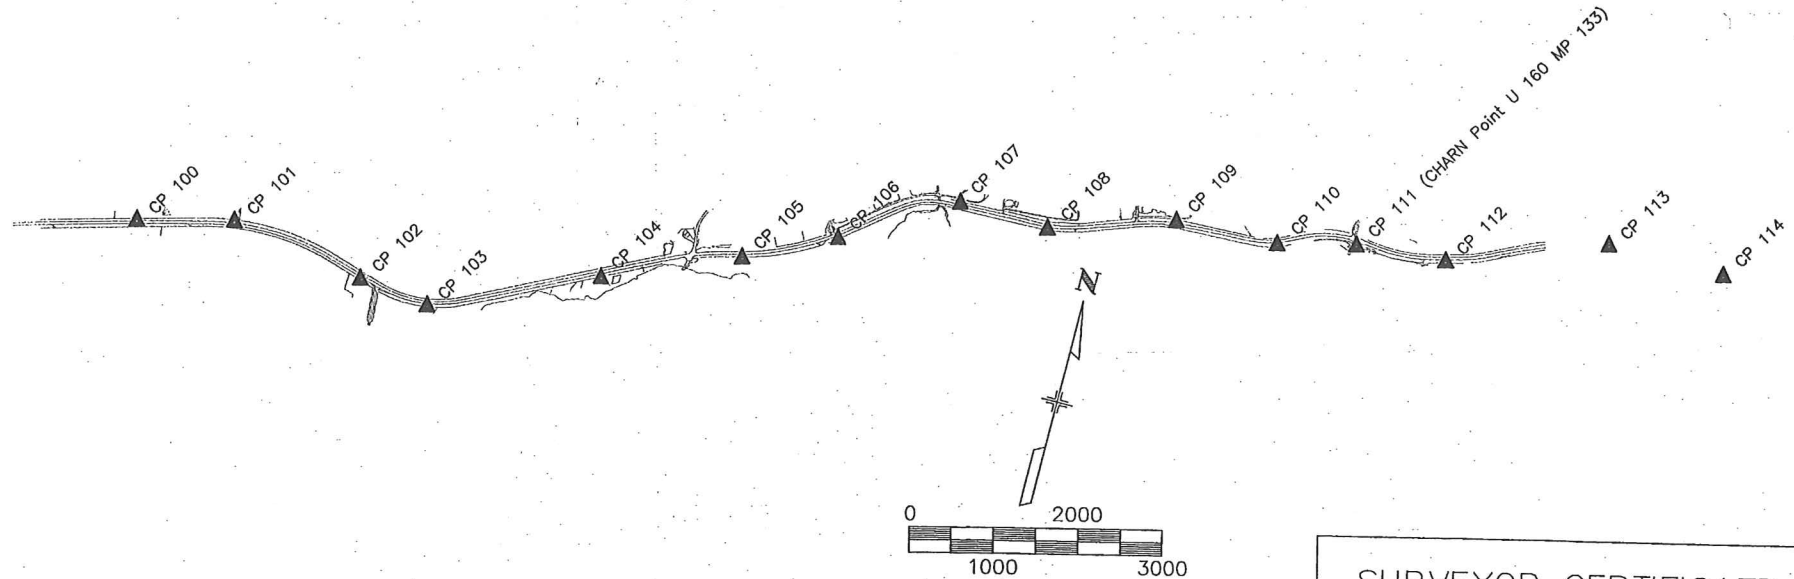

GENERAL NOTES

- This control survey is for the use of the Colorado Department of Transportation. The survey is not a complete boundary survey.
- No guarantee as to the accuracy of the information contained on the plat is either stated or implied unless this copy bears an original signature and stamp of the professional surveyor named hereon.
- NOTICE: According to Colorado law you must commence any legal action based upon any defect in this survey within three years after you first discover such defect. In no event may any action based upon any defect in this survey be commenced more than ten years from the date of the certification shown hereon.
- All coordinates listed are PROJECT COORDINATES only. Coordinates are carried out to 4 decimal places for calculation purposes and do not represent survey precision. Survey precision exceeds C.D.O.T. "B" order precision.

SURVEYOR CERTIFICATE

CONTROL SURVEY, CONTROL MONUMENTATION, ALIQUOT CORNER TIES, AND PROPERTY MONUMENT TIES WERE DONE UNDER MY SUPERVISION AND CHECKING.



JOHN M. WILLIS

P.L.S. NO. 29772

FLING CERTIFICATION: DEPOSITED THIS DAY OF 19 AT M. FOR INFORMATION ONLY IN BOOK OF THE COUNTY LAND SURVEYS/RIGHT OF WAY SURVEYS AT PAGE RECEPTION NUMBER

SIGNED DEPT.

date stamp

51181B

51181B

COLORADO DEPARTMENT OF TRANSPORTATION



Region 5
3803 N. Main Ave., Suite 300
Durango, CO 81301
Phone: (970) 385-1400 FAX: (970) 385-1410

Right of Way Plans Unit: Willis



Sheet Revisions	
X/XX/02	XXXXXXXXXXXXXXXXXXXXXXXXXXXX

Sheet Revisions	
mm/yy	XXXX

Sheet Revisions	
mm/yy	XXXX

Right of Way Plans					
Land Survey Control Diagram Sheet					
Project Number: NH 1602-089					
Project Location: US 160 & TURKEY SPRINGS ROAD					
Project Location:					
Project Code:	Last Mod. Date	Subset Sheets	Sheet No.	Total No. of Sheets	
13927	XX-XX-XX	2 of 3	3A	12	

LAND SURVEY CONTROL DIAGRAM SHEET

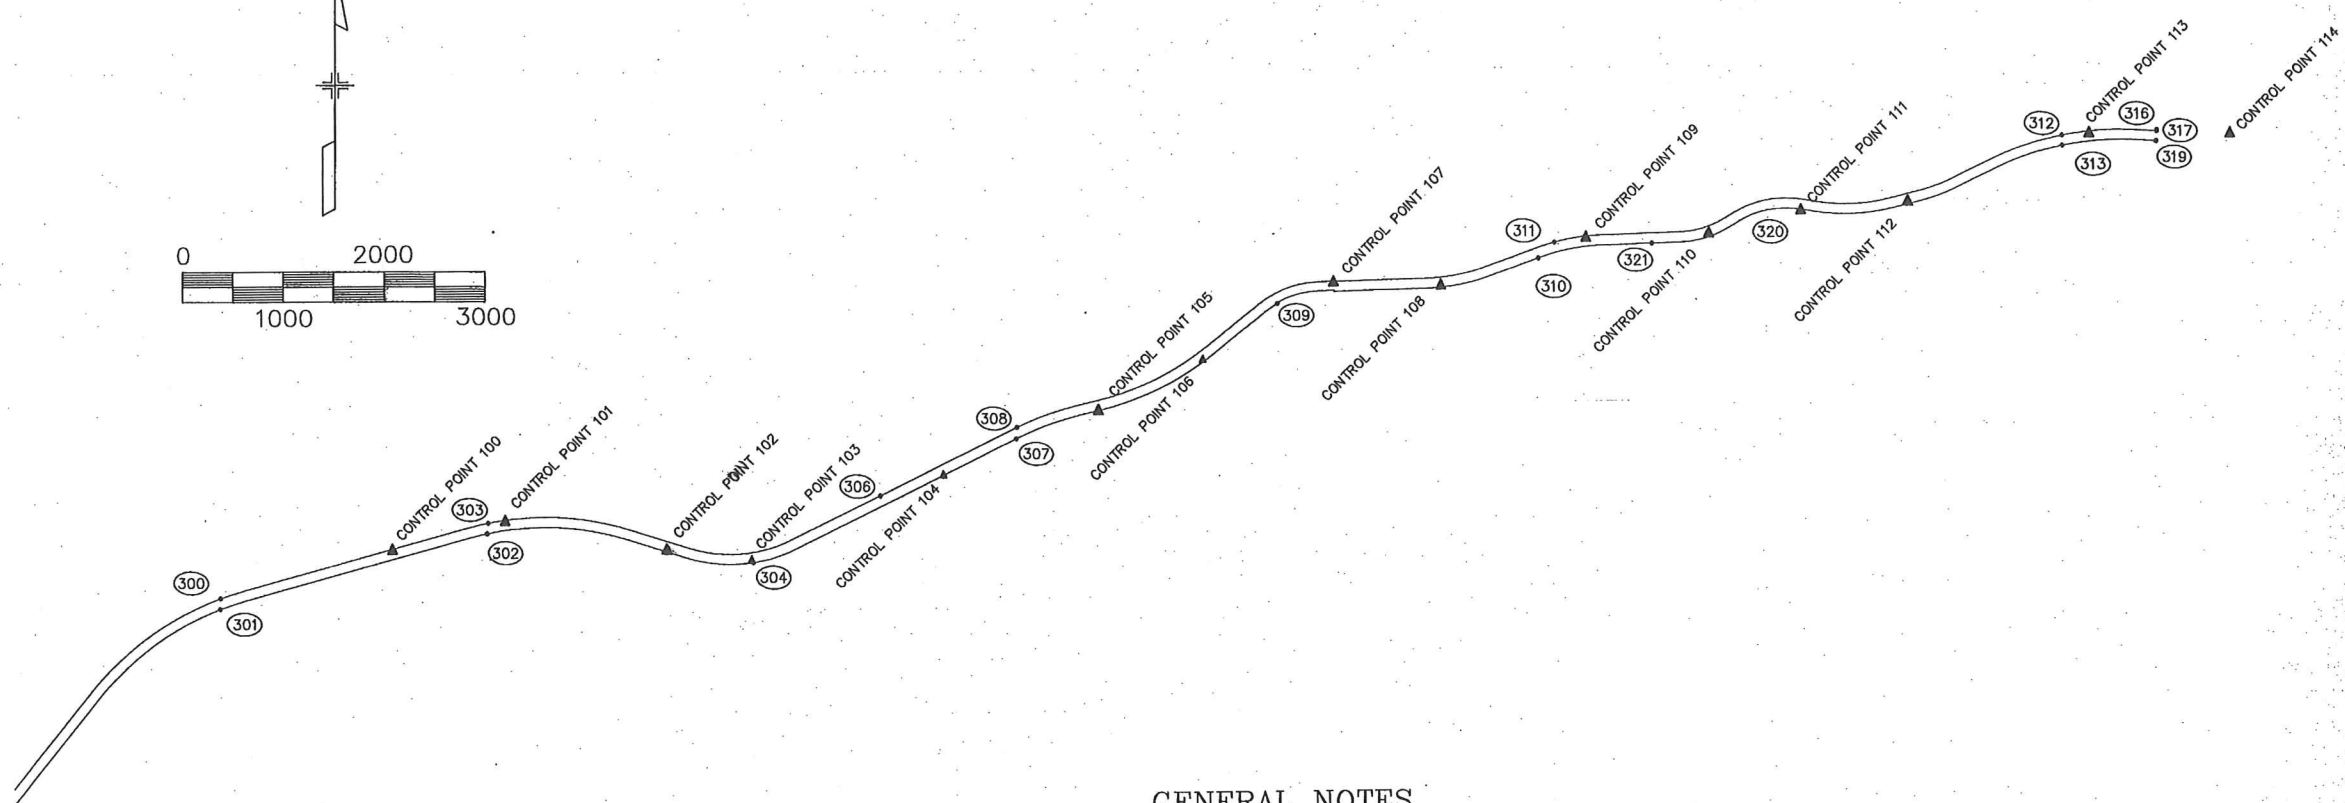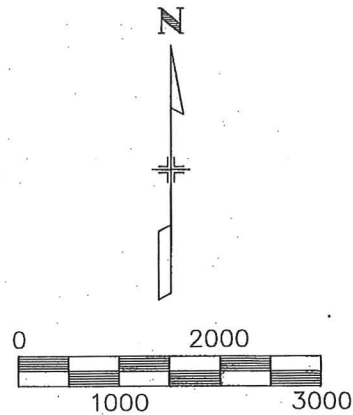

GENERAL NOTES

1. This control survey is for the use of the Colorado Department of Transportation. The survey is not a complete boundary survey.
2. No guarantee as to the accuracy of the information contained on the plat is either stated or implied unless this copy bears an original signature and stamp of the professional surveyor named hereon.
3. This sheet shows all found "control corners" and "control monuments" as defined in C.R.S. 38-51-102 (6), and C.R.S. 38-51-106 (1) (f). Only those corners that control the location of the Right of Way lines of U.S. Highway 160 as established on Federal Aid Project 243-G are shown. All other corners that may control the location of the boundaries of parcels to be acquired on this project are not shown.
3. NOTICE: According to Colorado law you must commence any legal action based upon any defect in this survey within three years after you first discover such defect. In no event may any action based upon any defect in this survey be commenced more than ten years from the date of the certification shown hereon.
4. All coordinates listed are PROJECT COORDINATES only. Coordinates are carried out to 3 decimal places for calculation purposes and do not represent survey precision. Survey precision exceeds C.D.O.T. "B" order precision.

BASIS OF BEARING

Bearings are based on the "State Plane" grid bearing from CDOT Control Point 103 to CDOT Control Point 104 being N 66° 02' 18" E. Both monuments are standard CDOT 3 1/4" aluminum caps on 3/4" aluminum finned rods.

SURVEYOR CERTIFICATE

CONTROL SURVEY, CONTROL MONUMENTATION, ALIQUOT CORNER TIES, AND PROPERTY MONUMENT TIES WERE DONE UNDER MY SUPERVISION AND CHECKING.



JOHN M. WILLIS

P.L.S. NO. 29772

S1181C

S1181C



Region 5
3803 N. Main Ave., Suite 300
Durango, CO 81301
Phone: (970) 385-1400 FAX: (970) 385-1410

Right of Way Plans Unit: Willis

Sheet Revisions		
04/26/02	Added point 513	jmw

Sheet Revisions		
	XXXXX	XXX

Sheet Revisions		
	XXXXX	XXX

Right of Way Plans					
Tabulation of Boundary Evidence					
Project Number:		NH 1602-089			
Project Location:		US 160 Turkey Springs Road			
Project Location:		US 160			
Project Code:	Last Mod. Date	Subset Sheets	Sheet No.	Total No. of Sheets	
13927		3 of 3	3B	12	

TABULATION OF BOUNDARY EVIDENCE

FOUND BOUNDARY EVIDENCE (CONTROL CORNERS)

Point	Northing	Easting	Description
300	28105.475	9061.834	Conc. Mkr. w/3" Brass Cap (Typical)
301	27997.905	9059.018	
302	28741.093	11699.016	
303	28845.144	11709.478	
304	28459.694	14355.631	
306	29127.028	15616.927	
307	29695.160	16976.343	
308	29810.506	16983.021	
309	31039.362	19604.746	
310	31472.050	22218.699	
311	31628.329	22378.854	
312	32680.888	27447.609	
313	32578.905	27449.554	
316	32737.382	28388.878	
317	32727.461	28388.513	
319	32627.954	28381.624	
320	31942.376	24834.486	
321	31613.901	23350.982	

GENERAL NOTES

1. This R. O. W. plan and survey is for the use of the Colorado Department of Transportation. The survey is not a complete boundary survey of all adjoining owners.

2. This R. O. W. plan does not represent a title search. Title commitments were provided by C.D.O.T. personnel.
3. NOTE: According to Colorado law you must commence any legal action based upon any defect in this survey within three years after you first discover such defect. In no event may any action based upon any defect in this survey be commenced more than ten years from the date of certification shown hereon.

4. All coordinates listed are PROJECT COORDINATES only. Coordinates are carried out to 3 decimal places for calculation purposes and do not represent survey precision. Survey precision exceeds C.D.O.T. "B" order precision.

S1181D

S1181D



Region 5
3803 N. Main Ave., Suite 300
Durango, CO 81301
Phone: (970) 385-1400 FAX: (970) 385-1410

Right of Way Plans Unit: Willis

Sheet Revisions

Sheet Revisions

Sheet Revisions

Right of Way Plans

Right of Way Monumentation Sheet

Project Number: NH 1602-089

Project Location: US 160 Turkey Springs Rd.

Project Location: US 160

Project Code	Last Mod. Date	Subset Sheets	Sheet No.	Total No. of Sheets
13927	XX-XX-XX		4	12

RIGHT OF WAY MONUMENTATION SHEET

TABULATION OF R. O. W. MARKERS TO BE SET

Point	Northing	Easting	Description (CDOT/Type 1)
330	28083.310	9317.589	
331	28179.645	9290.765	
332	28699.834	11531.766	
333	28796.169	11504.942	
334	28680.850	13106.971	
335	28776.511	13136.109	
336	28504.578	13685.679	
337	28600.239	13714.817	
338	28596.902	14780.857	
339	28686.335	14736.116	
340	29708.988	17003.794	
341	29798.421	16959.053	
342	29927.356	17600.657	
343	30024.546	17577.120	
344	29980.239	17819.031	
345	30077.430	17795.494	
346	30534.027	18950.024	
347	30612.218	18887.685	
348	30953.895	19476.665	
349	31032.086	19414.326	
351	31250.970	20017.183	
352	31062.180	19605.052	
354	31170.992	20019.062	
356	31174.485	20167.756	
358	31154.491	20168.225	
360	31176.443	21102.640	
361	31276.415	21100.291	
362	31292.909	21723.650	
363	31386.939	21689.615	
364	31485.275	22255.105	
365	31579.305	22221.070	
366	31595.142	22822.174	
367	31695.079	22818.629	
368	31624.053	23637.160	
369	31723.990	23633.615	
370	31765.142	24116.076	
371	31851.039	24064.874	
372	31827.328	24220.401	
373	31913.226	24169.200	
374	31944.145	24823.141	
375	32042.951	24838.545	
376	31919.704	24979.906	
377	32018.511	24995.311	
378	31957.819	25761.302	
379	32054.657	25736.354	
380	32042.362	26089.470	
381	32139.200	26064.523	
382	32145.017	26369.008	
383	32234.985	26325.354	
384	32358.680	26809.355	
385	32448.648	26765.701	
386	32637.685	28175.625	
387	32737.566	28180.510	
388	28361.319	10316.028	
389	28457.654	10289.204	
390	29141.447	15869.342	
391	29230.879	15824.601	

GENERAL NOTES

- This R. O. W. plan and survey is for the use of the Colorado Department of Transportation. The survey is not a complete boundary survey of all adjoining owners.
- This R. O. W. plan does not represent a title search. Title commitments were provided by C.D.O.T. personnel.
- NOTE: According to Colorado law you must commence any legal action based upon any defect in this survey within three years after you first discover such defect. In no event may any action based upon any defect in this survey be commenced more than ten years from the date of certification shown hereon.
- All coordinates listed are PROJECT COORDINATES only. Coordinates are carried out to 3 decimal places for calculation purposes and do not represent survey precision. Survey precision exceeds C.D.O.T. "B" order precision.

QUANTITY OF MONUMENT TO BE SET

CAP TYPE	MONUMENT TYPE									
	1	1A	2	2A	3	3A	4	4A	5	6
REFERENCE										
RIGHT OF WAY	57									
CONTROL										
ALIQUOT CORNER										
PERMANENT EASEMENT										
REFERENCE										
WITNESS POST										

SURVEYOR CERTIFICATE

RIGHT OF WAY PLANS AND LEGAL DESCRIPTIONS WERE
WERE PREPARED UNDER MY SUPERVISION AND CHECKING.



JOHN M. WILLIS

P.L.S. NO. 29772

COLORADO DEPARTMENT OF TRANSPORTATION



Region 5
Address: 3803 N. Main Ave., Suite 300
Durango, CO 81301
Phone: (970) 385-1400 FAX: (970) 385-1410

Right of Way Plans Unit: Willis

Sheet Revisions

Rev	Date	Description

Sheet Revisions

Rev	Date	Description

Sheet Revisions


Rev	Date	Description

Right of Way Plans

Plan Sheet				
Project Number: NH 1602-089				
Project Location: US 160 Turkey Springs Rd.				
Project Location: U. S. 160				
Project Code	Last Mod. Date	Subst. Sheets	Sheet No.	Total No. of Sheets
13927		1 of 6	5	12

T. 34 N., R. 3 W., N.M.P.M.

NE 1/4 SECTION 9

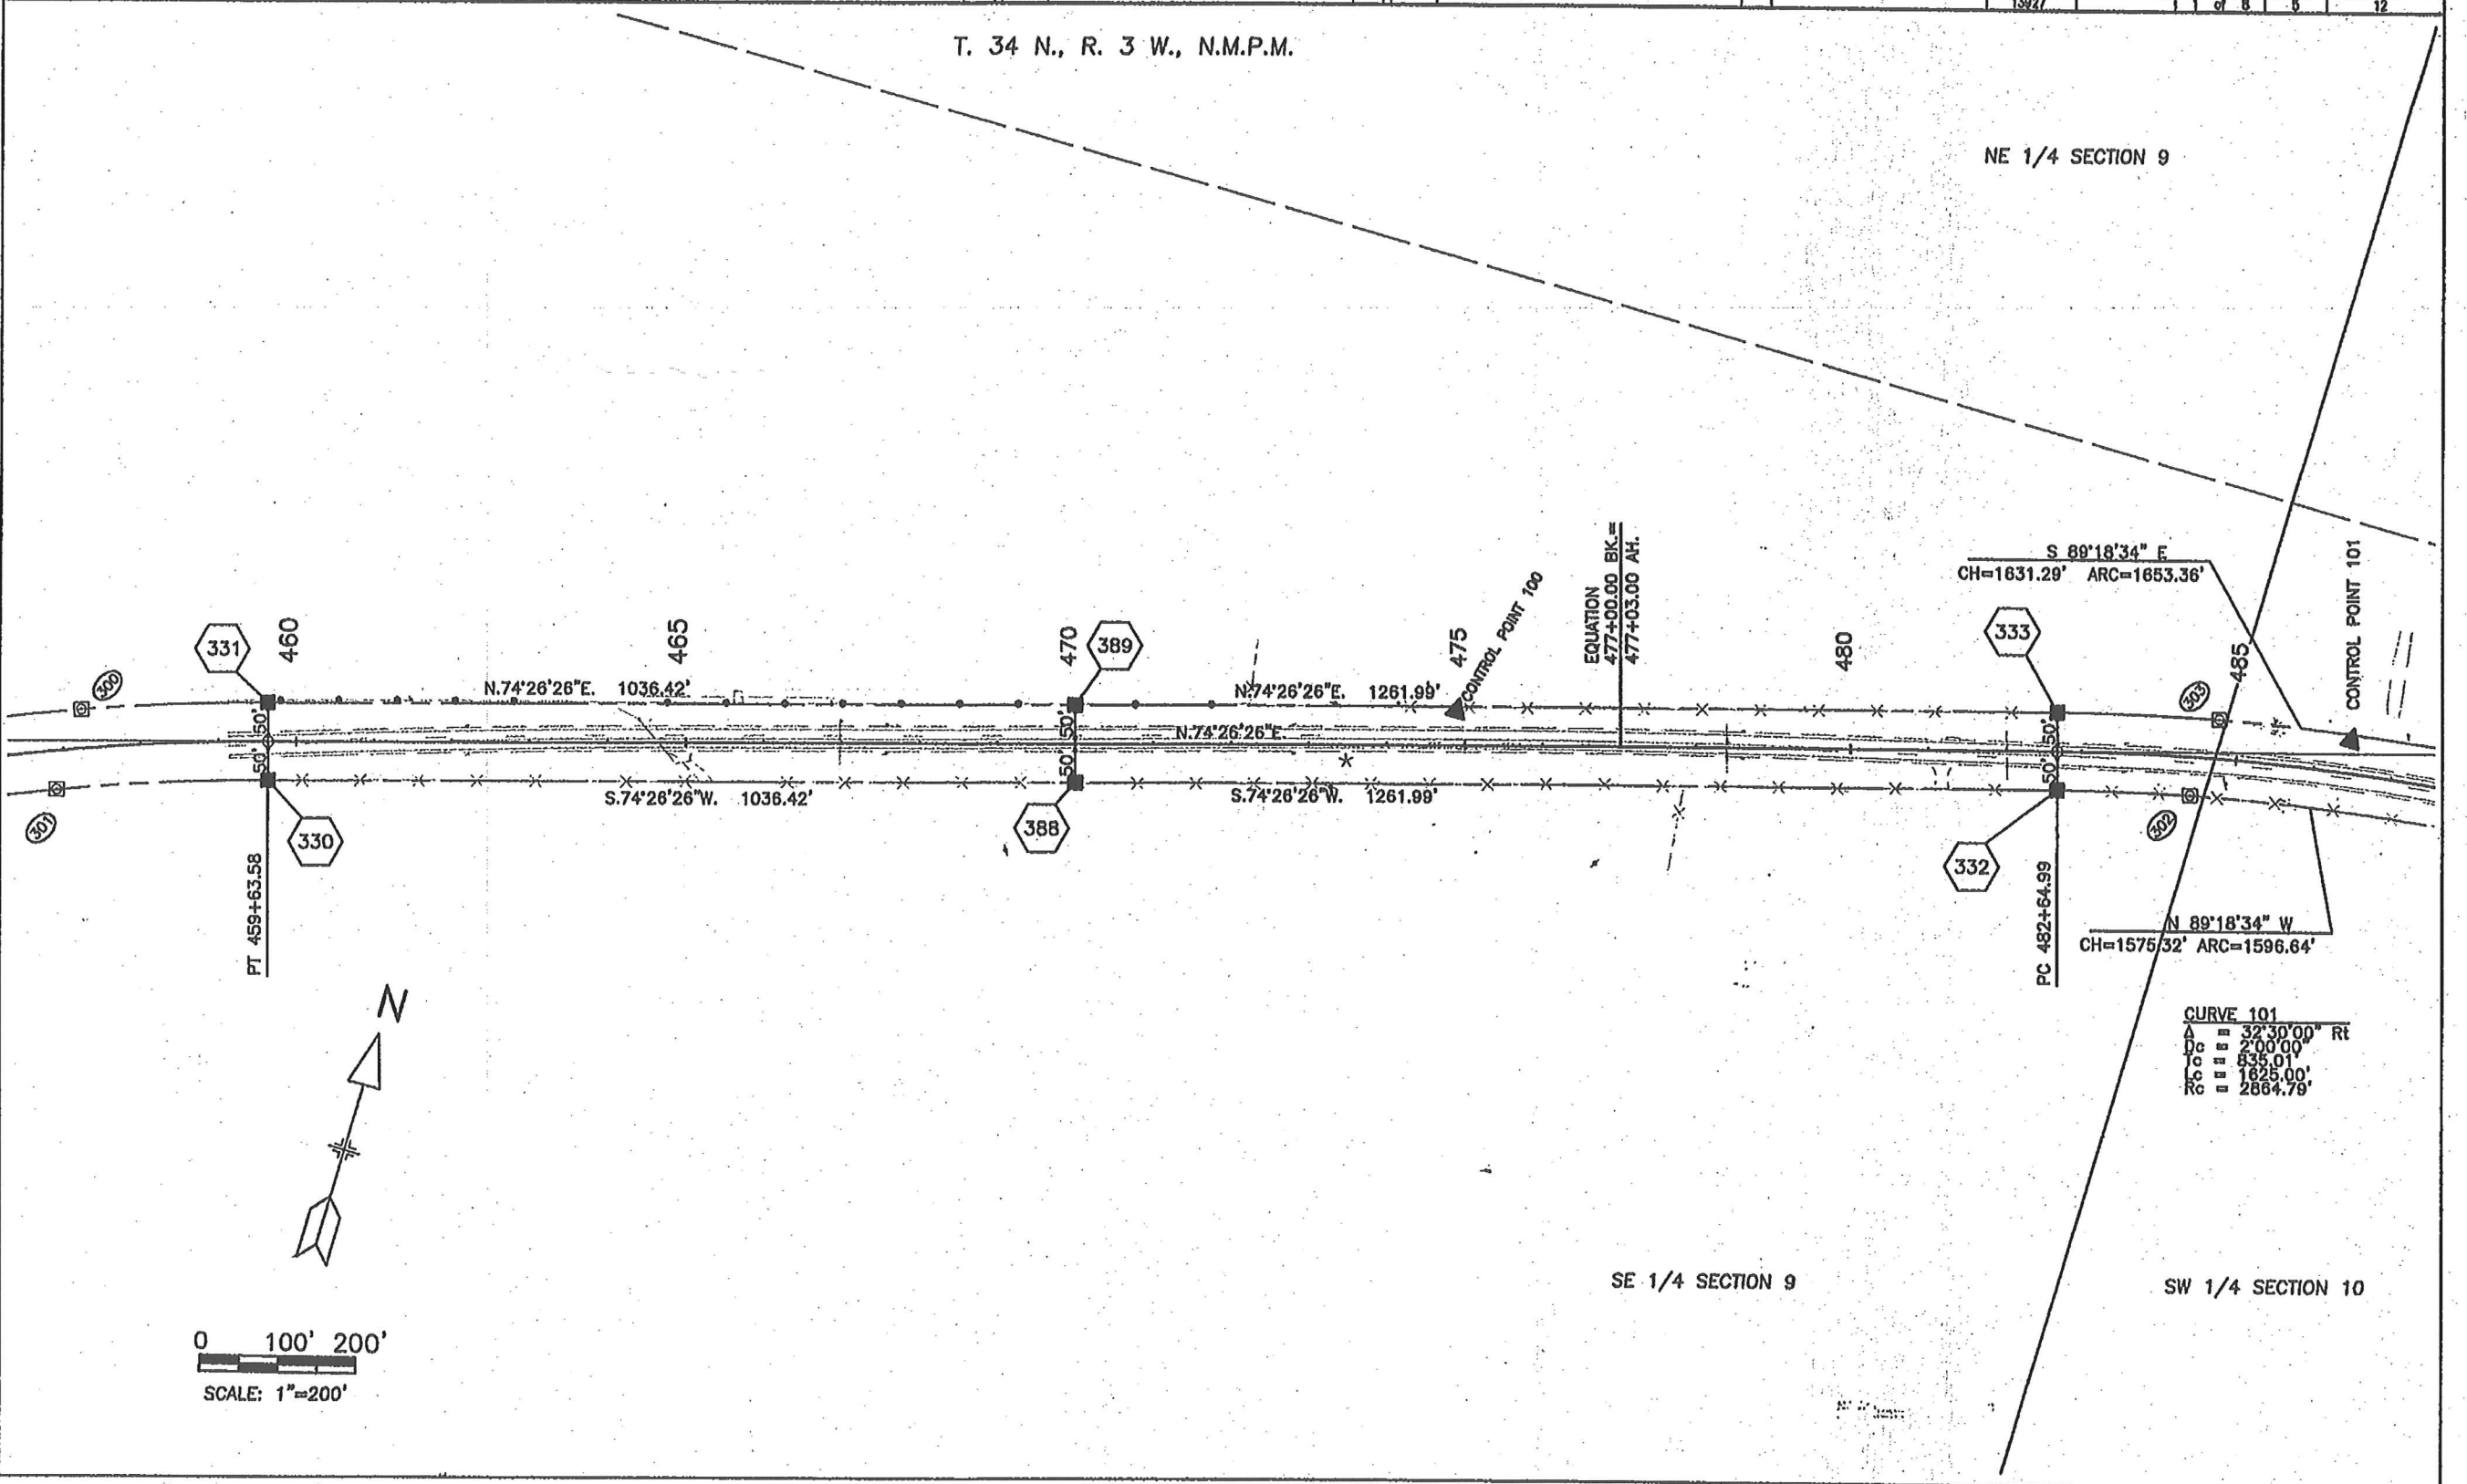

CURVE 101
Δ = 32°30'00" Rt
Dc = 200.00'
Lc = 835.01'
Lc = 1825.00'
Rc = 2864.79'

SE 1/4 SECTION 9

SW 1/4 SECTION 10

0 100' 200'
SCALE: 1"=200'

COLORADO DEPARTMENT OF TRANSPORTATION


Region 5
Address: 3803 N. Main Ave., Suite 300
Durango, CO 81301
Phone: (970) 385-1400 FAX: (970) 385-1410
Right of Way Plans Unit: Willis

Sheet Revisions		Sheet Revisions		Sheet Revisions		Right of Way Plans			
mm/yy	XXXX	mm/yy	XXXX	mm/yy	XXXX	Plan Sheet			
						Project Number: NH 1602-089			
						Project Location: US 160 Turkey Springs Rd.			
						Project Location: U. S. 160			
						Project Code: 13927	Last Mod. Date:	Sheet No. 2 of 8	Total No. of Sheets 12

T. 34 N., R. 3 W., N.M.P.M.

NW 1/4 SECTION 10

NE 1/4 SECTION 10

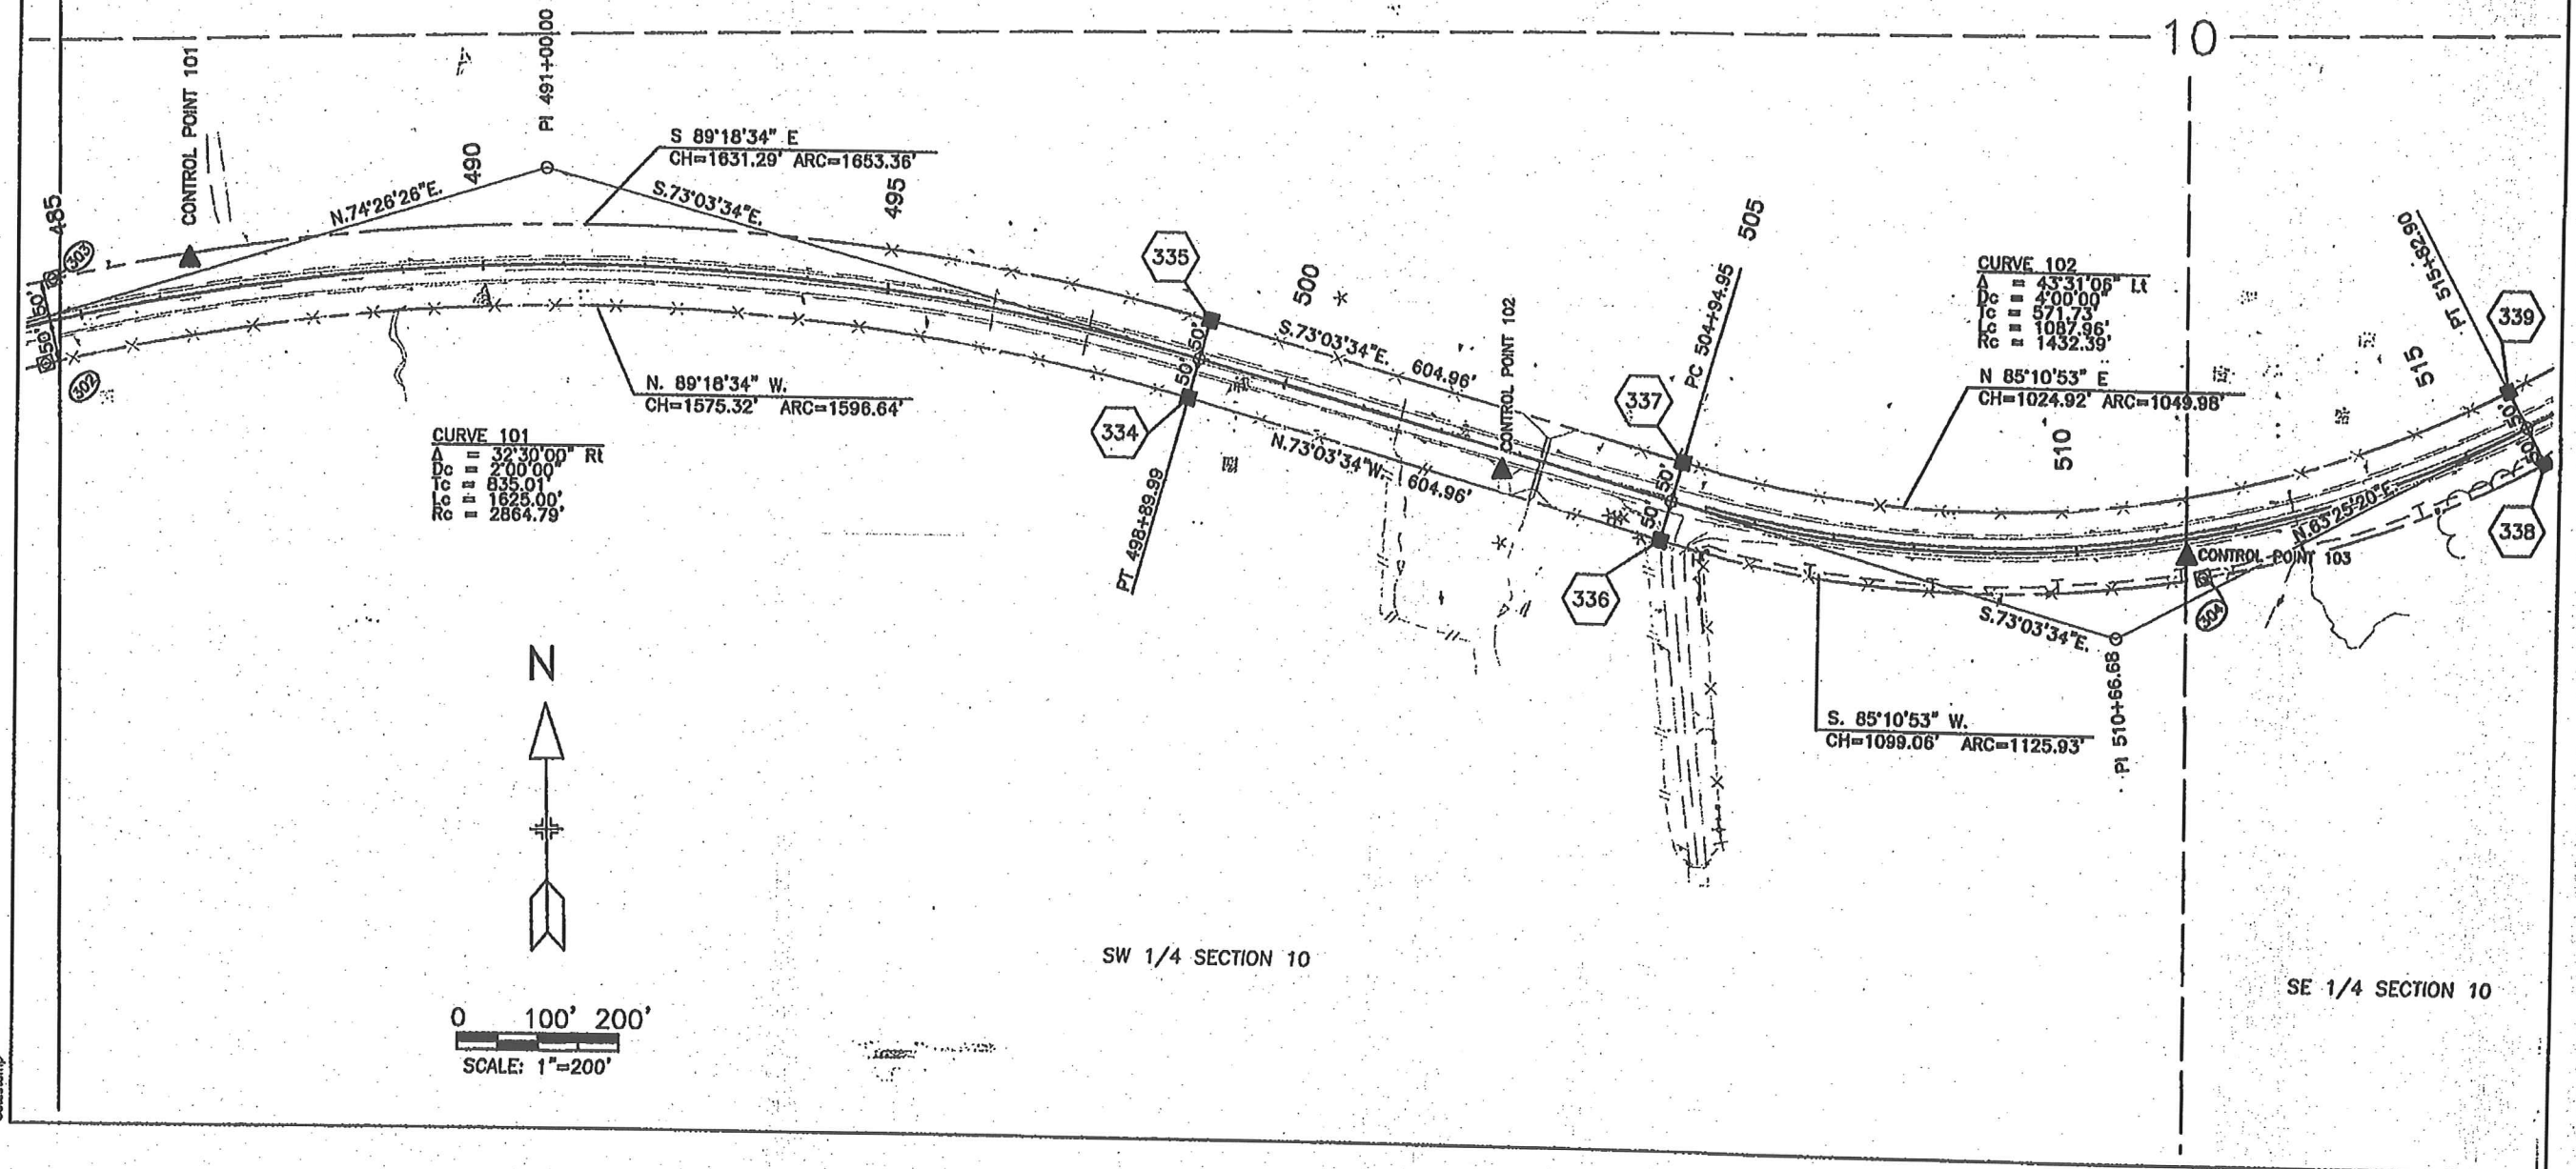

COLORADO DEPARTMENT OF TRANSPORTATION



Region 5
Address: 3803 N. Main Ave., Suite 300
Durango, CO 81301
Phone: (970) 385-1400 FAX: (970) 385-1410

Right of Way Plans Unit: Willis

Sheet Revisions

Rev	Date	Description

Sheet Revisions

Rev	Date	Description

Sheet Revisions

Rev	Date	Description

Right of Way Plans

Plan Sheet				
Project Number: NH 1602-089				
Project Location: US 160 Turkey Springs Rd.				
Project Location: U. S. 160				
Project Code: 13827	Last Mod. Date:	Sheet No. 3 of 6	Sheet No. 7	Total No. of Sheets 12



T. 34 N., R. 3 W., N.M.P.M.

NE 1/4 SECTION 10

SE 1/4 SECTION 10

NW 1/4 SECTION 11

0 100' 200'
SCALE: 1"=200'

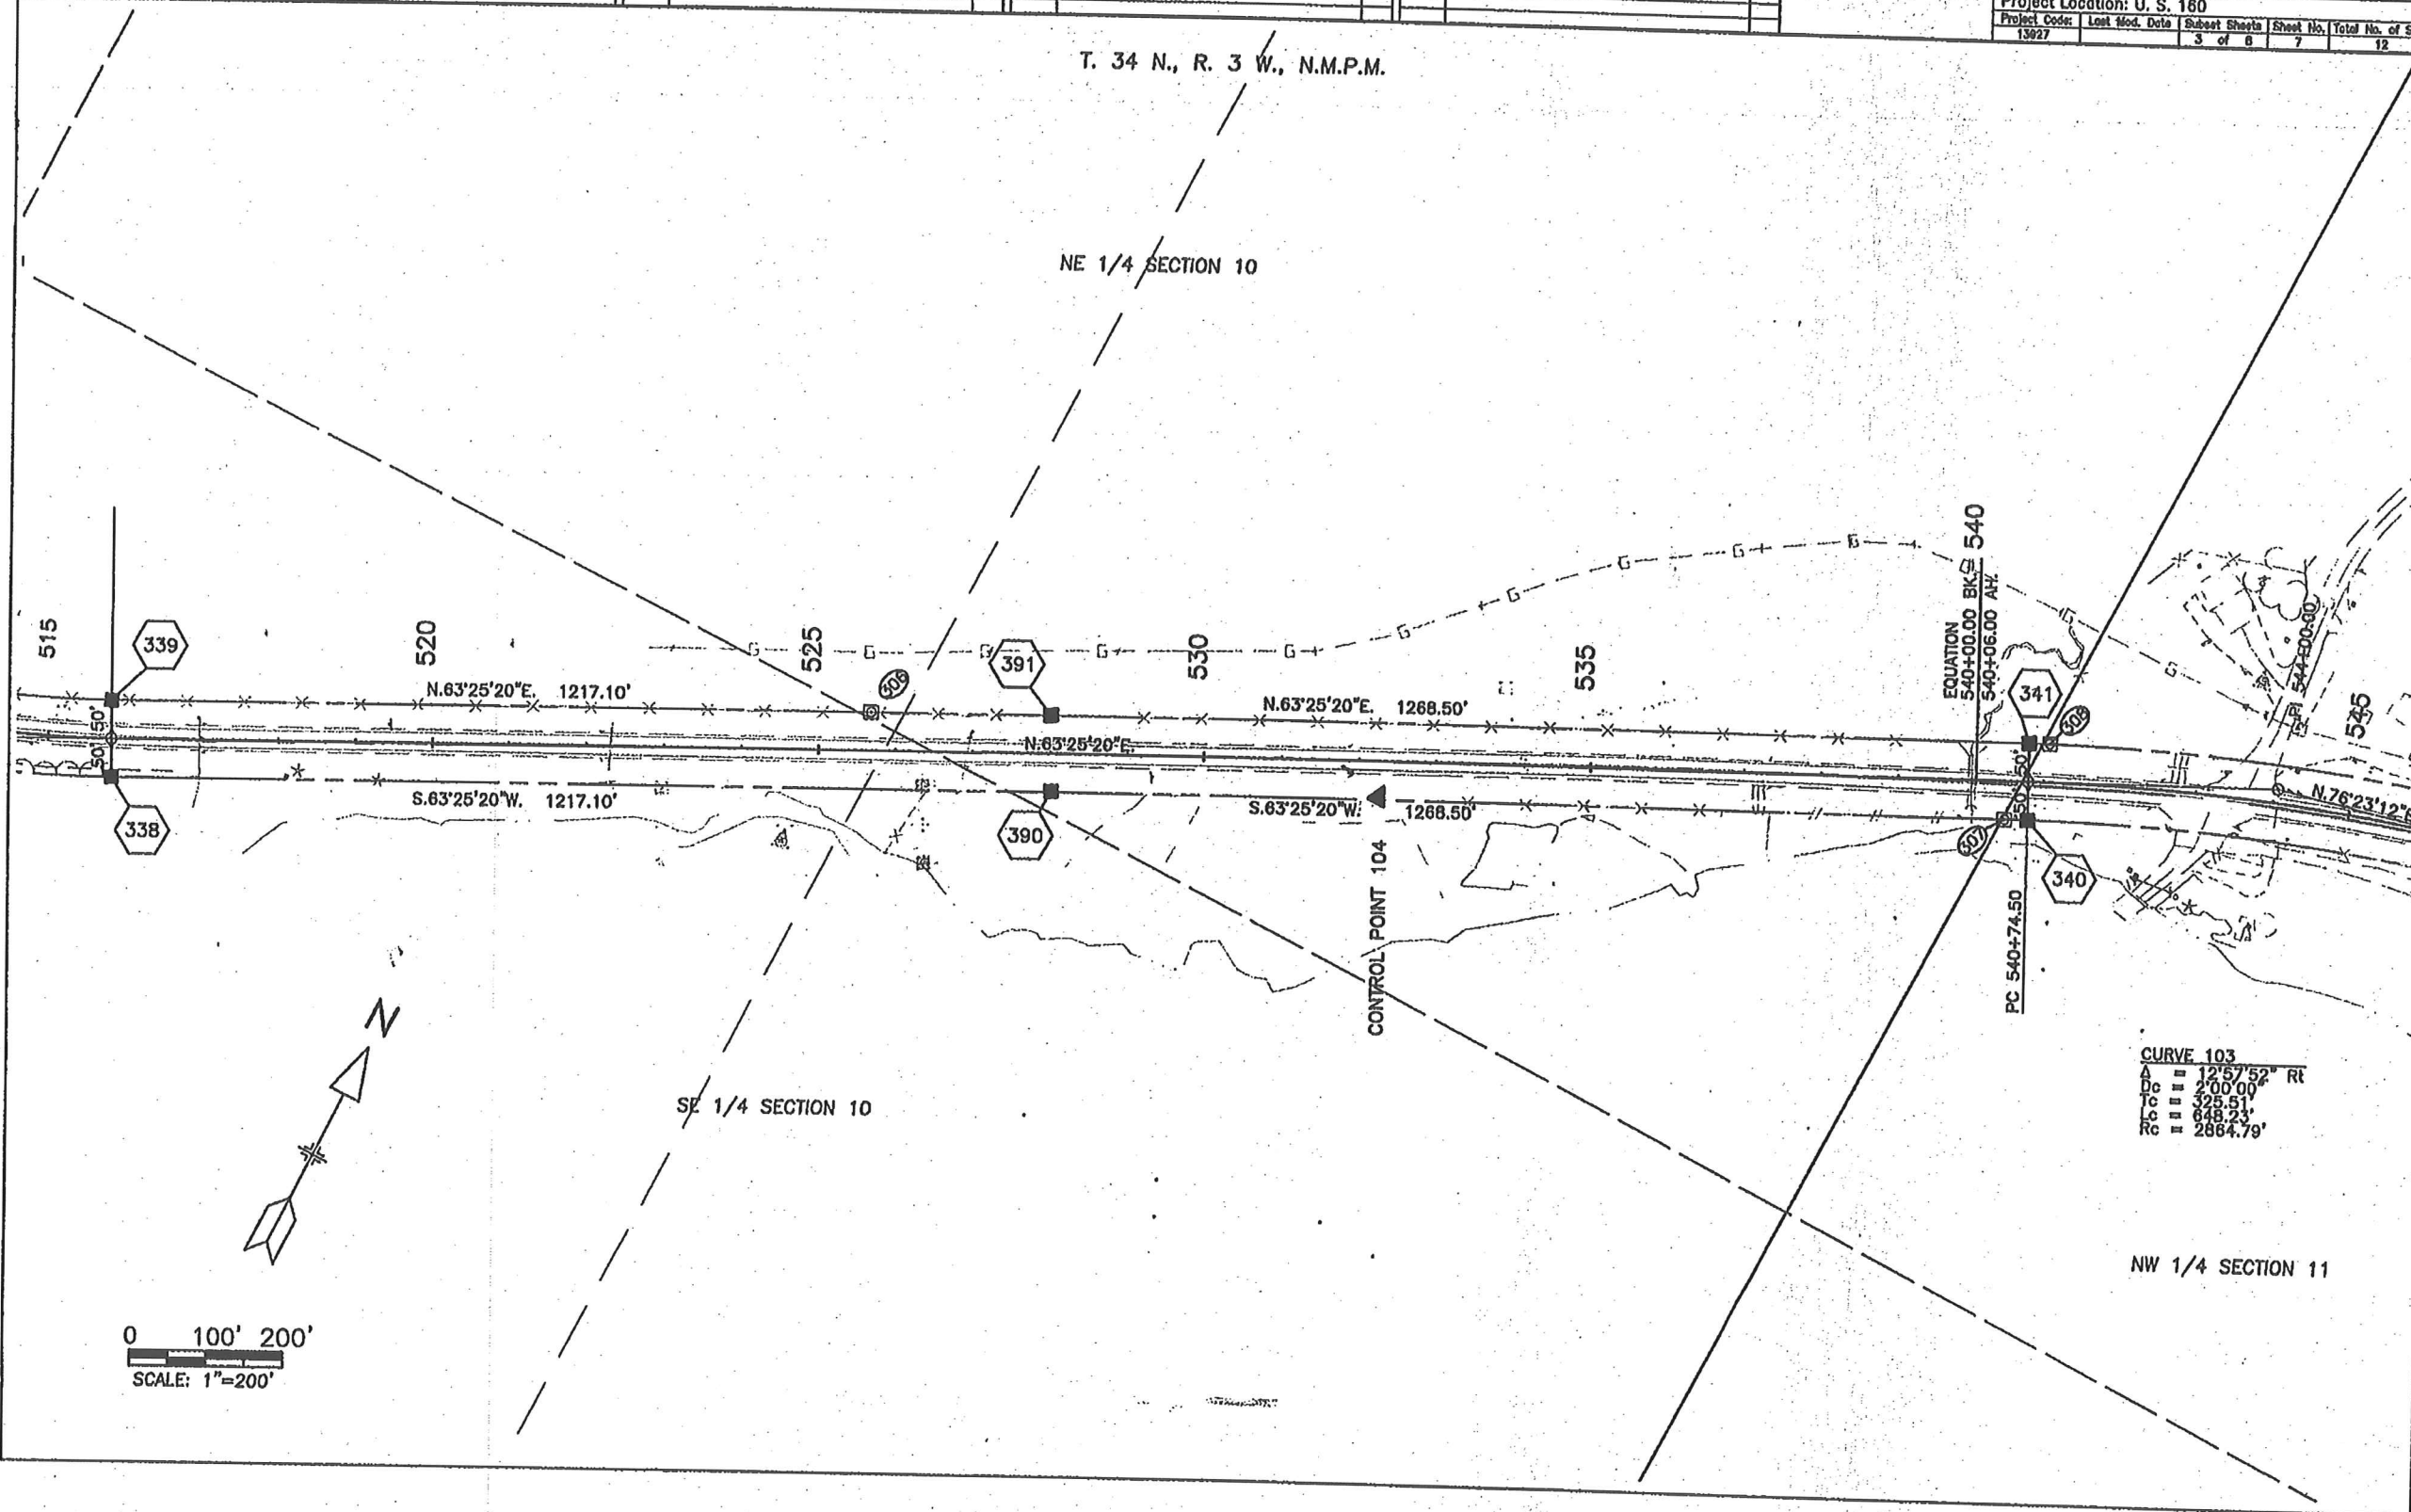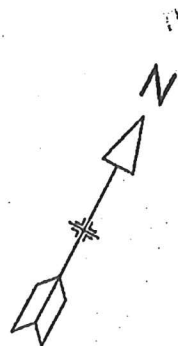

5181f

COLORADO DEPARTMENT OF TRANSPORTATION



Region 5
Address: 3803 N. Main Ave., Suite 300
Durango, CO 81301
Phone: (970) 385-1400 FAX: (970) 385-1410

Right of Way Plans Unit: Willis

Sheet Revisions

Sheet Revisions

Sheet Revisions

Right of Way Plans


Plan Sheet

Project Number: NH 1602-089
Project Location: US 160 Turkey Springs Rd.
Project Location: U. S. 160


Project Code	Last Mod. Date	Sheet No.	Total No. of Sheets
13027		4 of 8	132

T. 34 N., R. 3 W., N.M.P.M.

NE 1/4 SECTION 10

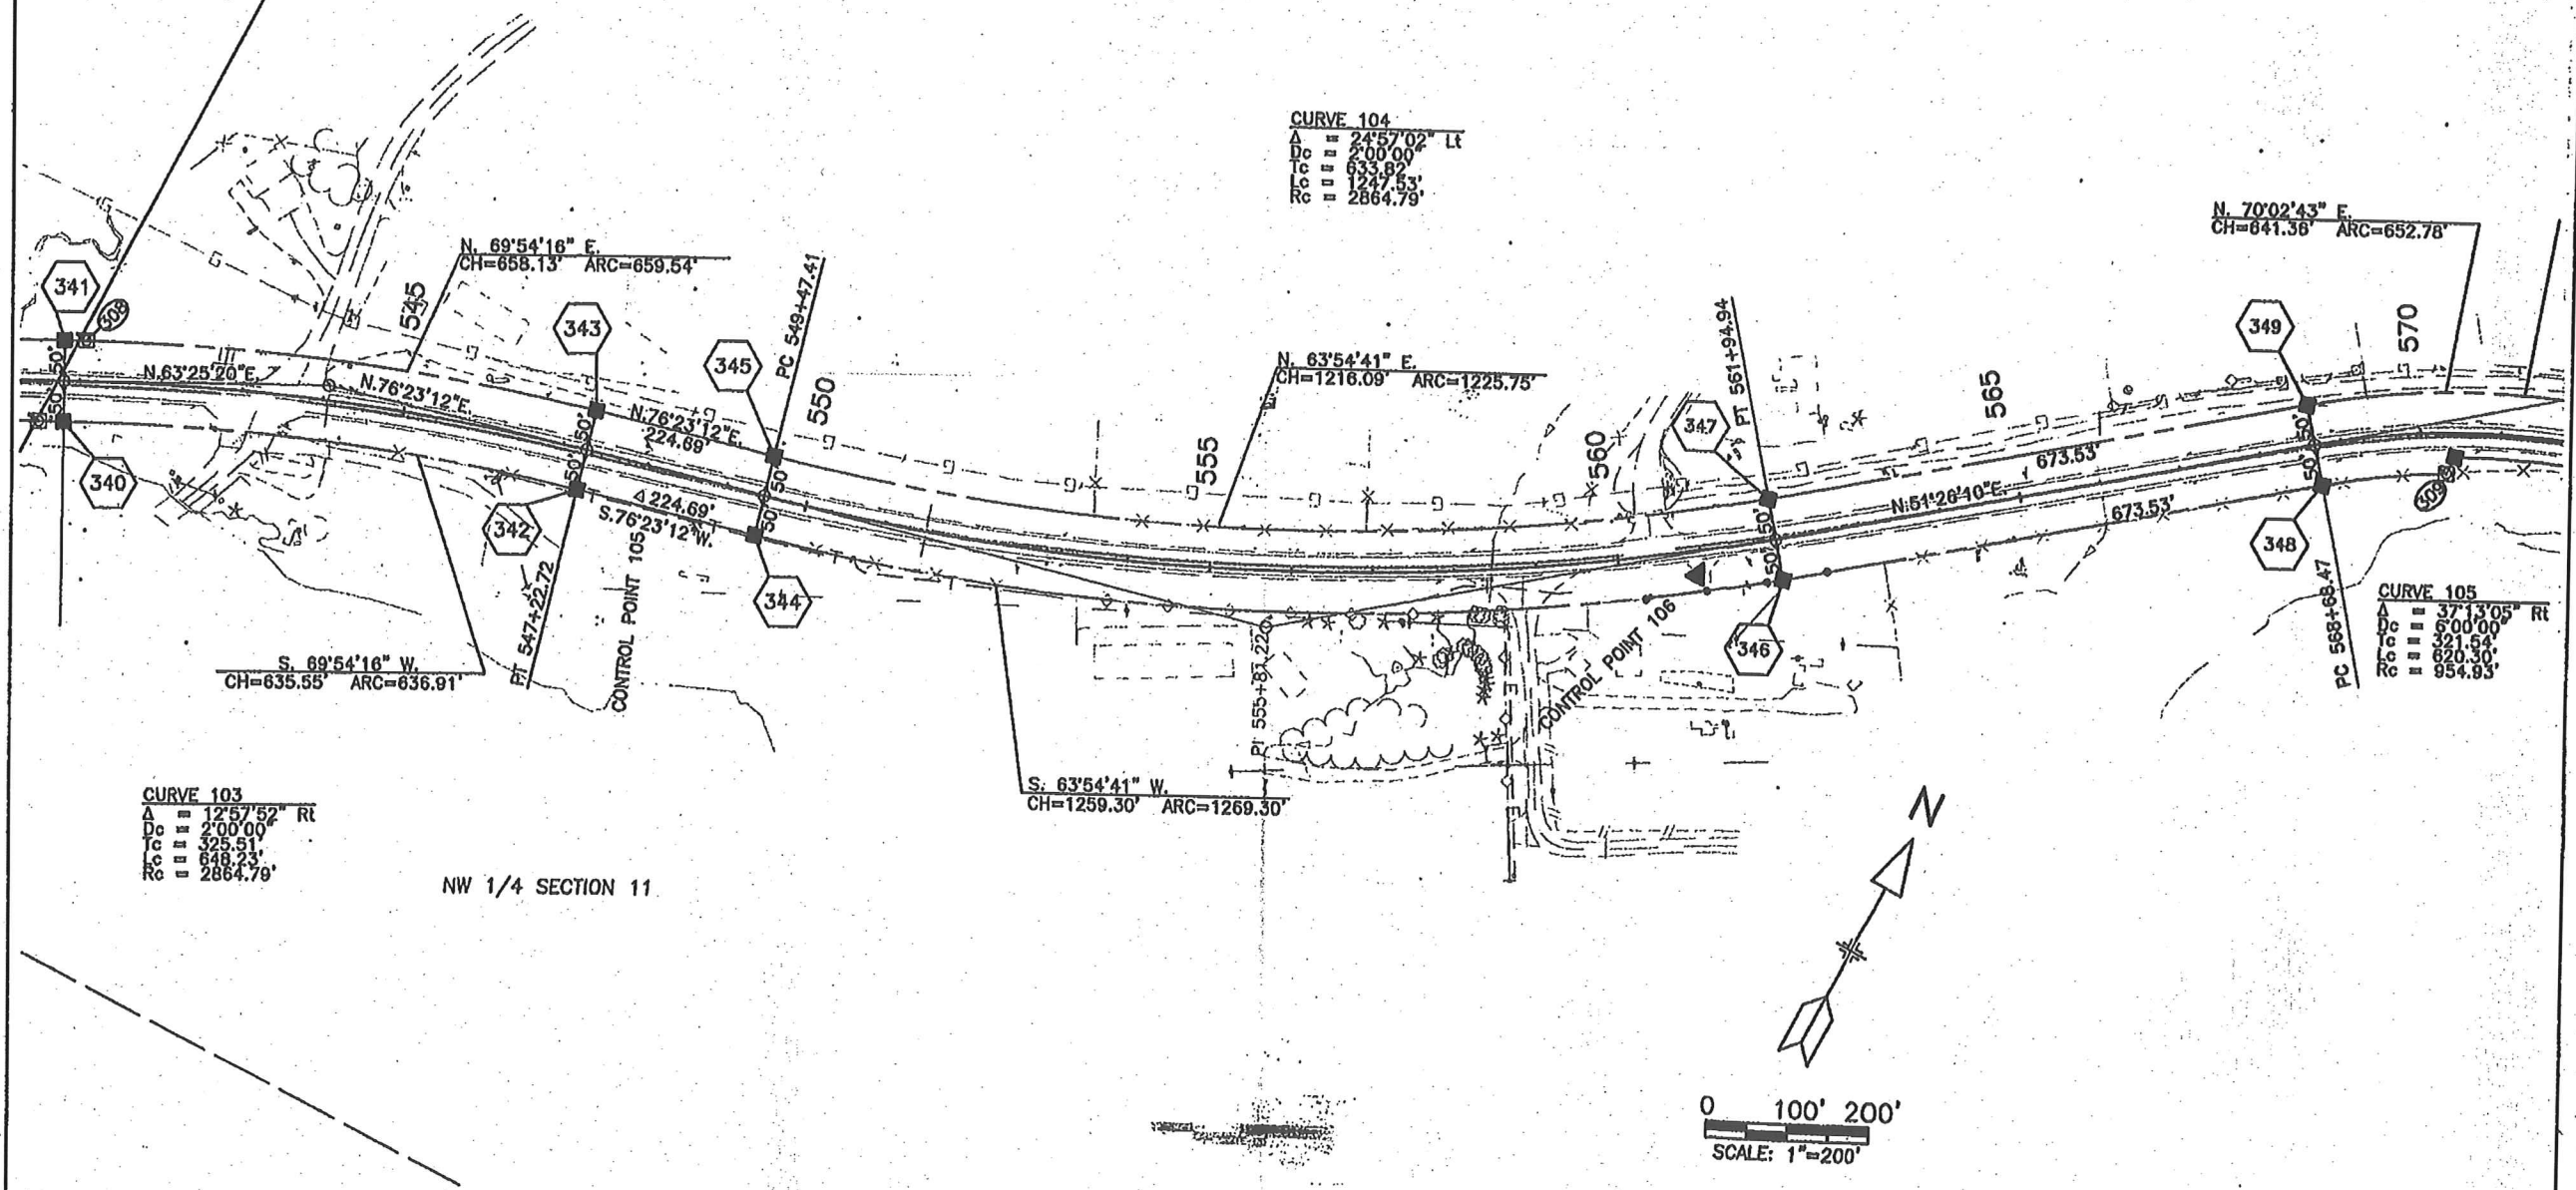

NW 1/4 SECTION 11

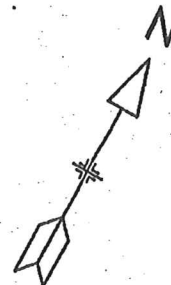

0 100' 200'
SCALE: 1"=200'

51181F


COLORADO DEPARTMENT OF TRANSPORTATION

DOT Region 5
Address: 3803 N. Main Ave., Suite 300
Durango, CO 81301
Phone: (970) 385-1400 FAX: (970) 385-1410
Right of Way Plans Unit: Willis

Sheet Revisions		Sheet Revisions		Sheet Revisions	
mm/yy	xxxx	mm/yy	xxxx	mm/yy	xxxx

Right of Way Plans				
Plan Sheet				
Project Number: NH 1602-089				
Project Location: US 160 Turkey Springs Rd.				
Project Location: U. S. 160				
Project Code: 13927	Last Mod. Date: 5 of 8	Subst. Sheets: 8	Sheet No.: 9	Total No. of Sheets: 12

T. 34 N., R. 3 W., N.M.P.M.

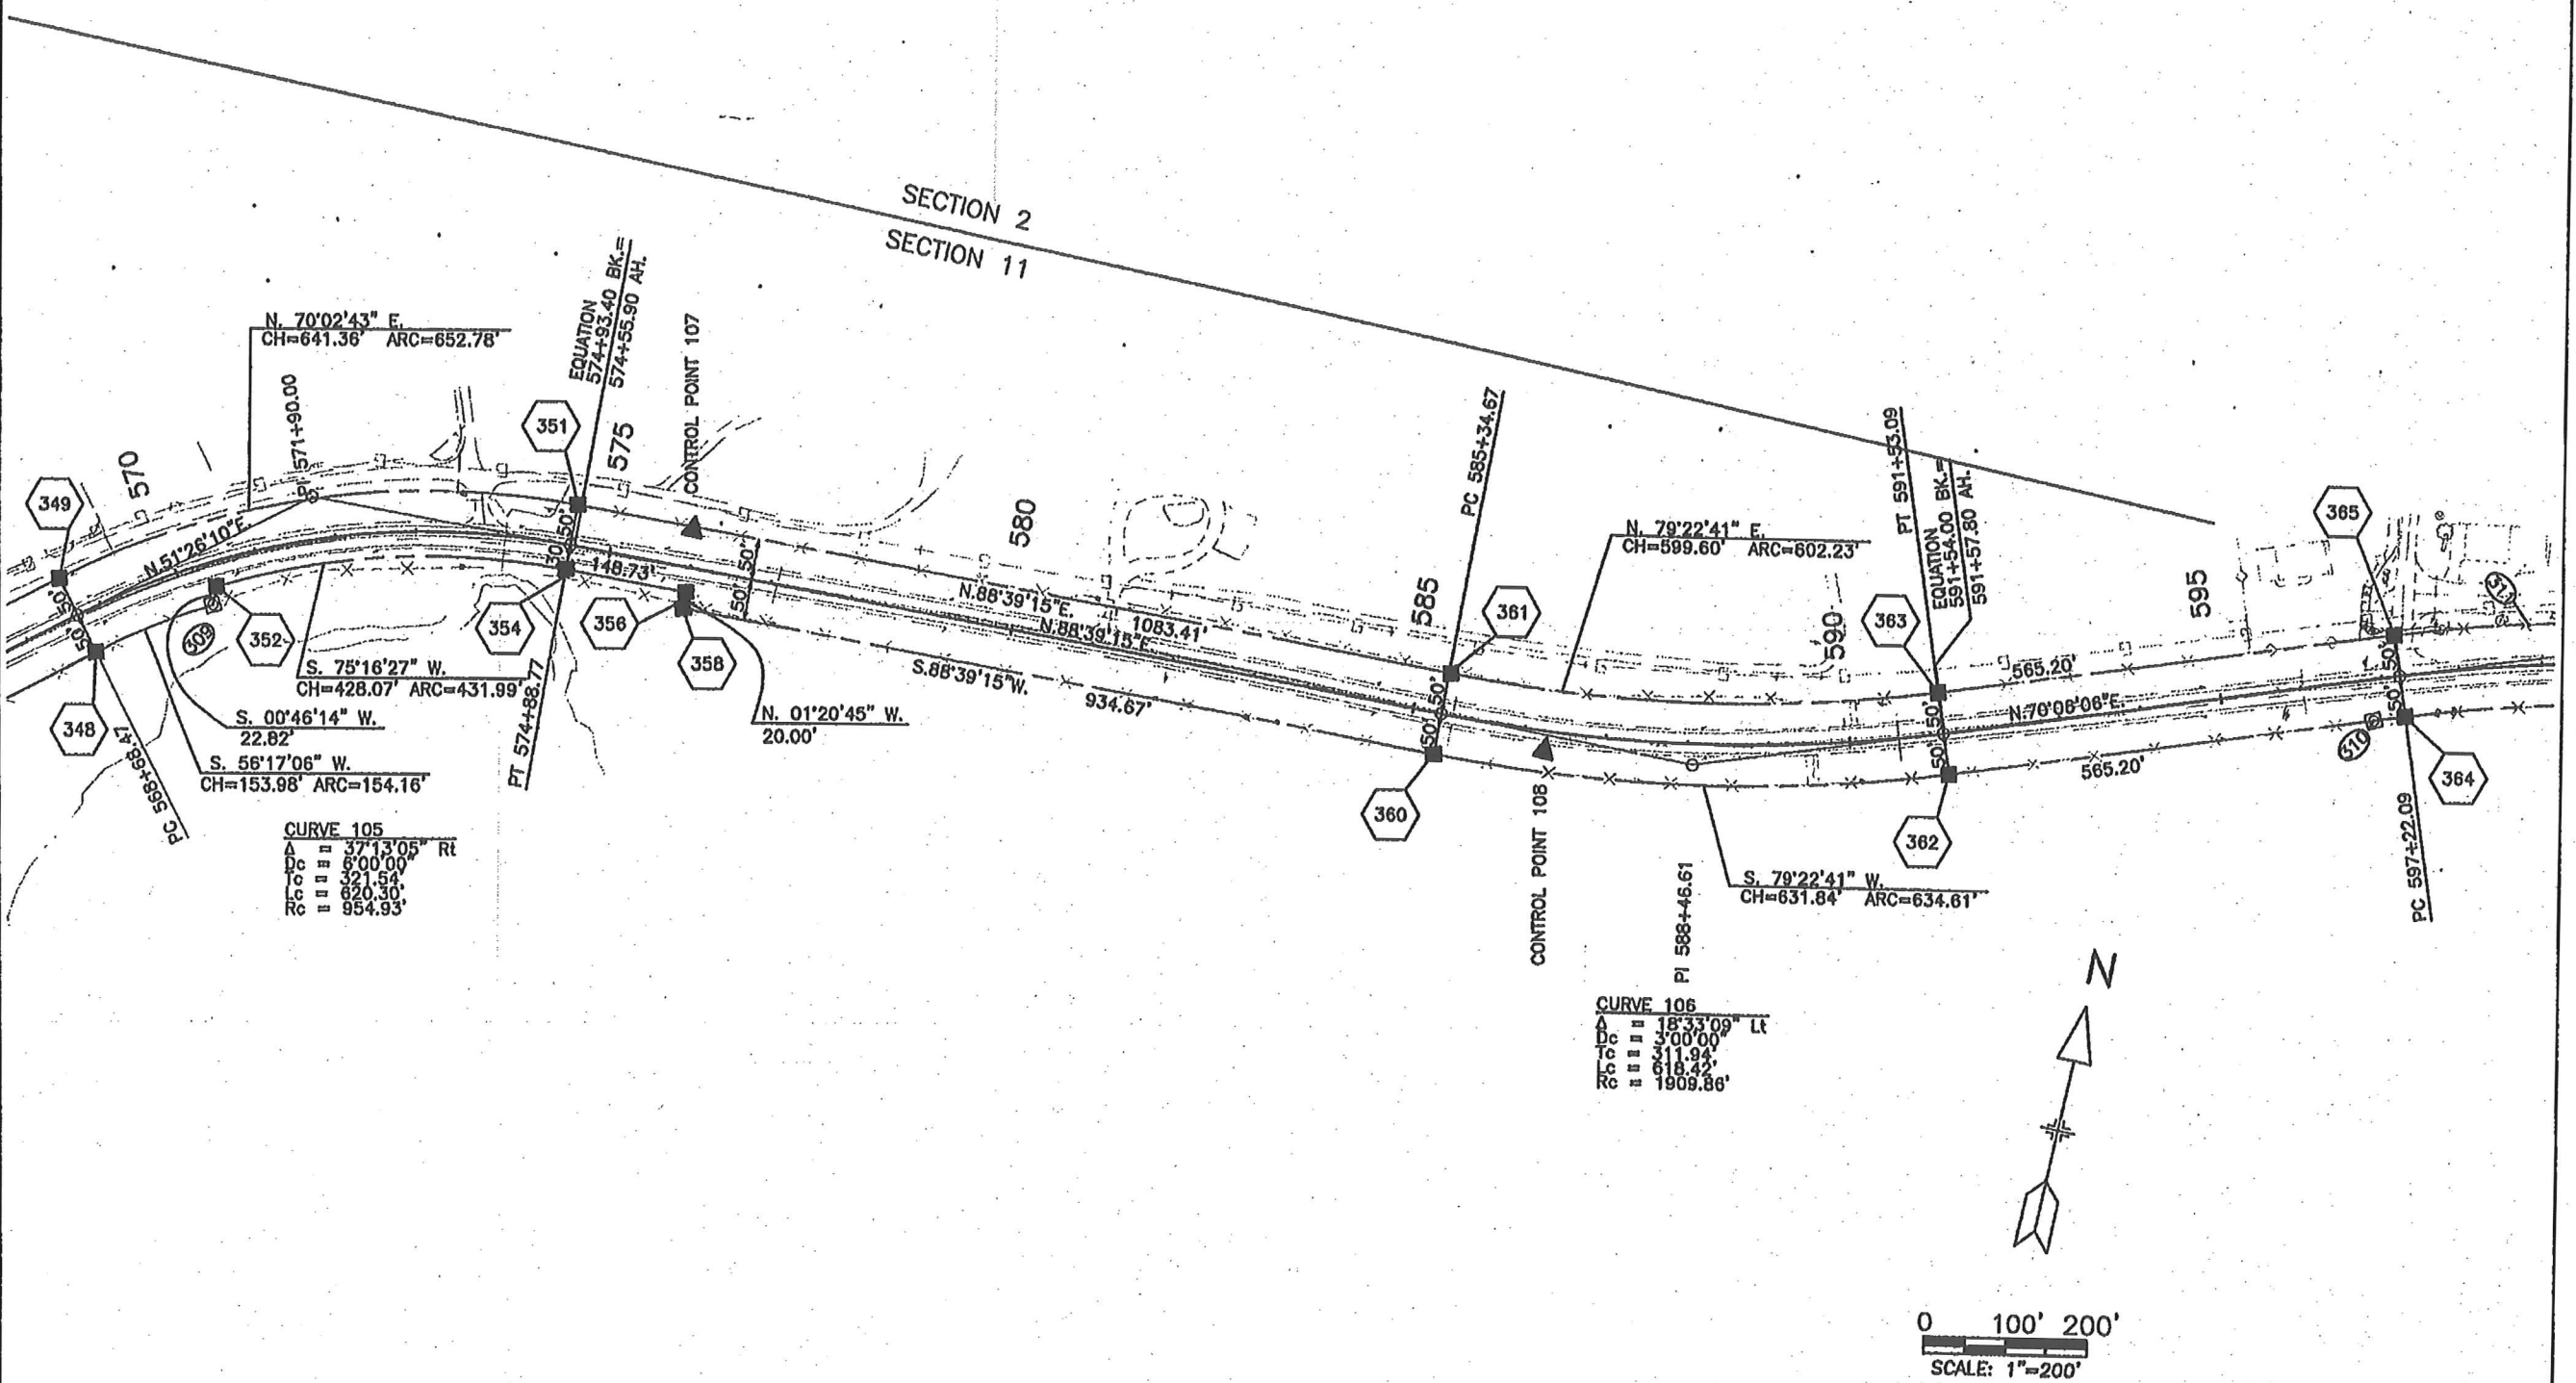

COLORADO DEPARTMENT OF TRANSPORTATION



Region 5
Address: 3803 N. Main Ave., Suite 300
Durango, CO 81301
Phone: (970) 385-1400 FAX: (970) 385-1410

Right of Way Plans Unit: Willis

Sheet Revisions

Rev	Date	Description

Sheet Revisions

Rev	Date	Description

Sheet Revisions


Rev	Date	Description

Right of Way Plans

Plan Sheet

Project Number: NH 1602-089
Project Location: US 160 Turkey Springs Rd.
Project Location: U. S. 160
Project Code: Last Mod. Date Subst. Sheets Sheet No. Total No. of Sheets
13927 6 of 8 10 12

T. 34 N., R. 3 W., N.M.P.M.

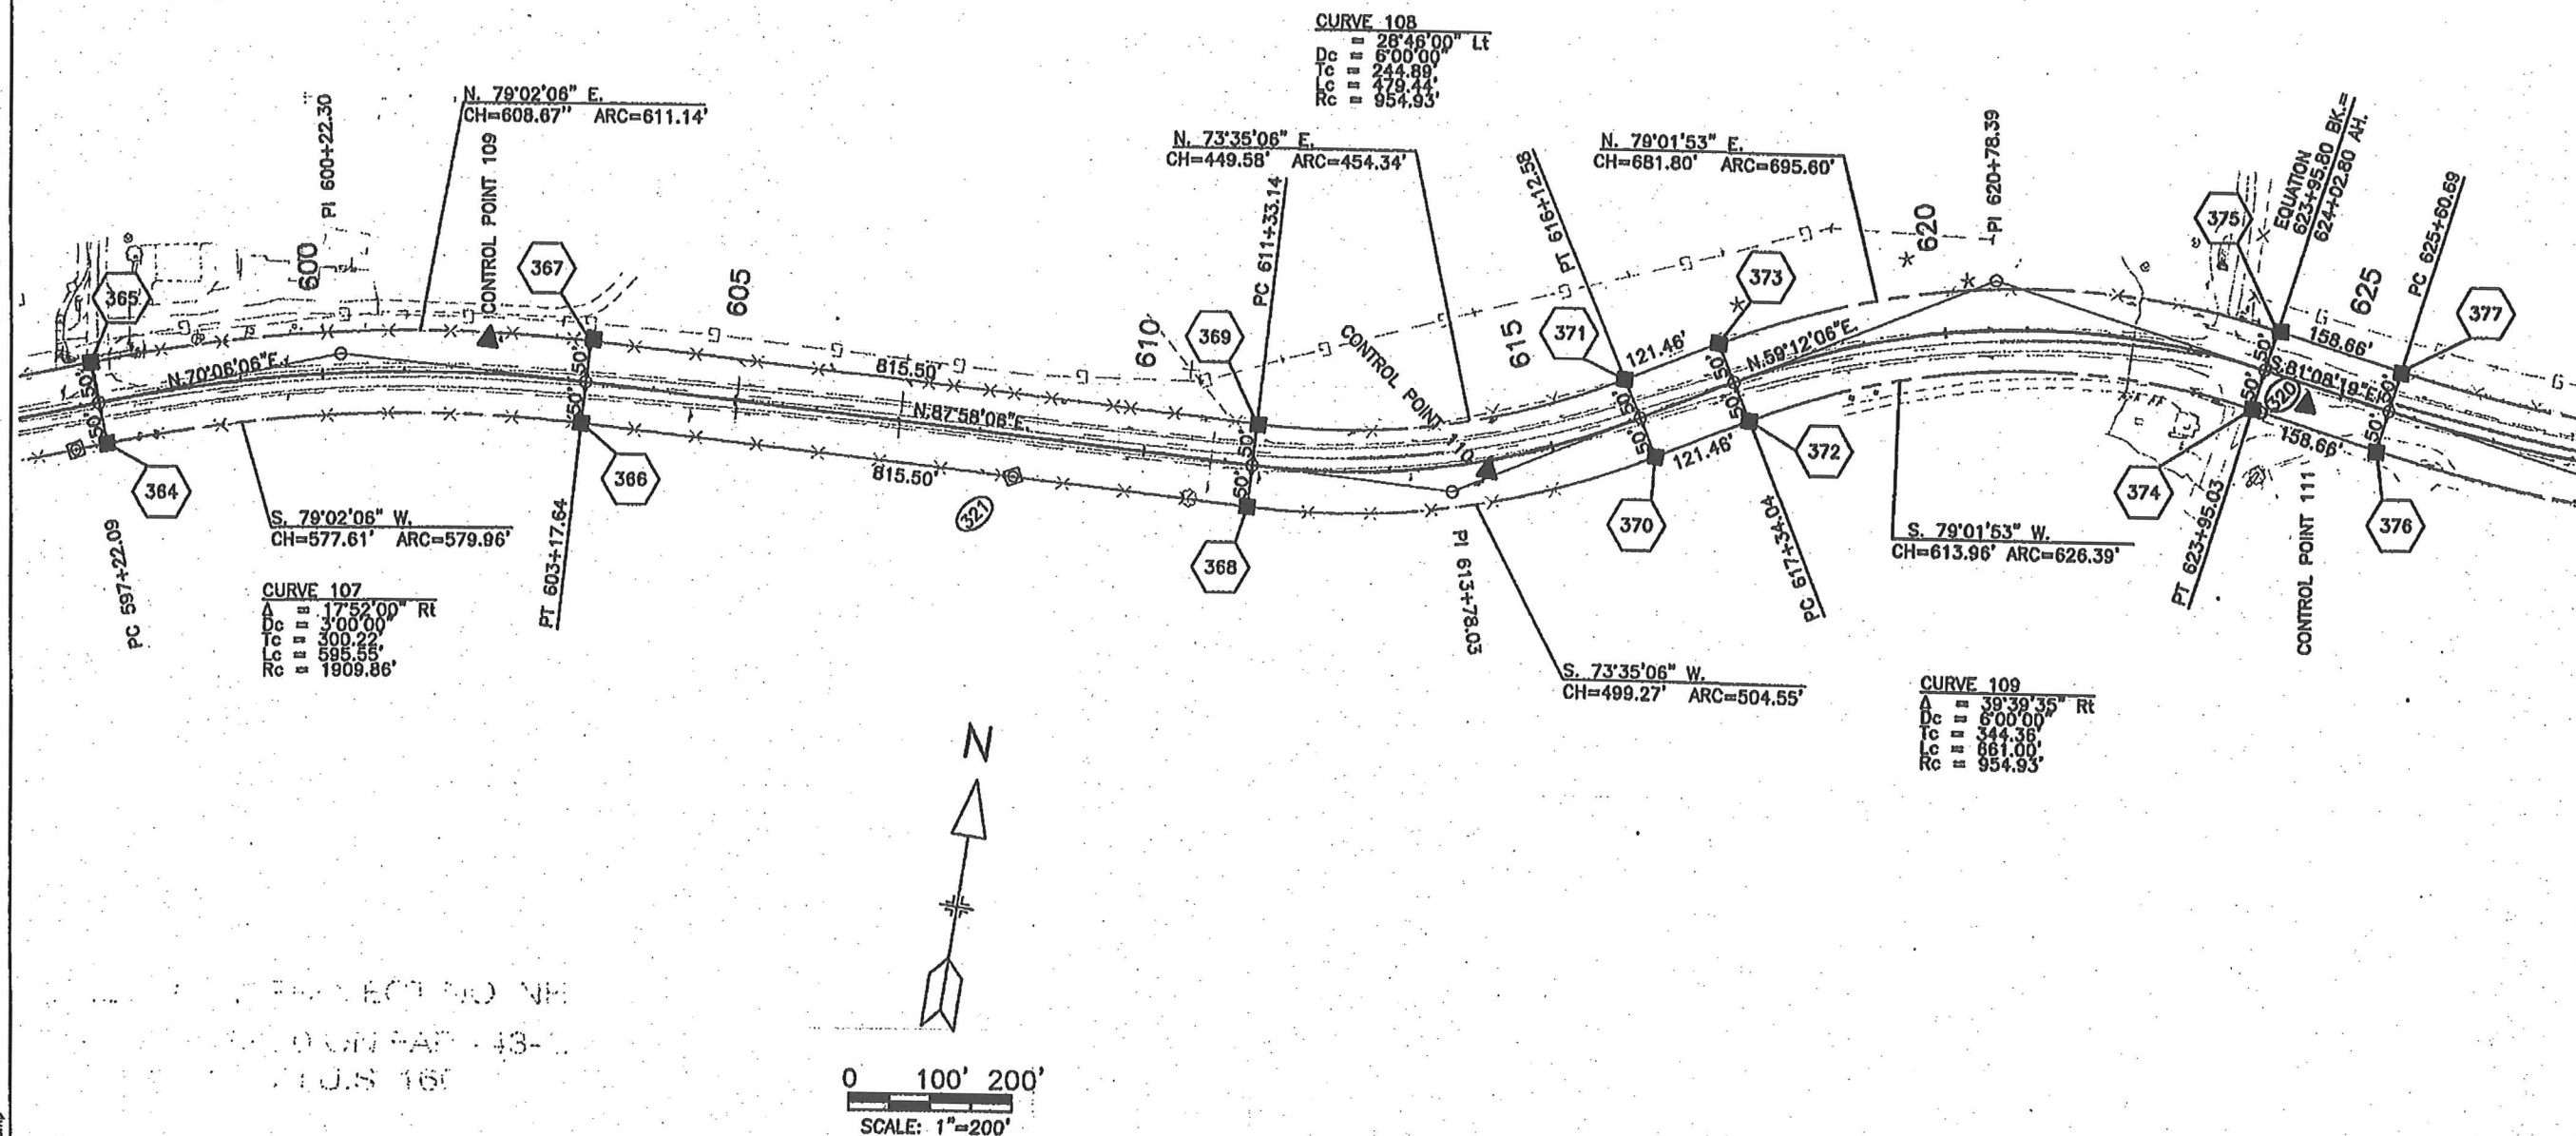

S11816

COLORADO DEPARTMENT OF TRANSPORTATION



Region 5
Address: 3803 N. Main Ave., Suite 300
Durango, CO 81301
Phone: (970) 385-1400 FAX: (970) 385-1410

Right of Way Plans Unit: Willis

Sheet Revisions

mm/yy	xxxx	xxx

Sheet Revisions

mm/yy	xxxx	xxx

Sheet Revisions

mm/yy	xxxx	xxx

Right of Way Plans

Plan Sheet

Project Number: NH 1602-089


Project Location: US 160 Turkey Springs Rd.

Project Location: U. S. 160

Project Code	Last Mod. Date	Sheet No.	Total No. of Sheets
15927		7 of 8	11


T. 34 N., R. 3 W., N.M.P.M.

CURVE 110
Δ = 23°18'28" Lt
Dc = 3°02'14"
Tc = 389.08'
Lc = 767.41'
Rc = 1886.45'

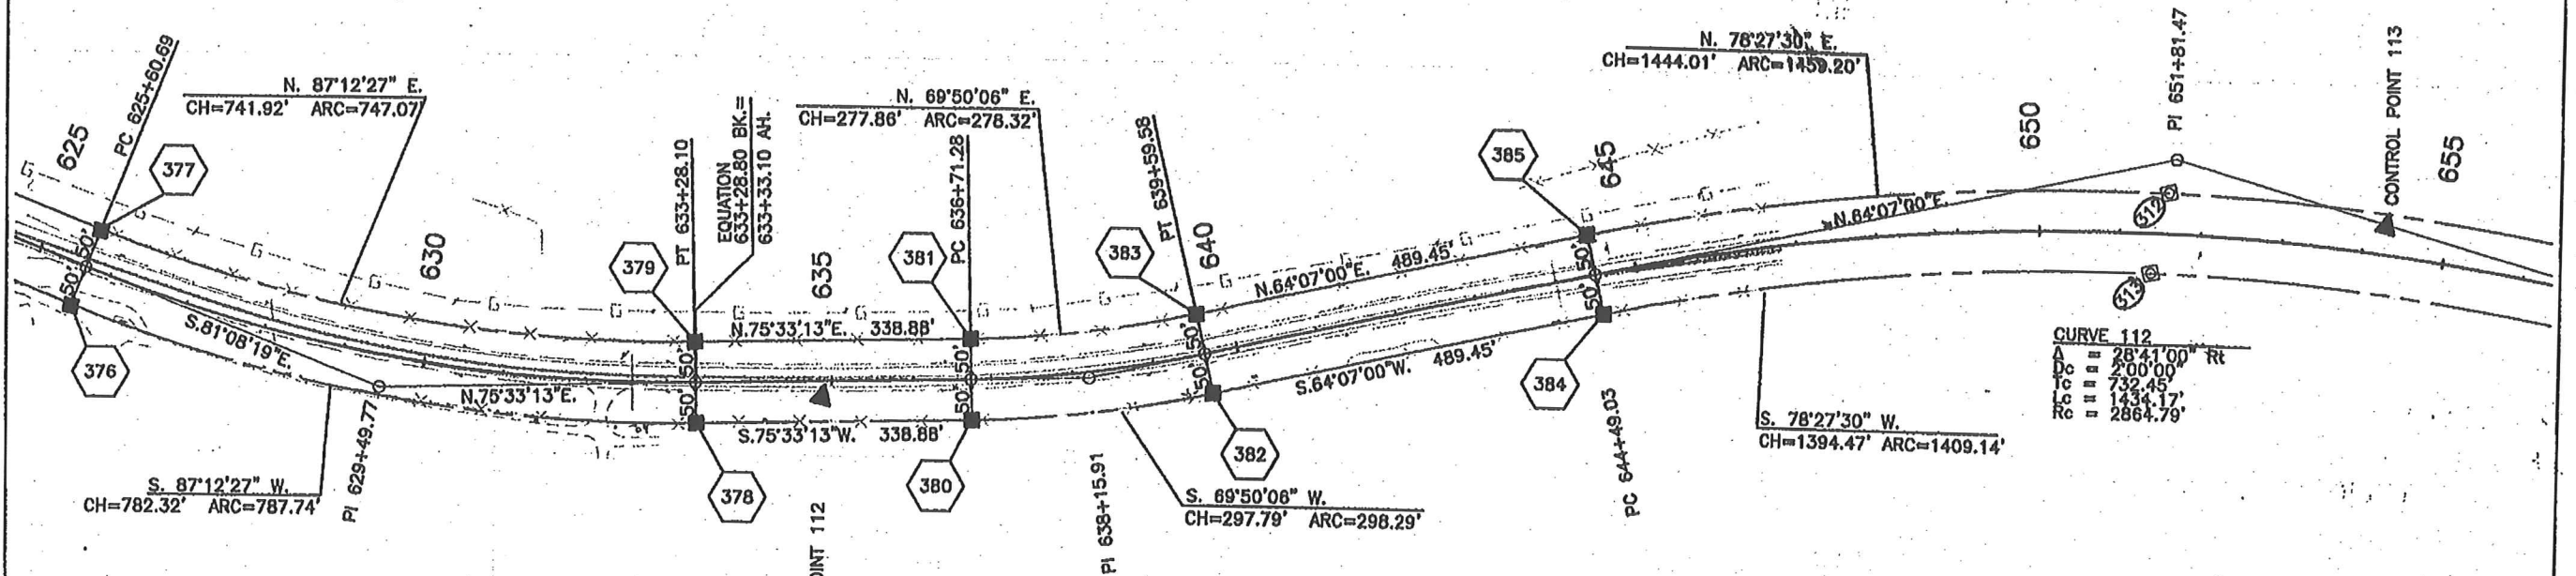

CURVE 111
Δ = 11°28'13" Lt
Dc = 3°58'01"
Tc = 144.64'
Lc = 288.31'
Rc = 1444.33'

CURVE 112
Δ = 28°41'00" Rt
Dc = 2°00'00"
Tc = 732.45'
Lc = 1434.17'
Rc = 2864.79'

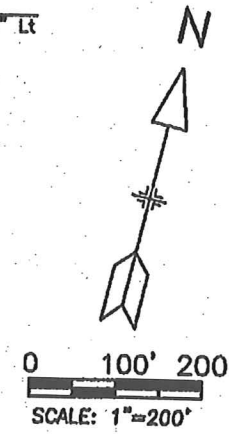

COLORADO DEPARTMENT OF TRANSPORTATION



Region 5
Address: 3803 N. Main Ave., Suite 300
Durango, CO 81301
Phone: (970) 385-1400 FAX: (970) 385-1410

Right of Way Plans Unit: Willis

Sheet Revisions

Rev	Date	Description

Sheet Revisions

Rev	Date	Description

Sheet Revisions

Rev	Date	Description

Right of Way Plans

Plan Sheet


Project Number: NH 1602-089

Project Location: US 160 Turkey Springs Rd.

Project Location: U. S. 160

Project Code	Last Mod. Date	Sheet No.	Total No. of Sheets
13027		8 of 8	12

T. 34 N., R. 3 W., N.M.P.M.

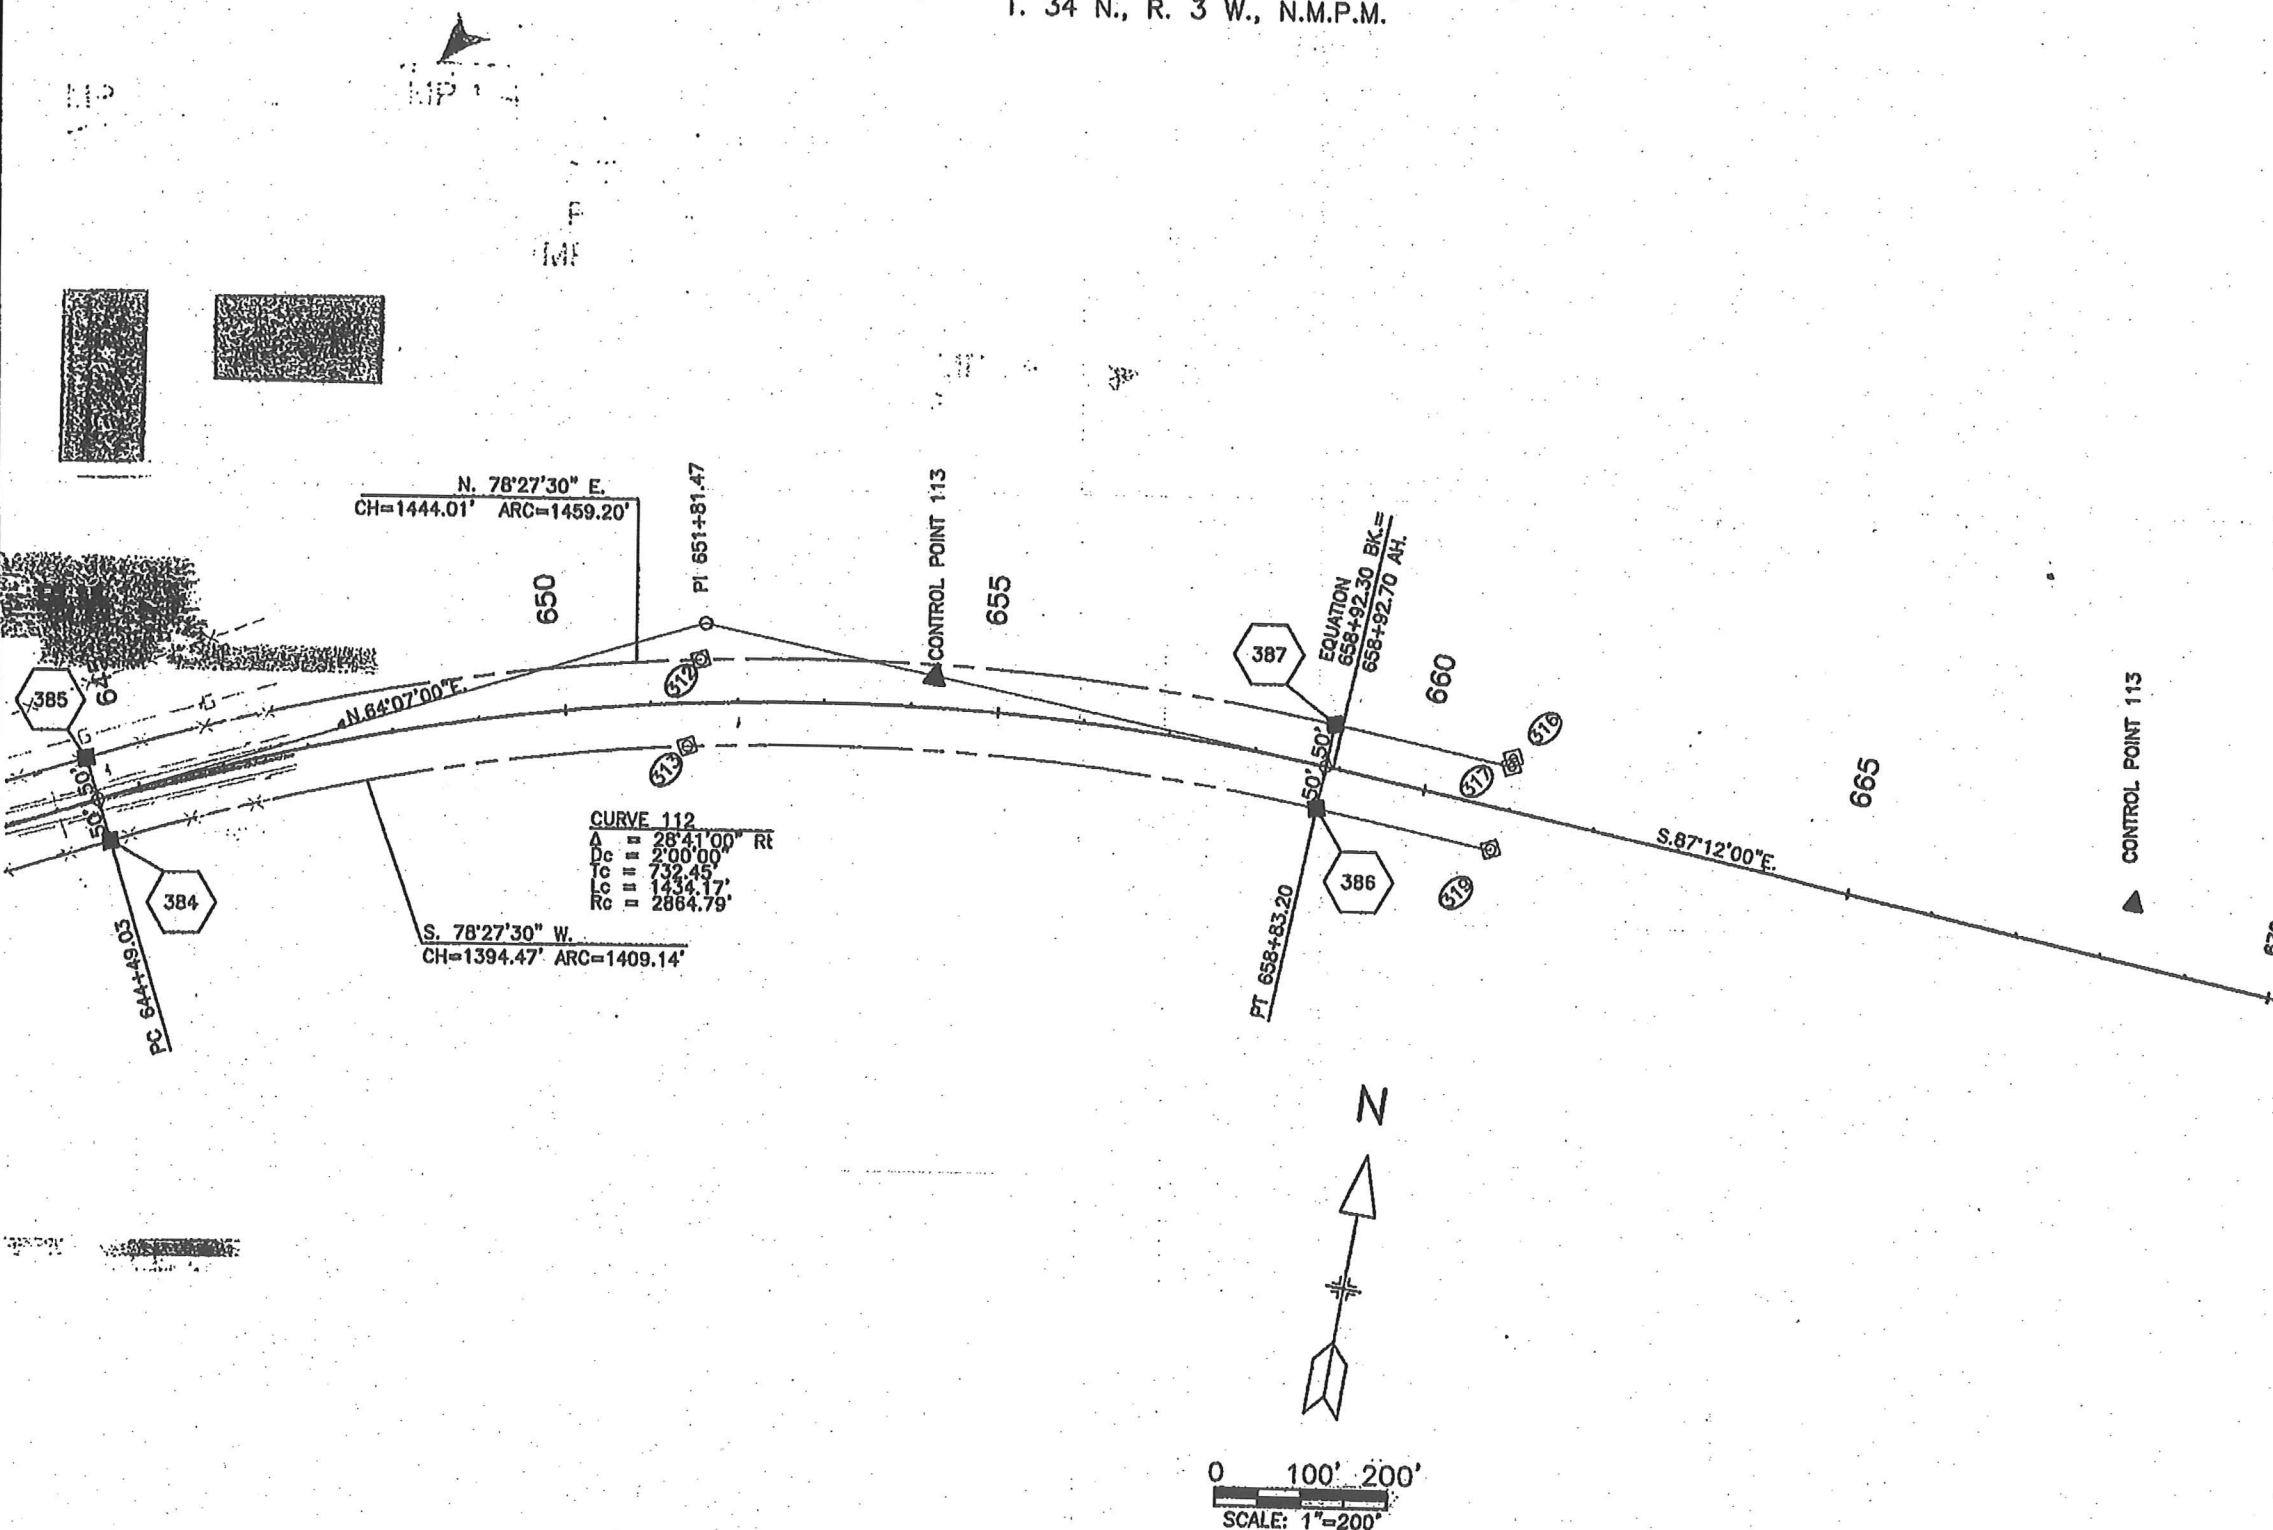

S11816