

STATE DEPARTMENT OF HIGHWAYS

DIVISION OF HIGHWAYS - STATE OF COLORADO

FED. ROAD REGION	DIVISION	PROJECT NUMBER	SHEET NUMBER
VIII	COLO.	RS(CX) 0007(7) & RS(CX) 0007(8)	1
REVISIONS			

RIGHT OF WAY PLAN OF PROPOSED FEDERAL AID PROJECT NOS. RS(CX) 0007(7) & RS(CX) 0007(8) STATE HIGHWAY NO. 7 LARIMER AND BOULDER COUNTIES RIGHT OF WAY

CONVENTIONAL SIGNS

County Line	-----
Township or Range Line	-----
Land Lines Section Line 1/4 Section Line 1/16 Section Line	-----
Property or Tract Line	-----
City Limits	-----
Railroad	-----
Existing Road	-----
New Road	-----
Control of Access	-----
Access denied by Deed	-----
Right of Way Line	-----
Protected by Freeway (Virgin Location)	-----
Top of Cuts	-----
Toe of Fills	-----
Barbed Wire Fence	-----
Chain Link Fence	-----
Woven Wire-Combination Fence	-----
Snow Fence	-----
Wood Fence	-----
Deer Fence	-----
Trees	Deciduous Coniferous
Tel. & Teleg. Lines	-----
Electric Lines	-----
Elec. Trans. Tower	-----
Buried Tel. Cable	-----
Buried Electric Cable	-----
Gas Main	-----
Oil Main	-----
Water Main	-----
Sanitary Sewers	-----
Storm Sewers	-----
Road Approaches	-----
Section Corner	-----
Culverts & Drains	-----
Bridges	-----

SCALES OF ORIGINAL DRAWINGS

PLAN SHEETS 1" = 50'
DETAIL SHEETS 1" = 50'
OWNERSHIP MAP 1" = 200'
R.O.W. LENGTH OF PROJECT = 1.40 MI.


INDEX OF SHEETS

- 1 TITLE SHEET
- 2-2B TABULATION OF PROPERTIES SHEET
- 3-3B CONTROL AND MONUMENTATION SHEET
- 4-10 PLAN SHEETS
- 11-12 OWNERSHIP MAPS

END PROJ. RS(CX) 0007(8) R.O.W.
STA. 613+00 M.P. 7.33
END PROJ. RS(CX)-CX 0007(7) CONST.
STA. 612+00 M.P. 7.35
BEGIN PROJ. RS(CX) 0007(8) R.O.W.
STA. 582+41.37 M.P. 7.91
BEGIN PROJ. RS(CX)-CX 0007(7) CONST.
STA. 580+02.34 M.P. 7.98
END PROJ. RS(CX) 0007(7) R.O.W.
END PROJ. RS(CX)-CX 0007(7) CONST.
STA. 443+50 M.P. 10.55
BEGIN PROJ. RS(CX) 0007(7) R.O.W.
BEGIN PROJ. RS(CX)-CX 0007(7) CONST.
STA. 400+00 M.P. 11.37

BASIS OF BEARINGS

All bearings are based on a line connecting the SE corner of Section 22, T. 4 N., R. 73 W., 6th P.M. (BLM Brass Cap) and the E 1/6th corner common to Sections 22-27, (Metal Cap on Pipe PLS 6499) as bearing S. 89° 55' 57" W.

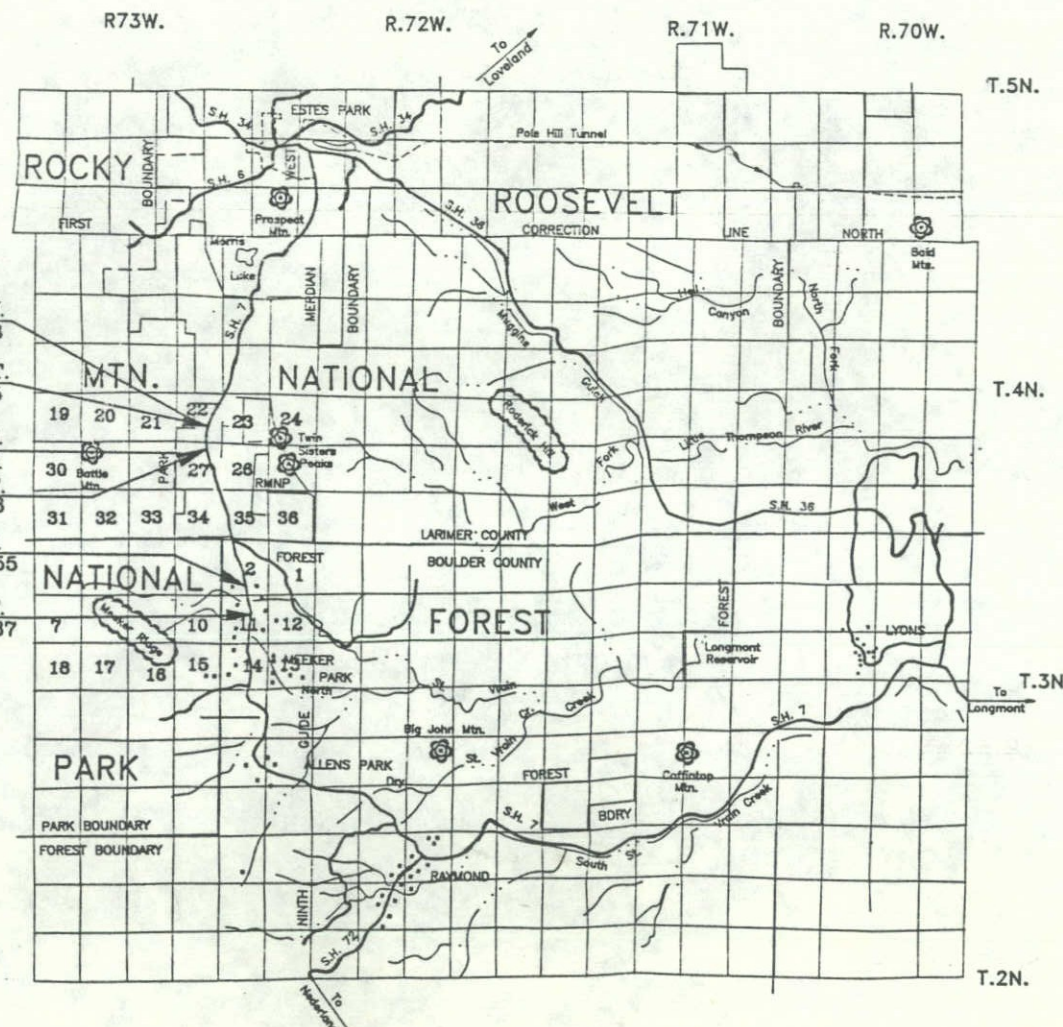

ORIGINAL SCALE IN MILES
0 1 2 3 4 MILES

DEPARTMENT OF TRANSPORTATION FEDERAL HIGHWAY ADMINISTRATION	
APPROVED	DATE
DIVISION ADMINISTRATOR	

R.O.W. TABULATION OF PROPERTIES IN BOULDER COUNTY

S.H. NO. 7

RIGHT OF WAY
NORTH OF MEEKER PARK
AT ST. MALO

C D O H	FED. ROAD REGION	DIVISION	PROJ. NO.	SHEET NO.
	VIII	COLO.	RS(CX) 0007(7)	2
	REVISIONS			

PARCEL NO.	OWNER	ADDRESS	LOCATION	AREA IN ACRES				PARCEL NO.	REMARKS
				PARCEL	TO BE ACQUIRED	REMAINDER			
						LEFT	RIGHT		
			T. 3 N., R. 73 W., 6TH P.M.						
TE-1	THE CLARICE ALDRIDGE MELTON REVOCABLE LIVING TRUST	1010 CHAUTAUQUA NORMAN, OKLAHOMA 73072	NW 1/4 SE 1/4 SEC. 11	0.055	0.055	---	---	TE-1	TEMPORARY EASEMENT TO ACCOMMODATE HIGHWAY SLOPES
TE-3	MONROE S. COX & EARLENE I. COX	MT. MEEKER ESTATES ALLENSPARK, COLORADO	W 1/2 NE 1/4 SEC. 11	0.076	0.076	---	---	TE-3	TEMPORARY EASEMENT TO ACCOMMODATE HIGHWAY SLOPES
TE-4	LAWRENCE A. KROHA & WILMA M. KROHA, J.T.	20 SHORECREST CIRCLE GROSSE POINTE, MICHIGAN 48236	SW 1/4 NE/ 1/4 SEC. 11	0.046	0.046	---	---	TE-4	TEMPORARY EASEMENT TO RECONSTRUCT ROAD APPROACH
5	UNITED STATES OF AMERICA With Permit to Holiday Trails Inc.		S 1/2 NW 1/4 SEC. 11	2.234	0.460	74.18+/-	3.45+/-	5	
TE-5				0.141	0.141	---	---	TE-5	TEMPORARY EASEMENT TO ACCOMMODATE HIGHWAY SLOPES
5X	COLORADO DEPARTMENT OF HIGHWAYS TO UNITED STATES OF AMERICA With Permit to Holiday Trails Inc.	1420 2ND STREET GREELEY, COLORADO 80631	S 1/2 NW 1/4 SEC. 11	0.022	0.022	---	SEE PAR 5	5X	EXCESS ROW TO BE TRADED OR SOLD
6	THE ARCHDIOCESE OF DENVER A Colorado Corporation Sole		N 1/2 NW 1/4 SEC. 11 & S 1/2 SW 1/4 SEC. 2	9.434	7.206	109.40+/-	34.08+/-	6	
TE-6	"		S 1/2 SW 1/4 SEC. 2	0.139	0.139	---	---	TE-6	TEMPORARY EASEMENT TO OBLITERATE ROAD
TE-6A	"		S 1/2 SW 1/4 SEC. 2	0.084	0.084	---	---	TE-6A	TEMPORARY EASEMENT FOR POWERLINE CONNECTION
6A	THE ARCHDIOCESE OF DENVER A Colorado Corporation Sole		N 1/2 NW 1/4 SEC. 11 & S 1/2 SW 1/4 SEC. 2	0.165	0.165	---	SEE PAR 6	6A	
6X	COLORADO DEPARTMENT OF HIGHWAYS TO THE ARCHDIOCESE OF DENVER A Colorado Corporation Sole	1420 2ND STREET GREELEY, COLORADO 80631	N 1/2 NW 1/4 SEC. 11 & S 1/2 SW 1/4 SEC. 2	1.518	1.518	---	SEE PAR 6	6X	EXCESS ROW TO BE TRADED OR SOLD
6R	THE ARCHDIOCESE OF DENVER		N 1/2 NW 1/4 SEC. 11	1.310	1.310	---	SEE PAR 6	6R	
6RA	A Colorado Corporation Sole			0.101	0.101	---	SEE PAR 6	6RA	

R.O.W. TABULATION OF PROPERTIES IN BOULDER & LARIMER COUNTY

S.H. NO. 7

RIGHT OF WAY
NORTH OF MEEKER PARK
AT ASPEN LODGE

C	FED. ROAD REGION	DIVISION	PROJ. NO.	SHEET NO.
D	XIII	COLO.	RS(CX) 0007(8)	2A
O				
H				
REVISIONS				
3-25-91		REVISED PARCEL 21A, 23, 24, 25		0-4
5-14-91		ADDED PERM. EASEMENT PE-24		0-4
		JUL 17 1991		

PARCEL NO.	OWNER	ADDRESS	LOCATION	AREA IN ACRES				PARCEL NO.	REMARKS
				PARCEL	TO BE ACQUIRED	REMAINDER			
						LEFT	RIGHT		
			T. 4 N., R. 73 W., 6TH P.M.						
21	RJA, INC., a Colorado corporation	P.O. BOX 2210	NE 1/4 NE 1/4 SEC.27	0.037	0.037	84+/-	----	21	
TE-21	"	ESTES PARK, COLORADO 80517	NE 1/4 NE 1/4 SEC. 27	0.071	0.071	----	----	TE-21	TEMPORARY EASEMENT TO RECONSTRUCT A HORSE TRAIL
21A REV	RJA, INC., a Colorado corporation	P.O. BOX 2210	NE 1/4 NE 1/4 SEC. 27	1.520	1.520	SEE PAR 21	----	21A REV	PARCEL TO BE USED FOR A WETLANDS REPLACEMENT AREA
		ESTES PARK, COLORADO 80517							
21X	COLORADO DEPARTMENT OF HIGHWAYS TO RJA, INC., a Colorado corporation	1420 2ND STREET GREELEY, COLORADO 80631	NE 1/4 NE 1/4 SEC. 27	0.007	0.007	SEE PAR 21	----	21X	EXCESS ROW TO BE TRADED OR SOLD
23 REV	MARION E. KLEIN & JOYCE A. KLEIN J.T.	P.O. BOX 478	NE 1/4 NE 1/4 SEC. 27	0.045	0.045	----	2.049+/-	23 REV	
		ESTES PARK, COLORADO 80517							
24 REV	NORMAN L. GILCREST & TRESA M. GILCREST, J.T.	148 WEST TINSLEY WACO, TEXAS 76706	NE 1/4 NE 1/4 SEC. 27	0.019	0.019	----	2.543+/-	24 REV	
PE-24	NORMAN L. GILCREST & TRESA M. GILCREST, J.T. TO MARION E. KLEIN & JOYCE A. KLEIN J.T.		NE 1/4 NE 1/4 SEC. 27	0.042	0.017	----		PE-24	PERMANENT EASEMENT FOR ROAD ACCESS
25 REV	MARION E. KLEIN & JOYCE A. KLEIN, J.T.	P.O. BOX 478	NE 1/4 NE 1/4 SEC. 27	0.386	0.386	----	1.617+/-	25 REV	
		ESTES PARK, COLORADO 80517							
26	RESOLUTION TRUST CORPORATION		PT SE 1/4 SE 1/4 SEC. 22	2.012	1.376	----	80.6+/-	26	
TE-26	"		SE 1/4 SE 1/4 SEC. 22	0.468	0.468	----	----	TE-26	TEMPORARY EASEMENT TO RECONSTRUCT A DRIVEWAY
26X	COLORADO DEPARTMENT OF HIGHWAYS TO RESOLUTION TRUST CORPORATION	1420 2ND STREET GREELEY, COLORADO 80631	PT SE 1/4 SE 1/4 SEC. 22	0.280	0.280	----	SEE PAR 26	26X	EXCESS RIGHT OF WAY TO BE DISPOSED OF

29-Jan-1991 PROJECT6: 85087.BETA\B136AA.DXF

C D O H	FED. ROAD REGION	DIVISION	PROJ. NO.	SHEET NO.
	VIII	COLO.	RS(CX) 0007(8)	2B
	REVISIONS			
	3-25-91	REVISED PARCEL 27, TE-27		D-4
	3-25-91	ADDED EASEMENTS PE-27, TE-28A		D-4
	12-9-91	DELETE PE-27		D-4

R.O.W. TABULATION OF PROPERTIES IN LARIMER COUNTY

S.H. NO. 7

RIGHT OF WAY
NORTH OF MEEKER PARK
AT ASPEN LODGE

PARCEL NO.	OWNER	ADDRESS	LOCATION	AREA IN ACRES				PARCEL NO.	REMARKS
				PARCEL	TO BE ACQUIRED	REMAINDER			
						LEFT	RIGHT		
			T. 4 N., R. 73 W., 6TH P.M.						
27 REV	RICHARD F. SCOTT & MARGARET O'B, SCOTT, J.T.	P.O. BOX 3378	PT TR 2 SE 1/4 SE 1/4 SEC 22	1.649	1.046	19.7+/-	----	27 REV	
TE-27 REV	"	ESTES PARK, COLORADO 80517	SE 1/4 SE 1/4 SEC. 22	0.308	0.308	----	----	TE-27 REV	TEMPORARY EASEMENT TO RECONSTRUCT A HORSE TRAIL
27X	COLORADO DEPARTMENT OF HIGHWAYS TO	1420 2ND STREET	E 1/2 SE 1/4 SEC. 22	0.208	0.208	----	----	27X	EXCESS RIGHT OF WAY TO BE DISPOSED OF
	RICHARD F. SCOTT & MARGARET O'B, SCOTT, J.T.	GREELEY, COLORADO 80631							
28	WILLIAM I. ELLIOTT	1808 10TH STREET	E 1/2 SE 1/4 SEC. 22	0.965	0.163	45.484+/-	----	28	
TE-28	"	GREELEY, COLORADO 80631	E 1/2 SE 1/4 SEC. 22	0.333	0.333	----	----	TE-28	TEMPORARY EASEMENT TO RECONSTRUCT A HORSE TRAIL
TE-28A	"		E 1/2 SE 1/4 SEC. 22	0.366	0.366	----	----	TE-28A	TEMPORARY EASEMENT TO OBLITERATE EXISTING ROAD APPROACH
28X	COLORADO DEPARTMENT OF HIGHWAYS TO	1420 2ND STREET	E 1/2 SE 1/4 SEC. 22	0.386	0.386	----	----	28X	EXCESS ROW TO BE DISPOSED OF
	WILLIAM I. ELLIOTT	GREELEY, COLORADO 80631							
29	IRVIN FAMILY PARTNERSHIP, LTD.	P.O. BOX 3410	E 1/2 SE 1/4 SEC. 22	1.643	0.657	----		29	
		ESTES PARK, COLORADO 80517							

CONTROL AND MONUMENTATION SHEET

TABULATION OF R.O.W. MARKERS TO BE SET

16	554672.219	84945.937	RT. OF STA. 584+	(PROJ)
80	553841.539	85131.714	RT. OF STA. 575+	(PROJ)
81	553824.079	85053.643	LT. OF STA. 575+	(PROJ)
171	556752.446	84831.298	LT. OF STA. 605+	(PROJ)
174	557317.269	84990.485	LT. OF STA. 611+	(PROJ)
188	556610.944	84754.172	LT. OF STA. 604+	(PROJ)
210	555961.632	84606.205	LT. OF STA. 597+	(PROJ)
211	555853.000	84602.332	LT. OF STA. 596+	(PROJ)
600	554672.169	84955.944	RT. OF STA. 584+	(PROJ)
603	555376.848	84789.327	RT. OF STA. 591+	(PROJ)
604	555484.846	84786.301	RT. OF STA. 592+	(PROJ)
608	555456.088	84639.083	LT. OF STA. 592+	(PROJ)
612	556367.574	84830.765	RT. OF STA. 602+	(PROJ)
613	556507.159	84877.004	RT. OF STA. 603+	(PROJ)
614	555376.873	84810.357	RT. OF STA. 591+	(PROJ)
618	556410.979	84687.183	LT. OF STA. 602+	(PROJ)
619	556556.169	84735.236	LT. OF STA. 603+	(PROJ)
621	556981.800	84892.639	LT. OF STA. 608+	(PROJ)
622	557317.240	84977.284	LT. OF STA. 611+	(PROJ)
623	556956.109	84994.447	RT. OF STA. 608+	(PROJ)
624	557332.763	85089.492	RT. OF STA. 612+	(PROJ)
625	557432.683	85102.234	RT. OF STA. 613+	(PROJ)
626	554456.828	84912.132	LT. OF STA. 582+	(PROJ)
628	554742.723	84779.988	LT. OF STA. 585+	(PROJ)
629	554775.443	84592.427	LT. OF STA. 586+	(PROJ)
630	554905.934	84535.884	LT. OF STA. 587+	(PROJ)
631	555016.096	84741.040	LT. OF STA. 588+	(PROJ)
634	555306.805	84672.303	LT. OF STA. 591+	(PROJ)
1023	537381.948	88199.691	LT. OF STA. 406+	(PROJ)
1500	537600.653	88201.595	RT. OF STA. 408+	(PROJ)
1502	537662.873	88202.137	RT. OF STA. 409+	(PROJ)
1503	536758.376	88393.039	LT. OF STA. 400+	(PROJ)
1504	537663.054	88181.434	RT. OF STA. 409+	(PROJ)
1506	537795.908	88106.359	RT. OF STA. 410+	(PROJ)
1507	536916.638	88321.533	LT. OF STA. 401+	(PROJ)
1508	538086.359	87935.413	RT. OF STA. 414+	(PROJ)
1509	536969.371	88302.183	LT. OF STA. 402+	(PROJ)
1510	538214.634	87862.874	RT. OF STA. 415+	(PROJ)
1513	537136.320	88254.354	LT. OF STA. 404+	(PROJ)
1514	538502.020	87752.079	RT. OF STA. 418+	(PROJ)
1515	537254.019	88223.795	LT. OF STA. 405+	(PROJ)
1516	538645.792	87719.737	RT. OF STA. 420+	(PROJ)
1517	537341.918	88199.343	LT. OF STA. 406+	(PROJ)
1518	539433.369	87556.827	RT. OF STA. 428+	(PROJ)
1519	537395.992	88184.301	LT. OF STA. 408+	(PROJ)
1520	539504.836	87593.831	RT. OF STA. 428+	(PROJ)
1521	537616.911	88092.717	LT. OF STA. 409+	(PROJ)
1522	539993.663	87579.751	RT. OF STA. 434+	(PROJ)
1523	537745.185	88020.178	LT. OF STA. 410+	(PROJ)
1524	540119.248	87685.502	RT. OF STA. 435+	(PROJ)
1525	538035.637	87849.231	LT. OF STA. 414+	(PROJ)
1526	540295.261	87722.673	RT. OF STA. 437+	(PROJ)
1527	538168.491	87774.156	LT. OF STA. 415+	(PROJ)
1528	540470.409	87634.256	RT. OF STA. 439+	(PROJ)
1530	540911.484	87637.539	RT. OF STA. 443+	(PROJ)
1531	538476.667	87655.346	LT. OF STA. 418+	(PROJ)
1533	538625.536	87621.810	LT. OF STA. 420+	(PROJ)
1535	538738.932	87598.354	LT. OF STA. 421+	(PROJ)
1537	538710.746	87462.089	LT. OF STA. 421+	(PROJ)
1539	538818.883	87491.192	LT. OF STA. 422+	(PROJ)
1541	538836.859	87578.098	LT. OF STA. 422+	(PROJ)
1543	538934.786	87557.842	LT. OF STA. 423+	(PROJ)
1545	539120.512	87468.366	LT. OF STA. 425+	(PROJ)
1549	539520.081	87385.716	LT. OF STA. 429+	(PROJ)
1551	539733.296	87354.554	LT. OF STA. 431+	(PROJ)
1553	540026.242	87372.294	LT. OF STA. 434+	(PROJ)
1555	540179.170	87401.760	LT. OF STA. 435+	(PROJ)
1557	540344.851	87487.852	LT. OF STA. 437+	(PROJ)
1559	540489.026	87515.709	LT. OF STA. 439+	(PROJ)
1561	540894.635	87518.728	LT. OF STA. 443+	(PROJ)
1808	536878.688	88434.566	RT. OF STA. 401+	(PROJ)
1809	536842.956	88362.989	LT. OF STA. 401+	(PROJ)
1810	537057.814	88367.490	RT. OF STA. 403	(PROJ)
1811	537037.744	88290.048	LT. OF STA. 403+	(PROJ)
1812	537348.339	88292.198	RT. OF STA. 406+	(PROJ)
1813	537328.269	88214.756	LT. OF STA. 406+	(PROJ)
1816	539053.523	87352.818	LT. OF STA. 425+	(PROJ)
1817	539012.884	87283.909	LT. OF STA. 424+	(PROJ)
1818	539215.293	87349.724	LT. OF STA. 426+	(PROJ)
1819	539253.266	87279.311	LT. OF STA. 427+	(PROJ)
1820	539319.750	87406.057	LT. OF STA. 427+	(PROJ)
1821	539357.723	87335.644	LT. OF STA. 428+	(PROJ)

TABULATION OF PERMANENT AND TEMPORARY EASEMENTS TO BE STAKED

112	554896.564	84923.439	RT. OF STA. 586+	(PROJ)
113	554997.884	84899.482	RT. OF STA. 587+	(PROJ)
212	556080.594	84617.316	LT. OF STA. 598+	(PROJ)
213	556120.348	84446.327	LT. OF STA. 599+	(PROJ)
216	556321.941	84482.497	LT. OF STA. 600+	(PROJ)
217	556297.034	84590.504	LT. OF STA. 600+	(PROJ)
227	556014.772	84760.934	RT. OF STA. 598+	(PROJ)
228	556114.944	84773.497	RT. OF STA. 599+	(PROJ)
229	556051.639	84966.466	RT. OF STA. 598+	(PROJ)
230	555949.596	84956.173	RT. OF STA. 597+	(PROJ)
231	555253.635	84659.186	LT. OF STA. 590+	(PROJ)
232	555301.053	84647.974	LT. OF STA. 591+	(PROJ)
233	555451.295	84614.547	LT. OF STA. 592+	(PROJ)
234	555376.661	84631.152	LT. OF STA. 592+	(PROJ)
236	555897.481	84578.186	LT. OF STA. 597+	(PROJ)
237	555896.724	84603.175	LT. OF STA. 597+	(PROJ)
238	556758.905	84807.147	LT. OF STA. 605+	(PROJ)
239	556988.088	84868.442	LT. OF STA. 608+	(PROJ)
240	557317.182	84951.486	LT. OF STA. 611+	(PROJ)
241	555259.388	84683.515	LT. OF STA. 590+	(PROJ)
601	554898.3413	84902.450	RT. OF STA. 586+	(PROJ)
602	554974.200	84884.531	RT. OF STA. 587+	(PROJ)
1012	539913.431	87358.814	LT. OF STA. 434+	(PROJ)
1013	540140.266	87394.264	LT. OF STA. 435+	(PROJ)
1407	536753.859	88407.468	LT. OF STA. 400+	(PROJ)
1409	537108.691	88375.342	RT. OF STA. 403+	(PROJ)
1411	537103.405	88355.675	RT. OF STA. 403+	(PROJ)
1412	537204.945	88350.184	RT. OF STA. 404+	(PROJ)
1414	537199.879	88330.672	RT. OF STA. 404+	(PROJ)
1415	537593.361	88104.681	LT. OF STA. 409+	(PROJ)
1416	537582.251	88082.285	LT. OF STA. 409+	(PROJ)
1417	537605.375	88070.537	LT. OF STA. 409+	(PROJ)
1418	537795.097	87961.793	LT. OF STA. 411+	(PROJ)
1419	537807.778	87983.339	LT. OF STA. 411+	(PROJ)
1501	536748.274	88397.911	LT. OF STA. 400+	(PROJ)
1507	536916.638	88321.533	LT. OF STA. 401+	(PROJ)
1509	536969.371	88302.183	LT. OF STA. 402+	(PROJ)
1513	537136.320	88254.354	LT. OF STA. 404+	(PROJ)
1515	537254.019	88223.795	LT. OF STA. 405+	(PROJ)
1528	540470.409	87634.256	RT. OF STA. 439+	(PROJ)
1562	540439.058	87821.651	RT. OF STA. 439+	(PROJ)
1563	540419.333	87818.351	RT. OF STA. 438+	(PROJ)
1564	540448.261	87645.437	RT. OF STA. 438+	(PROJ)
1824	539937.339	87347.583	LT. OF STA. 433+	(PROJ)
1826	540116.072	87372.981	LT. OF STA. 435+	(PROJ)

SURVEY CONTROL POINT TABULATION

15	554278.156	84954.063	TRAVERSE POINT "BRUCE"
25	554946.500	84904.200	TRAVERSE POINT "GLORIA"
35	555608.996	84713.798	TRAVERSE POINT "MATT"
45	556155.426	84678.322	TRAVERSE POINT "BOB"
55	556682.968	84870.257	TRAVERSE POINT "WES"
65	557078.512	84934.259	TRAVERSE POINT "WILLIE"
100	557279.573	85061.321	TRAVERSE POINT "TP1D"
109	553454.429	85183.726	TRAVERSE POINT "PR109"
110	554632.154	84893.091	TRAVERSE POINT "PR110"
114	557745.388	85121.251	TRAVERSE POINT "PR114"
200	555377.560	85392.846	SE CORNER SECTION 22, T. 4 N., R. 73 W. BLM BRASS CAP SET ON A PIPE
221	556691.990	84871.425	TRAVERSE POINT "TP1A"
222	556205.930	84569.206	TRAVERSE POINT "TP2A"
223	555602.318	84849.227	TRAVERSE POINT "TP3A"
224	553562.325	85153.021	TRAVERSE POINT "TP4A"
226	552786.929	85423.402	E 1/4 CORNER SECTION 27, T. 4 N., R. 73 W. BLM BRASS CAP SET IN ROCK
300	557846.032	85190.798	TRAVERSE POINT "TP3D"
400	557181.228	84966.561	TRAVERSE POINT "TP4D"
401	555376.007	84076.651	E 1/16TH COR COMMON SEC 22-27, T. 4 N., R. 73 W. METAL CAP ON PIPE PLS NO. 6499
403	555397.177	85118.029	TRAVERSE POINT "TP3C"
502	557964.863	85263.300	E 1/4 CORNER SECTION 22, T. 4 N., R. 73 W. BLM BRASS CAP SET ON A PIPE
890	554010.043	85046.379	P.O.T. 577+75.56 (PROJ)
900	554264.085	84995.917	P.I. 580+34.57 (PROJ)
950	555936.692	84600.438	P.I. 597+53.25 (PROJ)
960	556849.302	84915.928	P.I. 606+11.54 (PROJ)
970	557499.038	85079.883	P.O.T. 613+58.87 (PROJ)
1001	541078.966	87518.151	TRAVERSE POINT "TP1"
1002	540729.393	87632.829	TRAVERSE POINT "TP2"
1003	539161.863	87691.256	TRAVERSE POINT "TP3E"
1004	540116.614	87288.260	TRAVERSE POINT "TP4"
1005	537929.869	87956.026	TRAVERSE POINT "TP5"
1006	538344.058	88208.067	NC 1/16TH CORNER SECTION 11 (CALC)
1007	538373.509	85598.387	N 1/16TH COR. COMMON SEC. 10 & SEC 11 (CALC)
1010	537746.372	88108.077	TRAVERSE POINT "TOM"
1020	538293.741	87716.193	TRAVERSE POINT "KURT"
1030	538800.118	87621.637	TRAVERSE POINT "MEL"
1040	539160.603	87694.972	TRAVERSE POINT "GIL"
1050	539373.802	87586.680	TRAVERSE POINT "GARY"
1060	540111.142	87277.179	TRAVERSE POINT "RAY"
1070	540184.130	87486.059	TRAVERSE POINT "MIKE"
1080	540650.240	87409.608	TRAVERSE POINT "STEPH"
1090	541366.790	87518.806	TRAVERSE POINT "LINDA"
1092	538461.579	87622.188	TRAVERSE POINT "PR92"
1093	539113.019	87319.664	TRAVERSE POINT "PR93"
1095	540463.523	87624.517	TRAVERSE POINT "PR95"
1098	536754.872	88450.239	P.O.T. 399+85.83 (PROJ)
1099	536957.861	88352.346	P.I. 402+11.19 (PROJ)
1100	537533.176	88202.974	P.I. 408+04.69 (PROJ)
1101	538330.000	87734.000	P.I. 417+26.53 (PROJ)
1102	539790.000	87432.000	P.I. 432+12.98 (PROJ)
1103	540691.048	87622.287	P.I. 441+25.14 (PROJ)
1104	541557.632	87452.715	POT 450+00.06
1121	539895.575	85925.652	TRAVERSE POINT "TP1B"
1122	539713.408	85608.063	NW COR. SEC. 11 (B.L.M. BRASS CAP)
1123	539488.270	85622.509	TRAVERSE POINT "TP3B"
1124	539173.230	85600.134	TRAVERSE POINT "TP4B"
1125	538936.702	85594.094	TRAVERSE POINT "TP5B"
1126	538791.184	85595.627	TRAVERSE POINT "TP6B"
1127	538584.608	85592.294	TRAVERSE POINT "TP7B"
1128	538344.162	85596.527	TRAVERSE POINT "TP8B"
1129	538091.329	85592.599	TRAVERSE POINT "TP9B"
1130	537814.176	85592.375	TRAVERSE POINT "TP10B"
1131	537596.946	85590.040	TRAVERSE POINT "TP11B"
1132	537403.766	85591.147	TRAVERSE POINT "TP12B"
1133	537130.223	85588.982	TRAVERSE POINT "TP13B"
1134	537033.611	85588.710	W 1/4 COR. SEC. 11 (B.L.M. BRASS CAP)
1135	537008.811	85946.723	TRAVERSE POINT "TP15B"
1136	537066.220	86476.704	TRAVERSE POINT "TP16B"
1137	537172.937	87488.806	TRAVERSE POINT "TP17B"
1138	537331.471	87722.717	TRAVERSE POINT "TP18B"
1139	537254.356	87996.435	TRAVERSE POINT "TP19B"
1140	537031.286	88196.639	C 1/4 CORNER SECTION 11, T.3 N, R.73 W. (Brass cap set in Cone)
1141	537252.981	88201.925	TRAVERSE POINT "TP21B"
1200	539656.829	88219.495	N 1/4 COR. SEC. 11 (C.D.O.H. ALUM. 3 1/4" DISK)
1291	537549.167	88209.289	TRAVERSE POINT "PR91" Bureau of Public Roads

T. 3 N., R. 73 W., 6TH P.M.

SURVEY CONTROL DIAGRAM

FED. ROAD REGION	DIVISION	PROJ. NO.	SHEET NO.	TOTAL SHEETS
XIII	COLORADO	RS(CX) 0007(7)	3A	12

RIGHT OF WAY

NORTH OF MEEKER PARK
AT ST. MALO

TRAVERSES 1, 3, 6

REVISIONS



NOTES: POINTS 1210 (TRAVERSE 1) & 1310 (TRAVERSE 3) ARE CHECK IN POINTS FOR POINT 1010; DUE TO TRAVERSE CLOSURES, THEY DO NOT HAVE IDENTICAL COORDINATES.

POINT 1240 (TRAVERSE 1) IS A CHECK-IN POINT FOR POINT 1040 DUE TO TRAVERSE CLOSURE, THEY DO NOT HAVE IDENTICAL COORDINATES. POINT 1030 IS A TURNING POINT FOR TRAVERSE 6

POINT 1260 (TRAVERSE 6) AND POINT 1060 (TRAVERSE 1) ARE THE SAME POINT; DUE TO TRAVERSE CLOSURE, THEY DO NOT HAVE IDENTICAL COORDINATES.

POINT 1391 (TRAVERSE 3) AND POINT 1291 (TRAVERSE 1) ARE THE SAME POINT; DUE TO TRAVERSE CLOSURE, THEY DO NOT HAVE IDENTICAL COORDINATES.

ALL ANGLES AND DISTANCES FIELD MEASURED

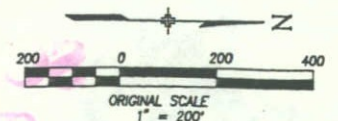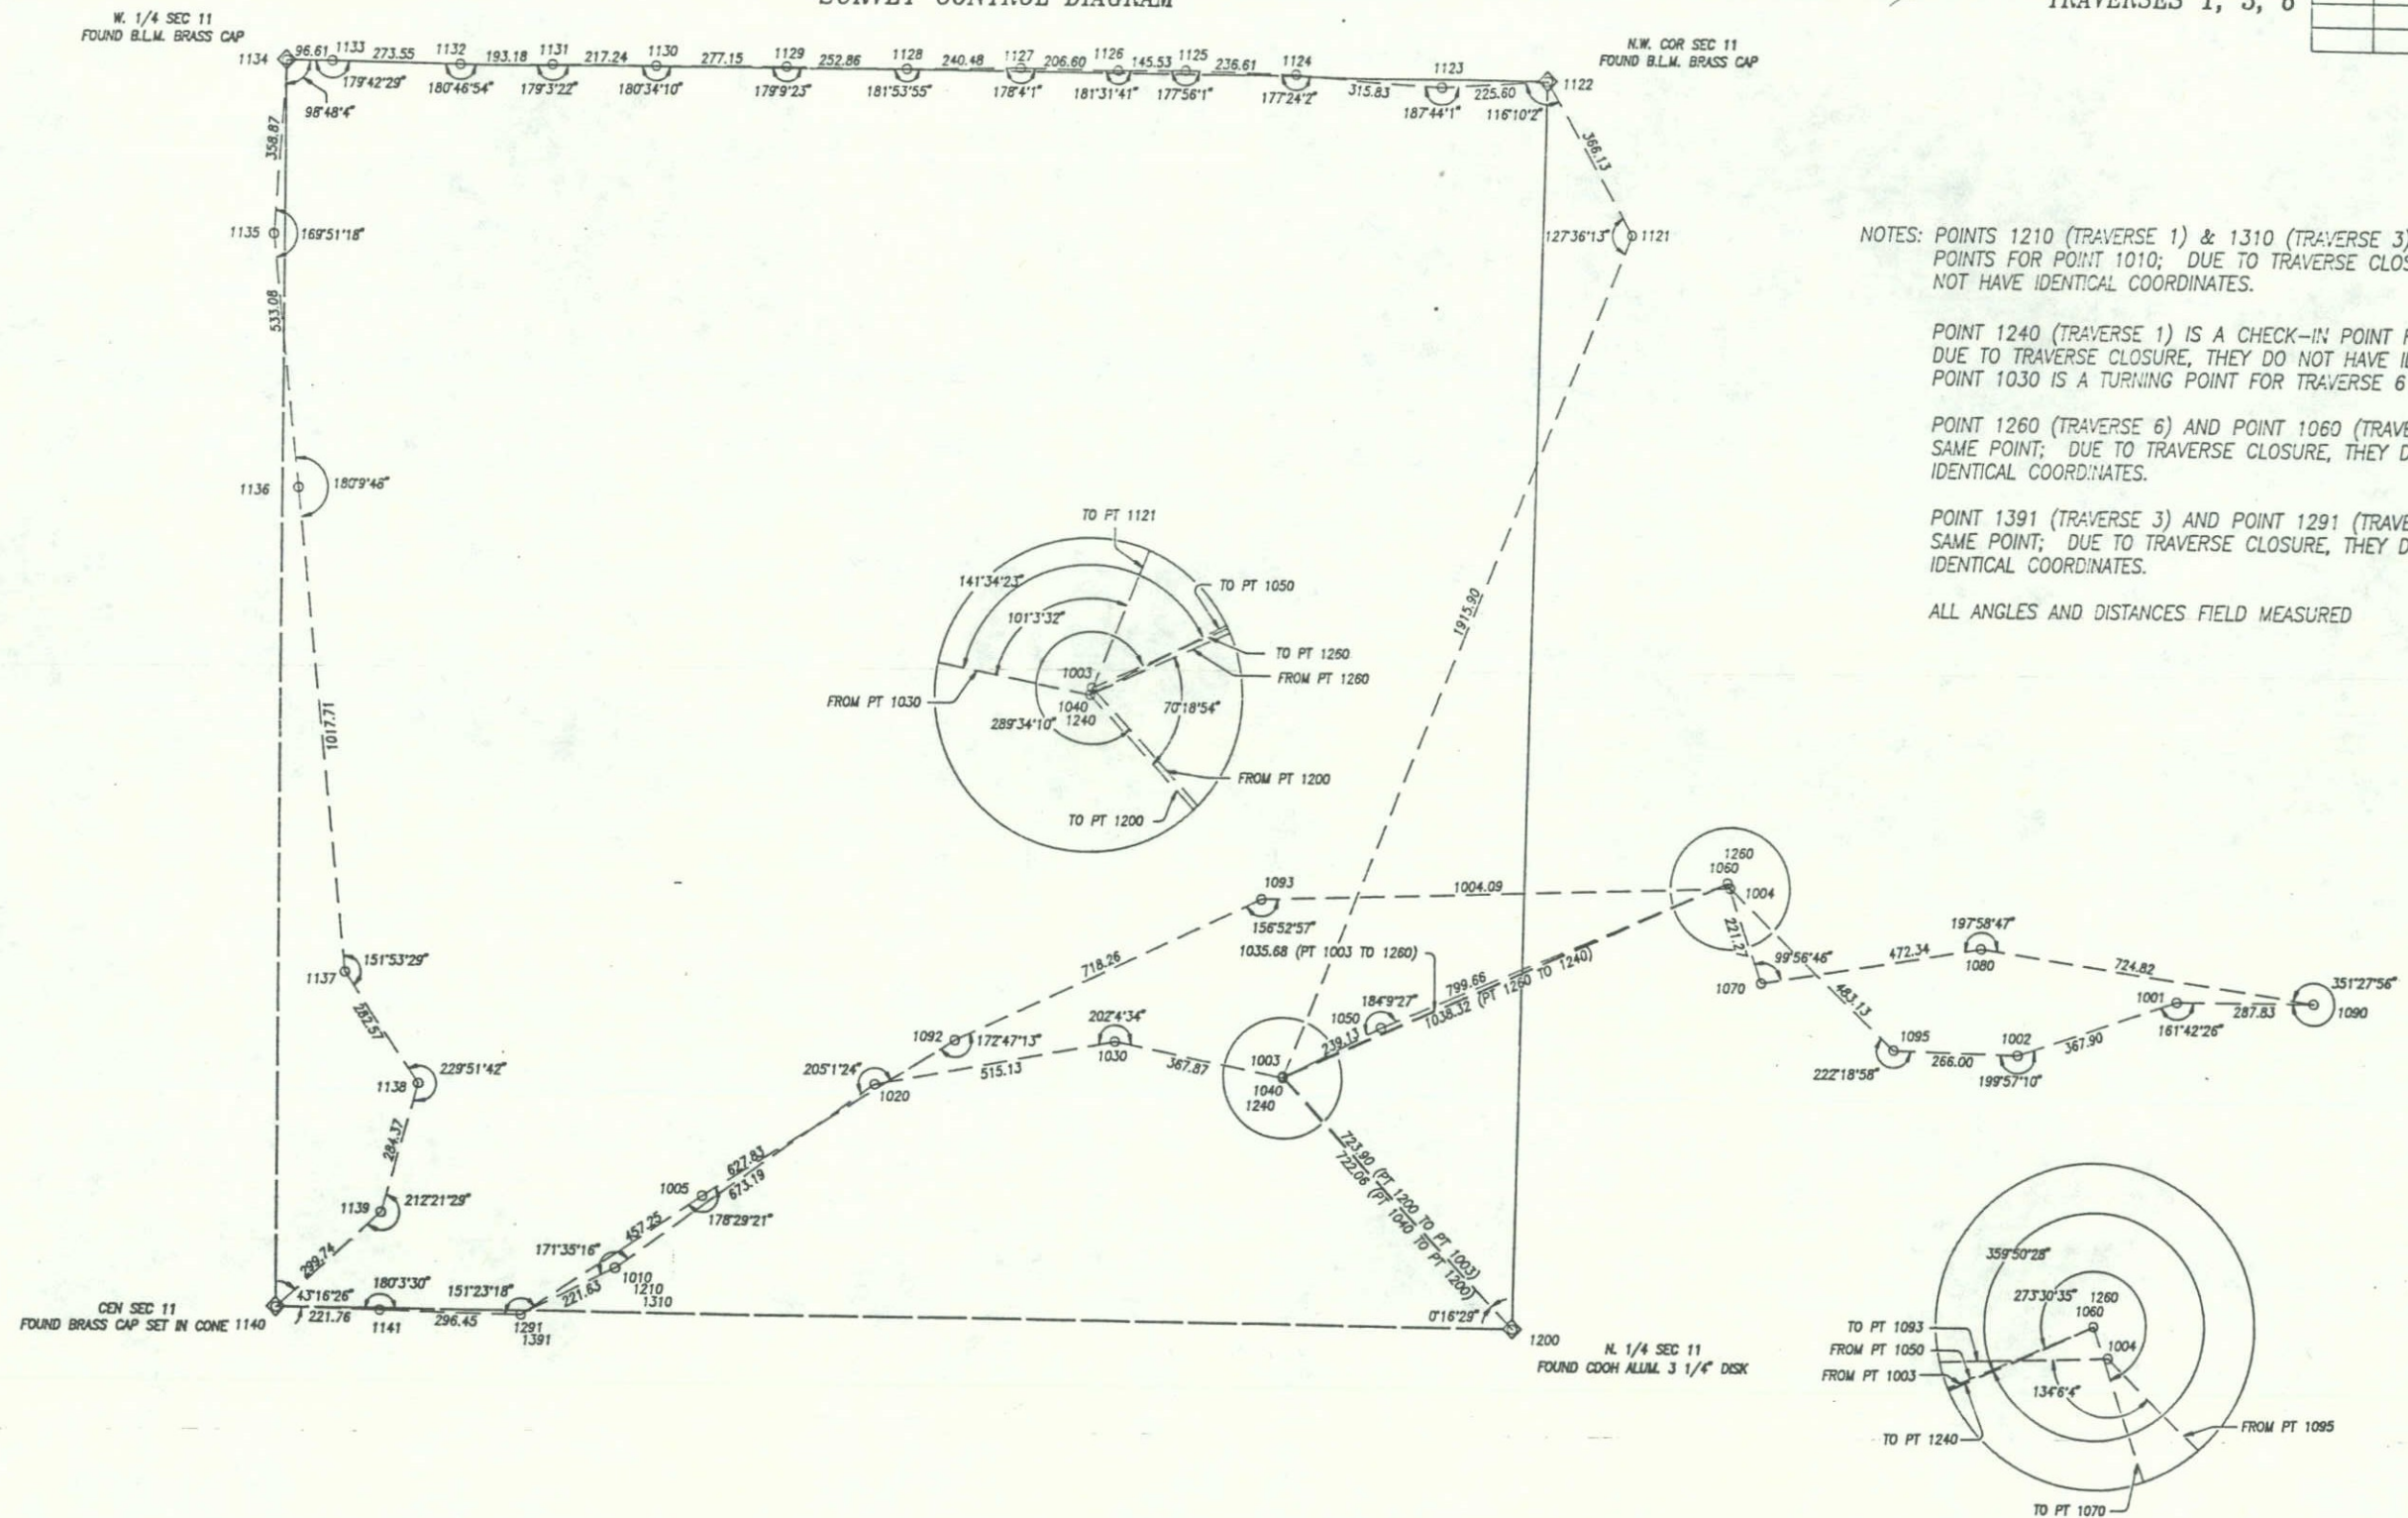

T. 4 N., R. 73 W., 6TH P.M.

SURVEY CONTROL DIAGRAM

FED. ROAD REGION	DIVISION	PROJ. NO.	SHEET NO.	TOTAL SHEETS
VIII	COLORADO	RS(CX) 0007(8)	3B	12

RIGHT OF WAY

NORTH OF MEEKER PARK
AT ASPEN LODGE

TRAVERSES 2, 4, 5

REVISIONS

NOTES: POINT 215 (TRAVERSE 2) IS A CHECK-IN POINT FOR POINT 15. DUE TO TRAVERSE CLOSURE, THEY DO NOT HAVE THE SAME COORDINATES.

POINT 225 (TRAVERSE 2) IS A CHECK-IN POINT FOR POINT 25. DUE TO TRAVERSE CLOSURE, THEY DO NOT HAVE THE SAME COORDINATES.


POINT 255 (TRAVERSE 5) AND POINT 55 (TRAVERSE 2) ARE THE SAME POINT. DUE TO TRAVERSE CLOSURE, THEY DO NOT HAVE THE SAME COORDINATES.

POINT 265 (TRAVERSE 5) AND POINT 65 (TRAVERSE 2) ARE THE SAME POINT. DUE TO TRAVERSE CLOSURE, THEY DO NOT HAVE THE SAME COORDINATES.

POINT 235 (TRAVERSE 4) AND POINT 35 (TRAVERSE 2) ARE THE SAME POINT. DUE TO TRAVERSE CLOSURE, THEY DO NOT HAVE THE SAME COORDINATES.

POINT 225 (TRAVERSE 4) AND POINT 25 (TRAVERSE 2) ARE THE SAME POINT. DUE TO TRAVERSE CLOSURE, THEY DO NOT HAVE THE SAME COORDINATES.

ALL ANGLES AND DISTANCES ARE FIELD MEASURED.

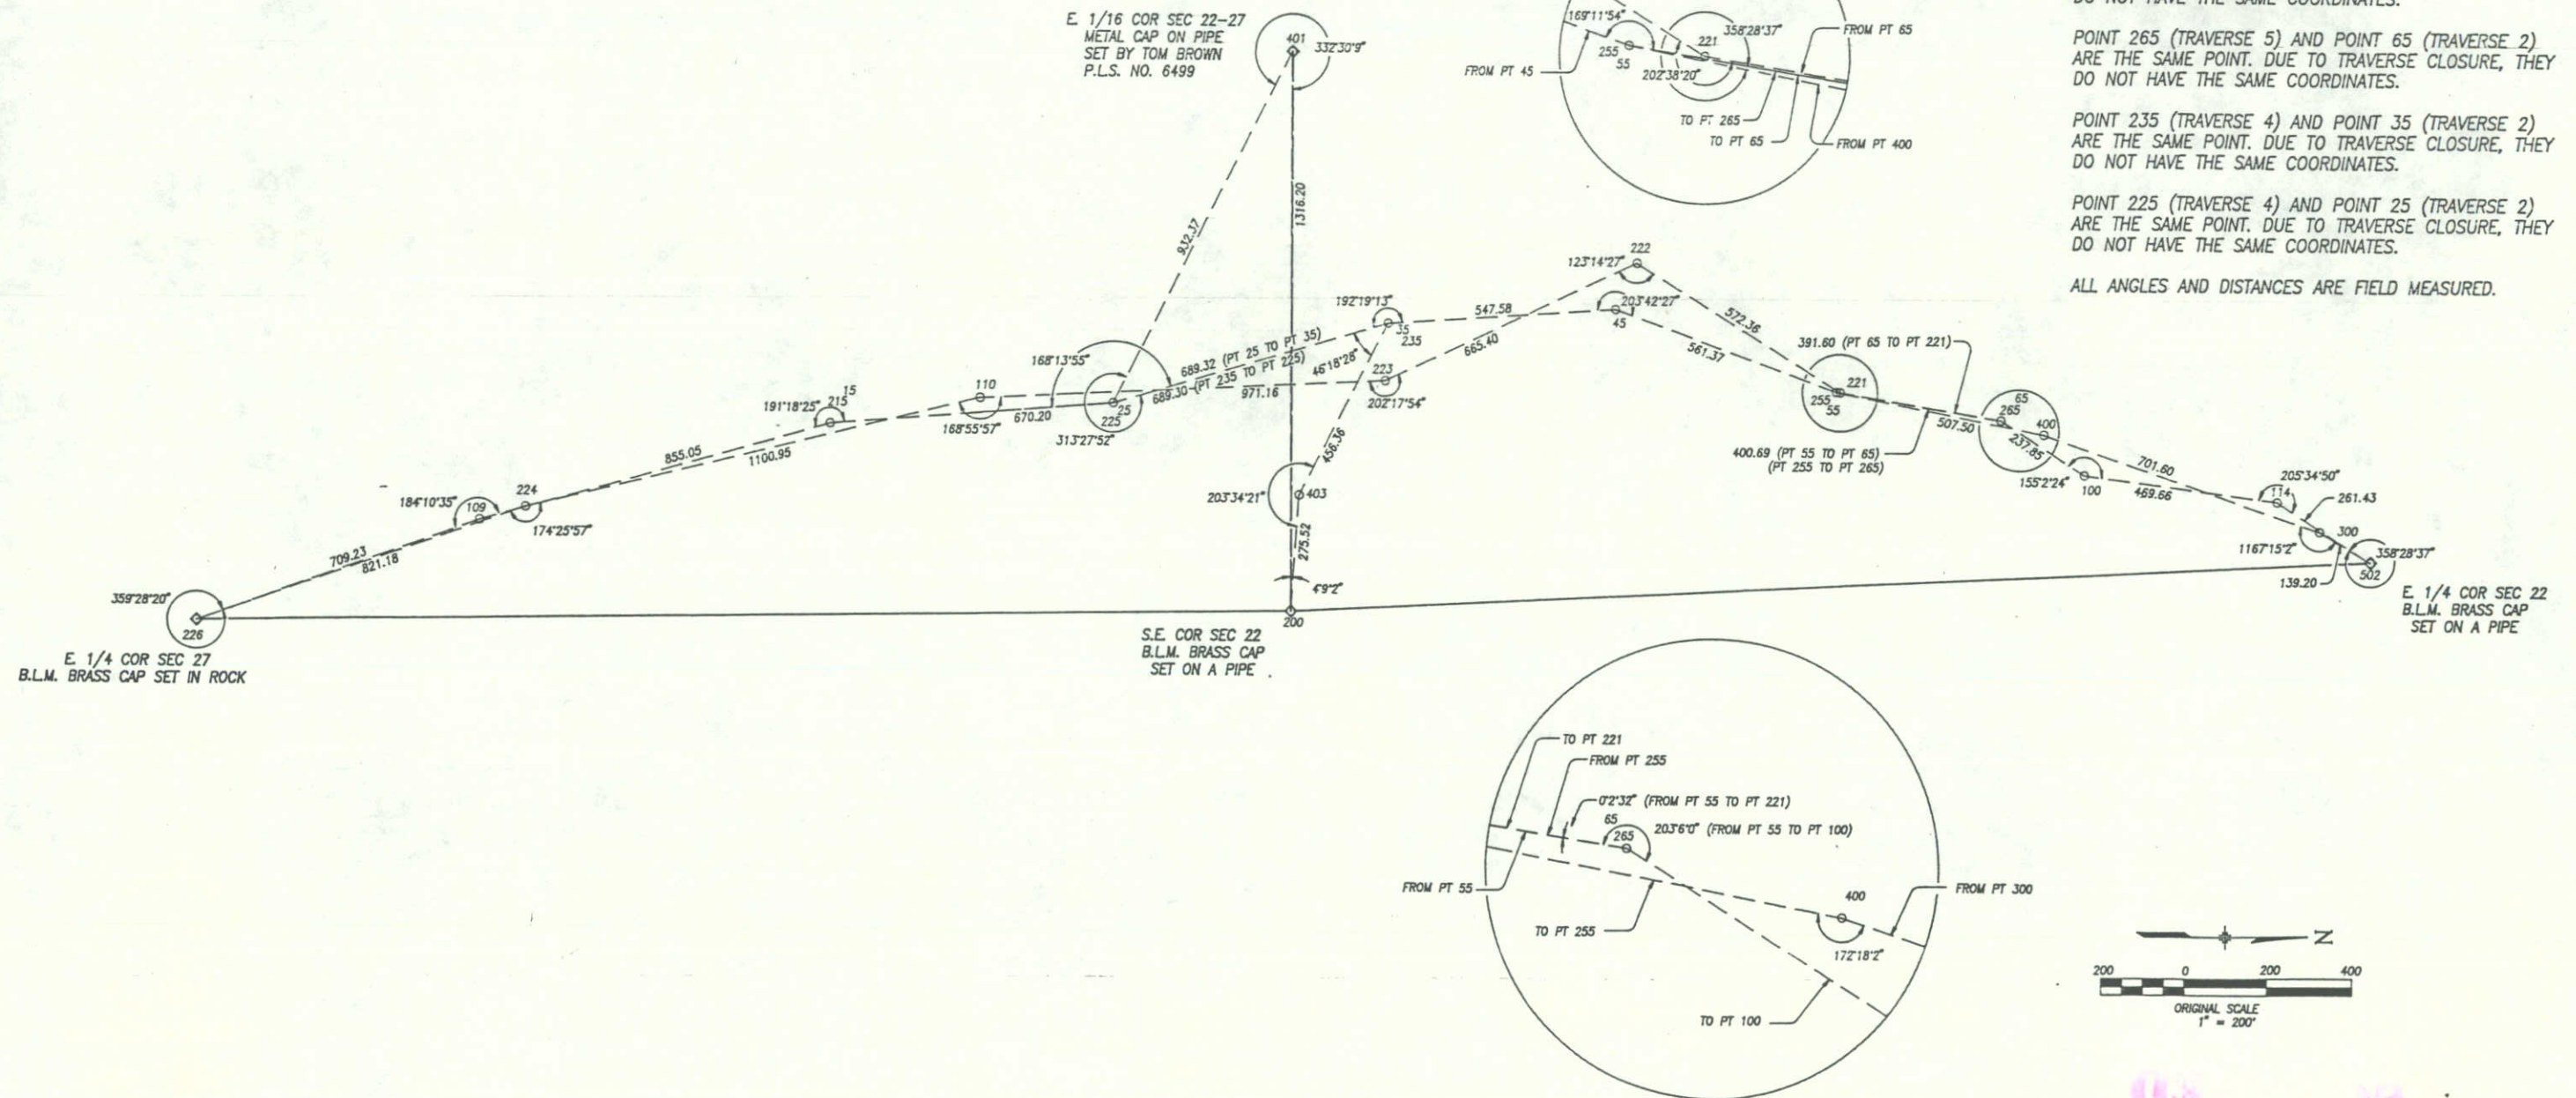

FED. ROAD REGION	DIVISION	PROJ. NO.	SHEET NO.	TOTAL SHEETS
XIII	COLORADO	RS(CX) 0007(7) & RS(CX) 0007(8)	4	12

RIGHT OF WAY

NORTH OF MEEKER PARK
AT ST. MALO

REVISIONS		
7-1-91	ADDED TE3A, TE3B, TE4A, TE5A	D-4

UTILITY COMPANIES:
US WEST COMMUNICATIONS
ESTES PARK POWER AND LIGHT

T. 3 N., R. 73 W., 6TH P.M.

(SURV.) CURVE DATA

$\Delta = 14^{\circ}44'59''$ $\phi = 03^{\circ}45'00''$
 $Ts = 446.83'$ $Ls = 300.00'$
 $\Delta c = 07^{\circ}14'59''$ $L.T. = 200.05'$
 $Dc = 02^{\circ}30'00''$ $S.T. = 100.04'$
 $Lc = 289.99'$
 $Rc = 2,291.83'$

SW 1/4 SEC. 11

SE 1/4 SEC. 11

TE 1 THE CLARICE ALDRIDGE MELTON
REVOCABLE LIVING TRUST

CEN. SEC. 11
BRASS CAP SET IN CONE

S 1/2 NW 1/4 SEC. 11

CURVE DATA PI 408+04.69 (Proj)

$\Delta = 15^{\circ}55'28''$ Lt
 $\theta_s = 3^{\circ}00'00''$ Lt
 $Ts = 275.43'$
 $Es = 14.60'$
 $Ls = 150.00'$
 $LT = 100.01'$
 $ST = 50.01'$
 $\Delta c = 9^{\circ}55'28''$ Lt
 $Dc = 4^{\circ}00'00''$
 $Tc = 124.37'$
 $Lc = 248.11'$
 $Rc = 1432.39'$

TO MEEKER PARK

SE 1/4 SEC. 11

LORRIE JANE ADRIAN ET. AL. &
WILLIAM BRIAN ADRIAN JR.

CURVE DATA PI 402+11.19 (Proj)


$\Delta = 11^{\circ}11'29''$ Rt
 $\theta_s = 4^{\circ}15'00''$ Rt
 $Ts = 197.36'$
 $Es = 6.54'$
 $Ls = 170.00'$
 $LT = 113.37'$
 $ST = 56.70'$
 $\Delta c = 2^{\circ}41'29''$ Rt
 $Dc = 5^{\circ}00'00''$
 $Tc = 26.92'$
 $Lc = 53.83'$
 $Rc = 1145.92'$

TE 4 LAWRENCE A. KROHA &
WILMA M. KROHA, J.T.

TE 3 MONROE S. COX &
EARLENE I. COX, J.T.

BEGIN PROJECT RS(CX) 0007(7) R.O.W.
BEGIN PROJECT RS(CX)-CX 0007(7) CONST.

STA. 400+00.00 MP 11.370

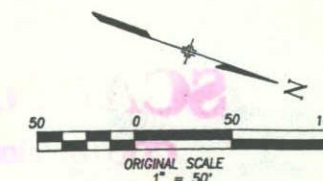

FED. ROAD REGION	DIVISION	PROJ. NO.	SHEET NO.	TOTAL SHEETS
VIII	COLORADO	RS(CX) 0007(7) & RS(CX) 0007(8)	5	12

RIGHT OF WAY
NORTH OF MEEKER PARK
AT ST. MALO

REVISIONS

T. 3 N., R. 73 W., 6TH P.M.

(SURV.) CURVE DATA

Δ = 06°48'00" Rt. θ = 03°00'00"
Ts = 213.51' Ls = 200.00'
Δc = 00°48'00" L.T. = 133.35'
Dc = 03°00'00" S.T. = 66.68'
Lc = 26.67'
Rc = 1,909.86'

S 1/2 NW 1/4 SEC. 11

5X UNITED STATES OF AMERICA
With Permit to
Holiday Trails Inc.
S 1/2 NW 1/4 Sec. 11

5X COLO. DEPT. OF HWYS.
TO
UNITED STATES OF AMERICA
To Be Abandon Subject to Highway
Commission Approval

CURVE DATA
P.L. 417+26.53 (Proj)

Δ = 18°47'32" Rt
θs = 3°00'00" Rt
Ts = 312.13'
Es = 20.14'
Ls = 150.00'
LT = 100.01'
ST = 50.01'
Δc = 12°47'32" Rt
Dc = 4°00'00"
Lc = 160.57'
Tc = 319.81'
Rc = 1432.39'

N 1/2 NW 1/4 SEC. 11

6 6A THE ARCHDIOCESE OF DENVER,
A Colorado Corporation Sole
N 1/2 NW 1/4 Sec 11, &
S 1/2 SW 1/4 Sec. 2


6X COLO. DEPT. OF HWYS.
TO
THE ARCHDIOCESE OF DENVER,
A Colorado Corporation Sole
To Be Abandon Subject to Highway
Commission Approval



MONROE S. COX &
EARLENE I. COX
W 1/2 NE 1/4

Calc. Location of 1/16th corner

N.0°29'56"E, 1312.82' to the N 1/4 Cor.
Property Line

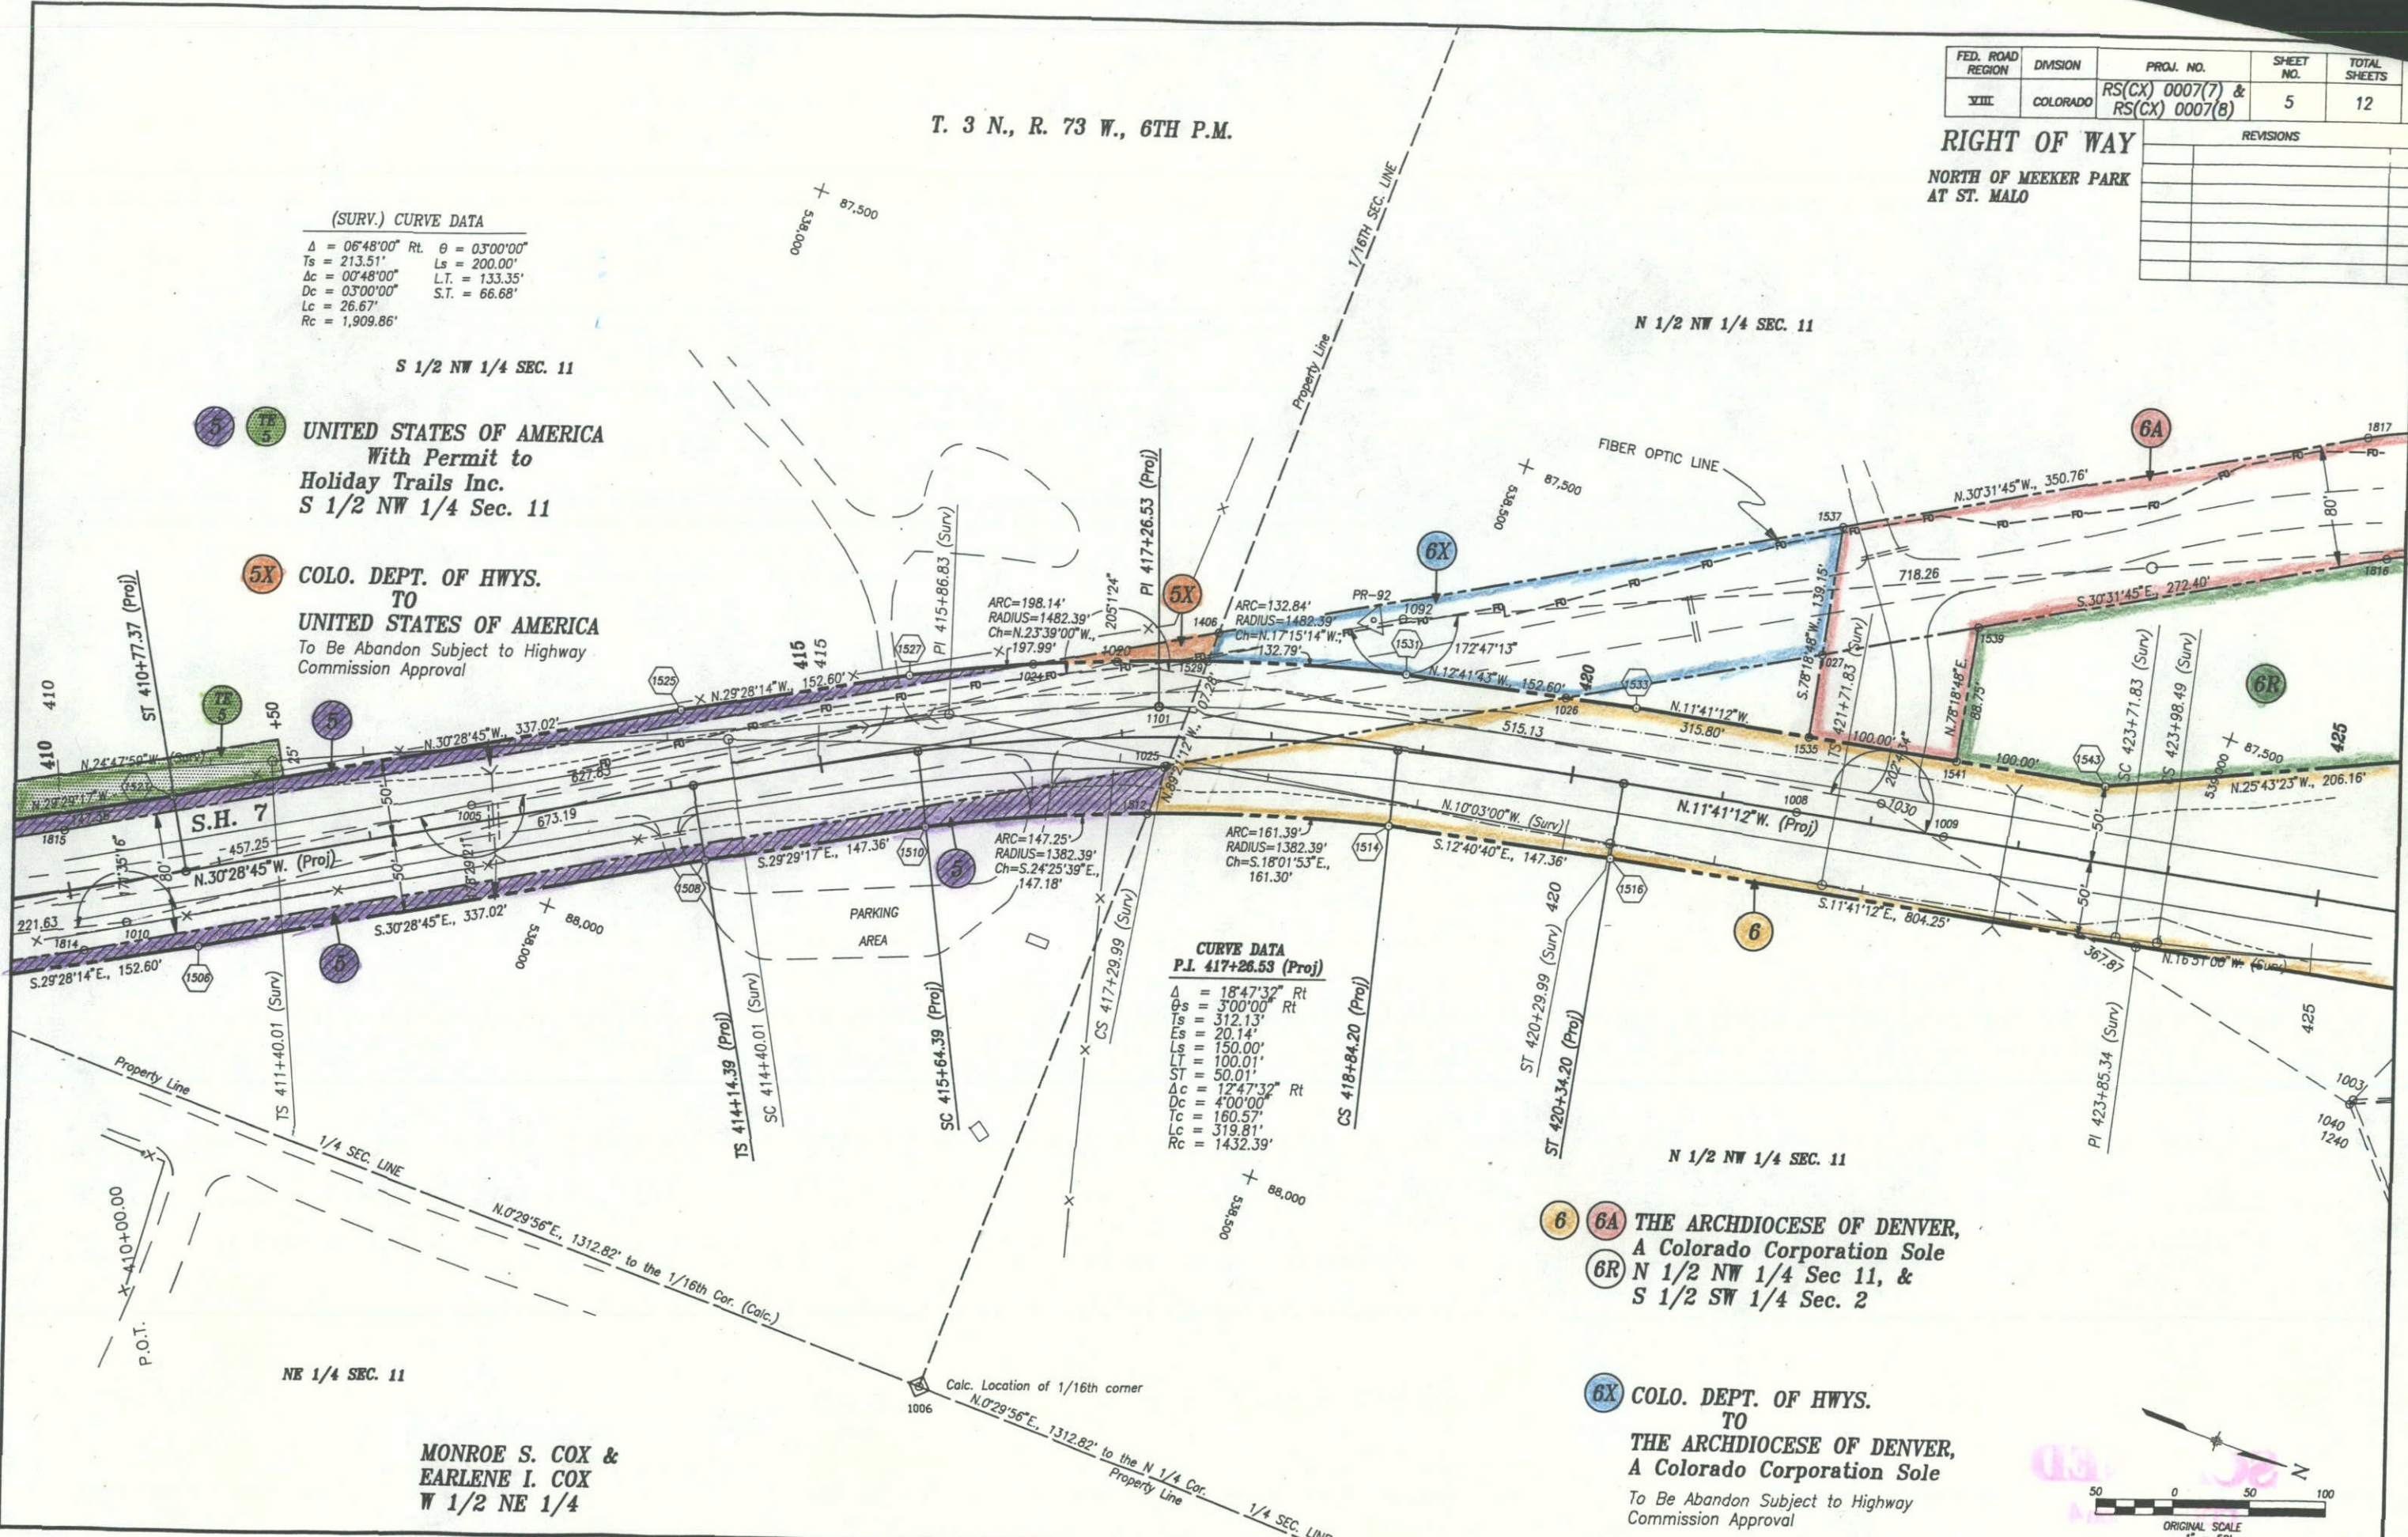

FED. ROAD REGION	DIVISION	PROJ. NO.	SHEET NO.	TOTAL SHEETS
VIII	COLORADO	RS(CX) 0007(7) & RS(CX) 0007(8)	6	12

RIGHT OF WAY
NORTH OF MEEKER PARK
AT ST. MALO


REVISIONS		
5-13-91	ADDED TE-28A	D-4
6-10-91	ADDED TE-28B	D-4

T. 3 N., R. 73 W., 6TH P.M.

N 1/2 NW 1/4 SEC. 11

6 6A THE ARCHDIOCESE OF DENVER,
A Colorado Corporation Sole
N 1/2 NW 1/4 Sec 11, &
S 1/2 SW 1/4 Sec. 2

6X COLO. DEPT. OF HWYS.
TO
THE ARCHDIOCESE OF DENVER,
A Colorado Corporation Sole
S 1/2 SW 1/4 SEC. 2

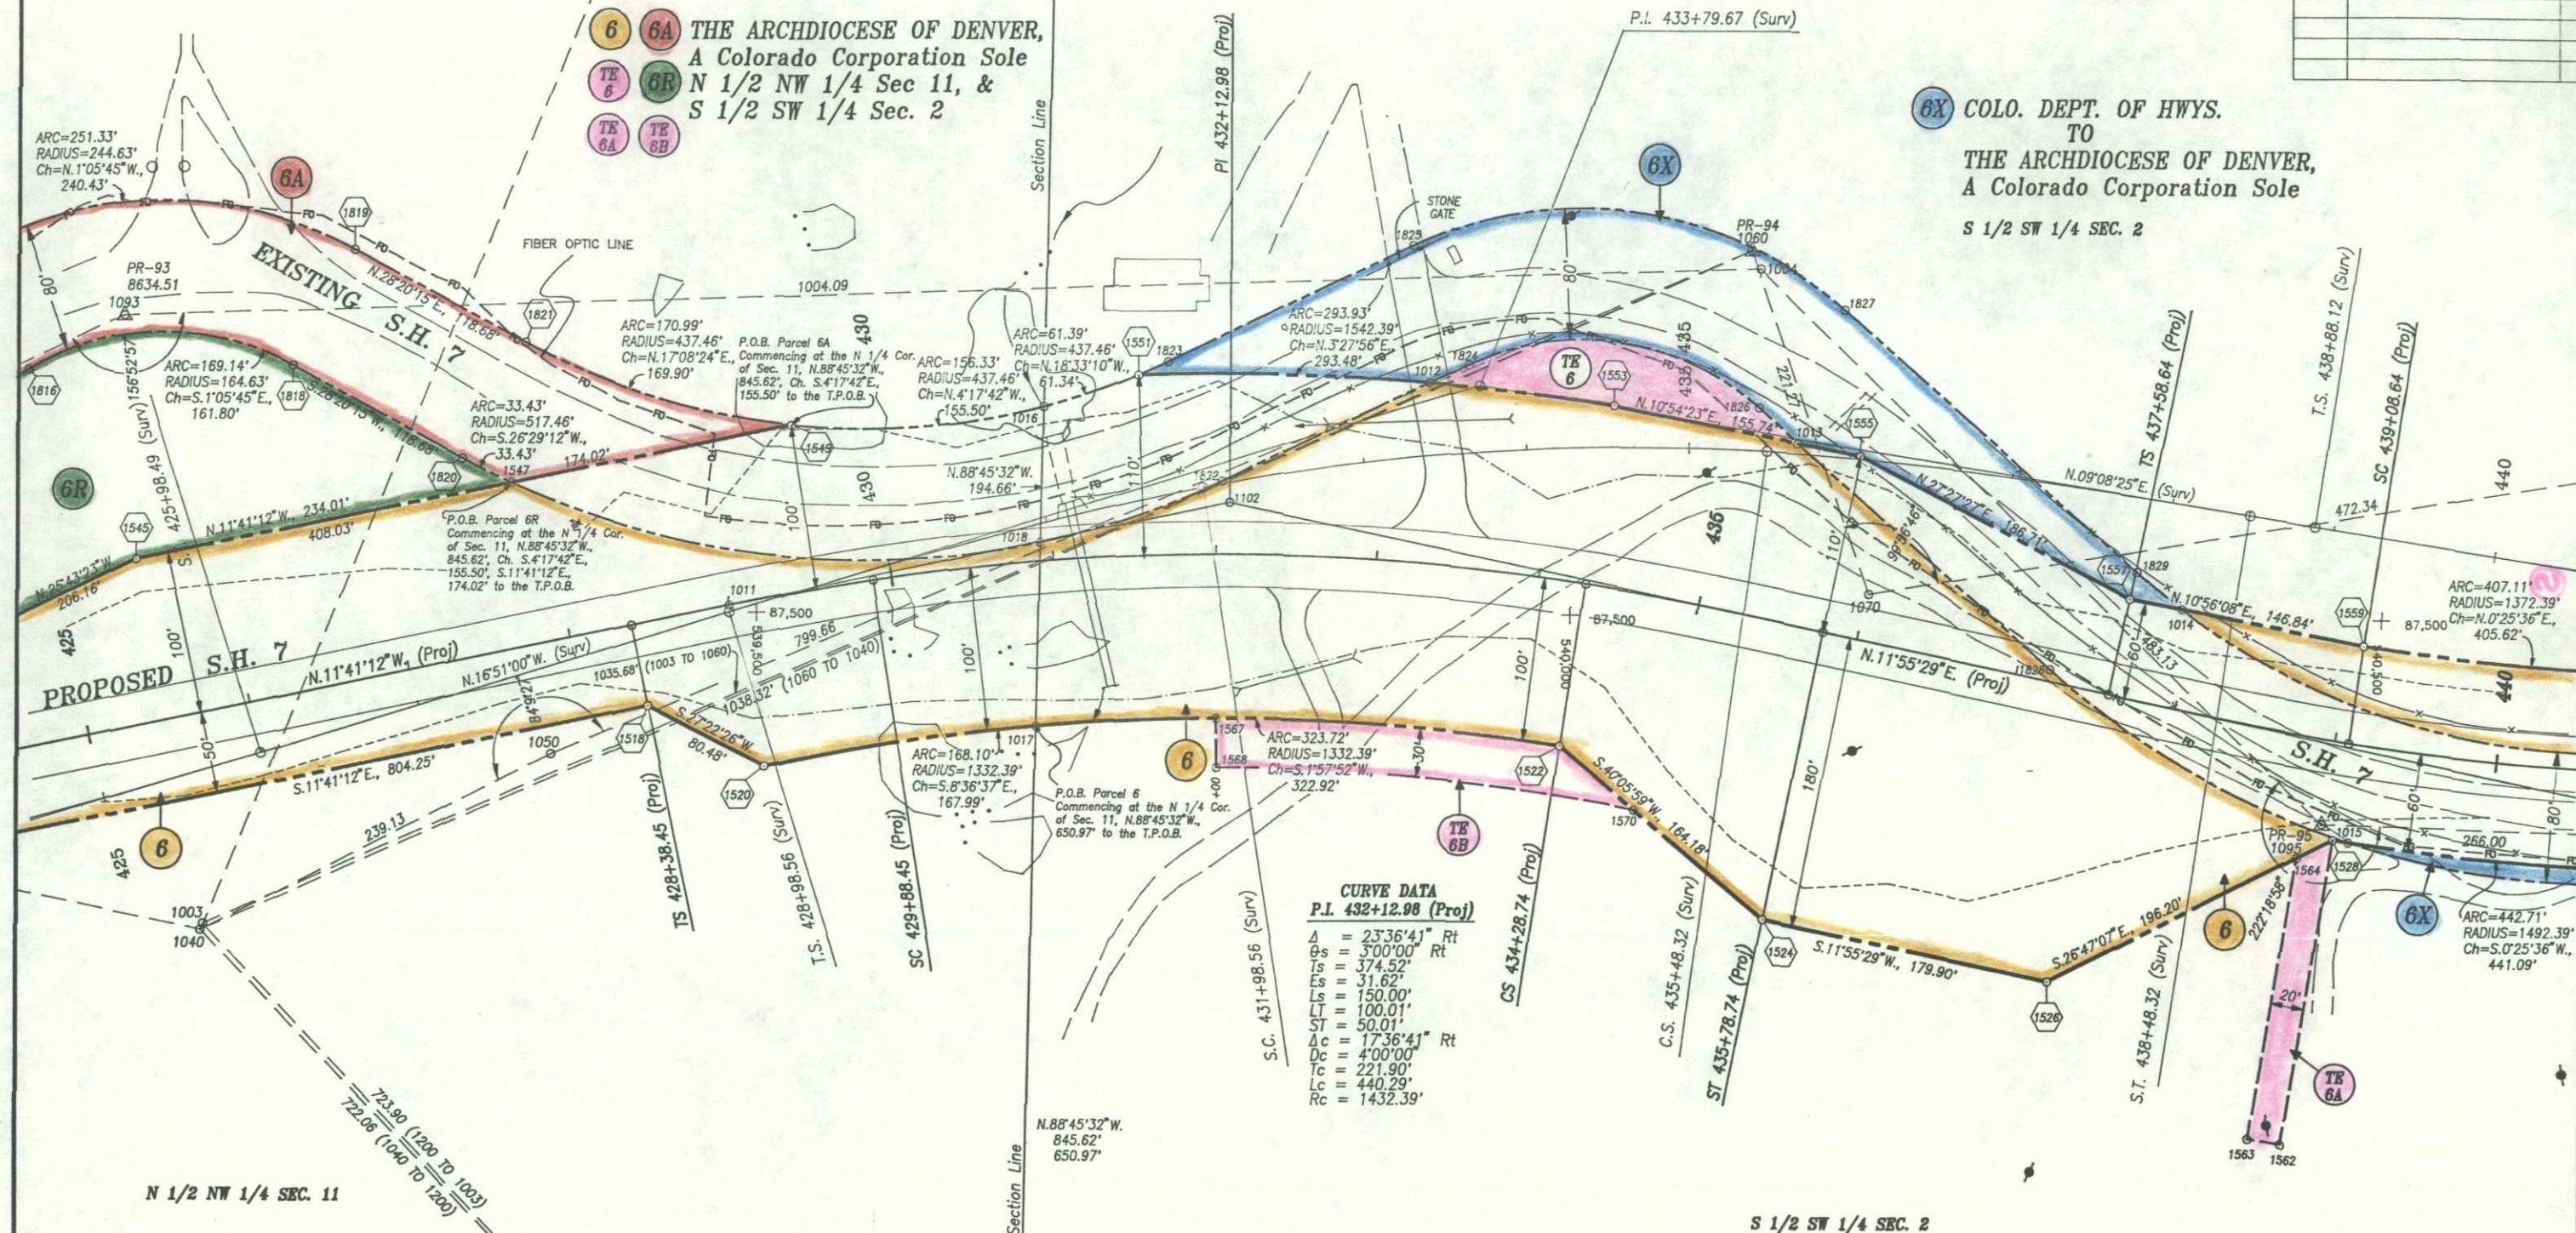

FED. ROAD REGION	DIVISION	PROJ. NO.	SHEET NO.	TOTAL SHEETS
VIII	COLORADO	RS(CX) 0007(7) & RS(CX) 0007(8)	7	12

RIGHT OF WAY	
NORTH OF MEEKER PARK AT ST. MALO	
REVISIONS	

T. 3 N., R. 73 W., 6TH P.M.

S 1/2 SW 1/4 SEC. 2

6 6X THE ARCHDIOCESE OF DENVER,
A Colorado Corporation Sole
N 1/2 NW 1/4 Sec 11, &
S 1/2 SW 1/4 Sec. 2

CURVE DATA
P.I. 441+25.14 (Proj)

$\Delta = 22^{\circ}59'47''$ Lt
 $\theta_s = 3^{\circ}00'00''$ Lt
 $T_s = 366.50'$
 $L_s = 30.00'$
 $L_t = 150.00'$
 $LT = 100.01'$
 $ST = 50.01'$
 $\Delta c = 16^{\circ}59'47''$ Lt
 $D_c = 4^{\circ}00'00''$
 $T_c = 214.03'$
 $L_c = 424.91'$
 $R_c = 1432.39'$

(SURV.) CURVE DATA
P.I. 445+24.68

$\Delta = 19^{\circ}16'13''$ $\theta = 03^{\circ}00'00''$
 $T_s = 636.56'$ $L_s = 300.00'$
 $\Delta c = 13^{\circ}16'13''$ $L.T. = 200.03'$
 $D_c = 02^{\circ}00'00''$ $S.T. = 100.03'$
 $L_c = 663.51'$
 $R_c = 2,864.79'$

FRY

N 1/2 SW 1/4 SEC. 2

HUMPHREY

McCORMICK

WOLFE

SKLAR

(SURV.) CURVE DATA
P.I. 457+41.17

$\Delta = 25^{\circ}59'25''$ $\theta = 06^{\circ}00'00''$
 $T_s = 481.12'$ $L_s = 300.00'$
 $\Delta c = 13^{\circ}59'25''$ $L.T. = 200.12'$
 $D_c = 04^{\circ}00'00''$ $S.T. = 100.11'$
 $L_c = 349.76'$
 $R_c = 1,432.39'$

PARAMUS, S. A.,
A Panamanian Corporation

KELLER


SUNDBERG

ZANETTE

N 1/2 SW 1/4 SEC. 2

S 1/2 SW 1/4 SEC. 2

225' APPROACH TO PROJECT
END PROJECT RS(CX) 0007(7) R.O.W.
END PROJECT RS(CX)-CX 0007(7) CONSTR.
STA. 443+50 M.P. 10.546

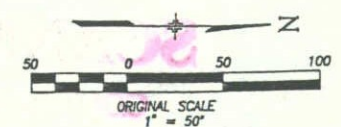

FED. ROAD REGION	DIVISION	PROJ. NO.	SHEET NO.	TOTAL SHEETS
VIII	COLORADO	RS(CX) 0007(7) & RS(CX) 0007(8)	8	12

RIGHT OF WAY			
REVISIONS			
3-25-91	REVISED PARCEL 21A, 23, 24, 25	D-4	
6-14-91	ADDED PERM. EASEMENT PE-24	D-4	

T. 4 N., R. 73 W., 6TH P.M.

21A REV RJA, INC. a Colorado Corporation
21X COLO. DEPT. OF HWYS
 TO
 RJA, INC. a Colorado Corporation
 To Be Abandon Subject to Highway
 Commission Approval
 NE 1/4 SEC. 27

LAKE

CURVE DATA
 PI 580+34.56
 $\Delta = 2^{\circ}04'06''$ Lt
 $D_c = 0^{\circ}30'00''$
 $T_c = 206.86'$
 $L_c = 413.66'$
 $R_c = 11459.16'$

S.H. 7
 TO MEEKER PARK

22 NO PARCEL

NE 1/4 SEC. 27

BEGIN R.O.W. PROJECT RS(CX) 0007(8)
 STATION 582+41.37 M.P. 7.91

BEGIN PROJECT RS(CX)-CX 0007(7) CONST.
 STA. 580+02.34 M.P. 7.96


 
225' APPROACH
 TO PROJECT

23 REV MARION E. KLEIN &
 JOYCE A. KLEIN J.T.

25 REV MARION E. KLEIN &
 JOYCE A. KLEIN J.T.

24 REV NORMAN L. GILCHREST &
 TRESA M. GILCHREST J.T.

24 NORMAN L. GILCHREST &
 TRESA M. GILCHREST J.T.
 TO
 MARION E. KLEIN &
 JOYCE A. KLEIN J.T.

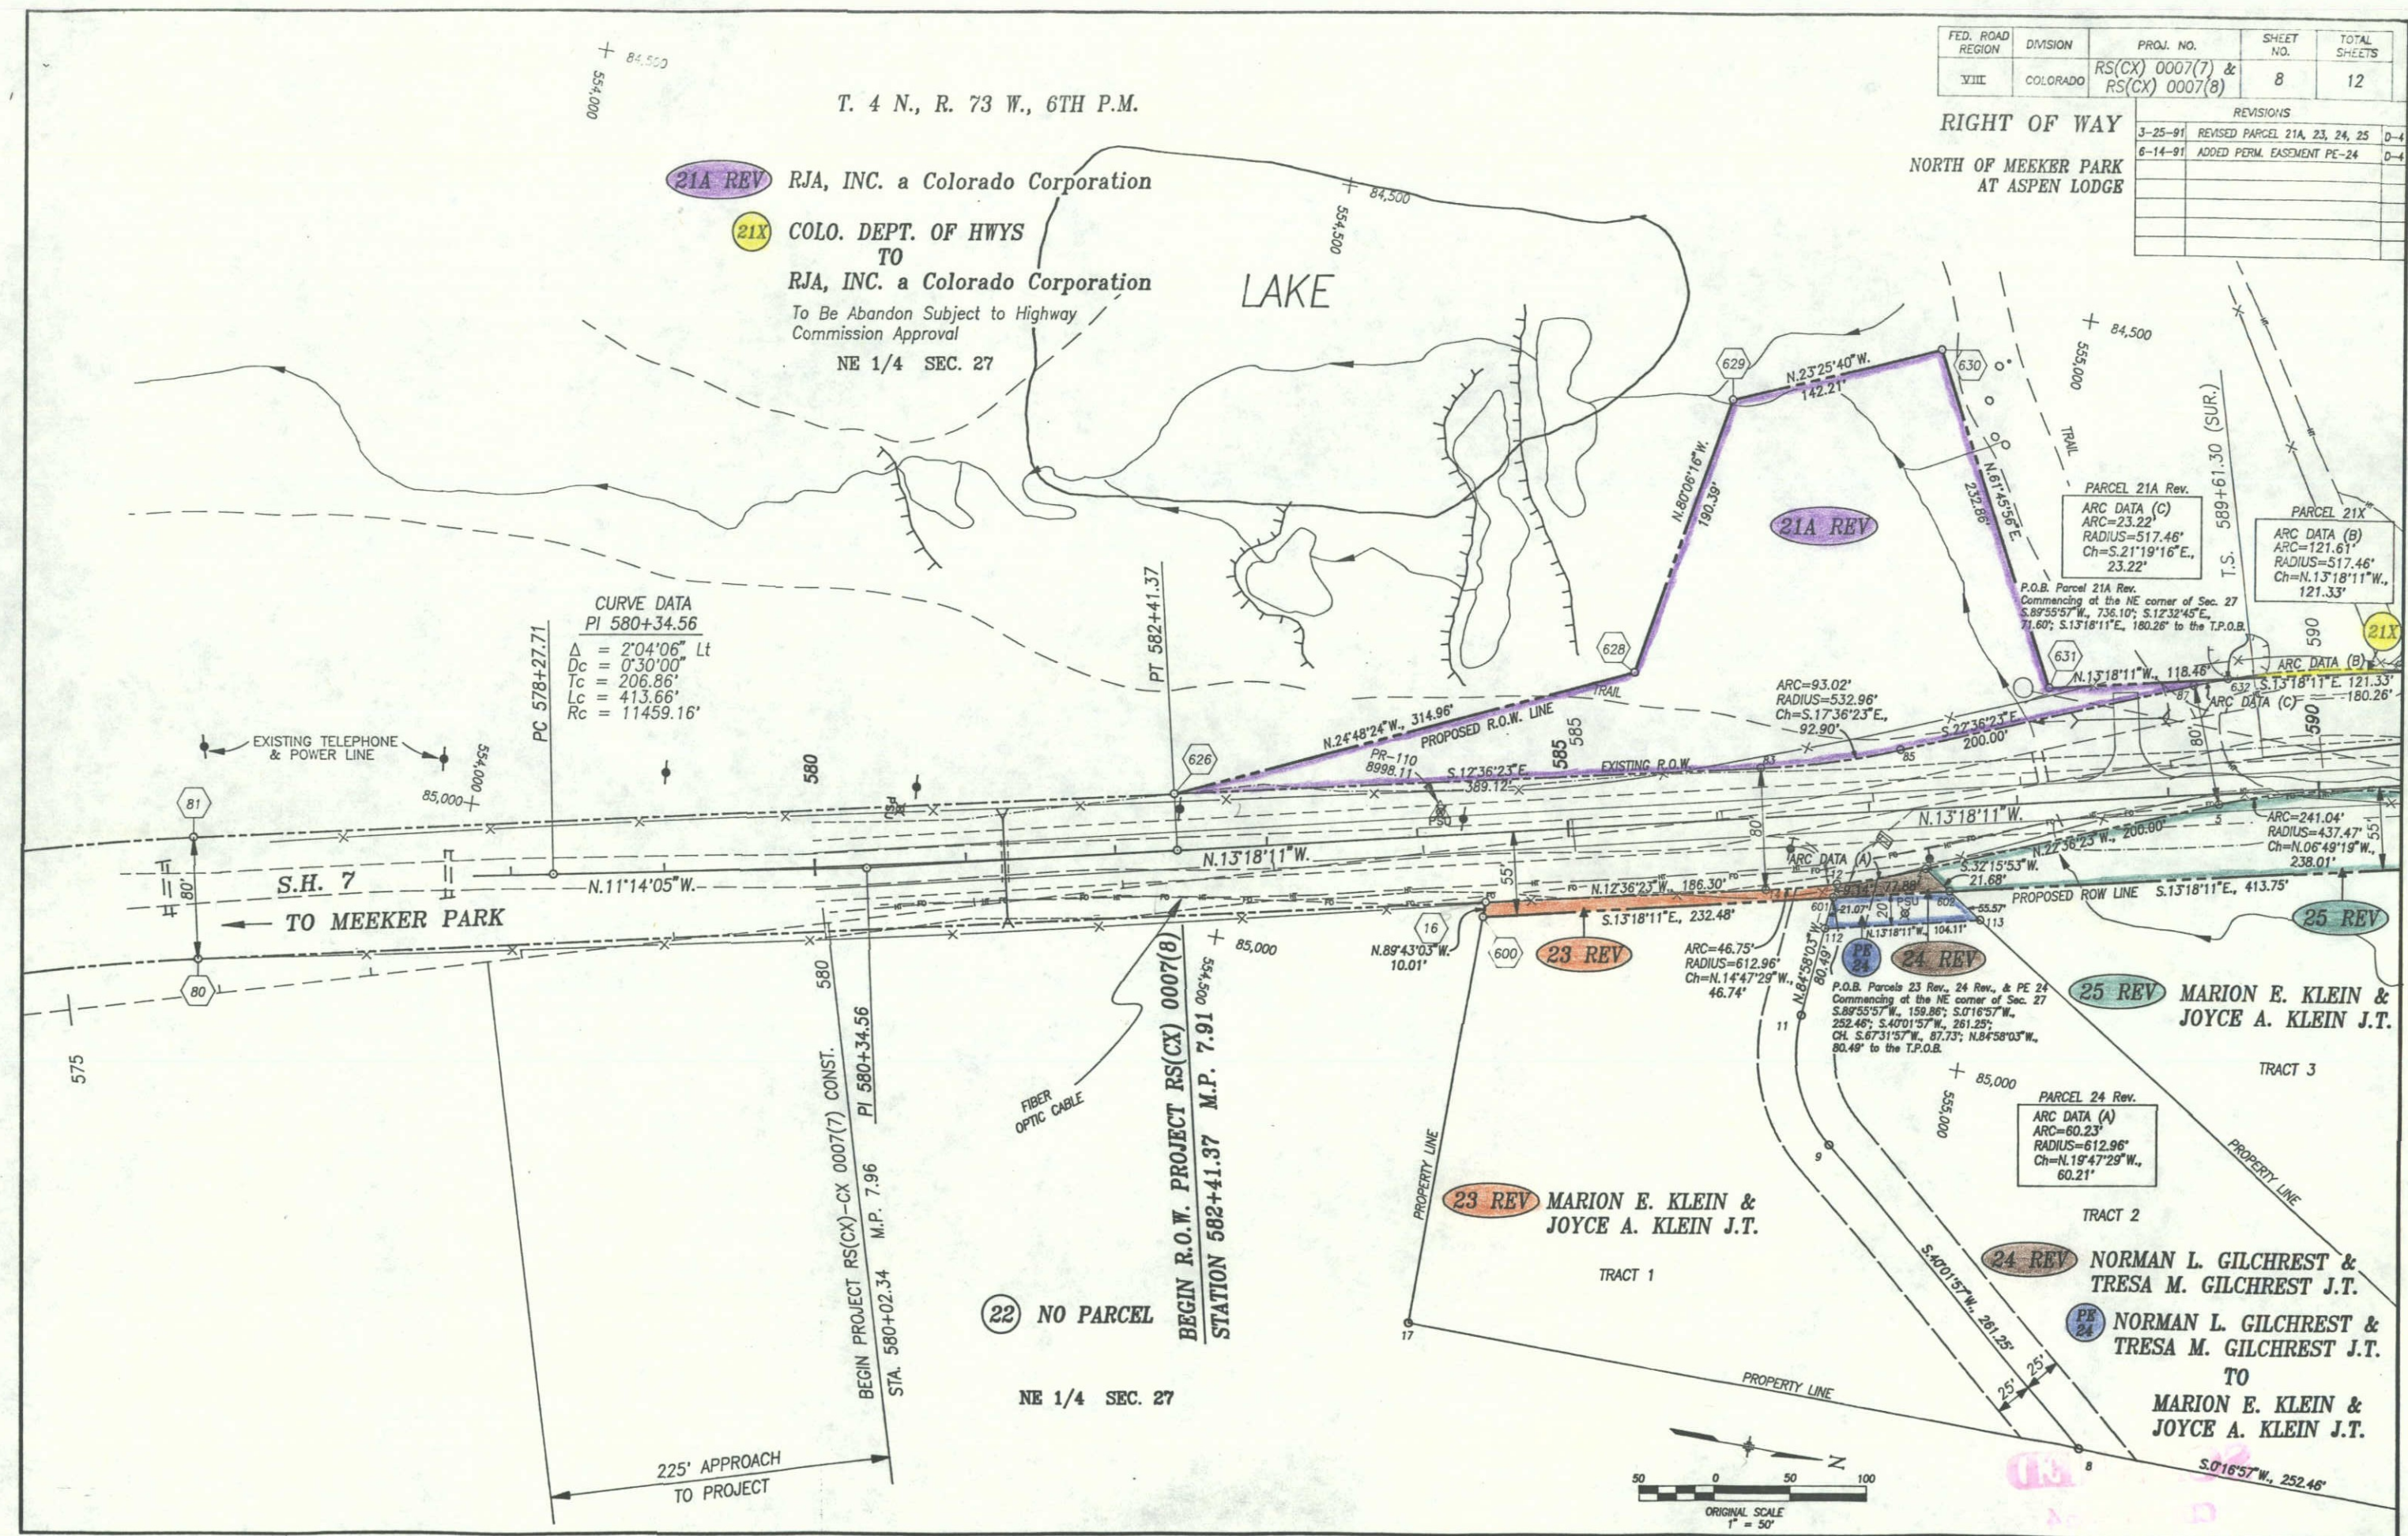


FED. ROAD REGION	DIVISION	PROJ. NO.	SHEET NO.	TOTAL SHEETS
VIII	COLORADO	RS(CX) 0007(7) & RS(CX) 0007(8)	9	12

RIGHT OF WAY

NORTH OF MEEKER PARK
AT ASPEN LODGE

REVISIONS		
3-25-91	REVISED PARCEL 27, TE 27, 24,25	D-4
3-25-91	ADDED E-27, TE-28A	D-4
9-17-91	NAME CHANGE PARCEL 26	D-4
12-8-91	DELETE PE-27	D-4

* Parcel 27X & 28X
will not be abandon
Scott & Elliott
have access to
there property
thru both of
these parcels.
ROW will remain
in old location
6/9/92 Dan Nichols

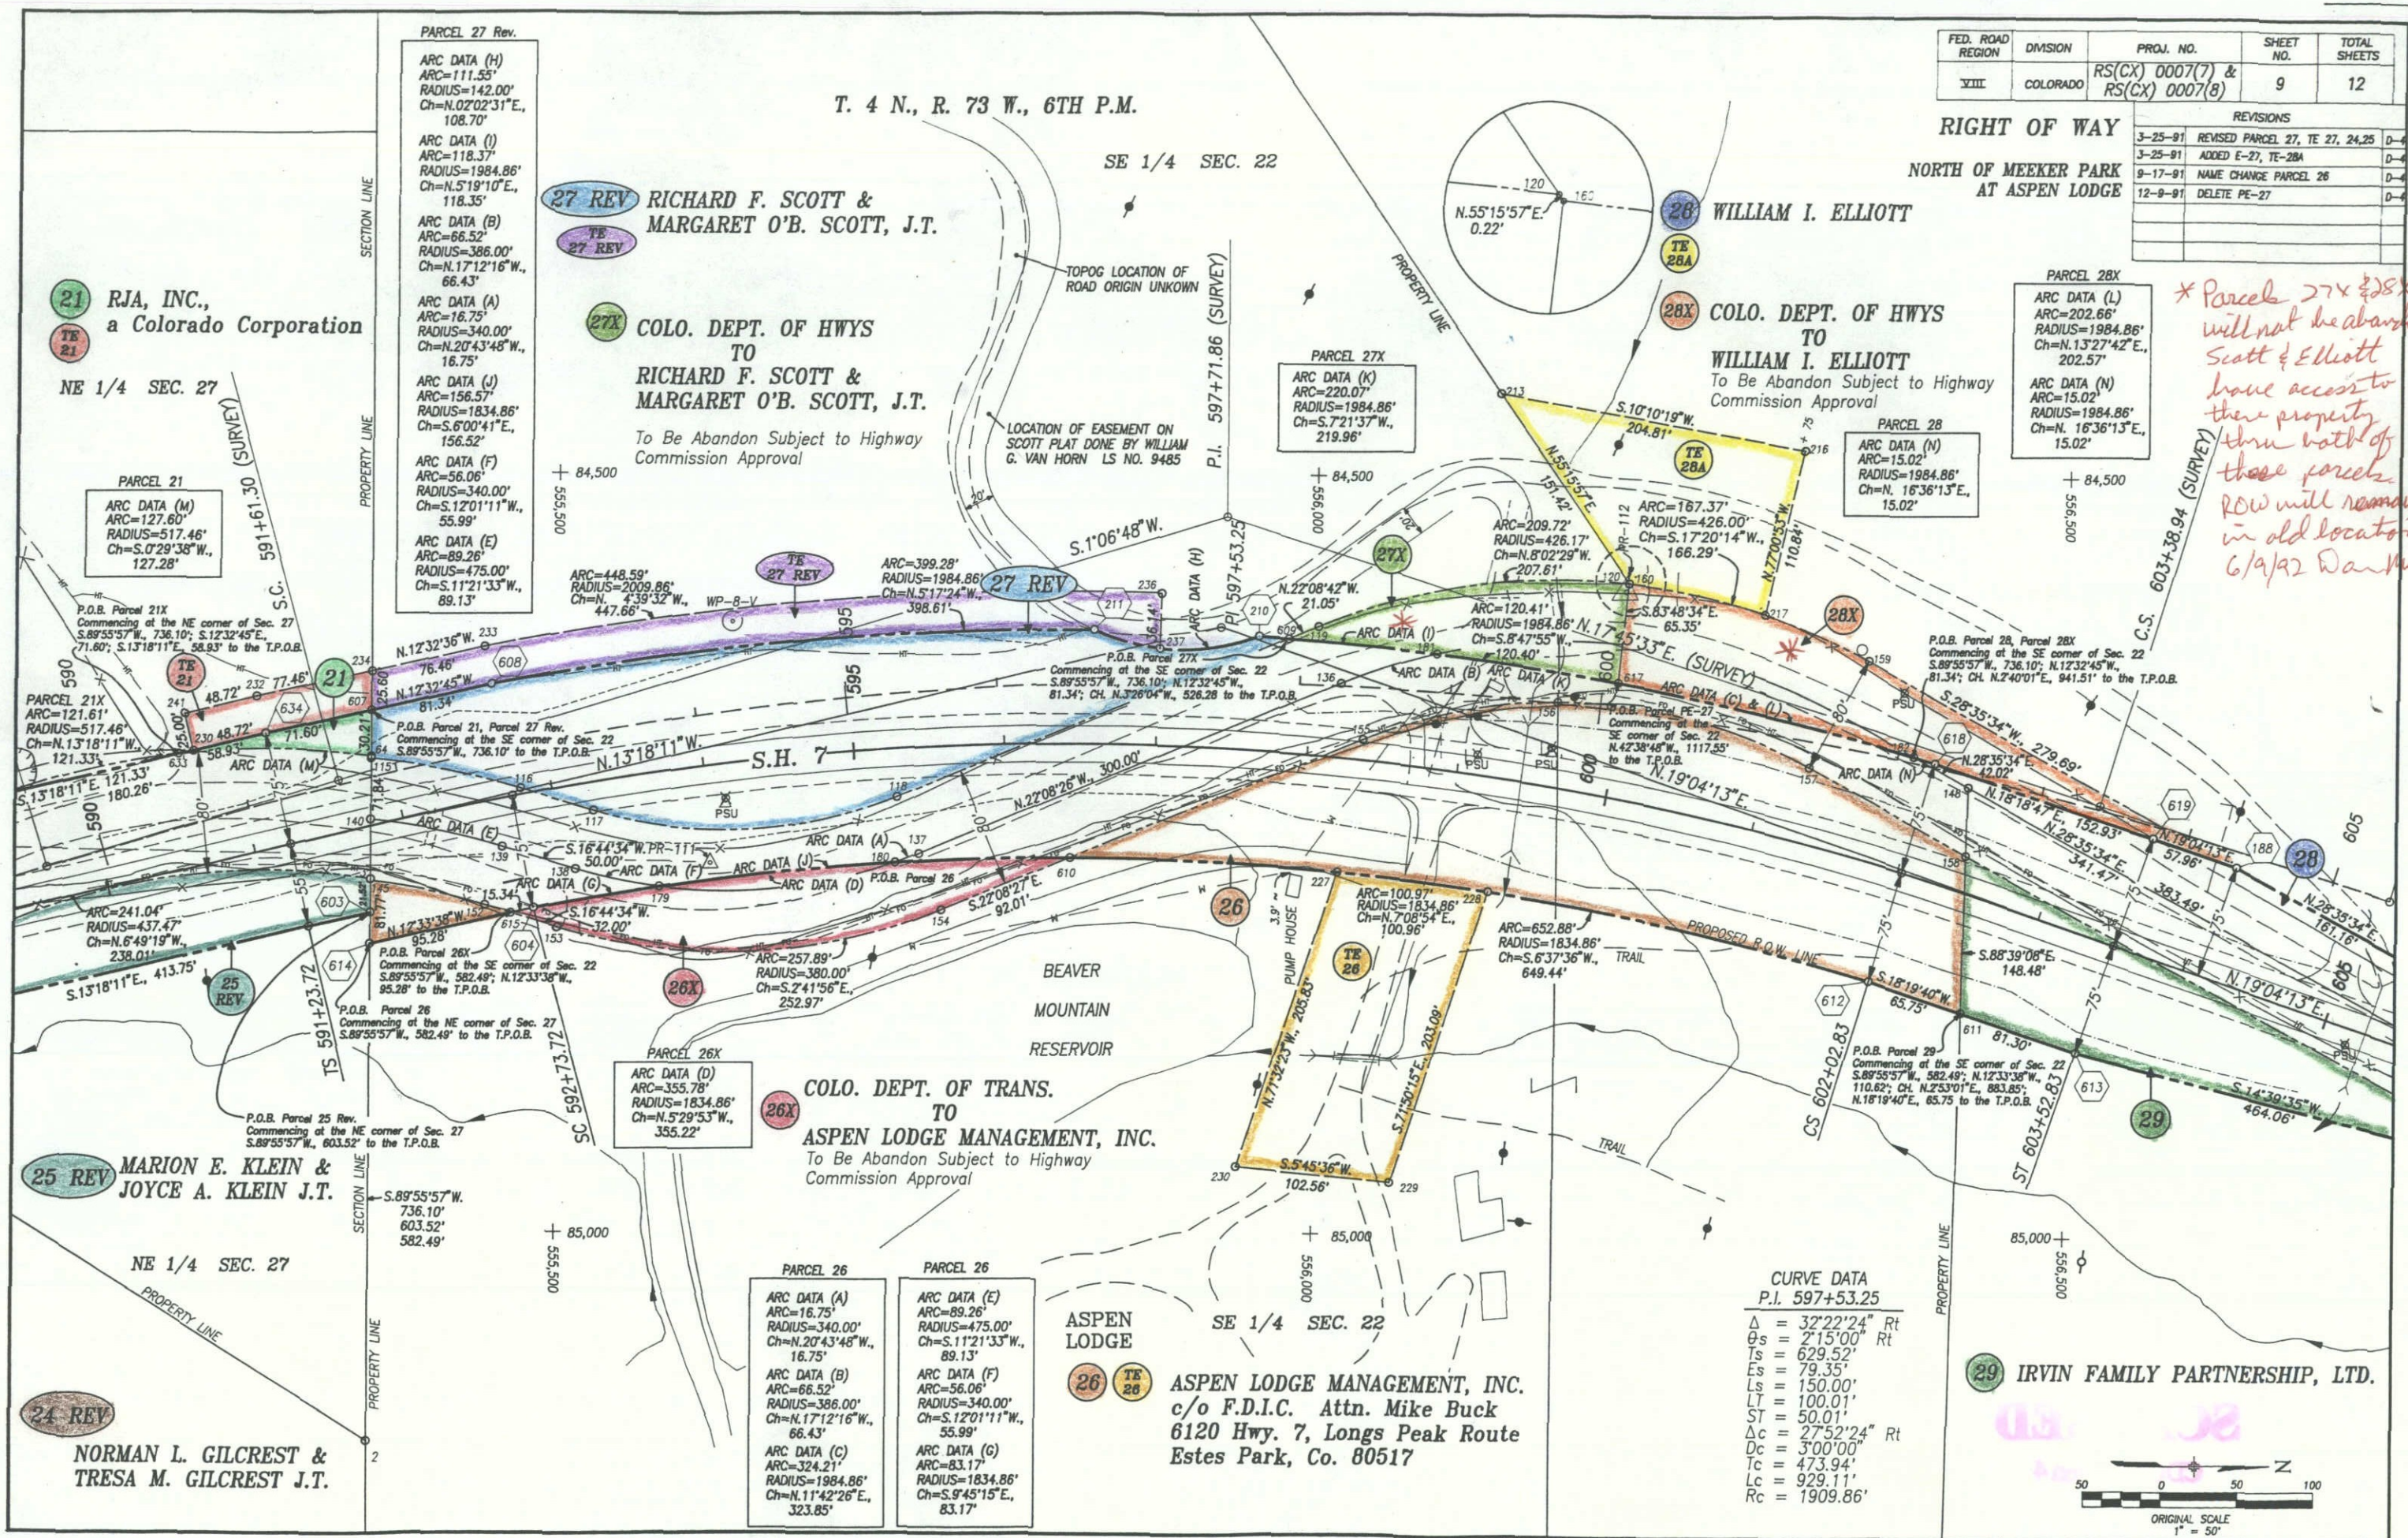

$$\begin{array}{r} 84,500 \\ - 557,000 \\ \hline \end{array}$$

RIGHT OF WAY		REVISIONS
NORTH OF MEEKER PARK AT ASPEN LODGE		

LAURENCE I. MOSS

SE 1/4 SEC. 22

CURVE DATA
PI 606+88.92


$\Delta = 4^{\circ}54'28''$ Lt
 $D_c = 2^{\circ}00'00''$
 $T_c = 122.78'$
 $L_c = 245.39'$
 $R_c = 2864.79'$

ARC DATA (A)
ARC=135.56'
RADIUS=540.00'
Ch=N.21°24'04"E.,
135.20'

SE 1/4 SEC. 22

END PROJECT RS(CX)-CX 0007(7) CONSTRUCTION
STA. 612+00 M.P. 7.35

225' APPROACH
TO PROJECT

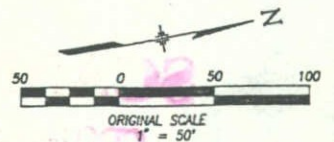

W. 1/4 SEC 11
FOUND B.L.M. BRASS CAP

T. 3 N., R. 73 W., 6TH P.M.
Section Line

N.W. COR SEC 11
FOUND B.L.M. BRASS CAP

FED. ROAD REGION	DIVISION	PROJ. NO.	SHEET NO.	TOTAL SHEETS
VIII	COLORADO	RS(CX) 0007(7) & RS(CX) 0007(8)	11	12

RIGHT OF WAY
OWNERSHIP MAP
NORTH OF MEEKER PARK
AT ST. MALO

REVISIONS		
5-13-91	ADDED TE-26A	D-4
6-10-91	ADDED TE-26B	D-4
7-01-91	ADDED TE3A, TE3B, TE4A, TE5A	D-4

N 1/2 NW 1/4 SEC. 11

S 1/2 NW 1/4 SEC. 11

S 1/2 SW 1/4 SEC. 2

N 1/2 SW 1/4 SEC. 2

SW 1/4 SEC. 11

1/4 Section Line
PROPERTY LINE

1/16th Section Line
PROPERTY LINE

Section Line

1/16th Section Line (Approx.)
PROPERTY LINE

5
TE 5
TE 5A
UNITED STATES OF AMERICA
With Permit to
Holiday Trails Inc.
S 1/2 NW 1/4 Sec. 11

5X
COLO. DEPT. OF HWYS.
TO
UNITED STATES OF AMERICA
To Be Abandon Subject to Highway
Commission Approval

6 6A THE ARCHDIOCESE OF DENVER,
A Colorado Corporation Sole
N 1/2 NW 1/4 Sec 11, &
S 1/2 SW 1/4 Sec. 2
TE 6
TE 6A
TE 6B

6X
COLO. DEPT. OF HWYS.
TO
THE ARCHDIOCESE OF DENVER,
To Be Abandon Subject to Highway
Commission Approval

TE 1
THE CLARICE ALDRIDGE MELTON
REVOCABLE LIVING TRUST
1010 CHAUTAUQUA
NORMAN, OKLAHOMA 73072
NW 1/4 SE 1/4 SEC. 11

1/4 Section Line
PROPERTY LINE

N. 1/4 SEC 11
FOUND COOH ALUM. 3 1/4" DISK

THE ARCHDIOCESE OF DENVER,
PROPERTY LINE

PARAMUS S. A.

END R.O.W. PROJECT RS(CX) CX 0007(7)
END PROJECT RS(CX)-CX 0007(7) CONSTRUCTION
STATION 443+50.00 MP 10.546

SE 1/4 SEC. 2

TE 3
TE 3A
TE 3B
MONROE S. COX & EARLENE I. COX
MT. MEEKER ESTATES
ALLENSPARK, COLORADO
W 1/2 NE 1/4 SEC. 11

TE 4
TE 4A
LAWRENCE A. KROHA & WILMA M. KROHA, J.T.
20 SHORECREST CIRCLE
GROSSE POINTE, MICHIGAN 48236
SW 1/4 NE 1/4 SEC. 11

BEGIN R.O.W. PROJECT RS(CX) 0007(7)
BEGIN PROJECT RS(CX)-CX 0007(7) CONSTRUCTION
STATION 400+00.00 MP 11.370

LORRIE JANE ADRIAN & WILLIAM BRYAN
ADRIAN JR. ET AL
c/o D. T. GORDON
7393 S. WASHINGTON CIRCLE
LITTLETON, COLORADO 80122
NW 1/4 SE 1/4 SEC. 11



FED. ROAD REGION	DIVISION	PROJ. NO.	SHEET NO.	TOTAL SHEETS
VIII	COLORADO	RS(CX) 0007(7) & RS(CX) 0007(8)	12	12

REVISIONS			
3-25-91	REVISED PARCELS 21A, 27 & TE-27	D-4	
3-25-91	REVISED PARCELS 23, 24 & 25	D-4	
3-25-91	ADDED EASEMENTS PE-27, TE-28A	D-4	
6-14-91	ADDED EASEMENTS PE-24	D-4	
9-17-91	NAME CHANGE PARCEL 26	D-4	
12-9-91	DELETE PE-27	D-4	

RIGHT OF WAY
NORTH OF MEEKER PARK
AT ASPEN LODGE
OWNERSHIP MAP

JEAN M. SUTHERLAND &
THOMAS M. SUTHERLAND

LAURENCE I. MOSS
PARCEL NO. 1 (34220-00-025)

LAURENCE I. MOSS
5769 LONGS PEAK ROUTE
ESTES PARK, COLORADO 80517
TR IN E 1/2 SEC. 22
PARCEL NO. 2 (34220-00-026)

29 IRVIN FAMILY PARTNERSHIP, LTD.
P. O. BOX 3410
ESTES PARK, COLORADO 80517
PT. SE 1/4 SE 1/4 SEC 22 & S 1/2 SW 1/4 SEC 23

T. 4 N., R. 73 W., 6TH P.M.

27 REV RICHARD F. SCOTT &
MARGARET O'B SCOTT
P.O. BOX 3378
ESTES PARK, COLORADO 80517
TR IN NW 1/4 NE 1/4 SEC. 27 &
S 1/2 SE 1/4 SEC. 22
27X COLO. DEPT. OF HWYS
TO
RICHARD F. SCOTT &
MARGARET O'B SCOTT

28 TE WILLIAM I. ELLIOTT
1808 10TH STREET
GREELEY, COLORADO 80631
TR IN E 1/2 SEC 22
28A
28X COLO. DEPT. OF HWYS
TO
WILLIAM I. ELLIOTT
To Be Abandon Subject to Highway
Commission Approval

RICHARD F. SCOTT &
MARGARET O'B SCOTT

RICHARD F. SCOTT &
MARGARET O'B SCOTT


26 ASPEN LODGE MANAGEMENT, INC.
c/o F.D.I.C. Attn. Mike Buck
6120 Hwy. 7, Longs Peak Route
Estes Park, Co. 80517
TE 26
26X COLO. DEPT. OF TRANS.
TO
ASPEN LODGE MANAGEMENT, INC.
To Be Abandon Subject to Highway
Commission Approval

23 REV MARION E. KLEIN &
JOYCE A. KLEIN J.T.
25 REV P.O. BOX 478
ESTES PARK, COLORADO 80517
TR IN NE 1/4 NE 1/4 SEC. 27

24 REV NORMAN L. GILCHREST &
TRESA M. GILCHREST J.T.
148 WEST TINSLEY
WACO TEXAS 76706
TR IN NE 1/4 NE 1/4 SEC. 27
PE 24 NORMAN L. GILCHREST &
TRESA M. GILCHREST J.T.
TO
MARION E. KLEIN &
JOYCE A. KLEIN J.T.

21 21A REV R J A, INC., A Colorado Corporation
P.O. BOX 2210
ESTES PARK, COLORADO 80517
TE 21
21X COLO. DEPT. OF HWYS
TO
R J A, INC., A Colorado Corporation
To Be Abandon Subject to Highway
Commission Approval

23 REV MARION E. KLEIN &
JOYCE A. KLEIN J.T.
24 REV NORMAN L. GILCHREST &
TRESA M. GILCHREST J.T.
25 REV P.O. BOX 478
ESTES PARK, COLORADO 80517
TR IN NE 1/4 NE 1/4 SEC. 27

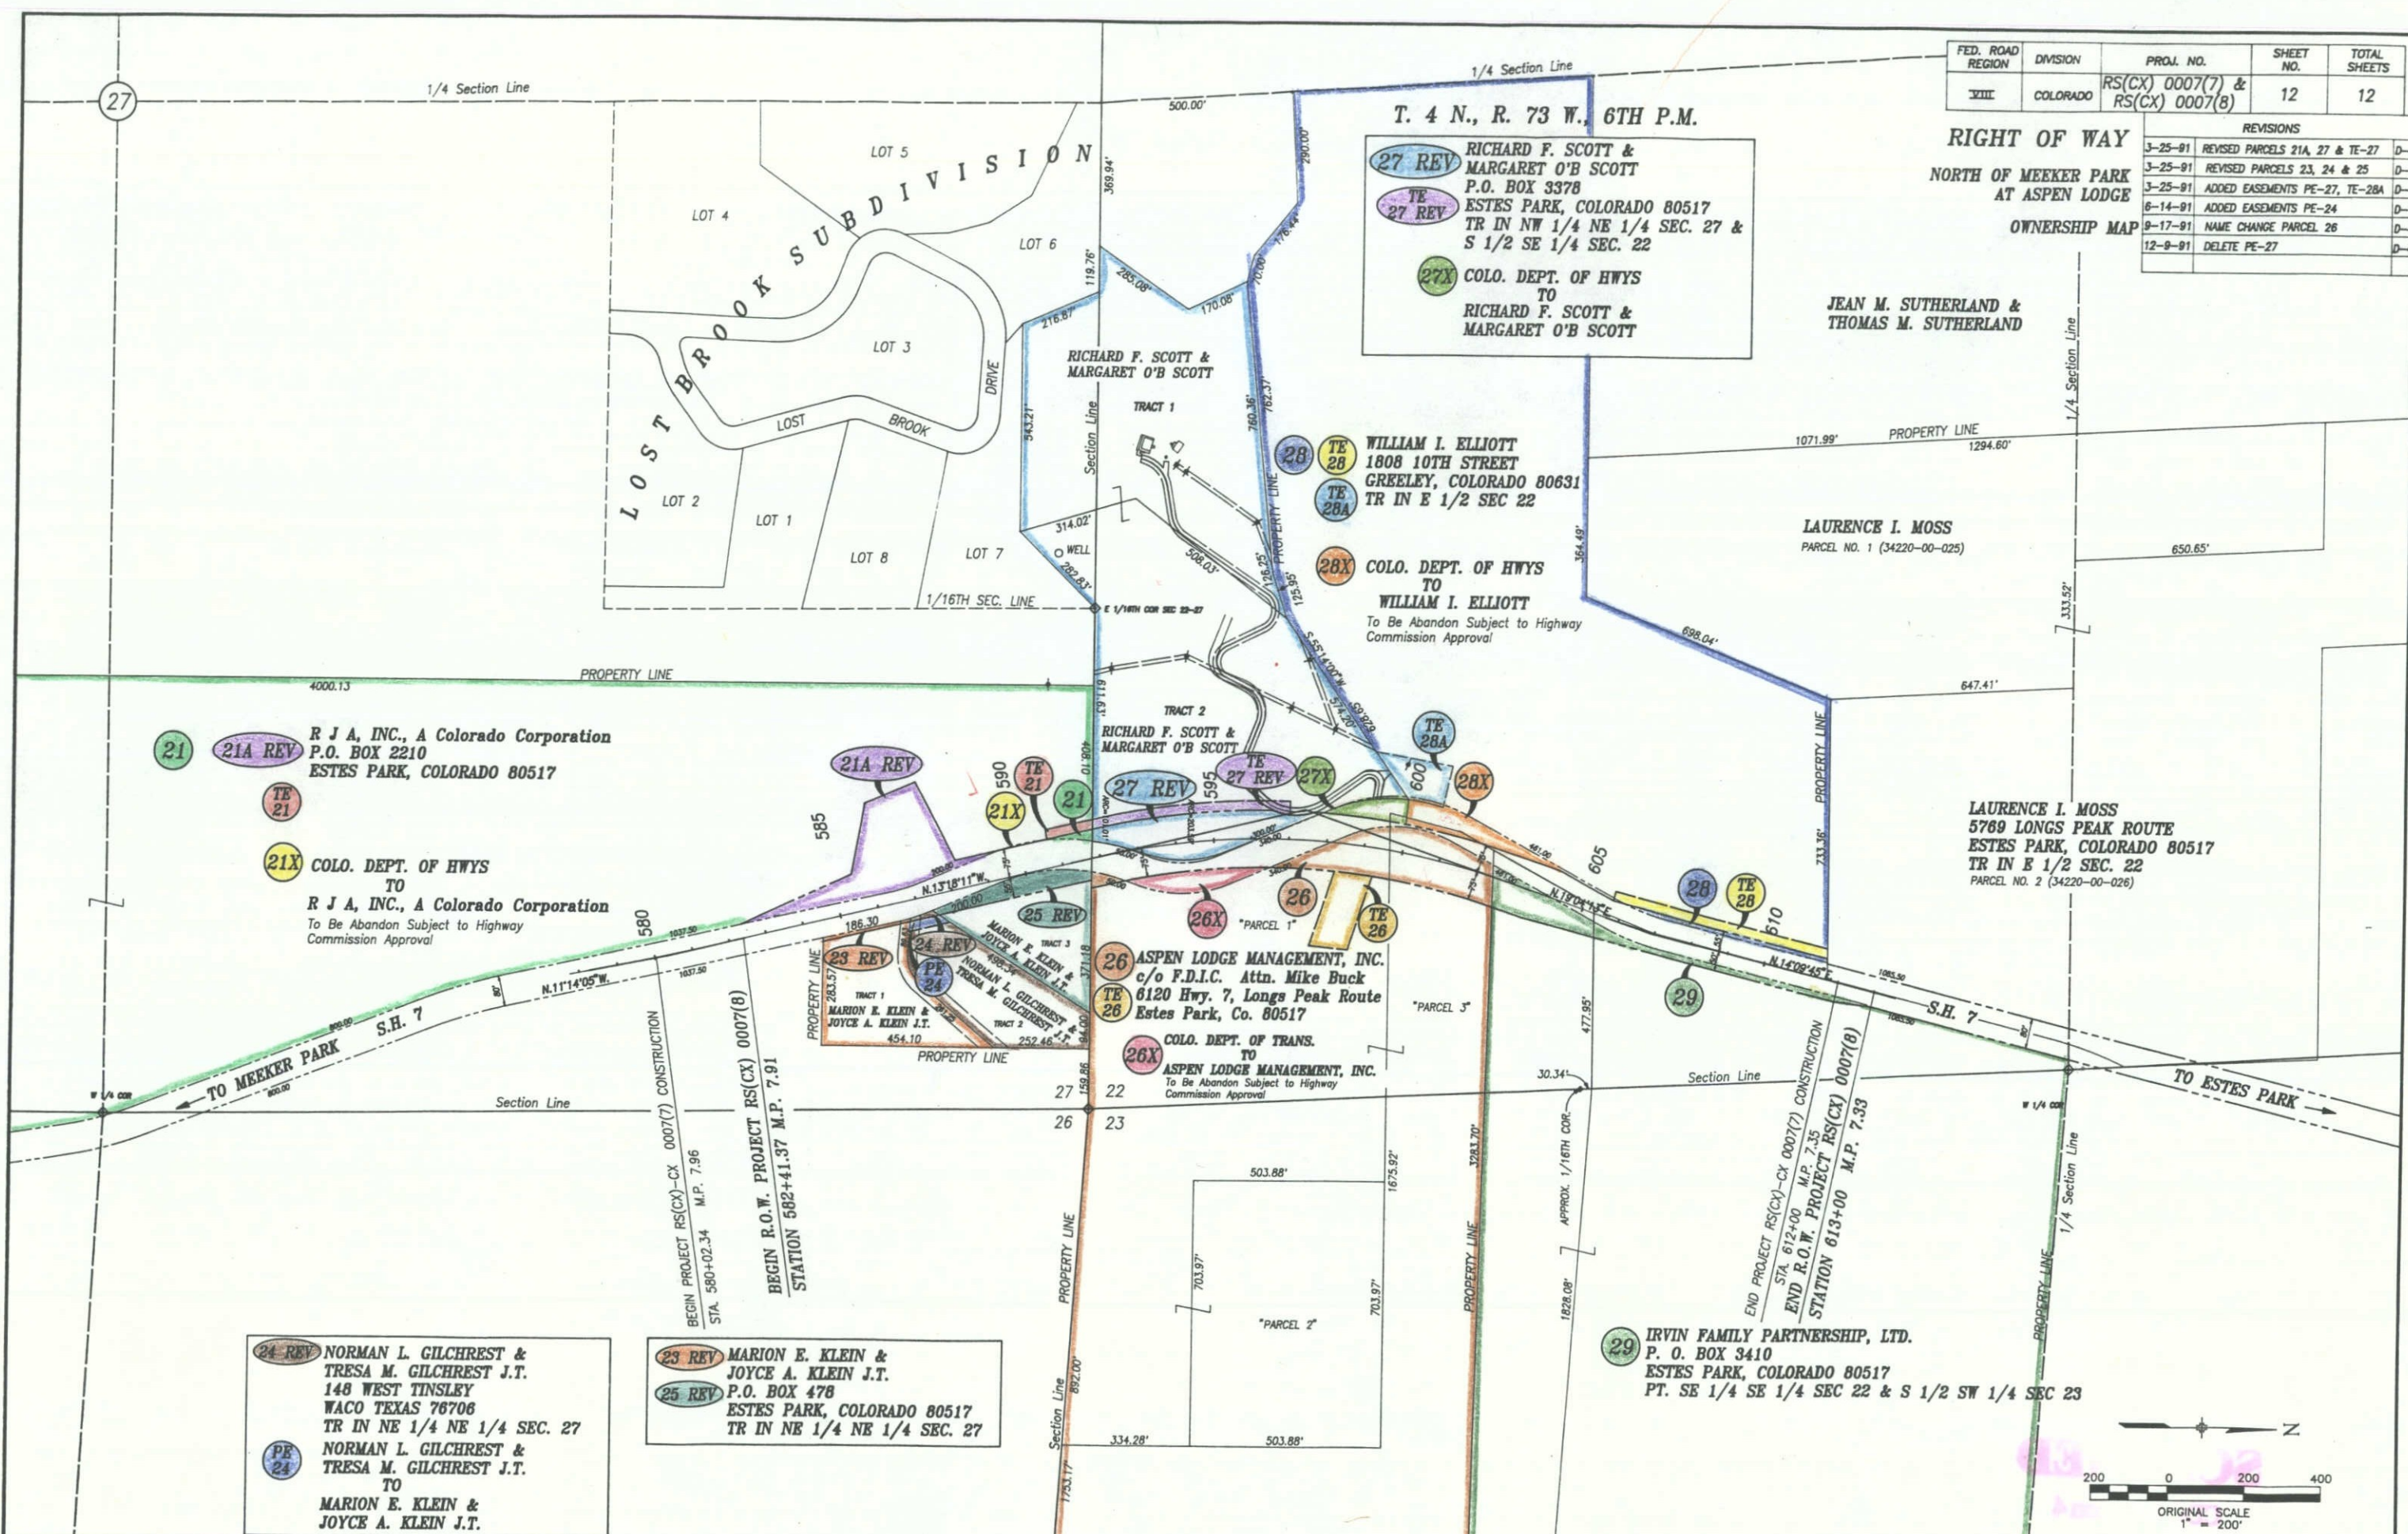

may exchange + dupl 2303-D - Comm - JACARD.