



I: \97154\ACAD\SHEET\A7154450.dwg Thu Feb 12 15:27:05 1998 Jeffery Dankenbring

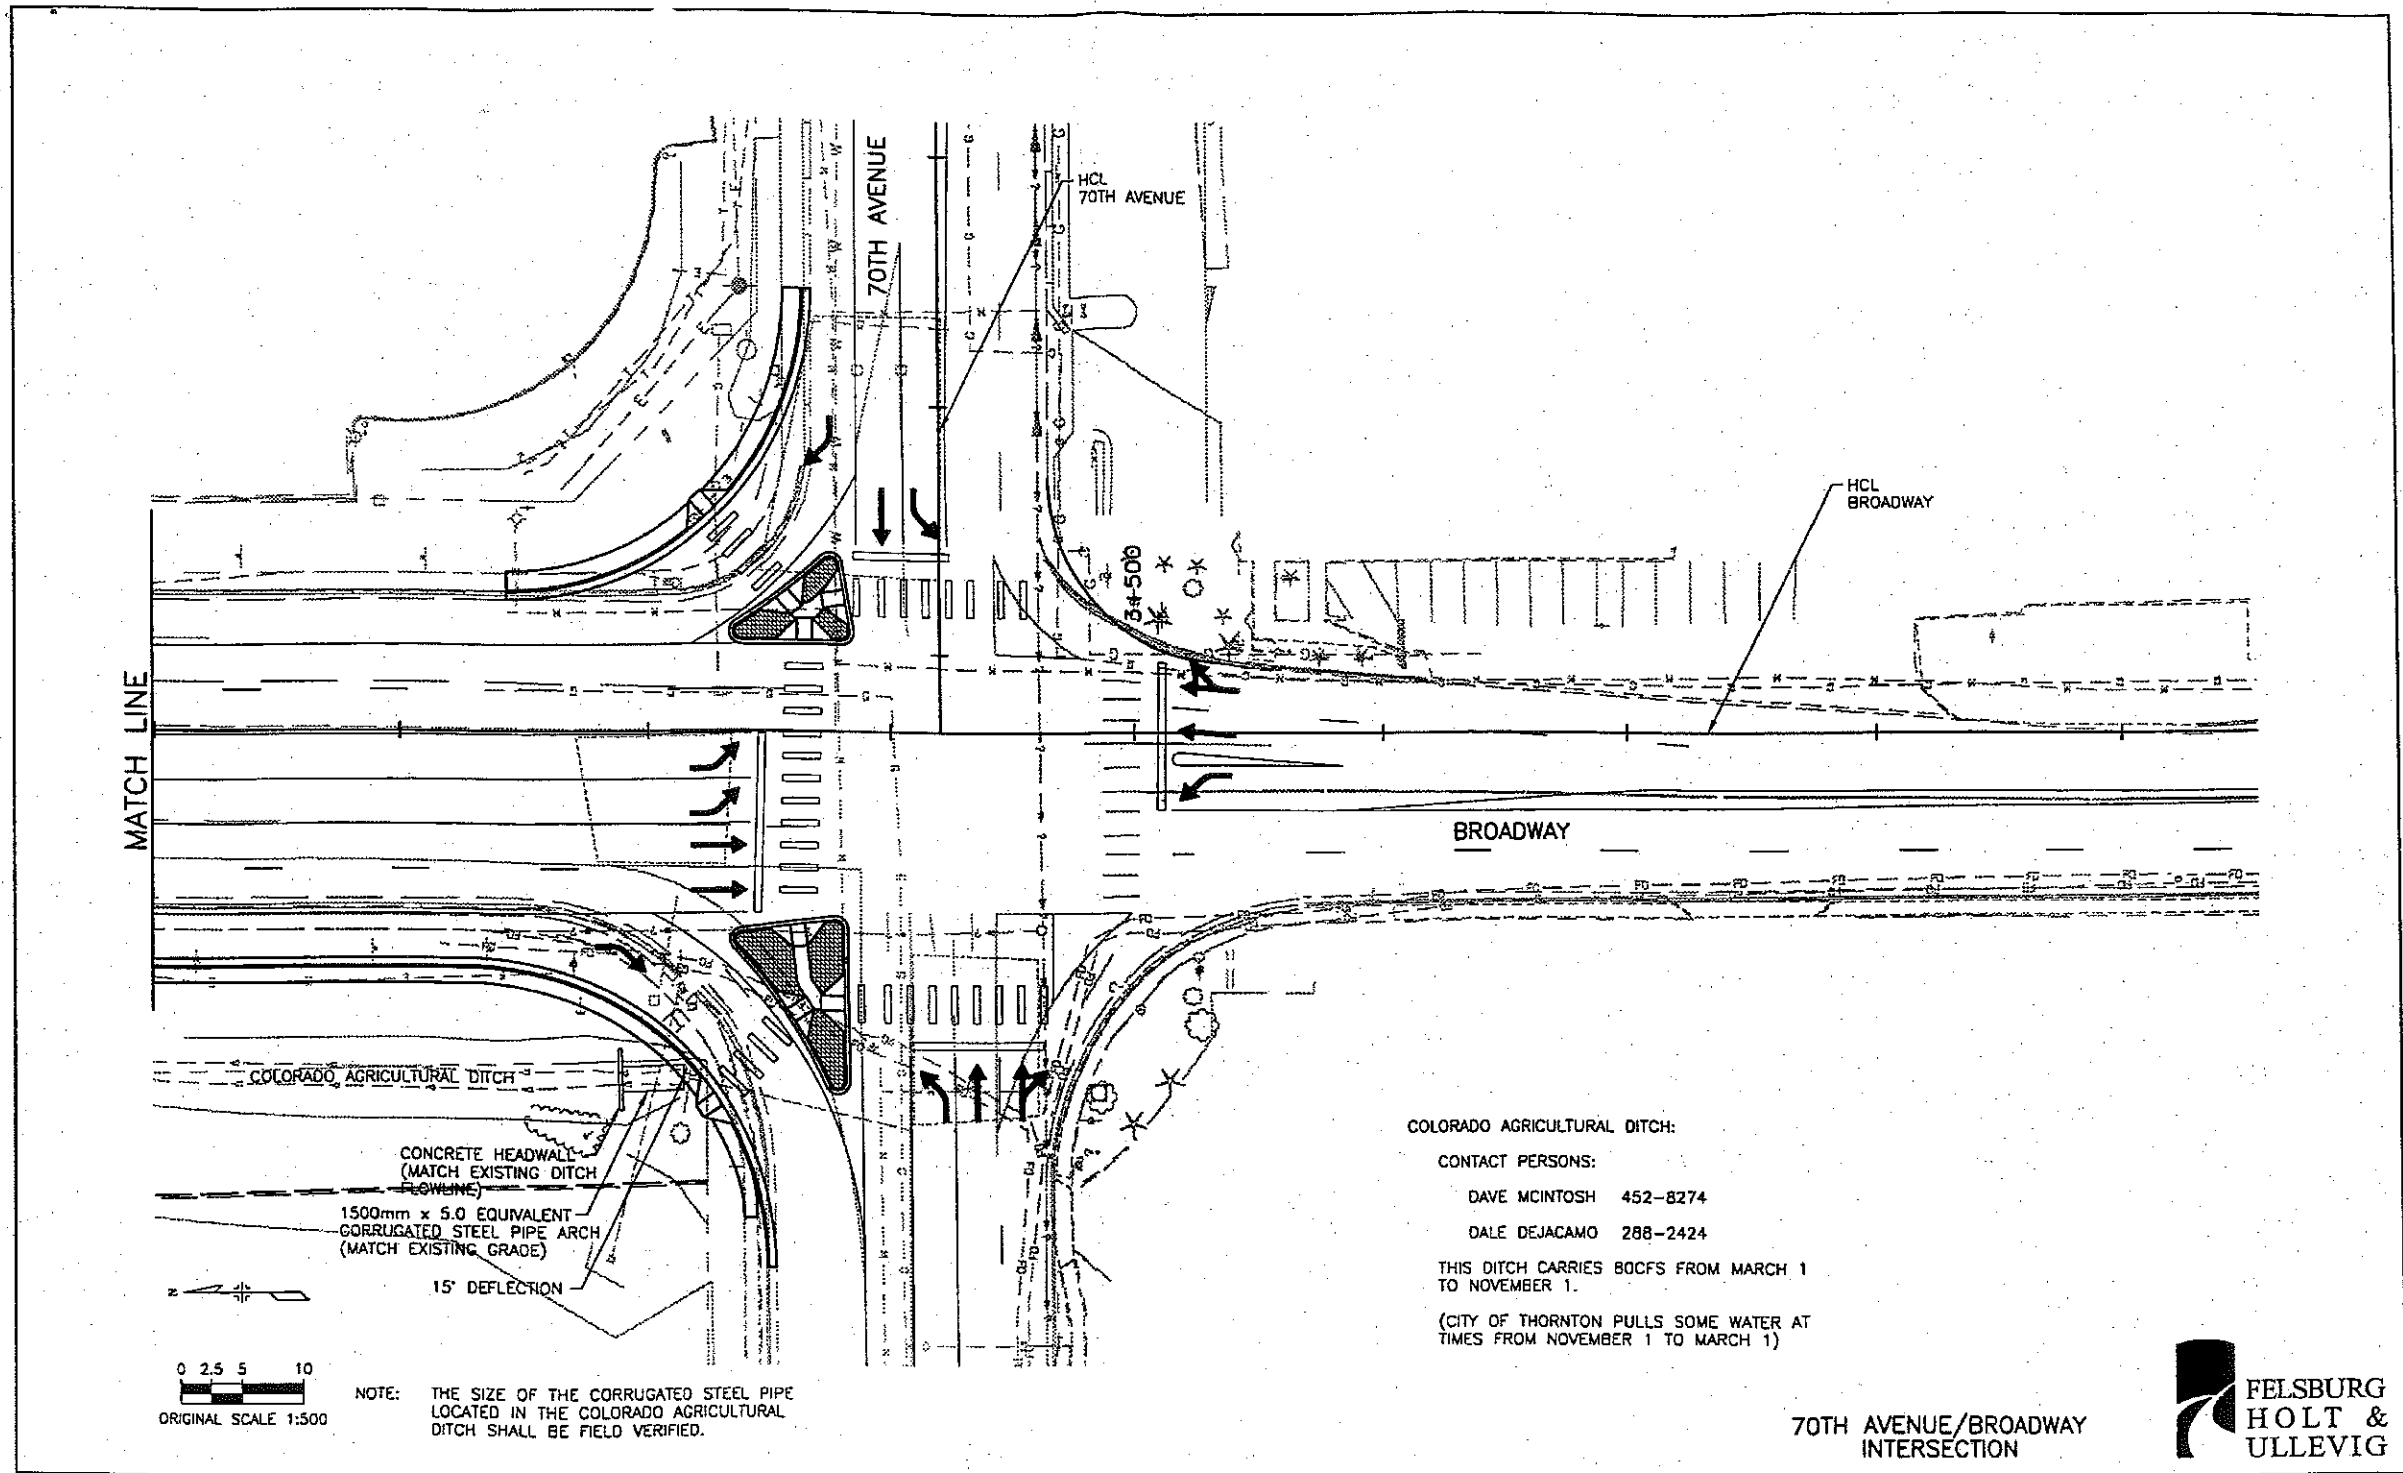


COLORADO AGRICULTURAL DITCH:
 CONTACT PERSONS:
 DAVE MCINTOSH 452-8274
 DALE DEJACAMO 288-2424
 THIS DITCH CARRIES 80CFS FROM MARCH 1 TO NOVEMBER 1.
 (CITY OF THORNTON PULLS SOME WATER AT TIMES FROM NOVEMBER 1 TO MARCH 1)

70TH AVENUE/BROADWAY INTERSECTION



Computer File Information Creation Date: 02/12/98 Initials: JWD Last Modification Date: Initials: Full Path: g:\97154\acad\sheet\ Drawing File Name: A7154450.DWG Acad Ver. R14 Scale: 1:500 Units: Metric		Index of Revisions <table border="1"> <tr><td> </td><td> </td><td> </td></tr> <tr><td> </td><td> </td><td> </td></tr> <tr><td> </td><td> </td><td> </td></tr> </table>											Colorado Department of Transportation  2000 S. Holly Street Denver, CO 80222 Phone: (303) 757-9255 FAX: (303) 757-9053 Region 6 Design MA/APH		As Constructed No Revisions: Revised: Void:		DRAINAGE PLAN Designer: JWD Detailer: JWD Sheet Subset: Roadway Subset Sheets: DP-1 of 2		Project No./Code SP 0253-150 11918 Sheet Number	

I:\97154\ACAD\SHEET\A7154451.dwg Thu Feb 12 15:25:51 1998 Jeffery Dankenbring

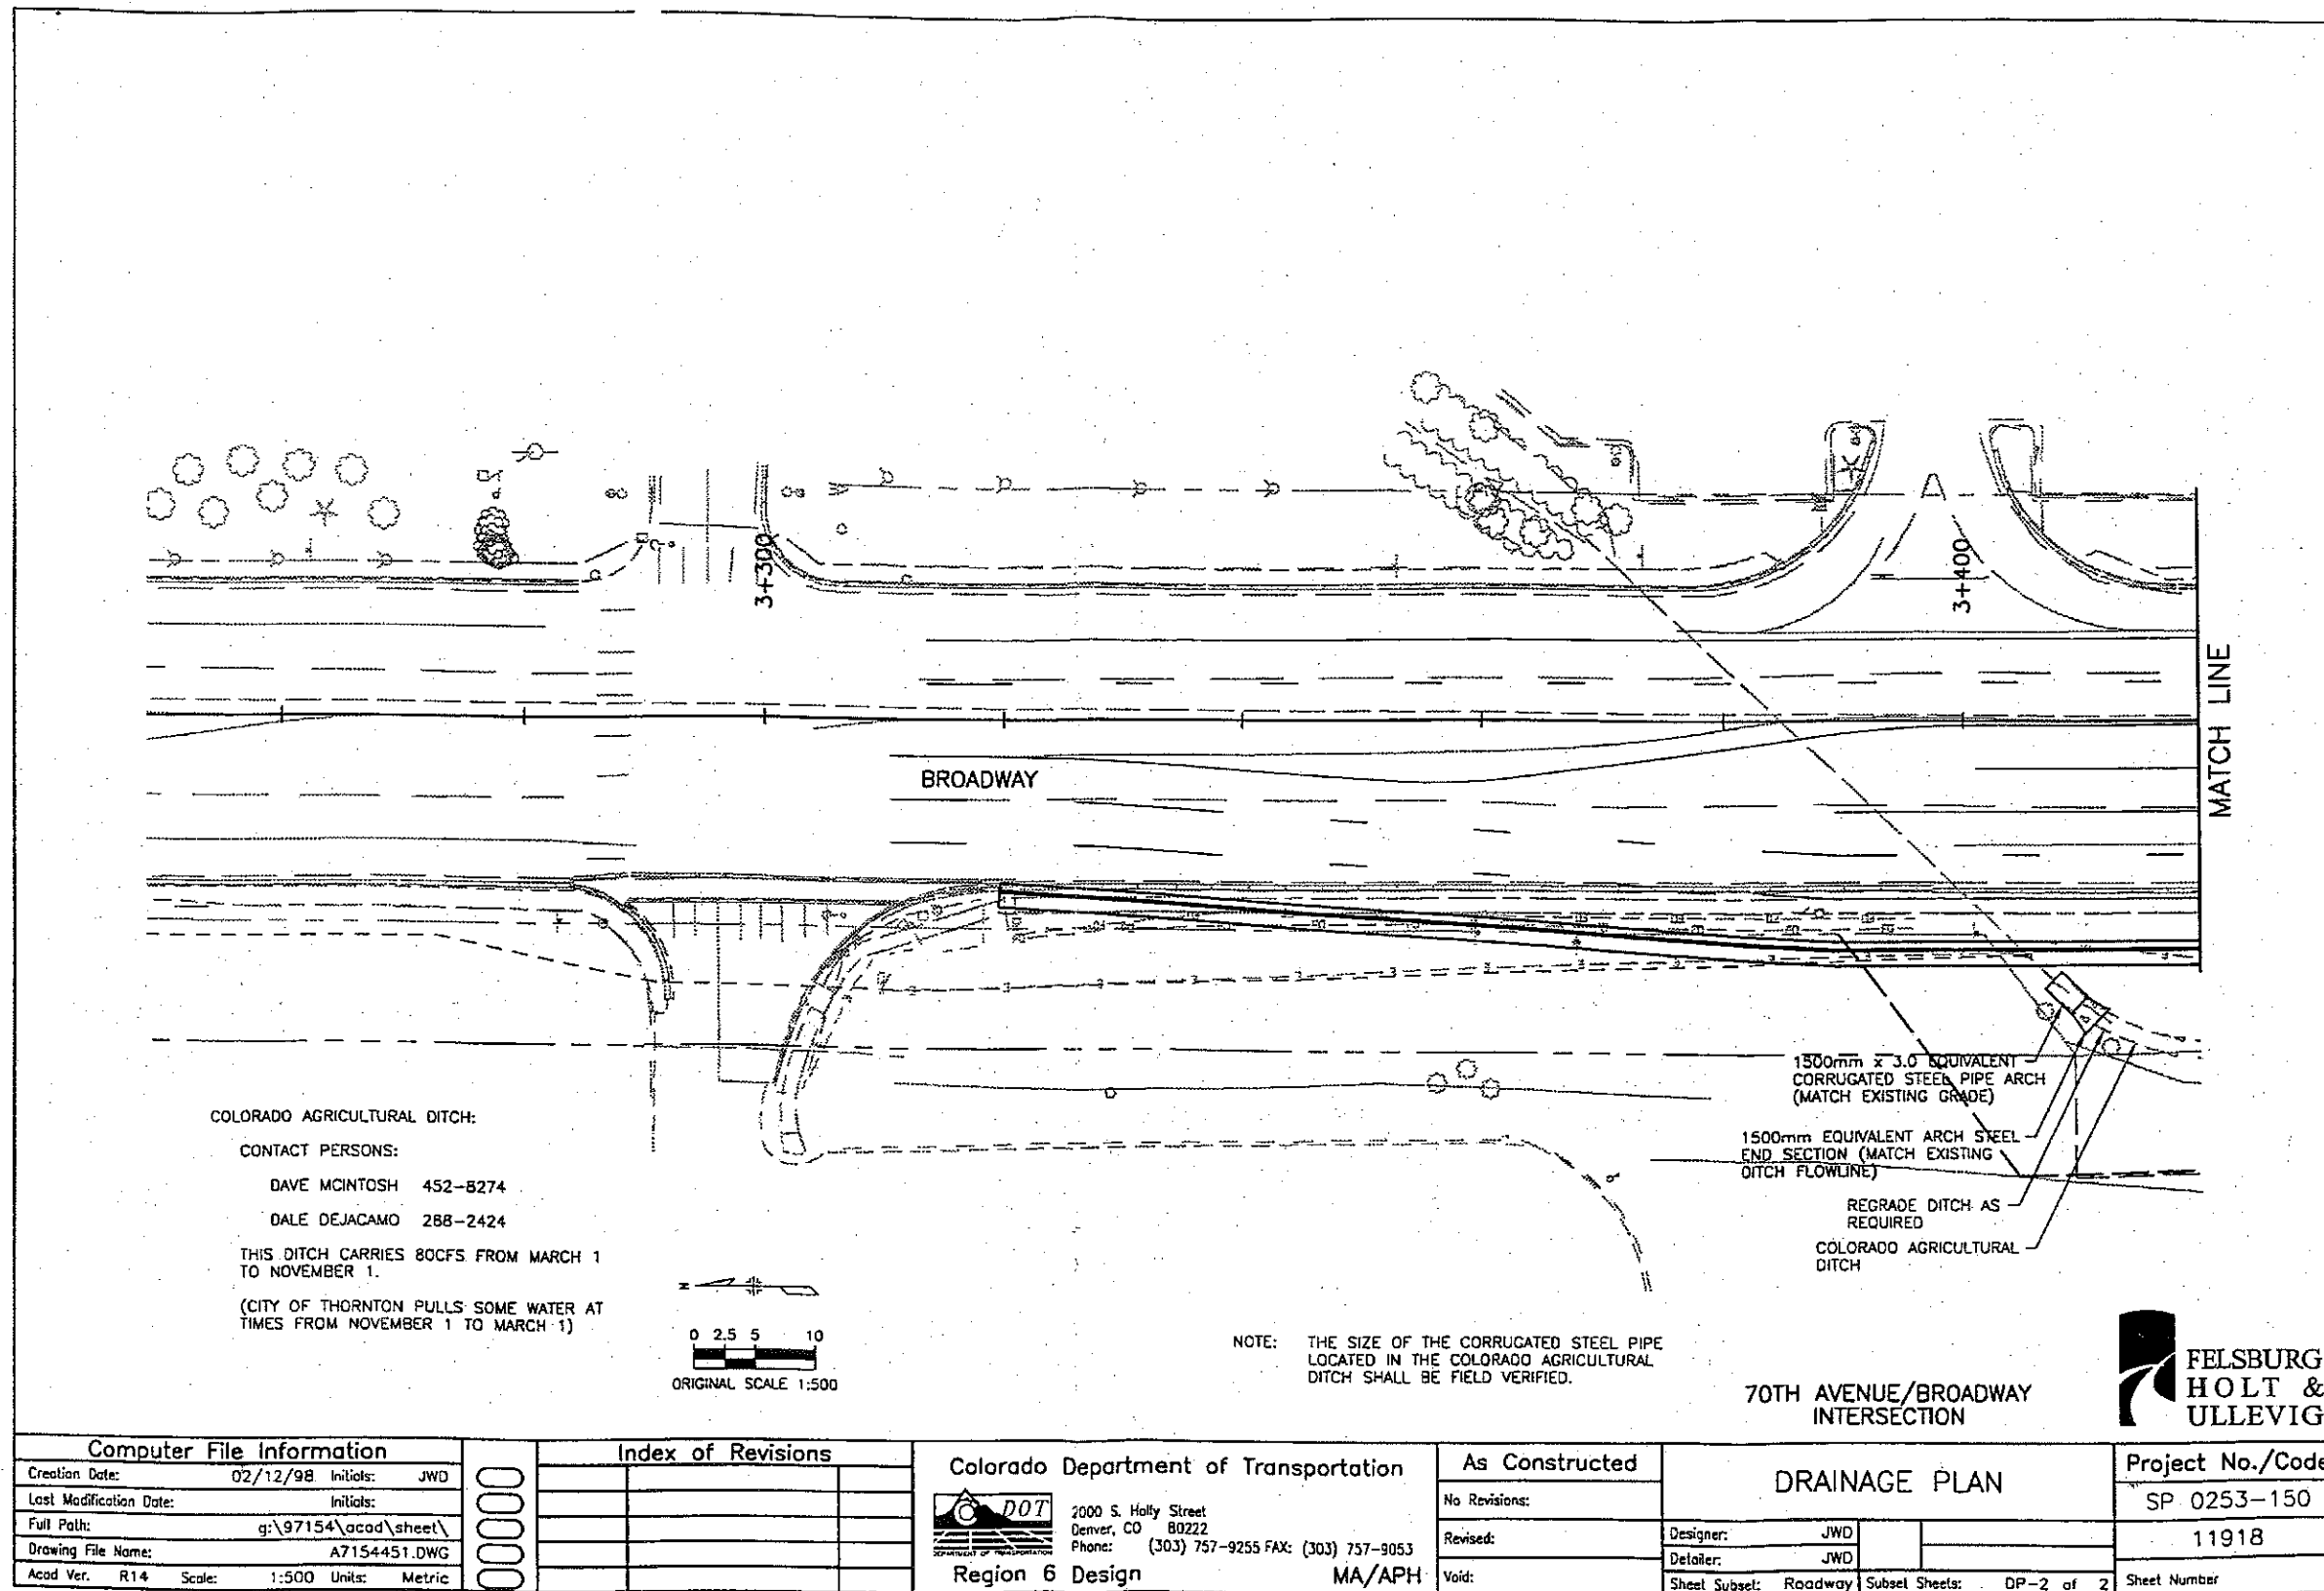

Computer File Information	
Creation Date:	02/12/98 Initials: JWD
Last Modification Date:	Initials:
Full Path:	g:\97154\acad\sheet\
Drawing File Name:	A7154451.DWG
Acad Ver. R14	Scale: 1:500 Units: Metric

Index of Revisions	

Colorado Department of Transportation



2000 S. Holly Street
 Denver, CO 80222
 Phone: (303) 757-9255 FAX: (303) 757-9053

Region 6 Design MA/APH

As Constructed	
No Revisions:	
Revised:	
Void:	

DRAINAGE PLAN

Designer: JWD
 Detailer: JWD

Sheet Subset: Roadway Subset Sheets: DP-2 of 2

Project No./Code	
SP 0253-150	
11918	
Sheet Number	

