



Sheet Revisions

Date	Description	Initials

LOCATED IN

ARAPAHOE NATIONAL FOREST
SUMMIT and CLEAR CREEK COUNTIES, COLORADO
US 6 M.P. 221.28 to M.P. 226.45


Project Control Diagram

Plan Sheet

Project Number: STA 006A-039				
Project Location: US 6 Loveland Pass				
Project Location: M.P. 221.28 to M.P. 226.45				
Project Code:	Last Mod. Date	Subset Sheets	Sheet No.	Total No. of Sheets
15976	03-01-07	1 of 7	3A	


PROJECT CONTROL DIAGRAM

▲ CM-MP 221.28
N 1659914.27
E 2896177.27
EL 10824.34

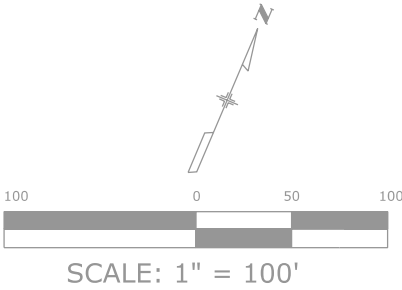

LOCATION OF ARAPAHOE BASIN SKI AREA

SITE 1 "The Question Mark"
M.P. 221.28 to M.P. 222.41

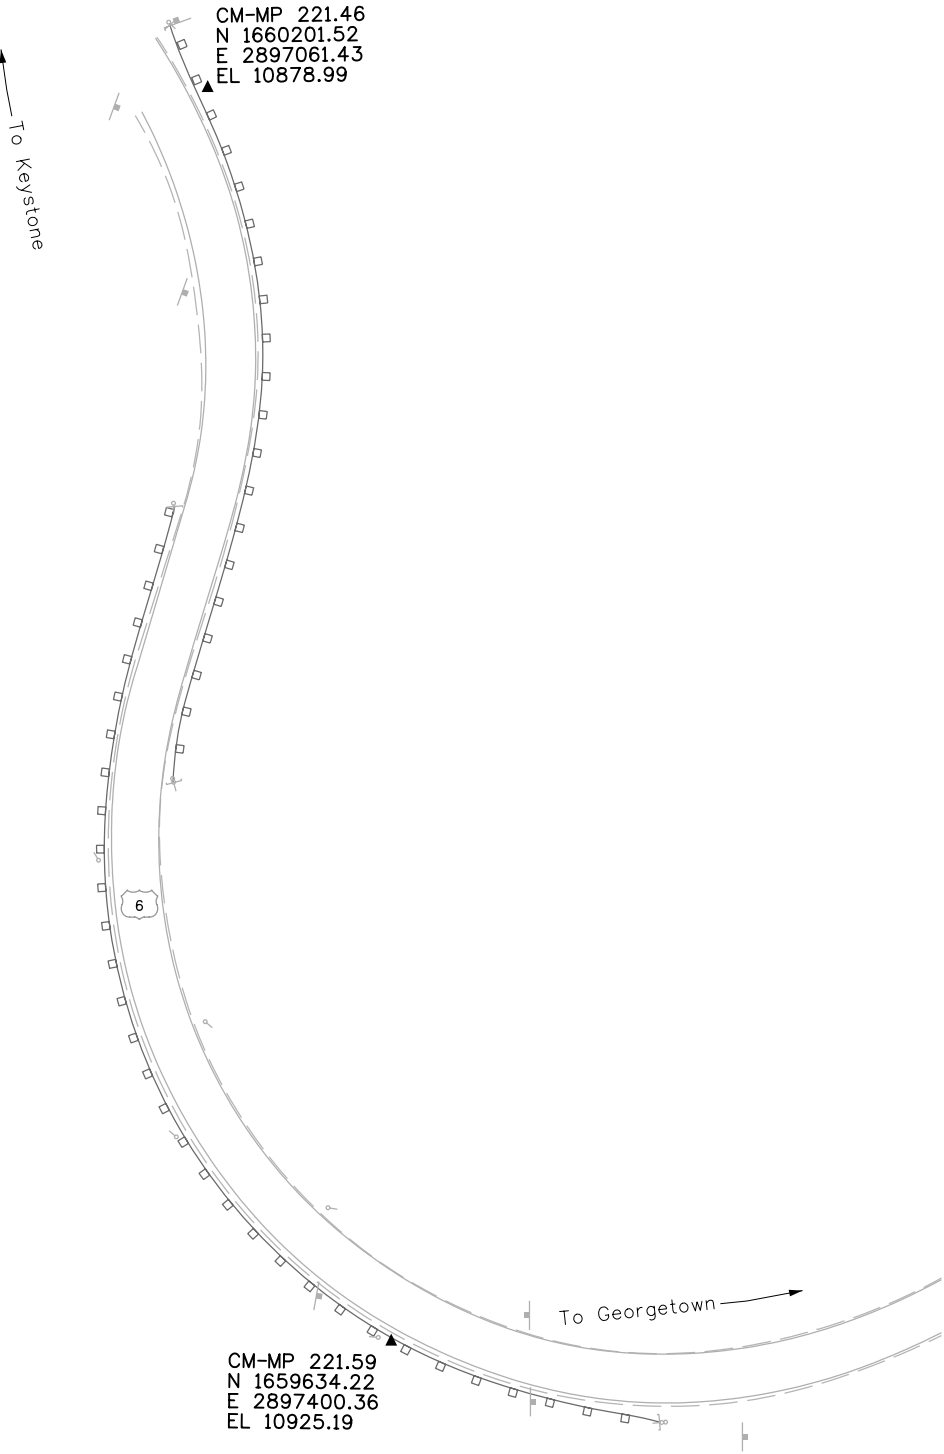



Sheet Revisions

Date	Description	Initials

LOCATED IN
ARAPAHOE NATIONAL FOREST
SUMMIT and CLEAR CREEK COUNTIES, COLORADO



Project Control Diagram

Plan Sheet

Project Number: STA 006A-039				
Project Location: US 6 Loveland Pass				
Project Location: M.P. 221.28 to M.P. 226.45				
Project Code:	Last Mod. Date	Subset Sheets	Sheet No.	Total No. of Sheets
15976	03-01-07	2 of 7	3B	

PROJECT CONTROL DIAGRAM

▲ CM-MP 221.93
N 1661115.44
E 2898211.39
EL 11051.64

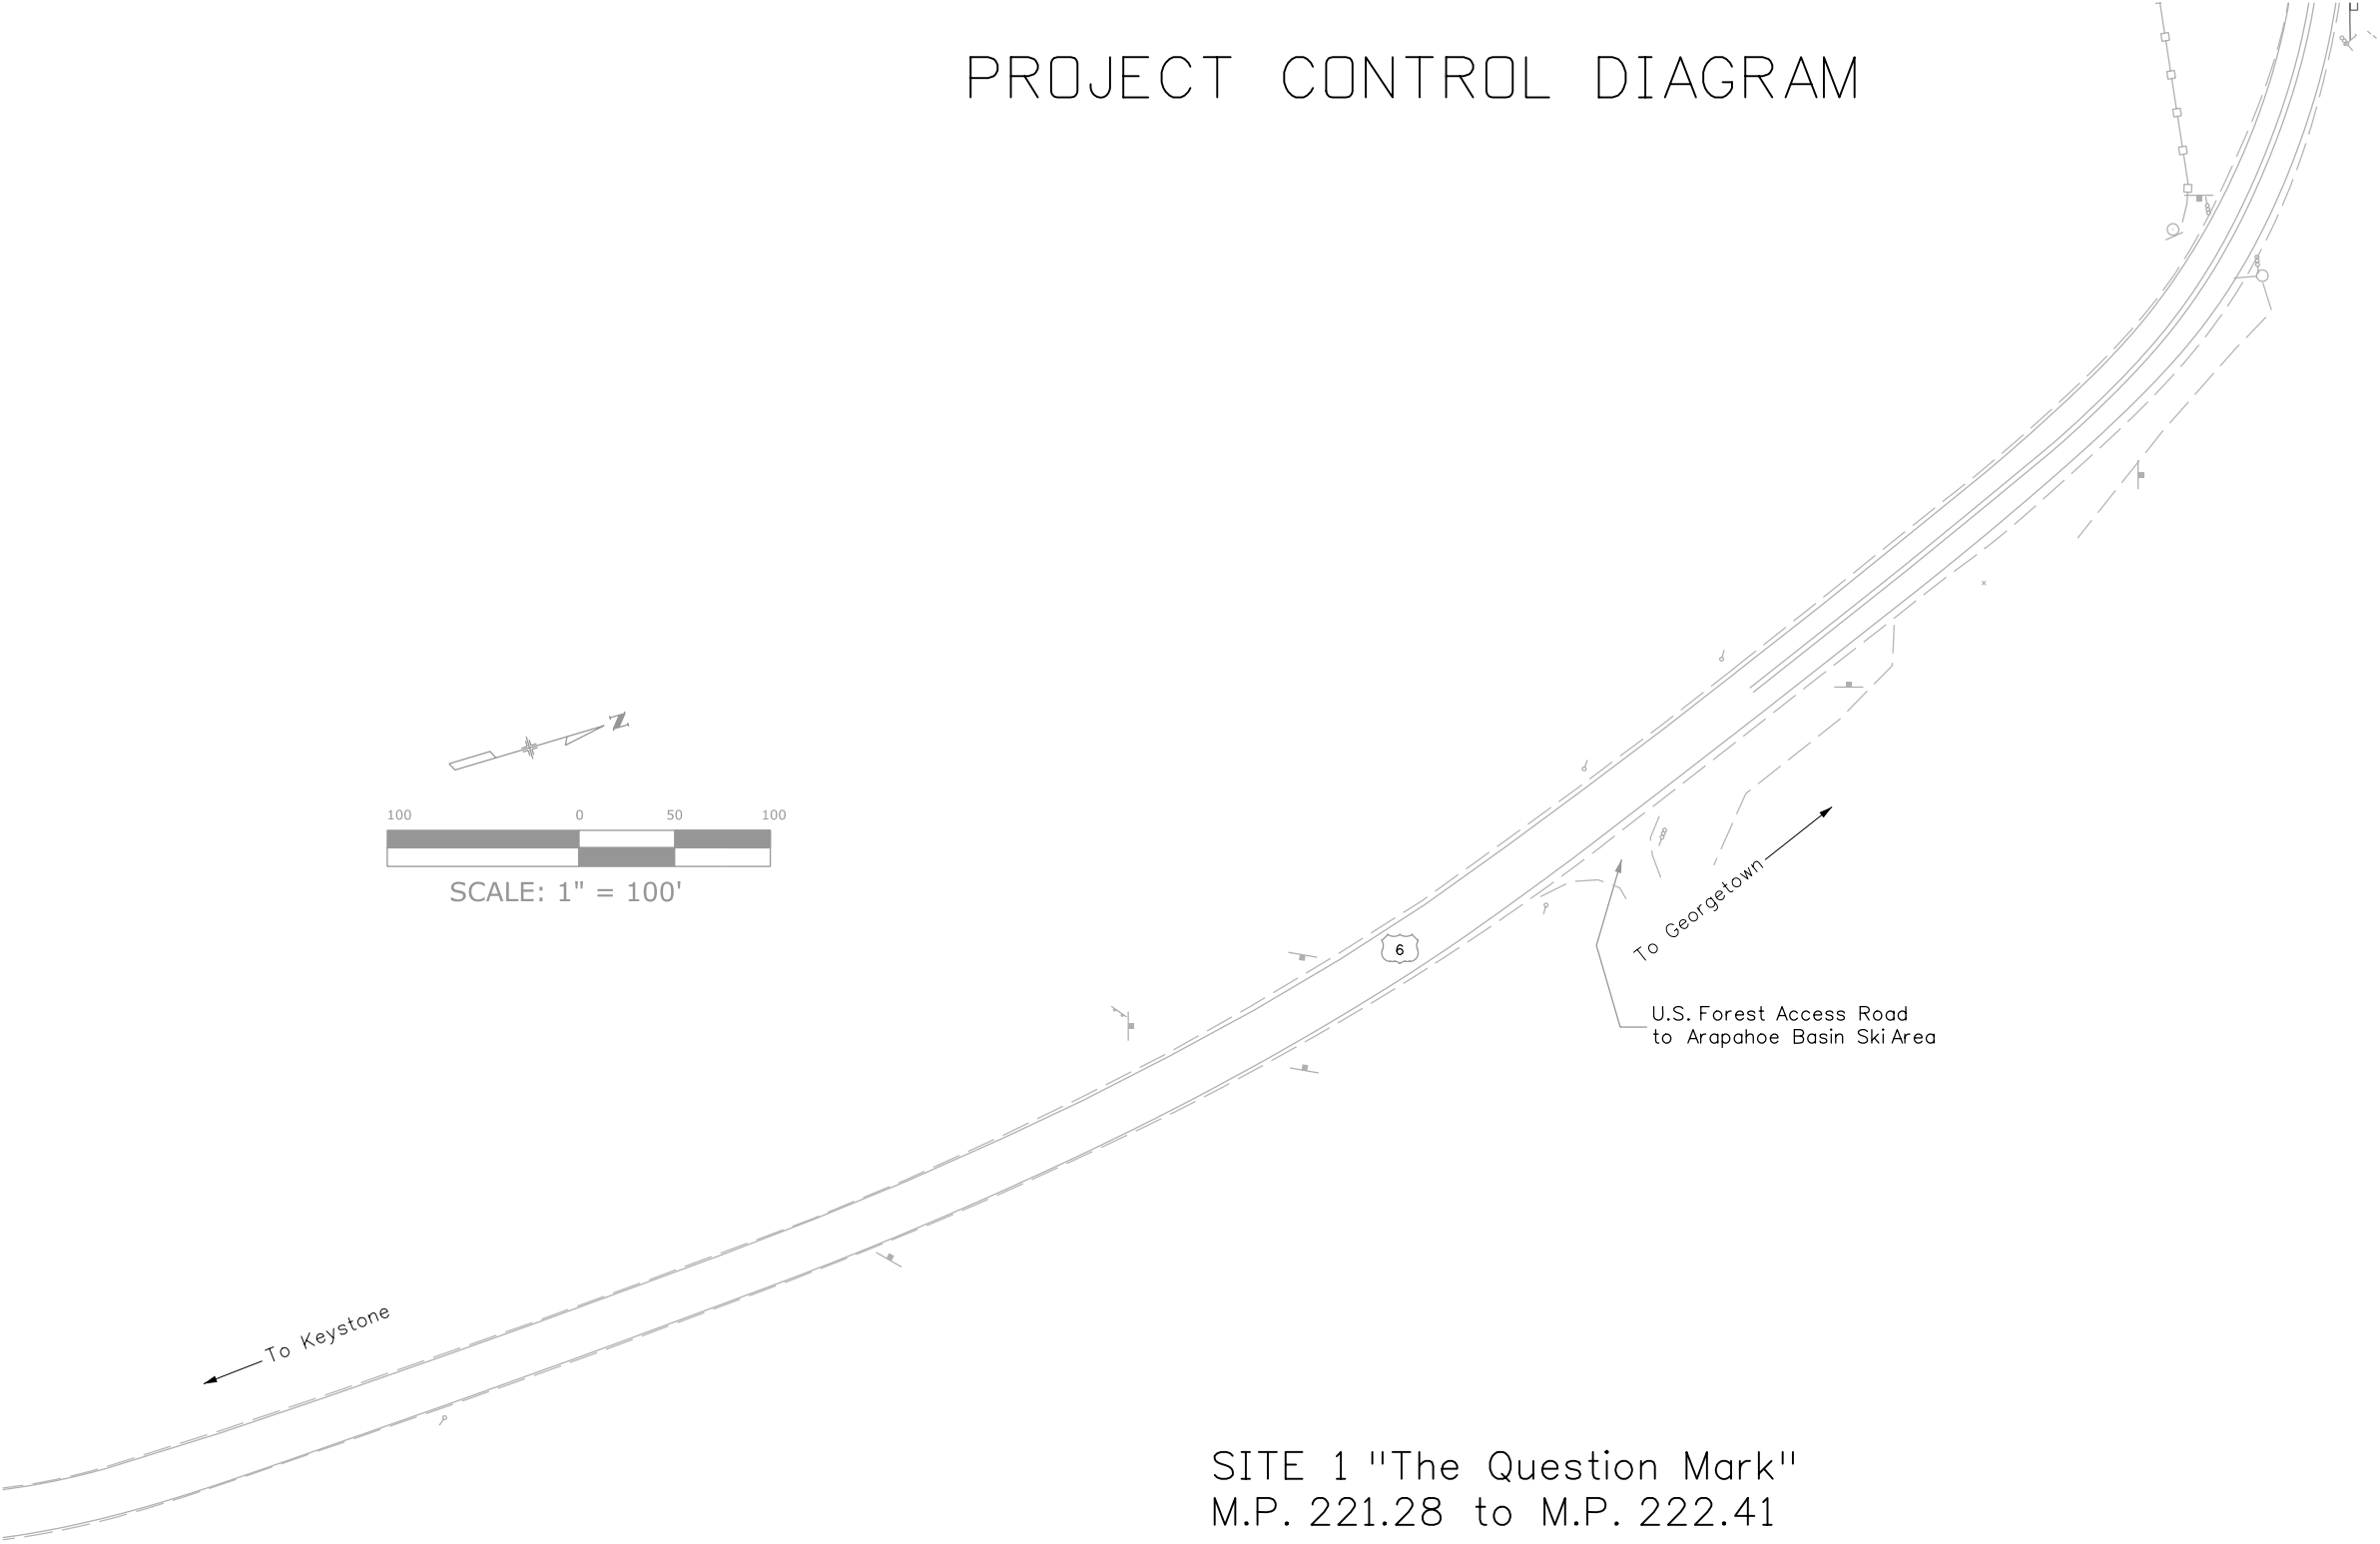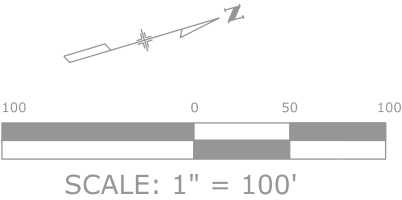

SITE 1 "The Question Mark"
M.P. 221.28 to M.P. 222.41



Sheet Revisions

Date	Description	Initials

LOCATED IN

ARAPAHOE NATIONAL FOREST


SUMMIT and CLEAR CREEK COUNTIES, COLORADO

Project Control Diagram

Plan Sheet

Project Number: STA 006A-039				
Project Location: US 6 Loveland Pass				
Project Location: M.P. 221.28 to M.P. 226.45				
Project Code:	Last Mod. Date	Subset Sheets	Sheet No.	Total No. of Sheets
15976	03-01-07	3 of 7	3C	

PROJECT CONTROL DIAGRAM

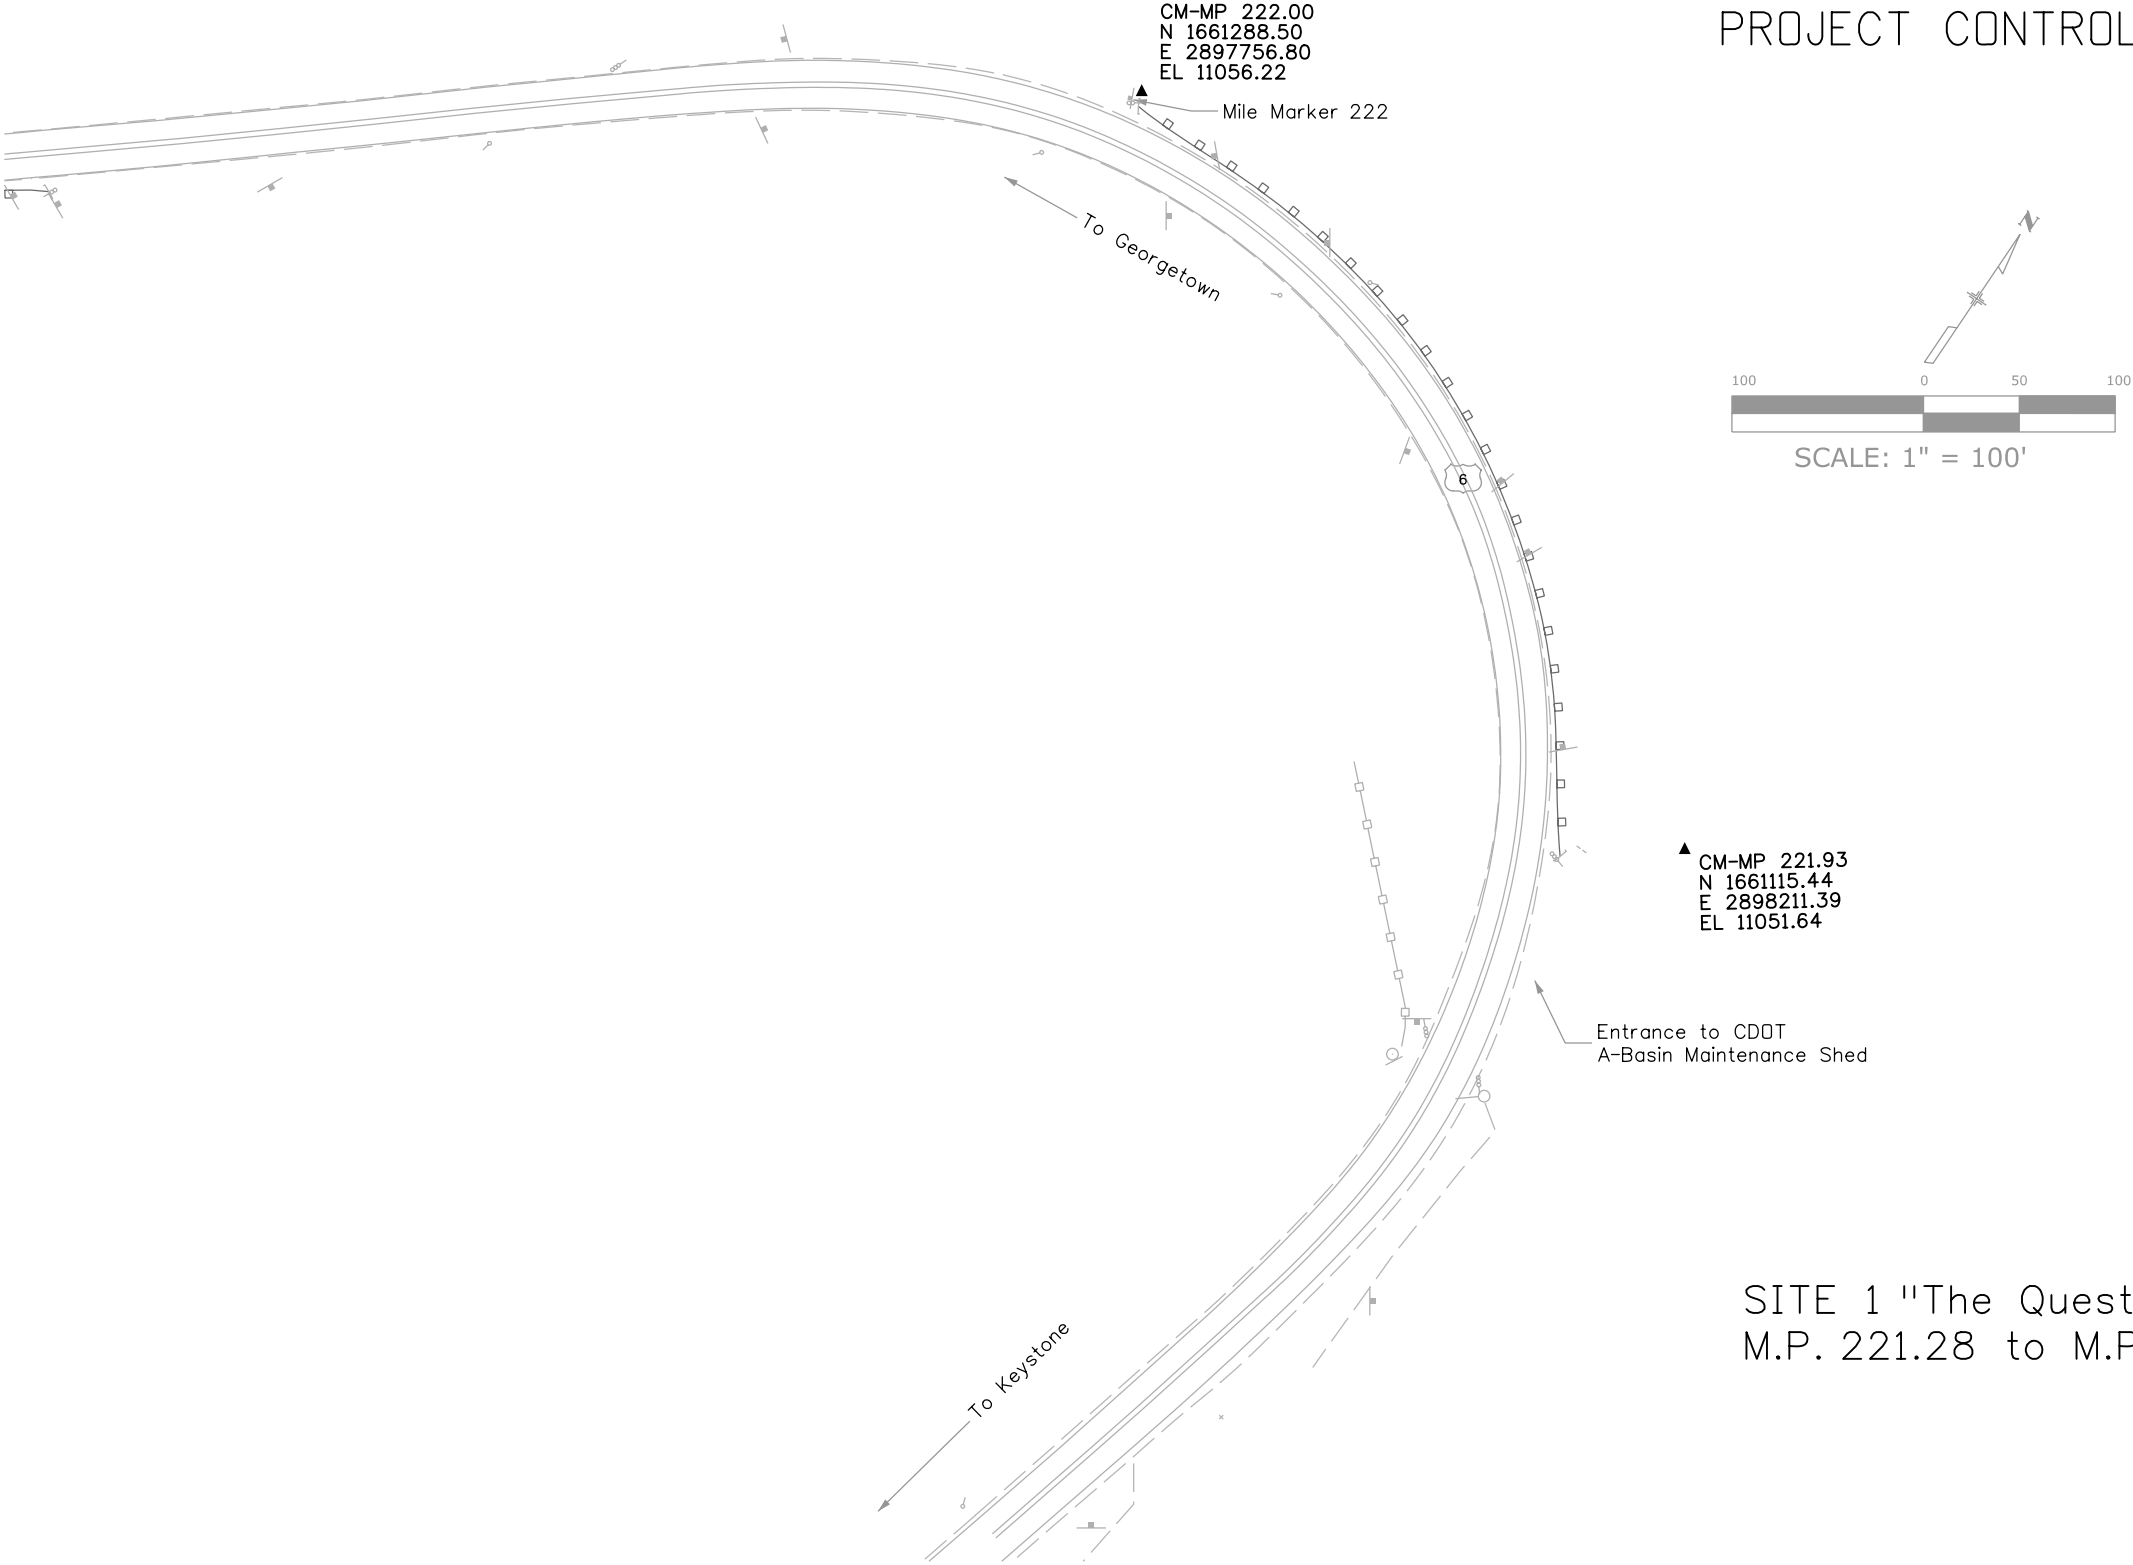



Sheet Revisions

Date	Description	Initials


LOCATED IN
ARAPAHOE NATIONAL FOREST
SUMMIT and CLEAR CREEK COUNTIES, COLORADO

Project Control Diagram

Plan Sheet

Project Number: STA 006A-039				
Project Location: US 6 Loveland Pass				
Project Location: M.P. 221.28 to M.P. 226.45				
Project Code:	Last Mod. Date:	Subset Sheets	Sheet No.	Total No. of Sheets
15976	03-01-07	4 of 7	3D	

PROJECT CONTROL DIAGRAM

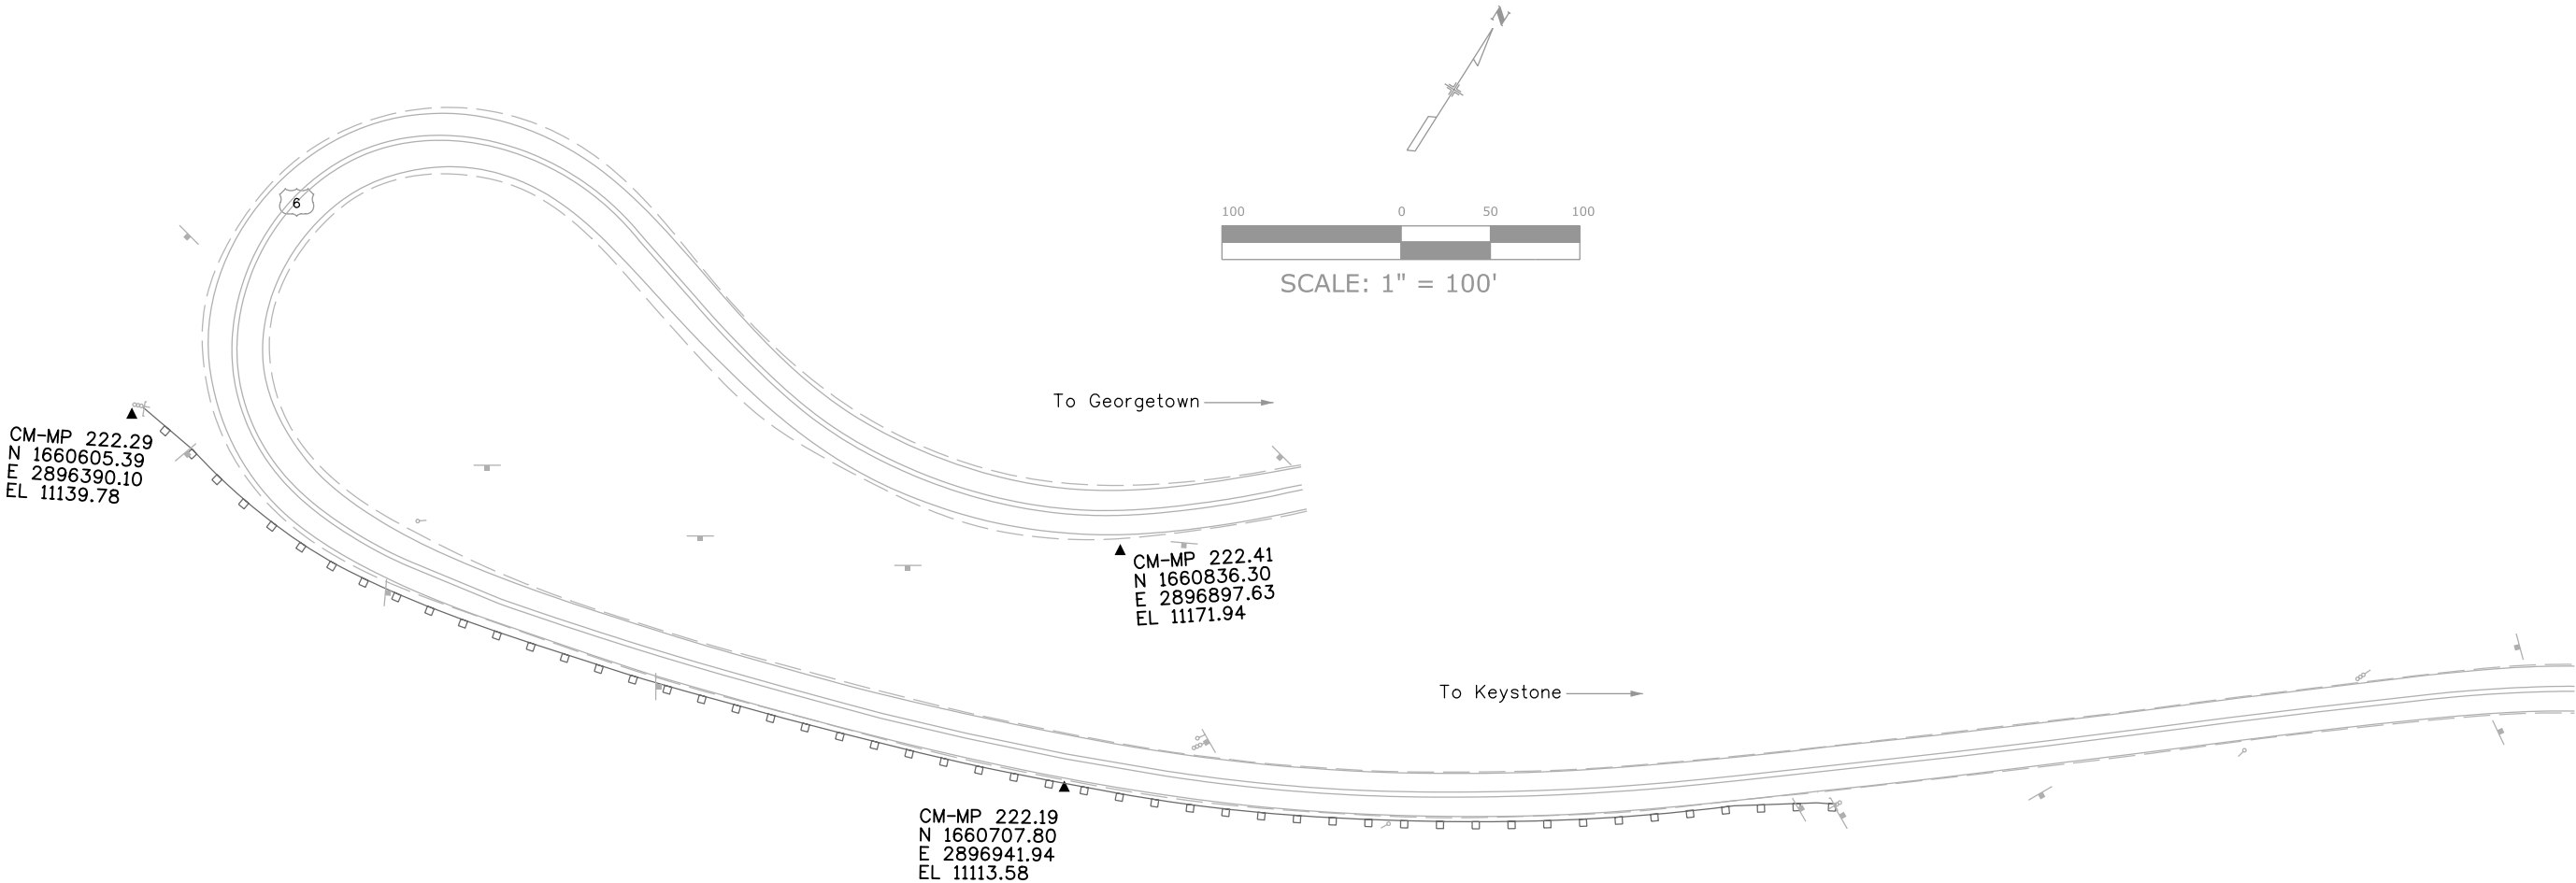

SITE 1 "The Question Mark"
M.P. 221.28 to M.P. 222.41



Sheet Revisions

Date	Description	Initials



LOCATED IN
ARAPAHOE NATIONAL FOREST
SUMMIT and CLEAR CREEK COUNTIES, COLORADO

Project Control Diagram

Plan Sheet

Project Number: STA 006A-039				
Project Location: US 6 Loveland Pass				
Project Location: M.P. 221.28 to M.P. 226.45				
Project Code:	Last Mod. Date	Subset Sheets	Sheet No.	Total No. of Sheets
15976	03-01-07	5 of 7	3E	

PROJECT CONTROL DIAGRAM

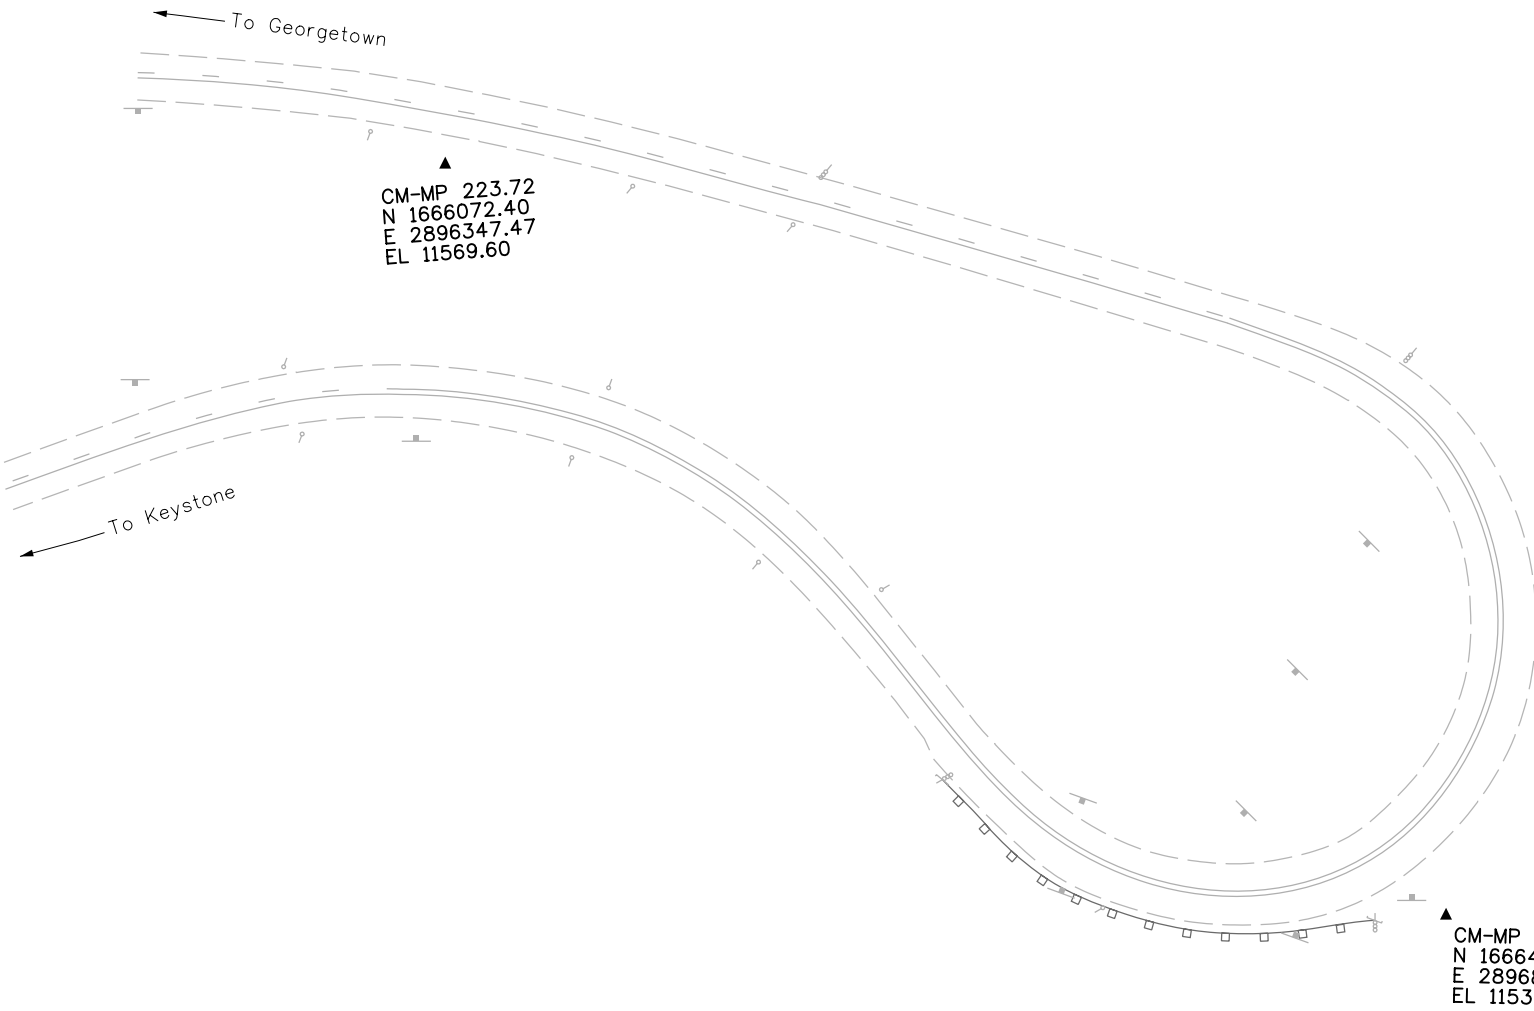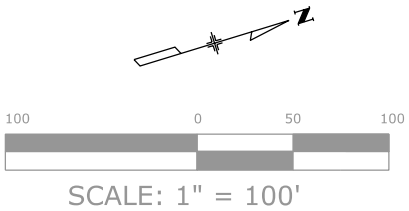

SITE 2 "2235"
M.P. 223.56 to M.P. 224.21



Sheet Revisions

Date	Description	Initials

LOCATED IN

ARAPAHOE NATIONAL FOREST


SUMMIT and CLEAR CREEK COUNTIES, COLORADO

Project Control Diagram

Plan Sheet

Project Number: STA 006A-039				
Project Location: US 6 Loveland Pass				
Project Location: M.P. 221.28 to M.P. 226.45				
Project Code: 15976	Last Mod. Date: 03-01-07	Subset Sheets: 6 of 7	Sheet No.: 3F	Total No. of Sheets:

PROJECT CONTROL DIAGRAM

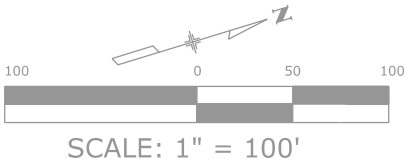

CM-MP 223.90
N 1665168.97
E 2896129.32
EL 11633.32 ▲

There isn't any survey topography for this sheet.
This is to show the location of the control monuments,
that are further up the road from the previous sheet,
Sheet 3F (Subset Sheet 5 of 7).

▲
CM-MP 224.21
N 1663740.65
E 2896072.97
EL 11726.80

▲
CM-MP 224.16
N 1663944.06
E 2896257.94
EL 11713.26

SITE 2 "2235"
M.P. 223.56 to M.P. 224.21



Sheet Revisions

Date	Description	Initials

LOCATED IN

ARAPAHOE NATIONAL FOREST



SUMMIT and CLEAR CREEK COUNTIES, COLORADO

Project Control Diagram

Plan Sheet

Project Number: STA 006A-039				
Project Location: US 6 Loveland Pass				
Project Location: M.P. 221.28 to M.P. 226.45				
Project Code:	Last Mod. Date	Subset Sheets	Sheet No.	Total No. of Sheets
15976	03-01-07	7 of 7	3G	

PROJECT CONTROL DIAGRAM

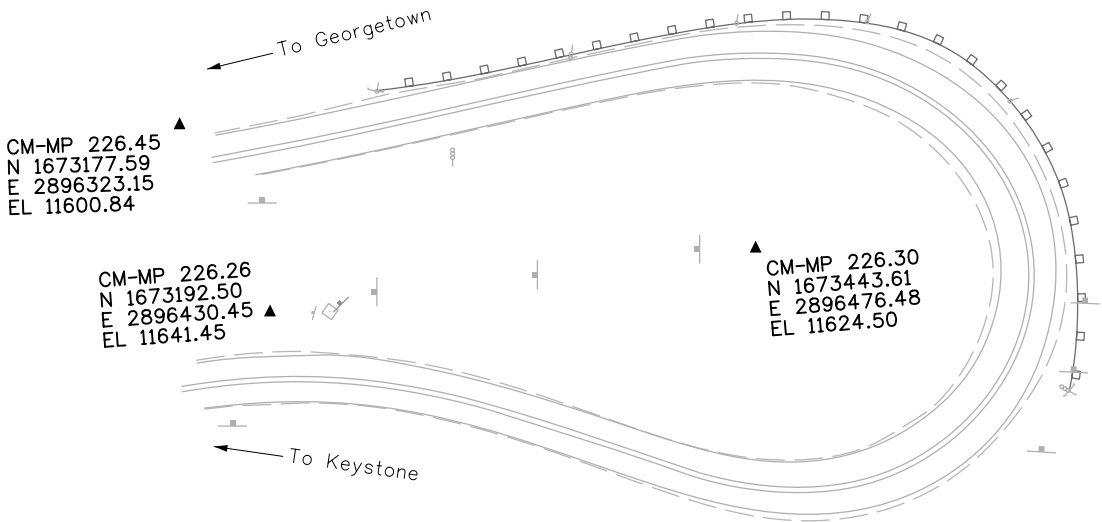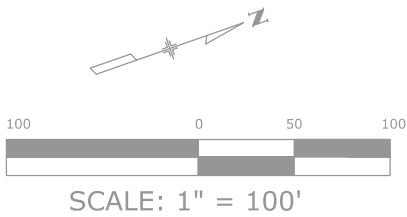

SITE 3 "Scotty's Curve"
M.P. 226.26 to M.P. 226.45