



Region 1
18500 E. Colfax Avenue
Aurora, CO 80011
Phone: (303) 757-9117 FAX: (303) 303-9746

Right-of-Way and Survey Unit: Kevin Williams

Sheet Revisions

Date	Description	Initials

Supplemental to Right of Way Plans for Federal
Aid Project No. STA 009A-022, recorded @
Reception # 693581, August 22, 2002, Summit
County Office of the Clerk and Recorder

Computer File Information

CREATION DATE: 6/23/03 INITIALS: BDL
LAST MODIFICATION DATE: 7/2/03 INITIALS: BDL
FULL PATH: See left side of sheet
DRAWING FILE NAME: titlesheet-rev-062303.dwg
SCALE: n.t.s. UNITS: Metric
URS Corporation
Denver, Colorado Tel:(303) 740-2600

Right of Way Plans- Supplemental

TITLE SHEET

Project Number: STA 009A-022
Project Location: Blue River CG to Ute Pass Rd.
Project Code: 12534 Last Mod. Date: 7/2/03 Subset Sheets: 1 Sheet No.: 1 Total No. of Sheets: 6

INDEX OF SHEETS

- | | |
|---|--------------------------|
| 1 | Title Sheet |
| 2 | Tabulation of Properties |
| 3 | Control Diagram |
| 4 | Monumentation Sheets |
| 5 | Plan Sheets |
| 6 | Ownership Maps |


DEPARTMENT OF TRANSPORTATION STATE OF COLORADO

RIGHT OF WAY PLAN OF PROPOSED FEDERAL AID PROJECT NO. STA 009A-022 STATE HIGHWAY NO. 9 SUMMIT COUNTY RIGHT OF WAY

SCALES OF ORIGINAL DRAWINGS

PLAN SHEETS 1:1000
OWNERSHIP MAP 1:4000
R.O.W. LENGTH OF PROJECT = 8.824 KM (5.48 MI)

CONVENTIONAL SIGNS

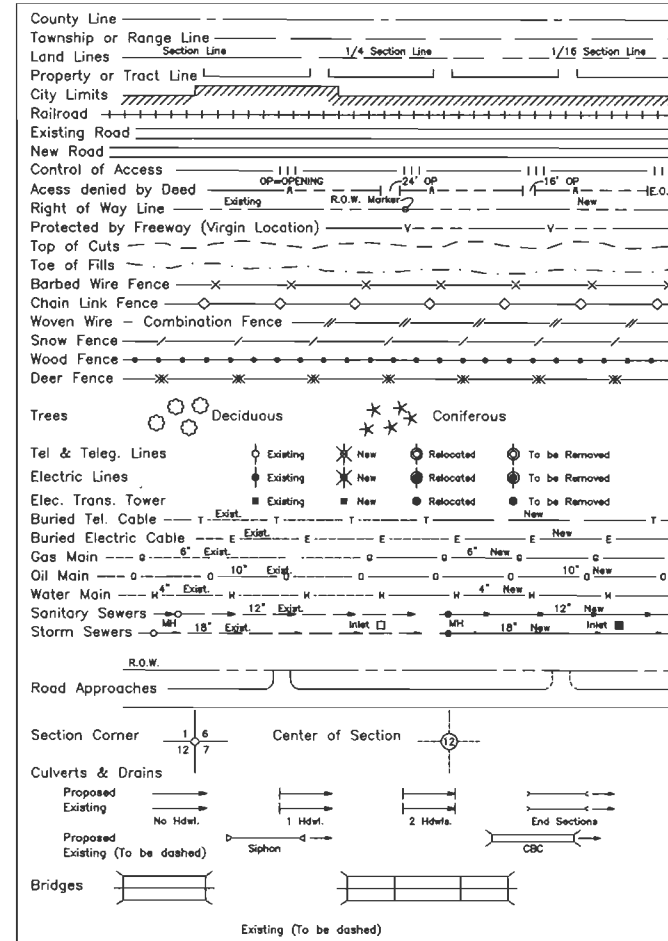

BASIS OF BEARINGS

Bearings used in the calculation of coordinates
are based a grid bearing of N58°48'51"W from
SH 9 CM-MP 109.11 to SH 9 CM-MP 109.21 as obtained
from a Global Positioning System (GPS) survey based on
the Colorado High Accuracy Reference Network (CHARN).

SH 9 MP 109.11 CM 911 GPS PROJECT STATION
N:118845.309, E:98939.251
SH 9 MP 109.21 CM 921 GPS PROJECT STATION
N:118949.132, E:98767.725
GPS survey line
N 58°48'51" W a distance of 200.500 meters



July, 2003
Region 1
Project Code 12534

End of Construction Project
STA 009A-022 27+471.81
MP 114.6

End of Right of Way
Project STA 009A-022
27+346.090
MP 113.8

Beginning of Right of
Way Project STA
009A-022 18+521.030
MP 109.2


Beginning of
Construction Project STA
009A-022 18+433.340
MP 109.0

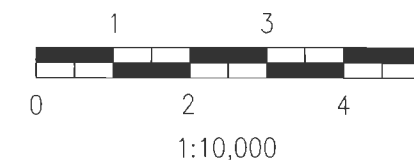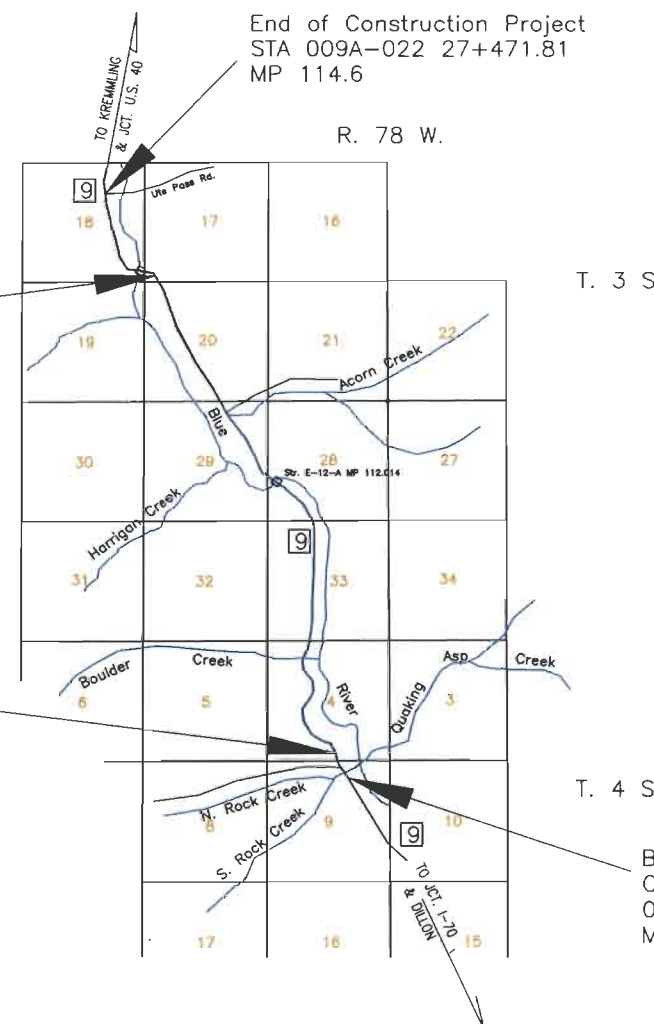

DEPARTMENT OF TRANSPORTATION
FEDERAL HIGHWAY ADMINISTRATION

AUTHORIZED: _____ DATE: _____

 DIVISION ADMINISTRATOR



Right-of-Way and Survey Unit: Kevin Williams

Sheet Revisions

[illegible]

Computer File Information

CREATION DATE: 6/23/03 INITIALS: BDL
LAST MODIFICATION DATE: 7/2/03 INITIALS: BDL
FULL PATH: See left side of sheet
DRAWING FILE NAME: tab sheets - rev - 062303.dwg
SCALE: N.T.S. UNITS: Metric
URS Corporation
Denver, Colorado Tel: (303) 740-2600

Right of Way Plans- Supplemental

TABULATION OF PROPERTIES

Project Number:	STA 009A-022
-----------------	--------------

Project Location: Blue River CG to Ute Pass Rd.

Project Code:	Last Mod. Date	Subset Sheets	Sheet No.	Total No. of Sheets
12534	7/2/03		2	6

R.O.W. TABULATION OF PROPERTIES IN SUMMIT COUNTY

S.H. NO. 9

FILING CERTIFICATION:
DEPOSITED THIS ____ DAY OF ____, 19 ____, AT ____, FOR INFORMATION
ONLY IN BOOK ____ OF THE COUNTY LAND SURVEYS/RIGHT OF WAY
SURVEYS AT PAGE ____, RECEPTION NUMBER ____.

SIGNED
DEPT.

\\6844304.10\cod\row\PLANS\tabsheets-rev-062303.dwg 06/27/2003 10:52:55 AM MDT

COLORADO DEPARTMENT OF TRANSPORTATION



Region 1
18500 E. Colfax Avenue
Aurora, CO 80011
Phone: (303) 757-9117 FAX: (303) 303-9746

Right-of-Way and Survey Unit: Kevin Williams

Sheet Revisions

Date	Descriptions	Initials

Computer File Information

CREATION DATE: 6/23/03	INITIALS: BDL
LAST MODIFICATION DATE: 7/2/03	INITIALS: BDL
FULL PATH: See left side of sheet	
DRAWING FILE NAME: CSD-rev-06230.dwg	
SCALE: N.T.S.	UNITS: Metric
URS Corporation	
Denver, Colorado Tel:(303) 740-2600	

Right of Way Plans- Supplemental

CONTROL SURVEY DIAGRAM

Project Number:		STA 009A-022		
Project Location: Blue River CG to Ute Pass Rd.				
Project Code:	Last Mod. Date	Subset Sheets	Sheet No.	Total No. of Sheets
12534	7/2/03		3	6

CONTROL SURVEY DIAGRAM SHEETS 3 TO 3N ARE RECORDED
AT:

THE SUMMIT COUNTY CLERK AND RECORDERS OFFICE:
RECEPTION NUMBER: 603426
DEPOSITED: 8/23/1999

FILING CERTIFICATION:
DEPOSITED THIS ____ DAY OF ____, 19____, AT ____ M., FOR INFORMATION
ONLY IN BOOK ____ OF THE COUNTY LAND SURVEYS/RIGHT OF WAY
SURVEYS AT PAGE ____ RECEPTION NUMBER ____

SIGNED _____
DEPT. _____

COLORADO DEPARTMENT OF TRANSPORTATION



Region 1
18500 E. Colfax Avenue
Aurora, CO 80011
Phone: (303) 757-9117 FAX: (303) 303-9746

Right-of-Way and Survey Unit: Kevin Williams

Sheet Revisions

Date	Description	Initials

Computer File Information

CREATION DATE: 6/23/03 INITIALS: BDL
LAST MODIFICATION DATE: 7/2/03 INITIALS: BDL
FULL PATH: See left side of sheet
DRAWING FILE NAME: Monumentation--rev-062303.dwg
SCALE: N.T.S. UNITS: Metric
URS Corporation
Denver, Colorado Tel:(303) 740-2600

Right of Way Plans- Supplemental

MONUMENTATION SHEET
Project Number: STA 009A-022
Project Location: Blue River CG to Ute Pass Rd.
Project Code: 12534 Last Mod. Date: 7/2/03 Subset Sheets: 4 Sheet No.: 4 Total No. of Sheets: 6

GENERAL NOTES

1. This Right-of-Way plan is not a complete boundary survey of all the adjoining property owners and is prepared for the Transportation Department purposes ONLY.
2. Title Commitments / Policies not supplied. Vesting Deeds, only, provided. (at the request of the client)
3. NOTICE: According to Colorado law you must commence any legal action based upon any defect in this survey within three years after you first discover such defect. In no event, may any action based upon any defect in this survey be commenced more than ten years from the date of certification shown hereon.
4. All R.O.W. Markers set from survey control points.
5. All centerline and offset stationing is theoretical only and may not represent the centerline as constructed in the field.
6. All coordinates listed are PROJECT COORDINATES.
7. BASIS OF BEARINGS: Bearings used in the calculation of coordinates are based on a grid bearing of N58°48'51"W from SH 9 CM-MP 109.11 to SH 9 CM-MP 109.21 as obtained from a Global Positioning System survey based on the Colorado High Accuracy Reference Network (CHARN).

Right of Way Markers To Be Set

Pnt	Northing	Easting	Station	Offset	Type
357	120649.858	98376.867	20+980.000	-41.070	1
358	120690.393	98397.114	21+020.070	-20.422	1(6mPOL)

Utility Easement Markers To Be Set

Pnt	Northing	Easting	Station	Offset	Type
405	120631.845	98371.463	20+962.052	-46.689	6
406	120652.943	98373.297	20+983.127	-44.603	6
407	120695.365	98394.487	21+024.964	-23.052	6
408	120645.382	98372.084	20+975.580	-45.906	6

QUANTITY OF MONUMENTS TO BE SET

CAP TYPE	MONUMENT TYPE									
	1	1A	2	2A	3	3A	4	4A	5	6
REFERENCE										
RIGHT OF WAY 3-1/4"	2									
CONTROL										
ALIQUOT CORNER										
WITNESS POST										
PERM. EASEMENT										4
C.R. RIGHT OF WAY										

FIELD SURVEYOR'S STATEMENT

ORIGINAL SURVEY MARKER LOCATION AND TOPO WERE PREPARED UNDER MY SUPERVISION AND CHECKING.

NAME x P.L.S. NO. x
DATE _____

Original Stamp

FIELD SURVEYOR'S STATEMENT

RIGHT OF WAY MONUMENTATION WAS DONE UNDER MY SUPERVISION AND CHECKING.

NAME Thomas W. Stoutenburg P.L.S. NO. 22103
DATE _____

Original Stamp

OFFICE SURVEYOR'S STATEMENT

R.O.W. PLANS AND LEGAL DESCRIPTIONS WERE PREPARED UNDER MY SUPERVISION AND CHECKING.

NAME Thomas W. Stoutenburg P.L.S. NO. 22103
DATE _____

Original Stamp

FILING CERTIFICATION:
DEPOSITED THIS _____ DAY OF _____, 19____, AT _____, FOR INFORMATION
ONLY IN BOOK _____ OF THE COUNTY LAND SURVEYS/RIGHT OF WAY
SURVEYS AT PAGE _____, RECEPTION NUMBER _____

SIGNED _____
DEPT. _____




Region 1
18500 E. Colfax Avenue
Aurora, CO 80011
Phone: (303) 757-9117 FAX: (303) 303-9746

Right-of-Way and Survey Unit: Kevin Williams

[illegible]

Computer File Information		Right of Way Plans— Supplemental				
CREATION DATE: 6/23/03	INITIALS: BDL	PLAN SHEET				
LAST MODIFICATION DATE: 7/2/03	INITIALS: BDL					
FULL PATH: See left side of sheet						
DRAWING FILE NAME: Rswplan-metric-rev-062303.dwg		Project Number: STA 009A-022				
SCALE: 1:1000	UNITS: Metric	Project Location: Blue River CG to Ute Pass Rd.				
URS Corporation		Project Code:	Last Mod. Date	Subset Sheets	Sheet No.	Total No. of Sheets
URS Corporation, 10000 E. 1st Avenue, Suite 1000, Denver, CO 80231						

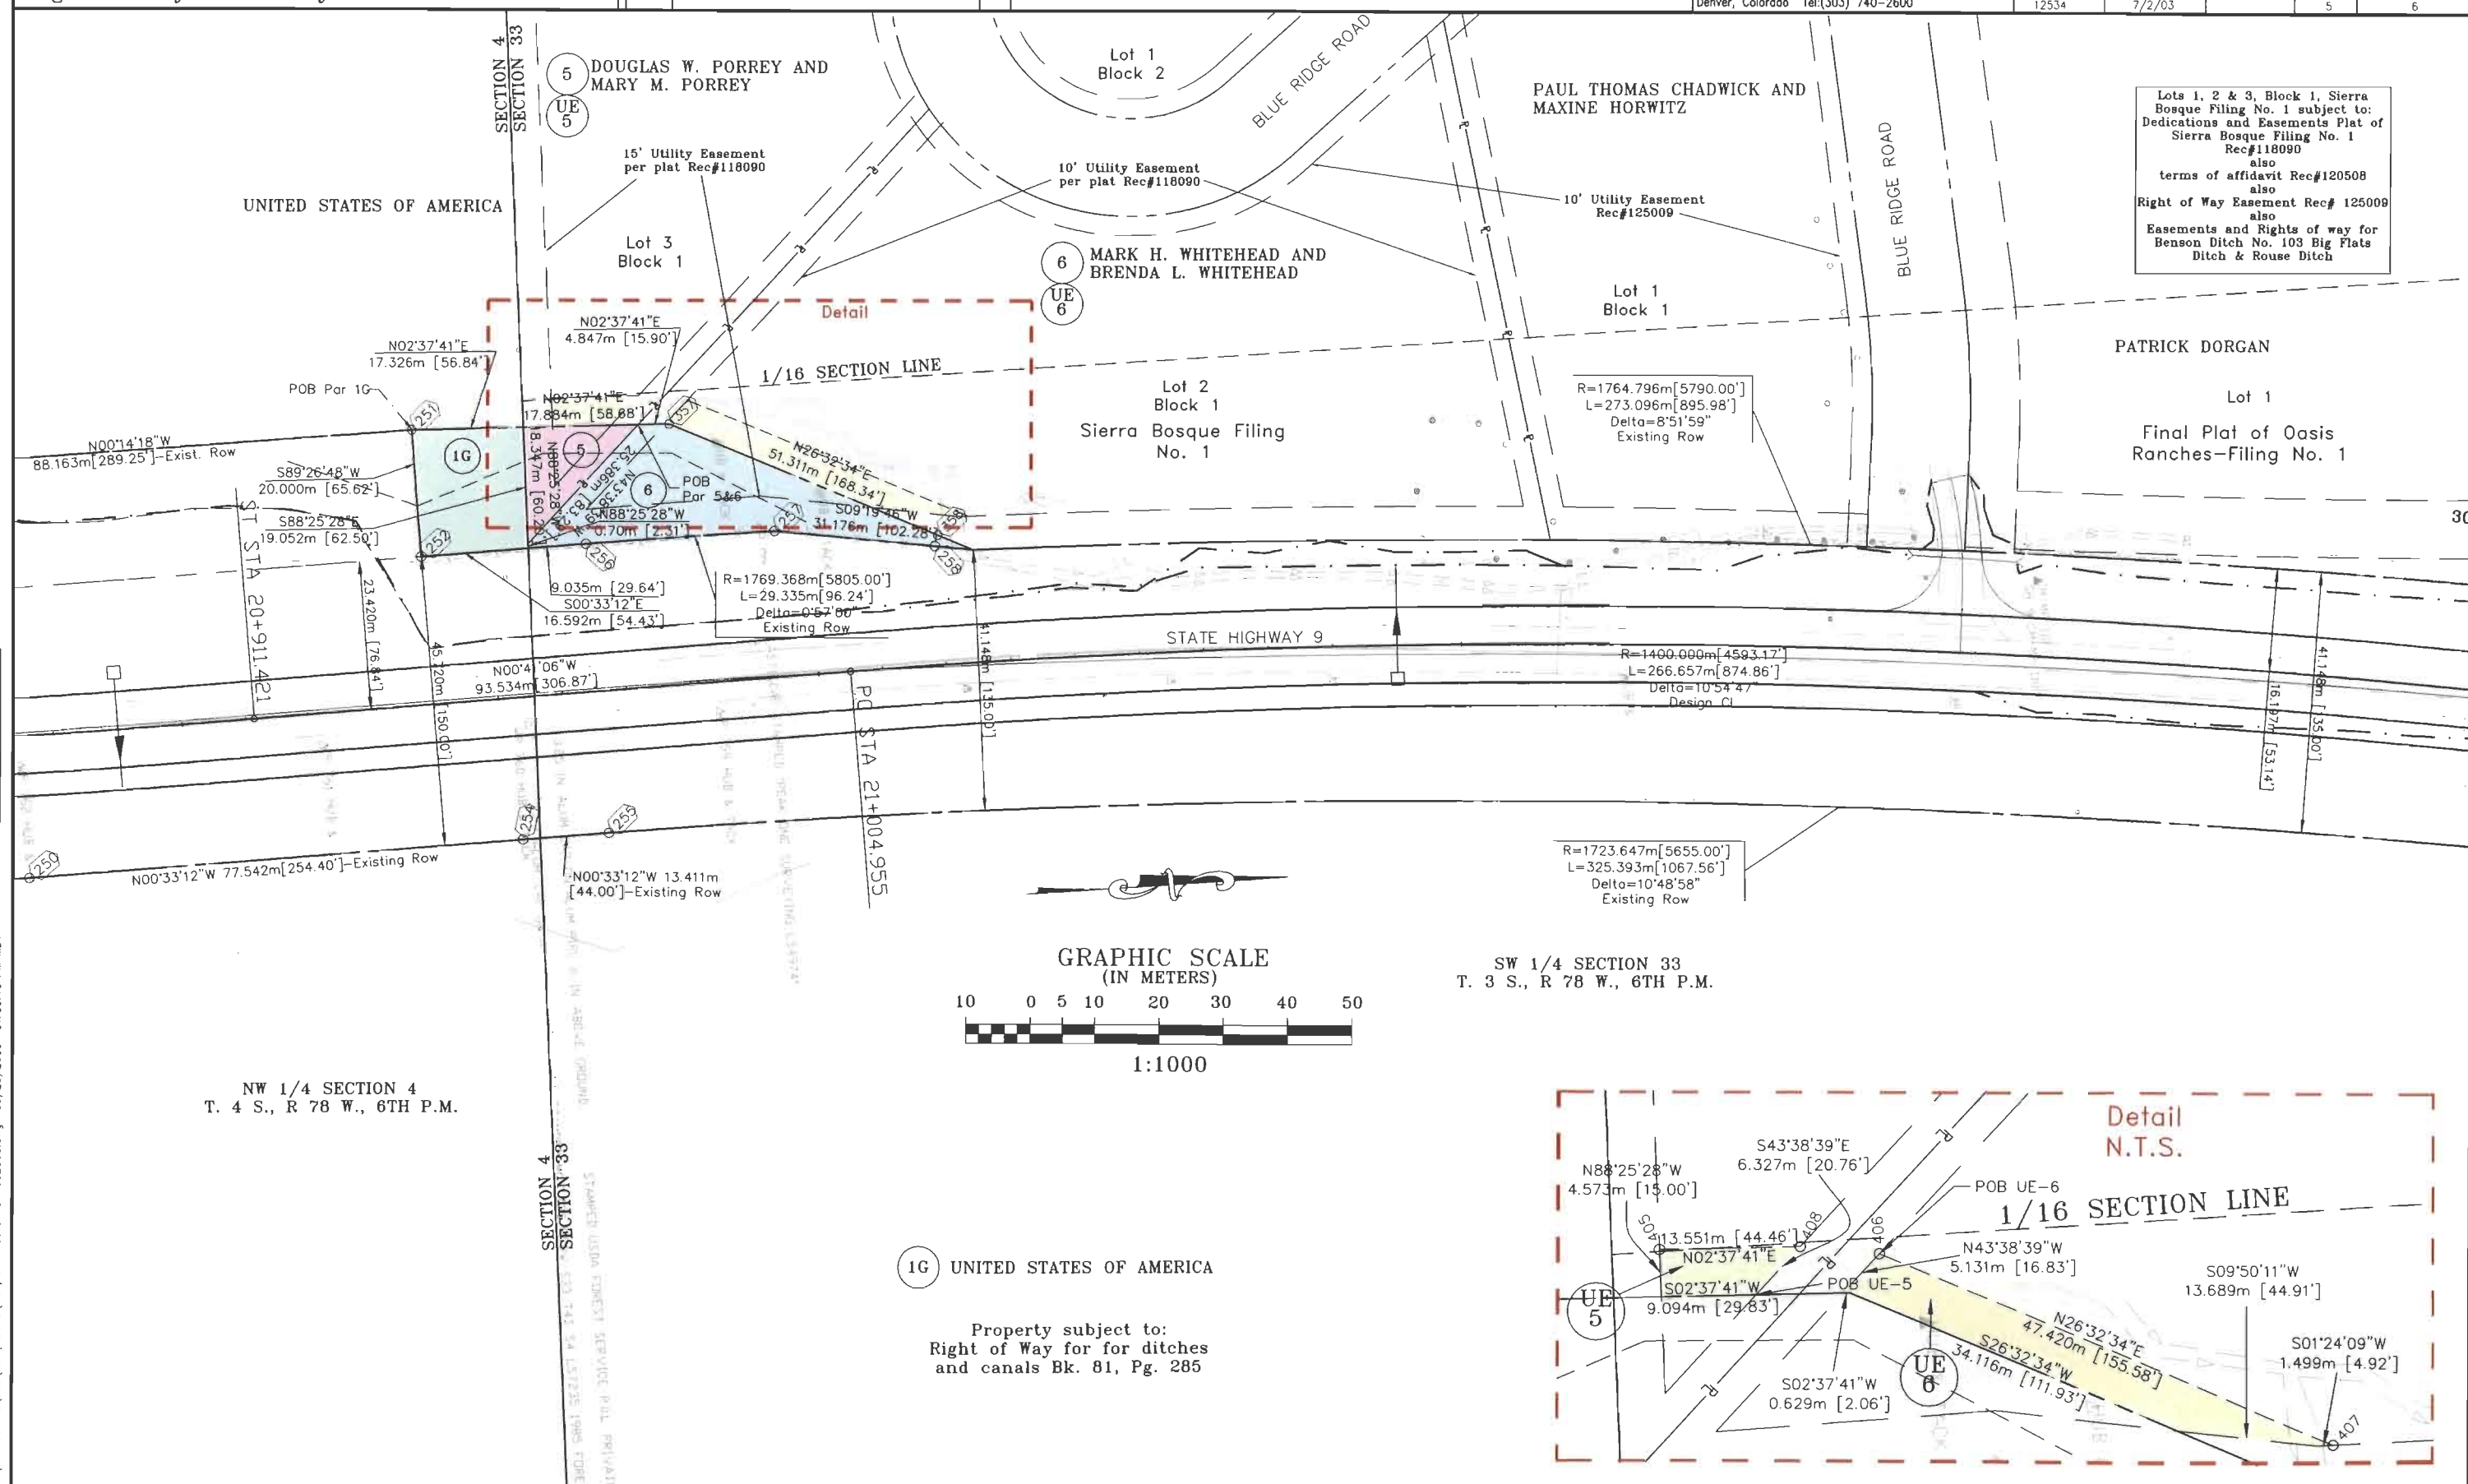

COLORADO DEPARTMENT OF TRANSPORTATION



Region 1
18500 E. Colfax Avenue
Aurora, CO 80011
Phone: (303) 757-9117 FAX: (303) 303-9746

Right-of-Way and Survey Unit: Kevin Williams

Sheet Revisions

Date	Description	Initials

Computer File Information

CREATION DATE: 6/23/03 INITIALS: BDL
LAST MODIFICATION DATE: 7/2/03 INITIALS: BDL
FULL PATH: See left side of sheet
DRAWING FILE NAME: Ownership-metric-rev-062303.dwg
SCALE: 1:4000 UNITS: Metric
URS Corporation
Denver, Colorado Tel:(303) 740-2600

Right of Way Plans- Supplemental

OWNERSHIP SHEET

Project Number: STA 009A-022
Project Location: Blue River CG to Ute Pass Rd.
Project Code: 12534 Last Mod. Date: 7/2/03 Subset Sheets: 6 Sheet No.: 6 Total No. of Sheets: 6

SECTION 5
SECTION 4

SECTION 5
SECTION 4


NW 1/4 SECTION 4
T. 4 S., R. 78 W., 6TH P.M.

SW 1/4 SECTION 33
T. 3 S., R. 78 W., 6TH P.M.

- 5 DOUGLAS W. PORREY AND
MARY M. PORREY
10425 GOOSE HAVEN DR.
LAFAYETTE, CO 80026
6 MARK H. WHITEHEAD AND
BREDNA L. WHITEHEAD
P.O. BOX 1017
FRISCO, CO 80443

1G UNITED STATES OF AMERICA
740 SIMMS,
LAKEWOOD, CO

SECTION 4
SECTION 33

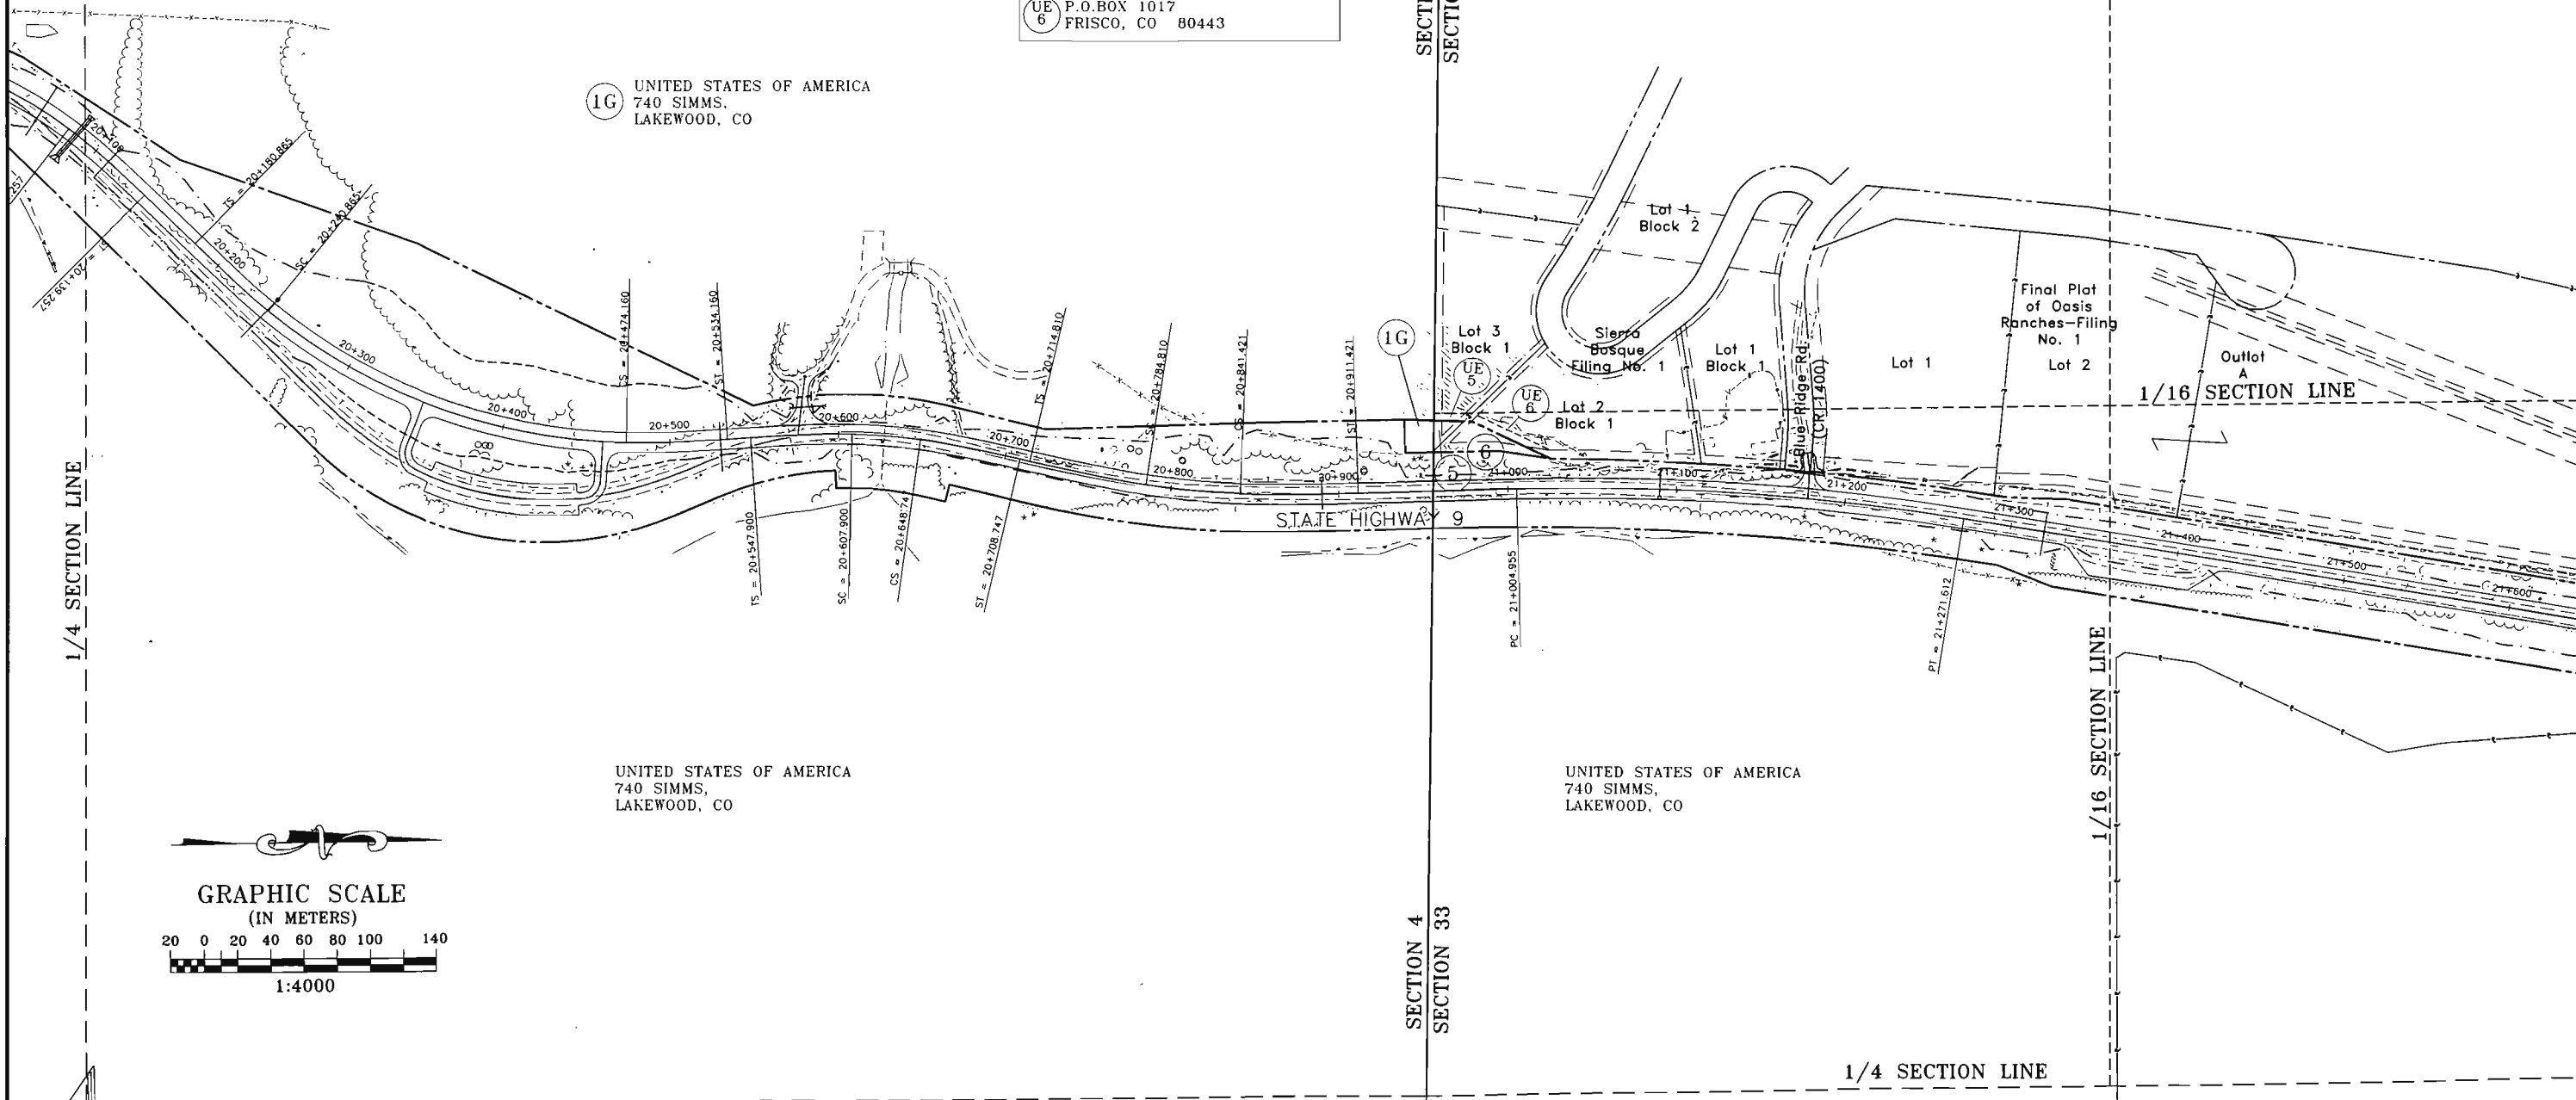

FILING CERTIFICATION:
DEPOSITED THIS ____ DAY OF ____ AT ____ M., FOR INFORMATION
ONLY IN BOOK ____ OF THE COUNTY LAND SURVEYS/RIGHT OF WAY
SURVEYS AT PAGE ____ RECEPTION NUMBER ____

SIGNED _____
DEPT. _____

I:\6844304.10\cad\own\PLANS\Ownership-metric-rev-062303.dwg 06/20/2003 08:44:43 AM MDT