 


COLORADO DEPARTMENT OF TRANSPORTATION



Region: 2

905 Erie Ave.

Pueblo, CO. 81002

Phone: (719) 546-5487 FAX: (719) 546-5414

Right of Way Plans Unit: Larry R, Lucas

Sheet Revisions				Sheet Revisions				Sheet Revisions				Right of Way Plans				
												OWNERSHIP TABULATIONS				
												Project Number: STA 012A-034				
												Project Location: Weston East				
												Project Location: Highway 12				
												Project Code:	Last Mod. Date	Subset Sheets	Sheet No.	Total No. of Sheets
												12834	02/04/02	1 of 5	2 of 2-20	24


R.O.W. TABULATION OF PROPERTIES IN Las Animas County

S.H. NO. 12

PARCEL NO.	OWNER	ADDRESS	LOCATION IN T. 33 S., R 66 W., 6th P.M.	AREA IN ACRES					TITLE DOCUMENT NO.	REMARKS
				AREA OF PARCEL	EXISTING ROW	NET AREA	REMAINDER			
							LEFT	RIGHT		
1	Richard S. Lopez & Sylvia A. Lopez Home: 719-868-3307	19901 Highway 12 Weston, CO. 81091	N.E. 1/4 Section 32	0.023 ±	N/A	0.023 ±	8.083 ±	N/A	67956	Acquired for construction of driveway improvements. Acquired for construction of pipes, detention basin, and outlet to ditch
TE1	same as above	same as above	same as above	0.145±	N/A	0.145 ±	N/A	N/A		
TE1A	same as above	same as above	same as above	0.129 ±	N/A	0.129 ±	N/A	N/A		
2	Wayne F. & Mary A. Weaver (1/2) Aron C. Weaver, Johnathon C. Weaver, Samuel B. Weaver, R. Laurie Hancock, Jason M. Weaver, (1/10th each)	#3 Pine, P.O. Box 192 Cokedale, CO. 81032	N.E. 1/4 Section 33	0.015 ±	N/A	0.015 ±	N/A	7.345 ±	67958	Acquired for construction of driveway improvements. Acquired for construction of a drainage pipe.
2A	same as above	same as above	same as above	0.014 ±	N/A	0.014 ±	N/A	5.236 ±		
TE2	same as above	same as above	same as above	0.009 ±	N/A	0.009 ±	N/A	N/A		
TE2A	same as above	same as above	same as above	0.005 ±	N/A	0.005 ±	N/A	N/A		
3	Michael L. Thompson & Shelia Thompson	8921 West Bopp Road Tucson, AZ 85746	N.E. 1/4 Section 32	0.015 ±	N/A	0.015 ±	N/A	0.225 ±	67957	Acquired for construction of driveway improvements and drainage pipe.
TE3	same as above	same as above	same as above	0.029 ±	N/A	0.029 ±	N/A	N/A		
TE4	Joe N. Trujillo Jr. & Isabel Louise Trujillo	19941 Highway 12 Weston, CO 81091	N.E. 1/4 Section 32	0.004 ±	N/A	0.004 ±	N/A	N/A		Acquired for construction of driveway improvements
TE4A	same as above	same as above	same as above	0.004 ±	N/A	0.004 ±	N/A	N/A		Acquired for construction of driveway improvements.
5	Clarence Kenneth Beebe	20001 Highway 12 Weston, CO 81091	N.E. 1/4 Section 32	0.020 ±	N/A	0.020 ±	N/A	9.300 ±	67906	Acquired for construction of driveway improvements. Acquired for construction of driveway improvements and drainage pipe. Acquired for construction of drainage pipe.
TE5	same as above	same as above	same as above	0.006 ±	N/A	0.006 ±	N/A	N/A		
TE5A	same as above	same as above	same as above	0.038 ±	N/A	0.038 ±	N/A	N/A		
TE5B	same as above	same as above	same as above	0.025 ±	N/A	0.025 ±	N/A	N/A		
TE7	Irvin W. Shupe & Mary Jane Shupe Home: 719-868-3370	20011 Highway 12 Weston, CO 81091	NE 1/4 Sec 32 & NW 1/4 Sec 33	0.025 ±	N/A	0.025 ±	N/A	N/A		Acquired for construction of driveway improvements.

COLORADO DEPARTMENT OF TRANSPORTATION				Sheet Revisions		Sheet Revisions		Sheet Revisions		Right of Way Plans	
 Region: 2 905 Erie Ave. Pueblo, CO. 81002 Phone: (719) 546-5487 FAX: (719) 546-5414 Right of Way Plans Unit: Larry R, Lucas										OWNERSHIP TABULATIONS	
										Project Number: STA 012A-034	
										Project Location: Weston East	
										Project Location: Highway 12	
										Project Code: 12834 Last Mod. Date: 02/04/02 Subset Sheets: 2 of 5 Sheet No.: 2A of 2-2D Total No. of Sheets: 23	
R.O.W. TABULATION OF PROPERTIES IN Las Animas County S.H. NO. 12											
PARCEL NO.	OWNER	ADDRESS	LOCATION IN T. 33 S., R 66 W., 6th P.M.	AREA IN ACRES					TITTLE DOCUMENT NO.	REMARKS	
				AREA OF PARCEL	EXISTING ROW	NET AREA	REMAINDER				
LEFT	RIGHT										
PE8 TE8 TE8A	Sam D. Gettings Josephine M. Gettings	4234 Kiva Trail S.W. Los Lunas, NM 87031	N.W. 1/4 Section 33	0.010 ±	N/A	0.010 ±	N/A	N/A	67893	Acquired for construction of roadway improvements.	
	same as above	same as above	same as above	0.003 ±	N/A	0.003 ±	N/A	N/A		Acquired for construction of driveway improvements.	
	same as above	same as above	same as above	0.016 ±	N/A	0.016 ±	N/A	N/A		Acquired for construction of driveway improvements.	
9 TE9	Primero Union High School Contact: Eric Davies 719-868-2715	20200 Highway 12 Weston, CO 81091	N.W. 1/4 Section 33	0.178 ±	N/A	0.178 ±	N/A	20.172 ±	67904	Acquired for construction of driveway improvements.	
	same as above	same as above	same as above	0.056 ±	N/A	0.056 ±	N/A	N/A			
10	Floyd J. Brown and Sadie M. Brown Home: 719-868-3398	20199 Highway 12 Weston, CO 81091	N.W. 1/4 Section 33	0.095 ±	N/A	0.095 ±	10.315 ±	N/A	67920		
11 11A TE11 TE11A	Joseph T. Marquez, Margaret M. Bradeen, Rosalie C. Miller & Madeline Marquez (Life Estate) Contact: Madeline Marquez Home: 719-868-2287	20350 County Road 41.7 Weston, CO 81091	W. 1/2 Section 33	0.442 ±	N/A	0.442 ±	7.268 ±	N/A	67892	Acquired for construction of driveway improvements. Acquired for construction of drainage pipe.	
	same as above	same as above	W. 1/2 Section 33	0.020 ±	N/A	0.020 ±	N/A	8.300 ±			
	same as above	same as above	same as above	0.009 ±	N/A	0.009 ±	N/A	N/A			
	same as above	same as above	same as above	0.008 ±	N/A	0.008 ±	N/A	N/A			
12	Sam D. Gettings Josephine M. Gettings	4234 Kiva Trail S.W. Los Lunas, NM 87091	W. 1/2 Section 33	1.016 ±	N/A	1.016 ±	1.830	N/A	67893		
13	Ronald Elton Leef and Cheryl Ann Leef	20199 Highway 12 Weston, CO 81091	S. 1/2 Section 33	3.147 ±	N/A	3.147±	119.853 ±	N/A	66754		
14 TE14 TE 14A	Marcus Gonzales and Geraldine Gonzales	12732 East 2nd Ave. Aurora, CO 80011	SW 1/4 Sec 33	0.067 ±	N/A	0.067 ±	N/A	49.473 ±	67935	Acquired for construction of drainage improvements. Acquired for construction of drainage pipe.	
	same as above	same as above	SW 1/4 Sec 33	0.016 ±	N/A	0.016 ±	N/A	N/A			
	same as above	same as above	same as above	0.026 ±	N/A	0.026 ±	N/A	N/A			

 COLORADO DEPARTMENT OF TRANSPORTATION



Region: 2

905 Erie Ave.

Pueblo, CO. 81002

Phone: (719) 546-5487 FAX: (719) 546-5414


Right of Way Plans Unit: Larry R, Lucas

Sheet Revisions				Sheet Revisions				Sheet Revisions				Right of Way Plans					
OWNERSHIP TABULATIONS																	
Project Number: STA 012A-034																	
Project Location: Weston East																	
Project Location: Highway 12																	
Project Code:	Last Mod. Date	Subset Sheets	Sheet No.	Total No. of Sheets													
12834	02/04/02	3 of 5	2B of 2-2D	23													

R.O.W. TABULATION OF PROPERTIES IN Las Animas County

S.H. NO. 12

PARCEL NO.	OWNER	ADDRESS	LOCATION IN T. 33 S., R 66 W., 6th P.M.	AREA IN ACRES					TITLE DOCUMENT NO.	REMARKS
				AREA OF PARCEL	EXISTING ROW	NET AREA	REMAINDER			
							LEFT	RIGHT		
16	Henry Guilbert Duran Theresa C. Duran	20740 Highway 12 Weston, CO. 81091	S.W. 1/4 Section 33	0.112 ±	N/A	0.112 ±	N/A	1.090 ±	67914	
TE17	Larry Guara and Cathi Guara	20861 Highway 12 Weston, CO 81091	S.E. 1/4 Section 33	0.005 ±	N/A	0.005 ±	N/A	N/A		Acquired for construction of driveway improvements.
18	Alex J. Garcia Erleen Garcia	20750 Highway 12 Weston, CO 81091	S.E. 1/4 Section 33	0.459 ±	N/A	0.459 ±	N/A	4.597 ±	67936	
19	Clarita Medina	Unknown	S.E. 1/4 Section 33	0.047 ±	N/A	0.047 ±	0.114 ±	N/A	67619	
TE19	same as above	same as above	S.E. 1/4 Section 33	0.047±	N/A	0.047±	N/A	N/A		Acquired for construction of driveway improvements.
TE20	Mathew M. Trujillo Theresa J. Trujillo	13747 Highway 350 SP#8 Trinidad, CO 81082	S.E. 1/4 Section 33	0.004 ±	N/A	0.004 ±	N/A			Acquired for construction of driveway improvements.
21	Danny Gallegos, Joseph Edward Gallegos, & Martha Martinez	1222 S. Federal Denver, CO 80219	S.E. 1/4 Section 33	0.195 ±	N/A	0.195 ±	N/A	3.555 ±	67942	
TE21	same as above	same as above	S.E. 1/4 Section 33	0.004 ±	N/A	0.004 ±	N/A	N/A		Acquired for construction of driveway improvements.
TE21A	same as above	same as above	S.E. 1/4 Section 33	0.051±	N/A	0.051 ±	N/A	N/A		Acquired for construction of driveway improvements.
TE22	Juanita C. Lamorie	P.O. Box 795 Lander, Wyoming 82520	S.E. 1/4 Section 33	0.004 ±	N/A	0.004 ±	N/A	N/A		Acquired for construction of driveway improvements.
23	Michael Lee Duran and Shirley A. Duran Home: 719-868-3317	21050 Highway 12 Weston, CO 81091	S.E. 1/4 Section 33	0.414 ±	N/A	0.414 ±	N/A	9.702 ±	67710	
TE23	same as above	same as above	same as above	0.411 ±	N/A	0.411 ±	N/A	N/A		Acquired for construction of driveway improvements and reconstruction of earth berm.
TE24	Michael Lee Duran and Geniveva Duran Home: 719-868-3317	21050 Highway 12 Weston, CO 81091	S.E 1/4 Section 33	0.005 ±	N/A	0.005 ±	N/A	N/A		Acquired for construction of driveway improvements.
TE25	William Kishman and Bessie Kishman Home: 719-868-3332	21061 Highway 12 Weston, CO 81091	S.E. 1/4 Section 33	0.007 ±	N/A	0.007 ±	N/A	N/A		Acquired for construction of driveway improvements.

 

COLORADO DEPARTMENT OF TRANSPORTATION

Region: 2
905 Erie Ave.
Pueblo, CO. 81002
Phone: (719) 546-5487 FAX: (719) 546-5414

Right of Way Plans Unit: Larry R, Lucas

Sheet Revisions		

Sheet Revisions		

Sheet Revisions		

Right of Way Plans				
OWNERSHIP TABULATIONS				
Project Number: STA 012A-034				
Project Location: Weston East				
Project Location: Highway 12				
Project Code:	Last Mod. Date	Subset Sheets	Sheet No.	Total No. of Sheets
12834	02/04/02	4 of 5	2C of 2-2D	23

R.O.W. TABULATION OF PROPERTIES IN Las Animas County

S.H. NO. 12

PARCEL NO.	OWNER	ADDRESS	LOCATION IN T. 33 S., R 66 W., 6th P.M.	AREA IN ACRES					TITLE DOCUMENT NO.	REMARKS
				AREA OF PARCEL	EXISTING ROW	NET AREA	REMAINDER			
							LEFT	RIGHT		
26	Florence Sandoval Home: 719-868-3392 Work: 719-868-2715	21200 Highway 12 Weston, CO 81091	S.E. 1/4 Section 33	0.085 ±	N/A	0.085 ±	N/A	4.915 ±	67938	
27	Richard S. Lopez & Sylvia A. Lopez Home: 719-868-3307	19901 Highway 12 Weston, CO 81091	S. 1/2 Sections 33 & 34	4.500 ±	N/A	4.500 ±	486 ±	N/A	67801	
TE 27A	same as above	same as above	same as above	0.229 ±	N/A	0.229 ±	N/A	N/A		Acquired for the construction of a drainage culvert.
TE 27	same as above	same as above	same as above	0.017 ±	N/A	0.017 ±	N/A	N/A		Acquired for construction of driveway improvements.
28	C. Manuel Ortega, Candido M Ortega and Beatrice V. Ortega	1250 So. Raleigh Denver, CO 80219	S.E. 1/4 Section 33	0.178 ±	N/A	0.178 ±	N/A	16.052 ±	67940	
TE 28	same as above	same as above	same as above	0.010 ±	N/A	0.010 ±	N/A	N/A		Acquired for the construction of a drainage pipe.
29	Florence Marie Sandoval Louise Sandoval	21200 Highway 12 Weston, CO 81091	S.E. 1/4 Section 33	0.035 ±	N/A	0.035 ±	N/A	0.875 ±	67943	
TE 29	same as above	same as above	same as above	0.046 ±	N/A	0.046 ±	N/A	N/A		Acquired for construction of driveway improvements.
PE30	B. F. Hill dba Hill Ranch & F.R. Hill dba FE Hill Company Contact: Mike Powell Cell: 719-680-2151 Work: 719-846-2110	P. O. Box 226 Fairfield, TX 75840	S 1/2 Sections 33 & 34	0.290 ±	N/A	0.290 ±	N/A	N/A	67960	Acquired for construction of roadway improvements.
TE 30	same as above	same as above	same as above	0.030 ±	N/A	0.030 ±	N/A	N/A		Acquired for the construction of a drainage pipe.
PE31	Dustin D. LePlatt, Howard E. LePlatt & Kaye LePlatt Contact: Dustin D. LePlatt Home: 719-868-3333 Work: 719-845-0500	21600 Highway 12 Trinidad, CO 81082	S. 1/2 Section 34	0.450 ±	N/A	0.450 ±	N/A	N/A	67954	Acquired for construction of roadway improvements.
TE 31	same as above	same as above	same as above	0.014 ±	N/A	0.014 ±	N/A	N/A		Acquired for construction of driveway improvements.
32	Howard E. LePlatt & Bernice B. LePlatt Contact: Bernice B. LePlatt Home: 719-846-8467 Work: 719-868-2715	21600 W. Highway 12 Trinidad, CO 81082	S.E. 1/4 Section 34	0.486 ±	N/A	0.486 ±	5.600 ±	41.917 ±	67945	
PE32	same as above	same as above	same as above	0.050 ±	N/A	0.050 ±	N/A	N/A		Acquired for construction of roadway improvements.
TE32	same as above	same as above	same as above	0.016 ±	N/A	0.016 ±	N/A	N/A		Acquired for construction of driveway improvements.

h



Region 2
905 Erie Ave., P.O. Box 536
Pueblo, CO. 81002
Phone: (719) 546-5487 FAX: (719) 546-5414

Right of Way Plans Unit: Larry R. Lucas

Sheet Revisions

Sheet Revisions

Sheet Revisions

Right of Way Plans

CONTROL DIAGRAM

Project Number: STA 012A-034

Project Location: Highway 12

Project Location: Weston East

Project Code:	Last Mod. Date	Subset Sheets	Sheet No.	Total No. of Sheets
12834	01/18/02	1 of 4	3 of 3-36	23

Township 33 South, Range 66 West, 6th P.M., Las Animas County

Sections 32, 33 & 34

DEPARTMENT OF TRANSPORTATION
STATE OF COLORADO

SURVEY CONTROL DIAGRAM

PROJECT STA 012A-034
STATE HIGHWAY 12 - WESTON EAST
LAS ANIMAS COUNTY

GENERAL NOTES

This survey was conducted to verify existing control and provide supplemental control for future highway design and construction purposes and is for the use of the Colorado Department of Transportation.

Coordinates as shown are project coordinates in U.S. feet (unless otherwise specified). Elevations as shown are based upon differential levels from U.S.G.S. Benchmark J67 as indicated in the appropriate N.O.A.A. data sheet, Elevation 6720.46.

Bearings were based upon S84°42'37"E between H.A.R.N. point J67B and 5433 as shown on established control as provided by the Colorado Department of Transportation.

This Control diagram does not represent a monumented land survey. It is intended to provide information in regard to the found existing control points and supplemental control points set.


NOTICE: according to Colorado law you must commence any legal action based upon any defect in this survey within three years after you first discover such defect. In no event may any action based upon any defect in this survey be commenced more than ten years from the date of the certification shown herein.

I, JOSEPH E. CHUMBLEY, A PROFESSIONAL LAND SURVEYOR DULY LICENSED UNDER THE LAWS OF THE STATE OF COLORADO, DO HEREBY STATE TO THE COLORADO DEPARTMENT OF TRANSPORTATION, THAT PROJECT SURVEY CONTROL AND THIS SURVEY CONTROL DIAGRAM WERE DONE UNDER MY SUPERVISION AND CHECKING.

FOR AND ON BEHALF OF WASHINGTON INFRASTRUCTURE SERVICES, INC.


JOSEPH E. CHUMBLEY, PLS
PROFESSIONAL LAND SURVEYOR
COLORADO REGISTRATION NO. 30088

DATE

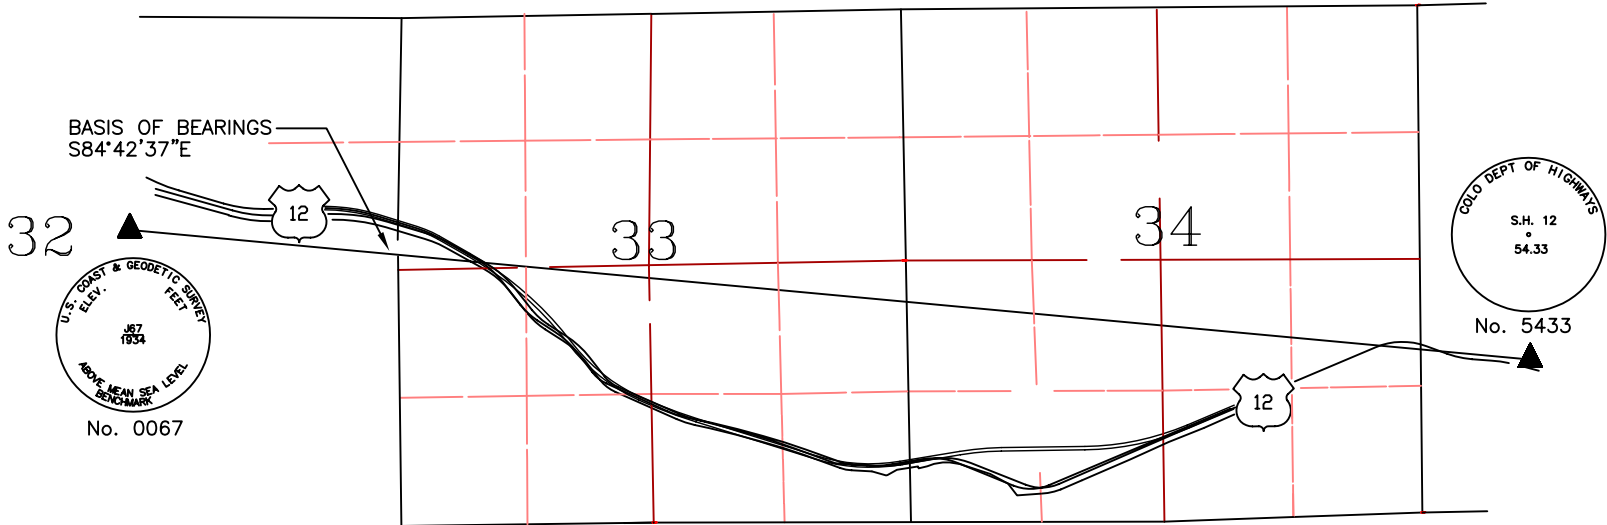

LEGEND

- INDICATES LAND CORNERS (ALIQUOT OR GRANT LINE)
- INDICATES OTHER FOUND PROPERTY OR RIGHT OF WAY MONUMENT EVIDENCE
- INDICATES PRIMARY CONTROL POINT SET BY WASHINGTON INFRASTRUCTURE SERVICES, INC.
- INDICATES PRIMARY CONTROL POINT PROVIDED BY COLORADO DEPARTMENT OF TRANSPORTATION

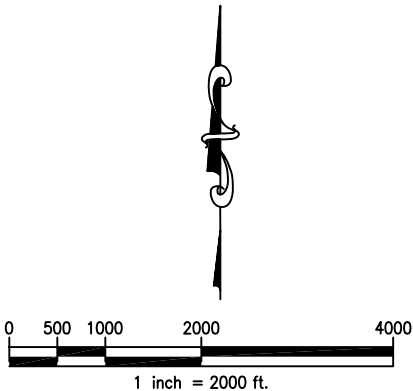

Washington
Infrastructure Services, Inc.



Region 2
905 Erie Ave., P.O. Box 536
Pueblo, CO. 81002
Phone: (719) 546-5487 FAX: (719) 546-5414

Right of Way Plans Unit: Larry R. Lucas

Sheet Revisions

Sheet Revisions

Sheet Revisions

Right of Way Plans

CONTROL DIAGRAM

Project Number: STA 012A-034


Project Location: Highway 12

Project Location: Weston East

Project Code:	Last Mod. Date	Subset Sheets	Sheet No.	Total No. of Sheets
12834	01/18/02	2 OF 4	3A OF 3-3C	23

Township 33 South, Range 66 West, 6th P.M., Las Animas County

Sections 32, 33 & 34

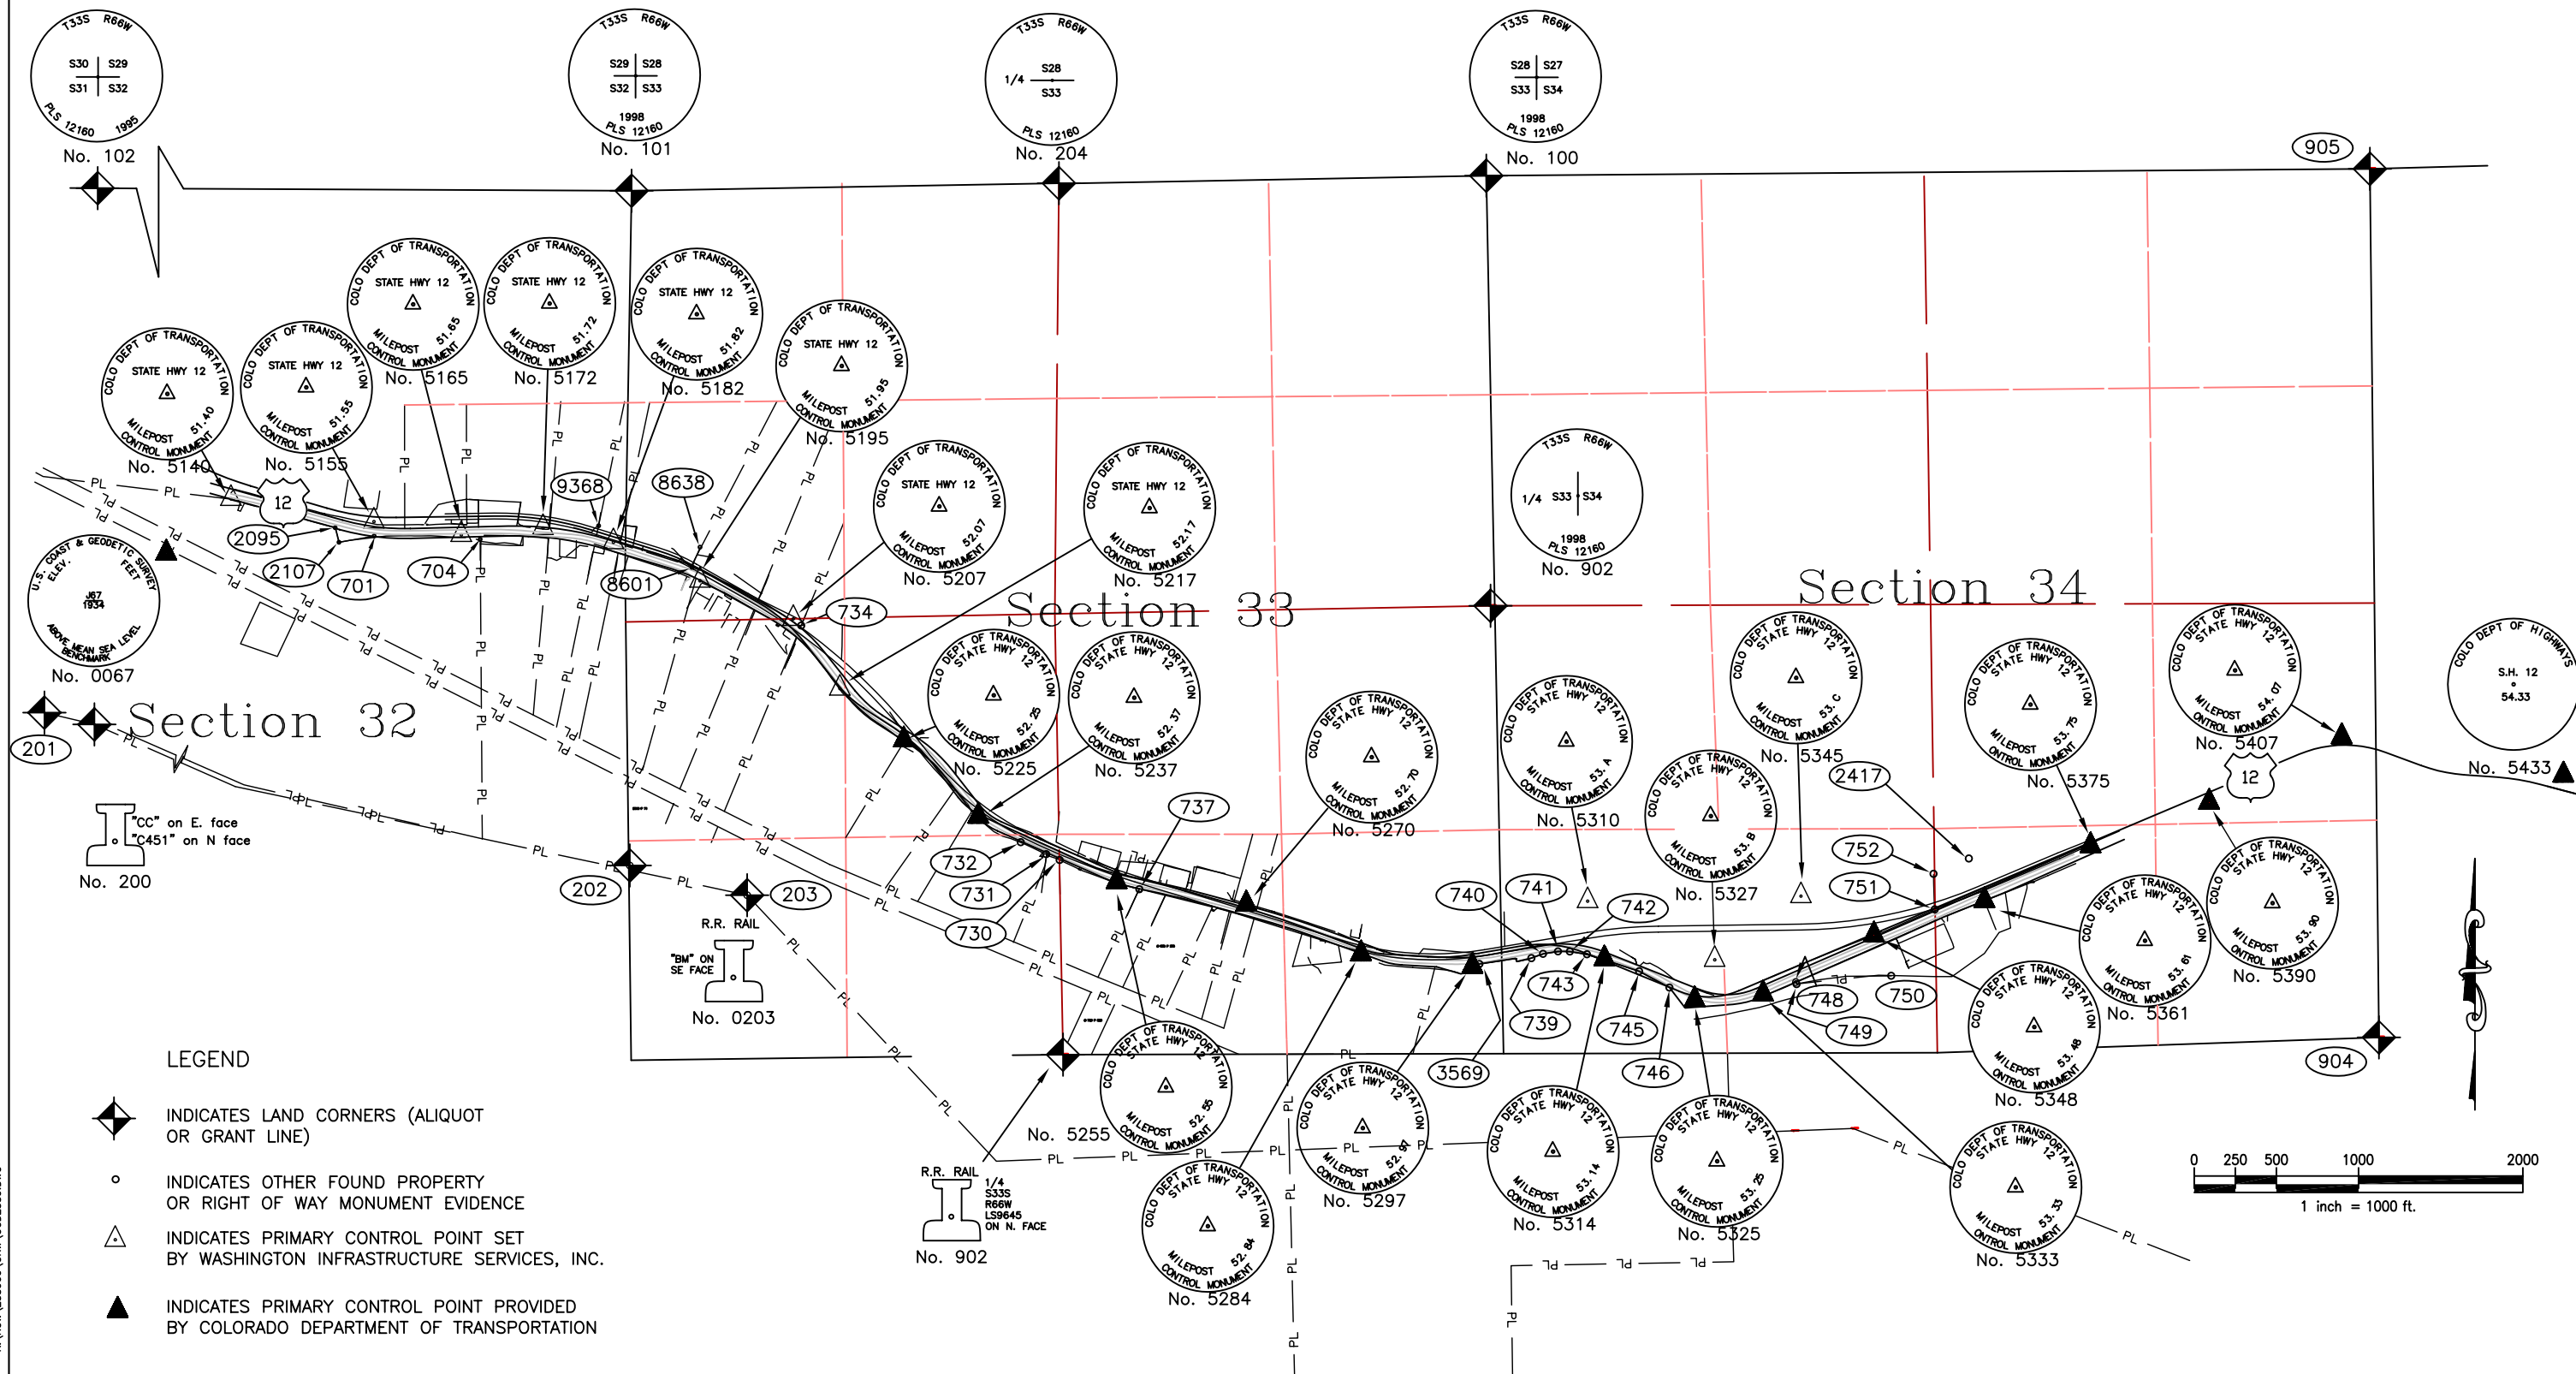



Region 2
905 Erie Ave., P.O. Box 536
Pueblo, CO. 81002
Phone: (719) 546-5487 FAX: (719) 546-5414

Right of Way Plans Unit: Larry R. Lucas

Sheet Revisions		

Sheet Revisions		

Sheet Revisions		

Right of Way Plans				
CONTROL DIAGRAM				
Project Number: STA 012A-034				
Project Location: Highway 12				
Project Location: WESTON EAST				
Project Code:	Last Mod. Date	Subset Sheets	Sheet No.	Total No. of Sheets
12834	01/18/02	3 of 4	3B of 3-3C	23

PROJECT COORDINATES

EXISTING CONTROL PROVIDED BY C.D.O.T.

POINT	NORTHING	EASTING	ELEVATION	DESCRIPTION
67			6720.46	3 1/2" USC&GS BRASS CAP "J67 1934"
5225	168239.7225	208553.8668	6682.67*4	CDOT CM-SH 12 MP 52.25 R
5237	167775.5995	209007.7558	6692.76*4	CDOT CM-SH 12 MP 52.37 R
5255	167378.6875	209849.2918	6697.12*4	CDOT CM-SH 12 MP 52.55 R *1
5270	167241.8875	210638.0028	6687.08*4	CDOT CM-SH 12 MP 52.70 L
5284	166937.9065	211336.4638	6650.77*4	CDOT CM-SH 12 MP 52.84 R
5297	166863.0915	212015.0798		CDOT CM-SH 12 MP 52.97 R *2
5314	166906.6855	212817.6178	6618.18*4	CDOT CM-SH 12 MP 53.14 R
5325	166658.5965	213366.6118	6614.94*4	CDOT CM-SH 12 MP 53.25 R
5333	166694.1125	213783.0588	6626.80*4	CDOT CM-SH 12 MP 53.33 R
5348	167053.4975	214457.6978	6631.87*4	CDOT CM-SH 12 MP 53.48 L
5361	167263.1525	215130.8728		CDOT CM-SH 12 MP 53.61 R *3
5375	167596.5215	215776.3708	6593.53*4	CDOT CM-SH 12 MP 53.75 L
5390	167860.8785	216498.4298		CDOT CM-SH 12 MP 53.09 R
5407	168259.3635	217304.9168		CDOT CM-SH 12 MP 54.07 L
5421	168036.8305	218028.9998		CDOT CM-SH 12 MP 54.21 R
5433	168025.7490	218654.0100		CDOT CM-SH 54.33

*1 DISTURBED - WASHINGTON GROUP INFRASTRUCTURE INC. VALUES FOR THIS POINT ARE
N 167378.586 E 209849.596 ELEV 6697.124

*2 NOT FOUND - POSSIBLY DESTROYED

*3 UNOCCUPY-ABLE - NEXT TO NEW FENCE - POSSIBLY DISTURBED

*4 GROUND ELEVATIONS WERE NOT PROVIDED BY C.D.O.T., BUT WERE DETERMINED BY DIFFERENTIAL
LEVELS BASED UPON U.S.C. & G.S. POINT J67.

CONTROL SET BY WASHINGTON INFRASTRUCTURE SERVICES, INC.

POINT	NORTHING	EASTING	ELEVATION	DESCRIPTION (STAMPED AS SHOWN ON SHEET 2)
5140	169708.495	204458.935	6743.23	CDOT TYPE 2 "MP 51.40"
5155	169570.397	205328.868	6753.25	CDOT TYPE 2 W/2.1' LONG ROD *5 "MP 51.55"
5165	169489.184	205860.637	6728.07	CDOT TYPE 2 "MP 51.65"
5172	169531.263	206358.144	6727.60	CDOT TYPE 2 "MP 51.72"
5182	169444.497	206786.398	6709.76	CDOT TYPE 2 W/3' LONG ROD *5 "MP 51.82"
5195	169210.871	207313.478	6695.86	CDOT TYPE 2 "MP 51.95"
5207	168978.395	207880.862	6702.72	CDOT TYPE 2 W/2.4' LONG ROD *5 "MP 52.07"
5217	168554.033	208164.653	6674.62	CDOT TYPE 2 "MP 52.17"
5310	167261.186	212715.365	6683.86	CDOT TYPE 2 W/3' LONG ROD *5 "MP 53 A"
5327	166904.201	213488.809	6669.81	CDOT TYPE 2 "MP 53 B"
5345	167291.601	214013.590	6667.74	CDOT TYPE 2 "MP 53 C"

ALL SET MONUMENTS HAVE ORANGE CARSONITE POSTS

*5 - IN ROCK AREA - DRIVEN TO REFUSAL

EXISTING MONUMENTATION TIED BY WASHINGTON INFRASTRUCTURE SERVICES, INC.

POINT	NORTHING	EASTING	ELEVATION	DESCRIPTION
701	169483.272	205329.909	6736.53	YPC #4 REBAR PLS 12160
704	169463.046	205975.423	6718.62	YPC #4 REBAR PLS 12160
730	167511.840	209501.765	6684.08	#5 REBAR (NO CAP)
731	167547.291	209420.254	6686.58	#5 REBAR (NO CAP)
732	167620.155	209265.012	6687.02	#4 REBAR (NO CAP)
734	168938.414	207929.538	6696.06	YPC #4 REBAR (ILLEGIBLE)
737	167333.969	209986.991	6694.45	1.5" BRASS CAP LS 2548"
739	166914.464	212373.120	6619.79	YPC #4 REBAR PLS 12160
740	166940.977	212443.441	6619.79	YPC #4 REBAR PLS 12160
741	166955.477	212534.811	6621.09	YPC #4 REBAR PLS 12160
742	166954.776	212606.866	6621.46	YPC #4 REBAR PLS 12160
743	166937.910	212710.820	6621.13	YPC #4 REBAR PLS 12160
745	166834.530	213028.411	6615.26	YPC #4 REBAR PLS 12160
746	166735.702	213213.054	6614.96	YPC #4 REBAR PLS 12160
748	166768.493	213982.591	6623.38	YPC #4 REBAR PLS 12160
749	166756.563	213986.531	6622.79	YPC #4 REBAR PLS 12160
750	166807.338	214562.994	6616.59	LARGE SPIKE @ FENCE COR
751	167211.101	214827.358	6630.22	YPC #4 REBAR PLS 12160
752	167427.674	214820.425	6647.40	YPC #4 REBAR PLS 12160
2095	169533.36	205092.85	6740.75	YPC #4 REBAR PLS 12160
2107	169444.76	205116.02	6736.15	YPC #4 REBAR PLS 12160
2417	167520.99	215035.32	6627.31	YPC #4 REBAR PLS 12160
3569	166878.91	212056.46	6619.82	YPC #4 REBAR PLS 12160
8601	169291.94	207264.21	6700.86	YPC #4 REBAR PLS 12160
8638	169415.08	207313.27	6741.38	YPC #4 REBAR PLS 12160
9368	169545.05	206696.35	6733.02	1.5" IRON PIPE

LAND CORNERS TIED BY WASHINGTON INFRASTRUCTURE SERVICES, INC.

POINT	NORTHING	EASTING	DESCRIPTION
100	171675.045	212098.412	#6 REBAR W/ 2" AC PLS 12160 (NE COR SEC 33)
101	171582.786	206897.197	#6 REBAR W/ 2" AC PLS 12160 (NW COR SEC 33)
102	171610.69	201389.01	#6 REBAR W/ 2" AC LS 12160 (NW COR SEC 32)
200	169245.86	201568.06	VERT RR RAIL W/ "CC" ON E. FACE (LAND GRANT MARKER)
201	169317.52	201264.04	0.1 X 0.8 X 0.4 STONE (LAND GRANT MARKER)
202	167478.23	206885.67	#4 REBAR (NO CAP) IN MOUND OF STONES (CLOSING CORNER)
203	167297.33	207600.62	RR RAIL W/ "BM" ON SE FACE (LAND GRANT CORNER)
204	171629.02	209497.61	#6 REBAR W/ 2" AC LS 12160 (N 1/4 SEC 33)

LAND CORNER MONUMENT LOCATIONS PROVIDED BY C.D.O.T.

POINT	NORTHING	EASTING	DESCRIPTION
901	166327.76	209522.63	RR RAIL W/ "1/4 33" N. FACE (S 1/4 COR SEC 33) *5
902	169057.99	212124.53	2" AC PLS 12160 (E 1/4 SEC 33) *5
904	166432.58	217530.69	1/2" REBAR (NO CAP) IN STONE MOUND (SE COR 34) *5
905	171716.91	217476.39	#6 REBAR W/2" AC PLS 12160

*5 - DESCRIPTION FROM MOST RECENT MONUMENT RECORD FILED

COLORADO DEPARTMENT OF TRANSPORTATION



Region 2
905 Erie Ave., P.O. Box 536
Pueblo, CO. 81002
Phone: (719) 546-5487 FAX: (719) 546-5414

Right of Way Plans Unit: Larry R. Lucas

Sheet Revisions				Sheet Revisions				Sheet Revisions				Right of Way Plans				
												CONTROL DIAGRAM				
												Project Number: STA 012A-034				
												Project Location: Highway 12				
												Project Location: WESTON EAST				
Project Code:				Last Mod. Date				Subset Sheets				Sheet No.		Total No. of Sheets		
12834				01/18/02				4 of 4				3C of 3-3C		23		

STATE PLANE DATUM

STATE PLANE COORDINATES PROVIDED BY THE COLORADO DEPARTMENT OF TRANSPORTATION

US State Plane (METERS)
Colorado South 0503 NAD 1983/92
NAD83/92 COLORADO SOUTH ZONE

HORIZ ORDER	VERT ORDER	NAME	NORTH LATITUDE NAD83/92	WEST LONGITUDE NAD83/92	ELLIPSOID HEIGHT	NORTHING CO. SPC S ZONE	EASTING CO. SPC S ZONE	ORTHO HEIGHT NAVD88	SCALE FACTOR	CONVERGENCE	COMBINED FACTOR	NAME	DESCRIPTION
C1	2	J67B	37°07'43.68879	104°48'11.87456	2030.355	356321.474	976312.337	2048.401	1.000020617	00°25'38.42907	0.999702089	J67B	CGS CAP - BM J67
C2-I		5433	37°07'29.22461	104°45'11.93356	1990.767	355909.896	98757.469	2008.89	1.000021475	00°27'28.80093	0.999709156	5433	CDOT CM - SH 12 MP 54.33 LT

STATE PLANE COORDINATES OF OBSERVATIONS PERFORMED BY WASHINGTON INFRASTRUCTURE SERVICES, INC.

US State Plane 1983 (US FT)
Colorado South 0503 NAD 1983 (Conus) GEOID99 (Conus)
FINAL USFT NAD83 COLORADO SOUTH ZONE 503 COORDINATES

NAME	NORTHING	EASTING	ORTHO HEIGHT	LATITUDE	LONGITUDE	ELLIP HEIGHT	COMBINED FACTOR	SCALE FACTOR	ELEVATION FACTOR	CONVERGENCE
67	1169031.3692	3203118.0583	6720.4760	37°07'43.68879"N	104°48'11.87456"W	6661.7056	0.99970275	1.0000206172	0.99968214	0°25'38"
102	1171265.0095	3200441.9249	6843.3068	37°08'05.96824"N	104°48'44.71555"W	6784.6285	0.99969557	1.0000193051	0.99967627	0°25'18"
100	1171329.2825	3211148.1599	6798.7799	37°08'05.80372"N	104°46'32.50181"W	6739.6689	0.99969773	1.0000193147	0.99967842	0°26'39"
5140	1169363.3501	3203510.9641	6743.2280	37°07'46.94200"N	104°48'06.99246"W	6684.4394	0.99970147	1.0000204249	0.99968105	0°25'41"
5155	1169225.2899	3204380.6349	6753.2510	37°07'45.51264"N	104°47'56.26673"W	6694.4156	0.99970108	1.0000205093	0.99968058	0°25'48"
5165	1169144.0993	3204912.2440	6728.0670	37°07'44.67043"N	104°47'49.71010"W	6669.2299	0.99970233	1.0000205591	0.99968178	0°25'52"
5172	1169186.1632	3205409.6020	6727.5960	37°07'45.04926"N	104°47'43.56496"W	6668.7352	0.99970233	1.0000205367	0.99968180	0°25'56"
5182	1169099.4220	3205837.7280	6709.7620	37°07'44.15972"N	104°47'38.28668"W	6650.8726	0.99970324	1.0000205893	0.99968265	0°25'59"
5195	1168865.8626	3206364.6478	6695.8570	37°07'41.81116"N	104°47'31.80230"W	6636.9093	0.99970404	1.0000207283	0.99968332	0°26'03"
5207	1168633.4554	3206931.8611	6702.7230	37°07'39.47086"N	104°47'24.82041"W	6643.7893	0.99970385	1.0000208669	0.99968299	0°26'07"
5217	1168209.2189	3207215.5648	6674.6160	37°07'35.25523"N	104°47'21.35725"W	6615.6512	0.99970544	1.0000211169	0.99968433	0°26'09"
5225	1167894.9966	3207604.6694	6682.6730	37°07'32.11930"N	104°47'16.58245"W	6623.6867	0.99970525	1.0000213031	0.99968395	0°26'12"
5327	1166559.8595	3212538.1171	6669.7283	37°07'18.54297"N	104°46'15.79735"W	6610.5960	0.99970668	1.0000221120	0.99968458	0°26'50"
5345	1166947.1421	3213062.7419	6667.6980	37°07'22.33139"N	104°46'09.28267"W	6608.5445	0.99970655	1.0000218858	0.99968467	0°26'54"
5433	1167681.0530	3217701.7963	6591.2521	37°07'29.22461"N	104°45'11.93356"W	6531.9314	0.99970980	1.0000214752	0.99968833	0°27'29"
5348	1166709.1120	3213506.7252	6631.7680	37°07'19.94368"N	104°46'03.82401"W	6572.6189	0.99970841	1.0000220283	0.99968639	0°26'57"
5310	1166916.7411	3211764.9070	6683.8147	37°07'22.13090"N	104°46'25.30951"W	6624.7088	0.99970579	1.0000218978	0.99968390	0°26'44"
101	1171237.0757	3205948.4966	6884.7638	37°08'05.28581"N	104°47'36.71931"W	6825.8577	0.99969365	1.0000193451	0.99967431	0°26'00"

THIS DATA IS RAW DATUM FOR CALIBRATION PURPOSES

	LATITUDE	LONGITUDE	ELLIP HEIGHT
67_GPS	37°07'43.68879"N	104°48'11.87456"W	6661.2671
102_GPS	37°08'05.96815"N	104°48'44.71551"W	6784.1438
5433_GPS	37°07'29.22482"N	104°45'11.93431"W	6531.4170
100_GPS	37°08'05.80372"N	104°46'32.50226"W	6739.0854
5140_GPS	37°07'46.94200"N	104°48'06.99247"W	6684.0028
5155_GPS	37°07'45.51264"N	104°47'56.26679"W	6693.9777
5165_GPS	37°07'44.67047"N	104°47'49.71021"W	6668.7857
5172_GPS	37°07'45.04929"N	104°47'43.56507"W	6668.2940
5182_GPS	37°07'44.15974"N	104°47'38.28683"W	6650.4357
5195_GPS	37°07'41.81121"N	104°47'31.80247"W	6636.4778
5207_GPS	37°07'39.47091"N	104°47'24.82065"W	6643.3498
5217_GPS	37°07'35.25531"N	104°47'21.35753"W	6615.2251
5225_GPS	37°07'32.11944"N	104°47'16.58288"W	6623.2717
5327_GPS	37°07'18.54310"N	104°46'15.79792"W	6610.1983
5348_GPS	37°07'19.94369"N	104°46'03.82466"W	6572.2276
5345_GPS	37°07'22.33148"N	104°46'09.28326"W	6608.1270
5310_GPS	37°07'22.13103"N	104°46'25.31006"W	6624.2802
101_GPS	37°08'05.28576"N	104°47'36.71951"W	6825.3291

STATE PLANE COORDINATE NOTES

THE ORIGIN AND APPLICABLE TRANSFORMATION FACTORS OF THE STATE PLANE VALUES FOR THIS PROJECT WERE NOT PROVIDED BY THE COLORADO DEPARTMENT OF TRANSPORTATION, AND THE PUBLISHED PROJECT COORDINATES ARE THE RESULT OF FIELD OBSERVATIONS TO DETERMINE THE MOST HARMONIOUS SCENARIO FOR THE GRID TO GROUND RELATIONSHIP.

COORDINATE TRANSFORMATIONS FROM STATE PLANE TO PROJECT COORDINATES FOR THIS PROJECT WERE DONE BY THE HELMERT TRANSFORMATION PROCESS.

THE COMBINED FACTOR APPLIED TO SPC NORTHING VALUES TO REACH PROJECT COORDINATES IS 0.9997049. THOSE ARE THEN TRUNCATED TO RESULT IN THESE PUBLISHED PROJECT COORDINATES.

THE COMBINED FACTOR APPLIED TO SPC EASTING VALUES TO REACH PROJECT COORDINATES IS 0.9997041. THOSE ARE THEN TRUNCATED TO RESULT IN THESE PUBLISHED PROJECT COORDINATES.

COLORADO DEPARTMENT OF TRANSPORTATION



Region 2
905 Erie Ave., P.O. Box 536
Pueblo, CO. 81002
Phone: (719) 546-5487 FAX: (719) 546-5414

Right of Way Plans Unit: Larry R. Lucas

Sheet Revisions

Sheet Revisions

Sheet Revisions

Right of Way Plans

MONUMENTATION

Project Number: STA 012A-034				
Project Location: Highway 12				
Project Location: WESTON EAST				
Project Code:	Last Mod. Date	Subset Sheets	Sheet No.	Total No. of Sheets
12834	01/18/02	1 of 2	4 of 4-4a	23

PERMANANT EASEMENT POINTS TO BE SET


PNT	NORTHING	EASTING	STATION	OFFSET
200	169417.23	206669.68	10+80.17	36.94 R
201	169404.87	206733.11	11+46.47	30.98 R
202	169379.10	206819.32	12+36.43	29.09 R
262	166868.16	212037.86	71+74.15	38.80 R
263	166885.27	212288.53	74+17.73	57.75 R
264	166943.23	212631.37	77+75.96	34.98 R
265	166914.71	212782.54	79+33.73	51.89 R
267	166759.57	214004.00	91+72.03	50.14 R
268	166780.24	214083.02	92+50.80	60.59 R
269	166839.34	214163.81	93+48.08	38.11 R
270	167015.03	214572.42	97+92.86	37.89 R
271	167139.45	214874.68	101+19.69	42.82 R
272	167153.54	214908.92	101+56.22	43.41 R
275	167299.41	215259.21	105+35.45	52.77 R
276	167395.86	215438.66	107+39.19	35.40 R
277	167359.69	215384.75	106+75.42	47.49 R
278	167301.53	215264.29	105+40.95	52.90 R

R.O.W. MONUMENTS TO BE SET

PNT	NORTHING	EASTING	STATION	OFFSET
300	169543.02	206145.93	5+42.14	34.77 L
301	169462.35	206750.30	11+45.22	29.00 L
302	169341.16	207155.67	15+68.22	37.88 L
303	169244.42	207385.43	18+11.59	35.74 L
304	169217.54	207433.88	18+66.58	34.93 L
305	169061.82	207815.33	22+76.28	78.52 L
306	169047.82	207956.98	23+98.45	136.25 L
307	168775.45	208278.00	27+71.98	156.16 L
308	168470.94	208512.63	31+87.45	104.09 L
309	168252.77	208755.06	35+01.66	91.83 L
310	168134.10	208823.70	36+29.82	59.11 L
311	167875.86	209077.18	39+99.87	51.72 L
312	167595.47	209482.74	45+04.06	41.57 L
313	167166.24	210974.72	60+68.61	63.68 L
314	167461.37	209785.91	48+39.93	46.48 L
315	167403.77	209962.00	50+30.75	46.96 L
316	167368.15	210124.44	51+98.67	49.58 L
317	167302.49	210392.95	54+75.06	45.74 L
318	167229.66	210662.59	57+52.95	39.42 L
319	167210.76	210730.90	58+23.50	38.85 L
320	167094.69	211225.35	63+28.68	69.99 L
321	167068.01	211241.40	63+51.96	49.32 L
322	167021.31	211423.86	65+41.41	58.75 L
323	167099.95	211570.55	66+85.14	166.60 L
324	167090.73	211672.36	67+97.91	166.76 L
325	167026.27	211845.83	69+75.59	114.99 L
326	167026.28	211937.98	70+72.78	120.56 L
327	166987.27	212065.03	72+09.54	78.31 L
328	166988.91	212124.91	72+73.08	73.73 L
329	166997.51	212243.49	73+96.90	61.39 L
330	167023.77	212419.41	75+69.71	56.41 L
331	166980.37	213069.72	81+97.32	76.35 L
332	166969.85	213205.47	83+21.49	113.88 L
333	166847.61	213557.45	87+25.07	99.16 L
334	166837.64	213809.69	90+03.43	78.36 L
335	166865.19	214020.31	92+25.88	42.01 L
336	167041.44	214398.22	96+43.21	55.11 L
337	167234.01	214814.68	101+01.87	67.75 L
338	167351.64	215087.23	103+99.62	64.94 L
339	167454.93	215347.18	106+78.26	54.85 L
340	167509.16	215537.18	108+74.29	30.13 L
342	169483.04	206147.43	5+45.82	25.12 R
343	169482.77	206251.62	6+50.59	19.90 R
344	169466.87	206349.67	7+49.69	28.47 R
345	169454.53	206482.84	8+83.42	30.77 R
346	169440.78	206569.44	9+73.72	34.39 R

PNT	NORTHING	EASTING	STATION	OFFSET
347	169415.37	206677.57	10+88.56	36.72 R
348	169378.23	206801.94	12+20.16	35.24 R
349	169291.67	207068.10	15+00.03	36.07 R
350	169210.87	207313.48	17+62.38	26.43 R
351	169032.36	207629.03	21+26.17	35.69 R
352	169016.57	207661.62	21+62.35	34.15 R
353	168976.20	207745.17	22+55.06	30.12 R
354	168742.90	208020.52	26+31.79	61.46 R
355	168506.17	208208.67	29+34.98	68.94 R
356	168341.27	208391.64	31+69.23	72.32 R
357	168223.39	208576.45	33+91.18	50.70 R
358	168012.64	208808.23	37+09.19	33.97 R
359	167812.48	208964.45	39+55.15	69.57 R
360	167689.18	209122.57	41+49.89	67.73 R
361	167611.73	209297.67	43+34.44	34.88 R
362	167477.18	209457.38	45+34.55	75.45 R
363	167413.22	209666.98	47+49.49	44.64 R
364	167357.49	209781.57	48+73.08	52.05 R
365	167282.24	210000.45	50+97.07	61.92 R
366	167216.66	210271.55	53+75.98	65.11 R
367	167181.85	210519.22	56+25.86	42.41 R
368	167082.13	210859.21	59+82.09	49.99 R
369	167014.46	211140.02	62+71.21	32.05 R
370	166896.84	211467.04	66+13.78	51.44 R
371	166873.10	211584.71	67+27.58	57.19 R
372	166861.92	211796.14	69+37.89	52.52 R
373	166819.26	211943.16	70+83.16	86.27 R
374	166822.55	211958.92	70+97.90	82.76 R
375	166878.91	212056.46	71+92.85	29.16 R
376	166913.30	212276.83	74+12.04	27.91 R
377	166893.88	212283.90	74+14.96	48.37 R
378	166914.44	212373.29	75+08.62	45.21 R
379	166940.56	212443.67	75+83.89	29.07 R
380	166955.58	212535.04	76+77.85	21.39 R
381	166954.81	212607.17	77+51.10	23.71 R
382	166938.01	212711.03	78+57.82	36.22 R
383	166834.51	213028.72	82+03.98	75.01 R
384	166735.69	213213.43	84+17.34	99.53 R
385	166611.39	213308.69	85+36.83	183.60 R
386	166630.20	213558.00	87+45.60	117.28 R
387	166673.95	213763.38	89+32.96	76.61 R
388	166768.49	213982.63	91+55.64	34.39 R
389	166987.22	214488.10	97+04.41	30.17 R
390	167165.85	214884.77	101+39.37	22.54 R
391	167315.22	215256.81	105+39.69	37.36 R
393	167036.35	212657.72	77+99.35	58.88 L
394	167005.57	212973.34	81+02.68	73.68 L

MONUMENTATION

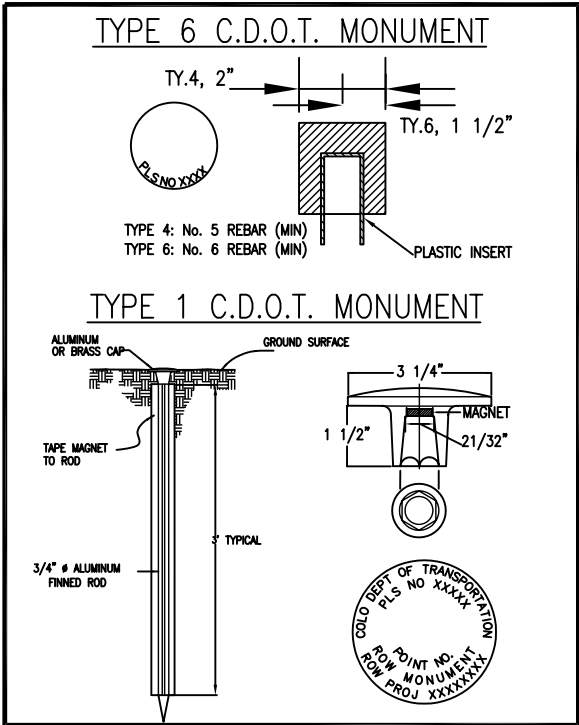

QUANTITY OF MONUMENTS TO BE RESET

CAP TYPE	MONUMENT TYPE									
	1	1A	2	2A	3	3A	4	4A	5	6
REFERENCE										
ROW	93									
CONTROL										
ALIQUOT CORNER										
WITNESS POST										
PERM. EASEMENT										17
C.R. ROW										

GENERAL NOTES

- Notice according to Colorado law you must commence any legal action based upon any defect found in this survey within three years after you find such defect. In no event may any action based upon any defect in this survey be commenced more than ten years from the date of the certification shown hereon.
- All coordinates listed are project coordinates in feet.
- Title commitments supplied by Trinidad Abstract & Title Co..
- Centerline stationing and offsets are proposed only and may not represent the present centerline as constructed.
- The monumenting land surveyor will, upon completion, certify to the monumentation as per the certification shown, and file with the county per C.R.S. 38-51-106.
- R.O.W. markers set must display the professional land surveyor's registration number.
- This right of way plan is not a complete boundary survey of all adjoining owners. Coordinates, Stations, and Offsets shown do not indicate actual field position of individual boundary lines. Positions shown are for use by CDot for appraisal purposes only and is prepared for CDOT purposes only.
- All R.O.W. markers will be set from survey control points, as shown on the control sheet.
- The contractor is responsible for the preservation and replacement of all disturbed aliquot corners and control monuments, under the direct supervision of a registered land surveyor.
- Aliquot corners that control this project and shown hereon which may be disturbed during the construction of this project, must be reset and monument records filed per rule xiii of bylaws and rules of procedure of the state board of registration for professional engineers and professional land surveyors and per 38-53-103, C.R.S., by the contractor's surveyor.
- Easements shown are of record.

OFFICE SURVEYOR CERTIFICATE

R.O.W. plans and legal descriptions were prepared under my supervision and checking.

Date _____ Name _____



Region 2
905 Erie Ave., P.O. Box 536
Pueblo, CO. 81002
Phone: (719) 546-5487 FAX: (719) 546-5414

Right of Way Plans Unit: Larry R. Lucas

Sheet Revisions			

Sheet Revisions			

Sheet Revisions			

Right of Way Plans				
MONUMENTATION				
Project Number: STA 012A-034				
Project Location: Highway 12				
Project Location: WESTON EAST				
Project Code:	Last Mod. Date	Subset Sheets	Sheet No.	Total No. of Sheets
12834	01/18/02	2 OF 2	4A of 4-4A	23

MONUMENTATION

TEMPORARY EASEMENT AND PARCEL POINTS

	PNT	NORTHING	EASTING	STATION	OFFSET		PNT	NORTHING	EASTING	STATION	OFFSET		PNT	NORTHING	EASTING	STATION	OFFSET		PNT	NORTHING	EASTING	STATION	OFFSET
100	169542.11	206271.61	6+66.29	40.70	L	159	167367.70	210172.38	52+45.50	59.88	L	222	168926.01	207792.19	23+20.62	51.95	R	401	169483.50	206217.48	6+16.26	21.33	R
101	169592.09	206273.16	6+64.24	90.65	L	160	167358.55	210167.46	52+42.75	49.86	L	223	168938.16	207770.02	22+95.00	51.84	R	402	169483.17	206236.27	6+35.15	20.51	R
102	169582.72	206402.77	7+93.94	91.04	L	161	167332.26	210278.06	53+56.42	49.02	L	225	168173.90	208646.64	34+78.50	40.18	R	403	169425.23	206236.35	6+39.01	78.34	R
103	169532.90	206398.39	7+93.31	41.04	L	162	167342.17	210279.73	53+55.83	59.05	L	226	168196.57	208589.41	34+19.46	62.28	R	404	169425.16	206216.68	6+18.90	79.62	R
104	169541.00	206416.34	8+10.61	50.46	L	163	167337.04	210300.16	53+76.89	58.63	L	227	167556.97	209421.46	44+67.48	20.97	R	405	169386.07	206216.14	6+20.73	118.67	R
105	169531.03	206415.46	8+10.48	40.45	L	164	167327.41	210297.45	53+76.41	48.63	L	228	167521.52	209501.61	45+54.28	16.15	R	406	169383.89	206286.41	6+92.85	115.97	R
106	169483.64	206673.35	10+67.33	28.33	L	165	167268.84	210517.52	56+03.43	41.67	L	229	167463.54	209502.08	45+79.31	68.23	R	407	169477.15	206286.28	6+85.71	22.98	R
107	169502.62	206677.32	10+66.65	47.71	L	166	167277.12	210514.79	55+98.84	49.06	L	230	167512.05	209415.98	44+83.36	63.23	R	408	169416.38	206537.23	9+44.02	63.15	R
108	169499.74	206686.94	10+76.26	47.26	L	167	167282.51	210534.64	56+16.72	59.02	L	231	167406.50	209761.64	48+37.58	13.48	R	409	169425.94	206560.30	9+66.70	50.46	R
109	169481.15	206683.05	10+77.09	28.29	L	168	167262.58	210540.73	56+27.34	41.13	L	232	167345.16	209949.15	50+33.40	12.98	R	410	169436.78	206586.47	9+91.75	35.53	R
110	169492.55	206710.92	11+00.26	46.53	L	169	167089.02	211110.01	62+20.30	30.14	L	233	167336.94	209986.65	50+71.48	11.78	R	411	169382.32	206788.24	12+05.86	35.55	R
111	169481.65	206707.55	10+99.96	35.12	L	170	166953.30	211487.35	66+21.93	7.98	L	234	167293.88	209966.57	50+62.34	58.36	R	412	169351.70	206778.36	12+05.83	67.72	R
112	169453.05	206799.25	11+94.67	35.15	L	171	166933.02	211587.88	67+24.97	2.75	L	236	167309.55	210111.59	51+99.28	10.41	R	413	169340.75	206812.29	12+41.49	67.75	R
113	169468.16	206801.48	11+92.16	50.22	L	172	166918.69	211858.61	69+96.09	8.62	L	237	167301.27	210148.76	52+37.36	10.16	R	414	169008.12	207635.85	21+43.66	53.80	R
114	169461.78	206822.83	12+14.43	50.68	L	173	166935.14	212117.21	72+58.29	21.30	L	238	167251.93	210125.76	52+25.98	63.39	R	415	169002.10	207657.61	21+65.68	48.80	R
115	169464.81	206823.04	12+13.70	53.64	L	174	166989.66	212417.10	75+63.34	22.85	L	239	167293.45	209967.82	50+63.61	58.48	R	417	167642.83	209227.36	42+59.71	46.25	R
116	169439.26	206827.53	12+25.81	30.70	L	175	166949.43	212824.98	79+71.55	11.41	R	240	167287.15	209986.17	50+82.25	60.34	R	418	167629.46	209257.59	42+91.76	41.06	R
117	169461.84	206832.24	12+23.37	53.63	L	176	166723.34	213396.80	85+85.21	51.85	R	241	167277.97	209982.12	50+80.46	70.21	R	419	167597.95	209241.31	42+94.84	76.38	R
118	169450.28	206869.10	12+62.01	53.92	L	177	166728.99	213739.49	89+15.83	19.37	R	242	167284.32	209963.65	50+61.80	68.35	R	420	167613.10	209211.99	42+63.07	79.53	R
119	169438.25	206865.84	12+62.58	41.47	L	178	167066.80	214453.06	97+03.61	56.77	L	243	167198.74	210546.96	56+48.79	19.31	R	421	167262.23	210083.15	51+82.16	62.89	R
120	169434.44	206878.57	12+75.87	41.75	L	179	167084.95	214444.67	97+03.06	76.77	L	244	167175.58	210540.57	56+48.21	43.33	R	422	167197.95	210100.58	52+13.54	121.64	R
121	169428.74	206876.90	12+76.02	35.81	L	180	167100.31	214477.87	97+39.63	77.77	L	246	167192.82	210441.18	55+46.99	50.13	R	423	167205.22	210068.97	51+81.10	121.64	R
122	169419.79	206905.19	13+05.70	35.96	L	181	167082.15	214486.27	97+40.18	57.78	L	247	167183.42	210436.21	55+44.31	60.43	R	424	167132.37	210385.68	55+06.37	121.67	R
123	169416.27	206904.45	13+06.08	32.38	L	182	167239.10	214826.46	101+14.70	67.77	L	248	167186.52	210414.13	55+21.94	62.47	R	425	167033.61	211375.79	64+90.56	56.62	L
124	169395.47	206974.03	13+78.68	33.90	L	183	167201.24	214827.67	101+00.87	32.51	L	249	167171.74	210646.94	57+52.59	20.58	R	426	167065.91	211374.36	64+79.50	87.02	L
125	169391.59	206987.01	13+92.23	34.19	L	185	169473.13	206393.13	7+92.56	18.97	R	250	167160.89	210686.51	57+93.72	20.88	R	427	167069.11	211447.12	65+51.38	111.09	L
126	169400.70	207002.24	14+03.92	47.53	L	186	169464.74	206460.48	8+60.35	22.26	R	251	167134.89	210679.33	57+93.54	47.86	R	428	167034.60	211448.65	65+62.92	78.21	L
127	169372.64	207050.40	14+58.37	35.57	L	187	169456.62	206460.31	8+60.79	30.38	R	252	167070.99	210979.33	61+00.87	26.04	R	429	166922.87	211394.68	65+40.61	43.92	R
128	169344.75	207143.69	15+55.72	37.62	L	188	169462.92	206392.23	7+92.43	29.21	R	253	167054.35	210974.49	61+01.15	43.36	R	430	166905.90	211441.86	65+88.53	48.19	R
129	169354.10	207146.70	15+55.72	47.45	L	189	169462.89	206392.60	7+92.80	29.21	R	254	167032.56	211089.70	62+17.78	29.81	R	431	166903.86	211395.52	65+46.42	61.97	R
130	169342.80	207194.07	16+03.66	51.31	L	190	169460.52	206418.22	8+18.52	29.65	R	255	166993.55	211198.16	63+32.93	34.65	R	432	166881.79	212237.52	73+67.34	50.60	R
131	169322.11	207213.77	16+28.20	38.18	L	191	169445.88	206417.92	8+19.33	44.28	R	256	166988.65	211199.10	63+35.29	39.04	R	433	166883.99	212269.76	73+99.01	55.12	R
132	169118.28	207677.01	21+27.72	62.71	L	192	169448.28	206391.94	7+93.24	43.83	R	257	166972.59	211126.99	62+71.27	75.90	R	434	166846.90	212277.64	73+99.01	93.04	R
133	169088.76	207665.98	21+31.99	31.48	L	193	169447.64	206560.75	9+63.81	28.93	R	258	166976.38	211125.30	62+68.52	72.80	R	435	166840.25	212246.34	73+67.60	93.06	R
134	169028.66	207774.28	22+55.84	29.87	L	194	169442.18	206560.64	9+64.53	34.35	R	259	166970.93	211116.09	62+61.36	80.75	R	437	167090.62	212980.69	80+90.18	157.97	L
135	168926.29	207924.28	24+34.86	16.68	L	196	169445.65	206538.77	9+41.67	33.93	R	260	166989.77	211109.25	62+49.21	64.81	R	438	167075.07	213088.73	81+87.22	172.31	L
136	169036.74	207970.03	24+13.31	133.96	L	197	169437.14	206528.63	9+32.34	43.64	R	261	166990.51	211118.48	62+57.80	61.35	R	439	166979.54	213080.47	82+07.26	78.93	L
137	168780.23	208067.49	26+37.39	1.70	R	198	169446.19	206471.62	8+72.85	39.93	R	266	166757.75	213986.75	91+55.88	45.88	R						
138	168847.36	208193.24	26+70.51	136.38	L	199	169422.35	206670.75	10+79.91	31.72	R	273	167131.86	214910.18	101+49.32	63.80	R						
139	168620.30	208194.60	28+41.92	5.56	R	203	169372.95	206818.19	12+37.24	35.29	R	274	167122.89	214888.45	101+25.80	636							

COLORADO DEPARTMENT OF TRANSPORTATION



Region 2
905 Erie Ave., P.O. Box 536
Pueblo, CO. 81002
Phone: (719) 546-5487 FAX: (719) 546-5414

Right of Way Plans Unit: Larry R. Lucas

Sheet Revisions

Sheet Revisions

Sheet Revisions

Right of Way Plans

PLAN SHEET

Project Number: STA 012A-034

Project Location: WESTON EAST

Project Location: HIGHWAY 12

Project Code: Last Mod. Date Subset Sheets Sheet No. Total No. of Sheets

12834 01/18/02 5 23

NUMBER	C1	C2	C3
RAD	1940.00	1940.00	1940.00
DELTA	03°46'04"	00°30'26"	00°17'44"
ARC LEN	127.14	17.18	10.01
CH DIR	N 85°50'54" W	N 83°43'02" W	N 75°33'58" W
CH LEN	127.12	17.18	10.01

#	DIRECTION	DISTANCE
L3	S 05°01'40" W	10.01'
L4	S 83°45'15" E	17.18'
L5	S 05°01'40" W	10.02'

#	DIRECTION	DISTANCE
L6	N 11°48'57" E	19.39'
L7	S 73°19'18" E	10.04'
L8	S 11°48'57" W	19.00'
L9	S 73°19'18" E	25.03'
L10	S 17°10'13" W	11.42'
L11	S 72°40'40" E	96.06'
L12	N 08°23'07" E	15.28'
L13	S 73°21'21" E	22.28'
L14	N 04°00'25" E	3.04'

NUMBER	C4
RAD	1940.00
DELTA	02°03'45"
ARC LEN	69.83
CH DIR	N 74°23'13" W
CH LEN	69.83

Northeast 1/4 Section 32

Joe N. Trujillo Jr.
Isabel Louise Trujillo
Bk820-Pg652

Bearing and Distance from
Intersection at Sta. 12+85.12 to
1/4 Cor. Sec. 28 and Sec. 33

Begin R.O.W. STA 012A-034
Sta. 6+50.59
Begin Construction
Sta 6+00

Ronald H. &
Delores G. Feyad
Bk893-Pg638

Richard S. Lopez
and Sylvia A. Lopez
Bk929-Pg818

Michael L. Thompson
Sheila Thompson
Bk862-Pg193

Wayne F. & Mary A. Weaver (1/2)
Bk733-Pg529

(1/10th) Interest Each:
Aron C. Weaver
Jonathan C. Weaver
Samuel B. Weaver
R. Laurie Hancock
Jason M. Weaver
Bk840-Pg345

Clarence Kenneth Beebe
Bk947-Pg979

#	DIRECTION	DISTANCE
L95	S 05°01'40" W	10.24'
L96	N 84°42'28" W	42.75'
L97	S 01°12'00" W	8.13'
L98	S 01°12'00" W	5.46'
L99	N 84°42'28" W	22.63'
L100	S 11°48'57" W	5.23'
L101	N 80°58'37" W	8.91'
L102	S 10°23'03" W	6.25'
L103	N 71°59'02" W	17.08'
L104	N 76°46'37" W	8.11'
L107	S 84°42'28" E	25.72'
L108	S 01°08'41" W	14.64'
L109	N 84°42'28" W	27.08'

#	DIRECTION	DISTANCE
L110	N 05°01'40" E	14.61'
L111	S 84°42'28" E	11.84'
L112	S 80°58'37" E	56.63'
L113	N 22°30'06" W	22.46'
L114	N 80°58'37" W	57.73'
L115	S 73°22'21" E	24.74'
L116	S 02°27'44" E	10.58'
L117	N 73°22'21" W	24.74'
L118	N 02°27'44" W	10.58'
L131	N 03°23'36" W	9.45'

NUMBER	C50	C51
RAD	1880.00	1880.00
DELTA	00°34'22"	00°28'05"
ARC LEN	18.79	15.36
CH DIR	S 89°01'02" E	S 88°29'49" E
CH LEN	18.79	15.36

CENTERLINE
CURVE DATA
Delta = 05° 08' 43"
Degree of Curve (Arc)=01° 42' 36.42"
T = 150.54
R = 3350.40
L = 300.88
Degree of Curve (Chord)=01° 42' 36.65"
Hand of Arc=Right

185	7+92.56	18.97	R
186	8+60.35	22.26	R
187	8+60.79	30.38	R
189	7+92.43	29.21	R
190	8+18.52	29.65	R
191	8+19.33	44.28	R
192	7+92.25	43.81	R
193	9+63.81	28.93	R
194	9+64.53	34.35	R
195	8+71.58	30.56	R
196	9+41.67	33.93	R
197	9+32.34	43.64	R
198	8+72.85	39.93	R
199	10+79.91	31.72	R
200	10+80.17	36.94	R
201	11+46.47	30.98	R
202	12+36.43	29.09	R
203	12+37.24	35.29	R
204	11+43.64	36.87	R
205	11+68.37	36.34	R
206	11+72.04	46.27	R
207	11+47.31	46.79	R
401	6+16.26	21.33	R
402	6+35.15	20.51	R
403	6+39.01	78.34	R
404	6+18.90	79.62	R
405	6+20.73	118.67	R
406	6+92.85	115.97	R
407	6+85.71	22.98	R
408	9+44.02	63.15	R
409	9+66.70	50.46	R
410	9+91.75	35.53	R

CENTERLINE
CURVE DATA
Delta = 13° 32' 12"
Degree of Curve (Arc)=05° 13' 50.09"
T = 130.00
R = 1095.40
L = 258.80
Degree of Curve (Chord)=05° 13' 56.63"
Hand of Arc=Right

NUMBER	C26	C27	C28	C29	C30
RAD	1880.00	1880.00	1880.00	1880.00	1880.00
DELTA	04°19'25"	02°04'07"	03°06'02"	03°26'25"	01°58'26"
ARC LEN	141.87	67.87	101.73	112.88	64.77
CH DIR	S 86°06'03" E	S 82°54'17" E	S 80°19'13" E	S 77°03'00" E	S 74°20'34" E
CH LEN	141.84	67.87	101.72	112.86	64.77

0 25 50 75
1" = 50'



Region 2
905 Erie Ave., P.O. Box 536
Pueblo, CO. 81002
Phone: (719) 546-5487 FAX: (719) 546-5414

Right of Way Plans Unit: Larry R. Lucas

Sheet Revisions

Sheet Revisions

Sheet Revisions

Right of Way Plans

PLAN SHEET

Project Number: STA 012A-034

Project Location: WESTON EAST

Project Location: HIGHWAY 12

Project Code:	Last Mod. Date	Subset Sheets	Sheet No.	Total No. of Sheets
12834	01/18/02		6	23

#	DIRECTION	DISTANCE
L11	S 72°40'40" E	96.06'
L12	N 08°23'07" E	15.28'
L13	S 73°21'21" E	22.28'
L14	S 03°58'03" W	20.73'
L15	N 11°46'45" E	23.06'
L16	S 72°34'42" E	38.63'
L17	S 15°11'25" W	12.46'
L18	S 73°21'21" E	13.29'
L19	S 16°21'29" W	5.94'
L20	S 72°27'18" E	29.68'
L21	S 11°48'57" W	3.60'
L22	S 70°32'17" E	73.01'
L23	N 73°21'21" W	72.62'
L24	N 73°21'21" W	80.28'

Northwest 1/4 Section 33

Sam D. Gettings
Bk801-Pg559

#	DIRECTION	DISTANCE
L200	N 59°04'46" E	17.74'
L201	S 59°46'06" E	55.74'
L202	N 73°21'21" W	66.16'

#	DIRECTION	DISTANCE
L26	N 17°50'48" E	9.83'
L27	S 76°34'59" E	48.70'
L28	S 43°35'09" E	28.57'
L133	N 73°21'21" W	12.51'


NUMBER	C5
RAD	1156.00
DELTA	03°01'52"
ARC LEN	61.15
CH DIR	N 71°50'25" W
CH LEN	61.15

Floyd J. Brown &
Sadie M. Brown
Bk948-Pg746

10

Bearing and Distance from
Intersection at Sta. 12+85.12 to
1/4 Cor. Sec. 28 and Sec. 33

NUMBER	C4
RAD	1940.00
DELTA	02°03'45"
ARC LEN	69.83
CH DIR	N 74°23'13" W
CH LEN	69.83

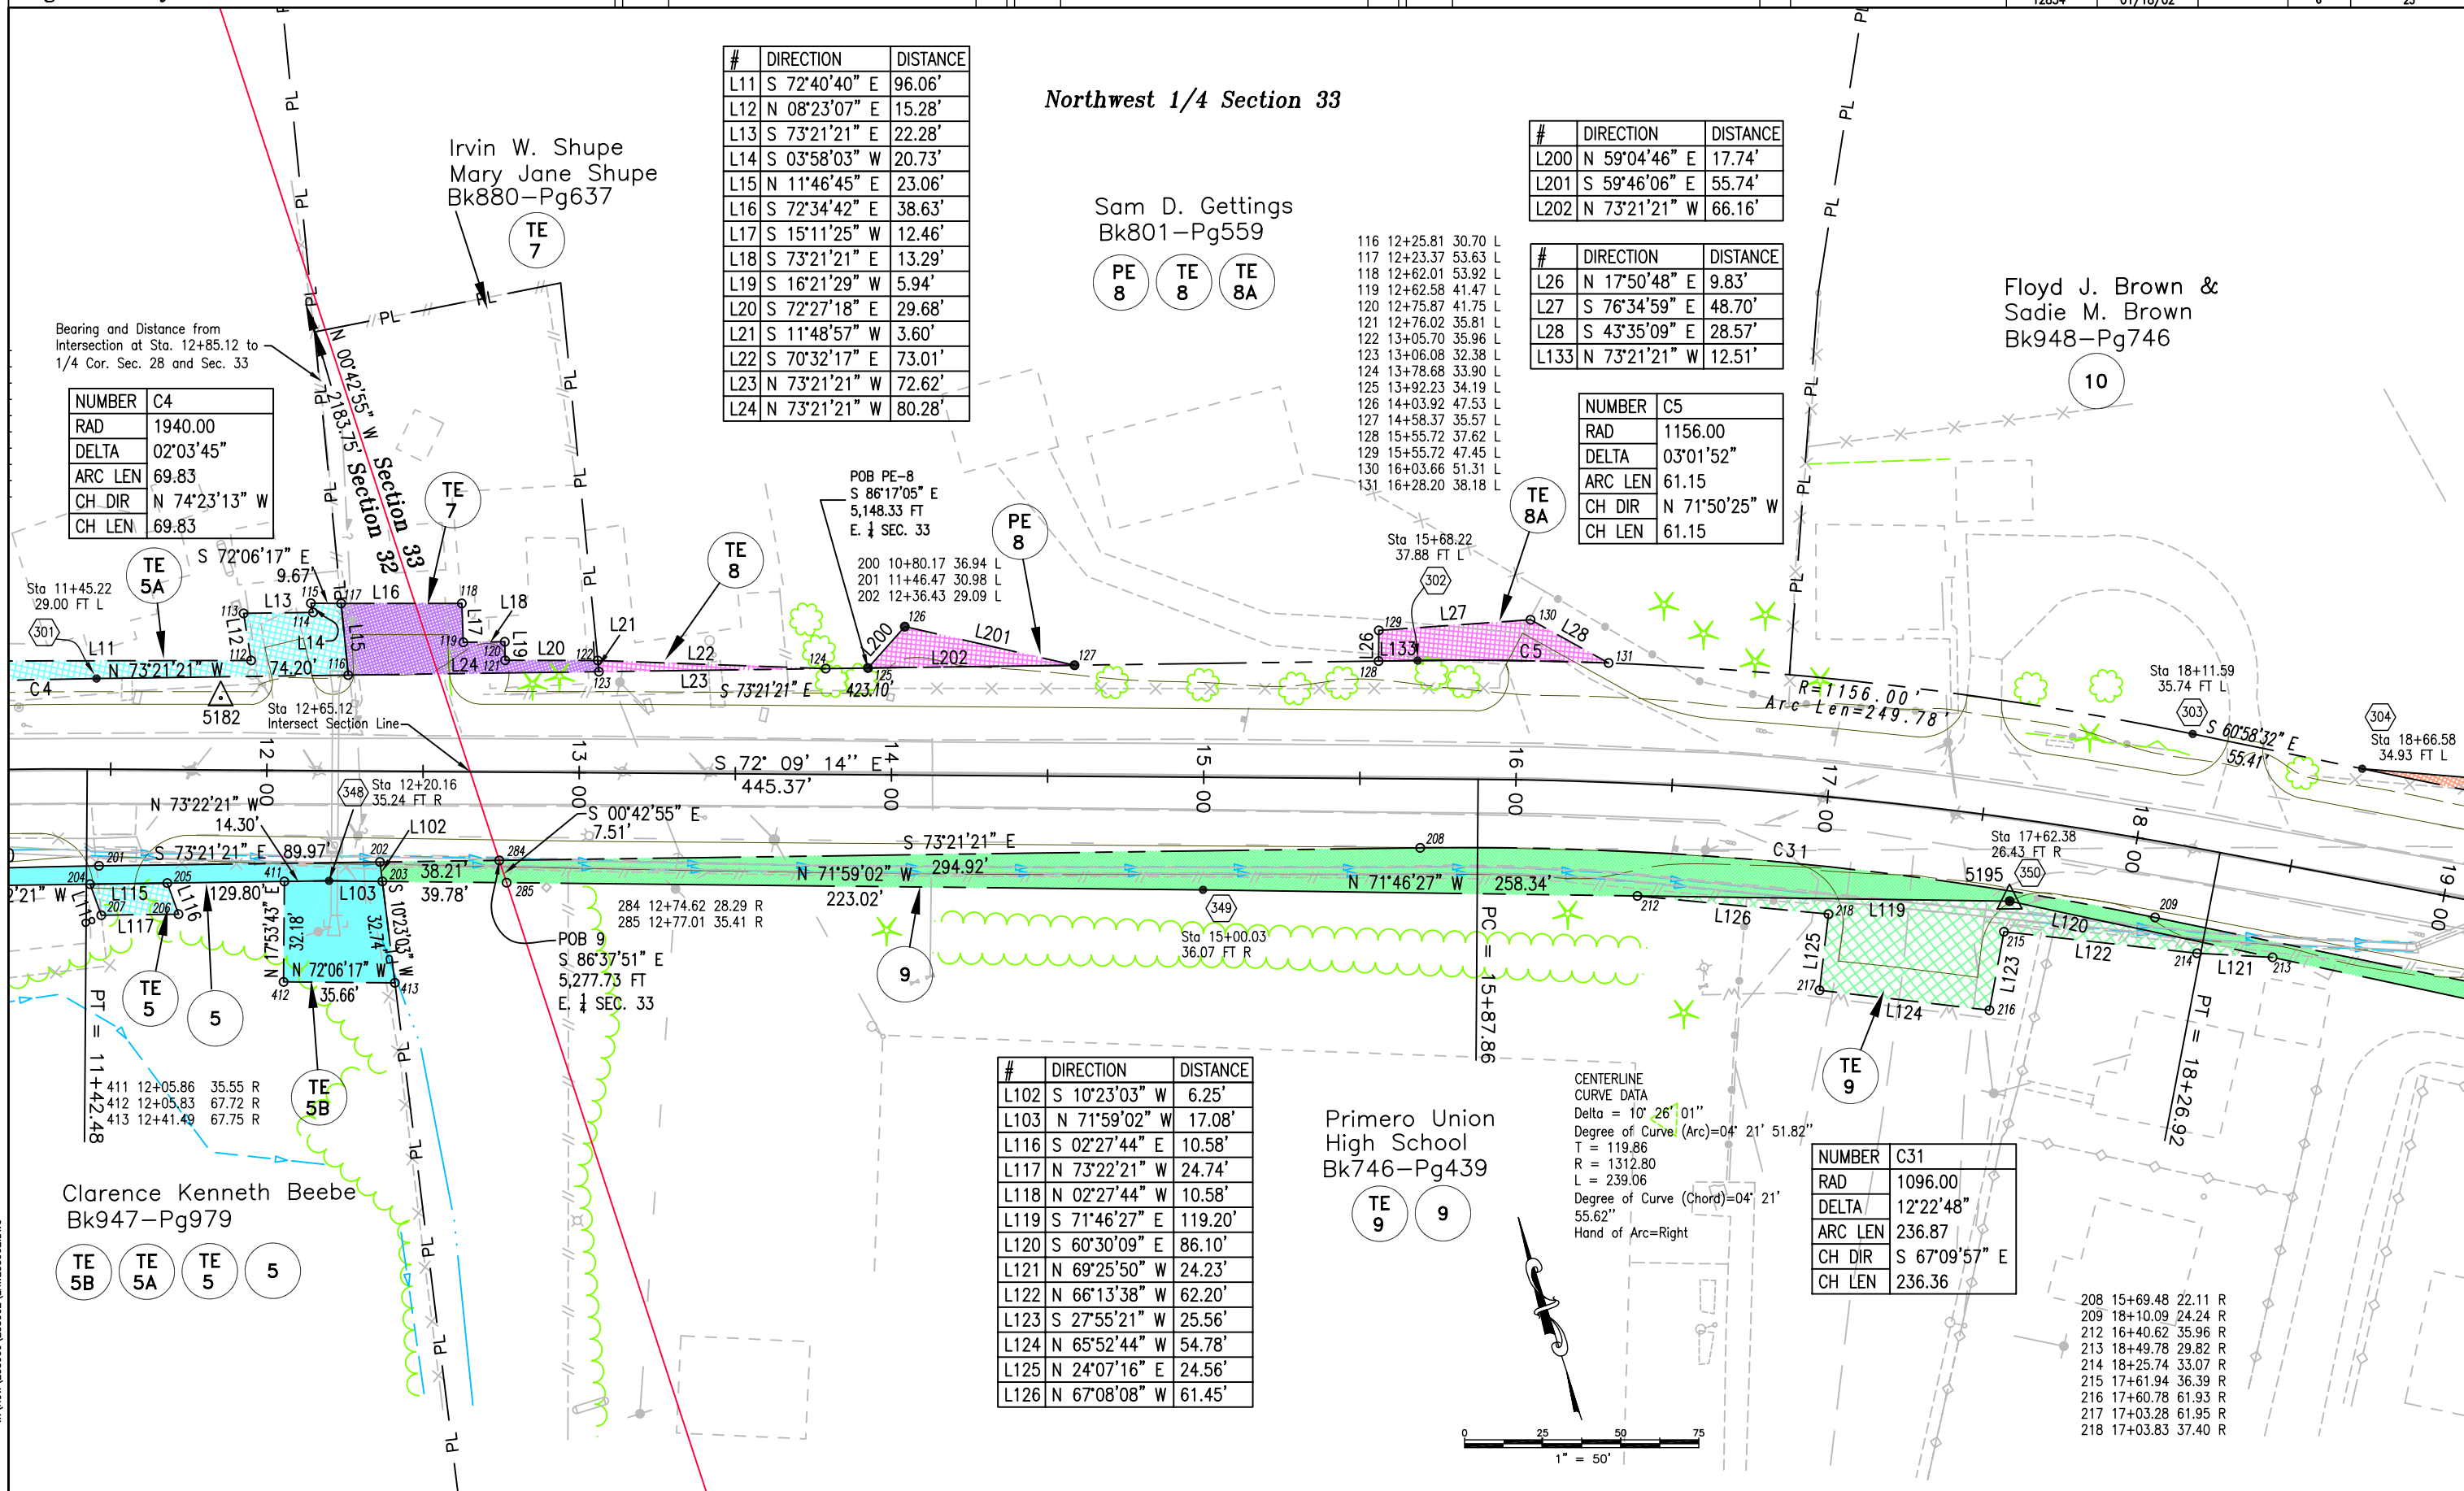

#	DIRECTION	DISTANCE
L102	S 10°23'03" W	6.25'
L103	N 71°59'02" W	17.08'
L116	S 02°27'44" E	10.58'
L117	N 73°22'21" W	24.74'
L118	N 02°27'44" W	10.58'
L119	S 71°46'27" E	119.20'
L120	S 60°30'09" E	86.10'
L121	N 69°25'50" W	24.23'
L122	N 66°13'38" W	62.20'
L123	S 27°55'21" W	25.56'
L124	N 65°52'44" W	54.78'
L125	N 24°07'16" E	24.56'
L126	N 67°08'08" W	61.45'

 
Primero Union
High School
Bk746-Pg439

TE 9 9

CENTERLINE
CURVE DATA
Delta = 10° 26' 01"
Degree of Curve (Arc)=04° 21' 51.82"
T = 119.86
R = 1312.80
L = 239.06
Degree of Curve (Chord)=04° 21'
55.62"
Hand of Arc=Right

NUMBER	C31
RAD	1096.00
DELTA	12°22'48"
ARC LEN	236.87
CH DIR	S 67°09'57" E
CH LEN	236.36

208 15+69.48 22.11 R
209 18+10.09 24.24 R
212 16+40.62 35.96 R
213 18+49.78 29.82 R
214 18+25.74 33.07 R
215 17+61.94 36.39 R
216 17+60.78 61.93 R
217 17+03.28 61.95 R
218 17+03.83 37.40 R





Region 2
905 Erie Ave., P.O. Box 536
Pueblo, CO. 81002
Phone: (719) 546-5487 FAX: (719) 546-5414

Right of Way Plans Unit: Larry R. Lucas

Sheet Revisions

Sheet Revisions

Sheet Revisions

Right of Way Plans

PLAN SHEET

Project Number: STA 012A-034

Project Location: WESTON EAST

Project Location: HIGHWAY 12

Project Code:	Last Mod. Date	Subset Sheets	Sheet No.	Total No. of Sheets
12834	01/18/02		7	23


NUMBER	RAD	DELTA	ARC LEN	CH DIR	CH LEN
C6	985.00	10°34'41"	181.85	N 55°41'11" W	181.60
C10	985.00	11°55'13"	204.93	S 44°26'14" E	204.55

Sam D. Gettings
Bk801-Pg559

Northwest 1/4 Section 33

Madeline Marquez (Life Estate)
Rosalie C. Miller
Margaret E. Bradeen
Joseph T. Marquez
Bk877-Pg975

Floyd J. Brown &
Sadie M. Brown
Bk948-Pg746

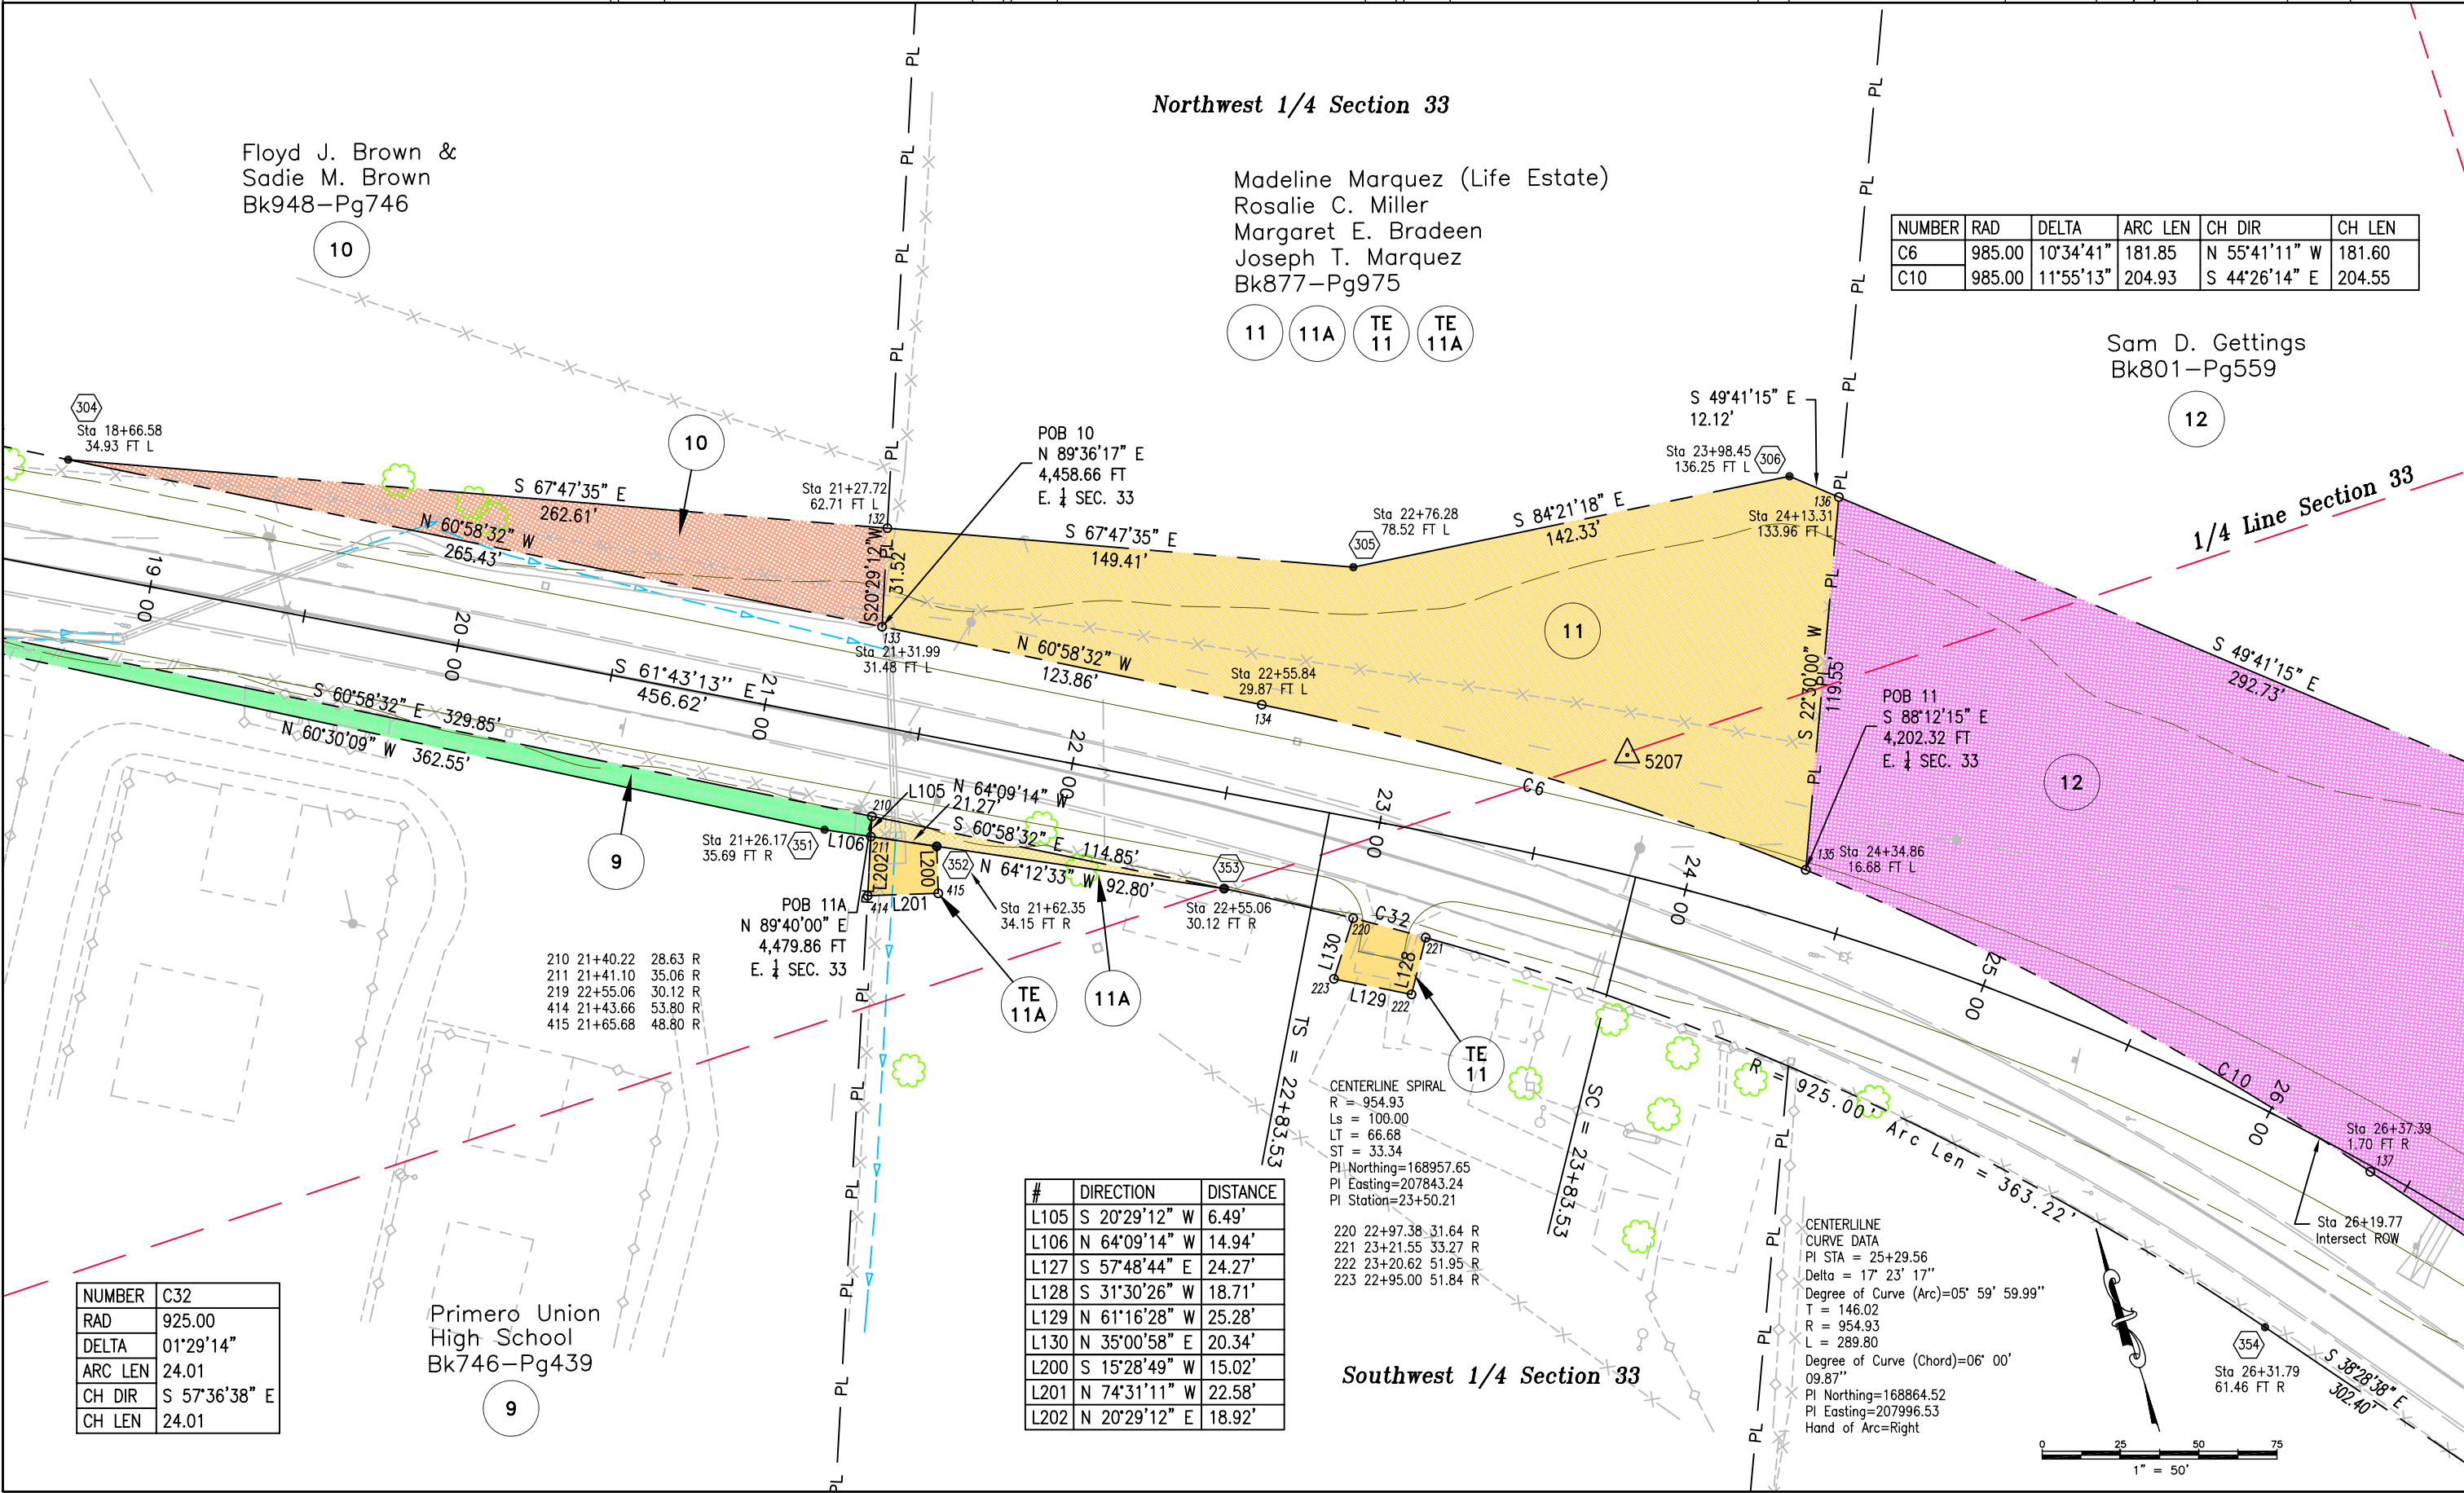



#	DIRECTION	DISTANCE
L105	S 20°29'12" W	6.49'
L106	N 64°09'14" W	14.94'
L127	S 57°48'44" E	24.27'
L128	S 31°30'26" W	18.71'
L129	N 61°16'28" W	25.28'
L130	N 35°00'58" E	20.34'
L200	S 15°28'49" W	15.02'
L201	N 74°31'11" W	22.58'
L202	N 20°29'12" E	18.92'

CENTERLINE SPIRAL
R = 954.93
Ls = 100.00
LT = 66.68
ST = 33.34
PI Northing=168957.65
PI Easting=207843.24
PI Station=23+50.21

220 22+97.38 31.64 R
221 23+21.55 33.27 R
222 23+20.62 51.95 R
223 22+95.00 51.84 R

  CENTERLINE CURVE DATA
PI STA = 25+29.56
Delta = 17° 23' 17"
Degree of Curve (Arc)=05° 59' 59.99"
T = 146.02
R = 954.93
L = 289.80
Degree of Curve (Chord)=06° 00' 09.87"
PI Northing=168864.52
PI Easting=207996.53
Hand of Arc=Right






Right of Way Plans Unit: Larry R. Lucas

[illegible][illegible][illegible]

Right of Way Plans				
PLAN SHEET				
Project Number: STA 012A-034				
Project Location: WESTON EAST				
Project Location: HIGHWAY 12				
Project Code:	Last Mod. Date	Subset Sheets	Sheet No.	Total No. of Sheets
12834	01/18/02		8	23

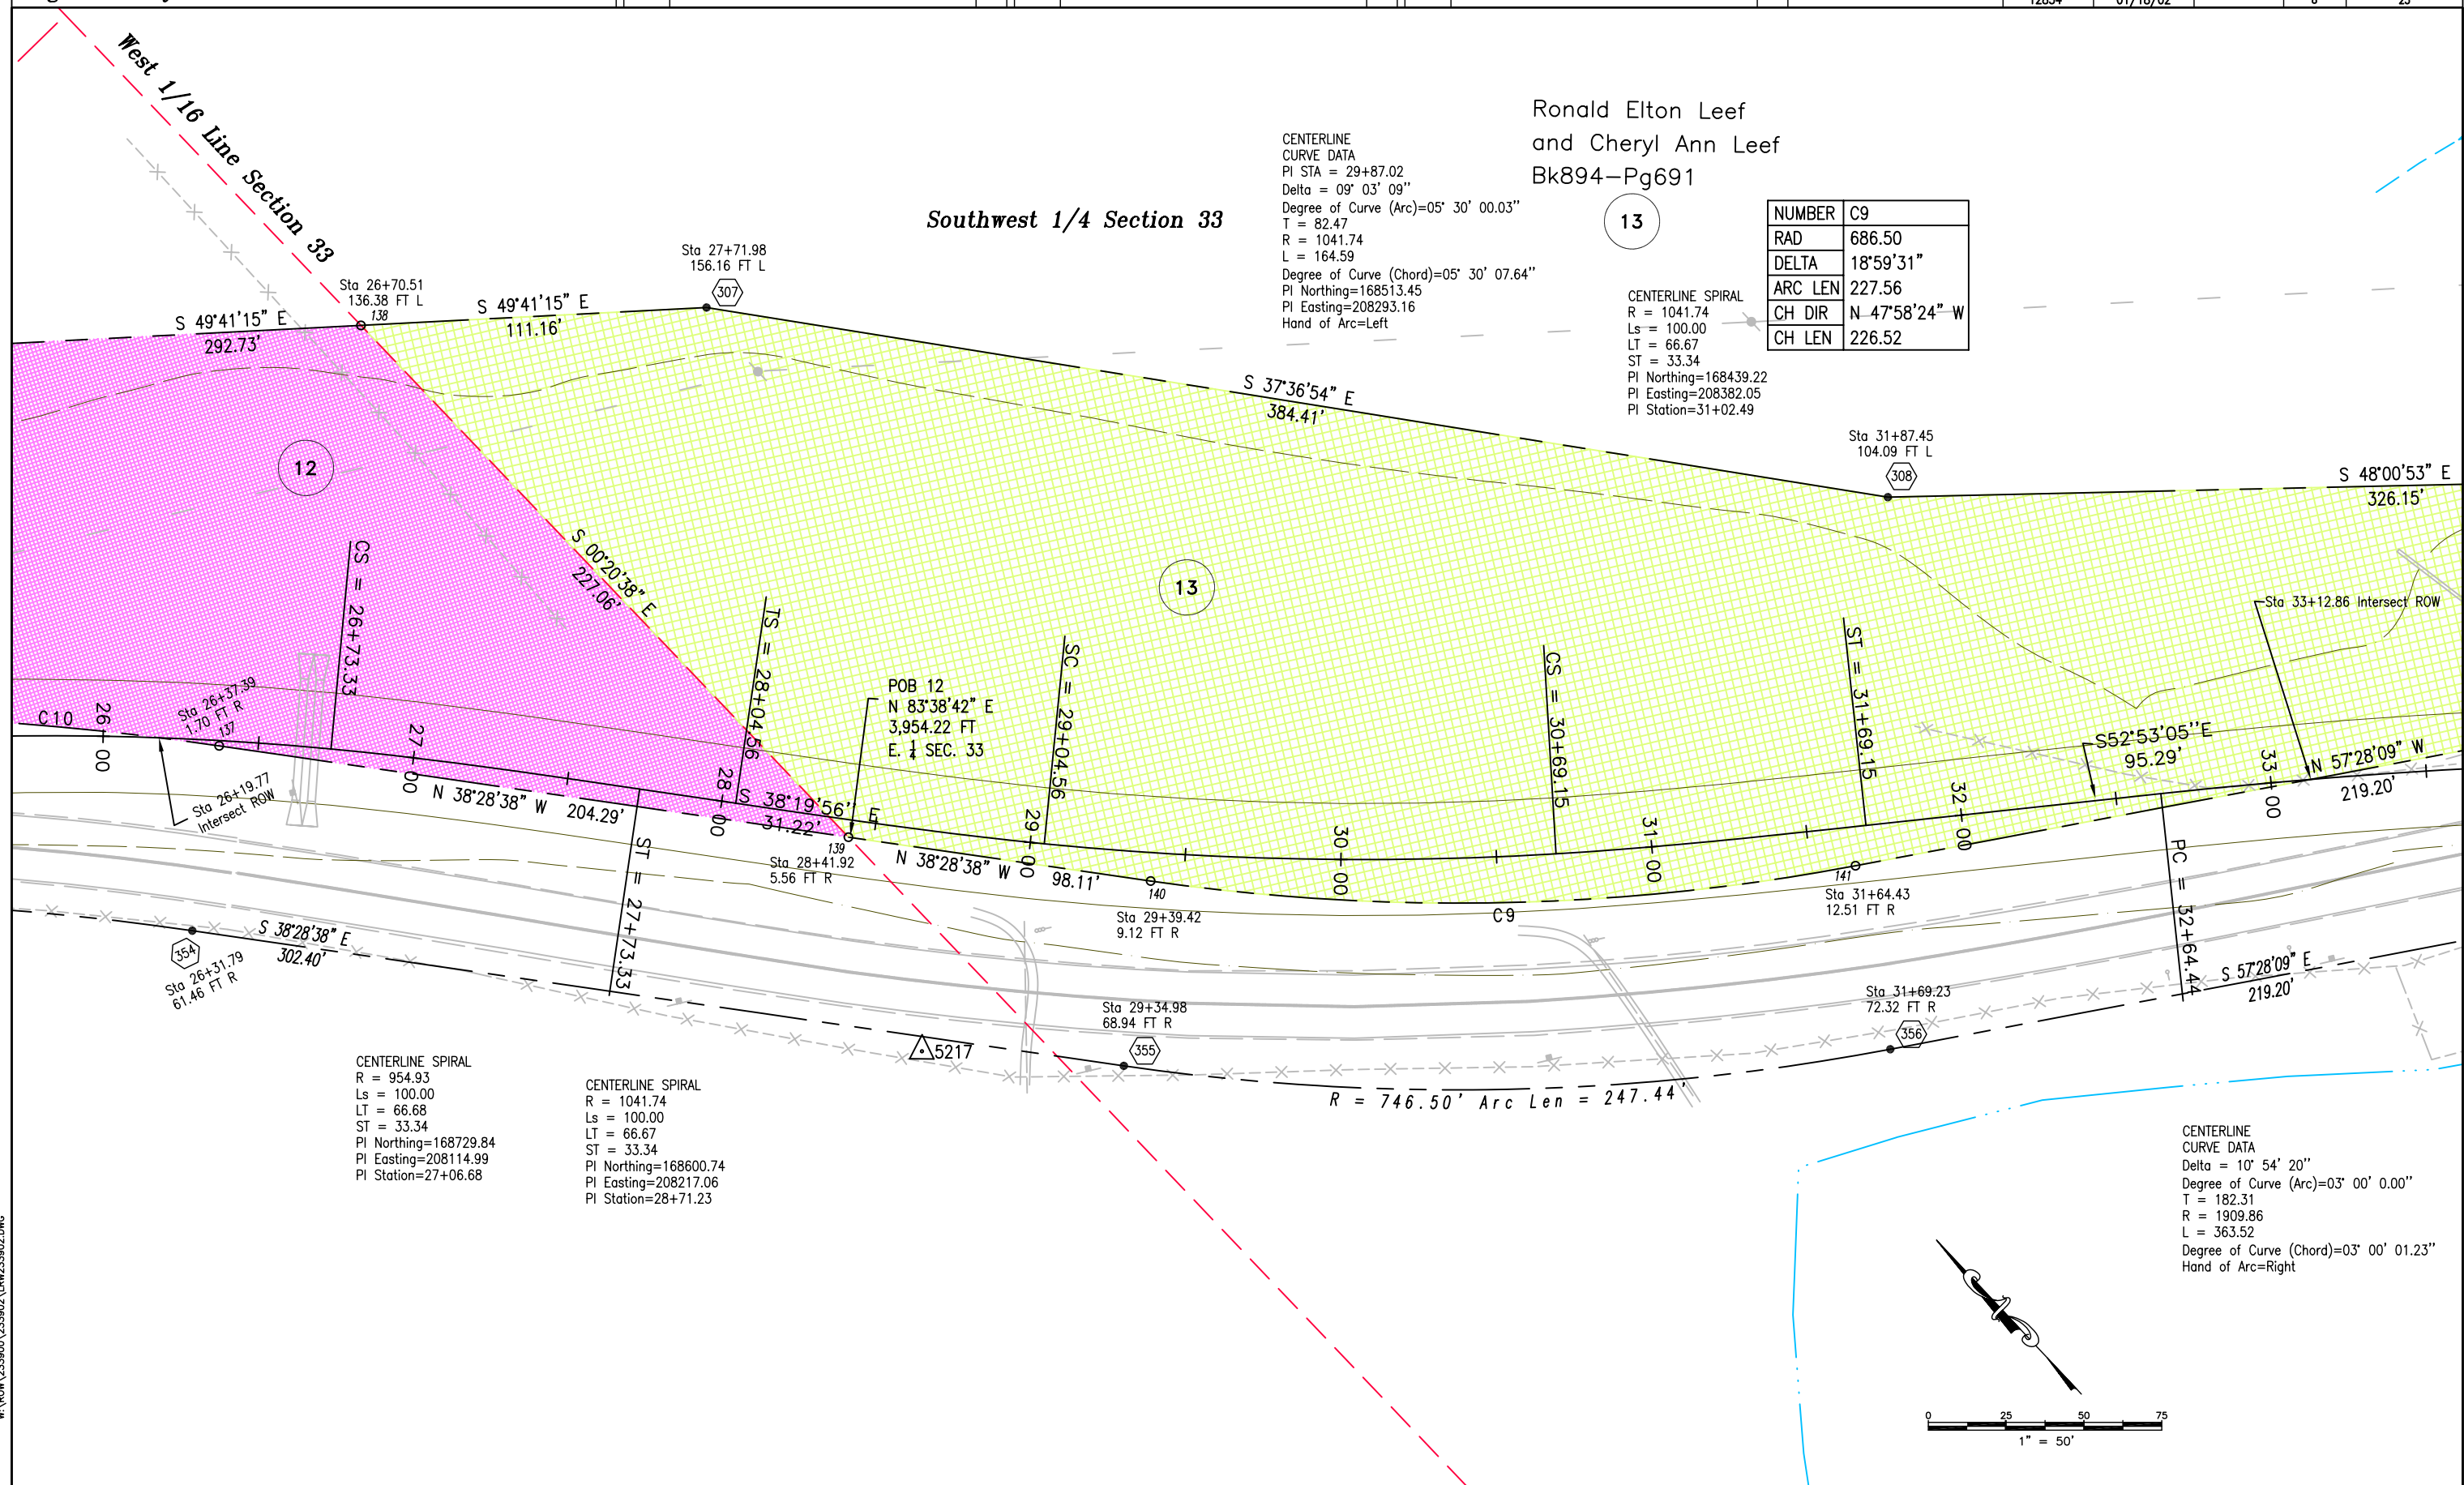

COLORADO DEPARTMENT OF TRANSPORTATION



Region 2
905 Erie Ave., P.O. Box 536
Pueblo, CO. 81002
Phone: (719) 546-5487 FAX: (719) 546-5414

Right of Way Plans Unit: Larry R. Lucas

Sheet Revisions

Sheet Revisions

Sheet Revisions

Right of Way Plans

PLAN SHEET

Project Number: STA 012A-034

Project Location: WESTON EAST

Project Location: HIGHWAY 12

Project Code:	Last Mod. Date	Subset Sheets	Sheet No.	Total No. of Sheets
12834	01/18/02		9	23

Southwest 1/4 Section 33

Ronald Elton Leef
and Cheryl Ann Leef
Bk894-Pg691

13

NUMBER	C8
RAD	985.00
DELTA	19°29'54"
ARC LEN	335.21
CH DIR	N 47°43'12" W
CH LEN	333.59

Sta 35+01.66
91.83 FT L

CENTERLINE
CURVE DATA
Delta = 23° 13' 01"
Degree of Curve (Arc)=02° 30' 00.00"
T = 470.80
R = 2291.83
L = 928.67
Degree of Curve (Chord)=02° 30' 00.72"
Hand of Arc=Left

Sta 39+99.87
51.72 FT L

CENTERLINE
CURVE DATA
Delta = 10° 54' 20"
Degree of Curve (Arc)=03° 00' 0.00"
T = 182.31
R = 1909.86
L = 363.52
Degree of Curve (Chord)=03° 00' 01.23"
Hand of Arc=Right


NUMBER	C25
RAD	925.00
DELTA	05°19'17"
ARC LEN	85.91
CH DIR	S 54°48'31" E
CH LEN	85.88

#	DIRECTION	DISTANCE
L94	N 25°46'51" W	29.79'

Marcus Gonzales and
Geraldine Gonzales
Bk745-Pg193

TE
14

 NUMBER	C7
RAD	352.00
DELTA	28°10'05"
ARC LEN	173.05
CH DIR	N 52°03'17" W
CH LEN	171.31



COLORADO DEPARTMENT OF TRANSPORTATION



Region 2
905 Erie Ave., P.O. Box 536
Pueblo, CO. 81002
Phone: (719) 546-5487 FAX: (719) 546-5414

Right of Way Plans Unit: Larry R. Lucas

Sheet Revisions

Sheet Revisions

Sheet Revisions

Right of Way Plans


PLAN SHEET

Project Number: STA 012A-034

Project Location: WESTON EAST

Project Location: HIGHWAY 12

Project Code:	Last Mod. Date	Subset Sheets	Sheet No.	Total No. of Sheets
12834	01/18/02		10	23

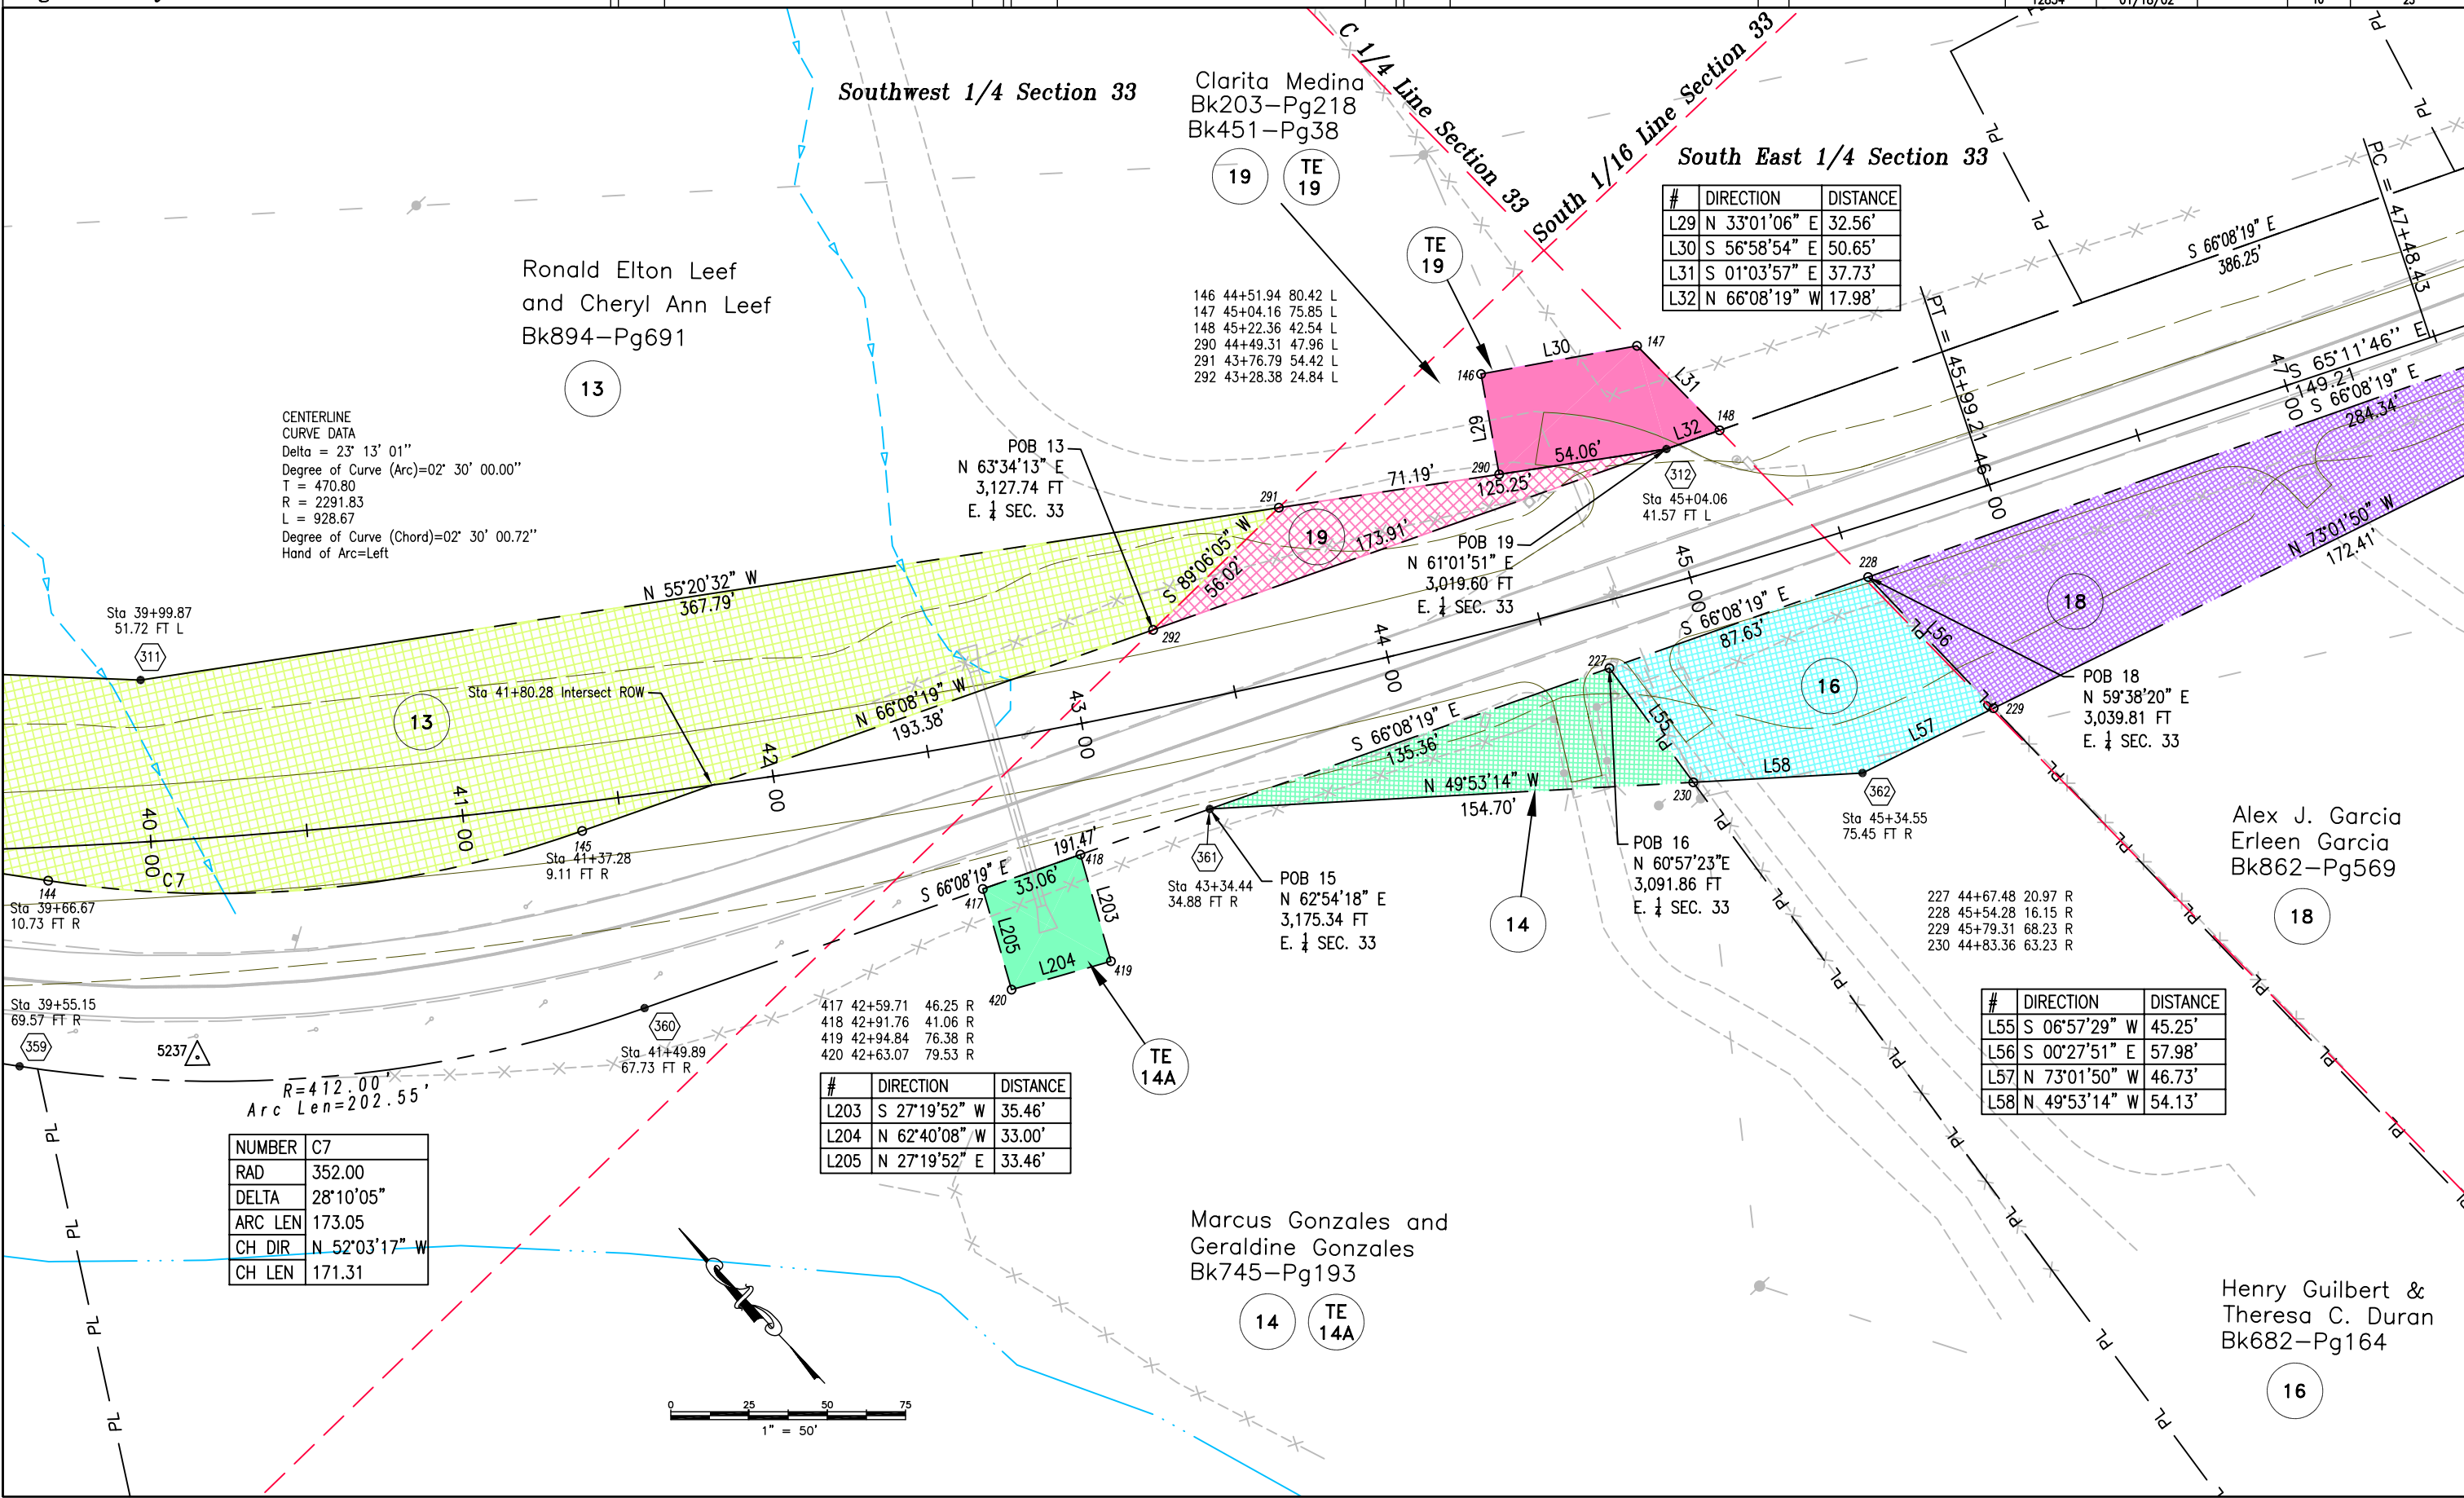

COLORADO DEPARTMENT OF TRANSPORTATION



Region 2
905 Erie Ave., P.O. Box 536
Pueblo, CO. 81002
Phone: (719) 546-5487 FAX: (719) 546-5414

Right of Way Plans Unit: Larry R. Lucas

Sheet Revisions

Sheet Revisions

Sheet Revisions

Right of Way Plans

PLAN SHEET

Project Number: STA 012A-034

Project Location: WESTON EAST

Project Location: HIGHWAY 12

Project Code:	Last Mod. Date	Subset Sheets	Sheet No.	Total No. of Sheets
12834	01/18/02		11	23

South 1/16 Line Section 33

#	DIRECTION	DISTANCE
L33	N 31°46'28" E	10.60'
L34	S 77°38'02" E	18.60'
L35	S 15°30'49" W	10.02'
L36	N 02°02'32" W	10.32'
L37	S 77°38'02" E	20.80'
L38	S 15°41'37" W	10.02'
L39	N 77°38'02" W	17.65'
L40	N 14°10'12" E	10.01'
L41	S 77°17'42" E	20.00'
L42	S 28°16'30" W	10.39'
L43	N 09°36'15" E	10.05'
L44	S 75°54'36" E	21.06'
L45	S 15°41'37" W	10.00'
L54	N 77°38'02" W	21.58'

149	50+41.52	47.39	L
150	50+44.77	57.52	L
151	50+64.05	58.08	L
152	50+63.73	48.07	L
153	51+62.02	49.22	L
154	51+59.35	59.19	L
155	51+80.15	59.40	L
156	51+79.67	49.39	L
157	52+25.28	49.79	L
158	52+25.50	59.80	L
159	52+45.50	59.88	L
160	52+42.75	49.86	L
161	53+56.42	49.02	L
162	53+55.83	59.05	L
163	53+76.89	58.63	L
164	53+76.41	48.63	L

Southeast 1/4 Section 33

NUMBER	C11	C12
RAD	5760.00	5760.00
DELTA	00°10'26"	00°11'56"
ARC LEN	17.47	19.99
CH DIR	N 77°16'56" W	N 75°57'54" W
CH LEN	17.47	19.99

Michael Lee Duran
Geniveva Duran
Bk796-Pg99

Larry & Cathi
Guara
Bk850-Pg144

Mathew M. &
Theresa J. Trujillo
Bk950-Pg845
Exhibit A

Juanita(Jenny) C. Lamorie
Bk985-Pg888

CENTERLINE
CURVE DATA
Delta = 11° 51' 36"
Degree of Curve (Arc)=03° 30' 00.02"
T = 170.04
R = 1637.02
L = 338.86
Degree of Curve (Chord)=03° 30'
01.98"
Hand of Arc=Left

R=925.00'
Arc Len=185.58'

R=5760.00'
Arc Len=276.44'

#	DIRECTION	DISTANCE
L59	S 77°38'02" E	38.39'
L62	N 71°01'36" W	35.82'
L78	S 71°01'36" E	19.40'
L79	S 23°50'52" W	10.04'
L80	N 71°01'36" W	19.53'
L81	N 24°33'32" E	10.05'

232	50+33.40	12.98	R
233	50+71.48	11.78	R
234	50+62.34	58.36	R
236	51+99.28	10.41	R
237	52+37.36	10.16	R
238	52+25.98	63.39	R
239	50+63.61	58.48	R
240	50+82.25	60.34	R
241	50+80.46	70.21	R

 
NUMBER	C18	C19	C20
RAD	985.00	5700.00	5700.00
DELTA	11°29'43"	00°22'58"	02°22'01"
ARC LEN	197.62	38.08	235.48
CH DIR	S 71°53'10" E	S 77°26'33" E	S 76°04'03" E
CH LEN	197.29	38.08	235.47

Alex J. Garcia
Erleen Garcia
Bk862-Pg569

Danny Gallegos
Joseph Edward Gallegos
Martha Martinez
Bk910-Pg445

Michael Lee Duran
Shirley A. Duran
Bk925-Pg255

246	55+46.99	50.13	R
247	55+44.31	60.43	R
248	55+21.94	62.47	R
283	54+72.79	14.22	R
421	51+82.16	62.89	R
422	52+13.54	121.64	R
423	51+81.10	121.64	R
424	55+06.37	121.67	R



COLORADO DEPARTMENT OF TRANSPORTATION



Region 2
905 Erie Ave., P.O. Box 536
Pueblo, CO. 81002
Phone: (719) 546-5487 FAX: (719) 546-5414

Right of Way Plans Unit: Larry R. Lucas

Sheet Revisions

Sheet Revisions

Sheet Revisions

Right of Way Plans


PLAN SHEET

Project Number: STA 012A-034

Project Location: WESTON EAST

Project Location: HIGHWAY 12

Project Code:	Last Mod. Date	Subset Sheets	Sheet No.	Total No. of Sheets
12834	01/18/02		12	23

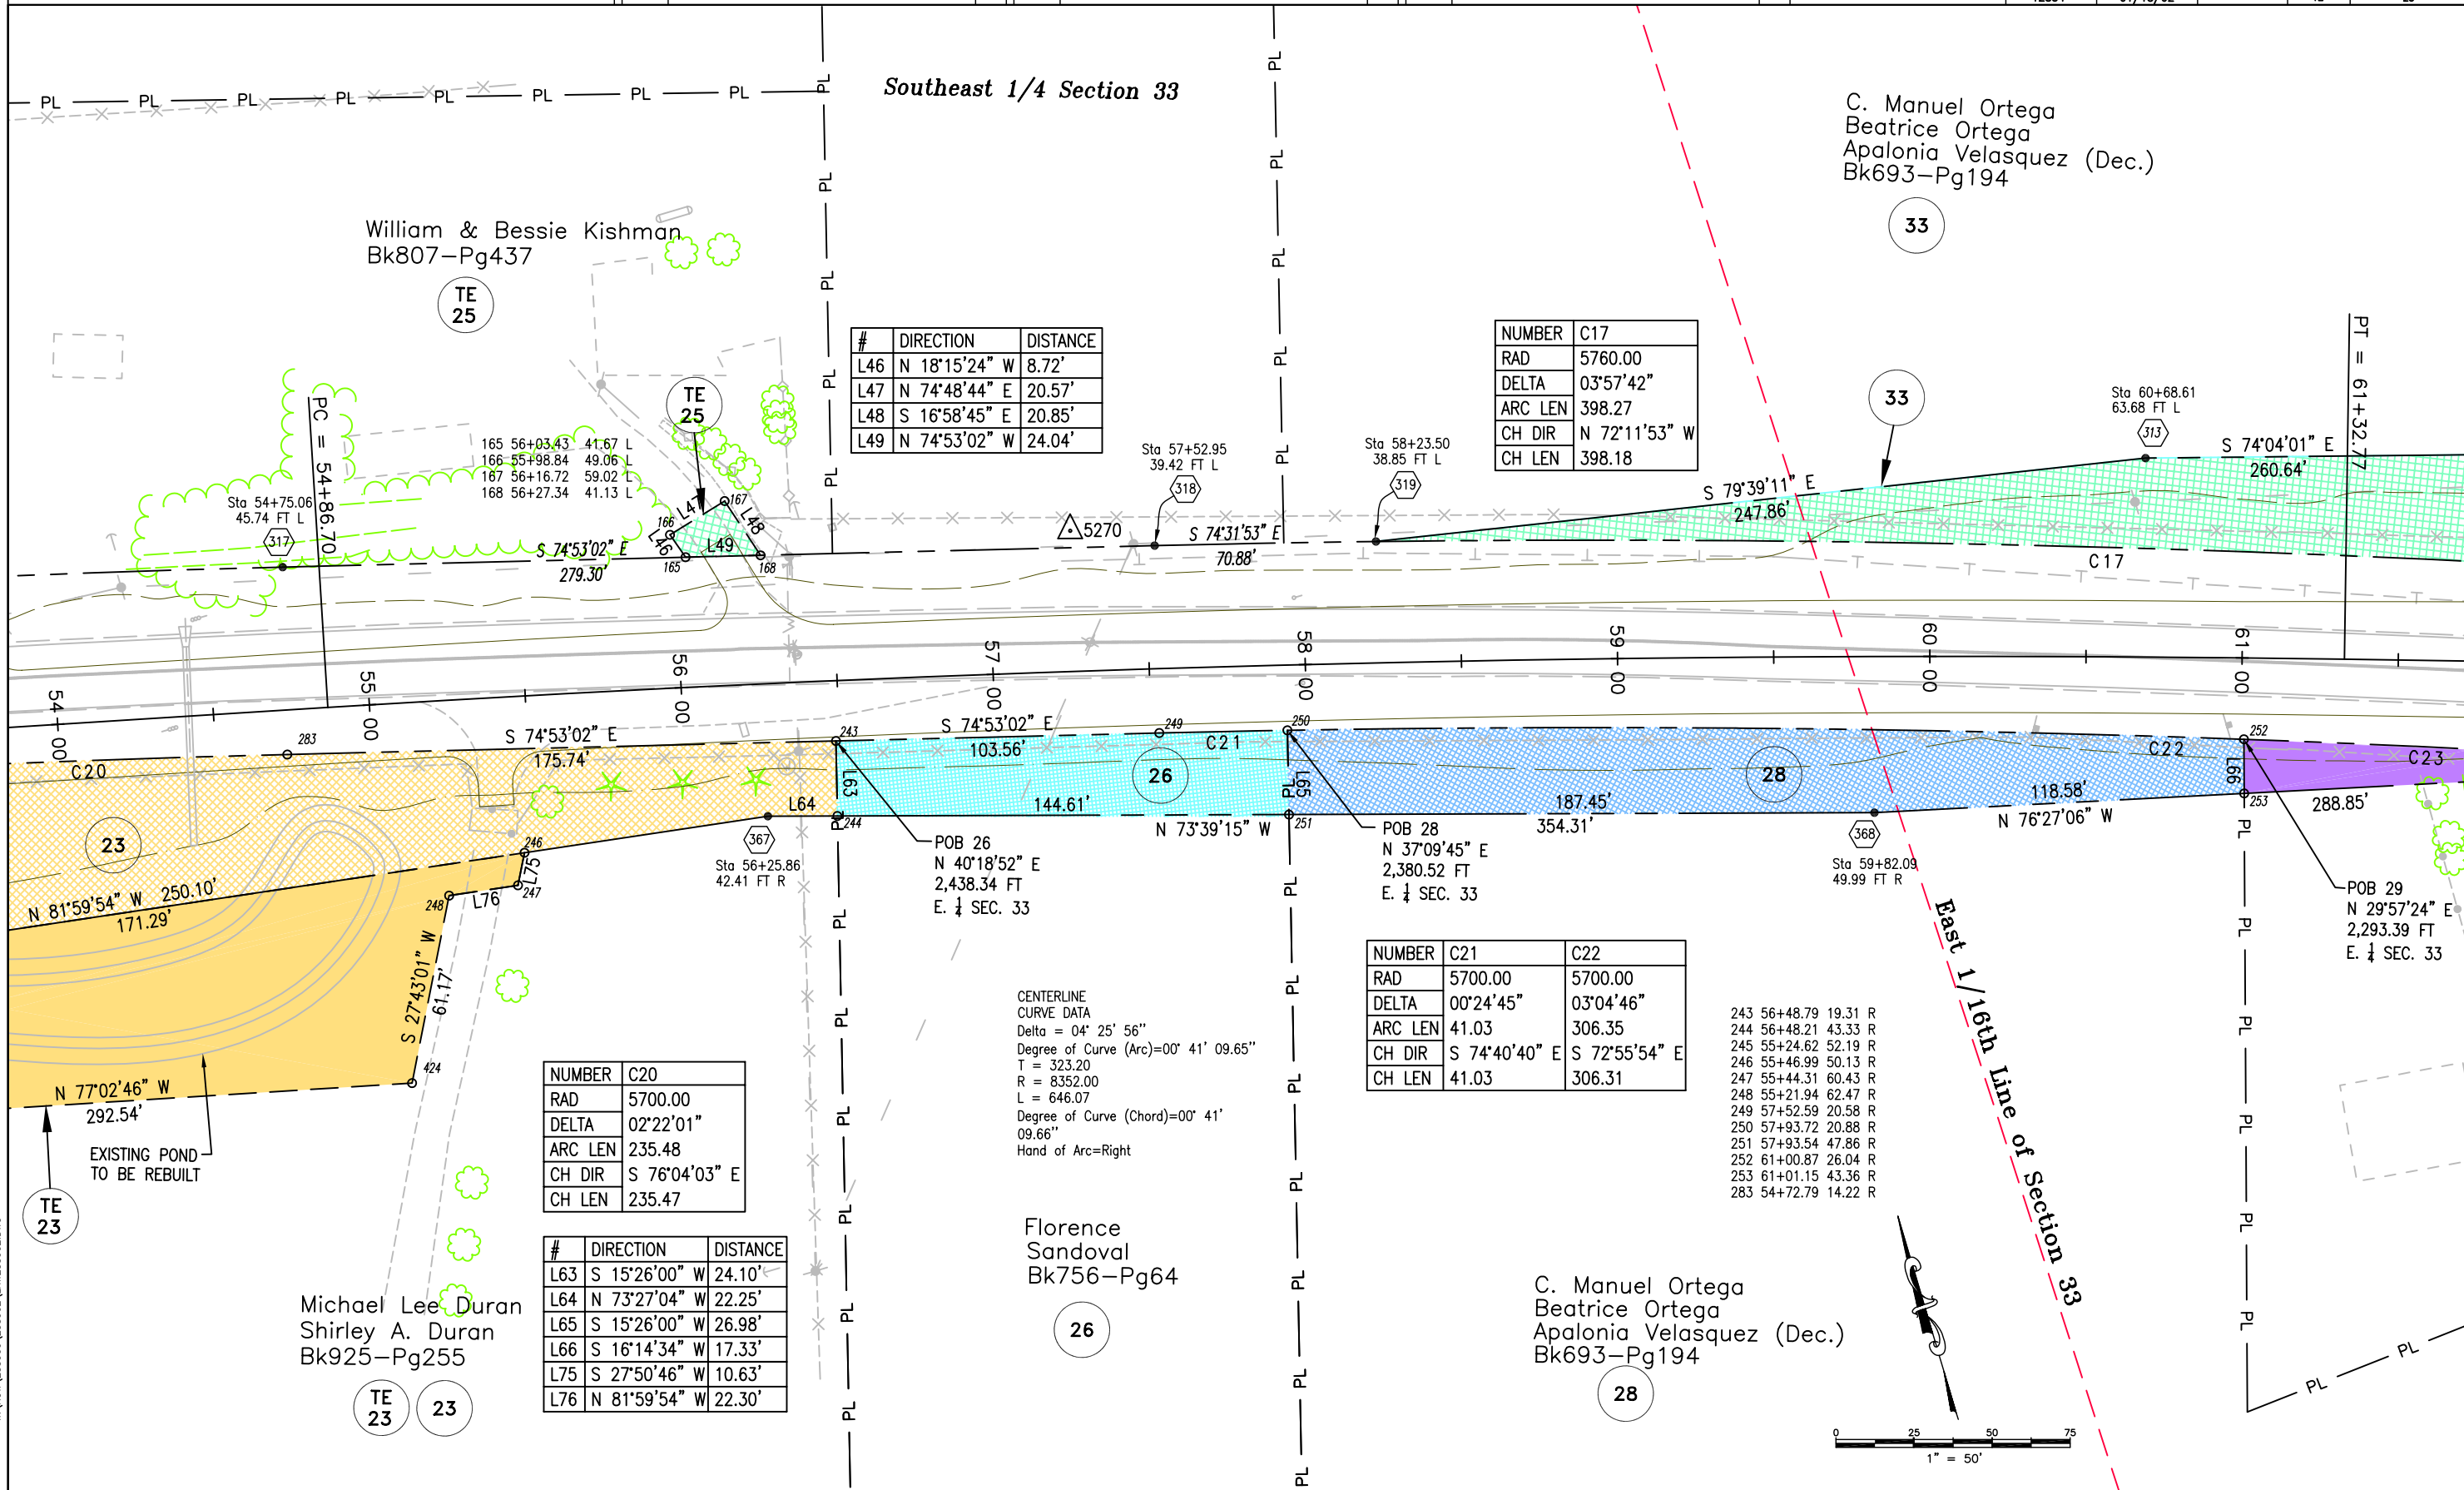



Region 2
905 Erie Ave., P.O. Box 536
Pueblo, CO. 81002
Phone: (719) 546-5487 FAX: (719) 546-5414

Right of Way Plans Unit: Larry R. Lucas

Sheet Revisions

Sheet Revisions

Sheet Revisions

Right of Way Plans

PLAN SHEET

Project Number: STA 012A-034

Project Location: WESTON EAST

Project Location: HIGHWAY 12

Project Code:	Last Mod. Date	Subset Sheets	Sheet No.	Total No. of Sheets
12834	01/18/02		13	23

Southeast 1/4 Section 33

NUMBER	C17	C16	C23
RAD	5760.00	352.00	5700.00
DELTA	03°57'42"	16°45'14"	01°10'29"
ARC LEN	398.27	102.93	116.87
CH DIR	N 72°11'53" W	N 78°35'39" W	S 70°48'17" E
CH LEN	398.18	102.56	116.87

C. Manuel Ortega
Beatrice Ortega
Apalonia Velasquez (Dec.)
Bk693-Pg194

CENTERLINE SPIRAL
R = 954.93
Ls = 100.00
LT = 66.68
ST = 33.34
PI Northing=166964.32
PI Easting=211407.62
PI Station=65+41.57

CENTERLINE
CURVE DATA
PI STA = 66+35.26
Delta = 07° 14' 06"
Degree of Curve (Arc)=05° 59' 59.99"
T = 60.37
R = 954.93
L = 120.58
Degree of Curve (Chord)=06° 00'
09.87"
PI Northing=166941.06
PI Easting=211498.40
Hand of Arc=Left

CENTERLINE SPIRAL
R = 954.93
Ls = 100.00
LT = 66.68
ST = 33.34
PI Northing=166929.41
PI Easting=211591.39
PI Station=67+28.81

425 64+90.56 56.62 L
426 64+79.50 87.02 L
427 65+51.38 111.09 L
428 65+62.92 78.21 L


429 65+40.61 43.92 R
430 65+88.53 48.19 R
431 65+46.42 61.97 R

#	DIRECTION	DISTANCE
L66	N 16°14'34" E	17.33'
L67	S 70°13'02" E	53.48'
L68	S 10°51'38" E	4.99'
L69	N 24°09'30" W	4.15'
L70	S 59°23'36" W	10.70'
L71	N 19°56'43" W	20.04'
L72	N 85°23'09" E	9.26'
L73	N 41°58'04" E	32.21'

252 61+00.87 26.04 R
253 61+01.15 43.36 R
254 62+17.78 29.81 R
255 63+32.93 34.65 R
256 63+35.29 39.04 R
257 62+71.27 75.90 R
258 62+68.52 72.80 R
259 62+61.36 80.75 R
260 62+49.21 64.81 R
261 62+57.80 61.35 R

NUMBER	C22
RAD	5700.00
DELTA	03°04'46"
ARC LEN	306.35
CH DIR	S 72°55'54" E
CH LEN	306.31

C. Manuel Ortega
Beatrice Ortega
Apalonia Velasquez (Dec.)
Bk693-Pg194

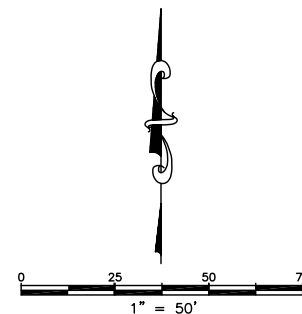



Region 2
905 Erie Ave., P.O. Box 536
Pueblo, CO. 81002
Phone: (719) 546-5487 FAX: (719) 546-5414

Right of Way Plans Unit: Larry R. Lucas

Sheet Revisions

Sheet Revisions

Sheet Revisions

Right of Way Plans

PLAN SHEET

Project Number: STA 012A-034

Project Location: WESTON EAST

Project Location: HIGHWAY 12

Project Code:	Last Mod. Date	Subset Sheets	Sheet No.	Total No. of Sheets
12834	01/18/02		14	23

NUMBER	C15
RAD	1116.00
DELTA	13°20'02"
ARC LEN	259.72
CH DIR	S 86°21'43" W
CH LEN	259.13

Southeast 1/4 Section 33


Pete C. Ortega
C. Manuel Ortega
Bk693-Pg194

Southwest 1/4 Section 34

Richard S. Lopez
and Sylvia A. Lopez
Bk1008-Pg1173

CENTERLINE
CURVE DATA
Delta = 16° 08' 14"
Degree of Curve (Arc)=04° 29' 59.99"
T = 180.50
R = 1273.24
L = 358.60
Degree of Curve (Chord)=04° 30'
04.16"
Hand of Arc=Left

Bearing and Distance from
Intersection at Sta. 73+26.04 to
1/4 Cor. Sec 33 and Sec 34

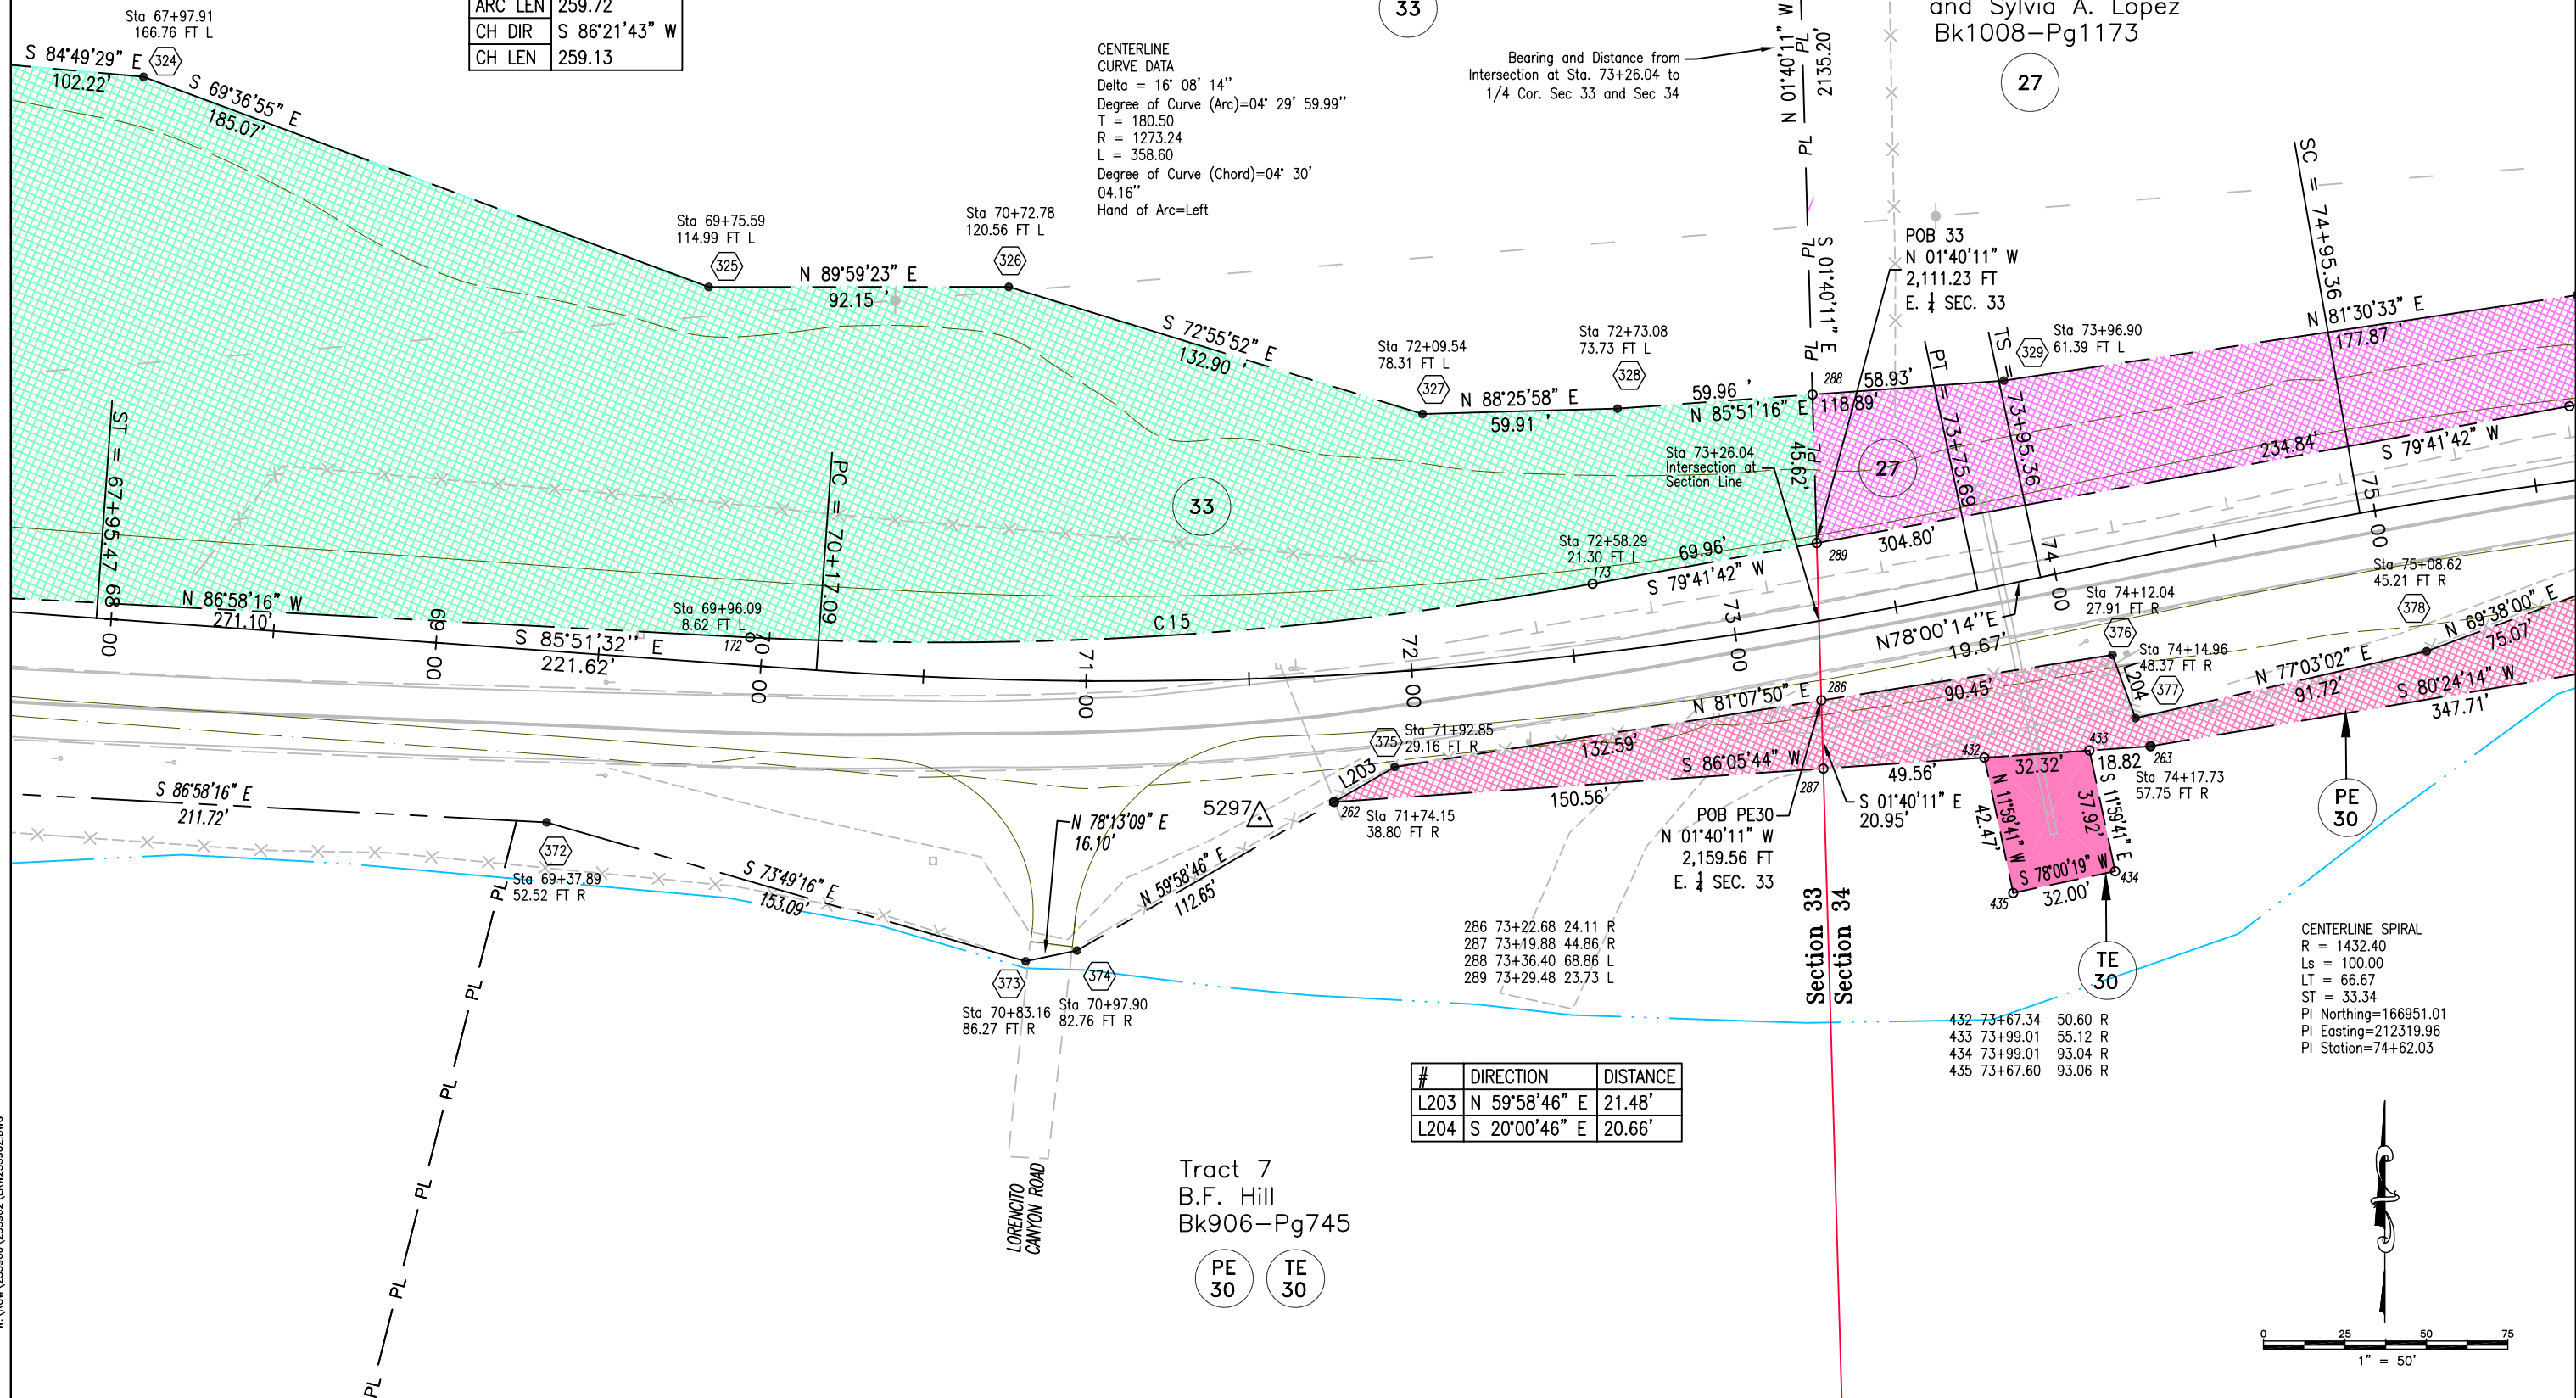


#	DIRECTION	DISTANCE
L203	N 59°58'46" E	21.48'
L204	S 20°00'46" E	20.66'

Tract 7
B.F. Hill
Bk906-Pg745

PE 30
TE 30

CENTERLINE SPIRAL
R = 1432.40
Ls = 100.00
LT = 66.67
ST = 33.34
PI Northing=166951.01
PI Easting=212319.96
PI Station=74+62.03

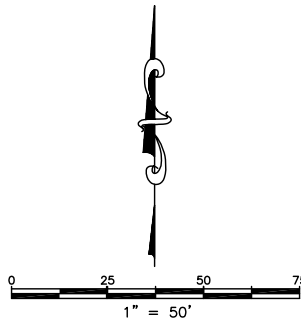

COLORADO DEPARTMENT OF TRANSPORTATION



Region 2
905 Erie Ave., P.O. Box 536
Pueblo, CO. 81002
Phone: (719) 546-5487 FAX: (719) 546-5414

Right of Way Plans Unit: Larry R. Lucas

Sheet Revisions

Sheet Revisions

Sheet Revisions

Right of Way Plans

PLAN SHEET

Project Number: STA 012A-034

Project Location: WESTON EAST

Project Location: HIGHWAY 12


Project Code	Last Mod. Date	Subset Sheets	Sheet No.	Total No. of Sheets
12834	01/18/02	HIGHWAY 12	15	23

Richard S. Lopez
and Sylvia A. Lopez
Bk1008-Pg1173

NUMBER	C14
RAD	746.25
DELTA	31°52'40"
ARC LEN	415.19
CH DIR	N 84°21'59" W
CH LEN	409.86

Southwest 1/4 Section 34

27

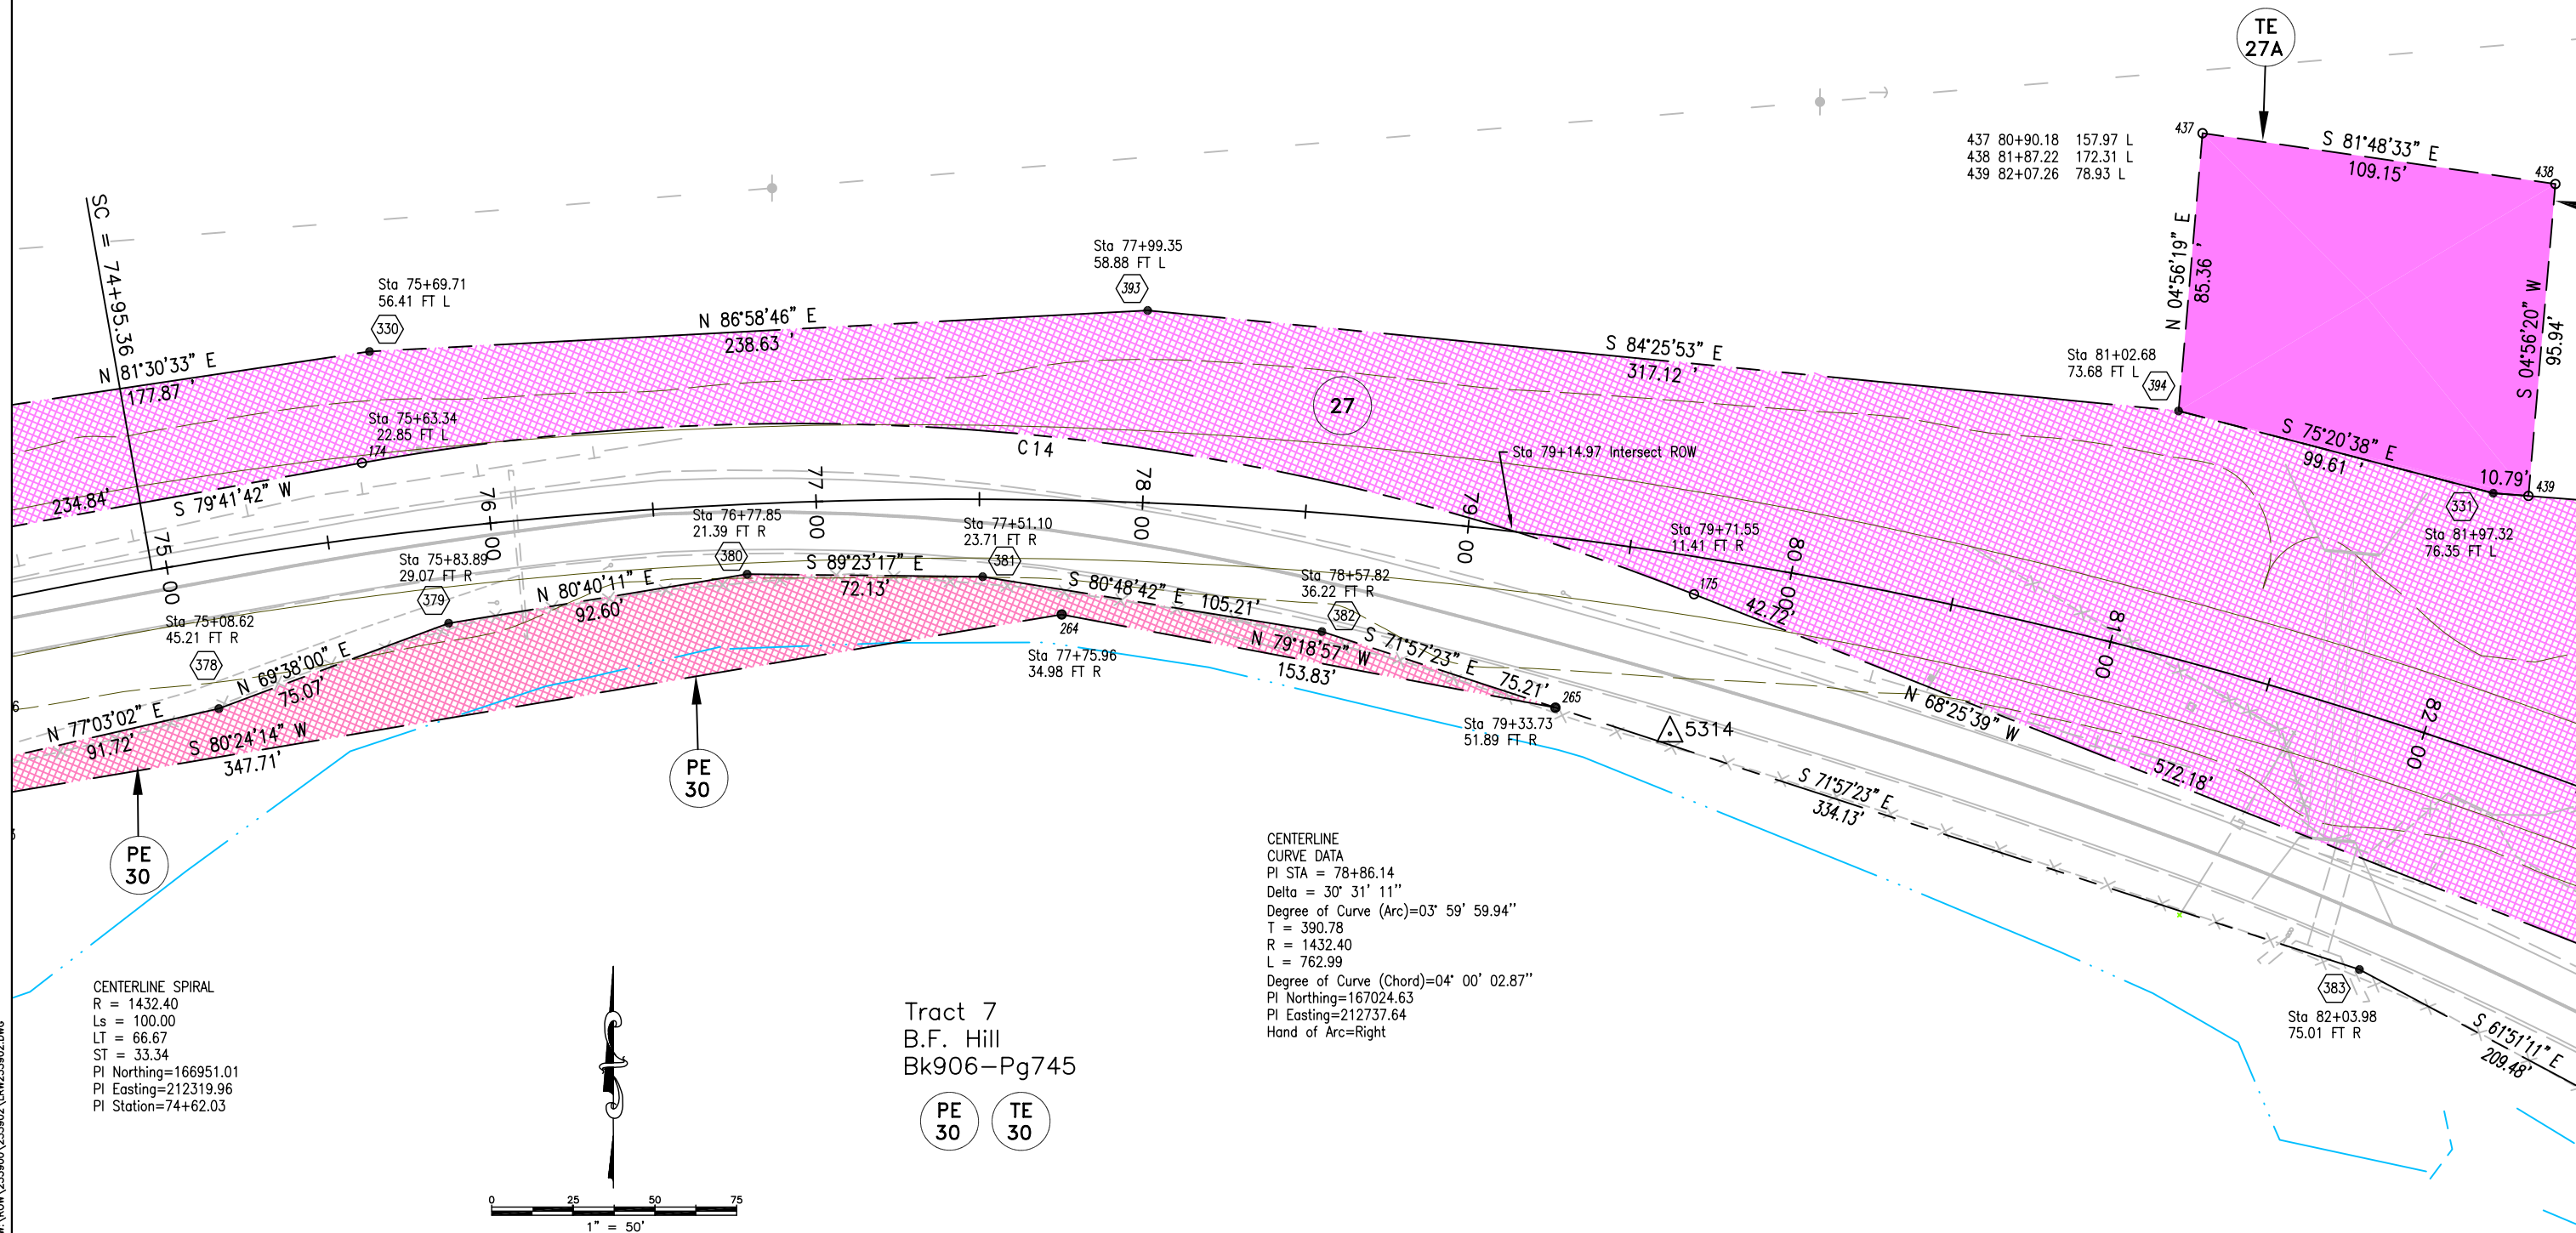



Region 2
905 Erie Ave., P.O. Box 536
Pueblo, CO. 81002
Phone: (719) 546-5487 FAX: (719) 546-5414

Right of Way Plans Unit: Larry R. Lucas

Sheet Revisions

Sheet Revisions

Sheet Revisions

Right of Way Plans

PLAN SHEET

Project Number: STA 012A-034

Project Location: WESTON EAST

Project Location: HIGHWAY 12

Project Code:	Last Mod. Date	Subset Sheets	Sheet No.	Total No. of Sheets
12834	01/18/02		16	23

Richard S. Lopez
and Sylvia A. Lopez
Bk1008-Pg1173

Southwest 1/4 Section 34

27

CENTERLINE SPIRAL
R = 954.93
Ls = 150.00
LT = 100.03
ST = 50.03
PI Northing=166806.21
PI Easting=213302.99
PI Station=84+73.71

5327

Sta 87+25.07
99.16 FT L

S 87°44'05" E
252.44'

CENTERLINE
CURVE DATA
PI STA = 88+40.99
Delta = 36° 45' 41"
Degree of Curve (Arc)=05° 59' 59.99"
T = 317.30
R = 954.93
L = 612.69
Degree of Curve (Chord)=06° 00' 09.87"
PI Northing=166692.56
PI Easting=213652.29
Hand of Arc=Left

27

SC = 85+23.68

TS = 83+73.68

ST = 83+58.35

CS = 82+58.35

S 67°28'36" E
15.33'

N 68°25'39" W
572.18'

S 61°51'11" E
209.48'

Sta 82+03.98
75.01 FT R

CENTERLINE SPIRAL
R = 1432.40
Ls = 100.00
LT = 66.67
ST = 33.34
PI Northing=166875.94
PI Easting=213134.84
PI Station=82+91.69

Sta 84+17.34
99.53 FT R


Sta 85+85.21
51.85 FT R

Sta 87+45.60
117.28 FT R

R=590.49' Arc Len=211.11'

East 1/16 Line Section 34

NUMBER	C13
RAD	447.50
DELTA	45°01'57"
ARC LEN	351.72
CH DIR	S 89°03'22" W
CH LEN	342.74

 



Region 2
905 Erie Ave., P.O. Box 536
Pueblo, CO. 81002
Phone: (719) 546-5487 FAX: (719) 546-5414

Right of Way Plans Unit: Larry R. Lucas

Sheet Revisions

Sheet Revisions

Sheet Revisions

Right of Way Plans

PLAN SHEET

Project Number: STA 012A-034

Project Location: WESTON EAST

Project Location: HIGHWAY 12

Project Code:	Last Mod. Date	Subset Sheets	Sheet No.	Total No. of Sheets
12834	01/18/02		17	23

CENTERLINE
CURVE DATA
PI STA = 88+40.99
Delta = 36° 45' 41"
Degree of Curve (Arc)=05° 59' 59.99"
T = 317.30
R = 954.93
L = 612.69
Degree of Curve (Chord)=06° 00'
09.87"
PI Northing=166692.56
PI Easting=213652.29
Hand of Arc=Left

Southwest 1/4 Section 34

Richard S. Lopez
and Sylvia A. Lopez
Bk1008-Pg1173

CENTERLINE SPIRAL
R = 954.93
Ls = 150.00
LT = 100.03
ST = 50.03
PI Northing=166810.56
PI Easting=214000.16
PI Station=91+86.40

27

ST = 92+86.37

CS = 91+36.37

N 82°32'44" E
212.41'

Sta 90+03.43
78.36 FT L

Sta 92+25.88
42.01 FT L

N 64°59'50" E
417.00'

S 66°32'24" W
1186.24'

N 66°45'44" E
864.18'

96+00

Sta 91+55.64
34.39 FT R

N 66°40'25" E
238.76'

Sta 89+32.96
76.61 FT R

N 66°36'01" E
550.77'

S 66°44'01" W
444.78'

POB PE31
N 39°03'43" W
2,948.62 FT
E. 1/4 SEC. 33

266	91+55.88	45.88	R
267	91+72.03	50.14	R
268	92+50.80	60.59	R
269	93+48.08	38.11	R

PE 31

Dustin D. LePlatt
Howard E. LePlatt
Kaye LePlatt
Bk935-Pg144

TE 31

PE 31

Tract 7
B.F. Hill
Bk906-Pg745

#	DIRECTION	DISTANCE
L83	S 83°58'57" W	17.34'
L84	N 21°01'49" W	11.50'

0 25 50 75
1" = 50'

COLORADO DEPARTMENT OF TRANSPORTATION



Region 2
905 Erie Ave., P.O. Box 536
Pueblo, CO. 81002
Phone: (719) 546-5487 FAX: (719) 546-5414

Right of Way Plans Unit: Larry R. Lucas

Sheet Revisions

Sheet Revisions

Sheet Revisions

Right of Way Plans

PLAN SHEET

Project Number: STA 012A-034

Project Location: WESTON EAST

Project Location: HIGHWAY 12

Project Code:	Last Mod. Date	Subset Sheets	Sheet No.	Total No. of Sheets
12834	01/18/02		18	23

Richard S. Lopez
and Sylvia A. Lopez
Bk1008-Pg1173

James Worley
Sue Worley
Bk985-Pg238

#	DIRECTION	DISTANCE
L50	N 24°48'58" W	20.00'
L51	N 65°11'02" E	36.58'
L52	S 24°48'58" E	20.00'
L53	S 65°11'02" W	36.58'

CENTERLINE
CURVE DATA
Delta = 00° 47' 00"
Degree of Curve (Arc)=11° 27' 32.96"
T = 3.42
R = 500.00
L = 6.84
Degree of Curve (Chord)=11° 28'
42.03"
Hand of Arc=Left

182 101+14.70 67.77 L
183 101+00.87 32.51 L
184 101+87.58 32.38 L

N 66°39'23" E
12.83'

Sta 101+01.87
67.75 FT L

PT = 101+57.39
PC = 101+50.55

POB 27
N 55°30'56" W
3,279.41 FT
E. 1/4 SEC. 33

POB 35
N 58°51'14" W
3,409.52 FT
E. 1/4 SEC. 33

234.07'
234.26'

N 66°39'23" E 284.01'
N 58°51'14" W 3,409.52 FT
E. 1/4 SEC. 33
S 66°32'24" W 773.44'

S 01°49'59" E
37.88'

Sta 101+59.37
22.54 FT R

103+00
102+00
101+00

N 65°58'43" E
429.93'

N 66°45'44" E
864.18'

N 66°36'01" E
550.77'

S 66°44'01" W
444.78'

N 68°07'30" E
400.91'

S 66°32'24" W
1186.24'

N 65°11'02" E
458.83'

S 67°37'36" W
363.90'

S 67°23'29" W
384.95'

N 65°45'26" E
435.03'

S 67°37'36" W
363.90'

S 67°37'36" W
363.90'

S 67°37'36" W
363.90'

N 66°45'44" E
864.18'

N 66°36'01" E
550.77'

S 66°44'01" W
444.78'

N 68°07'30" E
400.91'

S 66°32'24" W
1186.24'

N 65°11'02" E
458.83'

S 67°37'36" W
363.90'

S 67°23'29" W
384.95'

N 65°45'26" E
435.03'

S 67°37'36" W
363.90'

S 67°37'36" W
363.90'

S 67°37'36" W
363.90'

N 66°45'44" E
864.18'

N 66°36'01" E
550.77'

S 66°44'01" W
444.78'

N 68°07'30" E
400.91'

S 66°32'24" W
1186.24'

N 65°11'02" E
458.83'

S 67°37'36" W
363.90'

S 67°23'29" W
384.95'

N 65°45'26" E
435.03'

S 67°37'36" W
363.90'

S 67°37'36" W
363.90'

S 67°37'36" W
363.90'

N 66°45'44" E
864.18'

N 66°36'01" E
550.77'

S 66°44'01" W
444.78'

N 68°07'30" E
400.91'

S 66°32'24" W
1186.24'

N 65°11'02" E
458.83'

S 67°37'36" W
363.90'

S 67°23'29" W
384.95'

N 65°45'26" E
435.03'

S 67°37'36" W
363.90'

S 67°37'36" W
363.90'

S 67°37'36" W
363.90'

N 66°45'44" E
864.18'

N 66°36'01" E
550.77'

S 66°44'01" W
444.78'

N 68°07'30" E
400.91'

S 66°32'24" W
1186.24'

N 65°11'02" E
458.83'

S 67°37'36" W
363.90'

S 67°23'29" W
384.95'

N 65°45'26" E
435.03'

S 67°37'36" W
363.90'

S 67°37'36" W
363.90'

S 67°37'36" W
363.90'

N 66°45'44" E
864.18'

N 66°36'01" E
550.77'

S 66°44'01" W
444.78'

N 68°07'30" E
400.91'

S 66°32'24" W
1186.24'

N 65°11'02" E
458.83'

S 67°37'36" W
363.90'

S 67°23'29" W
384.95'

N 65°45'26" E
435.03'

S 67°37'36" W
363.90'

S 67°37'36" W
363.90'

S 67°37'36" W
363.90'

N 66°45'44" E
864.18'

N 66°36'01" E
550.77'

S 66°44'01" W
444.78'

N 68°07'30" E
400.91'

S 66°32'24" W
1186.24'

N 65°11'02" E
458.83'

S 67°37'36" W
363.90'

S 67°23'29" W
384.95'

N 65°45'26" E
435.03'

S 67°37'36" W
363.90'

S 67°37'36" W
363.90'

S 67°37'36" W
363.90'

N 66°45'44" E
864.18'

N 66°36'01" E
550.77'

S 66°44'01" W
444.78'

N 68°07'30" E
400.91'

S 66°32'24" W
1186.24'

N 65°11'02" E
458.83'

S 67°37'36" W
363.90'

S 67°23'29" W
384.95'

N 65°45'26" E
435.03'

S 67°37'36" W
363.90'

S 67°37'36" W
363.90'

S 67°37'36" W
363.90'

N 66°45'44" E
864.18'

N 66°36'01" E
550.77'

S 66°44'01" W
444.78'

N 68°07'30" E
400.91'

S 66°32'24" W
1186.24'

N 65°11'02" E
458.83'

S 67°37'36" W
363.90'

S 67°23'29" W
384.95'

N 65°45'26" E
435.03'

S 67°37'36" W
363.90'

S 67°37'36" W
363.90'

S 67°37'36" W
363.90'

N 66°45'44" E
864.18'

N 66°36'01" E
550.77'

S 66°44'01" W
444.78'

N 68°07'30" E
400.91'

S 66°32'24" W
1186.24'

N 65°11'02" E
458.83'

S 67°37'36" W
363.90'

S 67°23'29" W
384.95'

N 65°45'26" E
435.03'

S 67°37'36" W
363.90'

S 67°37'36" W
363.90'

S 67°37'36" W
363.90'

N 66°45'44" E
864.18'

N 66°36'01" E
550.77'

S 66°44'01" W
444.78'

N 68°07'30" E
400.91'

S 66°32'24" W
1186.24'

N 65°11'02" E
458.83'

S 67°37'36" W
363.90'

S 67°23'29" W
384.95'

N 65°45'26" E
435.03'

S 67°37'36" W
363.90'

S 67°37'36" W
363.90'

S 67°37'36" W
363.90'

N 66°45'44" E
864.18'

N 66°36'01" E
550.77'

S 66°44'01" W
444.78'

N 68°07'30" E
400.91'

S 66°32'24" W
1186.24'

N 65°11'02" E
458.83'

S 67°37'36" W
363.90'

S 67°23'29" W
384.95'

N 65°45'26" E
435.03'

S 67°37'36" W
363.90'

S 67°37'36" W
363.90'

S 67°37'36" W
363.90'

N 66°45'44" E
864.18'

N 66°36'01" E
550.77'

S 66°44'01" W
444.78'

N 68°07'30" E
400.91'

S 66°32'24" W
1186.24'

N 65°11'02" E
458.83'

S 67°37'36" W
363.90'

S 67°23'29" W
384.95'

N 65°45'26" E
435.03'

S 67°37'36" W
363.90'

S 67°37'36" W
363.90'

S 67°37'36" W
363.90'

N 66°45'44" E
864.18'

N 66°36'01" E
550.77'

S 66°44'01" W
444.78'

N 68°07'30" E
400.91'

S 66°32'24" W
1186.24'

N 65°11'02" E
458.83'

S 67°37'36" W
363.90'

S 67°23'29" W
384.95'

N 65°45'26" E
435.03'

S 67°37'36" W
363.90'

S 67°37'36" W
363.90'

S 67°37'36" W
363.90'

N 66°45'44" E
864.18'

N 66°36'01" E
550.77'

S 66°44'01" W
444.78'

N 68°07'30" E
400.91'

S 66°32'24" W
1186.24'

N 65°11'02" E
458.83'

S 67°37'36" W
363.90'

S 67°23'29" W
384.95'

N 65°45'26" E
435.03'

S 67°37'36" W
363.90'

S 67°37'36" W
363.90'

S 67°37'36" W
363.90'

N 66°45'44" E
864.18'

N 66°36'01" E
550.77'

S 66°44'01" W
444.78'

N 68°07'30" E
400.91'

S 66°32'24" W
1186.24'

N 65°11'02" E
458.83'

S 67°37'36" W
363.90'

S 67°23'29" W
384.95'

N 65°45'26" E
435.03'

S 67°37'36" W
363.90'

S 67°37'36" W
363.90'

S 67°37'36" W
363.90'

N 66°45'44" E
864.18'

N 66°36'01" E
550.77'

S 66°44'01" W
444.78'

N 68°07'30" E
400.91'

S 66°32'24" W
1186.24'

N 65°11'02" E
458.83'

S 67°37'36" W
363.90'

S 67°23'29" W
384.95'

N 65°45'26" E
435.03'

COLORADO DEPARTMENT OF TRANSPORTATION



Region 2
905 Erie Ave., P.O. Box 536
Pueblo, CO. 81002
Phone: (719) 546-5487 FAX: (719) 546-5414

Right of Way Plans Unit: Larry R. Lucas

Sheet Revisions

Sheet Revisions

Sheet Revisions

Right of Way Plans

PLAN SHEET

Project Number: STA 012A-034

Project Location: WESTON EAST

Project Location: HIGHWAY 12

Project Code:	Last Mod. Date	Subset Sheets	Sheet No.	Total No. of Sheets
12834	01/18/02		19	23


James Worley
Sue Worley
Bk985-Pg238

Southeast 1/4 Section 34

Howard E. LePlatt
Bernice B. LePlatt
Bk788-Pg650


End R.O.W. STA 012A-034
Sta. 108+74.29


End Construction
Sta 110+00

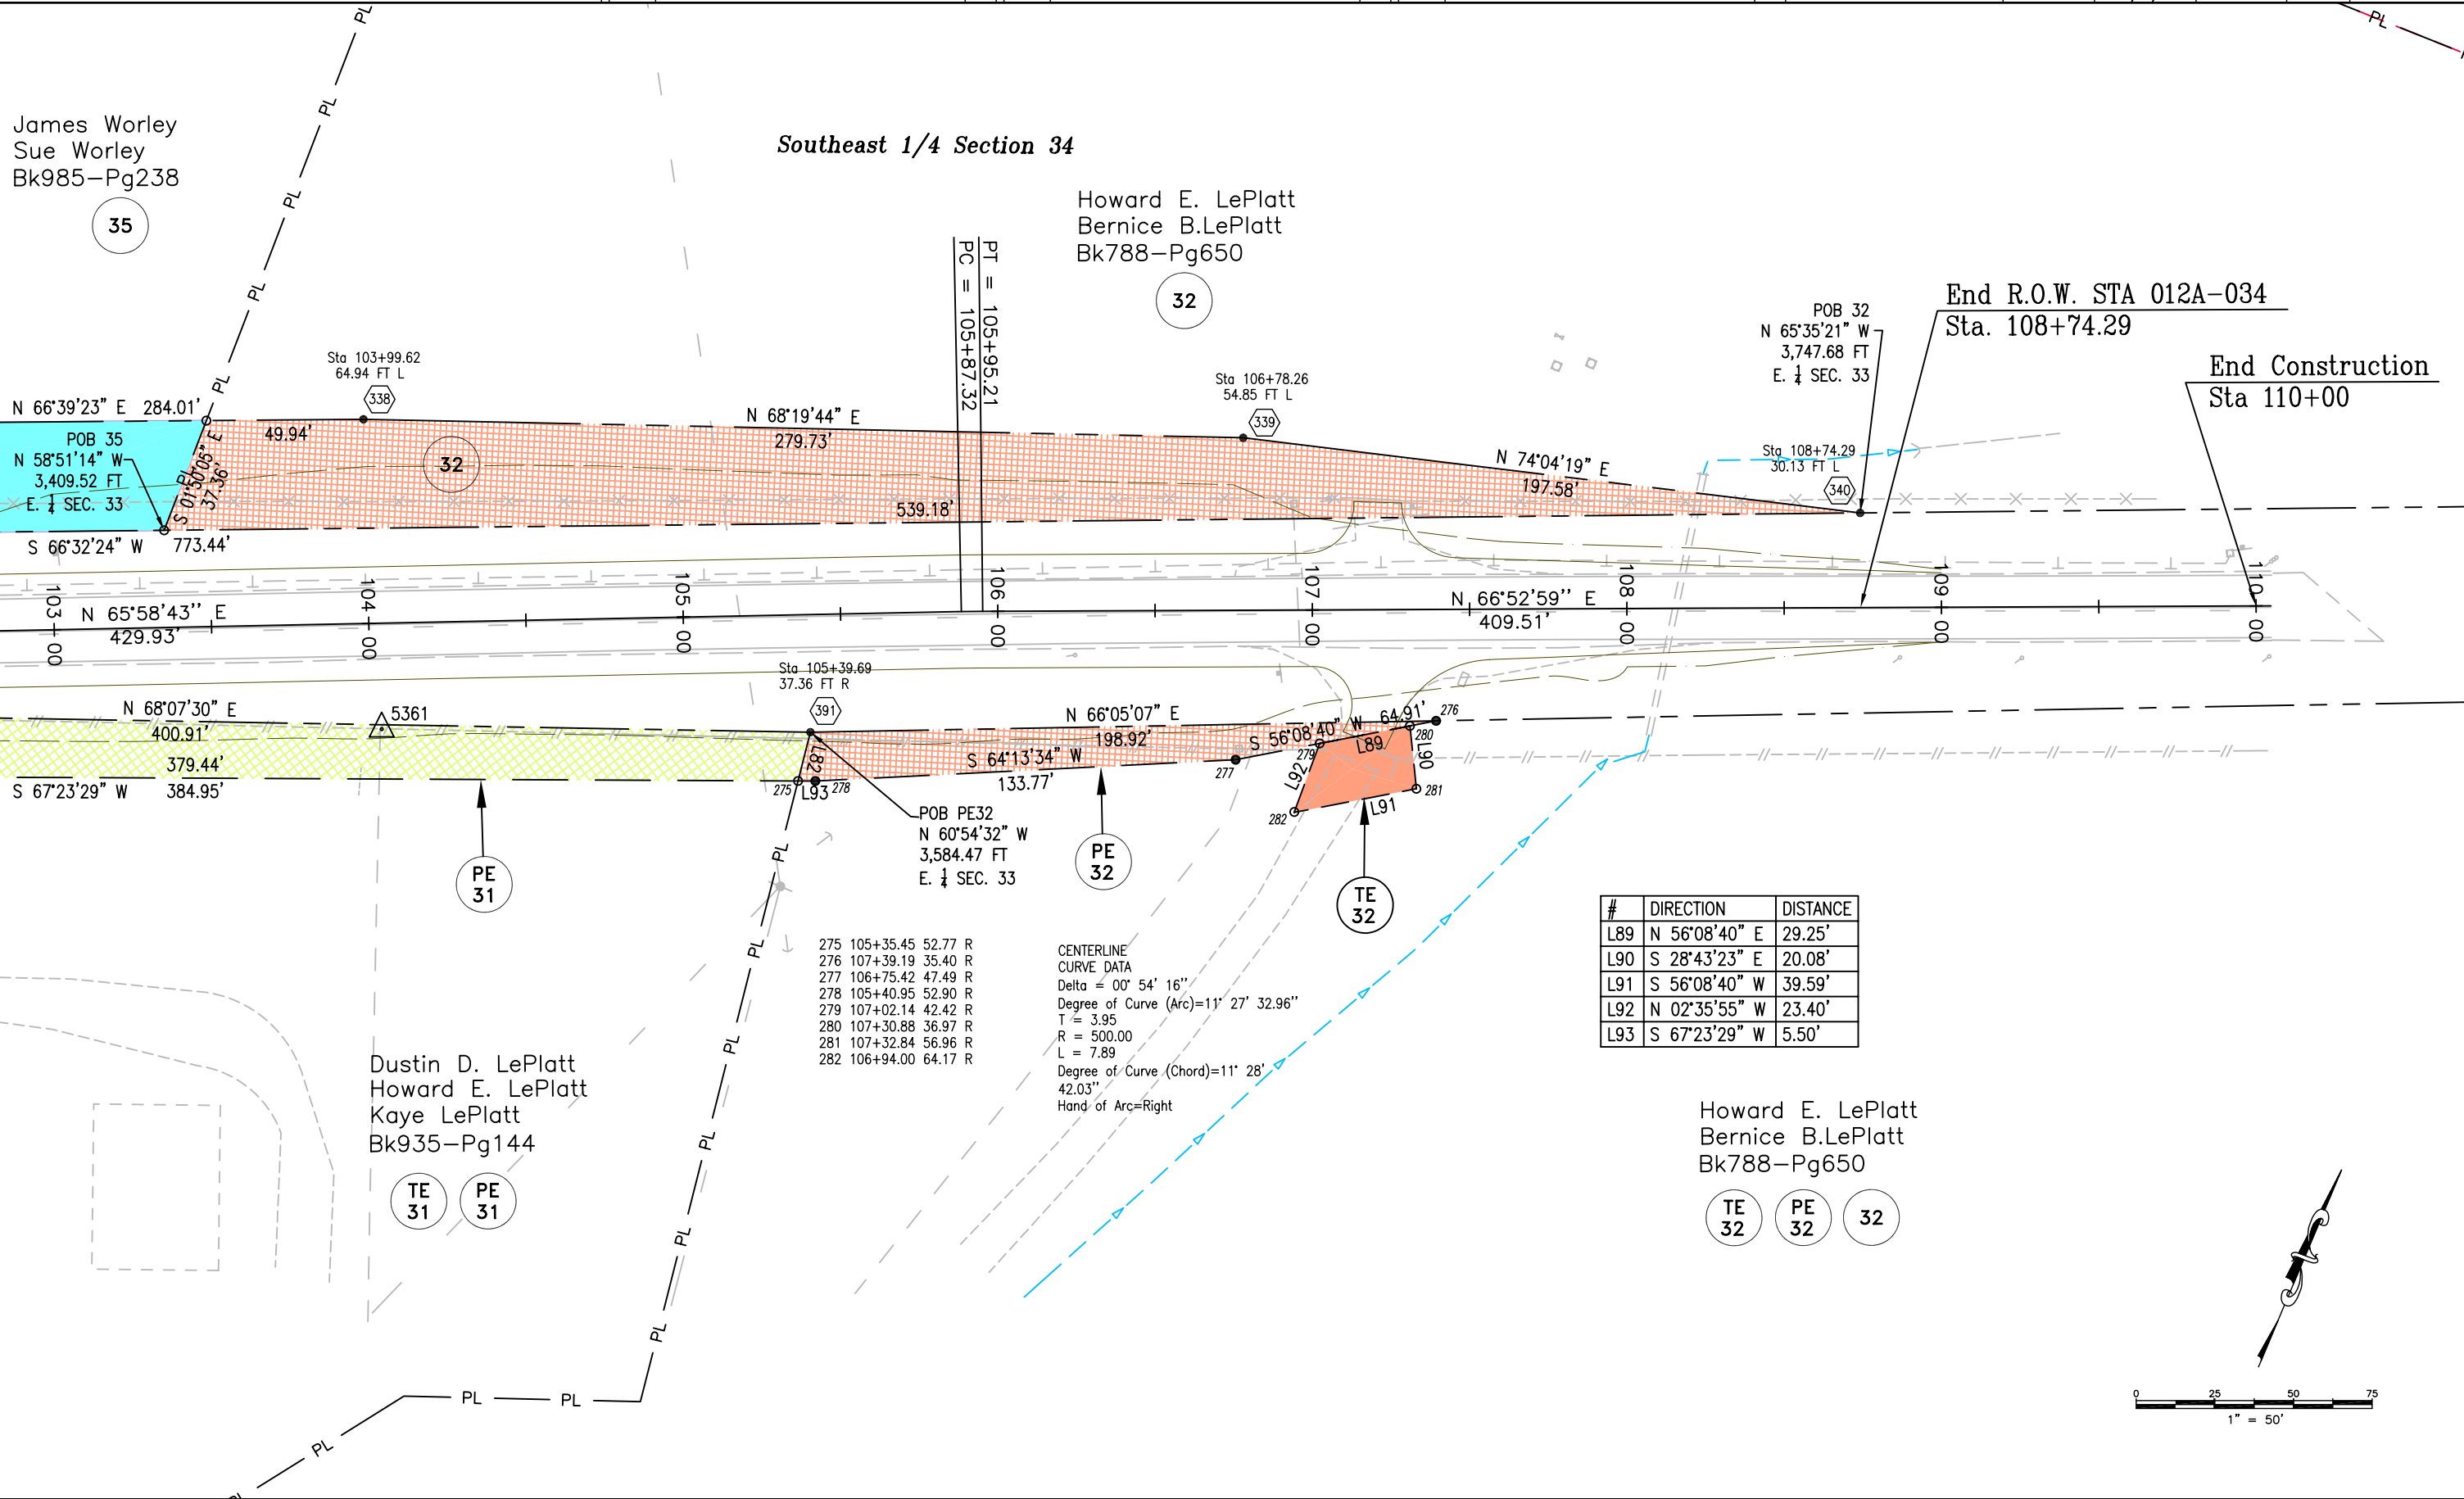

#	DIRECTION	DISTANCE
L89	N 56°08'40" E	29.25'
L90	S 28°43'23" E	20.08'
L91	S 56°08'40" W	39.59'
L92	N 02°35'55" W	23.40'
L93	S 67°23'29" W	5.50'

 Howard E. LePlatt
Bernice B. LePlatt
Bk788-Pg650

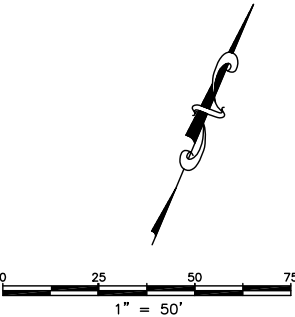



Region: 2
905 Erie Ave. P.O. Box 536
Pueblo, CO. 81002
Phone: (719) 546-5487 FAX: (719)546-5414

Right of Way Plans Unit: Larry R. Lucas

Sheet Revisions

Sheet Revisions

Sheet Revisions

Right of Way Plans

OWNERSHIP MAP

Project Number: STA 012A-034

Project Location: Weston East

Project Location: Highway 12

Project Code:	Last Mod. Date	Subset Sheets	Sheet No.	Total No. of Sheets
12834	01/18/02	1 of 4	20	23

Las Animas County

Section 32 & 33, Township 33 South, Range 66 West, 6th P.M.

- TE 1

1

Richard S. Lopez & Sylvia A. Lopez
19901 Highway 12
Weston, CO. 81091 TC# 67956
- 2A

TE 2A

TE 2

2

Wayne F. & Mary A. Weaver (1/2 interest) &
Aron C. Weaver, Jonathan C. Weaver, Samuel B. Weaver,
R. Laurie Hancock, Jason M. Weaver, (1/10th interest each).
#3 Pine, P.O. Box 192
Cokedale, CO. TC# 67958
- TE 3

3

Michael L. Thompson & Sheila Thompson
8921 W. Bopp Rd.
Tucson, AZ. 85746 TC# 67957
- TE 4

TE 4A

Joe N. Trujillo Jr. & Isabel Louise Trujillo
19941 Highway 12
Weston, CO. 81091
- TE 5B

TE 5A

TE 5

5

Clarence Kenneth Beebe
20001 Highway 12
Weston, CO. 81091 TC# 67906
- TE 7

Irvin W. Shupe & Mary Jane Shupe
20011 Highway 12
Weston, CO. 81091
- TE 8A

TE 8

PE 8

Sam D. & Josephine M. Gettings
4234 Kiva Trail
W.W. Los Lunas, NM 87031 TC# 67893
- TE 9

9

Primerio Union High School
20200 Highway 12
Weston, CO. 81091 TC# 67904
- 10

Floyd J. Brown & Sadie M. Brown
20199 Highway 12
Weston, CO. 81091 TC# 67920
- 11A

TE 11A

TE 11

11

Joseph T. Marquez, Margaret M. Bradeen,
Rosalie C. Miller & Madeline Marquez (Life Estate)
20350 County Road 41.7
Weston, CO. 81091 TC# 67892
- 12


Sam D. & Josephine M. Gettings
4234 Kiva Trail
W.W. Los Lunas, NM 87031 TC# 67893
- 13


Ronald Elton Leef & Cheryl Ann Leef
20199 Highway 12
Weston, CO. 81091 TC# 66754
- TE 14A

15

TE 14

 Marcus Gonzales & Geraldine Gonzales
12732 East 2nd Ave.
Aurora, CO 80011 TC# 67935

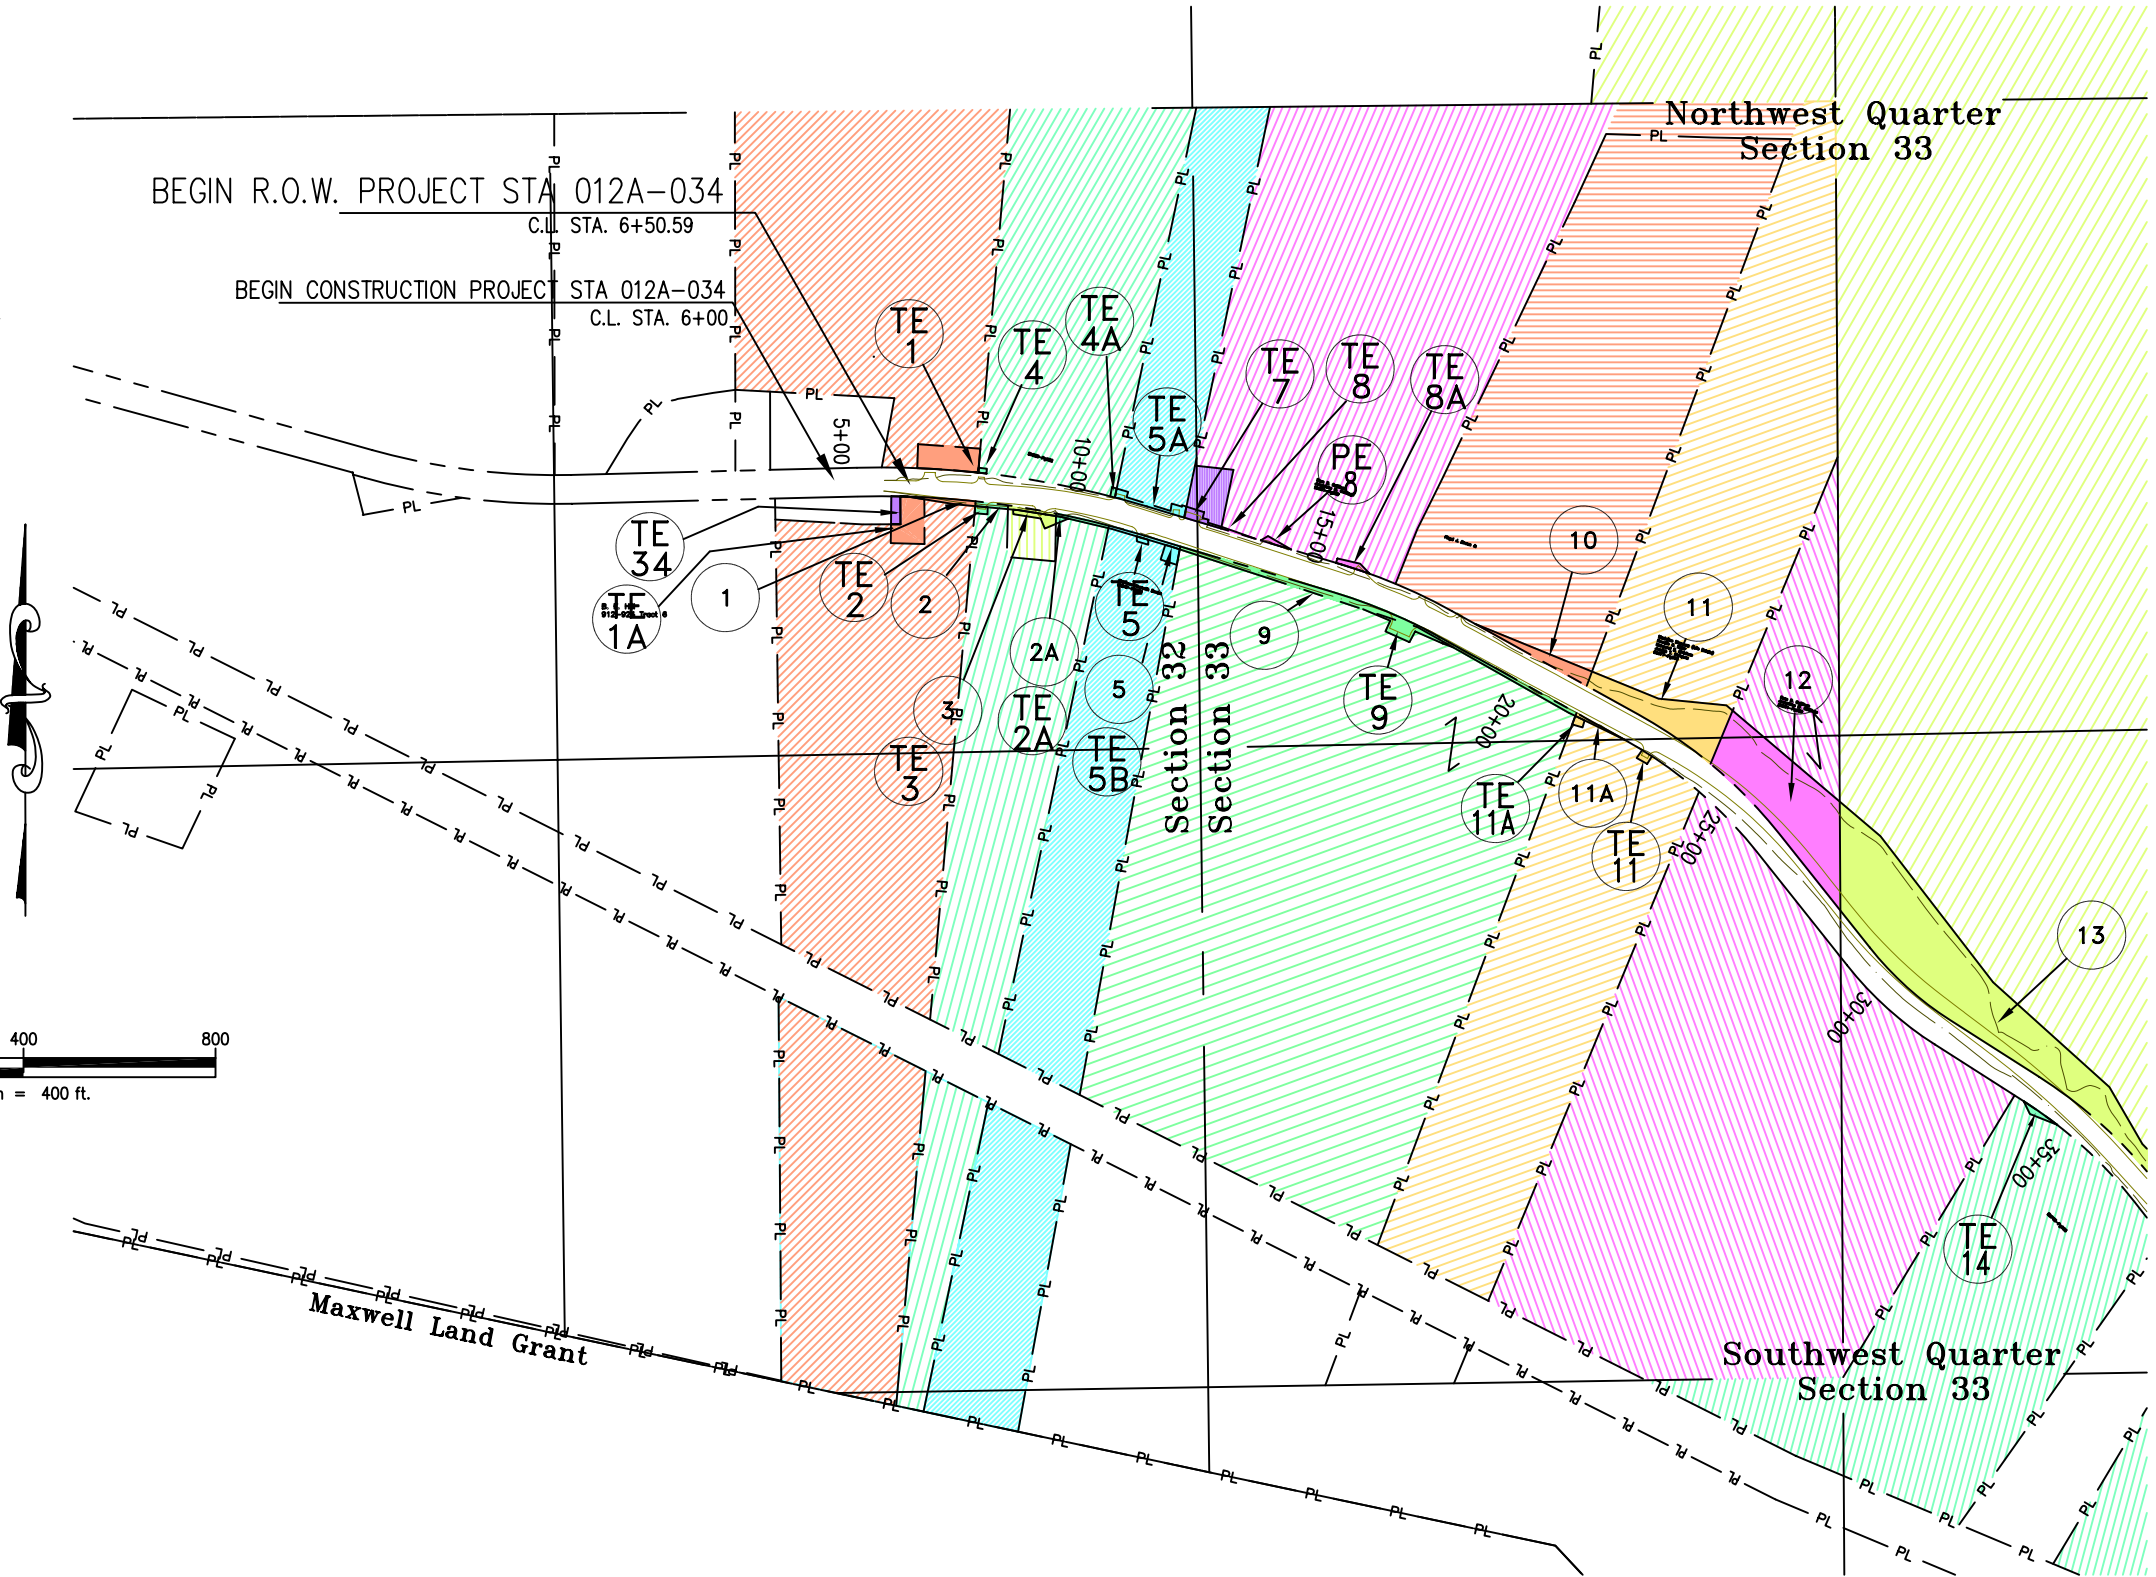



Region: 2
905 Erie Ave. P.O. Box 536
Pueblo, CO. 81002
Phone: (719) 546-5487 FAX: (719)546-5414

Right of Way Plans Unit: Larry R. Lucas

Sheet Revisions

Sheet Revisions

Sheet Revisions

Right of Way Plans

OWNERSHIP MAP

Project Number: STA 012A-034

Project Location: Weston East

Project Location: Highway 12

Project Code:	Last Mod. Date	Subset Sheets	Sheet No.	Total No. of Sheets
12834	01/18/02	2 of 4	21	23

Las Animas County

Section 32 & 33, Township 33 South, Range 66 West, 6th P.M.

- 13

Ronald Elton Leef & Cheryl Ann Leef
20199 Highway 12
Weston, CO. 81091 TC# 66754
- TE 14A

15

TE 14

Marcus Gonzales & Geraldine Gonzales
12732 East 2nd Ave.
Aurora, CO 80011 TC# 67935
- 16

Henry Guilbert & Theresa C. Duran
20740 Highway 12
Weston, CO. 81091 TC# 67914
- TE 17

Larry Guara & Cathi Guara
20861 Highway 12
Weston, CO. 81091
- 18

Alex J. & Erleen Garcia
20750 Highway 12
Weston, CO 81091 TC# 67936
- TE 19

19

Clarita Medina
TC# 67619
- TE 20

Mathew M. Trujillo & Theresa J.Trujillo
13900 Highway 12
Weston, CO. 81091
- TE 21A

TE 21

21

Danny Gallegos, Joseph Edward Gallegos & Martha Martinez
1212 S. Federal Blvd.
Denver, CO. 80219 TC# 67942
- TE 22

Juanita C. Lamorie
P.O. Box 795
Lander, Wyoming 82520
- TE 23

23

Michael Lee Duran & Shirley A. Duran
21050 Highway 12
Weston, CO. 81091 TC# 67710
- TE 24

Michael Lee & Geniveva Duran
21050 Highway 12
Weston, CO. 81091
- TE 25

William Kishman & Bessie Kishman
21061 Highway 12
Weston, CO. 81091
- 26

Florence Sandoval
21200 Highway 12
Weston, CO. 81091 TC# 67938
- TE 27

TE 27A

27


 
Richard S. Lopez & Sylvia A. Lopez
19901 Highway 12
Weston CO. 81091 TC# 67801
- TE 28

28

C. Manuel, Candido M, and Beatrice V. Ortega
1250 S. Raleigh St.
Denver, CO. 80219 TC# 67940
- TE 29

29

Florence Marie Sandoval & Louise Sandoval
21200 Highway 12
Weston, CO. 81091 TC# 67943

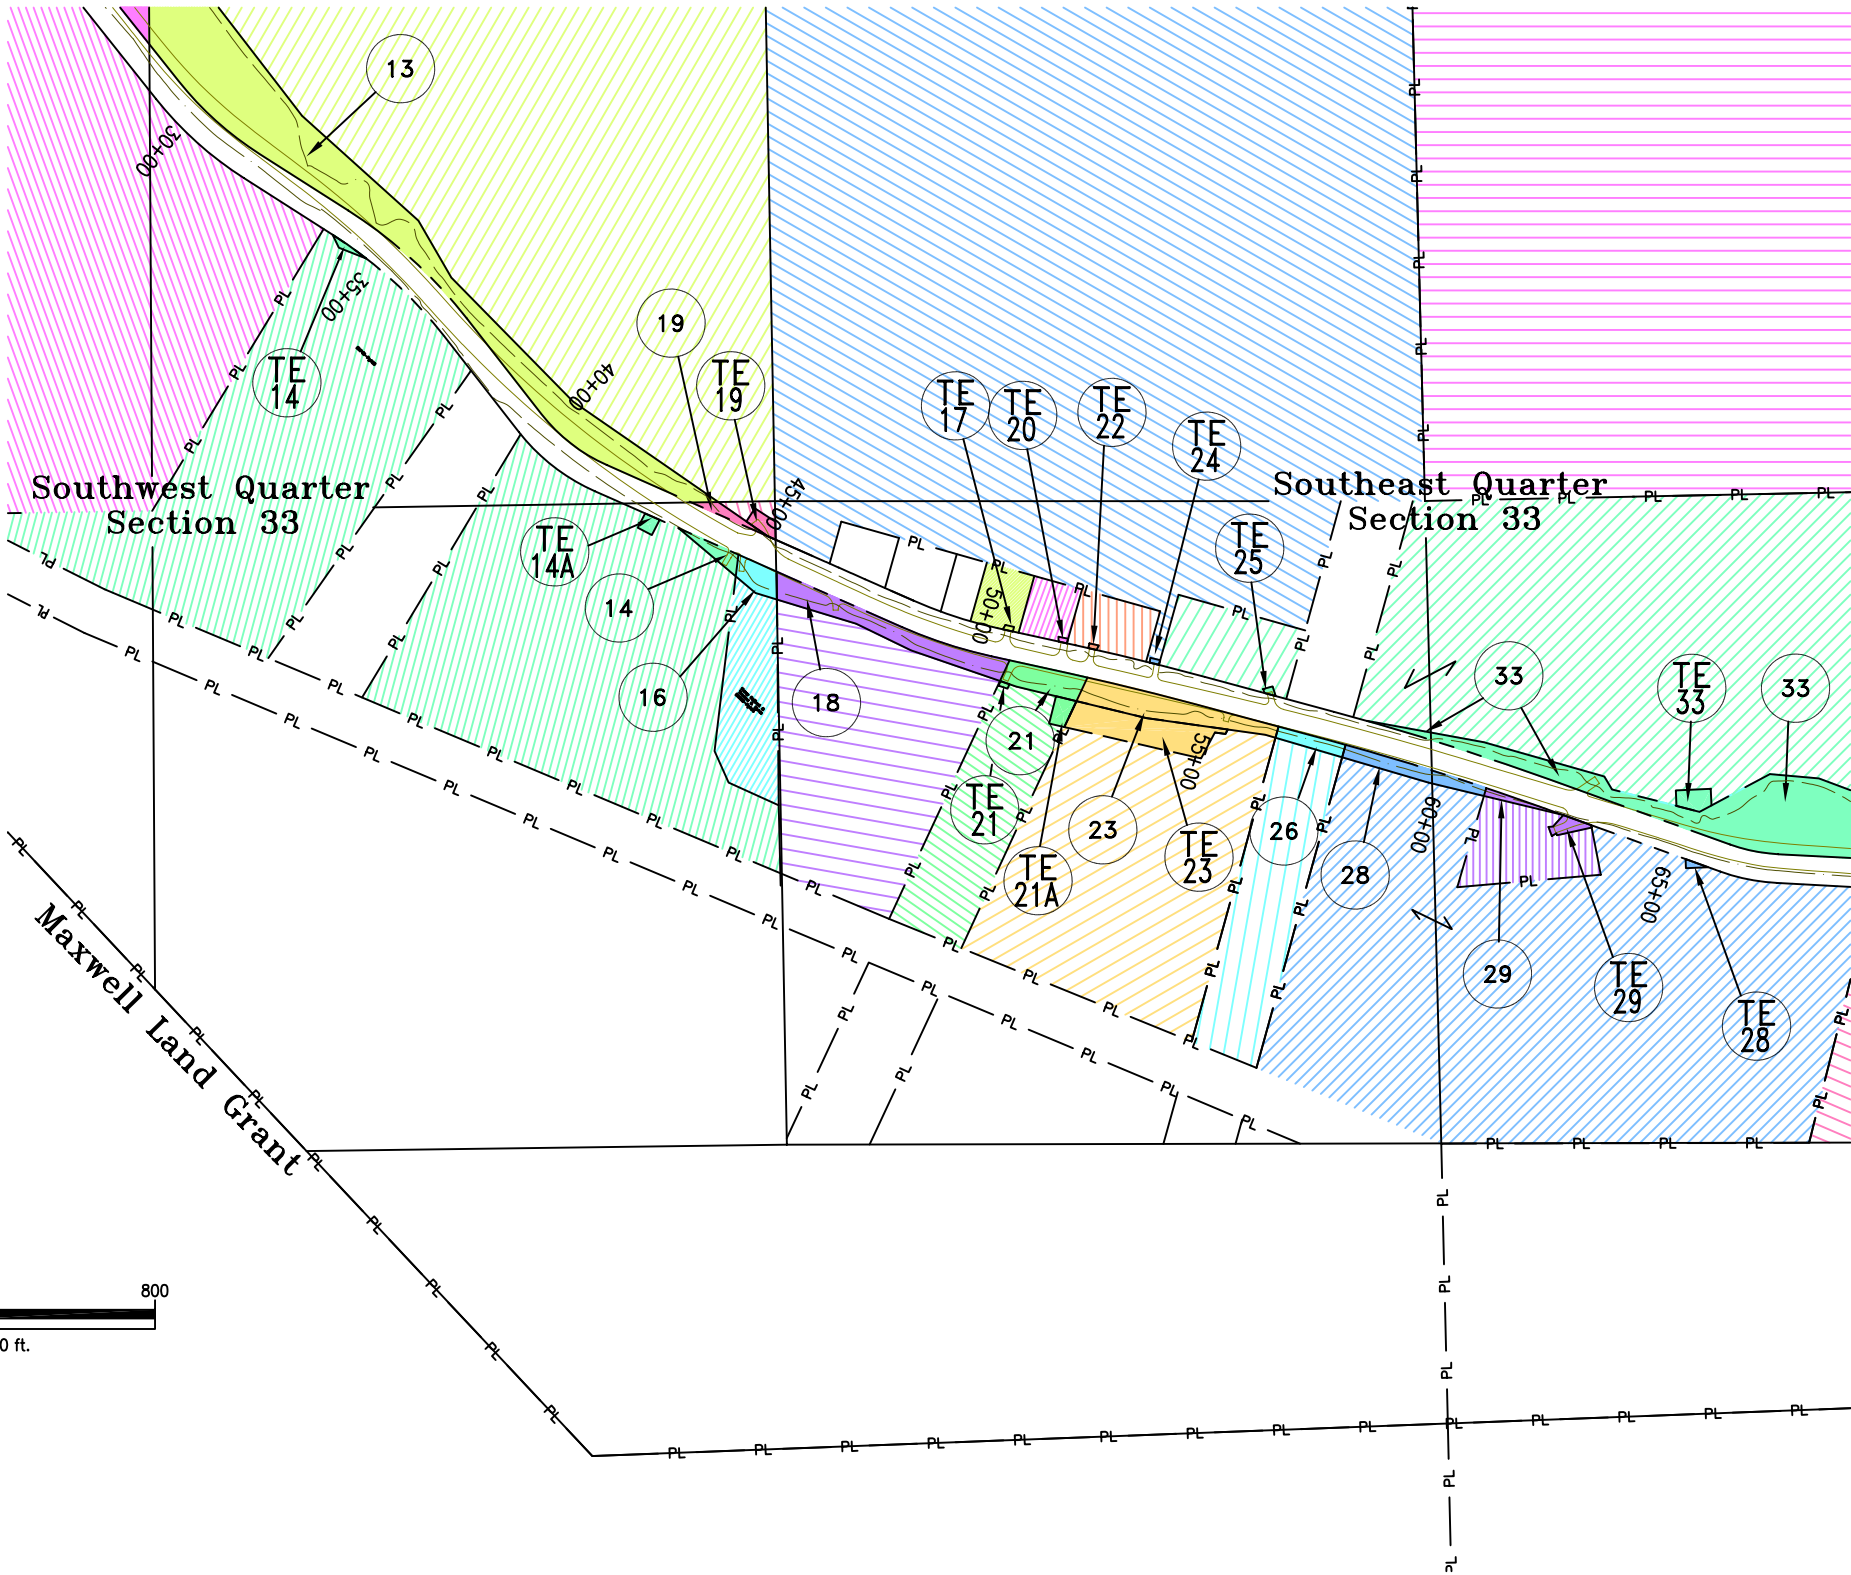



Region: 2
905 Erie Ave. P.O. Box 536
Pueblo, CO. 81002
Phone: (970) 546-5487 FAX: (719)546-5414

Right of Way Plans Unit: Larry R. Lucas

Sheet Revisions

Sheet Revisions

Sheet Revisions

Right of Way Plans

OWNERSHIP MAP

Project Number: STA 012A-034



Project Location: Weston East

Project Location: Highway 12

Project Code:	Last Mod. Date	Subset Sheets	Sheet No.	Total No. of Sheets
12834	01/18/02	3 of 4	22	23

Las Animas County

 Section 32 & 33, Township 33 South, Range 66 West, 6th P.M.

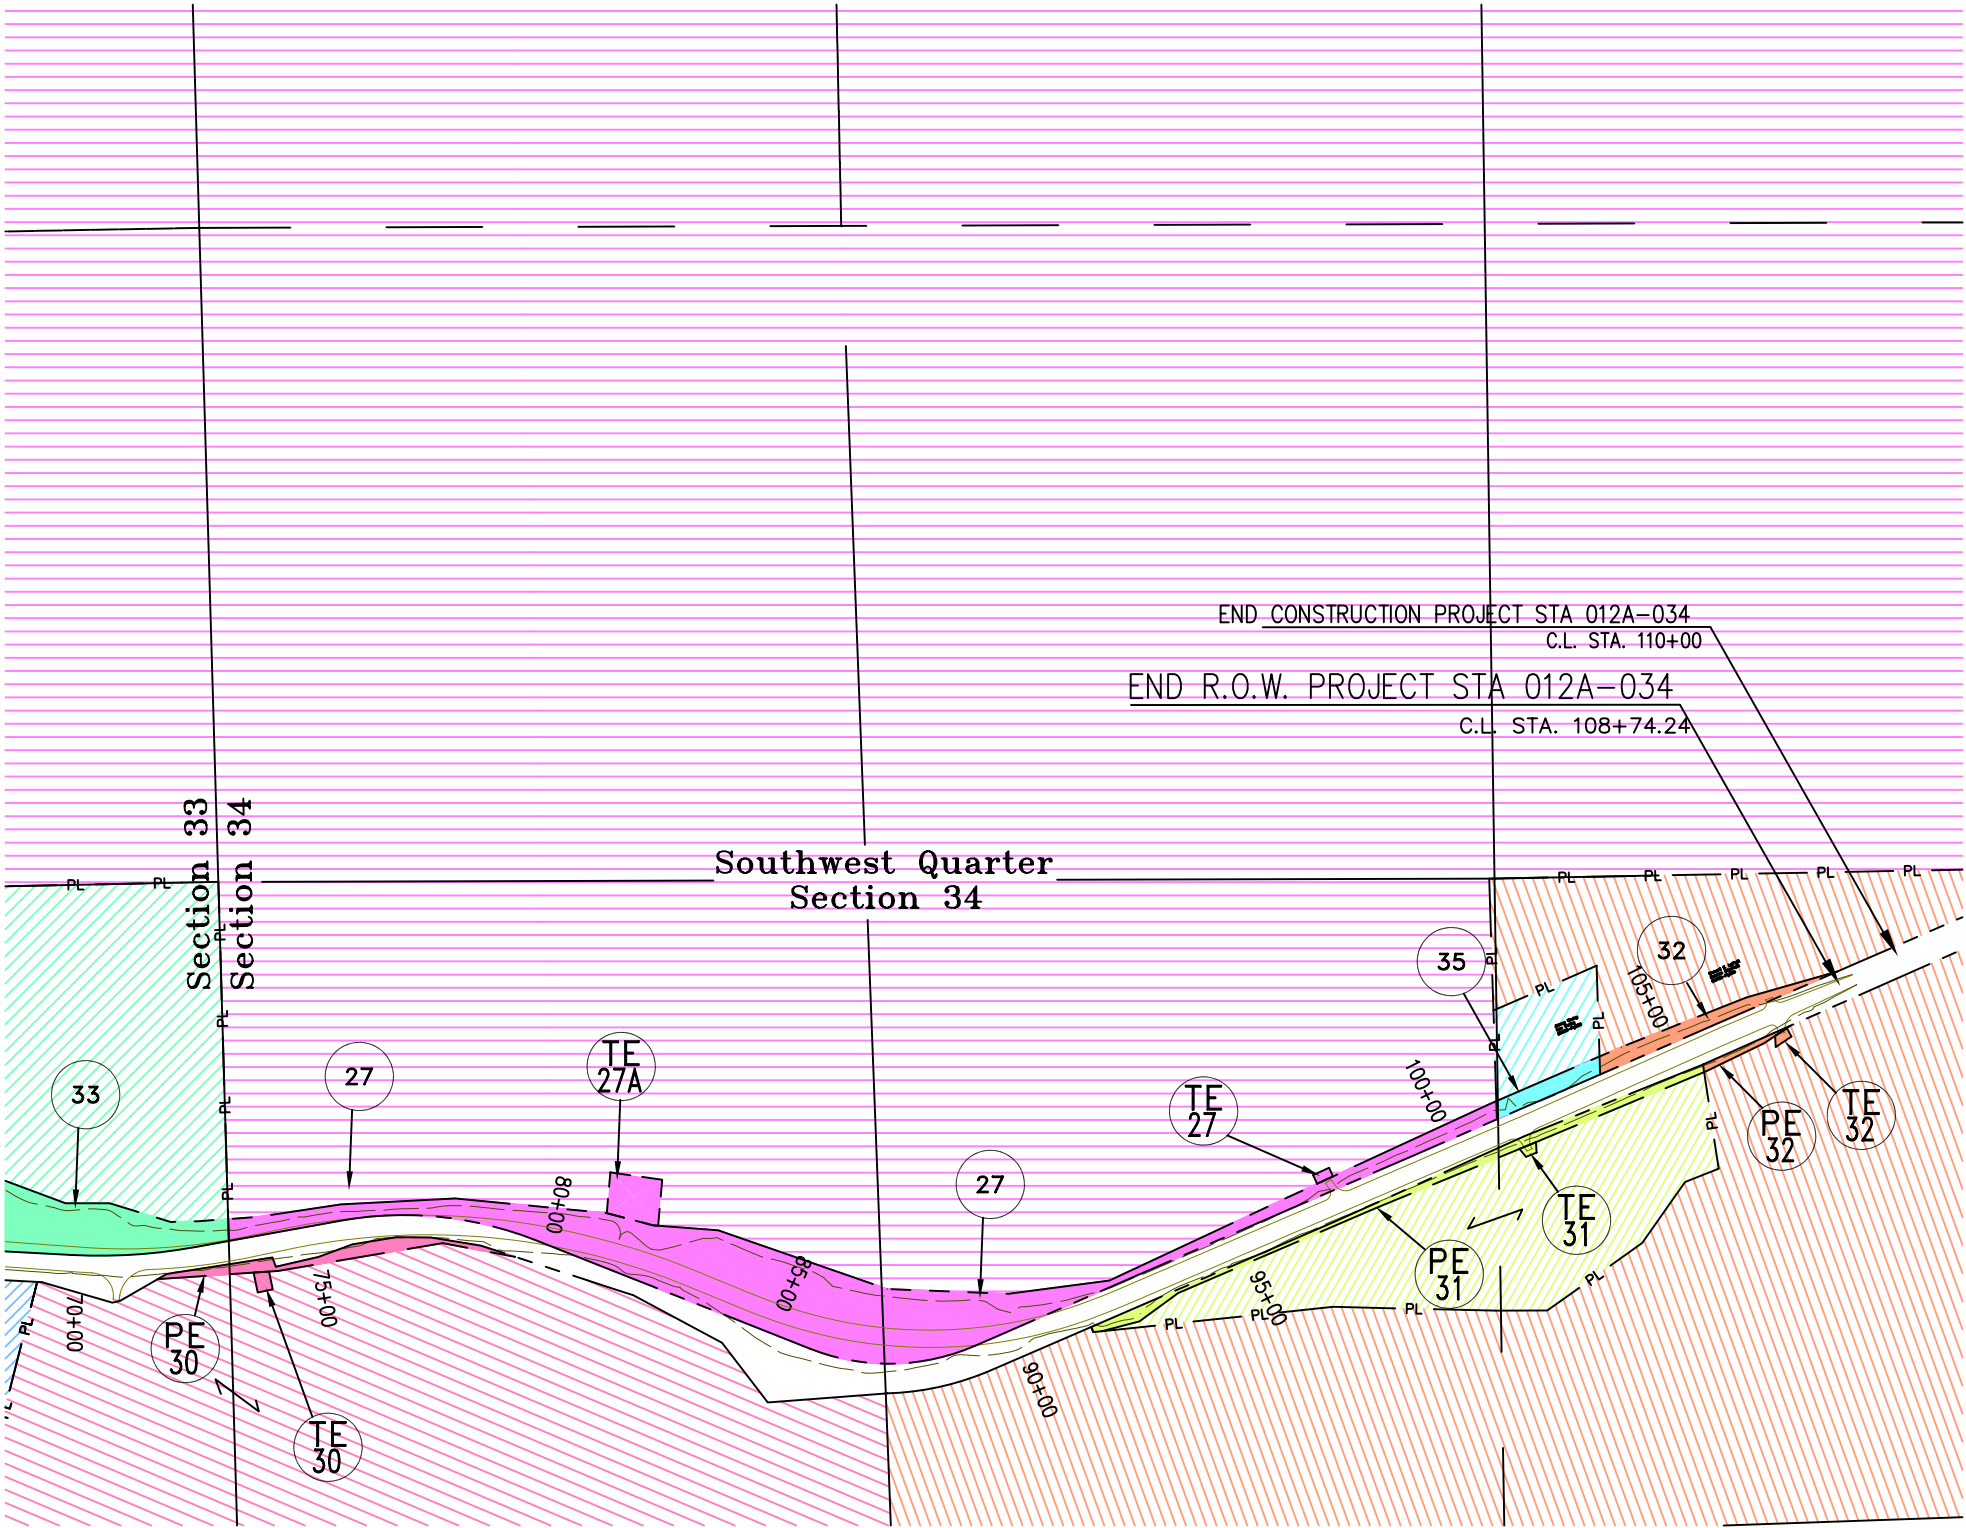

- TE 27** **TE 27A** **27** Richard S. Lopez & Sylvia A. Lopez
19901 Highway 12
Weston CO. 81091 TC# 67801
- TE 28** **28** C. Manuel, Candido M, and Beatrice V. Ortega
1250 S. Raleigh St.
Denver, CO. 80219 TC# 67940
- TE 29** **29** Florence Marie Sandoval & Louise Sandoval
21200 Highway 12
Weston, CO. 81091 TC# 67943
- TE 30** **PE 30** B.F. Hill, dba Hill Ranch & F.R. Hill, dba FE Hill Company
P.O. Box 226
Fairfield, TX TC# 67960
- TE 31** **PE 31** Dustin D. LePlatt, Howard E. LePlatt & Kaye LePlatt
21600 Highway 12
Trinidad, CO. 81082 TC# 67954
- 32** **PE 32** **TE 32** Howard E. LePlatt & Bernice B. LePlatt
21600 Highway 12
Trinidad, CO. 81082 TC# 67945
- TE 33** **33** Pete C. Ortega & C. Manuel Ortega
1250 S. Raleigh St.
Denver, CO. 80219 TC# 67940
- TE 34** Ronald H. Feyad & Delores G. Feyad
19810 Highway 12
Weston, CO 81091
- 35** James & Sue Worley
2001 Santa Fe Trail
Trinidad, CO 81082 TC# 67968



Region: 2
905 Erie Ave. P.O. Box 536
Pueblo, CO. 81002
Phone: (970) 546-5487 FAX: (970)546-5414

Right of Way Plans Unit: Larry R. Lucas

Sheet Revisions

Sheet Revisions

Sheet Revisions

Right of Way Plans

OWNERSHIP MAP

Project Number: STA 012A-034

Project Location: Weston East

Project Location: Highway 12

Project Code:	Last Mod. Date	Subset Sheets	Sheet No.	Total No. of Sheets
12834	01/18/02	4 of 4	22	23

Las Animas County

Section 32 & 33, Township 33 South, Range 66 West, 6th P.M.

