

Oversight / NHS	
FHWA REGION VII OVERSIGHT?	NO YES
NATIONAL HIGHWAY SYSTEM?	NO YES

TABULATION OF LENGTH & DESIGN DATA

STATION	ROADWAY METERS		MAJOR STRUCTURE
	INTERSTATE 25 RAMP	MEADOWS/FOUNDERS PARKWAYS	
MEADOWS/FOUNDERS PARKWAY 7+450.00 BEGIN PROJECT		287.272	70.760
7+737.272 STR. NO. G-17-AM 7+808.032		229.628	
8+037.66 END PROJECT			
INTERSTATE RAMP			
SOUTHEAST DIAMOND RAMP 1+000 TO 1+560.05	560.05		
NORTHEAST DIAMOND RAMP 2+007.78 TO 2+815.17	807.39		
NORTHWEST DIAMOND RAMP 2+797.36 TO 3+842.78	1045.42		
SOUTHWEST DIAMOND RAMP 4+002.24 TO 4+825.00	822.76		
SOUTHEAST LOOP RAMP 5+021.10 TO 5+760.00	738.90		
NORTHWEST LOOP RAMP 6+021.10 TO 6+755.00	733.90		
(SEE ALIGNMENTS SHEETS FOR TIES TO I-25 AND PREVIOUS PROJECTS)			
TOTAL	4708.42	516.900	70.760
SUMMARY OF PROJECT LENGTH			
ROADWAY (NET LENGTH)	516.900	0.5169	
MAJOR STRUCTURE	70.760	0.7076	
PROJECT GROSS LENGTH	587.660	0.5877	
DESIGN DATA			MEADOWS/ FOUNDERS
URBAN RADIIUS OF CURVE		216 m	
MAXIMUM GRADE		6%	
URBAN S.S.D. HORIZONTAL		93	
URBAN S.S.D. VERTICAL		95 m	
MAXIMUM DESIGN SPEED		60 km/h	
2018 DESIGN TRAFFIC		DHV = 4330 ADT = 39 400	
DAY TRUCKS		11%	

Computer File Information	
Creation Date: 07/01/96	Initials: SWD
Last Modification Date: 01/14/98	Initials: JPB
Full Path: C:\PROJECTS\11416\PLANS	
Drawing File Name: TITLESHT.DWG	
Acad Ver: R13	Scale: VARIES Units: METRIC

Index of Revisions	

Colorado Department of Transportation



18500 East Colfax Avenue
Aurora, Colorado 80011
Phone: 303-757-9371 FAX: 303-757-9746

Region 1

R.J.G.


As Constructed	
No Revisions:	
Revised:	
Void:	

Contract Information	
Contractor	
Resident Engineer	
Project Engineer	
PROJECT STARTED	ACCEPTED
Comments:	
Project No./Code	STU 0252-294
	11416
Sheet Number	1

DEPARTMENT OF TRANSPORTATION
STATE OF COLORADO
AWARD SET

HIGHWAY CONSTRUCTION BID PLANS OF PROPOSED
FEDERAL AID PROJECT NO. STU 0252-294

STATE HIGHWAY NO. 25
DOUGLAS COUNTY
PROJECT CODE NO. 11416

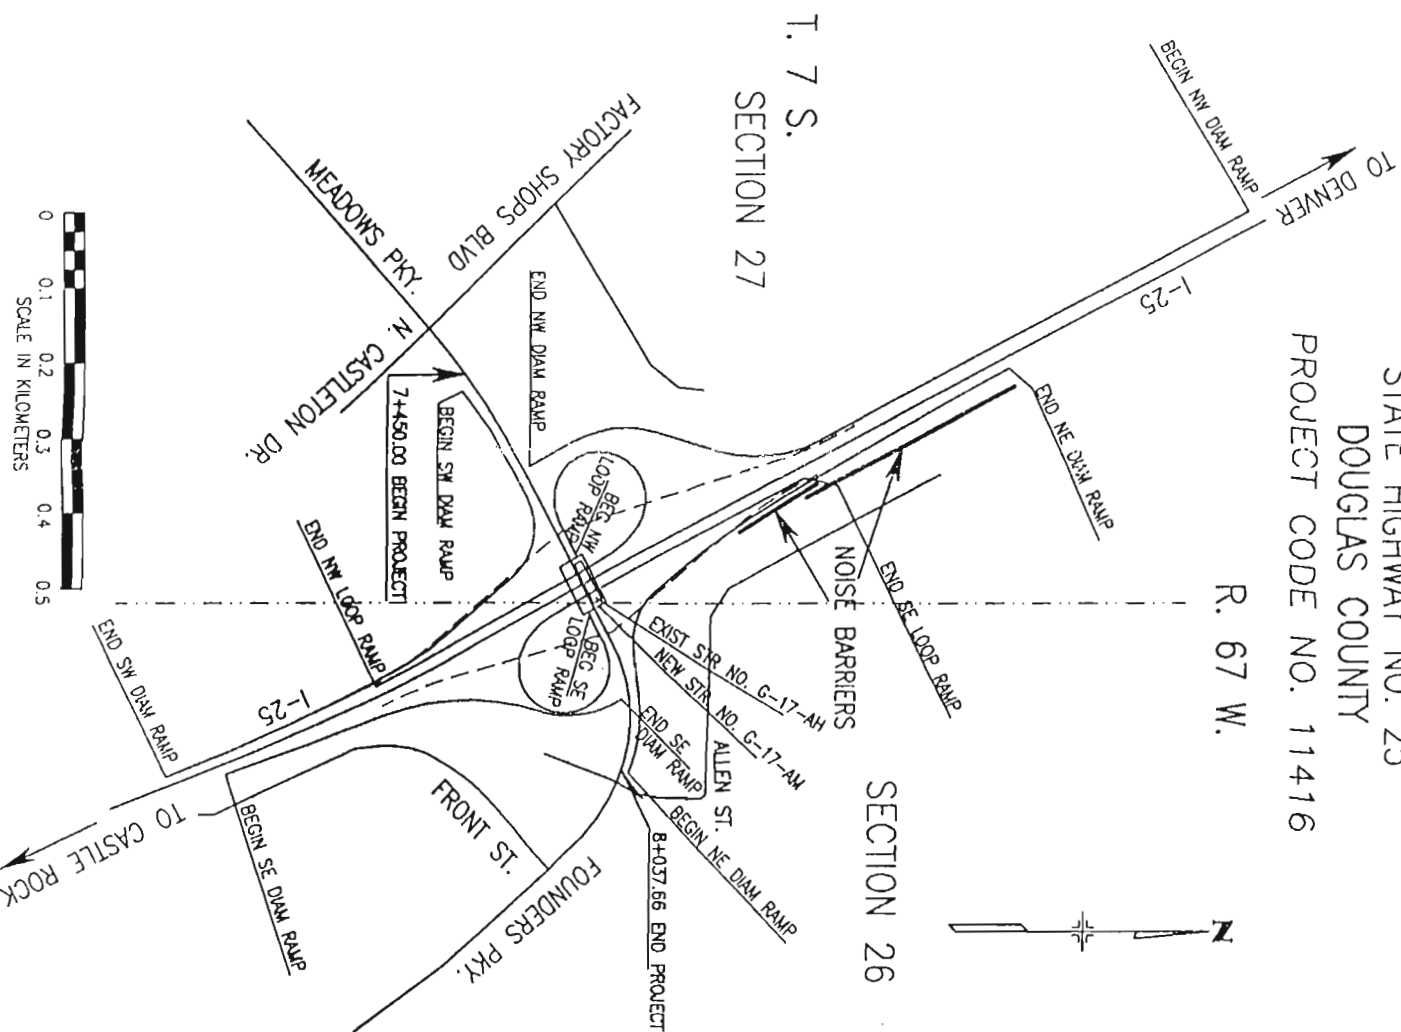

SHEET NO. INDEX OF SHEETS

1	TITLE SHEET
2	STANDARD PLANS LIST
3-7	TYPICAL SECTIONS
8-9	GENERAL NOTES
10-16	SUMMARY OF APPROXIMATE QUANTITIES
17	SUMMARY OF EARTHWORK QUANTITIES
18	SURFACING PLAN
19	FENCE TABULATION
20	GUARDRAIL TABULATION
21	MISCELLANEOUS GUARDRAIL DETAILS
22-23	SLOTTED RAIL TERMINAL (SRT-350)
24	MODIFIED THREE-BEAM GUARDRAIL TYPE 6 DETAIL
25-26	REVISED CURB SHAPES
27	DELINATOR TABULATION
28-33	CONCRETE PAVEMENT JOINT PLANS
34	MISCELLANEOUS DETAILS
35	TABULATION OF MISC. REMOVALS, RESETS & ADJUSTMENTS
36-38	TABULATION OF CONCRETE PAVEMENTS & CURB/GUTTER
39-73	STR. NO. G-17-AM
74-88	STR. NO. G-17-AM RETAINING WALLS
89-93	RETAINING WALLS
94-100	SOUND BARRIER
101-139	PLAN & PROFILE SHEETS
140-141	ALIGNMENT SHEETS
142	SUPERELEVATION TABULATION
143-146	PAVEMENT WIDTHS
147-189	HYDRAULICS SHEETS
190-199	EROSION CONTROL SHEETS
200-211	ROADWAY DETAILS - GEOMETRY & GRADING
212	TEMPORARY OFF-RAMP DETAILS
213	PHASING SECTIONS AND BARRIER LAYOUTS
214-226	CONSTRUCTION PHASING SHEETS
227-228	EXISTING AND PROPOSED TEMPORARY SIGNAL PLANS
229-231	PROPOSED SIGNAL PLANS
232-234	INTERCONNECT CONDUIT
235-270	SIGNING AND STRIPING SHEETS
271-277	LIGHTING PLANS
278-284	CONTROL SURVEY DIAGRAMS
285	SURVEY TABULATION SHEET
286-287	FINAL GRADING CONTOURS FOR SITE DESIGNS

NEW AND REVISED STANDARDS

M-107-1	TEMPORARY EROSION CONTROL	(4 SHEETS)	03/24/97
M-412-1	CONCRETE PAVEMENT JOINTS	(3 SHEETS)	08/21/97
M-629-1	SURVEY MONUMENTS	(2 SHEETS)	08/28/97

