

CITY OF THORNTON

Colorado Blvd, Welby Rd to 103rd Ave

11473

FED. ROAD REGION	DIVISION	PROJECT NUMBER	SHEET NUMBER
VIII	COLO.	STU C120-005	1
REVISIONS			
R-1	Revised Parcel PE131, PE132 &	GP	
08/25/98	132; Added Parcel 131; Revised		
	R/W Markers To Be Set; and		
	Revised End Project Station		

RIGHT OF WAY

RIGHT OF WAY PLAN OF PROPOSED FEDERAL AID PROJECT NO. STU C120-005 CITY OF THORNTON PROJECT NO. 96-85 ADAMS COUNTY RIGHT OF WAY

'V File'

CONVENTIONAL SIGNS


County Line	-----
Township or Range Line	-----
Land Lines	Section Line 1/4 Section Line 1/16 Section Line
Property or Tract Line	-----
City Limits	-----
Railroad	+++++
Existing Road	=====
New Road	=====
Control of Access	-----
Access denied by Deed	-----
Proposed Right of Way Line	-----
Protected by Freeway(Virgin Location)	-----
Existing Right of Way Line	-----
Permanenet Easement	-----
Slope Easement	-----
Temporary Easement	-----
Top of Cuts	-----
Toe of Fills	-----
Barbed Wire Fence	-----
Chain Link Fence	-----
Woven Wire-Combination Fence	-----
Snow Fence	-----
Wood Fence	-----
Deer Fence	-----
Trees	Deciduous Coniferous
Tel. & Teleg. Lines	-----
Electric Lines	-----
Elec. Trans. Tower	-----
Buried Tel. Cable	-----
Buried Electric Cable	-----
Gas Main	-----
Oil Main	-----
Water Main	-----
Sanitary Sewers	-----
Storm Sewers	-----
Road Approaches	-----
Section Corner	Center of Section
Culverts & Drains	-----
Proposed Existing	-----
Proposed Existing (to be dashed)	-----
Bridges	-----

SCALES OF ORIGINAL DRAWINGS

PLAN SHEETS 1" = 20'
R.O.W. LENGTH OF PROJECT = 5,059.33'


INDEX OF SHEETS

- 1 TITLE SHEET
- 2 TABULATION OF PROPERTIES
- 3 SURVEY CONTROL DIAGRAM
- 4 SURVEY CONTROL MONUMENTS
- 5-13 ROW PLAN SHEETS
- 14-15 OWNERSHIP MAP

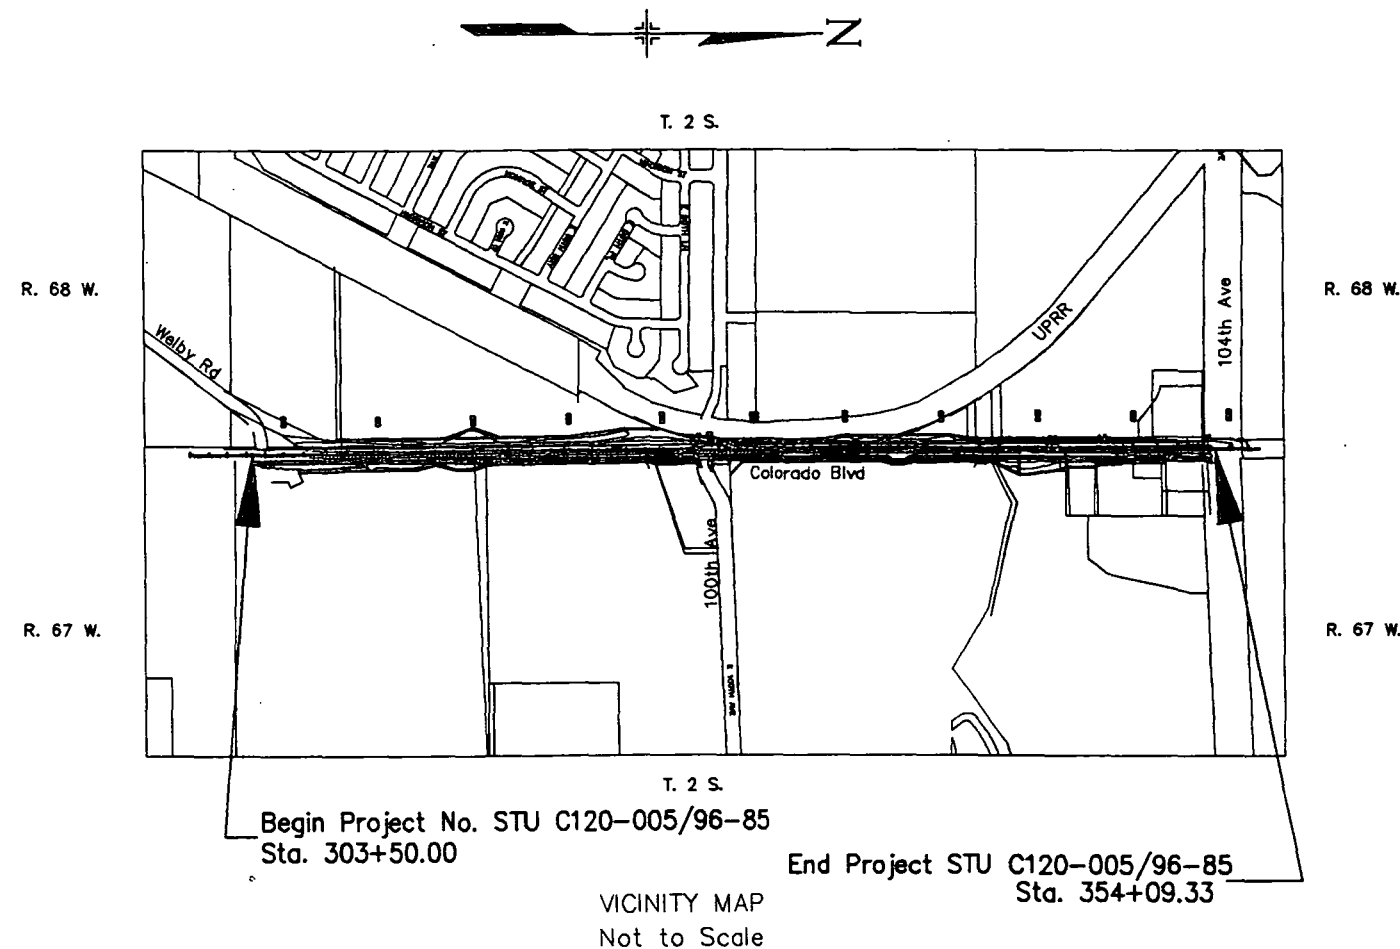

DEPARTMENT OF TRANSPORTATION FEDERAL HIGHWAY ADMINISTRATION	
AUTHORIZED	DATE
DIVISION ADMINISTRATOR	

FRASIER & NALRE
ENGINEERING COMPANY
1015 E. HARVARD, SUITE 200
DENVER, COLORADO 80202
(303) 733-9101

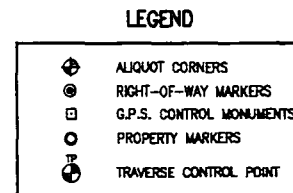

GRAPHIC SCALE

600 0 600 1200 1800

1"=600'

1. FOUND AND SET MONUMENTS MEET CDC TYPE 'A' SURVEY MINIMUM STANDARDS OF 30mm+/- WITH RESPECT TO CONTROLLING MONUMENTS AT A 95% CERTAINTY LEVEL.
2. NOTICE ACCORDING TO COLORADO LAW YOU MUST COMMENCE ANY LEGAL ACTION BASED UPON ANY DEFECT FOUND IN THIS SURVEY WITHIN THREE YEARS AFTER YOU FIND SUCH DEFECT, IN NO EVENT MAY ANY ACTION BASED UPON ANY DEFECT IN THIS SURVEY BE COMMENCED MORE THAN TEN YEARS FROM THE DATE OF THE CERTIFICATION SHOWN HEREON.
3. ALL COORDINATES LISTED ARE IN FEET & ARE MODIFIED COLORADO STATE PLANE NORTH ZONE COORDINATES.

THE FOLLOWING TWO BENCH MARKS WERE USED AS THE VERTICAL DATUM BASIS.
B.M. PID-KK1402 DESIGNATION:J 411 NAVD 88 ELEV=5229.47R(1583.948m) STATION
MARK IS A B.L.M. DISK ON 1/2" STEEL ROD SET IN A RANGE BOX; THE MARK IS
STAMPED "J 411 1984".

B.M. PID-KK1401 DESIGNATION:J 411 NAVD 88 ELEV=5098.47R(1554.017m) STATION
MARK IS A B.L.M. DISK ON 1/2" STEEL ROD SET IN A RANGE BOX; THE MARK IS
STAMPED "J 411 1984".

VERTICAL TOLERANCE MEETS THE ACCURACY TOLERANCE OF
 $4\text{mm} \pm \sqrt{\text{DISTANCE TRAVELED (IN KILOMETERS)}}$

Grid bearing as established by G.P.S. of South $33^{\circ}16'37''$ West
along the line between CDOT control point #25 and CDOT control
point #108.

DEPOSITED THIS _____ DAY OF _____, 19____, AT _____M
IN BOOK _____ OF THE COUNTY SURVEYOR'S LAND SURVEY PLATS/
RIGHT-OF-WAY SURVEYS AT PAGE _____, RECEPTION NUMBER _____
THIS LAND SURVEY PLAT COMPLIES WITH SECTION 38-51-102, COLORADO
REVISED STATUTES.

Computer File Information			
Creation Date:	12/29/97	Initials:	JRY
Last Modification Date:	04/14/98	Initials:	GP
Full Path:	j:\25814\rdwy		
Drawing File Name:	srcvctrl.dwg		
Acad Ver.	13	Scale:	N/A
		Units:	English

	Index of Revisions		
(R-)			
(R-)			
(R-)			
(R-)			
(R-)			




As Constructed	SURVEY CONTROL DIAGRAM			Project No./Code
No Revisions:				STU C120-005
Revised:	Designer: N/A	Structure Numbers		11473
	Detailer: JRY/EDC			
Void:	Sheet Subset: Survey	Subset Sheets	1 of 2	Sheet Number 3

SURVEY CONTROL MONUMENTS

SEC. 13 & 18 T. 2 S., R. 67 W., 6th P.M.
ADAMS COUNTY, COLORADO

 PREPARED BY:



CONTROL POINTS (ENGLISH)

POINT #	NORTHING	EASTING	ELEVATION	DESCRIPTION OF MONUMENT SET
2	1198841.4910	3156982.1456	5220.46	STATION MARK IS A CDOT ALUMINUM CAP, SET FLUSH W/GROUND THE MARK IS STAMPED "COLO DEPT OF TRANSPORTATION".
3	1200925.7250	3157052.4460	5202.51	STATION MARK IS A CDOT ALUMINUM CAP, SET FLUSH W/GROUND THE MARK IS STAMPED "COLO DEPT OF TRANSPORTATION".
4	1193543.8230	3157027.3110	5114.07	STATION MARK IS A CDOT ALUMINUM CAP, SET FLUSH W/GROUND THE MARK IS STAMPED "COLO DEPT OF TRANSPORTATION".
10	1195545.1220	3157019.8160	5127.33	STATION MARK IS A CDOT ALUMINUM CAP, SET FLUSH W/GROUND THE MARK IS STAMPED "COLO DEPT OF TRANSPORTATION".
102	1196244.8490	3156858.4250	5152.88	STATION MARK IS A CDOT ALUMINUM CAP, SET FLUSH W/GROUND SECONDARY CONTROL
103	1197442.5870	3156935.7680	5192.26	STATION MARK IS A CDOT ALUMINUM CAP, SET FLUSH W/GROUND THE MARK IS STAMPED "COLO DEPT OF TRANSPORTATION".
106	1200614.4340	3157209.8320	5192.47	STATION MARK IS A CDOT ALUMINUM CAP, SET FLUSH W/GROUND THE MARK IS STAMPED "COLO DEPT OF TRANSPORTATION".

RIGHT-OF-WAY MARKERS FOUND

POINT #	NORTHING	EASTING	DESCRIPTION OF SECTION CORNER FOUND
1001	1200903.5170	3157035.2250	CITY OF THORNTON RIGHT-OF-WAY MARKER; STATION IS A 2" ALUMINUM CAP.
1002	1201303.0970	3157033.3800	CITY OF THORNTON RIGHT-OF-WAY MARKER; STATION IS A 2" ALUMINUM CAP.
1012	1198747.5930	3157140.3790	COLORADO DEPT. OF TRANSPORTATION RIGHT-OF-WAY MONUMENT; STATION IS A 3-1/4" ALUMINUM CAP STAMPED NO. 137.
1013	1196329.3680	3157157.2180	COLORADO DEPT. OF TRANSPORTATION RIGHT-OF-WAY MONUMENT; STATION IS A 3-1/4" ALUMINUM CAP STAMPED NO. 136.
1014	1196329.4110	3157167.6740	COLORADO DEPT. OF TRANSPORTATION RIGHT-OF-WAY MONUMENT; STATION IS A 3-1/4" ALUMINUM CAP STAMPED NO. 135.
1015	1196125.4800	3157169.1320	COLORADO DEPT. OF TRANSPORTATION RIGHT-OF-WAY MONUMENT; STATION IS A 3-1/4" ALUMINUM CAP STAMPED NO. 134.
1016	1196125.8540	3157184.9510	COLORADO DEPT. OF TRANSPORTATION RIGHT-OF-WAY MONUMENT; STATION IS A 3-1/4" ALUMINUM CAP STAMPED NO. 133.
1020	1195659.1700	3157115.7800	COLORADO DEPT. OF TRANSPORTATION RIGHT-OF-WAY MONUMENT; STATION IS A 3-1/4" ALUMINUM CAP STAMPED NO. 130.
1021	1195450.2910	3157109.6030	COLORADO DEPT. OF TRANSPORTATION RIGHT-OF-WAY MONUMENT; STATION IS A 3-1/4" ALUMINUM CAP STAMPED CL MON 155+95.87 PC CURVE NO. 157.
1022	1194975.4950	3157078.1800	COLORADO DEPT. OF TRANSPORTATION RIGHT-OF-WAY MONUMENT; STATION IS A 3-1/4" ALUMINUM CAP STAMPED CL MON 151+19.93 PT CURVE NO. 149.

PROPERTY CORNER MARKERS FOUND

POINT #	NORTHING	EASTING	DESCRIPTION OF SECTION CORNER FOUND
1004	1200214.2570	3157058.5550	PN & CAP STAMPED "LIND ENGINEERING PLS NO.12730".
1005	1198805.7050	3157144.9280	PN & CAP STAMPED "DABA RLS".
1007	1198604.7980	3157148.0760	NO. 5 REBAR NO CAP.
1008	1198629.7060	3157170.9410	PN & CAP STAMPED "RLS 24988".
1009	1198589.5710	3157032.4000	PN & CAP STAMPED "RLS 13213".
1018	1195468.2050	3157173.8790	PN & CAP STAMPED "CUBIC SURVEYING CO. LS 16612".
1019	1195375.2900	3157175.0410	PN & CAP STAMPED "CUBIC SURVEYING CO. LS 16612".

ALIQUOT CORNERS FOUND

POINT #	NORTHING	EASTING	DESCRIPTION OF SECTION CORNER FOUND
7	1201402.7160	3157082.8980	NW COR SEC 18, 3-1/4" ALUMINUM CAP ON TYPE 3A C.D.O.T. MONUMENT, IN ALUMINUM RANGE BOX; STATION MARK IS STAMPED PLS #23516.
8	1196123.0990	3157112.2500	SW COR SEC 18, 3-1/4" ALUMINUM CAP ON TYPE 3A C.D.O.T. MONUMENT, IN ALUMINUM RANGE BOX; STATION MARK IS STAMPED PLS #28668.
9	1198764.1000	3157095.1000	W 1/4 COR SEC 18, 3-1/4" ALUMINUM CAP IN RANGE BOX STATION MARK IS STAMPED PLS #18400.

CONTROLLING MONUMENTS - VERTICAL

POINT #	ELEVATIONS METERS	FEET	DESCRIPTION OF MONUMENT FOUND
KK1401	1554.017	5098.47	DESIGNATION: J 411, PID: KK1401, NAVD 88, STATION MARK IS A B.M. DISK SET ON A 1/2" ROD SET IN A RANGE BOX; THE MARK IS STAMPED "J 411 1984".
KK1402	1593.946	5229.47	DESIGNATION: X 411, PID: KK1402, NAVD 88, STATION MARK IS A B.M. DISK SET ON A 1/2" ROD IN A RANGE BOX; THE MARK IS STAMPED "X 411 1984".

CONTROLLING MONUMENTS - HORIZONTAL

POINT #	COORDINATES NORTHING	EASTING	DESCRIPTION OF MONUMENT FOUND
25	1201489.3320	3160866.5530	DESIGNATION: RIVERDALE, PID: AB3301, HORZ. DATUM: NAD 83 (1992), VERT. DATUM: NAVD 88; THE STATION MARK IS STAMPED "RIVERDALE 1995" SET IN 24" ROUND POST FLUSH W/GROUND LATITUDE N 39°53'06.133680" LONGITUDE W 104°55'36.31405"
108	1184797.0530	3149811.3320	DESIGNATION: ROTELLA, PID: AB3303, HORZ. DATUM: NAD 83 (1992), VERT. DATUM: NAVD 88; THE STATION MARK IS STAMPED "ROTELLA 1995" SET IN 24" ROUND POST FLUSH W/GROUND LATITUDE N 39°50'21.84997" LONGITUDE W 104°57'58.13992"

TABULATION OF R/W MARKERS TO BE SET

POINT #	COORDINATES NORTHING	EASTING
5001	1198848.3506	3157045.6746
5006	1198811.1480	3157051.4168
5007	1198715.5494	3157051.8493
5008	1198709.3110	3157045.5366
5011	1199599.9260	3157047.2082
5021	1200084.4487	3157044.6230
5024	1200214.1104	3157041.5375
5025	1200179.1530	3157044.1177
5030	1198826.0106	3157039.9830
5032	1198826.0375	3157045.7784

Refer to Field Pak for Parcel and Easement Point
Coordinate Listings

SURVEYOR CERTIFICATE

G.P.S. DATA WAS COLLECTED AND PROCESSED
UNDER MY SUPERVISION AND CHECKING.

SURVEYOR CERTIFICATE

CONTROL SURVEY AND MONUMENTATION WAS DONE
UNDER MY SUPERVISION AND CHECKING.

ROBERT A. CHICHESTER P.L.S. #7735

JAMES H. LUKE P.L.S. #14115

Computer File Information				Index of Revisions			 CITY OF THORNTON	 The HNTB Companies 1800 Broadway Suite 1300 Denver, Colorado 80202 (303) 863-1469	As Constructed		SURVEY CONTROL MONUMENTS			Project No./Code	
Creation Date: 12/29/97 Initials: JRY		R-1	08/25/98	Revised R/W Markers	GP	No Revisions:			STU C120-005						
Last Modification Date: 08/25/98 Initials: GP		R-		To Be Set		Revised:			Designer: N/A	Structure	11473				
Full Path: j:\25814\rdwy		R-				Void:			Detailer: JRY/EDC	Numbers					
Drawing File Name: srvcntrl.dwg		R-							Sheet Subset: Survey	Subset Sheets	2 of 2	Sheet Number	4		
Acad Ver. 13 Scale: N/A Units: English		R-													



CITY OF
THORNTON



1600 Broadway
Suite 1300
Denver, Colorado
80202
(303) 683-1469

PARCEL
NO.

OWNERSHIP

SE
181

Duried Jallad, et al

PE
131
Rev

Terwilliger Properties LLC

T. 2 S., R. 68 W. 6th P.M.

Begin Project No. STU C120-005
Sta 303+50.00

SE1/4, Sec 13

Waboy Rd

N00°25'56.38"W
728.2862'

S89°43'49.42"W
6.0871'

Existing ROW (1998)

S05°43'49.65"W
83.0534'

P.O.B. PE131Rev

PE
131
Rev

(2009)

303

304

305

306

307

308

N00°25'56.38"W

Colorado Blvd

S04°25'21.58"E
368.5500'

Existing ROW (1998)

N66°20'57.42"E
9.2013'

P.O.B. SE181

N02°06'24.77"W
273.7635'

SE
181

SW1/4, Sec 18

T. 2 S., R. 67 W. 6th P.M.

20 0 20 40
ORIGINAL SCALE IN FEET


N

Computer File Information

Creation Date: 01/14/98 Initials: KRK
Last Modification Date: 08/25/98 Initials: GP
Full Path: j:\25814\rdwy
Drawing File Name: row-s01.dwg
Acad Ver. 13 Scale: 1"=20' Units: English

Index of Revisions

(R-1)	08/25/98	Revised Parcel PE131	GP
(R-2)			
(R-3)			
(R-4)			
(R-5)			

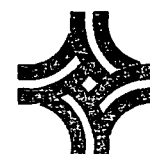

CITY OF
THORNTON

HNTB

The HNTB Companies

1800 Broadway
Suite 1300
Denver, Colorado
80202
(303) 683-1489

As Constructed

No Revisions:

Revised:

Void:

ROW PLAN SHEET

STA 303+50 TO STA 308+00

Designer: G. Prusik
Detailer: G. Prusik
Sheet Subset: ROW

Structure
Numbers

Subset Sheets 1 of 9

Project No./Code

STU C120-005

11473

Sheet Number 5

PARCEL NO. OWNERSHIP


PE 131 Rev Terwilliger Properties LLC

SE 131 Terwilliger Properties LLC

SE 181 Duried Jallad, et al

T. 2 S., R. 68 W. 6th P.M.

SE1/4, Sec 13

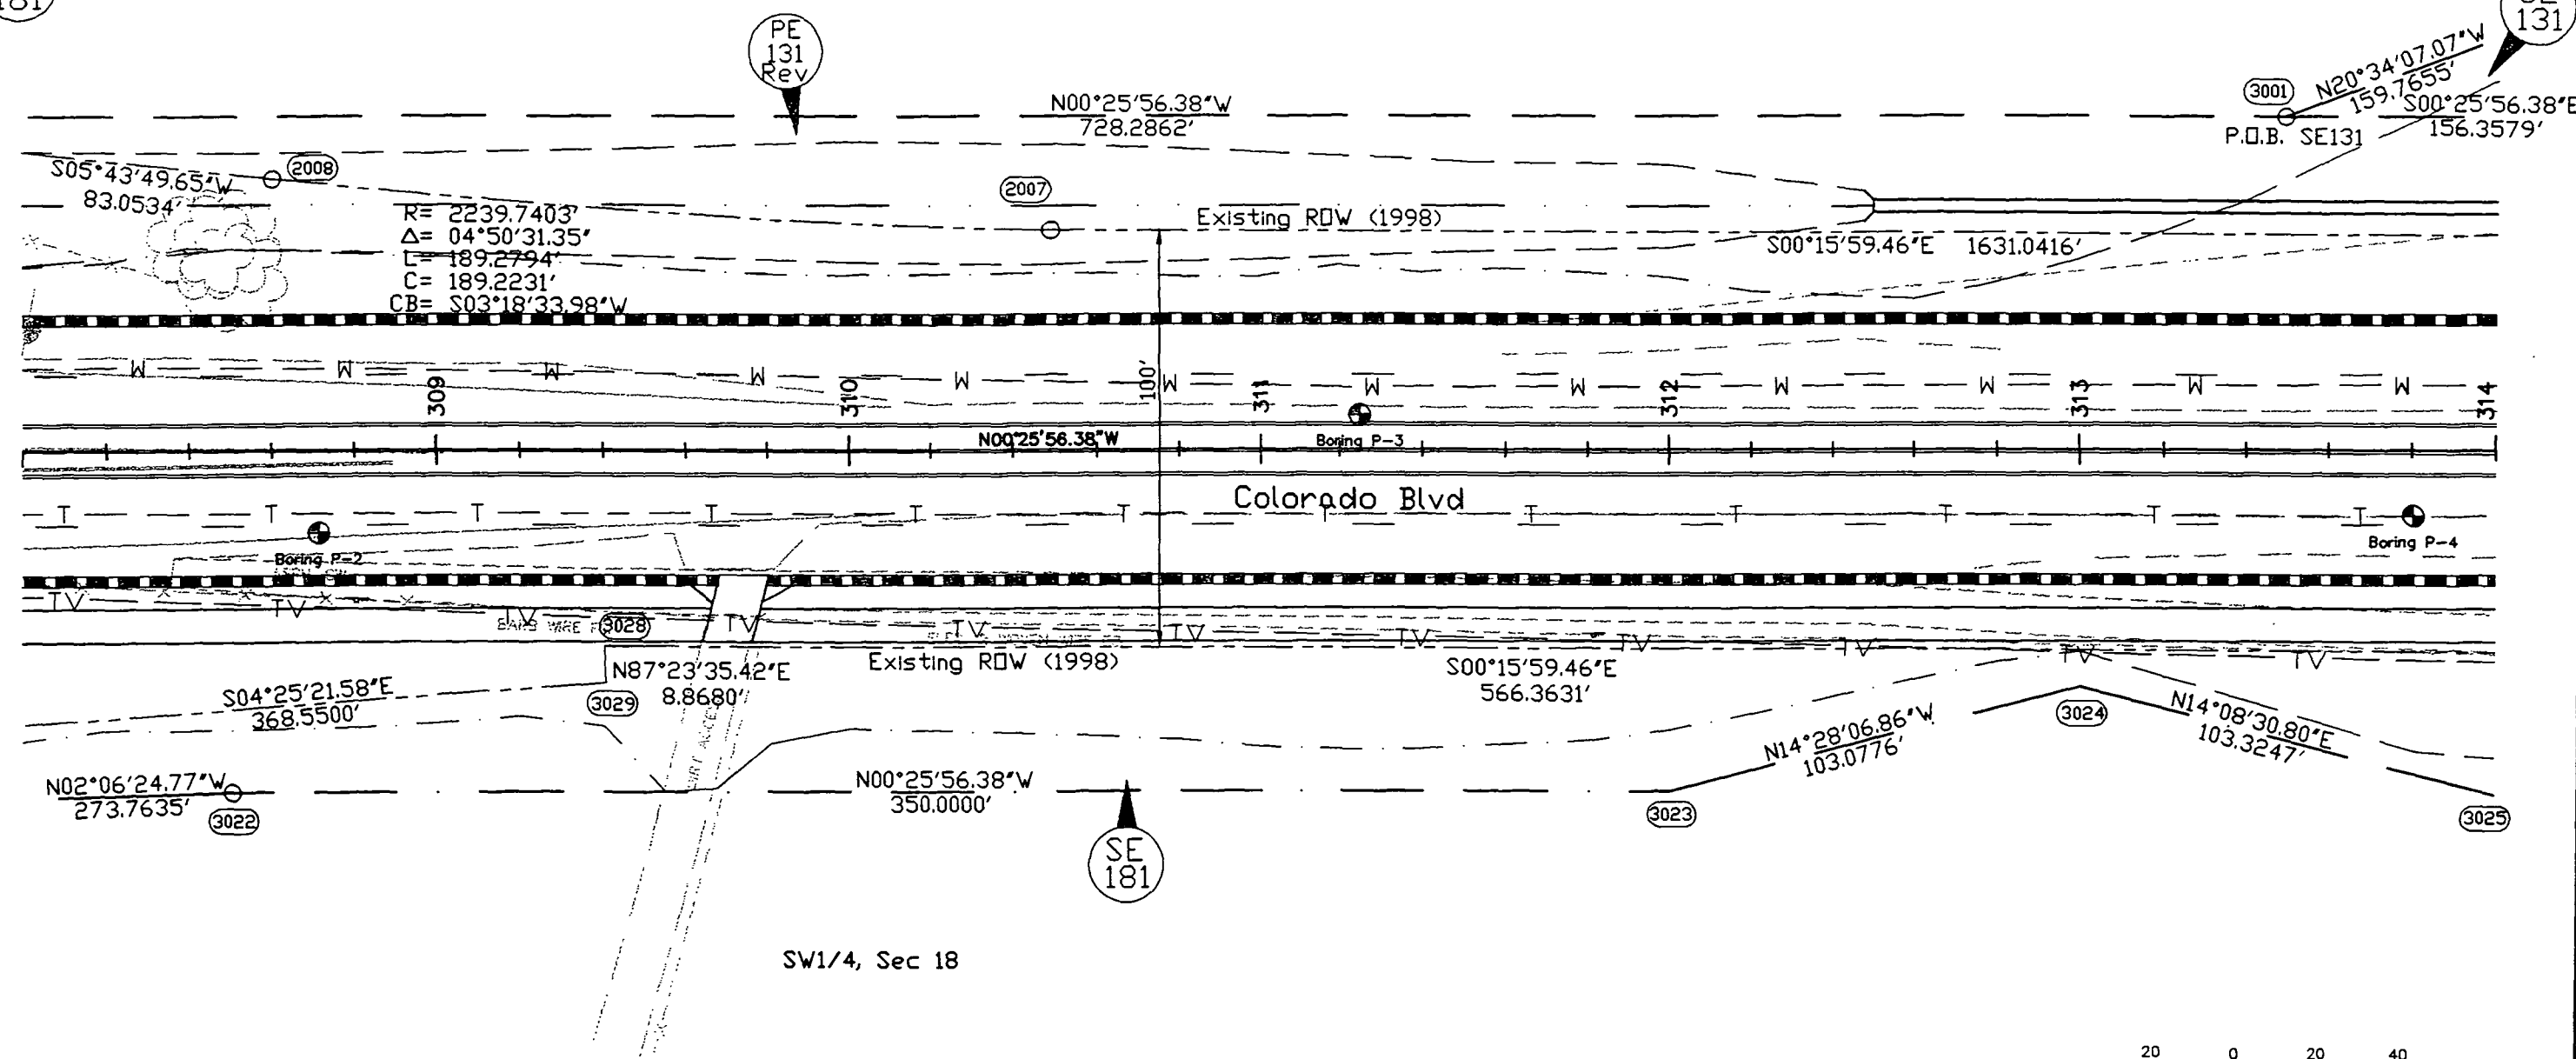


SW1/4, Sec 18

T. 2 S., R. 67 W. 6th P.M.

Computer File Information				Index of Revisions			 CITY OF THORNTON	 The HNTB Companies 1600 Broadway Suite 1300 Denver, Colorado 80202 (303) 683-1469	As Constructed		ROW PLAN SHEET			Project No./Code		
Creation Date:	01/14/98	Initials:	KRK		08/25/98	Revised			Parcel PE131	GP	No Revisions:	STA 308+00 TO STA 314+00			STU C120-005	
Last Modification Date:	08/25/98	Initials:	GP								Revised:	Designer:	G. Prusik	Structure		11473
Full Path:	j:\25814\rdwy										Void:	Detailer:	G. Prusik	Numbers		
Drawing File Name:	row-s01.dwg											Sheet Subset:	ROW	Subset Sheets	2 of 9	Sheet Number
Acad Ver.	13	Scale:	1"=20'	Units:	English											

PARCEL NO.	OWNERSHIP
PE 131 Rev	Terwilliger Properties LLC
SE 131	Terwilliger Properties LLC
SE 181	Duried Jallad, et al
SE 182	CP Limited Partnership

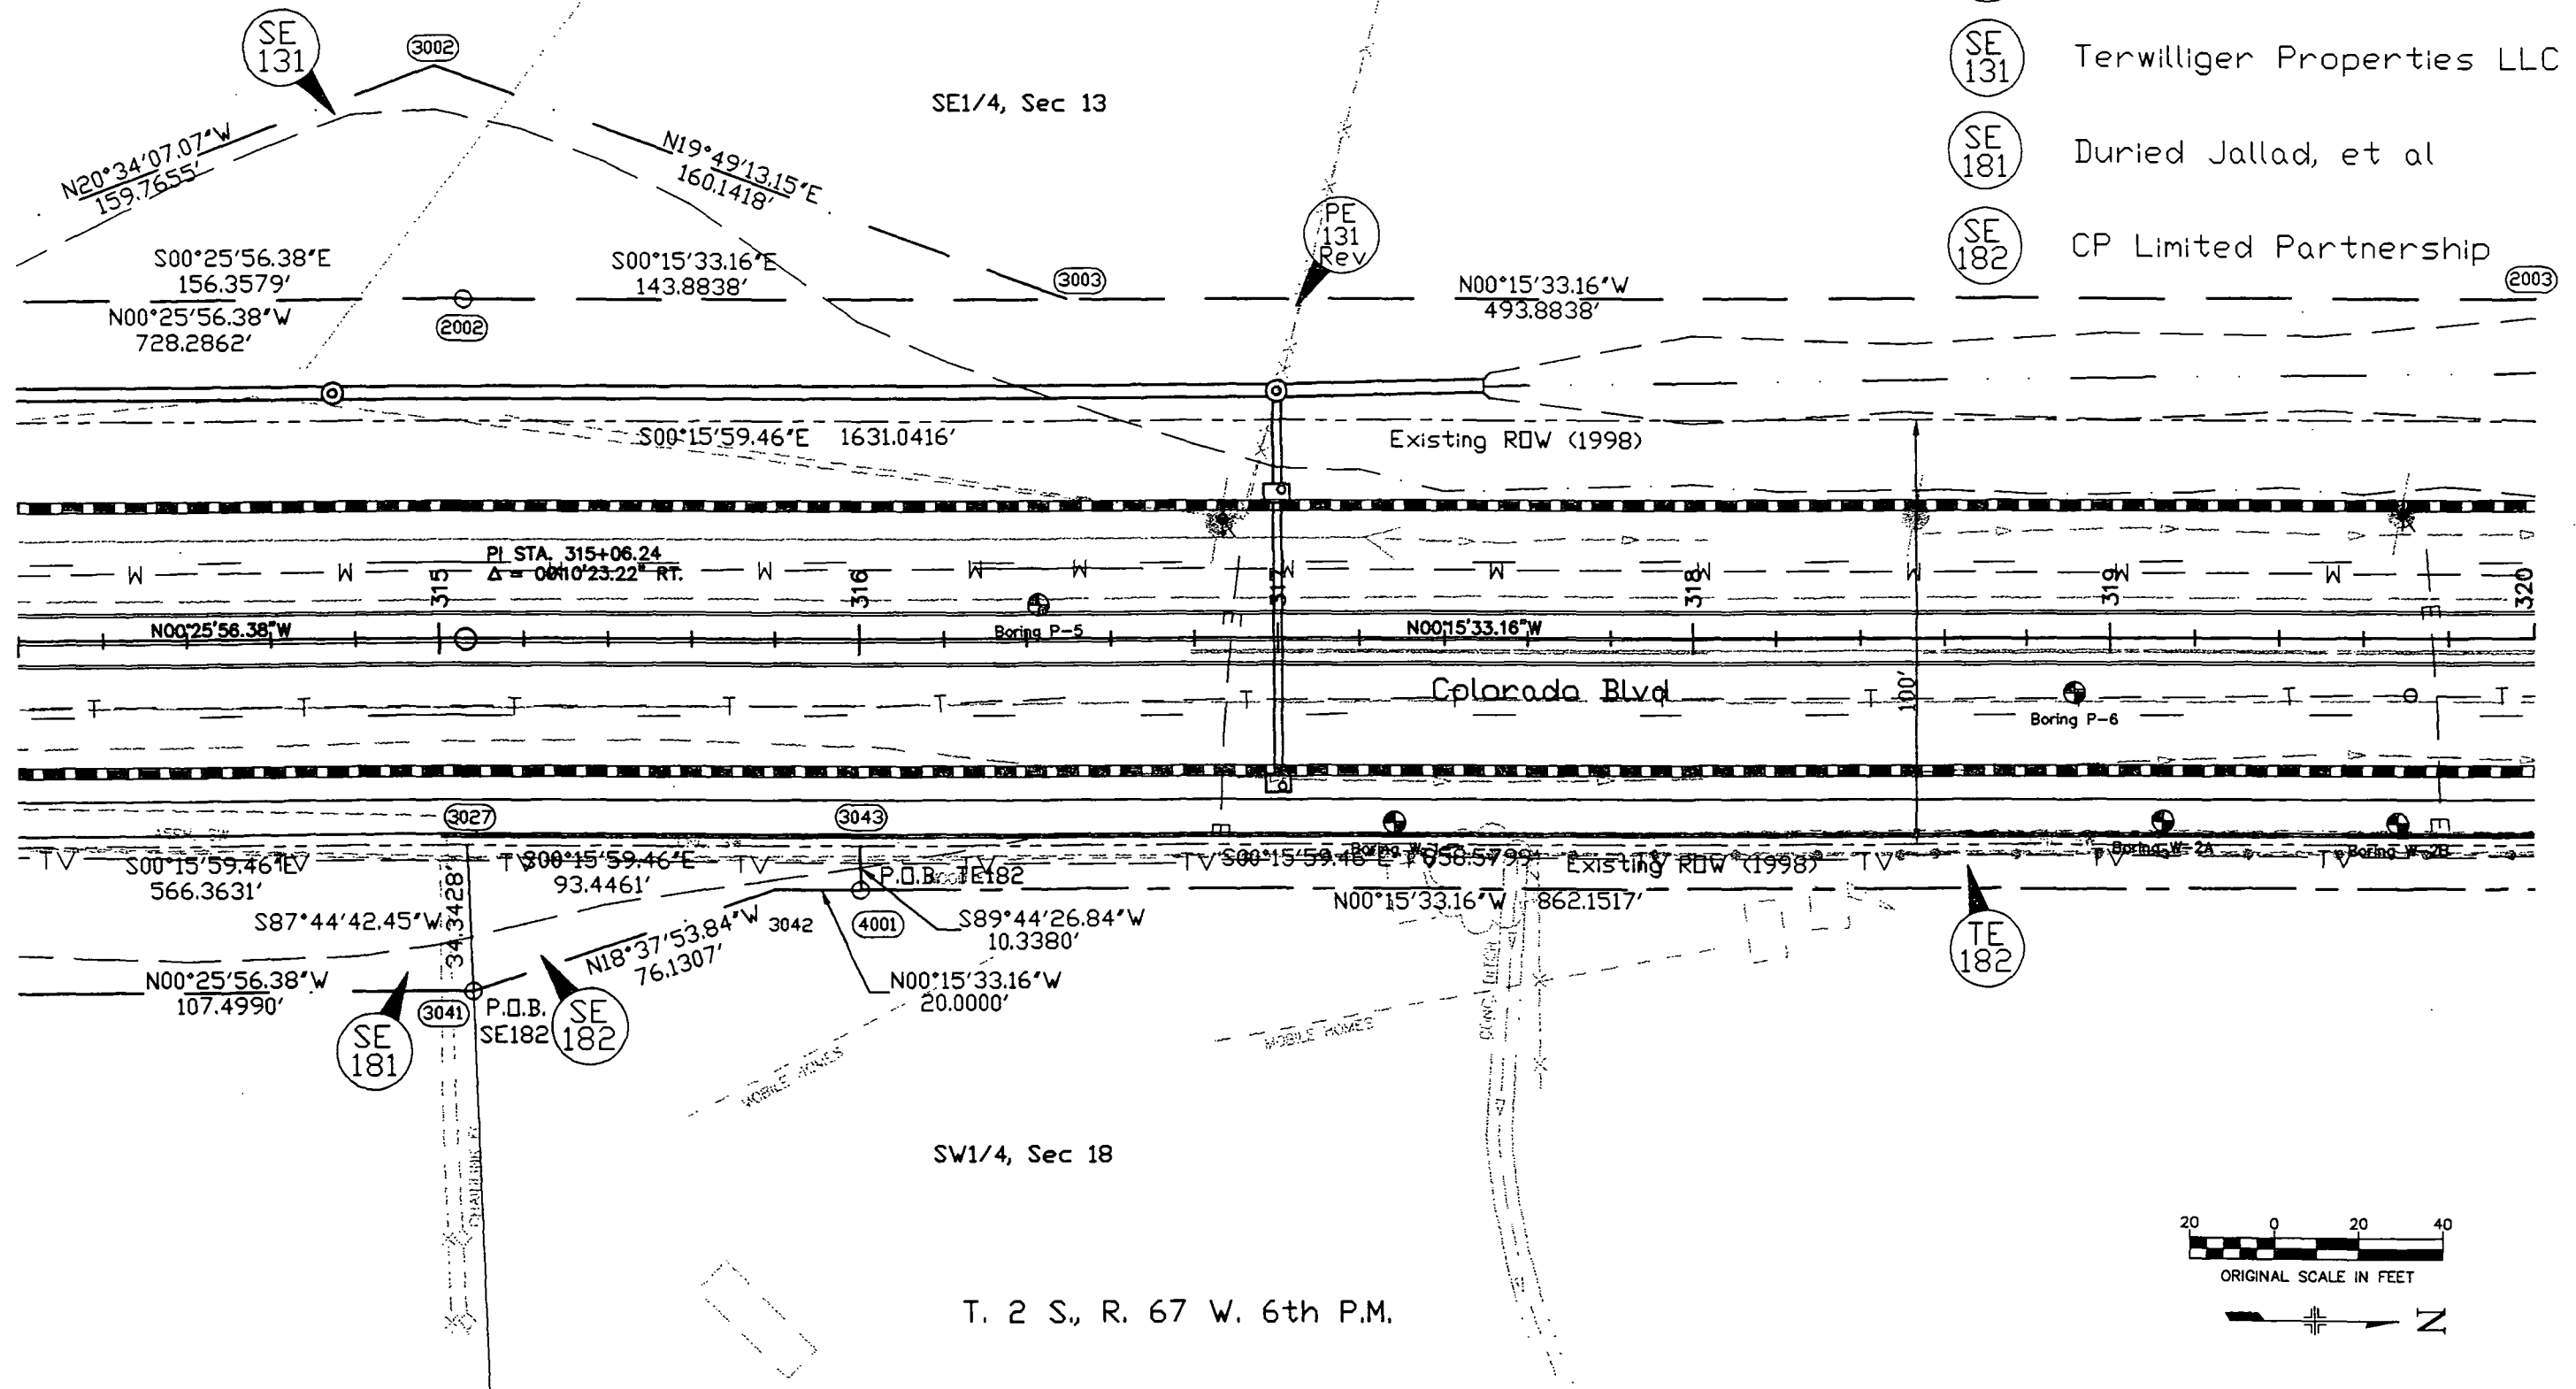

Computer File Information		Index of Revisions		 CITY OF THORNTON	 The HNTB Companies 1600 Broadway Suite 1300 Denver, Colorado 80202 (303) 683-1489	As Constructed		ROW PLAN SHEET		Project No./Code		
Creation Date:	01/14/98 Initials: KRK	☐	08/25/98 Revised Parcel PE131 GP			No Revisions:	STA 314+00 TO STA 320+00		STU C120-005			
Last Modification Date:	08/25/98 Initials: GP	☐				Revised:	Designer:	G. Prusik	Structure	11473		
Full Path:	j:\25814\rdwy	☐					Detailer:	G. Prusik	Numbers			
Drawing File Name:	row-s02.dwg	☐				Void:	Sheet Subset:	ROW	Subset Sheets	3 of 9	Sheet Number	7
Acad Ver.	13 Scale: 1"=20' Units: English	☐										

PARCEL NO. OWNERSHIP

PE 131 Rev

Terwilliger Properties LLC

PE 132

Union Pacific Railroad

SE 182

CP Limited Partnership

SE 183

Kerry Associates Corp

T. 2 S., R. 68 W. 6th P.M.

R= 1985.0000'
Δ= 05°54'44.17"
L= 204.8293'
C= 204.7384'
CB= N17°34'56.14"E

P.O.B. PE132Rev

PE 132 Rev

N04°59'31.79"E 162.8766'

SE1/4, Sec 13

PE 131 Rev

(2004)


N00°15'33.16"W
185.4393'

(2005)

N07°51'13.87"W
302.6549'

Existing ROW (1998)

S00°15'59.46"E 1631.0416'

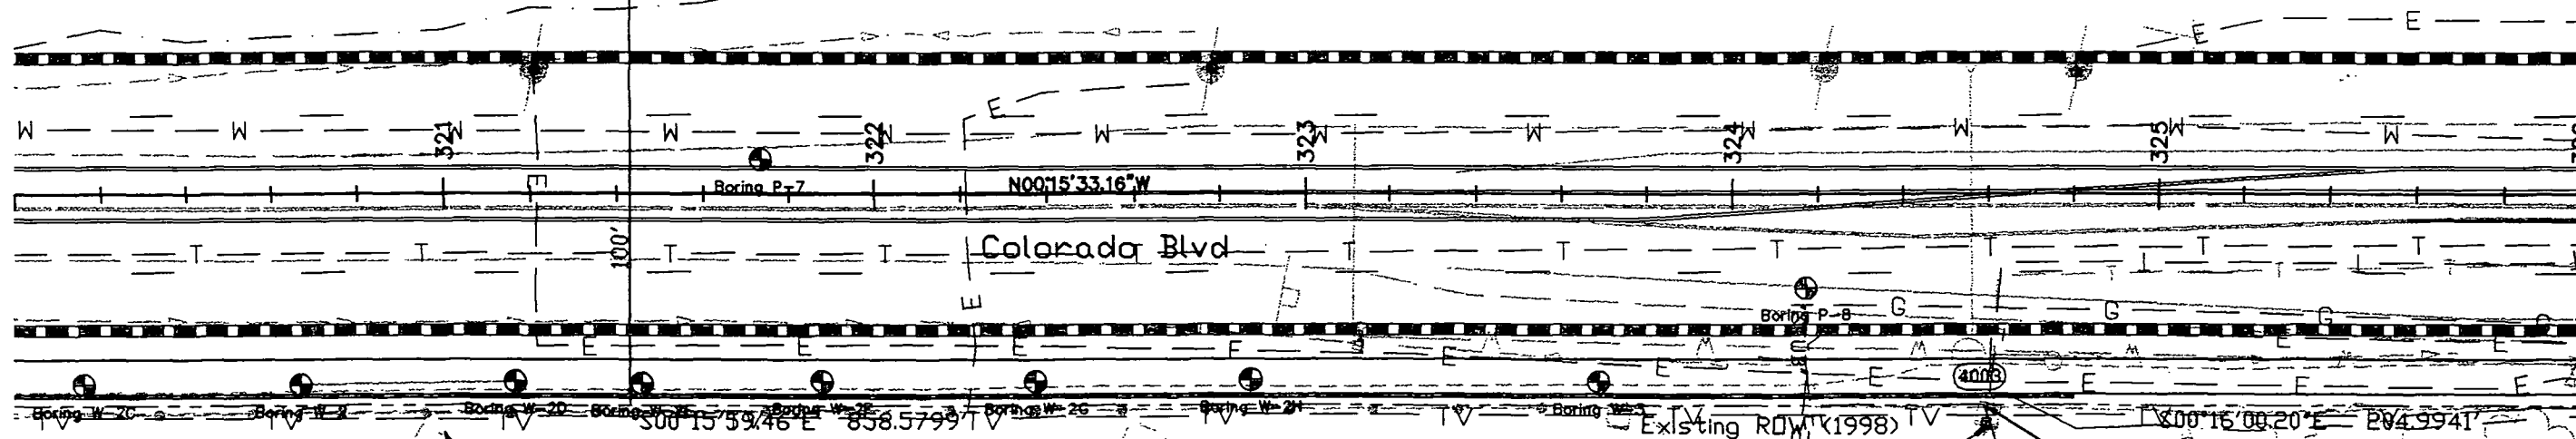


TE 182

SE 183

SW1/4, Sec 18

 T. 2 S., R. 67 W. 6th P.M.



Computer File Information

Creation Date: 01/14/98 Initials: KRK
Last Modification Date: 08/25/98 Initials: GP
Full Path: j:\25814\rdwy
Drawing File Name: row-s02.dwg
Acad Ver. 13 Scale: 1"=20' Units: English

Index of Revisions

Rev	Date	Description	By
R-1	08/25/98	Revised Parcel PE131	GP
R-2		& PE132	
R-3			
R-4			
R-5			



HNTB
The HNTB Companies

1600 Broadway
Suite 1300
Denver, Colorado
80202
(303) 683-1469

As Constructed

No Revisions:

Revised:

Void:

ROW PLAN SHEET

STA 320+00 TO STA 326+00

Designer: G. Prusik
Detailer: G. Prusik
Sheet Subset: ROW

Structure
Numbers

Subset Sheets

4 of 9

Project No./Code

STU C120-005

11473


Sheet Number

8


PARCEL NO. OWNERSHIP


T. 2 S., R. 68 W. 6th P.M.


132 Rev	Union Pacific Railroad	SE 132	Medical Offices Associates
SE 132	Union Pacific Railroad	PE 184	CP Limited Partnership
133	Medical Offices Associates	TE 184	CP Limited Partnership

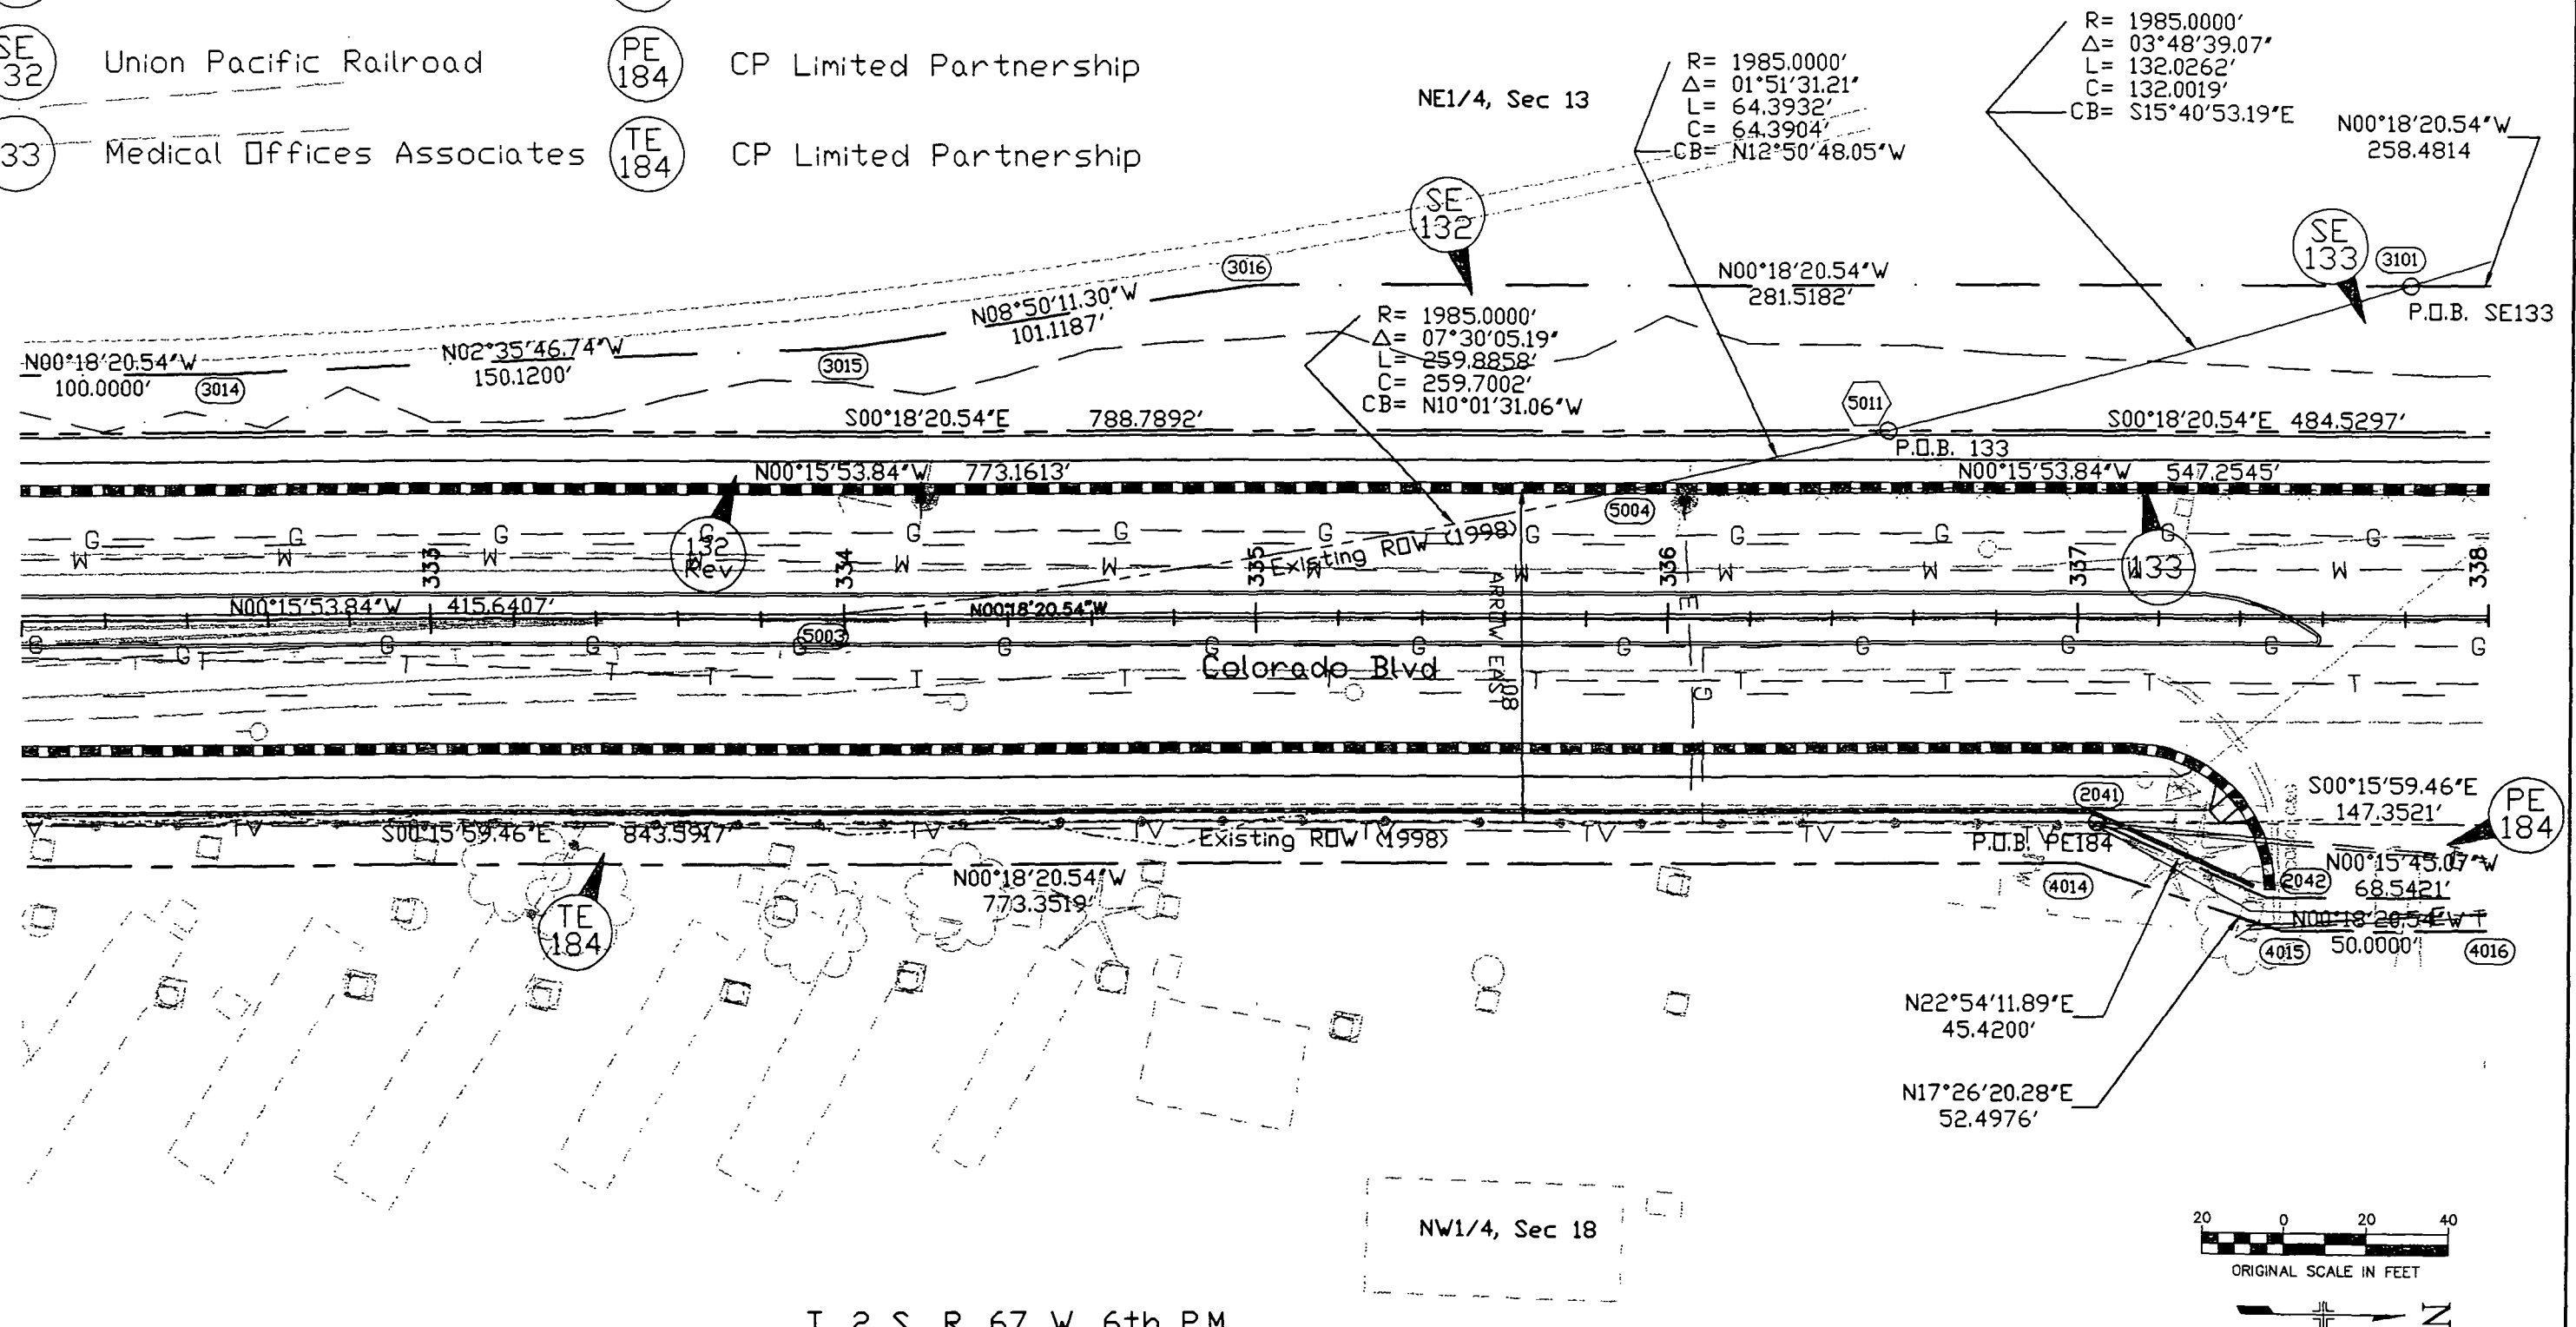


T. 2 S., R. 67 W. 6th P.M.

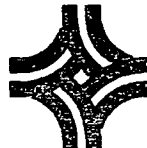Computer File Information		Index of Revisions		 CITY OF THORNTON	 HNTB The HNTB Companies 1800 Broadway Suite 1300 Denver, Colorado 80202 (303) 683-1489	As Constructed		ROW PLAN SHEET		Project No./Code
Creation Date:	01/14/98 Initials: KRK	08/25/98	Revised Parcel 132			No Revisions:		STA 332+00 TO STA 338+00		
Last Modification Date:	08/25/98 Initials: GP					Revised:		Designer: G. Prusik	Structure	STU C120-005
Full Path:	j:\25814\rdwy					Void:		Detailer: G. Prusik	Numbers	11473
Drawing File Name:	row-s03.dwg							Sheet Subset: ROW	Subset Sheets	10
Acad Ver. 13	Scale: 1"=20' Units: English								6 of 9	Sheet Number

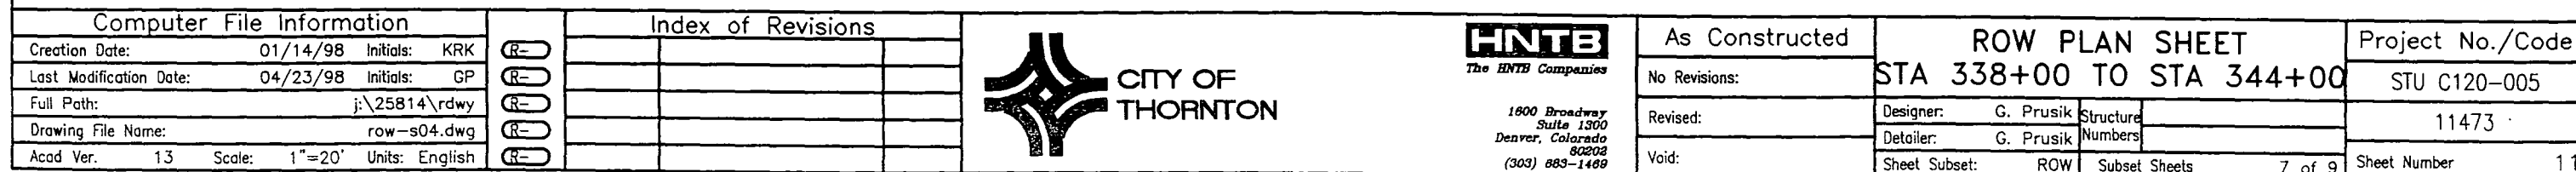


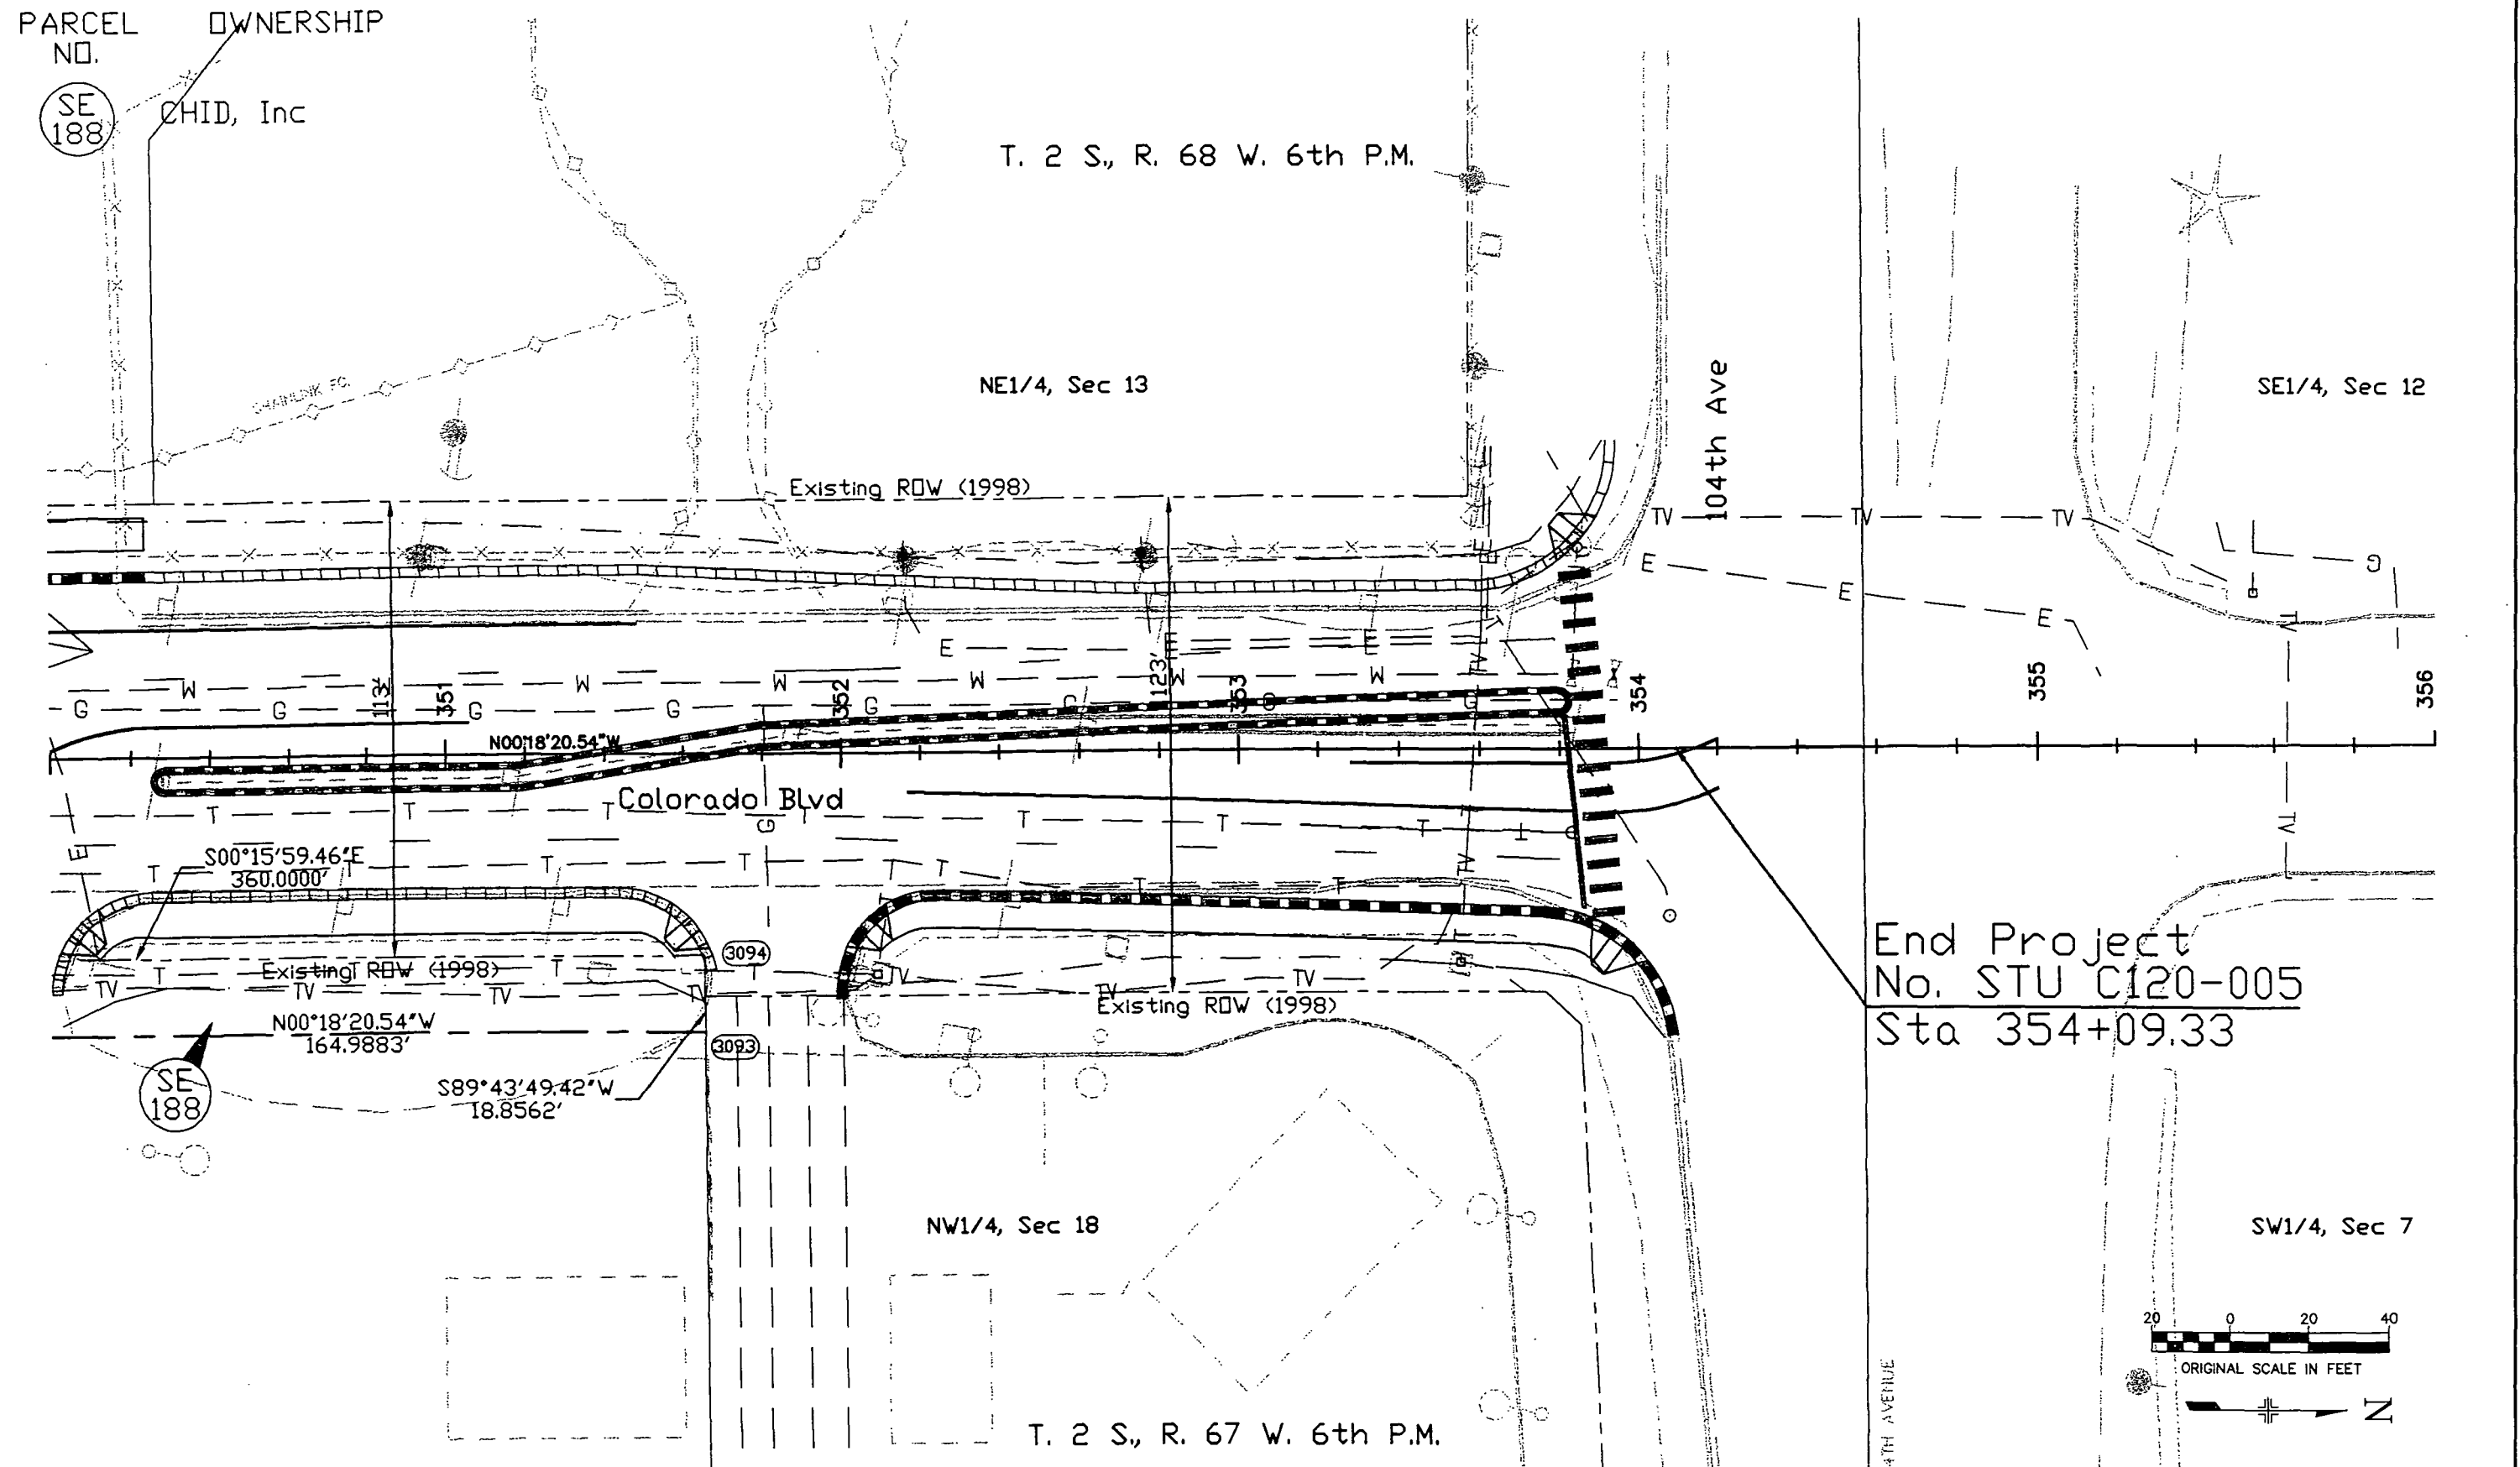


 Computer File Information			Index of Revisions			 CITY OF THORNTON	 The HNTB Companies 1800 Broadway Suite 1300 Denver, Colorado 80202 (303) 683-1489	As Constructed		ROW PLAN SHEET			Project No./Code		
Creation Date: 01/14/98 Initials: KRK			(R-1)	08/25/98	Revised End Project			GP	No Revisions:		STA 350+00 TO STA 356+00			STU C120-005	
Last Modification Date: 08/25/98 Initials: GP			(R-2)		Station				Revised:		Designer: G. Prusik	Structure	11473		
Full Path: j:\25814\rdwy			(R-3)						Void:		Detailer: G. Prusik	Numbers			
Drawing File Name: row-s05.dwg			(R-4)								Sheet Subset: ROW	Subset Sheets	9 of 9	Sheet Number	13
Acad Ver. 13 Scale: 1"=20' Units: English			(R-5)												



HNTB
The HNTB Companies
1600 Broadway
Suite 1300
Denver, Colorado
80202
(303) 683-1489


OWNERSHIP MAP T. 2 S., R. 68 W., 6th P.M. ADAMS COUNTY, COLORADO

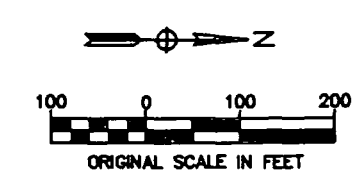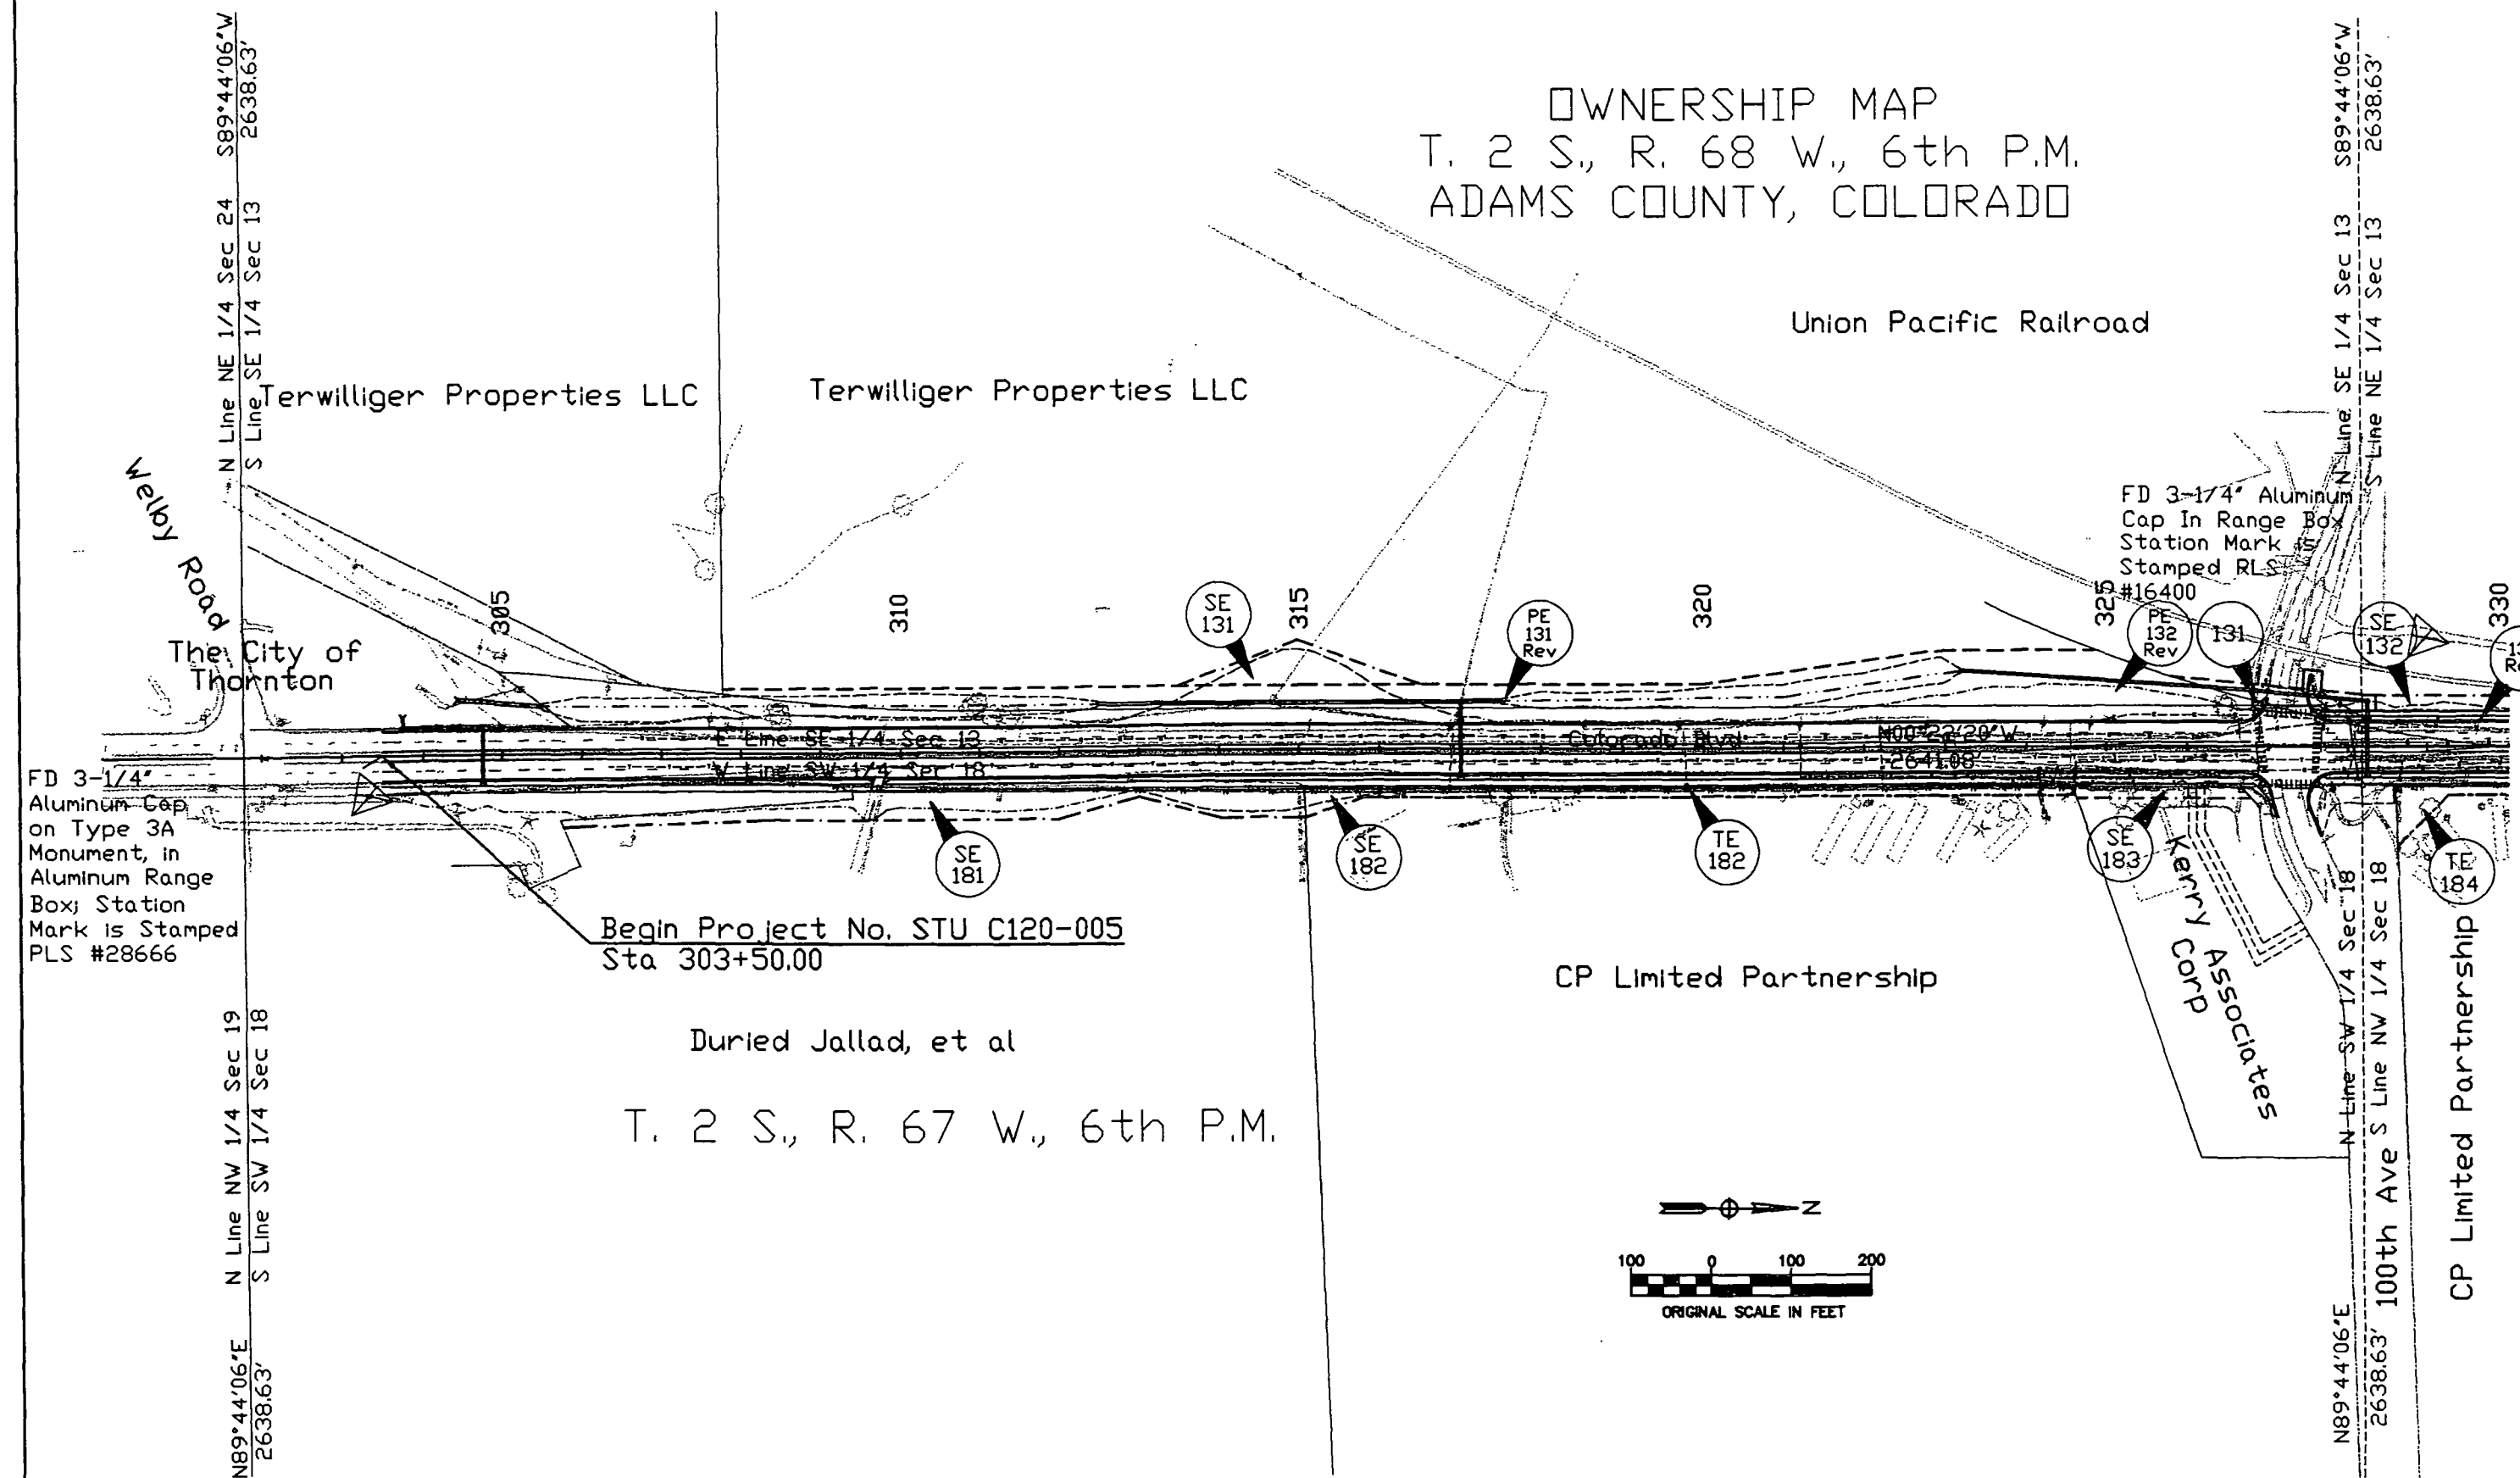

Computer File Information				Index of Revisions			 CITY OF THORNTON	 The HNTB Companies 1600 Broadway Suite 1300 Denver, Colorado 80202 (303) 683-1499	As Constructed		RIGHT OF WAY OWNERSHIP MAP			Project No./Code	
Creation Date:	02/14/98	Initials:	GP	R-1	08/25/98	Revised Parcel PE131,			GP	No Revisions:				STU C120-005	
Last Modification Date:	08/25/98	Initials:	GP	R-		PE132 & 132; and				Revised:		Designer:	Frasier	Structure	
Full Path:	j:\25814\rdwy			R-		Added Parcel 131						Detailer:	GP	Numbers	
Drawing File Name:	rowmap01.dwg			R-						Void:		Sheet Subset:	ROW-Map	Subset Sheets	1 of 2
Acad Ver.	13	Scale: 1" = 100'	Units: English	R-										Sheet Number	14

1600 Broadway
Suite 1300
Denver, Colorado
80202
(303) 683-1488

OWNERSHIP MAP
T. 2 S., R. 68 W., 6th P.M.
ADAMS COUNTY, COLORADO

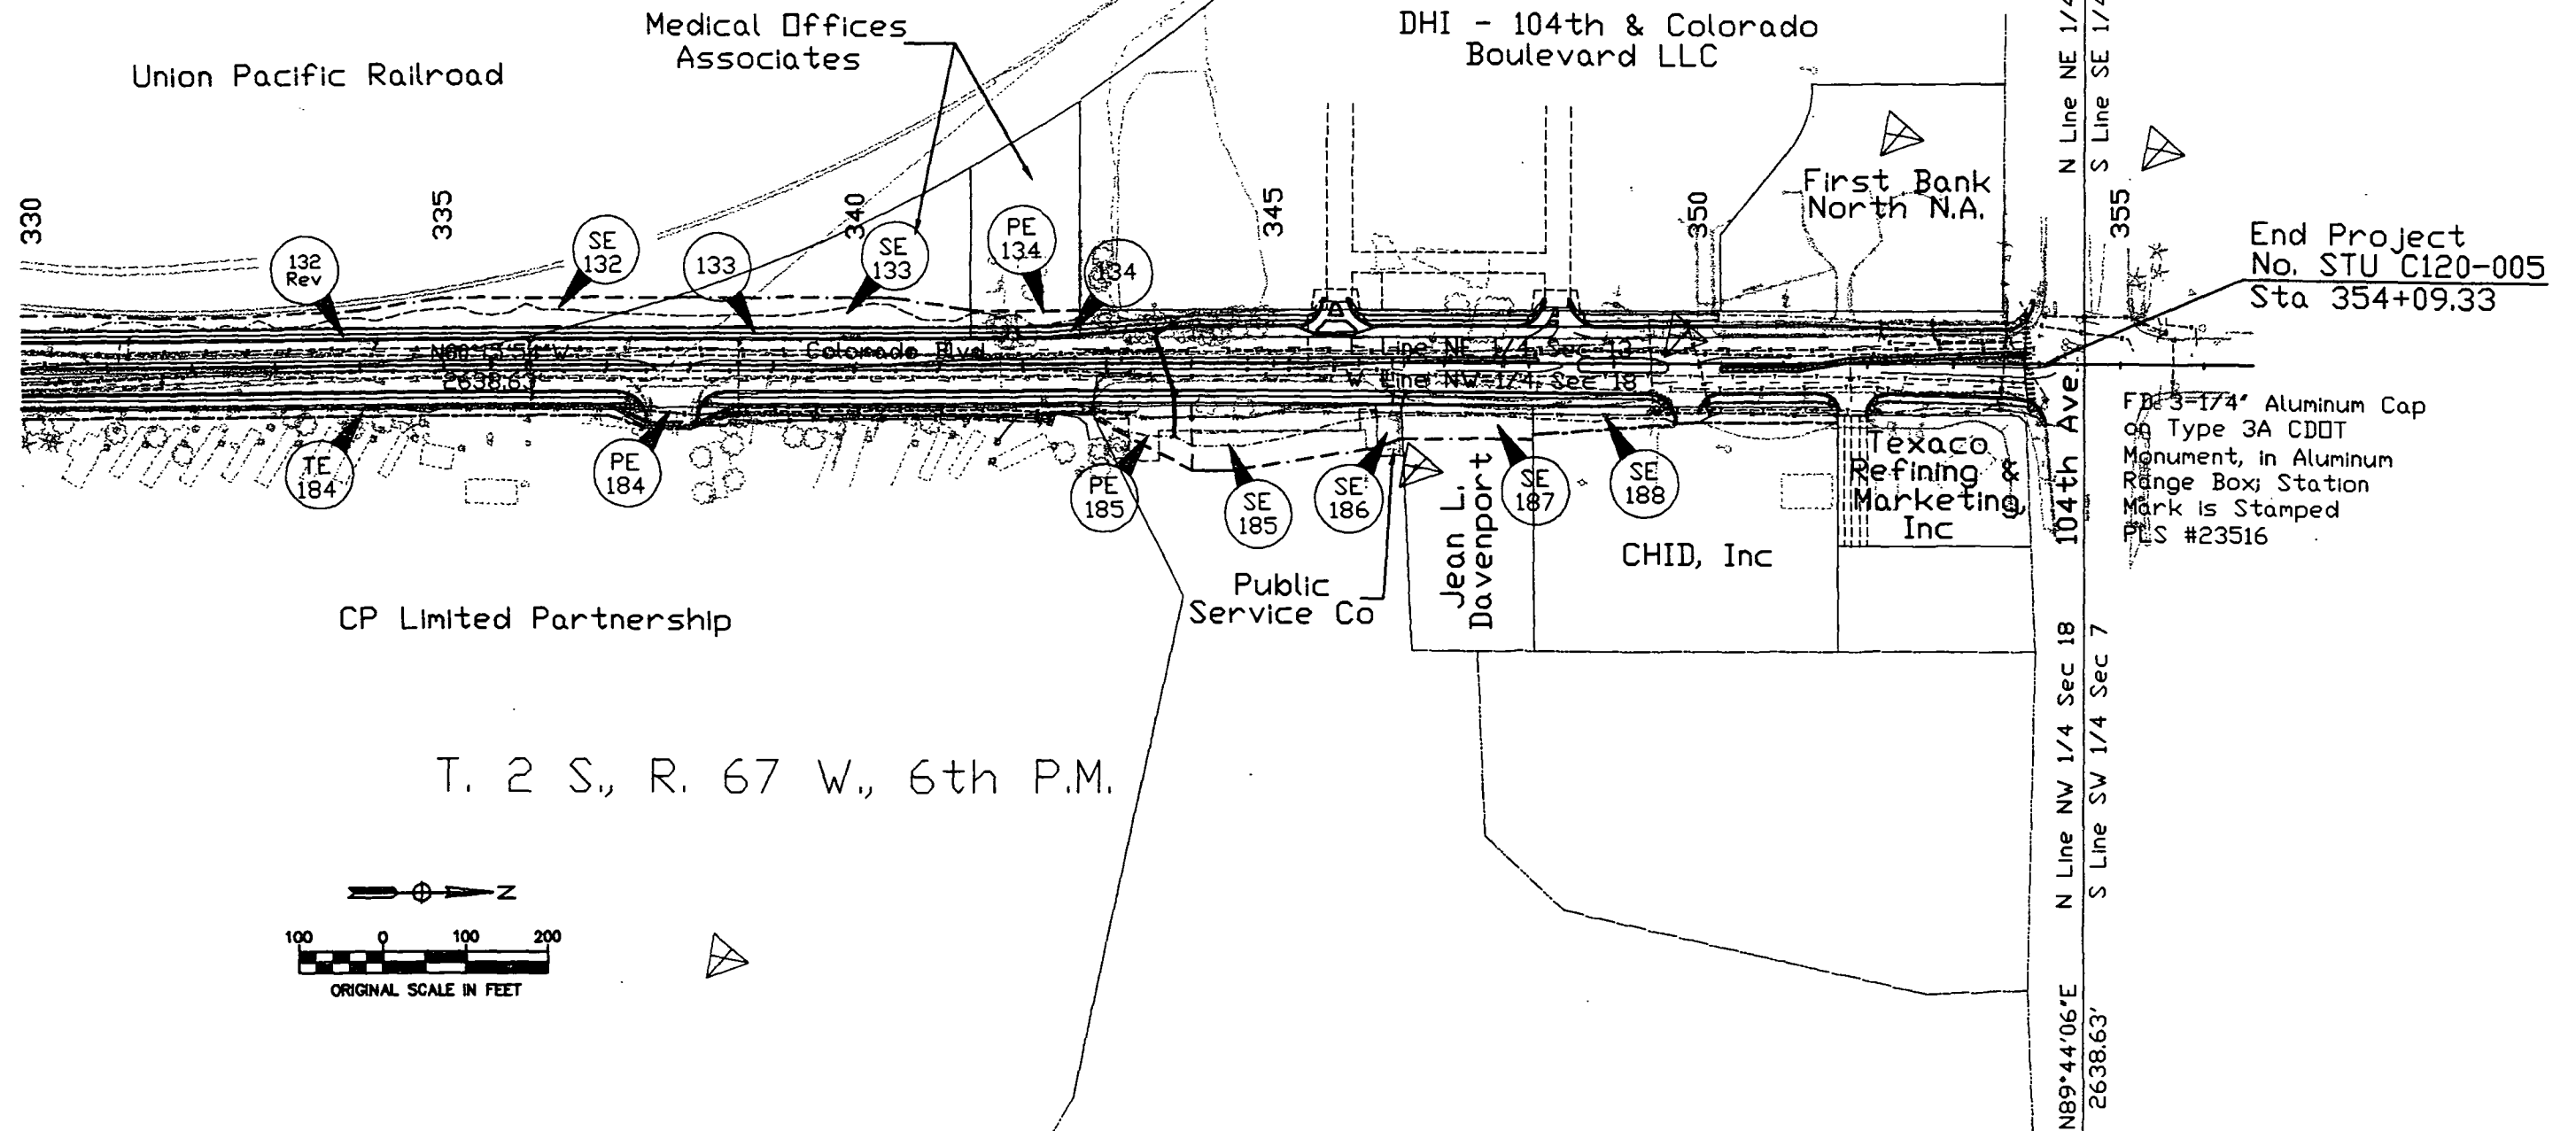

Computer File Information			Index of Revisions			As Constructed			RIGHT OF WAY OWNERSHIP MAP			Project No./Code	
Creation Date:	02/14/98	Initials: GP	(R-1)	08/25/98	Revised Parcel 132	GP	No Revisions:		Designer:	Frasier	Structure	STU C120-005	
Last Modification Date:	08/25/98	Initials: GP	(R-2)				Revised:		Detailer:	GP	Numbers	11473	
Full Path:	j:\25814\rdwy		(R-3)				Void:		Sheet Subset:	ROW-Map	Subset Sheets	2 of 2	
Drawing File Name:	rowmap01.dwg		(R-4)									Sheet Number	15
Acad Ver.	13	Scale: 1" = 100'	(R-5)										
		Units: English											

